


MATCHLINE, SEE SHEET 2

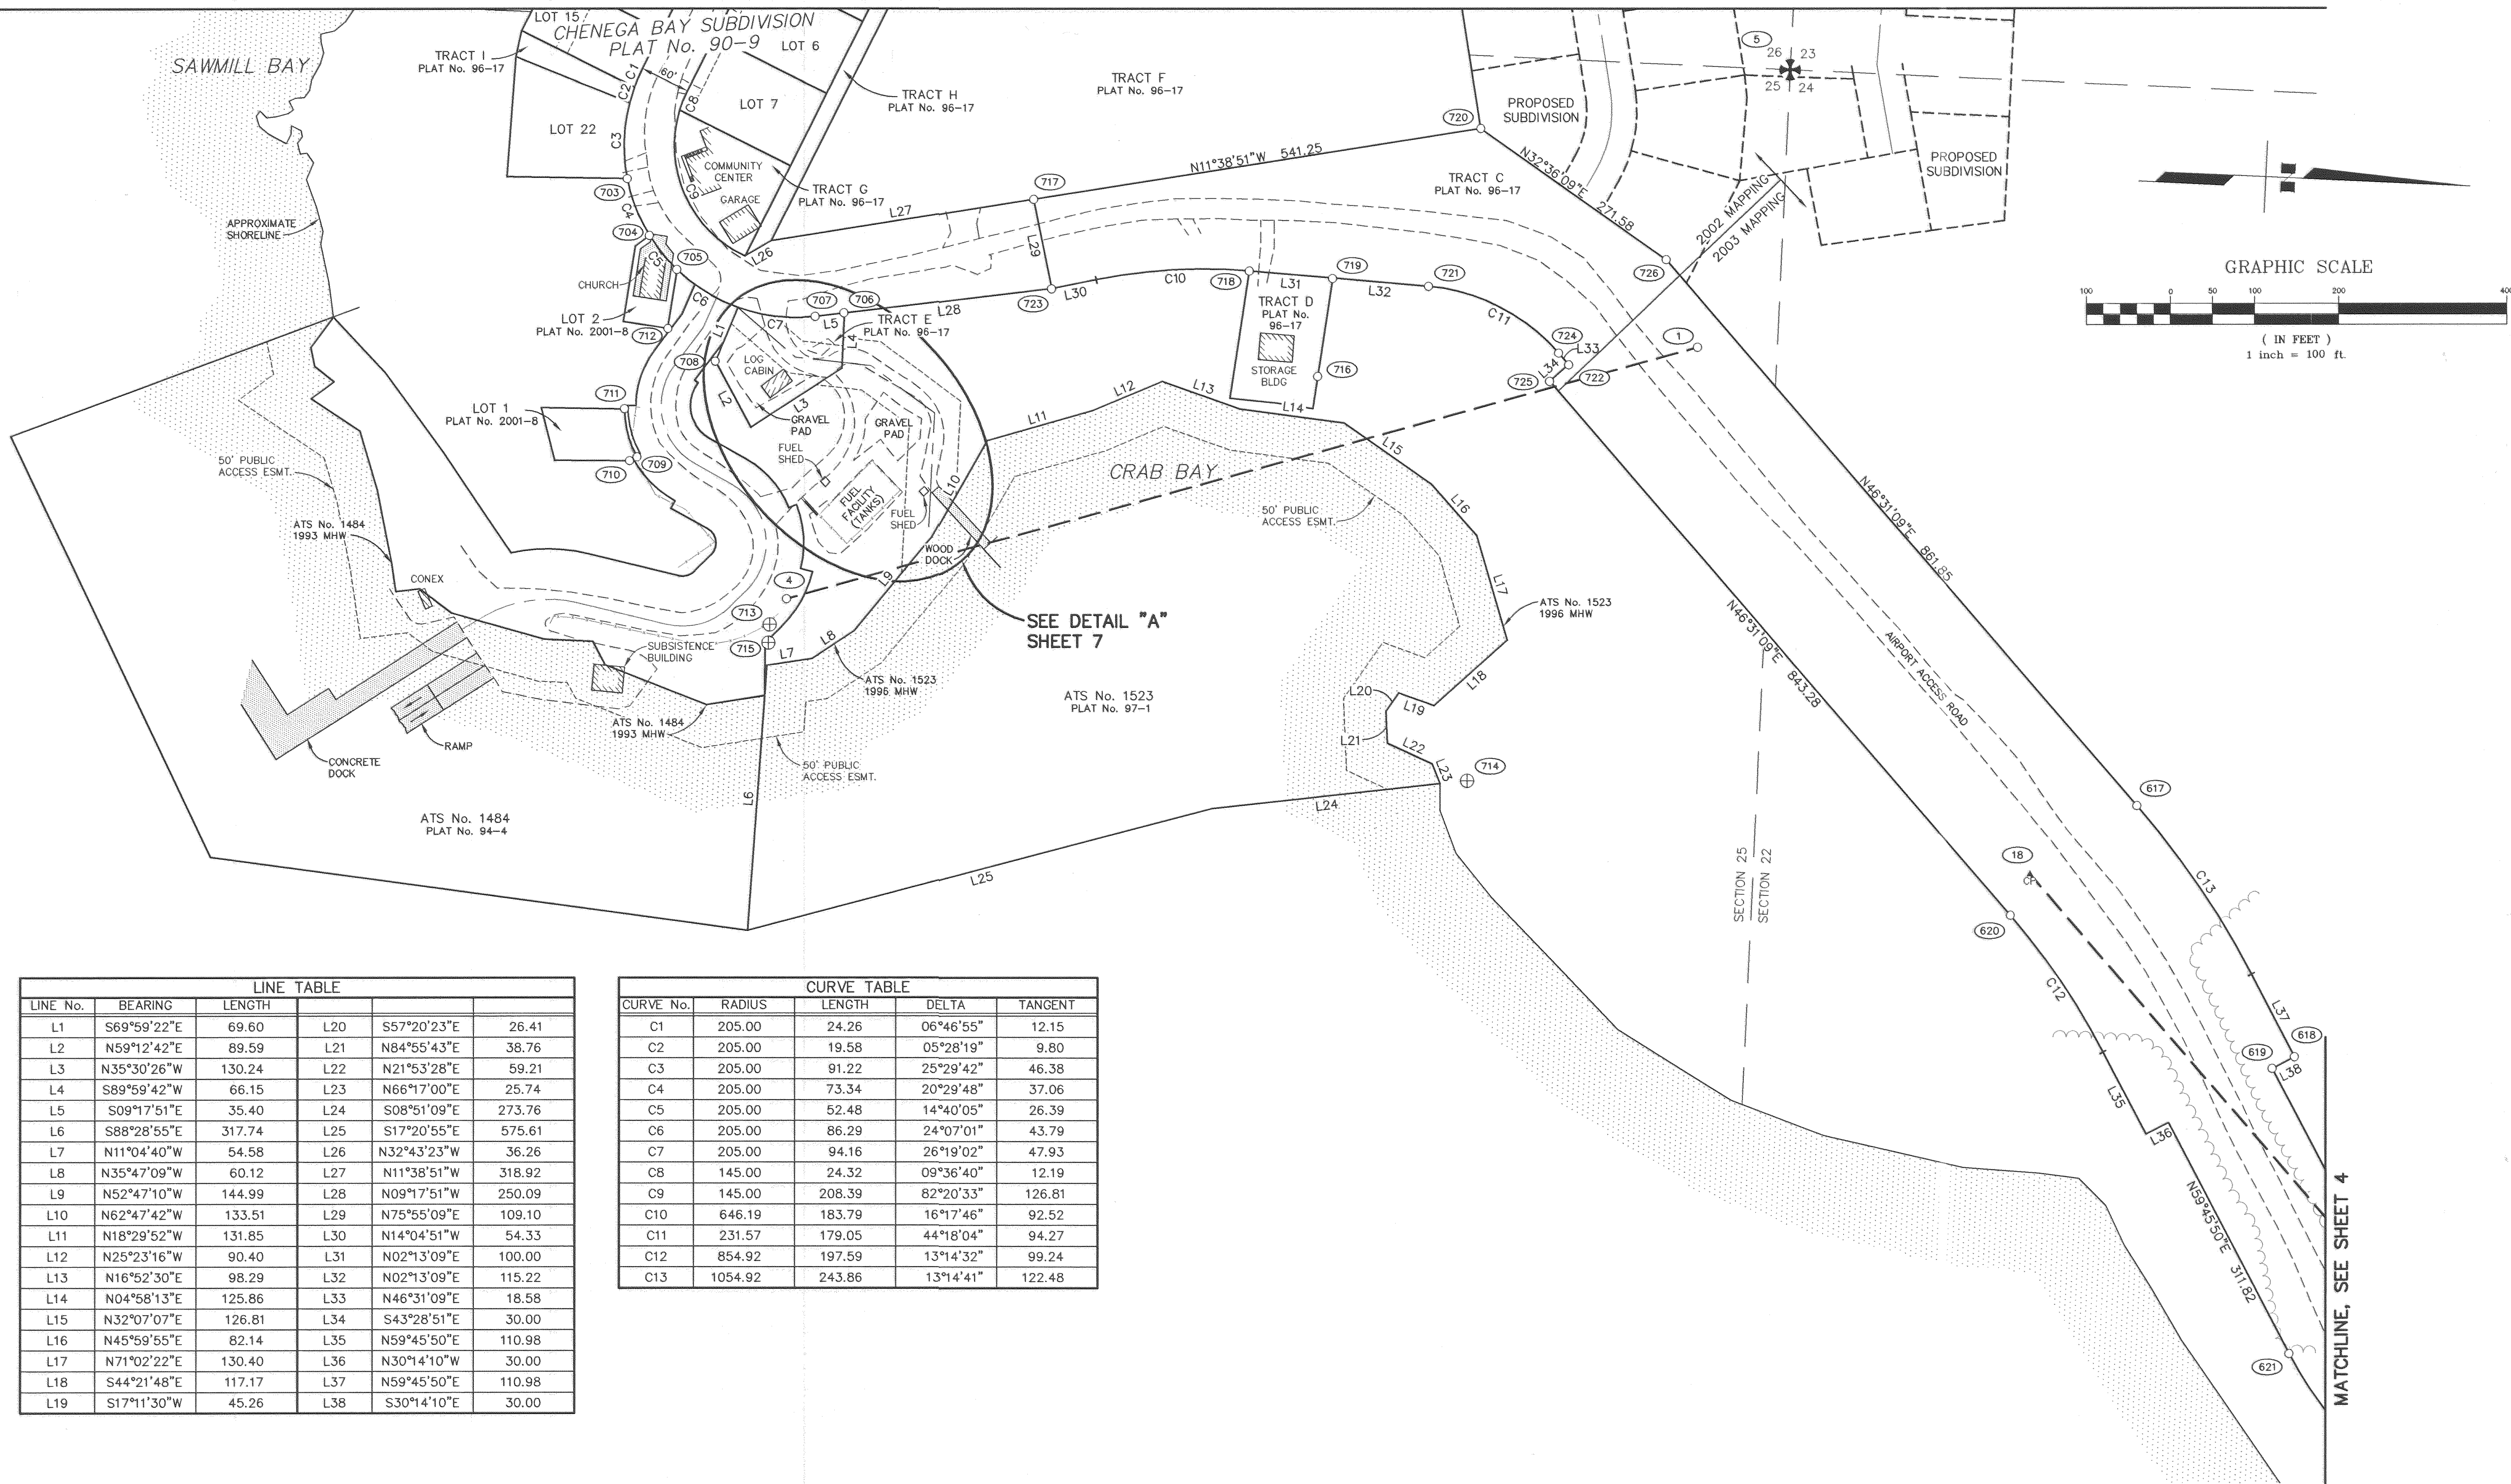

LINE TABLE					
LINE No.	BEARING	LENGTH			
L1	S69°59'22"E	69.60	L20	S57°20'23"E	26.41
L2	N59°12'42"E	89.59	L21	N84°55'43"E	38.76
L3	N35°30'26"W	130.24	L22	N21°53'28"E	59.21
L4	S89°59'42"W	66.15	L23	N66°17'00"E	25.74
L5	S09°17'51"E	35.40	L24	S08°51'09"E	273.76
L6	S88°28'55"E	317.74	L25	S17°20'55"E	575.61
L7	N11°04'40"W	54.58	L26	N32°43'23"W	36.26
L8	N35°47'09"W	60.12	L27	N11°38'51"W	318.92
L9	N52°47'10"W	144.99	L28	N09°17'51"W	250.09
L10	N62°47'42"W	133.51	L29	N75°55'09"E	109.10
L11	N18°29'52"W	131.85	L30	N14°04'51"W	54.33
L12	N25°23'16"W	90.40	L31	N02°13'09"E	100.00
L13	N16°52'30"E	98.29	L32	N02°13'09"E	115.22
L14	N04°58'13"E	125.86	L33	N46°31'09"E	18.58
L15	N32°07'07"E	126.81	L34	S43°28'51"E	30.00
L16	N45°59'55"E	82.14	L35	N59°45'50"E	110.98
L17	N71°02'22"E	130.40	L36	N30°14'10"W	30.00
L18	S44°21'48"E	117.17	L37	N59°45'50"E	110.98
L19	S17°11'30"W	45.26	L38	S30°14'10"E	30.00

CURVE TABLE				
CURVE No.	RADIUS	LENGTH	DELTA	TANGENT
C1	205.00	24.26	06°46'55"	12.15
C2	205.00	19.58	05°28'19"	9.80
C3	205.00	91.22	25°29'42"	46.38
C4	205.00	73.34	20°29'48"	37.06
C5	205.00	52.48	14°40'05"	26.39
C6	205.00	86.29	24°07'01"	43.79
C7	205.00	94.16	26°19'02"	47.93
C8	145.00	24.32	09°36'40"	12.19
C9	145.00	208.39	82°20'33"	126.81
C10	646.19	183.79	16°17'46"	92.52
C11	231.57	179.05	44°18'04"	94.27
C12	854.92	197.59	13°14'32"	99.24
C13	1054.92	243.86	13°14'41"	122.48

SURVEYOR'S CERTIFICATE

I HEREBY CERTIFY THAT I AM PROPERLY REGISTERED AND LICENSED TO PRACTICE LAND SURVEYING IN THE STATE OF ALASKA, AND THAT THIS DRAWING REPRESENTS A SURVEY MADE BY ME OR UNDER MY DIRECT SUPERVISION, AND THAT THE MONUMENTS SHOWN HEREON ACTUALLY EXIST AS DESCRIBED, AND THAT ALL DIMENSIONS AND OTHER DETAILS ARE CORRECT TO THE EXTENT SHOWN HEREON.

LENDLE C. STORY, L.S. 7843
DATE 1-5-04

BY	DATE	REVISIONS



STATE OF ALASKA
DEPARTMENT OF TRANSPORTATION
AND PUBLIC FACILITIES
CENTRAL REGION-DESIGN AND CONSTRUCTION

APPROVED: _____ DESIGN SECTION CHIEF
APPROVED: _____ PROJECT MANAGER

DATE: 12-05-03
DESIGN: DSN
DRAWN: KSLP
CHECKED: LCS

CHENEGA BAY AIRPORT
RESURFACING & LIGHTING
AKSAS PROJECT No. 56445
CONTROL DIAGRAM

SHEET
3
OF
9