
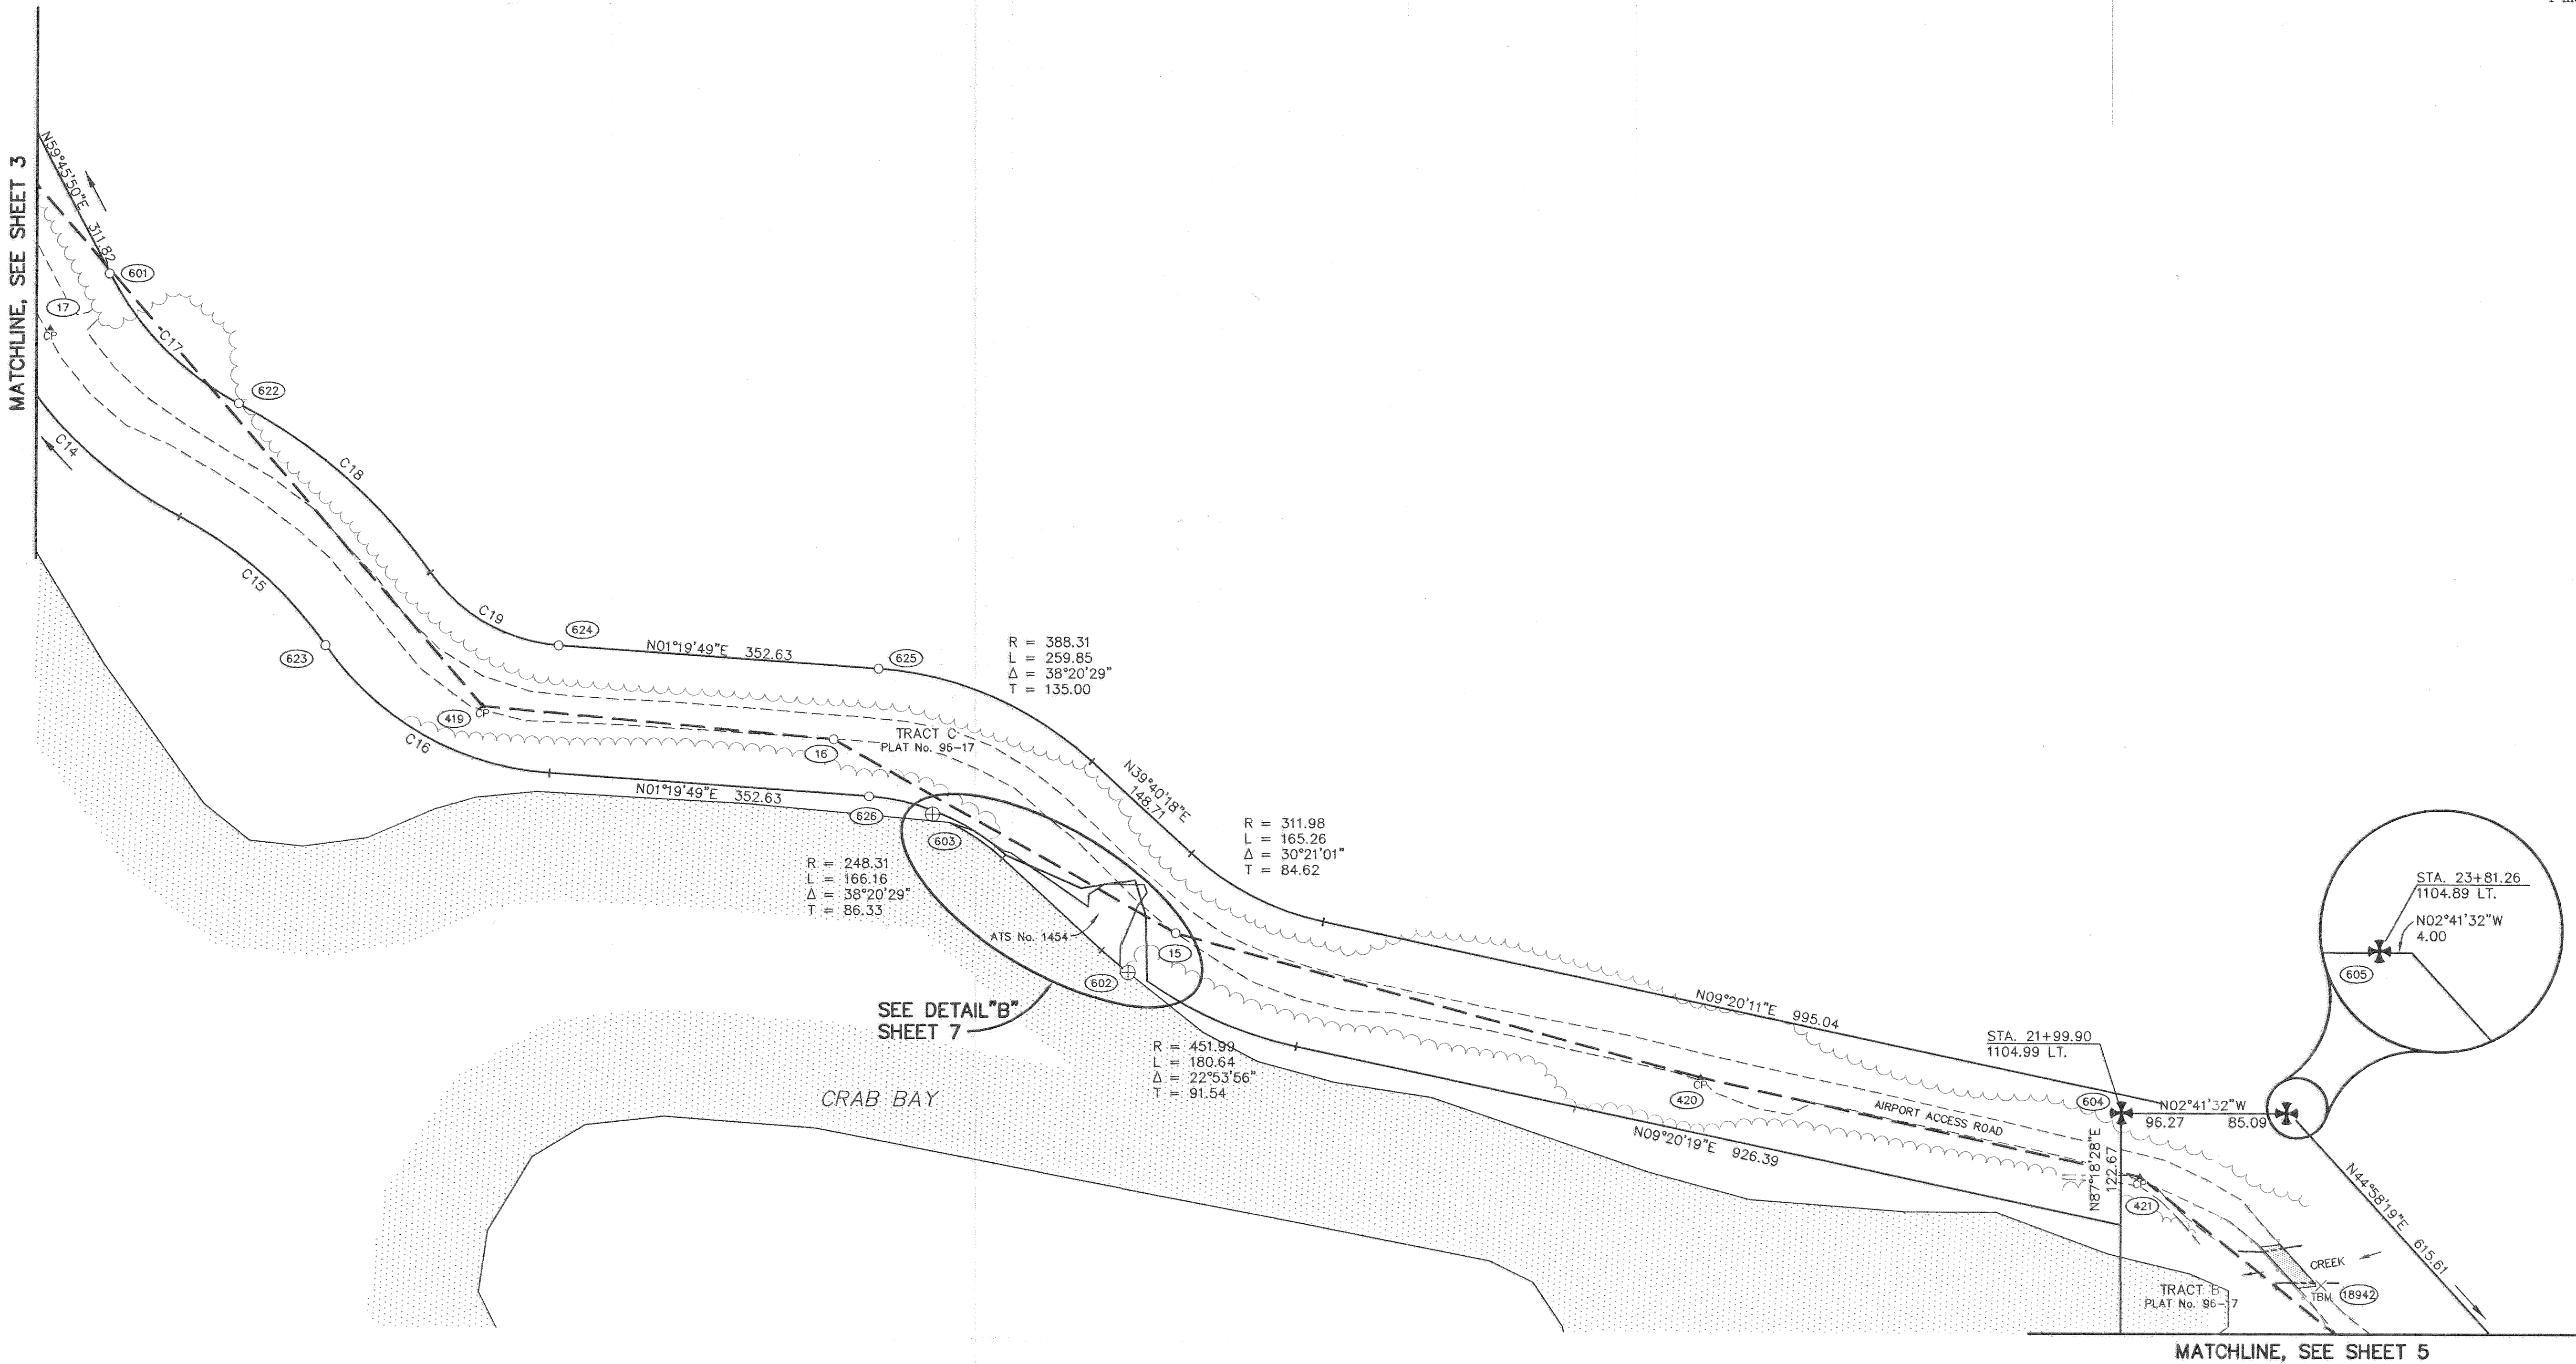


CURVE TABLE				
CURVE No.	RADIUS	LENGTH	DELTA	TANGENT
C14	473.56	289.08	34°58'33"	149.20
C15	449.46	215.79	27°30'28"	110.01
C16	328.71	292.39	50°57'55"	156.66
C17	333.56	203.62	34°58'33"	105.09
C18	589.46	283.00	27°30'28"	144.28
C19	188.71	167.86	50°57'55"	89.94

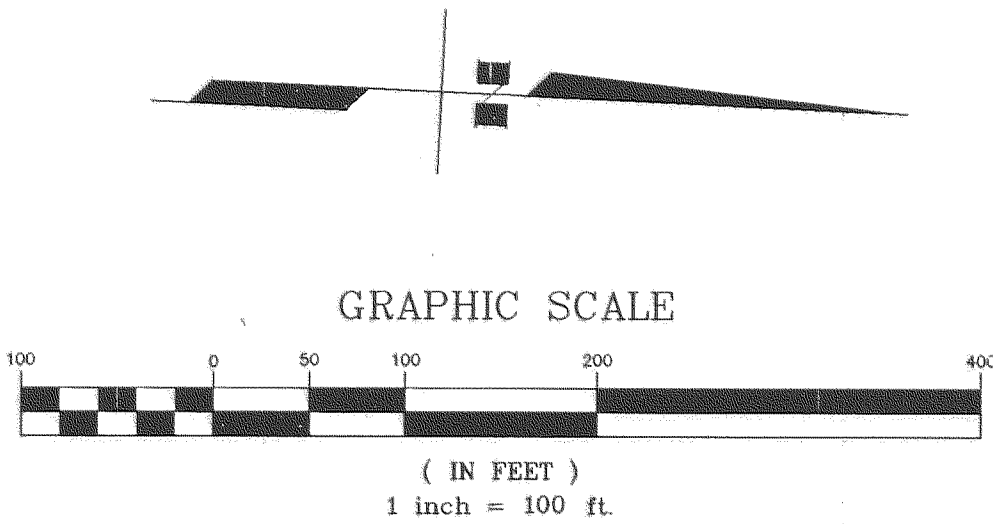


SURVEYOR'S CERTIFICATE

I HEREBY CERTIFY THAT I AM PROPERLY REGISTERED AND LICENSED TO PRACTICE LAND SURVEYING IN THE STATE OF ALASKA, AND THAT THIS DRAWING REPRESENTS A SURVEY MADE BY ME OR UNDER MY DIRECT SUPERVISION, AND THAT THE MONUMENTS SHOWN HEREON ACTUALLY EXIST AS DESCRIBED, AND THAT ALL DIMENSIONS AND OTHER DETAILS ARE CORRECT TO THE EXTENT SHOWN HEREON.

Lendle C. Story
LENDLE C. STORY, L.S. 7843

DATE 1-5-04

BY	DATE	REVISIONS

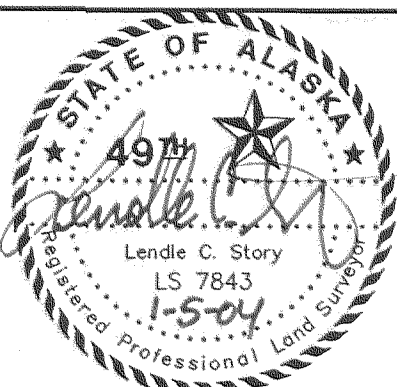

STATE OF ALASKA
DEPARTMENT OF TRANSPORTATION
AND PUBLIC FACILITIES
CENTRAL REGION-DESIGN AND CONSTRUCTION

APPROVED: _____ DESIGN SECTION CHIEF
APPROVED: _____ PROJECT MANAGER

DATE: 12-05-03
DESIGN: DSN
DRAWN: KSLP
CHECKED: LCS

CHENEGA BAY AIRPORT
RESURFACING & LIGHTING
AKSAS PROJECT No. 56445

CONTROL DIAGRAM

SHEET
4
OF
9

Project: 031196 Survey control, 1=100, 01/05/04 at 13:20 by kslp
VIEW: Full Half
XREF: 1196BDO1