


Project: 03\031196\Survey\control, 1=100, 01/05/04 at 13:20 by kslp
VIEW: Full, Half
XREF: 1196BD01

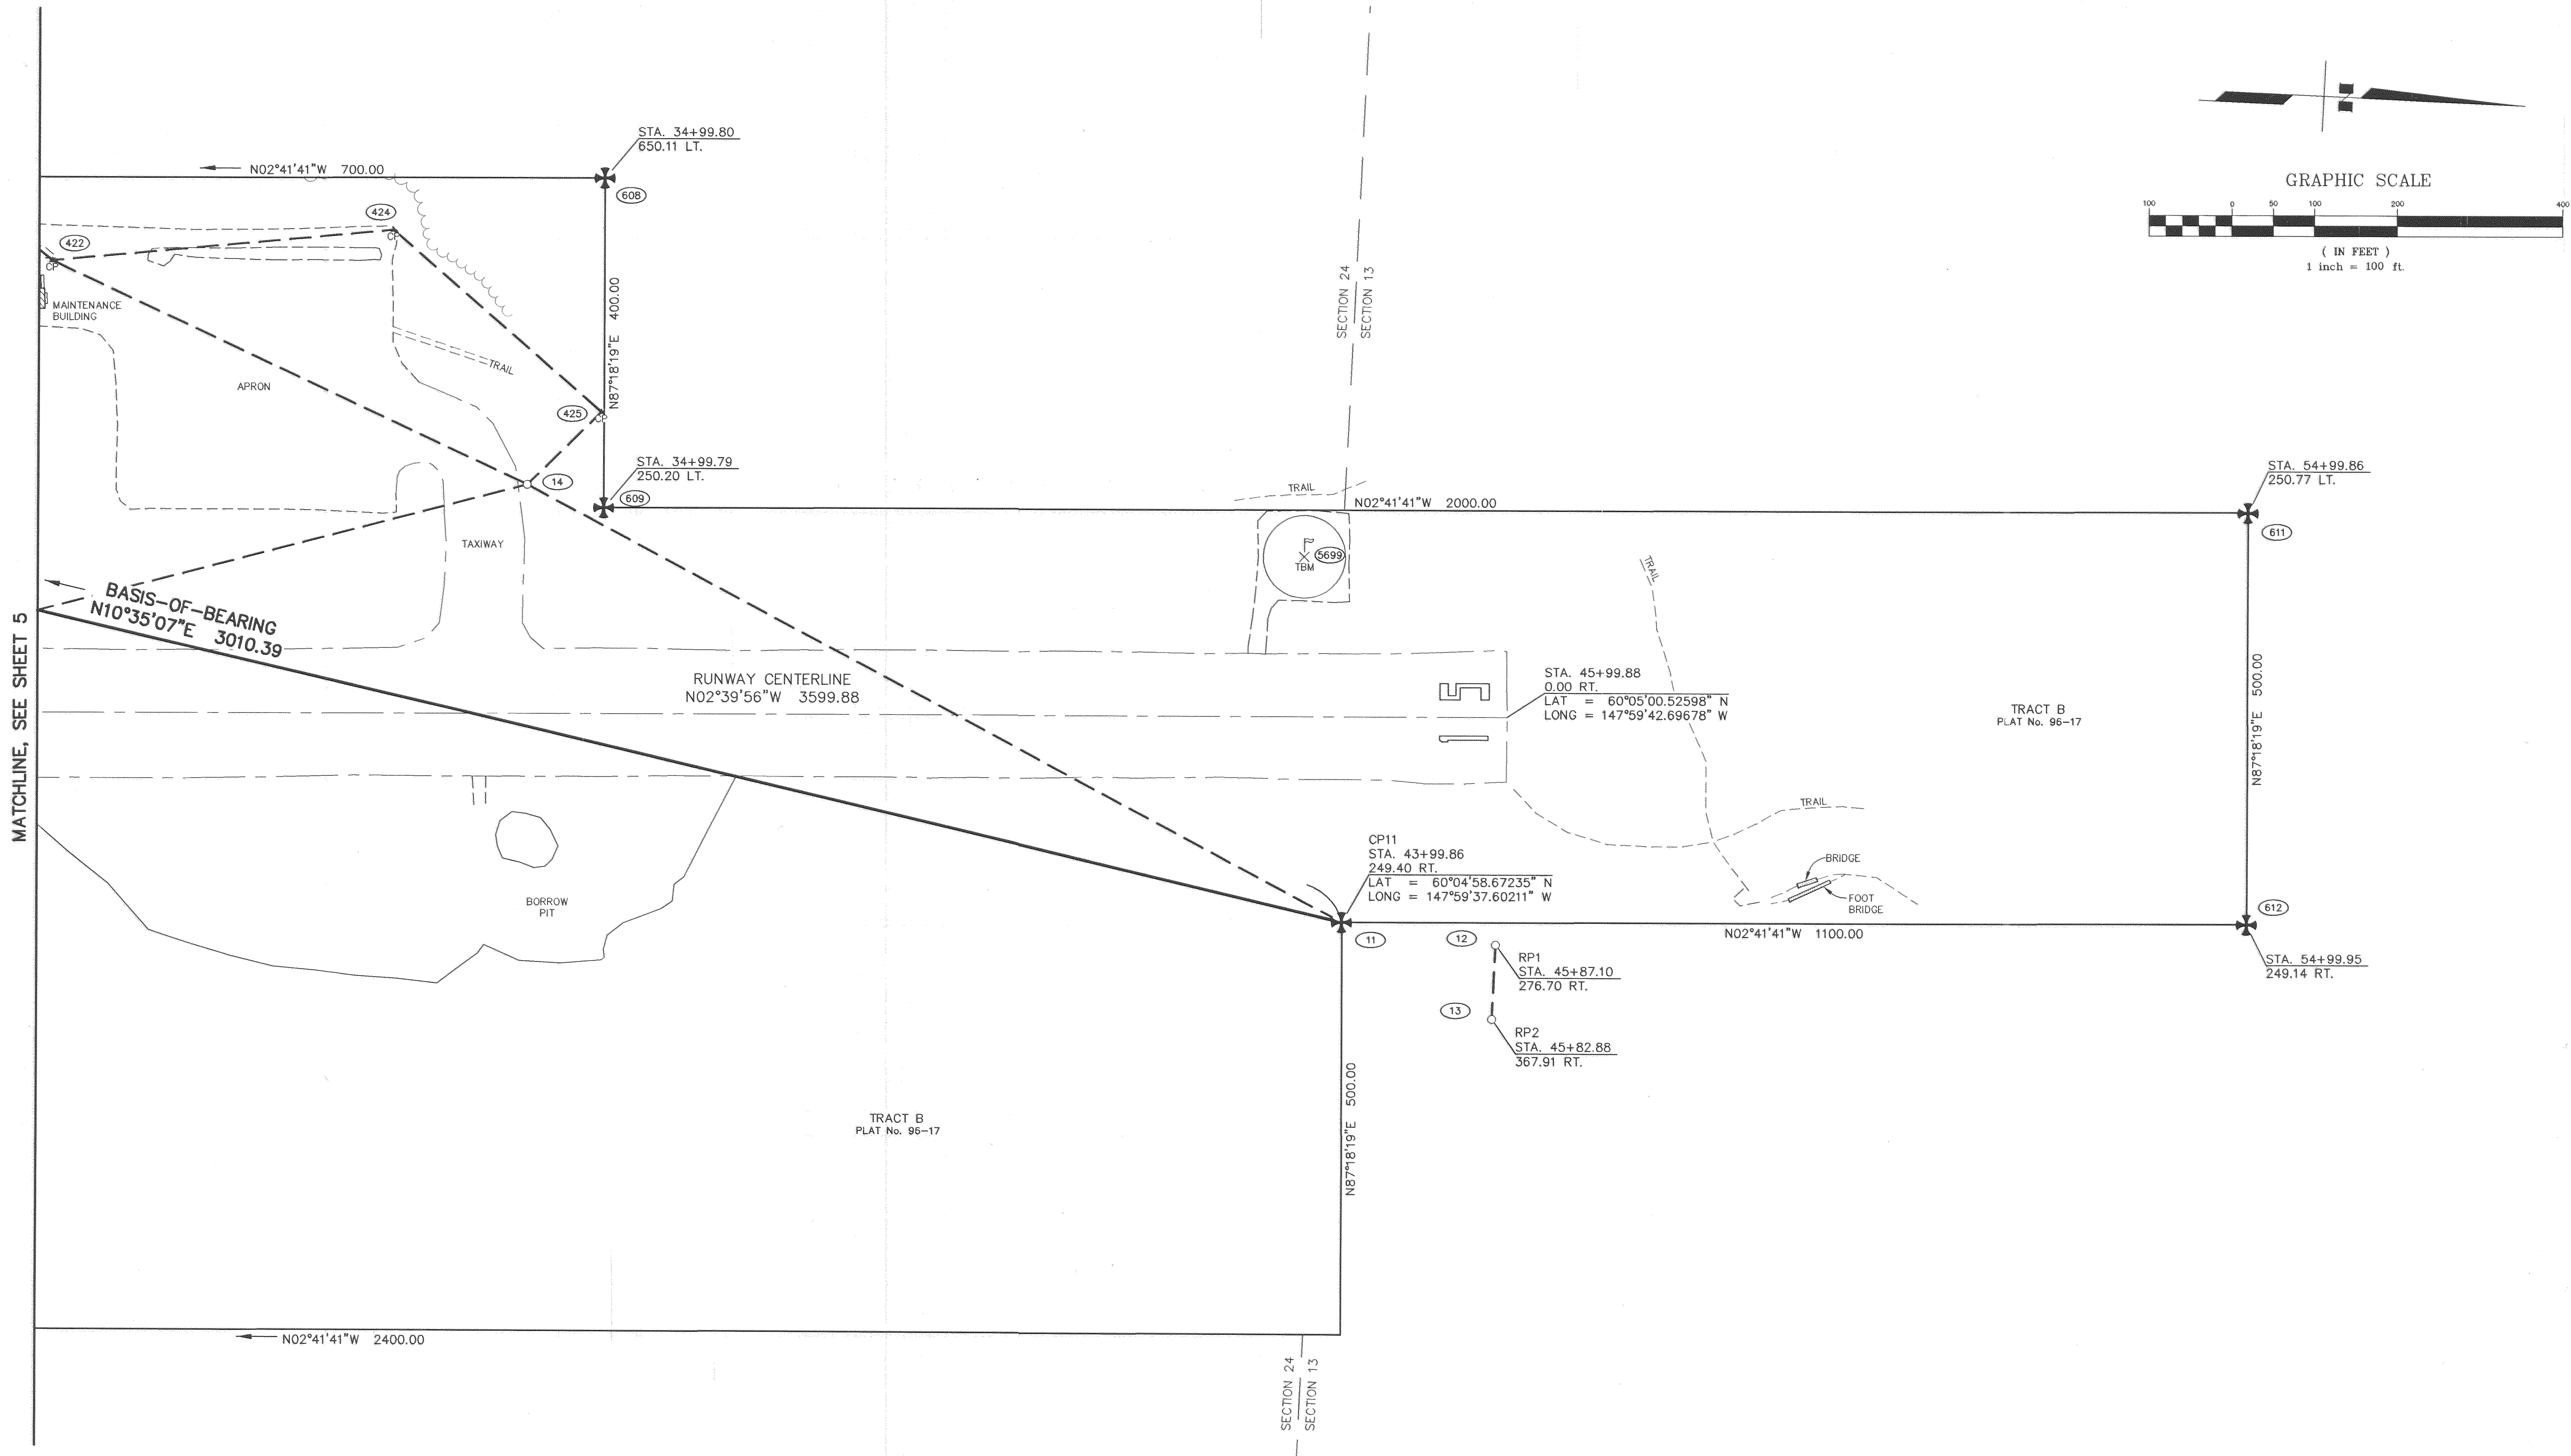

SURVEYOR'S CERTIFICATE

I HEREBY CERTIFY THAT I AM PROPERLY REGISTERED AND LICENSED TO PRACTICE LAND SURVEYING IN THE STATE OF ALASKA, AND THAT THIS DRAWING REPRESENTS A SURVEY MADE BY ME OR UNDER MY DIRECT SUPERVISION, AND THAT THE MONUMENTS SHOWN HEREON ACTUALLY EXIST AS DESCRIBED, AND THAT ALL DIMENSIONS AND OTHER DETAILS ARE CORRECT TO THE EXTENT SHOWN HEREON.

LENDLE C. STORY, L.S. 7843

DATE 1-5-04

BY	DATE	REVISIONS



STATE OF ALASKA DEPARTMENT OF TRANSPORTATION AND PUBLIC FACILITIES CENTRAL REGION-DESIGN AND CONSTRUCTION	
APPROVED: _____	DESIGN SECTION CHIEF
APPROVED: _____	PROJECT MANAGER

DATE: 12-05-03
DESIGN: DSN
DRAWN: KSLP
CHECKED: LCS

CHENEGA BAY AIRPORT
RESURFACING & LIGHTING
AKSAS PROJECT No. 56445
CONTROL DIAGRAM