

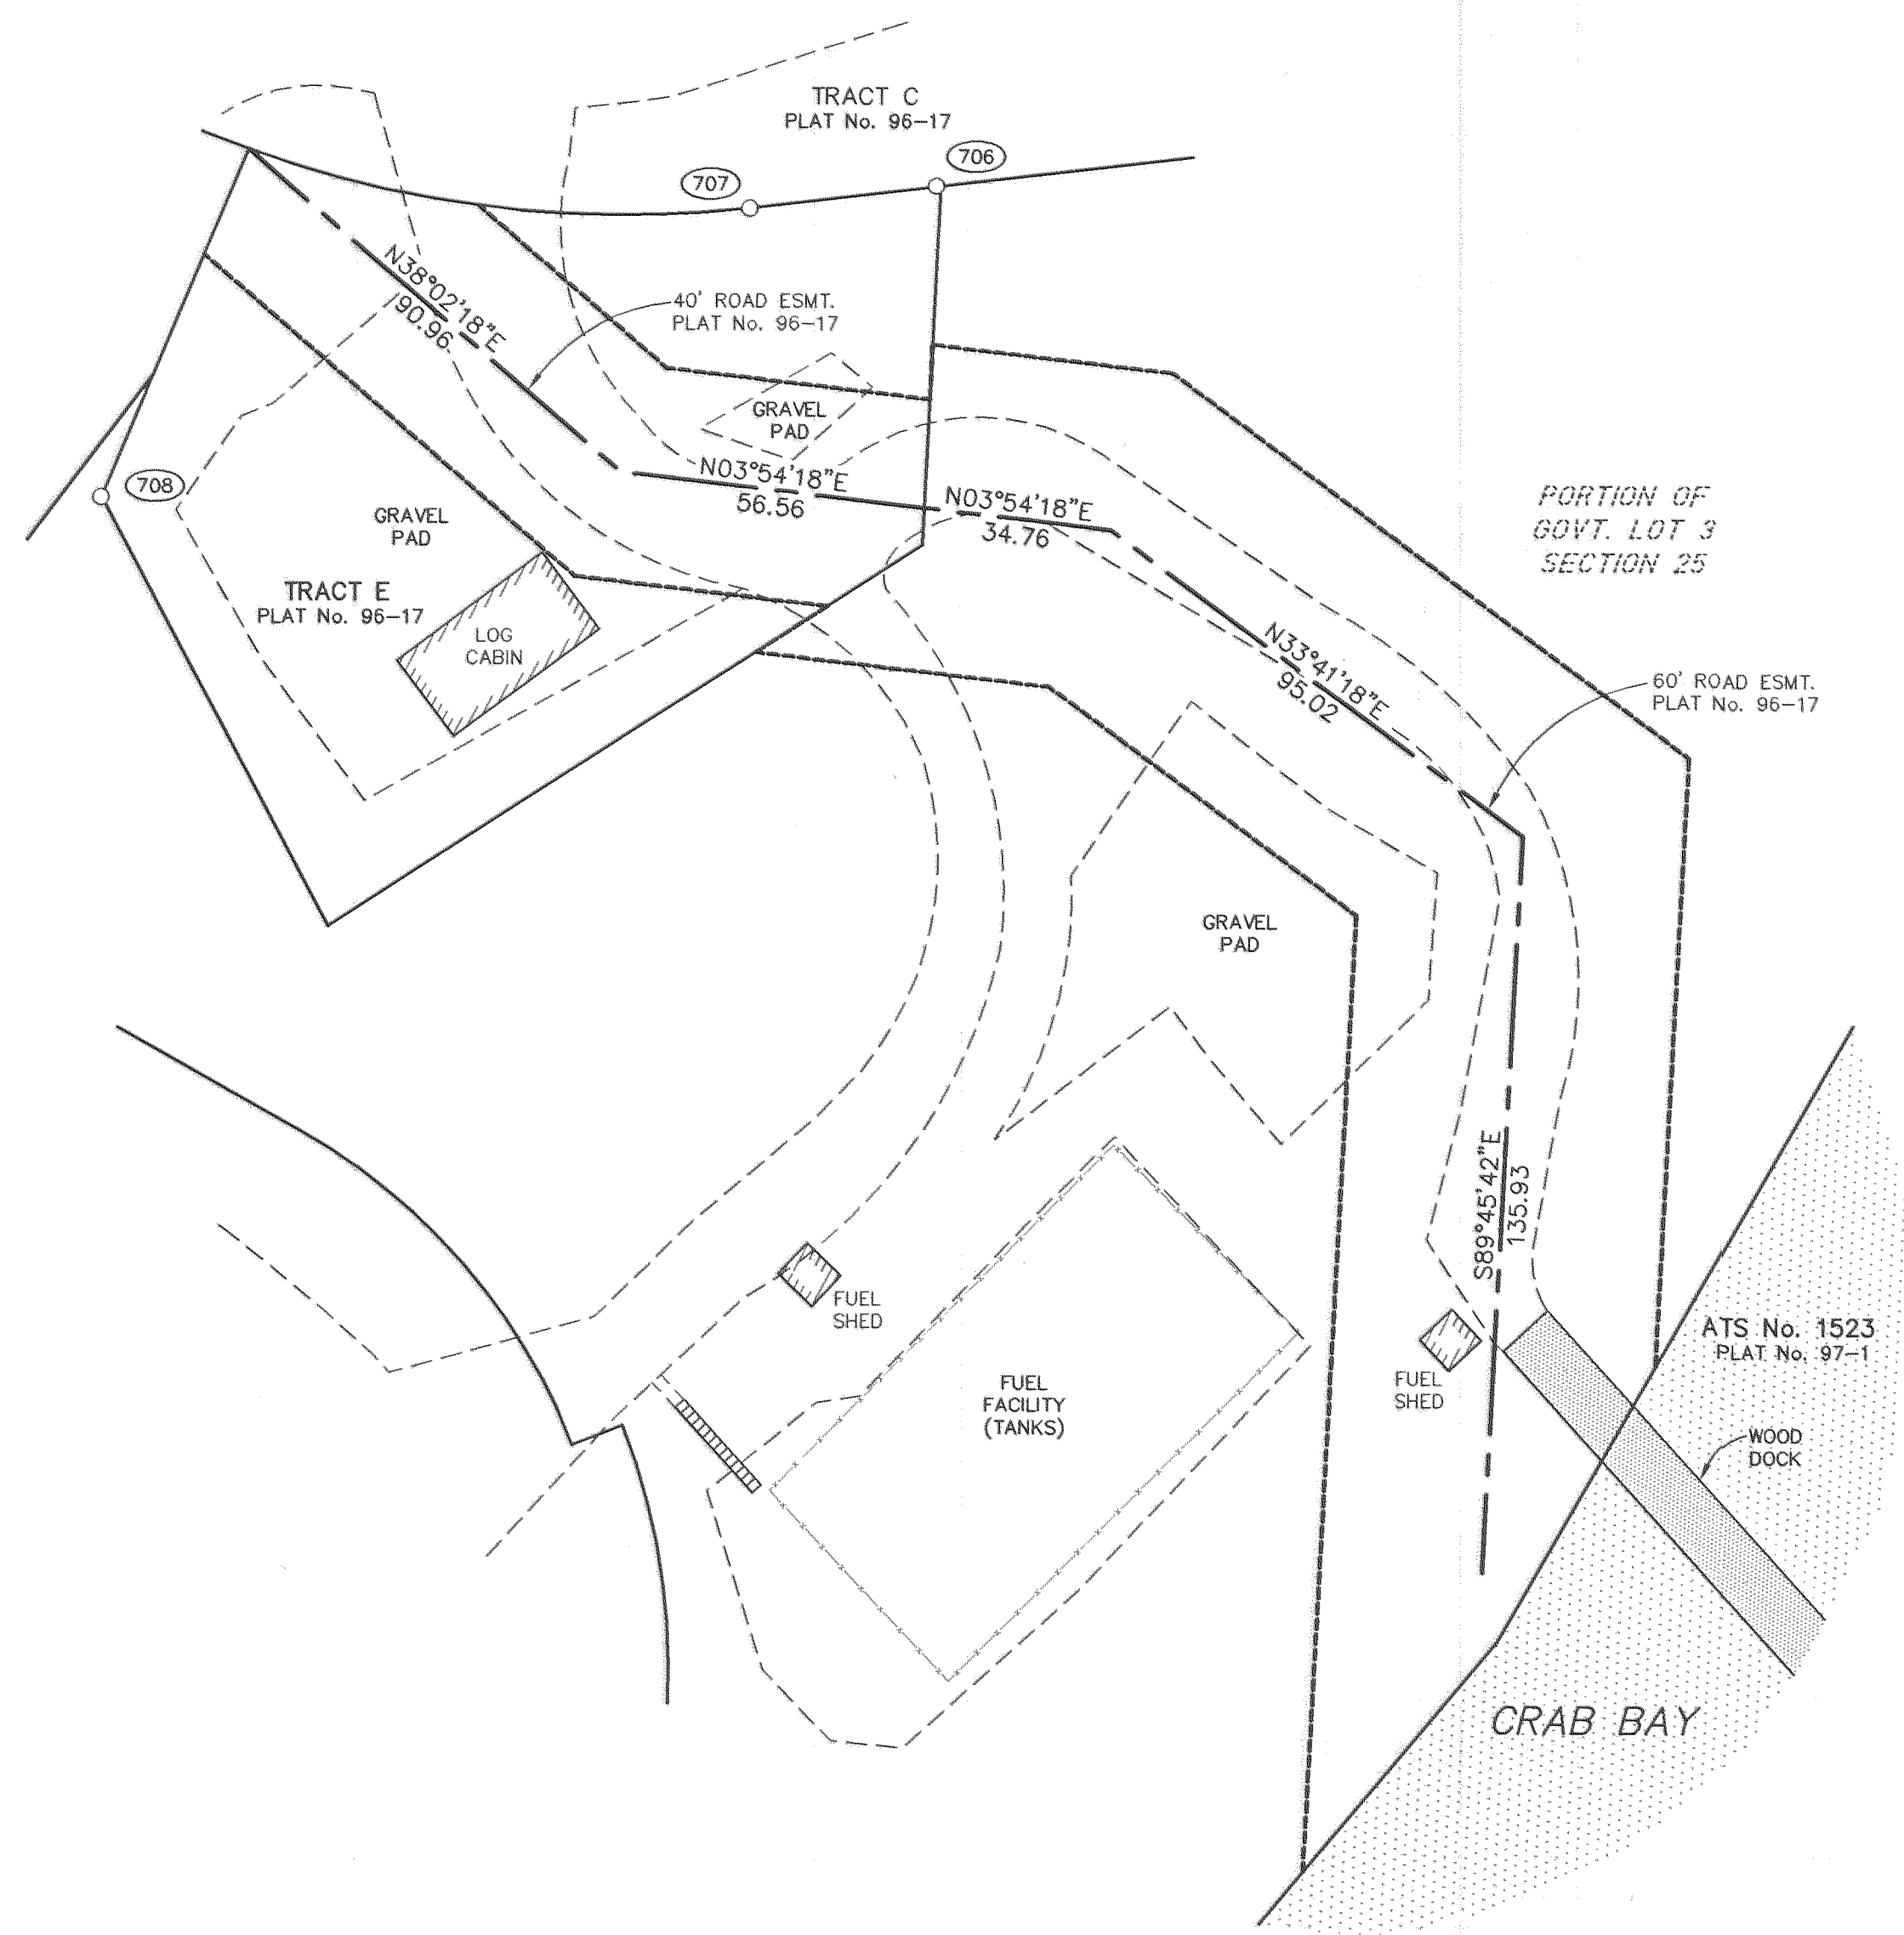


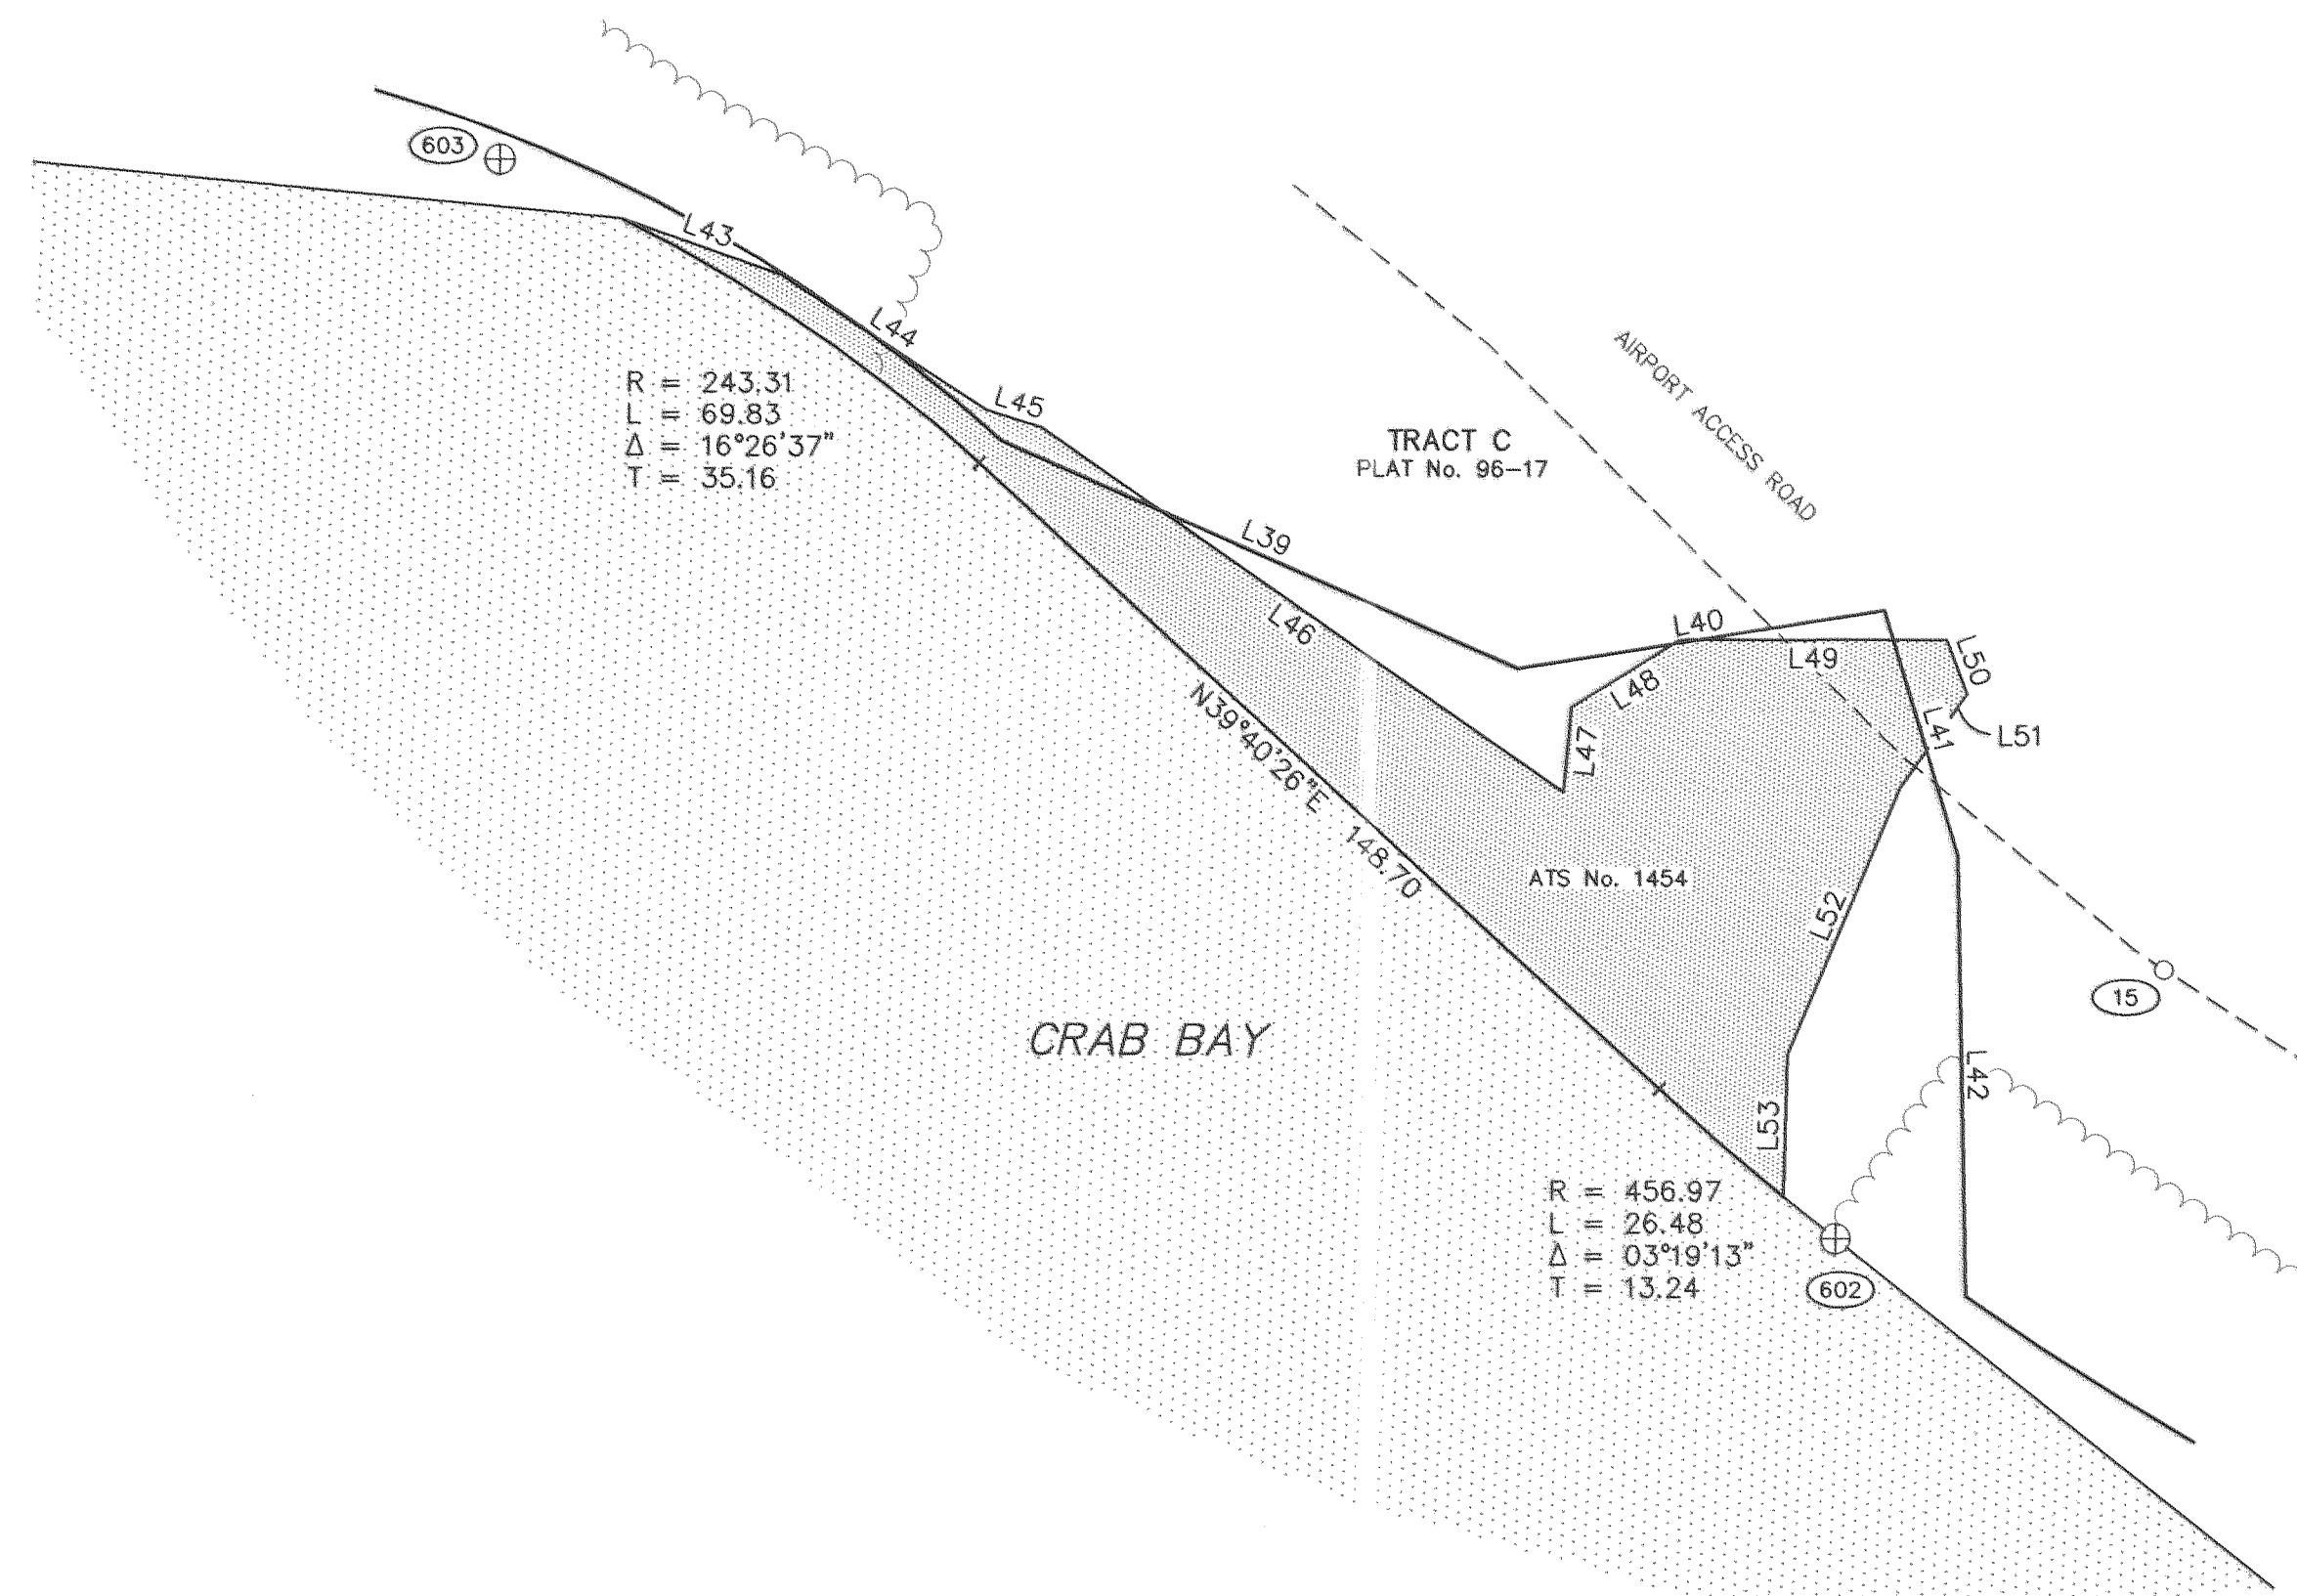

DETAIL "A"
SEE SHEET 3

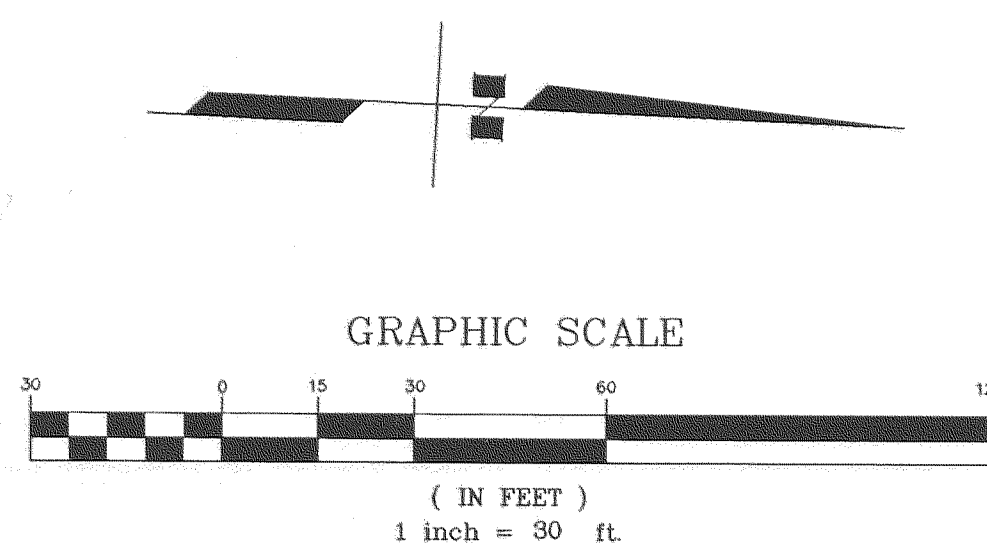

DETAIL "B"
SEE SHEET 4

LINE TABLE		
LINE No.	BEARING	LENGTH
L39	N20°49'02"E	91.08
L40	N11°44'52"W	59.54
L41	S70°29'08"W	41.11
L42	S86°02'08"W	70.61
L43	N16°28'18"E	27.32
L44	N30°32'53"E	39.49
L45	N14°16'47"E	9.20
L46	N31°59'25"E	102.40
L47	N87°40'15"W	13.71
L48	N34°45'36"W	20.47
L49	N02°50'50"W	42.95
L50	N66°49'27"E	9.33
L51	S57°32'58"E	18.64
L52	S70°03'04"E	46.32
L53	N88°34'37"E	22.88


SURVEYOR'S CERTIFICATE

I HEREBY CERTIFY THAT I AM PROPERLY REGISTERED AND LICENSED TO PRACTICE LAND SURVEYING IN THE STATE OF ALASKA, AND THAT THIS DRAWING REPRESENTS A SURVEY MADE BY ME OR UNDER MY DIRECT SUPERVISION, AND THAT THE MONUMENTS SHOWN HEREON ACTUALLY EXIST AS DESCRIBED, AND THAT ALL DIMENSIONS AND OTHER DETAILS ARE CORRECT TO THE EXTENT SHOWN HEREON.

Lendle C. Story
LENDLE C. STORY, L.S. 7843

DATE 1-5-04

BY	DATE	REVISIONS

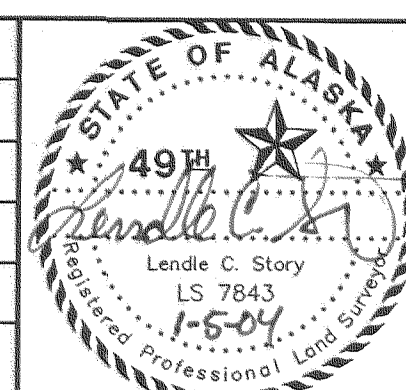

STATE OF ALASKA
DEPARTMENT OF TRANSPORTATION
AND PUBLIC FACILITIES
CENTRAL REGION-DESIGN AND CONSTRUCTION

APPROVED: _____
DESIGN SECTION CHIEF

APPROVED: _____
PROJECT MANAGER

DATE: 12-05-03
DESIGN: DSN
DRAWN: KSLP
CHECKED: LCS

CHENEGA BAY AIRPORT
RESURFACING & LIGHTING
AKSAS PROJECT No. 56445

CONTROL DIAGRAM

SHEET
7
OF
9