


- LEGEND
- Survey Control Point
 - Govt. Control Station
 - Temporary Benchmark
 - Benchmark
 - Point Number Identifier

DWG Path: [Drawing Path]

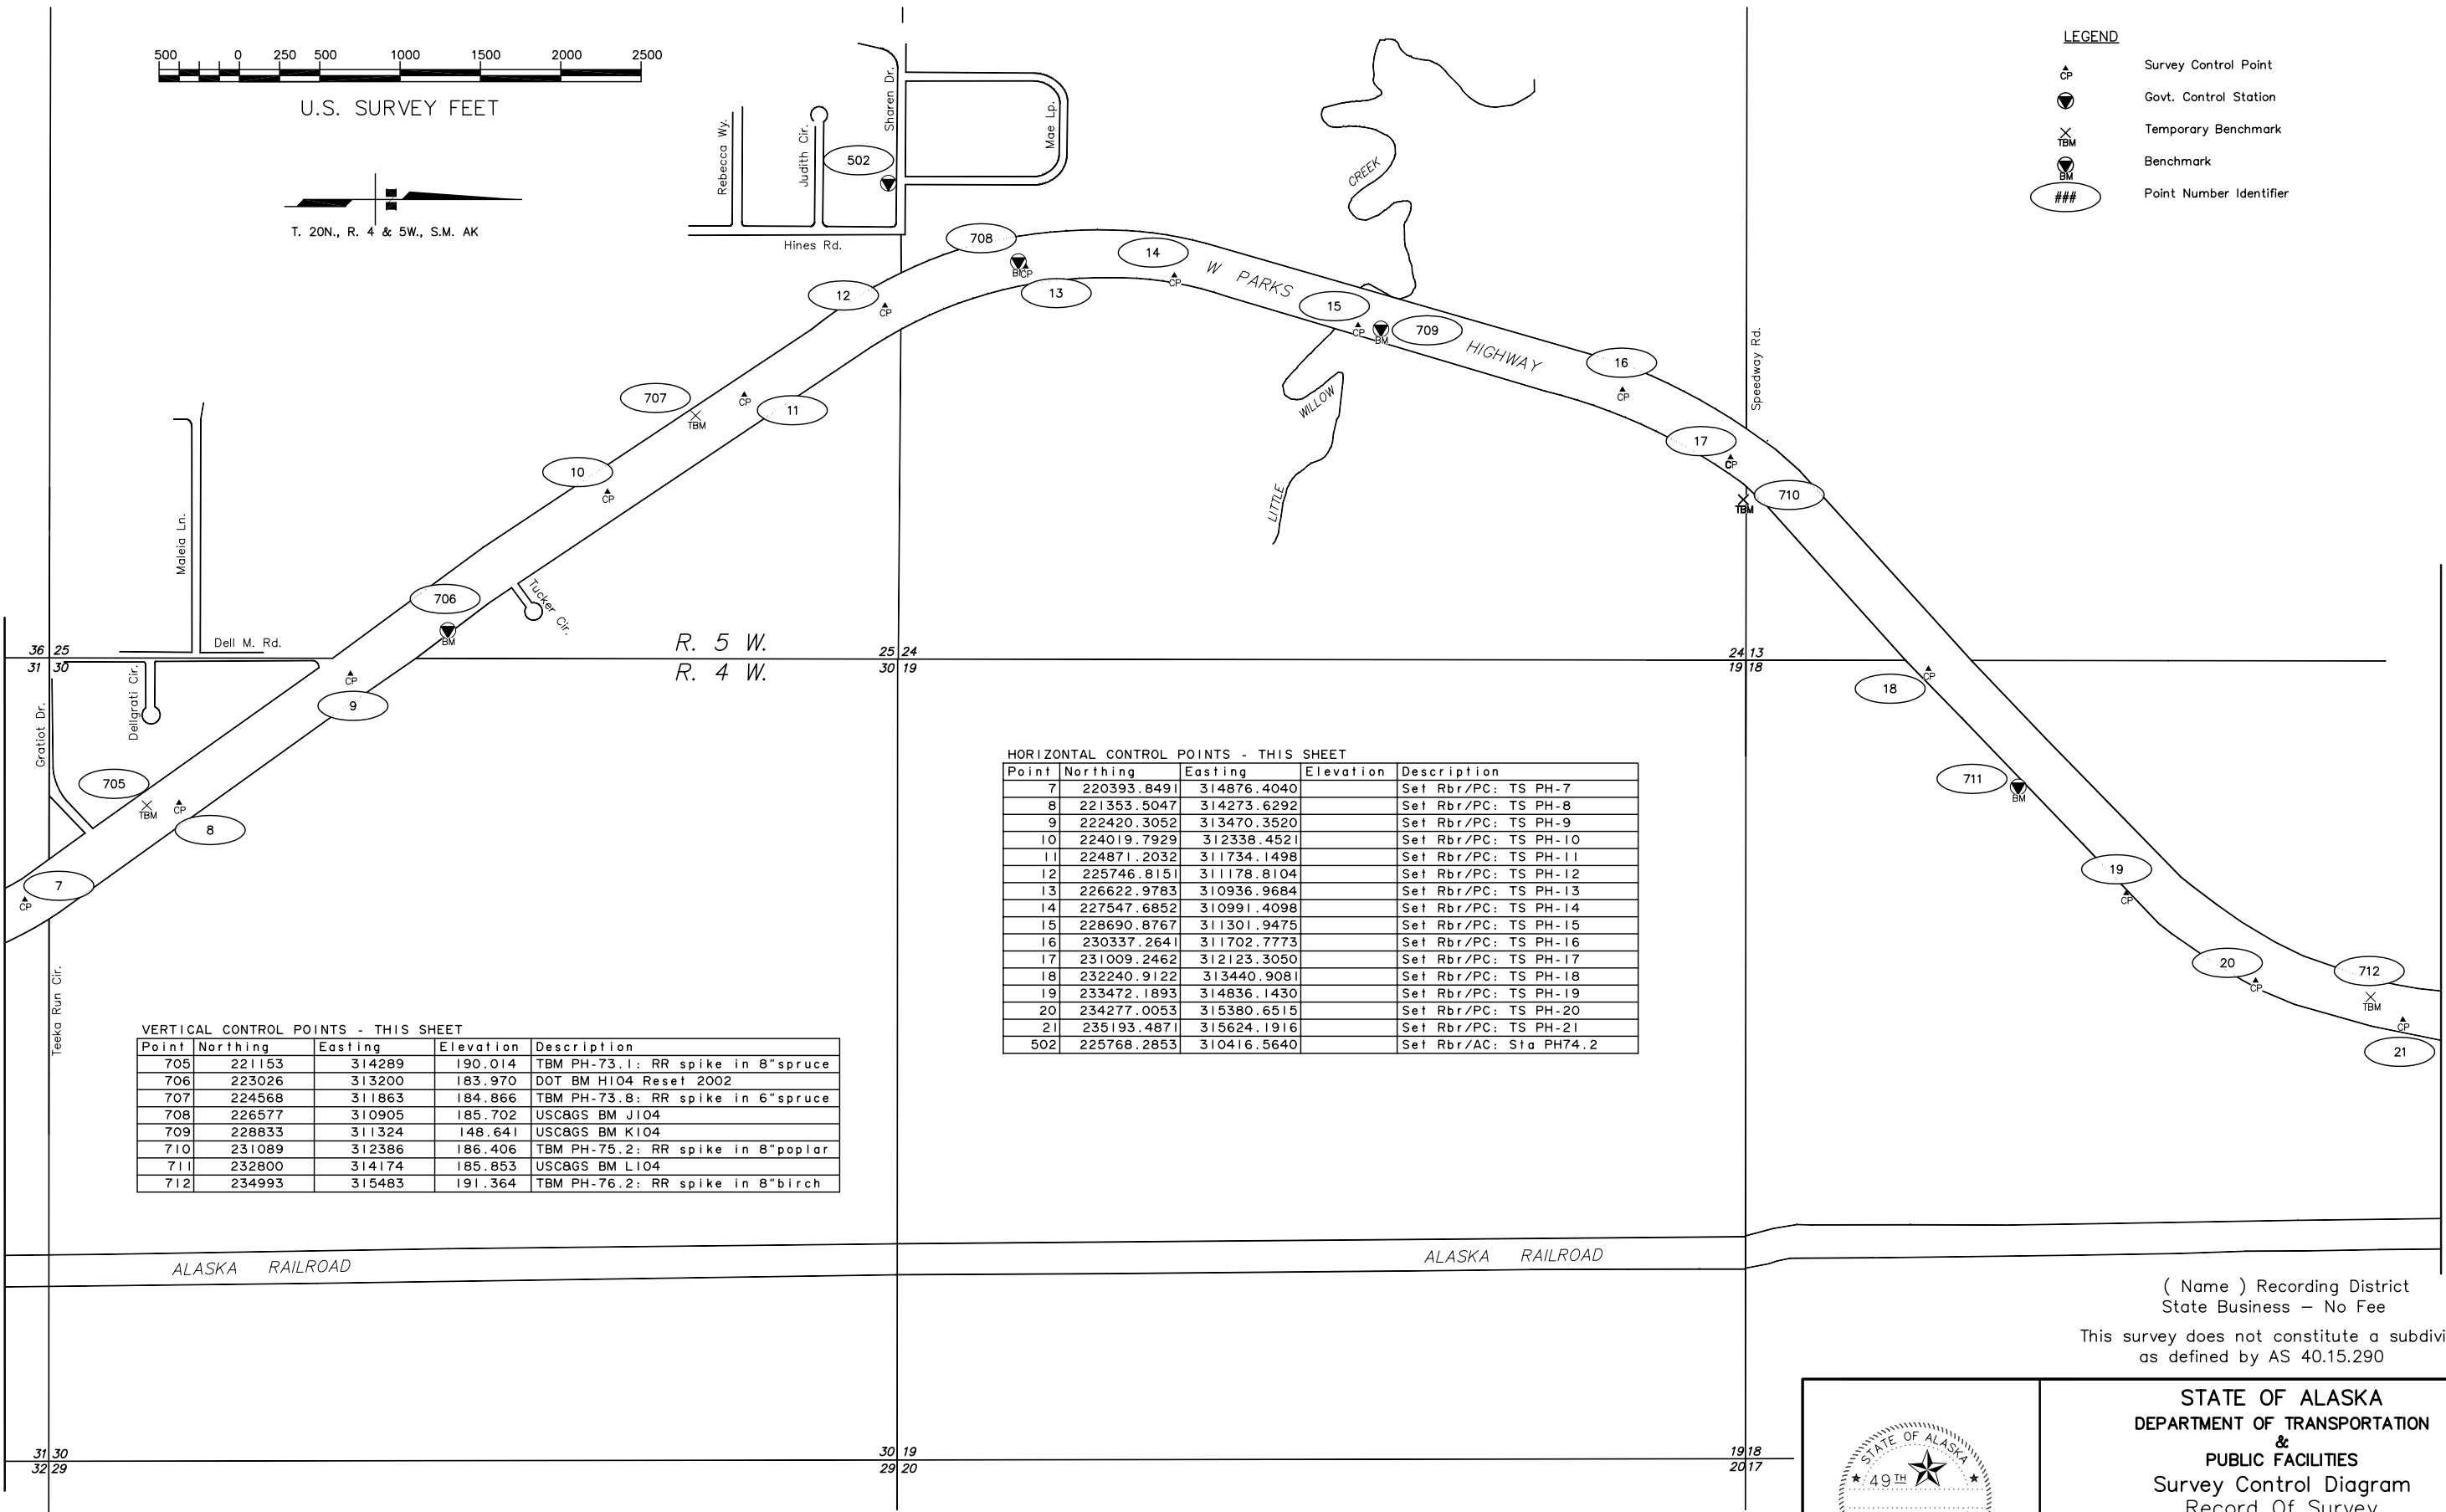

VERTICAL CONTROL POINTS - THIS SHEET

Point	Northing	Easting	Elevation	Description
705	221153	314289	190.014	TBM PH-73.1: RR spike in 8"spruce
706	223026	313200	183.970	DOT BM H104 Reset 2002
707	224568	311863	184.866	TBM PH-73.8: RR spike in 6"spruce
708	226577	310905	185.702	USC&GS BM J104
709	228833	311324	148.641	USC&GS BM K104
710	231089	312386	186.406	TBM PH-75.2: RR spike in 8"poplar
711	232800	314174	185.853	USC&GS BM L104
712	234993	315483	191.364	TBM PH-76.2: RR spike in 8"birch

HORIZONTAL CONTROL POINTS - THIS SHEET

Point	Northing	Easting	Elevation	Description
7	220393.8491	314876.4040		Set Rbr/PC: TS PH-7
8	221353.5047	314273.6292		Set Rbr/PC: TS PH-8
9	222420.3052	313470.3520		Set Rbr/PC: TS PH-9
10	224019.7929	312338.4521		Set Rbr/PC: TS PH-10
11	224871.2032	311734.1498		Set Rbr/PC: TS PH-11
12	225746.8151	311178.8104		Set Rbr/PC: TS PH-12
13	226622.9783	310936.9684		Set Rbr/PC: TS PH-13
14	227547.6852	310991.4098		Set Rbr/PC: TS PH-14
15	228690.8767	311301.9475		Set Rbr/PC: TS PH-15
16	230337.2641	311702.7773		Set Rbr/PC: TS PH-16
17	231009.2462	312123.3050		Set Rbr/PC: TS PH-17
18	232240.9122	313440.9081		Set Rbr/PC: TS PH-18
19	233472.1893	314836.1430		Set Rbr/PC: TS PH-19
20	234277.0053	315380.6515		Set Rbr/PC: TS PH-20
21	235193.4871	315624.1916		Set Rbr/PC: TS PH-21
502	225768.2853	310416.5640		Set Rbr/AC: Sta PH74.2

NOTES:
Refer to Sheet 1 for Notes, Certificates, and Control Information.

(Name) Recording District
State Business - No Fee
This survey does not constitute a subdivision
as defined by AS 40.15.290



STATE OF ALASKA
DEPARTMENT OF TRANSPORTATION
&
PUBLIC FACILITIES
Survey Control Diagram
Record Of Survey
(Federal Project No.)
(Project Name)

WITHIN T. 19 N., R. 4 W. : T. 20N, R. 4&5W. & T. 21N., R. 4W. S.M. AK

DRAWN	RMK	DATE	10/22/2002	SCALE	1"=500'
CHECKED	MHS	DATE	10/30/2002	SHEET	2 OF 5