



NOTES:
Refer to Sheet 1 for Notes, Certificates, and Control Information.

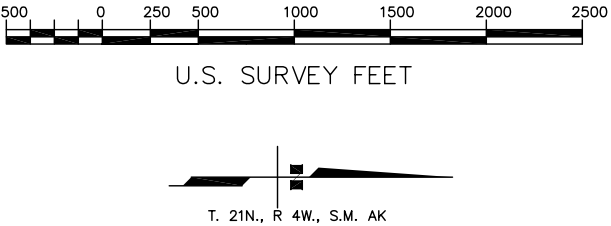

- LEGEND
- Survey Control Point
 - Govt. Control Station
 - Temporary Benchmark
 - Benchmark
 - Point Number Identifier

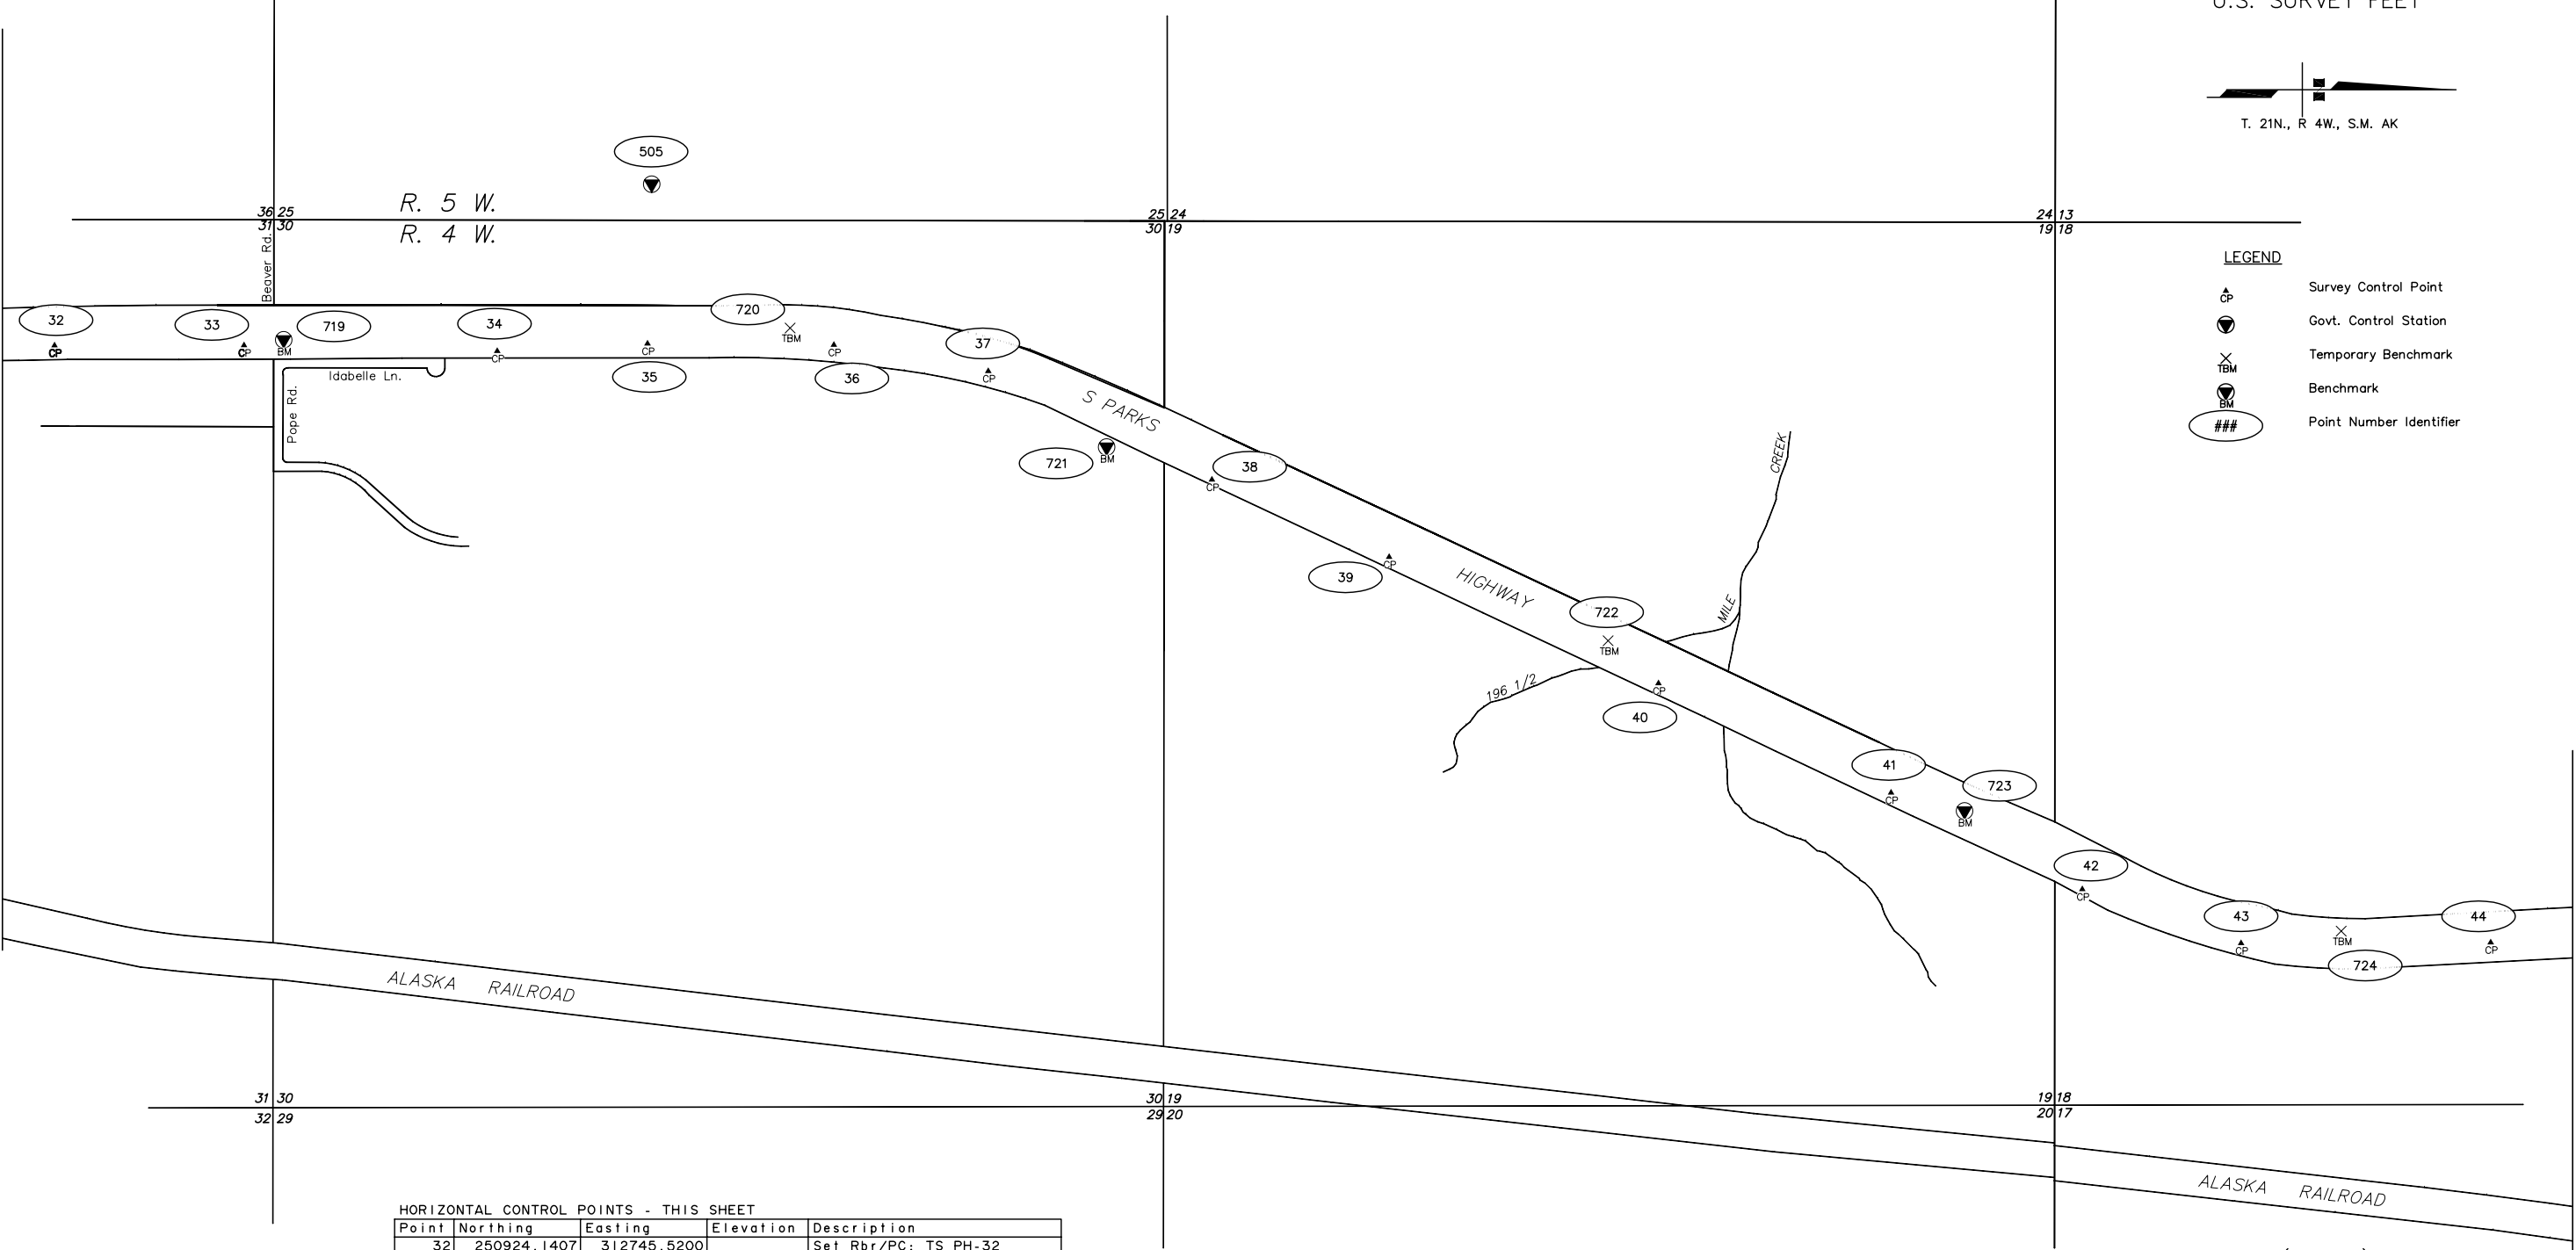

HORIZONTAL CONTROL POINTS - THIS SHEET				
Point	Northing	Easting	Elevation	Description
32	250924.1407	312745.5200		Set Rbr/PC: TS PH-32
33	252047.5120	312744.5843		Set Rbr/PC: TS PH-33
34	253548.4669	312778.4484		Set Rbr/PC: TS PH-34
35	254439.1914	312734.7097		Set Rbr/PC: TS PH-35
36	255544.0216	312742.0910		Set Rbr/PC: TS PH-36
37	256459.2000	312897.5348		Set Rbr/PC: TS PH-37
38	257784.8081	313541.2837		Set Rbr/PC: TS PH-38
39	258835.3098	313999.4116		Set Rbr/PC: TS PH-39
40	260431.8607	314748.6383		Set Rbr/PC: TS PH-40
41	261810.5924	315397.1774		Set Rbr/PC: TS PH-41
42	262944.2364	315969.5135		Set Rbr/PC: TS PH-42
43	263885.4150	316289.5904		Set Rbr/PC: TS PH-43
44	265365.1035	316284.9974		Set Rbr/PC: TS PH-44
505	254463.9714	311788.9399		Set Rbr/AC: Sta PH80.0

VERTICAL CONTROL POINTS - THIS SHEET				
Point	Northing	Easting	Elevation	Description
719	252283	312712	224.586	USCBGS BM Q104
720	255284	312642	197.678	TBM PH-80.2: RR spike in 10"birch
721	257161	313348	190.872	DOT BM R104 Reset 2002
722	260134	314496	163.173	TBM PH-81.2: RR spike in 6" poplar
723	262246	315505	189.888	DOT BM S104 Reset 2002
724	264479	316218	200.010	TBM PH-82.0: RR spike in 12"birch

(Name) Recording District
State Business – No Fee
This survey does not constitute a subdivision
as defined by AS 40.15.290



STATE OF ALASKA DEPARTMENT OF TRANSPORTATION & PUBLIC FACILITIES Survey Control Diagram Record Of Survey (Federal Project No.) (Project Name)			
WITHIN T. 19 N., R. 4W. : T.20N.,R.4&5W. & T. 21N., R. 4W. S.M. AK			
DRAWN	RMK	DATE	10/22/2002
CHECKED	MHS	DATE	10/30/2002
SCALE		1"=500'	
SHEET		4 OF 5	