

Change Order Items.

MT EDGE CUMBE HIGH SCHOOL
BUILDING 1330
ACADEMIC EXPANSION

Project Number 67751C
Sitka, Alaska
DECEMBER 13, 2004

- 10 Windows = sheet 3
- 2 LAB EQUIPMENT: sheet 57
- 3 Data Relocation: 73
- 4 Science TABLES: provided to MEHS.
- 5 Insect DAMAGE: sheet 8, 13
- 6 Sprinkler Additions: for construction only.
- 7 Additional Circuits: 72
- 8 Wall Carpet Base: 14
- 9 Lounge Remodel: 70
- 10 Existing Fuel Line Removal: 37, 56
- 11 Dry Wall Piping: 56
- 12 Concrete Placement: sheets 8, 34

CONTRACTOR: McGraw's Custom Construction
PROJECT ENGINEER: DON NEWELL
BEGIN DATE: 3-7-05
END DATE: 8-30-06


SHEET INDEX

ARCHITECT JENSEN YORBA LOTT, INC 522 WEST 10TH STREET JUNEAU, ALASKA 99801 (907) 586-1070 FAX (907) 586-3959		STRUCTURAL ENGINEER PERATROVICH, NOTTINGHAM & DRAGE, INC 3220 HOSPITAL DRIVE, SUITE 200 JUNEAU, ALASKA 99801 (907) 586-2093 FAX (907) 586-2099		MECHANICAL ENGINEER MURRAY & ASSOCIATES, P.C. P.O. BOX 21081 JUNEAU, AK 99802 (907) 780-6151 FAX (907) 780-6182		ELECTRICAL ENGINEER HAIGHT & ASSOCIATES, INC. 526 MAIN STREET JUNEAU, ALASKA 99801 (907) 586-9788 FAX (907) 586-5774	
A001	TITLE SHEET	A601	REFLECTED CEILING PLAN - MAIN FLOOR SCIENCE WING	S100	STRUCTURAL GENERAL NOTES	M001	SCHEDULES SYMBOLS
A002	ALTERNATE LEGEND	A602	REFLECTED CEILING PLAN - MECHANICAL MEZZANINE	S101	SHEAR WALL DIAGRAMS	M101	DEMOLITION FLOOR PLAN - BUILDING A SCIENCE ROOM
A003	SCHEDULES	A603	REFLECTED CEILING PLAN - CLASSROOM 128 & 129	S200	FOUNDATION PLAN - SCIENCE WING BASE BID	M201	FOUNDATION PLAN BUILDING C
A101	DEMOLITION PLAN	A701	EXTERIOR CONCRETE RAMP AND STEEL RAILING	S201	FOUNDATION DETAILS	M202	FLOOR PLAN - PIPING BUILDING C PART FLOOR PLAN - ALTERNATE
A201	OVERALL PLAN	A702	EXTERIOR STAIRS AND RAILING	S202	FOUNDATION DETAILS	M203	ATTIC FLOOR PLAN - PIPING BUILDING C AND B
A202	MAIN FLOOR PLAN - SCIENCE WING	A703	INTERIOR STAIRS	S203	FOUNDATION DETAILS	M204	FLOOR PLAN - BUILDING A CLASSROOMS
A203	MECHANICAL MEZZANINE PLAN	A801	EXTERIOR DETAILS	S300	2ND FLR FRAMING PLAN - MECH RM	M302	FLOOR PLAN VENTILATION BUILDING C
A204	ENLARGED FLOOR PLANS	A802	EXTERIOR DETAILS	S301	STRUCTURAL DETAILS	M303	ATTIC FLOOR PLAN - DUCTWORK BUILDING C
A205	ROOF PLAN - SCIENCE WING	A803	EXTERIOR DETAILS	S302	STRUCTURAL DETAILS	M401	ENLARGED FAN ROOM PLAN BUILDING C
A301	EXTERIOR ELEVATIONS	A804	EXTERIOR DETAILS	S400	ROOF FRAMING PLAN	M402	ENLARGED FAN ROOM SECTION BUILDING C
A302	EXTERIOR ELEVATIONS	A900	INTERIOR SIGNAGE	S401	ROOF FRAMING DETAILS	M501	PIPING DIAGRAMS
A303	BUILDING SECTIONS	A901	INTERIOR DETAILS	S402	ROOF FRAMING DETAILS	M502	PIPING DIAGRAMS
A304	BUILDING SECTIONS	L101	LANDSCAPE PLAN	S403	DETAILS	M601	CONTROL
A305	BUILDING SECTIONS	L102	LANDSCAPE PLAN			M701	MECHANICAL DETAILS
A306	EXTERIOR WALL SECTIONS	L103	LANDSCAPE DETAILS			M702	MECHANICAL DETAILS
A307	INTERIOR WALL SECTIONS						
A501	INTERIOR ELEVATIONS						
A502	INTERIOR ELEVATIONS						
A503	INTERIOR ELEVATIONS						
A504	INTERIOR ELEVATIONS						
E100	DEMOLITION PHOTOS						
E200	ELECTRICAL MASTER PLAN, LEGEND						
E201	PARTIAL LIGHTING DEMOLITION PLAN, PARTIAL POWER/SIGNAL DEMOLITION PLAN						
E202	FIRST FLOOR POWER						
E203	MECHANICAL ROOM 201 POWER/SIGNAL, EXISTING MECHANICAL ROOM						
E204	MECHANICAL ROOM ALTERNATE PLANS						
E205	PANEL SCHEDULES						
E206	FIRE ALARM DIAGRAMS, WIRING DIAGRAMS						
E207	SINGLE LINE DIAGRAMS						
E301	FIRST FLOOR PLAN - LIGHTING, SECOND FLOOR PLAN LIGHTING						
E302	LUMINAIRE SCHEDULE						

ABBREVIATIONS

A	AND	CT	CERAMIC TILE	FLR	FLOOR	LB	POUND
ANGLE	CTR	CNT	CENTER	FLUOR	FLUORESCENT	LOCKR	LOCKER
AT	CTSK	CNTSK	COUNTERSUNK	FOF	FACE OF FINISH	M	MIRROR
CENTERLINE	DBL	DOUBLE	DOUBLE	FOF	FACE OF FINISH	MAX	MAXIMUM
DIAMETER	DEPT	DEPTH	DEPTH	FRP	FIBERGLASS REINFORCED	MD	MEDIUM DENSITY
NUMBER	DR	DOOR	DOOR	FRF	FIRE RETARDANT	MECH	MECHANICAL
ACOUST	ACOUSTICAL	DET	DETAIL	FSR	FLEXIBLE SHEET ROOFING	MEMB	MEMBRANE
AC	ASPHALT CONCRETE	DIA	DIAMETER	FT	FOOT OR FEET	MFR	MANUFACTURER
ACM	ASBESTOS CONTAINING MATERIAL	DISP	DISPENSER	FTG	FOOTING	MH	MANHOLE
ADP	ACOUSTICAL PANEL	DN	DOWN	FUR	FURRING	MIN	MINIMUM
ADJ	ADJUSTABLE	DR	DOOR	FUT	FUTURE	MISC	MISCELLANEOUS
AFC	ABOVE FINISH FLOOR	DS	DOWNSPOUT	GA	GAUGE	MD	MASONRY OPENING
AFS	AIR INFILTRATION BARRIER	DWG	DRAWING	CA	CALCULATED	MTD	MOUNTED
AL	ALUMINUM	DWR	DRAWER	CB	CORNER BASE	MTL	METAL
AP	ACCOUSTICAL PANEL	E	EAST	GL	GLASS	MUL	MULLION
APPROX	APPROXIMATE	EA	EACH	GR	GRADE	N	NORTH
ARCH	ARCHITECTURAL	EF	EXHAUST FAN	GT	TEMPERED GLASS, 1/4"	NC	NOT IN CONTRACT
ASB	ASBESTOS	EJS	EXTERIOR INSULATION & FINISH SYSTEM	GW	WIRE GLASS, 1/4"	NO OR	NO OR
AST	ABOVE GROUND STORAGE TANK	EJ	EXPANSION JOINT	OW	GYPSON WALL BOARD	NOM	NOMINAL
BO	BOARD	EL	ELEVATION	OWB	GYPSON WALL BOARD	NTS	NOT TO SCALE
BIRM	BITUMINOUS	ELEC	ELECTRICAL	Q	QUARTER	O	OVER
BLDC	BLOCK	ELEV	ELEVATOR	H	HIGH	CA	CORNER
BLKG	BLOCKING	EMER	EMERGENCY	HC	HOLLOW CORE	OC	ON CENTER
BM	BEAM	ENCL	ENCLOSURE	HW	HARDWOOD	OD	OUTSIDE DIAMETER
BT	BOTTOM	EP	ELECTRICAL PANELBOARD	HW	HARDWARE	OFD	OVERFLOW DRAIN
CAB	CABINET	EPDM	ETHYLENE PROPYLENE DIENE MONOMER	HM	HOLLOW METAL	OFF	OFFICE
CB	CATCH BASIN	EQ	EQUAL	HR	HORIZONTAL	OPNC	OPENING
CEM	CEMENT	EQP	EQUIPMENT	HT	HEIGHT	OPP	OPPOSITE
CER	CERAMIC	EX	EXISTING	HW	HOIST	OSB	ORIENTED STRAND BOARD
CG	CORNER GUARD	EXP	EXPANDED	IC	INSULATED TEMPERED GLASS	PL	PLATE
CHAN	CHANNEL	EXT	EXTERIOR	ID	INSIDE DIAMETER	PLAM	PLASTIC LAMINATE
CI	CAST IRON	FA	FIRE ALARM	IGT	INSULATED GLASS THERMOPANE	PLAS	PLASTER
CLG	CEILING	FB	FLAT BAR	IC	INSULATED TEMPERED GLASS	PC	PRE-CAST
CLKG	CAULKING	FD	FLOOR DRAIN	IGT	INSULATED GLASS THERMOPANE	PF	PRE-FINISHED
CLO	CLOSET	FEN	FINISH FLOOR	IM	INSULATED METAL	PR	PAIR
CLR	CLEAR	FIN	FINISH	INSUL	INSULATION	PTG	PAPER TOWEL DISPENSER
CNTR	COUNTER	FIN	FINISH	INT	INTERIOR	PIN	PARTITION
COL	COLUMN	FEC	FIRE EXTINGUISHER CAB	JAN	JANITOR	PVC	POLYVINYL CHLORIDE
CONC	CONCRETE	FF	FINISH FLOOR	JT	JOINT	PWD	PLYWOOD
CONN	CONNECTION	FIN	FINISH	LAB	LABORATORY	QT	QUARRY TILE
CONT	CONTINUOUS	FLASH	FLASHING	LAM	LAMINATE		
CORR	CORRIDOR			LAV	LAVATORY		
CPT	CARPET						

SYMBOLS

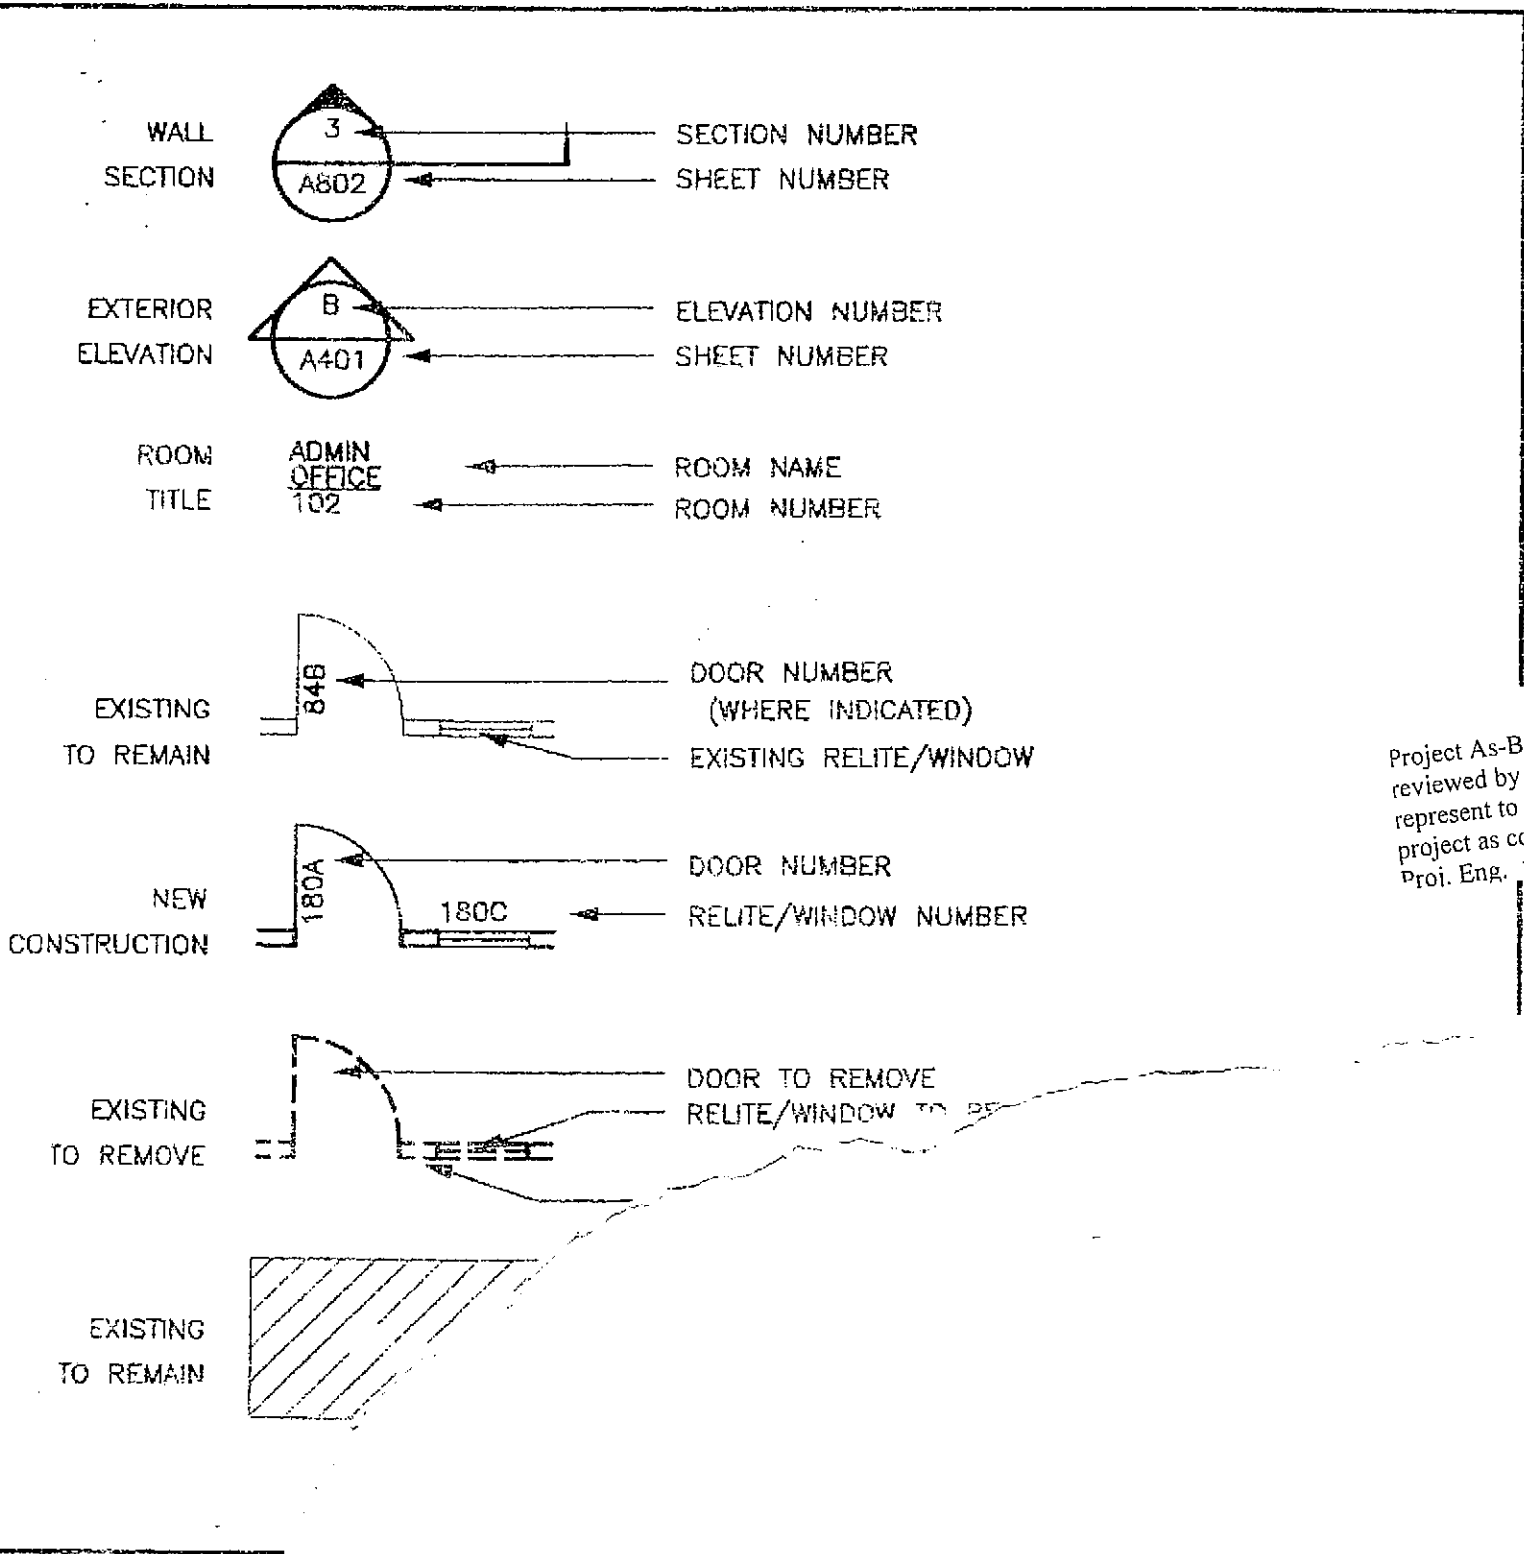

STATE OF ALASKA
DEPARTMENT OF TRANSPORTATION
AND
PUBLIC FACILITIES
SOUTHEAST REGION

APPROVED
Patrick J. Kamp, P.E.
Regional Preconstruction Engineer
Date 12/14/04
APPROVED
Gary L. Paxton
Regional S.E. Director
Date 12/15/04

Project As-Built Drawings have been reviewed by the Project Engineer and represent to the best of my knowledge, the project as constructed.
Prot. Eng. Date 7/27


PATH: G:\Projects\0411\CD\CD\1330\Arch\A002.dwg
 Tue, 14/Dec/04 02:27PM
 TAB: Layout1

ADDENDUM NUMBER


ATTACHMENT NUMBER

RECORD OF REVISIONS

No.	DATE	DESCRIPTION

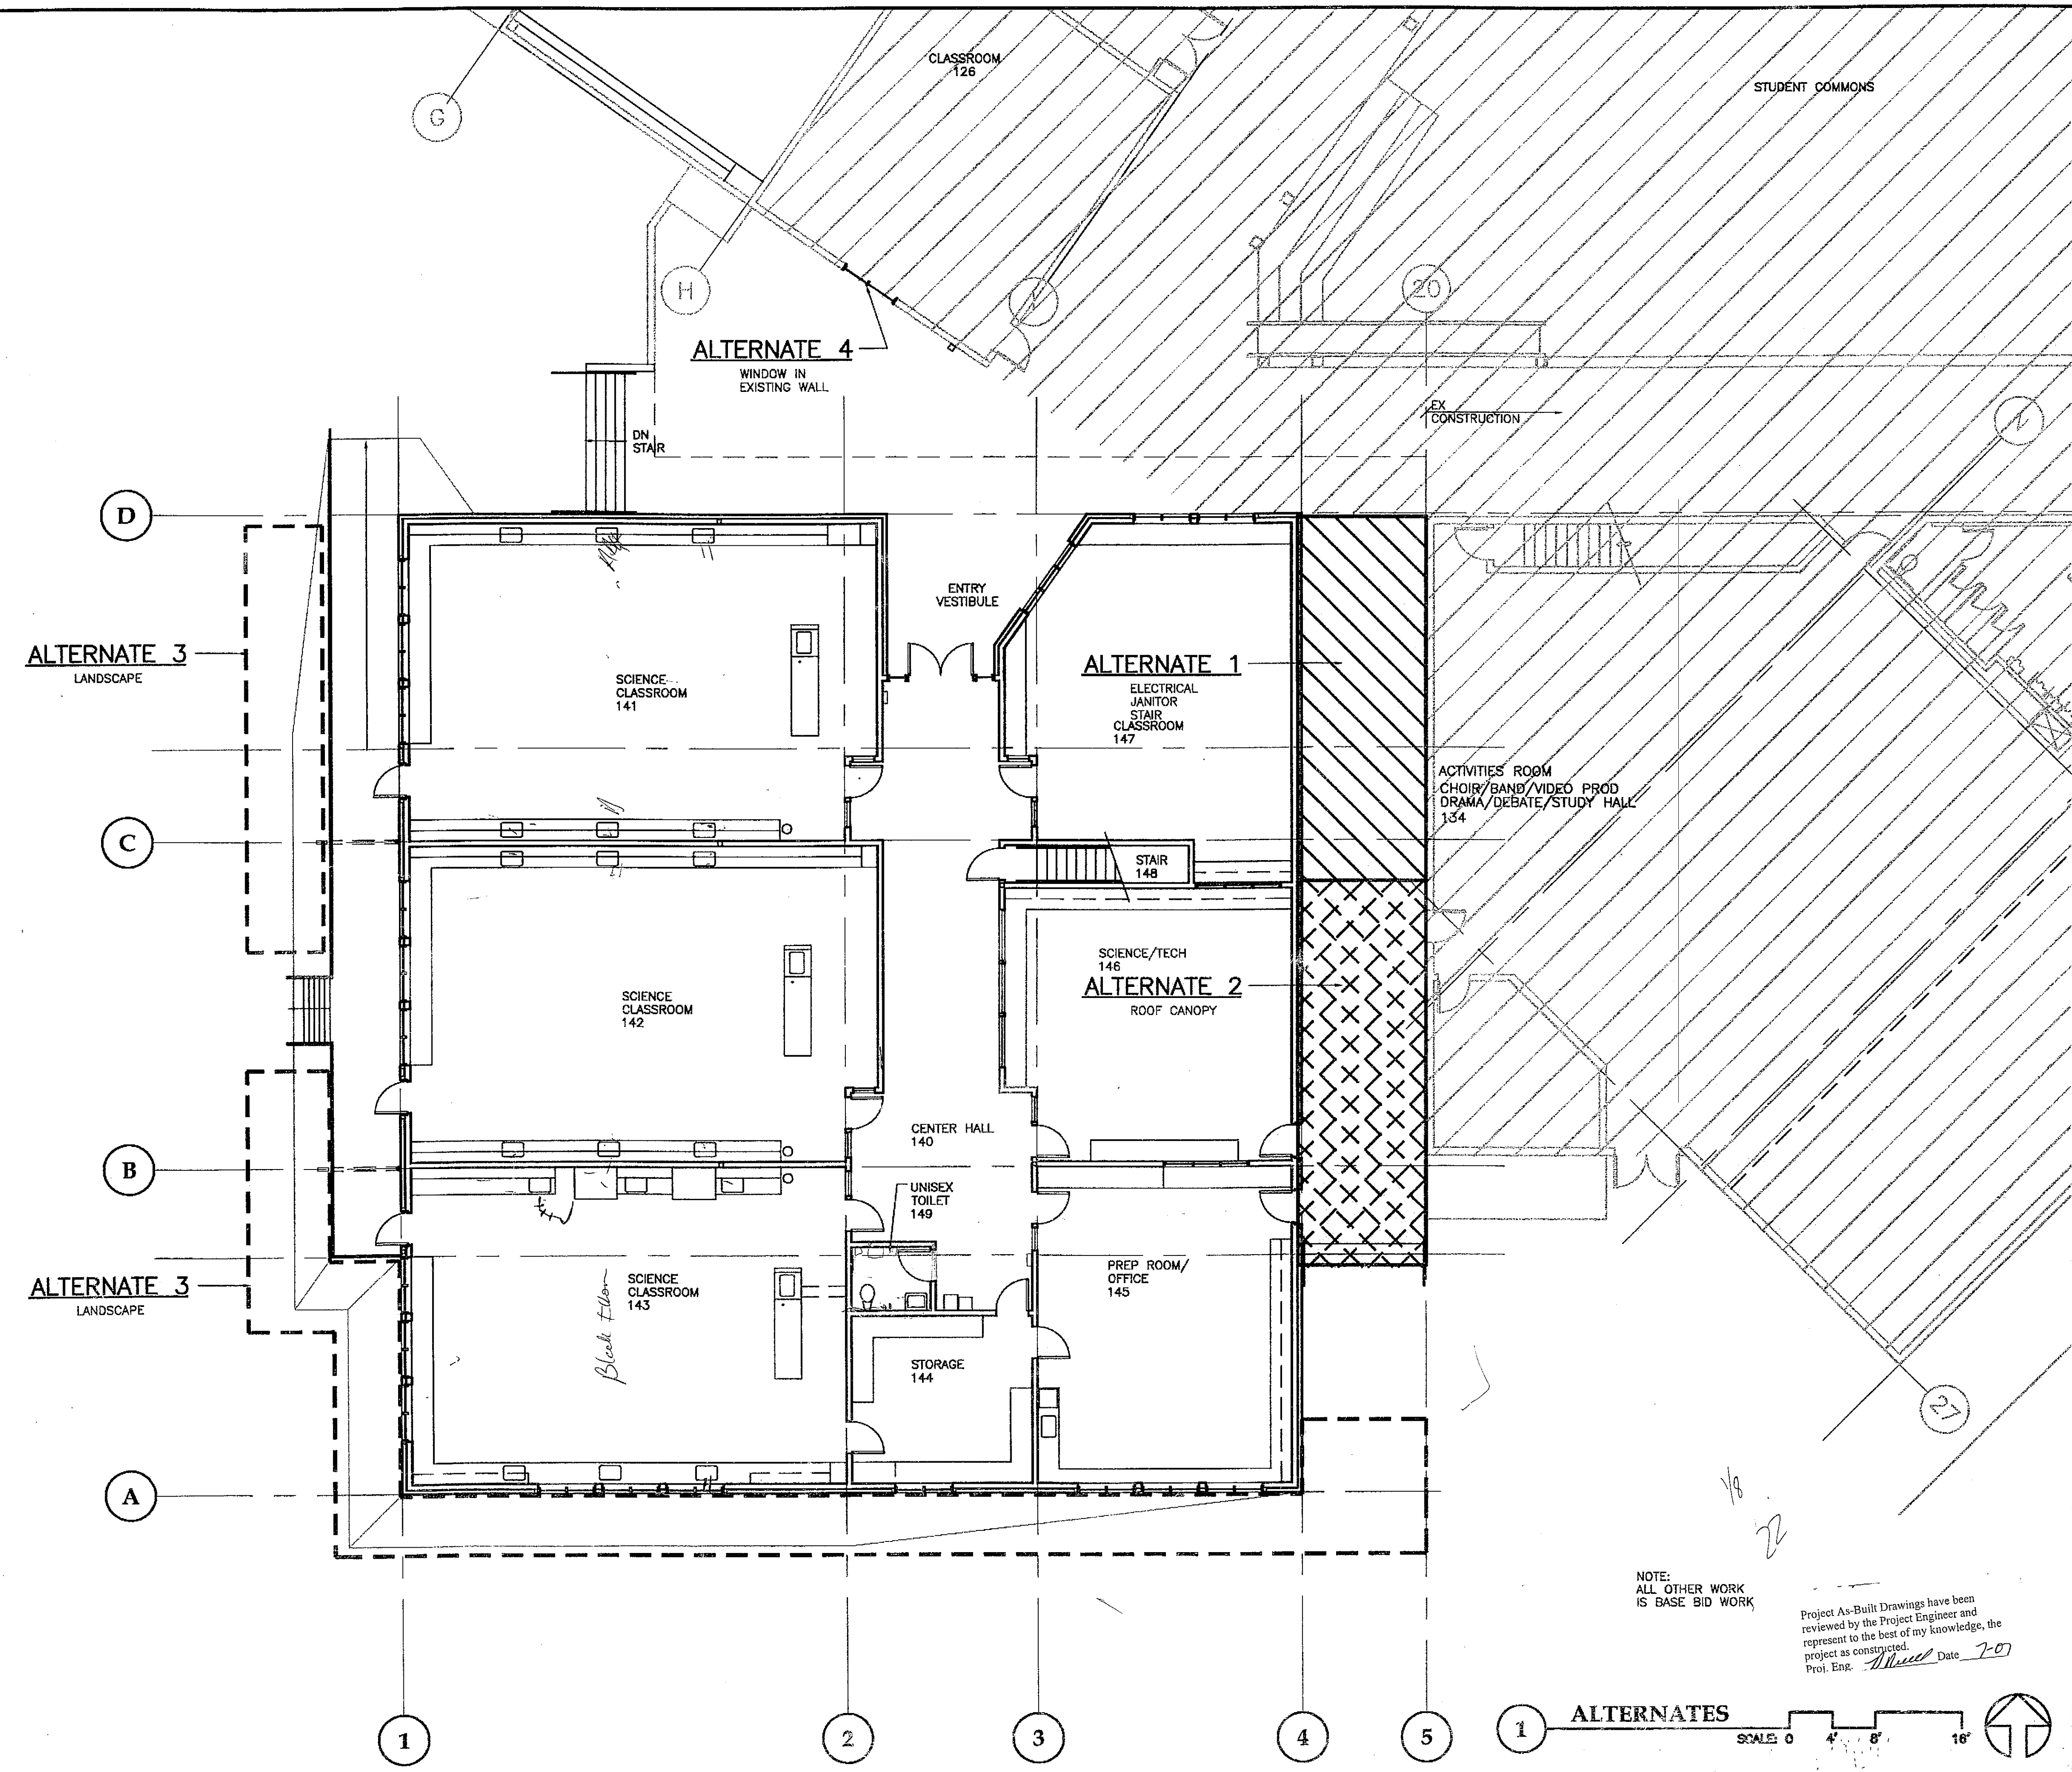

CHECKED BY:

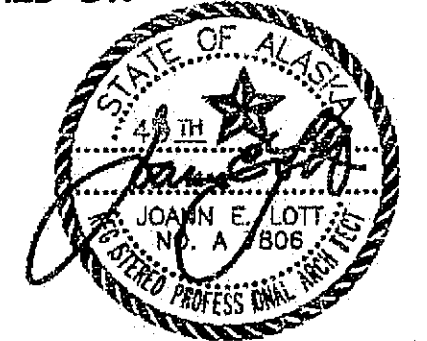

DESIGNED BY: JENSEN YORBA LOTT

DRAWN BY:

STATE OF ALASKA
 DEPARTMENT OF TRANSPORTATION
 & PUBLIC FACILITIES
 STATEWIDE DESIGN & ENGINEERING
 SERVICES DIVISION
 MT EDGECUMBE
 HIGH SCHOOL
 BUILDING 1330
 ACADEMIC
 EXPANSION

SHEET A002

PROJECT DESIGNATION NUMBER

67751C

STATE	YEAR
ALASKA	2004
SHEET NUMBER	TOTAL SHEETS
2	

NOTE:
ALL OTHER WORK
IS BASE BID WORK

Project As-Built Drawings have been
 reviewed by the Project Engineer and
 represent to the best of my knowledge, the
 project as constructed.
 Prof. Eng. *[Signature]* Date 7-07


ALTERNATES

SCALE 0 4' 8' 16'




DOOR & RELITE TYPE

DOOR TYPES: PROVIDE SAFETY GLASS IN ALL DOORS AND ALL WINDOWS ADJACENT TO DOORS
PROVIDE HORIZONTAL LOUVER BLINDS FOR ALL RELITES INSTALL INSIDE CLASS/OFFICE TYPICAL

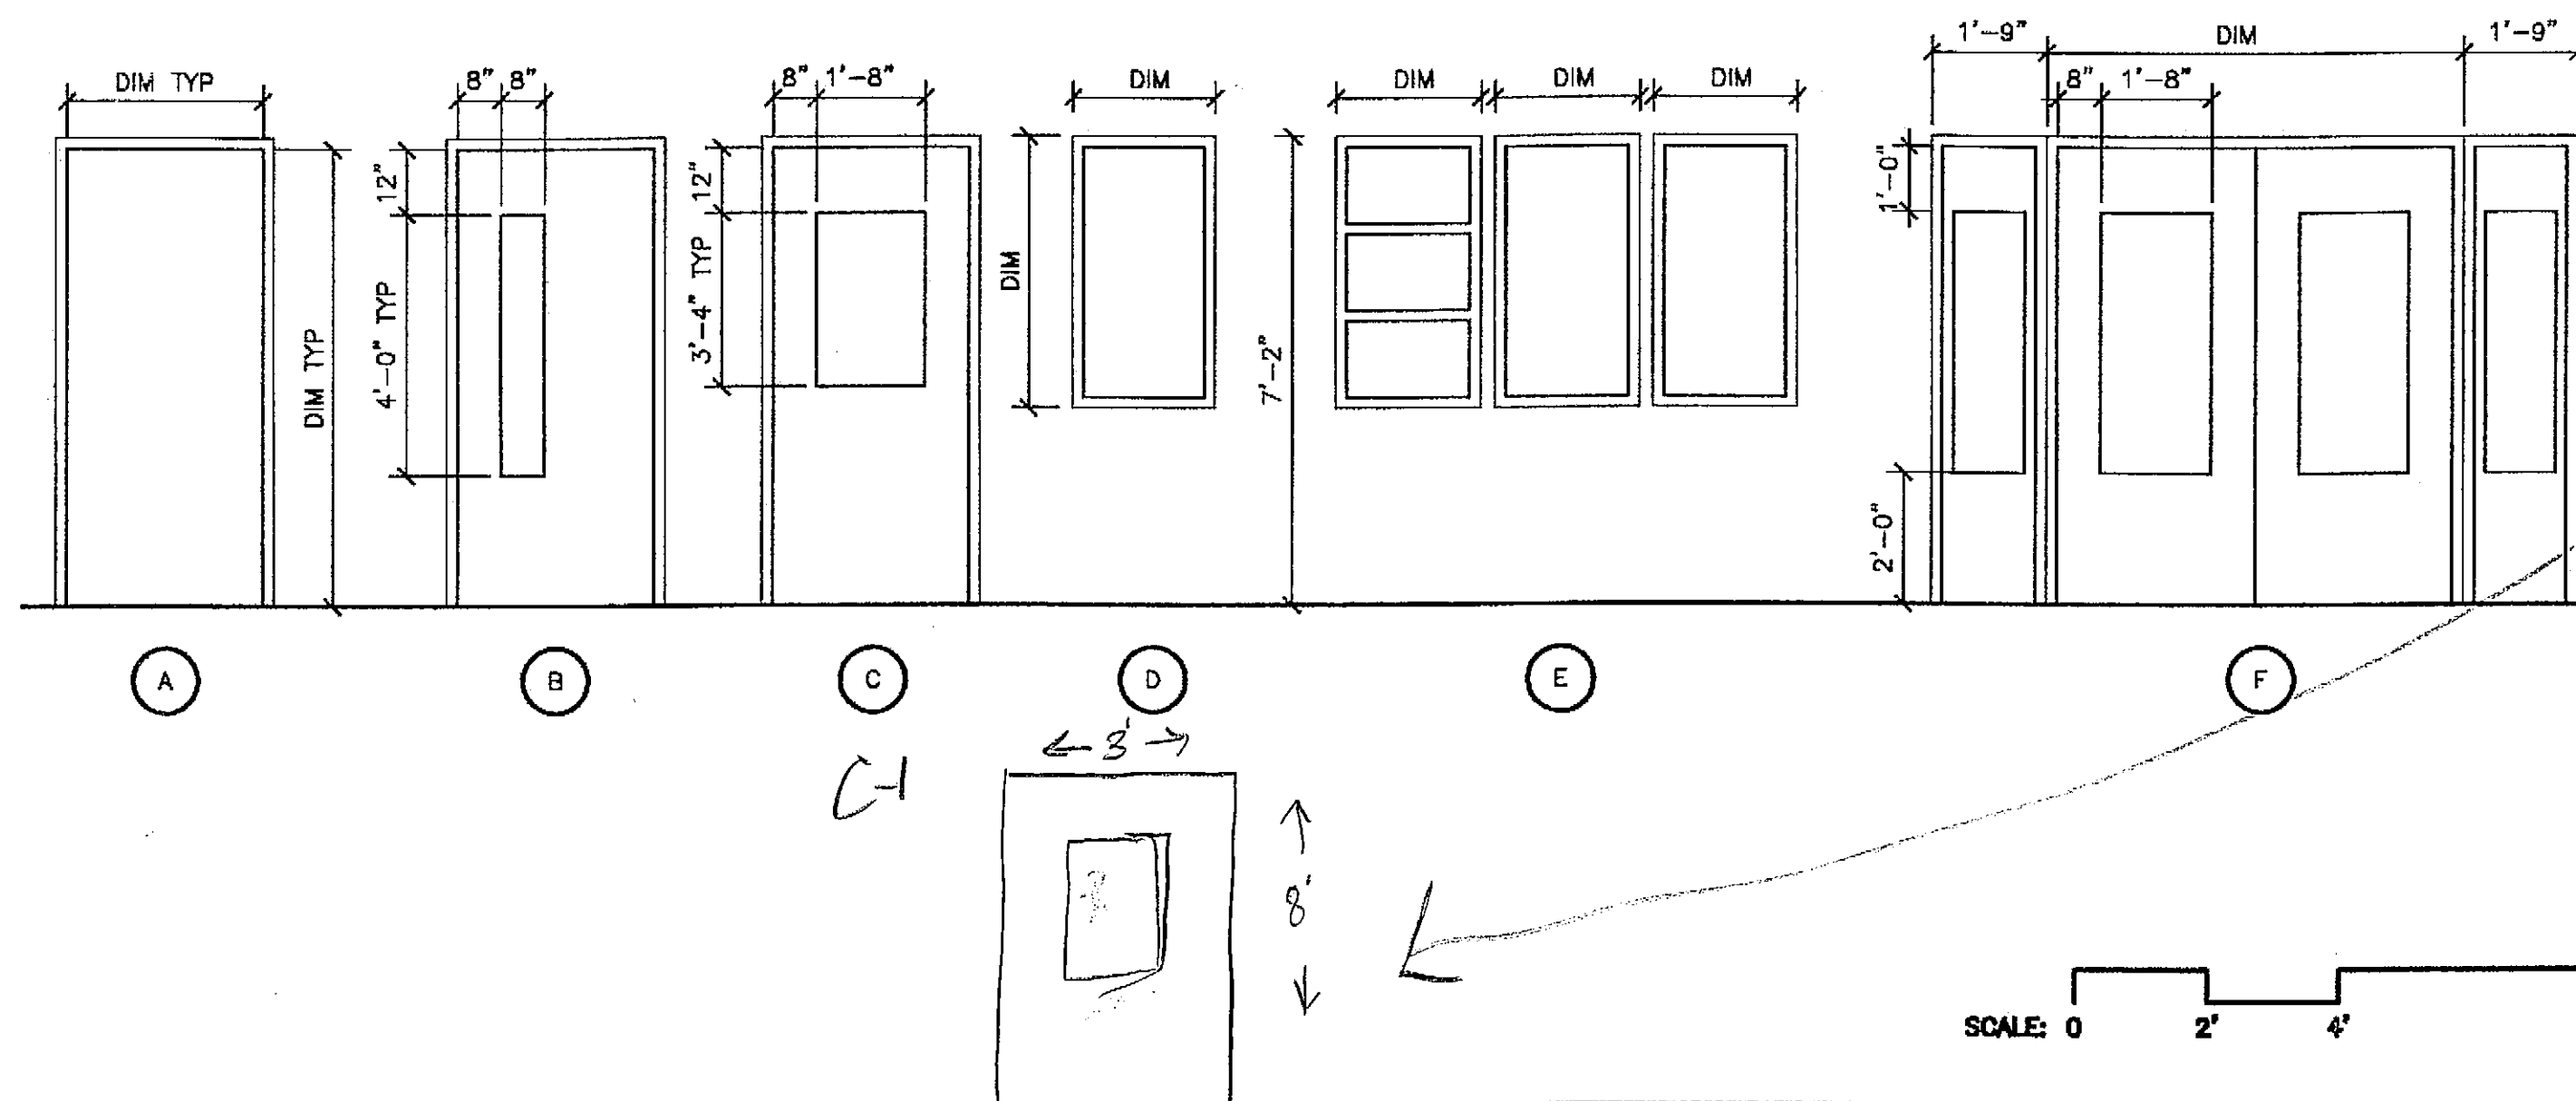

EXTERIOR WINDOW TYPE


PROVIDE HORIZONTAL LOUVER BLINDS FOR ALL EXTERIOR WINDOWS

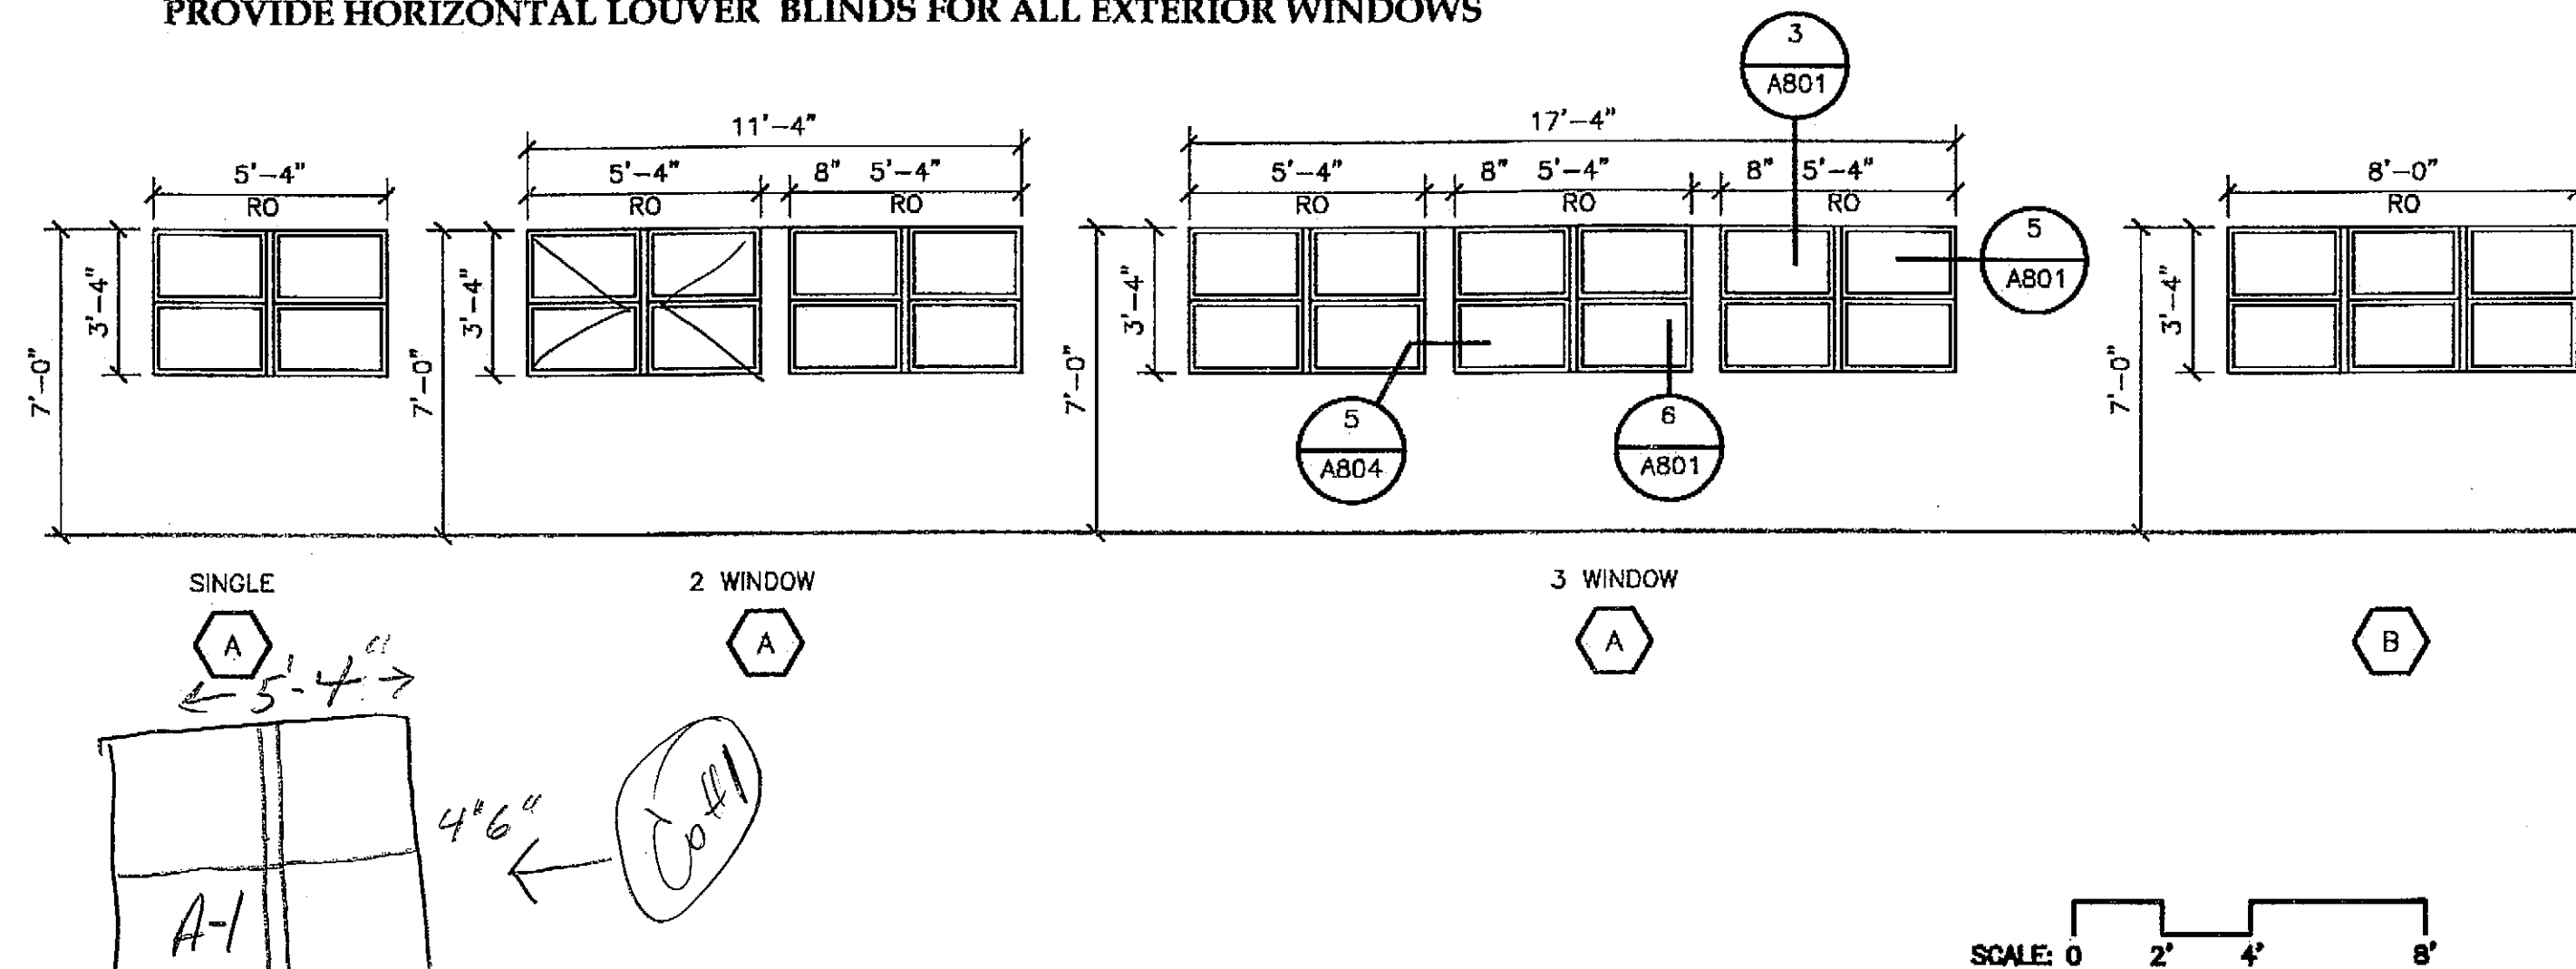

PARTITION SCHEDULE

SEE A201 FOR LOCATION OF RATED CONSTRUCTION

- NOTE:
1. ALL WALLS ARE TYPE A UON
2. PROVIDE ACOUSTICAL SEALANT AT PERIMETER & ALL PENETRATIONS TYP

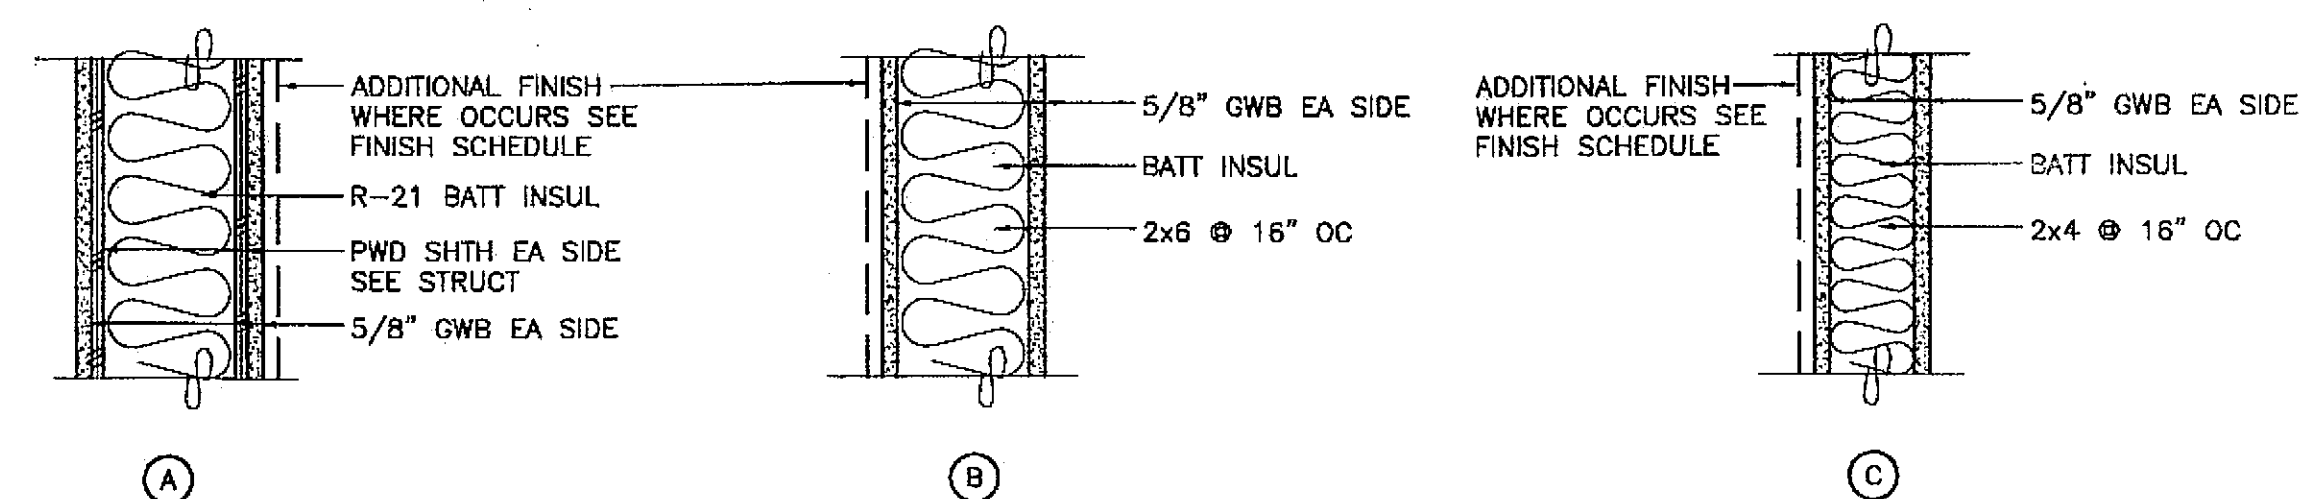

SECTION - DOOR AND RELITE SCHEDULE

OPENING				DOOR		FRAME		GLASS		SIGNAGE		RATING	DETAILS XXXX UON			HW	REMARKS
No.	Type	Size WxH		Mat. Fin.		Mat. Fin.			Type	Text			Head	Jamb	Sill		
128A																	Existing To Remain
128B																	Existing To Remain
129A-A	C	3'-0"x7'-0"		HM	PT	HM	PT	GT	A	000WORKROOM						03	
129A-B	D	1'-10"x4'-0"				HM	PT	GT									
129A-C	D	1'-10"x4'-0"						GT									
129B-A	C	3'-0"x7'-0"		HM	PT	HM	PT	GT	A	000OFFICE						11	
129C-A	C	3'-0"x7'-0"		HM	PT	HM	PT	GT	A	000OFFICE						11	
140A	F	PR3'-0"x7'-0"		HM	PT	HM	PT	IGT				1/A801	4/A801	2/A801	01		
141A	B	3'-0"x7'-0"				HM	PT	GT	A	000CLASSROOM 3-0 x					02		
141B	C-1	3'-0"x7'-0"		HM	PT	HM	PT	IGT			1/A801	4/A801	2/A801	09			
141C	D	1'-10"x4'-0"				HM	PT	GT									
141D	D	1'-10"x4'-0"				HM	PT	GT									
142A	B	3'-0"x7'-0"		HM	PT	HM	PT	GT	A	000CLASSROOM					02		
142B	C-1	3'-0"x7'-0"		HM	PT	HM	PT	IGT			1/A801	4/A801	2/A801	09			
142C	D	1'-10"x4'-0"						GT									
142D	D	1'-10"x4'-0"				HM	PT	GT									
143A	B	3'-0"x7'-0"		HM	PT	HM	PT	GT	A	000CLASSROOM					02		
143B	C-1	3'-0"x7'-0"		HM	PT	HM	PT	IGT			1/A801	4/A801	2/A801	09			
143C	D	1'-10"x4'-0"				HM	PT	GT									
144A	B	3'-0"x7'-0"		HM	PT	HM	PT	GT	A	000 WORK ROOM					04		
144B	B	3'-0"x7'-0"		HM	PT	HM	PT	GT	A	000 WORK ROOM					03		
145A	B	3'-0"x7'-0"		HM	PT	HM	PT	GT	A	000 OFFICE					05		
145B	B	3'-0"x7'-0"		HM	PT	HM	PT	IGT			1/A801	4/A801	2/A801	10			
145C	C-1	3'-0"x7'-0"		HM	PT	HM	PT	GT	4					04			
145D	D	1'-10"x4'-0"				HM	PT	GT									
145E	E	(3)1'-10"x4'-0"				HM	PT	GT									
146A	B	3'-0"x7'-0"		HM	PT	HM	PT	GT	A	000CLASSROOM					02		
146B	D	1'-10"x4'-0"				HM	PT	GT									
146C	D	4'-0"x4'-0"						GT			1/A801	4/A801	2/A801				
146D	D	4'-0"x4'-0"				HM	PT	GT									
146E	D	4'-0"x4'-0"				HM	PT	GT									
146F	E	(3)1'-10"x4'-0"				HM	PT	GT									
146G		3'-0"x7'-0"															
147A	B	3'-0"x7'-0"		HM	PT	HM	PT	GT	A	000CLASSROOM					02		
147B	D	1'-10"x4'-0"				HM	PT	GT									
147C	D	1'-10"x4'-0"				HM	PT	GT									
147D																	
148A	A	3'-0"x7'-0"		HM	PT	HM	PT		D	MECHANICAL					07		
149A	A	3'-0"x7'-0"		HM	PT	HM	PT		D	RESTROOM					06		
150A	A	3'-0"x7'-0"		HM	PT	HM	PT		A	000 JANITOR		1/A801	4/A801	2/A801	12		ALTERNATE 1
150B	A	PR3'-0"x7'-0"		HM	PT	HM	PT				1/A801	4/A801	2/A801	08			ALTERNATE 1
150C	A	PR3'-0"x7'-0"		HM	PT	HM	PT		A	000 STORAGE	1/A801	4/A801	2/A801	08			ALTERNATE 1
201A	A	PR3'-0"x7'-0"		HM	PT	HM	PT		A	000 MECHANICAL					08		ALTERNATE 1

SECTION 09000 - FINISH SCHEDULE

ROOM No.	Name	FLOOR	BASE	See Interior Elevations	WAINSCOT	WALLS	North	East	South	West	CEILING	NOTES
128	Classroom	CPT	Rubber 4"	WC	7' 2"	PT	PT	PT	PT	PT	ACP	
129A	Workroom	CPT	Rubber 4"			PT	PT	PT	PT	PT	ACP	
129B	Office	CPT	Rubber 4"			PT	PT	PT	PT	PT	ACP	
129C	Office	CPT	Rubber 4"			PT	PT	PT	PT	PT	ACP	
140	Center Hall	EM/SV	Rubber 4"	WC	7' 2"	PT	PT	PT	PT	PT	ACP	
141	Science Classroom	SV	Rubber 4"	WP	7' 2"	PT	PT	PT	PT	PT	ACP	
142	Science Classroom	SV	Rubber 4"	WP	7' 2"	PT	PT	PT	PT	PT	ACP	
143	Science Classroom	SV	Rubber 4"	WP	7' 2"	PT	PT	PT	PT	PT	ACP	
144	Storage	SV	Rubber 4"	WP	7' 2"	PT	PT	PT	PT	PT	ACP	
145	Prep Room/ Office	CPT/SV	Rubber 4"	WP	7' 2"	PT	PT	PT	PT	PT	ACP	
146	Classroom	CPT	Rubber 4"	WC	7' 2"	PT	PT	PT	PT	PT	ACP	
147	Classroom	CPT	Rubber 4"	WC	7' 2"	PT	PT	PT	PT	PT	ACP	
148	Stair	SV	Rubber 4"	WP	7' 2"	PT	PT	PT	PT	PT	PT	Note 1
149	Unisex toilet	SV	IC	6"	WP	4"	PT	PT	PT	PT	PT	
150	Janitor/Storage	CONC	Rubber 4"	WP	7' 2"	PT	PT	PT	PT	PT	PT	Alternate 1
151	Stair	SV	Rubber 4"	WP	7' 2"	PT	PT	PT	PT	PT	PT	Alternate 1, Note 1
201	Mechanical	CONC	Rubber 4"			PT	PT	PT	PT	PT	PT	
202	Electrical	CONC	Rubber 4"			PT	PT	PT	PT	PT	PT	Alternate 1

Note:
1. RUBBER STAIR TREAD & RISER ON STAIRS

CODE DATA

OCCUPANCY E OCCUPANT LOAD OF ADDITION 272
CONSTRUCTION TYP VB SPRINKLERED
503-VB $\alpha_1 = 9.5005F$ 1STORY/40'
 $\alpha_2 = 45,125$ $I_r = 75$ $I_g = 300$
ACTUAL = 30,597 EXISTING 23,125 + ADDITION 7,472

TABLE 601 - FIRE RESISTANCE REQUIREMENTS
STRUCTURAL FRAME 0 HR
EXTERIOR BEARING WALLS 0 HR
EXTERIOR NON BEARING WALLS 0 HR (TABLE 602 <30')
INTERIOR WALLS 0 HR (TABLE 302.1.1 LABORATORIES SMOKE BARRIER REQUIRED)
FLOOR CONSTRUCTION 0 HR
ROOF CONSTRUCTION 0 HR

Co#1 Add A-1 windows to RMS 14/142
143, 145. See sheet
Co#2 Add equipment to page

Project As-Built Drawings have been reviewed by the Project Engineer and represent to the best of my knowledge, the project as constructed.
Proj. Eng. *[Signature]* Date 7-07

PATH: G:\Projects\0411\CD\CD\1330\Arch\A003.dwg
Tue, 14/Dec/04 02:27PM
TAB: Layout1


ADDENDUM NUMBER

ATTACHMENT NUMBER

RECORD OF REVISIONS

No.	DATE	DESCRIPTION

CHECKED BY:

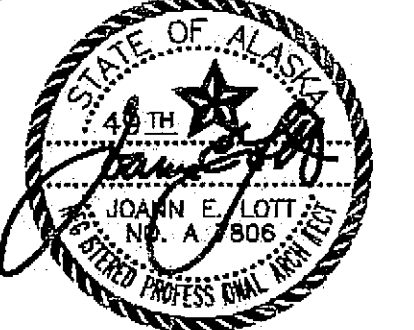

DESIGNED BY: JENSEN YORBA LOTT

DRAWN BY:


STATE OF ALASKA
DEPARTMENT OF TRANSPORTATION & PUBLIC FACILITIES
STATEWIDE DESIGN & ENGINEERING SERVICES DIVISION
MT EDGE CUMBE
HIGH SCHOOL
BUILDING 1330
ACADEMIC
EXPANSION

SHEET A003

PROJECT DESIGNATION NUMBER

67751C

STATE	YEAR
ALASKA	2004
SHEET NUMBER	TOTAL SHEETS
3	79

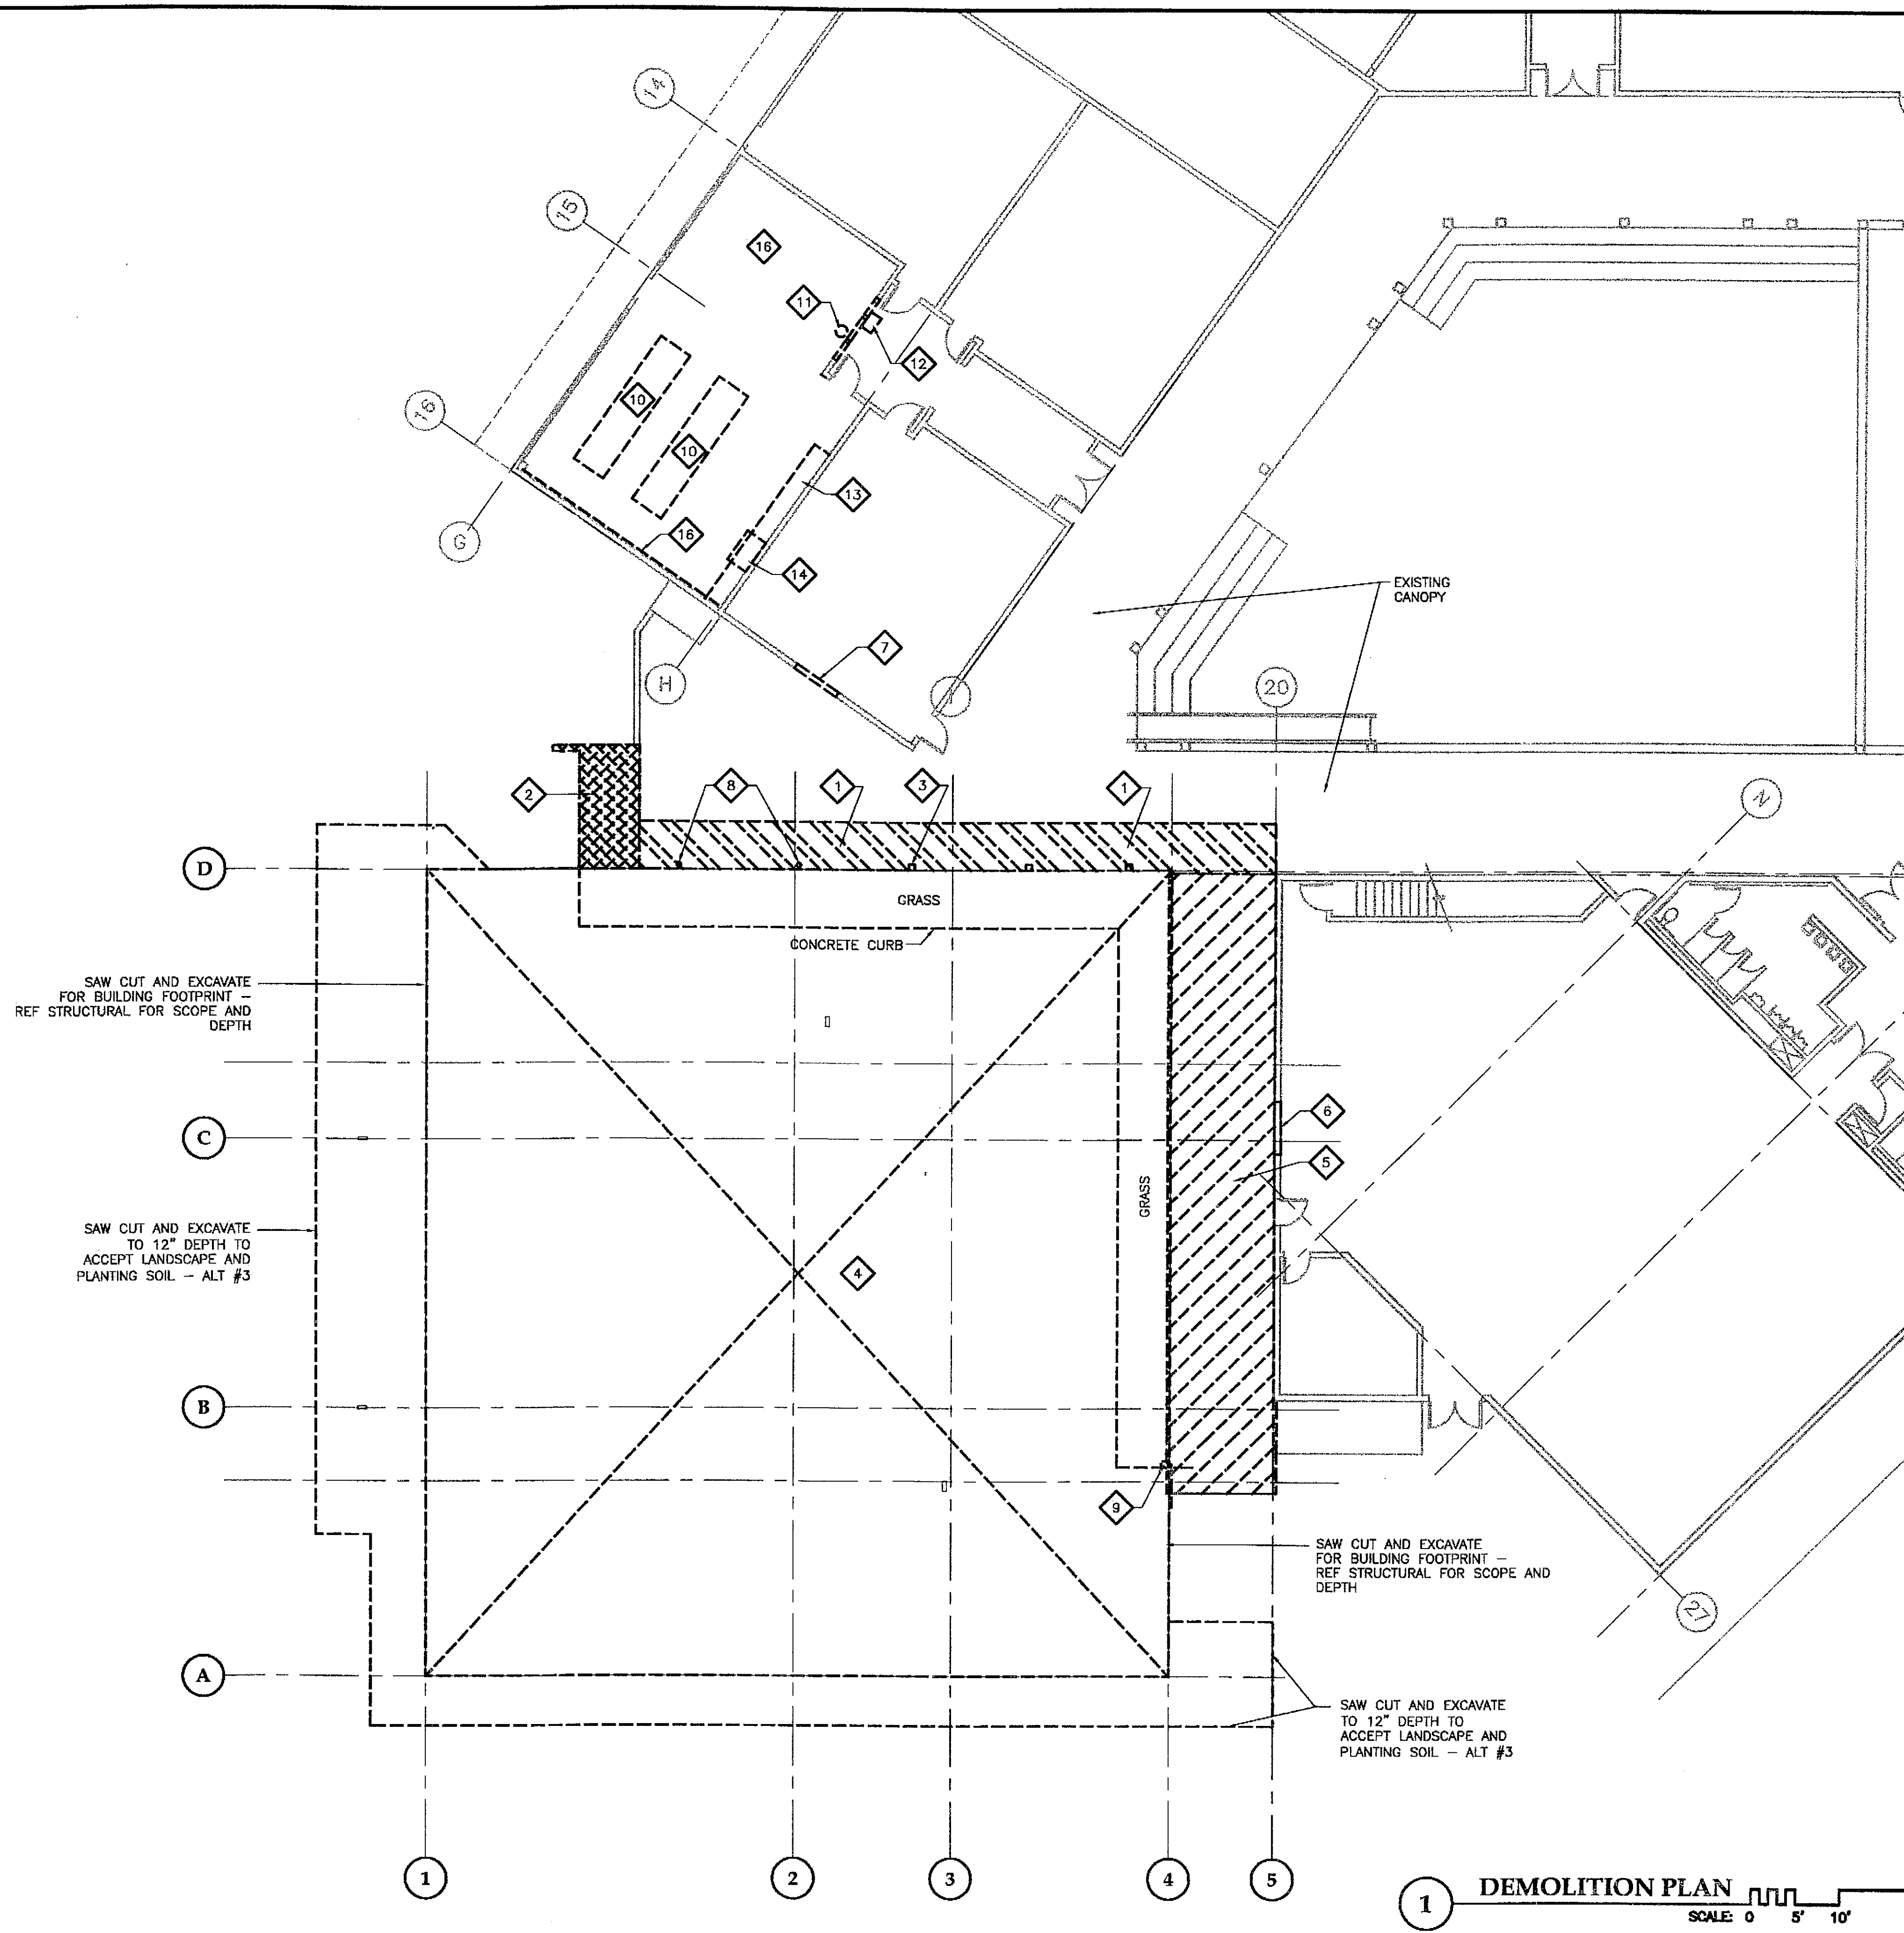

DEMOLITION KEY NOTES:

EXTERIOR DEMOLITION

- 1 SAW CUT & REMOVE CONCRETE WALKWAY AS REQ FOR NEW WORK
- 2 SAW CUT & REMOVE CONCRETE STAIR & STEEL HANDRAILS AS REQ FOR NEW WORK
- 3 REMOVE STEEL COLUMN SEE STRUCTURAL
- 4 SAW CUT & REMOVE EX 6" CONC SLAB ON GRADE, CONCRETE CURB & GRASS AS REQ FOR NEW WORK
- 5 SAW CUT & REMOVE CONCRETE SIDE WALK & STAIR
- 6 ALTERNATE 1 REMOVE EXISTING BRICK & WOOD STUD BEARING WALL FOR NEW DOOR 6'-0"x7'-0" VERIFY DOOR DIMENSIONS
- 7 ALTERNATE 4 REMOVE EXISTING BRICK & WOOD STUD BEARING WALL FOR NEW WINDOW REMOVE WHITE BD & TACK BD AS REQ FOR NEW WORK. SALVAGE FOR REUSE. REMOVE INTERIOR WALL FINISHES AS REQ FOR NEW WORK
- 8 REMOVE EXISTING BOLLARD TYP OF (3)
- 9 REMOVE EXISTING LIGHT

INTERIOR DEMOLITION

- 10 REMOVE COUNTER TOP, BASE CABINETS RETURN TO OWNER REMOVE ASSOCIATED PLUMBING & POWER SERVICE
- 11 REMOVE EMERGENCY EYEWASH & SHOWER RETURN TO OWNER
- 12 REMOVE DRINKING FOUNTAIN RETURN TO OWNER
- 13 REMOVE FULL HEIGHT HALL CABINETS RETURN TO OWNER
- 14 REMOVE LABORATORY HOOD & ASSOCIATED POWER WATER WASTE & DRAIN SERVICE RETURN TO OWNER
- 15 NOT USED
- 16 REMOVE EXISTING VISUAL DISPLAY BOARD

PATH: G:\Projects\0411\CD\CD\1330\Arch\A101.dwg
Tue, 14/Dec/04 02:27PM
TAB: Layout1


ADDENDUM NUMBER

ATTACHMENT NUMBER

RECORD OF REVISIONS

No.	DATE	DESCRIPTION

CHECKED BY:

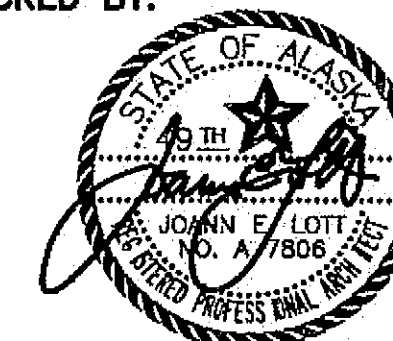

DESIGNED BY: JENSEN YORBA LOTT

DRAWN BY:

STATE OF ALASKA
DEPARTMENT OF TRANSPORTATION & PUBLIC FACILITIES
STATEWIDE DESIGN & ENGINEERING SERVICES DIVISION
MT EDGECUMBE
HIGH SCHOOL
BUILDING 1330
ACADEMIC
EXPANSION

SHEET A101



PROJECT DESIGNATION NUMBER

67751C

STATE	YEAR
ALASKA	2004
SHEET NUMBER	TOTAL SHEETS
4	79

Project As-Built Drawings have been reviewed by the Project Engineer and represent to the best of my knowledge, the project as constructed.
Proj. Eng. *John E. Lott* Date: 7-07

1 DEMOLITION PLAN
SCALE: 0 5' 10' 20'

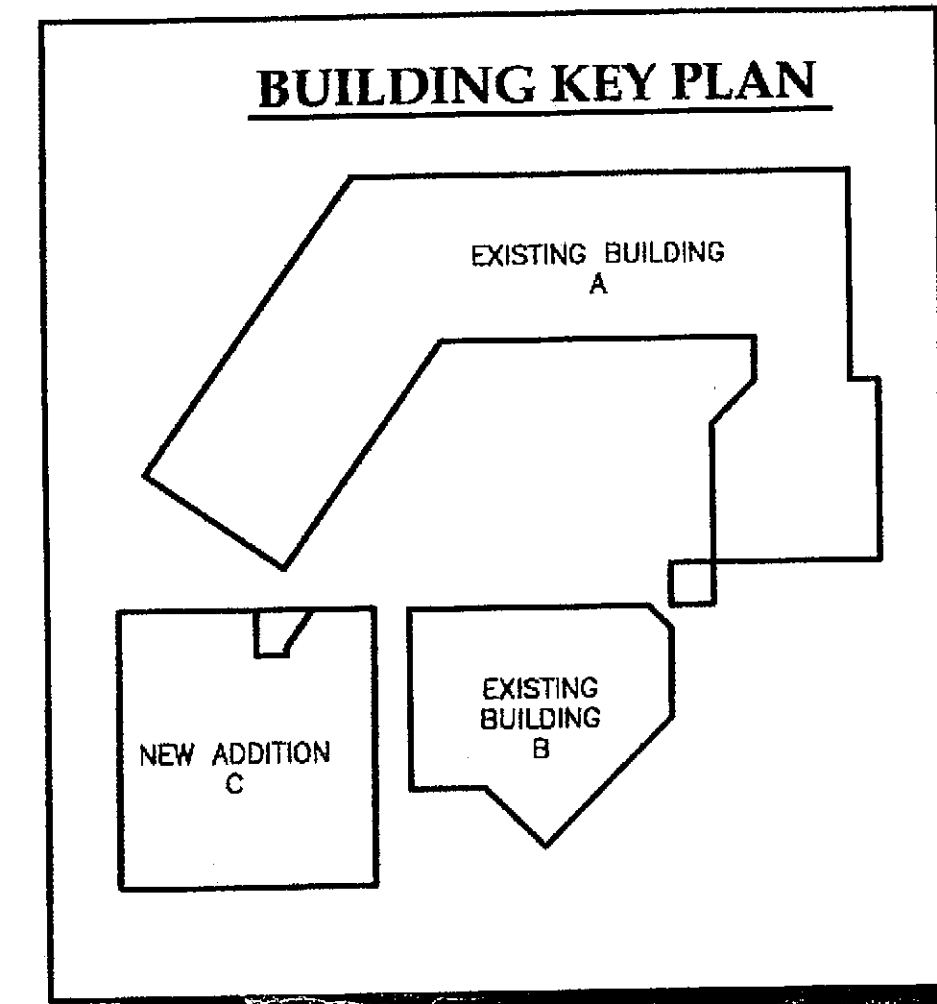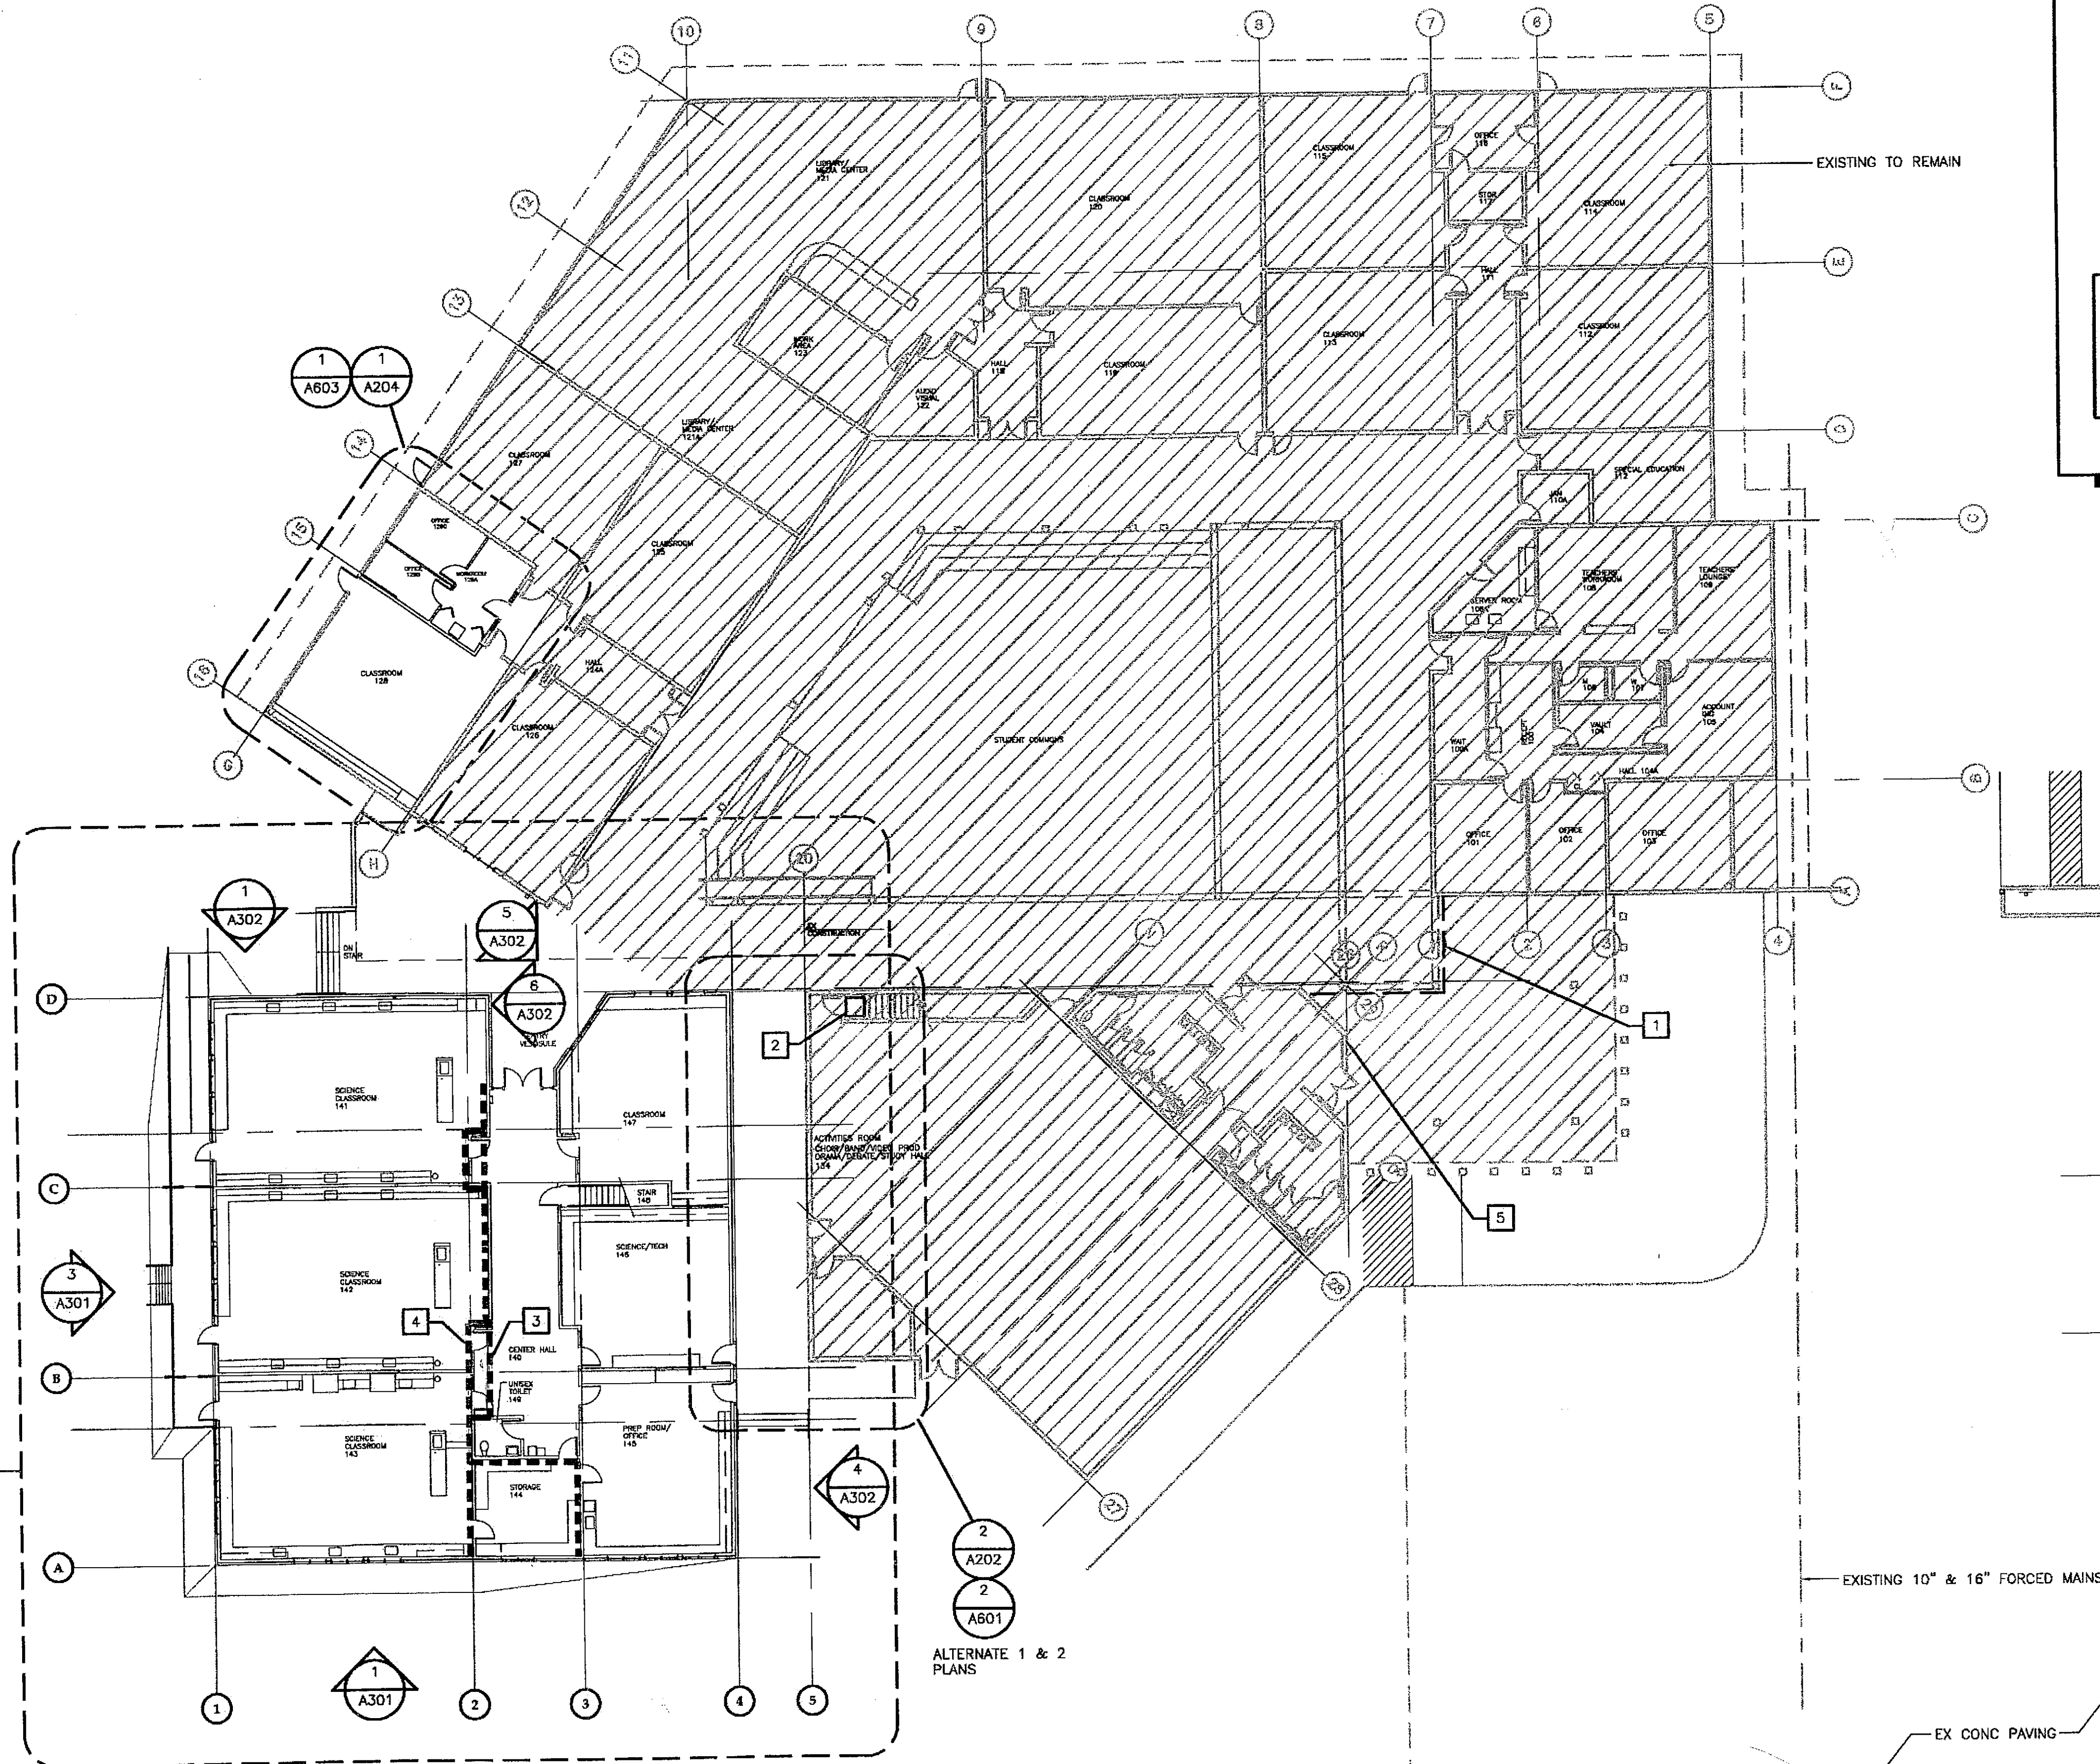

PATH: G:\Projects\0411\CD\CD\1330\Arch\A201.dwg
Tue, 14/Dec/04 02:27PM
TAB: Layout1

ADDENDUM NUMBER

ATTACHMENT NUMBER


RECORD OF REVISIONS

No.	DATE	DESCRIPTION

KEY NOTES:

- (5) 1"-2" SURFACE MOUNTED CONDUIT FROM BUILDING "B" MECHANICAL ROOM TO BUILDING "A" INTERSTITIAL SPACE ROUTED AT UNDERSIDE OF EXISTING SLOPED CANOPY AS SHOWN. PAINT TO MATCH EXISTING SOFFIT. SEAL ALL PENETRATIONS.
- PROVIDE NEW 3'-0"x3'-0" CEILING ACCESS DOOR IN EXISTING WOOD FRAME & GWB CEILING. REVISE FRAMING FOR NEW DOOR.
- SMOKE PARTITION ABOVE SOFFIT TYP.
- SMOKE PARTITION TYP.
- REMOVE EXISTING FIRE ALARM ANNUNCIATOR. INSTALL NEW (SEE ELEC). SEAL PERIMETER W/ INTEGRAL PANEL TRIM & SEALANT.

CHECKED BY:

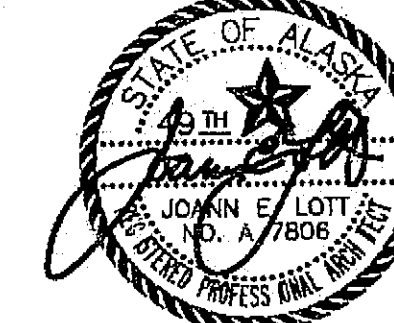

DESIGNED BY: JENSEN YORBA LOTT

DRAWN BY:

STATE OF ALASKA
DEPARTMENT OF TRANSPORTATION & PUBLIC FACILITIES
STATEWIDE DESIGN & ENGINEERING SERVICES DIVISION
MT EDGECUMBE
HIGH SCHOOL
BUILDING 1330
ACADEMIC
EXPANSION

SHEET A201


PROJECT DESIGNATION NUMBER

67751C

STATE	YEAR
ALASKA	2004
SHEET NUMBER	TOTAL SHEETS
5	79

1 OVERALL PLAN BASE BID

EXISTING SEWER
SCALE: 0 8' 16' 32'

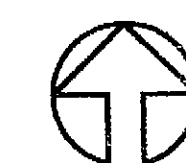


Project As-Built Drawings have been reviewed by the Project Engineer and represent to the best of my knowledge, the project as constructed.
Proj. Eng. *[Signature]* Date 7-07

No.	DATE	DESCRIPTION

Head
150 C NOTES
C6411
Double Chain Link Fence
Build wall reflect 150-B back

CHECKED BY:

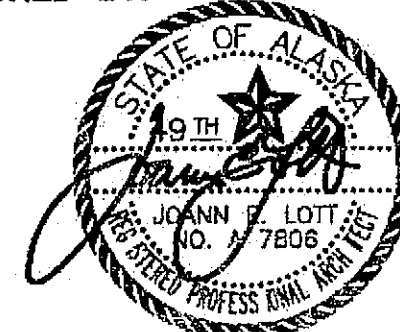

DESIGNED BY: JENSEN YORBA LOTT

DRAWN BY:

STATE OF ALASKA
DEPARTMENT OF TRANSPORTATION
& PUBLIC FACILITIES
STATEWIDE DESIGN & ENGINEERING
SERVICES DIVISION

MT EDGE CUMBE
HIGH SCHOOL
BUILDING 1330
ACADEMIC
EXPANSION


SHEET A202

PROJECT DESIGNATION NUMBER

67751C


STATE	YEAR
ALASKA	2004
SHEET NUMBER	TOTAL SHEETS
6	79

Project As-Built Drawings have been reviewed by the Project Engineer and represent to the best of my knowledge, the project as constructed.
Proj. Eng. *[Signature]* Date 7-07

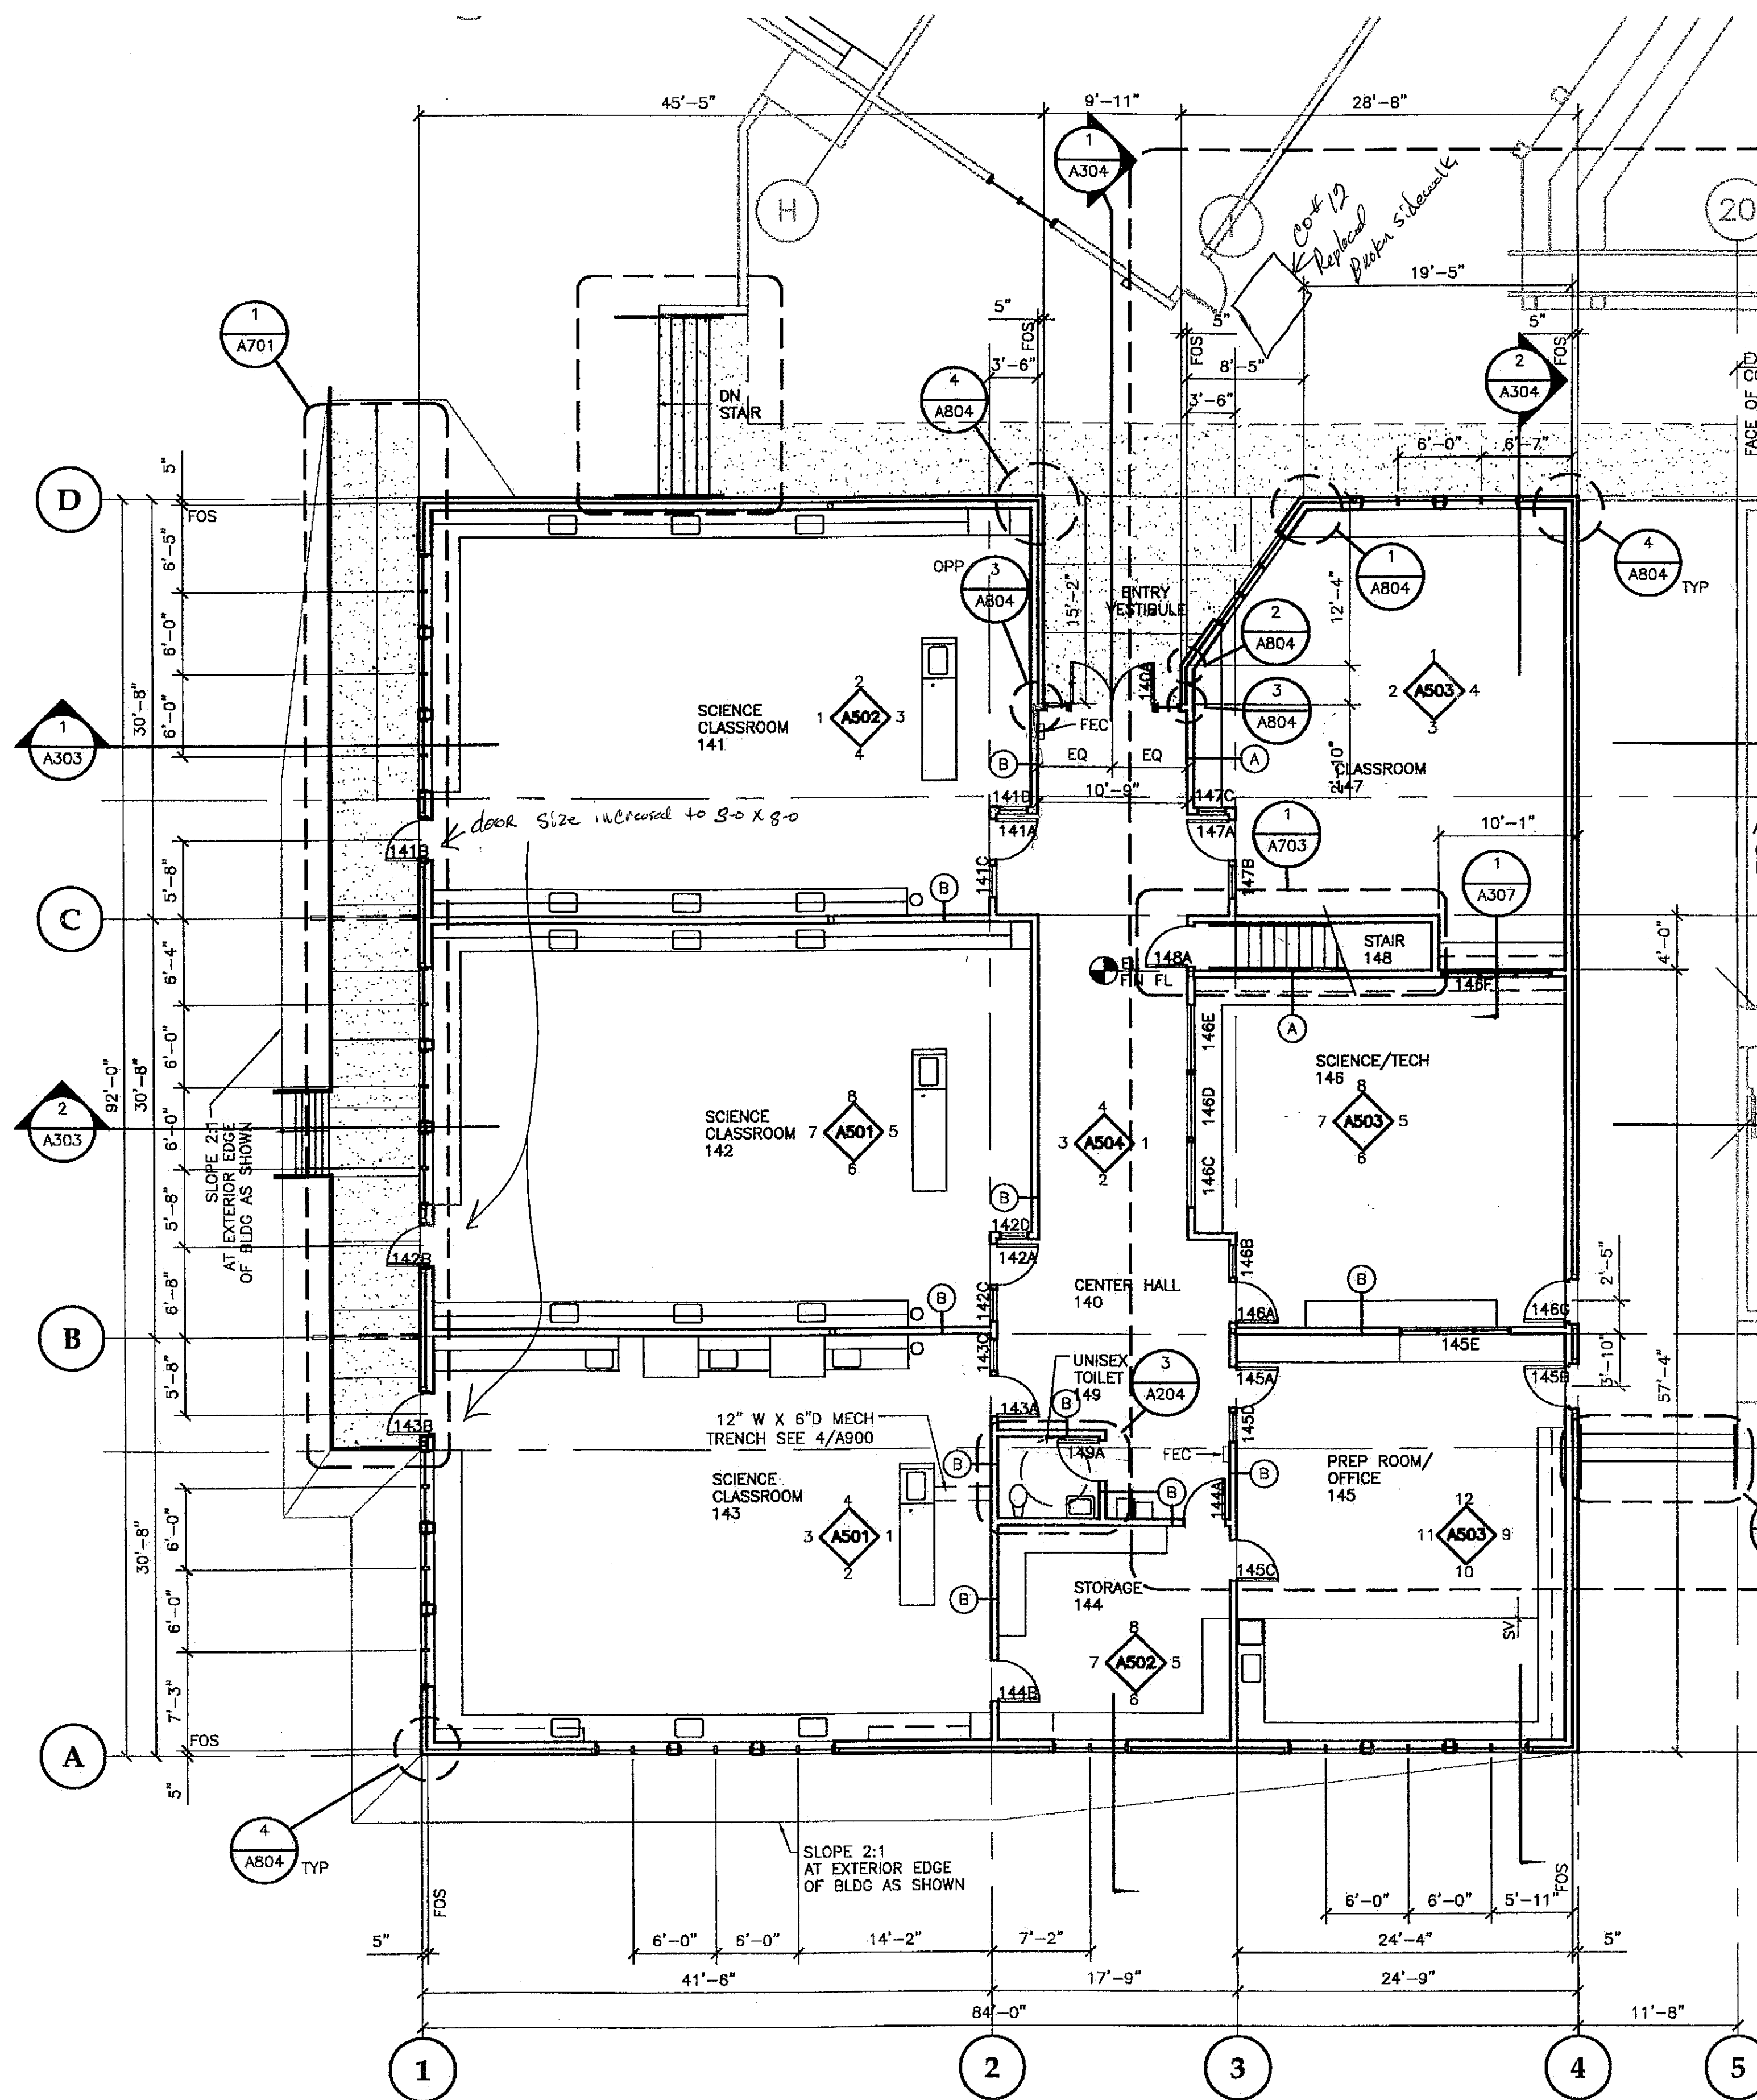

1 MAIN FLOOR PLAN-BASE BID
FINISH FLOOR ELEVATION 18.30' = DATUM 0'-0"

SCALE: 0 4' 8' 16'

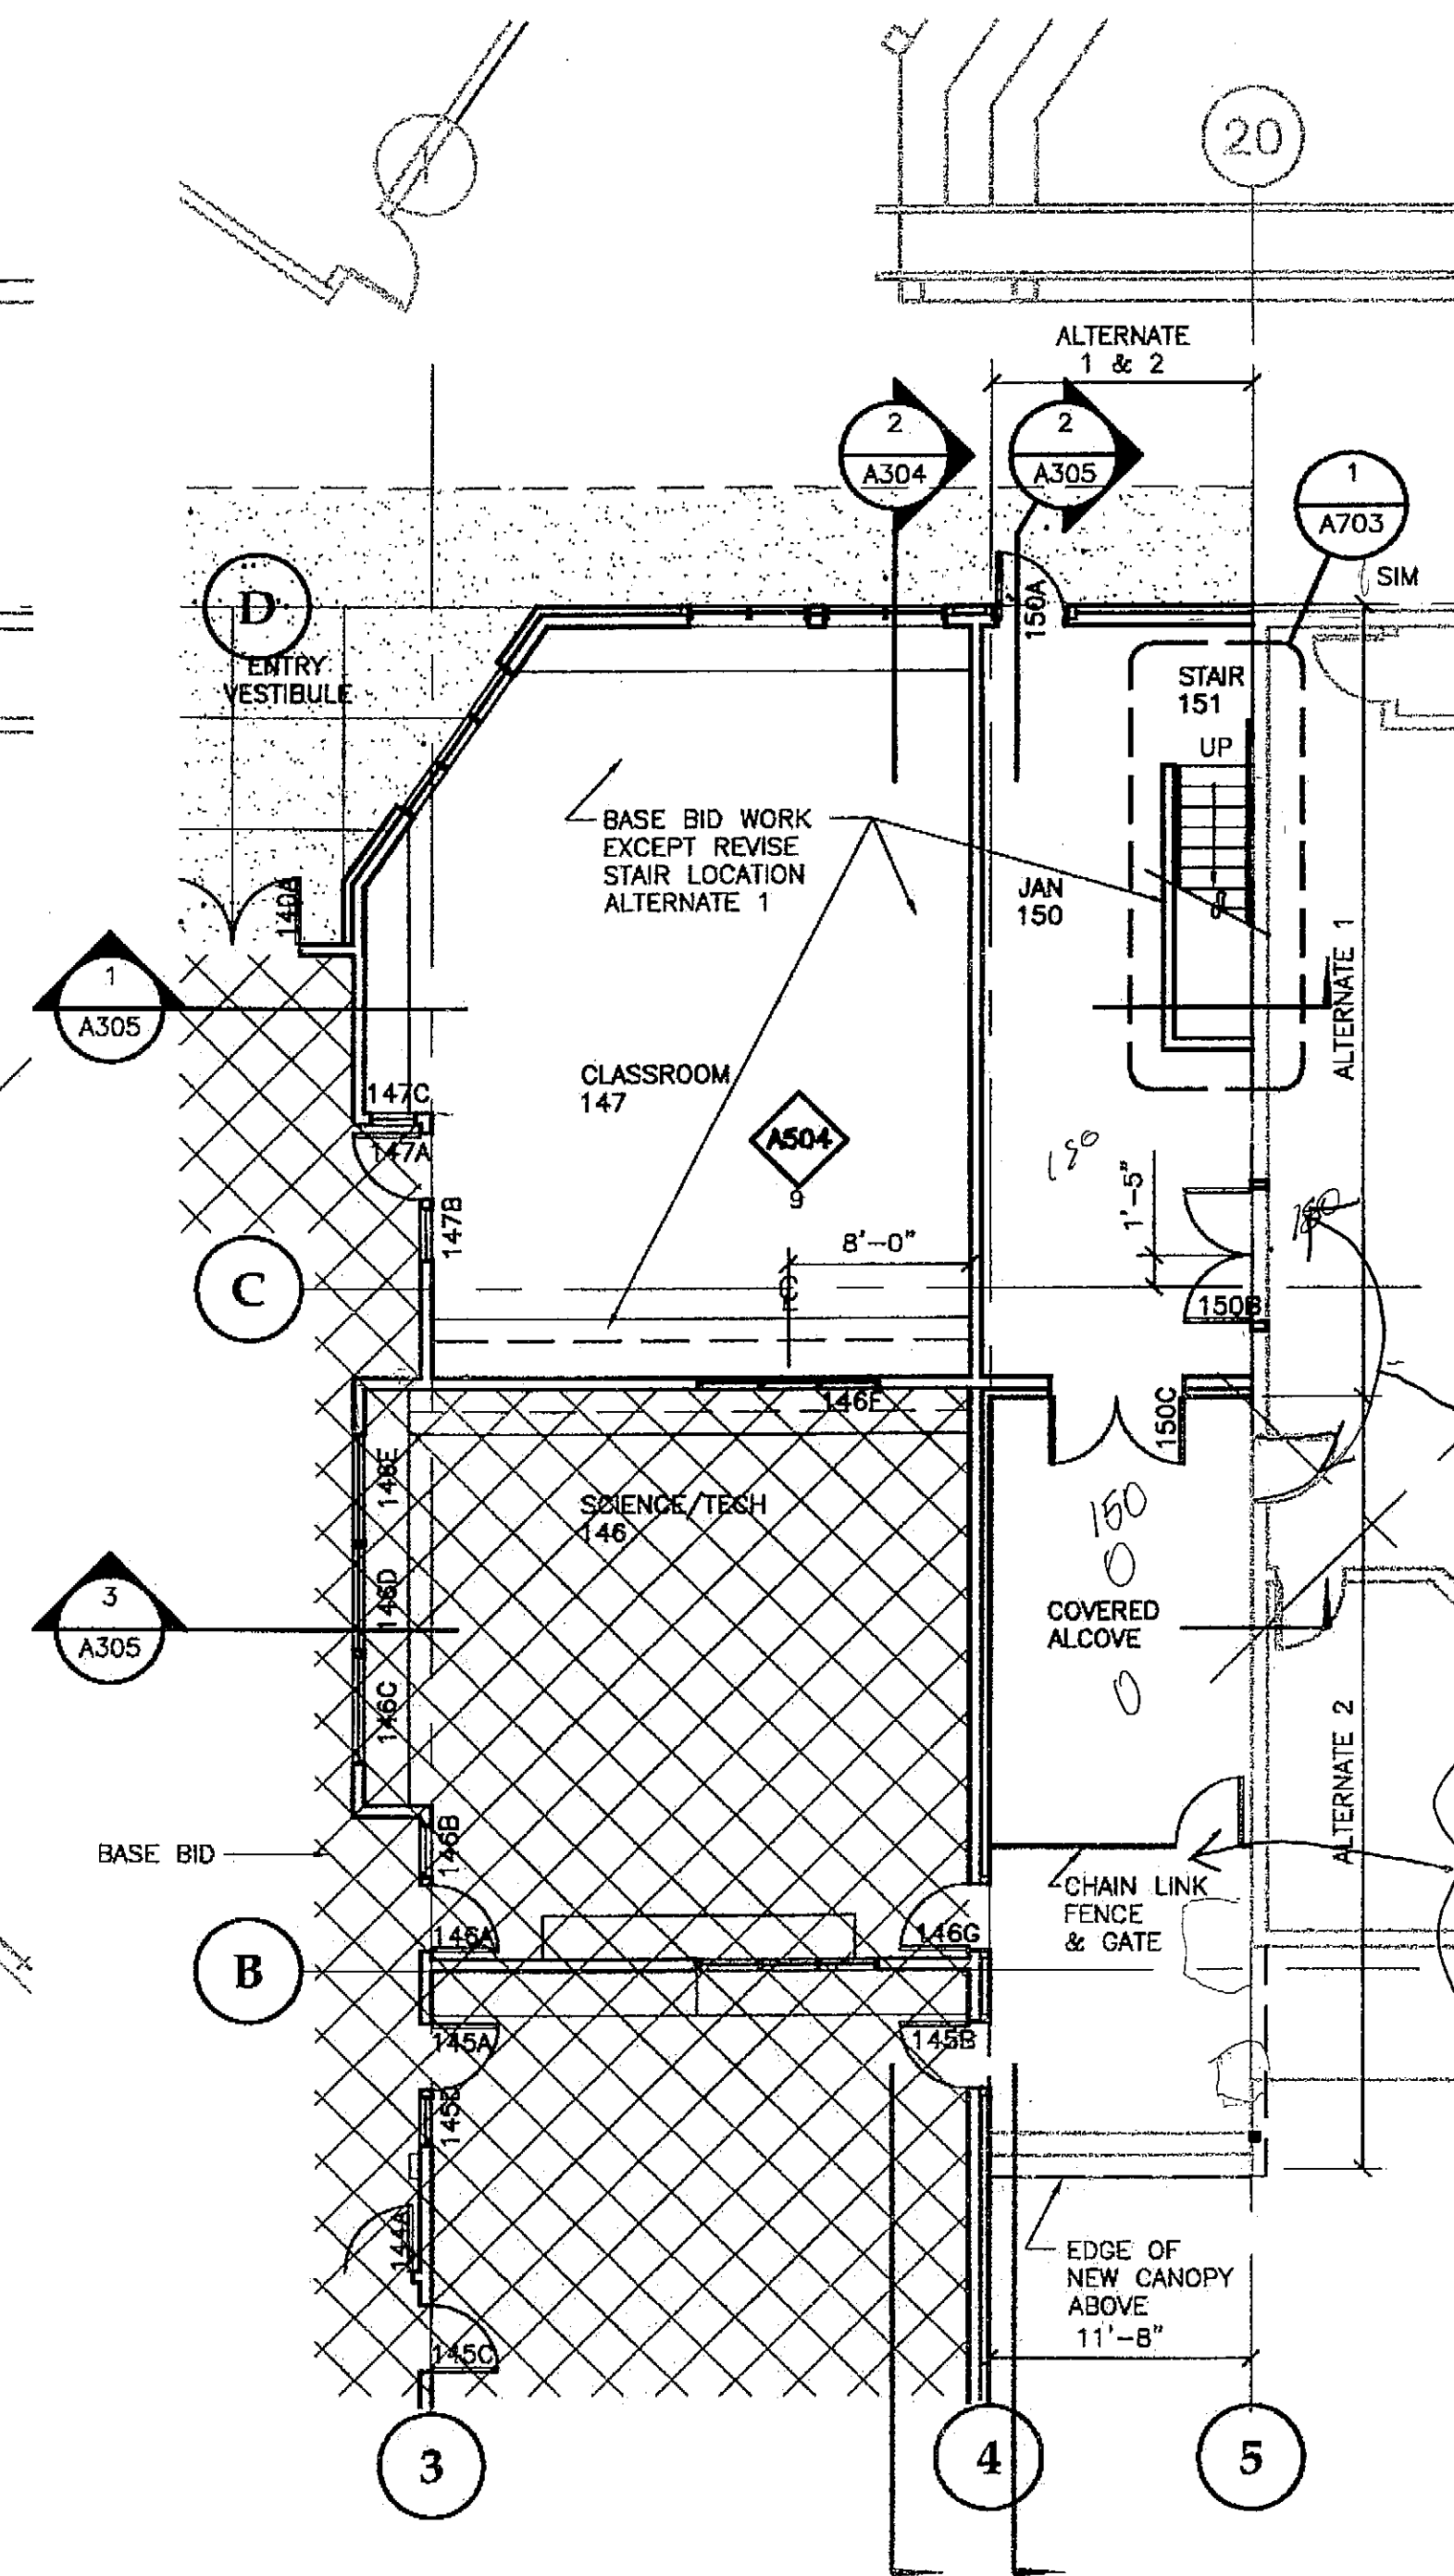

PARTIAL PLAN
ALTERNATE 1 & 2
MAIN FLOOR PLAN

SCALE: 0 4' 8' 16'

PATH: G:\Projects\0411\CD\1330\Arch\A203.dwg

Tue, 14/Dec/04 02:28PM


TAB: Layout1

ADDENDUM NUMBER


ATTACHMENT NUMBER

RECORD OF REVISIONS

No.	DATE	DESCRIPTION

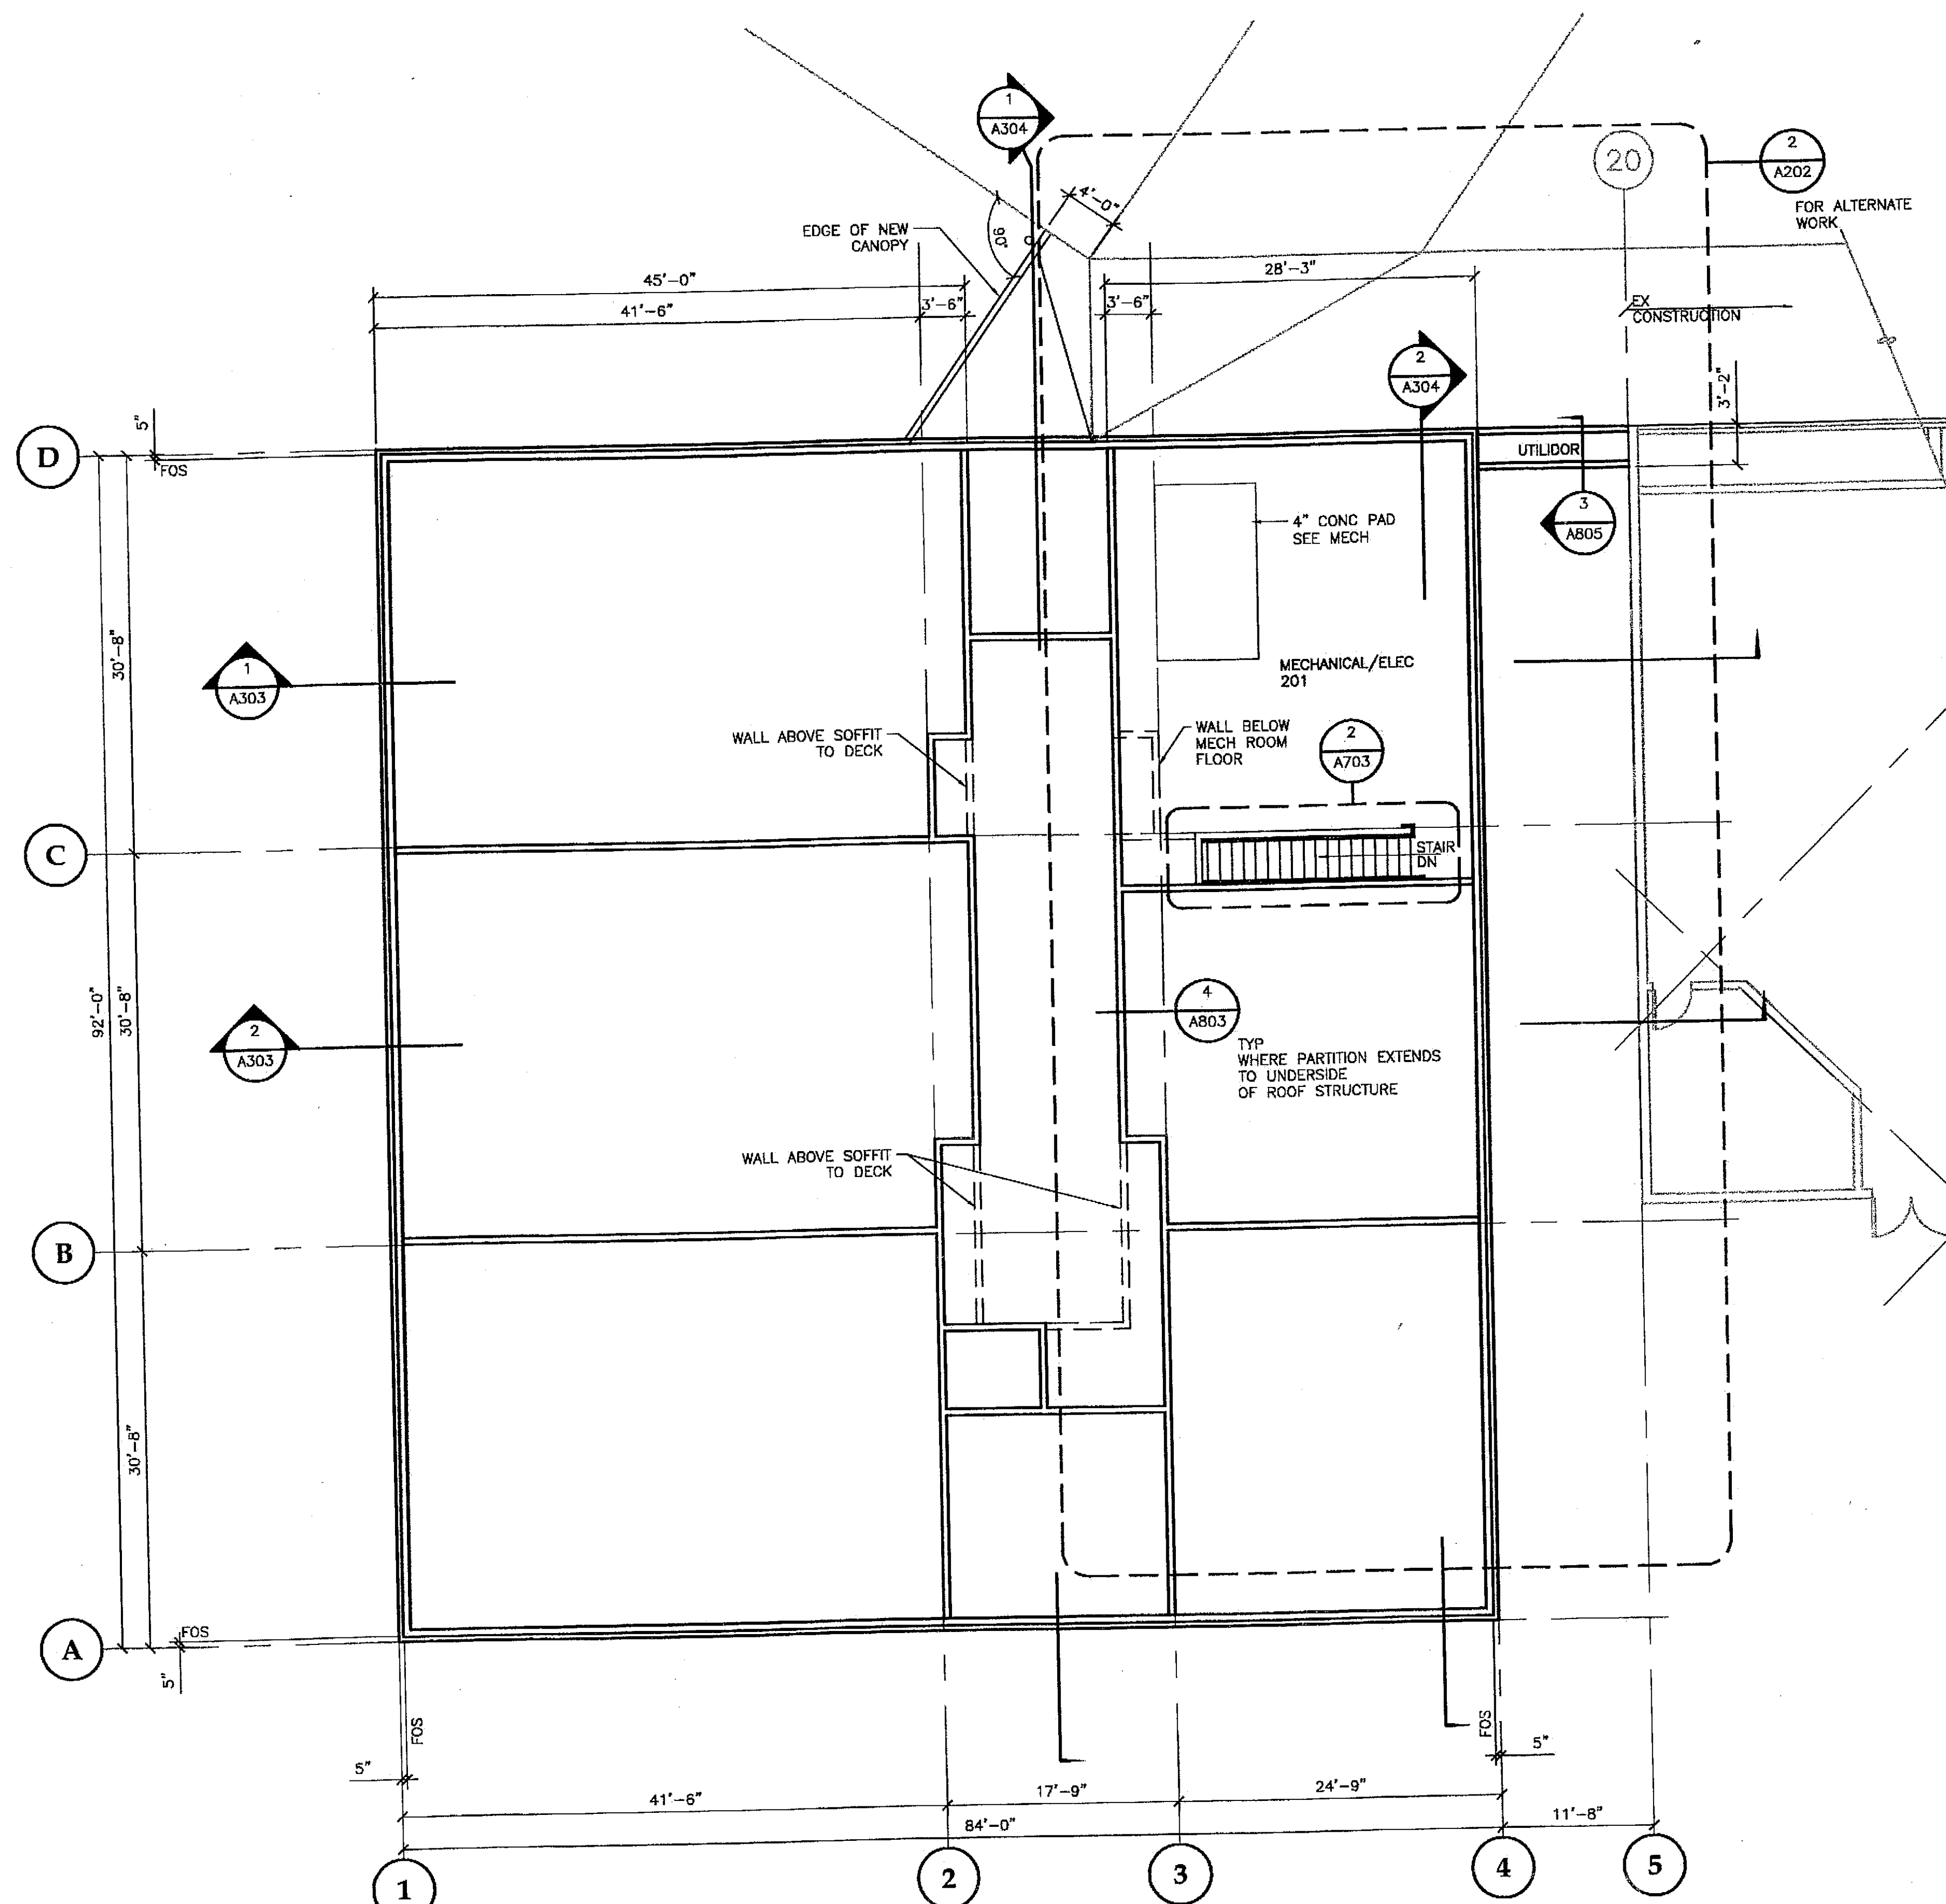


1 MECH ROOM FLOOR PLAN-BASE BID
SCALE: 0 4' 8' 16'

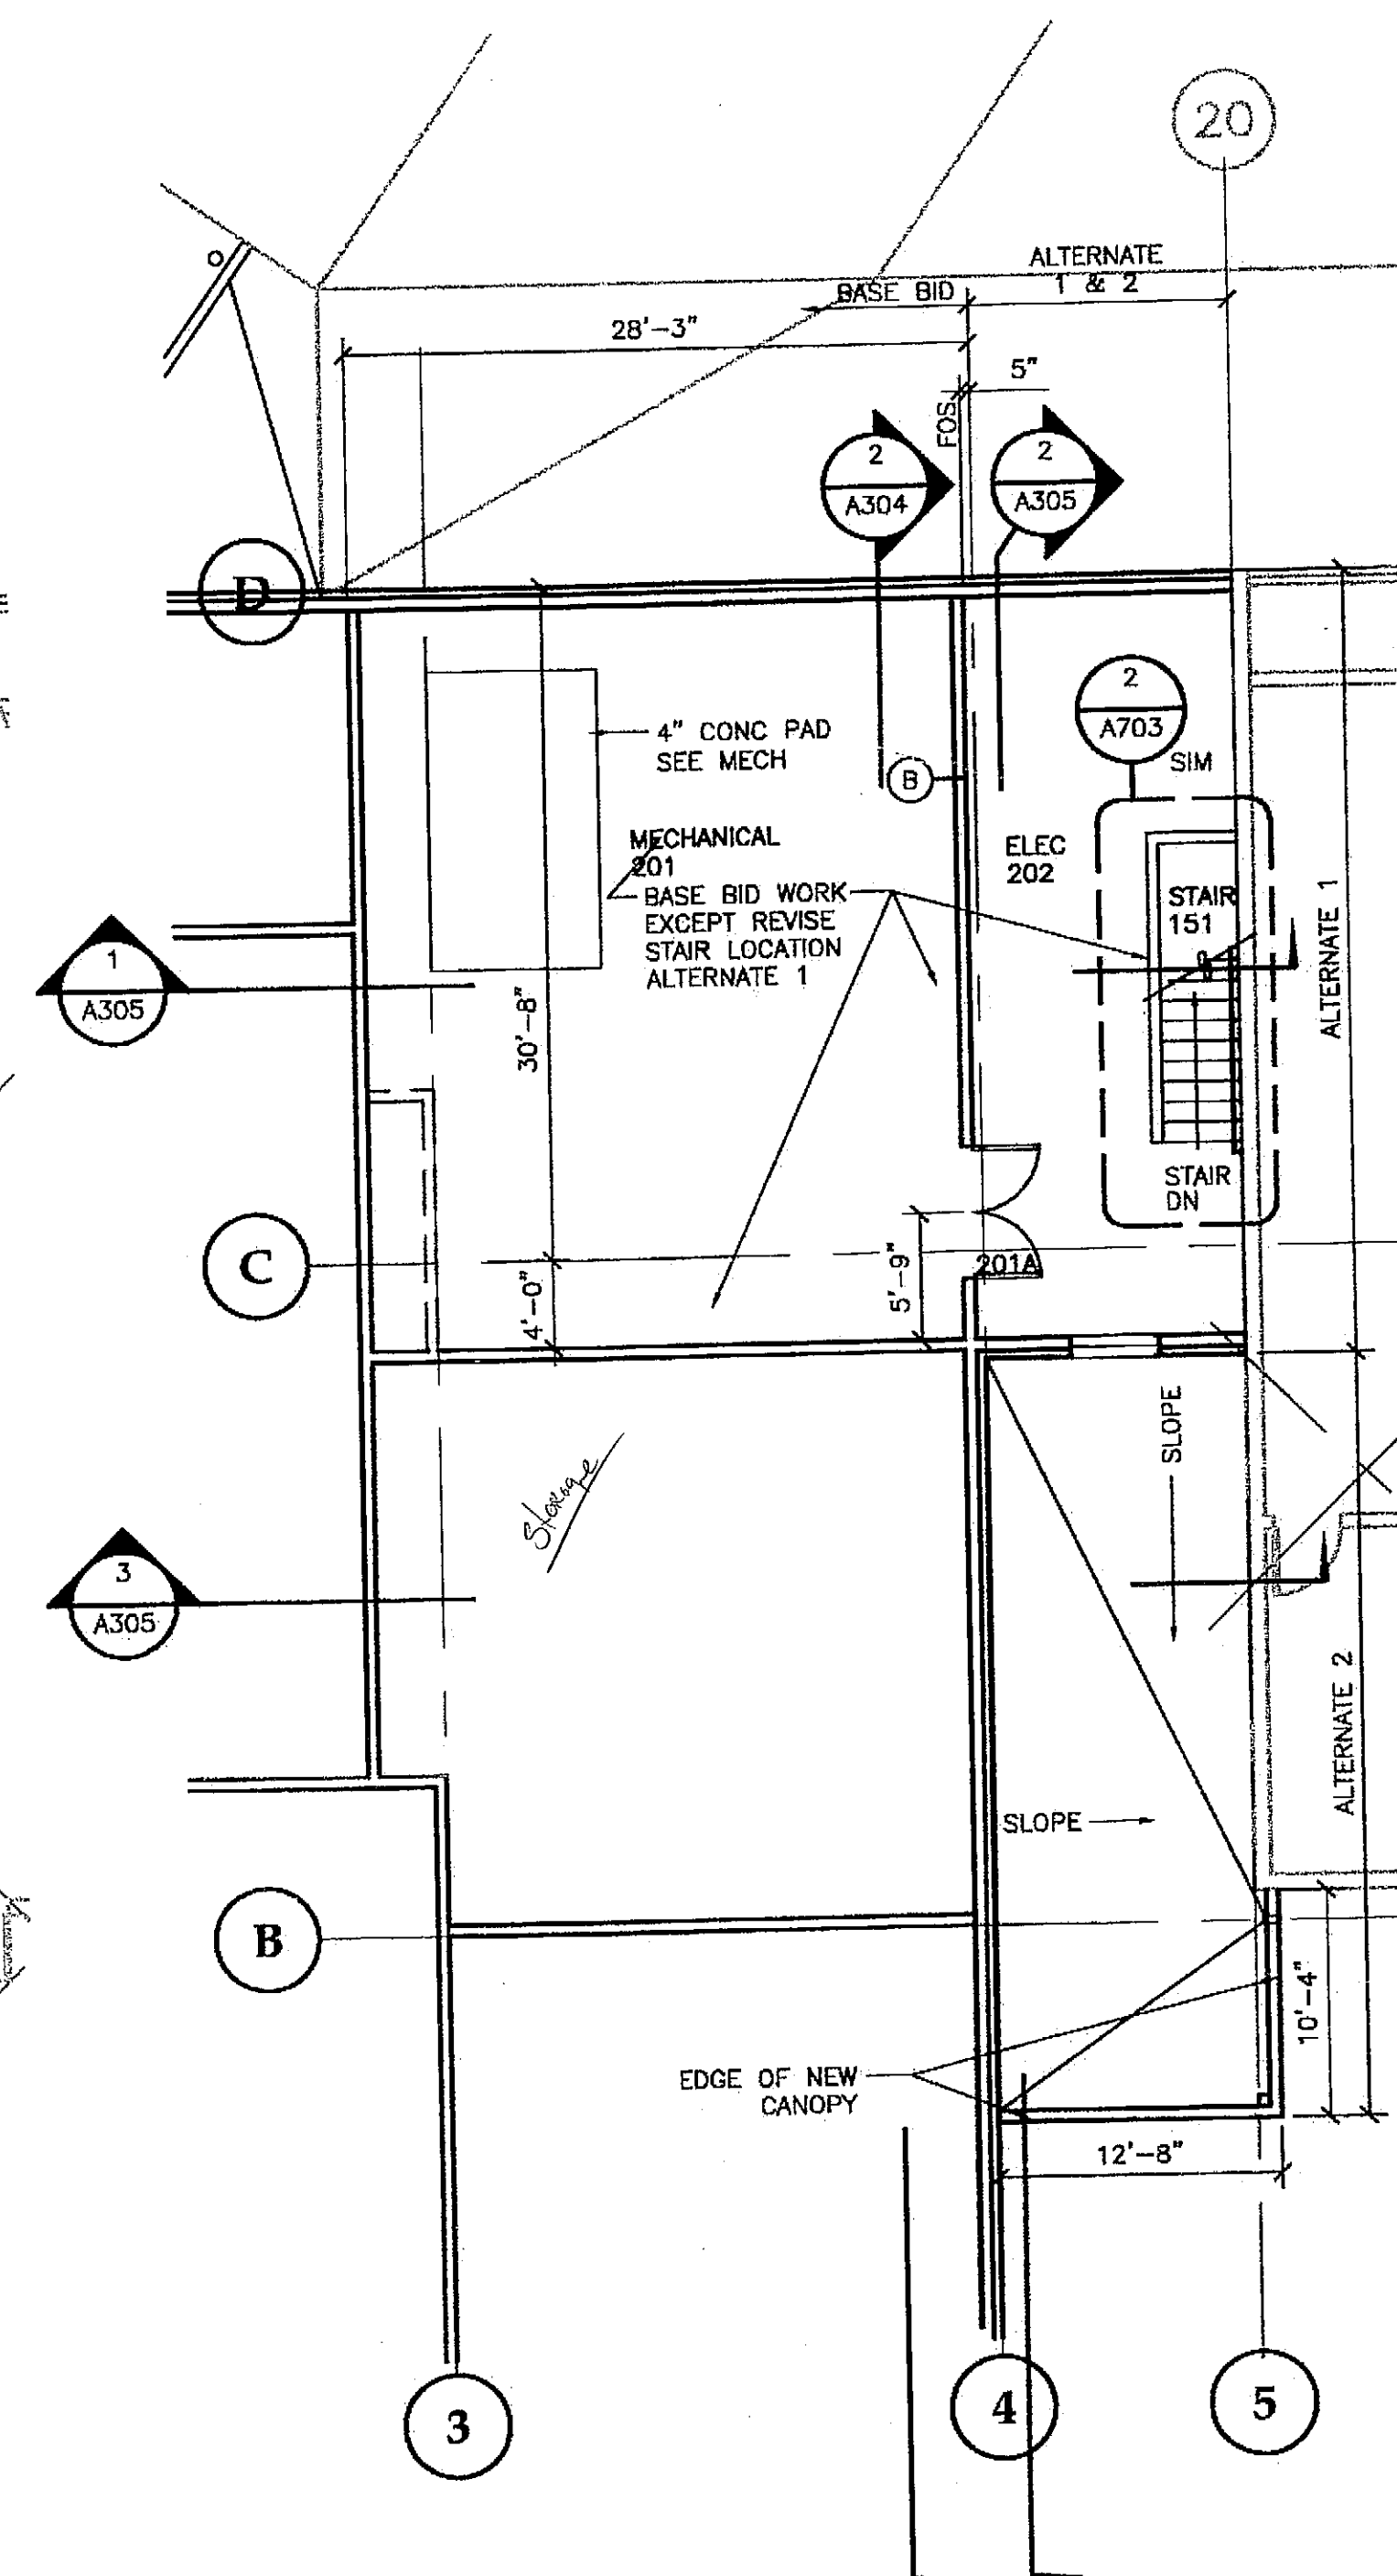

2 ALTERNATE 1 & 2 MECH/ROOM FLOOR PLAN
SCALE: 0 4' 8' 16'

CHECKED BY:

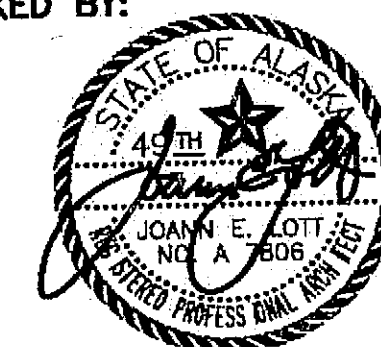

DESIGNED BY: JENSEN YORBA LOT

DRAWN BY:

STATE OF ALASKA
DEPARTMENT OF TRANSPORTATION
& PUBLIC FACILITIES
STATEWIDE DESIGN & ENGINEERING
SERVICES DIVISION

MT EDGE CUMBE
HIGH SCHOOL
BUILDING 1330
ACADEMIC
EXPANSION

SHEET A203

PROJECT DESIGNATION NUMBER

67751C

STATE	YEAR
ALASKA	2004

SHEET NUMBER	TOTAL SHEETS
7	79


ADDENDUM NUMBER

ATTACHMENT NUMBER

RECORD OF REVISIONS

No.	DATE	DESCRIPTION

CHECKED BY:

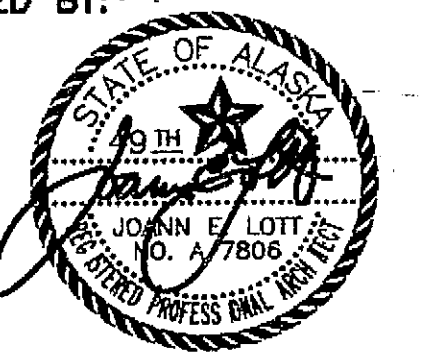

DESIGNED BY: JENSEN YORBA LOTT

DRAWN BY:

STATE OF ALASKA
DEPARTMENT OF TRANSPORTATION
& PUBLIC FACILITIES
STATEWIDE DESIGN & ENGINEERING
SERVICES DIVISION
MT EDGECUMBE
HIGH SCHOOL
BUILDING 1330
ACADEMIC
EXPANSION

SHEET A205

PROJECT DESIGNATION NUMBER


67751C

STATE YEAR



ALASKA 2004

SHEET NUMBER TOTAL SHEETS


9 79

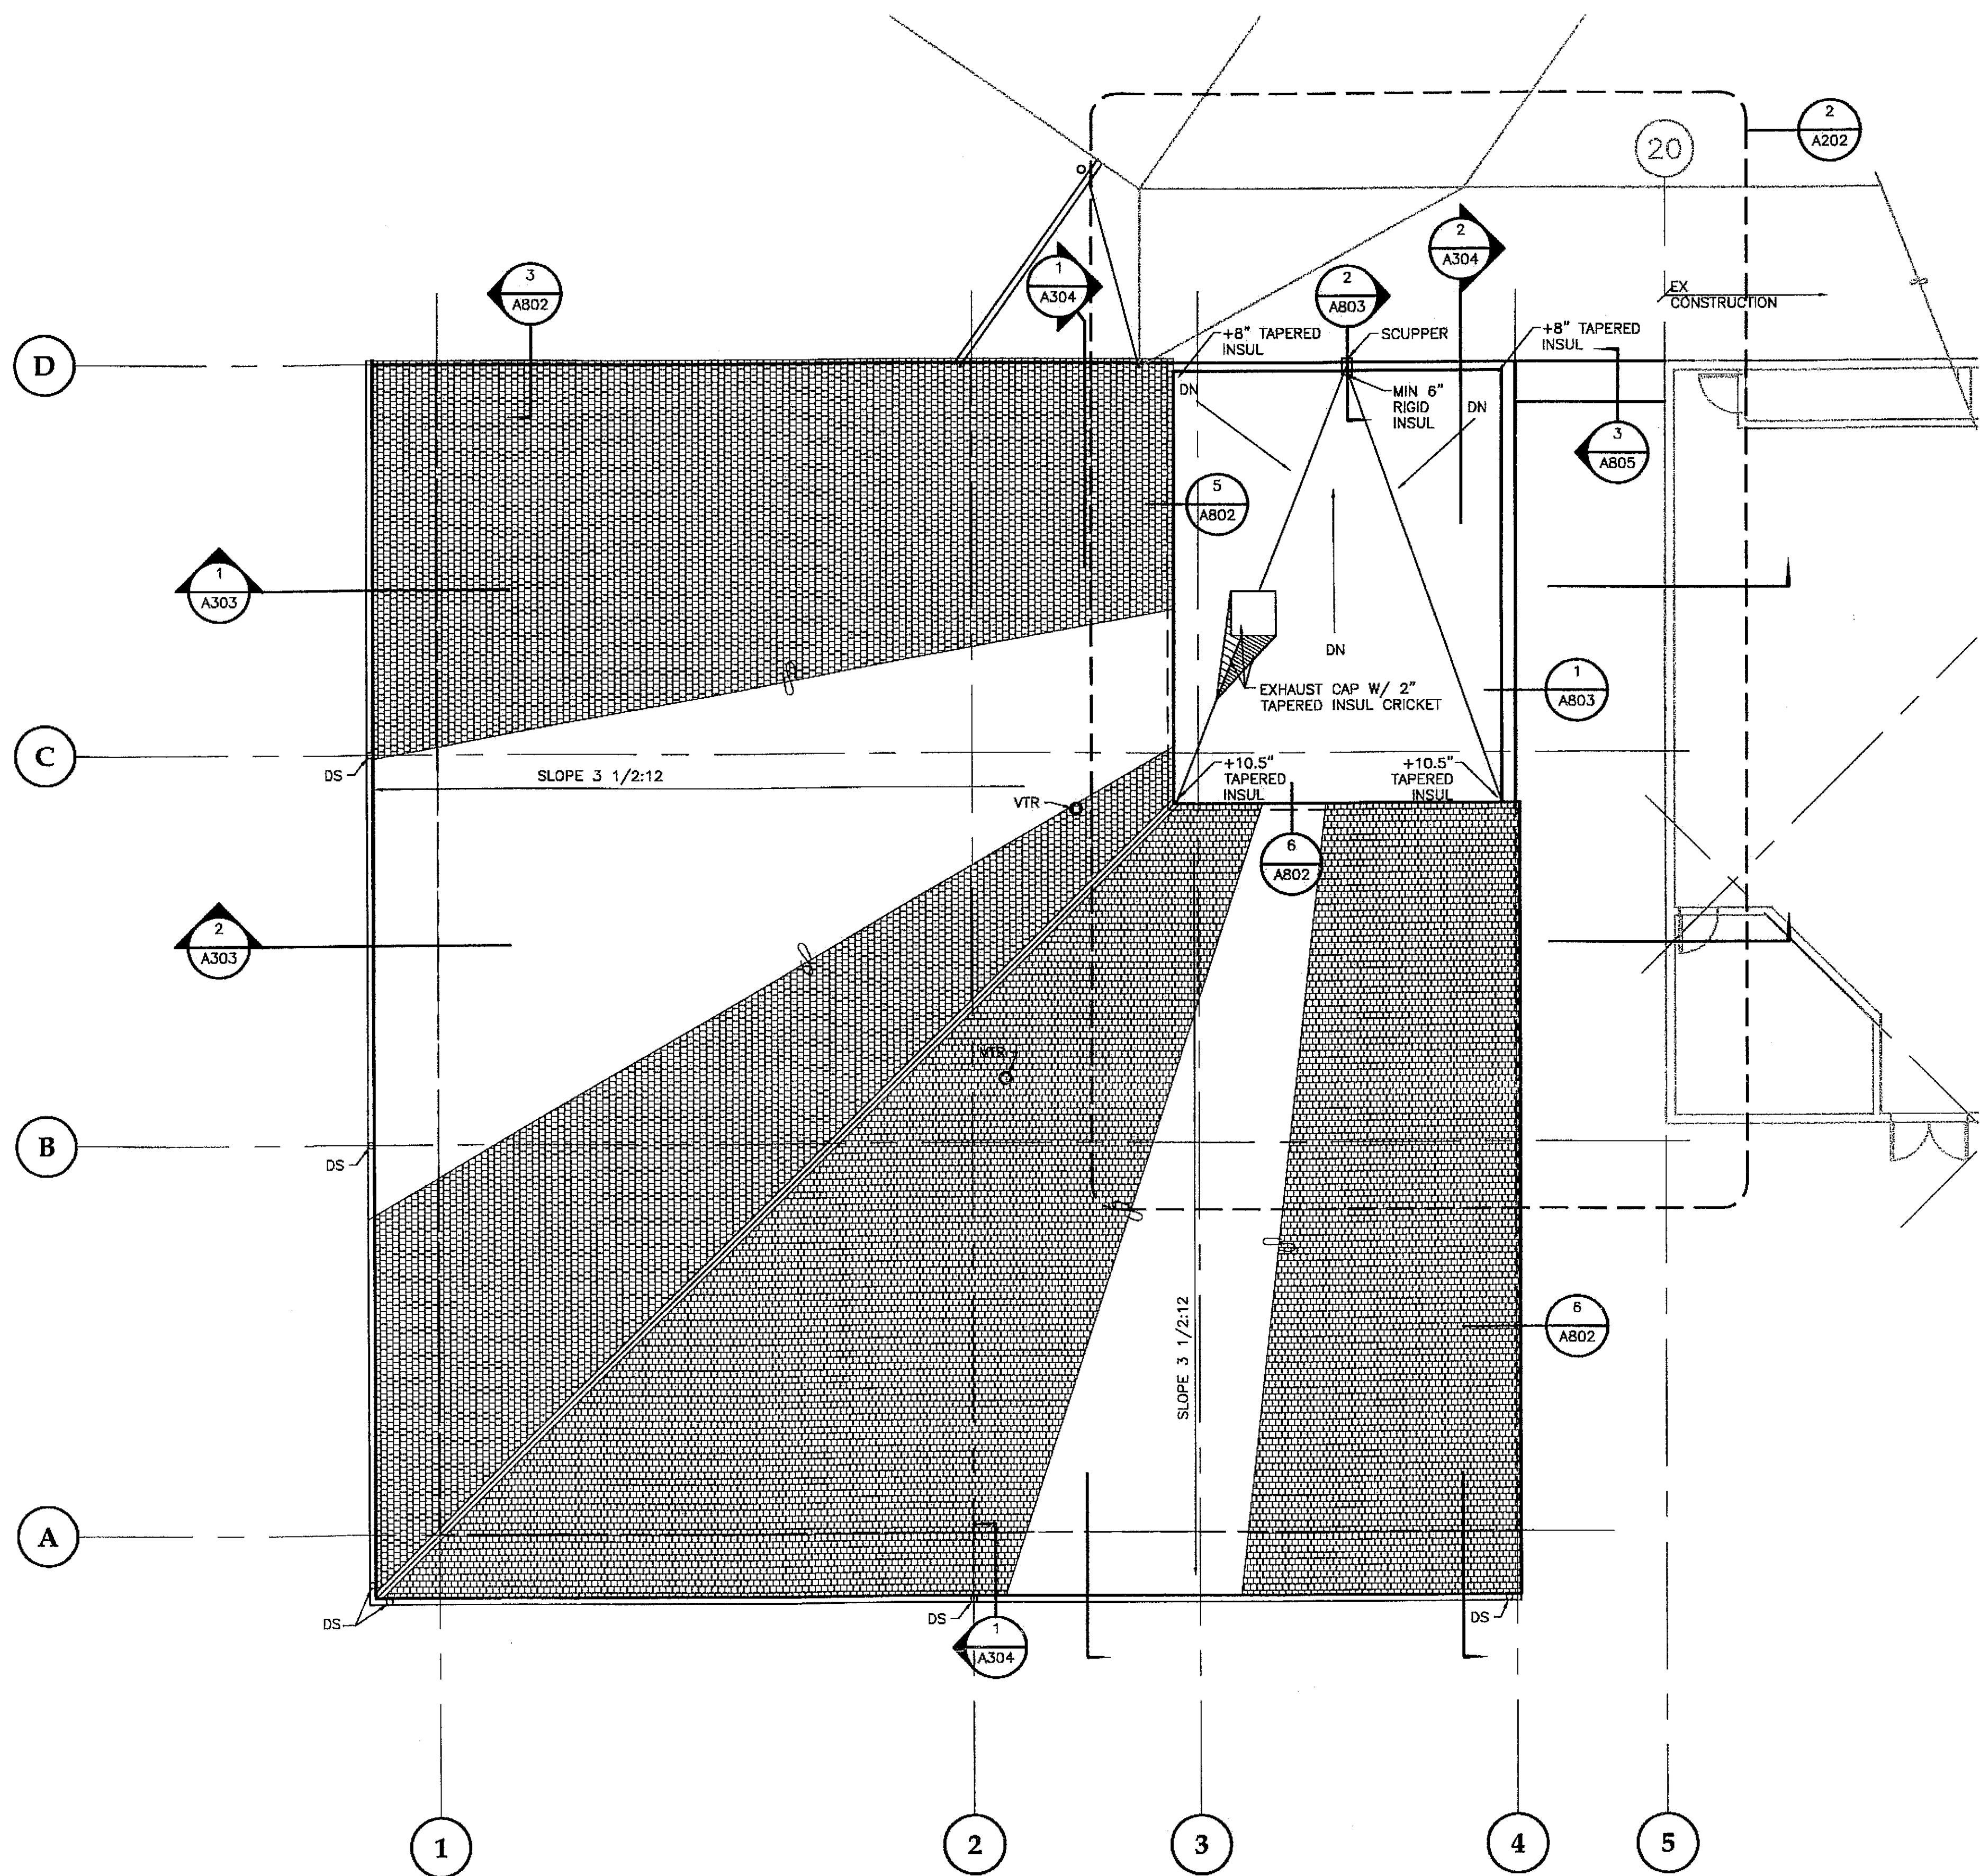

1 ROOF PLAN-BASE BID

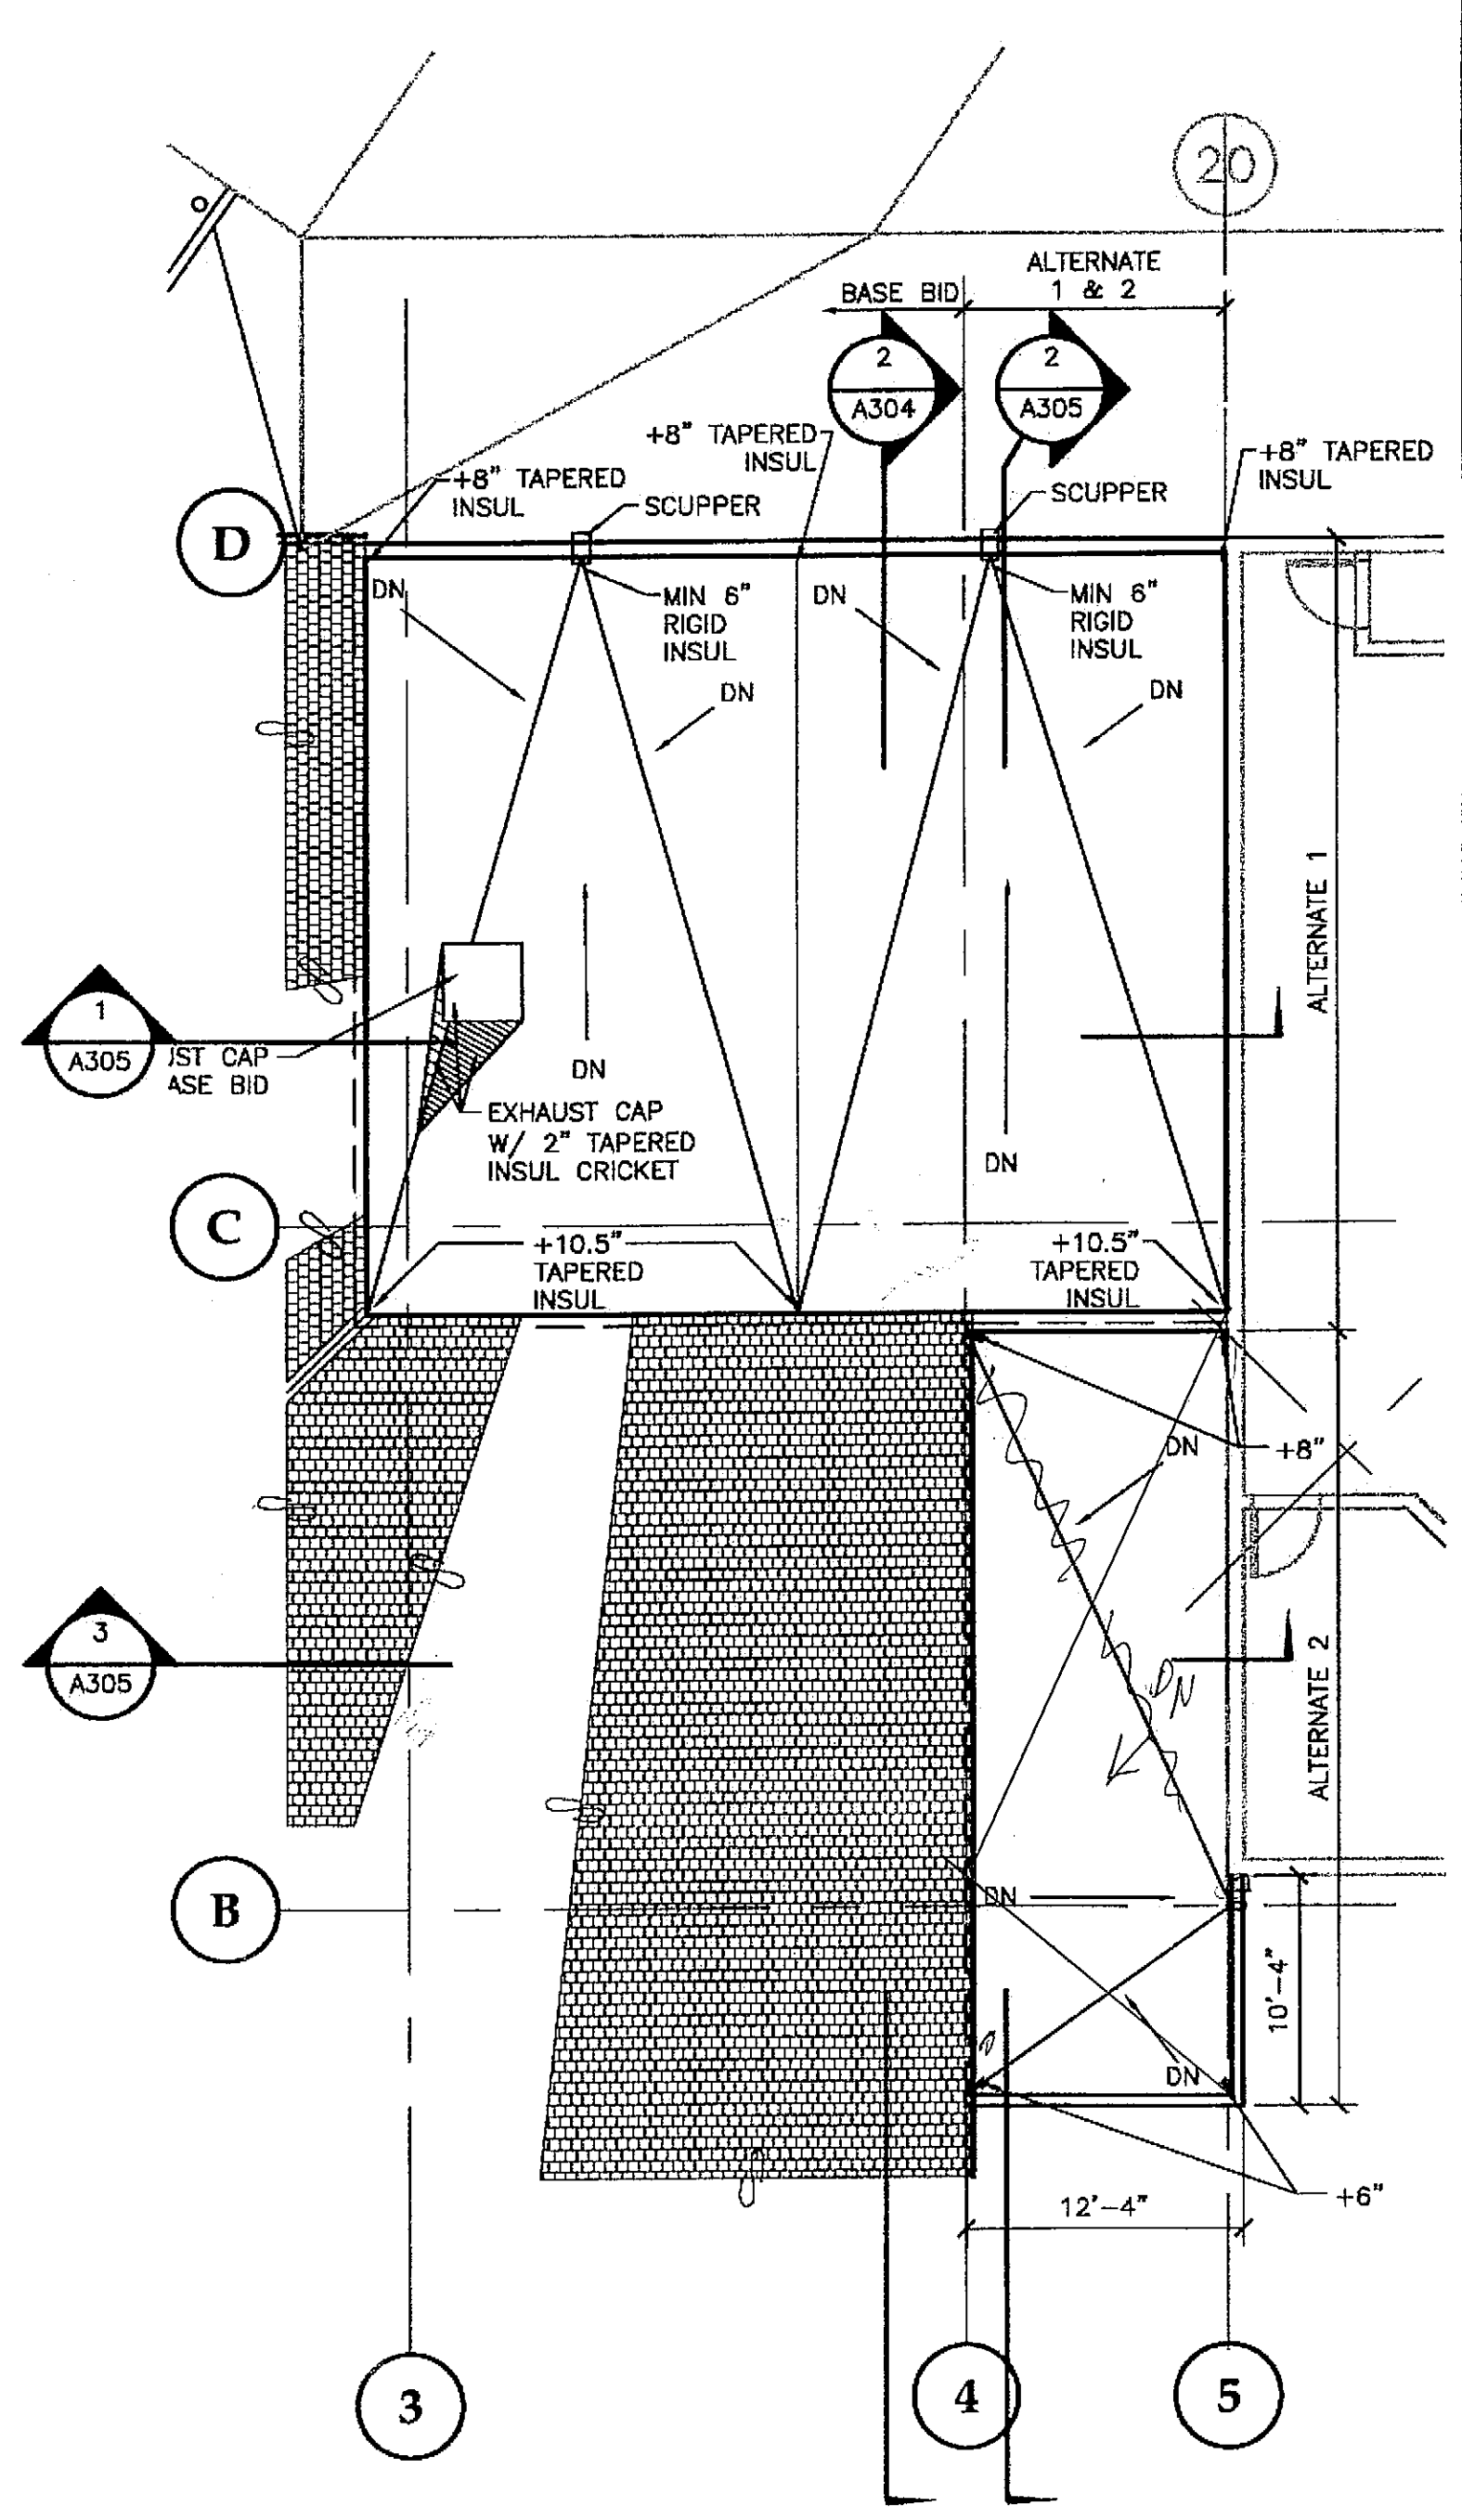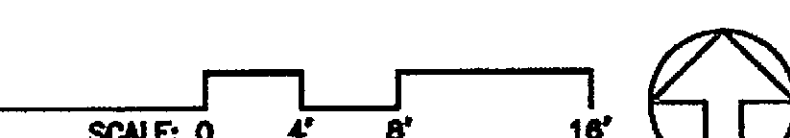

2 ALTERNATE 1 & 2 ROOF PLAN

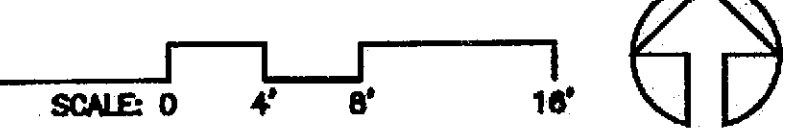

Project As-Built Drawings have been reviewed by the Project Engineer and represent to the best of my knowledge, the project as constructed.
Prof. Eng. *[Signature]* Date 7-07

PATH: G:_Projects\0411\CD\CD\1330\Arch\A301.dwg

Tue, 14/Dec/04 02:28PM


TAB: Layout1

ADDENDUM NUMBER

ATTACHMENT NUMBER


RECORD OF REVISIONS

No.	DATE	DESCRIPTION

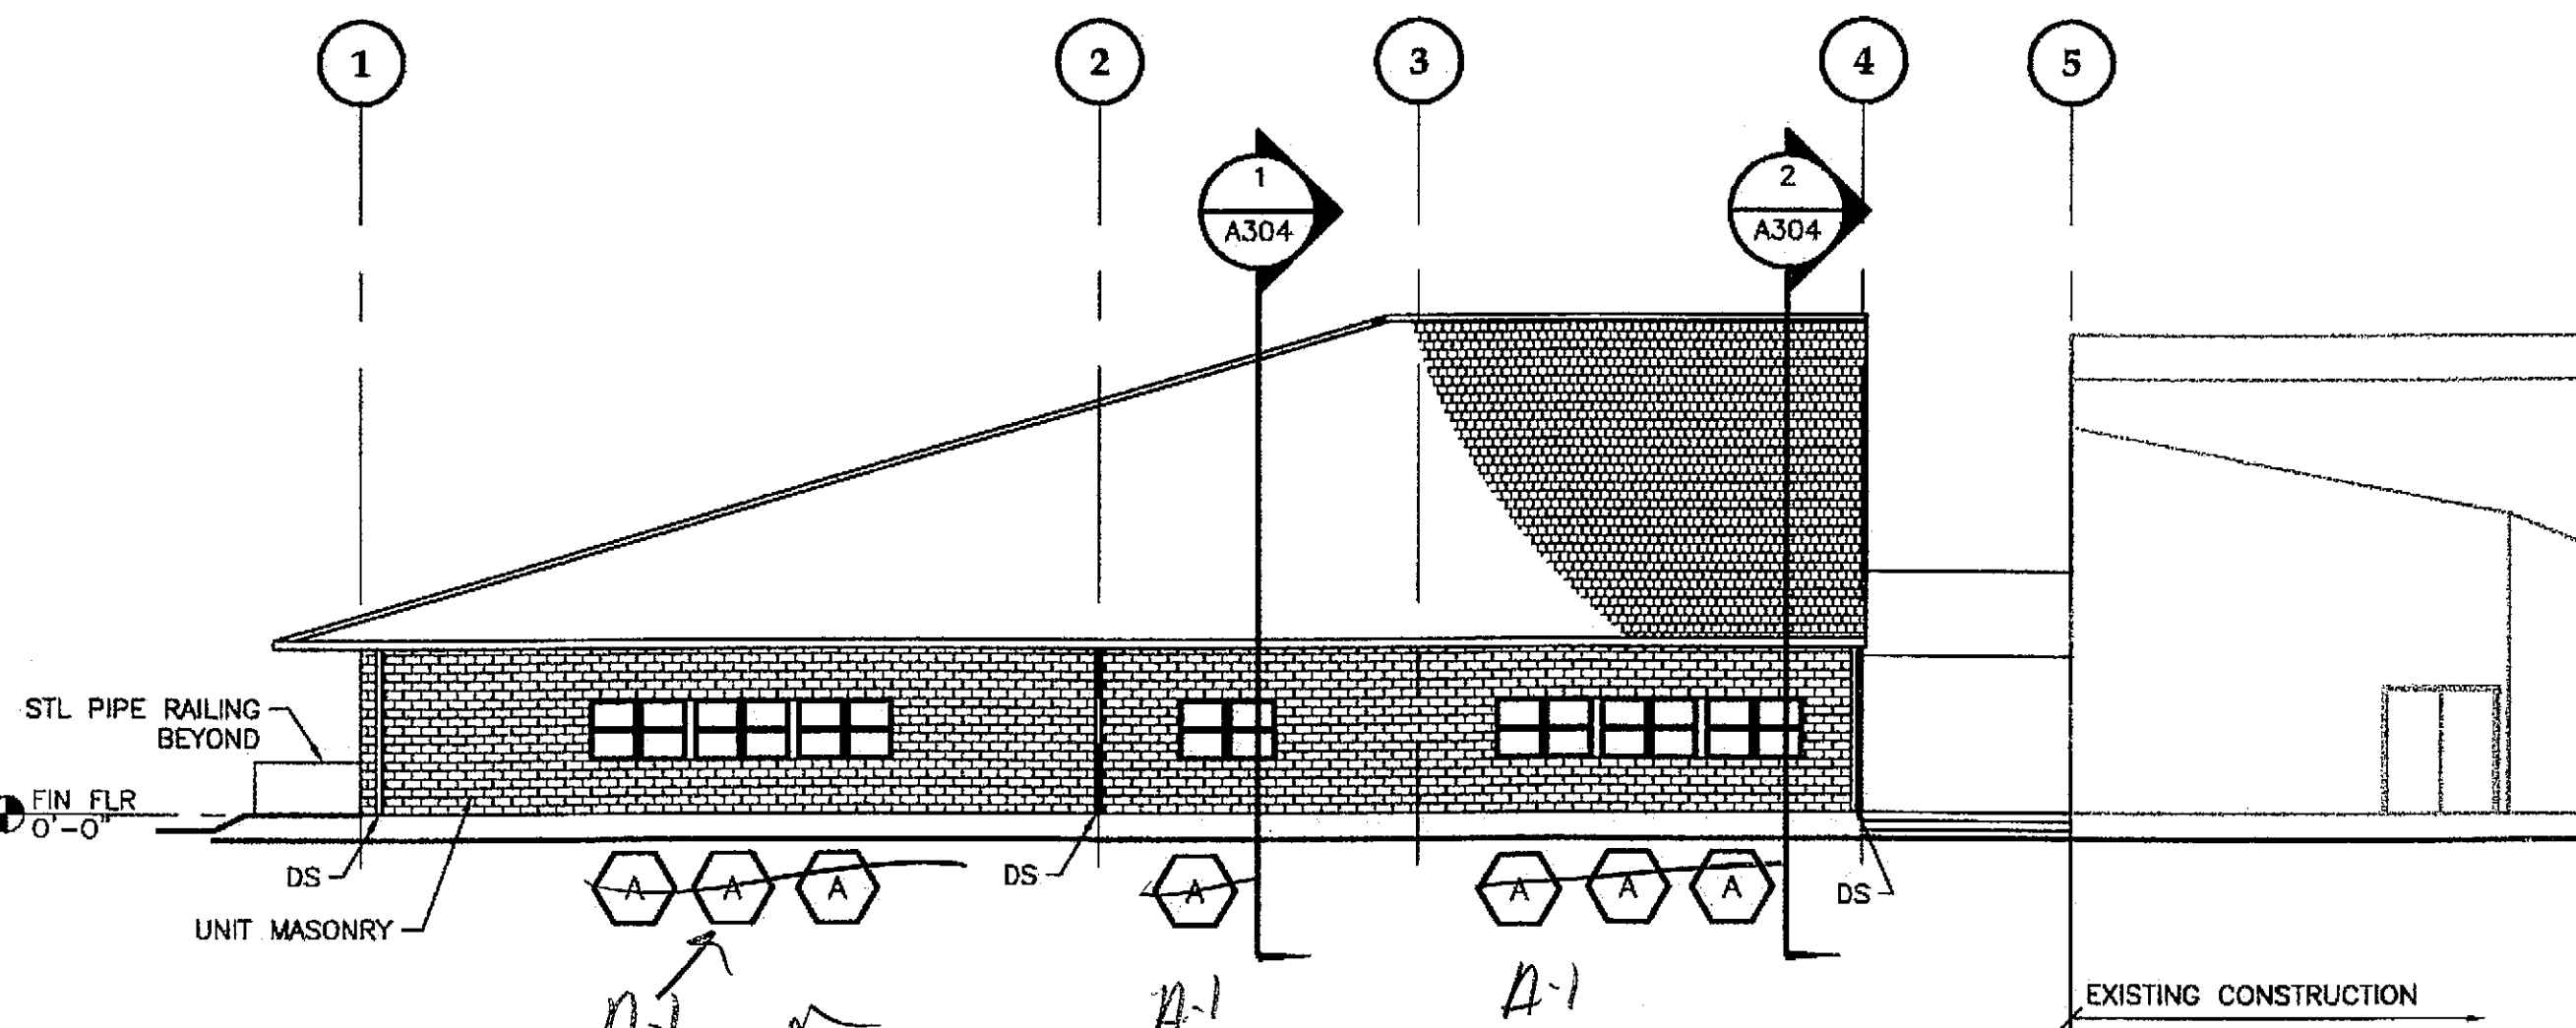


1 EXTERIOR ELEVATION - BASE BID

SCALE: 0 5' 10' 20'

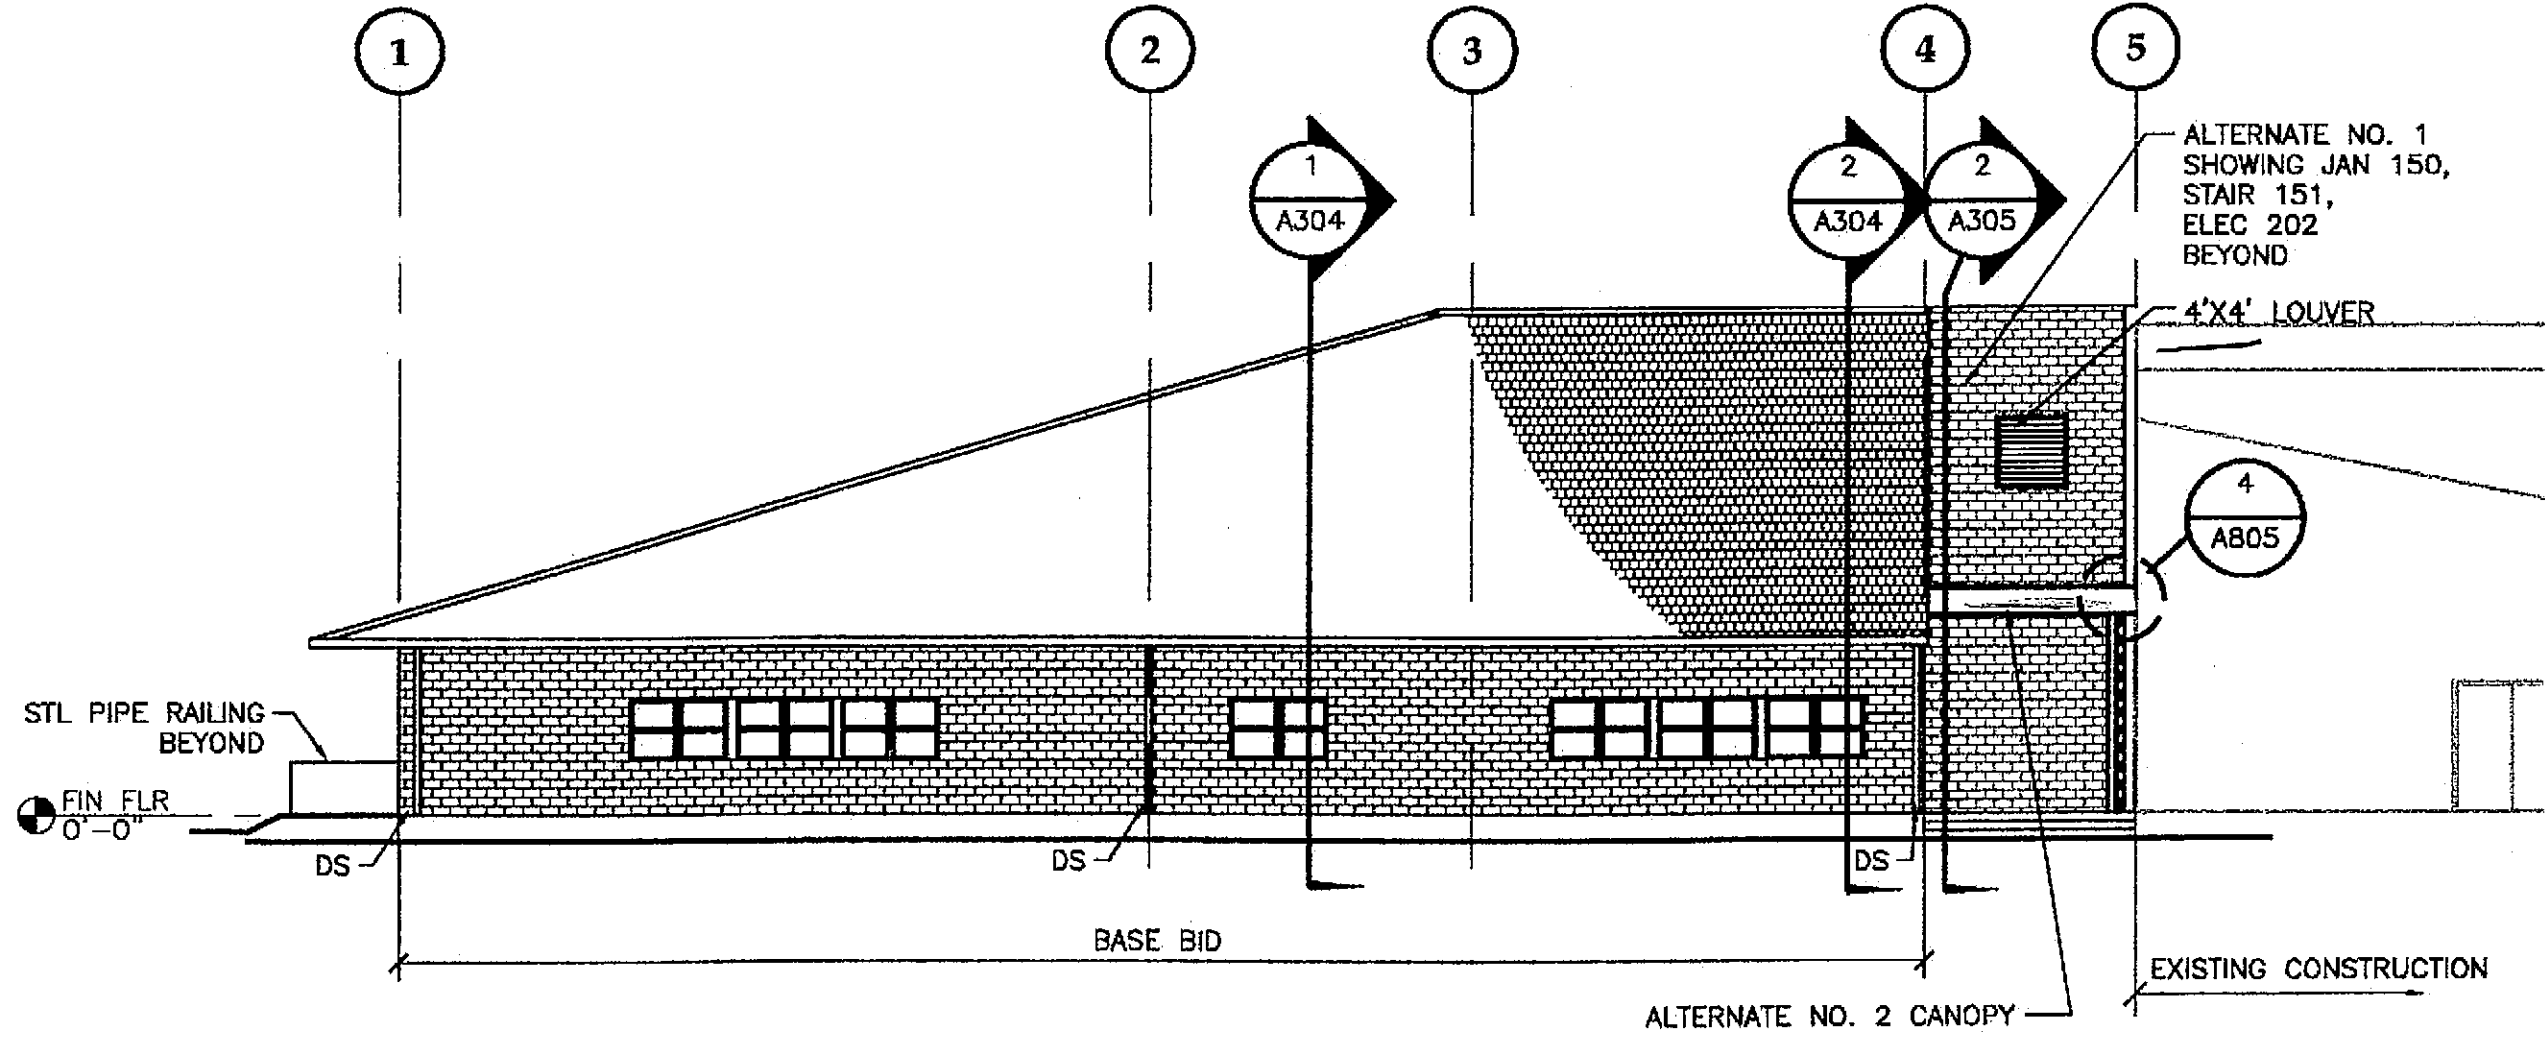

2 EXTERIOR ELEVATION - ALTERNATE NO. 1


SCALE: 0 5' 10' 20'

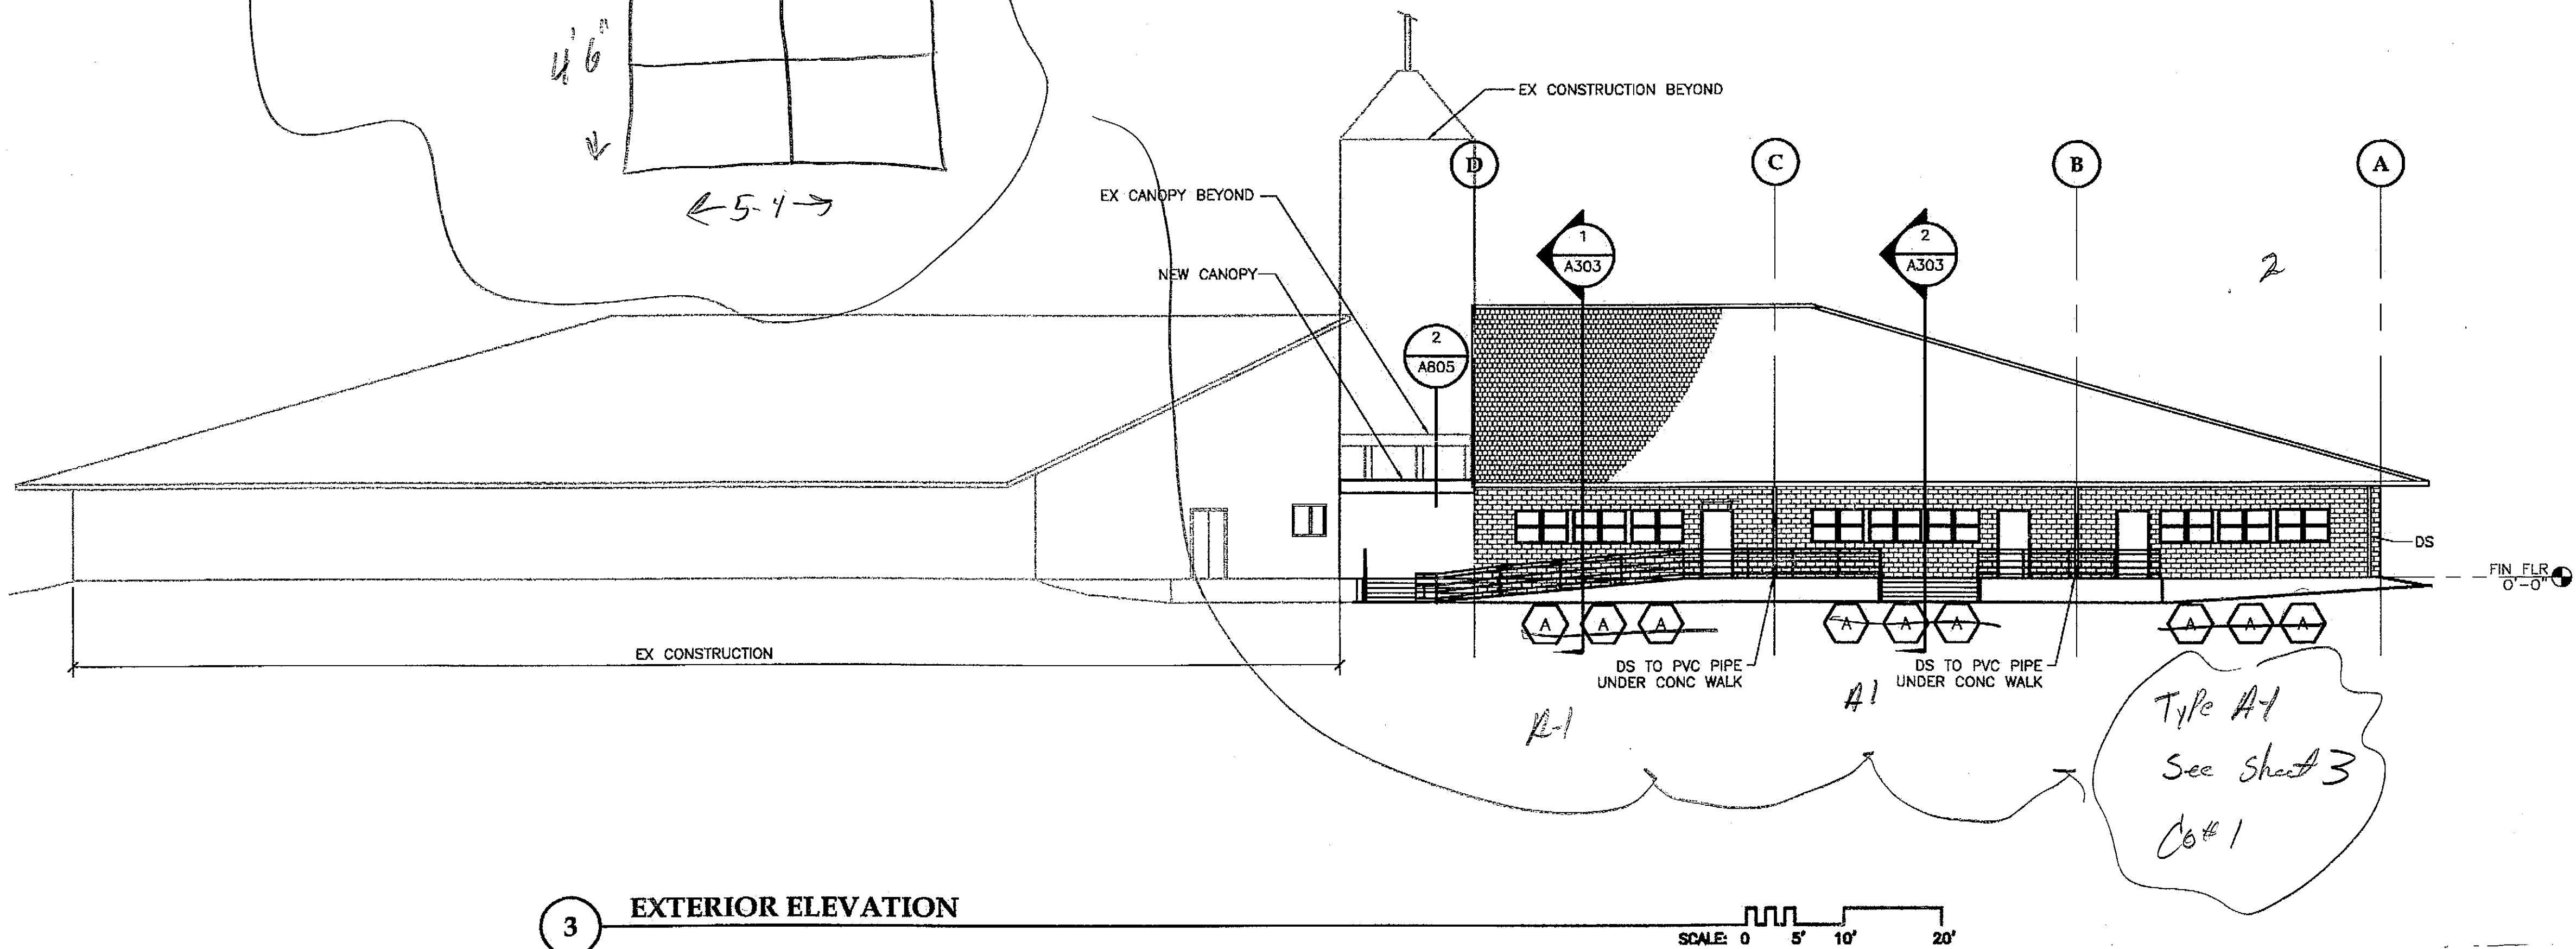

3 EXTERIOR ELEVATION

SCALE: 0 5' 10' 20'

CHECKED BY:

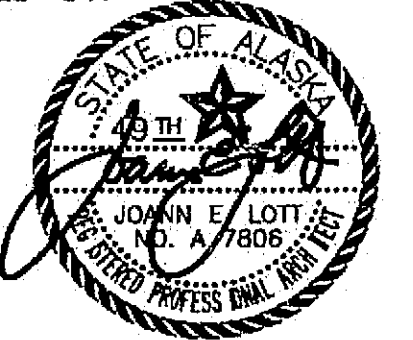

DESIGNED BY: JENSEN YORBA LOTT

DRAWN BY:

STATE OF ALASKA
DEPARTMENT OF TRANSPORTATION
& PUBLIC FACILITIES
STATEWIDE DESIGN & ENGINEERING
SERVICES DIVISION

MT EDGE CUMBE
HIGH SCHOOL
BUILDING 1330
ACADEMIC
EXPANSION

SHEET A301

PROJECT DESIGNATION NUMBER

67751C

STATE	YEAR
ALASKA	2004
SHEET NUMBER	TOTAL SHEETS
10	79

Project As-Built Drawings have been reviewed by the Project Engineer and represent to the best of my knowledge, the project as constructed.
Prof. Eng. *M. Mull* Date 7-07


PATH: G:\Projects\0411\CD\CD\1330\Arch\A302.dwg
 Tue, 14/Dec/04 02:28PM
 TAB: Layout1

ADDENDUM NUMBER

ATTACHMENT NUMBER


RECORD OF REVISIONS

No.	DATE	DESCRIPTION

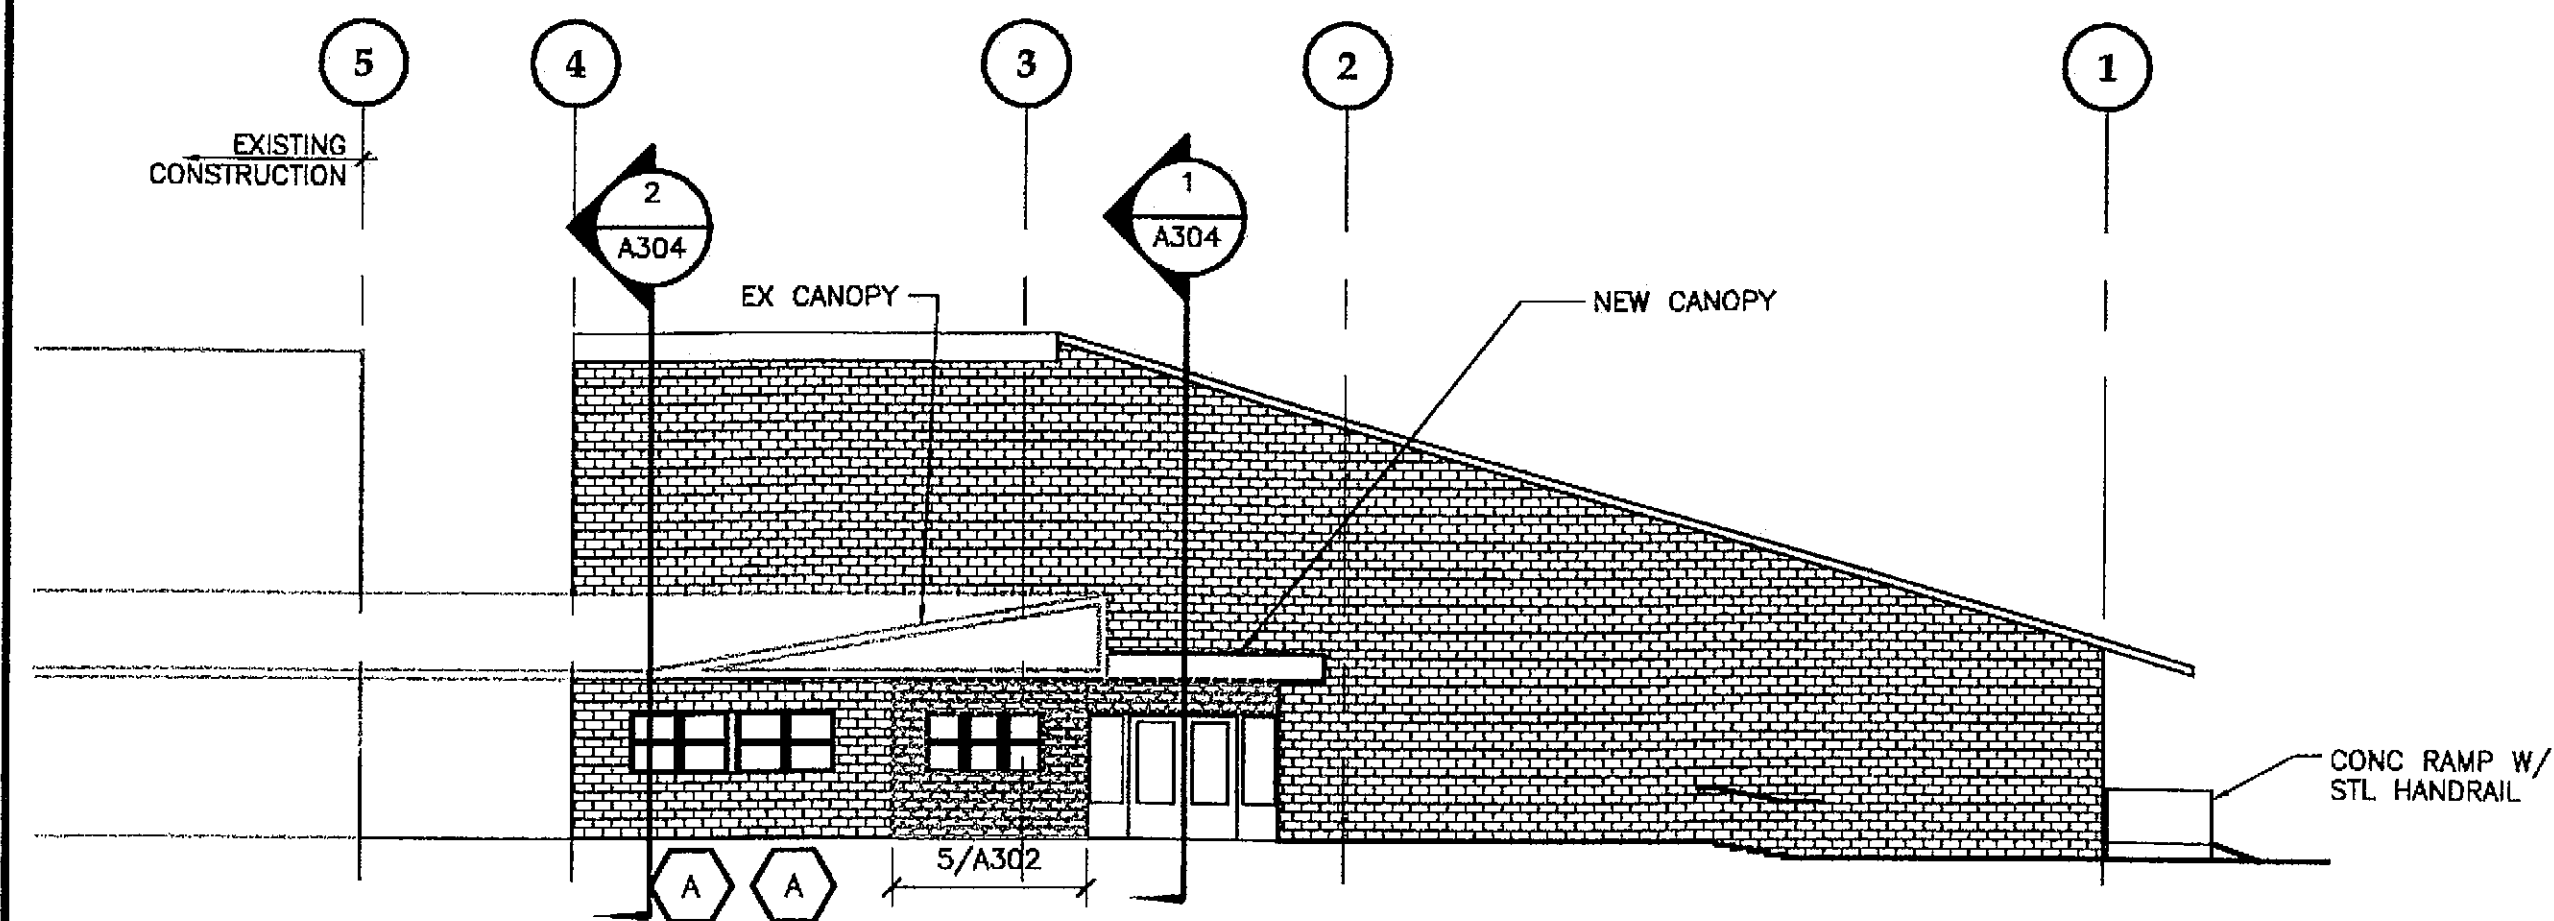


1 EXTERIOR ELEVATION - BASE BID

SCALE: 0 5' 10' 20'

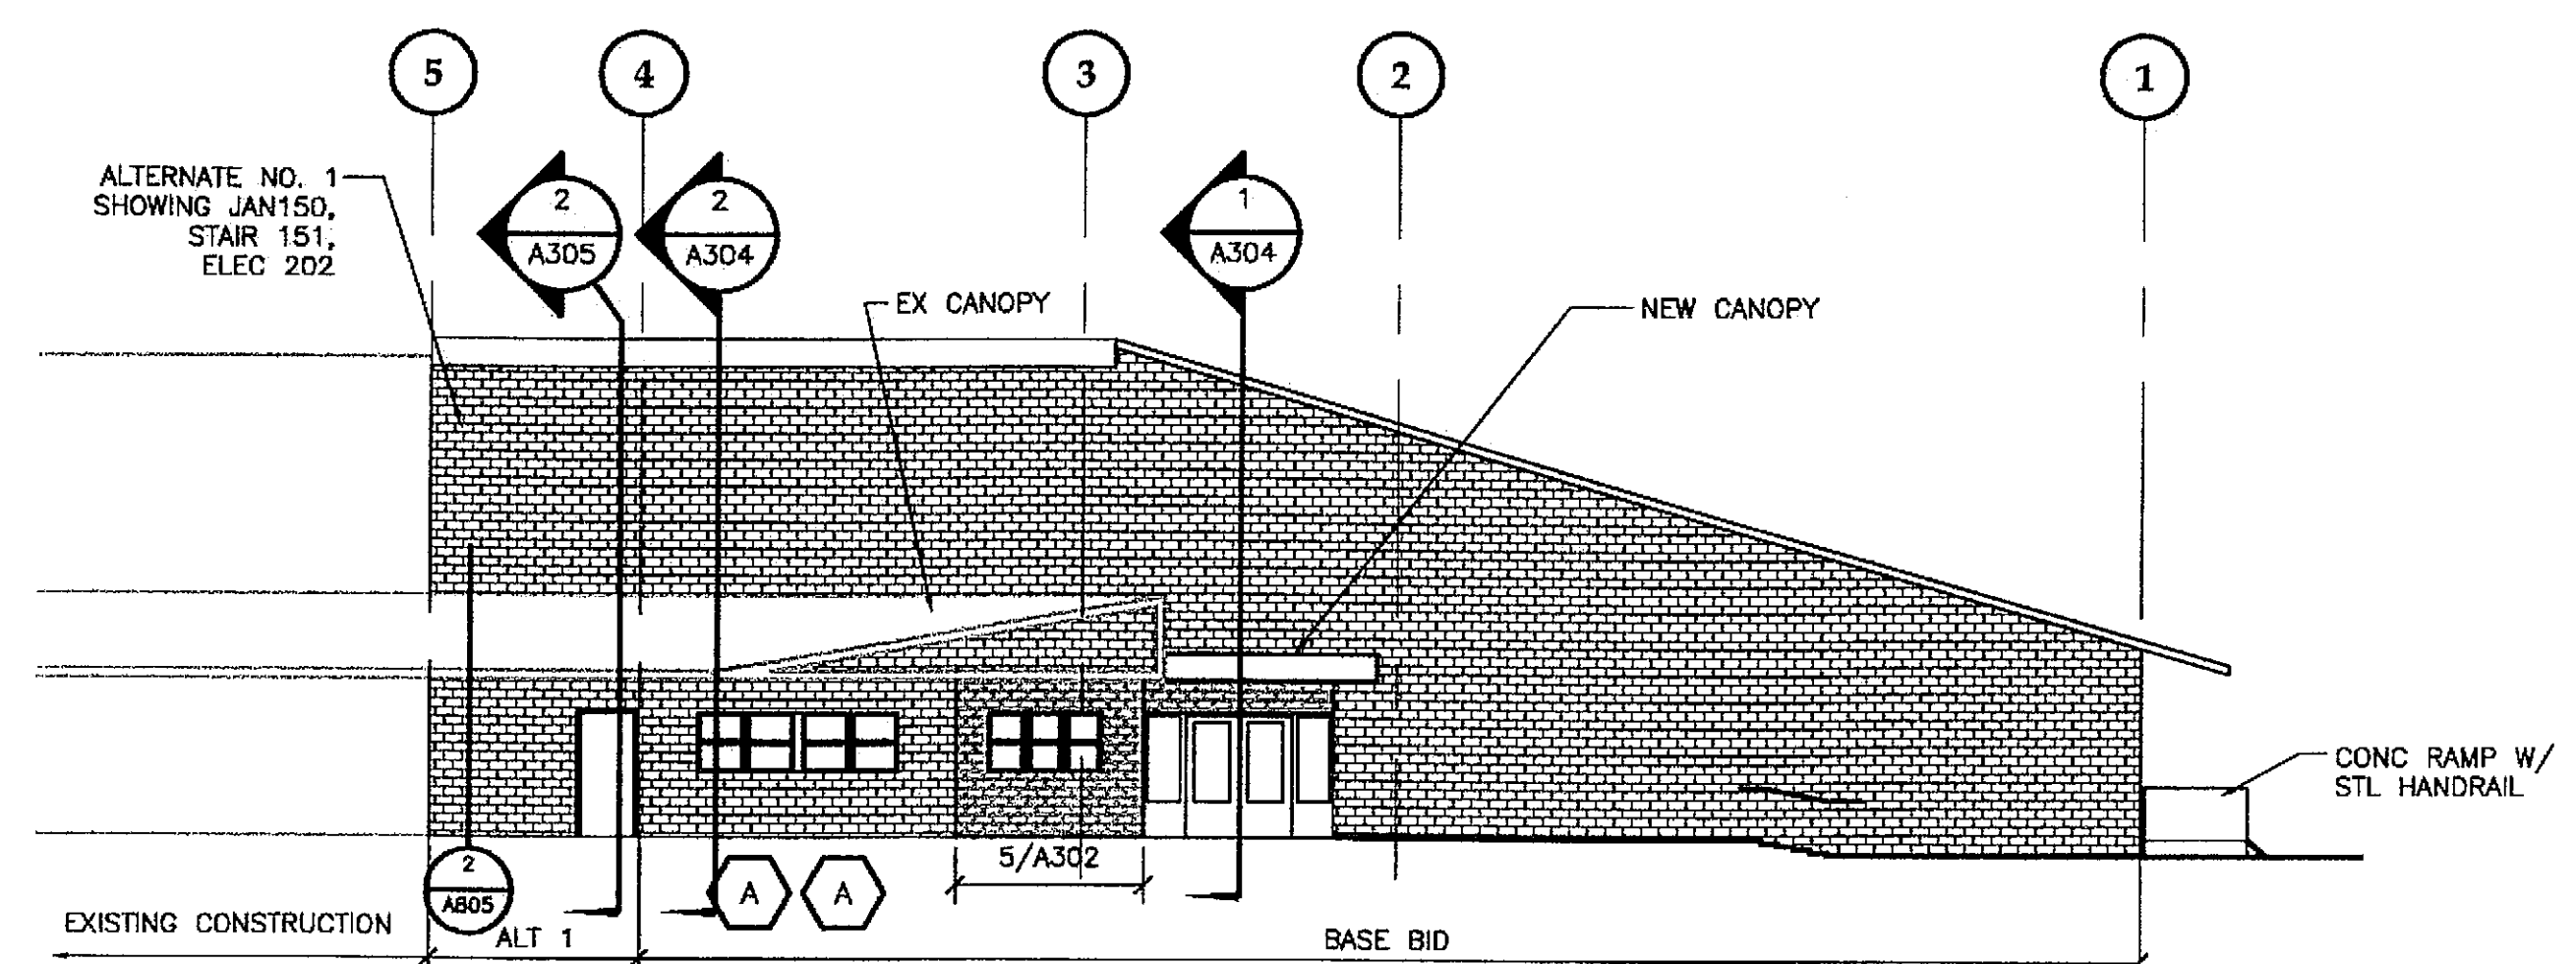


2 EXTERIOR ELEVATION - BASE BID & ALTERNATE NO. 1

SCALE: 0 5' 10' 20'

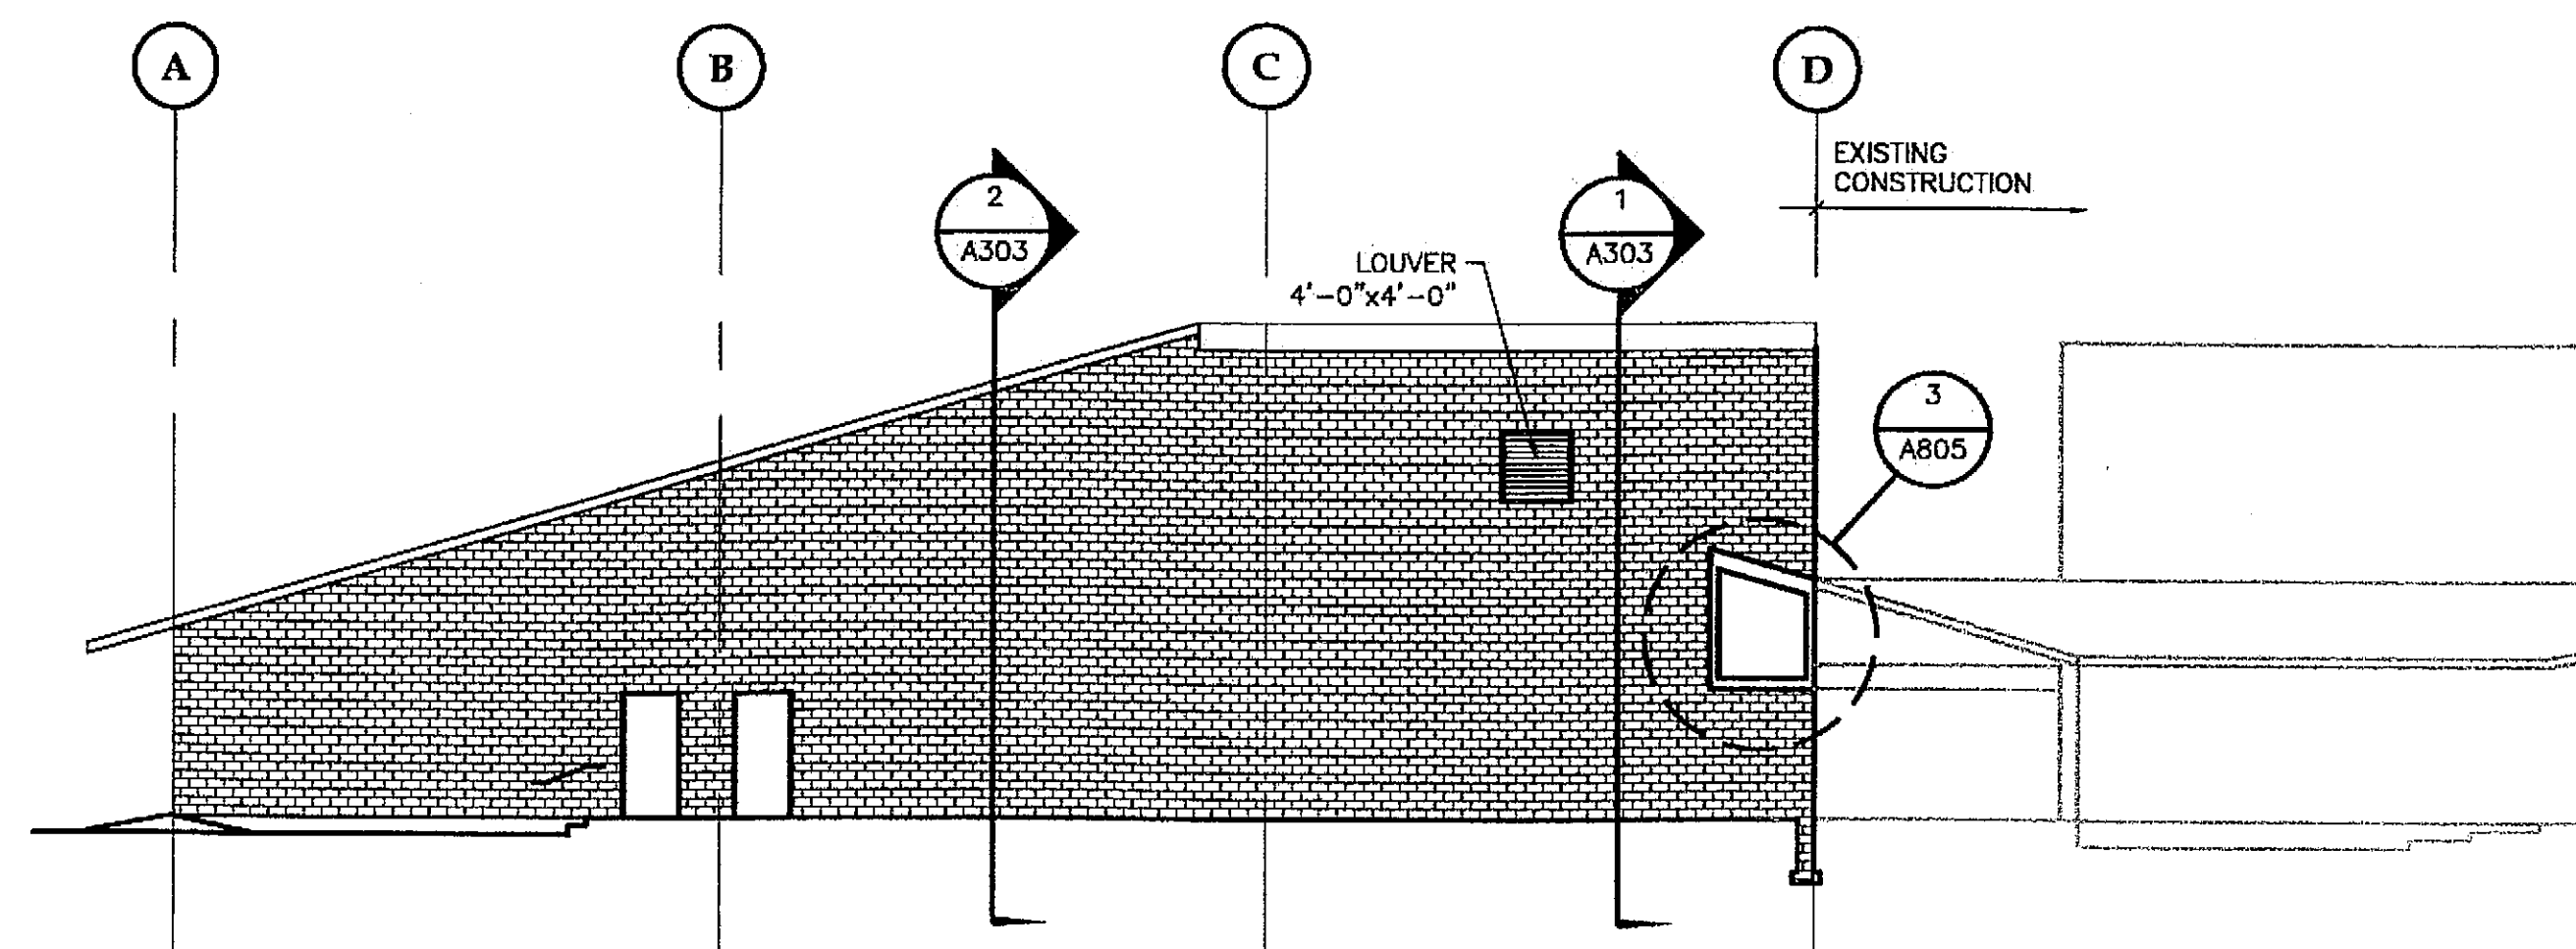


3 EXTERIOR ELEVATION - BASE BID

SCALE: 0 5' 10' 20'

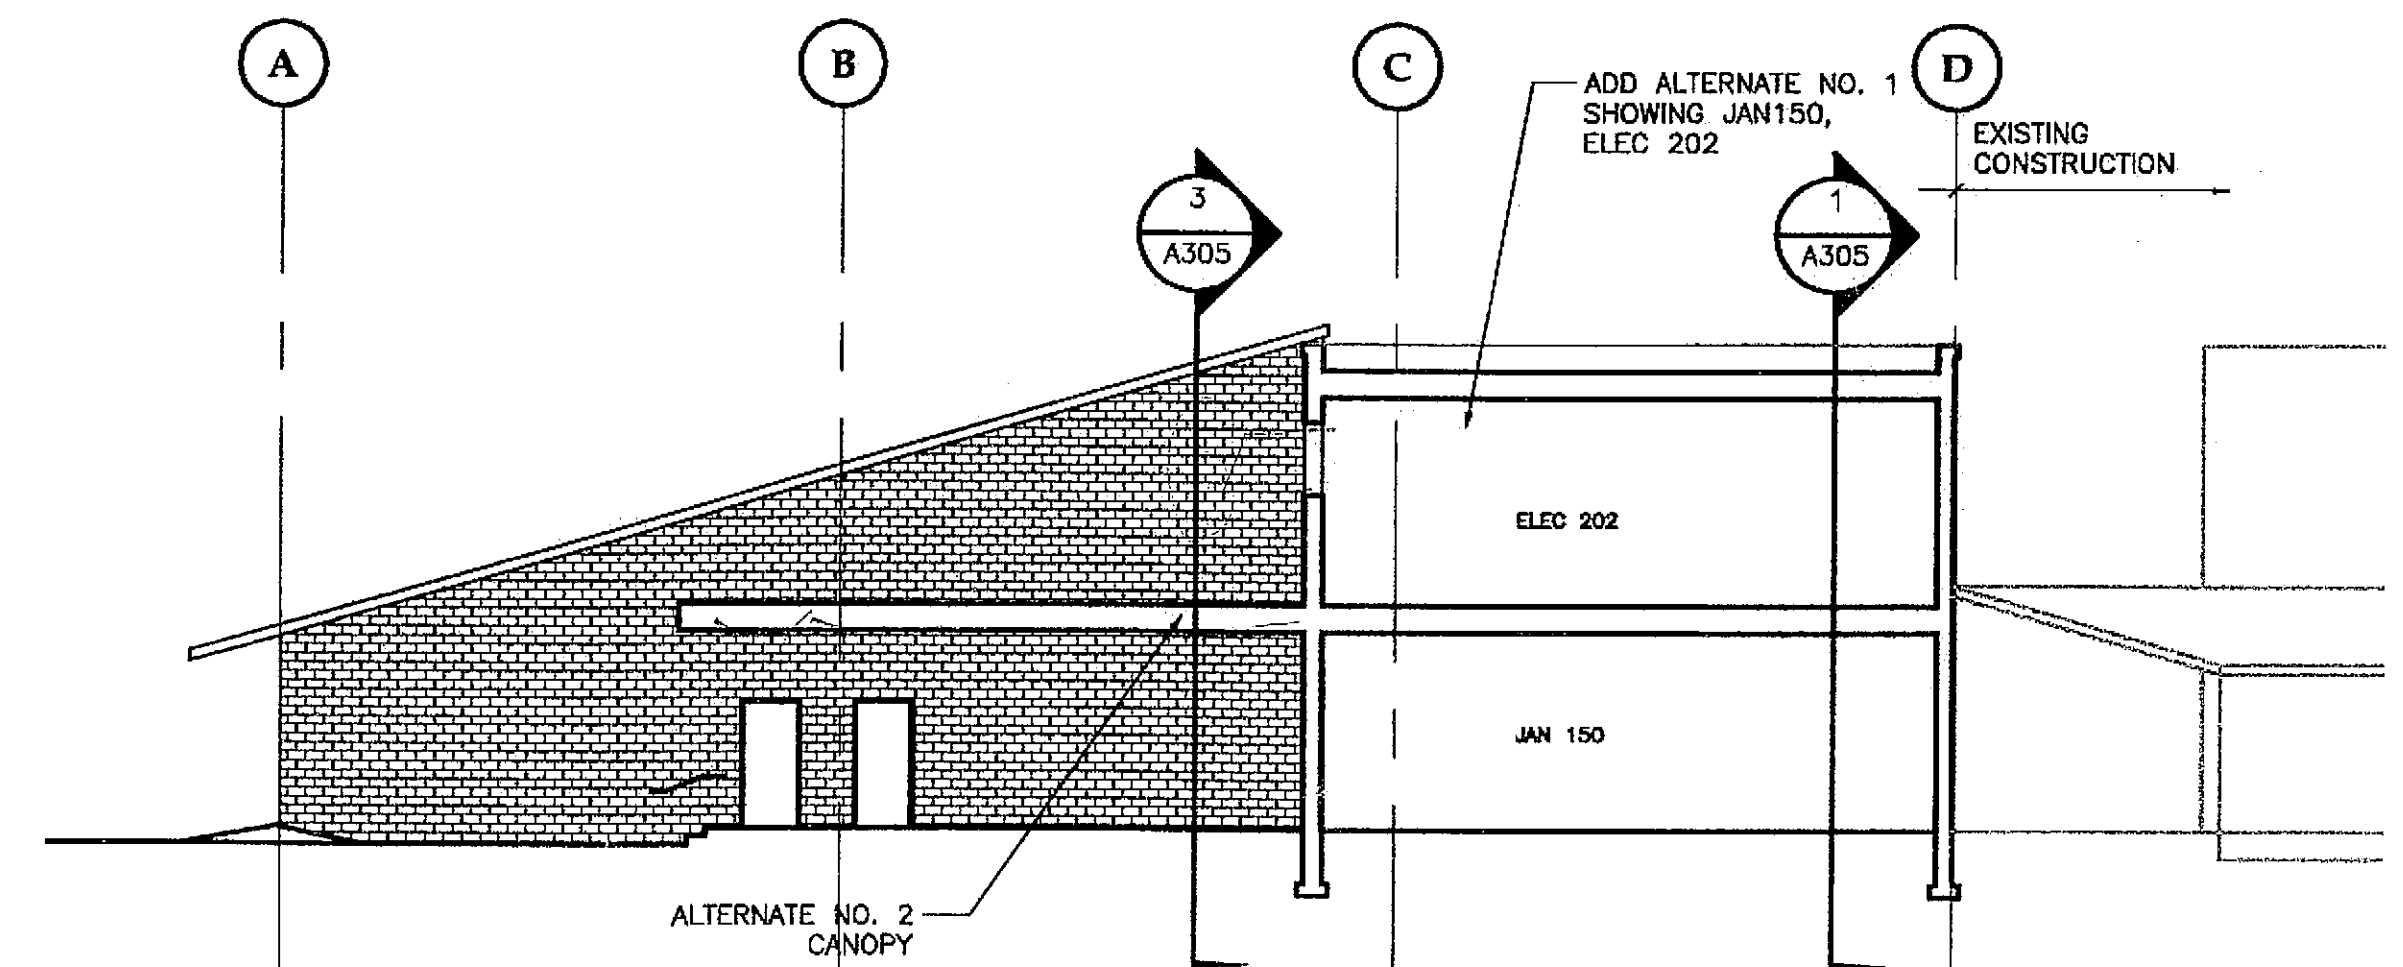


4 EXTERIOR ELEVATION - ALTERNATE NO. 1 AND NO. 2

SCALE: 0 5' 10' 20'

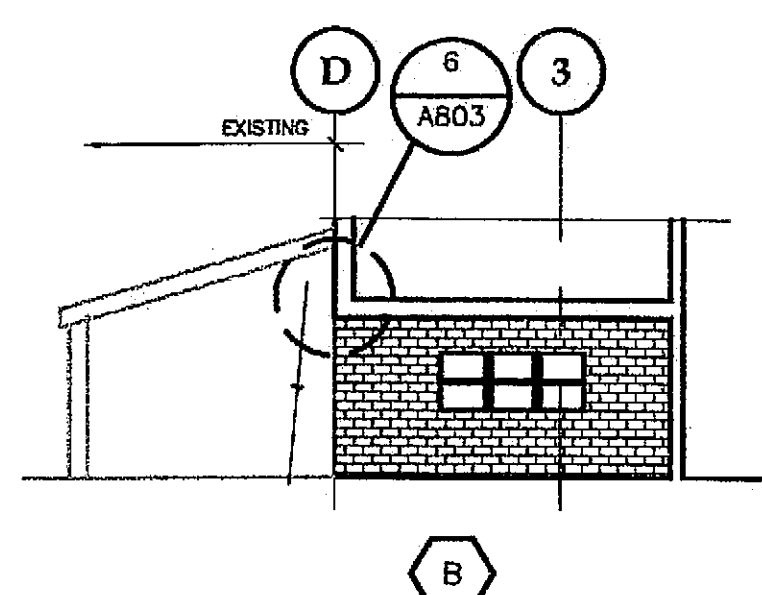

5 ENTRY ELEVATION

SCALE: 0 5' 10' 20'

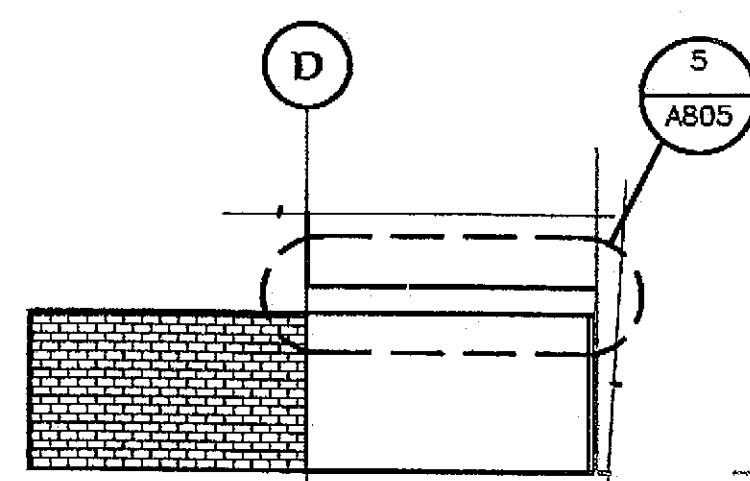


6 ENTRY ELEVATION

SCALE: 0 5' 10' 20'

Project As-Built Drawings have been
 reviewed by the Project Engineer and
 represent to the best of my knowledge, the
 project as constructed.
 Proj. Eng. *[Signature]* Date 7-07

CHECKED BY:

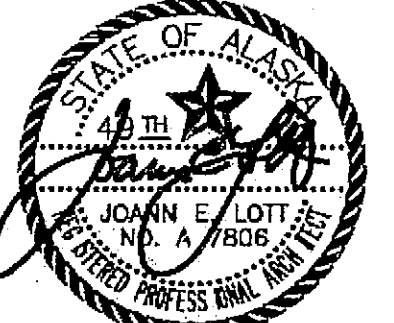

DESIGNED BY: JENSEN YORBA LOTT

DRAWN BY:

STATE OF ALASKA
 DEPARTMENT OF TRANSPORTATION
 & PUBLIC FACILITIES
 STATEWIDE DESIGN & ENGINEERING
 SERVICES DIVISION
 MT EDGECUMBE
 HIGH SCHOOL
 BUILDING 1330
 ACADEMIC
 EXPANSION

SHEET A302

PROJECT DESIGNATION NUMBER

67751C

STATE	YEAR
ALASKA	2004
SHEET NUMBER	TOTAL SHEETS
11	79

PATH:
G:\Projects\0411\Cad\CD\1330\Arch\A303.dwg

Tue, 14/Dec/04 02:29PM


TAB: Layout1

ADDENDUM NUMBER

ATTACHMENT NUMBER


RECORD OF REVISIONS

No.	DATE	DESCRIPTION

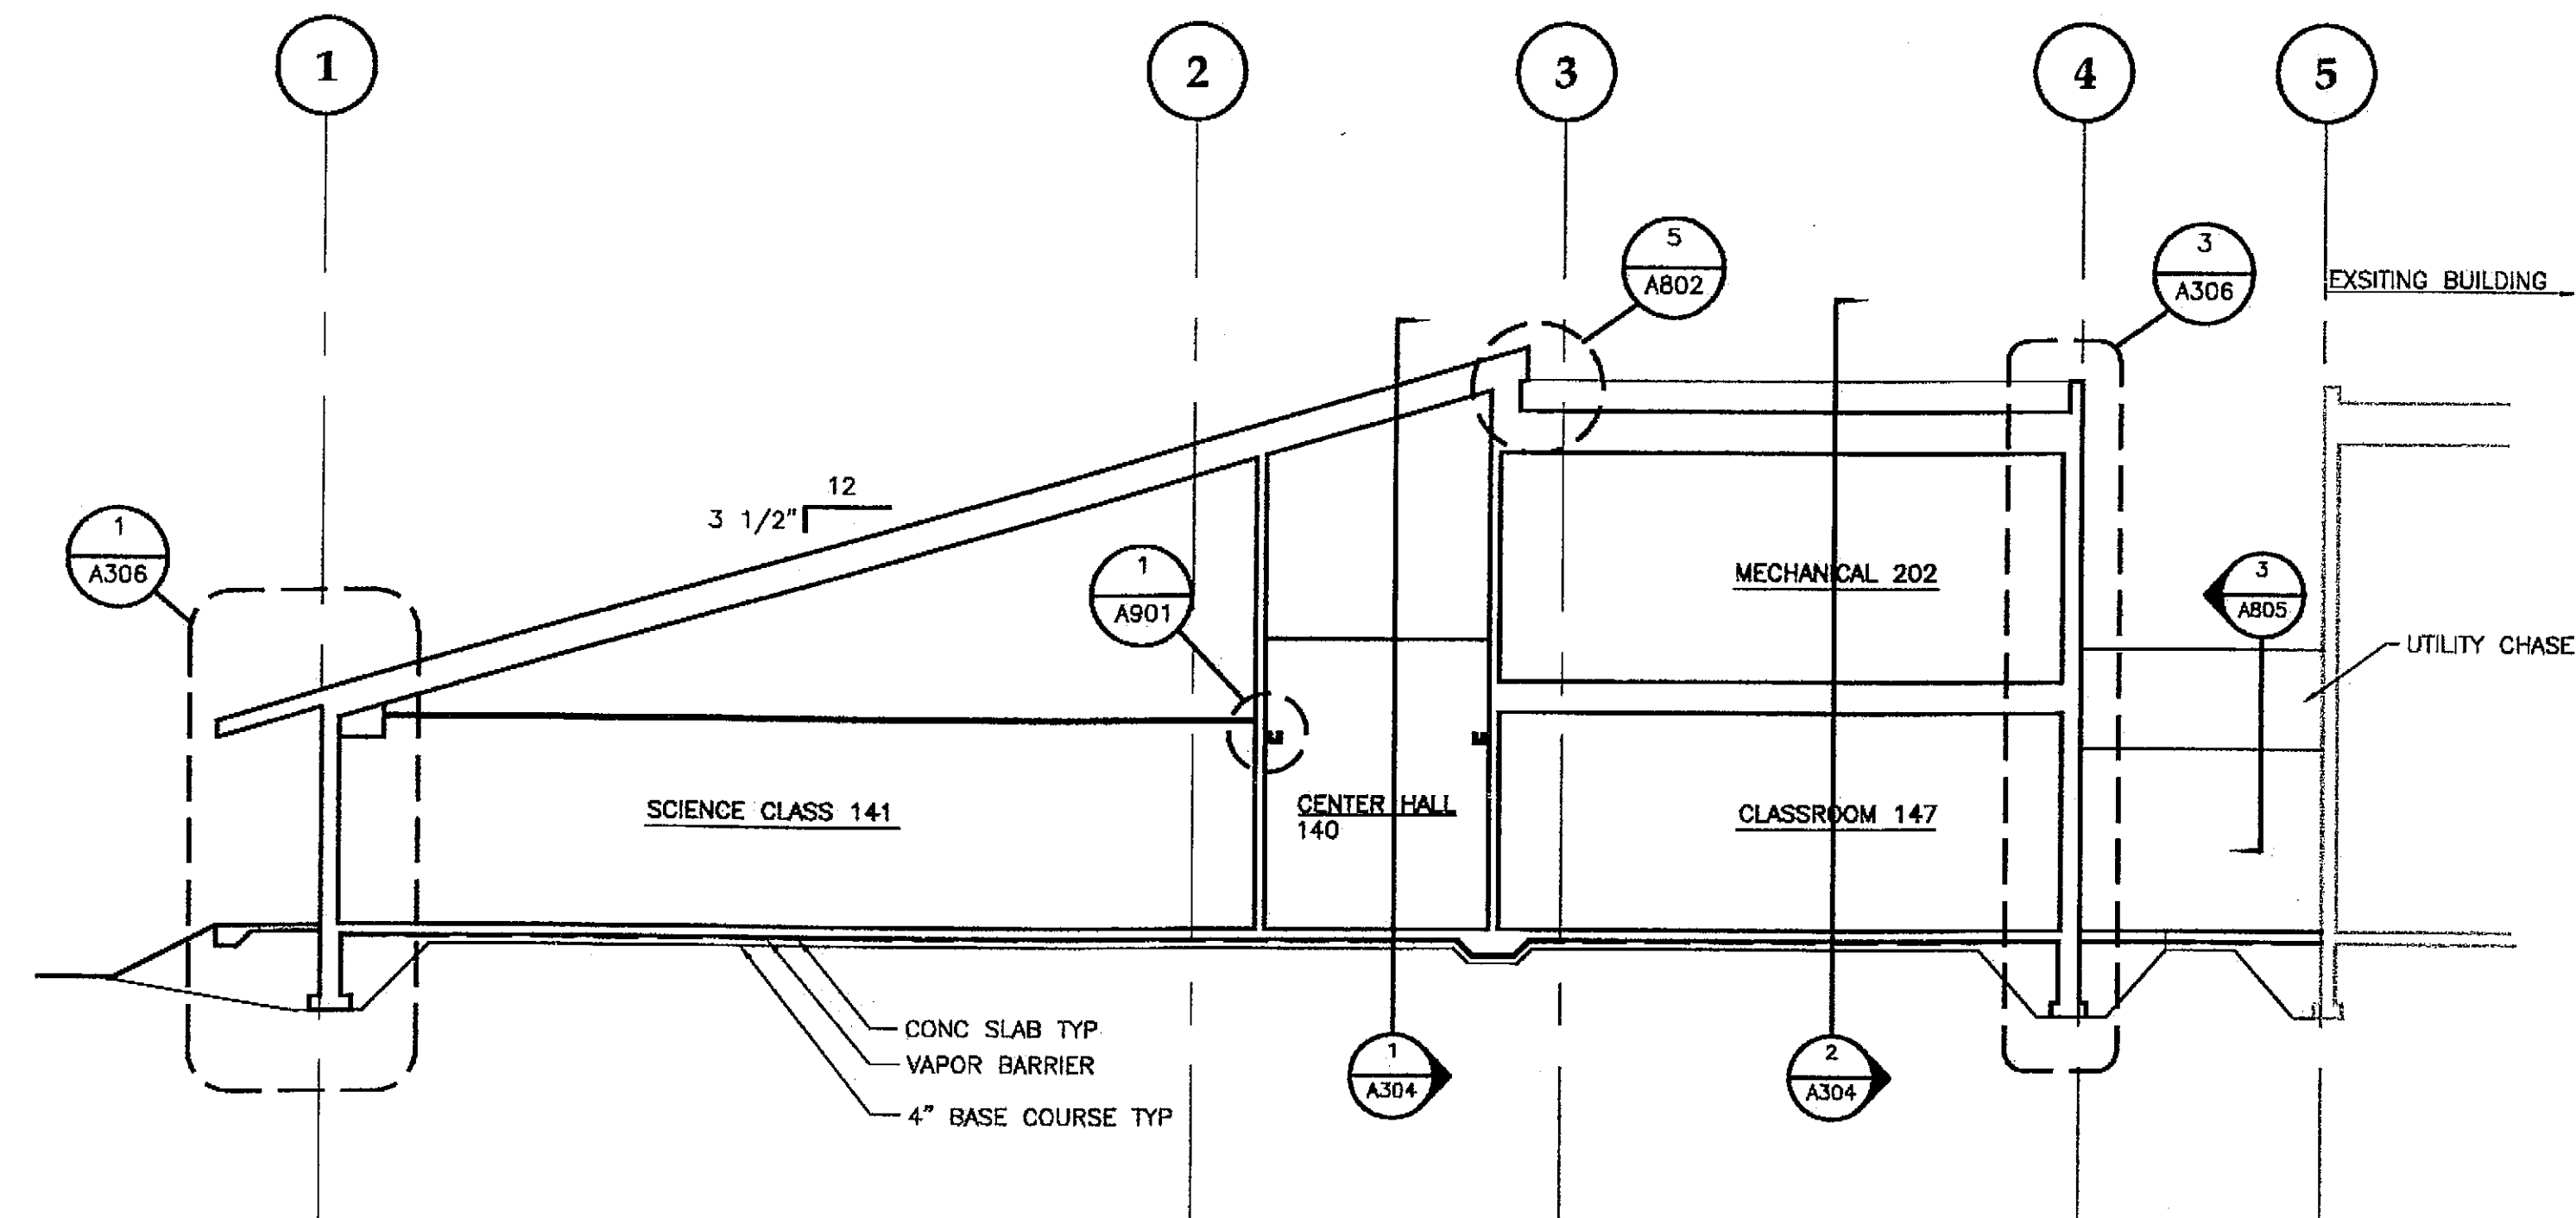

1 BUILDING SECTION BASE BID


SCALE: 0 4' 8' 16'

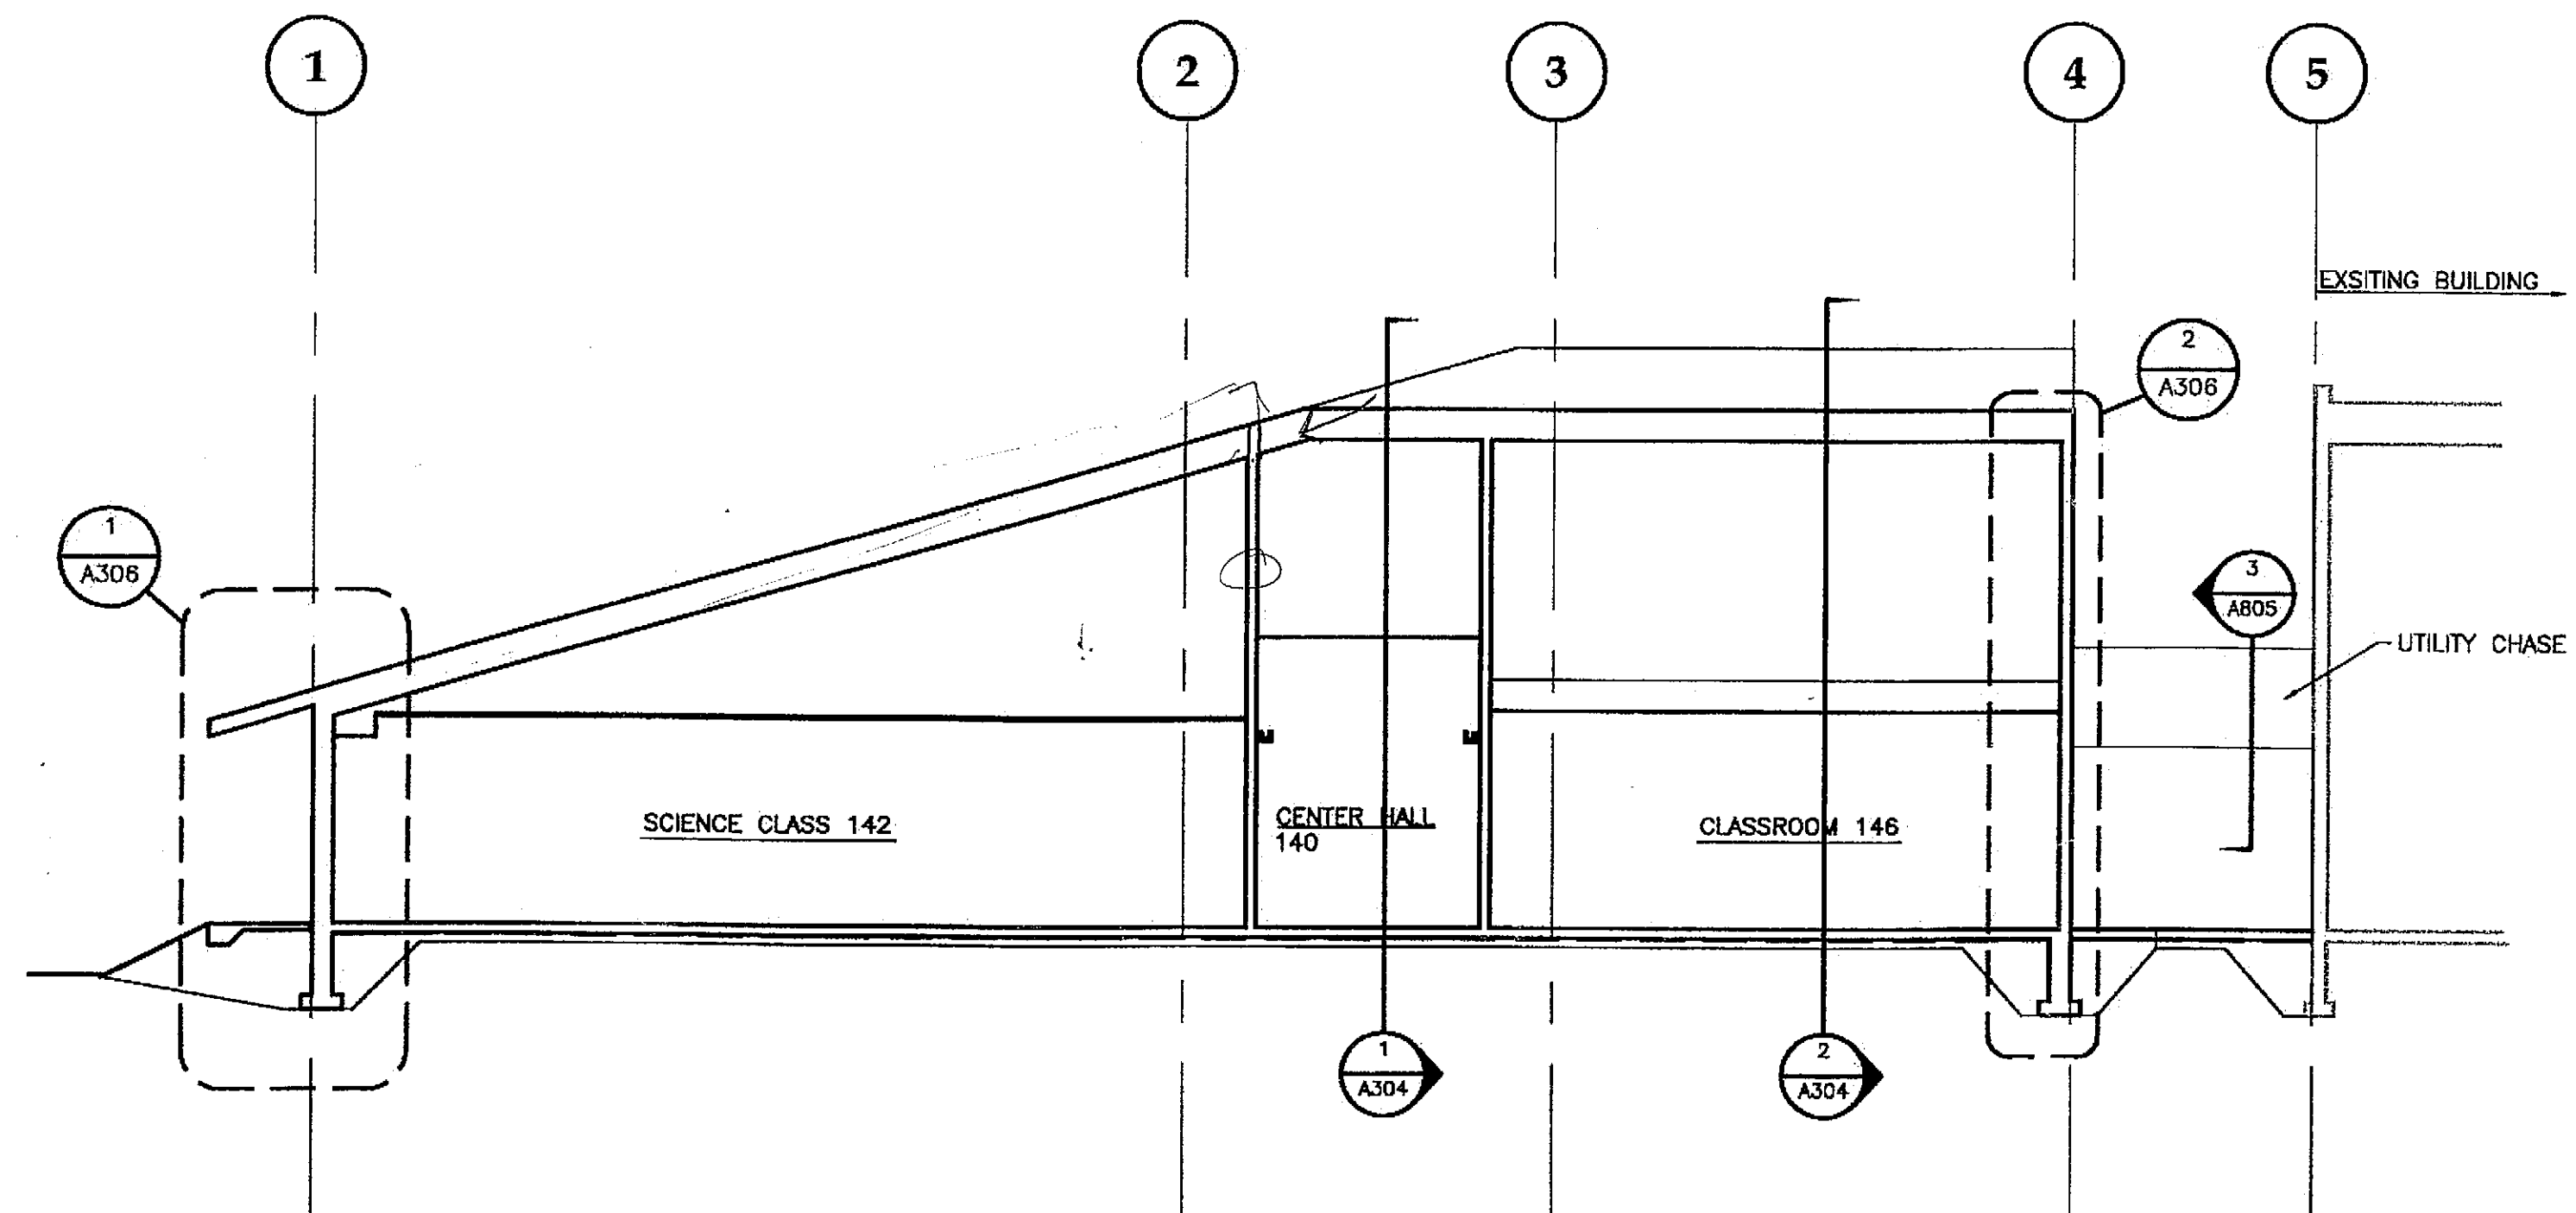

2 BUILDING SECTION BASE BID

SCALE: 0 4' 8' 16'

CHECKED BY:

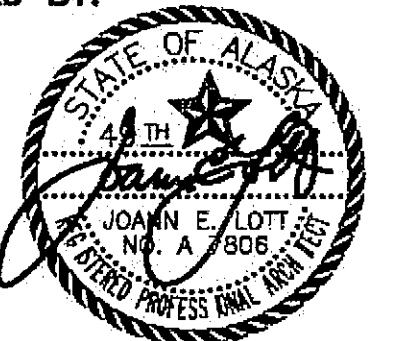

DESIGNED BY: JENSEN YORBA LOTT

DRAWN BY:

STATE OF ALASKA
DEPARTMENT OF TRANSPORTATION
& PUBLIC FACILITIES
STATEWIDE DESIGN & ENGINEERING
SERVICES DIVISION

MT EDGE CUMBE
HIGH SCHOOL
BUILDING 1330
ACADEMIC
EXPANSION


SHEET A303

PROJECT DESIGNATION NUMBER

67751C


STATE	YEAR
ALASKA	2004
SHEET NUMBER	TOTAL SHEETS
12	79

Project As-Built Drawings have been
reviewed by the Project Engineer and
present to the best of my knowledge, the
project as constructed.
Proj. Eng. *[Signature]* Date 7-07

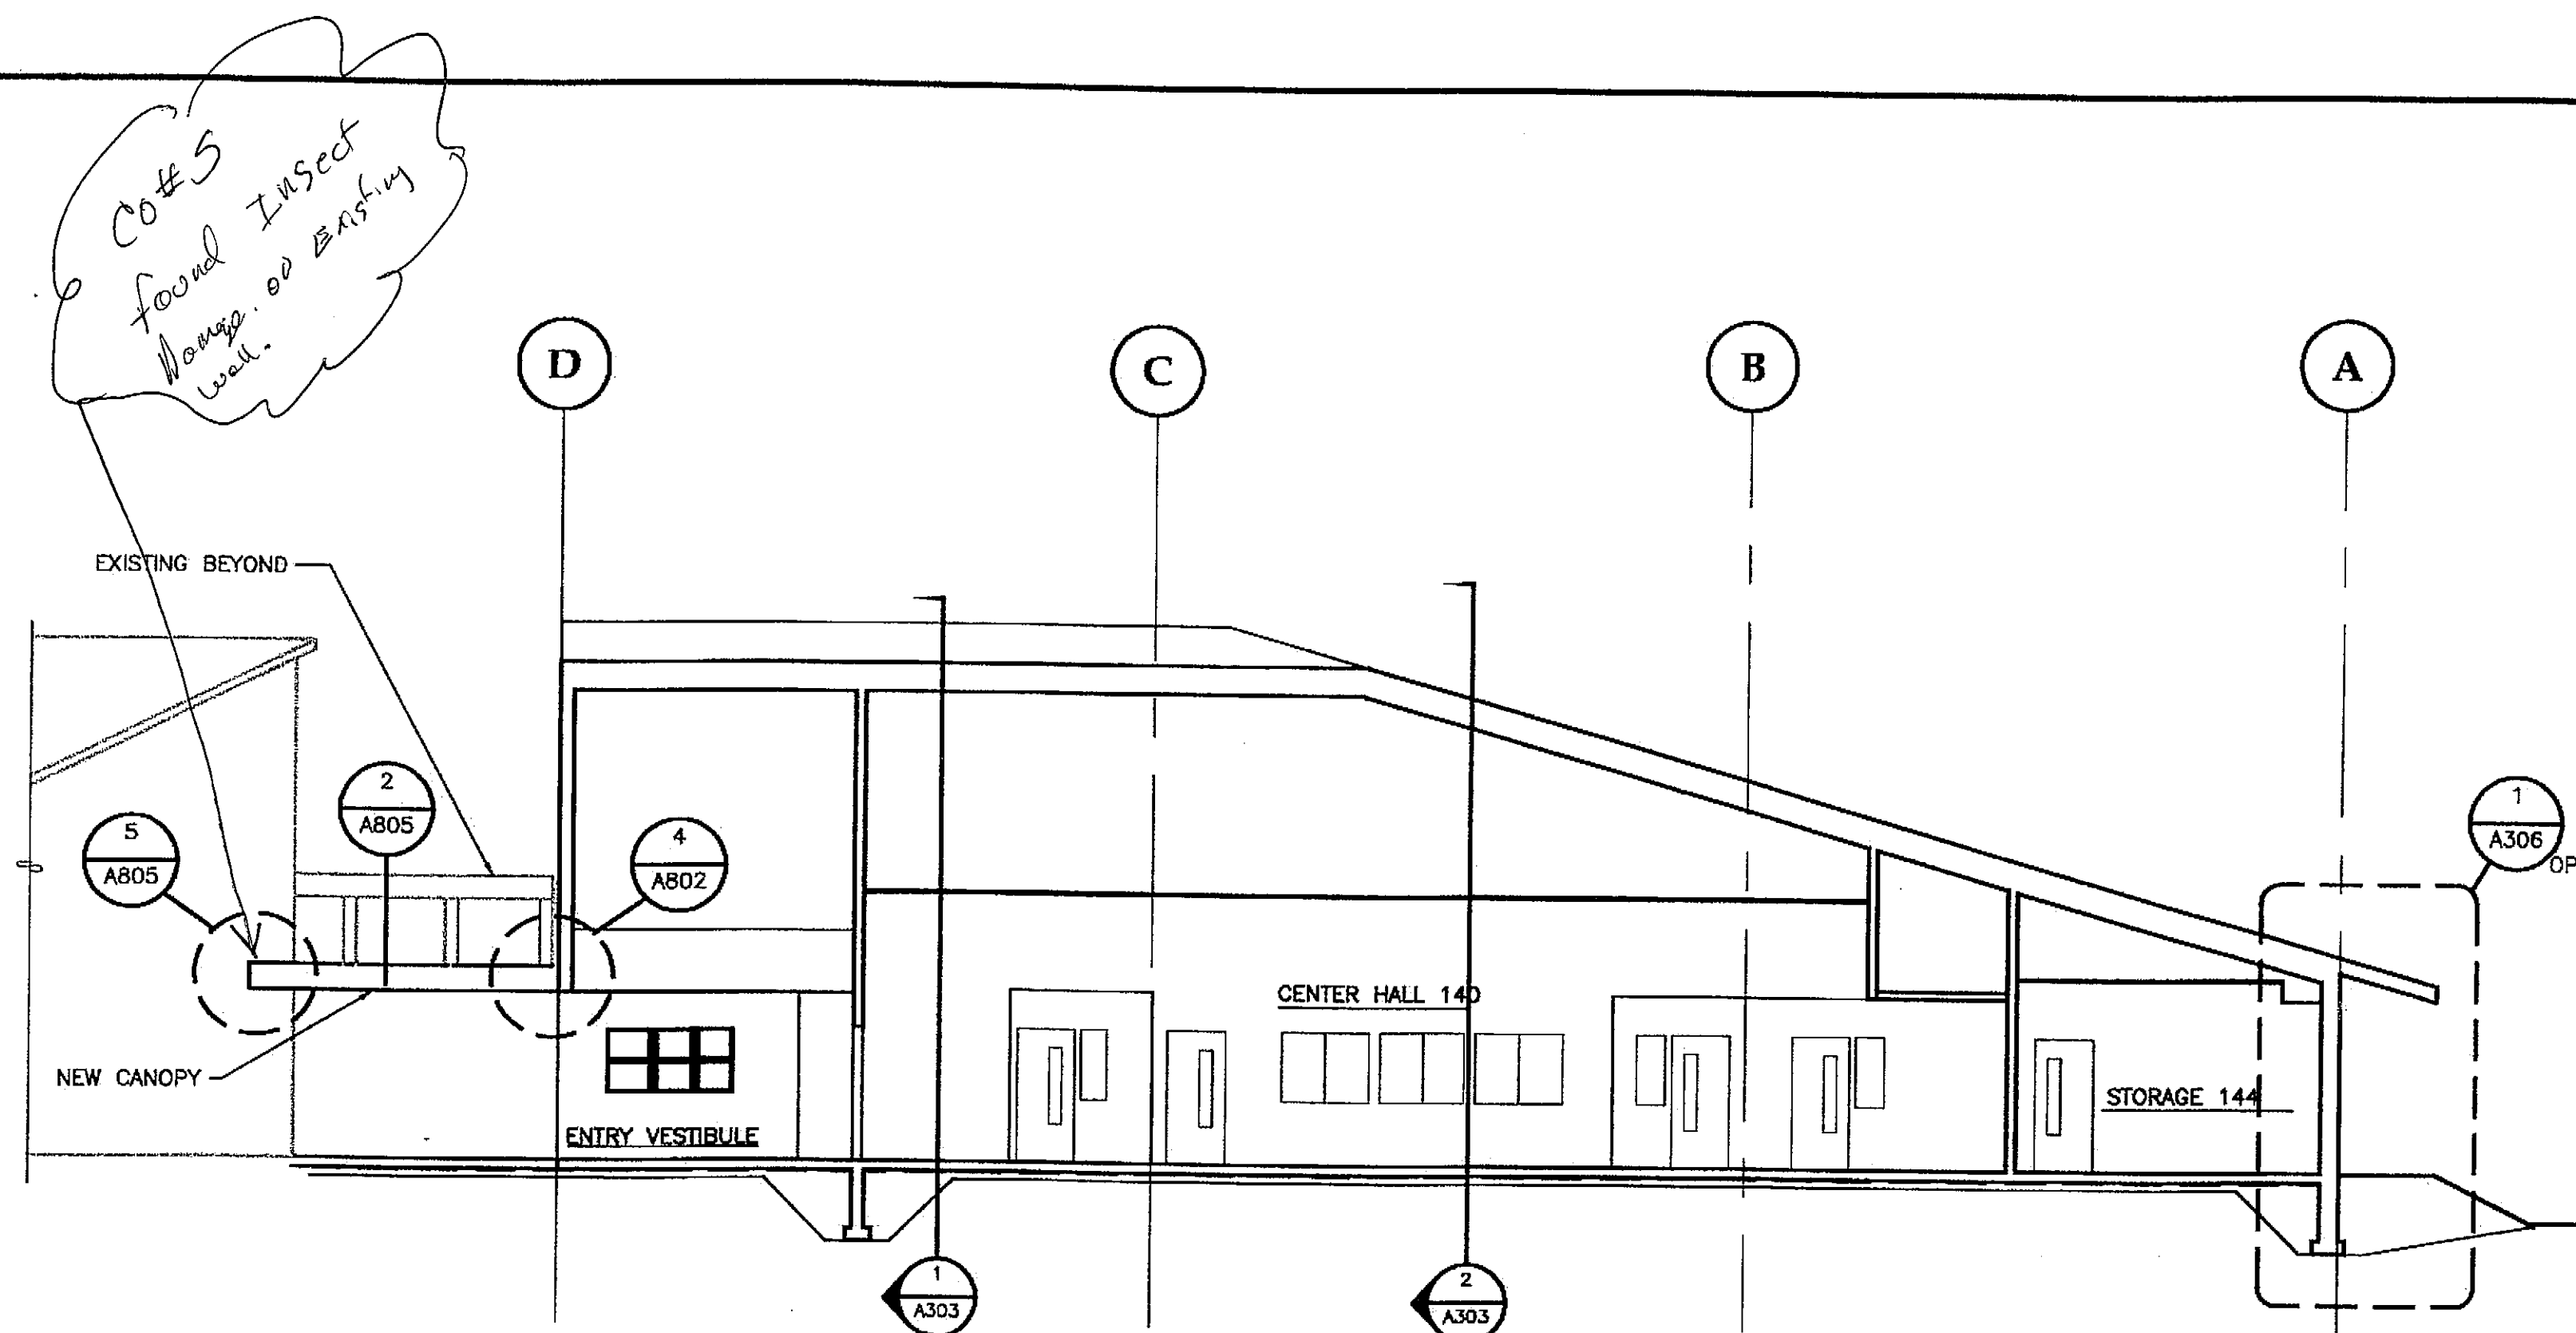

1 BUILDING SECTION BASE BID

SCALE: 0 4' 8' 16'

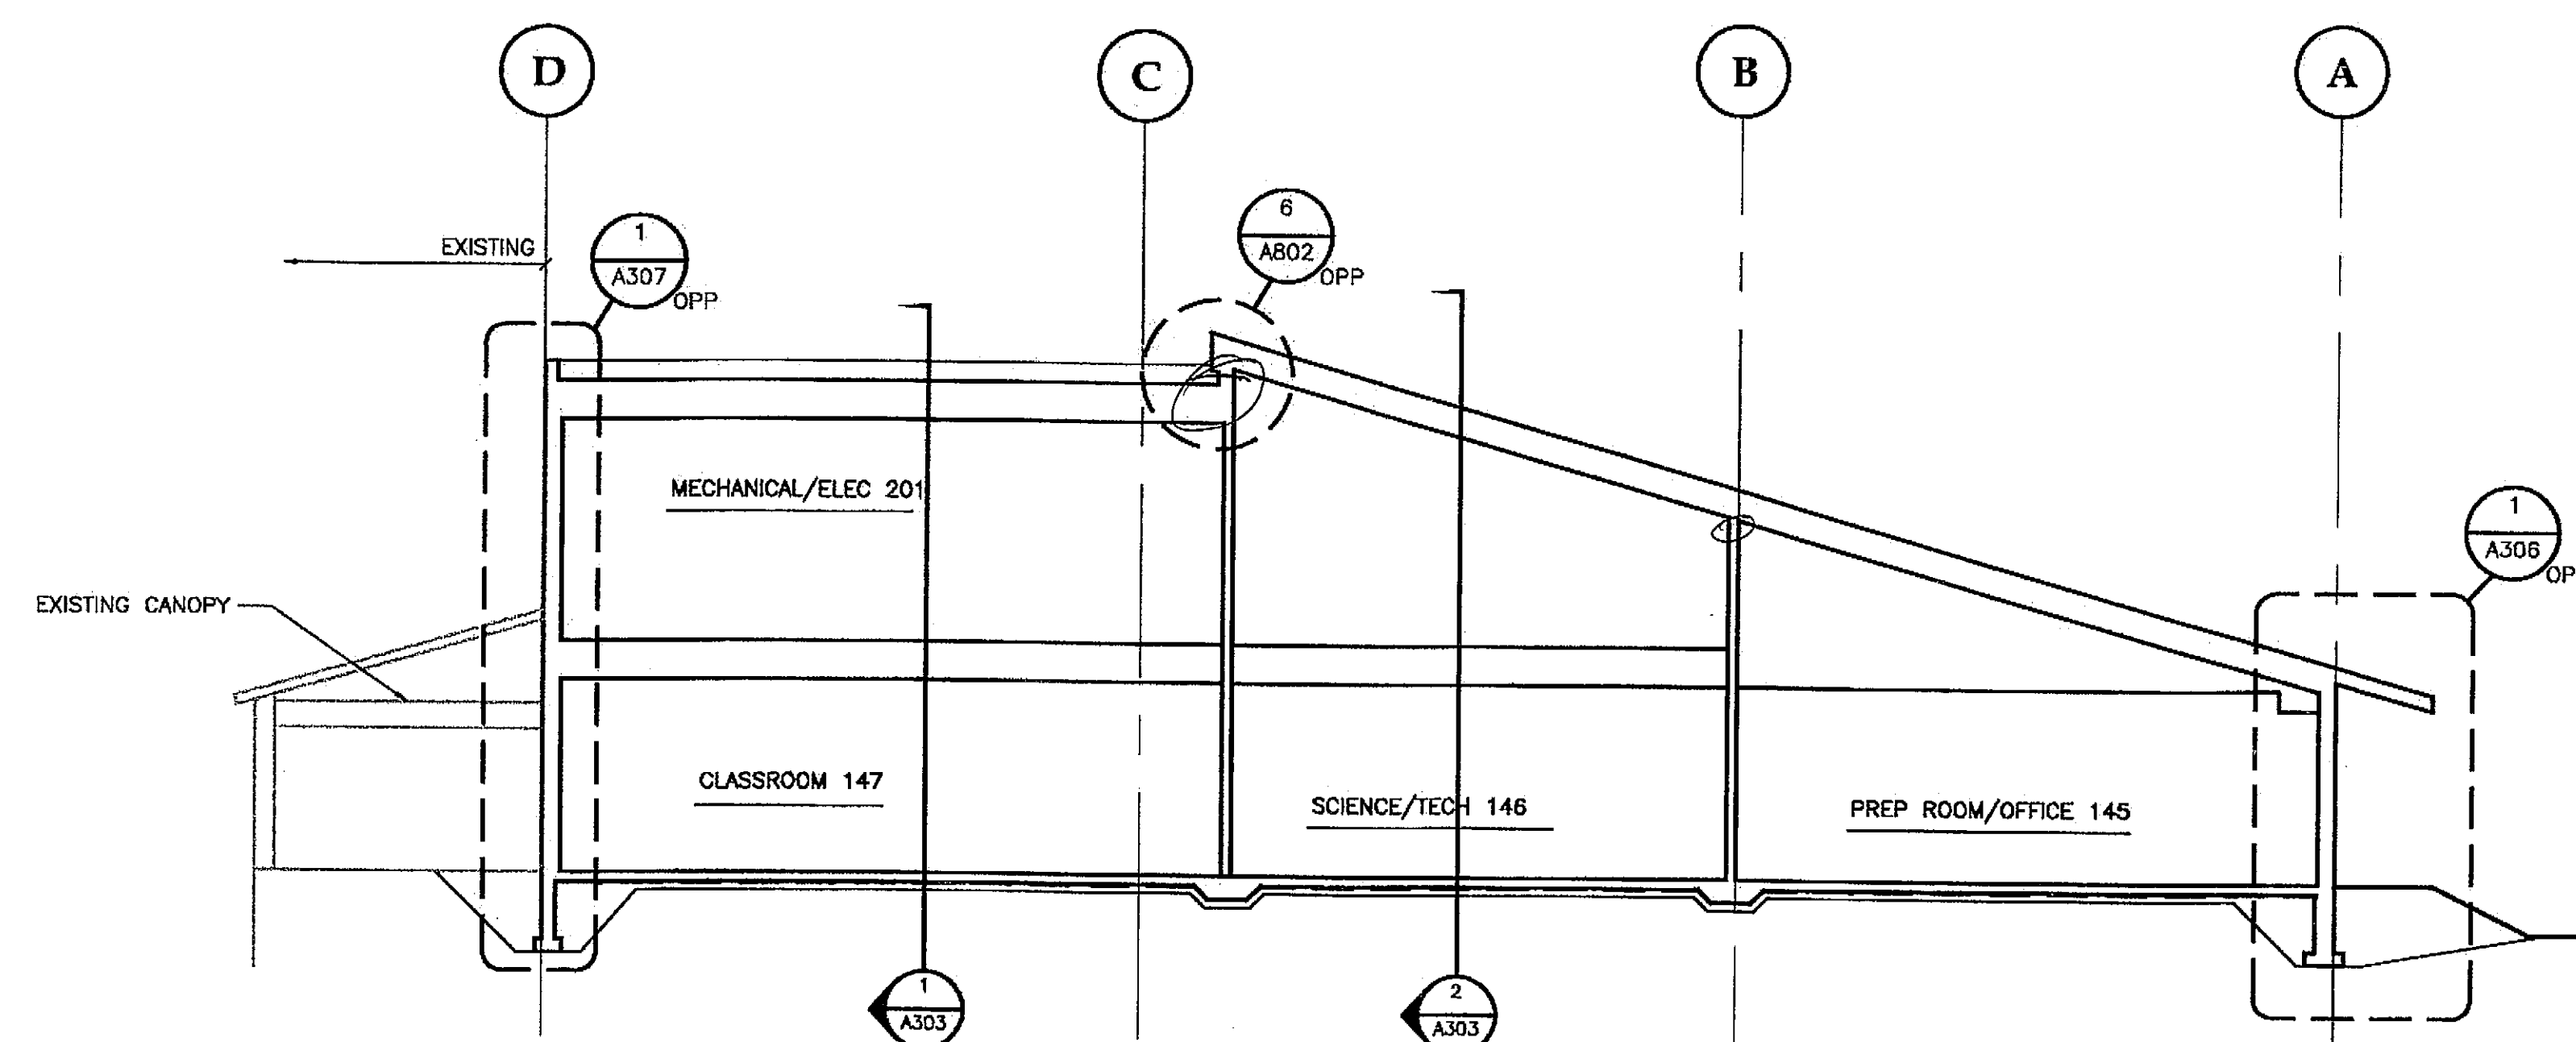

2 BUILDING SECTION BASE BID

SCALE: 0 4' 8' 16'

Project As-Built Drawings have been reviewed by the Project Engineer and represent to the best of my knowledge, the project as constructed.
Proj. Eng. *[Signature]* Date 7-07

PATH: G:\Projects\0411\CD\CD\1330\Arch\A304.dwg
Tue, 14/Dec/04 02:28PM
TAB: Layout1


ADDENDUM NUMBER

ATTACHMENT NUMBER

RECORD OF REVISIONS

No.	DATE	DESCRIPTION

CHECKED BY:

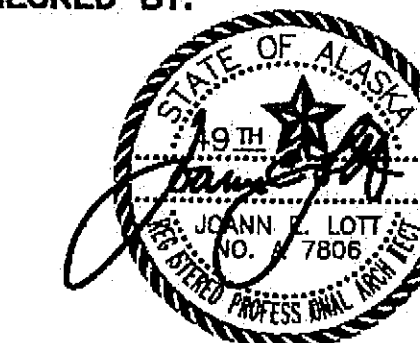

DESIGNED BY: JENSEN YORBA LOTT

DRAWN BY:

STATE OF ALASKA
DEPARTMENT OF TRANSPORTATION
& PUBLIC FACILITIES
STATEWIDE DESIGN & ENGINEERING
SERVICES DIVISION
MT EDGECUMBE
HIGH SCHOOL
BUILDING 1330
ACADEMIC
EXPANSION

SHEET A304

PROJECT DESIGNATION NUMBER

67751C

STATE	YEAR
ALASKA	2004

SHEET NUMBER	TOTAL SHEETS
13	79

PATH: G:_Projects\04111\Con\CD\1330\Arch\A305.dwg
Tue, 14/Dec/04 02:28PM
TAB: Layout1


ADDENDUM NUMBER

ATTACHMENT NUMBER

RECORD OF REVISIONS

No.	DATE	DESCRIPTION

CHECKED BY:

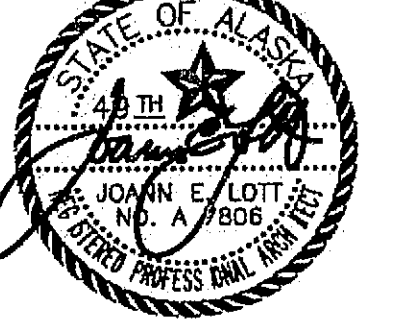

DESIGNED BY: JENSEN YORBA LOTT

DRAWN BY:

STATE OF ALASKA
DEPARTMENT OF TRANSPORTATION
& PUBLIC FACILITIES
STATEWIDE DESIGN & ENGINEERING
SERVICES DIVISION

MT EDGECUMBE
HIGH SCHOOL
BUILDING 1330
ACADEMIC
EXPANSION


SHEET A305

PROJECT DESIGNATION NUMBER


67751C

STATE	YEAR
ALASKA	2004


SHEET NUMBER	TOTAL SHEETS
14	79

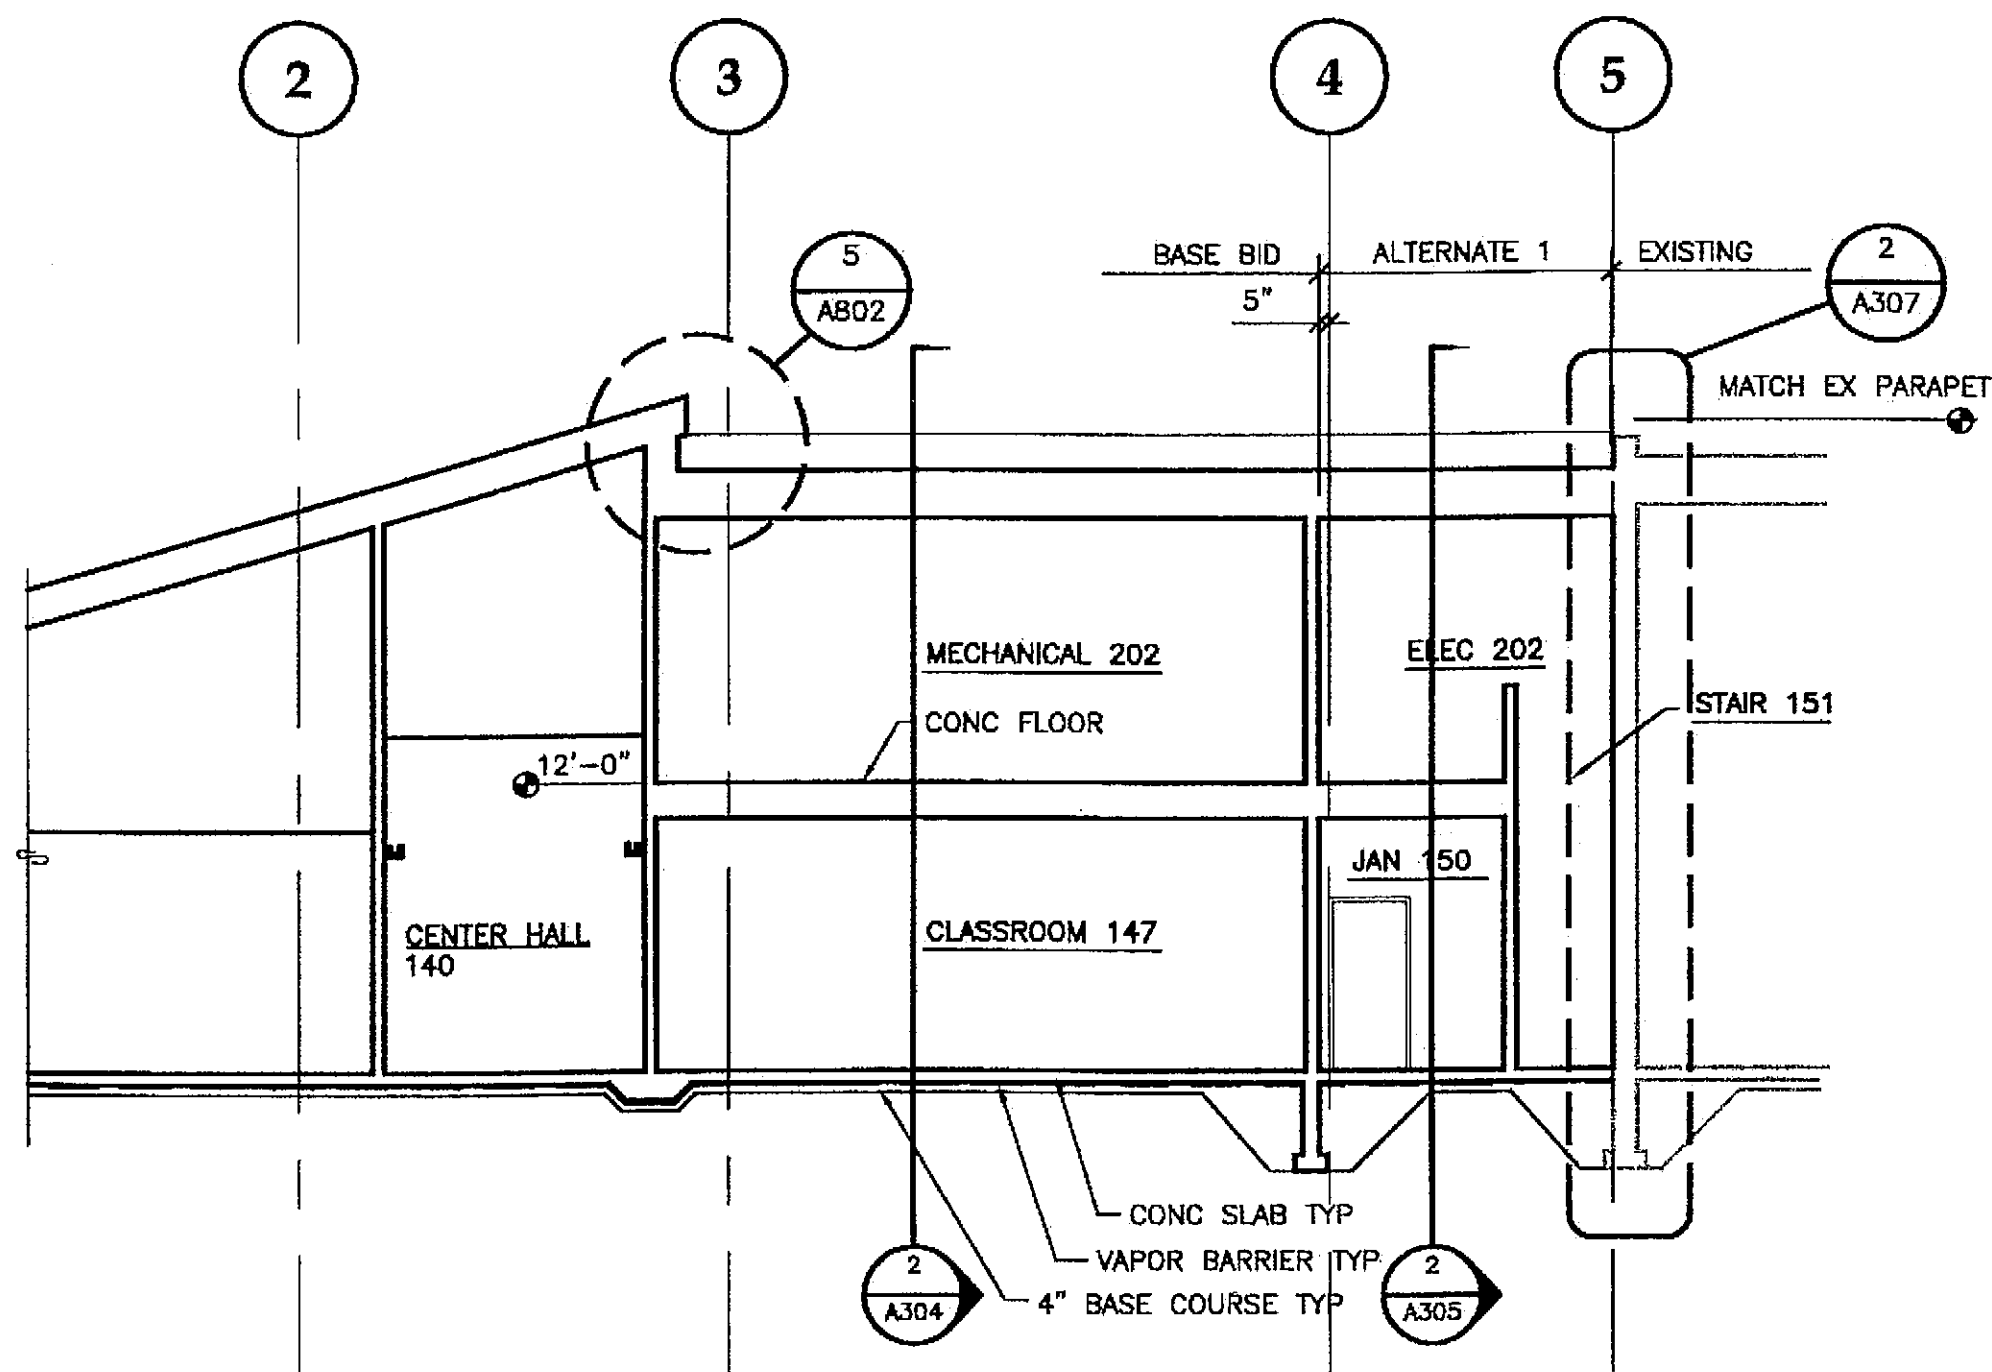

1 BUILDING SECTION ALTERNATE 1
SCALE: 0 4' 8' 16'



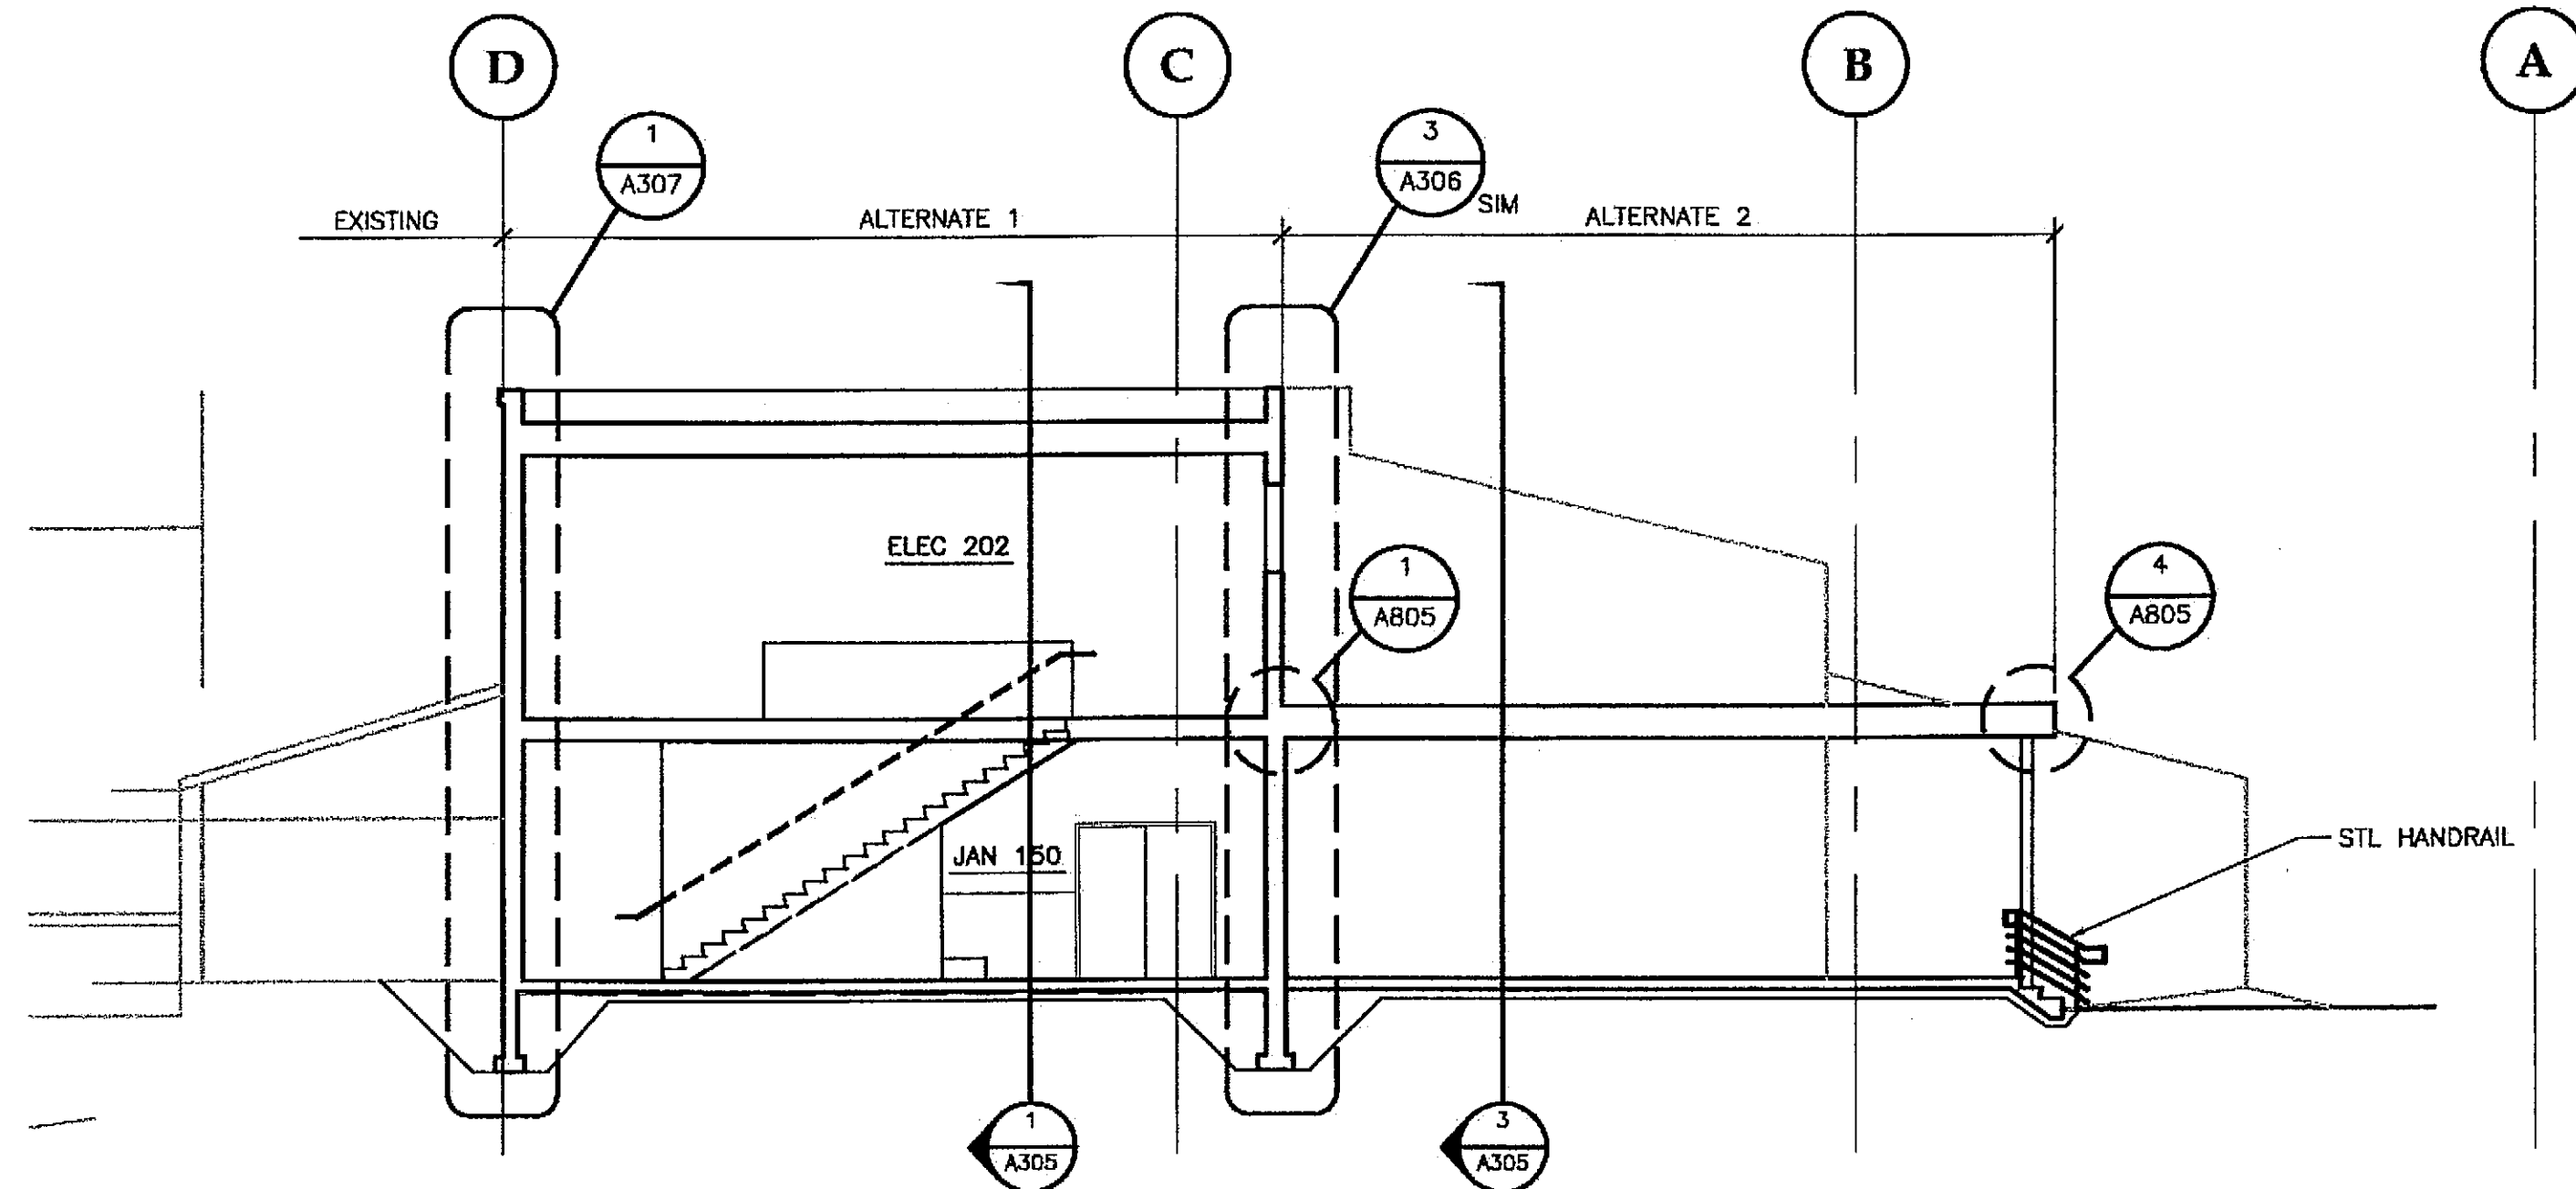



2 BUILDING SECTION ALTERNATE 1 & 2
SCALE: 0 4' 8' 16'

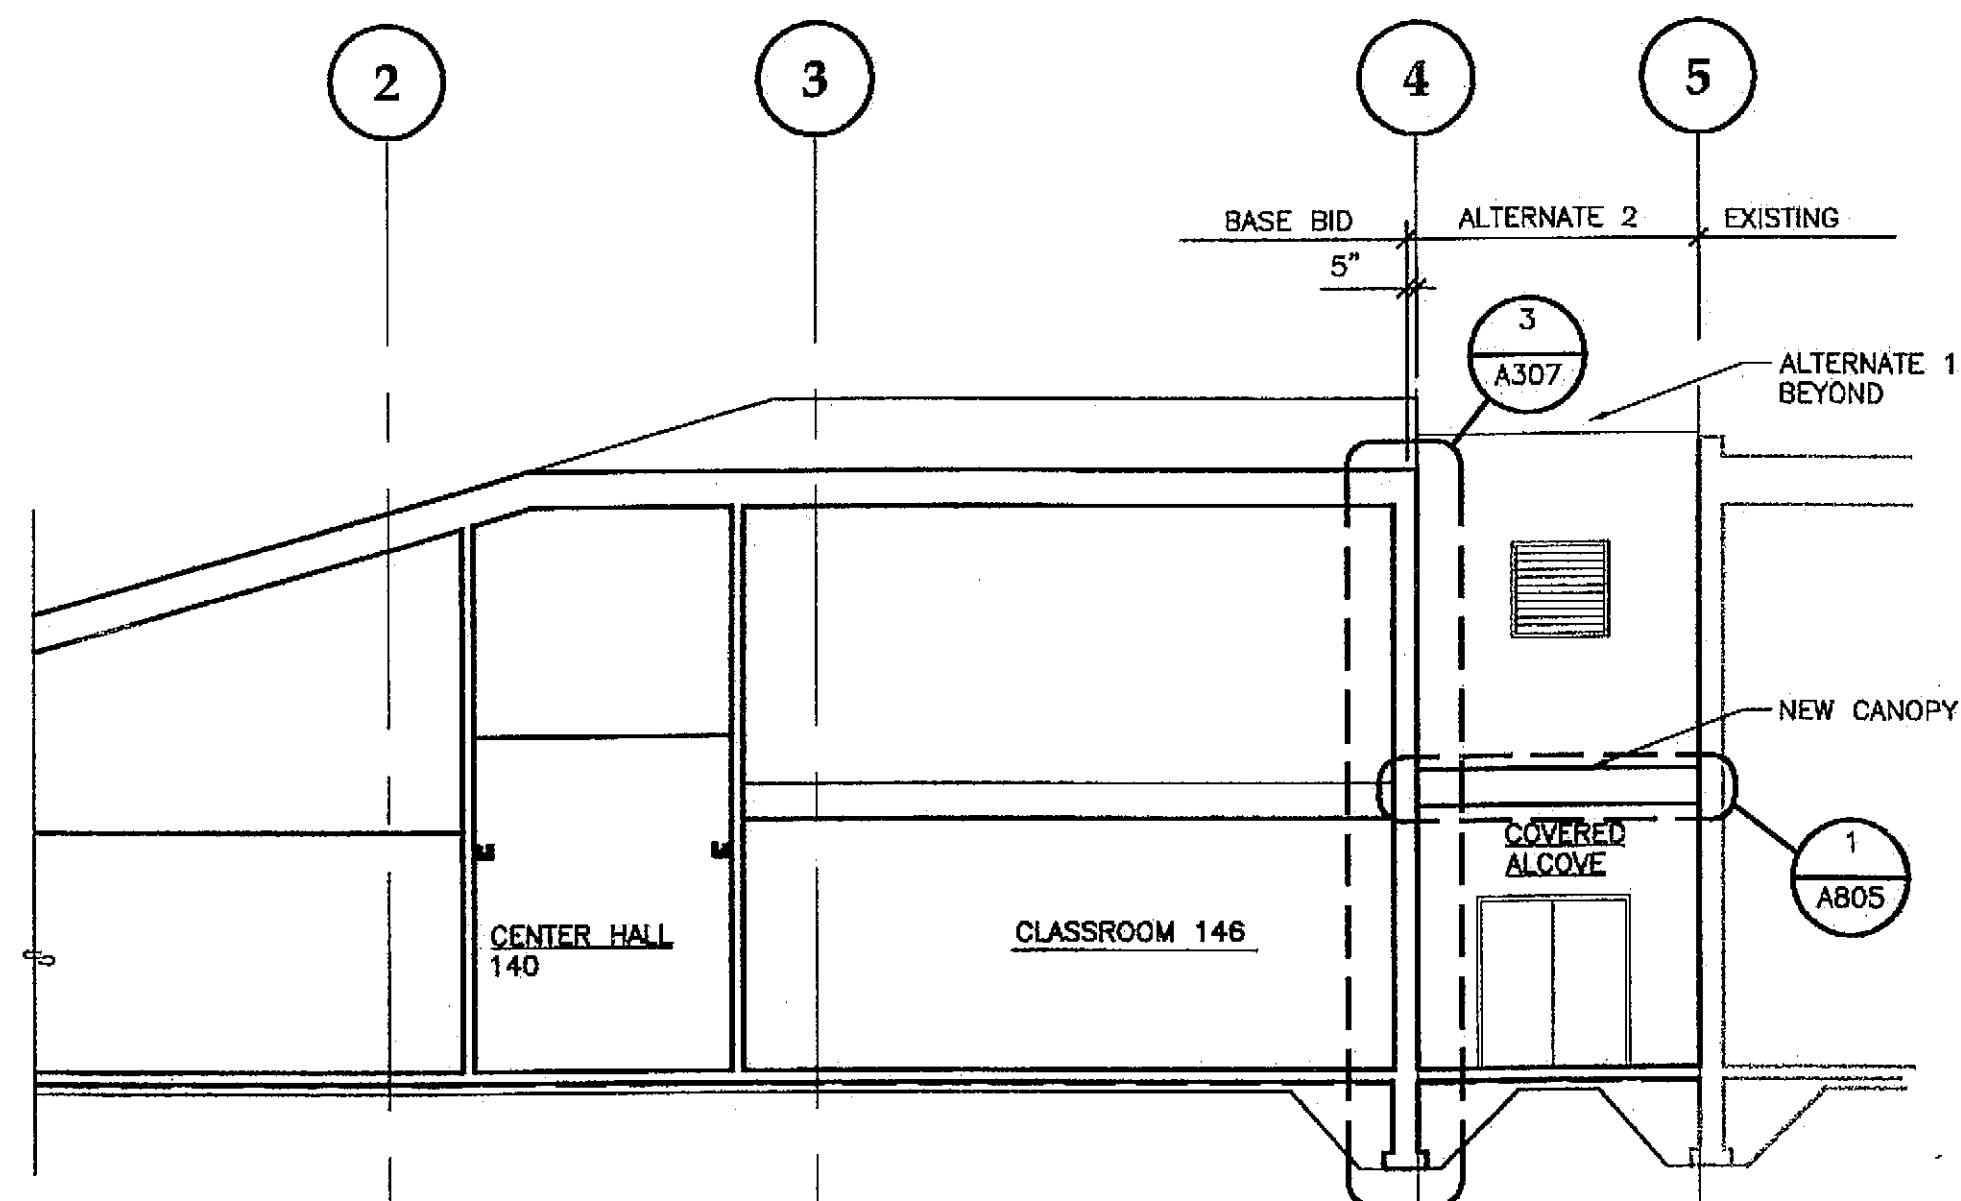

3 BUILDING SECTION ALTERNATE 2
SCALE: 0 4' 8' 16'

Project As-Built Drawings have been reviewed by the Project Engineer and represent to the best of my knowledge, the project as constructed.
Proj. Eng. *J. Lott* Date 7/07

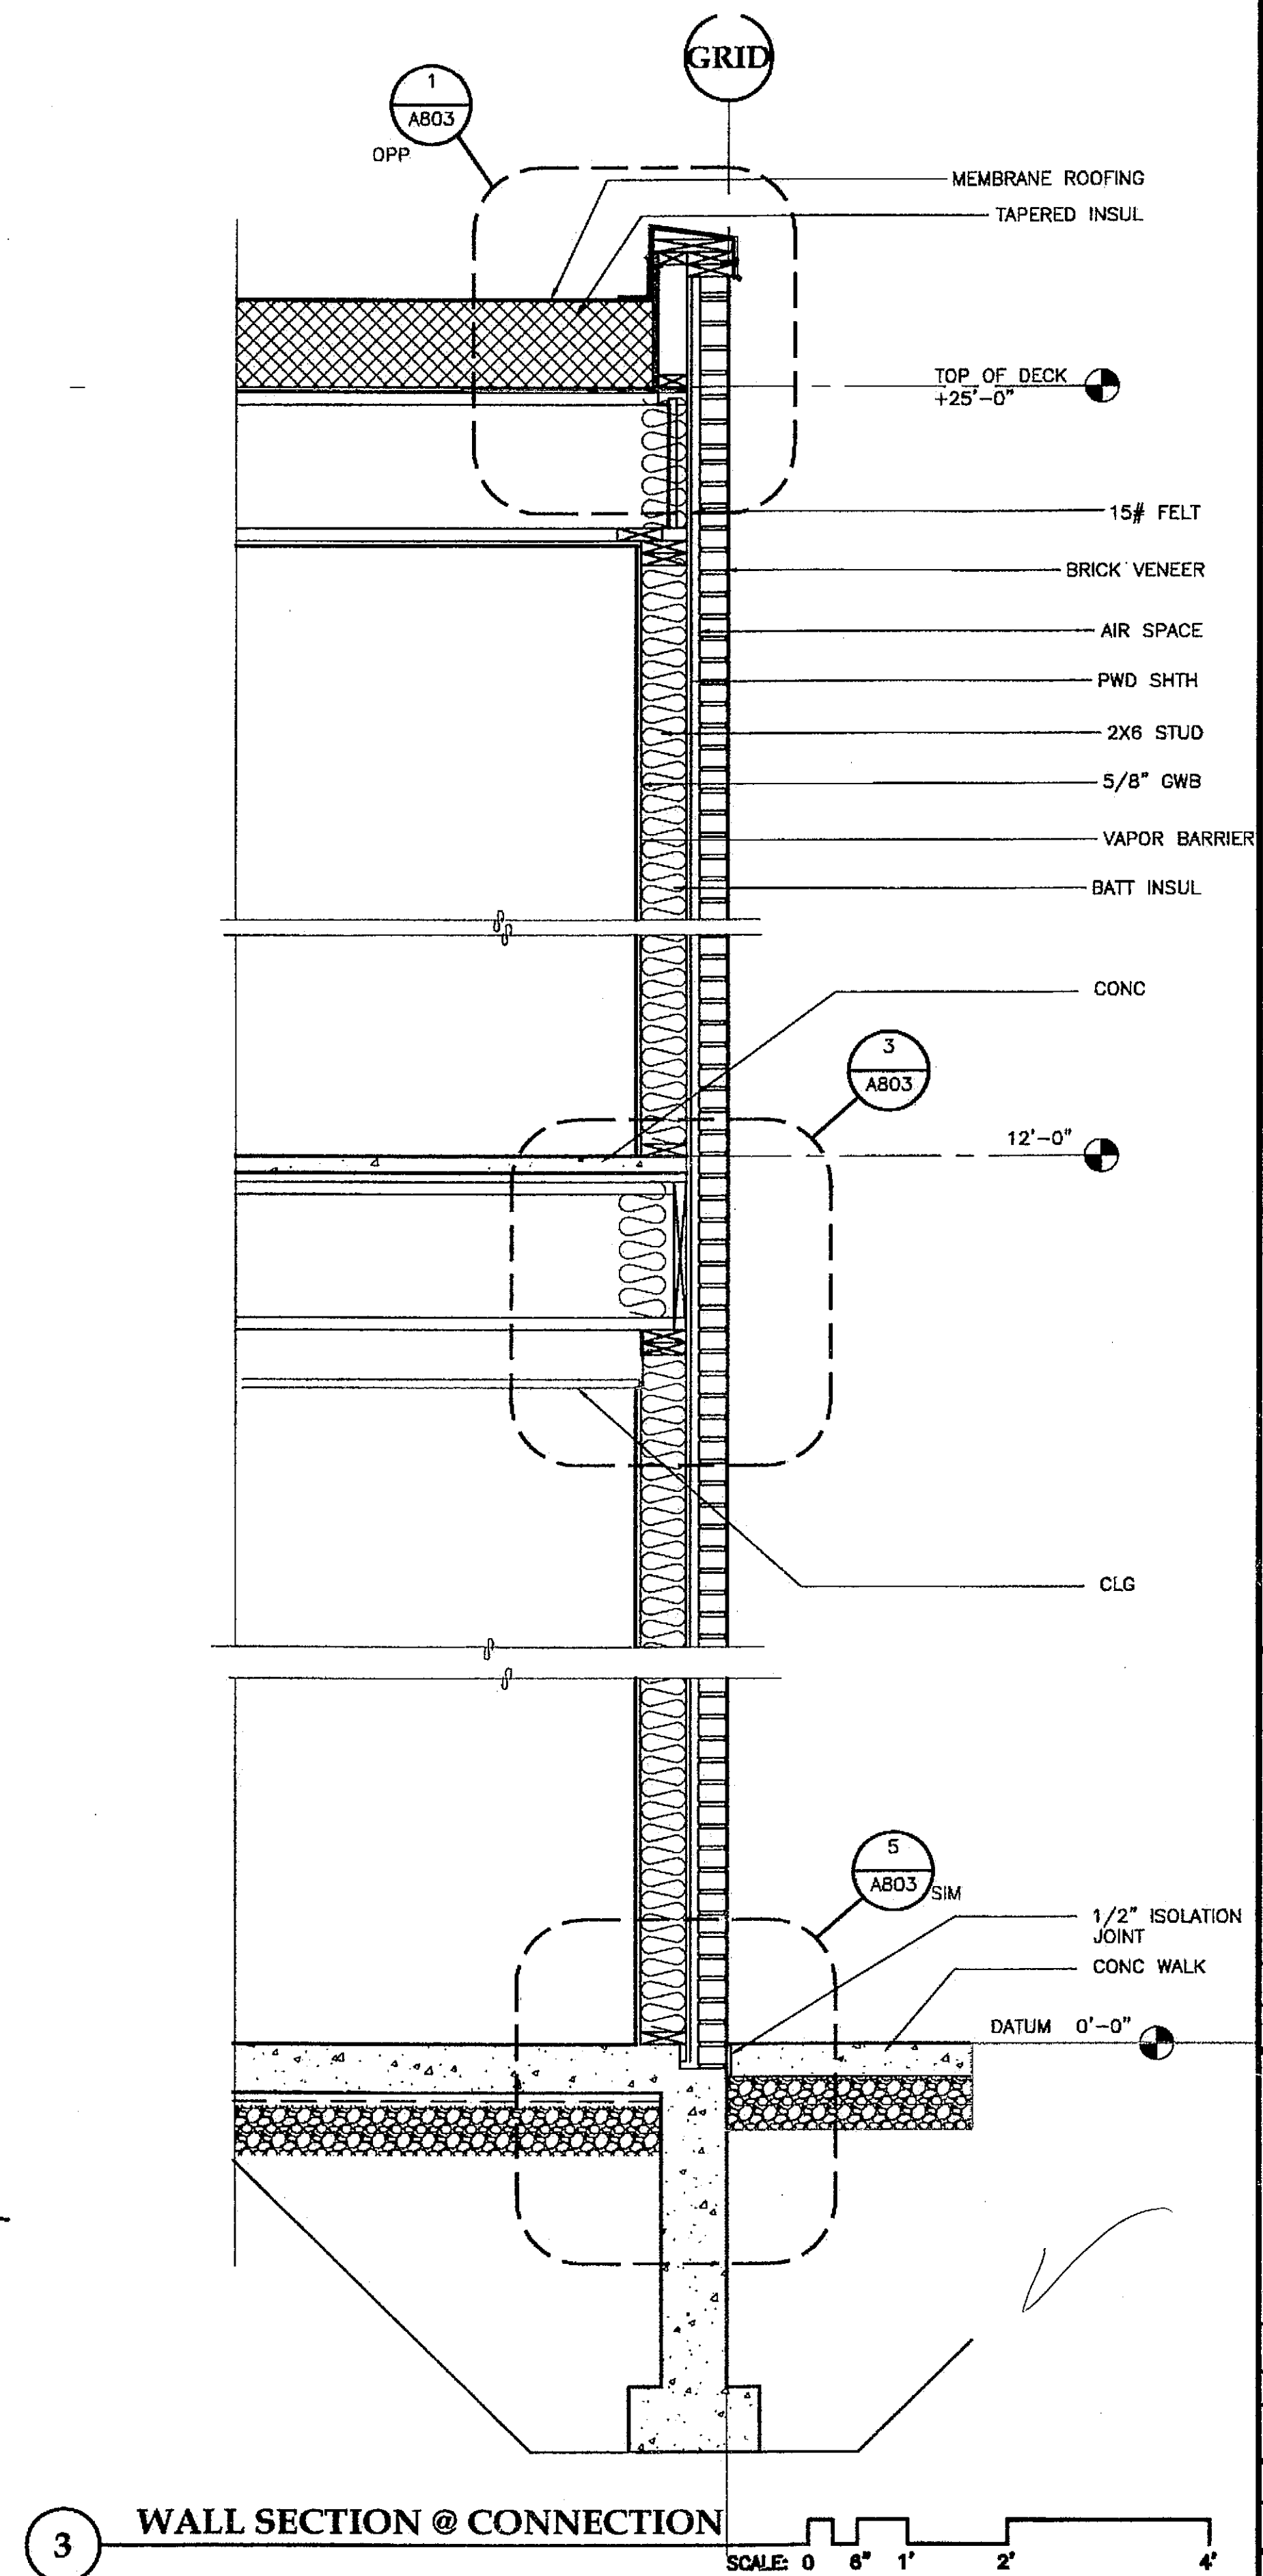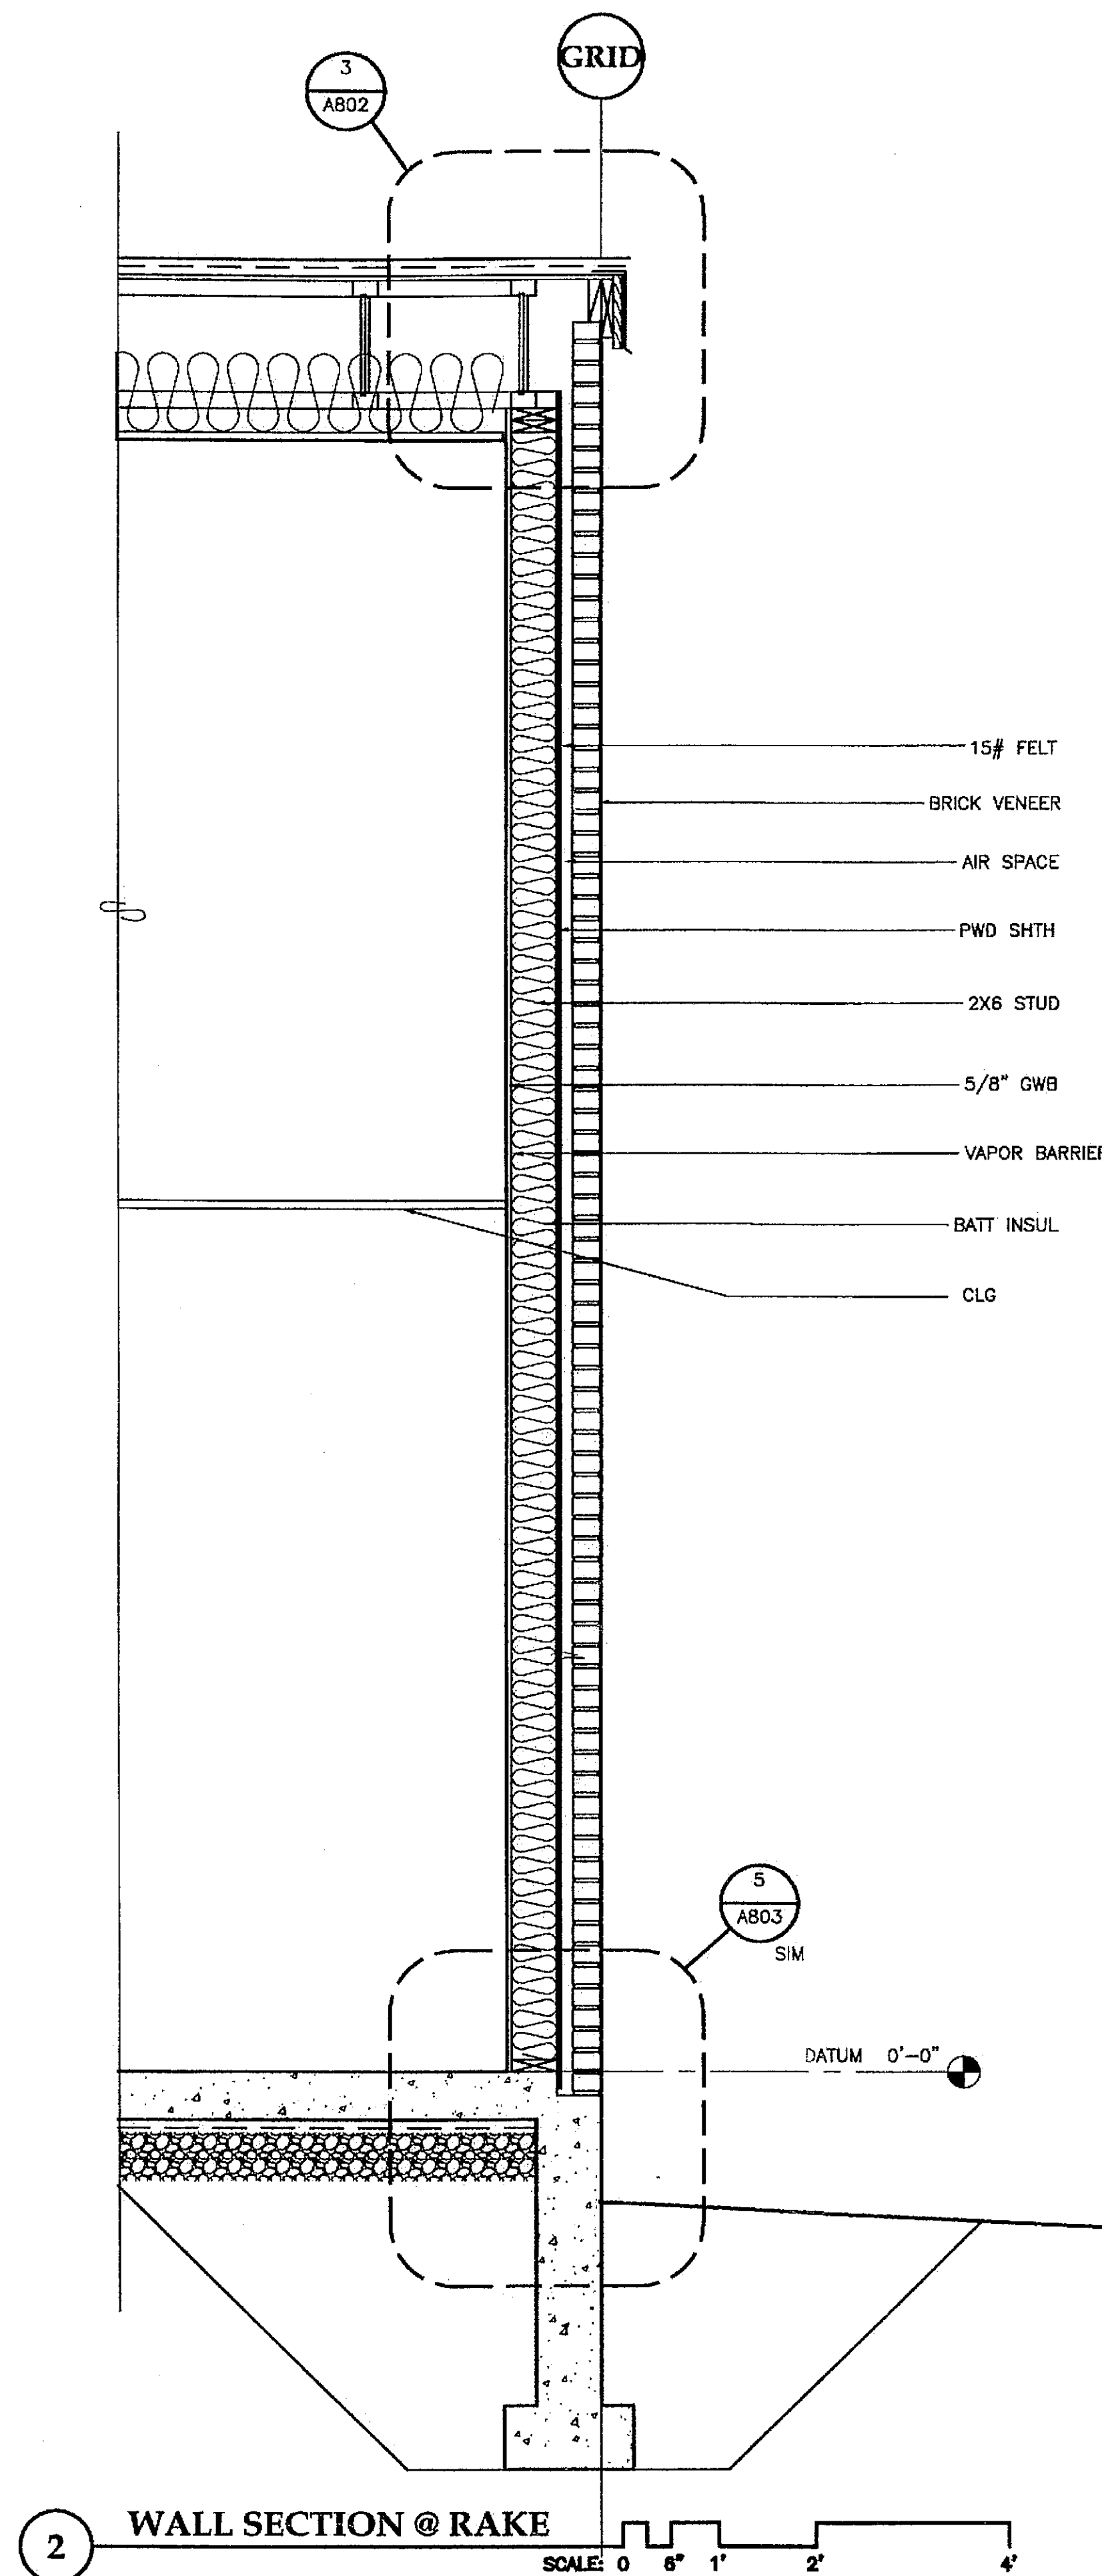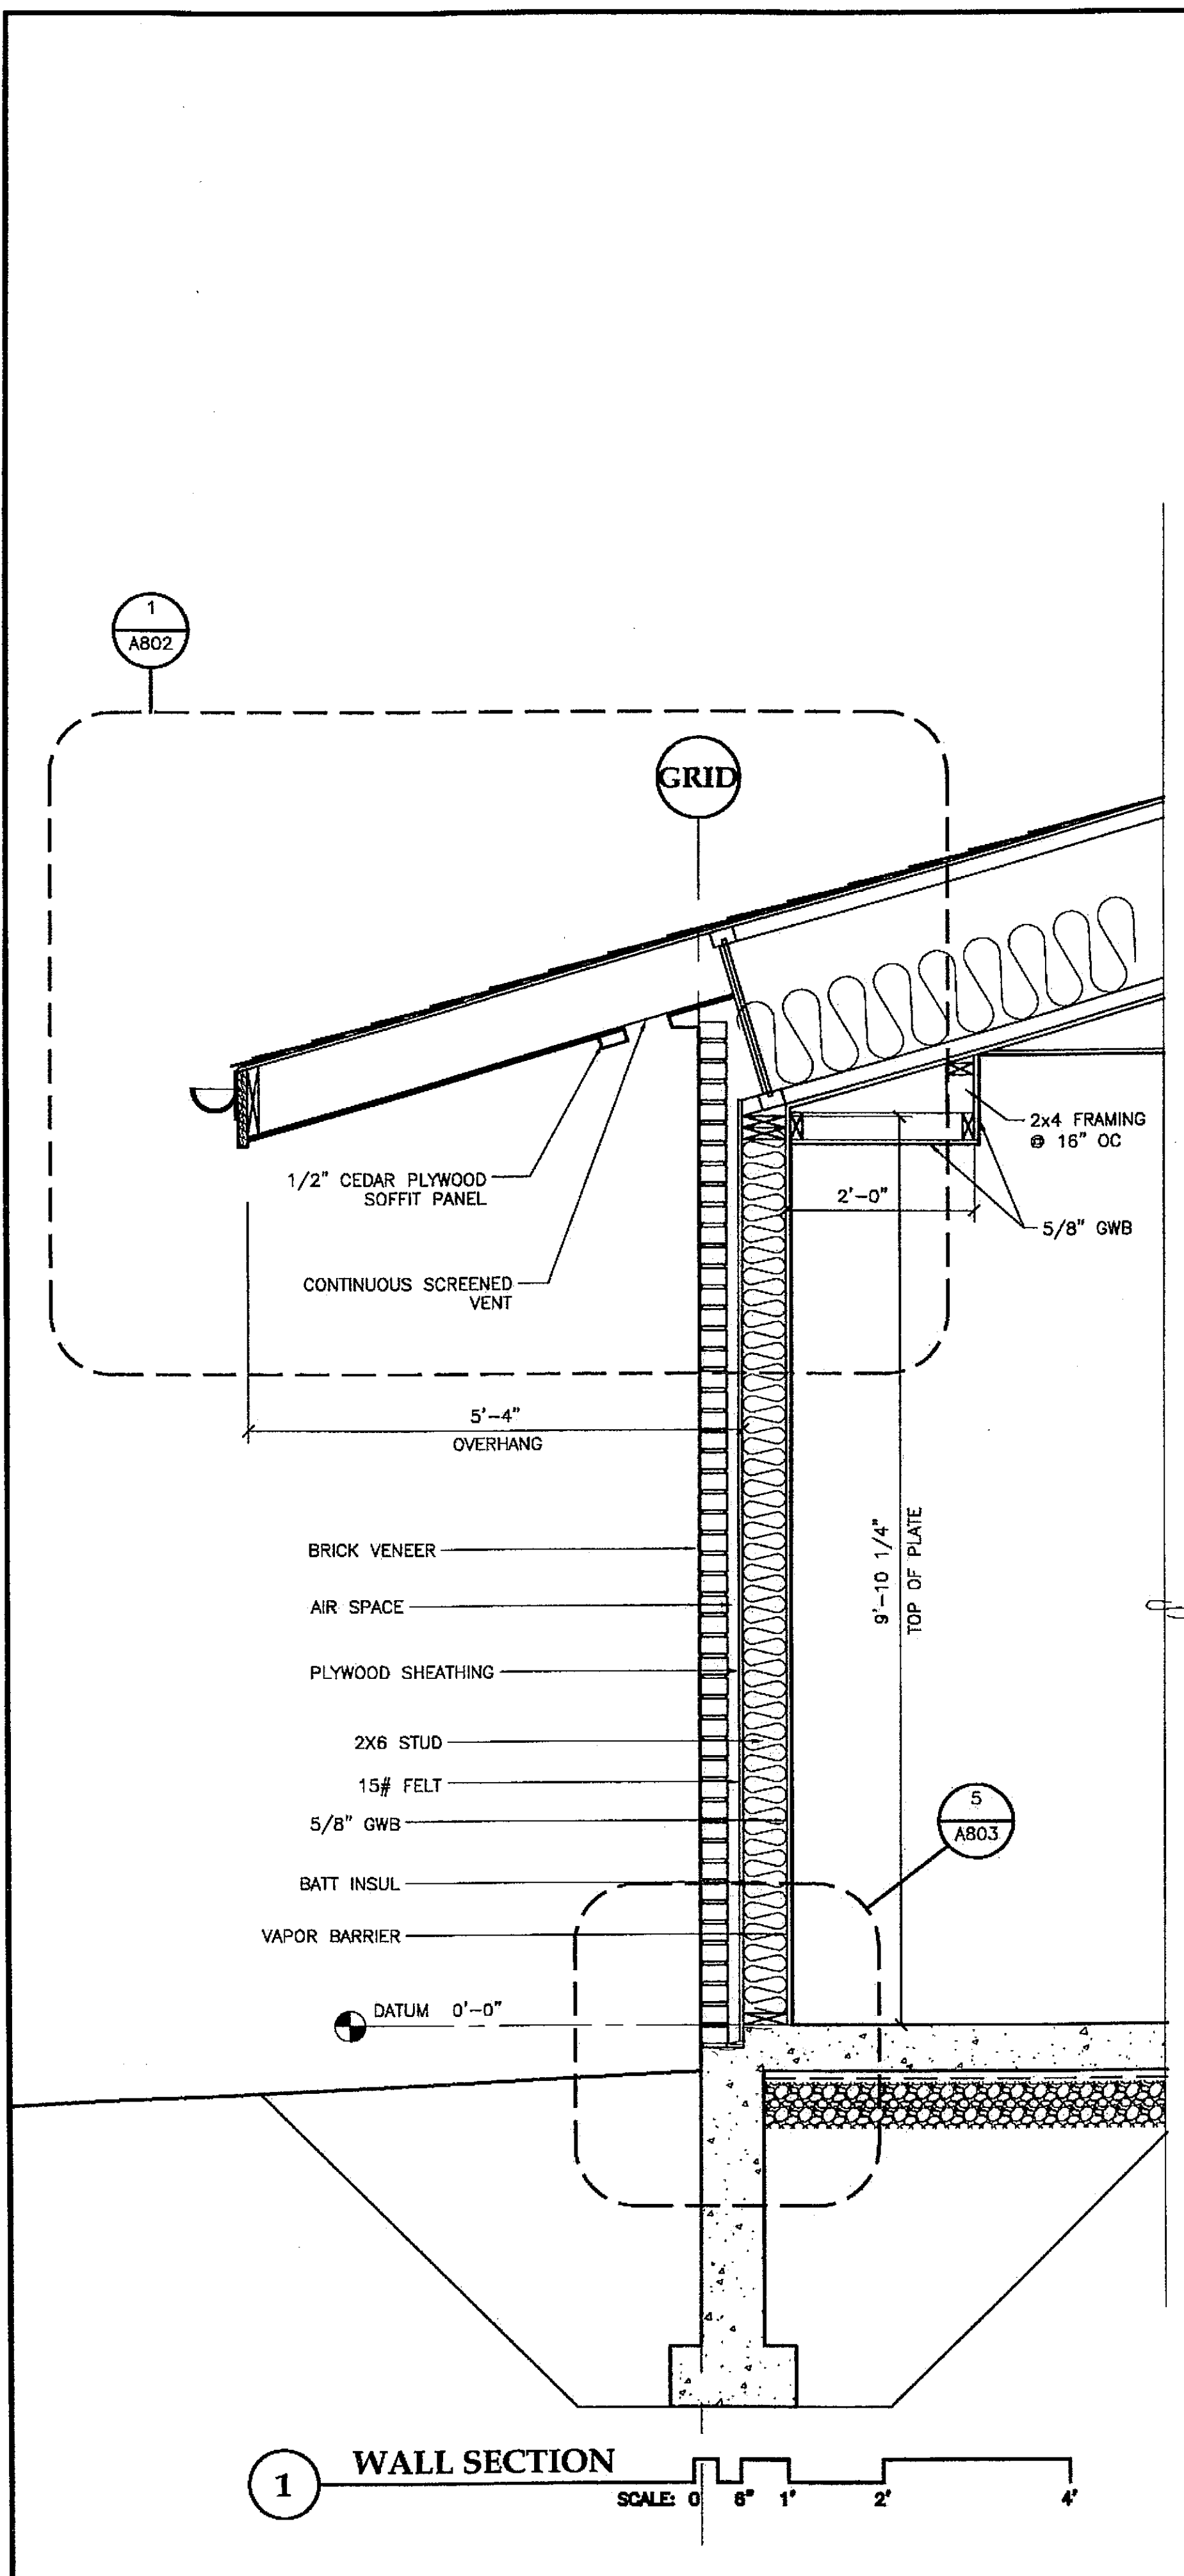

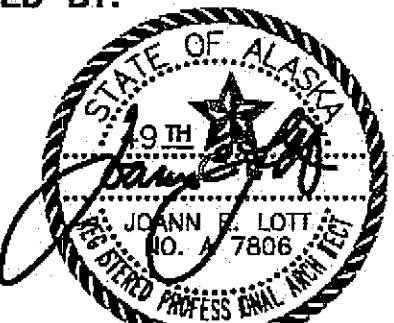PATH: G:\Projects\0411\CD\1330\Arch\A306.dwg Tue, 14/Dec/04 02:28PM TAB: Layout1		
ADDENDUM NUMBER		
ATTACHMENT NUMBER		
RECORD OF REVISIONS		
No.	DATE	DESCRIPTION
CHECKED BY: 		
DESIGNED BY: JENSEN YORBA LOTT		
DRAWN BY:		
STATE OF ALASKA DEPARTMENT OF TRANSPORTATION & PUBLIC FACILITIES STATEWIDE DESIGN & ENGINEERING SERVICES DIVISION MT EDGE CUMBE HIGH SCHOOL BUILDING 1330 ACADEMIC EXPANSION		
SHEET A306		
PROJECT DESIGNATION NUMBER		
67751C		
STATE	YEAR	
ALASKA	2004	
SHEET NUMBER	TOTAL SHEETS	
15	79	

Project As-Built Drawings have been reviewed by the Project Engineer and represent to the best of my knowledge, the project as constructed.
 Proj. Eng. *[Signature]* Date 7-07

PATH: G:\Projects\0411\0411\CD\1330\Arch\A307.dwg
 Tue, 14/Dec/04 02:28PM
 TAB: Layout1


ADDENDUM NUMBER

ATTACHMENT NUMBER

RECORD OF REVISIONS

No.	DATE	DESCRIPTION

CHECKED BY:

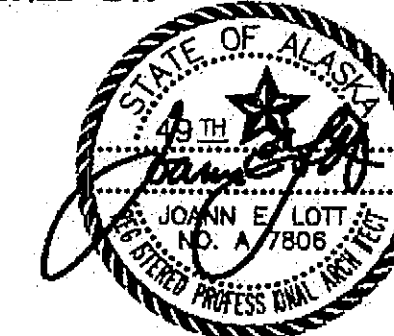

DESIGNED BY: JENSEN YORBA LOTT

DRAWN BY:

STATE OF ALASKA
 DEPARTMENT OF TRANSPORTATION
 & PUBLIC FACILITIES
 STATEWIDE DESIGN & ENGINEERING
 SERVICES DIVISION
 MT EDGE CUMBE
 HIGH SCHOOL
 BUILDING 1330
 ACADEMIC
 EXPANSION


SHEET A307

PROJECT DESIGNATION NUMBER

67751C


STATE	YEAR
ALASKA	2004
SHEET NUMBER	TOTAL SHEETS
16	79

Project As-Built Drawings have been reviewed by the Project Engineer and represent to the best of my knowledge, the project as constructed.
 Proj. Eng. *[Signature]* Date 7/07

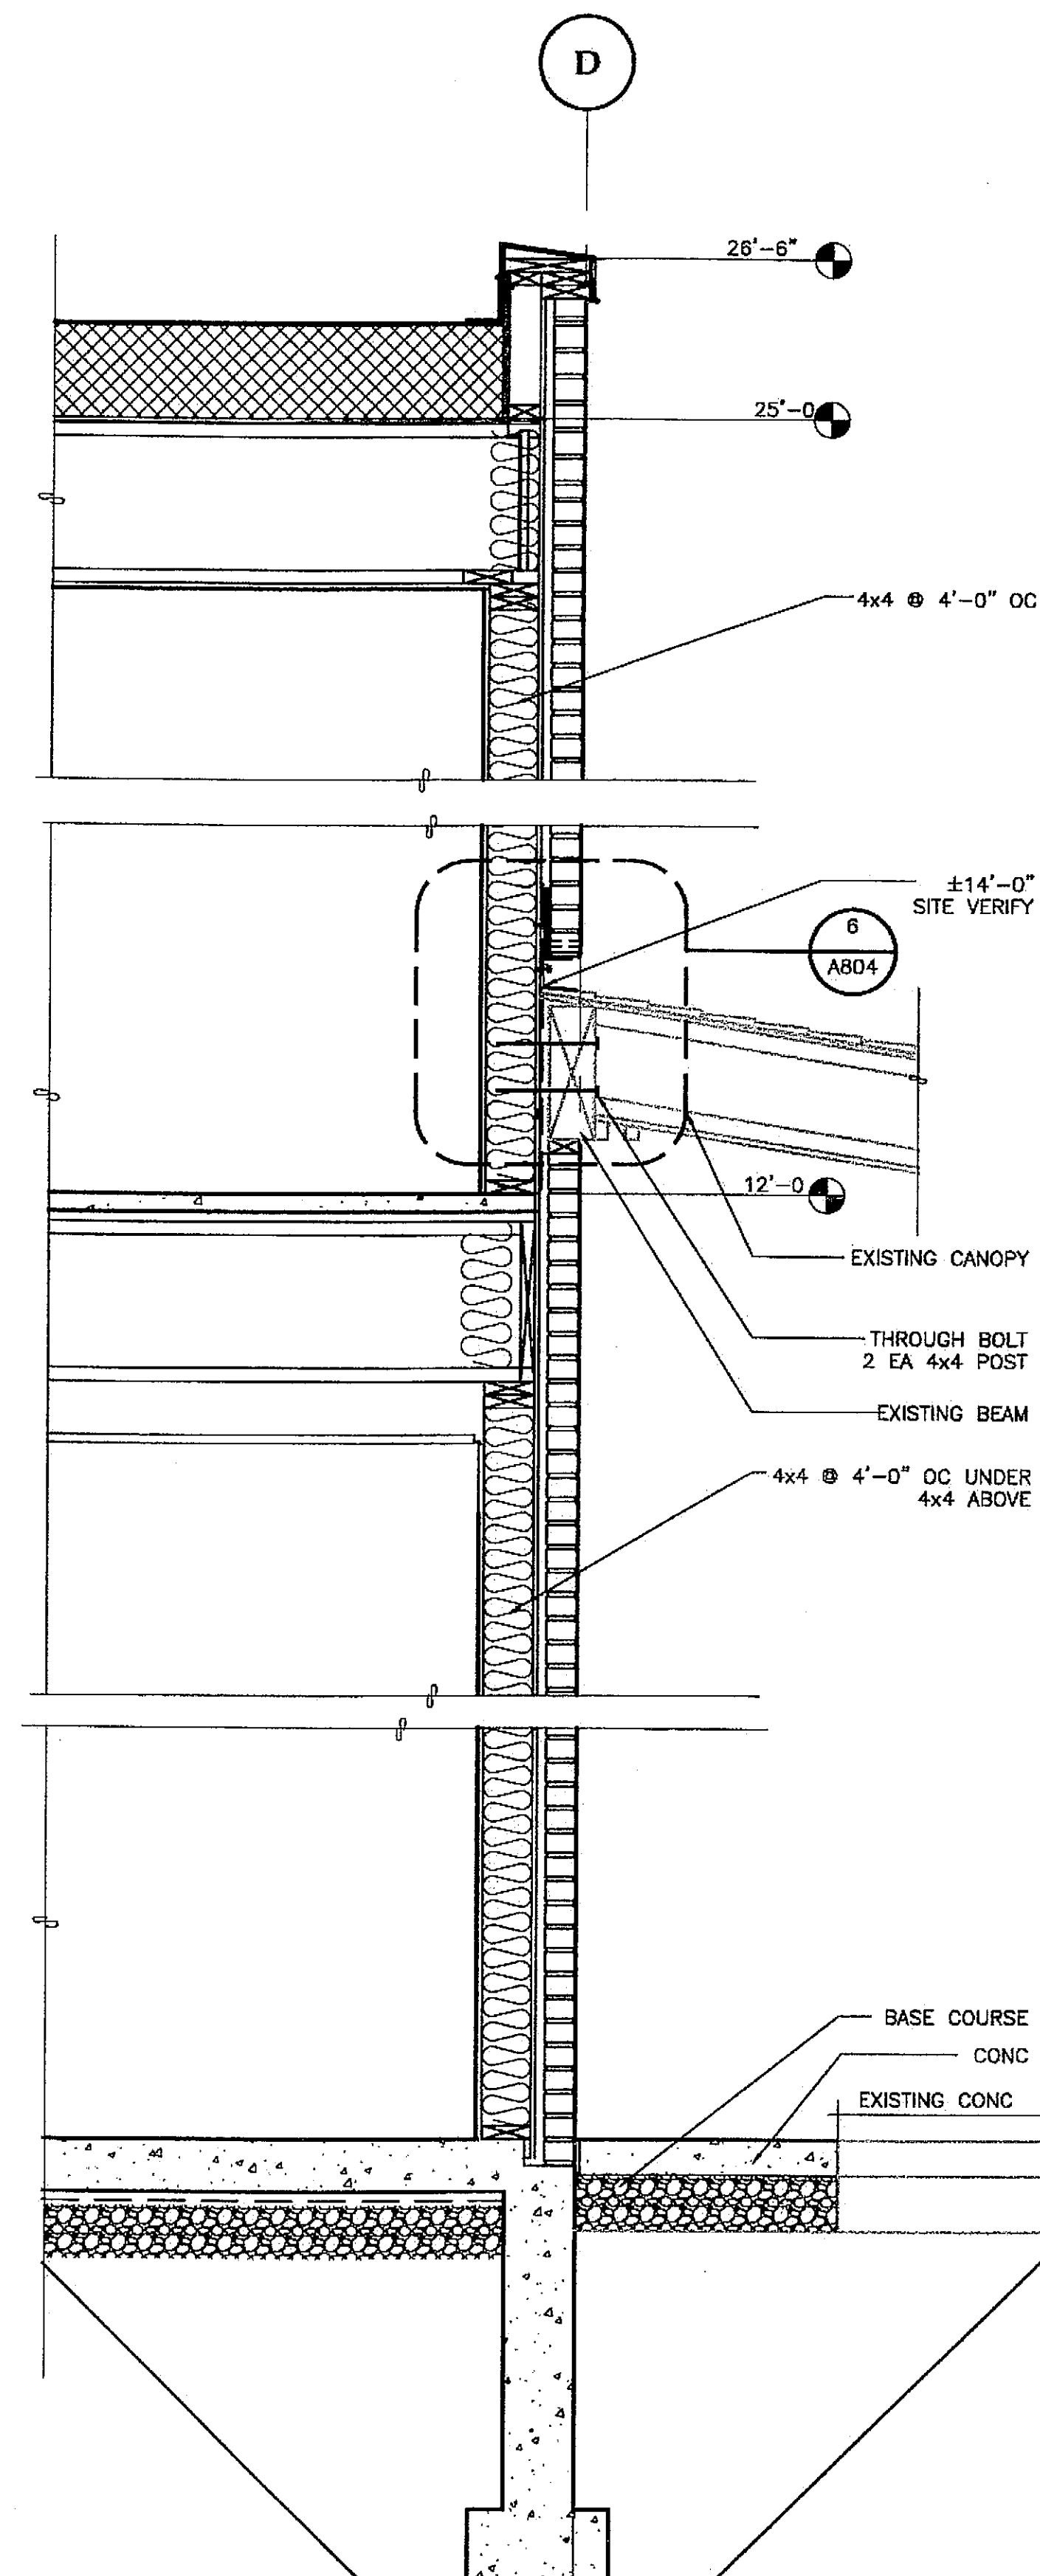


SEE 3/A306 FOR SIMILAR CALL OUTS


1 WALL SECTION
 SCALE: 0 6" 1' 2' 4'

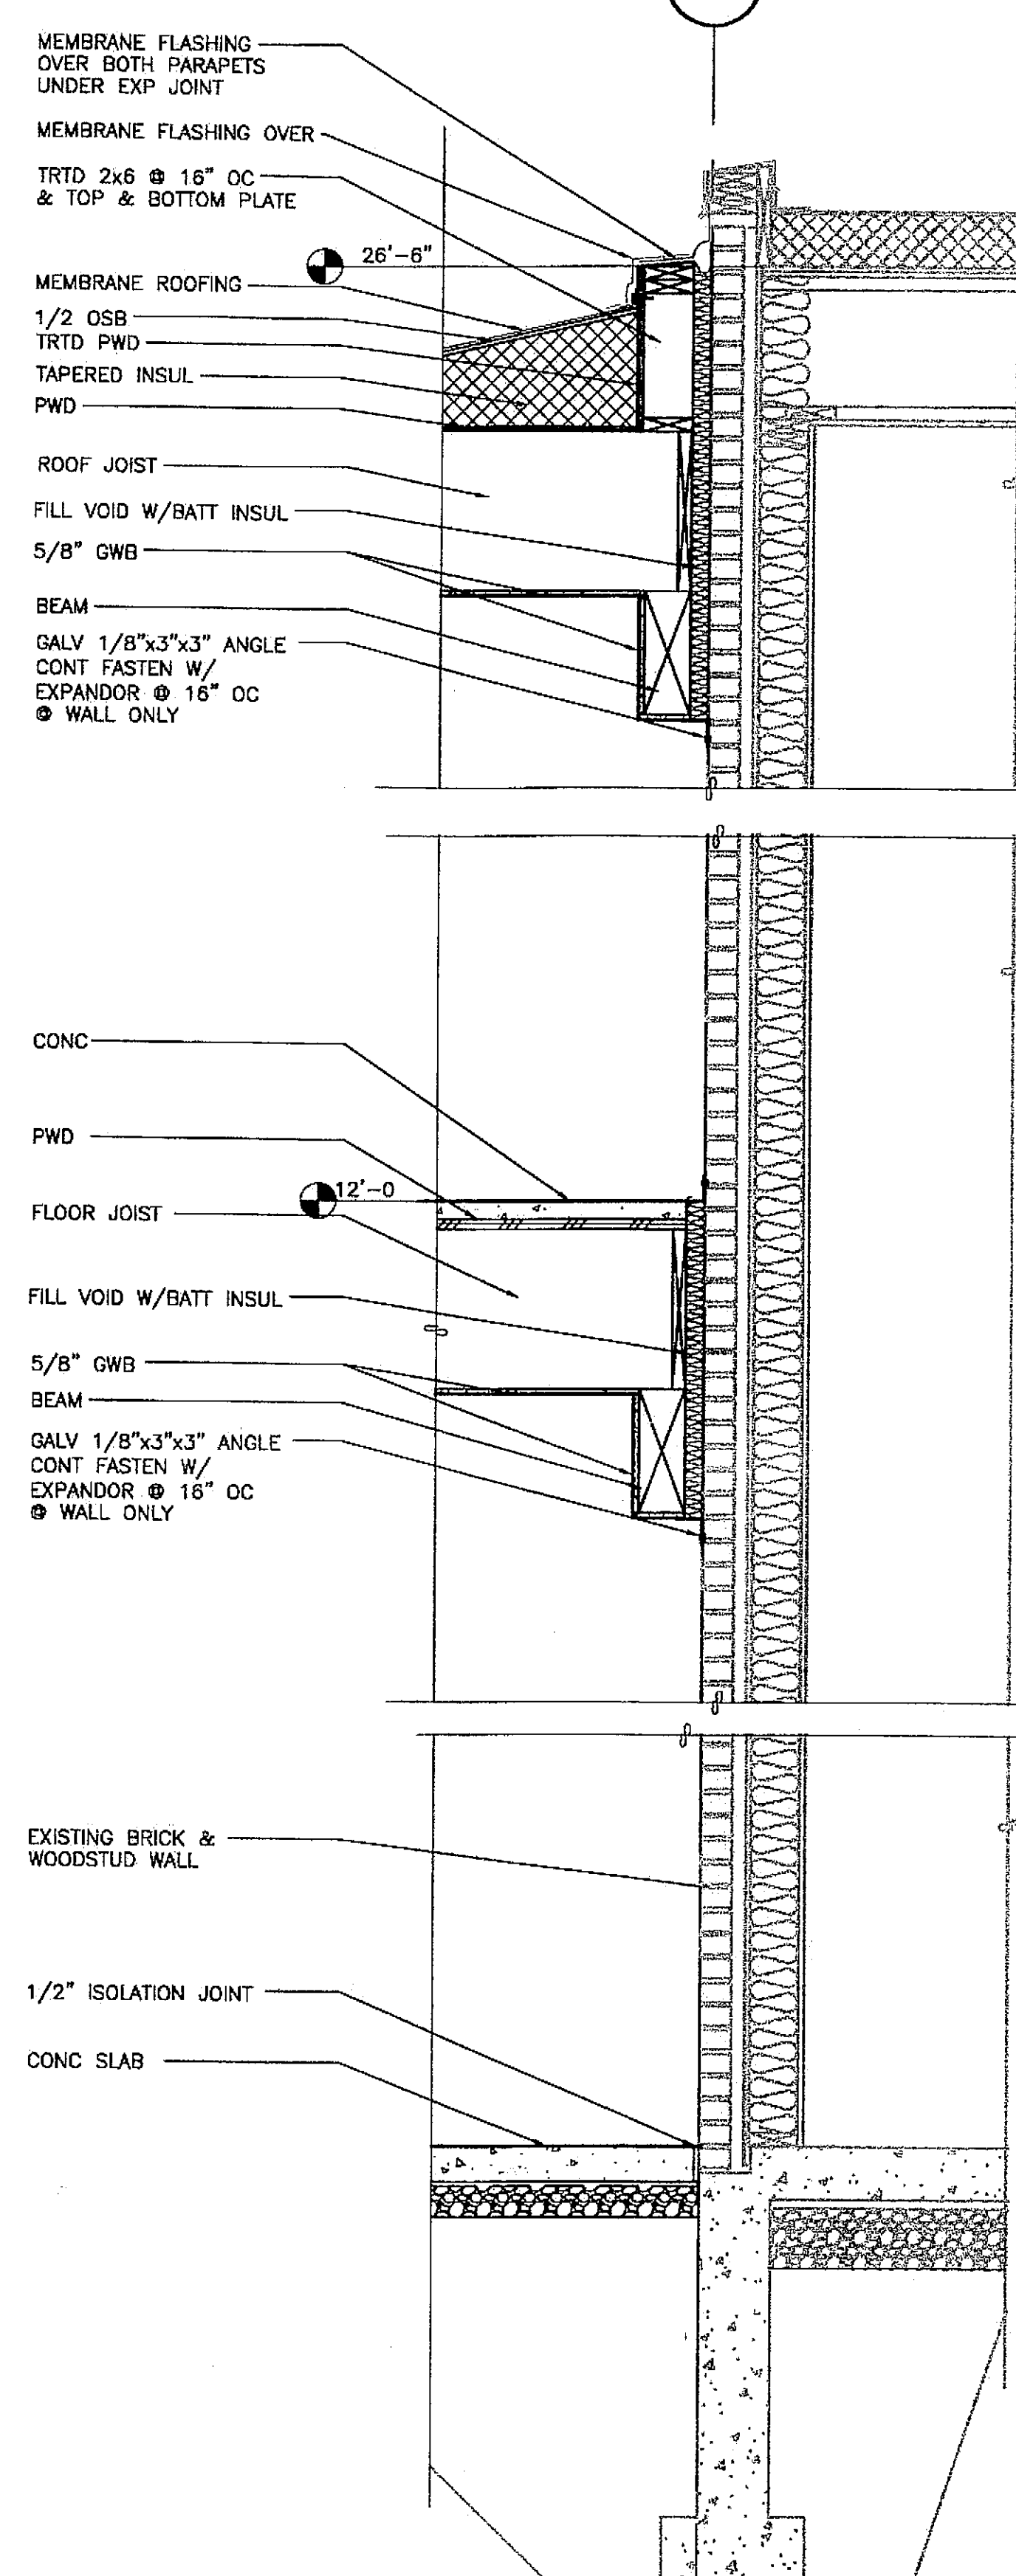


2 WALL SECTION @ JOINT TO EX BUILDING
 SCALE: 0 6" 1' 2' 4'

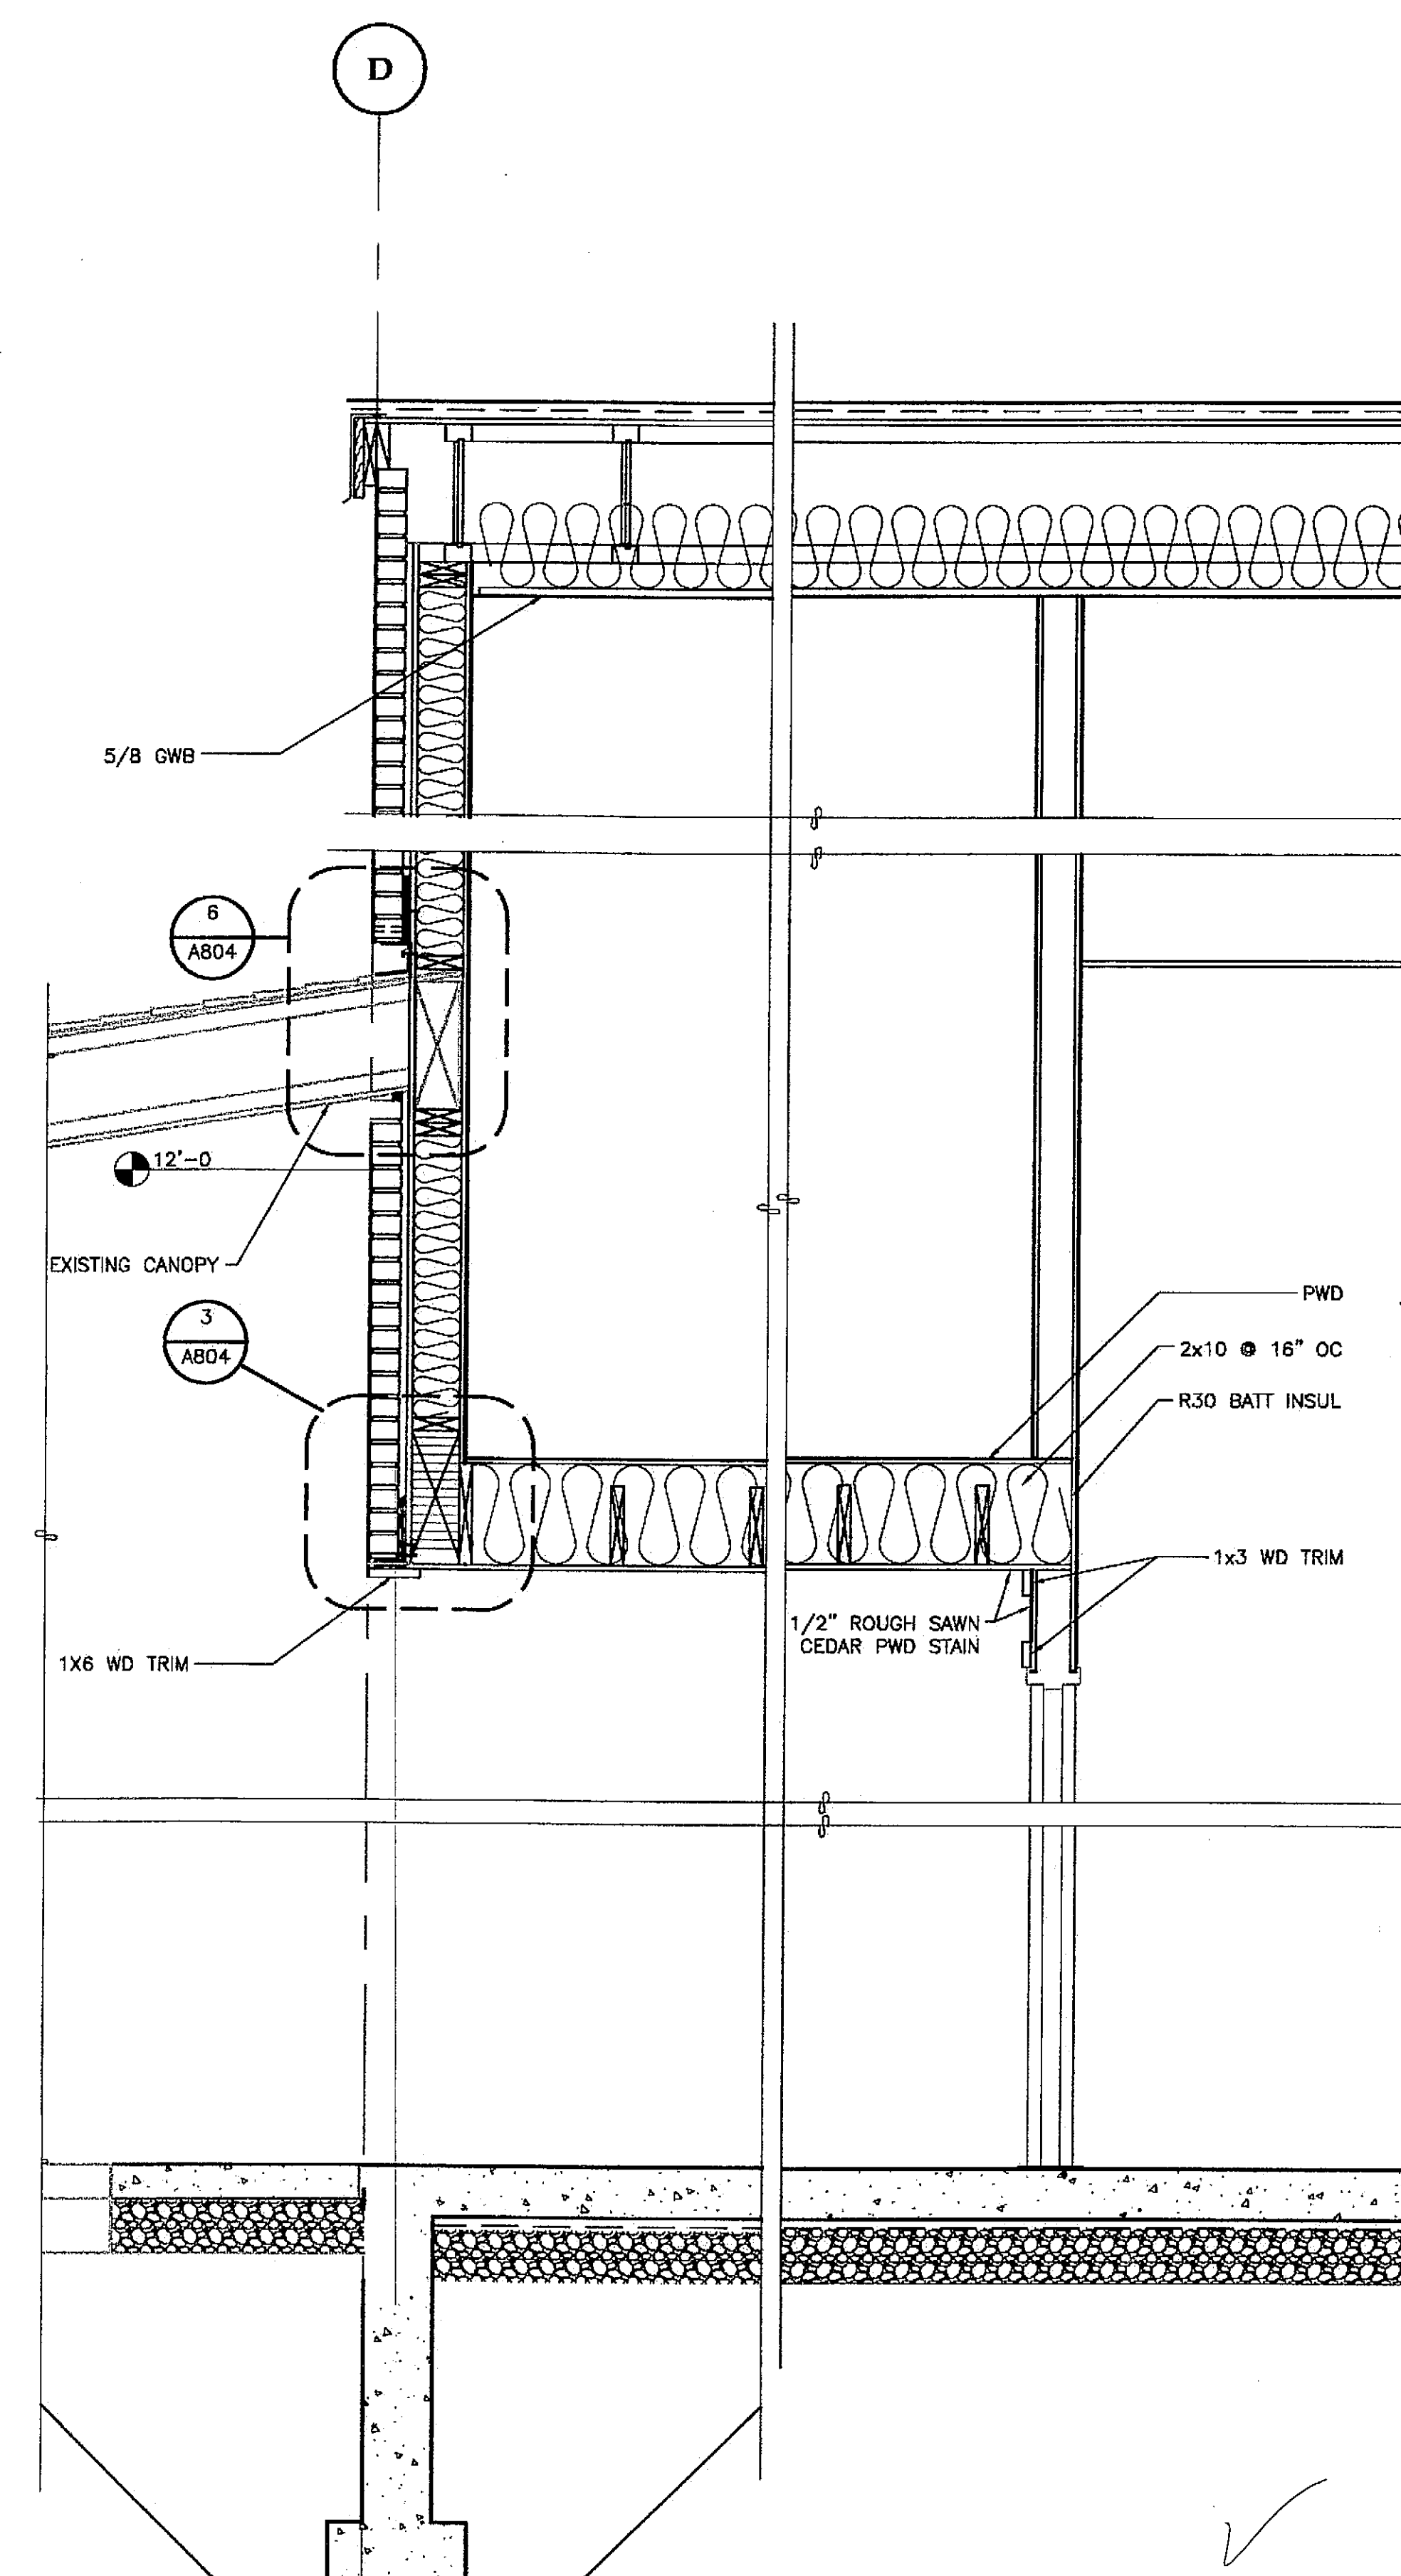


3 WALL SECTION @ EXISTING CANOPY
 SCALE: 0 6" 1' 2' 4'

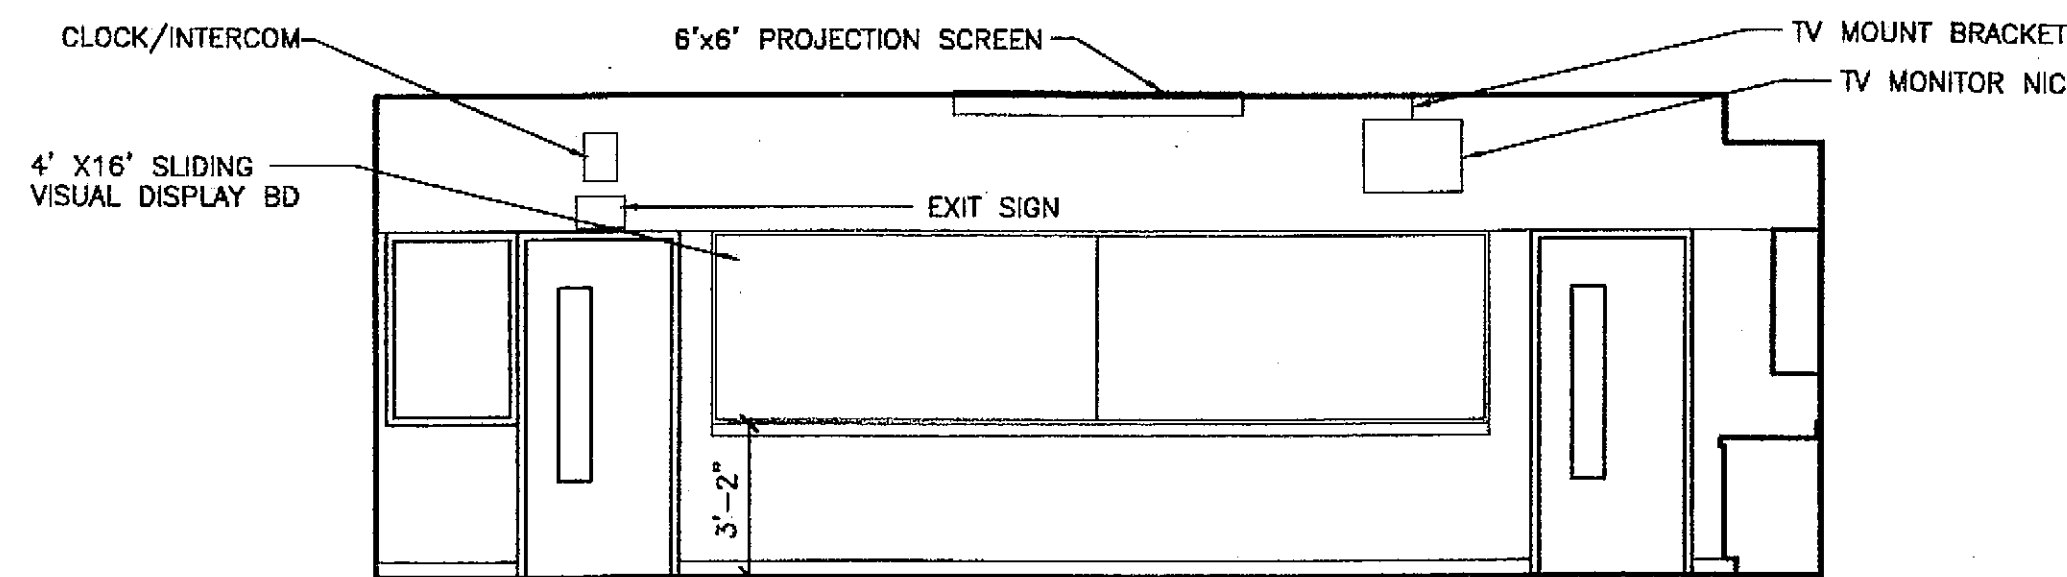


1 ROOM 143 SCIENCE SCALE: 0 2' 4' 8'

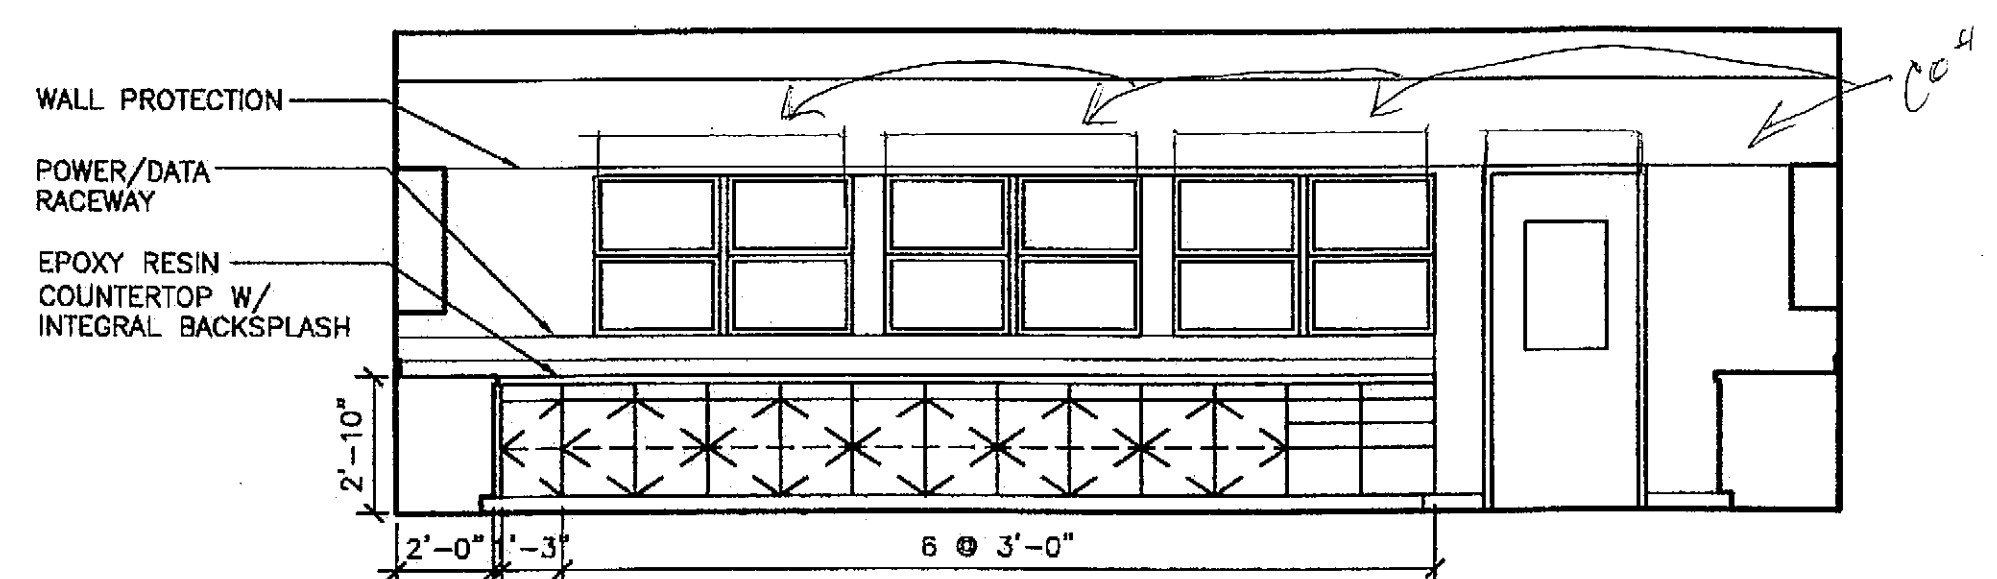


3 ROOM 143 SCIENCE SCALE: 0 2' 4' 8'

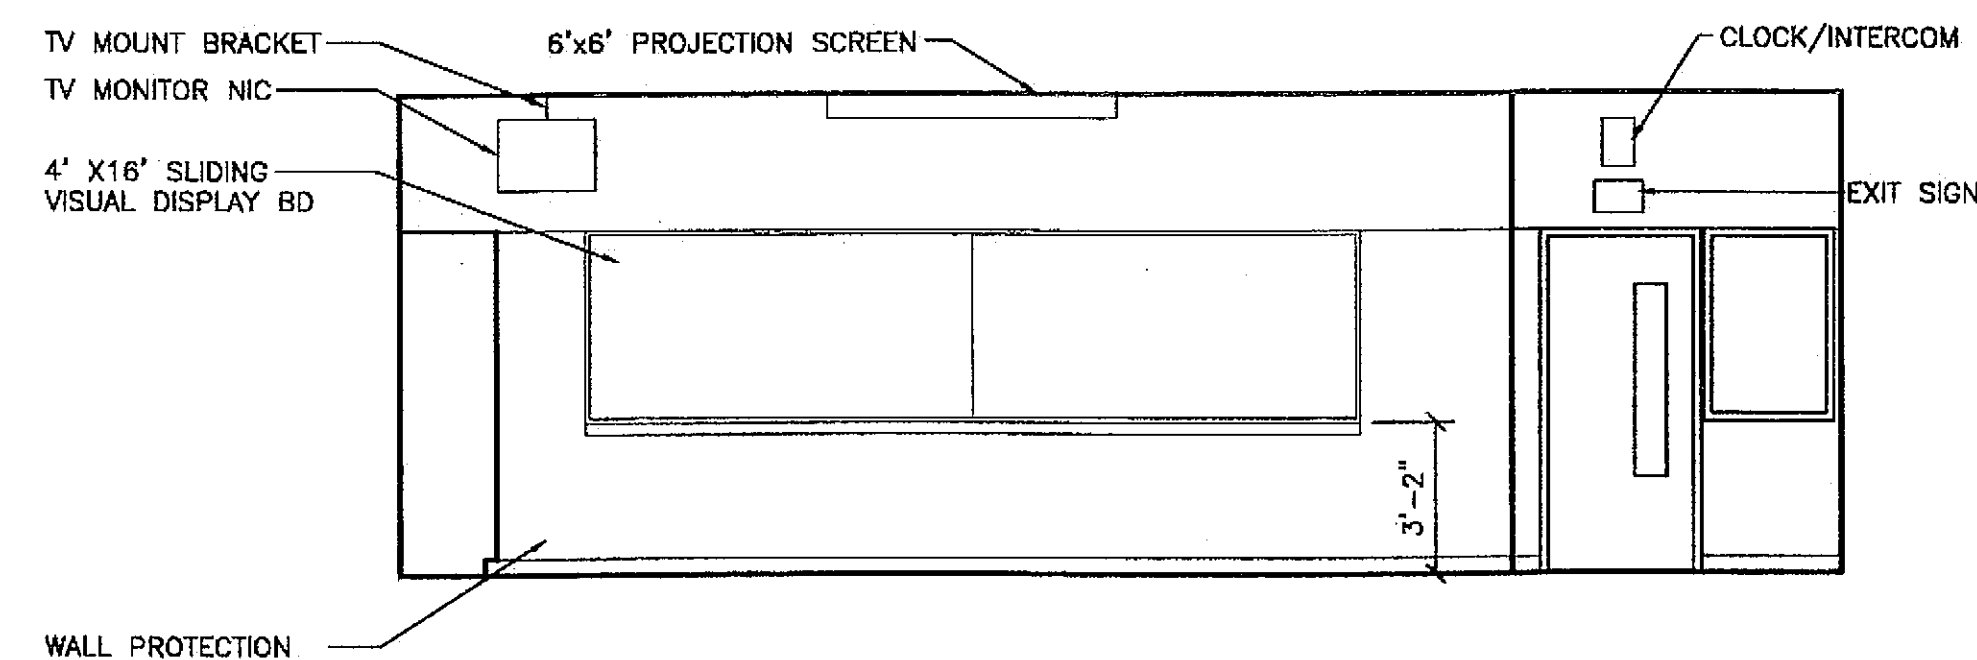


5 ROOM 142 SCIENCE SCALE: 0 2' 4' 8'

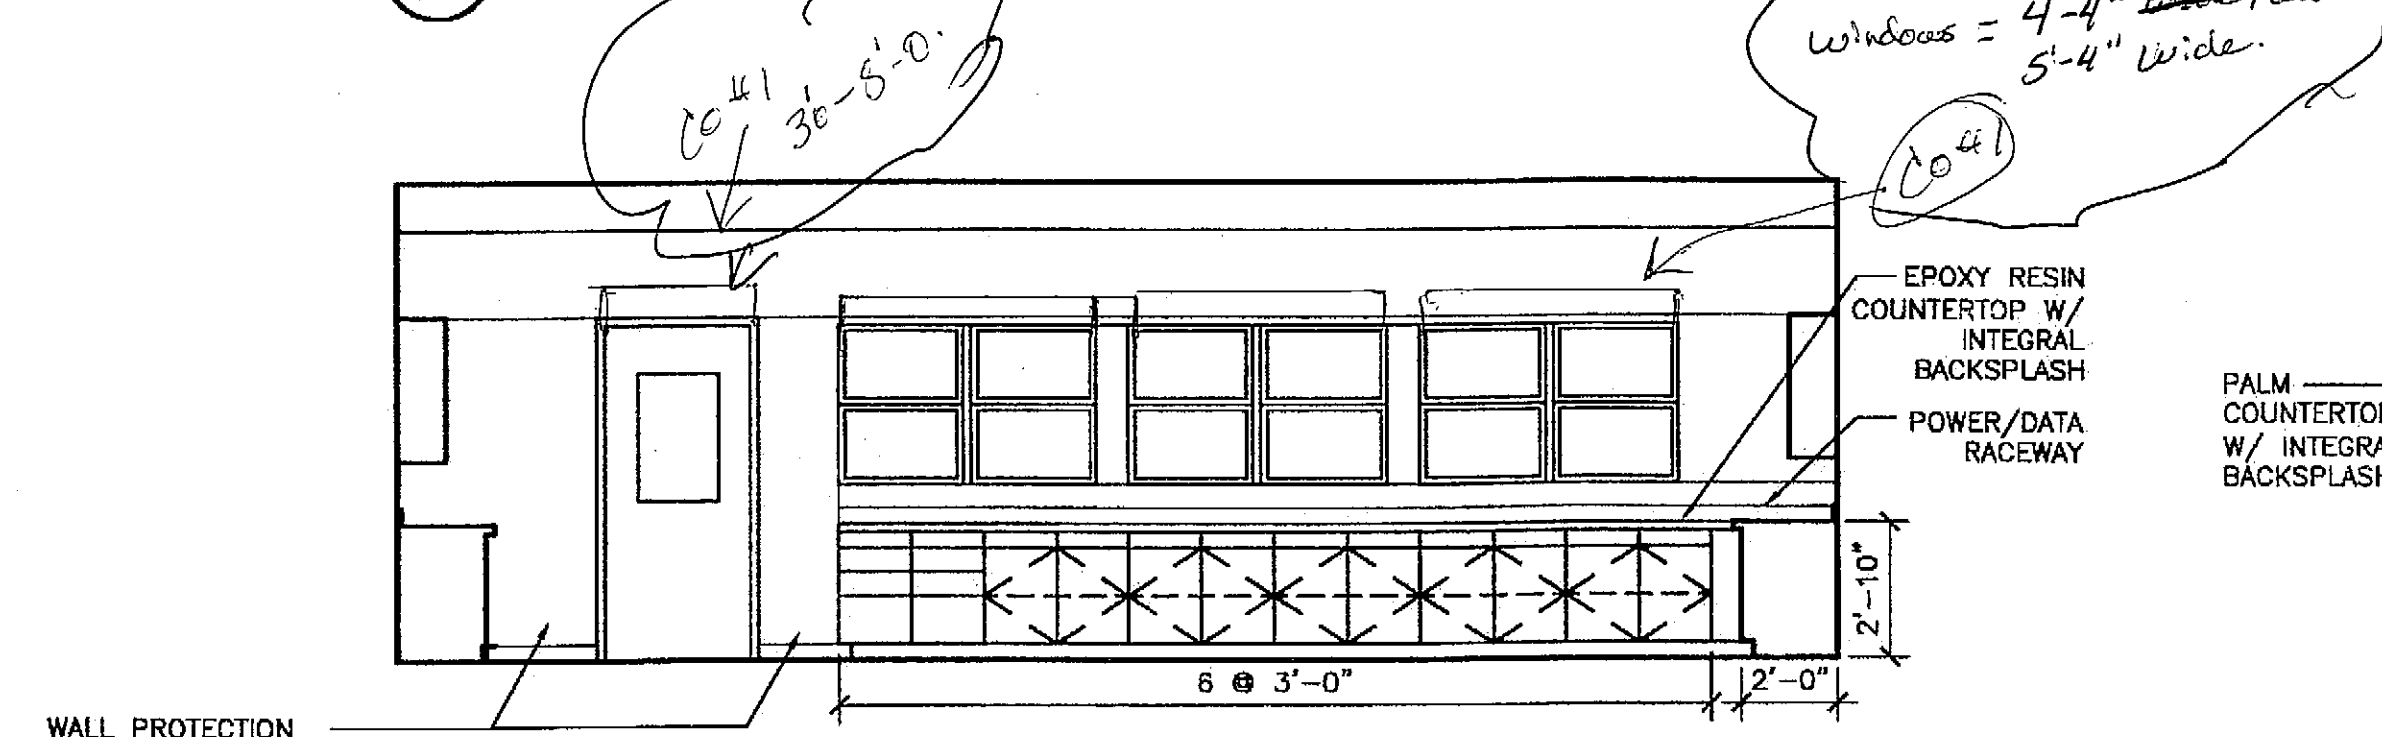


7 ROOM 142 SCIENCE SCALE: 0 2' 4' 8'

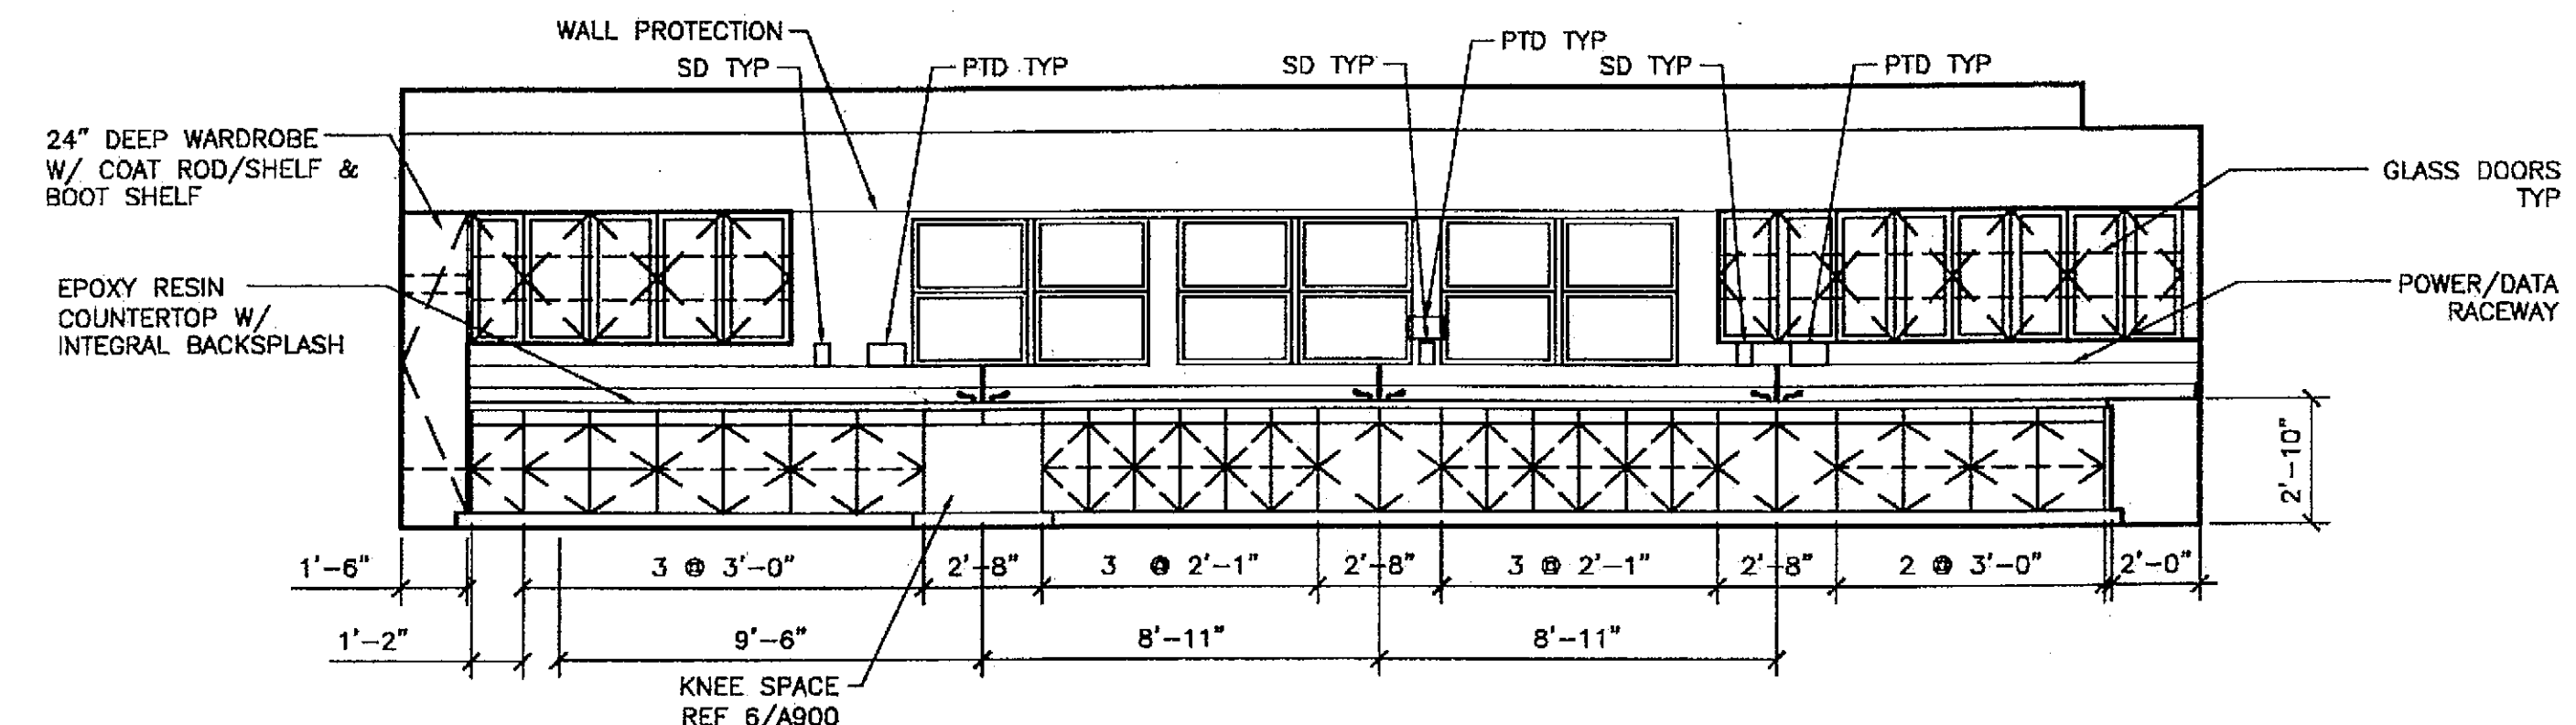


2 ROOM 143 SCIENCE SCALE: 0 2' 4' 8'

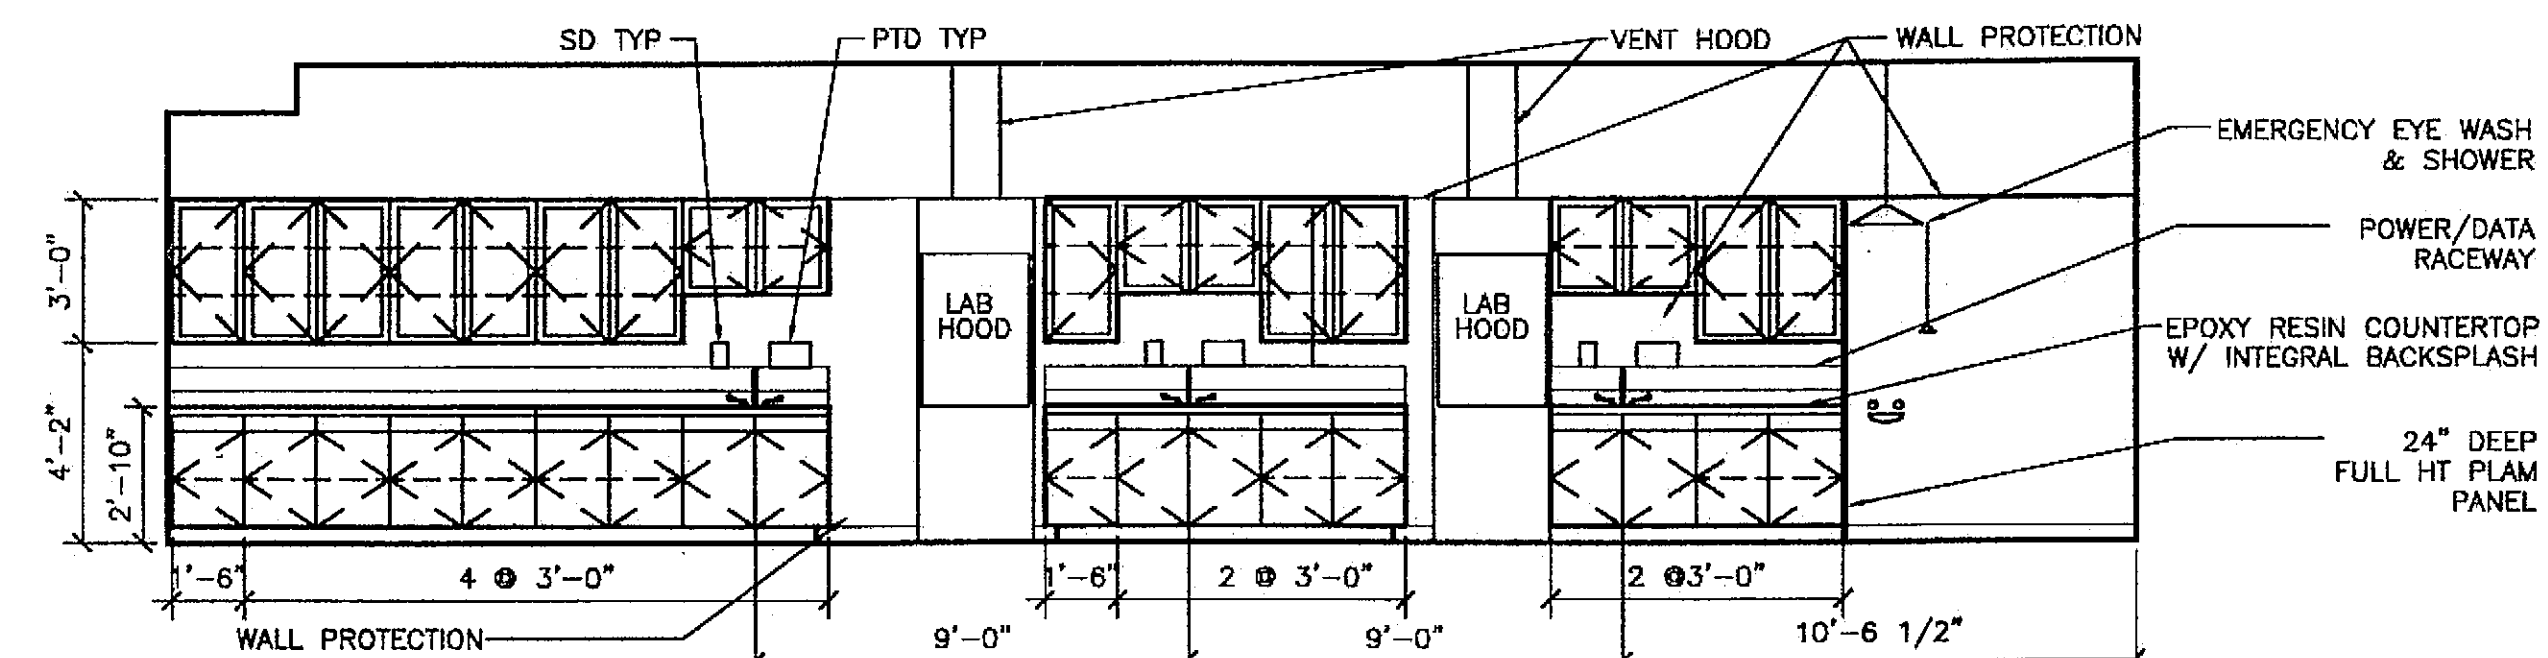

4 ROOM 143 SCIENCE SCALE: 0 2' 4' 8'

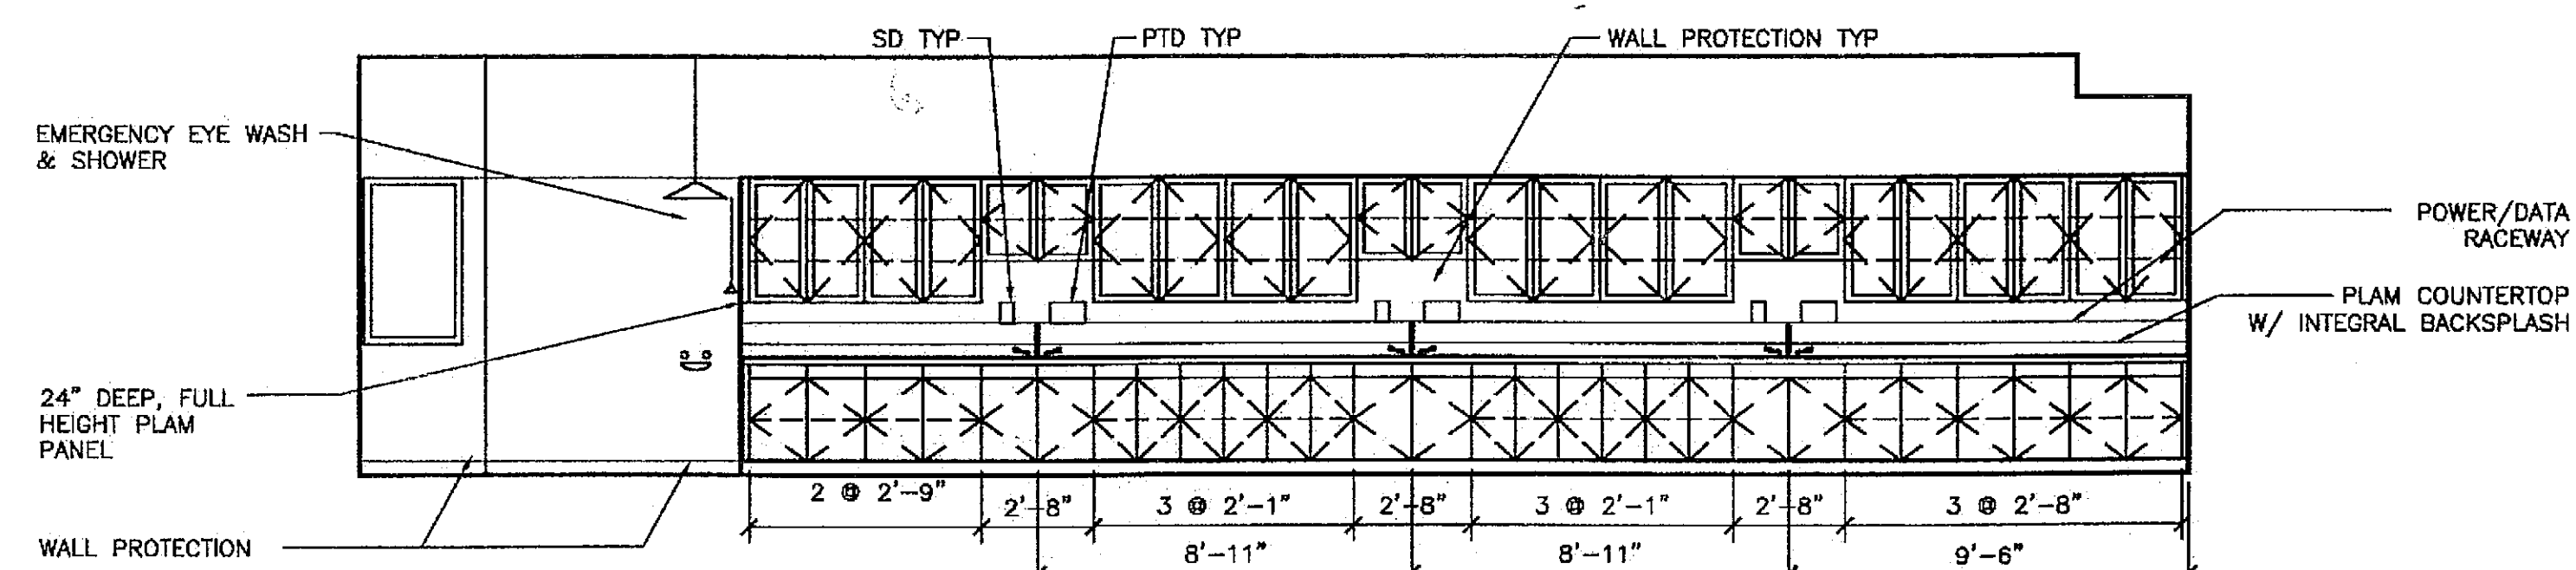


6 ROOM 142 SCIENCE SCALE: 0 2' 4' 8'

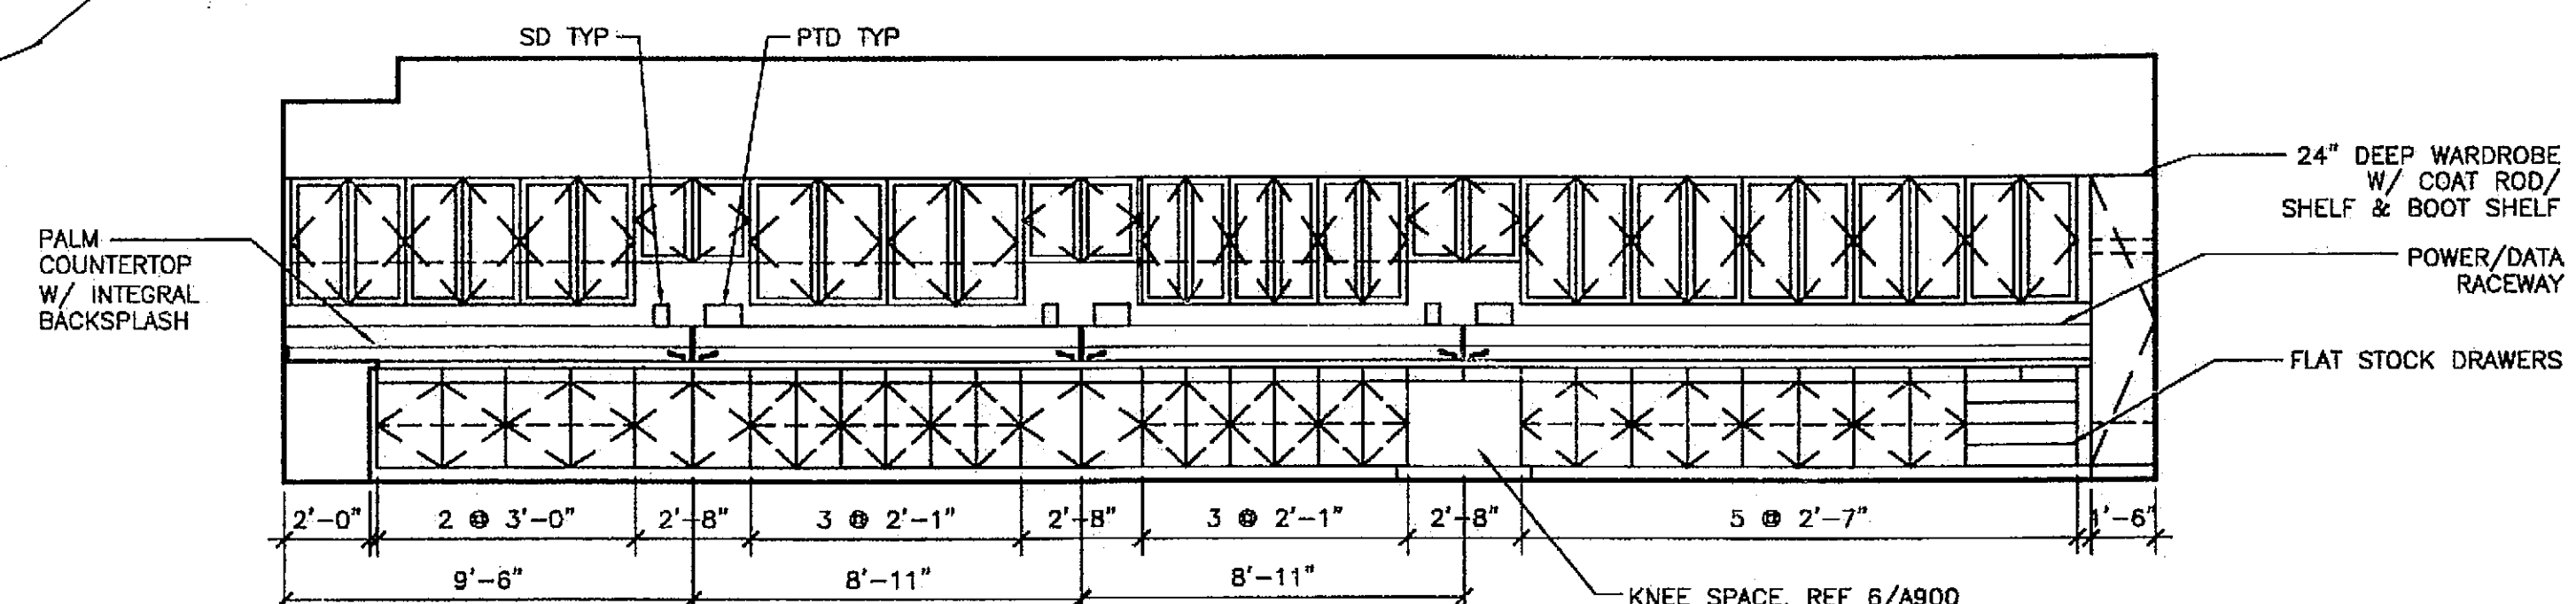

8 ROOM 142 SCIENCE SCALE: 0 2' 4' 8'


PATH: G:_Projects\0411\CD\CD\1330\Arch\A501.dwg Tue, 14/Dec/04 02:32PM TAB: Layout1		
ADDENDUM NUMBER		
ATTACHMENT NUMBER		
RECORD OF REVISIONS		
No.	DATE	DESCRIPTION
CHECKED BY:		
DESIGNED BY: JENSEN YORBA LOTT		
DRAWN BY:		
STATE OF ALASKA DEPARTMENT OF TRANSPORTATION & PUBLIC FACILITIES STATEWIDE DESIGN & ENGINEERING SERVICES DIVISION MT EDGECUMBE HIGH SCHOOL BUILDING 1330 ACADEMIC EXPANSION		
SHEET A501		
PROJECT DESIGNATION NUMBER		
67751C		
STATE	YEAR	
ALASKA	2004	
SHEET NUMBER	TOTAL SHEETS	
17	79	

Project As-Built Drawings have been reviewed by the Project Engineer and represent to the best of my knowledge, the project as constructed.
 Proj. Eng. *J. Lott* Date *7-01*

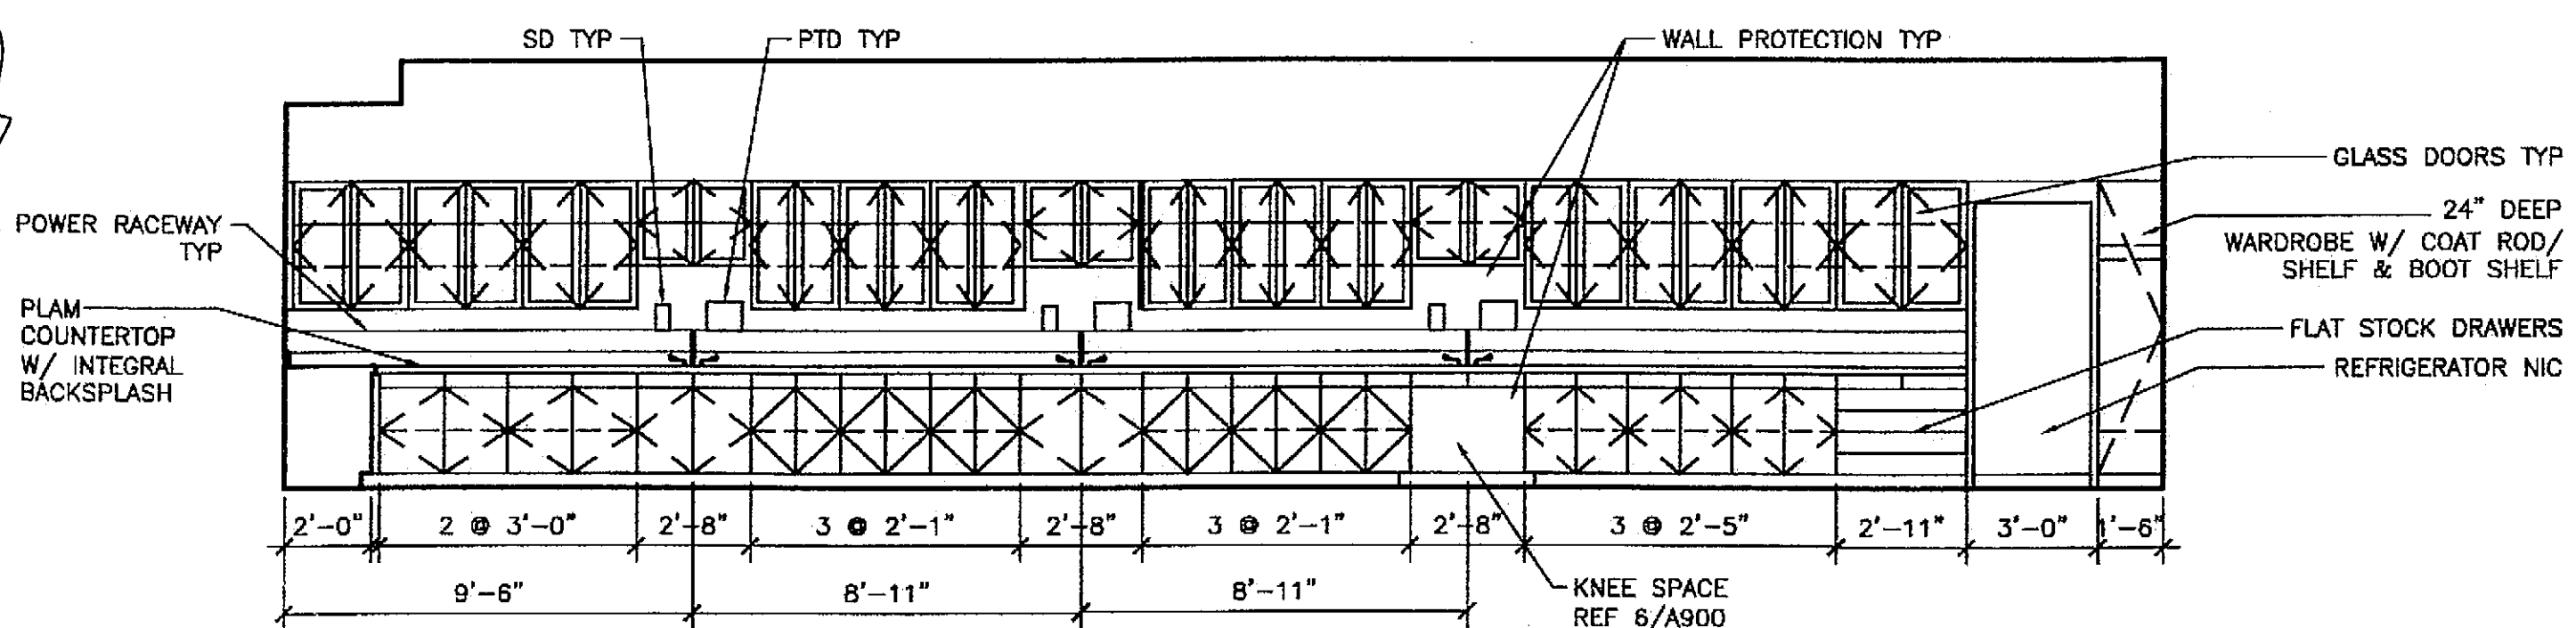


1 ROOM 141 SCIENCE


2 ROOM 141 SCIENCE

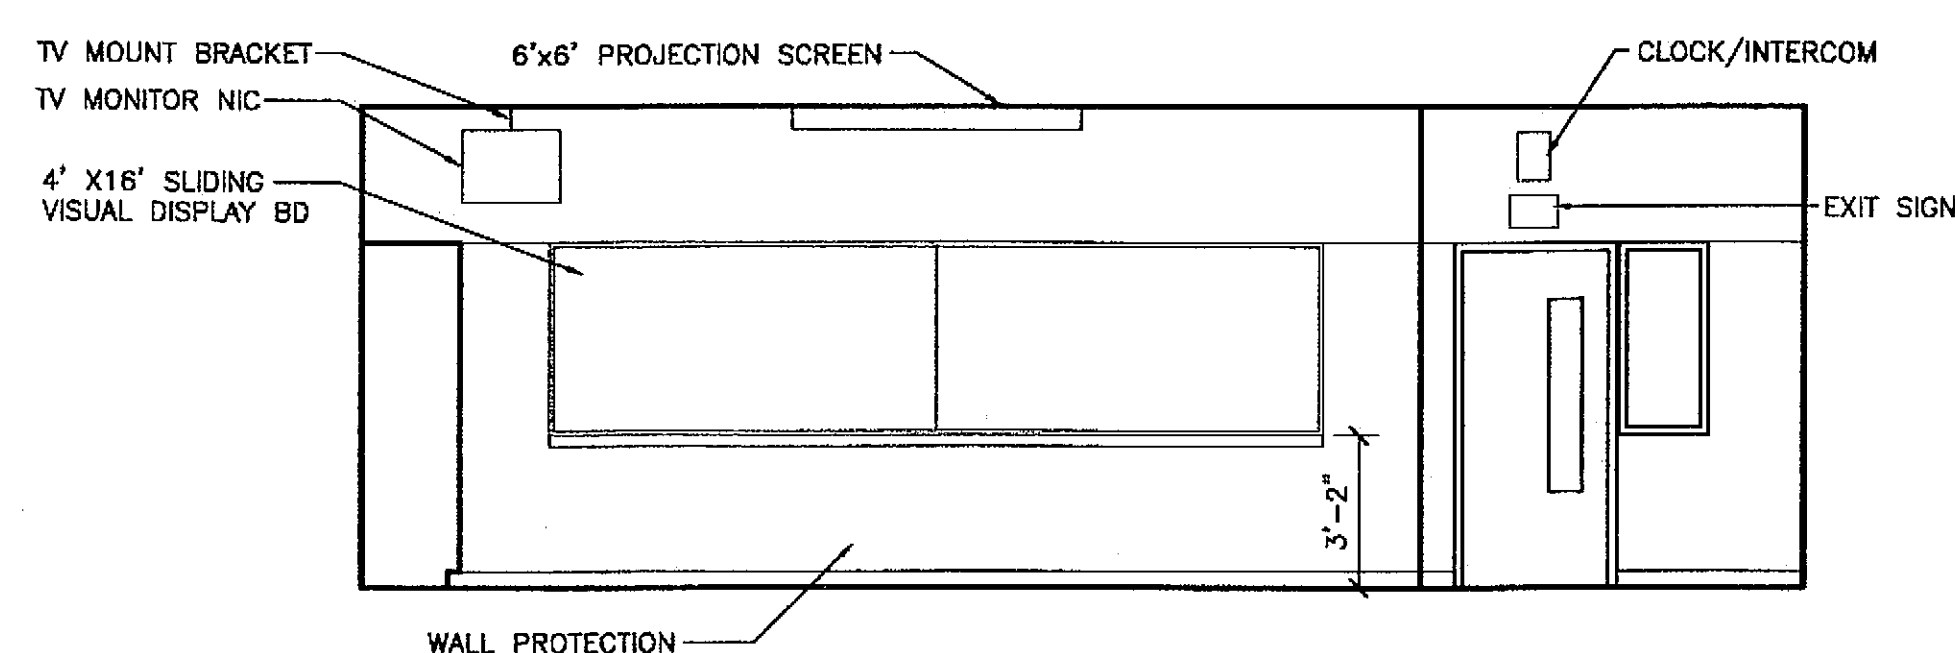


3 ROOM 141 SCIENCE

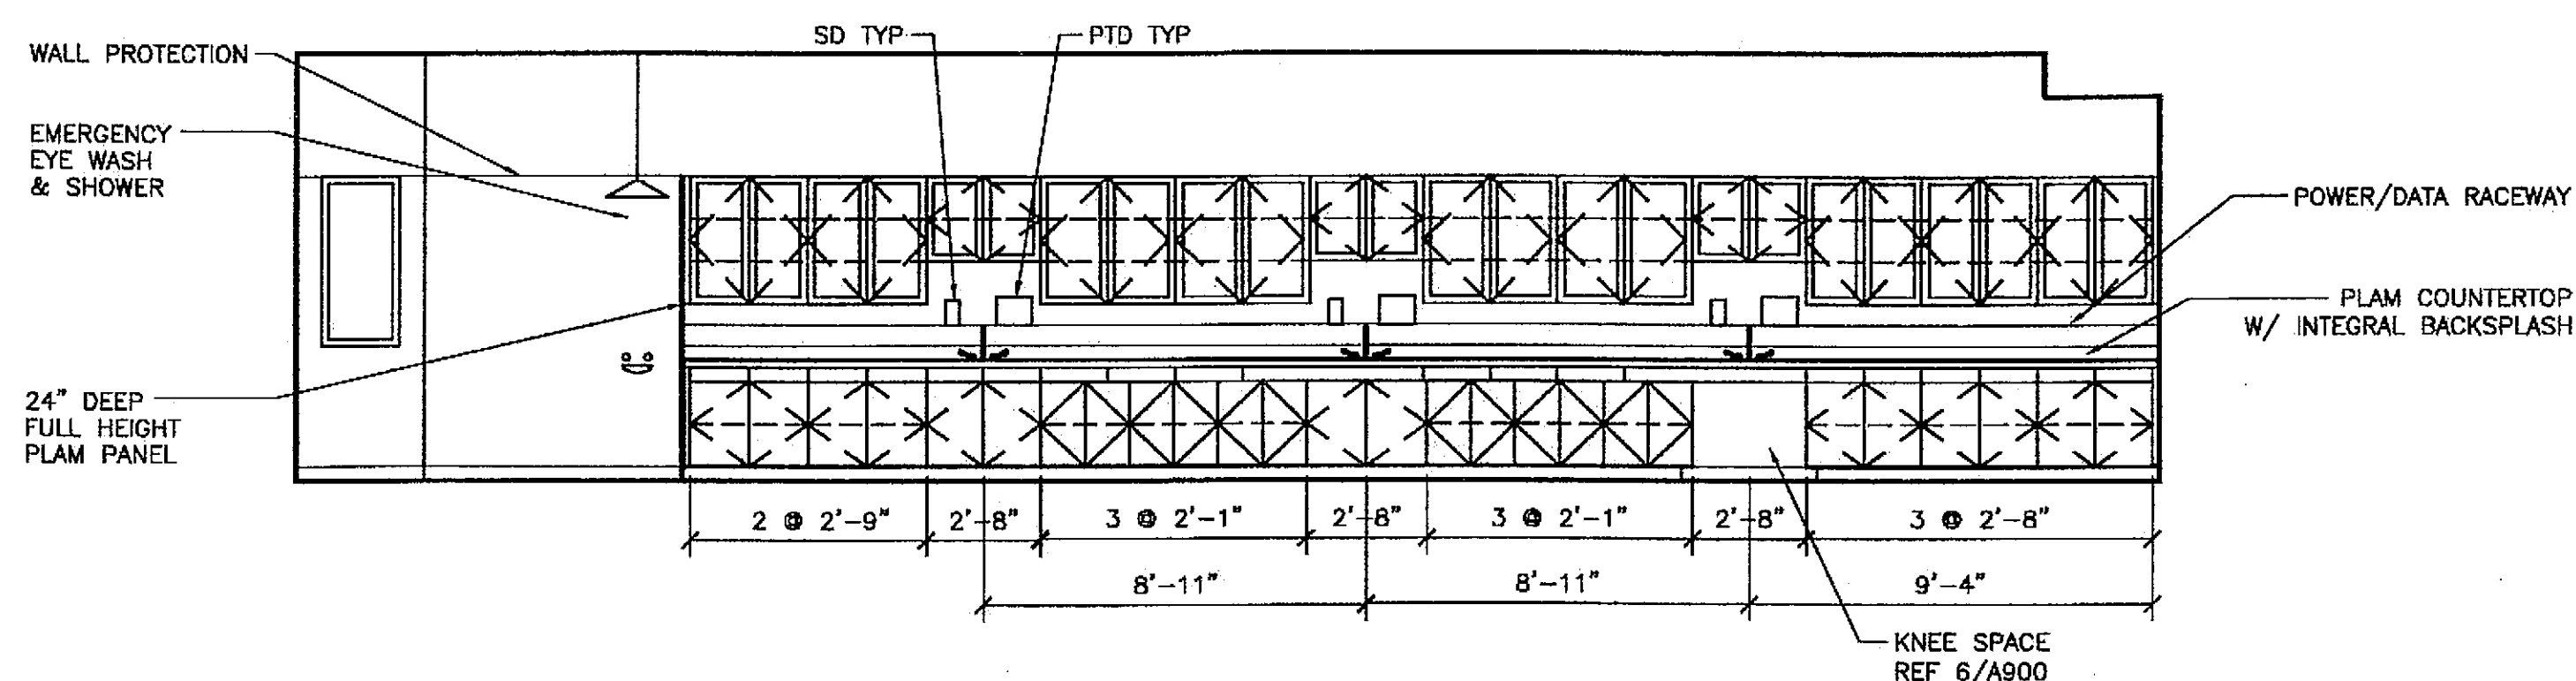


4 ROOM 141 SCIENCE

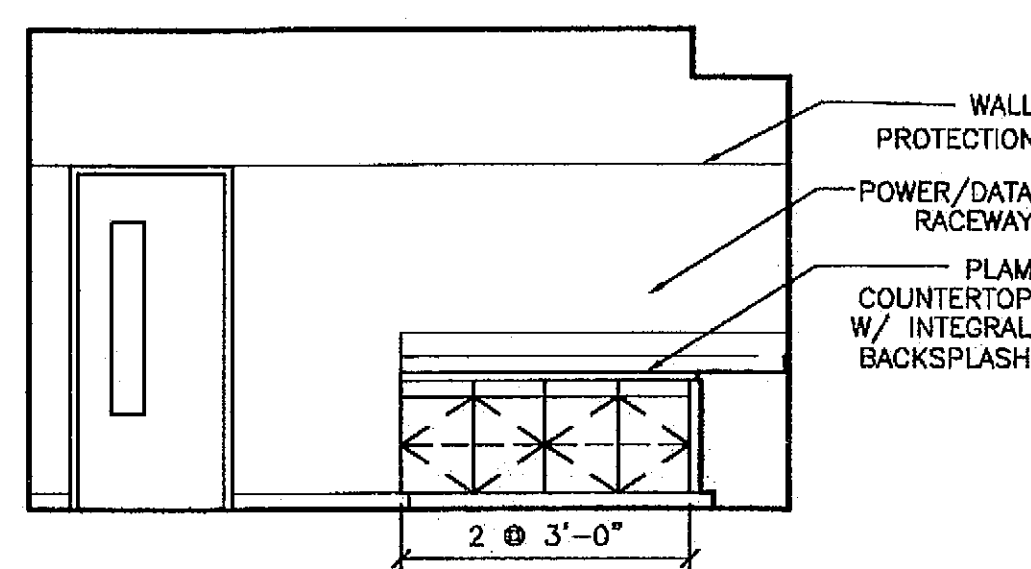


5 ROOM 144 STORAGE

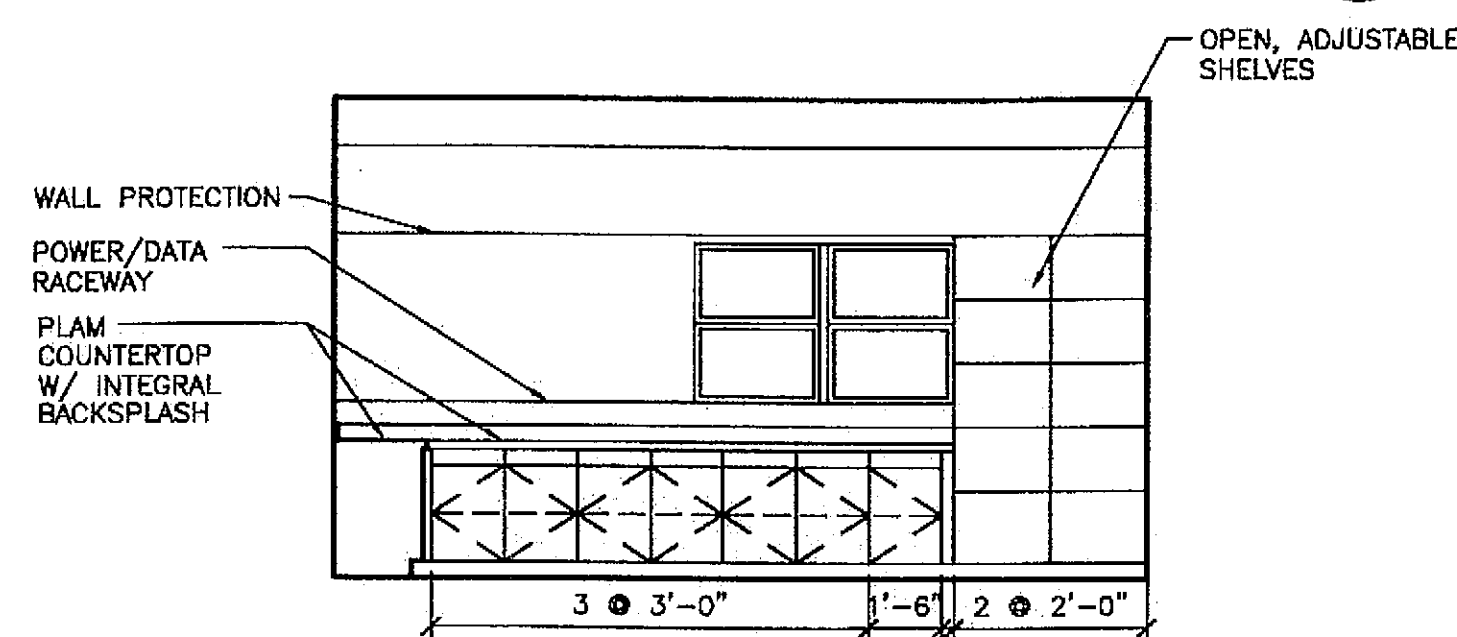


ROOM 144 STORAGE

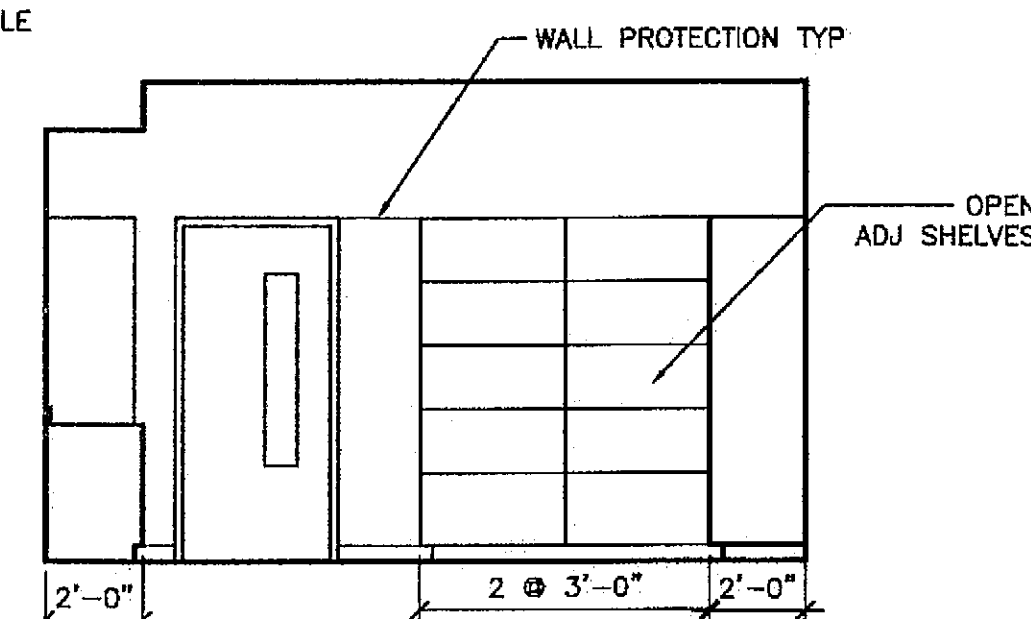

7 ROOM 144 STORAGE

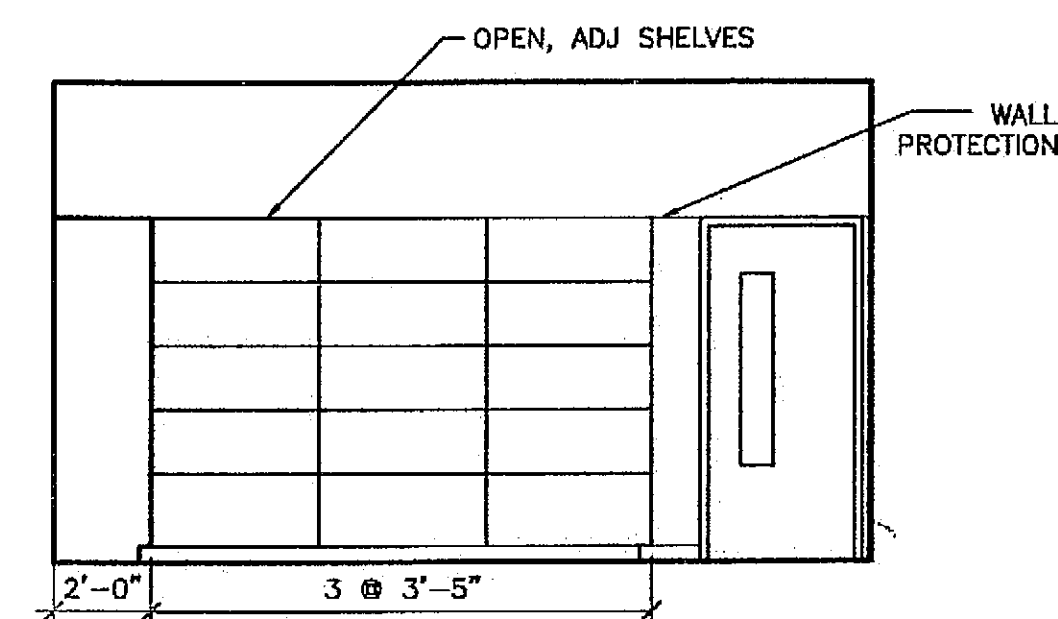


8 ROOM 144 STORAGE

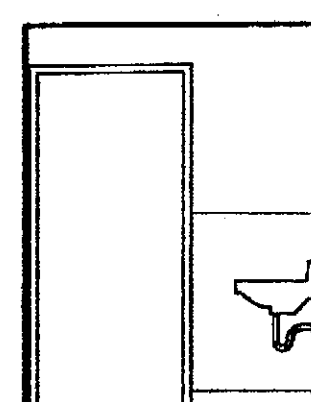


9 ROOM 149

SCALE: 0 2' 4' 8'

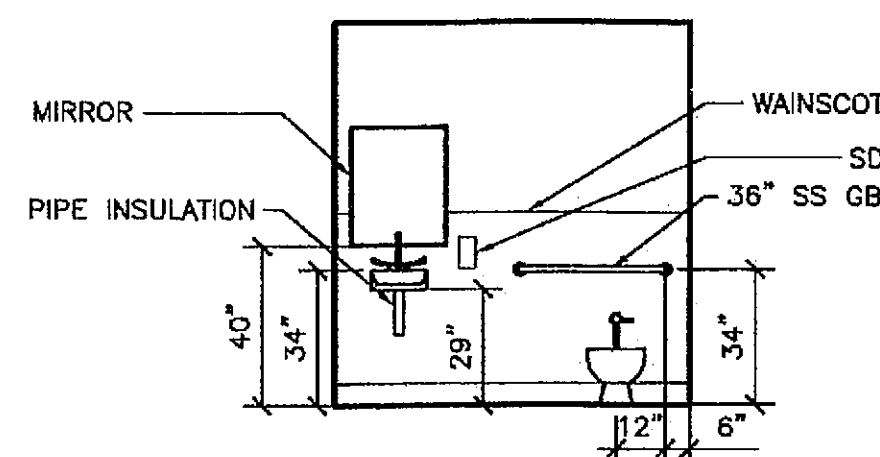


10 ROOM 149

SCALE: 0 2' 4' 8'

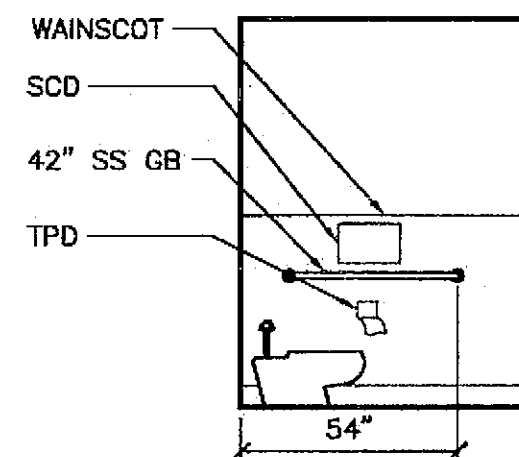


11 ROOM 149

SCALE: 0 2' 4' 8'

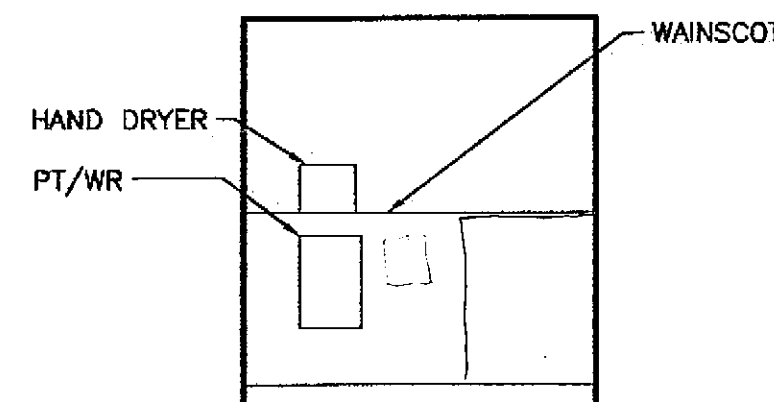

12 ROOM 149

SCALE: 0 2' 4' 8'

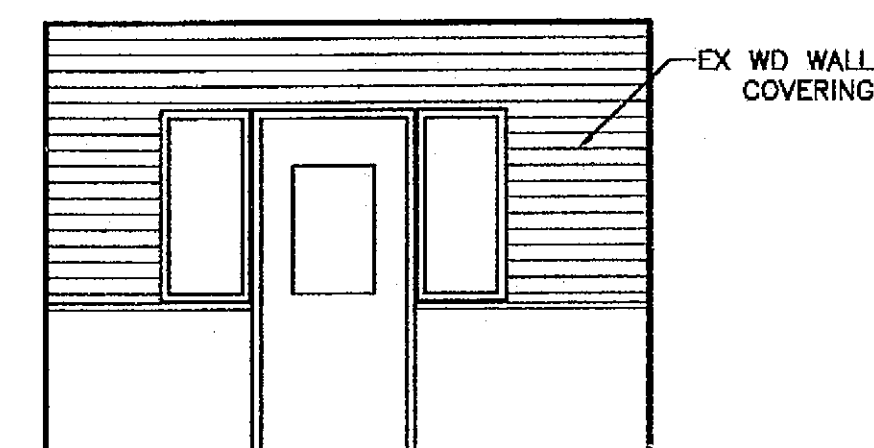

12 HALL 124

SCALE: 0 2' 4' 8'

PATH:
G:_Projects\0411\Cad\CD\1330\Arch\
A502.dwg
Tue, 14/Dec/04 02:32PM
TAG: Layout1


ADDENDUM NUMBER

ATTACHMENT NUMBER

RECORD OF REVISION

No.	DATE	DESCRIPTION

CHECKED BY:

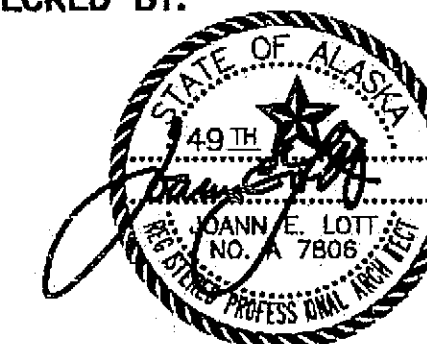

DESIGNED BY: JENSEN YORBA LOTT

DRAWN BY:

STATE OF ALASKA
DEPARTMENT OF TRANSPORTATION
& PUBLIC FACILITIES
STATEWIDE DESIGN & ENGINEERING
SERVICES DIVISION

MT EDGE CUMBER
HIGH SCHOOL
BUILDING 1330
ACADEMIC
EXPANSION

SHEET A502

PROJECT DESIGNATION NUMBER

67751C

STATE	YEAR
-------	------

ALASKA	2004
--------	------

FEET NUMBER	TOTAL SHEET
-------------	-------------

18	79
----	----

Project As-Built Drawings have been reviewed by the Project Engineer and represent to the best of my knowledge, the project as constructed.


Proj. Eng. [Signature] Date 7-07

ADDENDUM NUMBER


ATTACHMENT NUMBER

RECORD OF REVISIONS


No.	DATE	DESCRIPTION

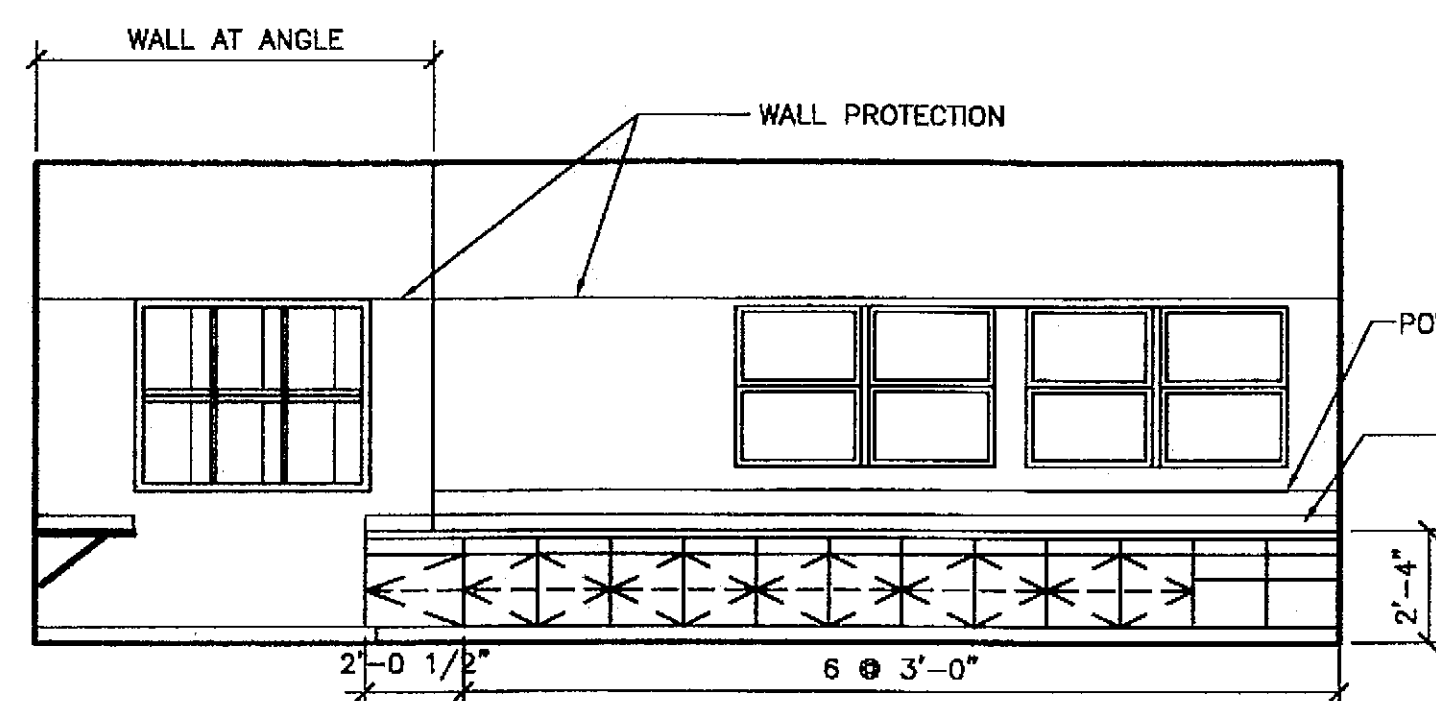





1 147 CLASSROOM
SCALE: 0 2' 4' 8'

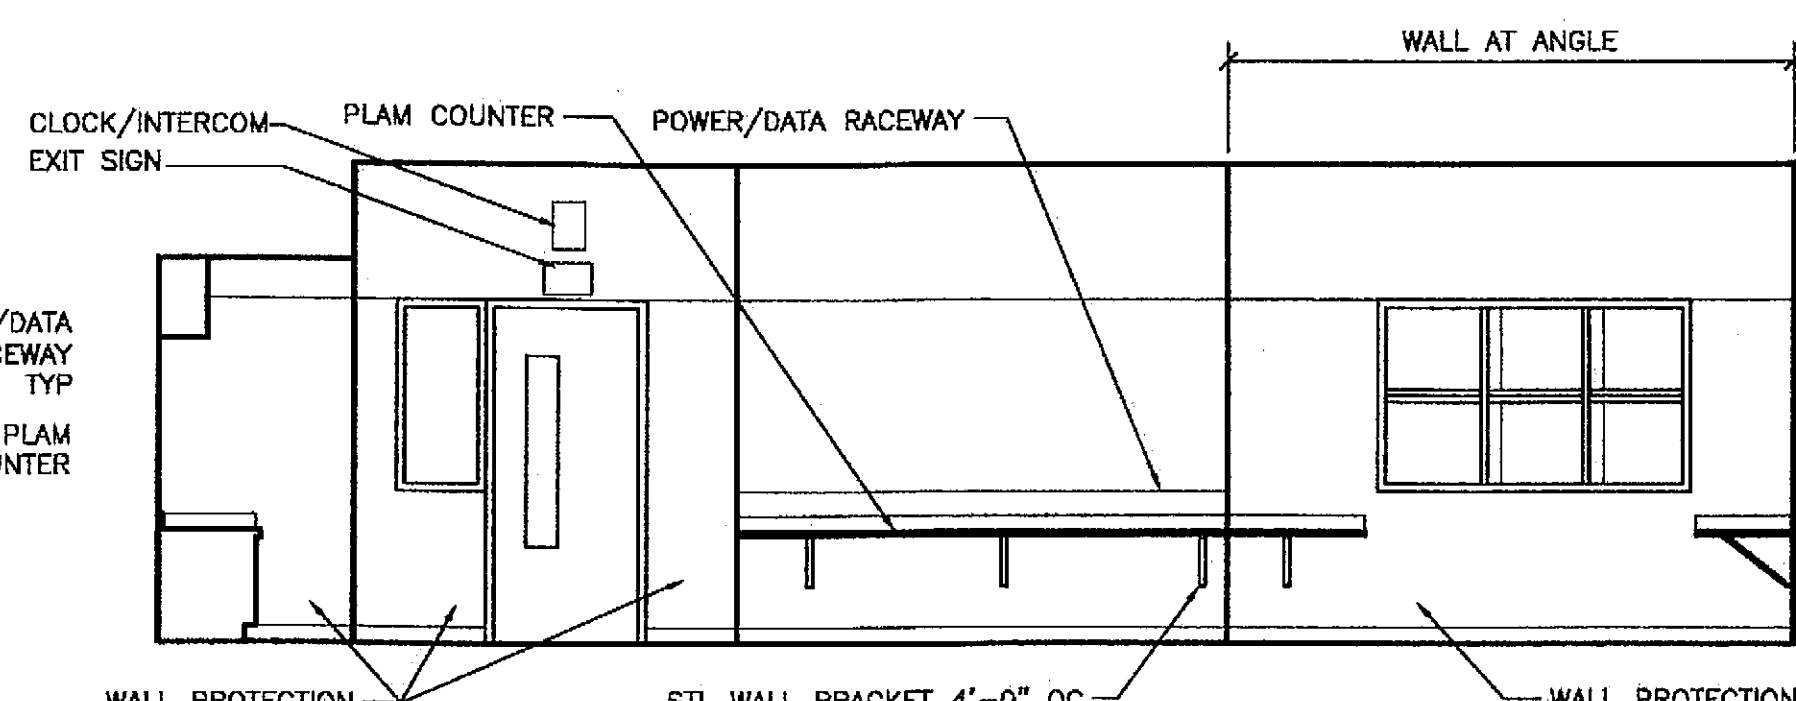


2 147 CLASSROOM
SCALE: 0 2' 4' 8'

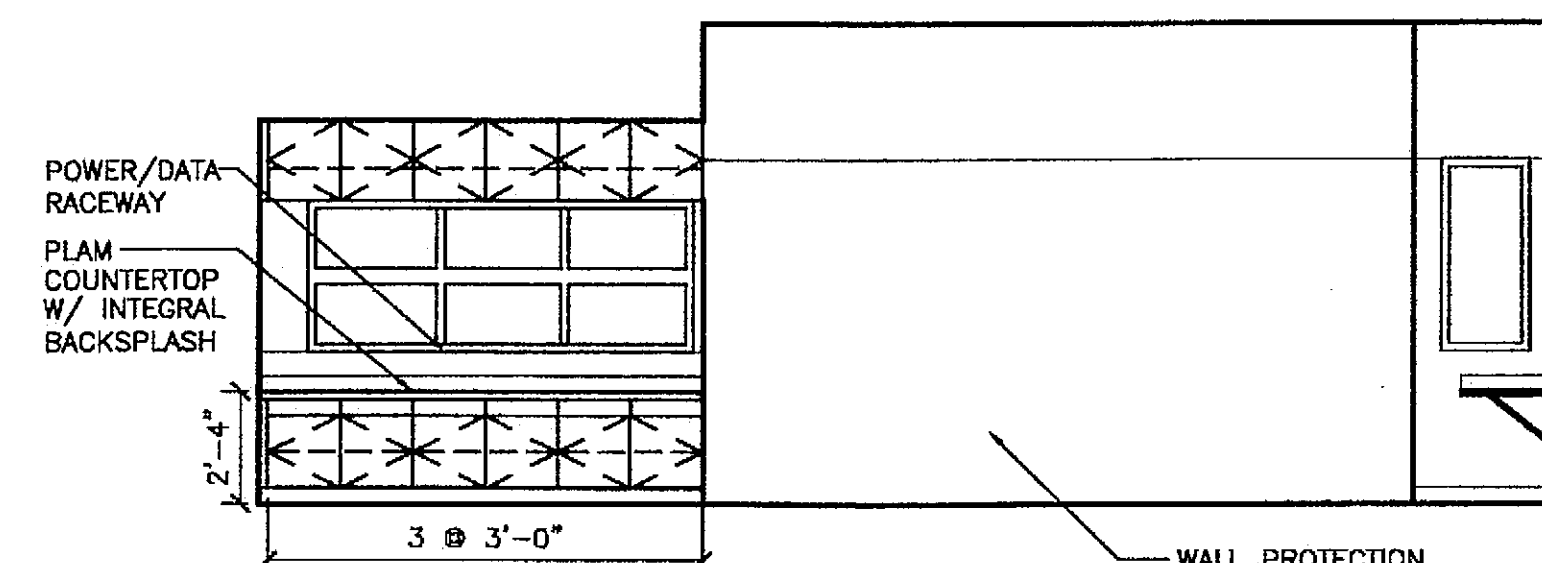


3 147 CLASSROOM
SEE 9/A504 FOR VIEW W/ALTERNATE 1
SCALE: 0 2' 4' 8'

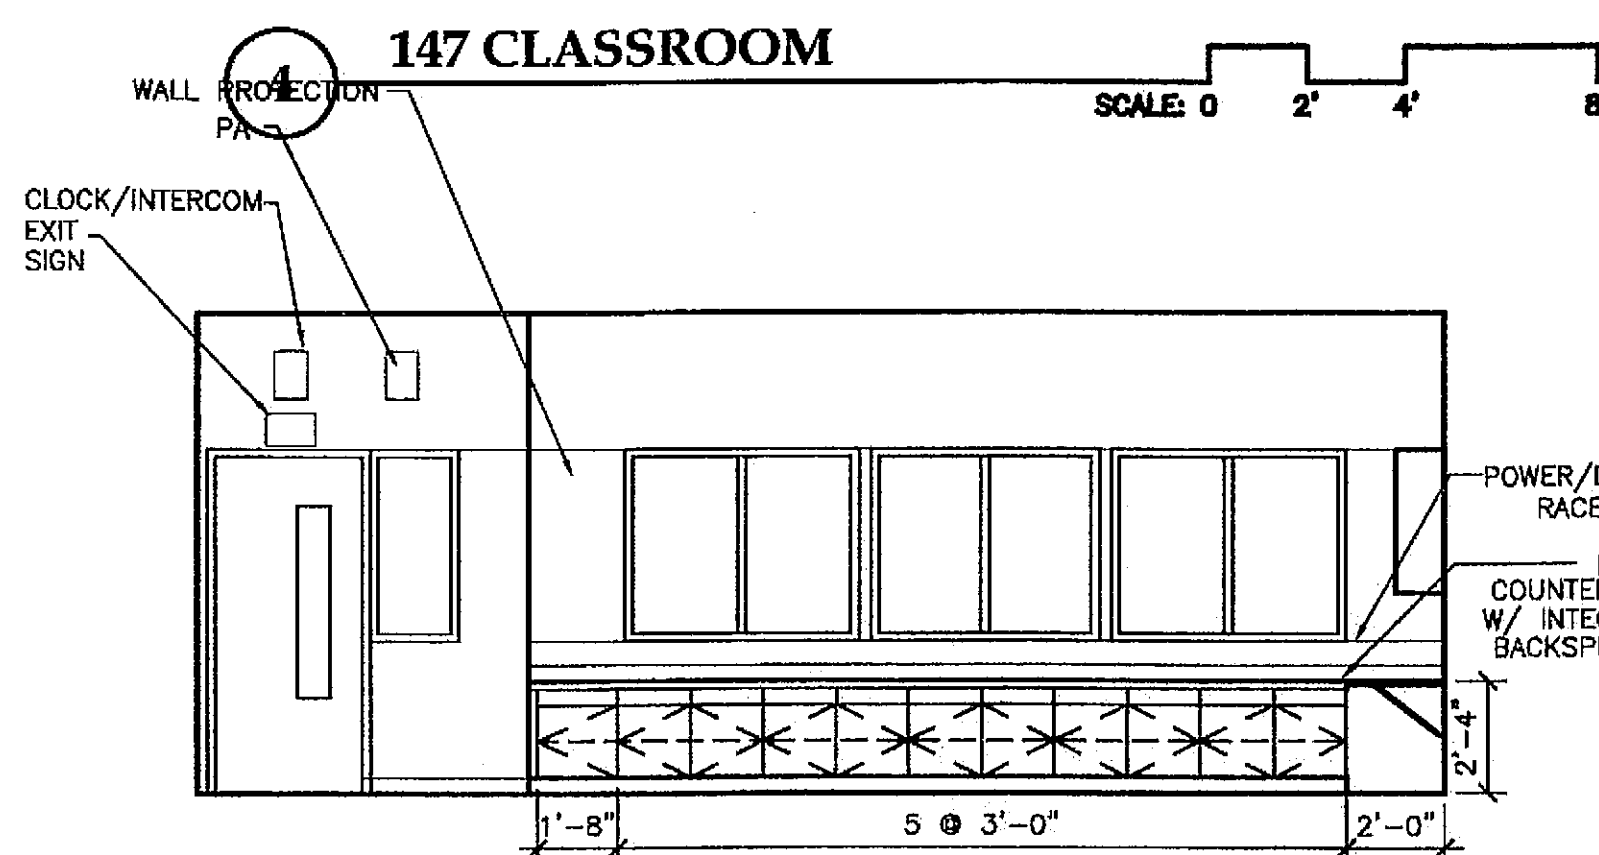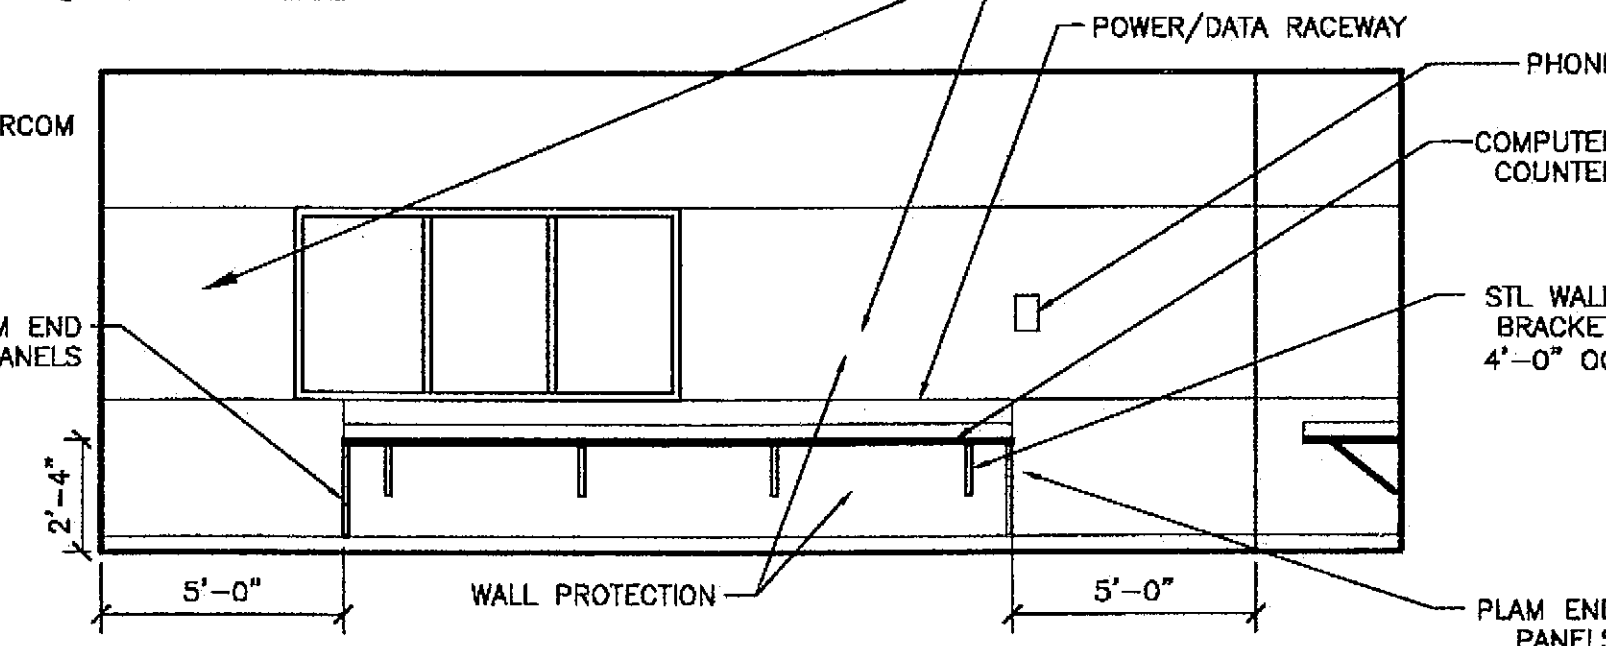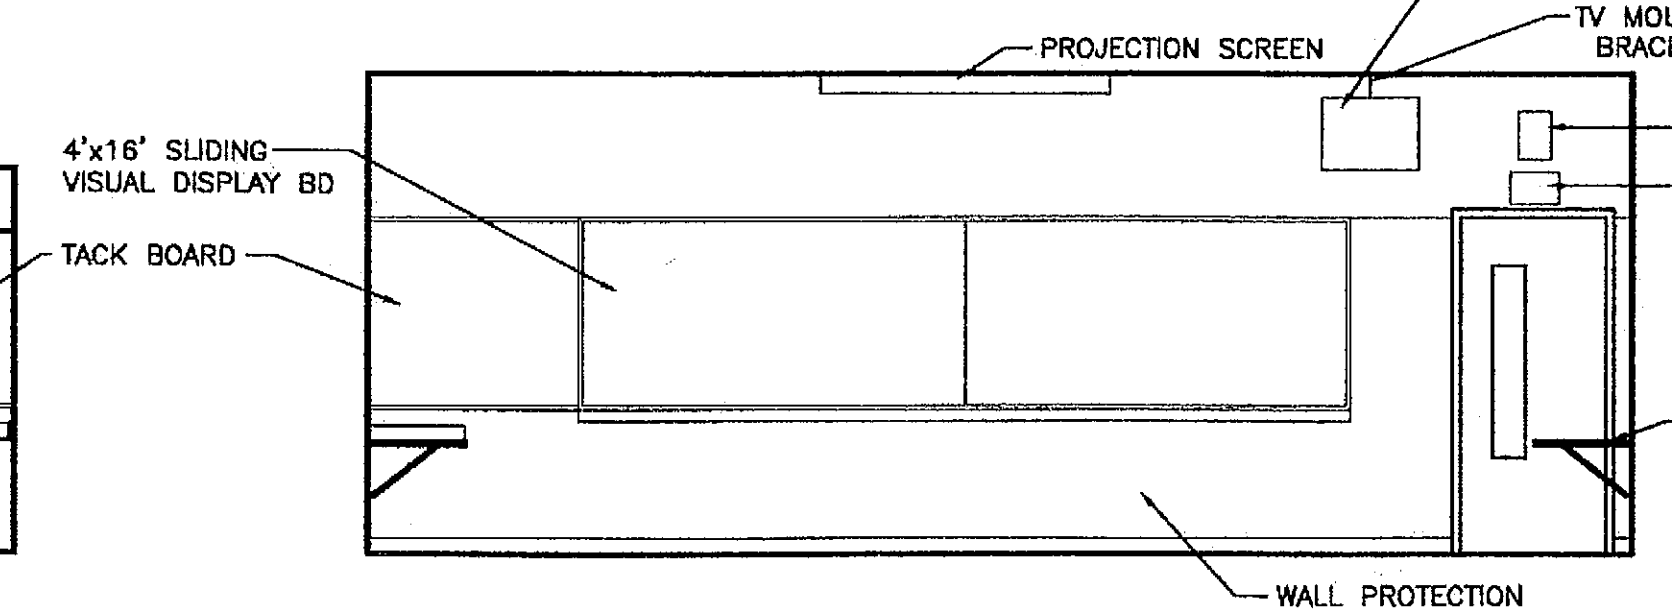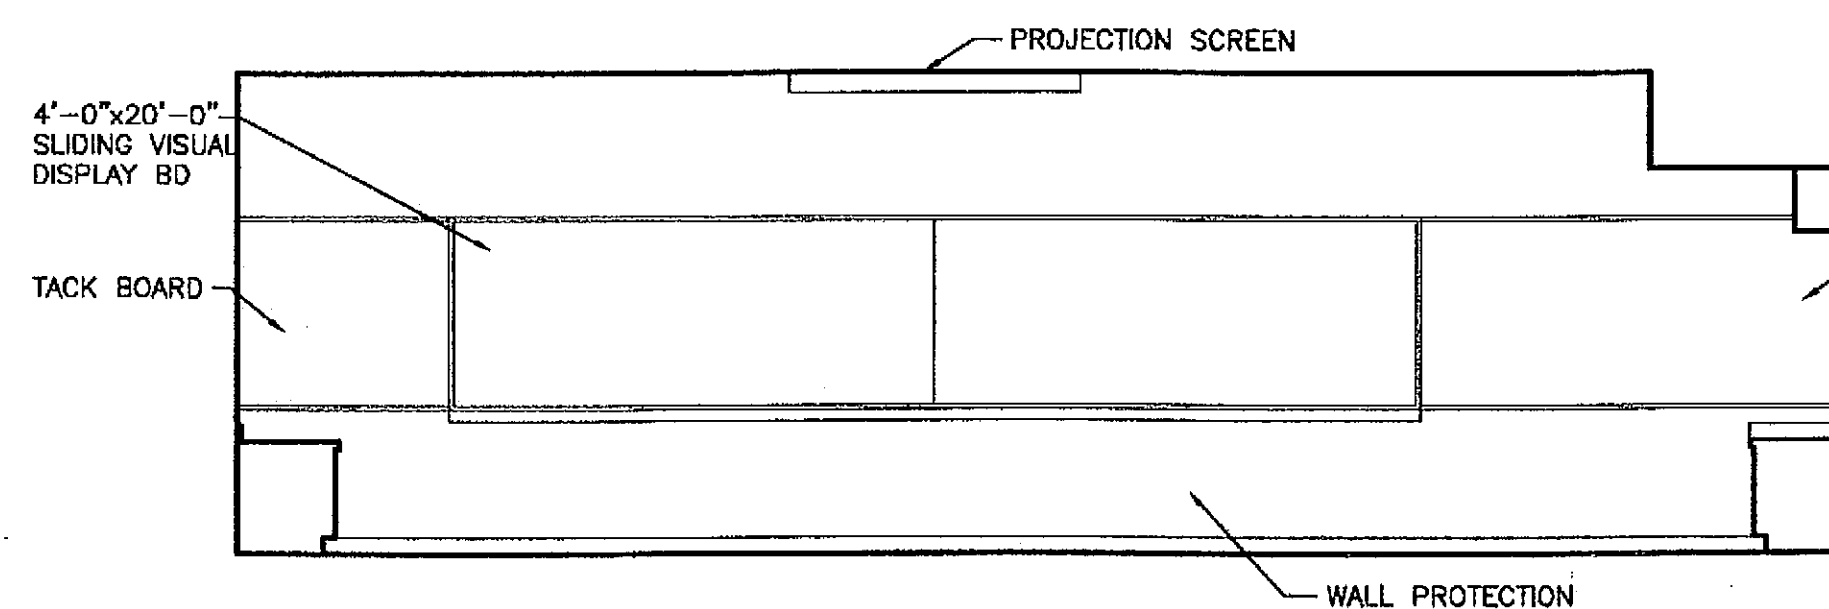


7 147 CLASSROOM
SCALE: 0 2' 4' 8'

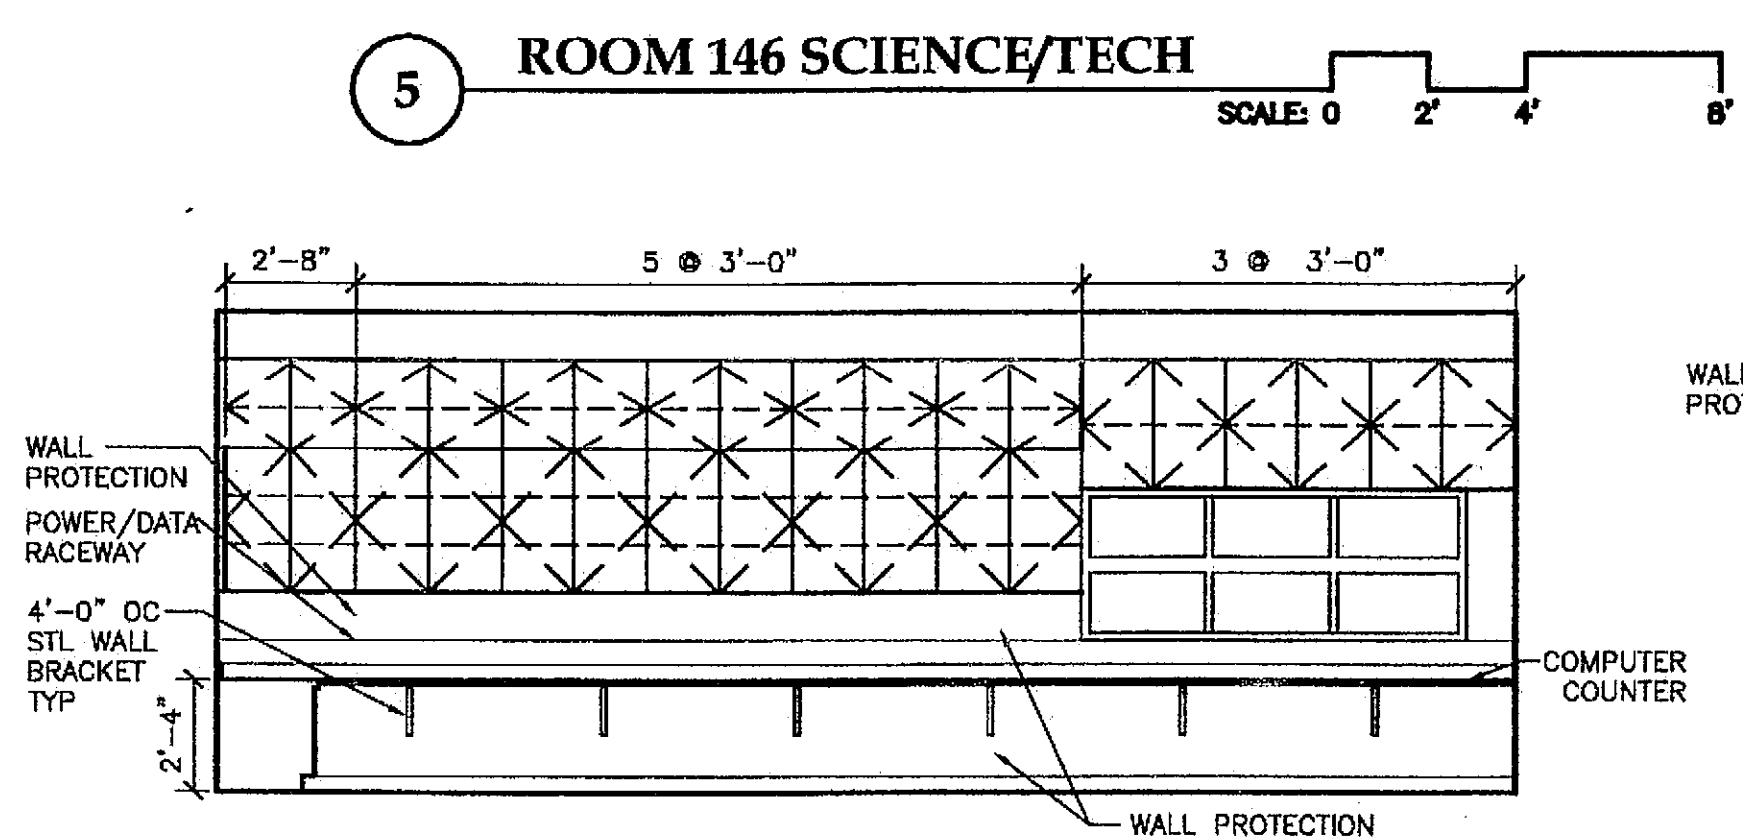


5 ROOM 146 SCIENCE/TECH
SCALE: 0 2' 4' 8'

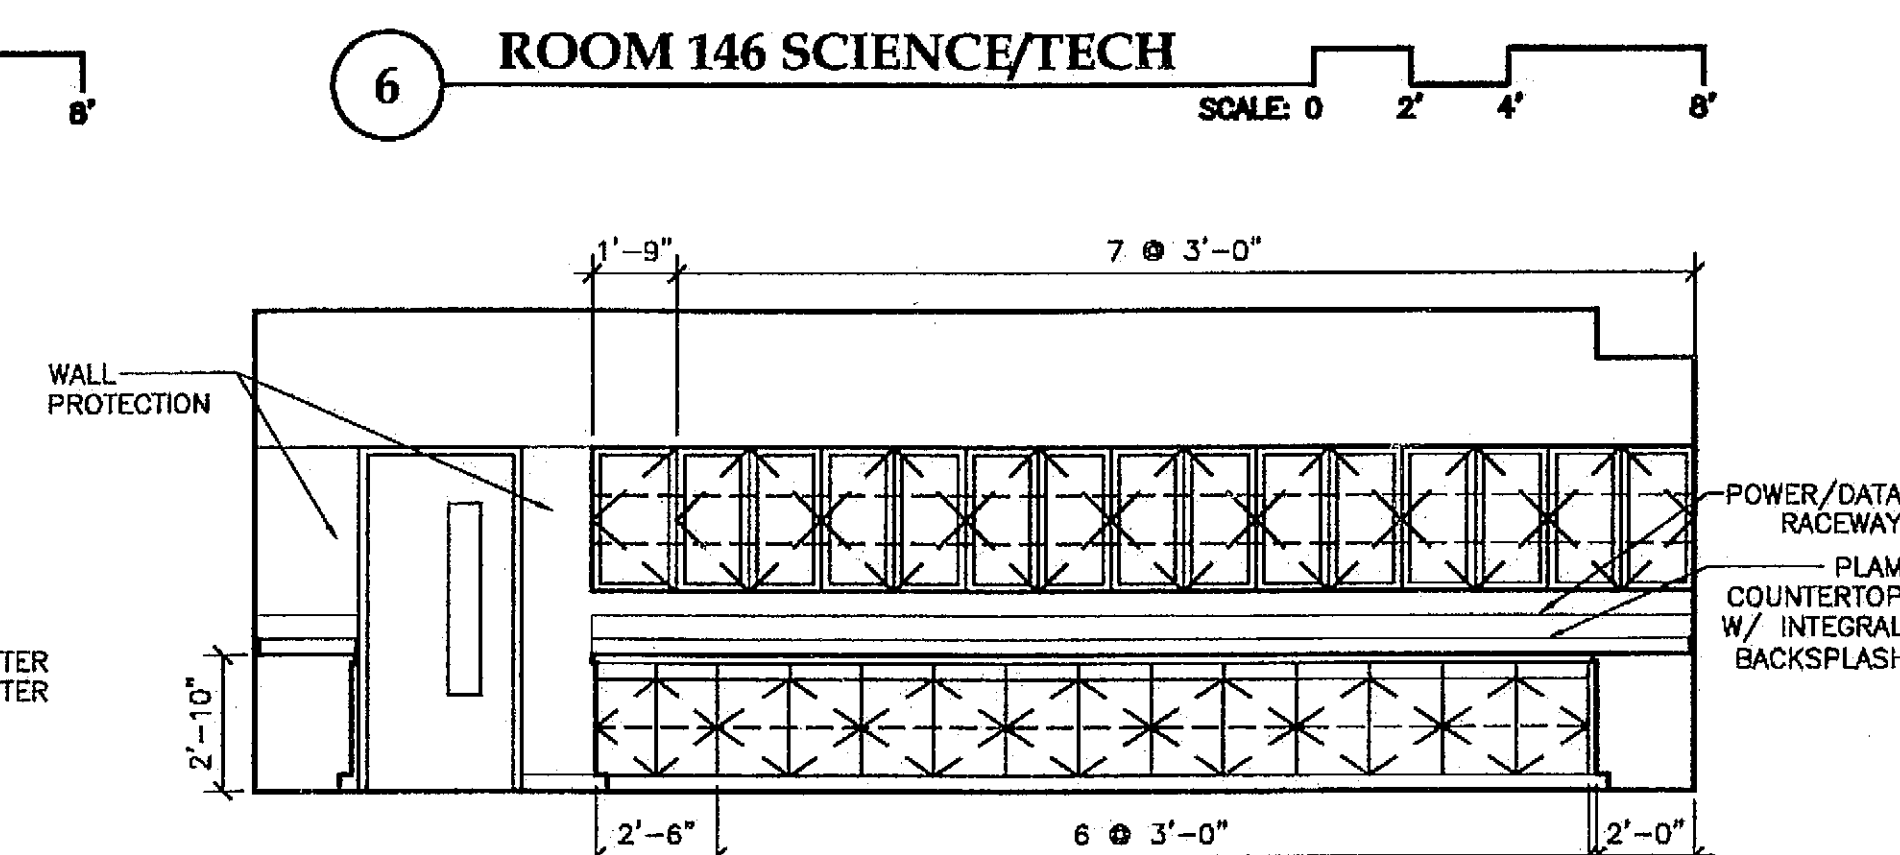


6 ROOM 146 SCIENCE/TECH
SCALE: 0 2' 4' 8'

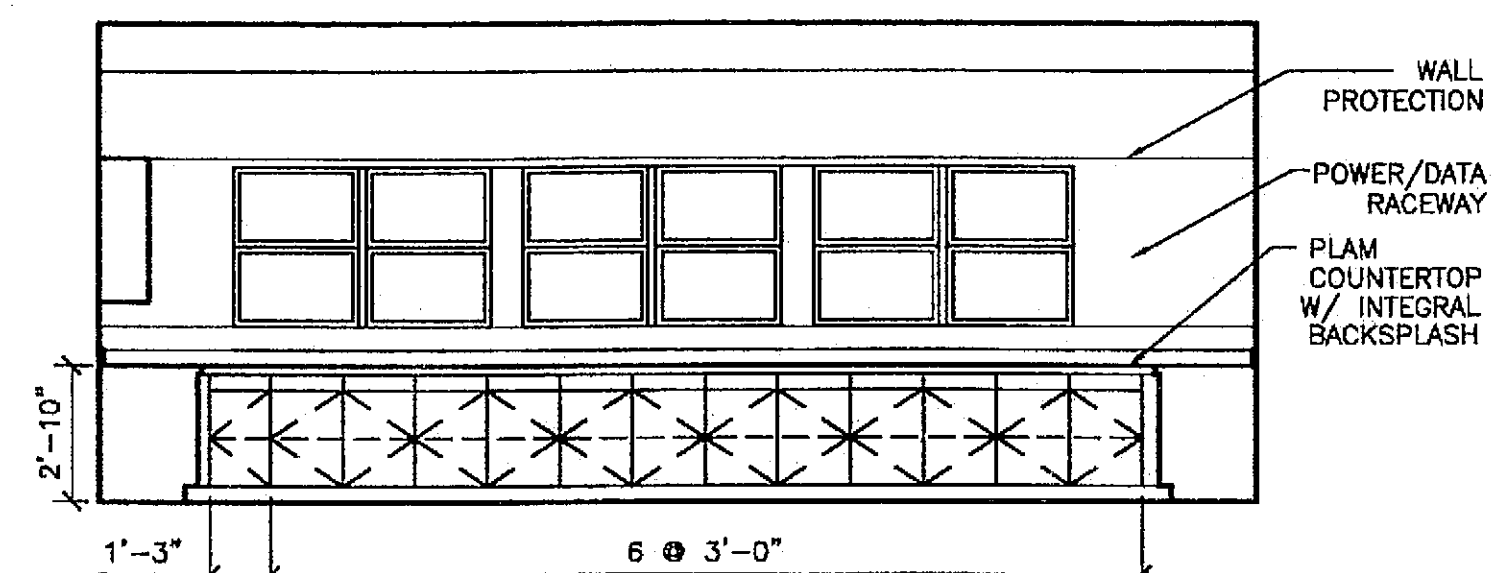

10 ROOM 145 PREP ROOM/OFFICE
SCALE: 0 2' 4' 8'

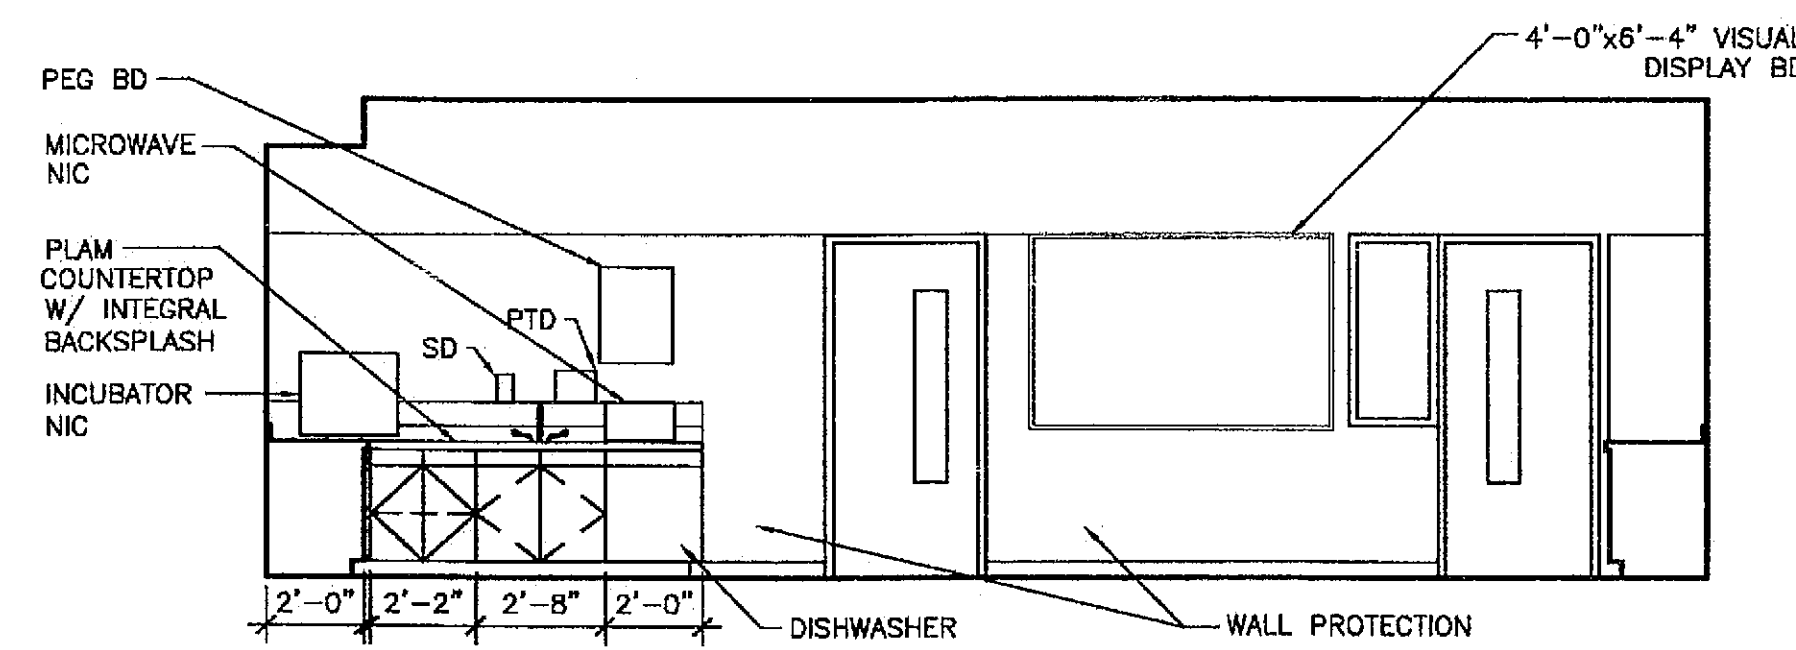


11 ROOM 145 PREP ROOM/OFFICE
SCALE: 0 2' 4' 8'

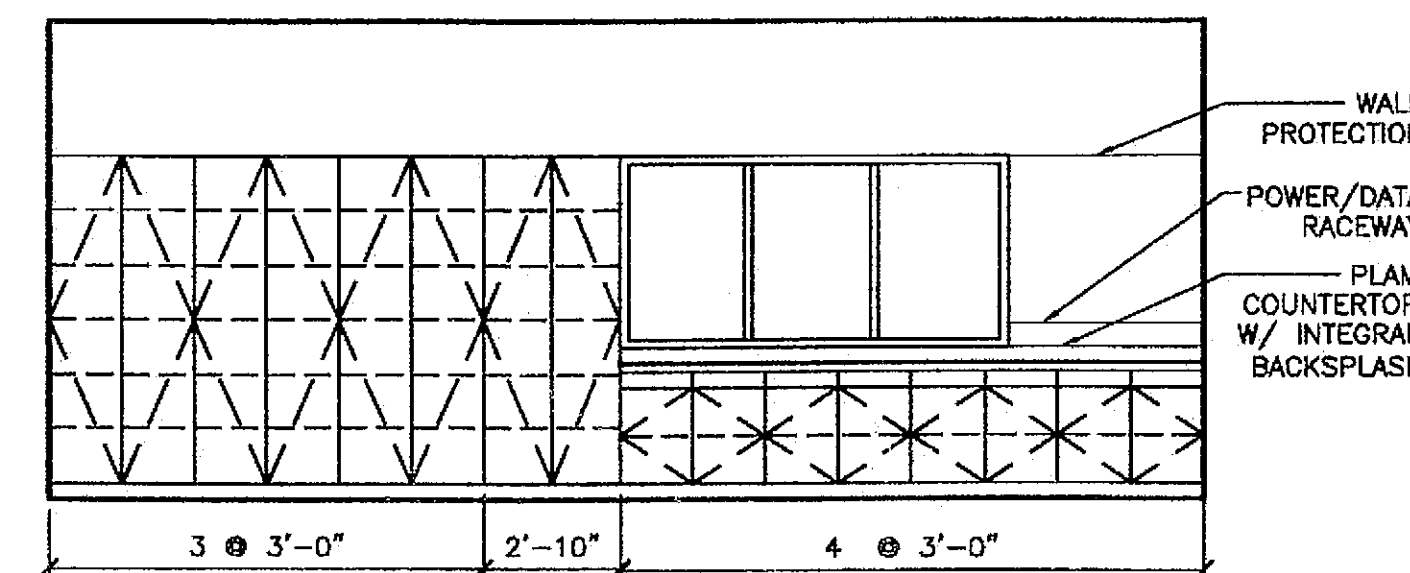

9 ROOM 145 PREP ROOM/OFFICE
SCALE: 0 2' 4' 8'

CHECKED BY:

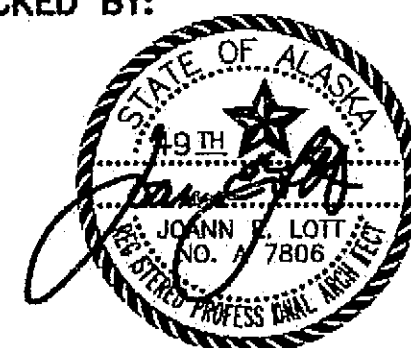

DESIGNED BY: JENSEN YORBA LOTT

DRAWN BY:

STATE OF ALASKA
DEPARTMENT OF TRANSPORTATION
& PUBLIC FACILITIES
STATEWIDE DESIGN & ENGINEERING
SERVICES DIVISION
MT EDGE CUMBE
HIGH SCHOOL
BUILDING 1330
ACADEMIC
EXPANSION


SHEET A503

PROJECT DESIGNATION NUMBER


67751C

STATE	YEAR
ALASKA	2004
SHEET NUMBER	TOTAL SHEETS
19	79


Project As-Built Drawings have been
reviewed by the Project Engineer and
represent to the best of my knowledge, the
project as constructed.
Proj. Eng. *M. Lott* Date 7-07

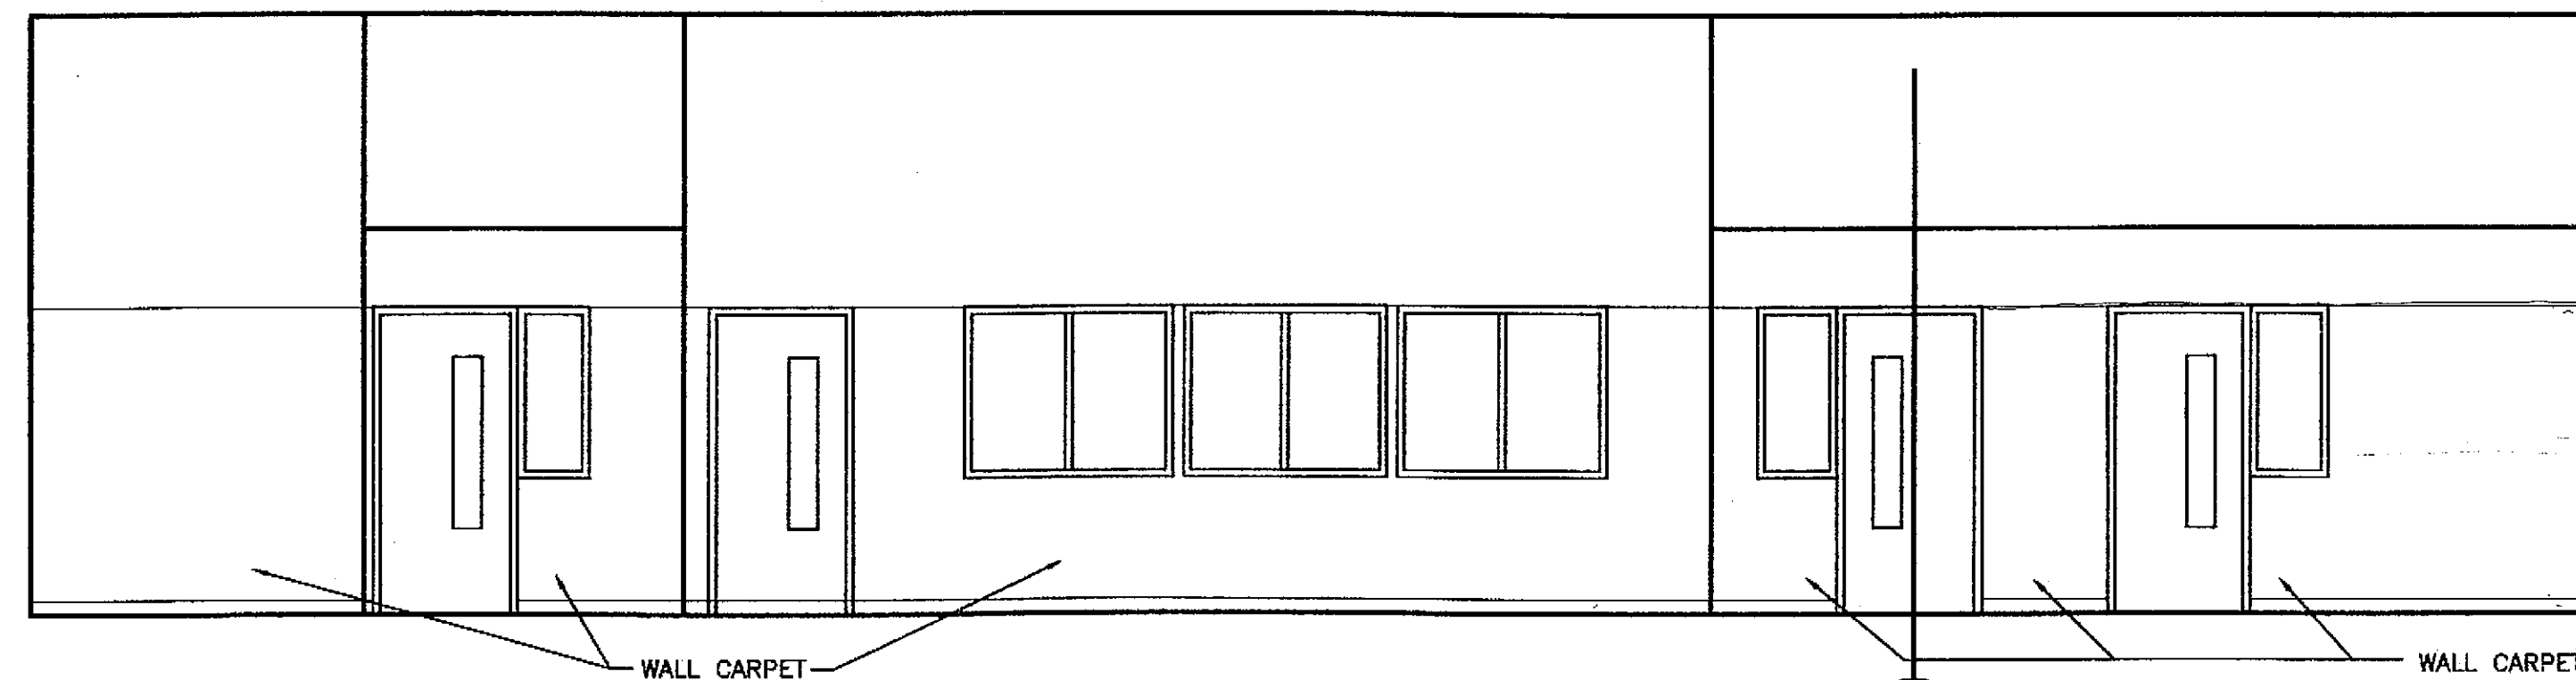


1 140 CENTER HALL SCALE: 0 2' 4' 8'

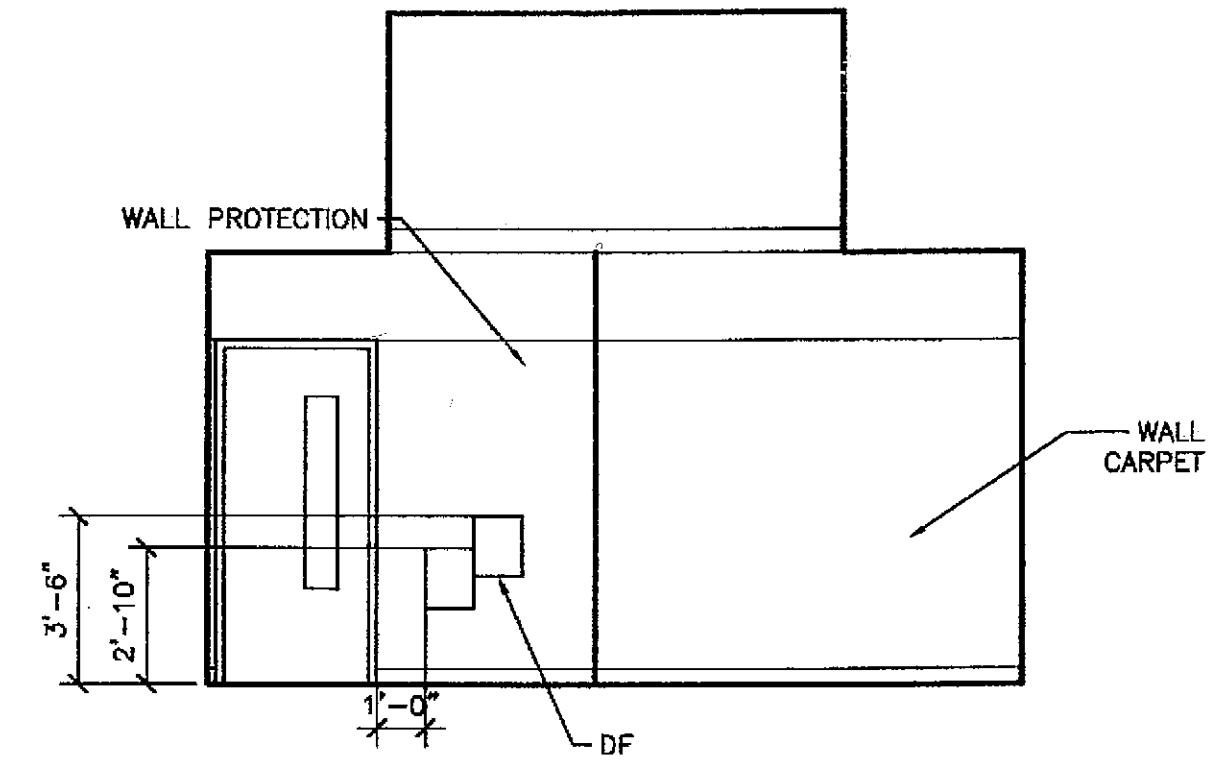


2 140 CENTER HALL SCALE: 0 2' 4' 8'

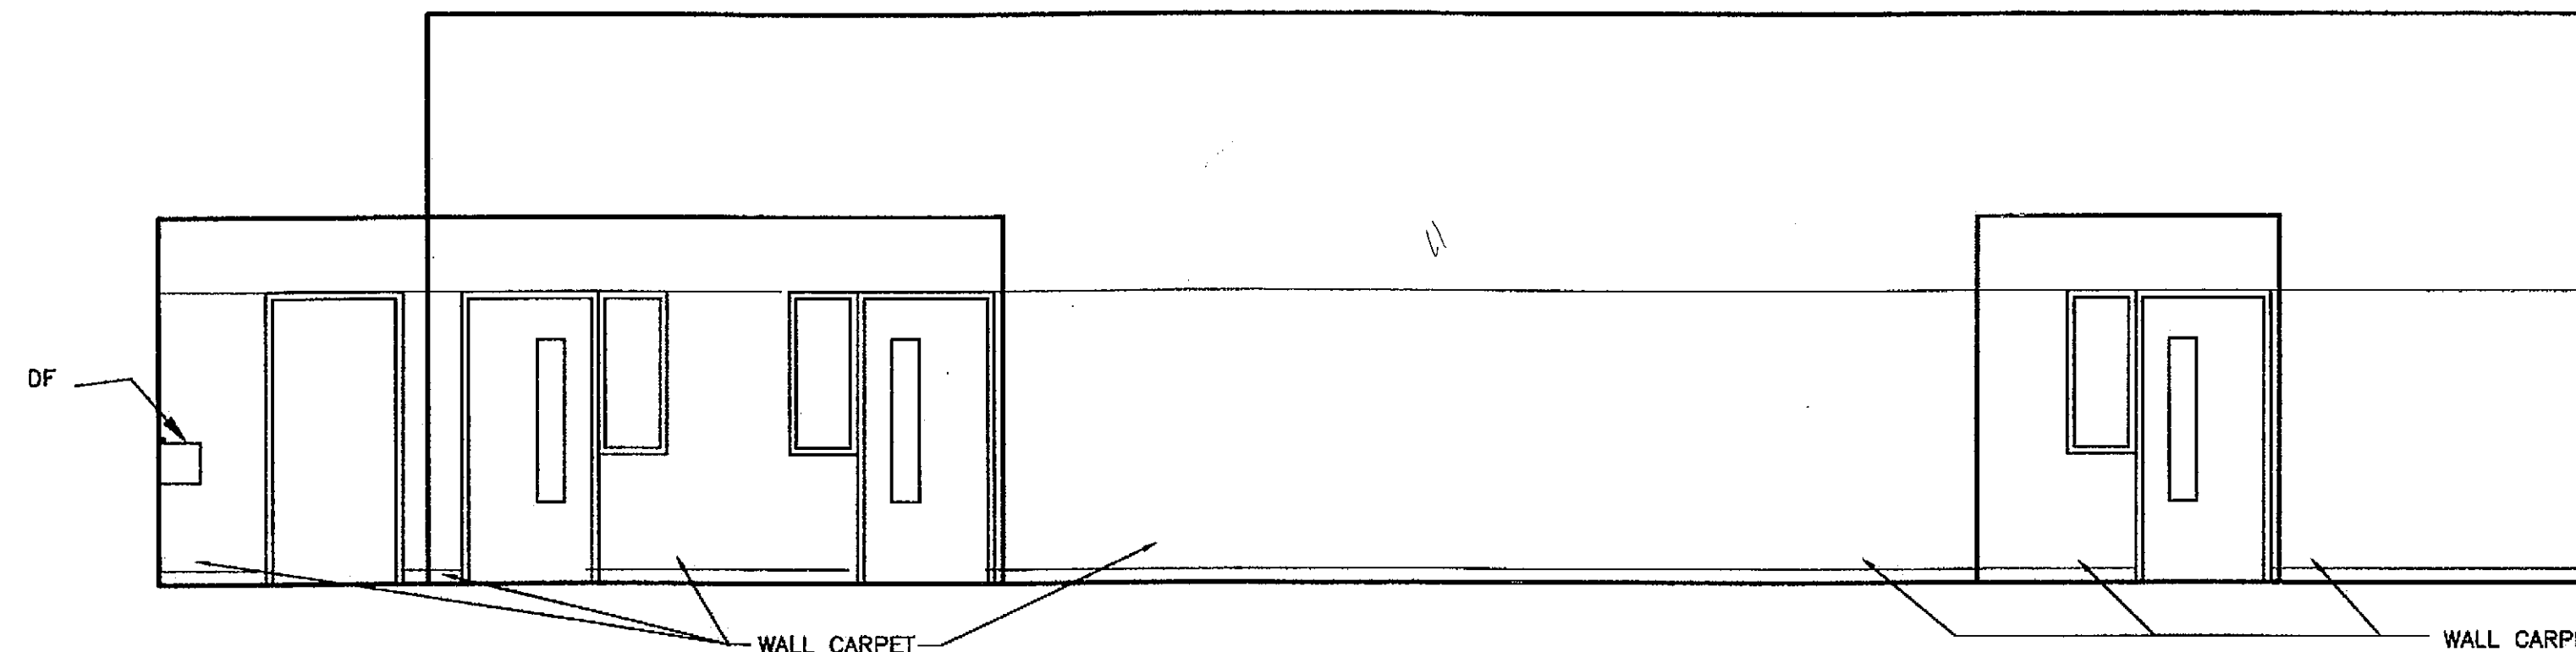


3 140 CENTER HALL SCALE: 0 2' 4' 8'

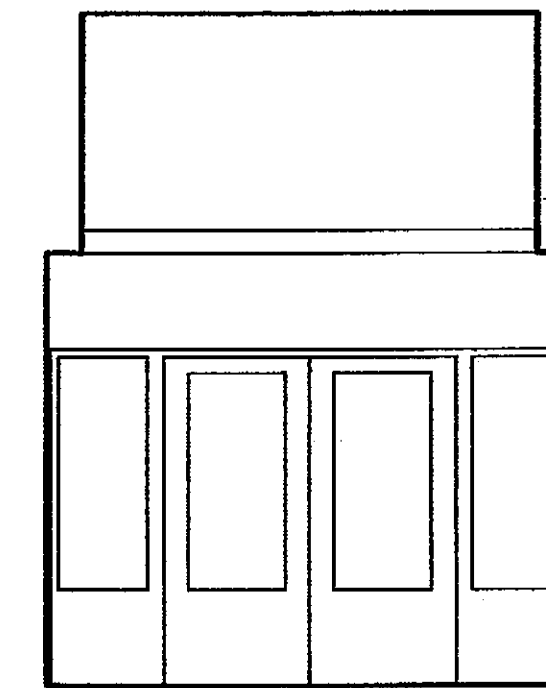


4 140 CENTER HALL SCALE: 0 2' 4' 8'

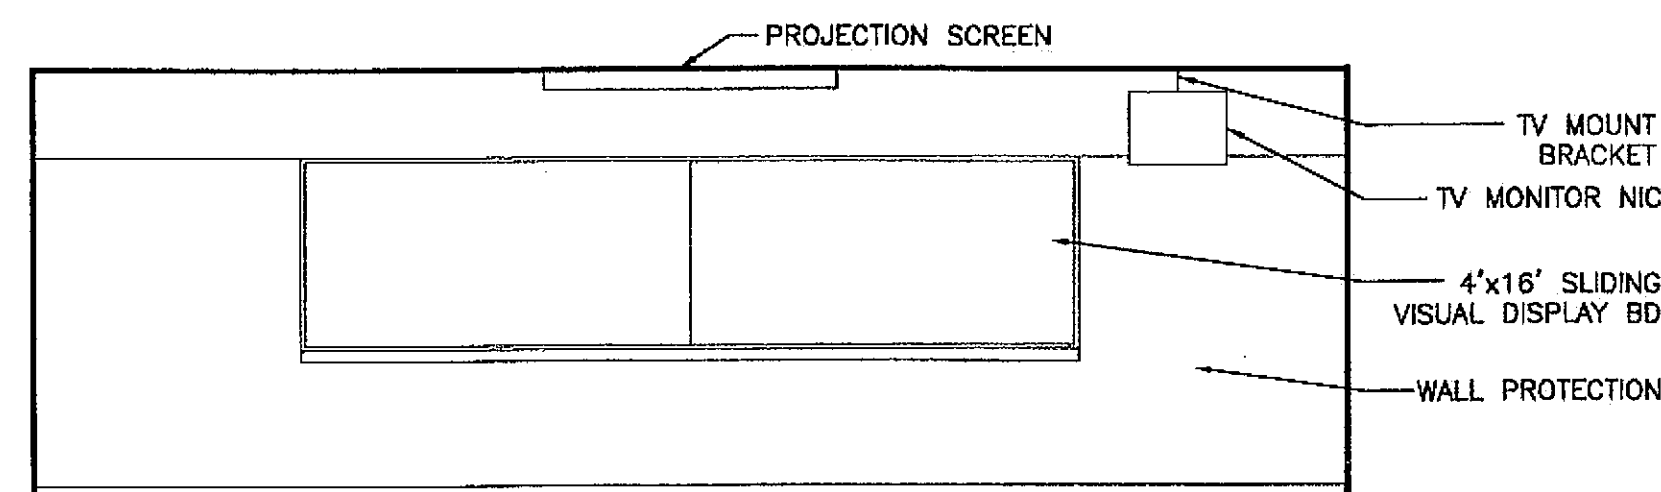


5 128 CLASSROOM SCALE: 0 2' 4' 8'

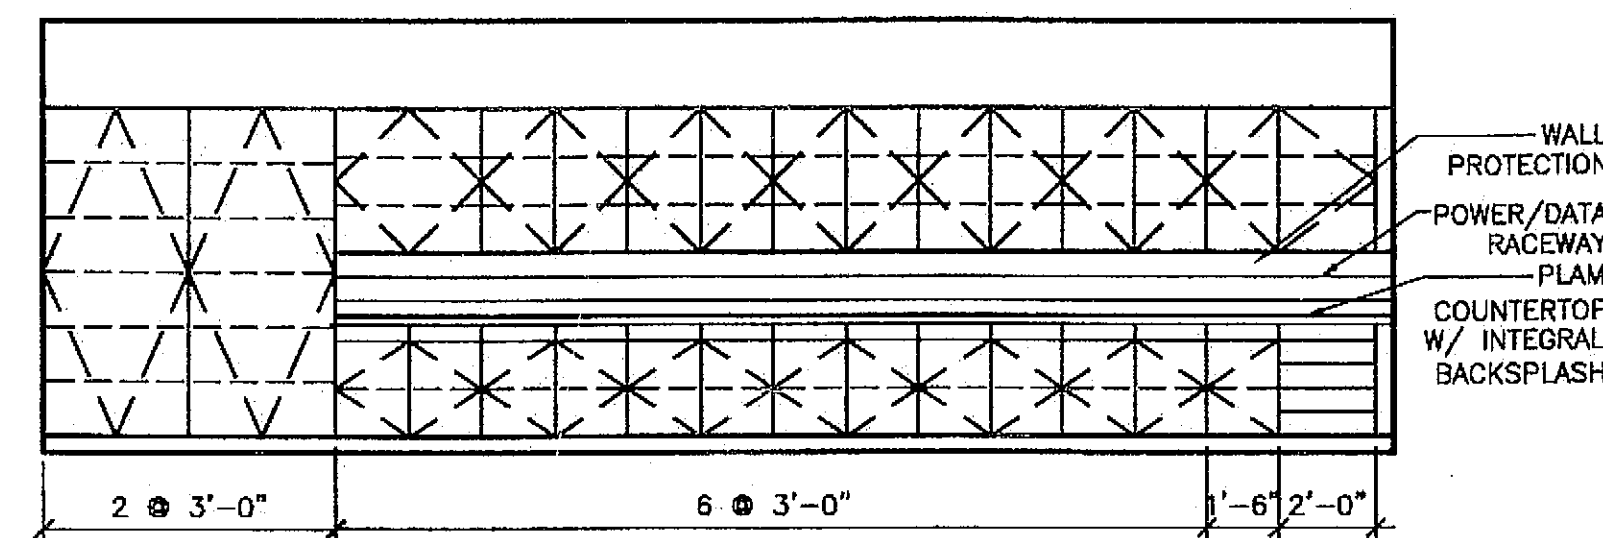


6 128 CLASSROOM SCALE: 0 2' 4' 8'

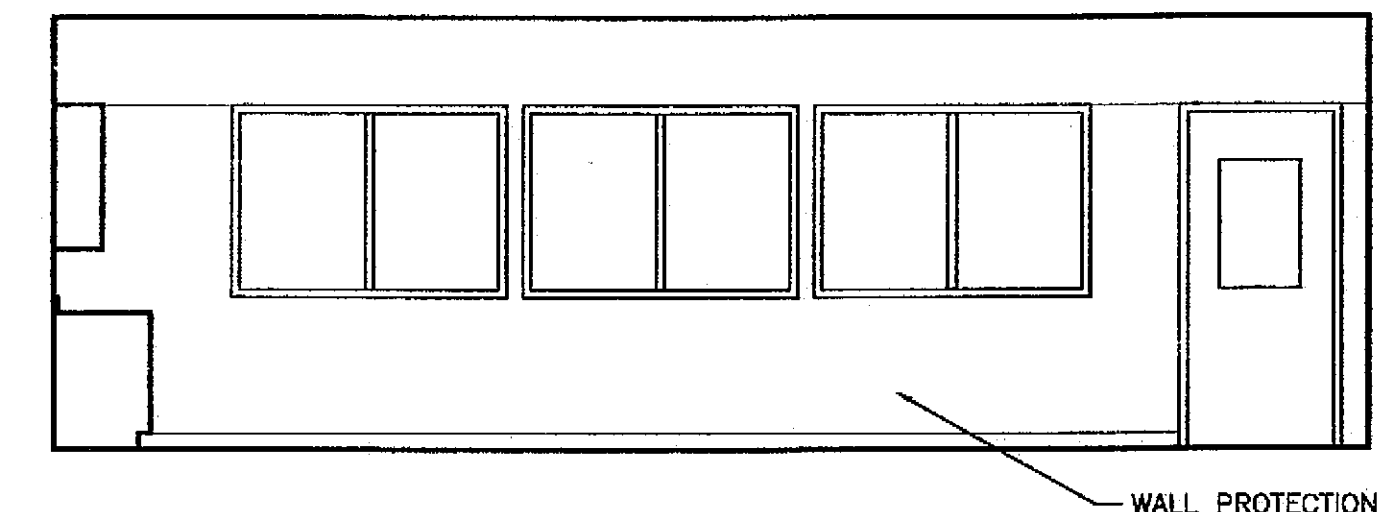

7 128 CLASSROOM SCALE: 0 2' 4' 8'

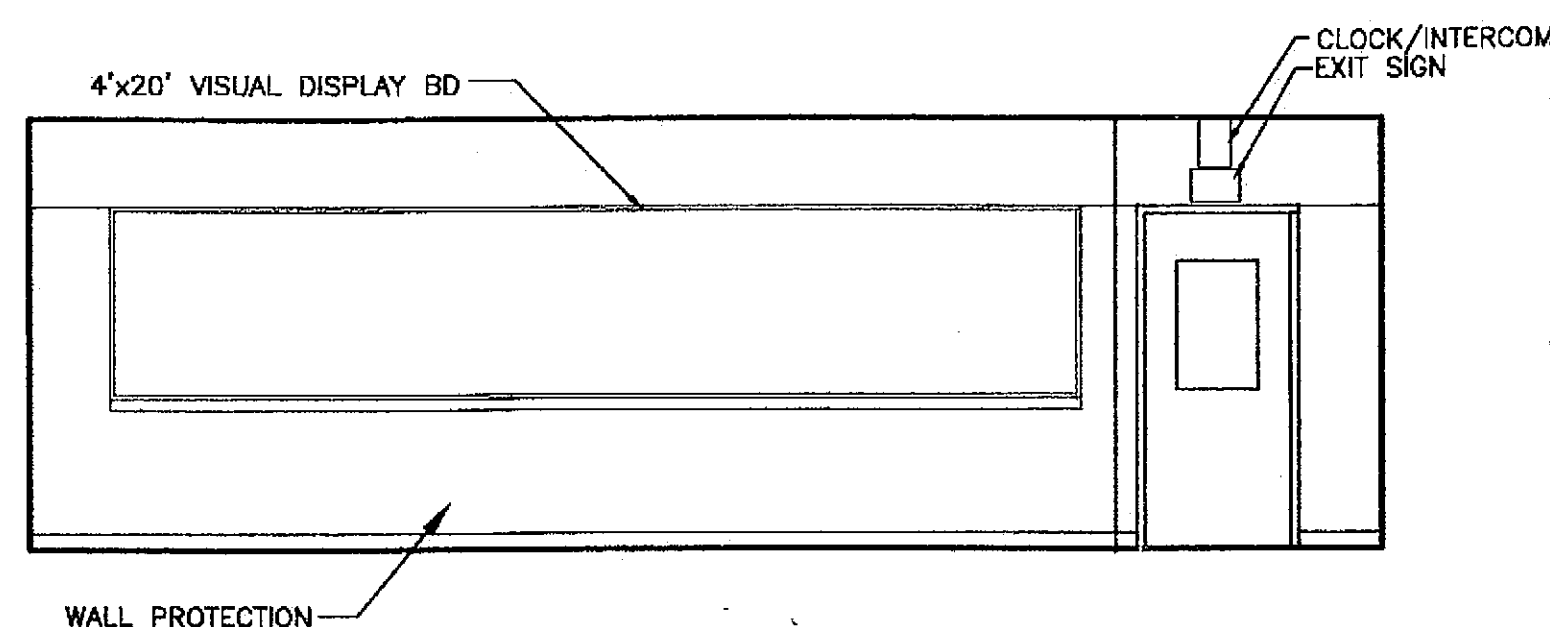

8 128 CLASSROOM SCALE: 0 2' 4' 8'

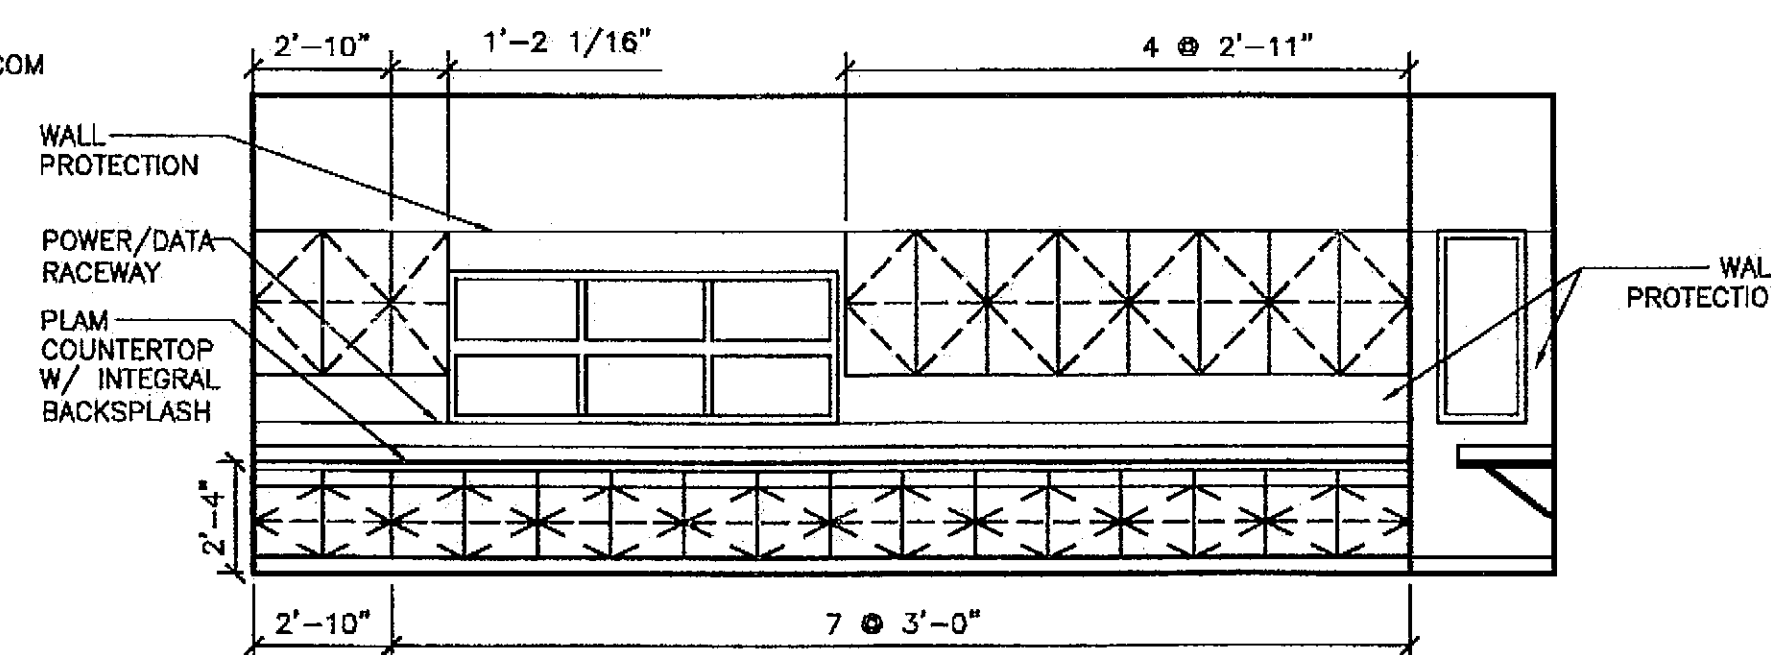

9 CLASSROOM 147 ALTERNATE 1 SCALE: 0 2' 4' 10' 8'


PATH: G:\Projects\0411\Cad\CD\1330\Arch\A504.dwg
Tue, 14/Dec/04 02:32PM
TAB: Layout1

ADDENDUM NUMBER

ATTACHMENT NUMBER

RECORD OF REVISIONS

No.	DATE	DESCRIPTION

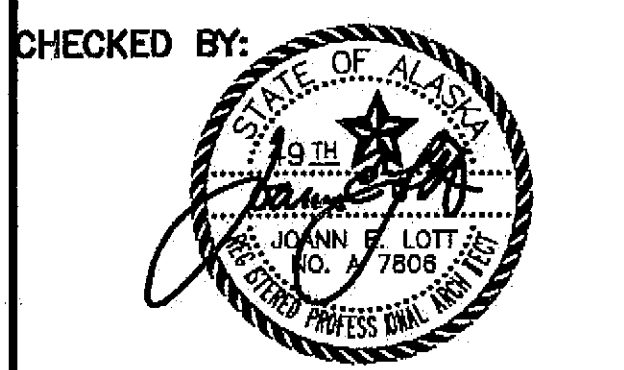

DESIGNED BY: JENSEN YORBA LOTT

DRAWN BY:

STATE OF ALASKA
DEPARTMENT OF TRANSPORTATION
& PUBLIC FACILITIES
STATEWIDE DESIGN & ENGINEERING
SERVICES DIVISION
MT EDGECOMBE
HIGH SCHOOL
BUILDING 1330
ACADEMIC
EXPANSION

SHEET A504

PROJECT DESIGNATION NUMBER

67751C

STATE	YEAR
ALASKA	2004
SHEET NUMBER	TOTAL SHEETS
20	79

Project As-Built Drawings have been reviewed by the Project Engineer and represent to the best of my knowledge, the project as constructed.
Proj. Eng. *[Signature]* Date 7-07


ADDENDUM NUMBER

ATTACHMENT NUMBER

RECORD OF REVISIONS

No.	DATE	DESCRIPTION

CHECKED BY:

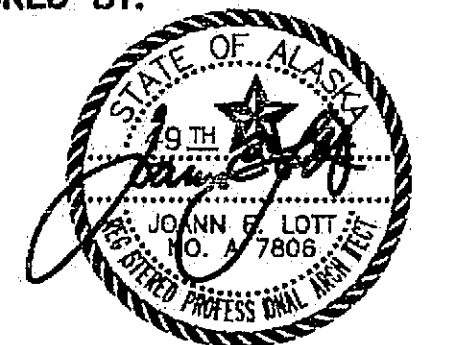

DESIGNED BY: JENSEN YORBA LOTT

DRAWN BY:

STATE OF ALASKA
DEPARTMENT OF TRANSPORTATION
& PUBLIC FACILITIES
STATEWIDE DESIGN & ENGINEERING
SERVICES DIVISION

MT EDGECUMBE
HIGH SCHOOL
BUILDING 1330
ACADEMIC
EXPANSION

SHEET A601


PROJECT DESIGNATION NUMBER

67751C

STATE	YEAR
ALASKA	2004

SHEET NUMBER	TOTAL SHEETS
21	79

Project As-Built Drawings have been reviewed by the Project Engineer and represent to the best of my knowledge, the project as constructed.
Proj. Eng. *[Signature]* Date 7-27

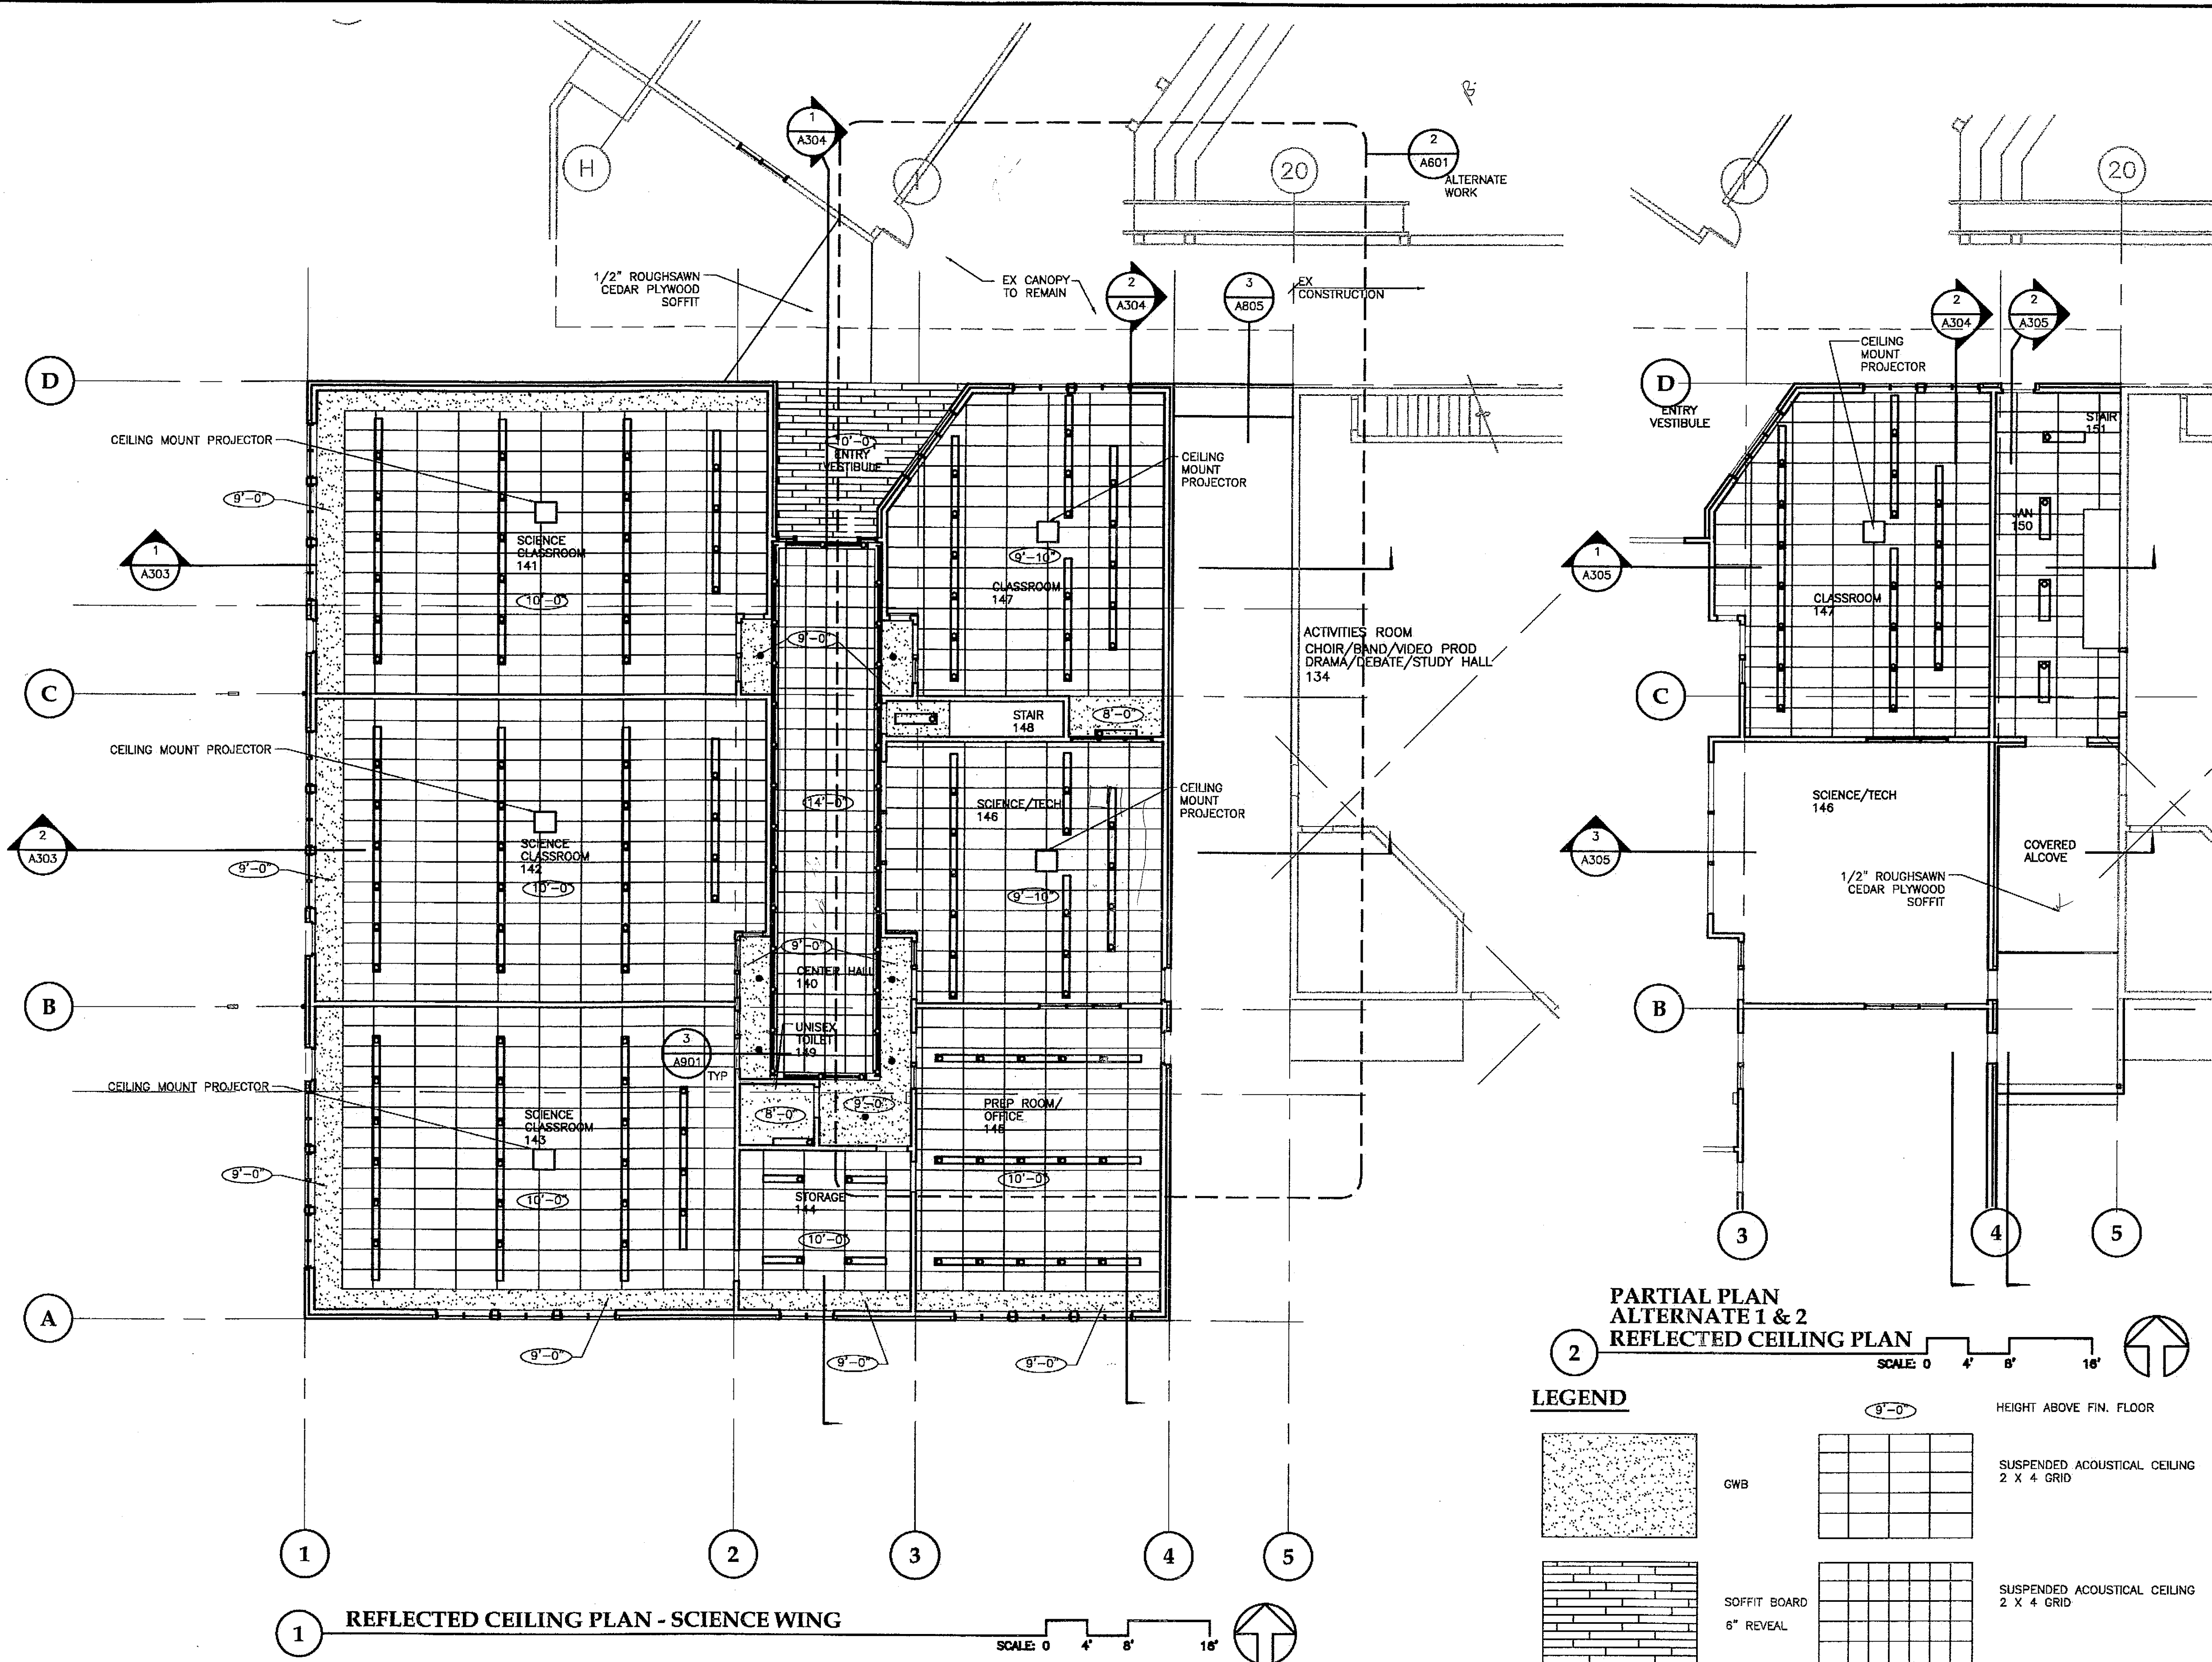

PATH: G:\Projects\0411\0411\0411\1330\Arch\A602.dwg
Tue, 14/Dec/04 02:32PM
TAB: Layout1


ADDENDUM NUMBER

ATTACHMENT NUMBER

RECORD OF REVISIONS

No.	DATE	DESCRIPTION

CHECKED BY:

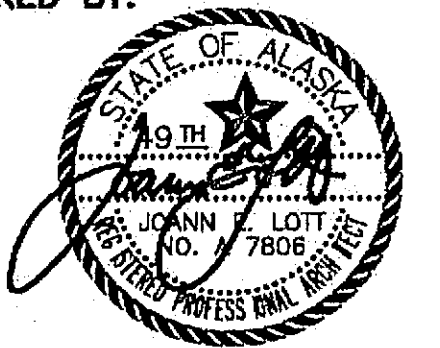

DESIGNED BY: JENSEN YORBA LOTT

DRAWN BY:

STATE OF ALASKA
DEPARTMENT OF TRANSPORTATION
& PUBLIC FACILITIES
STATEWIDE DESIGN & ENGINEERING
SERVICES DIVISION

MT EDGE CUMBE
HIGH SCHOOL
BUILDING 1330
ACADEMIC
EXPANSION

SHEET A602

PROJECT DESIGNATION NUMBER

67751C


STATE	YEAR
ALASKA	2004

SHEET NUMBER	TOTAL SHEETS
--------------	--------------

22

79

Project As-Built Drawings have been
reviewed by the Project Engineer and
present to the best of my knowledge, the
project as constructed.
Proj. Eng. *[Signature]* Date 2/27

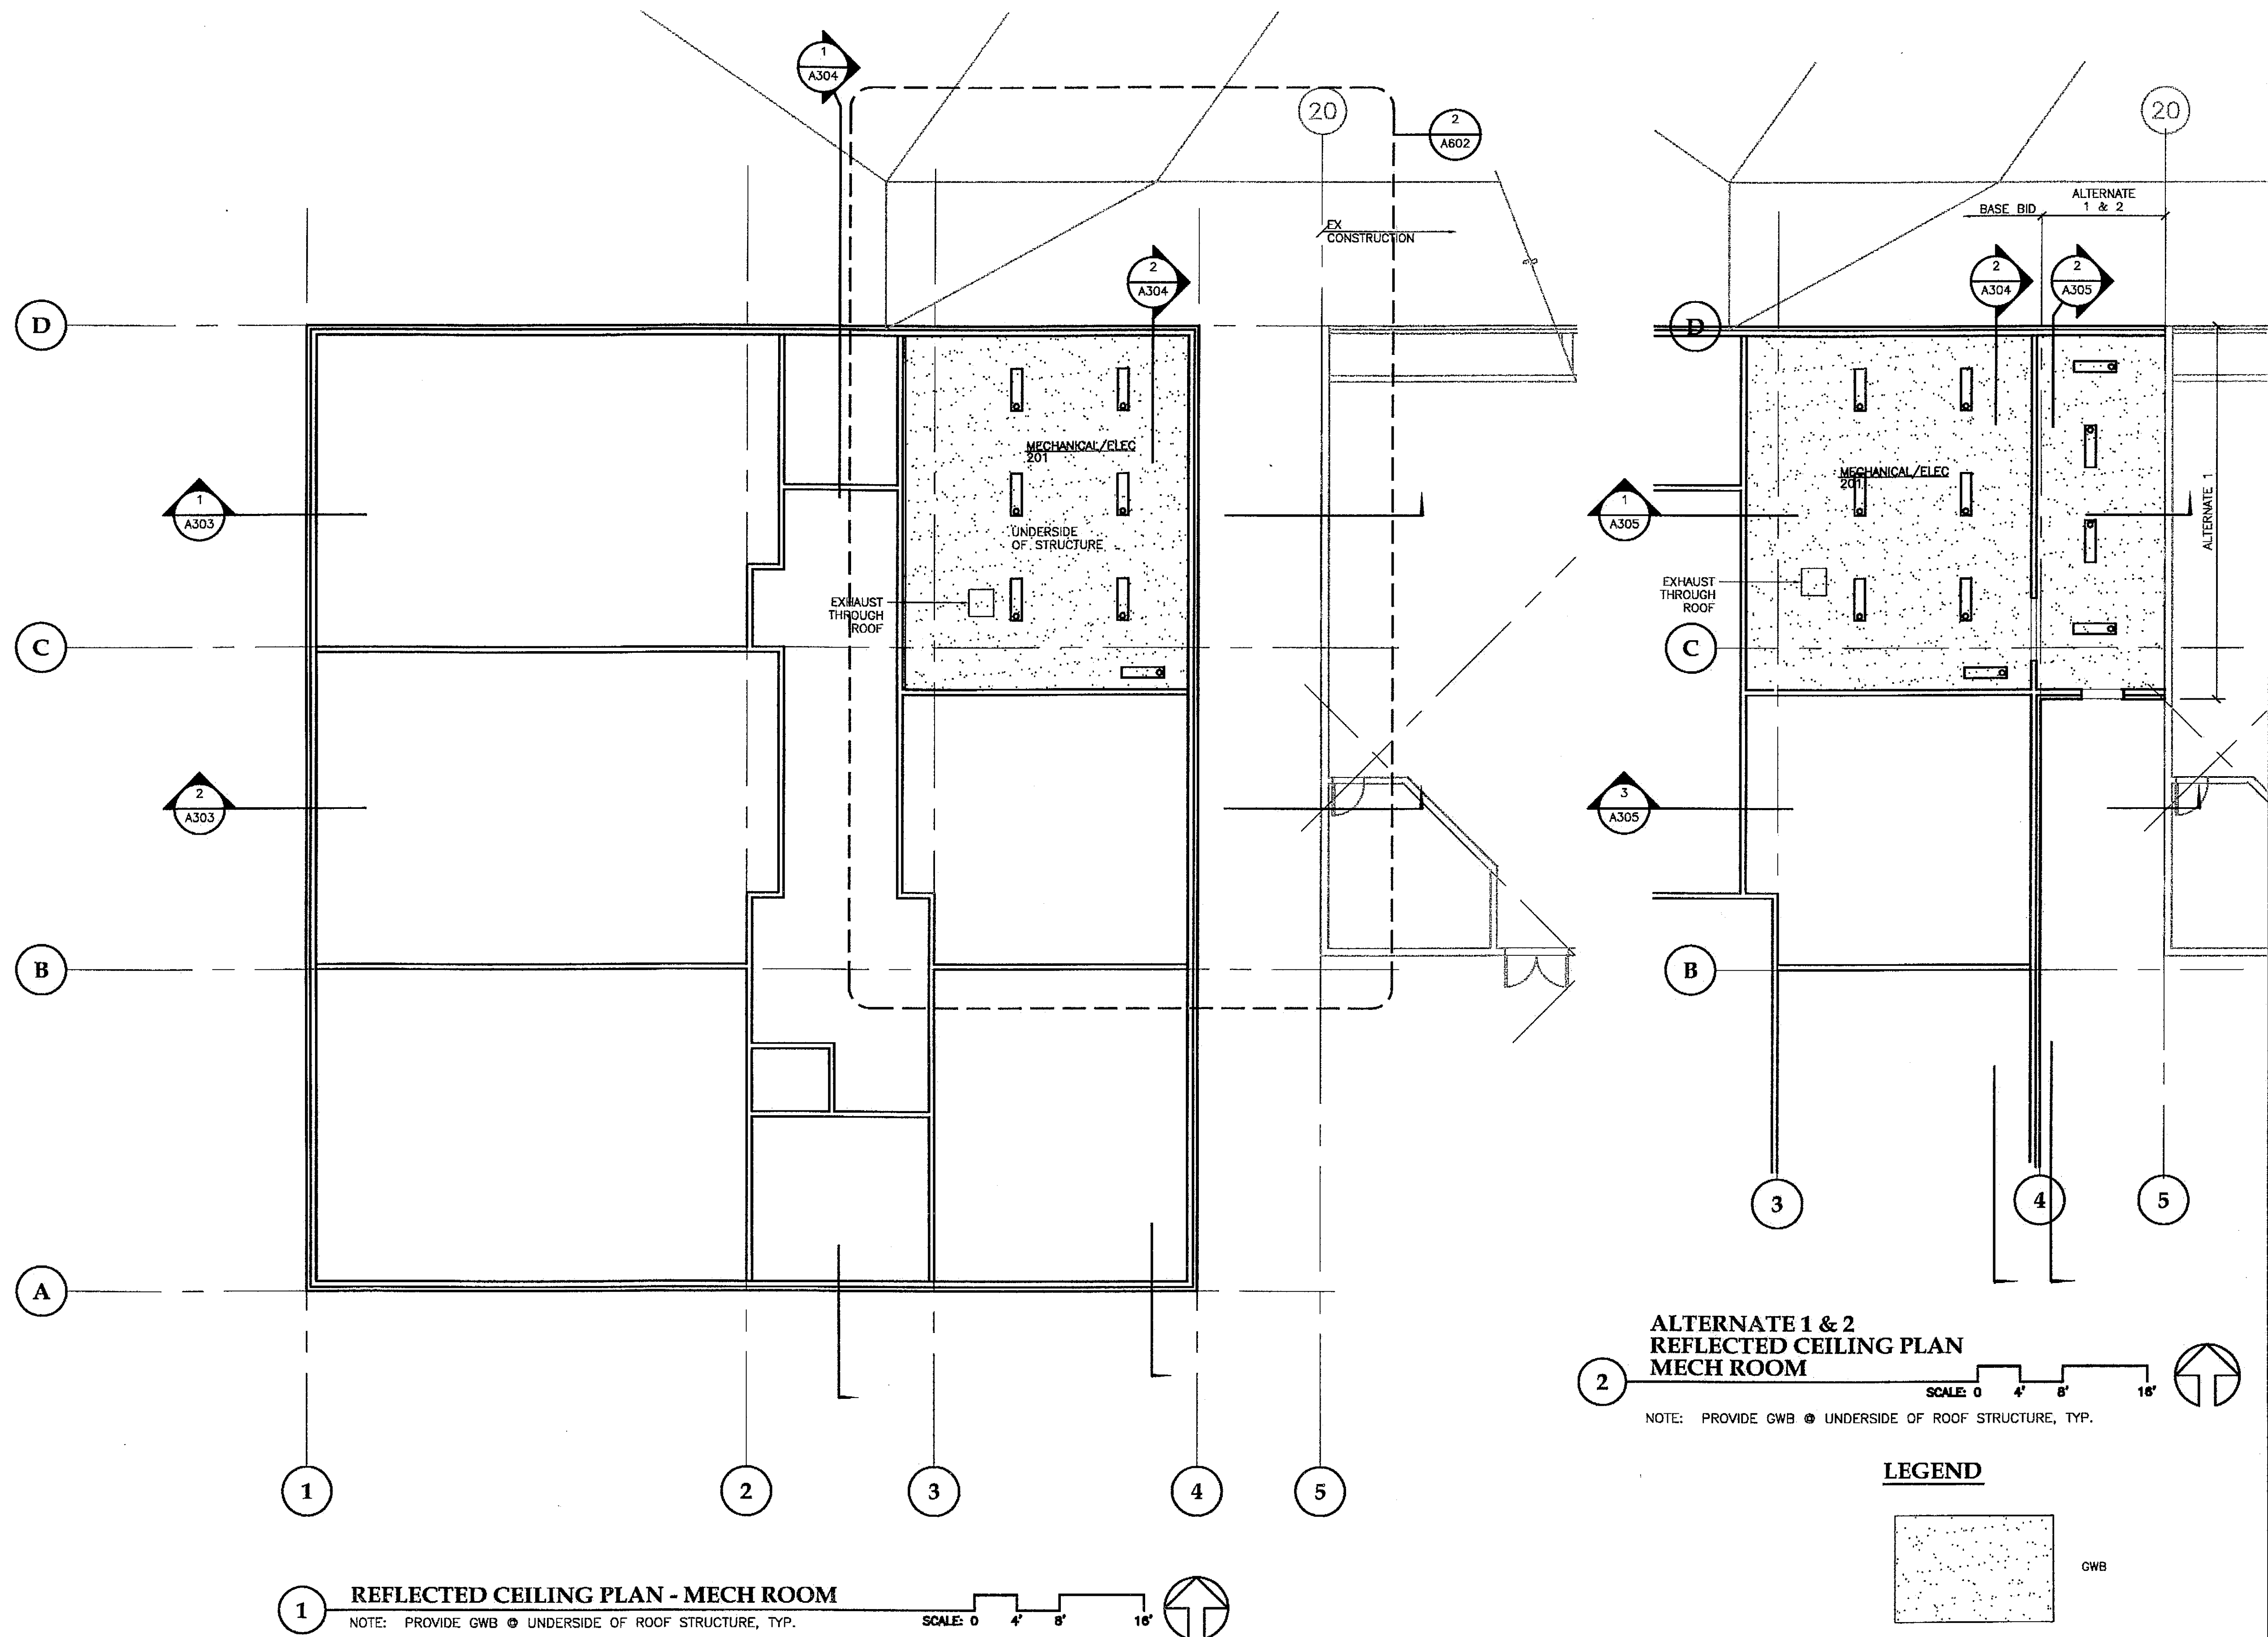

PATH:
G:_Projects\0411\CD\1330\Arch\A603.dwg
Tue, 14/Dec/04 02:33PM
TAB: Layout1


ADDENDUM NUMBER

ATTACHMENT NUMBER

RECORD OF REVISIONS

No.	DATE	DESCRIPTION

CHECKED BY:

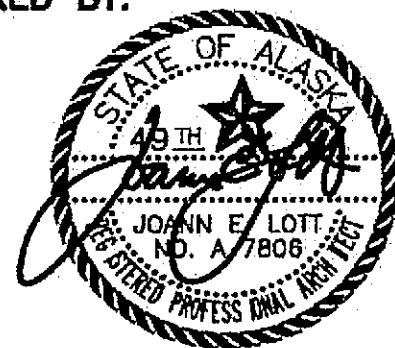

DESIGNED BY: JENSEN YORBA LOTT

DRAWN BY:

STATE OF ALASKA
DEPARTMENT OF TRANSPORTATION
& PUBLIC FACILITIES
STATEWIDE DESIGN & ENGINEERING
SERVICES DIVISION
MT EDGE CUMBE
HIGH SCHOOL
BUILDING 1330
ACADEMIC
EXPANSION


SHEET A603

PROJECT DESIGNATION NUMBER

67751C

STATE	YEAR
ALASKA	2004
SHEET NUMBER	TOTAL SHEETS
23	79

Project As-Built Drawings have been
reviewed by the Project Engineer and
presented to the best of my knowledge, the
project as constructed.
Proj. Eng. *[Signature]* Date 7-07

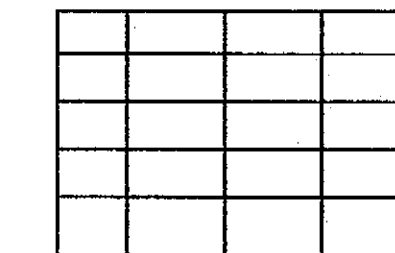

SUSPENDED ACOUSTICAL CEILING
2 X 4 GRID

9'-0"

HEIGHT ABOVE FIN. FLOOR

1 REFLECTED CEILING PLAN OFFICE 129 AND CLASSROOM 8
SCALE: 0 2' 4' 8'

PATH: G:\Projects\0411\Cad\CD\1330\Arch\A701.dwg
Tue, 14/Dec/04 02:33PM

TAB: Layout1


ADDENDUM NUMBER

ATTACHMENT NUMBER

RECORD OF REVISIONS

No.	DATE	DESCRIPTION

CHECKED BY:

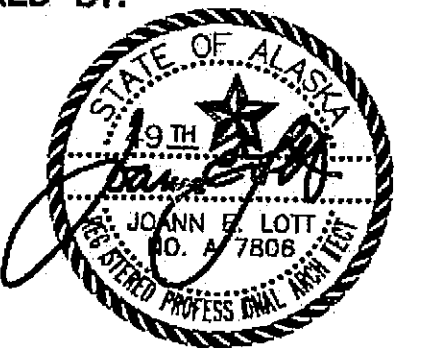

DESIGNED BY: JENSEN YORBA LOTT

DRAWN BY:

STATE OF ALASKA
DEPARTMENT OF TRANSPORTATION
& PUBLIC FACILITIES
STATEWIDE DESIGN & ENGINEERING
SERVICES DIVISION

MT EDGECUMBE
HIGH SCHOOL
BUILDING 1330
ACADEMIC
EXPANSION

SHEET A701






PROJECT DESIGNATION NUMBER


67751C

STATE	YEAR
ALASKA	2004

SHEET NUMBER	TOTAL SHEETS
24	79


Project As-Built Drawings have been
reviewed by the Project Engineer and
represent to the best of my knowledge, the
project as constructed.
Proj. Eng. *Meer* Date 7-07

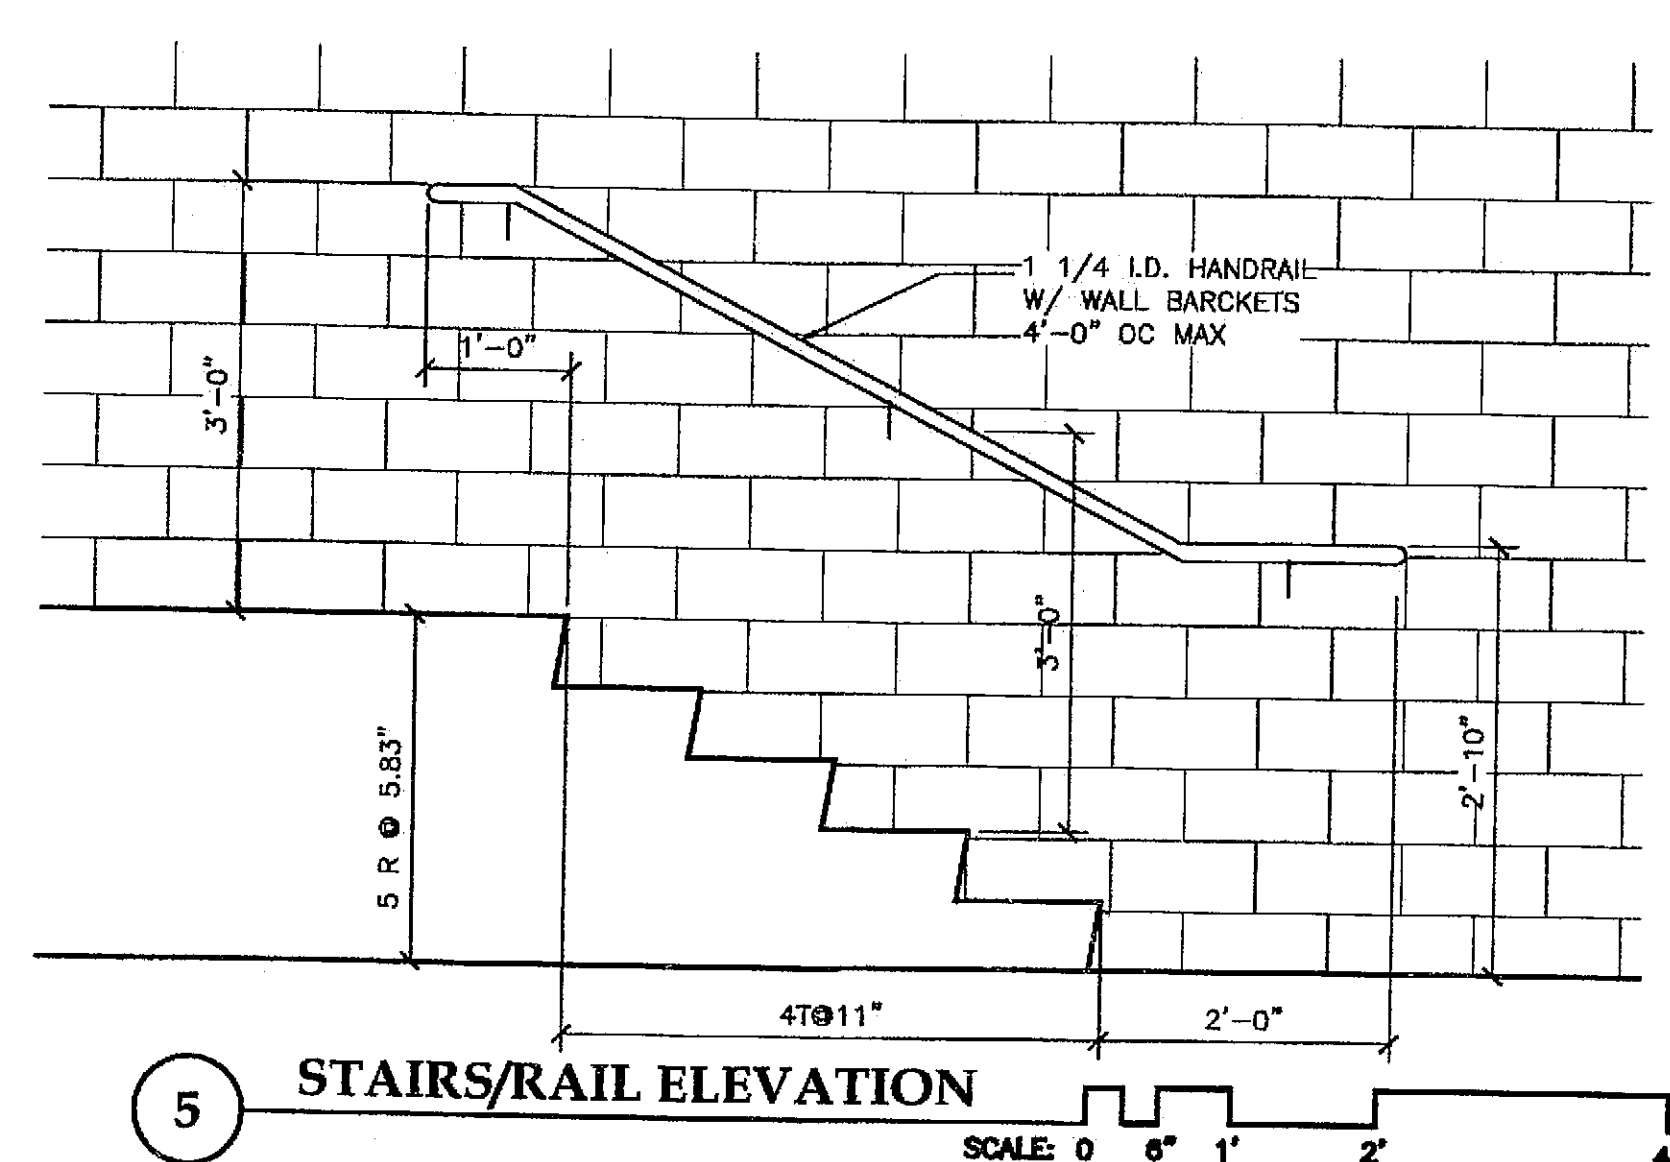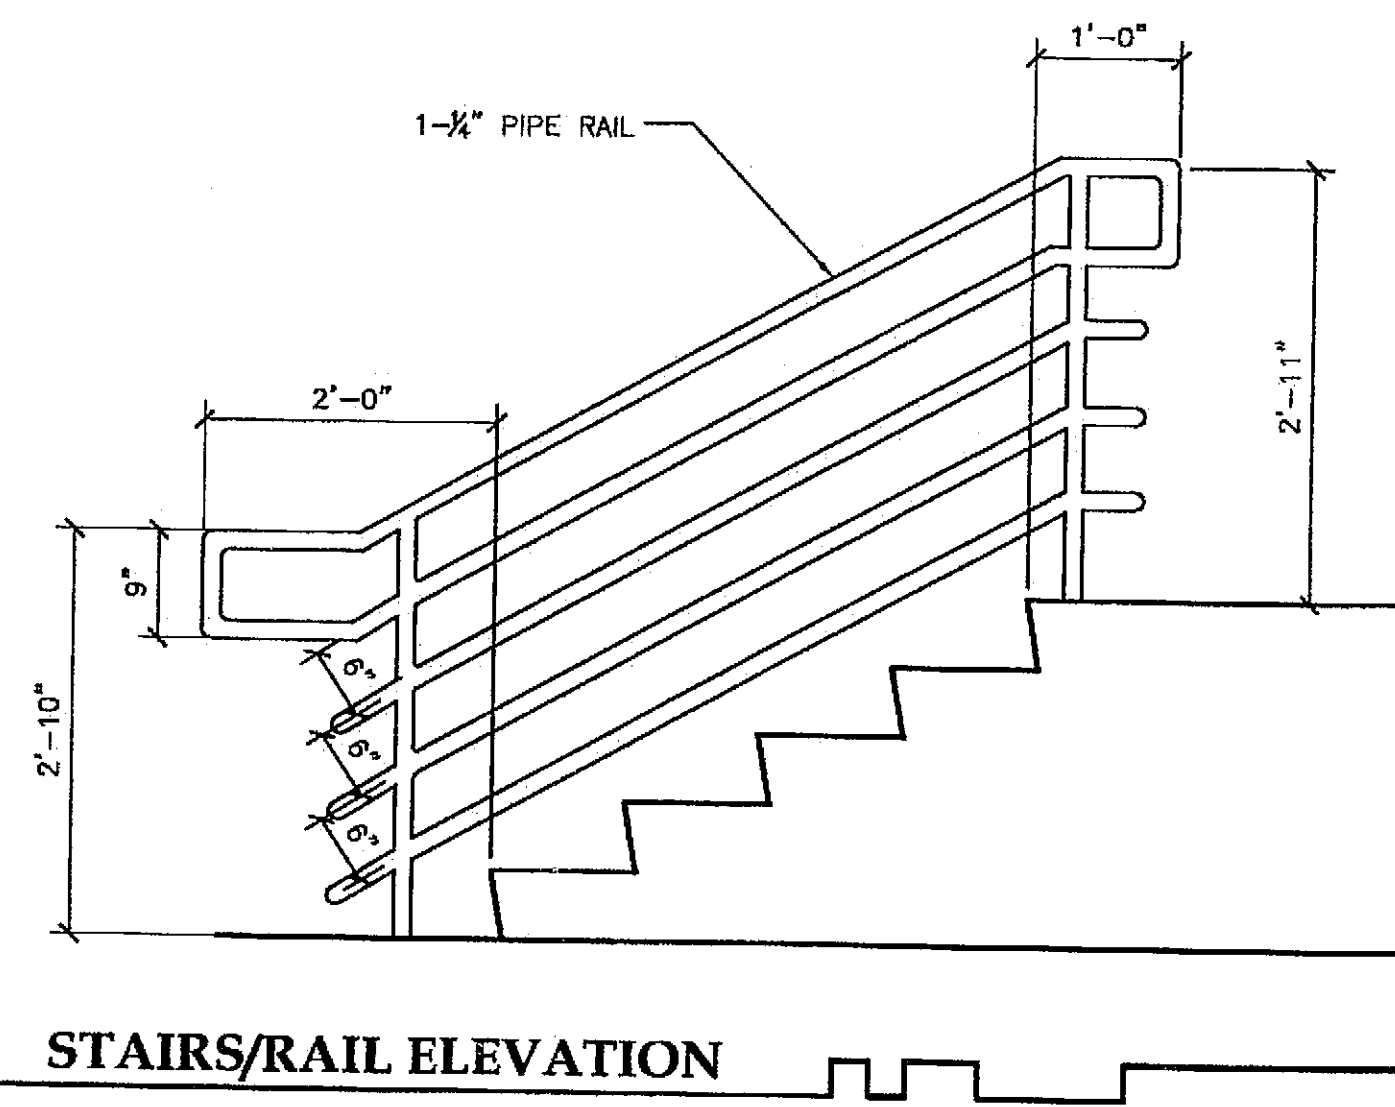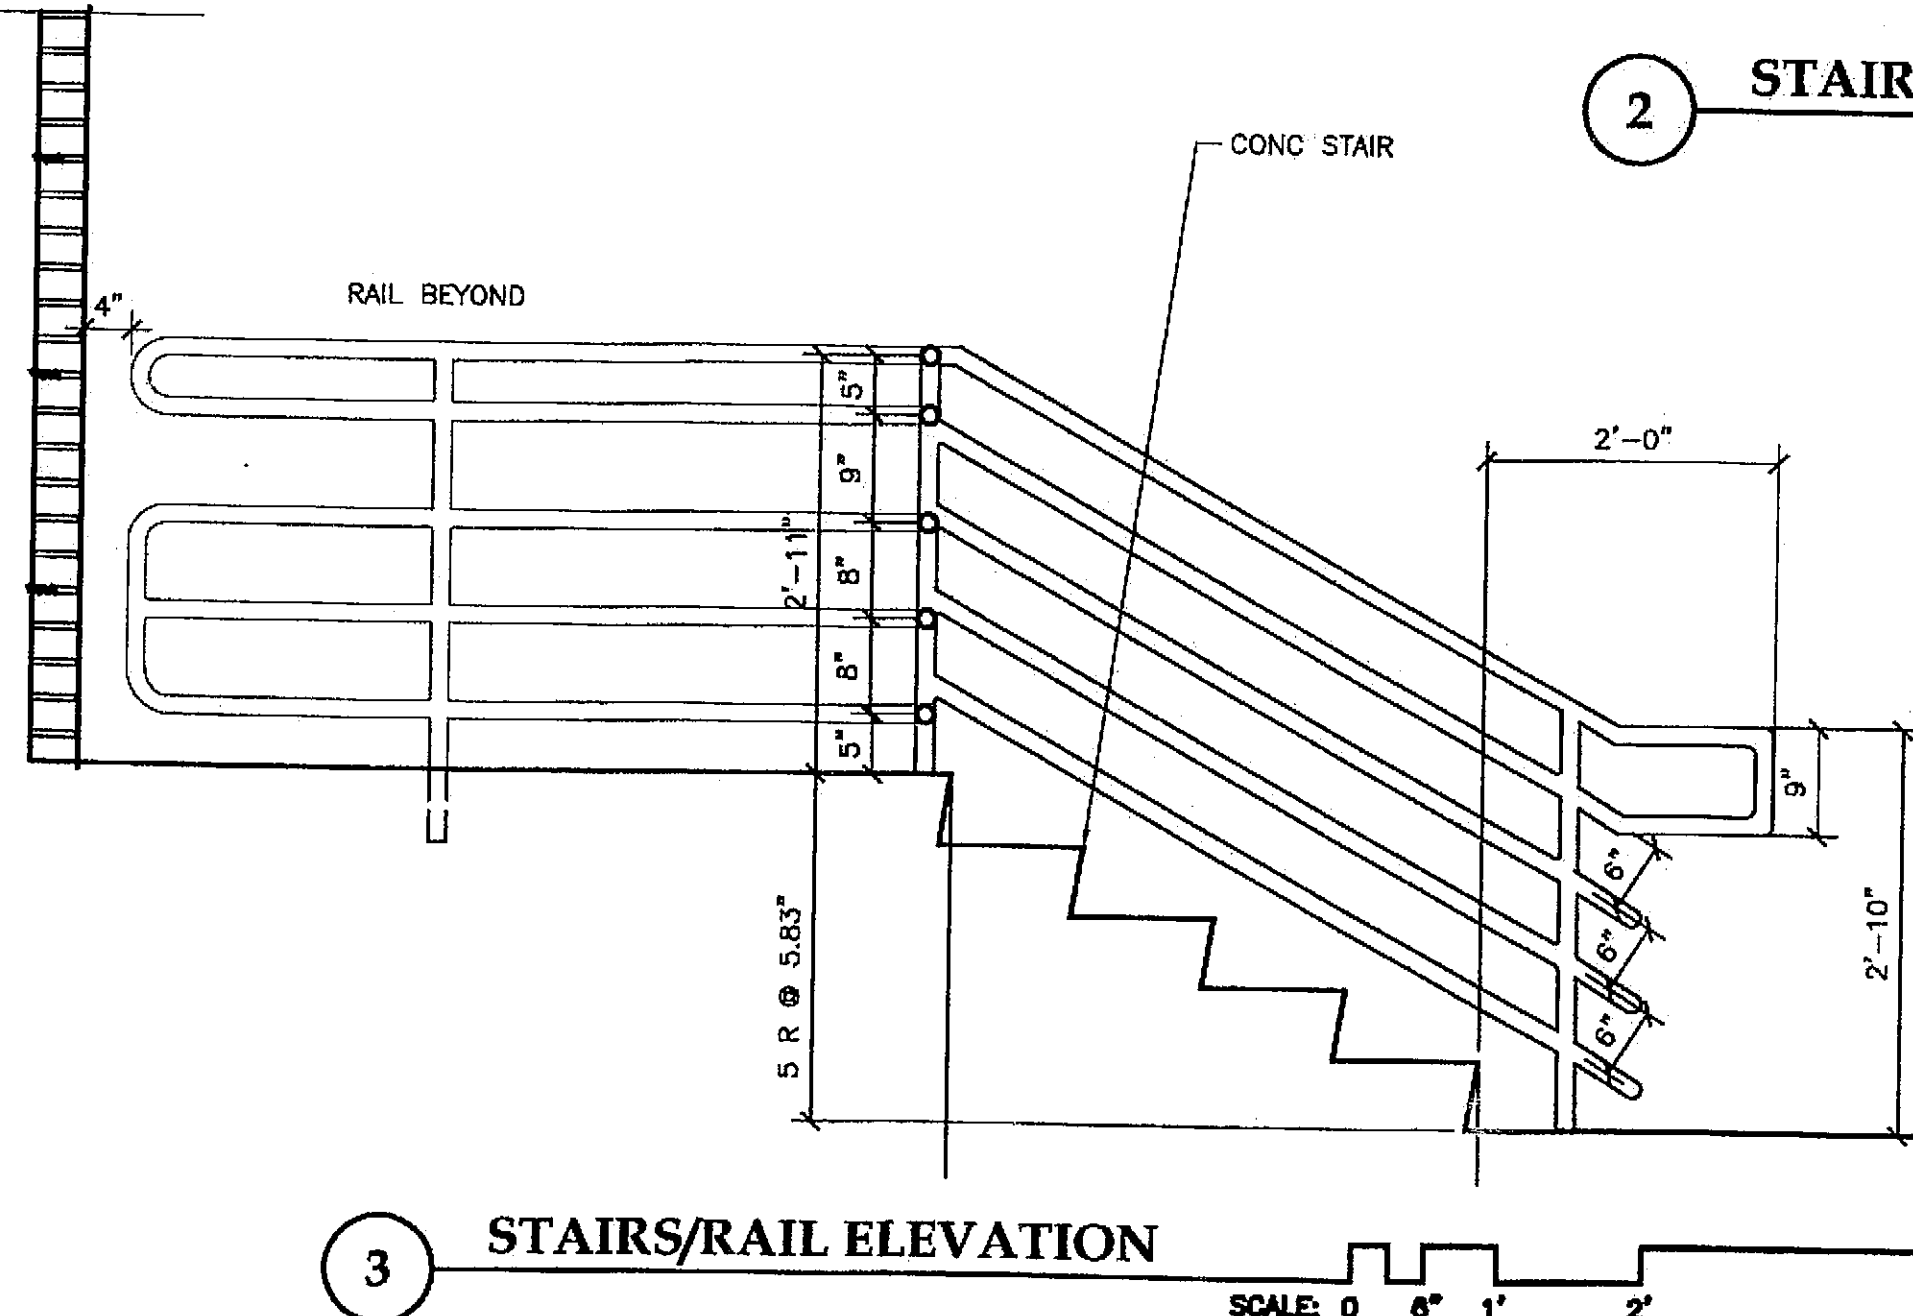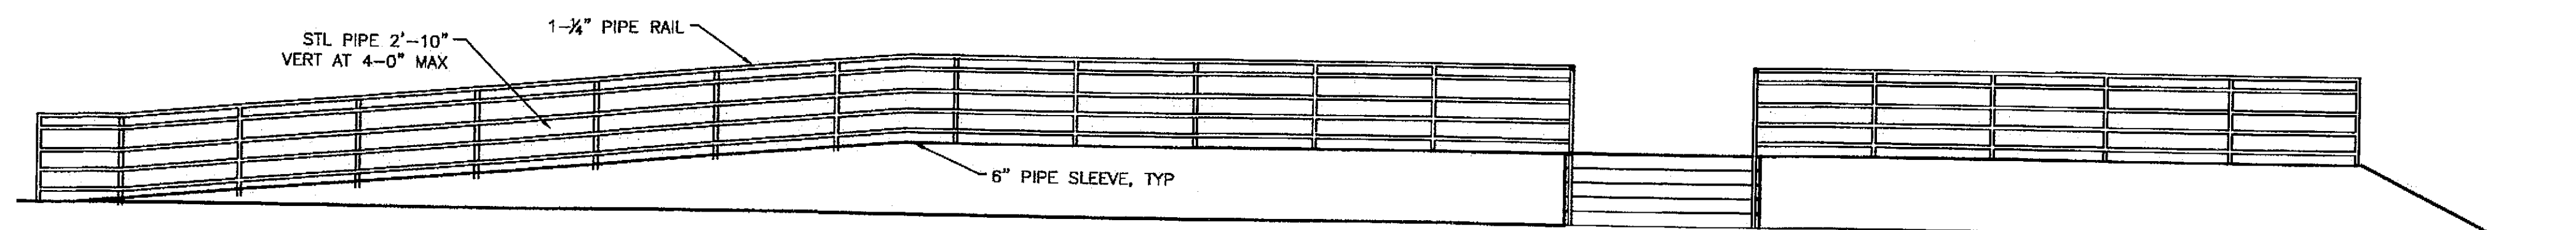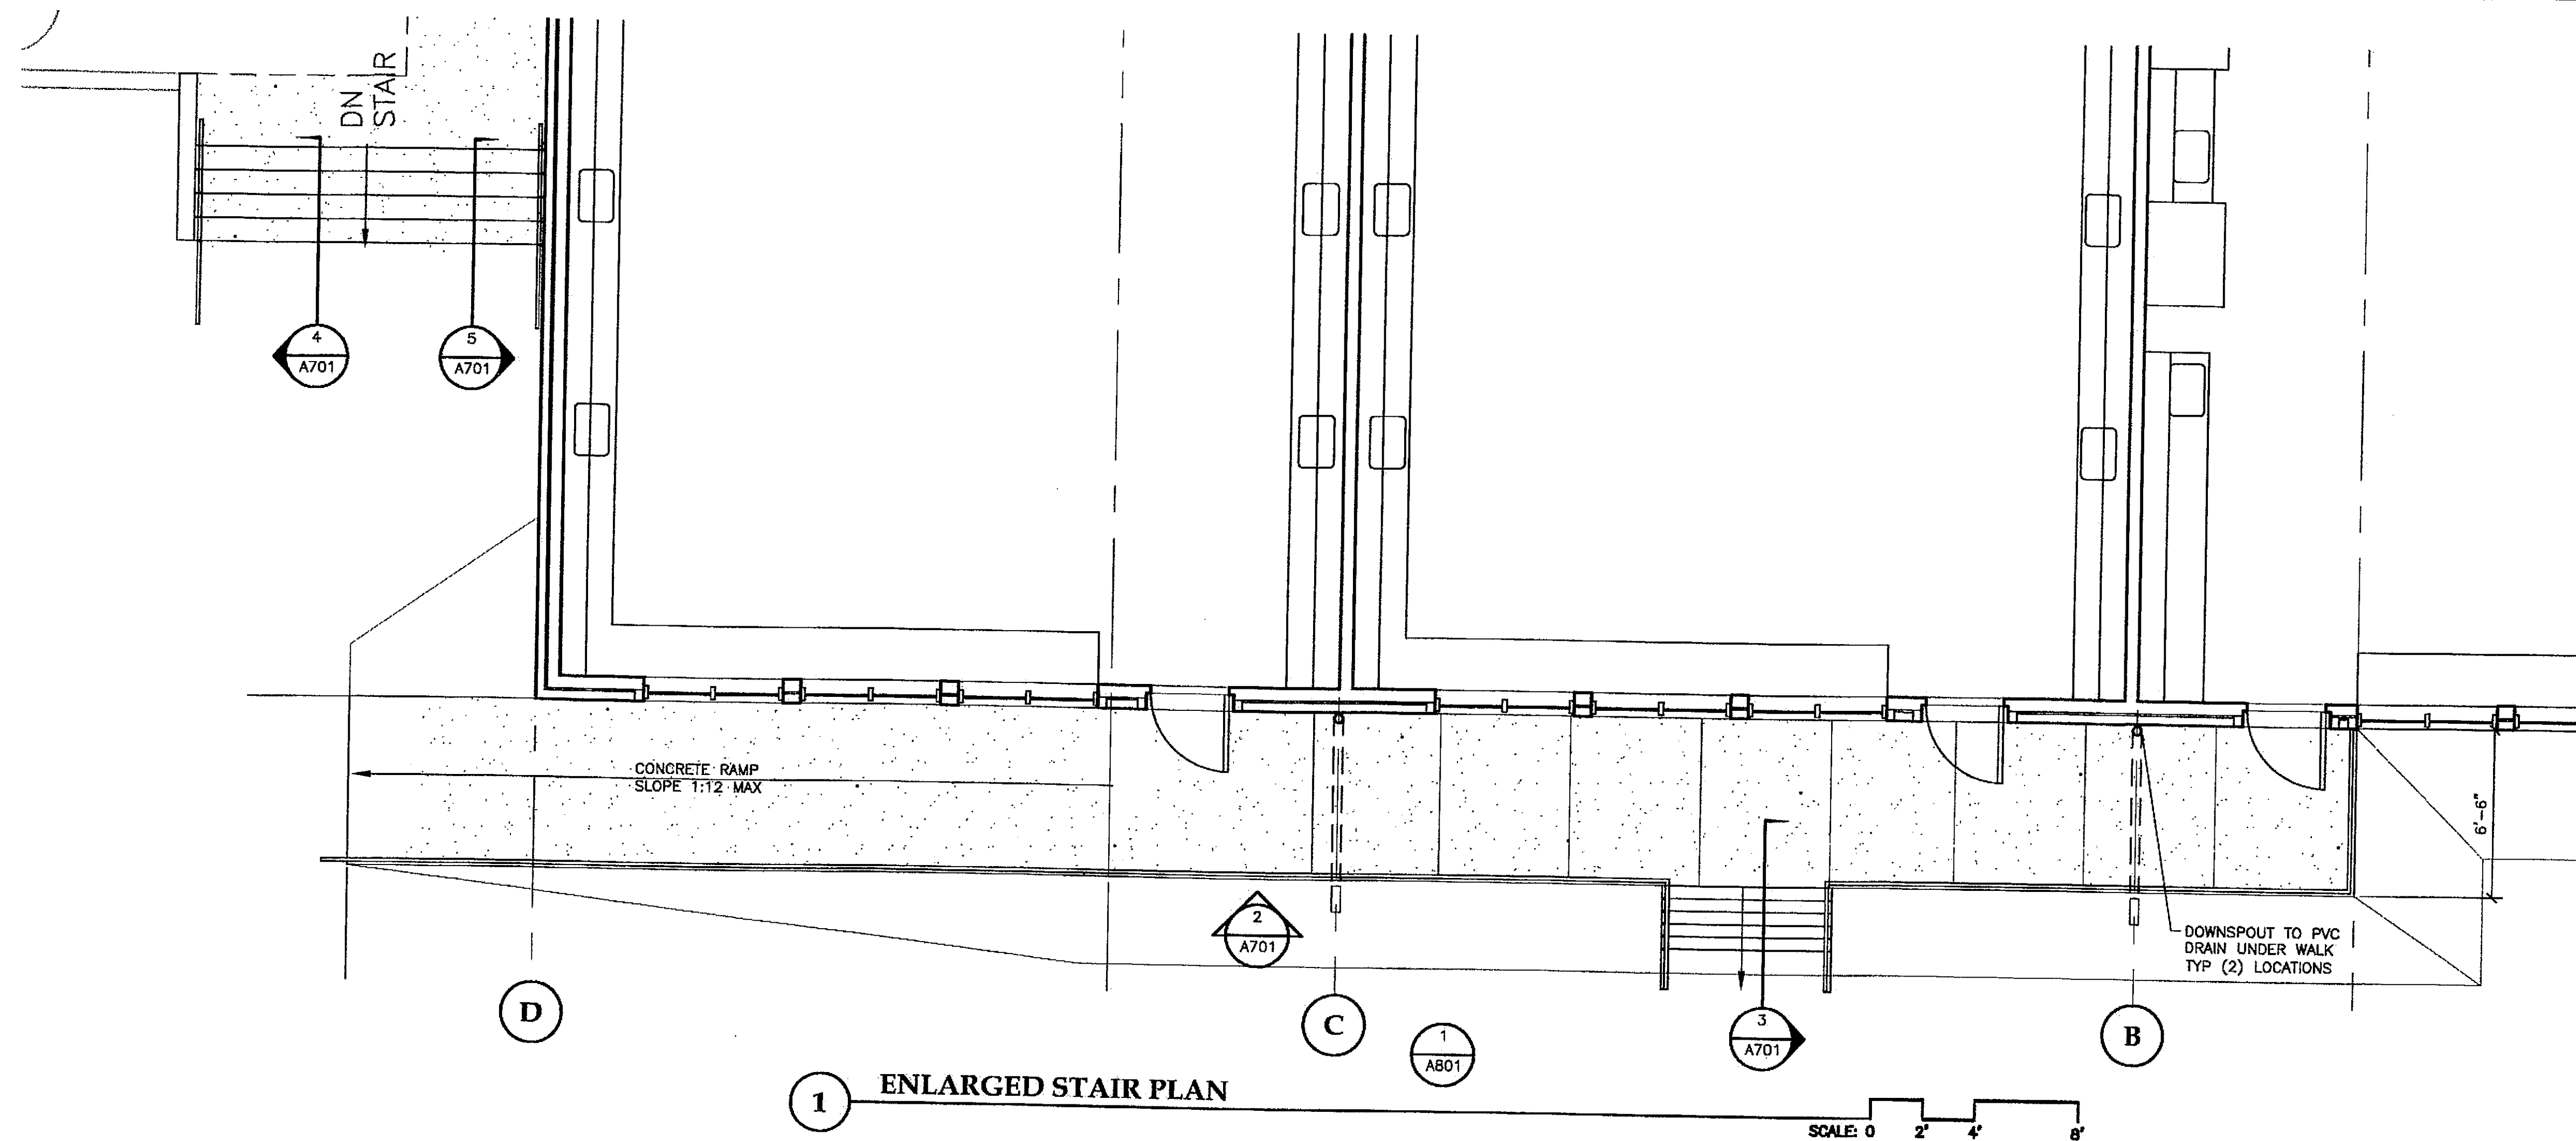

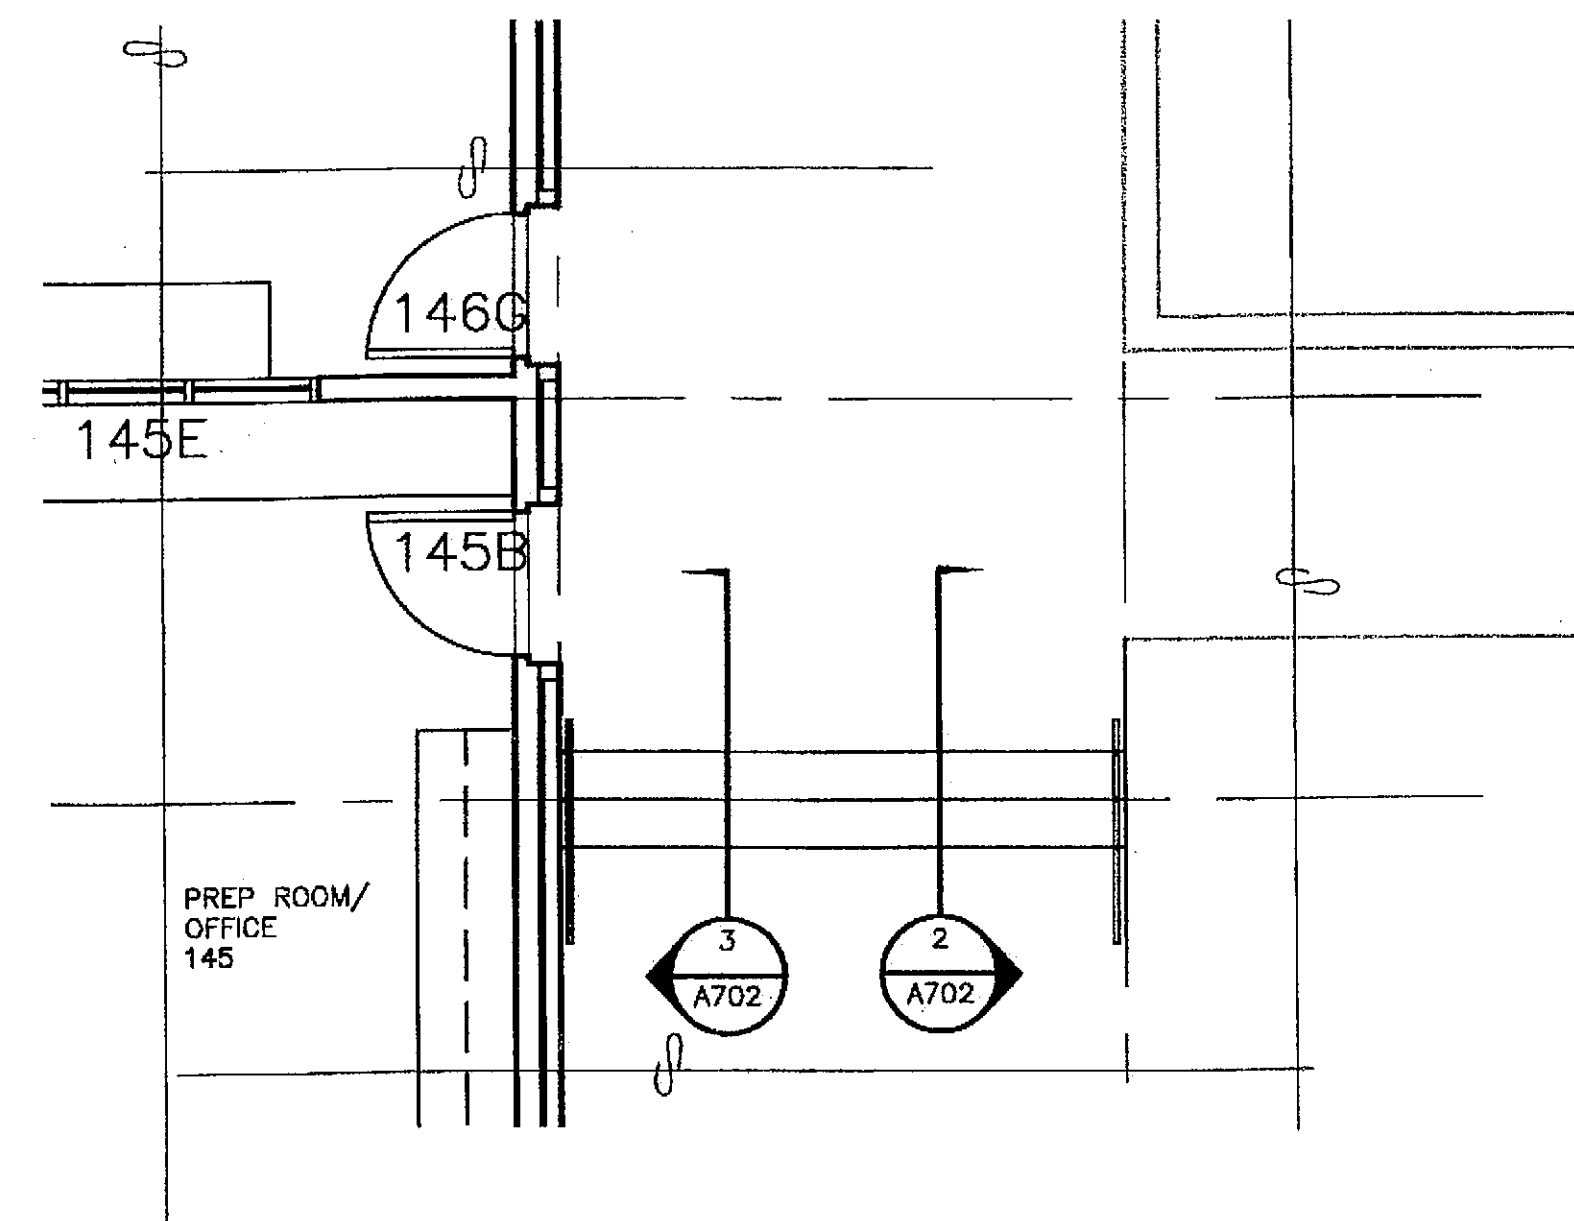


1 ENLARGED STAIR PLAN

SCALE: 0 2' 4' 8'

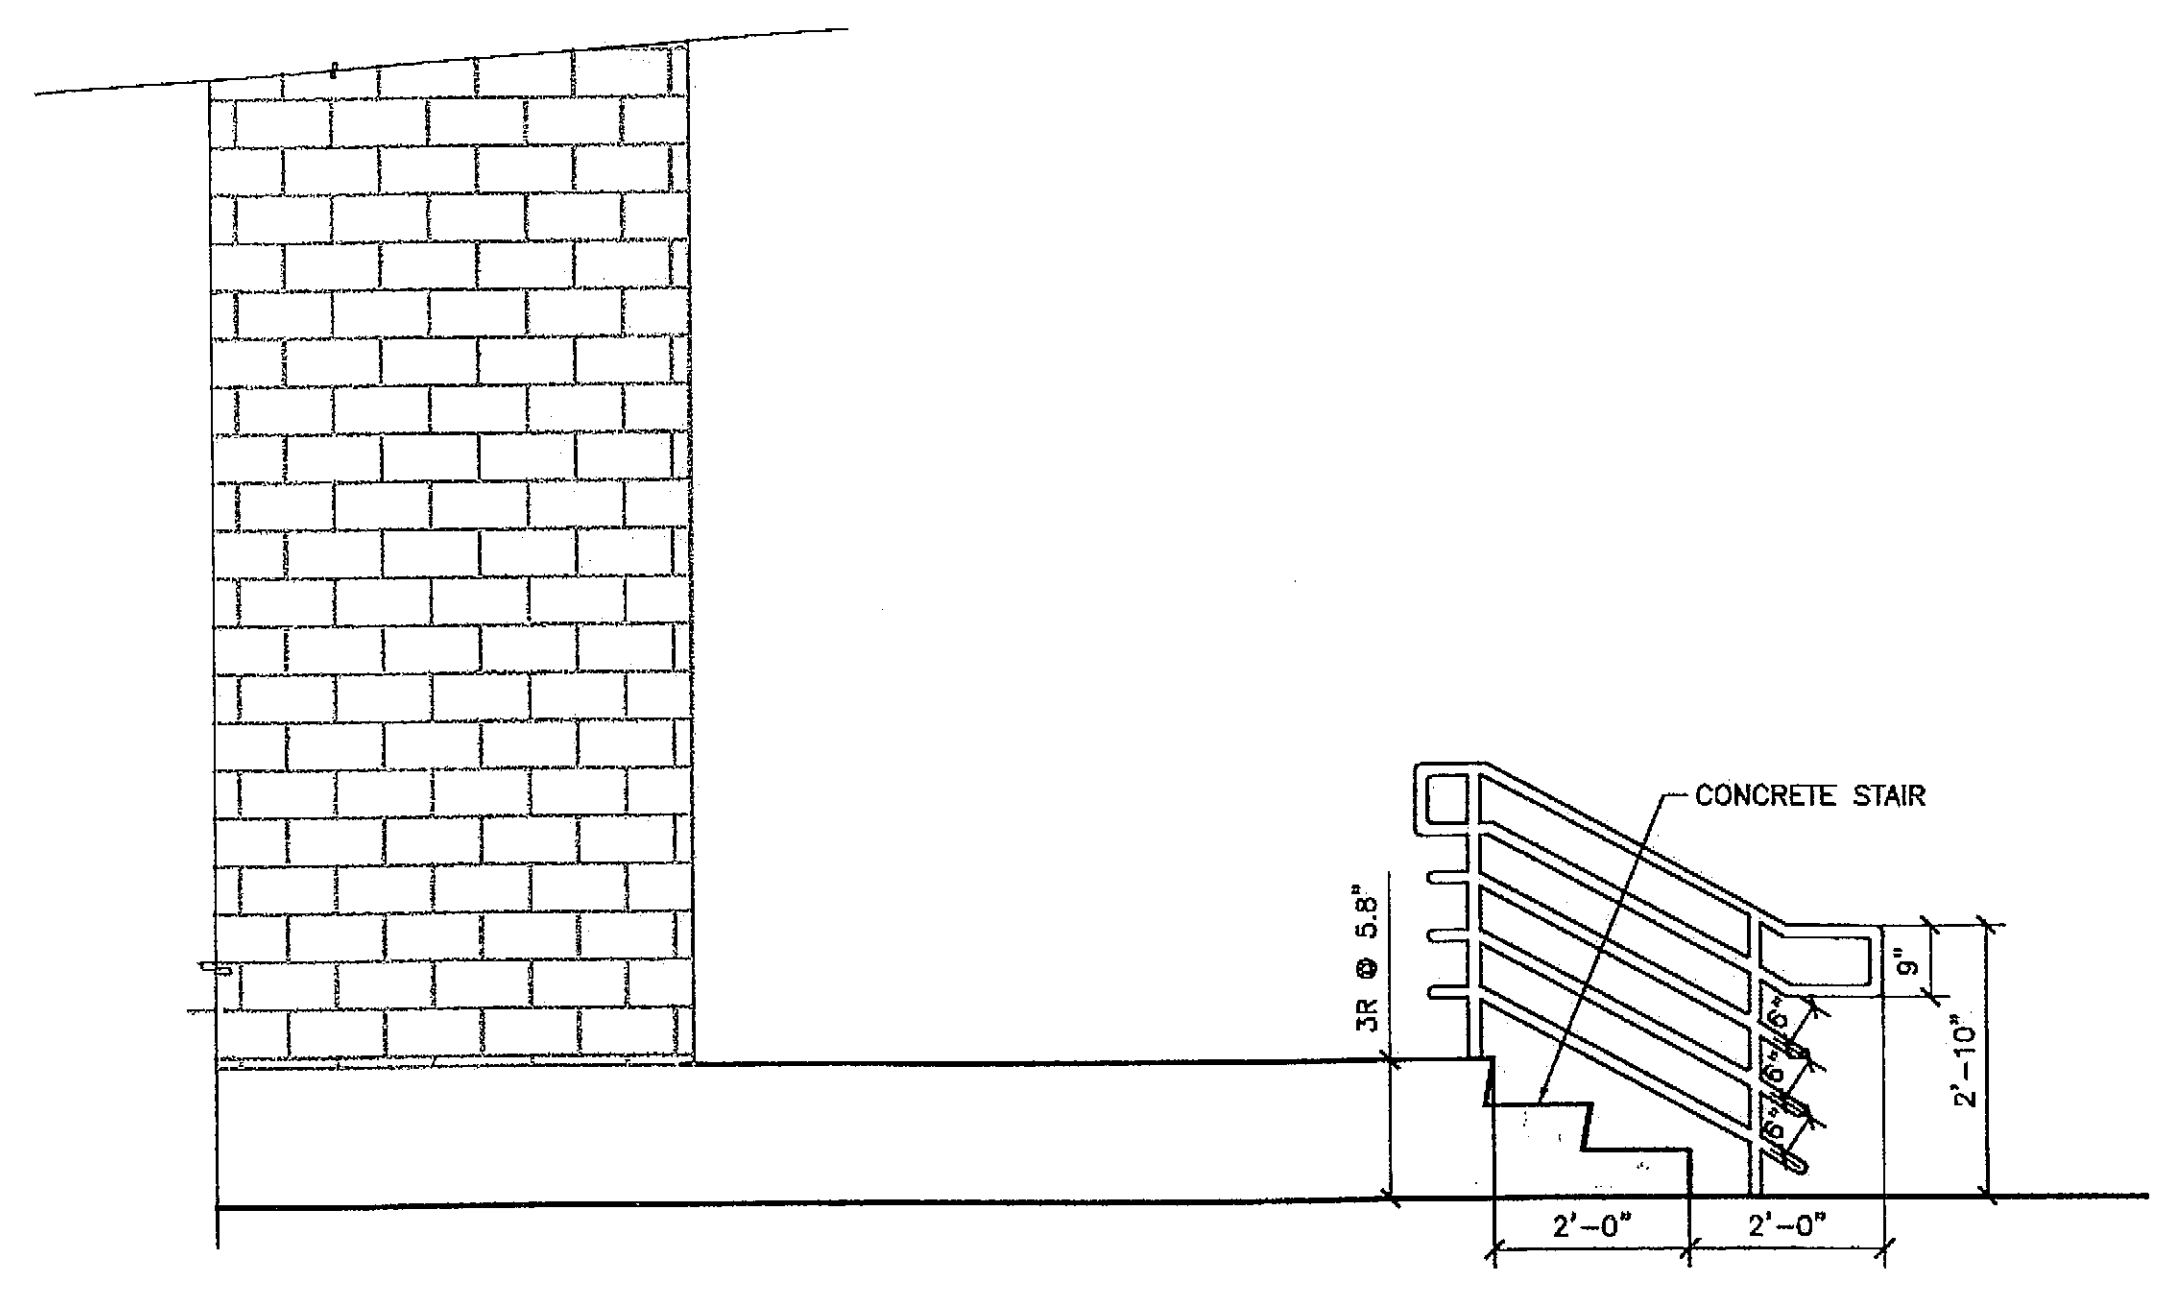

2 STAIRS/RAIL ELEVATION

SCALE: 0 6" 1' 2'

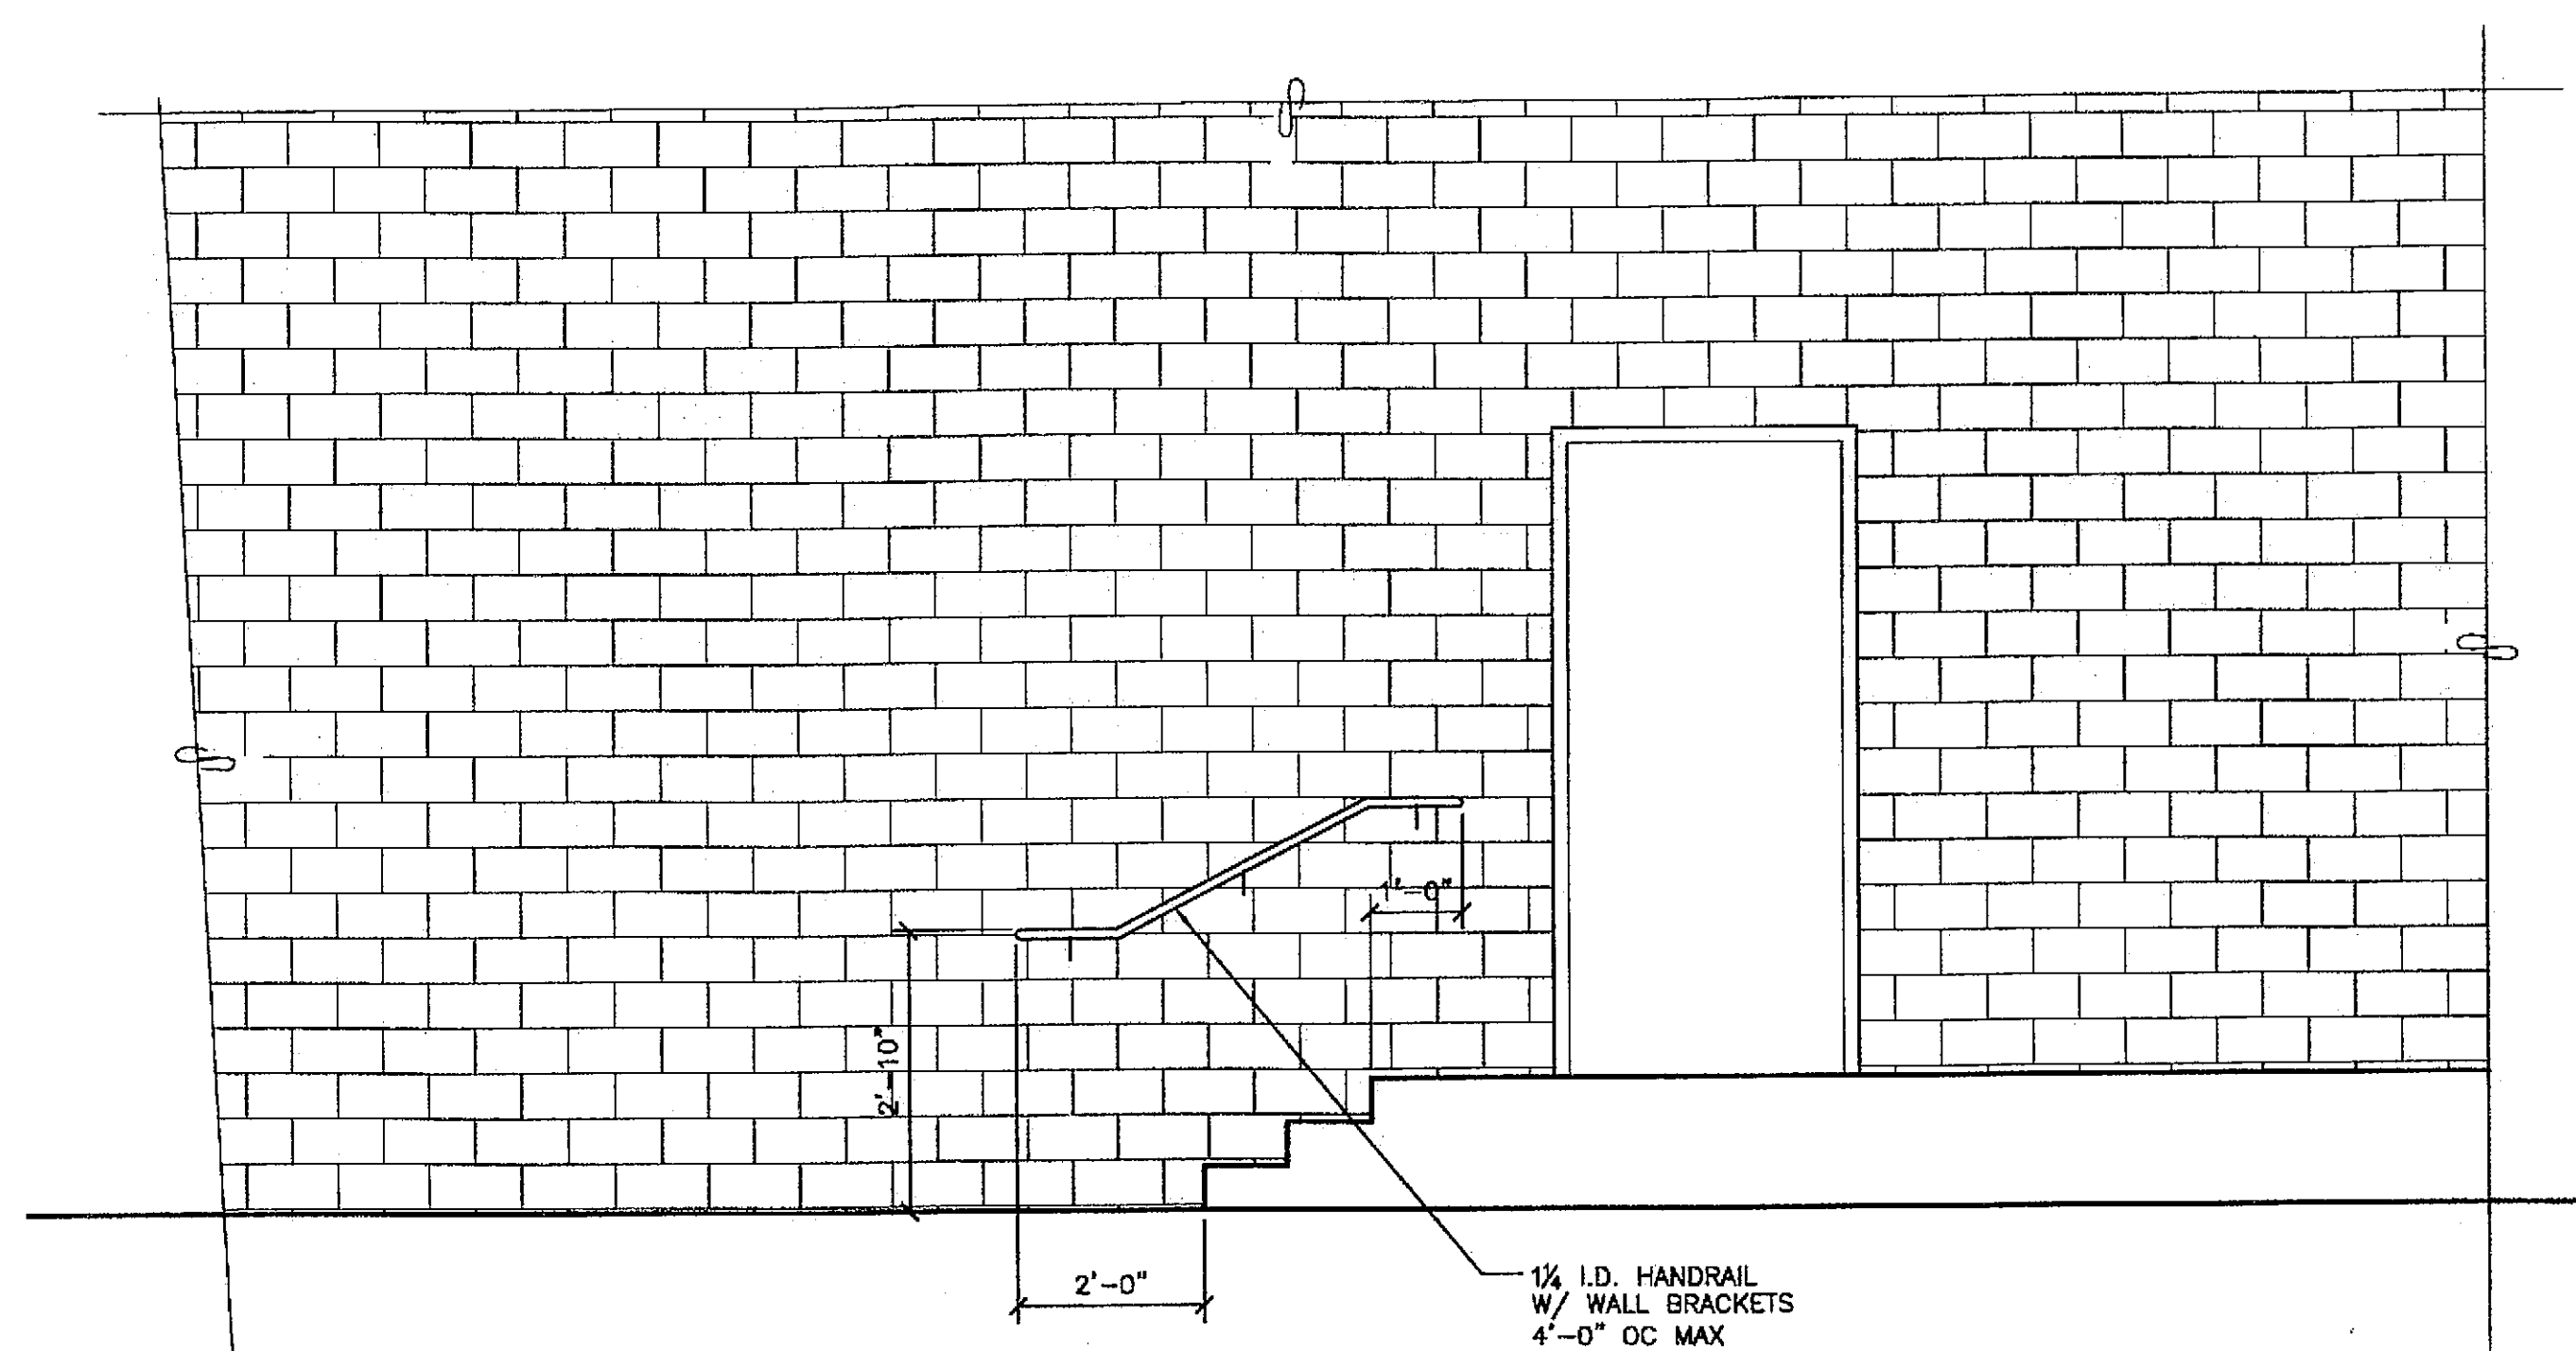

3 STAIRS/RAIL ELEVATION

SCALE: 0 6" 1' 2'

PATH: G:_Projects\0411\Cad\CD\1330\Arch\A702.dwg
 Tue, 14/Dec/04 02:33PM
 TAB: Layout1

ADDENDUM NUMBER		
ATTACHMENT NUMBER		
RECORD OF REVISIONS		
No.	DATE	DESCRIPTION

CHECKED BY:

DESIGNED BY: JENSEN YORBA LOTT
 DRAWN BY:

STATE OF ALASKA
 DEPARTMENT OF TRANSPORTATION & PUBLIC FACILITIES
 STATEWIDE DESIGN & ENGINEERING SERVICES DIVISION
 MT EDGE CUMBE HIGH SCHOOL BUILDING 1330 ACADEMIC EXPANSION

SHEET A702
 PROJECT DESIGNATION NUMBER
 67751C

STATE	YEAR
ALASKA	2004
SHEET NUMBER	TOTAL SHEETS
25	79

Project As-Built Drawings have been reviewed by the Project Engineer and represent to the best of my knowledge, the project as constructed.
 Proj. Eng. *M. Lott* Date 7-07


PATH: G:_Projects\0411\CD\CD\1330\Arch\A703.dwg
 Tue, 14/Dec/04 02:33PM
 TAB: Layout1

ADDENDUM NUMBER

ATTACHMENT NUMBER

RECORD OF REVISIONS


No.	DATE	DESCRIPTION

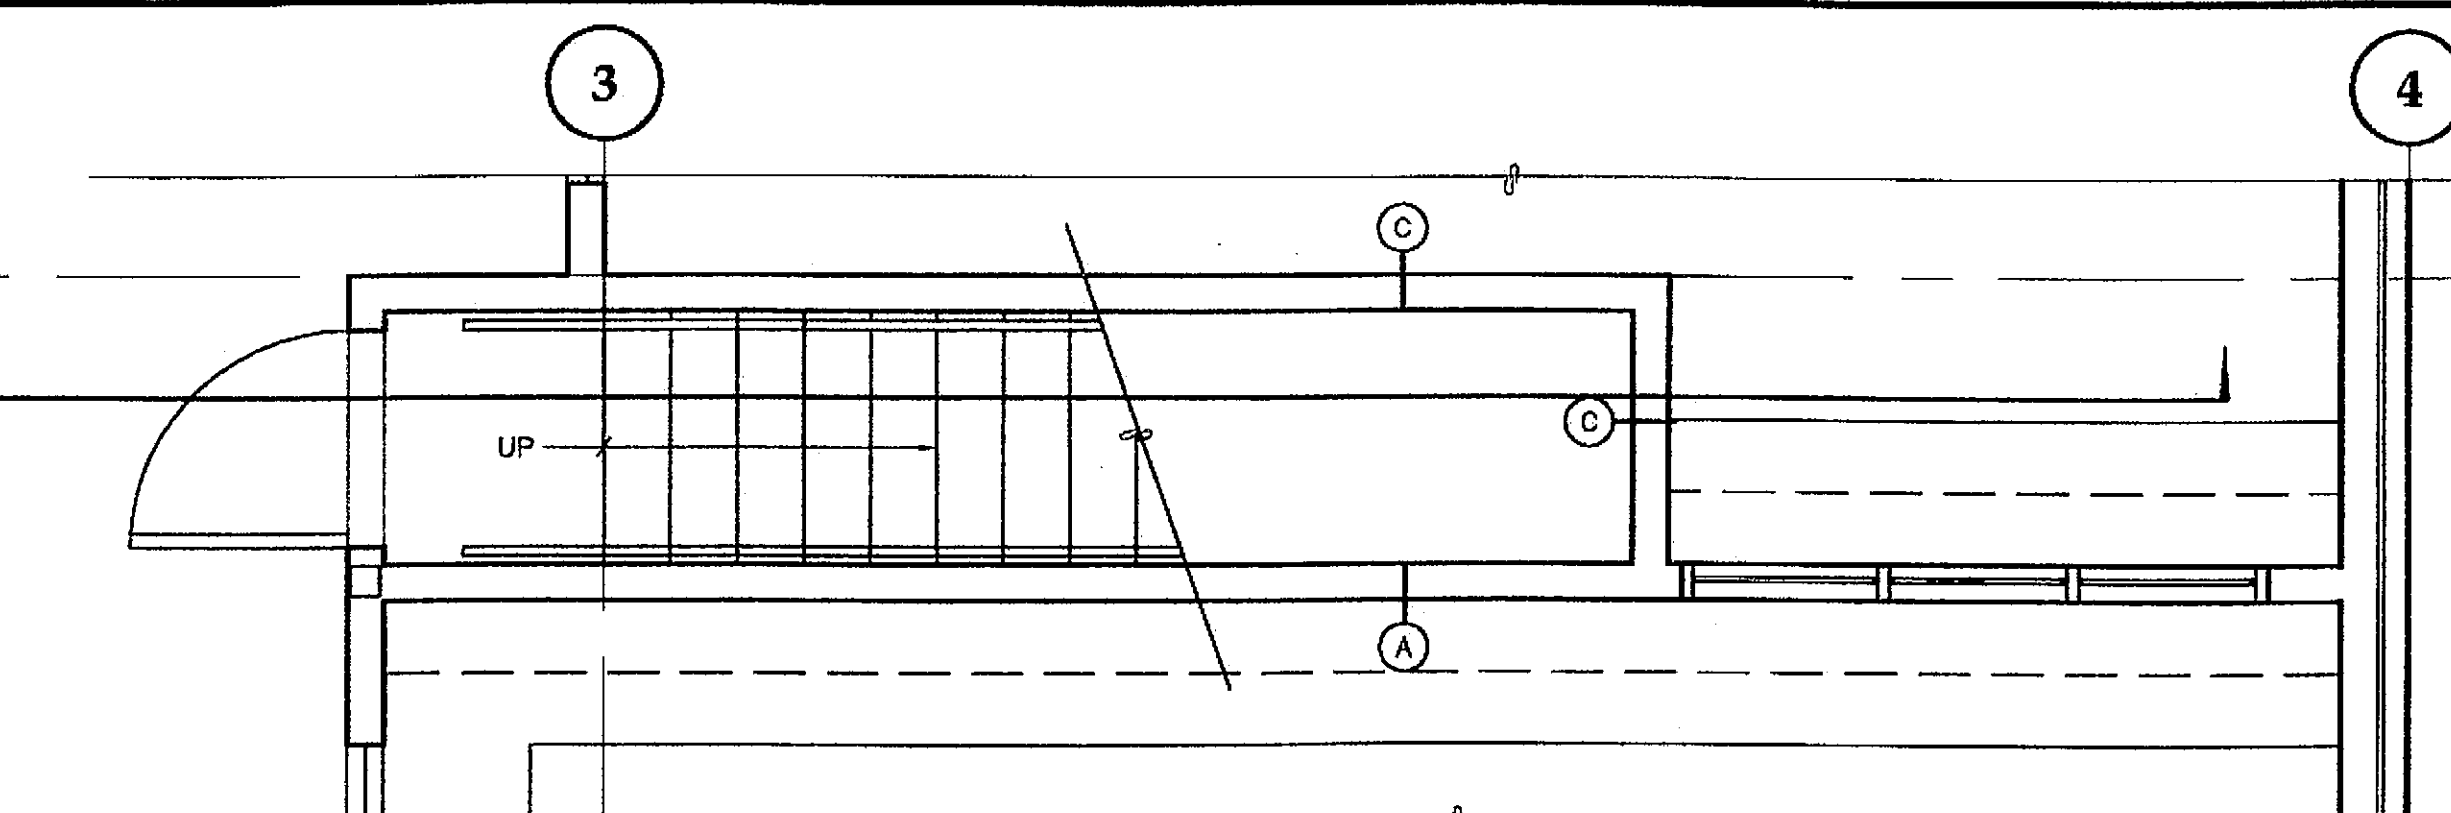

1 ENLARGED STAIR PLAN MAIN FLOOR

* SIM DELETE DOOR AT BOTTOM OF STAIR
 SEE 2/A202 FOR ENCLOSING WALL CONFIGURATION


SCALE: 0 2' 4' 8'

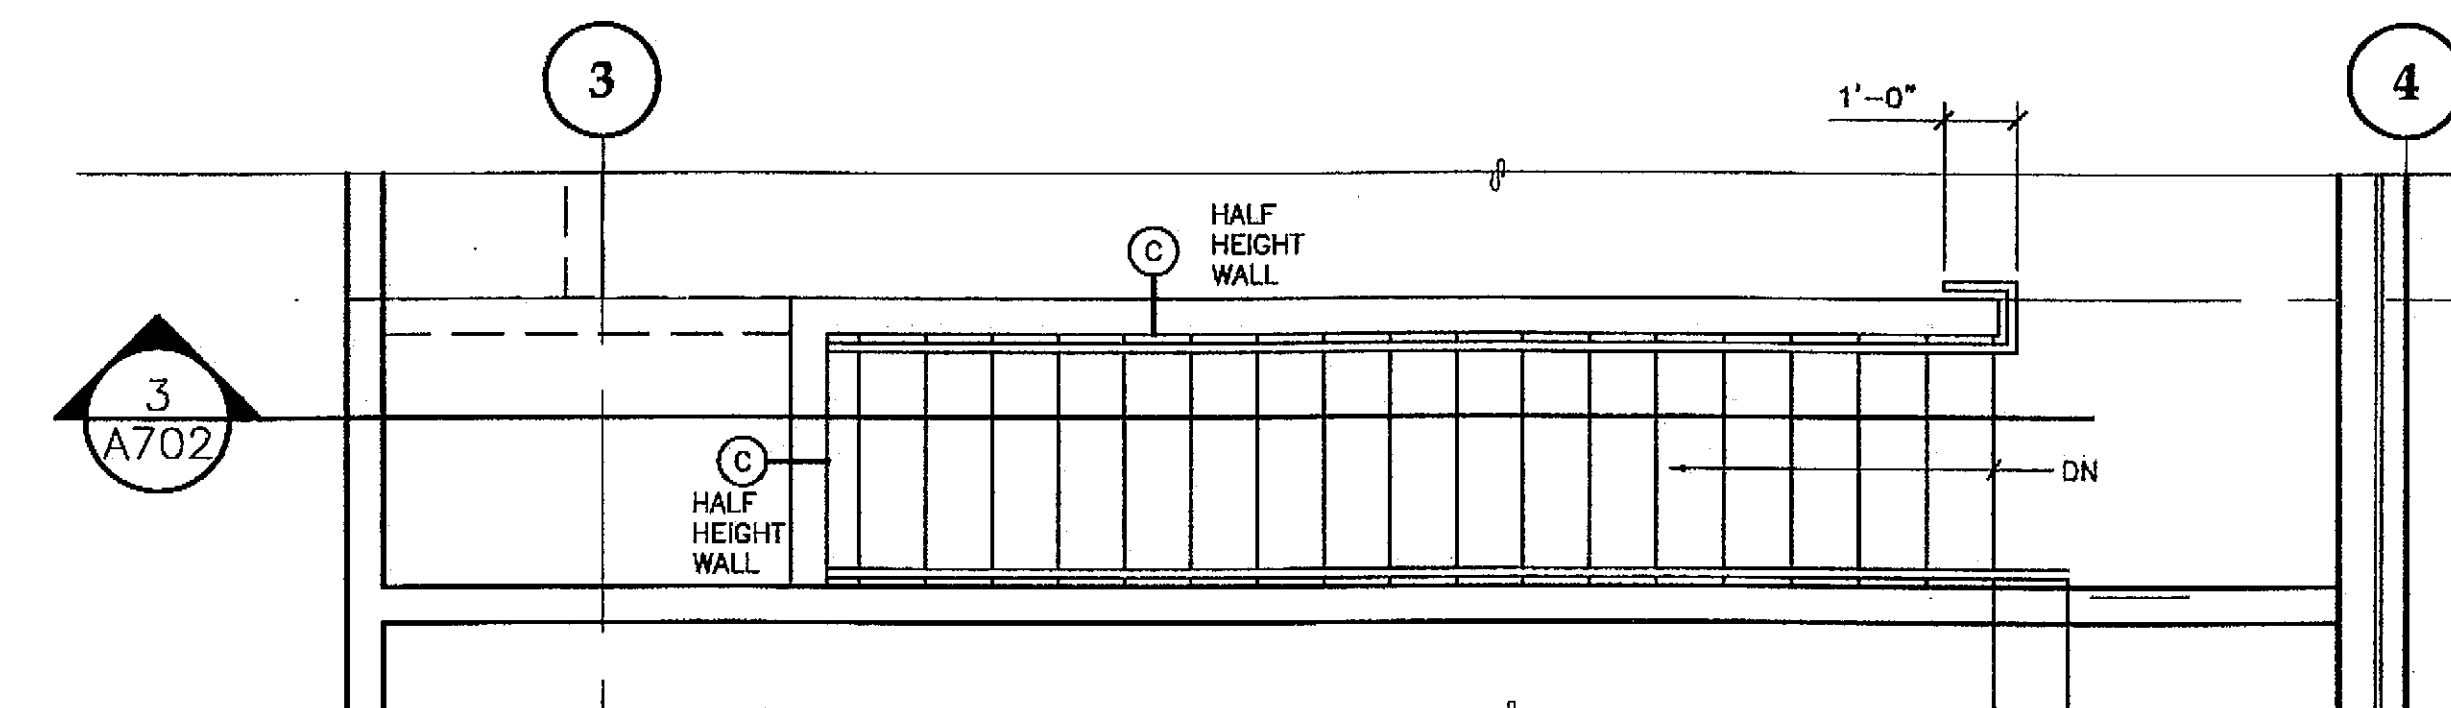

2 ENLARGED STAIR PLAN MECH ROOM


* SIM DELETE DOOR AT BOTTOM OF STAIR
 SEE 2/A202 FOR ENCLOSING WALL CONFIGURATION

SCALE: 0 2' 4' 8'

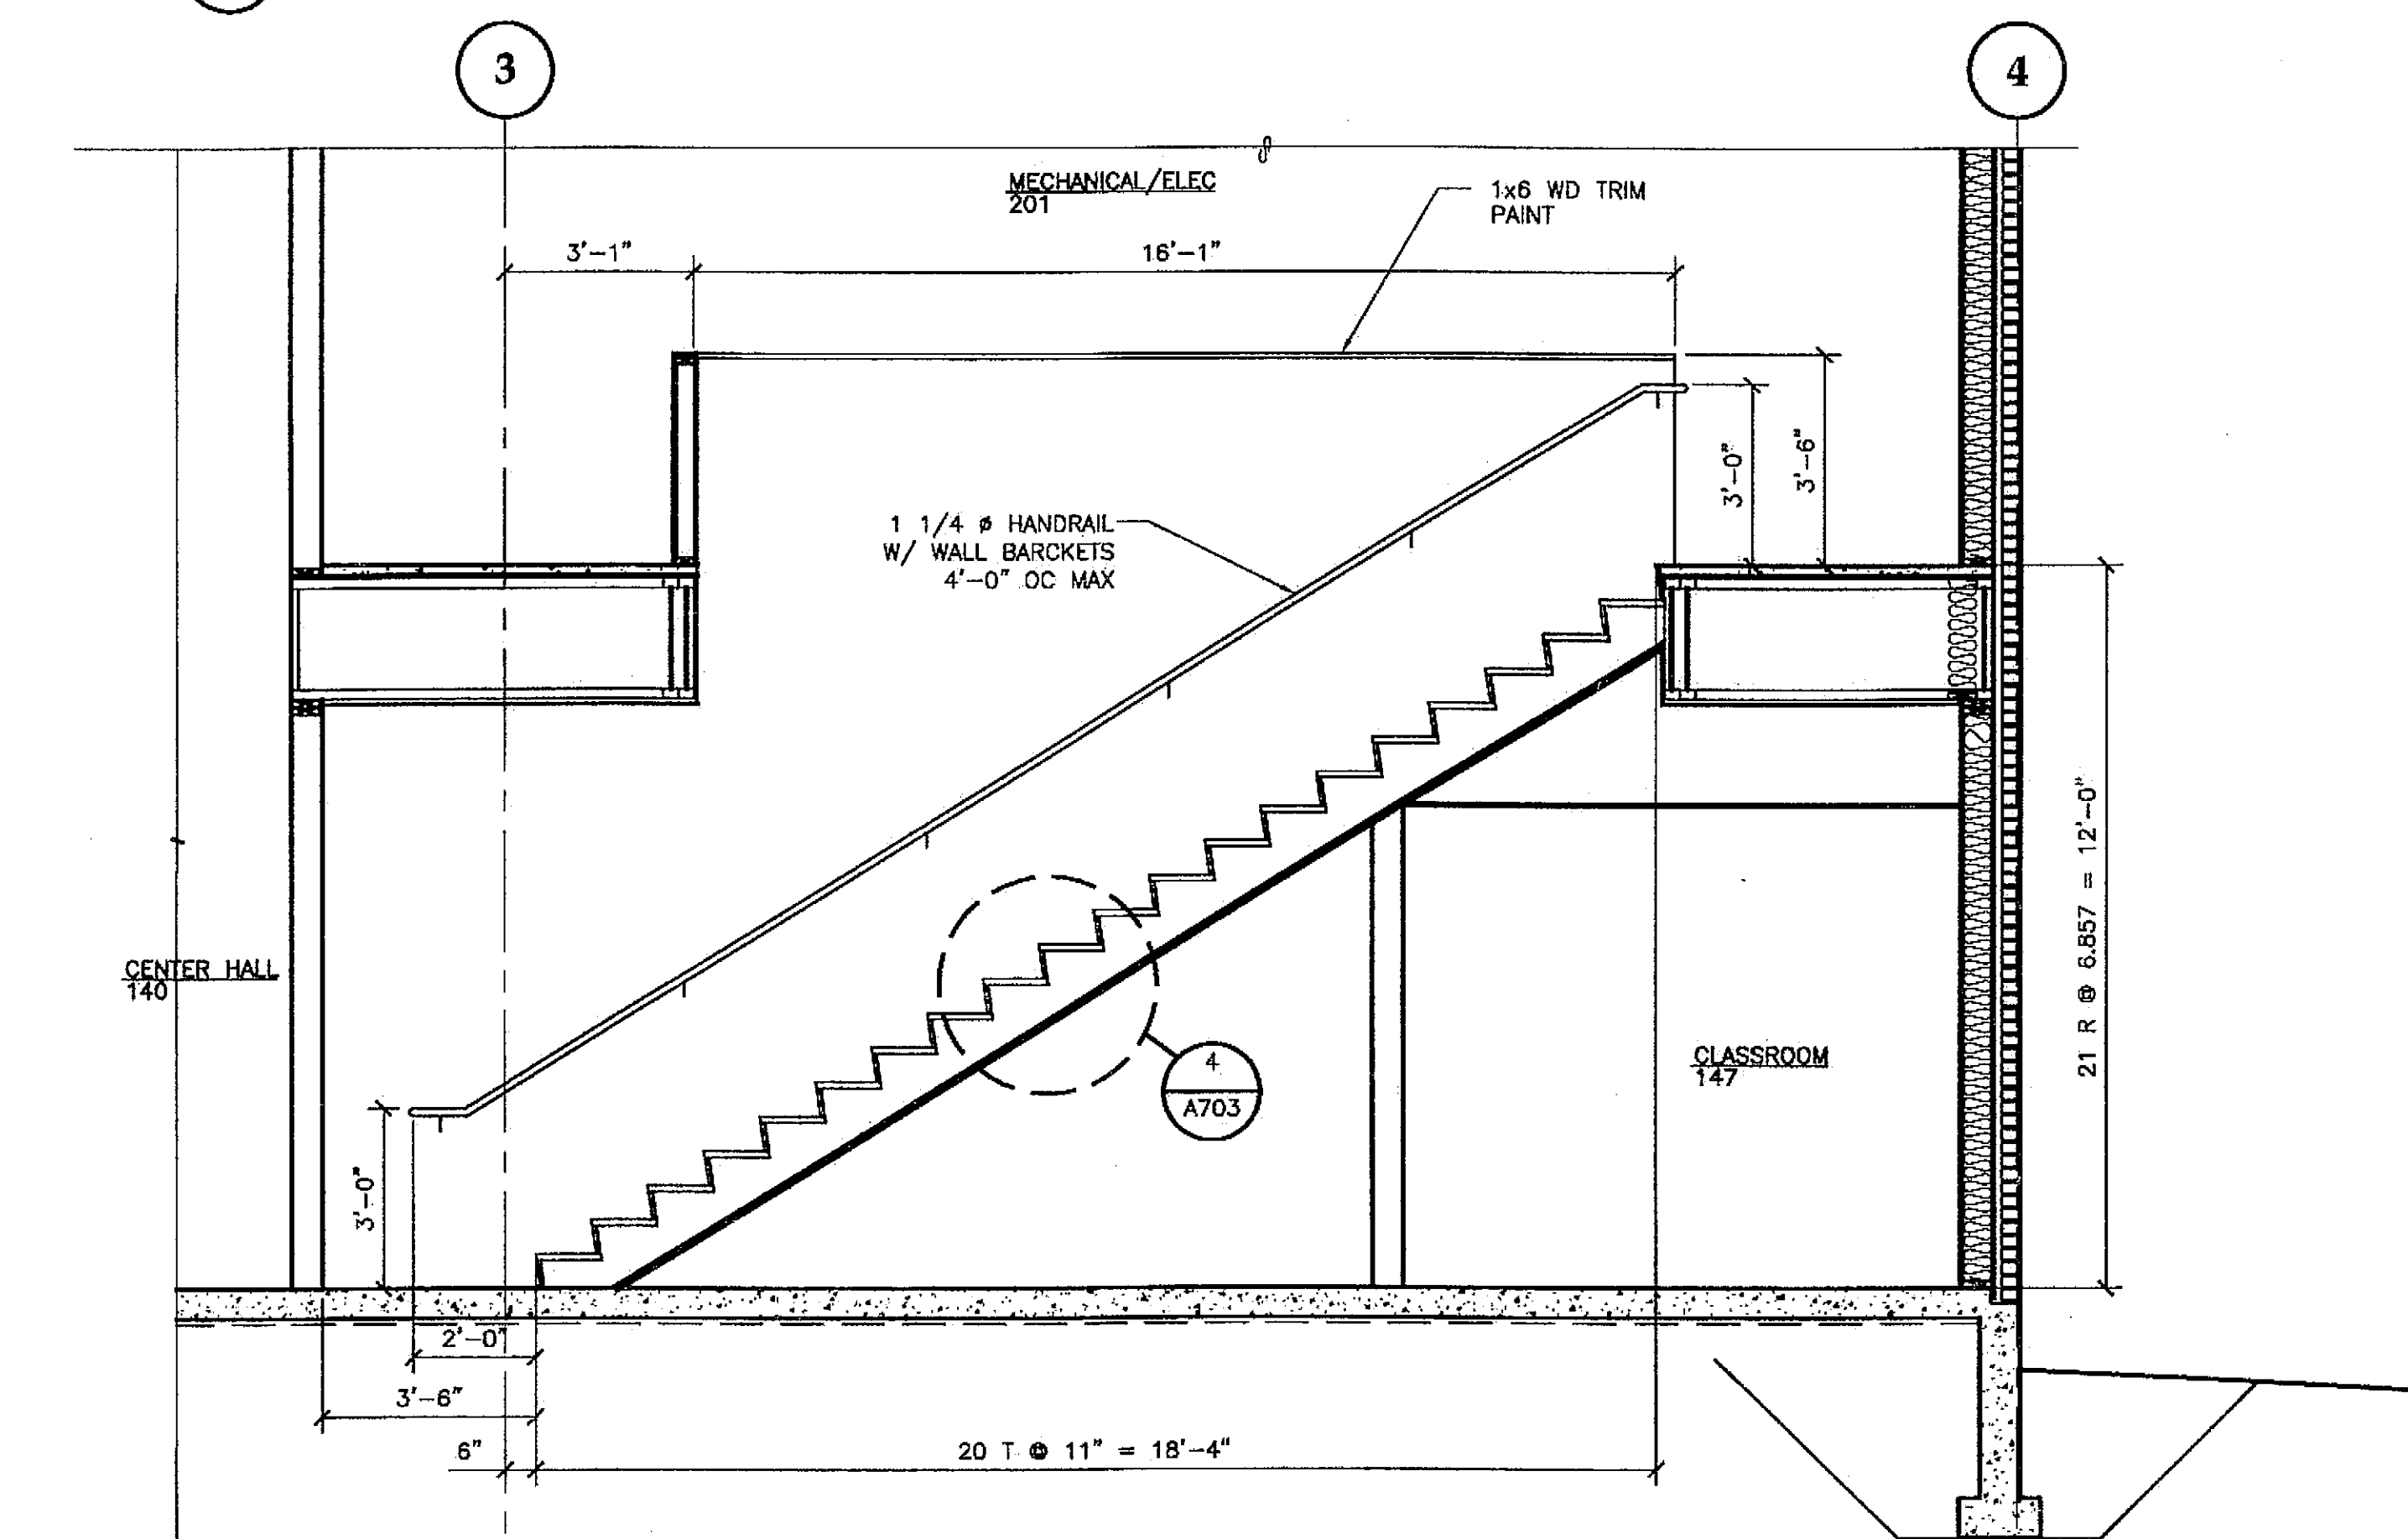

3 STAIR SECTION


SCALE: 0 2' 4' 8'

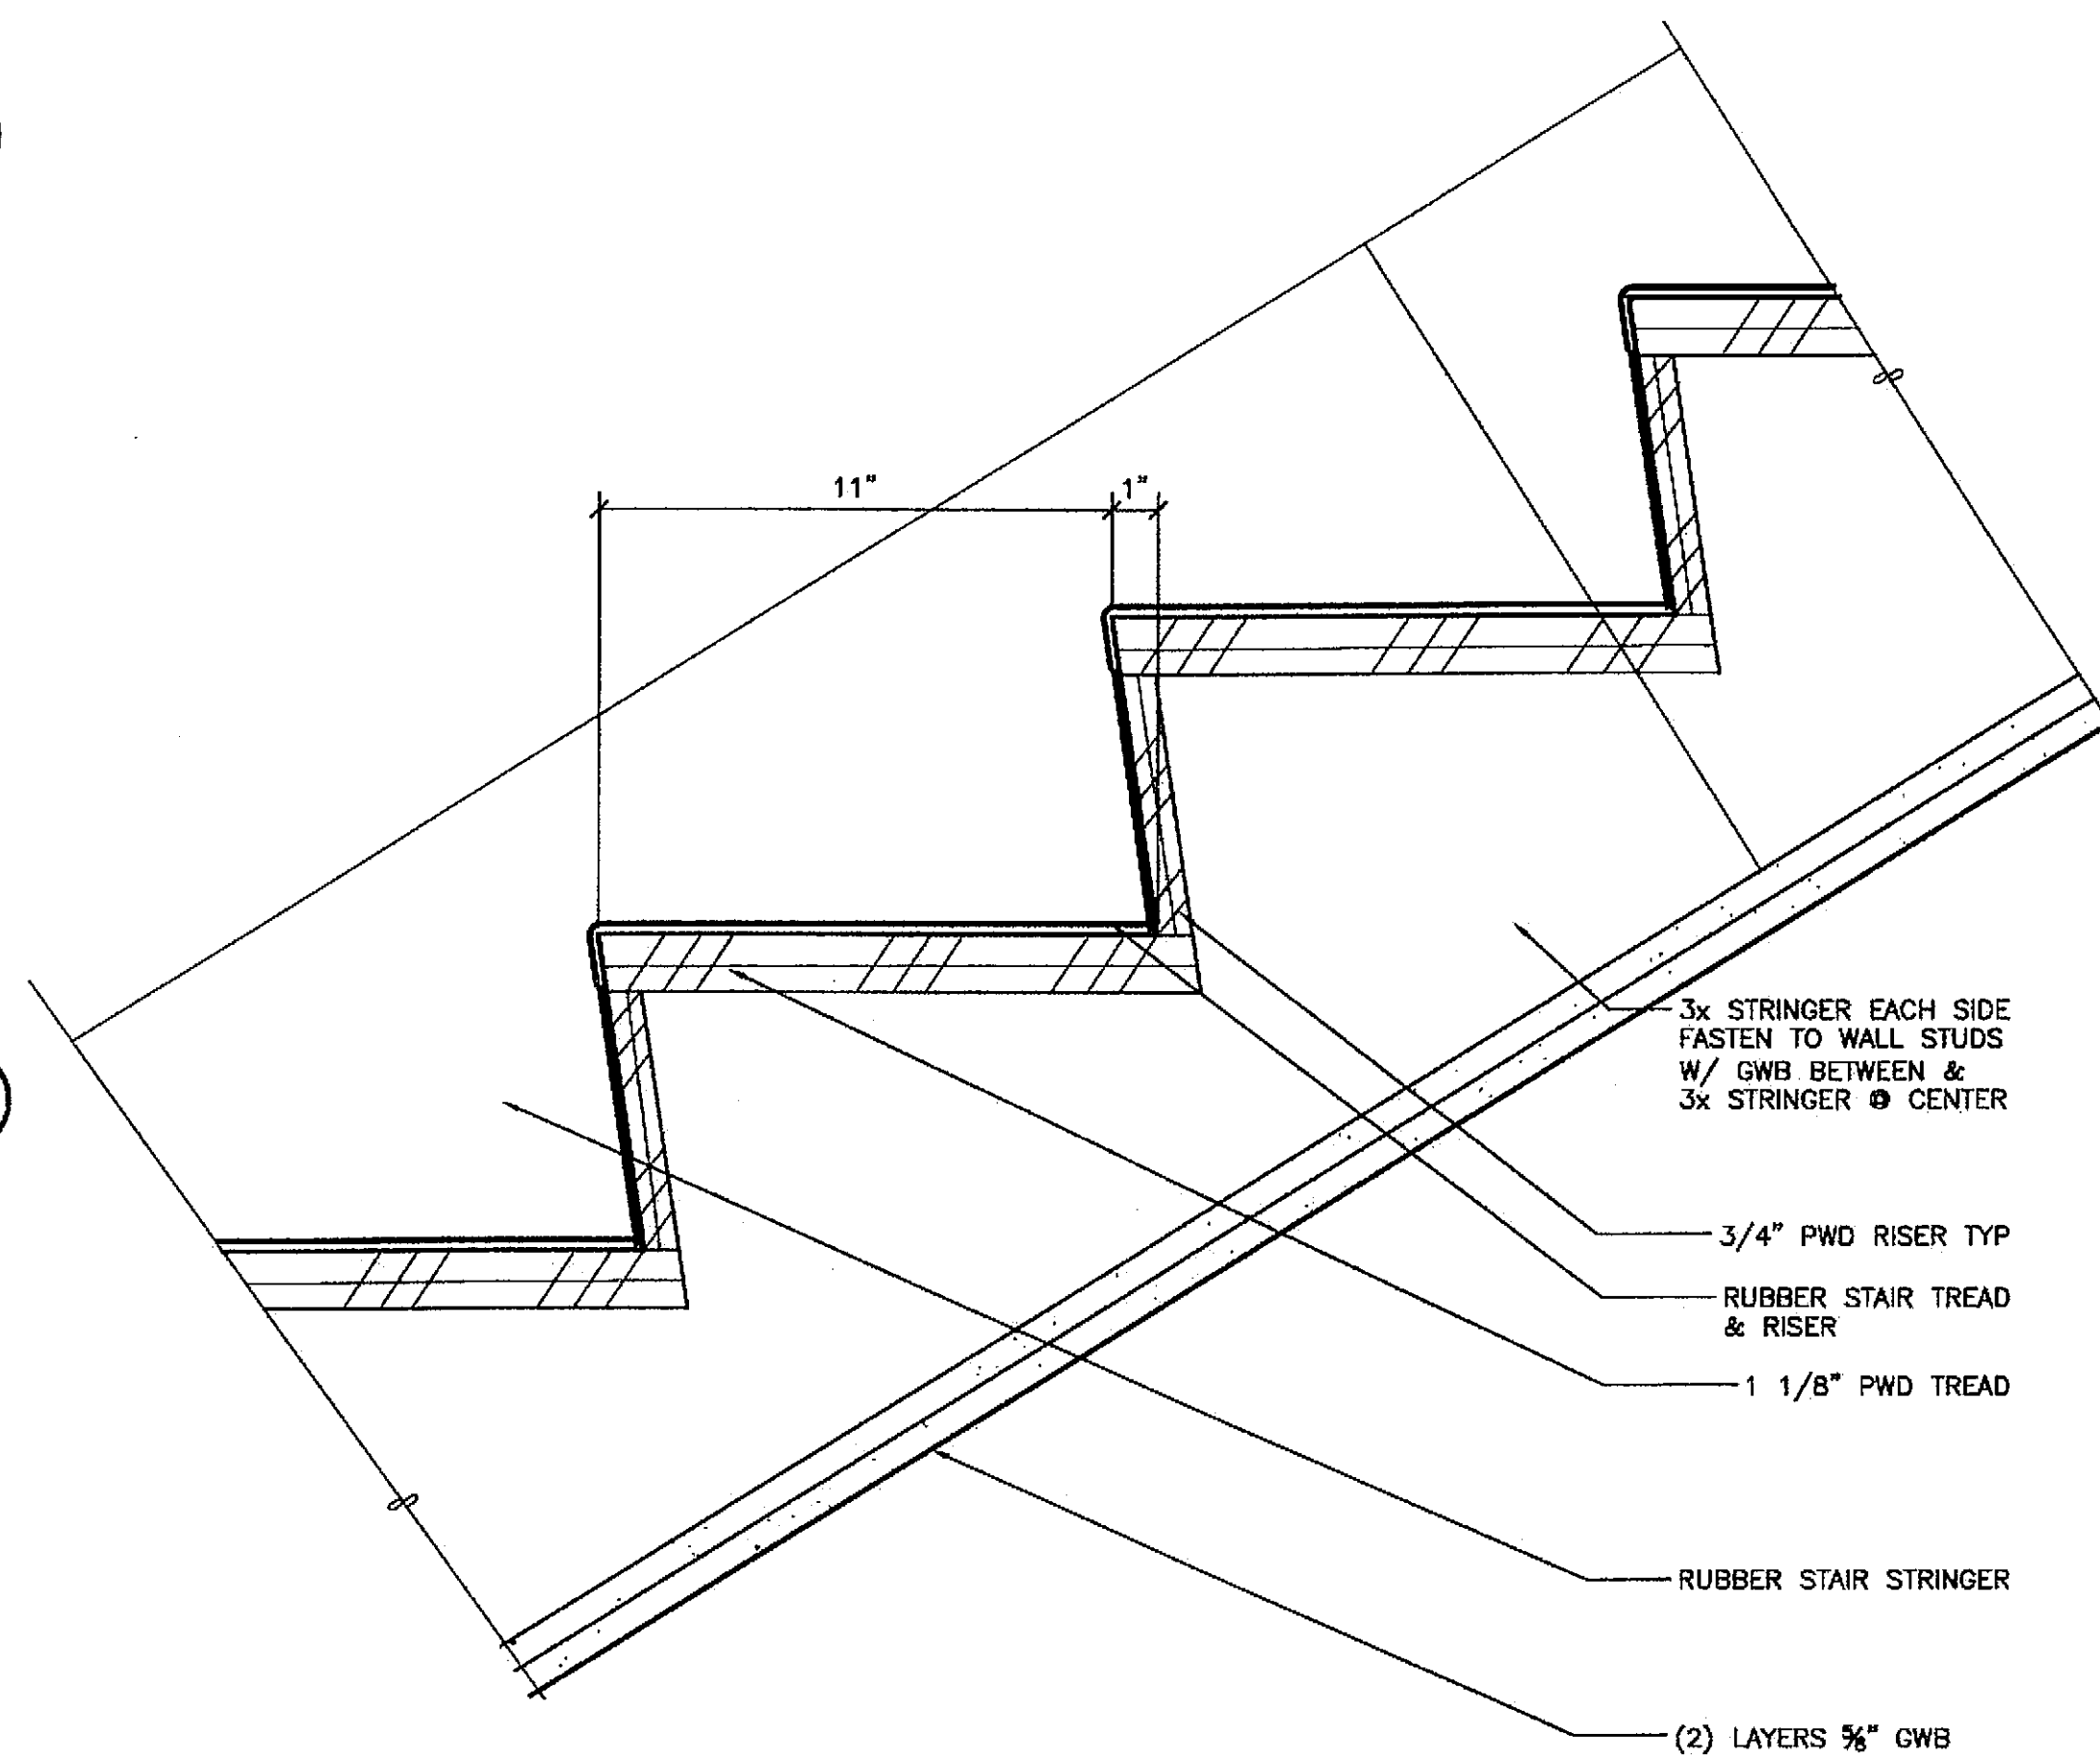

4 STAIR DETAIL

SCALE: 0 3" 6" 12"

CHECKED BY:

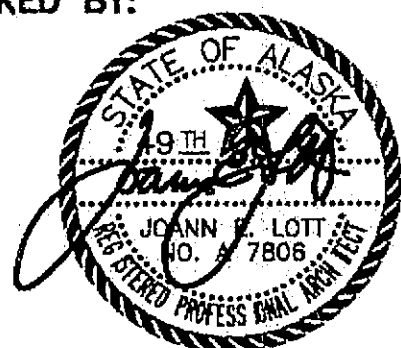

DESIGNED BY: JENSEN YORBA LOTT

DRAWN BY:

STATE OF ALASKA
 DEPARTMENT OF TRANSPORTATION
 & PUBLIC FACILITIES
 STATEWIDE DESIGN & ENGINEERING
 SERVICES DIVISION
 MT EDGE CUMBE
 HIGH SCHOOL
 BUILDING 1330
 ACADEMIC
 EXPANSION

SHEET A703

PROJECT DESIGNATION NUMBER

67751C

STATE	YEAR
ALASKA	2004
SHEET NUMBER	TOTAL SHEETS
26	79

Project As-Built Drawings have been
 reviewed by the Project Engineer and
 represent to the best of my knowledge, the
 project as constructed.
 Proj. Eng. *[Signature]* Date 2-07

PATH: G:\Projects\0411\CD\1330\Arch\A801.dwg

Tue, 14/Dec/04 02:33PM




TAB: Layout1

ADDENDUM NUMBER

ATTACHMENT NUMBER

RECORD OF REVISIONS




No.	DATE	DESCRIPTION

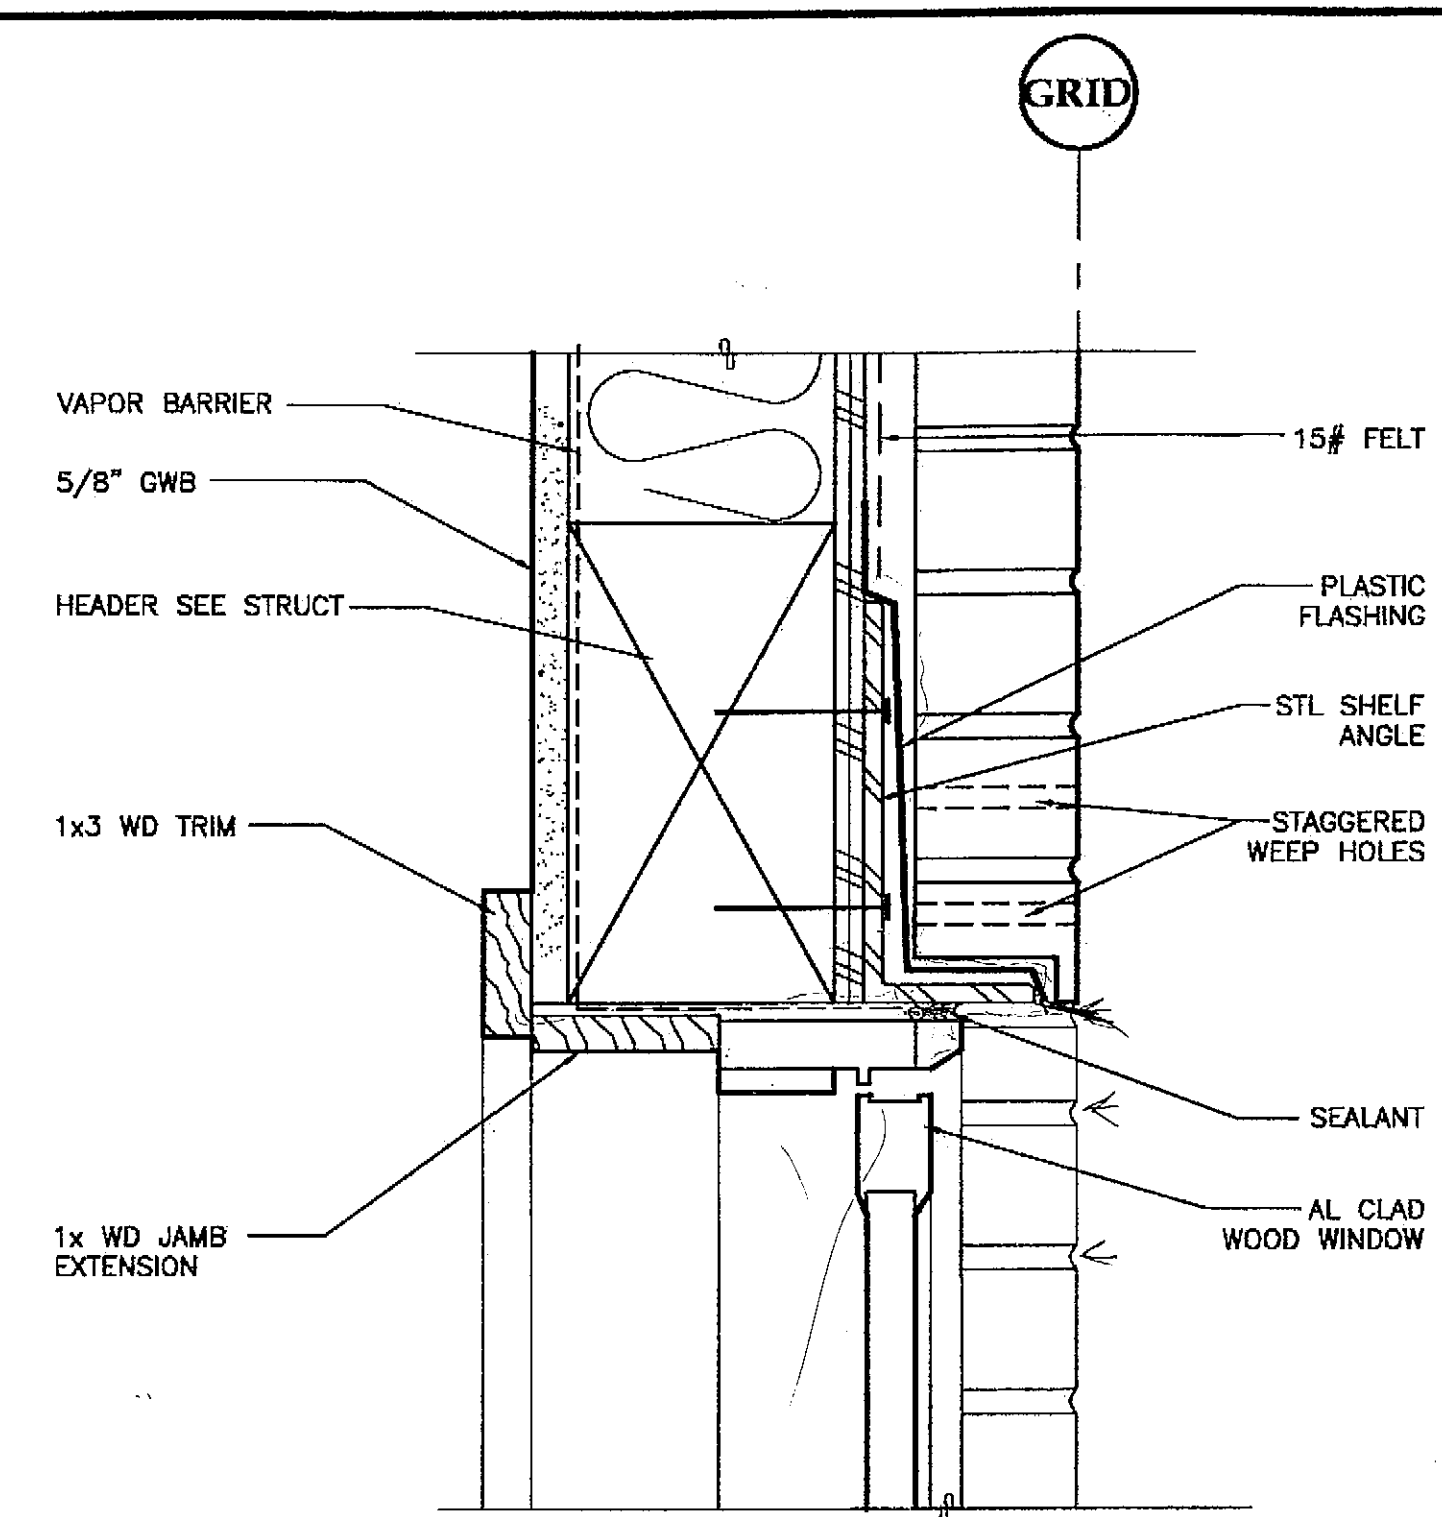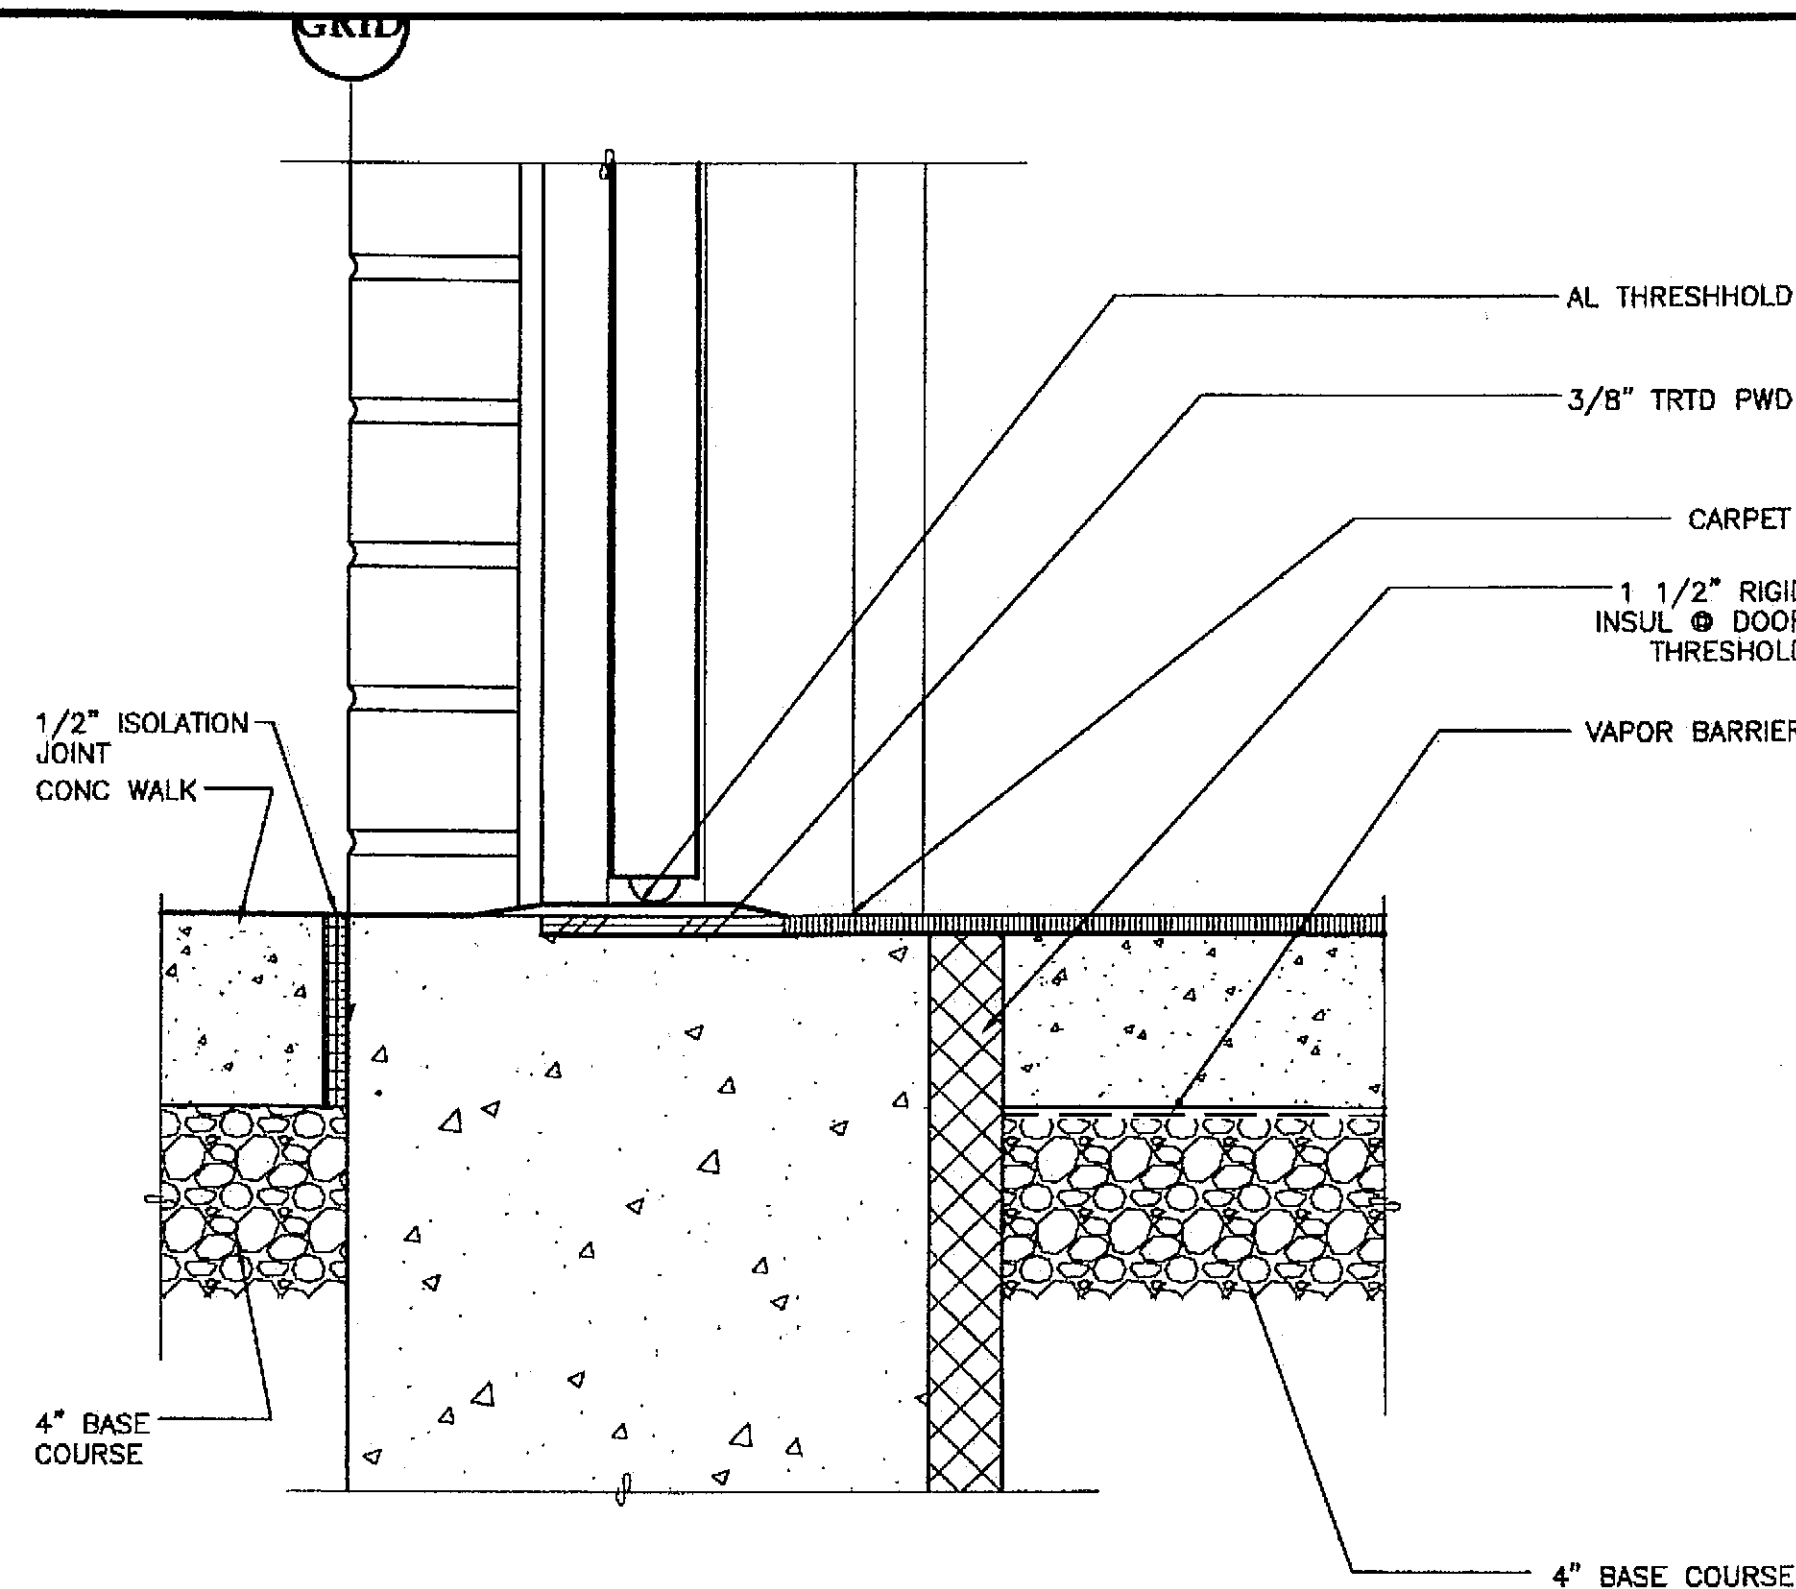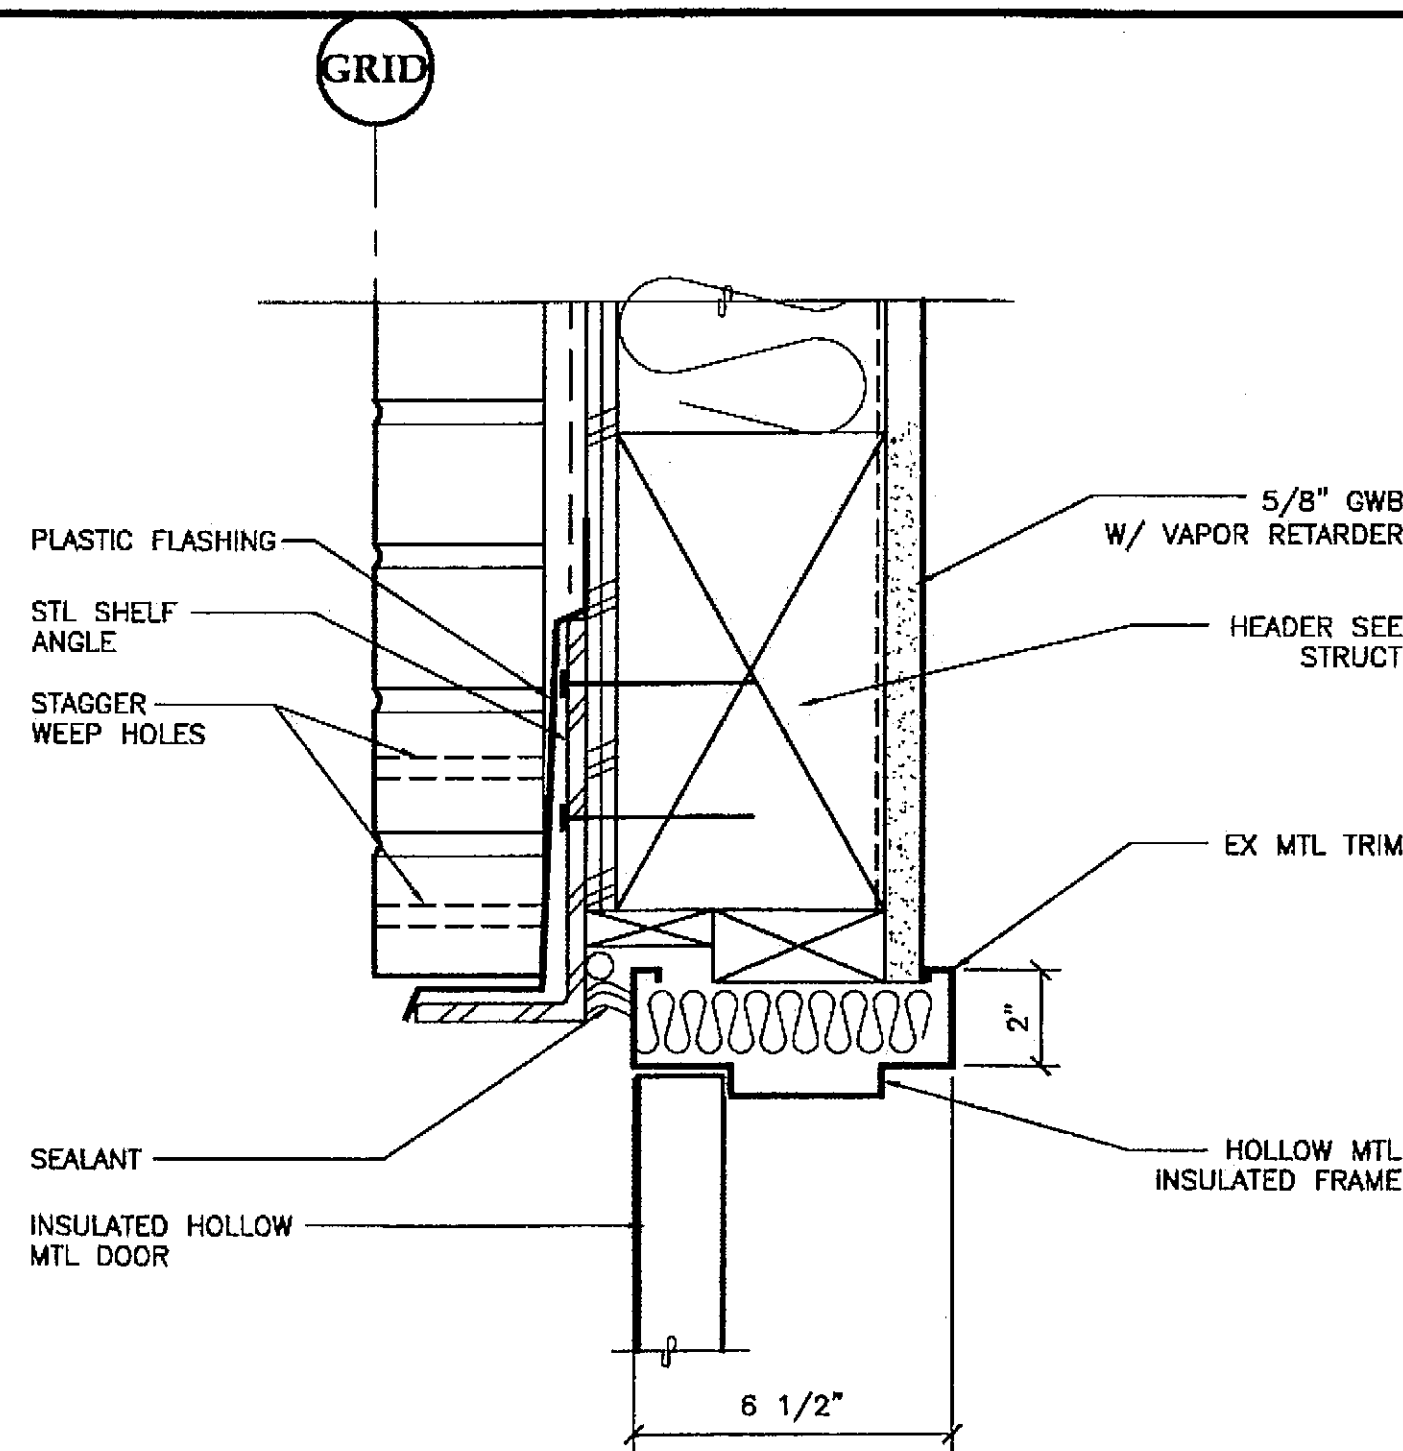

1 DOOR HEAD DETAIL SCALE: 0 3" 6" 12"

2 FOOTING DETAIL SCALE: 0 3" 6" 12"

3 WINDOW HEAD DETAIL SCALE: 0 3" 6" 12"

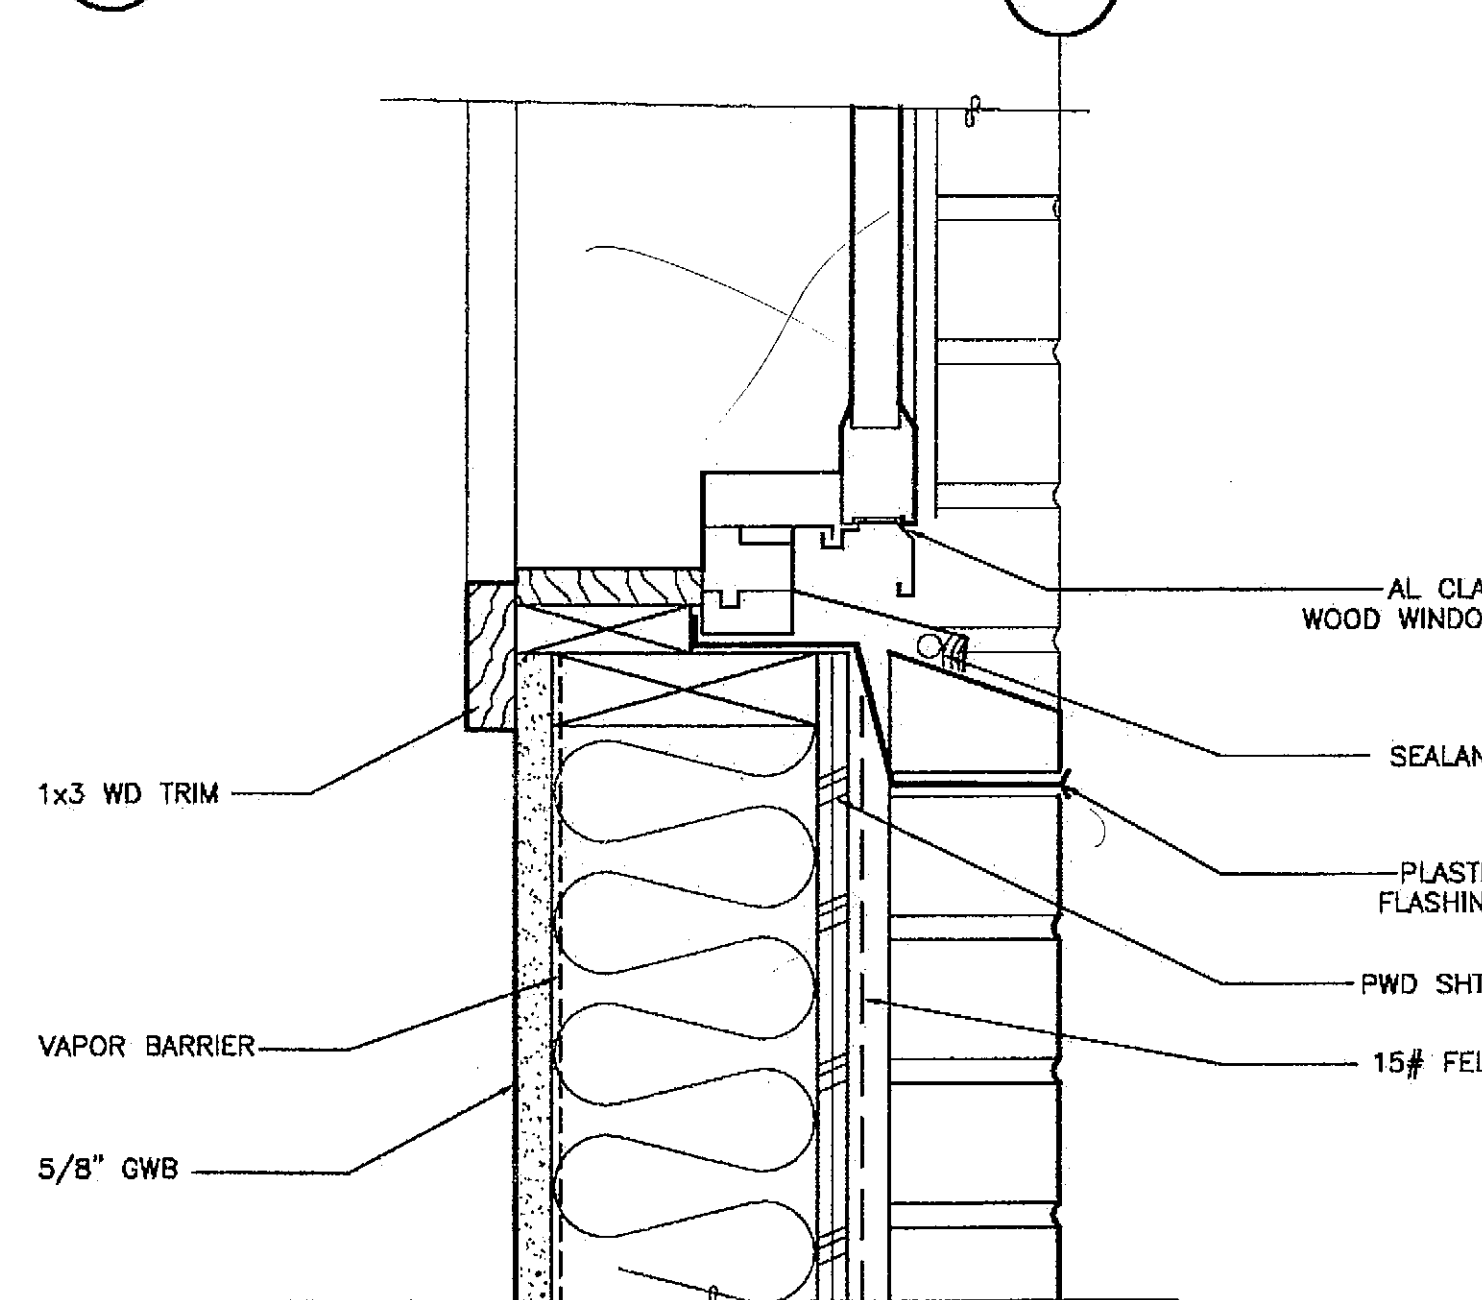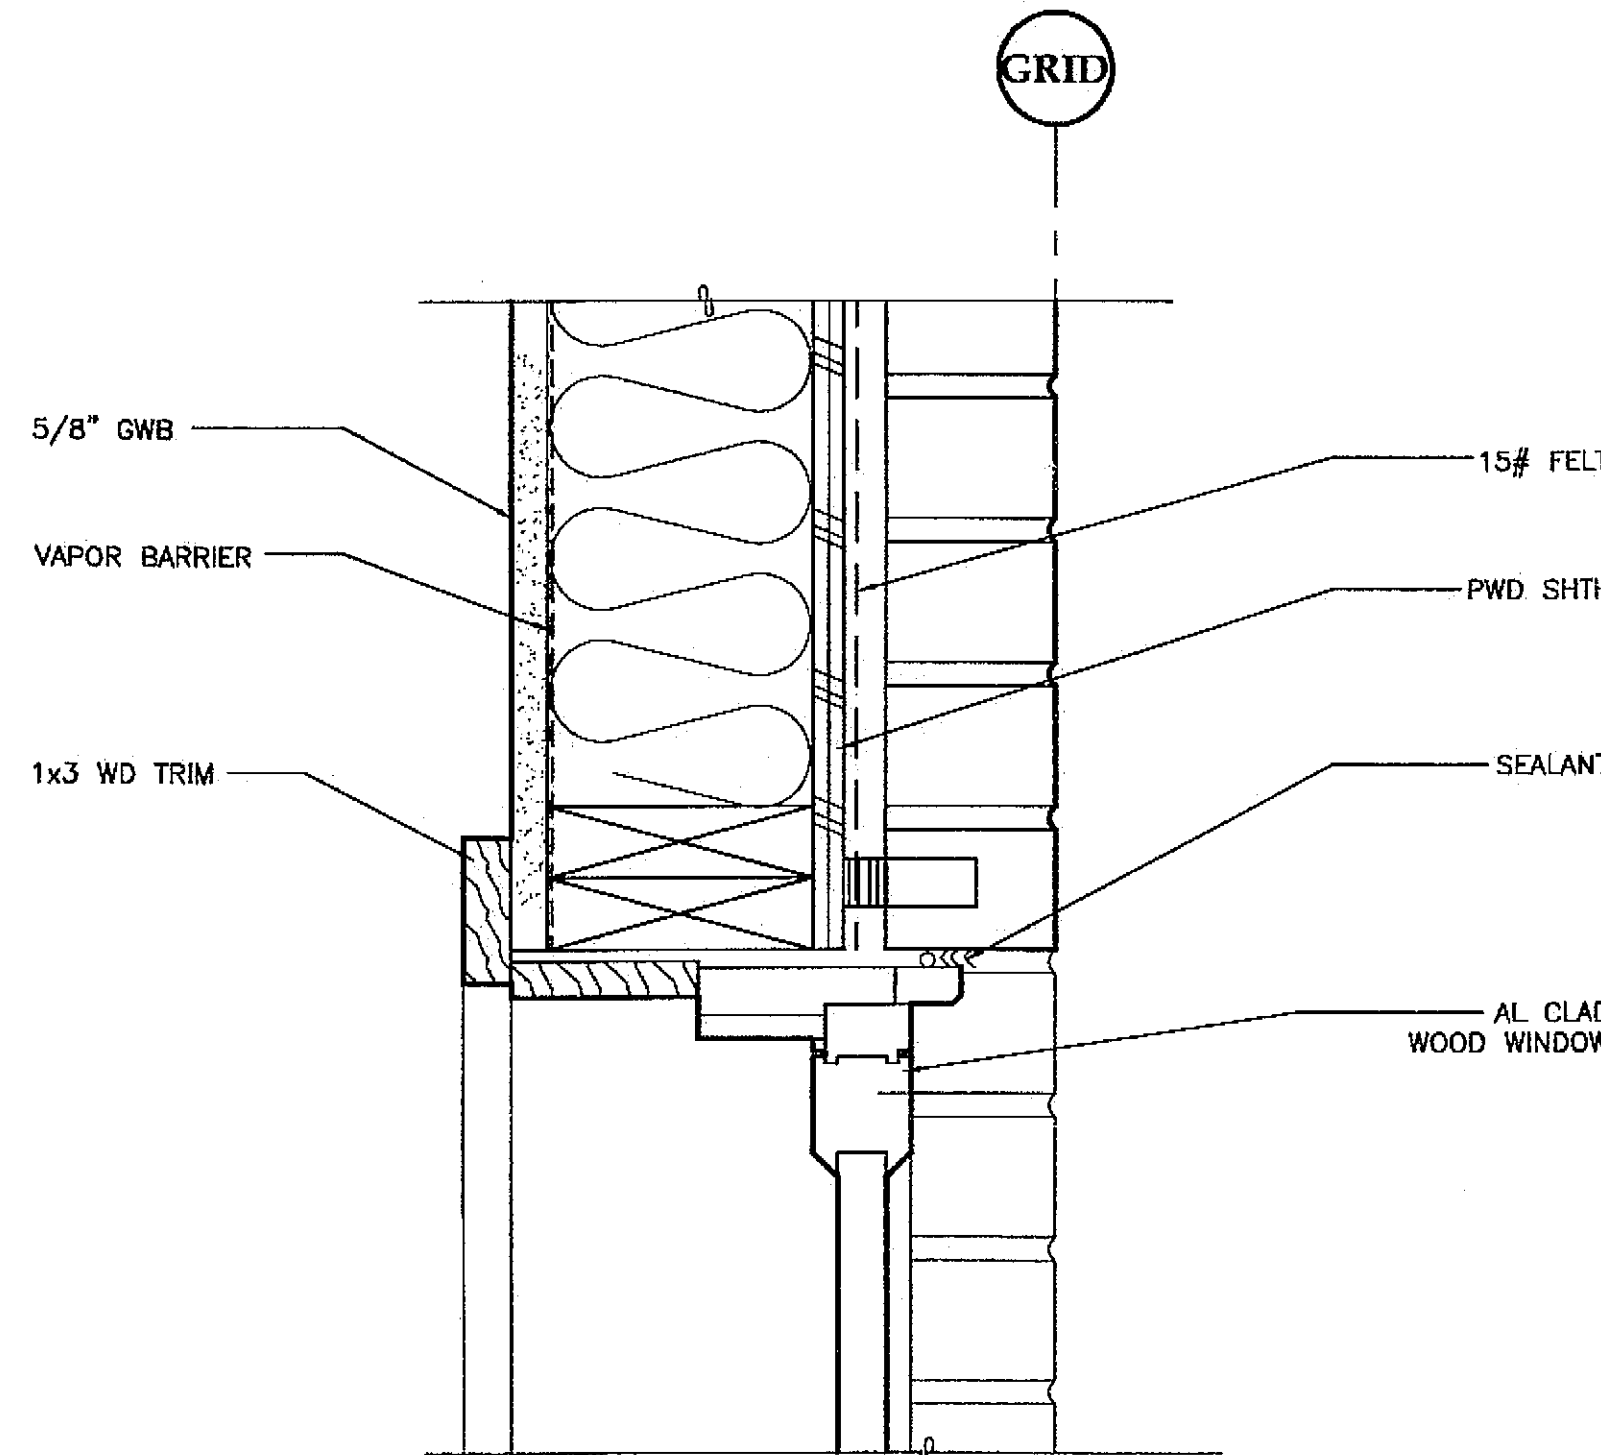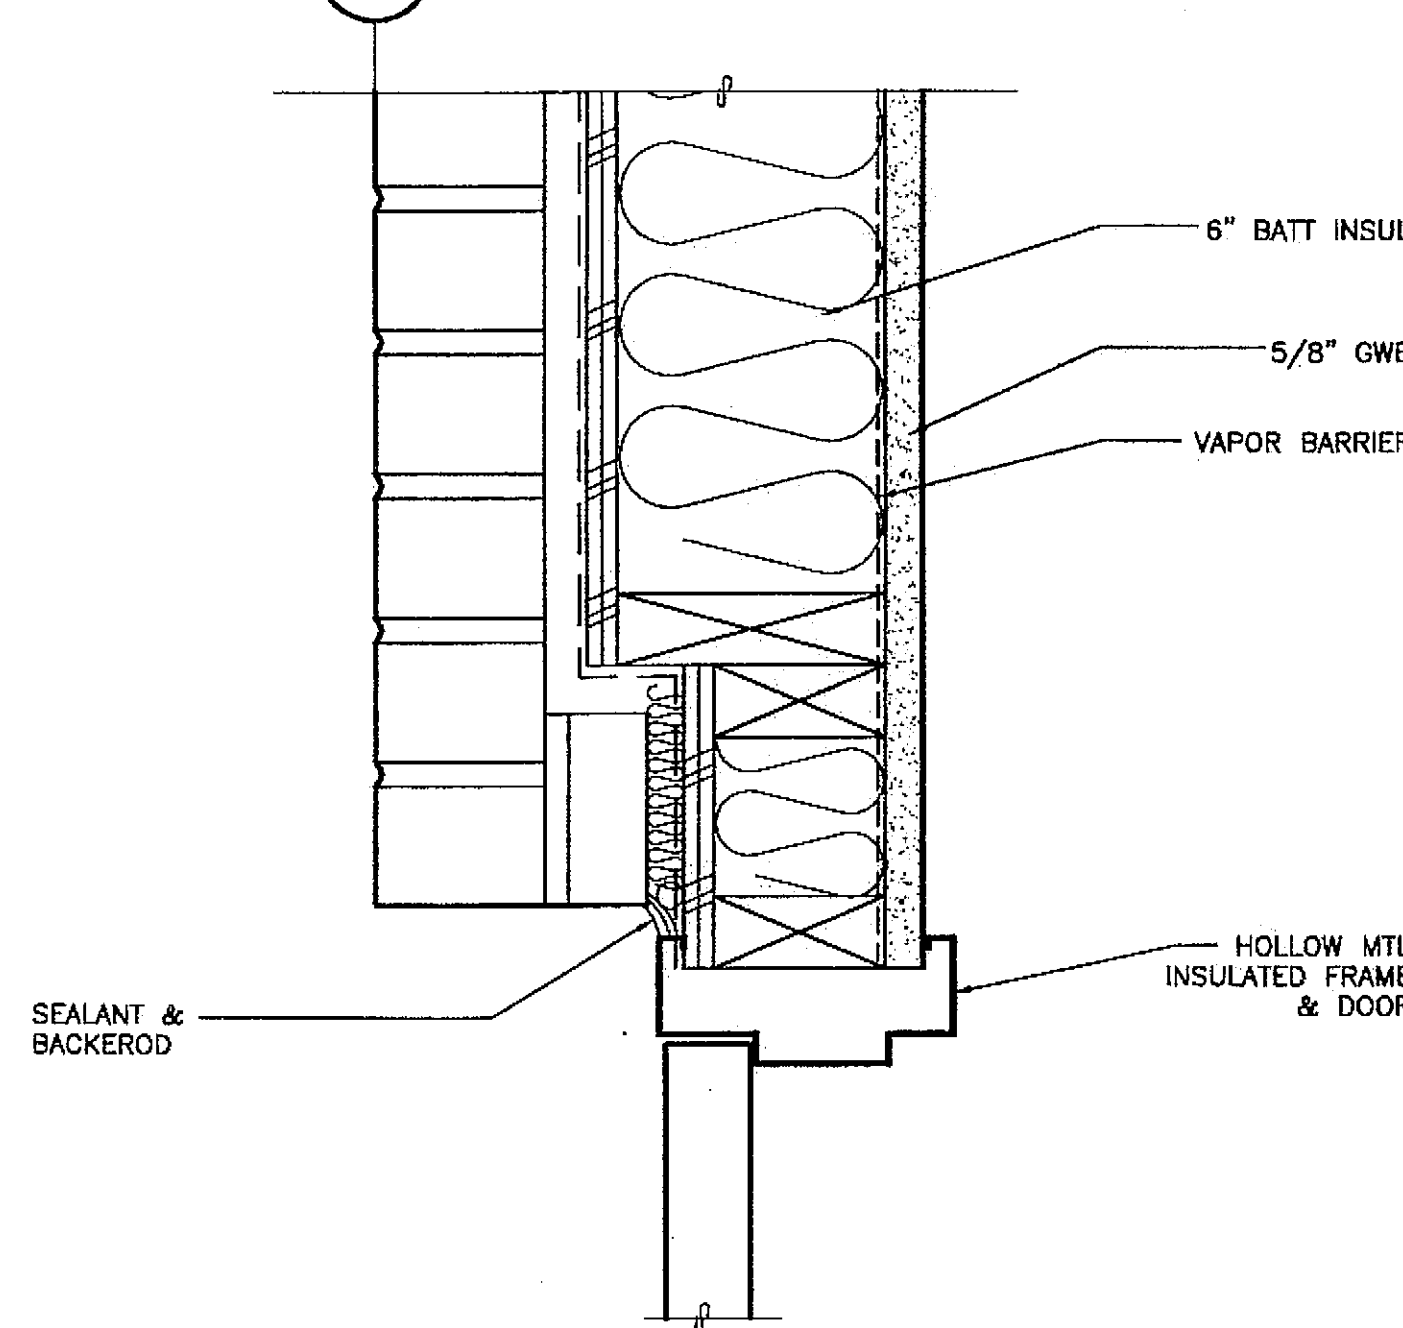

4 DOOR JAMB DETAIL SCALE: 0 3" 6" 12"


5 WINDOW JAMB DETAIL SCALE: 0 3" 6" 12"

6 WINDOW SILL DETAIL SCALE: 0 3" 6" 12"

SEE 3/A801 FOR SIMILAR CALLOUTS

SEE 3/A801 FOR SIMILAR CALLOUTS

CHECKED BY:

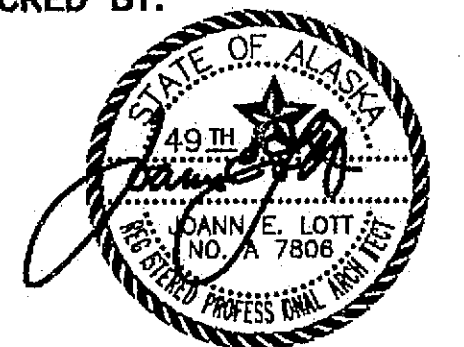

DESIGNED BY: JENSEN YORBA LOTT

DRAWN BY:

STATE OF ALASKA
DEPARTMENT OF TRANSPORTATION
& PUBLIC FACILITIES
STATEWIDE DESIGN & ENGINEERING
SERVICES DIVISION
MT EDGECUMBE
HIGH SCHOOL
BUILDING 1330
ACADEMIC
EXPANSION


SHEET A801

PROJECT DESIGNATION NUMBER

67751C


STATE	YEAR
ALASKA	2004
SHEET NUMBER	TOTAL SHEETS
27	79

Project As-Built Drawings have been reviewed by the Project Engineer and represent to the best of my knowledge, the project as constructed.
Proj. Eng. *[Signature]* Date 7-07

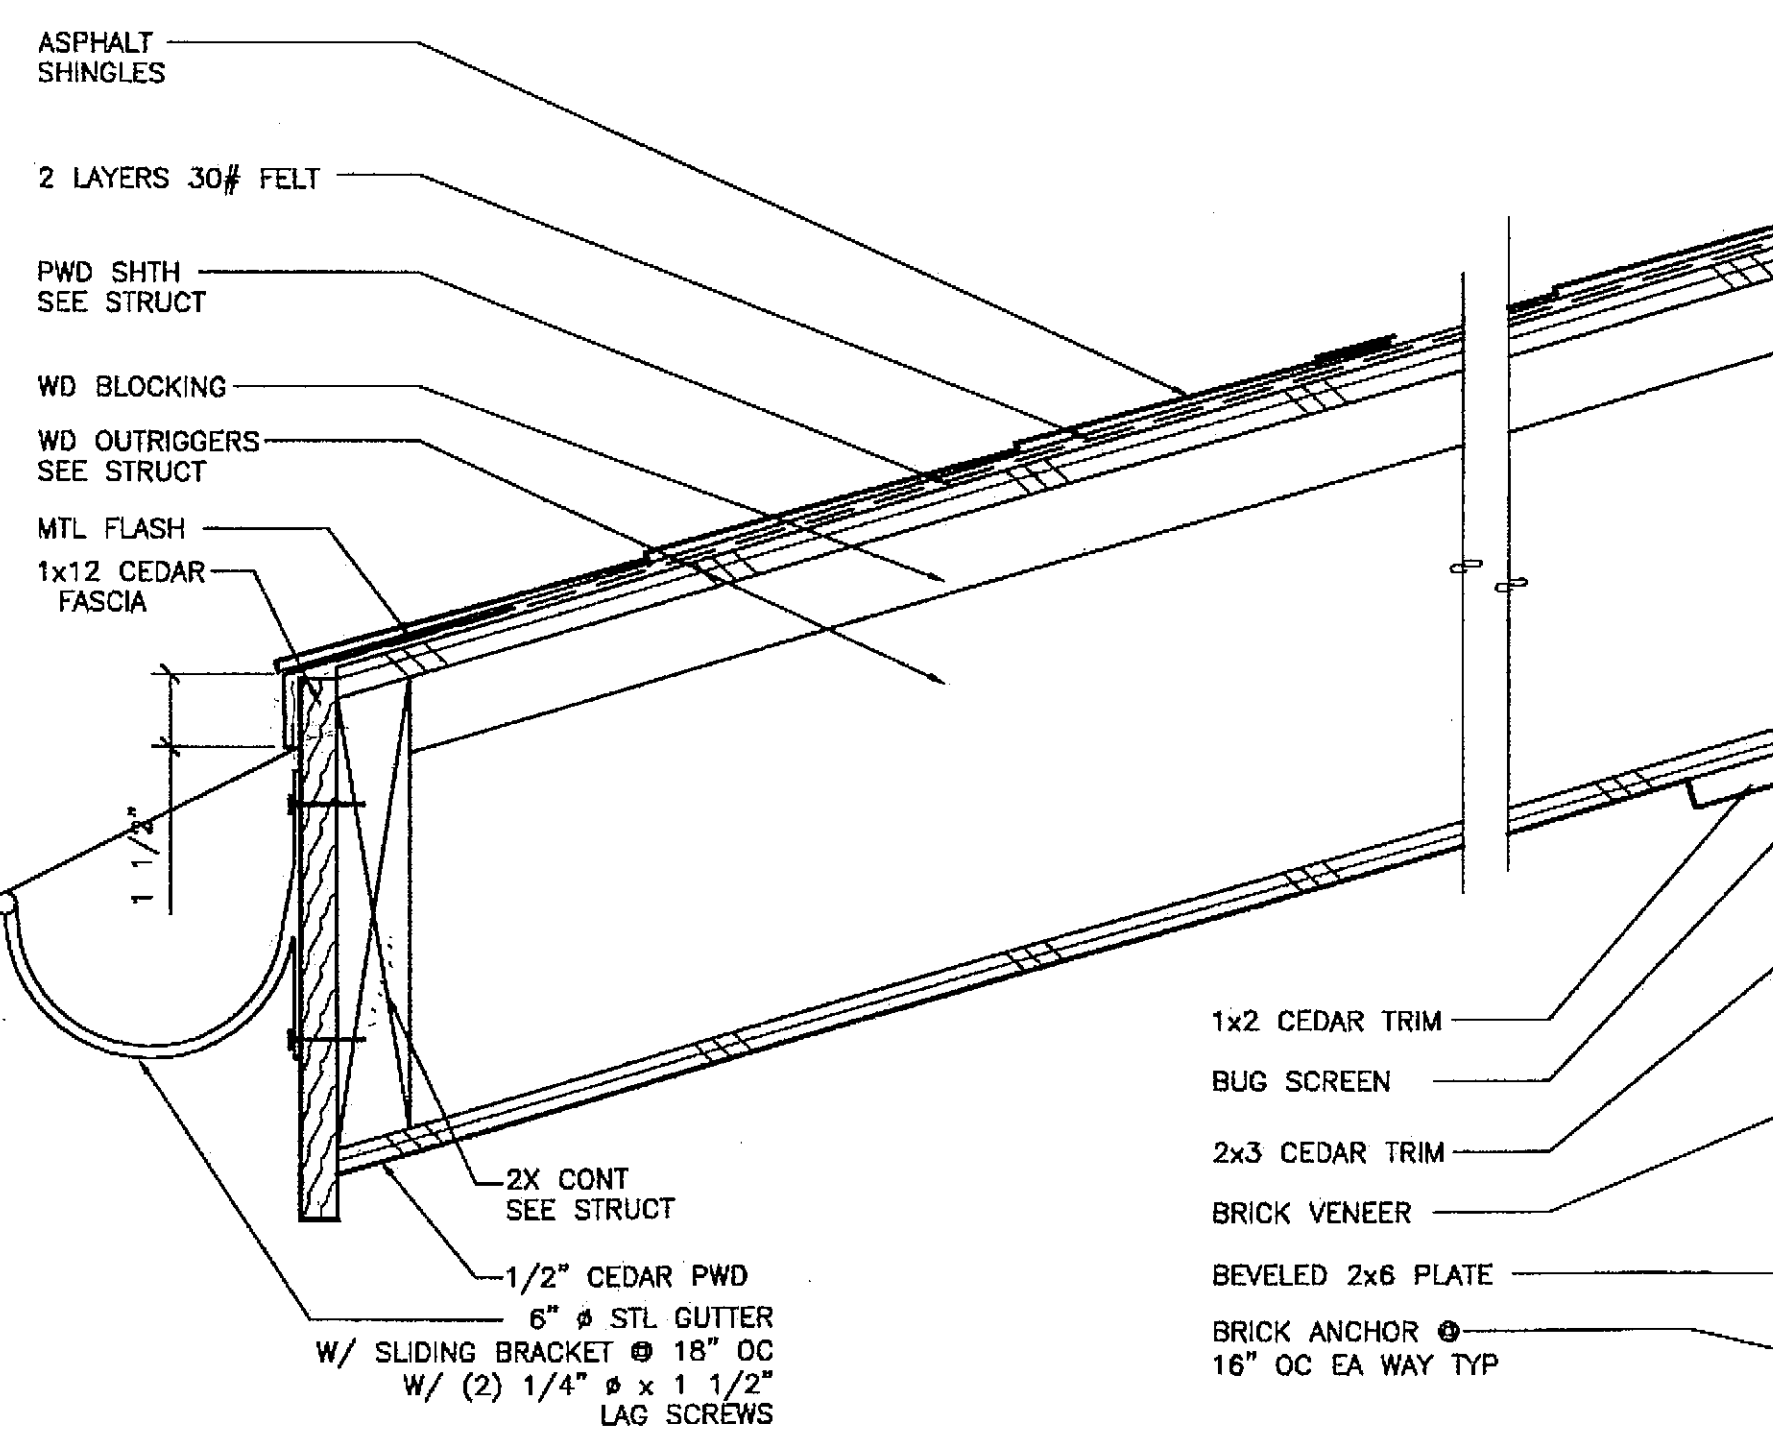


1 EAVE DETAIL

SCALE: 0 3" 6" 12"

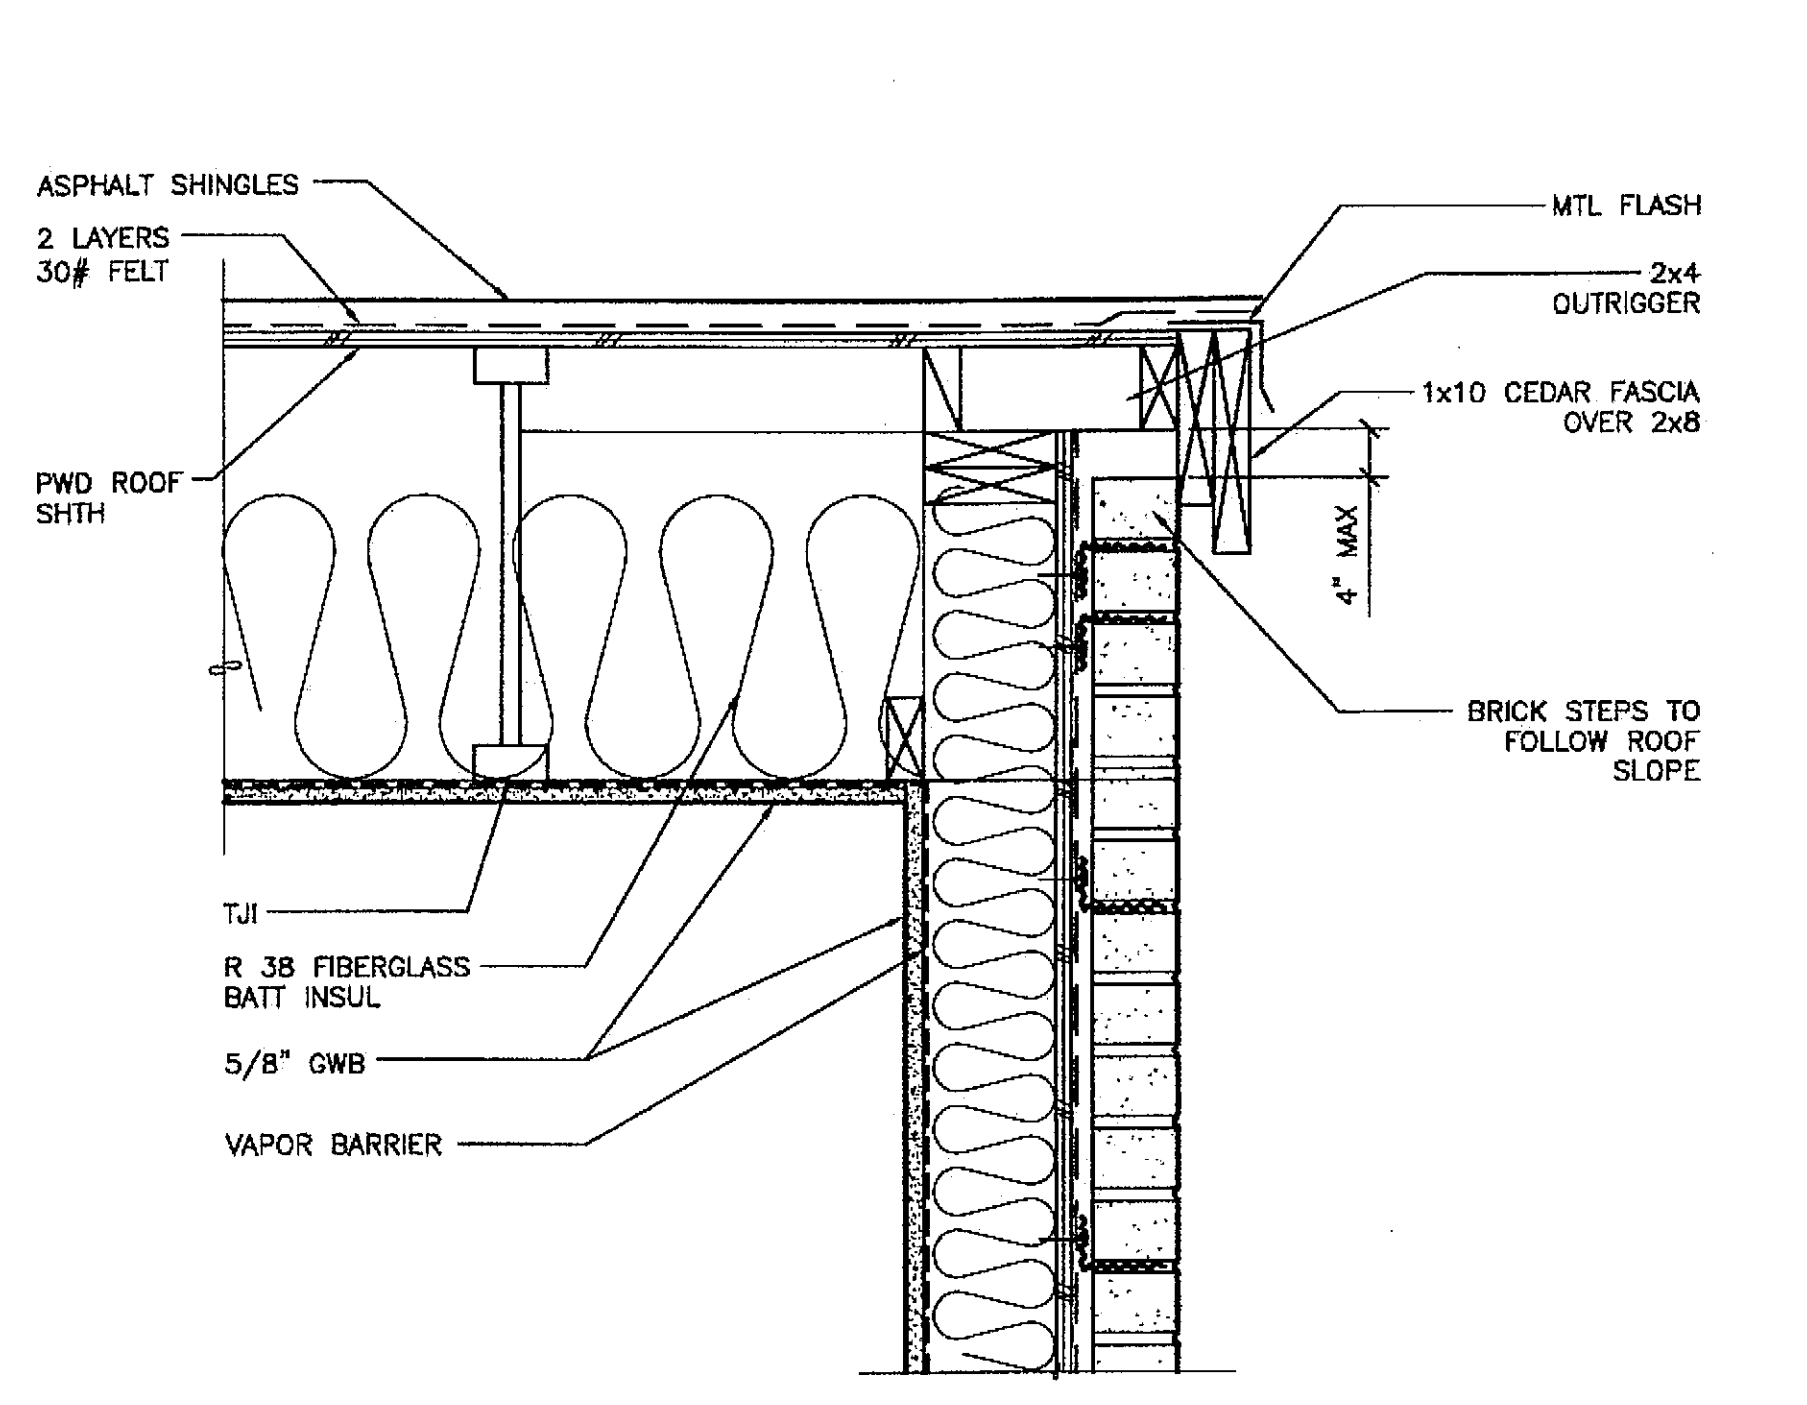


3 END WALL ROOF

SCALE: 0 6" 1' 2'

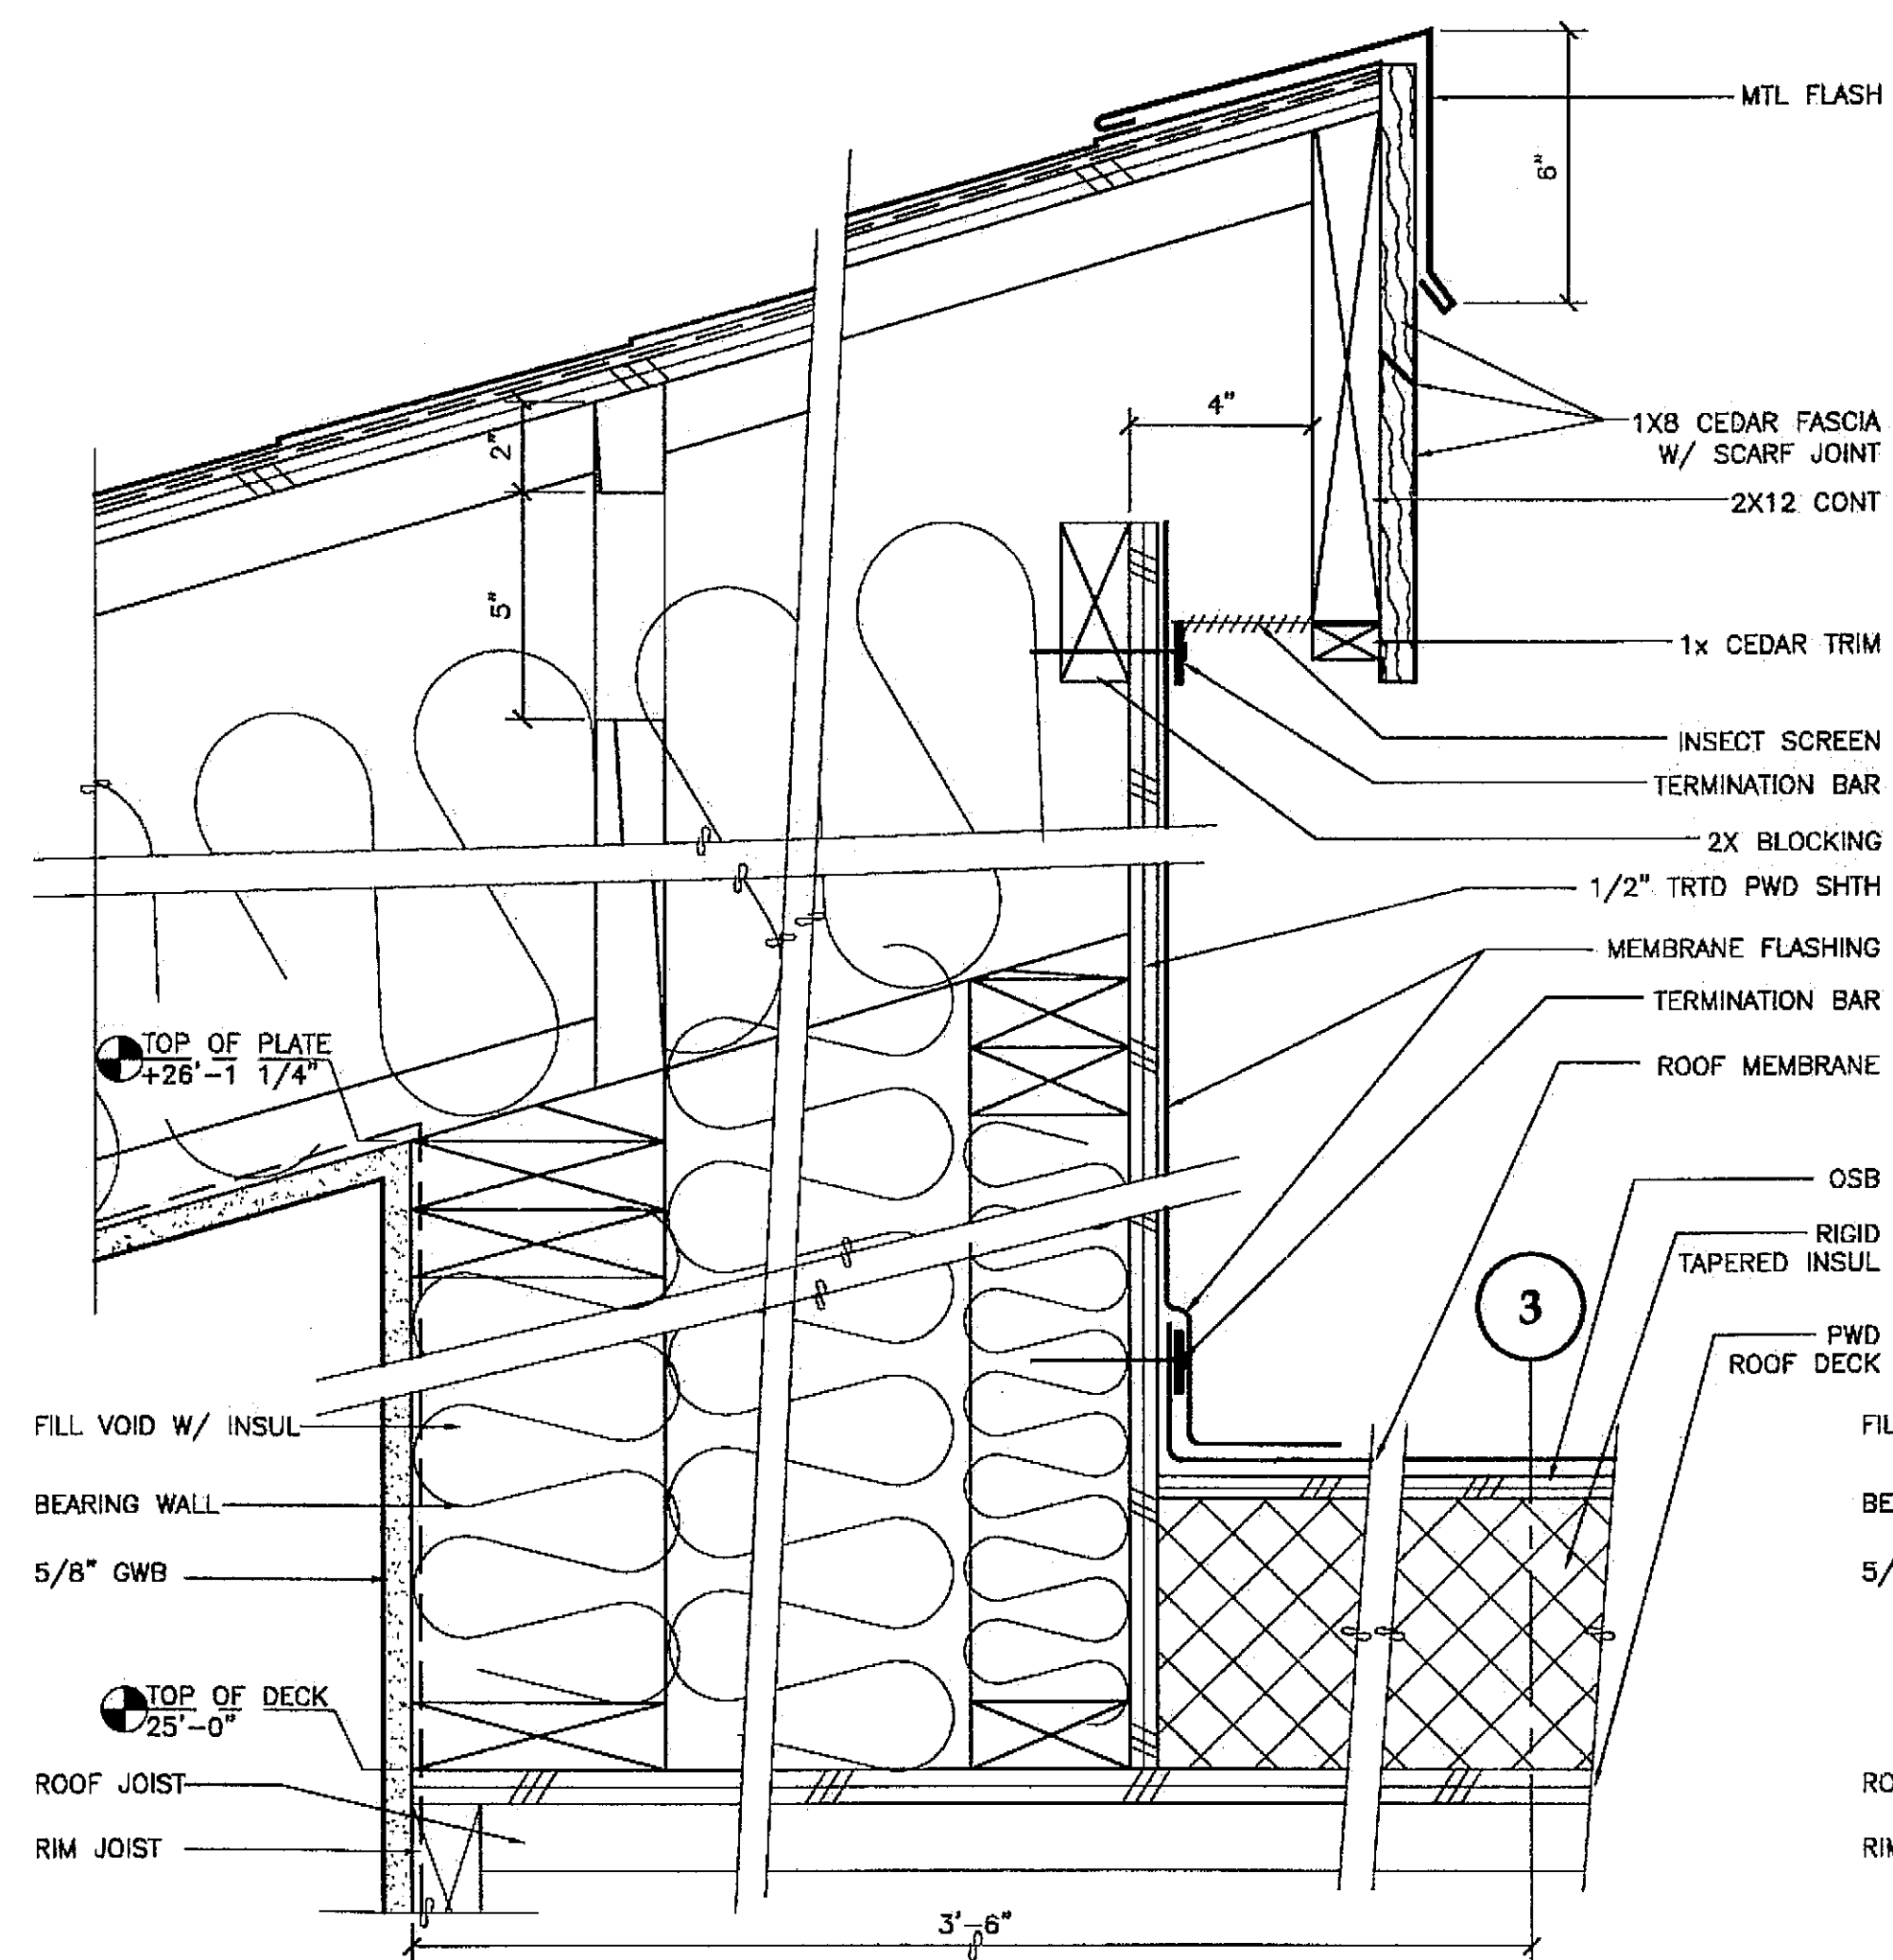

5 EAVE DETAIL

SCALE: 0 3" 6" 12"

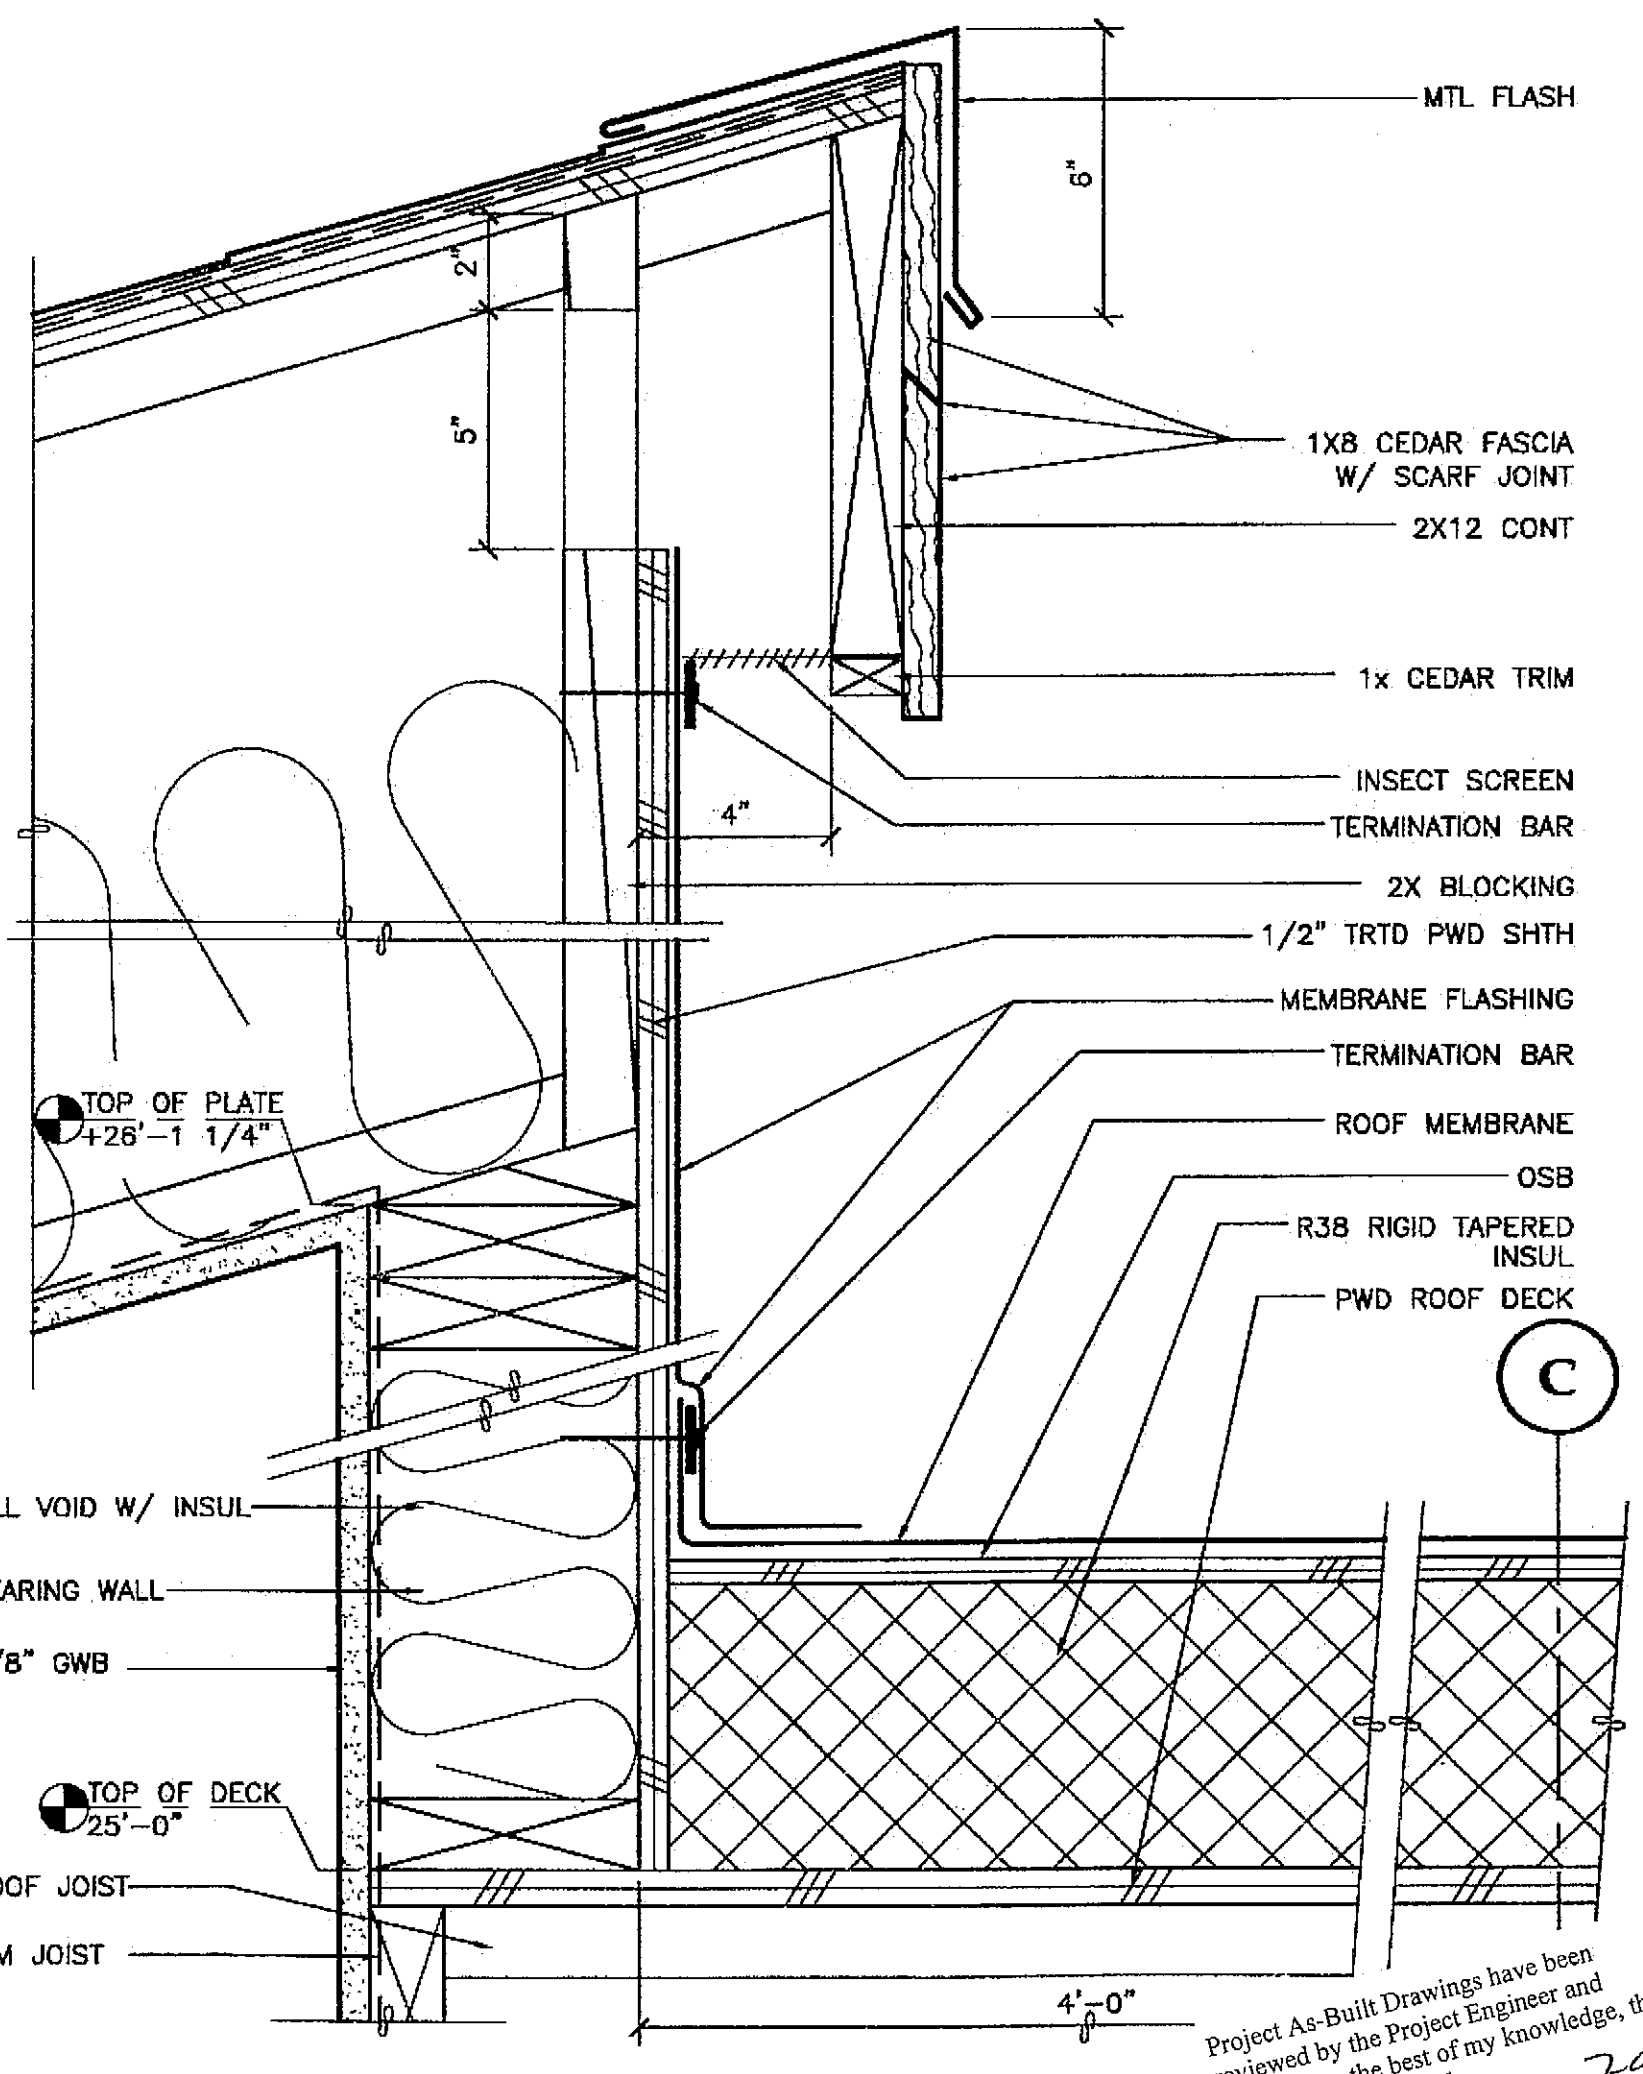

6 EAVE DETAIL

SCALE: 0 6" 1' 2'

Project As-Built Drawings have been reviewed by the Project Engineer and represent to the best of my knowledge, the project as constructed.
Date: 7/20/04
Proj. Eng. [Signature]

PATH: G:_Projects\0411\0411\CD\1330\Arch\A802.dwg
Tue, 14/Dec/04 02:33PM
TAB: Layout1


ADDENDUM NUMBER		
ATTACHMENT NUMBER		
RECORD OF REVISIONS		
No.	DATE	DESCRIPTION

CHECKED BY: [Signature]
DESIGNED BY: JENSEN YORBA LOTT
DRAWN BY: [Signature]

STATE OF ALASKA
DEPARTMENT OF TRANSPORTATION & PUBLIC FACILITIES
STATEWIDE DESIGN & ENGINEERING SERVICES DIVISION
MT EDGE CUMBE HIGH SCHOOL
BUILDING 1330
ACADEMIC EXPANSION

SHEET A802
PROJECT DESIGNATION NUMBER
67751C


STATE	YEAR
ALASKA	2004
SHEET NUMBER	TOTAL SHEETS
28	79

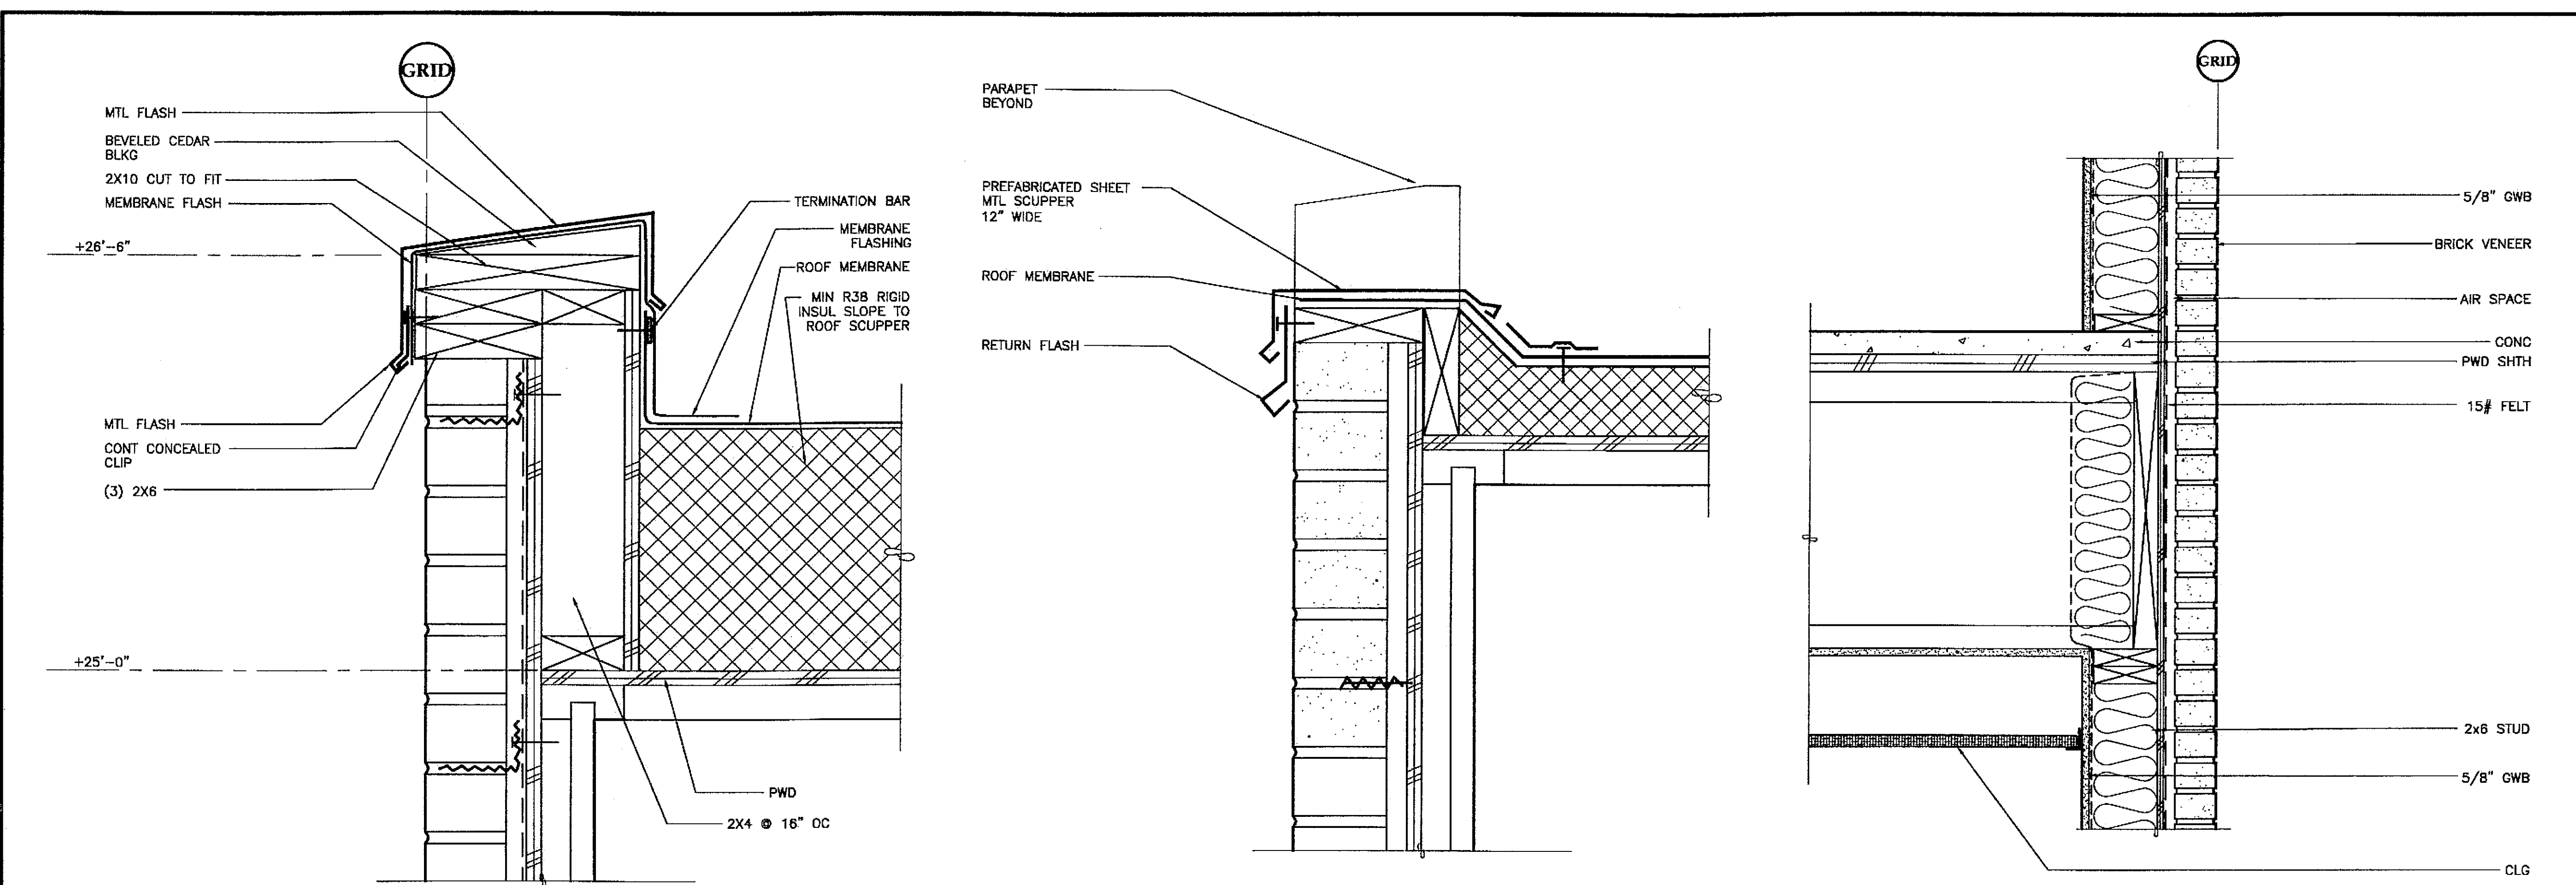

1 ROOF PARAPET DETAIL SCALE: 0 3' 6' 12'

2 ROOF SCUPPER W/ PARAPET DETAIL SCALE: 0 3' 6' 12'

3 WALL SECTION DETAIL SCALE: 0 6' 1' 2'

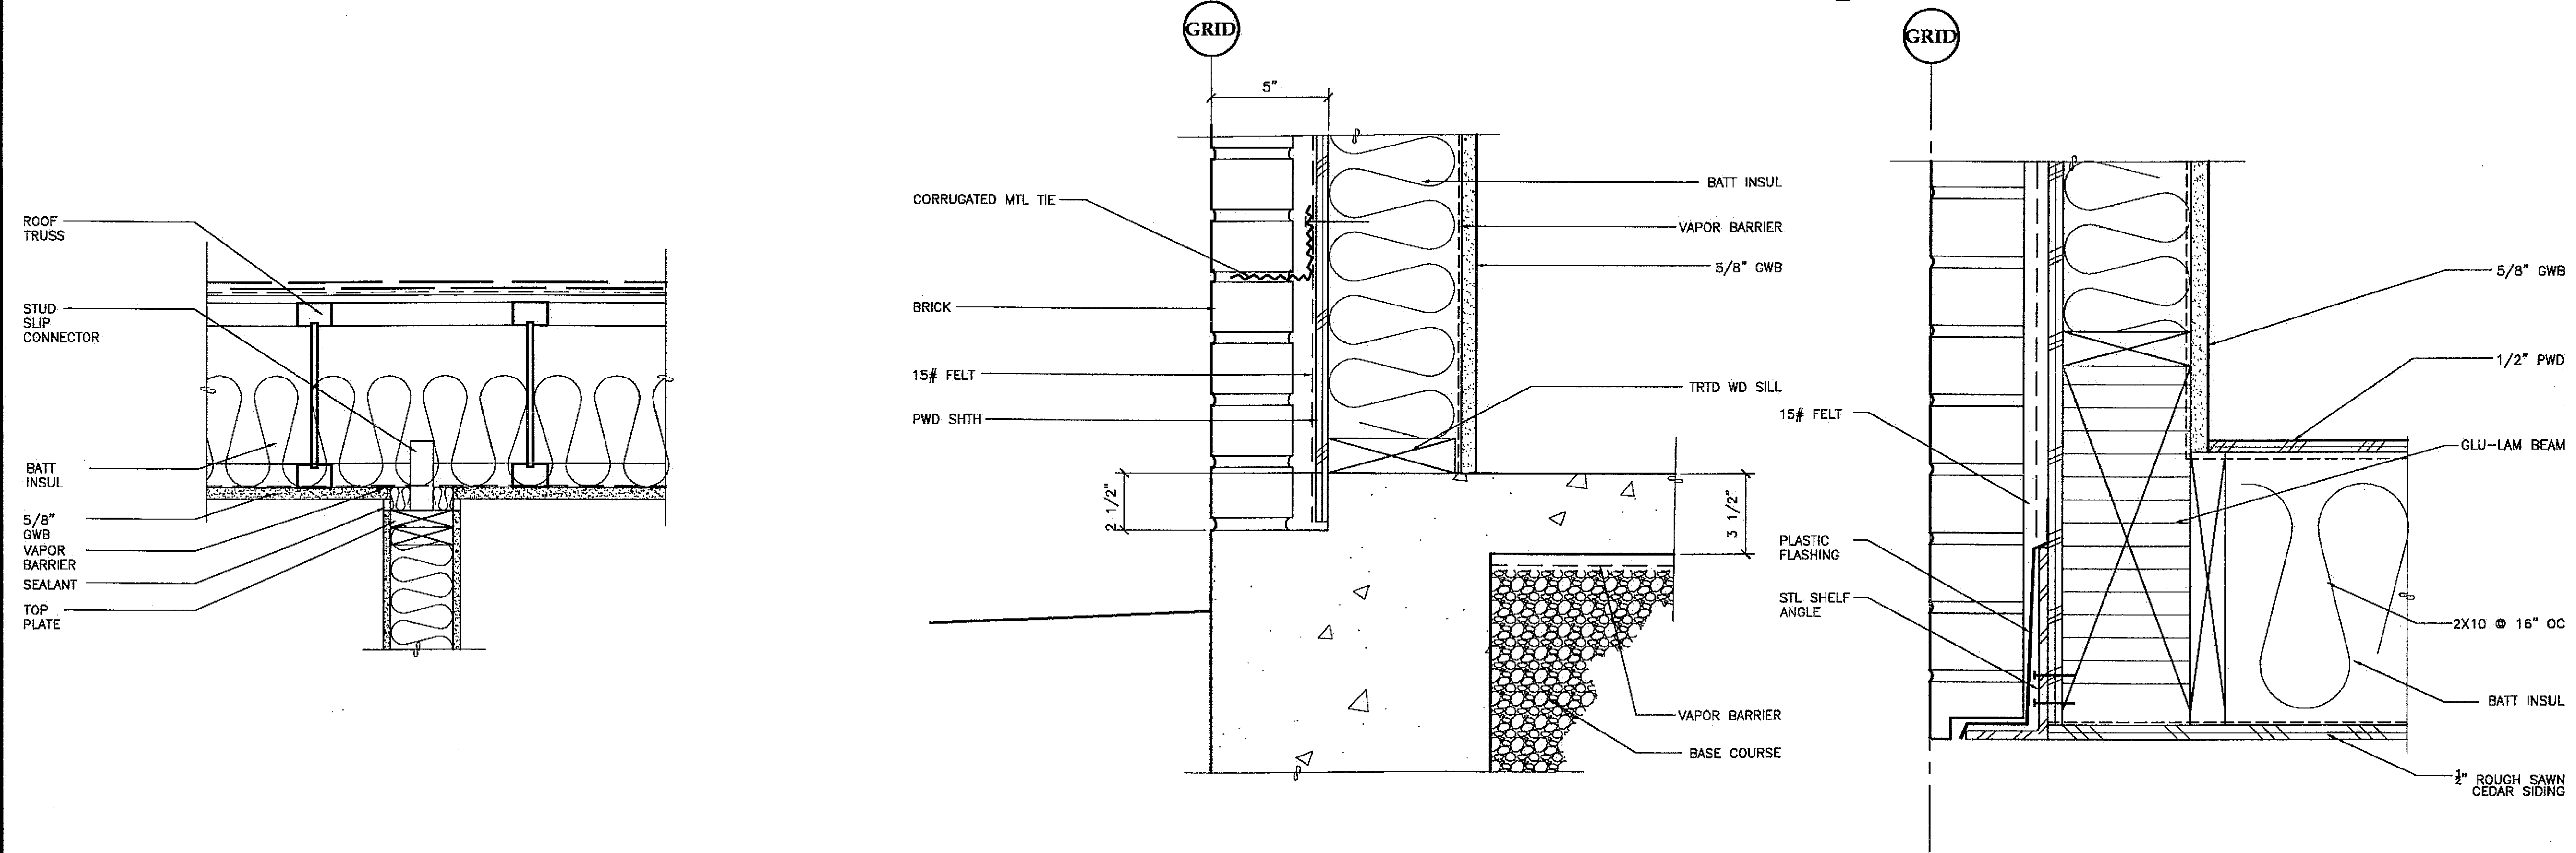

4 SLIP JOINT DETAIL SCALE: 0 6' 1' 2'

5 WALL SILL DETAIL SCALE: 0 3' 6' 12'

6 WALL SECTION DETAIL SCALE: 0 3' 6' 12'

PATH: G:\Projects\0411\Cad\CD\1330\Arch\A803.dwg
Tue, 14/Dec/04 02:33PM
TAB: Layout1

ADDENDUM NUMBER

ATTACHMENT NUMBER

RECORD OF REVISIONS

No.	DATE	DESCRIPTION

CHECKED BY:

DESIGNED BY: JENSEN YORBA LOTT

DRAWN BY:

STATE OF ALASKA
DEPARTMENT OF TRANSPORTATION & PUBLIC FACILITIES
STATEWIDE DESIGN & ENGINEERING SERVICES DIVISION
MT EDGE CUMBE HIGH SCHOOL BUILDING 1330 ACADEMIC EXPANSION

SHEET A803
PROJECT DESIGNATION NUMBER
67751C

STATE	YEAR
ALASKA	2004

SHEET NUMBER	TOTAL SHEETS
29	79


Project As-Built Drawings have been reviewed by the Project Engineer and represent to the best of my knowledge, the project as constructed.
Proj. Eng. *[Signature]* Date 2-07

ADDENDUM NUMBER

ATTACHMENT NUMBER


RECORD OF REVISIONS

No.	DATE	DESCRIPTION

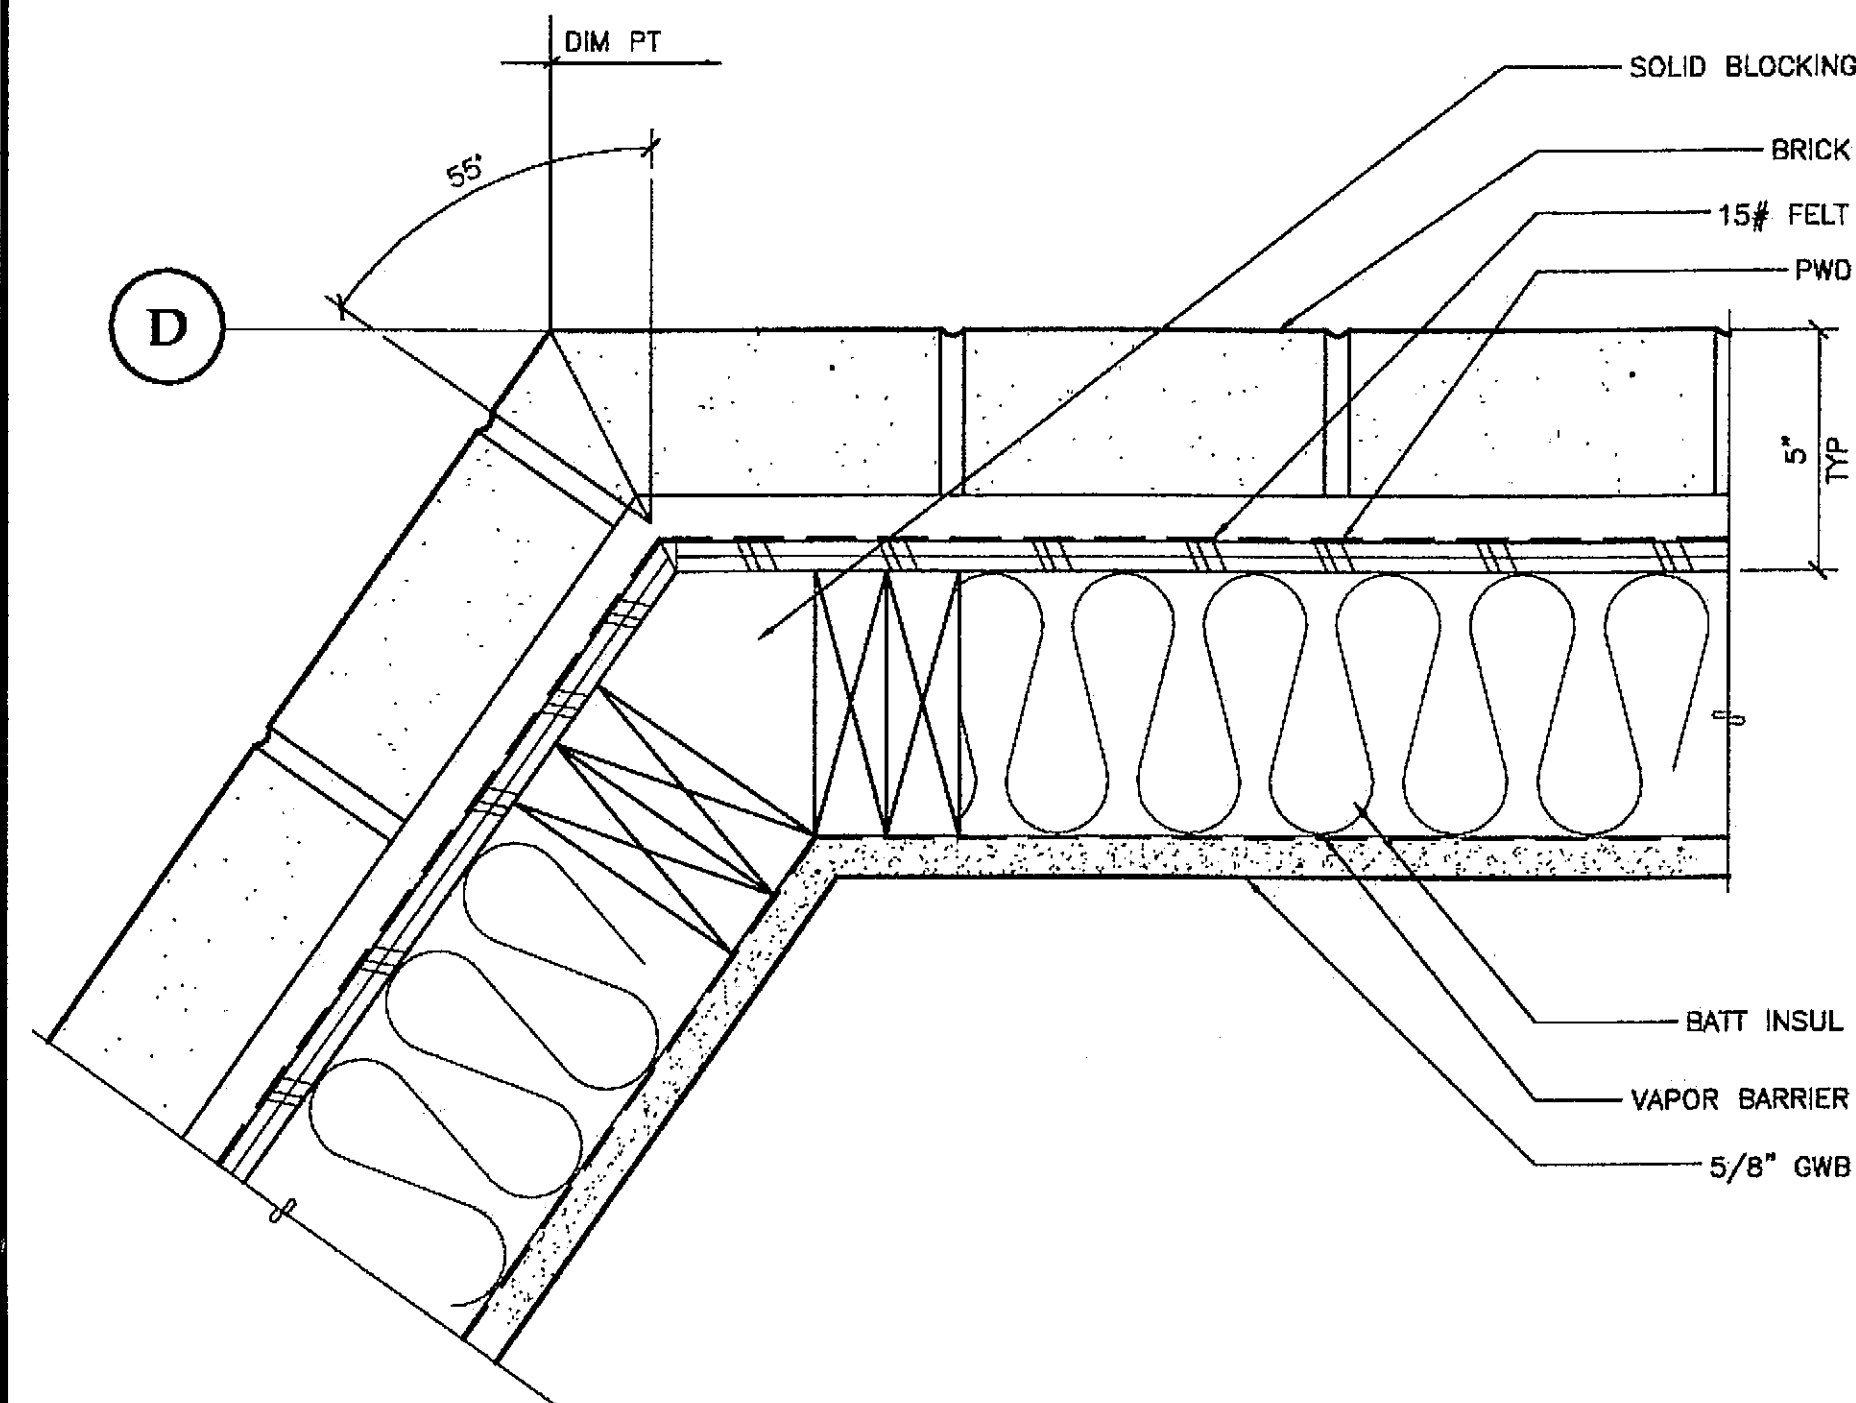


1 BRICK DETAIL

SCALE: 0 3" 6" 12"

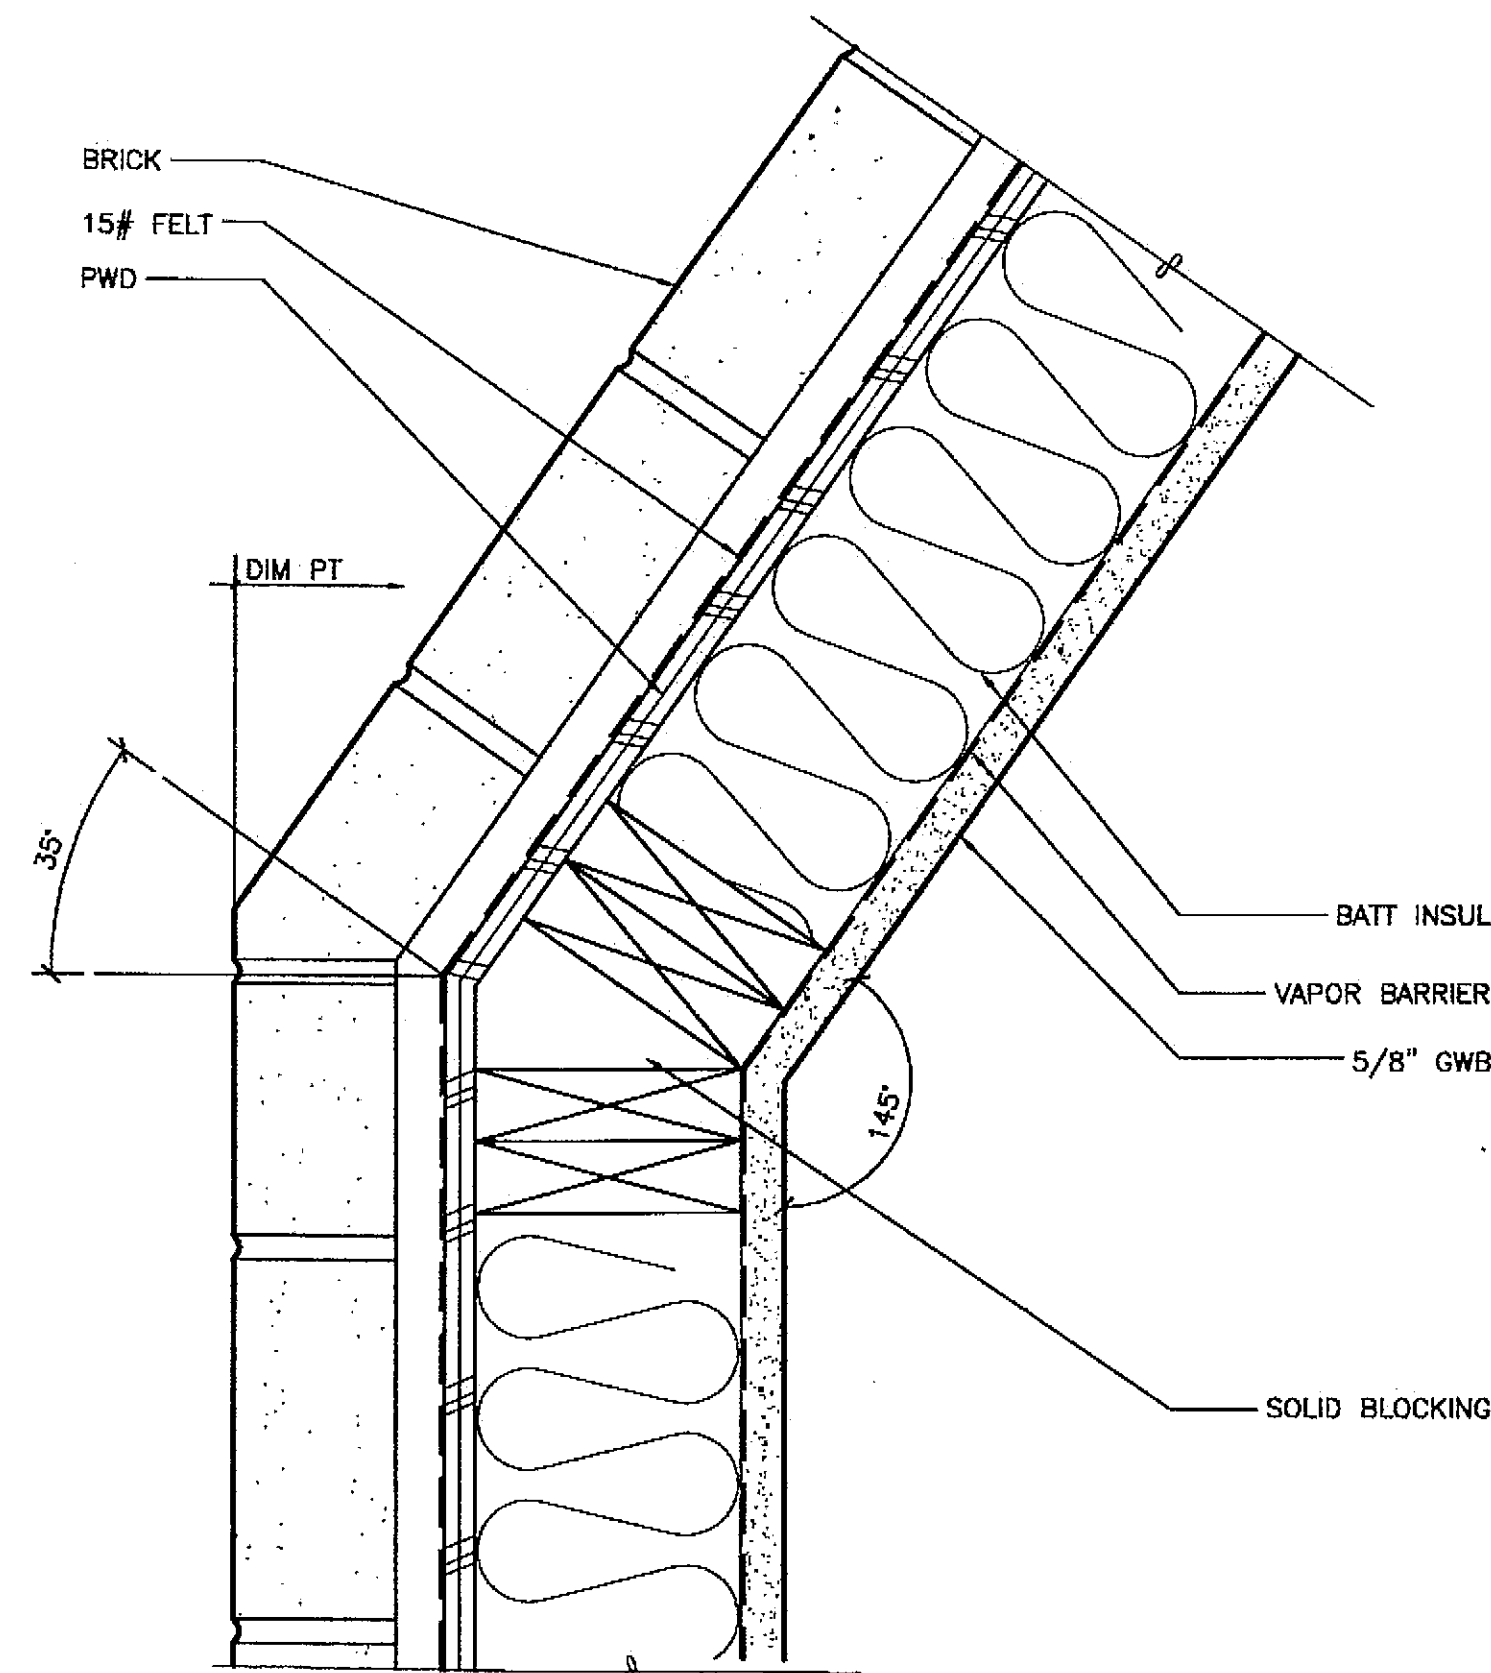


2 BRICK DETAIL

SCALE: 0 3" 6" 12"

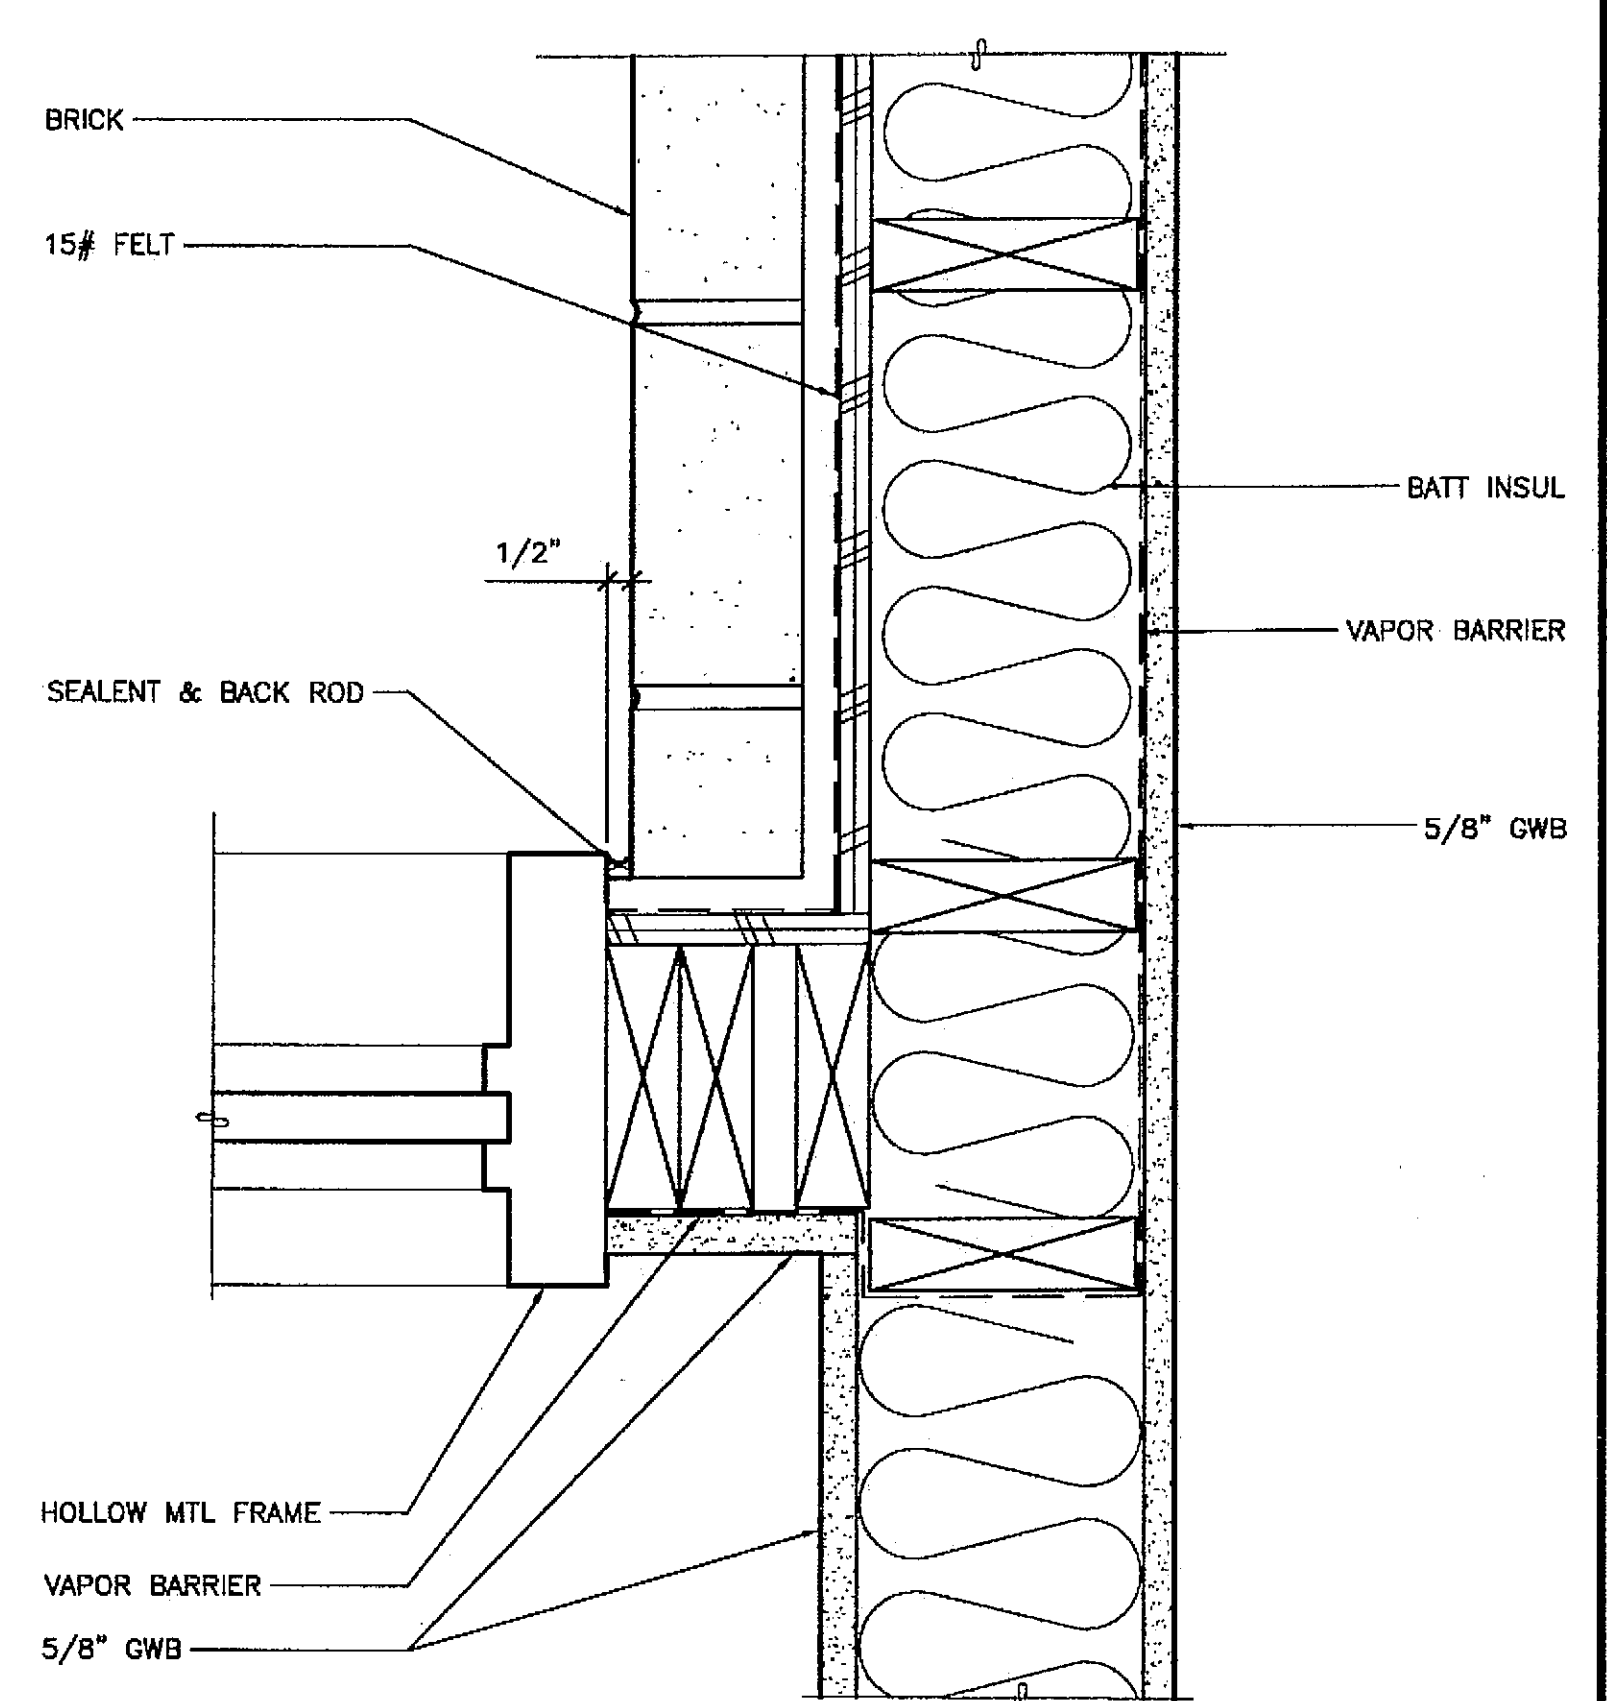


3 BRICK DETAIL

SCALE: 0 3" 6" 12"

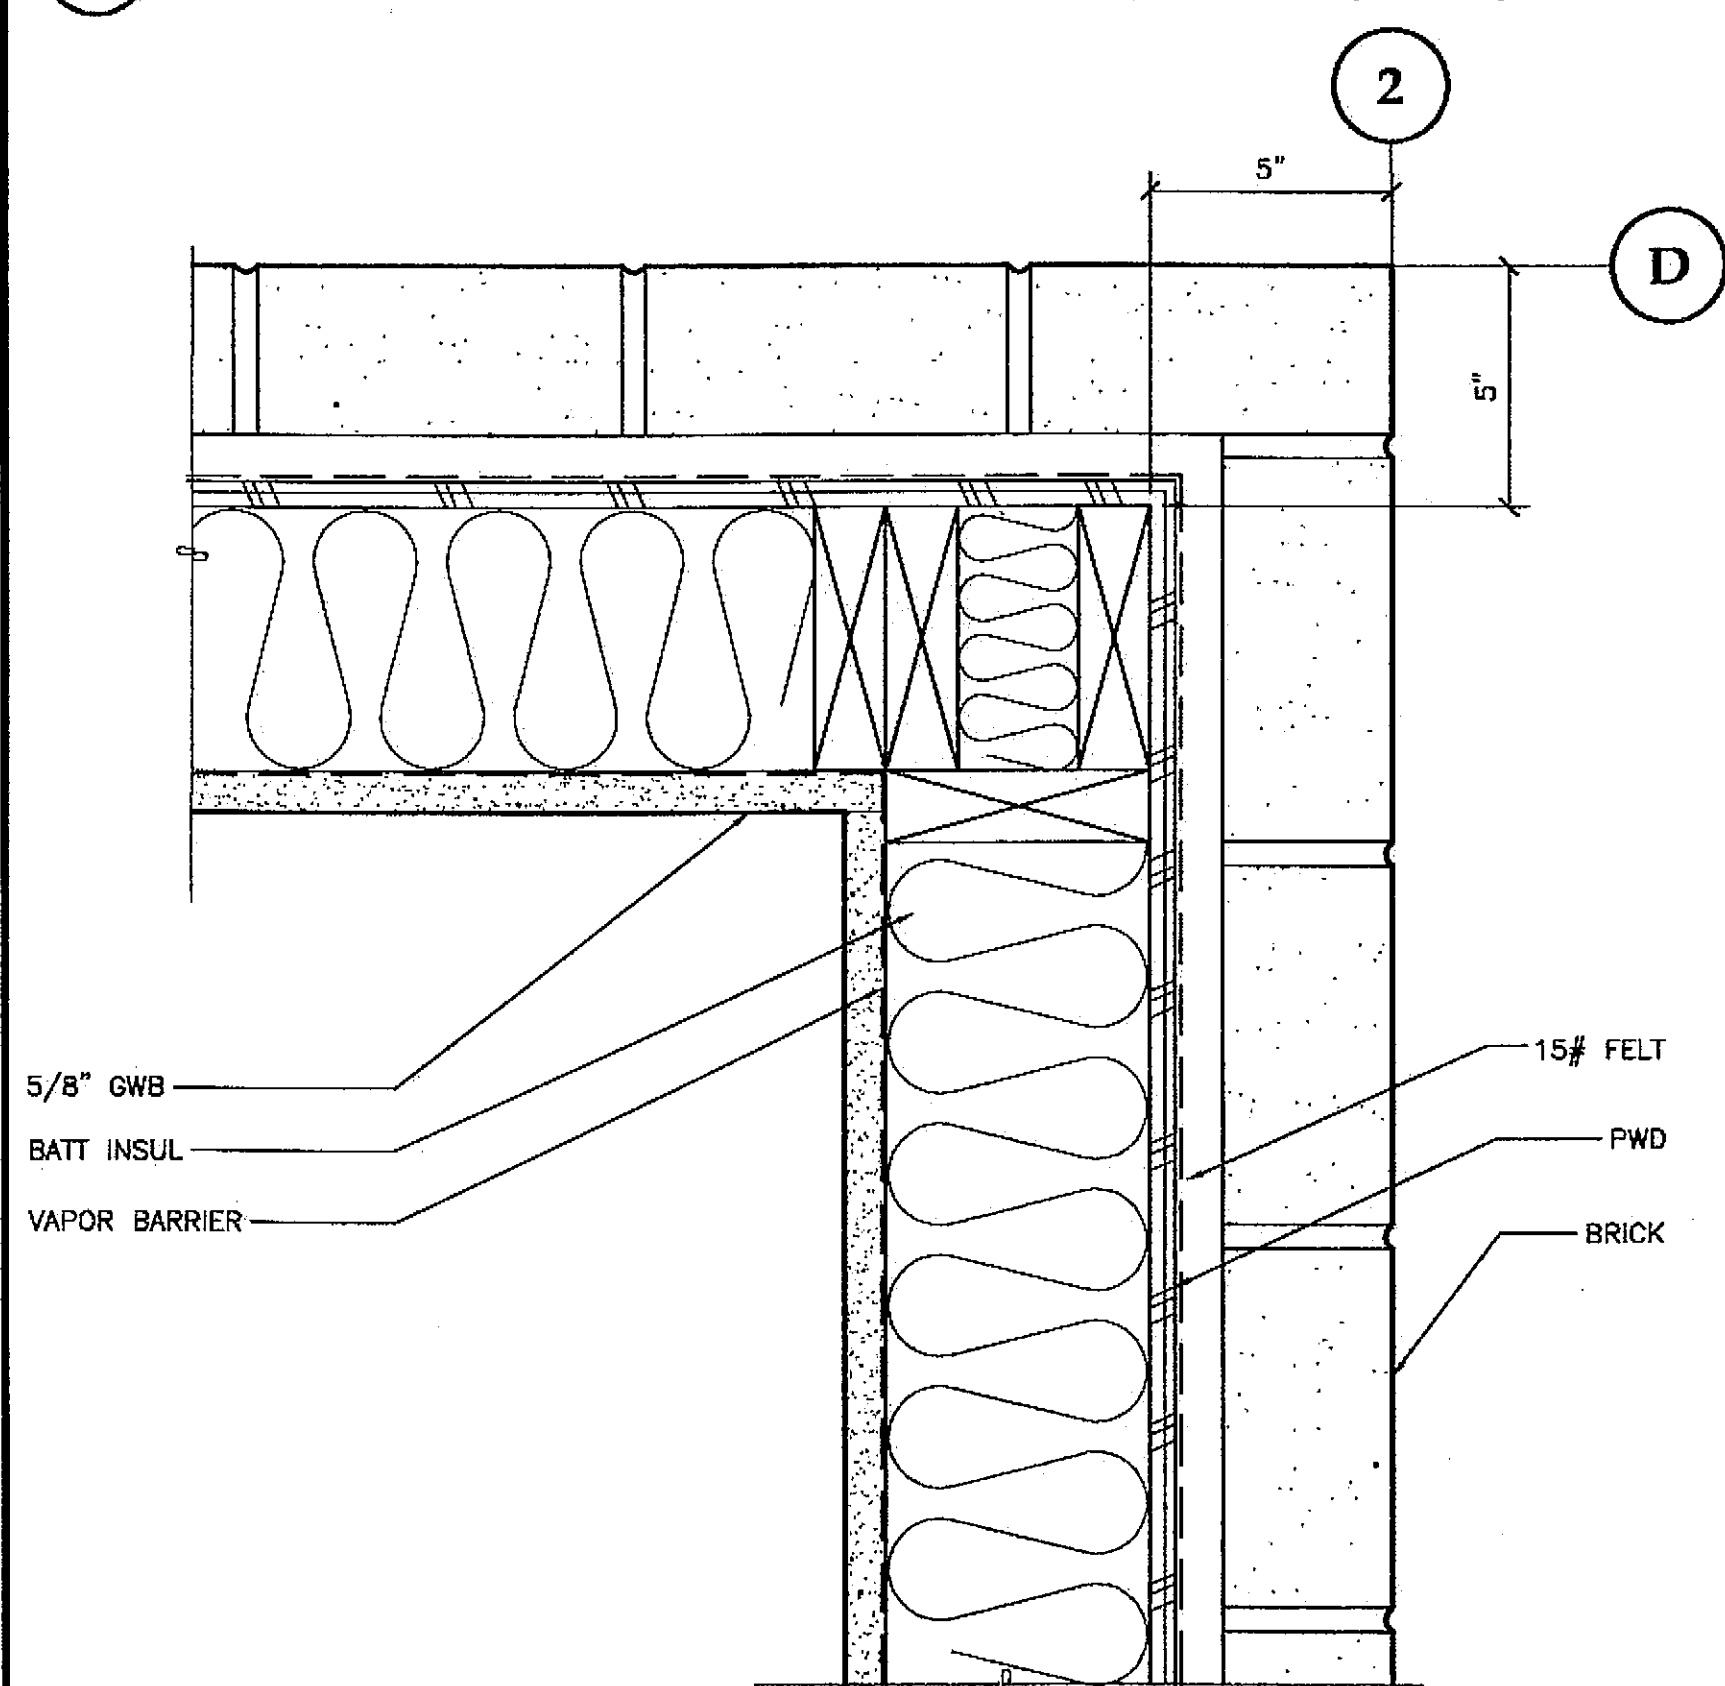


4 BRICK DETAIL

SCALE: 0 3" 6" 12"

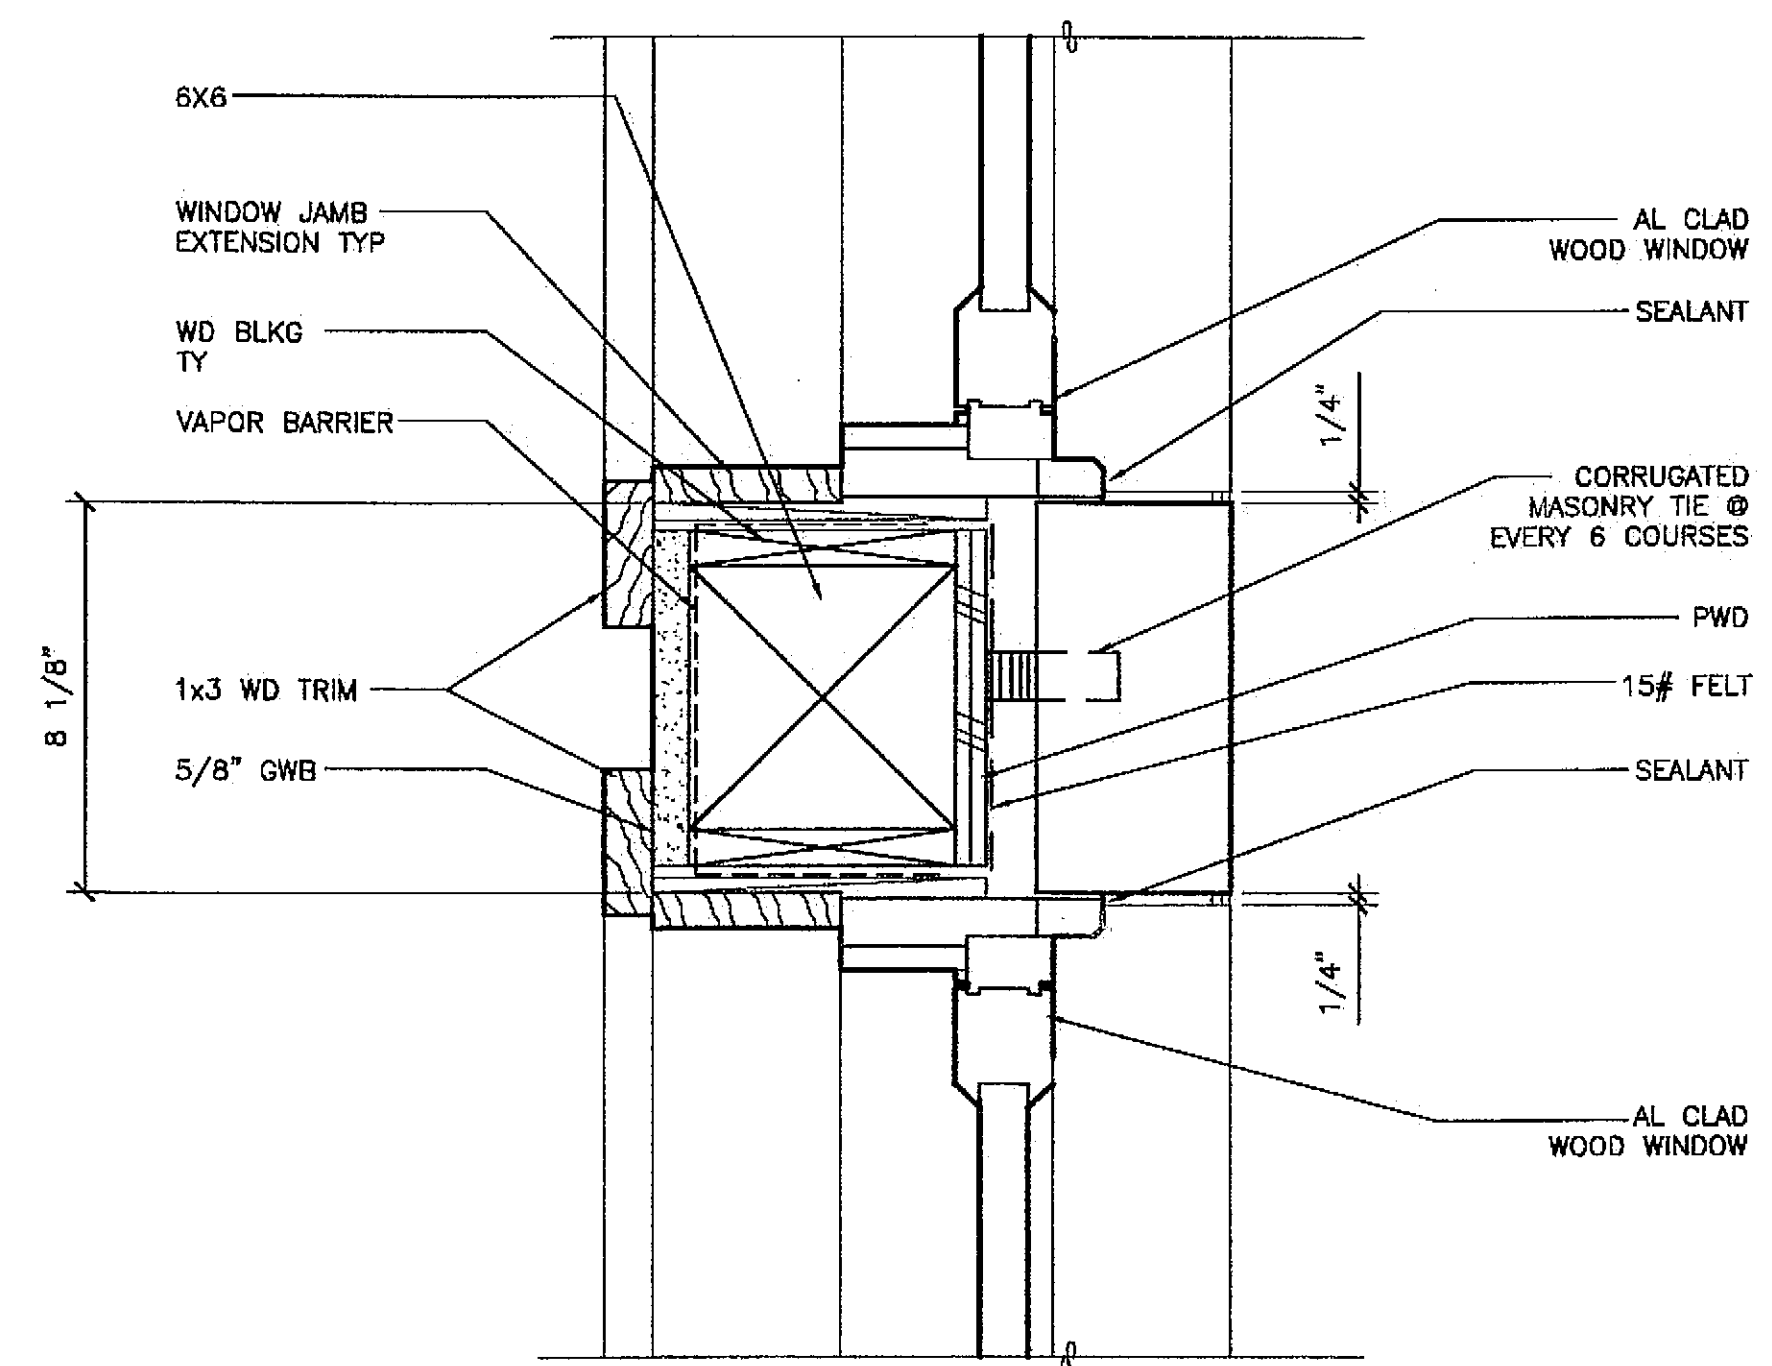

5 TYPICAL MULLION DETAIL


SCALE: 0 3" 6" 12"

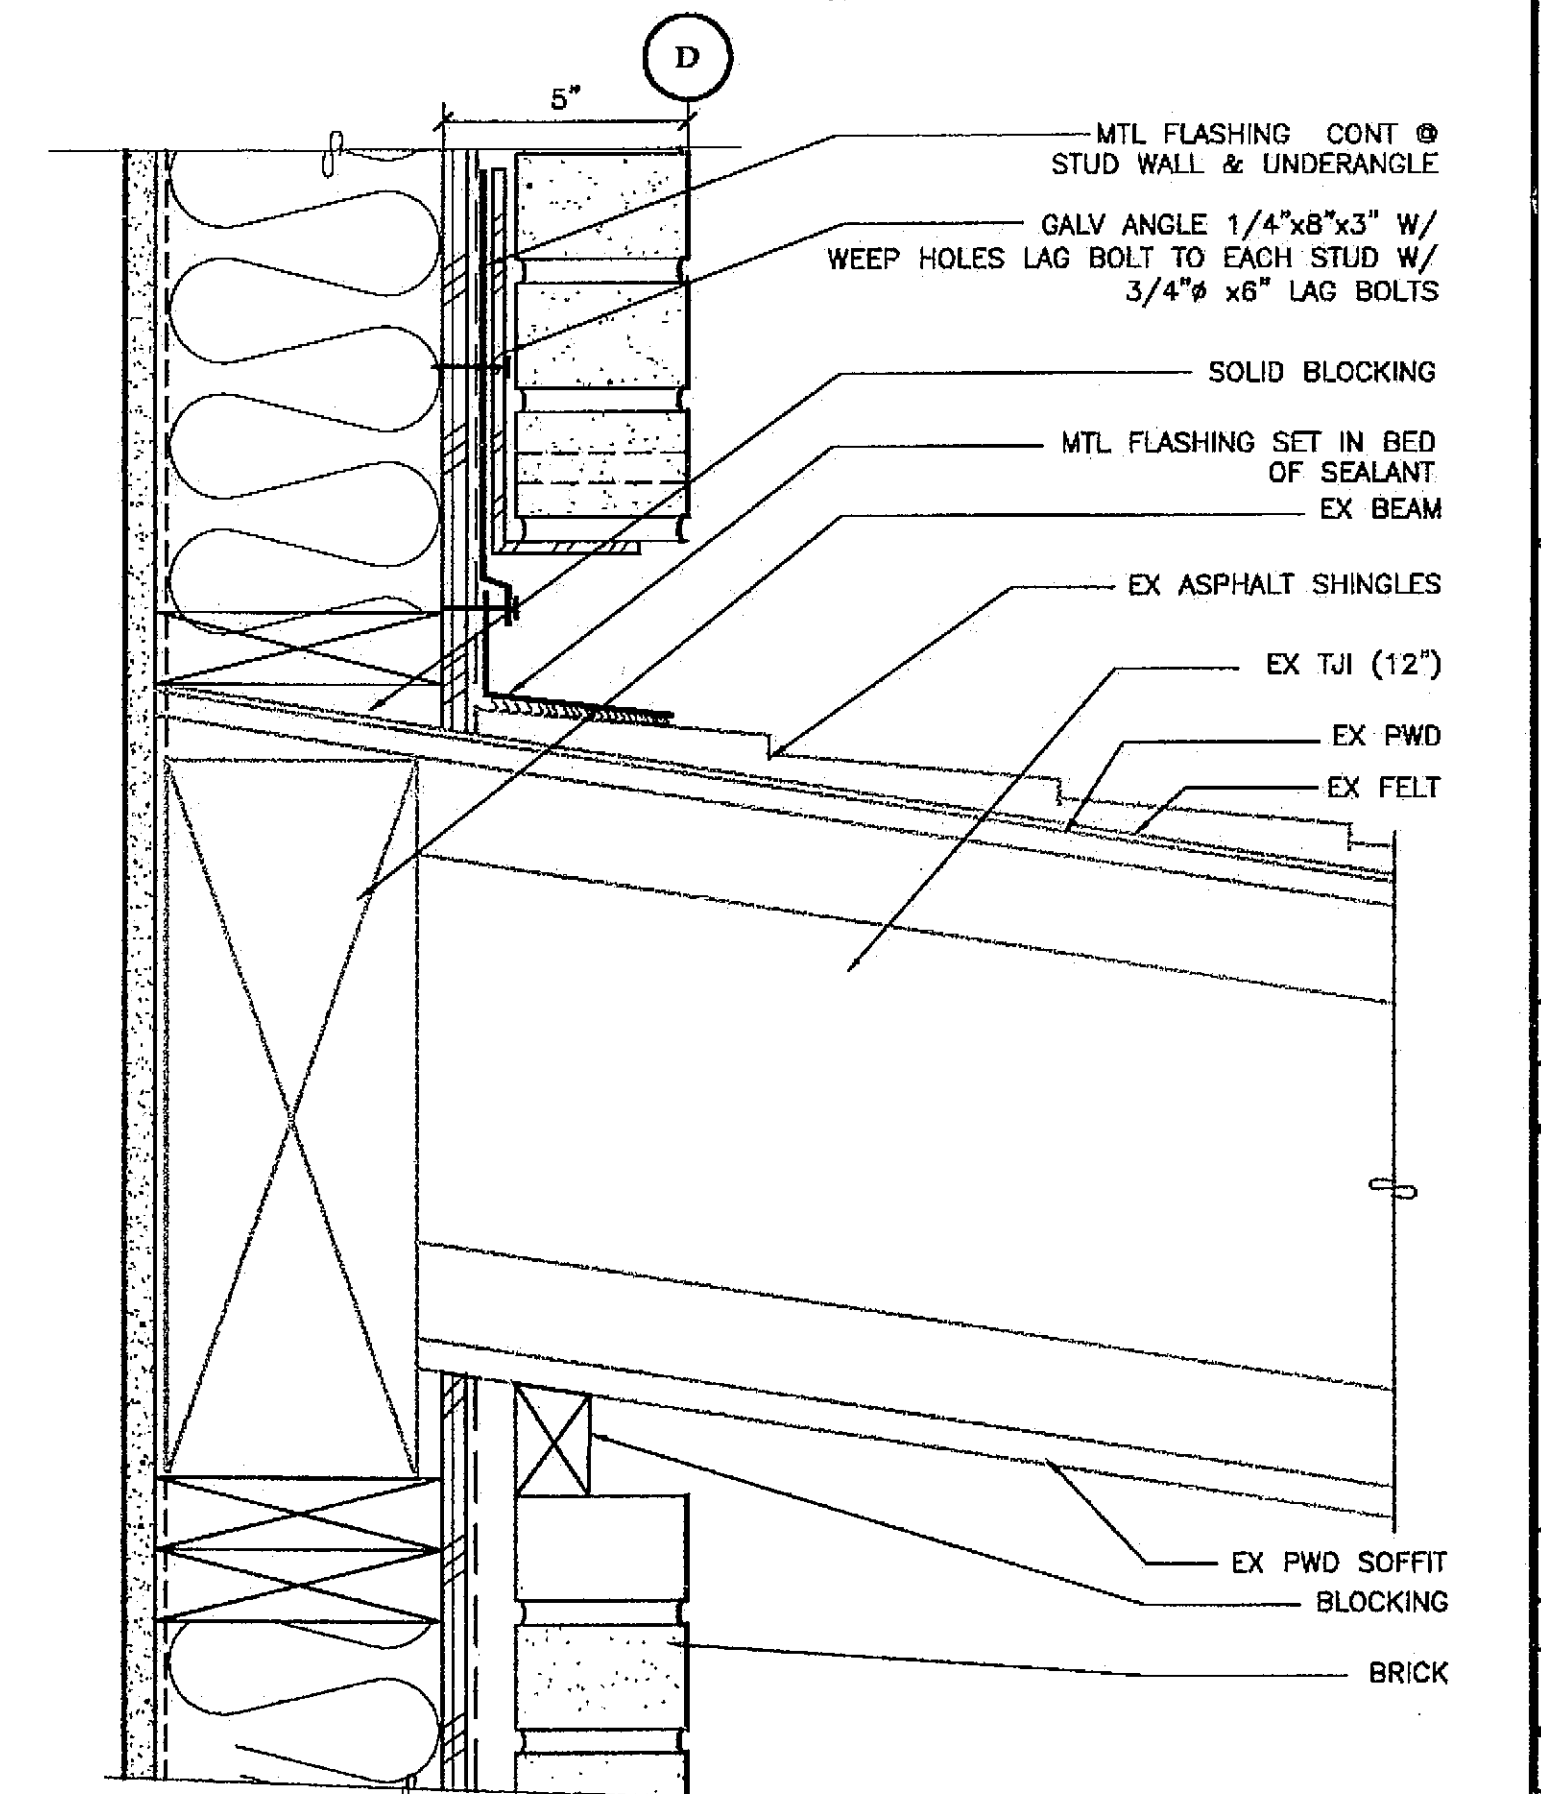

6 DETAIL @ EXISTING CANOPY

SCALE: 0 3" 6" 12"

CHECKED BY:

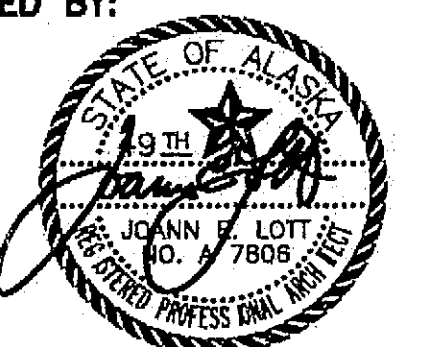

DESIGNED BY: JENSEN YORBA LOTT

DRAWN BY:

STATE OF ALASKA
 DEPARTMENT OF TRANSPORTATION
 & PUBLIC FACILITIES
 STATEWIDE DESIGN & ENGINEERING
 SERVICES DIVISION

MT EDGE CUMBE
 HIGH SCHOOL
 BUILDING 1330
 ACADEMIC
 EXPANSION


SHEET A804

PROJECT DESIGNATION NUMBER


67751C

STATE	YEAR
ALASKA	2004
MBER	TOTAL SHEETS
	79

Project As-Built Drawings have been reviewed by the Project Engineer and represent to the best of my knowledge, the project as constructed.
 Proj. Eng. *[Signature]* Date 7-97

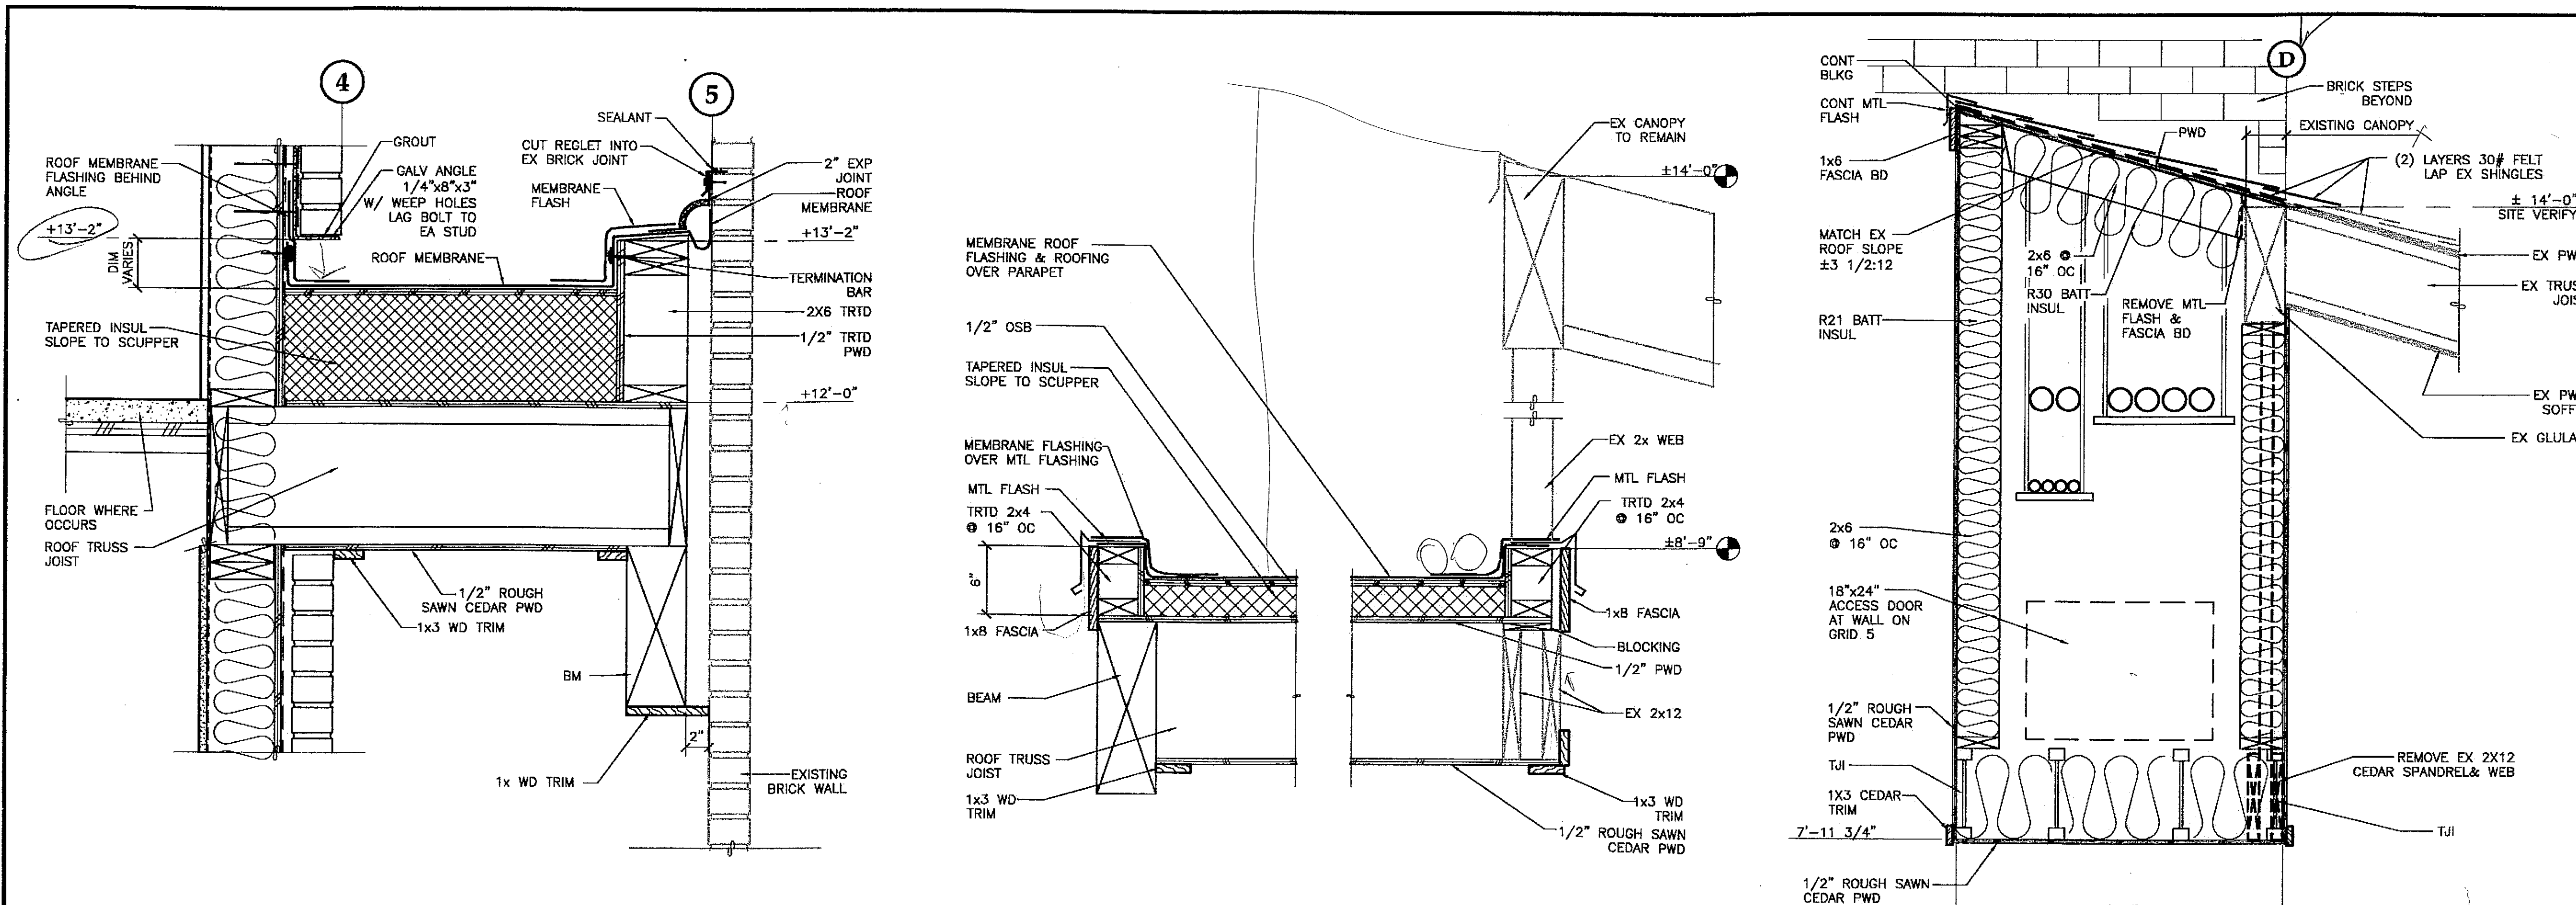

1 ROOF DETAIL ALT 2 SCALE: 0 3" 6" 12" 2 DETAIL @ ENTRY CANOPY SCALE: 0 3" 6" 12" 3 UTILITY CHASE SCALE: 0 6" 1" 2"

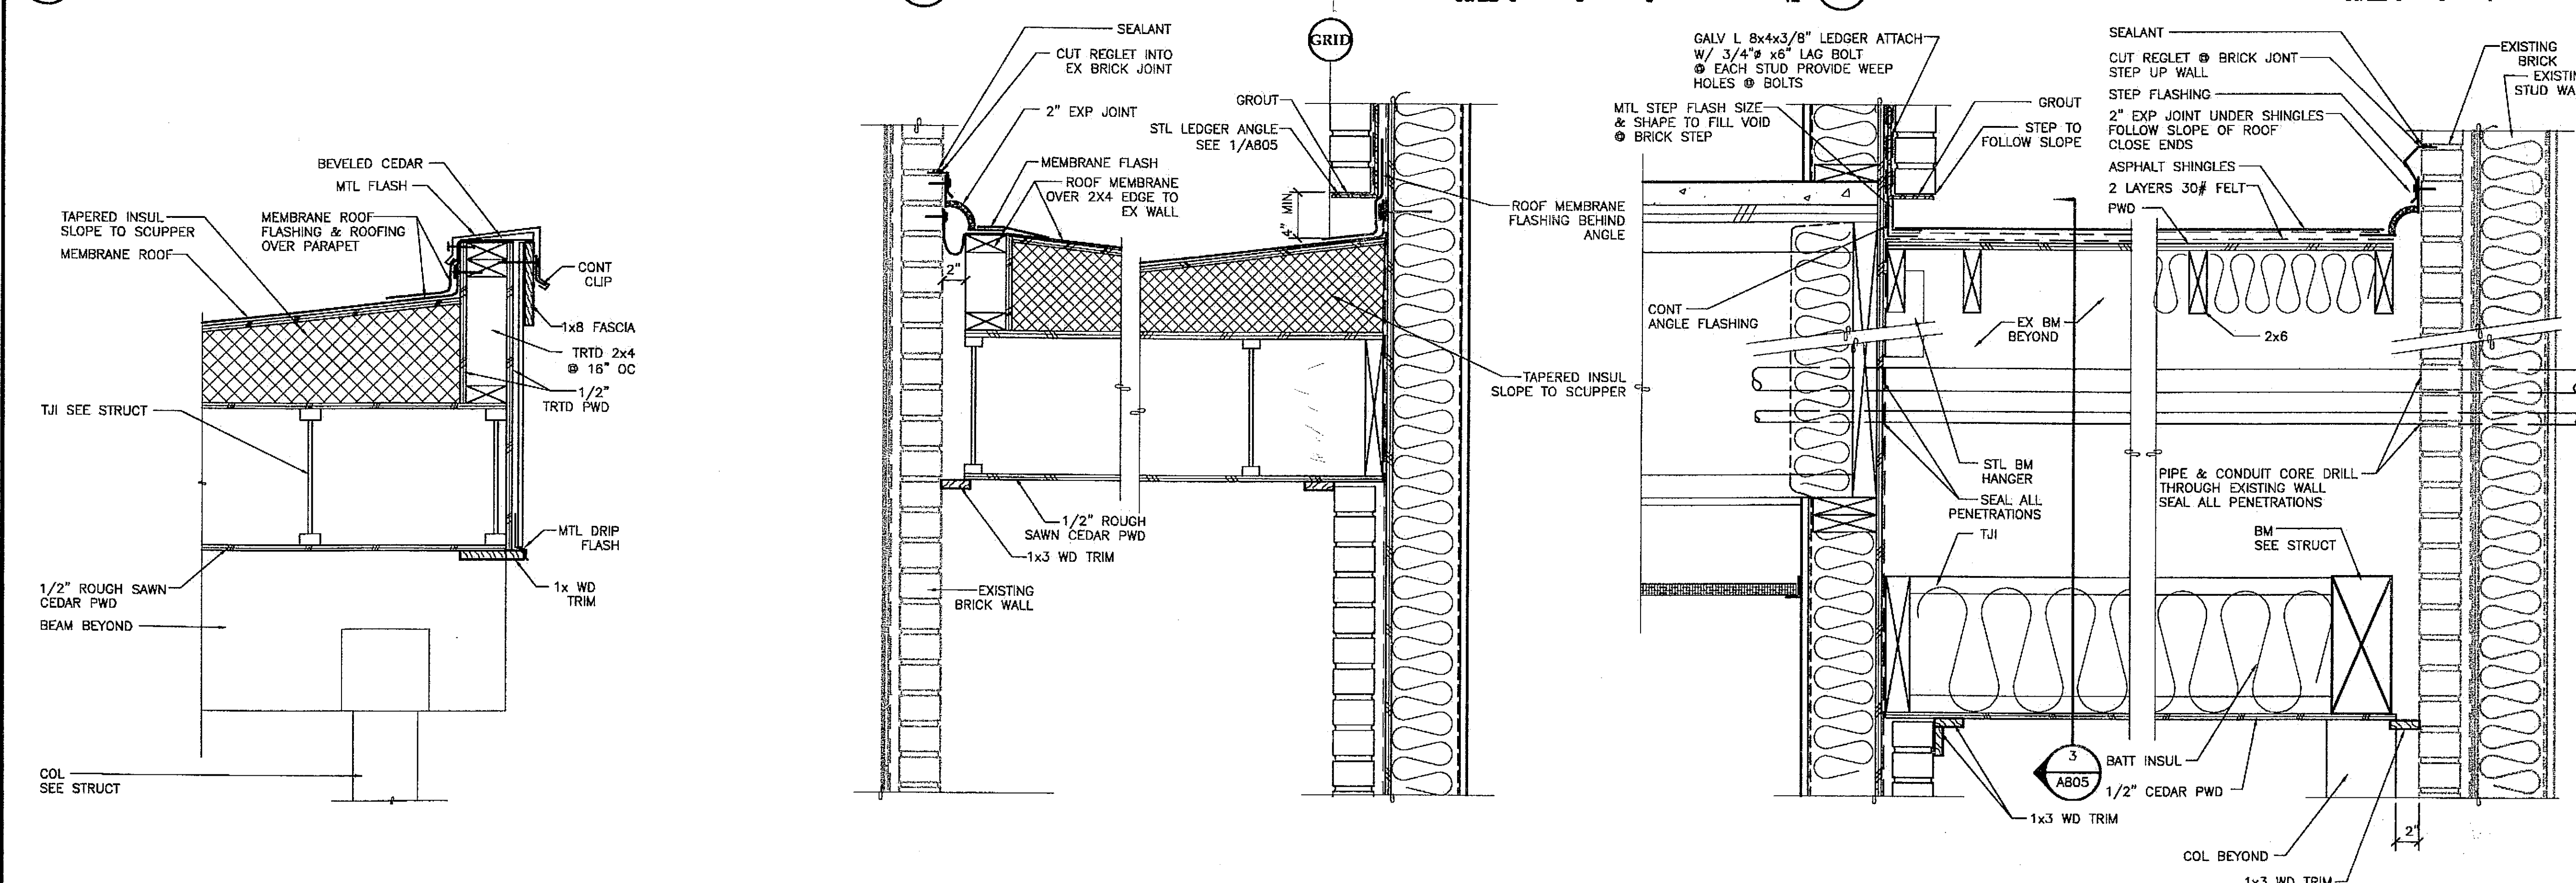

4 EAVE DETAIL ALTERNATE 2 SCALE: 0 3" 6" 12" 5 DETAIL @ ENTRY CANOPY SCALE: 0 3" 6" 12" 6 UTILITY CHASE @ EX BLDG SCALE: 0 6" 1" 2"

PATH: G:\Projects\0411\Cad\CD\1330\Arch\A805.dwg
 Tue, 14/Dec/04 02:33PM
 TAB: Layout1

ADDENDUM NUMBER	

ATTACHMENT NUMBER	

RECORD OF REVISIONS		
No.	DATE	DESCRIPTION

CHECKED BY:
 DESIGNED BY: JENSEN YORBA LOTT
 DRAWN BY:
 STATE OF ALASKA
 DEPARTMENT OF TRANSPORTATION & PUBLIC FACILITIES
 STATEWIDE DESIGN & ENGINEERING SERVICES DIVISION
 MT EDGE CUMBE HIGH SCHOOL BUILDING 1330 ACADEMIC EXPANSION
 SHEET A805
 PROJECT DESIGNATION NUMBER 67751C

STATE	YEAR
ALASKA	2004

SHEET NUMBER	TOTAL SHEETS
31	79


Project As-Built Drawings have been reviewed by the Project Engineer and represent to the best of my knowledge, the project as constructed.
 Proj. Eng. *[Signature]* Date 7/07

ADDENDUM NUMBER

ATTACHMENT NUMBER


RECORD OF REVISIONS

No.	DATE	DESCRIPTION

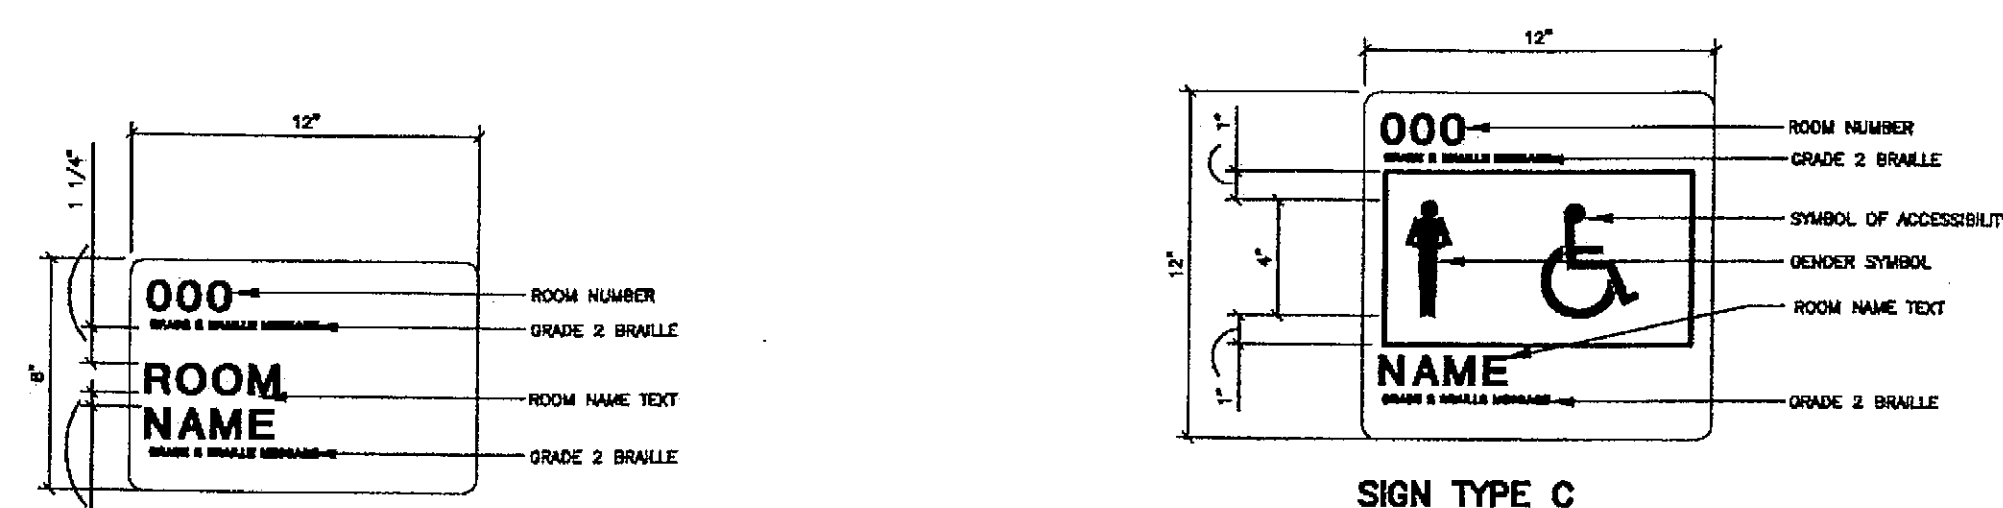


SIGN TYPE A

SIGN TYPE C


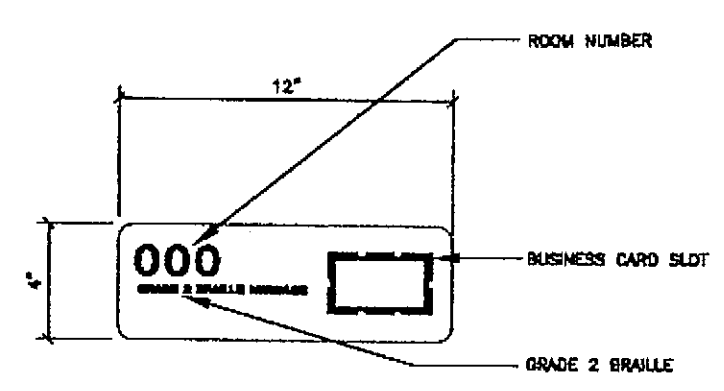


SIGN TYPE B

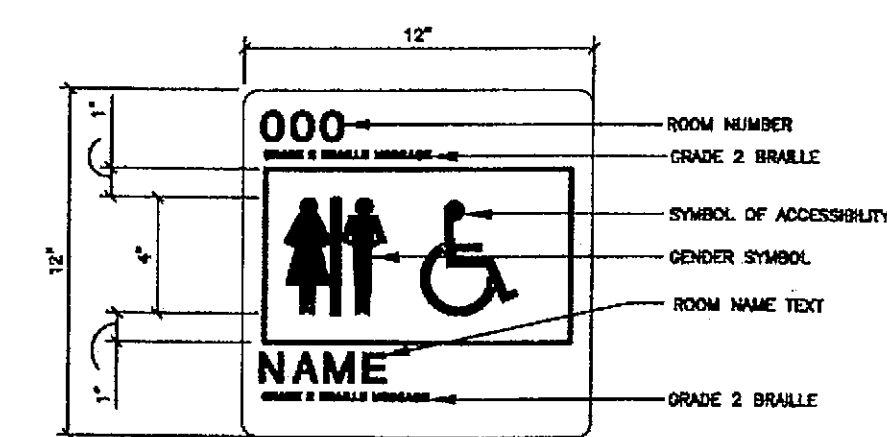

SIGN TYPE D

NOTES:
3/4" GRADING TO SIGN EDGE ALL AROUND
3/8" SPACING BETWEEN ROWS UON
GRADE 2 BRAILLE 1/4" HIGH
TEXT 1" HIGH UON
3/4" RADUS ALL CORNERS
TYP MOUNTING - SEE 1/A500
TEXT AND SYMBOLS PASED 3/32"

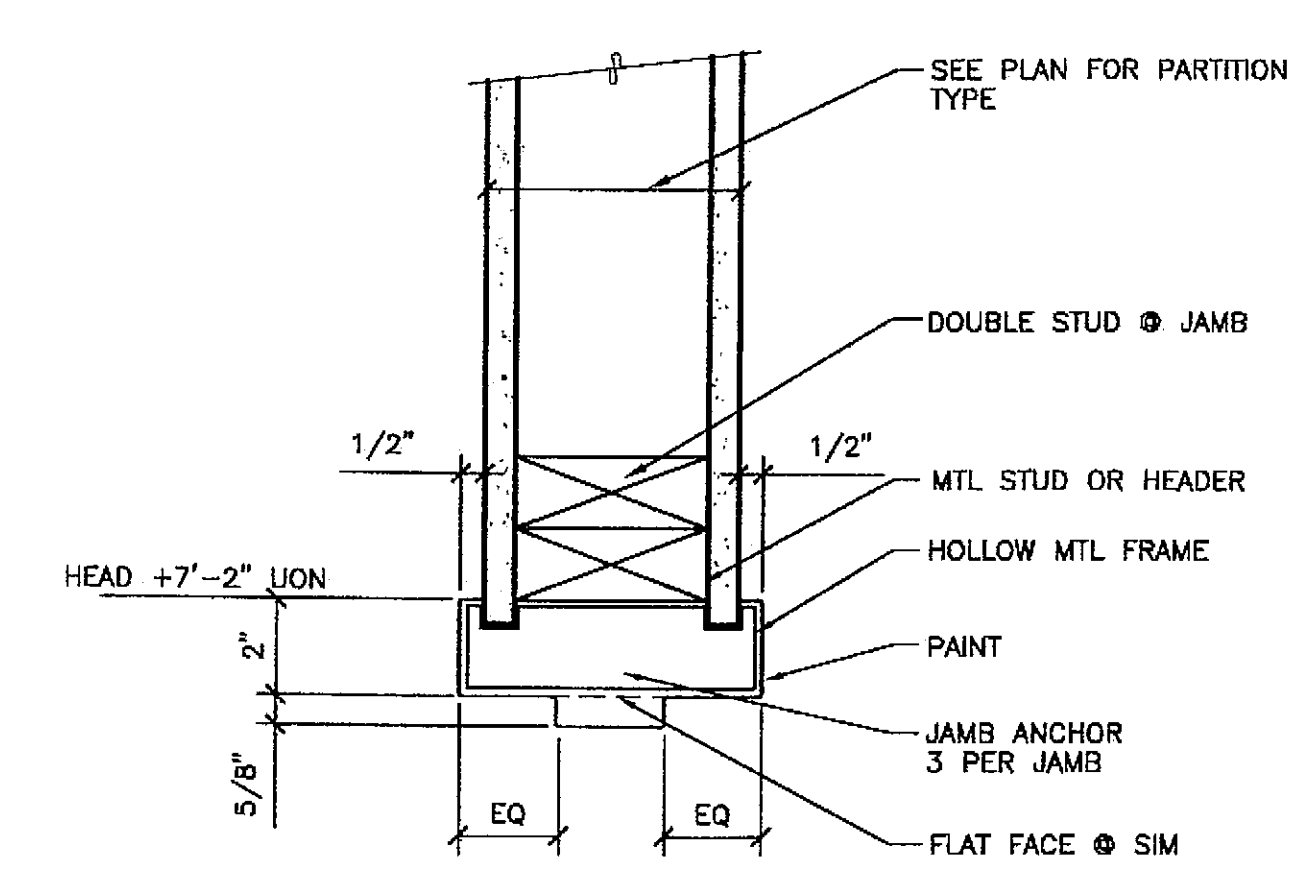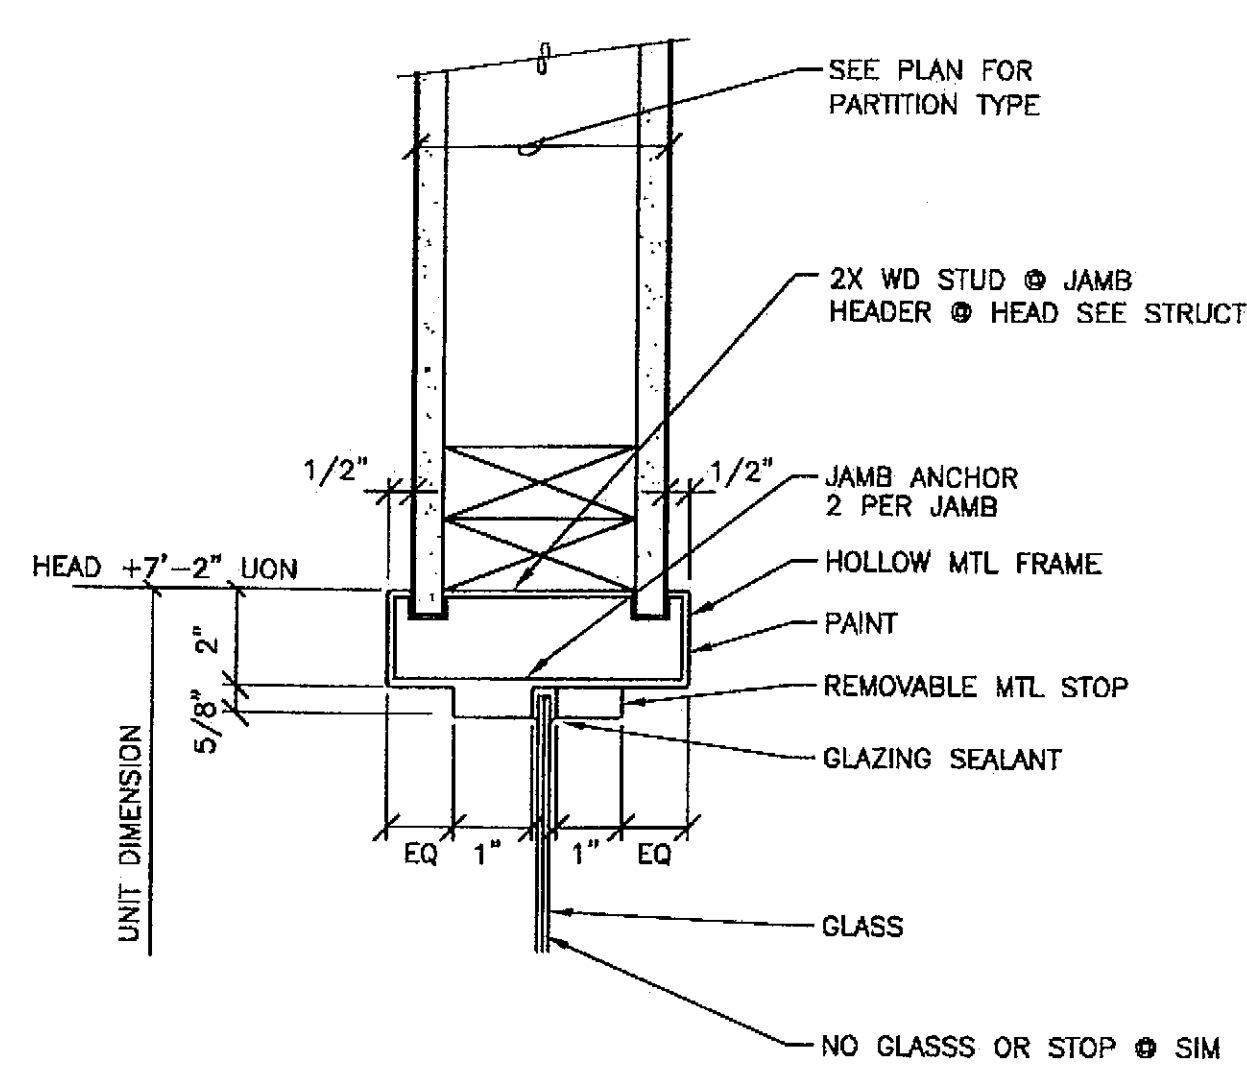

1 INTERIOR SIGNAGE


SCALE: 0 3" 6" 12"

2 RELITE HEAD (JAMB SIM)

SCALE: 0 3" 6" 12"


3 DOOR JAMB (HEAD SIM)

SCALE: 0 3" 6" 12"

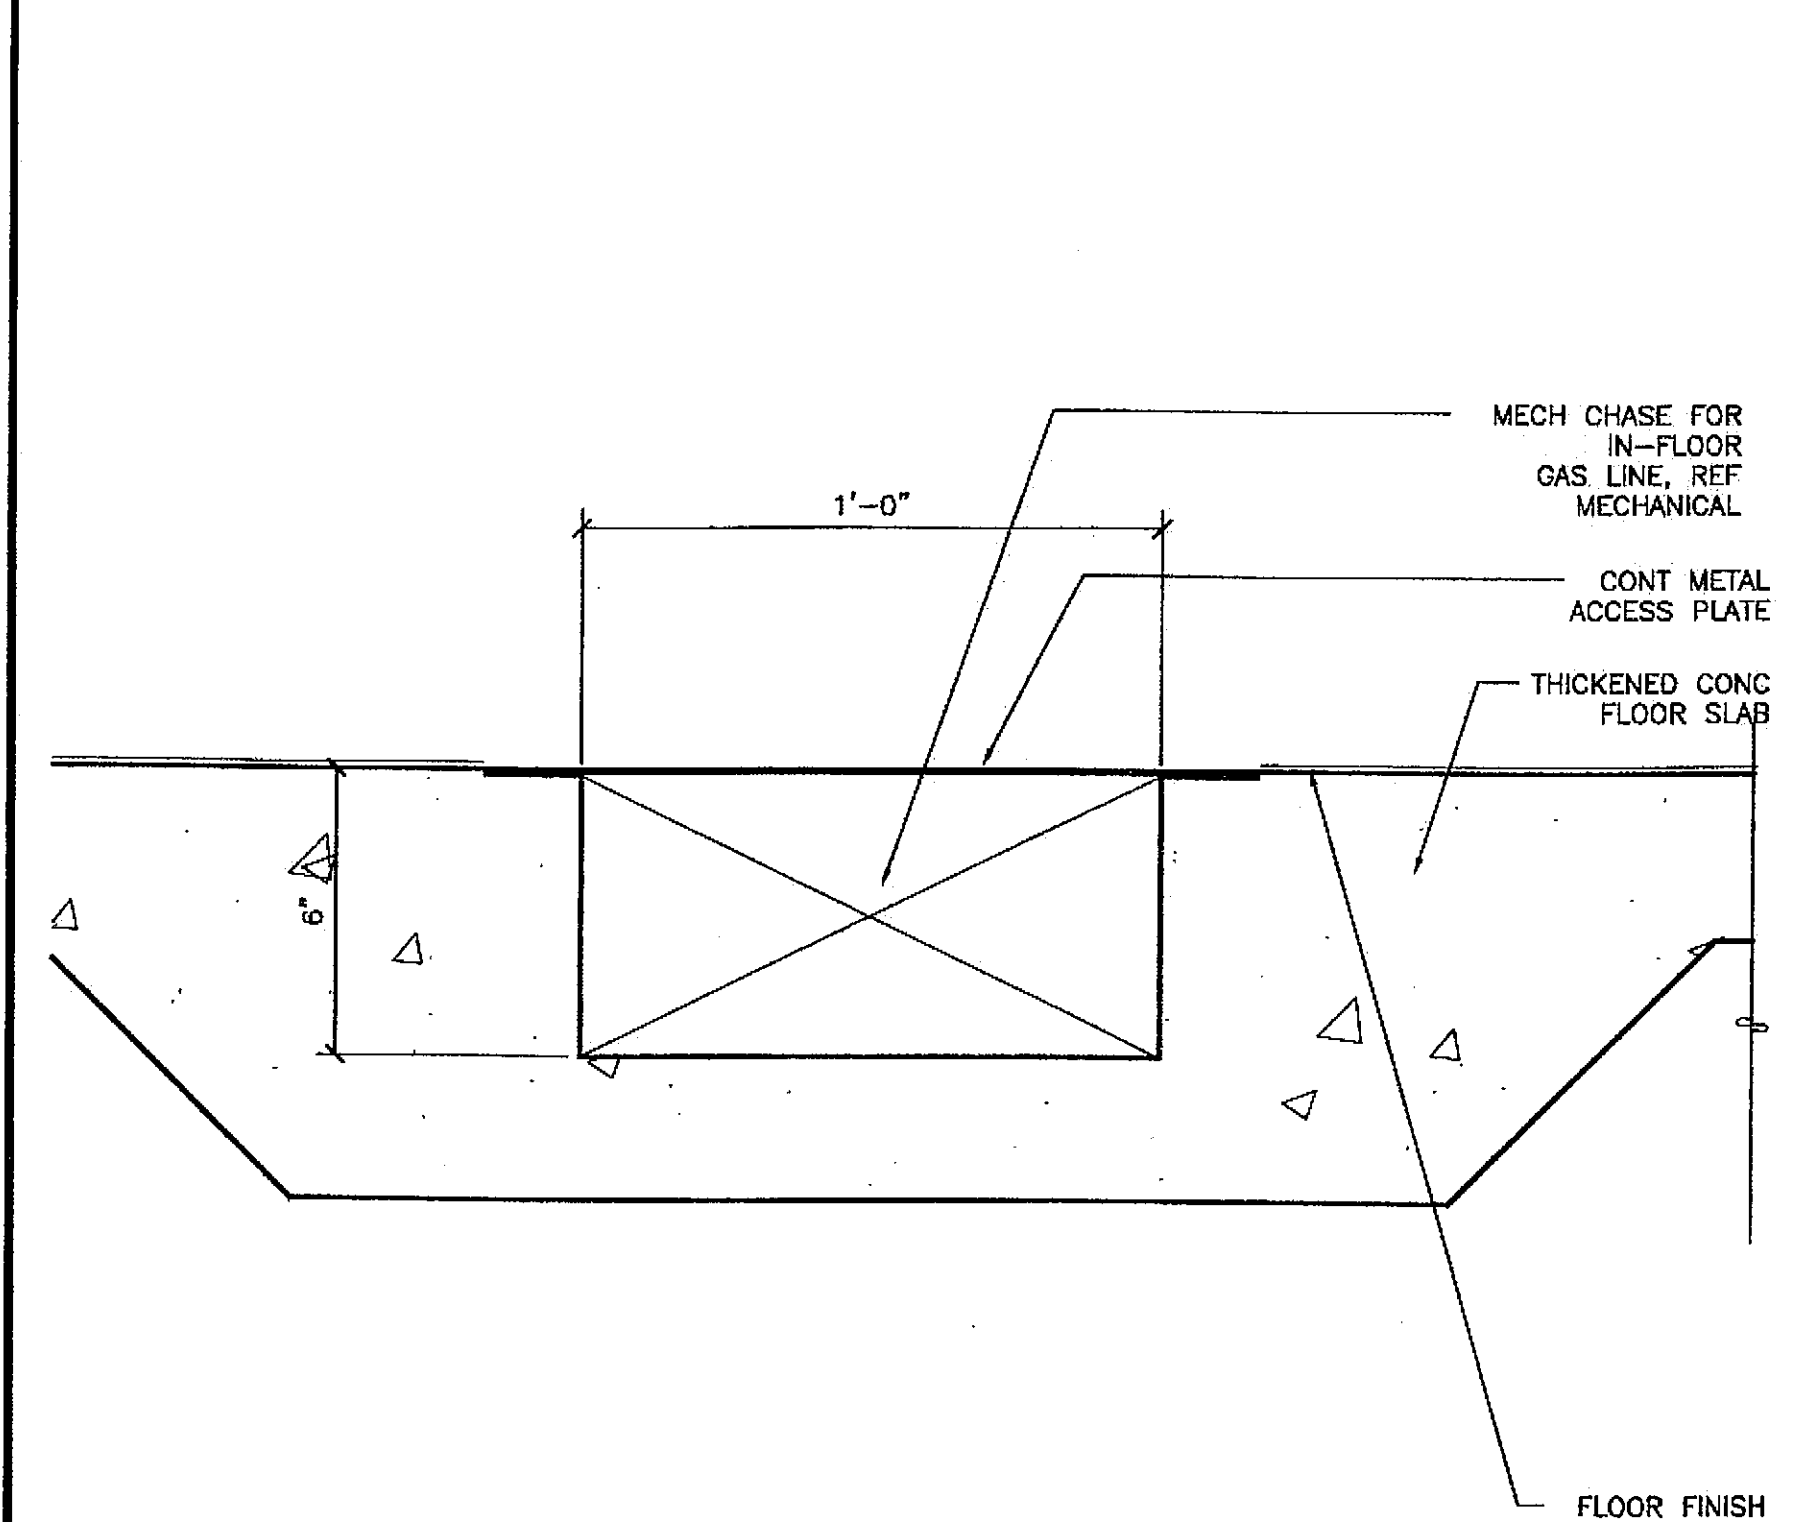


4 GAS TRENCH DETAIL

SCALE: 0 3" 6" 12"

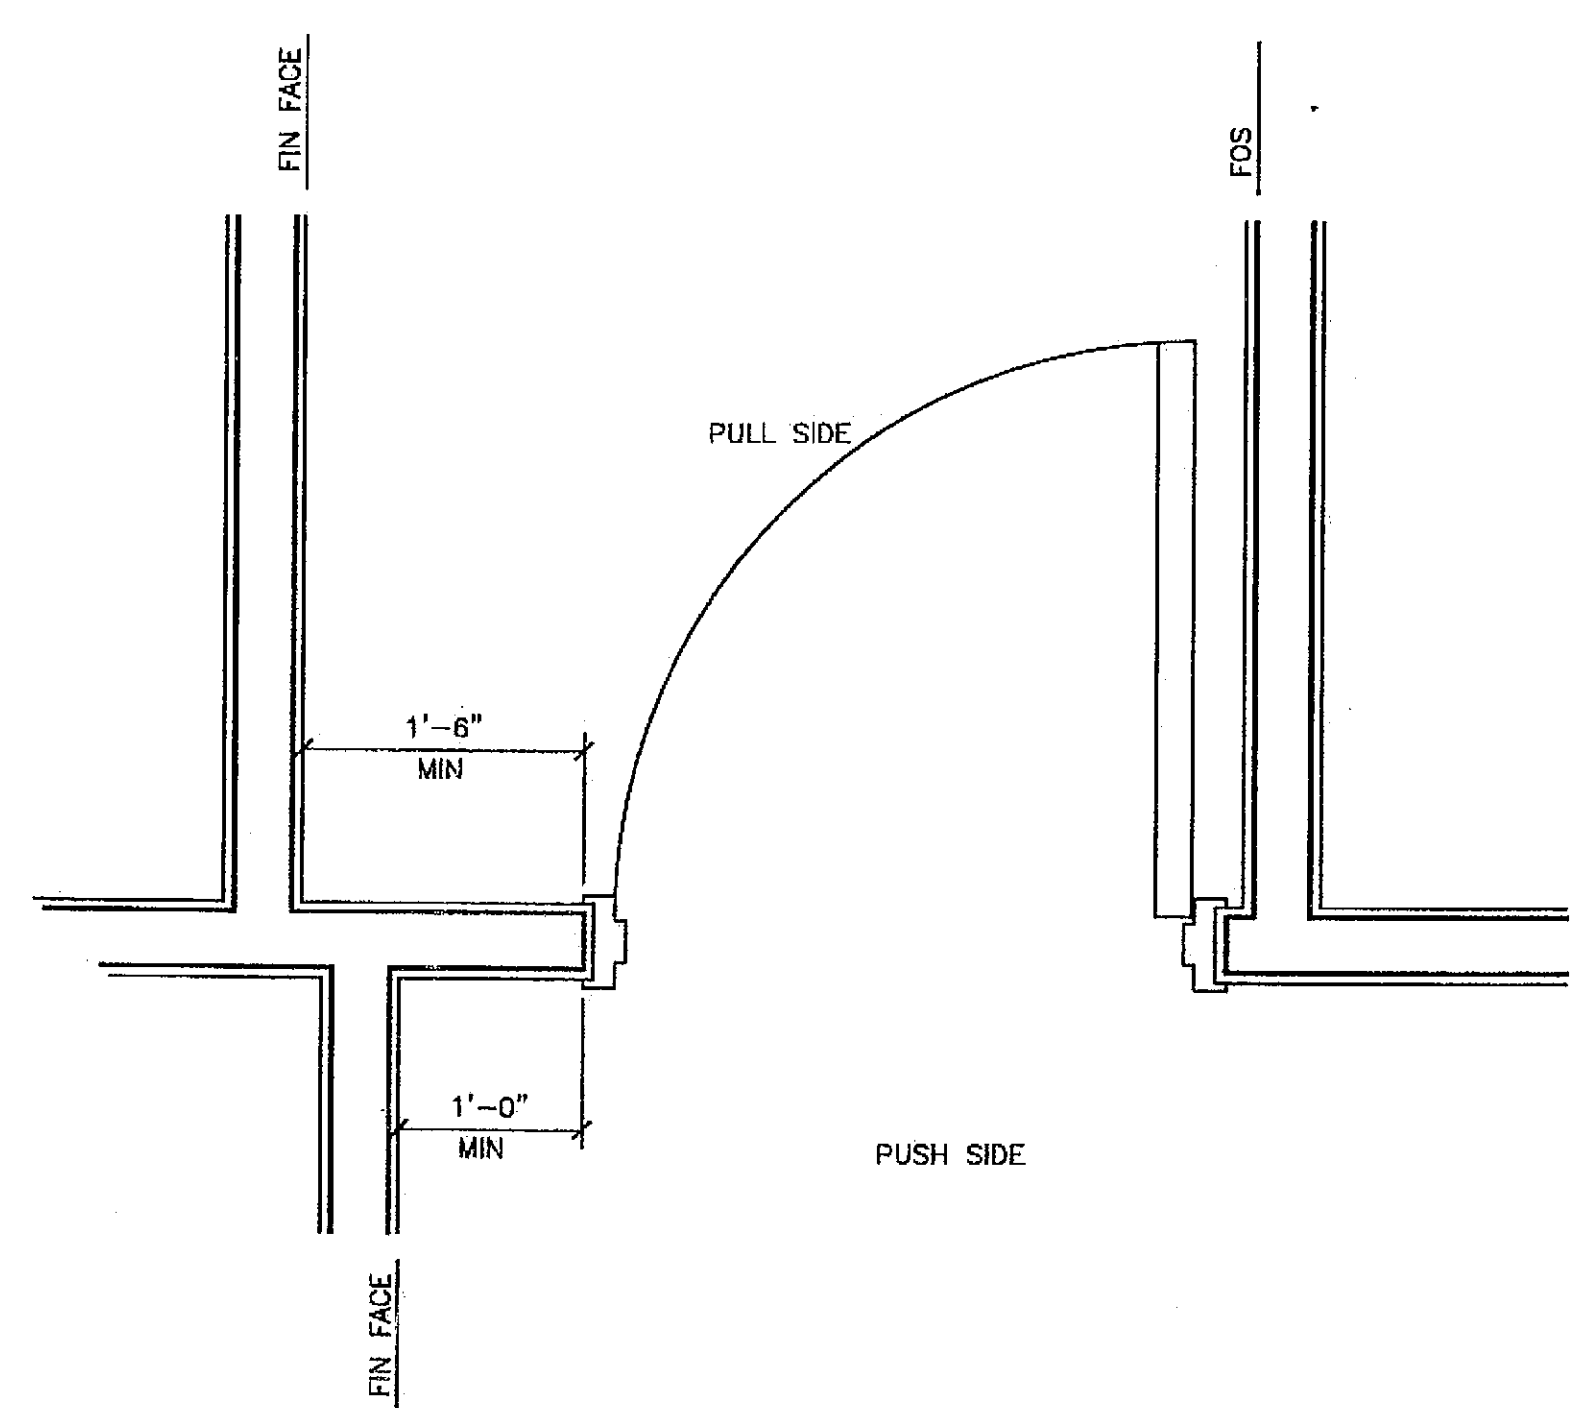

5 TYPICAL DOOR CLEARANCE

SCALE: 0 3" 6" 12"

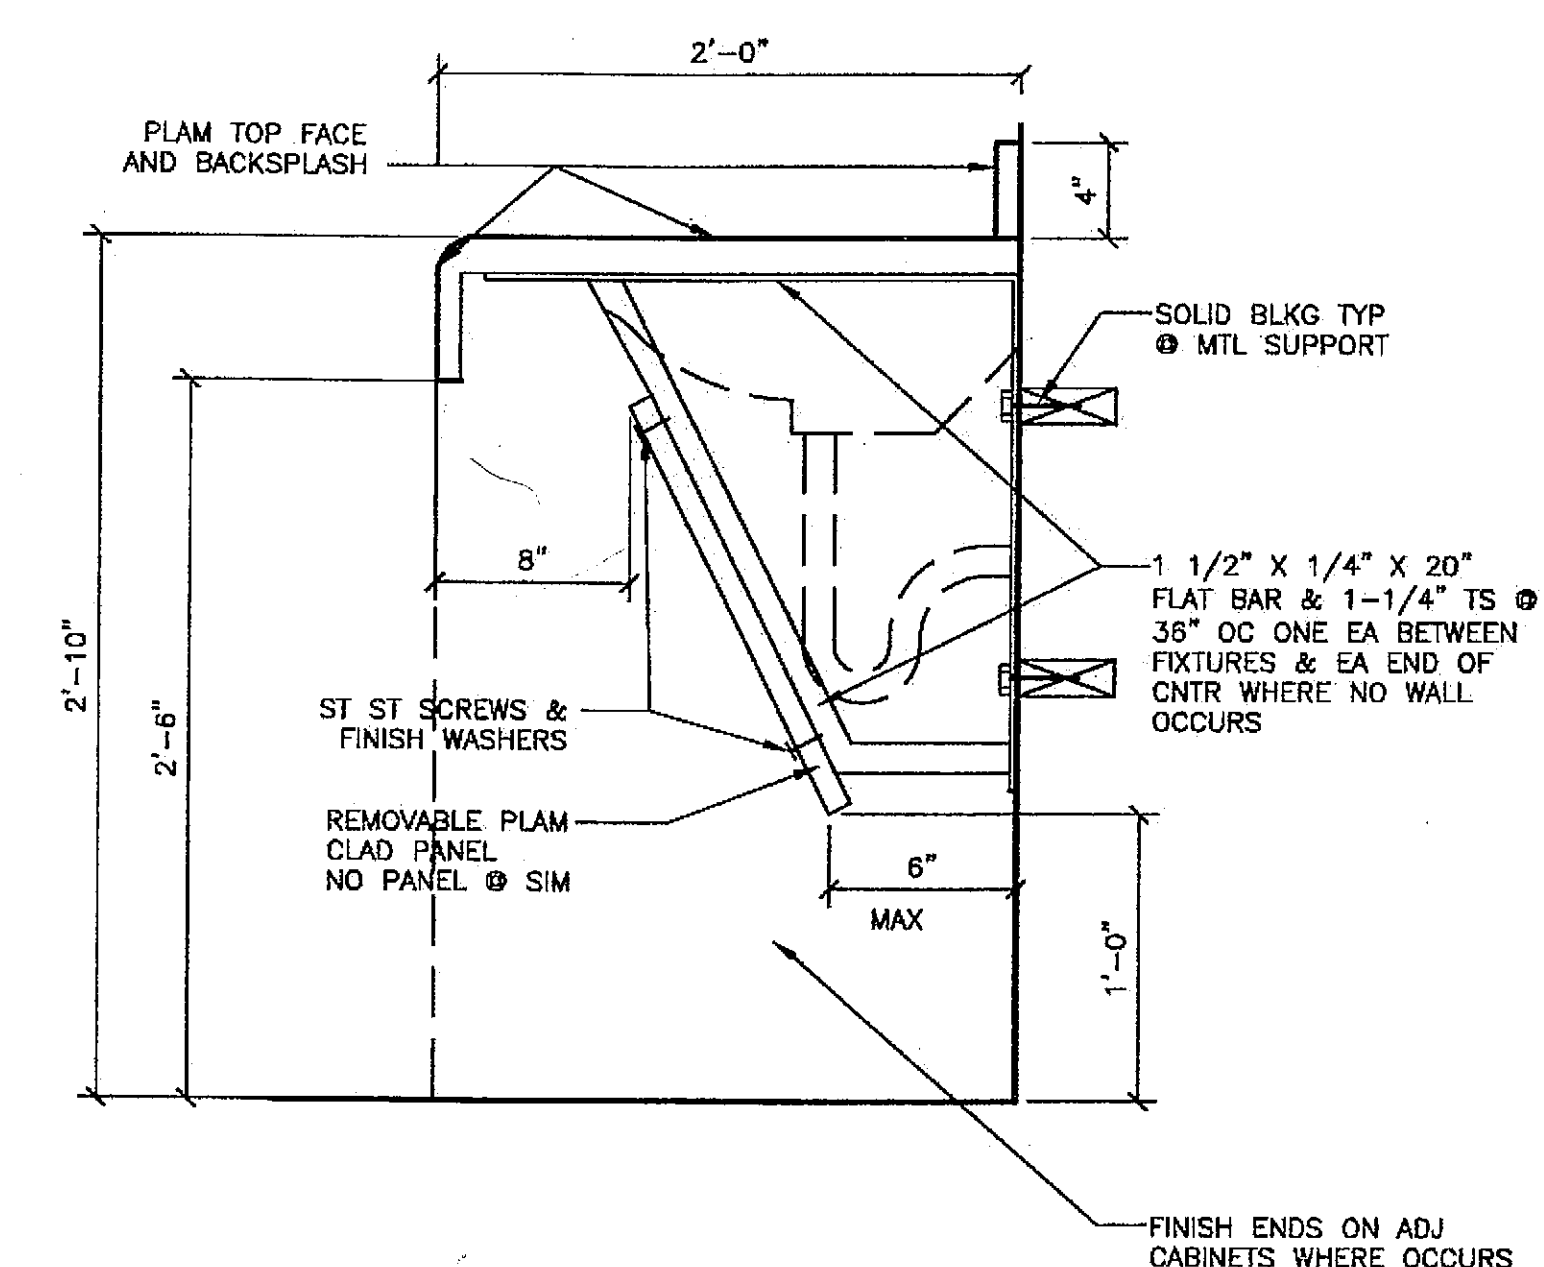


6 SECTION @ SINK COUNTER W/ KNEE SPACE

SCALE: 0 3" 6" 12"

NOTIFY OWNER & ARCHITECT IF DOOR INSTALLATION DOES NOT MEET OR EXCEED DIM SHOWN

Project As-Built Drawings have been reviewed by the Project Engineer and represent to the best of my knowledge, the project as constructed.
Prof. Eng. *[Signature]* Date 7/07

CHECKED BY:

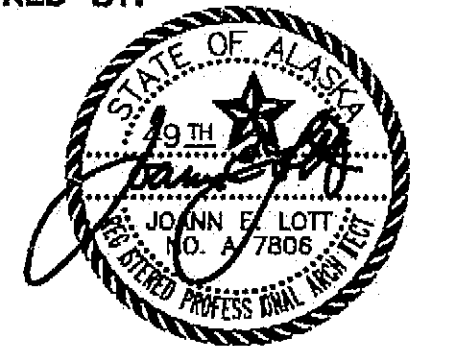

DESIGNED BY: JENSEN YORBA LOTT

DRAWN BY:


STATE OF ALASKA
DEPARTMENT OF TRANSPORTATION & PUBLIC FACILITIES
STATEWIDE DESIGN & ENGINEERING SERVICES DIVISION
MT EDGE CUMBE HIGH SCHOOL BUILDING 1330 ACADEMIC EXPANSION

SHEET A900

PROJECT DESIGNATION NUMBER


67751C

STATE	YEAR
ALASKA	2004
SHEET/NUMBER	TOTAL SHEETS
32	79

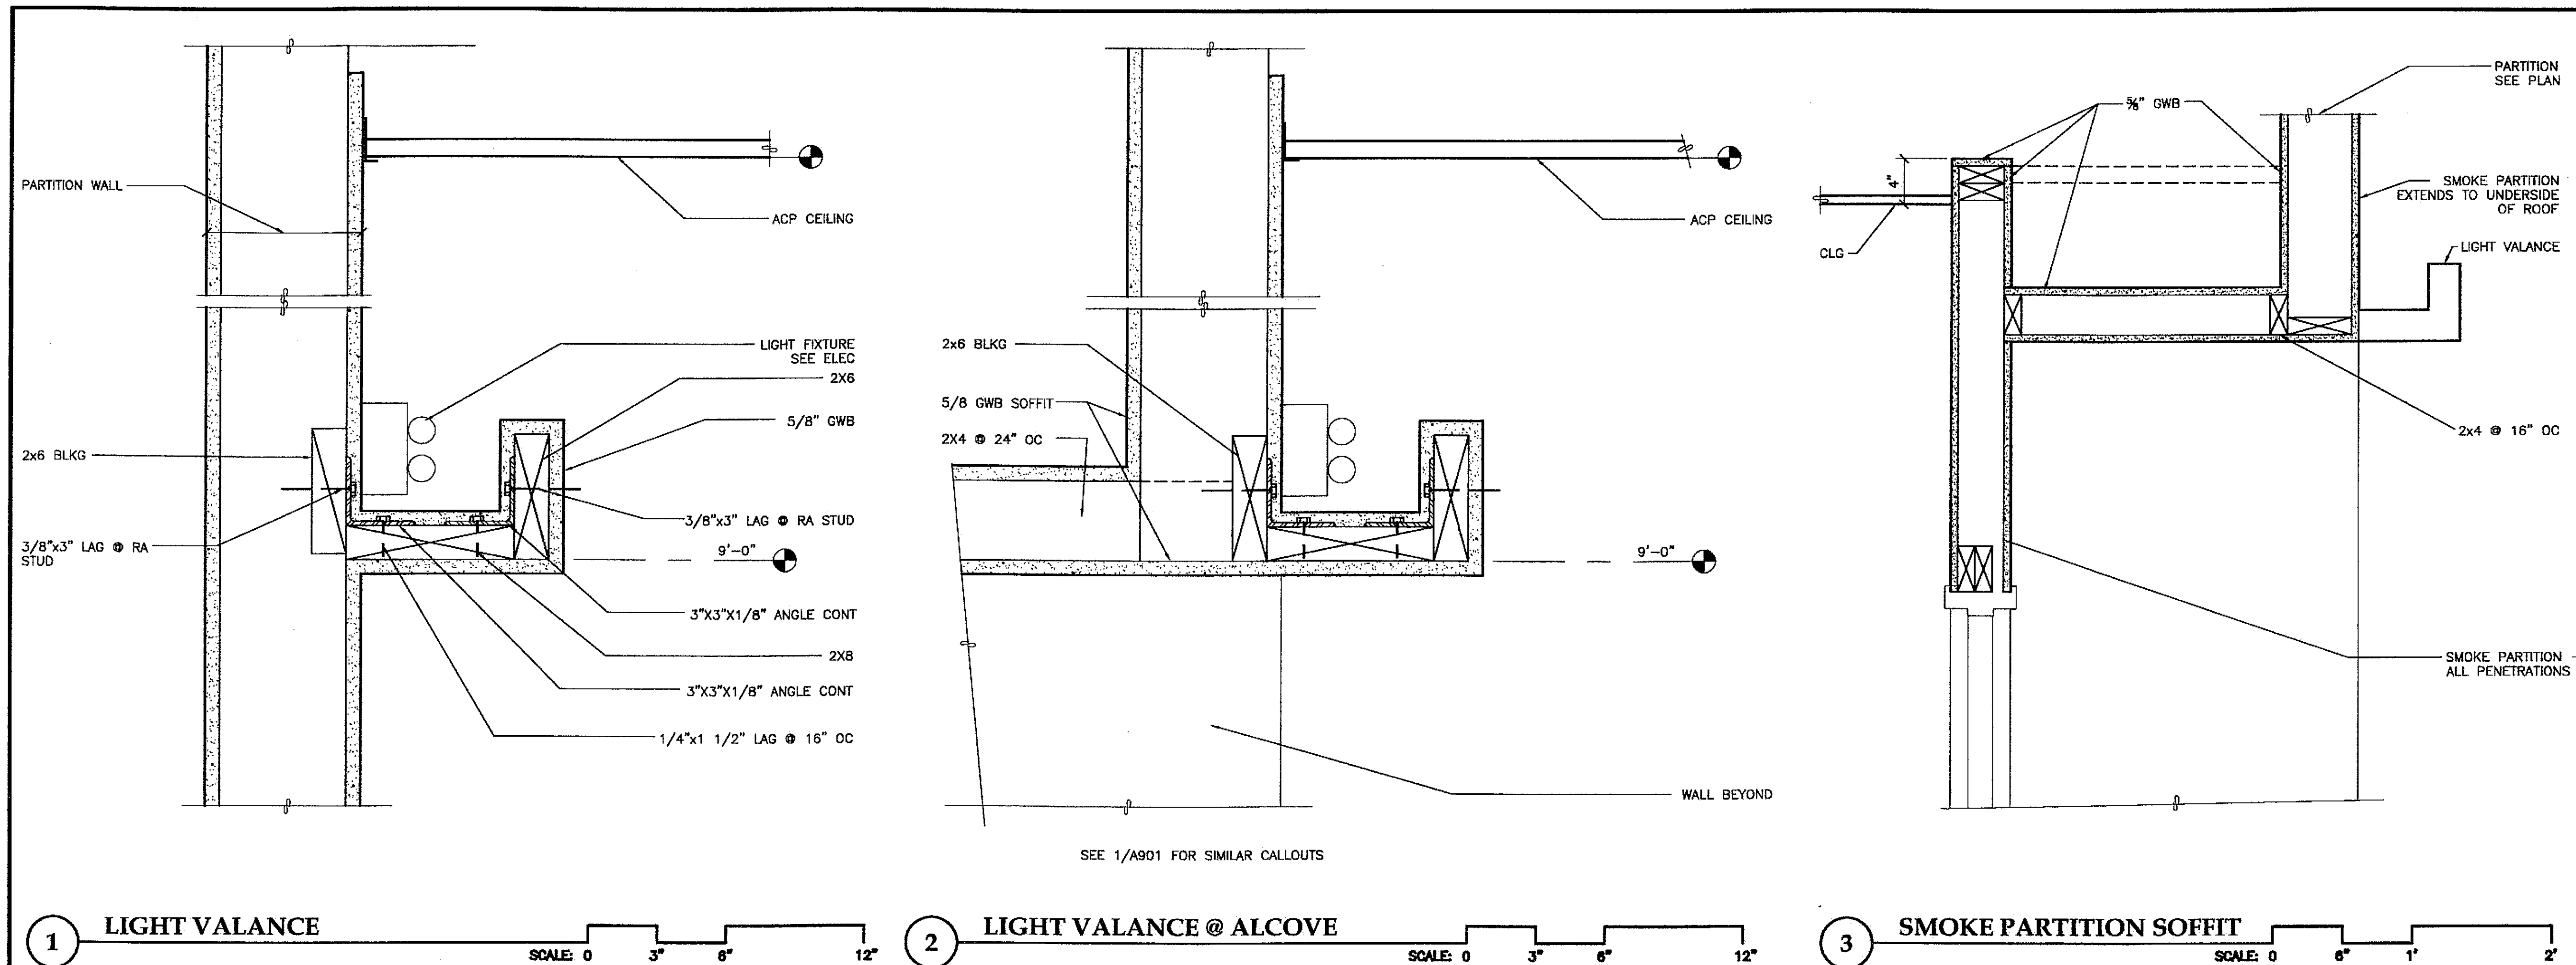

PATH: G:_Projects\0411\Cad\CD\1330\Arch\A901.dwg
 Tue, 14/Dec/04 02:34PM
 TAB: Layout1

ADDENDUM NUMBER		
ATTACHMENT NUMBER		
RECORD OF REVISIONS		
No.	DATE	DESCRIPTION

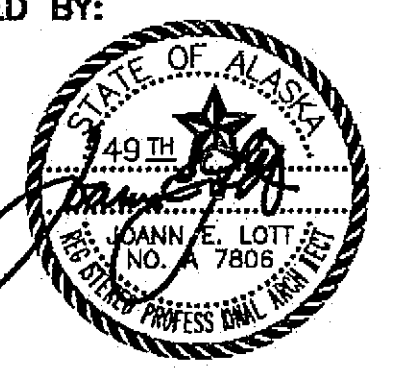CHECKED BY: 
 DESIGNED BY: JENSEN YORBA LOTT
 DRAWN BY:
 STATE OF ALASKA
 DEPARTMENT OF TRANSPORTATION
 & PUBLIC FACILITIES
 STATEWIDE DESIGN & ENGINEERING
 SERVICES DIVISION
 MT EDGECUMBE
 HIGH SCHOOL
 BUILDING 1330
 ACADEMIC
 EXPANSION
 SHEET A901
 PROJECT DESIGNATION NUMBER
 67751C

STATE	YEAR
ALASKA	2004
SHEET NUMBER	TOTAL SHEETS
33	79

Project As-Built Drawings have been
 reviewed by the Project Engineer and
 represent to the best of my knowledge, the
 project as constructed.
 Proj. Eng. *J. E. Lott* Date *7-07*

ADDENDUM NUMBER


ATTACHMENT NUMBER

RECORD OF REVISIONS


No.	DATE	DESCRIPTION

PLANT MATERIAL SCHEDULE

SYM	QTY	BOTANICAL	COMMON	SIZE	ROOT	COMMENTS
TREES						
AC	8	Acer circinatum	Vine maple	8' high	B&B	Multi-stemmed specimen. Detail 1/L103
PP	4	Pinus parviflora	Japanese white pine	6' high	B&B	Specimen. Detail 6/L103
SHRUBS						
RR	14	Rhododendron 'Ramapo'	Ramapo rhododendron	2 gal	CG	2.5' OC Detail 2/L103
SG	12	Spiraea japonica 'Golden Elf'	Golden elf spirea	1 gal	CG	2.0' OC Detail 2/L103
SJ	50	Spiraea japonica 'Magic Carpet'	Magic carpet spirea	2 gal	CG	2.0' OC Detail 2/L103
PERENNIALS/GRASSES						
A	62	Astilbe arendsii 'Fanal'	Fanal astilbe	1 gal	CG	1.5' OC Detail 2/L103
D	38	Deschampsia caespitosa	Tufted hair grass	1 gal	CG	1.5' OC Detail 2/L103
F	79	Athyrium filix-femina	Lady fern	1 gal	CG	1.5' OC Detail 2/L103

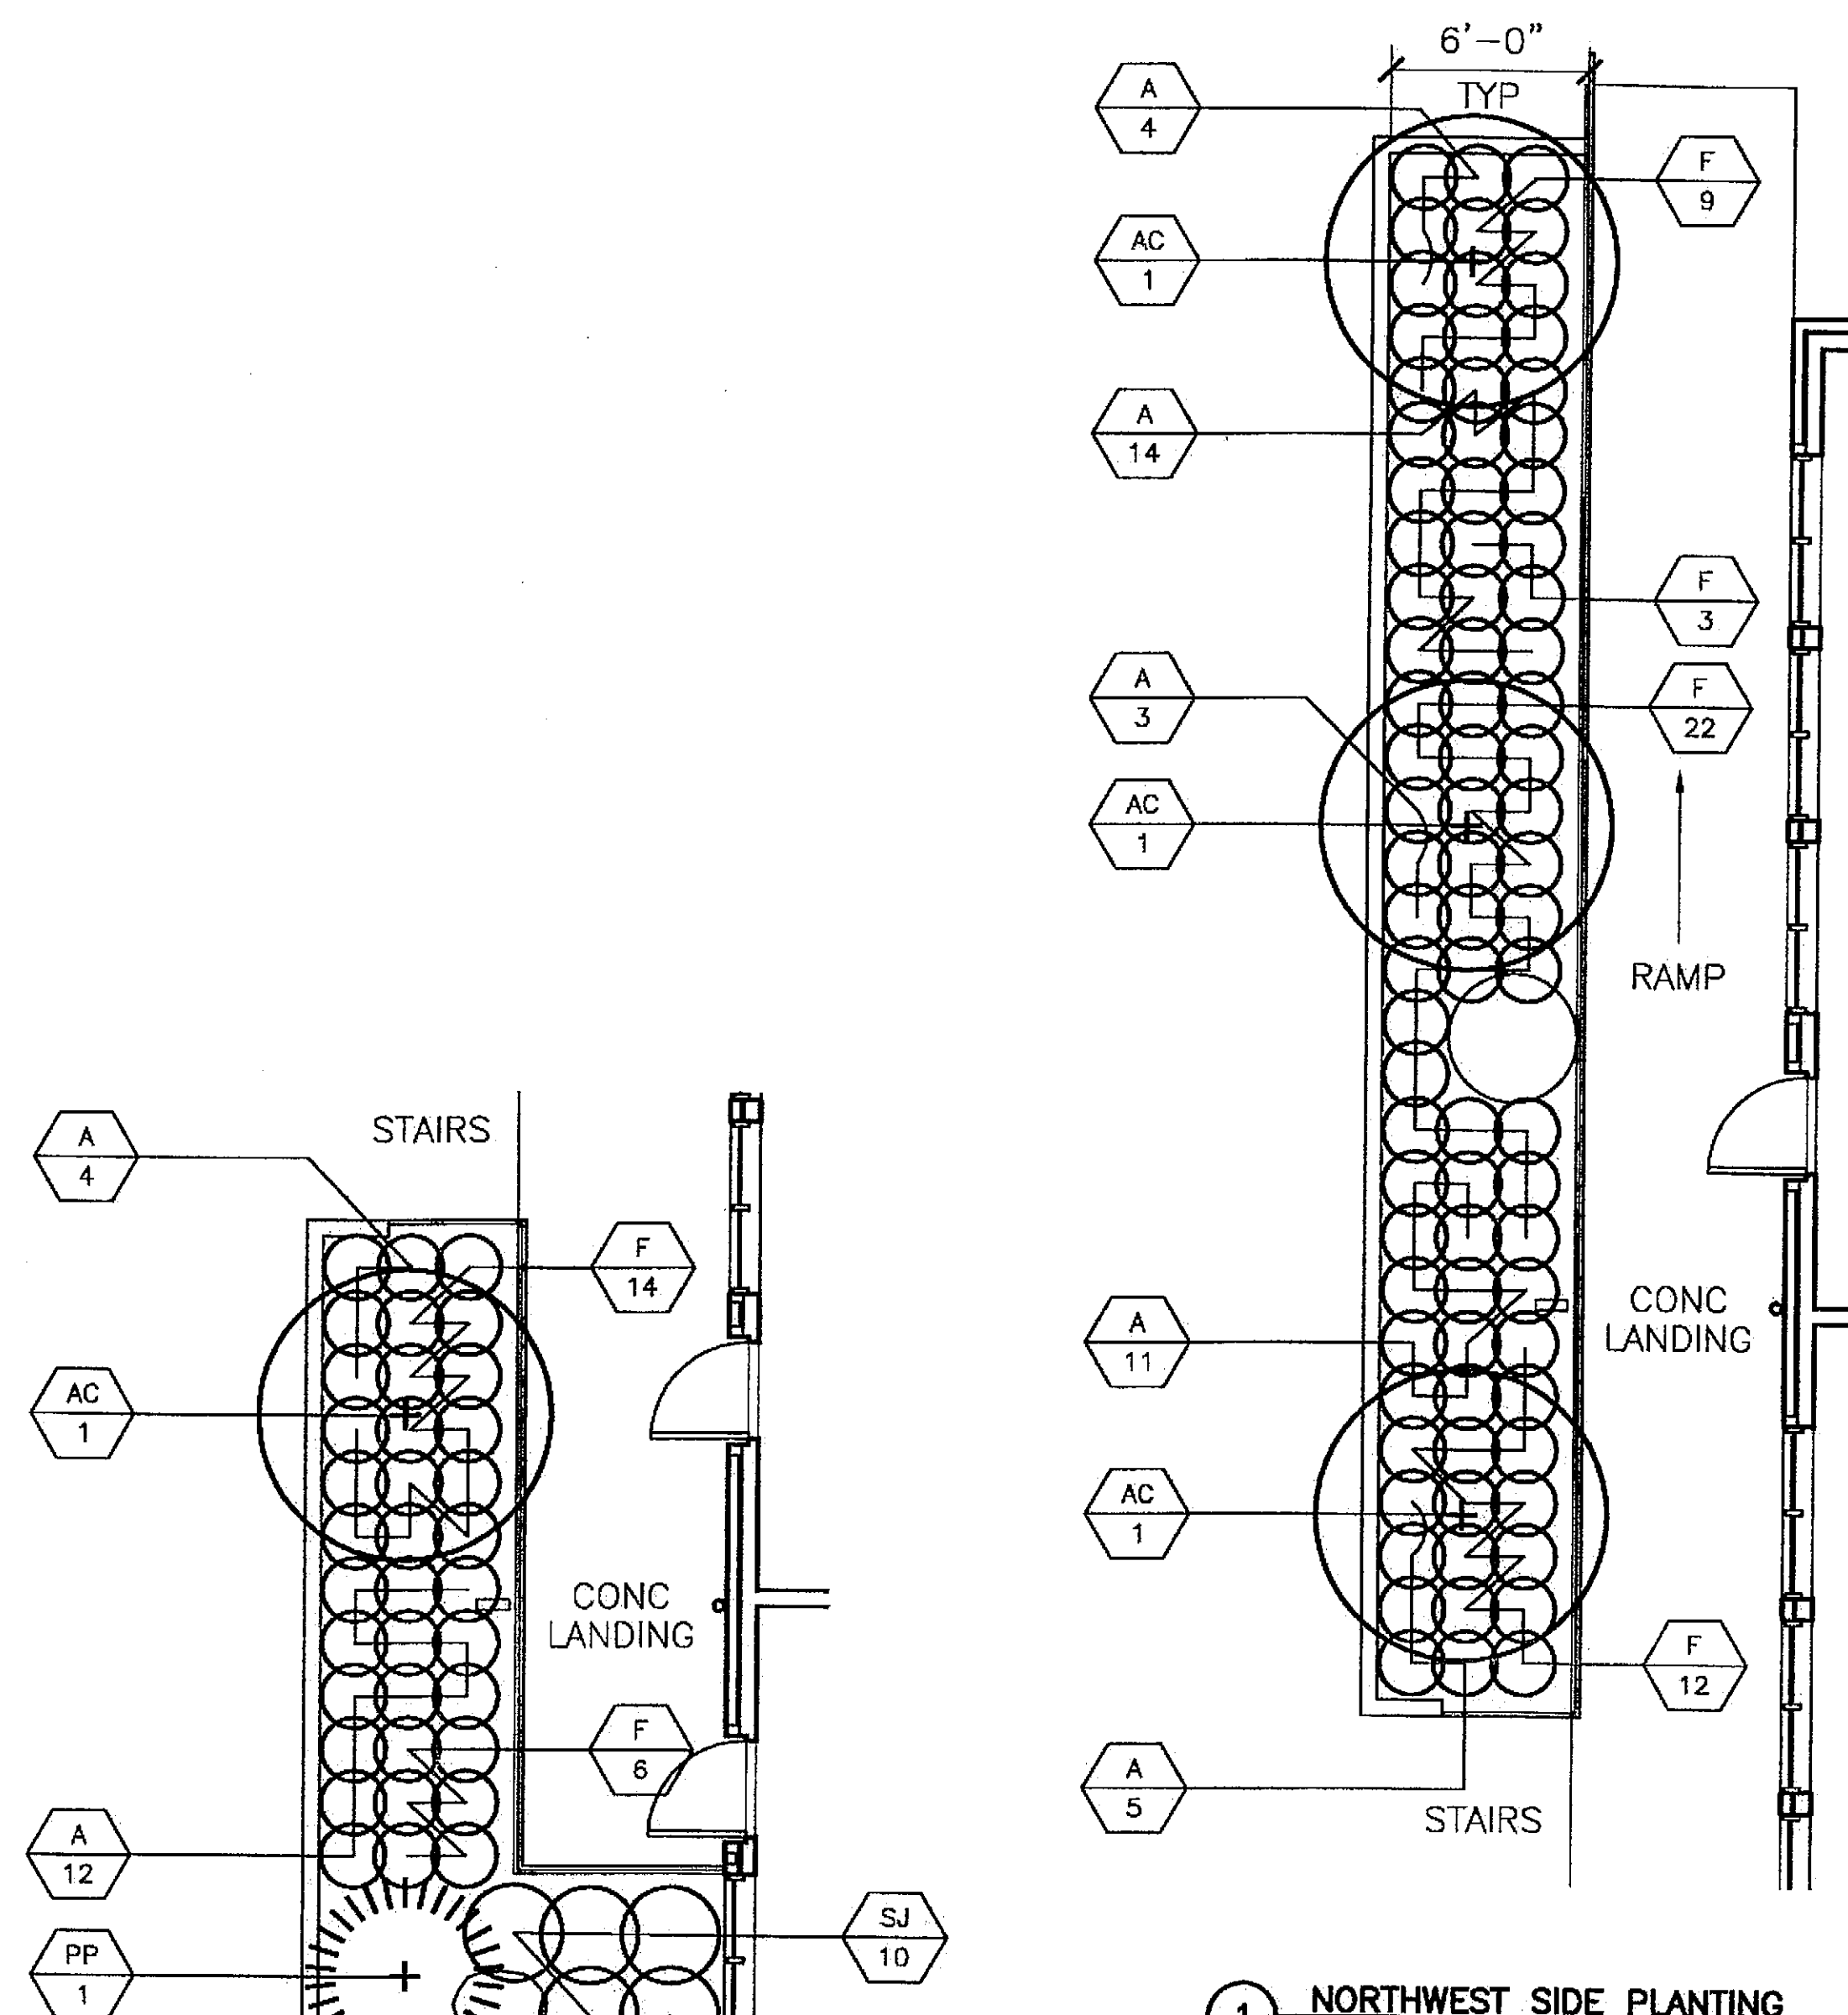

1 NORTHWEST SIDE PLANTING

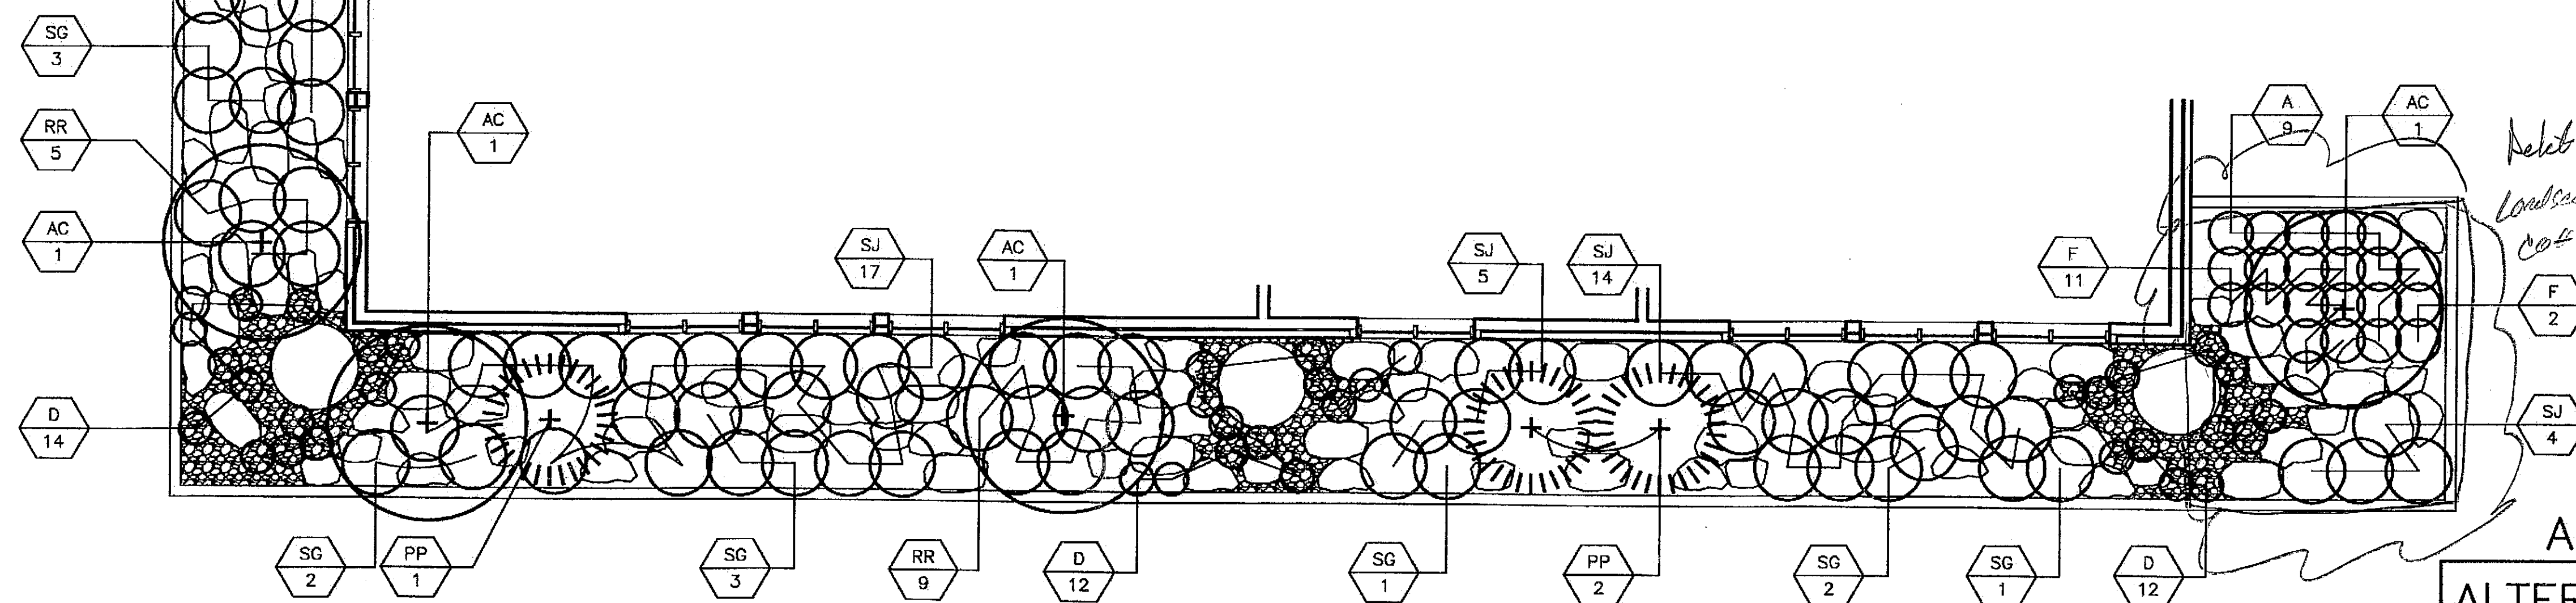

2 SOUTH SIDE PLANTING

LANDSCAPE PLANTING PLANS
SCALE: 0' 5' 10'

ALL WORK
ALTERNATE 3

CHECKED BY:



DESIGNED BY: JENSEN YORBA LOTT

DRAWN BY: CRM

STATE OF ALASKA
DEPARTMENT OF TRANSPORTATION
& PUBLIC FACILITIES
STATEWIDE DESIGN & ENGINEERING
SERVICES DIVISION
MT EDGECUMBE
HIGH SCHOOL
BUILDING 1330
ACADEMIC
EXPANSION

SHEET L102
PROJECT DESIGNATION NUMBER
67751C

STATE	YEAR
ALASKA	2004
SHEET NUMBER	TOTAL SHEETS
35	79


Project As-Built Drawings have been reviewed by the Project Engineer and represent to the best of my knowledge, the project as constructed.
Proj. Eng. *M. Mertz* Date 7-07

ADDENDUM NUMBER


ATTACHMENT NUMBER

RECORD OF REVISIONS


No.	DATE	DESCRIPTION

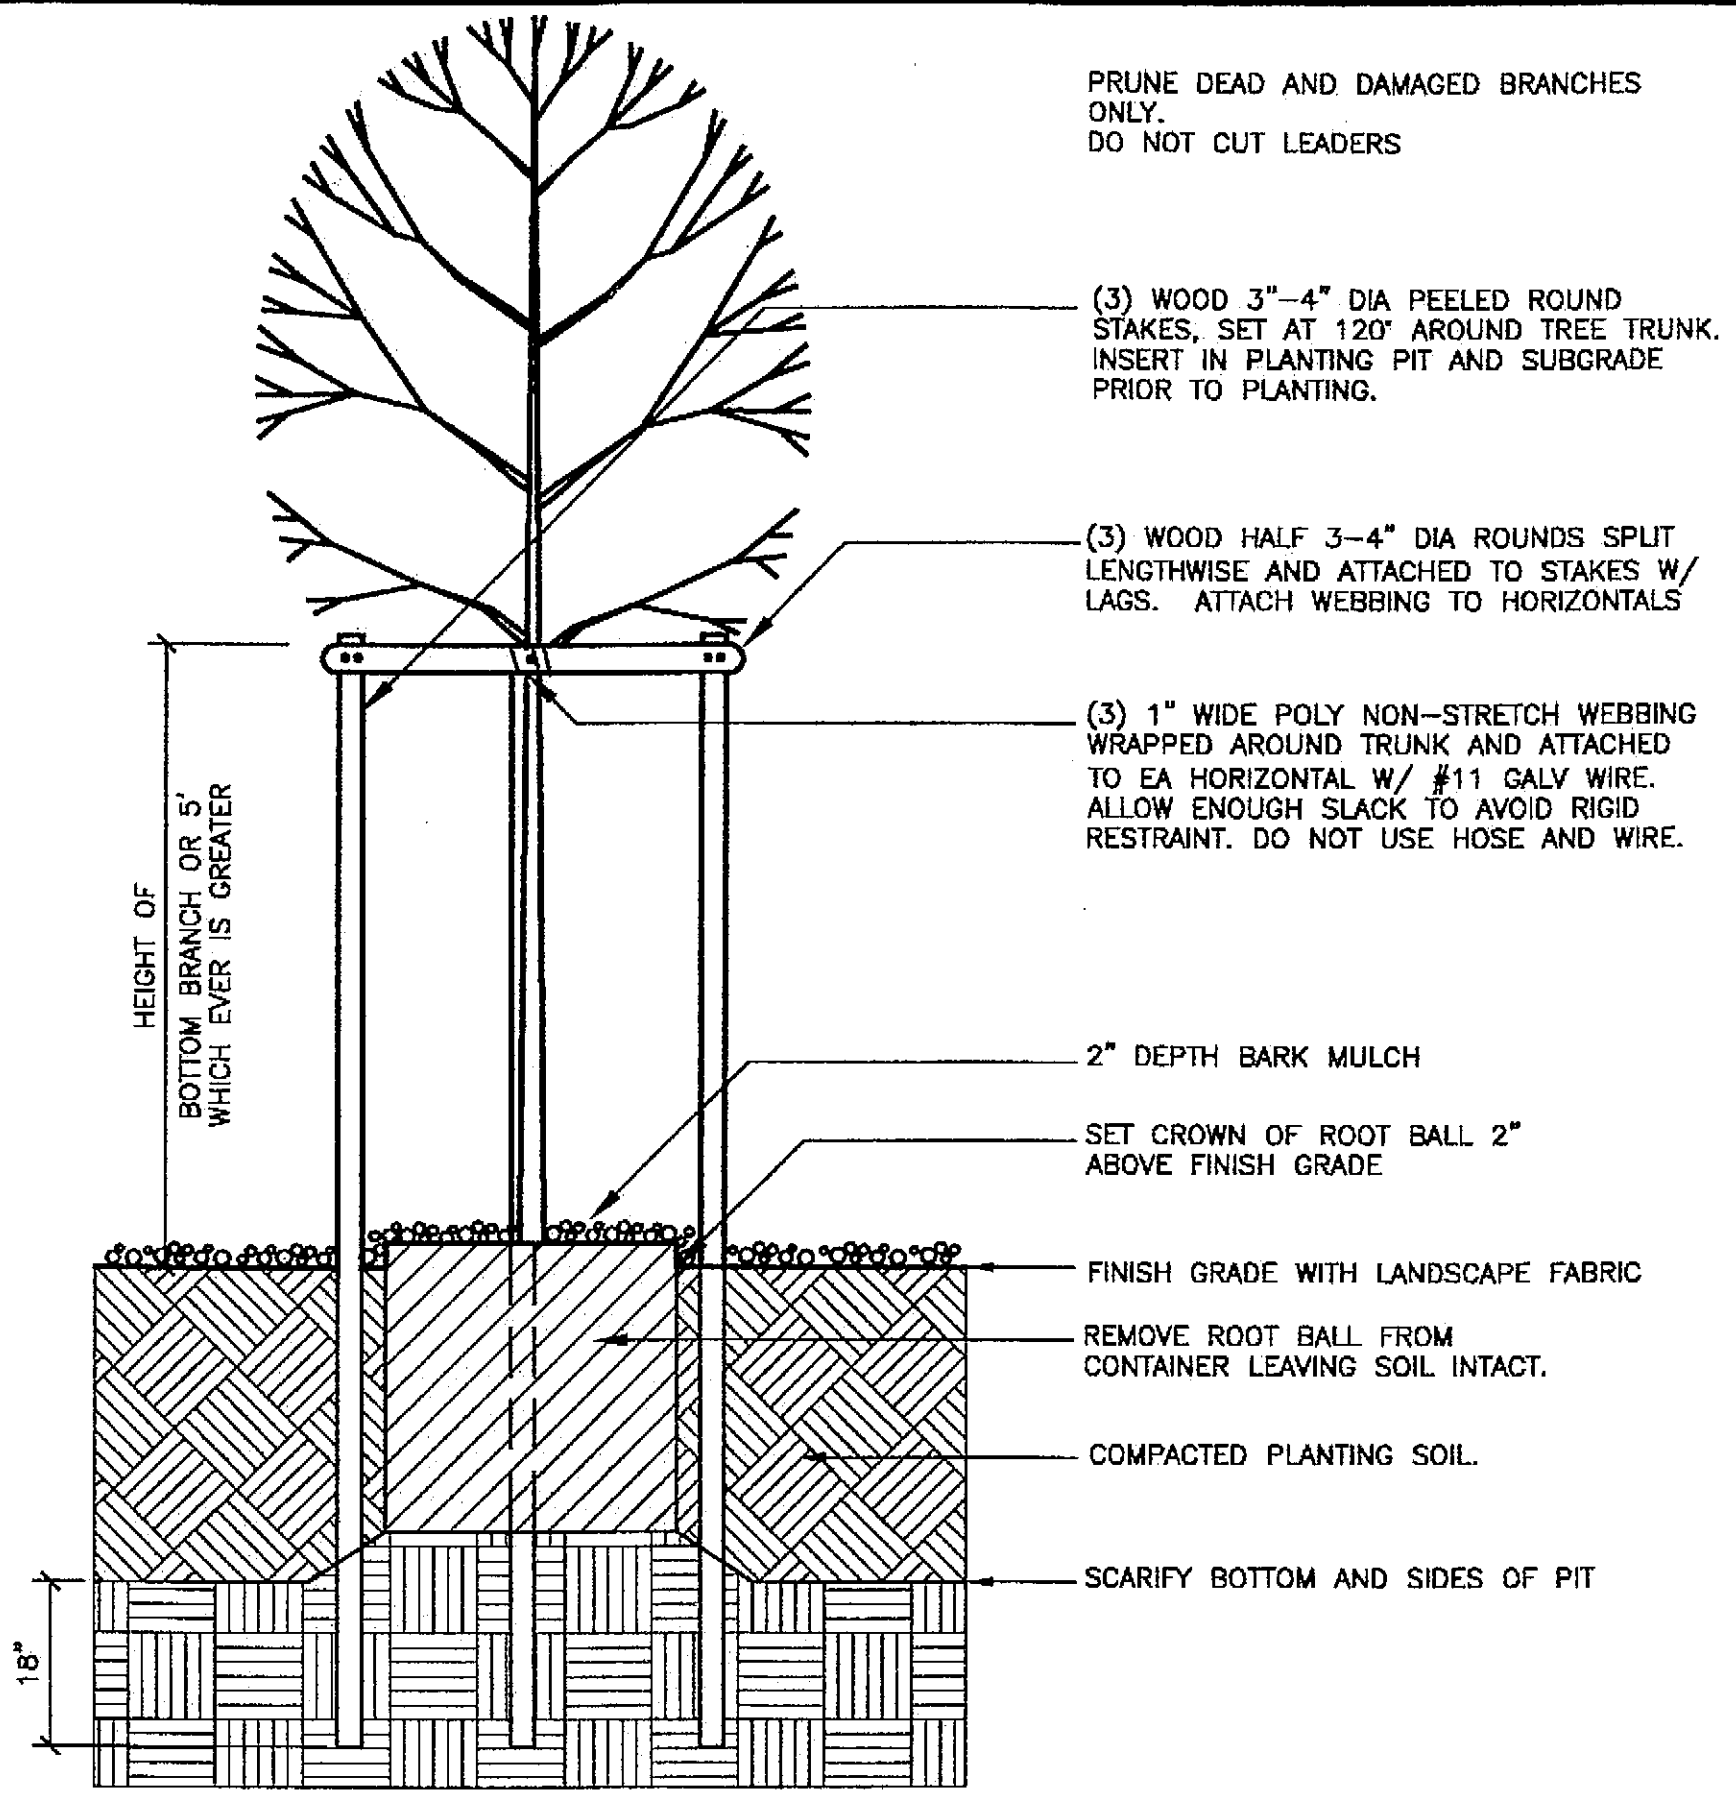

1 TREE W/ THREE STAKES
SCALE: 0 6" 1' 2' 4'

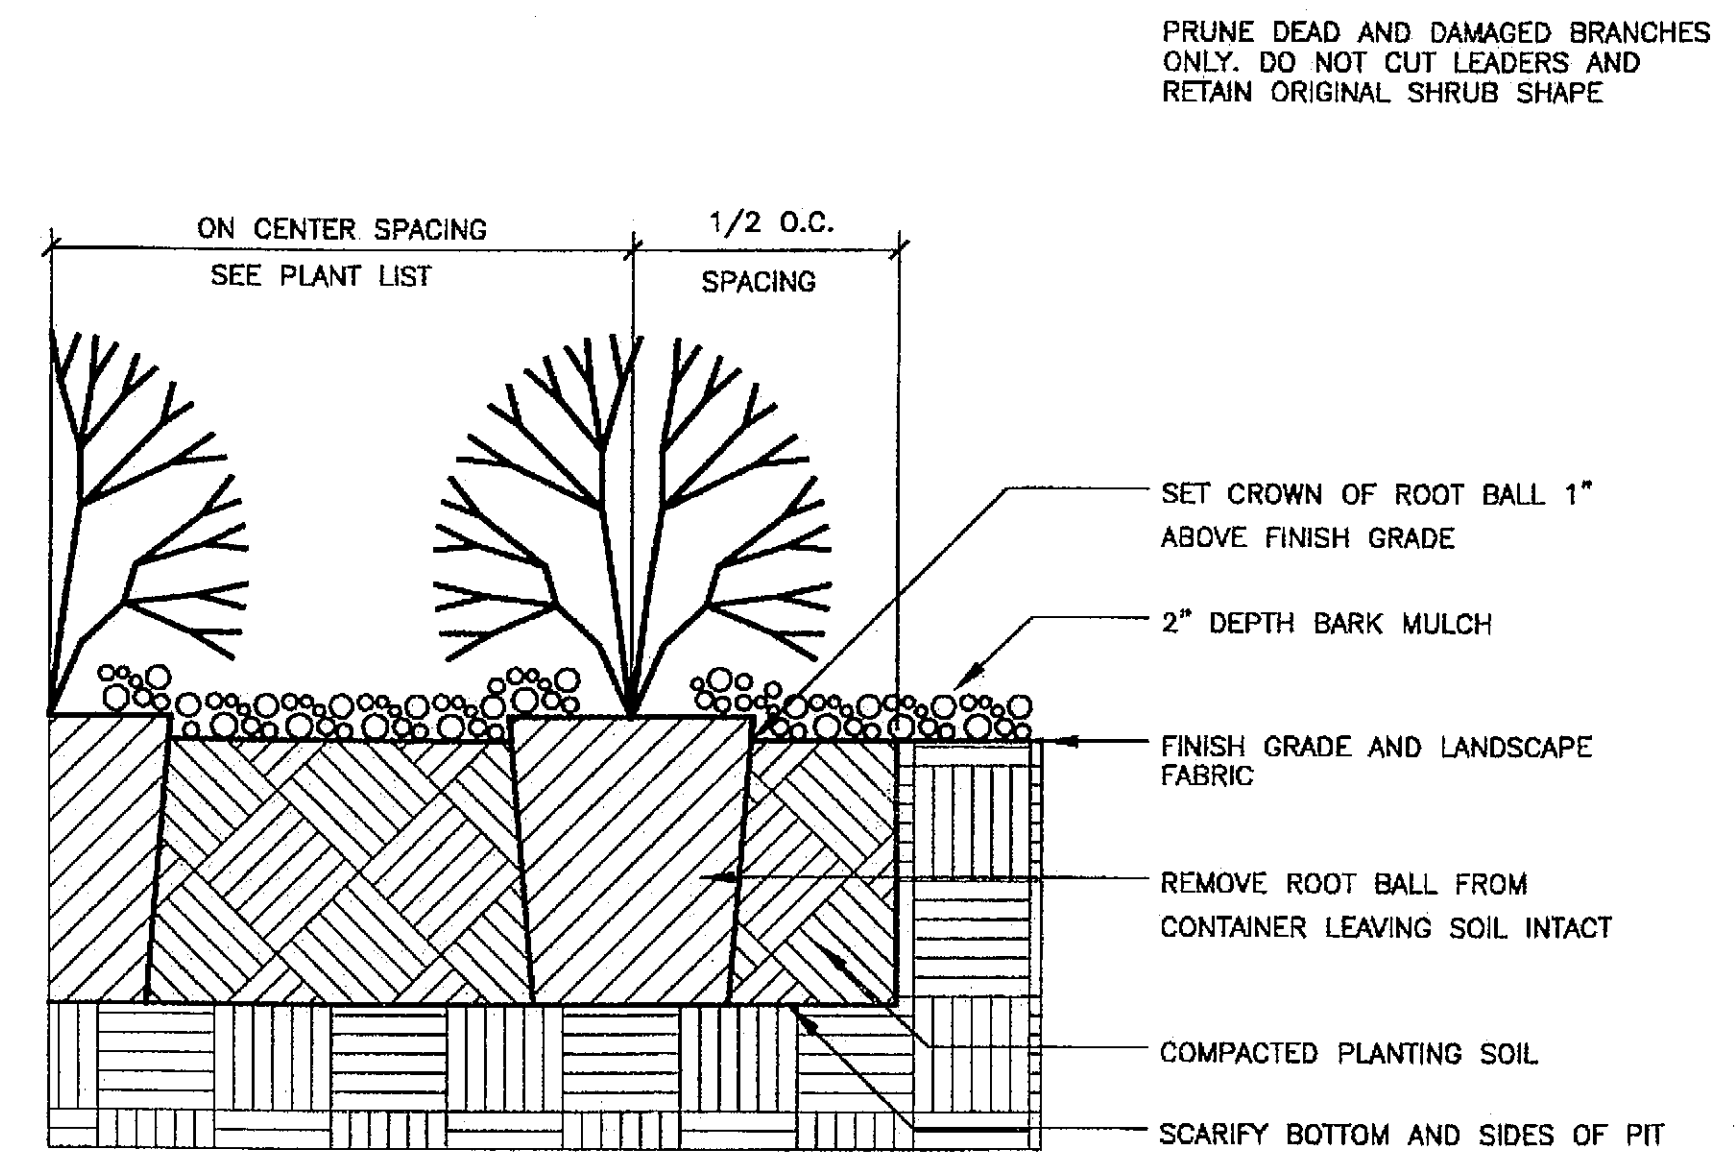


2 SHRUB/PERENNIAL PLANTING
SCALE: 0 6" 1' 2'

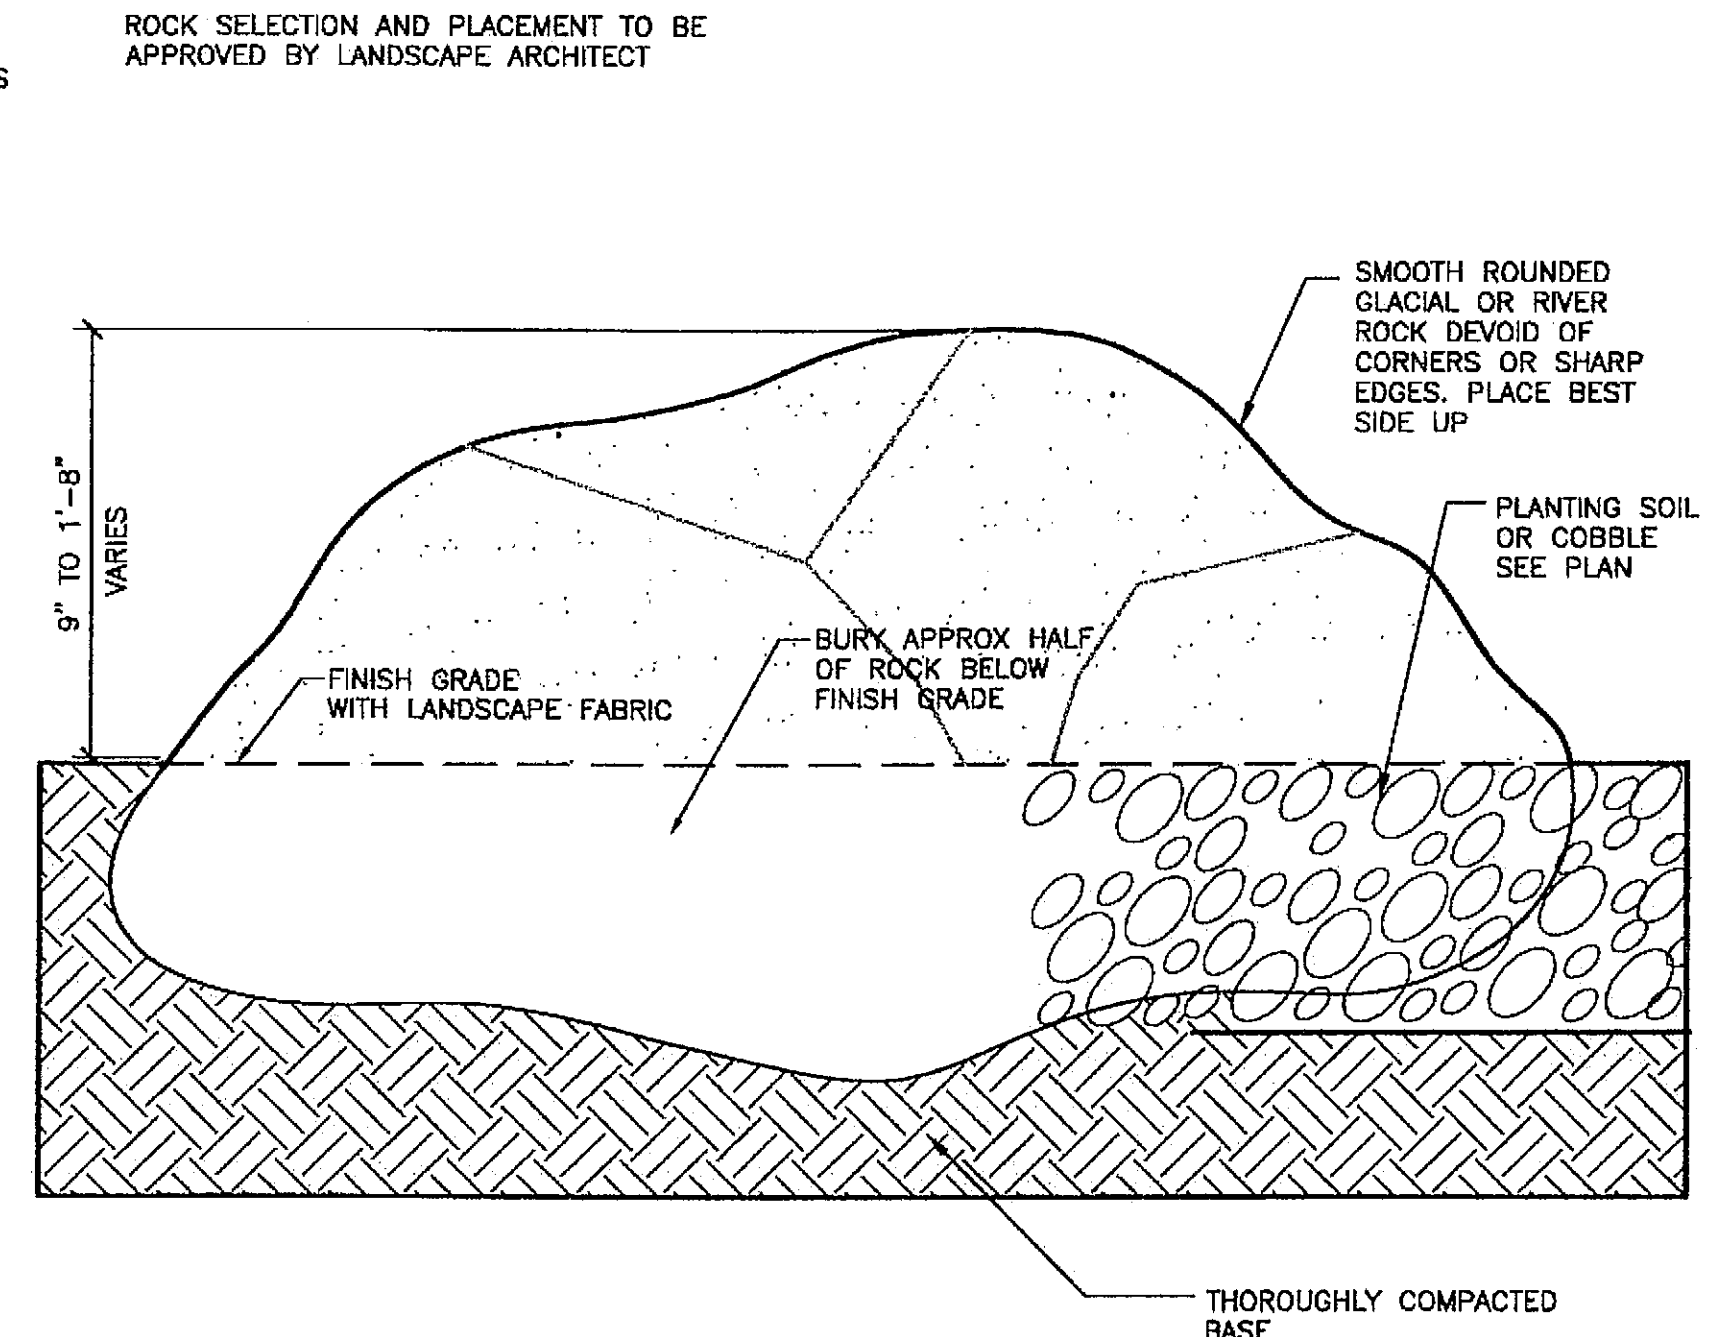


3 ROCK DETAIL
SCALE: 0 6" 1' 2'


ALL WORK
ALTERNATE 3

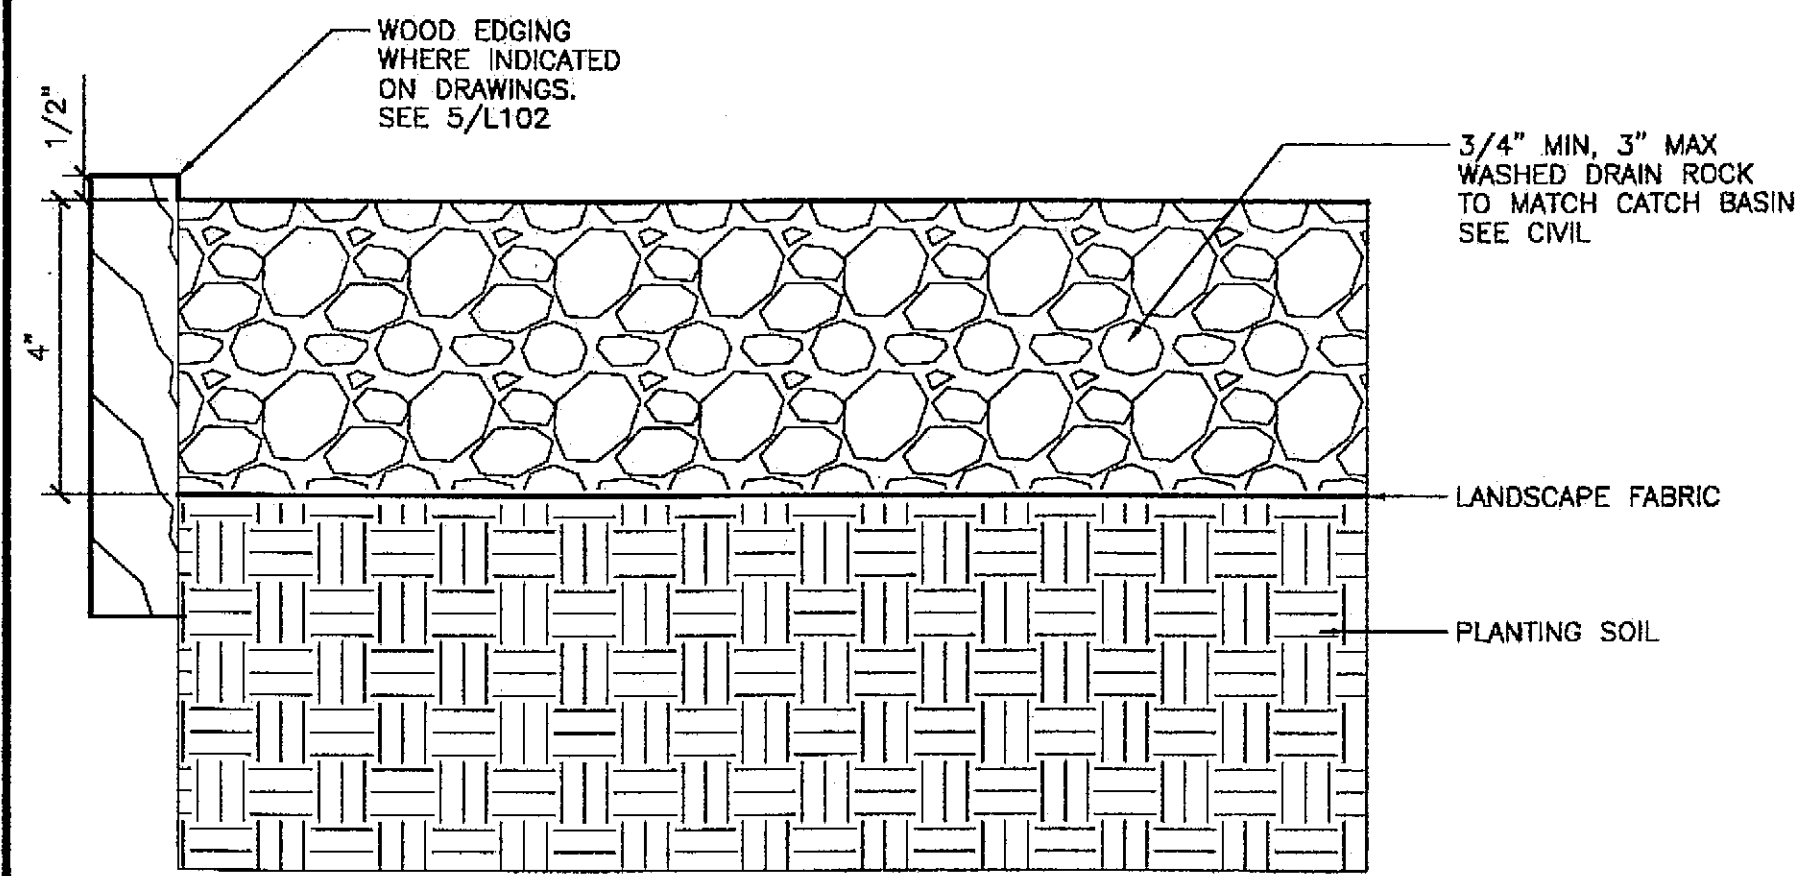

4 COBBLE SURFACING
SCALE: 0 3' 6" 12'

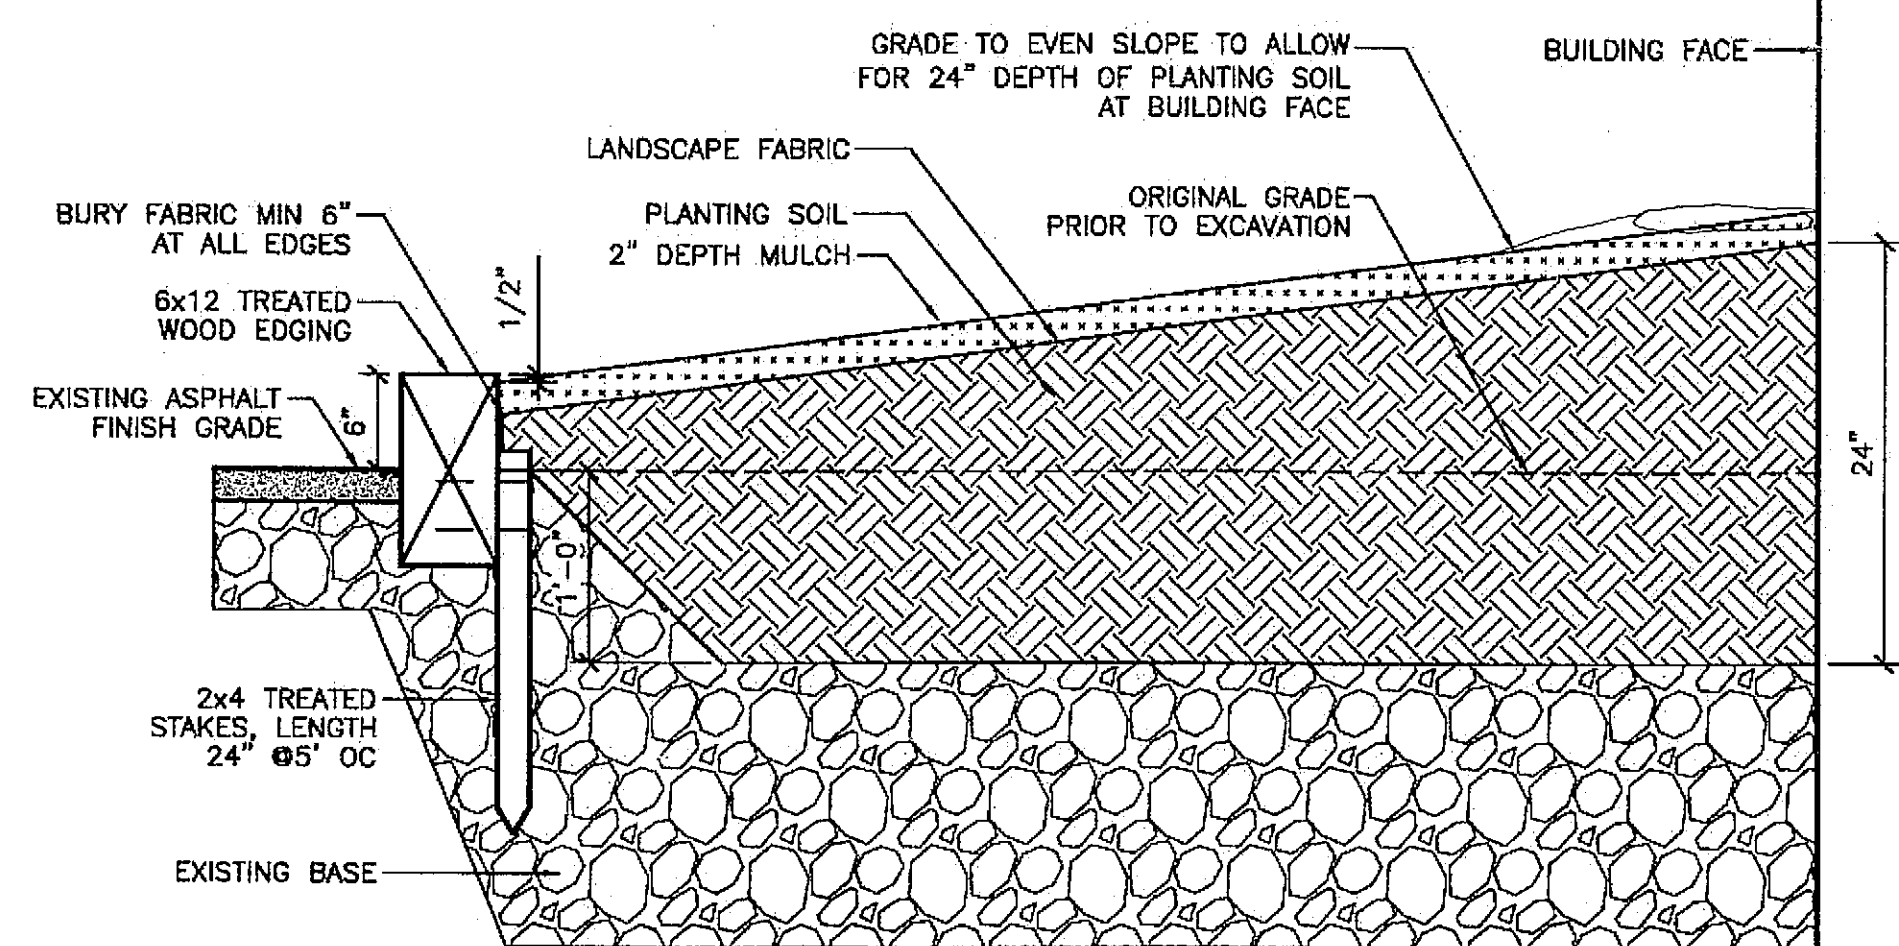


5 EDGING SOIL DETAIL
SCALE: 0 6" 1' 2'

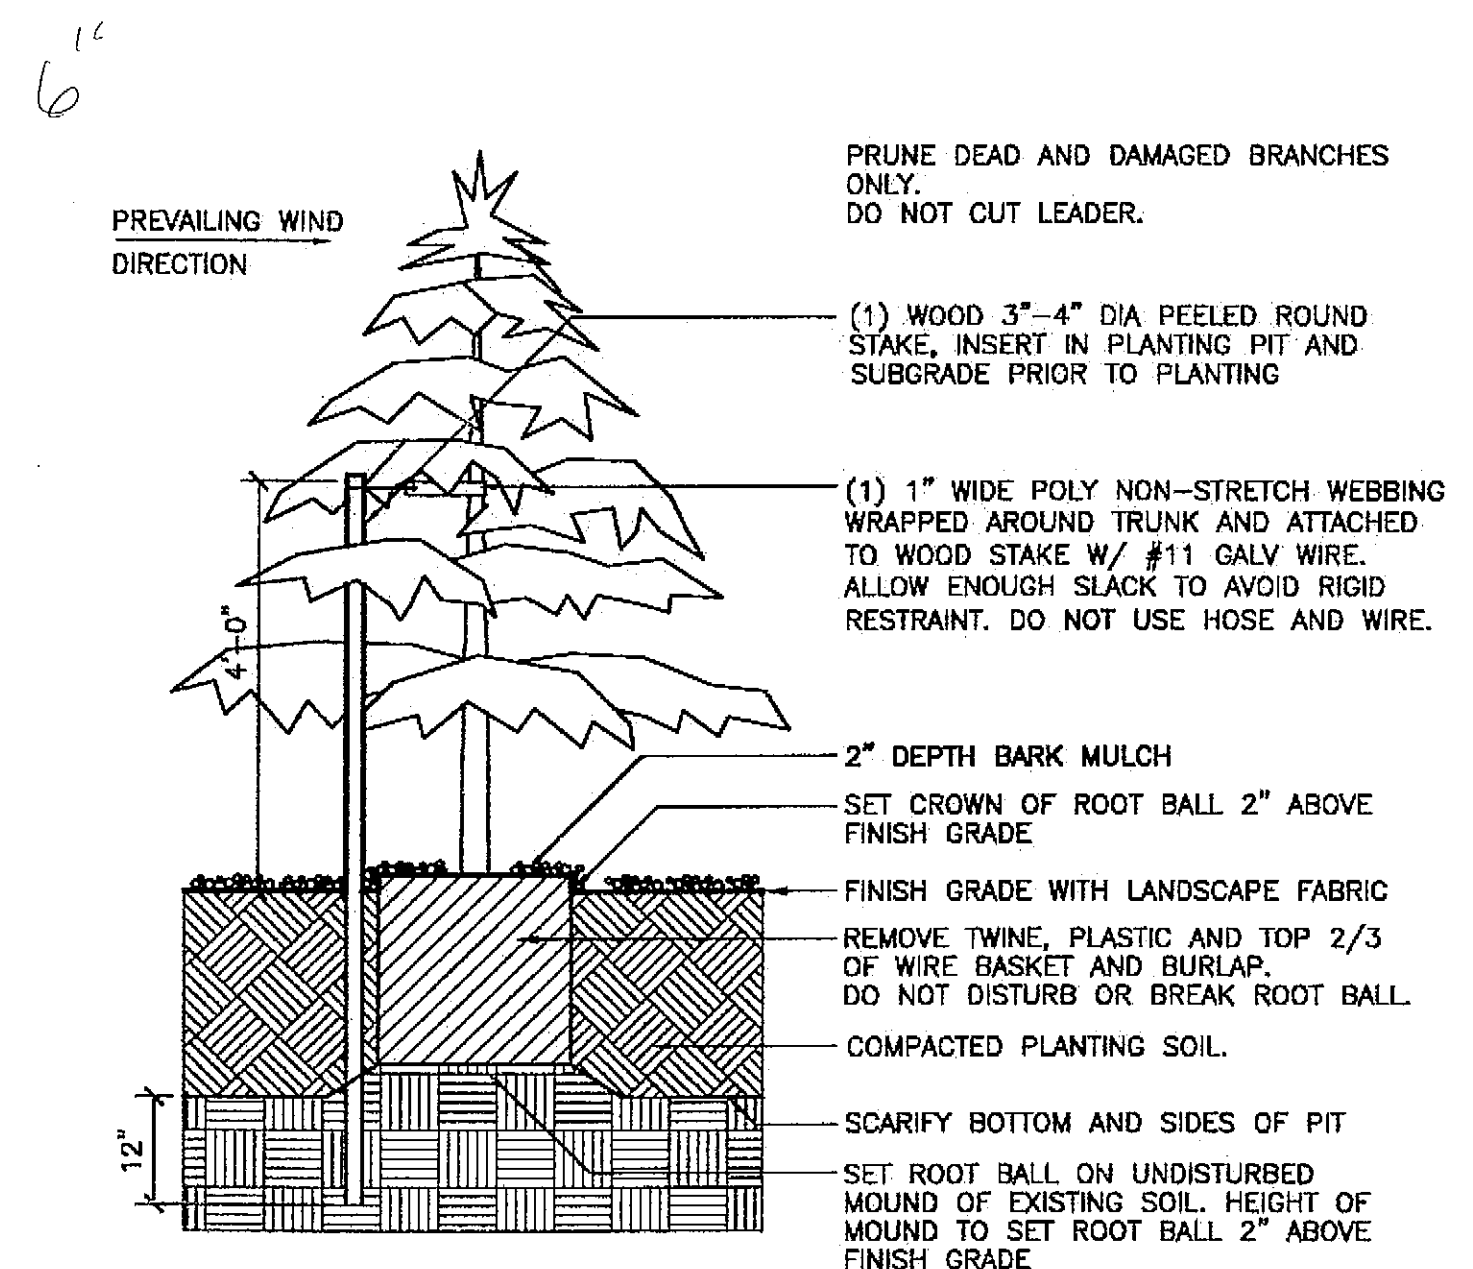

6 CONIFER TREE DETAIL
SCALE: 0 6" 1' 2'

CHECKED BY:

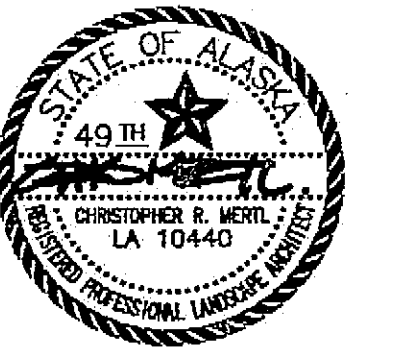

DESIGNED BY: JENSEN YORBA LOTT

DRAWN BY: CRM

STATE OF ALASKA
DEPARTMENT OF TRANSPORTATION & PUBLIC FACILITIES
STATEWIDE DESIGN & ENGINEERING SERVICES DIVISION
MT EDGE CUMBE HIGH SCHOOL
BUILDING 1330
ACADEMIC EXPANSION

SHEET L103


PROJECT DESIGNATION NUMBER

67751C

STATE	YEAR
ALASKA	2004

SHEET NUMBER	TOTAL SHEETS
66	79

SITKA HARBOR

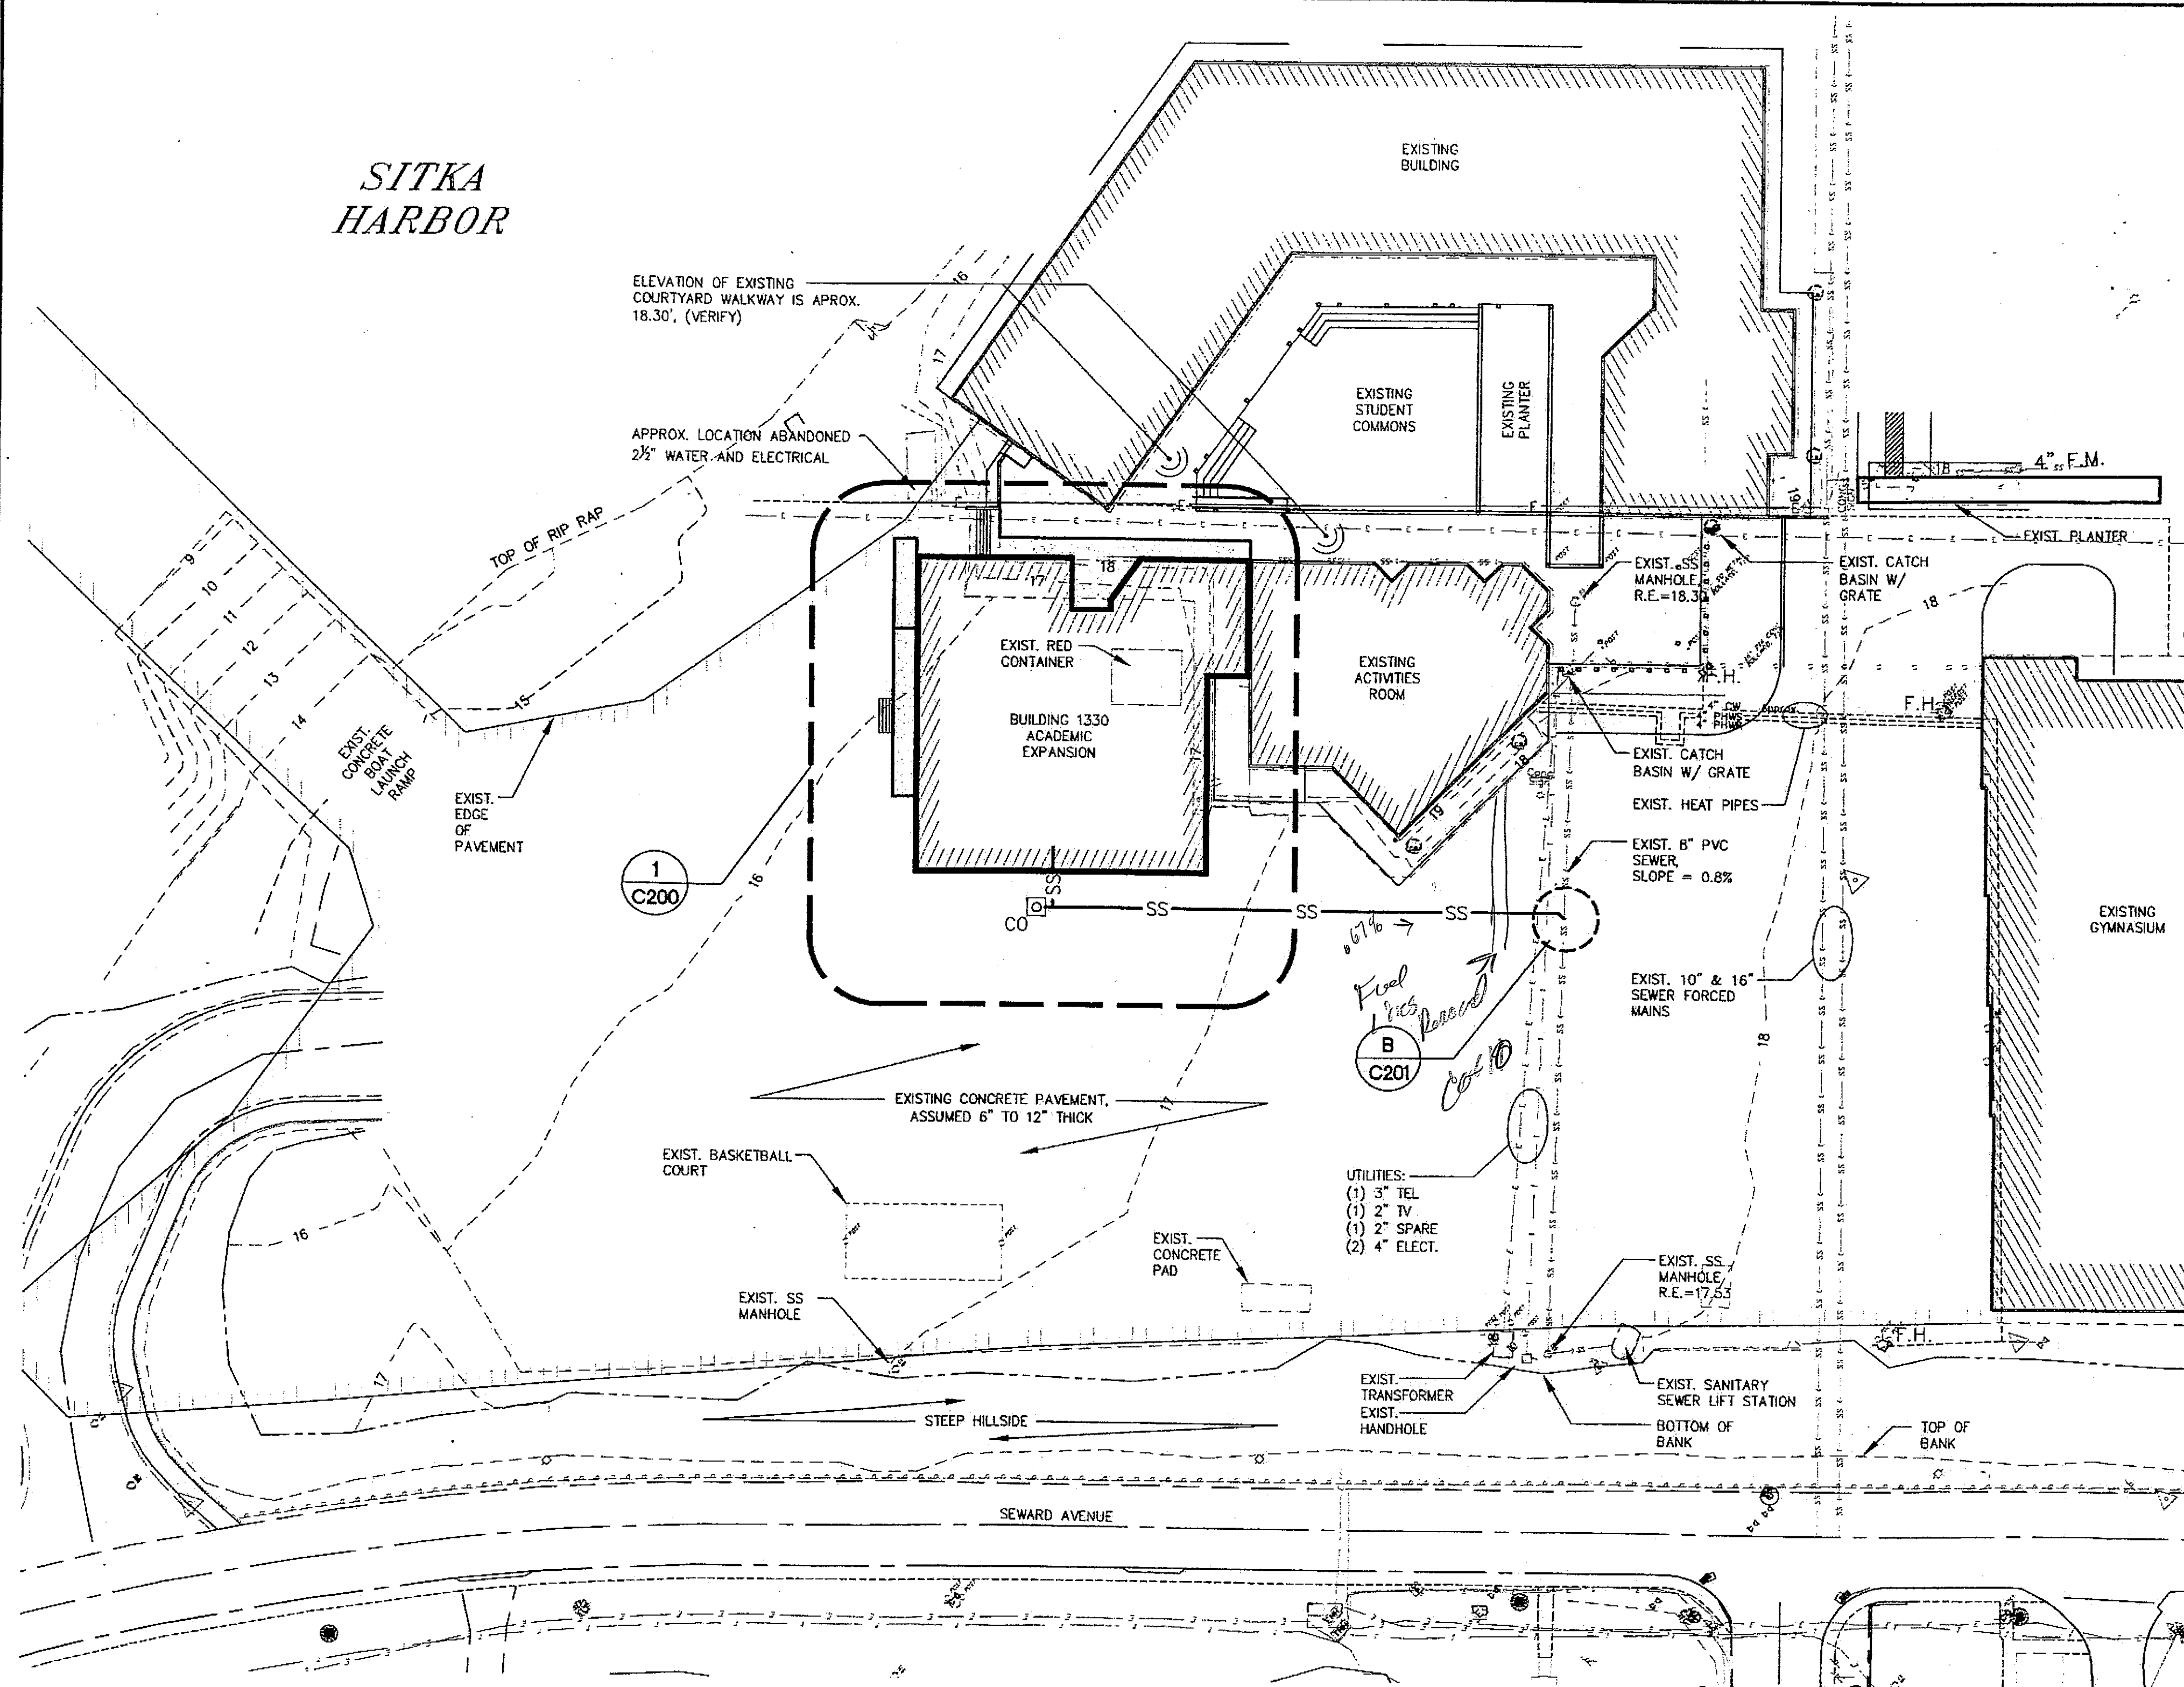

LEGEND

EXISTING

—E—
—SS—
—F.M.—
—SS—
—T—
—W—
—PHWS—
—PHWR—

PROPOSED

—SS—
—SS—
—SS—
—SS—
—SS—
—SS—
—SS—
—SS—

ELECTRICAL
SANITARY SEWER
SEWER FORCE MAIN
SEWER MAIN GRAVITY
TELEPHONE/TV
WATER MAIN
HOT WATER SUPPLY
HOT WATER RETURN

(C.B.)

CO

CATCH BASIN w/ GRATE
CLEANOUT
FIRE HYDRANT
SS MANHOLE
LIGHT POLE

F.H.

SS

EDGE OF PAVEMENT
GROUND ELEVATION, APPROX.
SURVEY MONUMENT

16

16

TREES

16

16

STRUCTURES

1 SITE PLAN

NOTES:

1. UNDERGROUND UTILITIES SHOWN IN APPROXIMATE LOCATION, EXCEPT FOR 16" AND 10" SEWER FORCE MAINS. OTHER EXISTING UTILITIES ARE REFERENCED FROM AS-BUILT PLANS AND SHOULD BE VERIFIED BEFORE DIGGING OR ORDERING OR FABRICATING ANY MATERIAL.
2. OTHER ABANDONED UTILITIES MAY BE ENCOUNTERED DURING EXCAVATION.
3. ENGINEER REFERENCED ON THIS DRAWING IS THE CONTRACTING OFFICER OR HIS DESIGNATED REPRESENTATIVE.
4. THESE PLANS ARE BASED UPON MAPPING BY ALASKA DOT/PL, SURVEYED 7/21/2004 BY T. REED, PLS & L. GEHRING, PE.
5. CONSULT WITH UTILITY OWNER BEFORE DISTURBING EXISTING UTILITY.
6. CONTRACTOR RESPONSIBLE FOR REPAIR OF ANY DAMAGED UTILITY CAUSED BY CONSTRUCTION.
7. RESTORE PAVEMENT DISTURBED DURING UTILITY WORK TO ORIGINAL CONDITION.

Tue, 14/Dec/04 12:00PM


ADDENDUM NUMBER

ATTACHMENT NUMBER

RECORD OF REVISIONS

No.	DATE	DESCRIPTION

CHECKED BY:

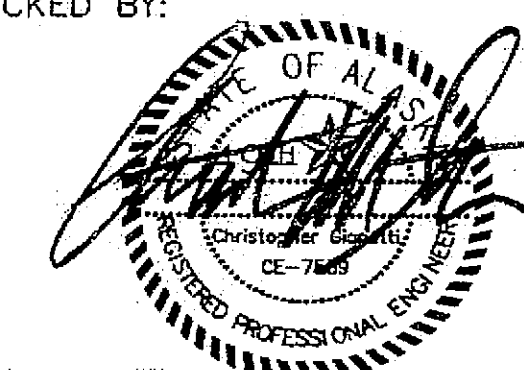

DESIGNED BY: CMG

DRAWN BY: PJD

STATE OF ALASKA
DEPARTMENT OF TRANSPORTATION
& PUBLIC FACILITIES
STATEWIDE DESIGN & ENGINEERING
SERVICES DIVISION

MT EDGECUMBE
HIGH SCHOOL
BUILDING 1330
ACADEMIC
EXPANSION

SHEET C100

PROJECT DESIGNATION NUMBER

67751

STATE	YEAR
ALASKA	2004
SHEET NUMBER	TOTAL SHEETS
37	79


Tue, 14/Dec/04 12:00PM

ADDENDUM NUMBER

ATTACHMENT NUMBER

RECORD OF REVISIONS


No.	DATE	DESCRIPTION

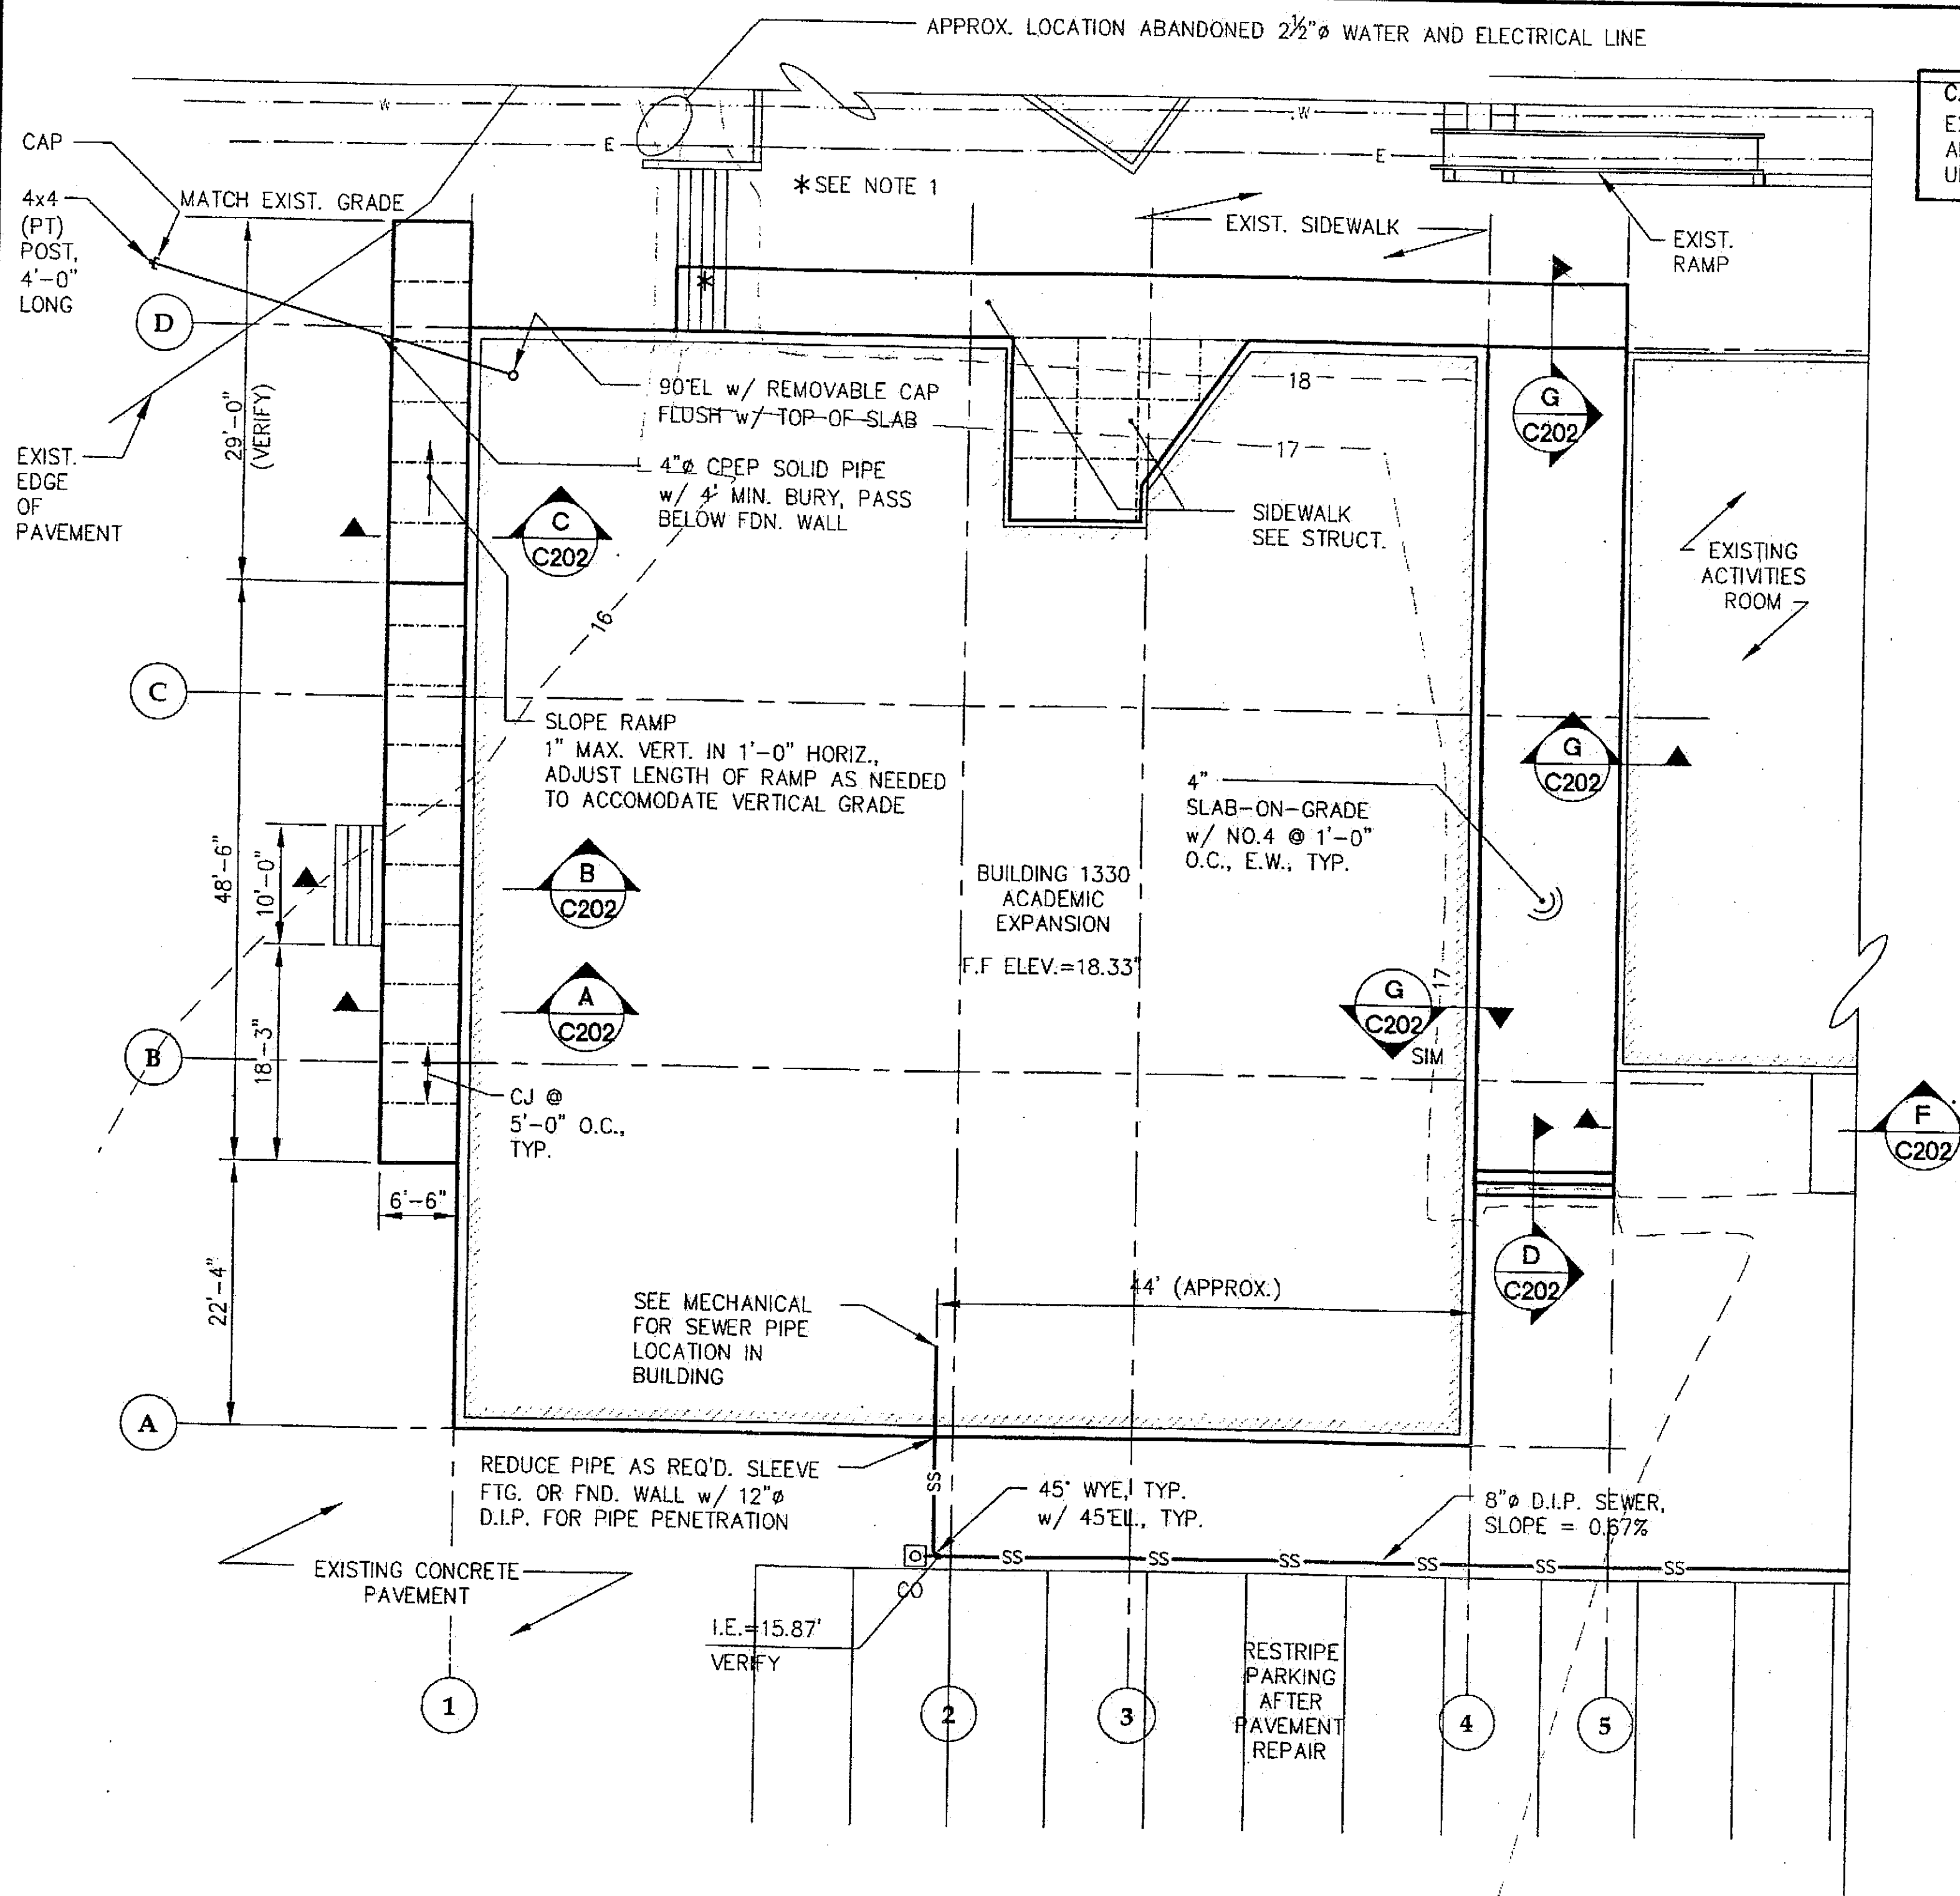

1 PARTIAL SITE PLAN
BASE BID

SCALE: 0 5' 10' 20'

- NOTES:
1. SAW CUT EXISTING STAIRS TO CONSTRUCT NEW FOUNDATION. AFTER FOUNDATION WALL CONSTRUCTION, BACKFILL AND COMPACT TO RECONSTRUCT STAIRS. DOWEL INTO EXISTING WITH NO.4 BARS, (2) EACH EXISTING STAIR TREAD AND AT 12" O.C. AT NEW WALL. EMBED 6" IN HILTI HIT HY150, TYP.
 2. SEWER ELEVATIONS ARE BASED ON SITE PLAN ARCTIC SLOPE ENGINEERS, OCTOBER 1987. ELEVATIONS DO NOT APPEAR TO MATCH SITE PLAN DATUM. VERIFY INVERT ELEVATION OF EXISTING MANHOLES PRIOR TO EXCAVATION. NOTIFY ARCHITECT OF EXISTING ELEVATIONS.

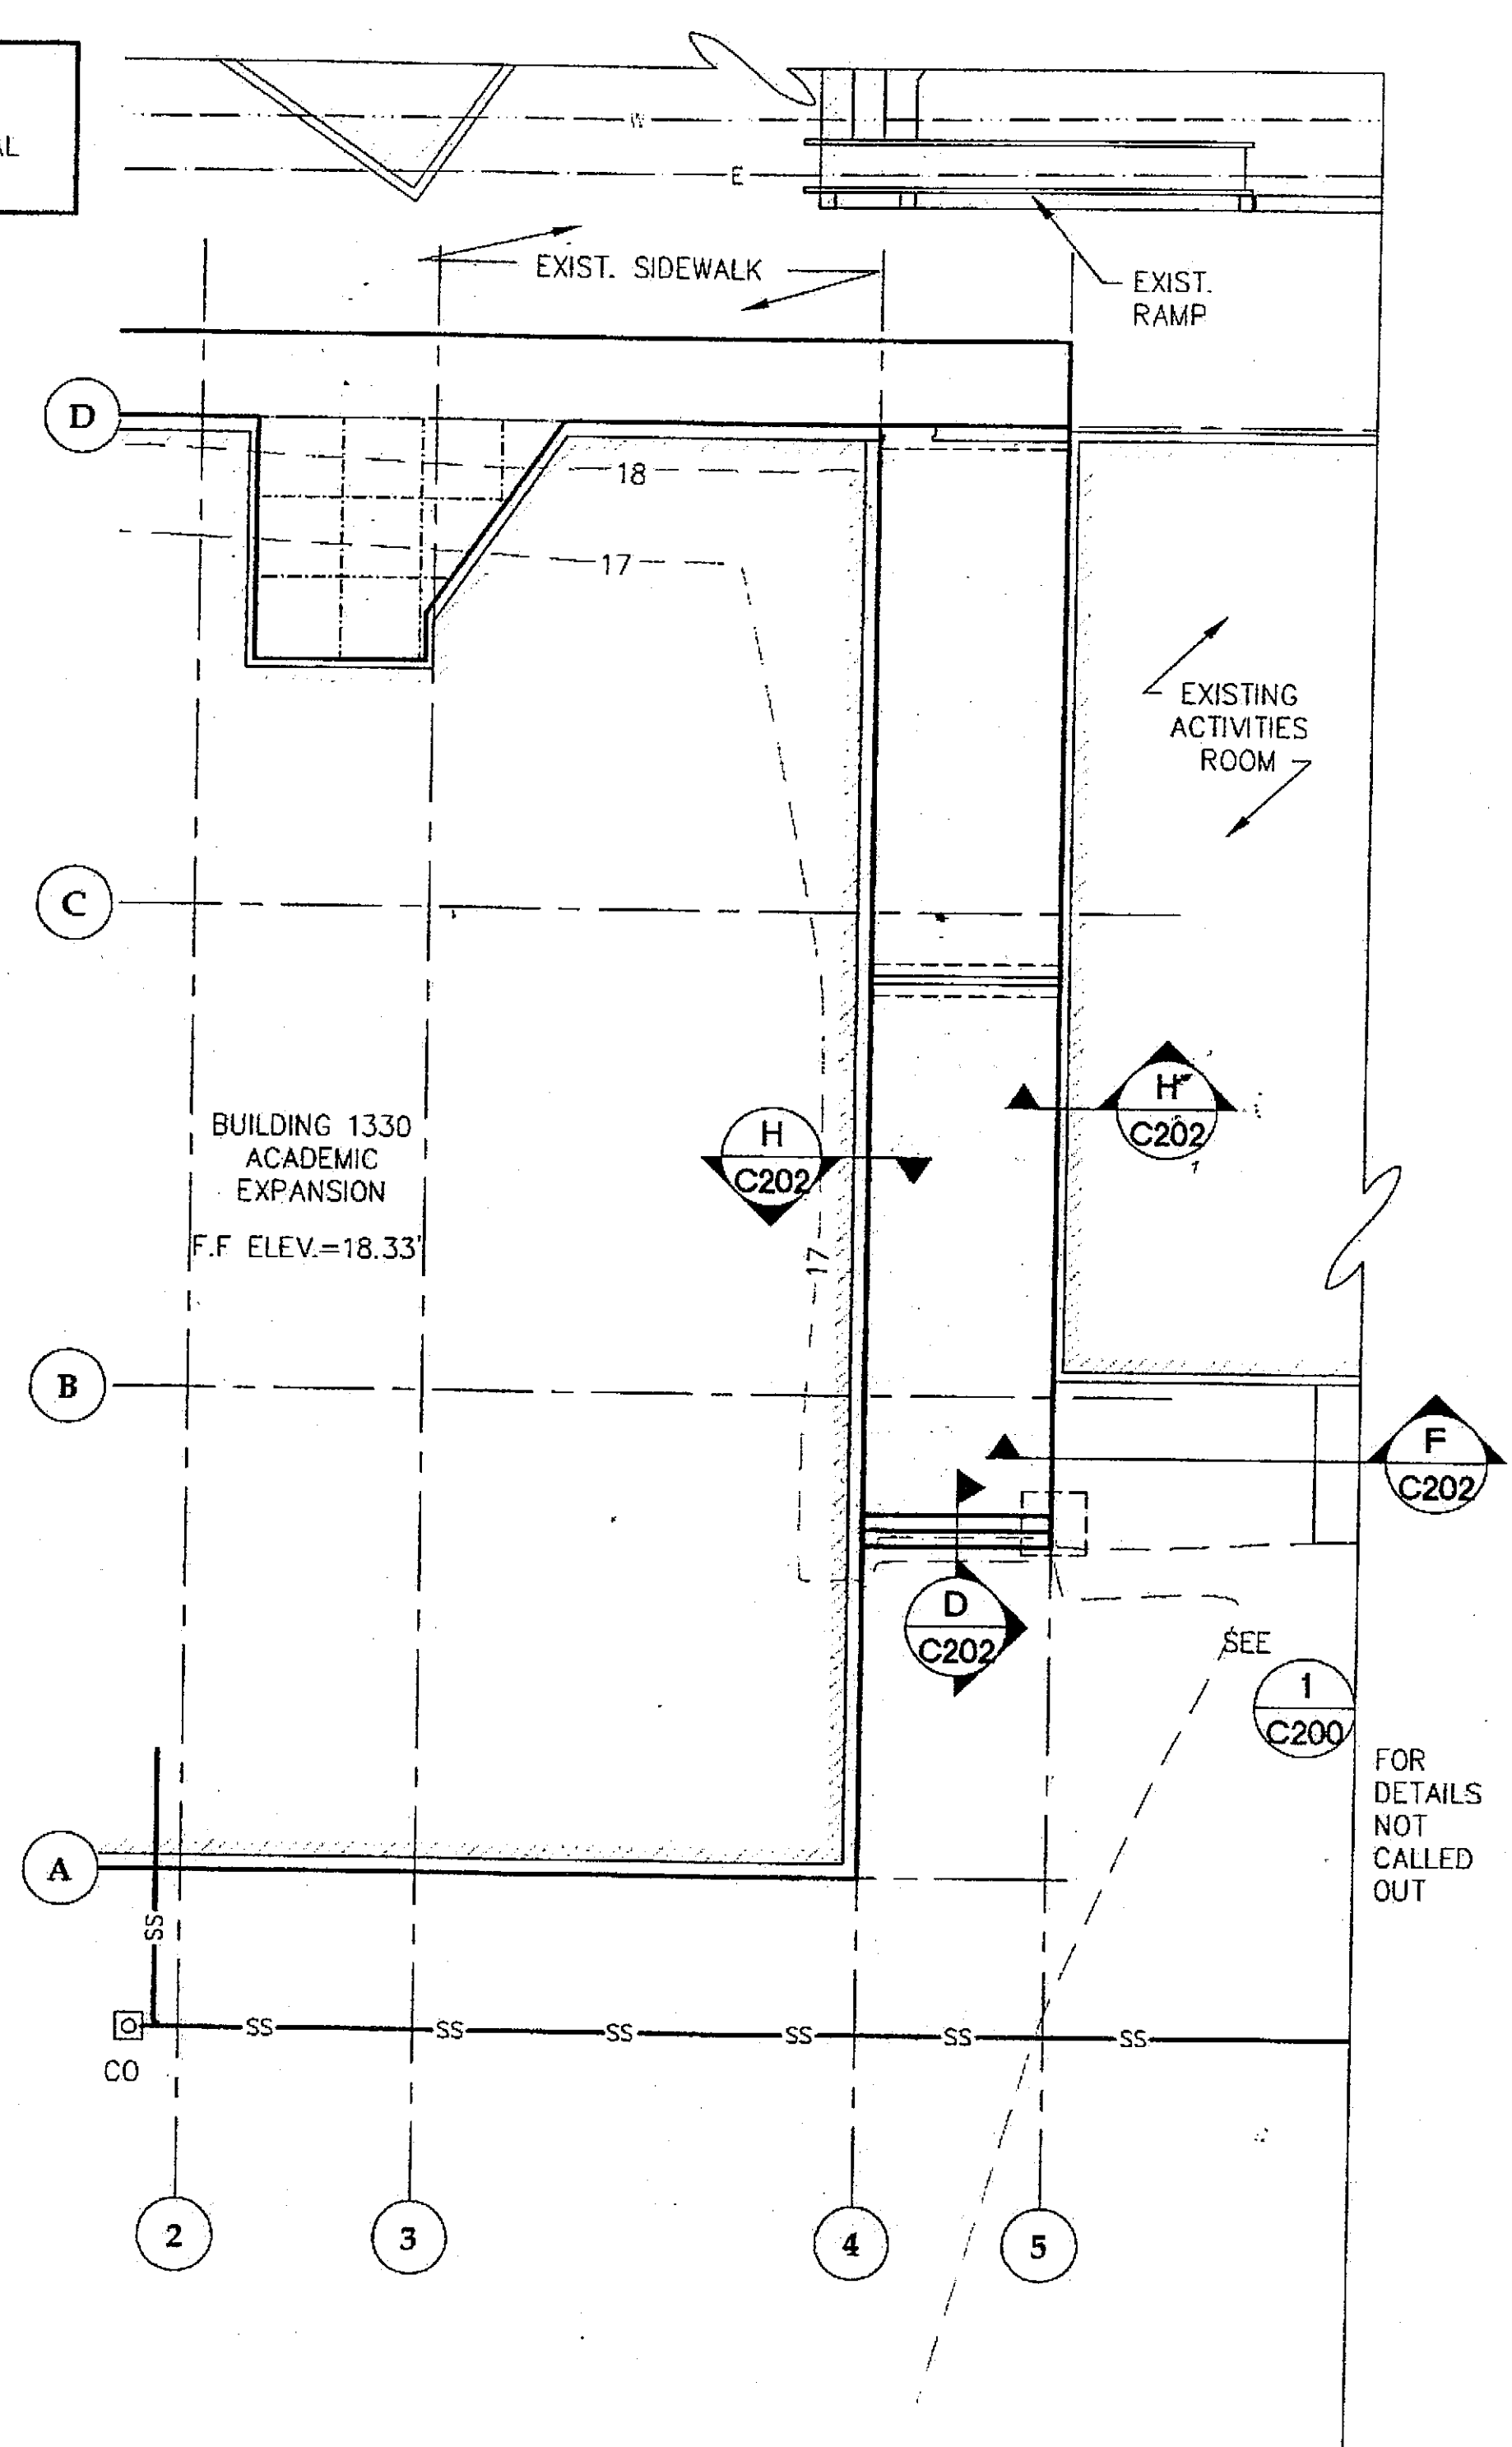


2 PARTIAL SITE PLAN
ADDITIVE ALTERNATE

SCALE: 0 5' 10' 20'

LEGEND

- SS NEW SEWER GRAVITY
- E EXIST. GROUND ELEVATION, APPROX.
- E ELECTRICAL (BURIED)
- W WATER PIPE
- CONCRETE CONTROL JOINT
- NEW CONSTRUCTION

CHECKED BY:

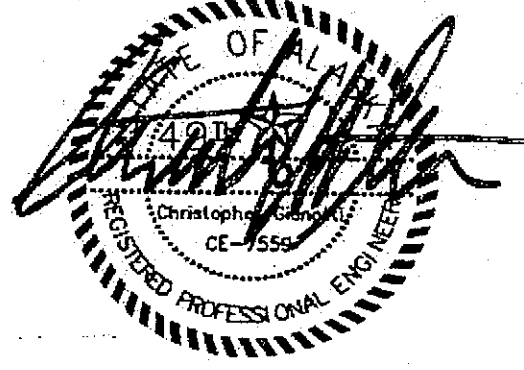

DESIGNED BY: CMG

DRAWN BY: PJD

STATE OF ALASKA
DEPARTMENT OF TRANSPORTATION
& PUBLIC FACILITIES
STATEWIDE DESIGN & ENGINEERING
SERVICES DIVISION

MT EDGE CUMBE
HIGH SCHOOL
BUILDING 1330
ACADEMIC
EXPANSION


SHEET C200

PROJECT DESIGNATION NUMBER

67751

STATE	YEAR
ALASKA	2004
SHEET NUMBER	TOTAL SHEETS
38	79

Project As-Built Drawings have been reviewed by the Project Engineer and represent to the best of my knowledge, the project as constructed.
Proj. Eng. *[Signature]* Date *7/07*

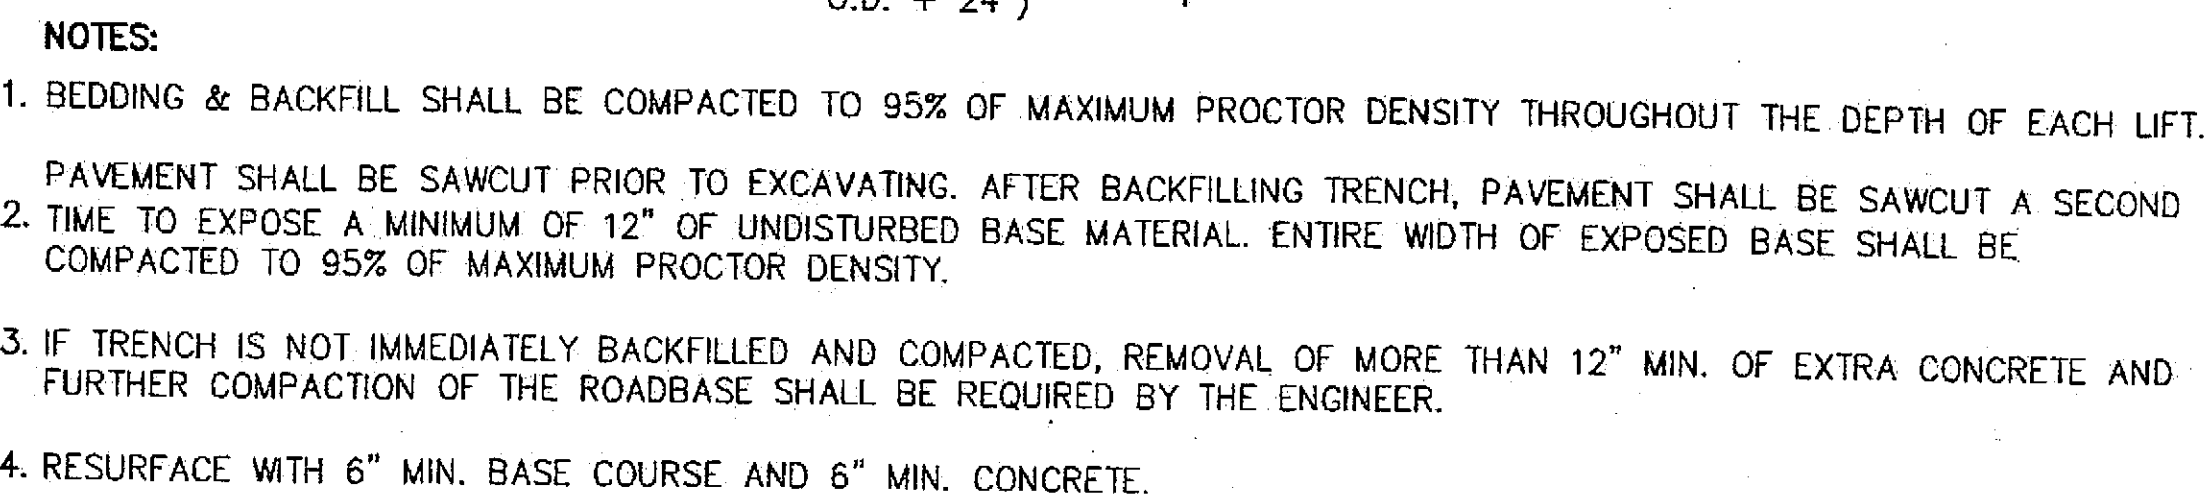

Technical drawing illustrating a sanitary cleanout assembly. The drawing shows a vertical ductile iron pipe (D.I.P.) with a mechanical joint, connected to an 8" D.I.P. Class 50 main line. The assembly includes a concrete collar, a watertight mechanical plug, and a sanitary cleanout cover. The drawing specifies dimensions for the cleanout size, concrete encasement, and ground compaction requirements.

Labels and Dimensions:

- SANITARY CLEANOUT COVER
- WATERTIGHT MECHANICAL PLUG
- CONCRETE COLLAR
- 3'-0" x 3'-0" MIN.
- RECESS 1/4"
- 8" D.I.P. CLASS 50,
- CLEANOUT SIZE AS SHOWN ON PLANS
- CONCRETE TO ENCASE PIPE 4" MIN.
- 24"
- 36"
- D.I.P. 45° EL. DIAMETER TO MATCH MAIN
- DUCTILE IRON CLASS 50
- VARIABLE
- UNDISTURBED GROUND OR BACKFILL TO BE COMPACTED TO 95% MAX. DENSITY


NOTE:
WHEN D.I. PIPE WITH MECHANICAL JOINT IS USED,
CONCRETE ENCASEMENT IS NOT NECESSARY

COVER

SET SCREW

1" RECESS
1/2" DEEP
TAPERED TO
TOP OF LID.

3°

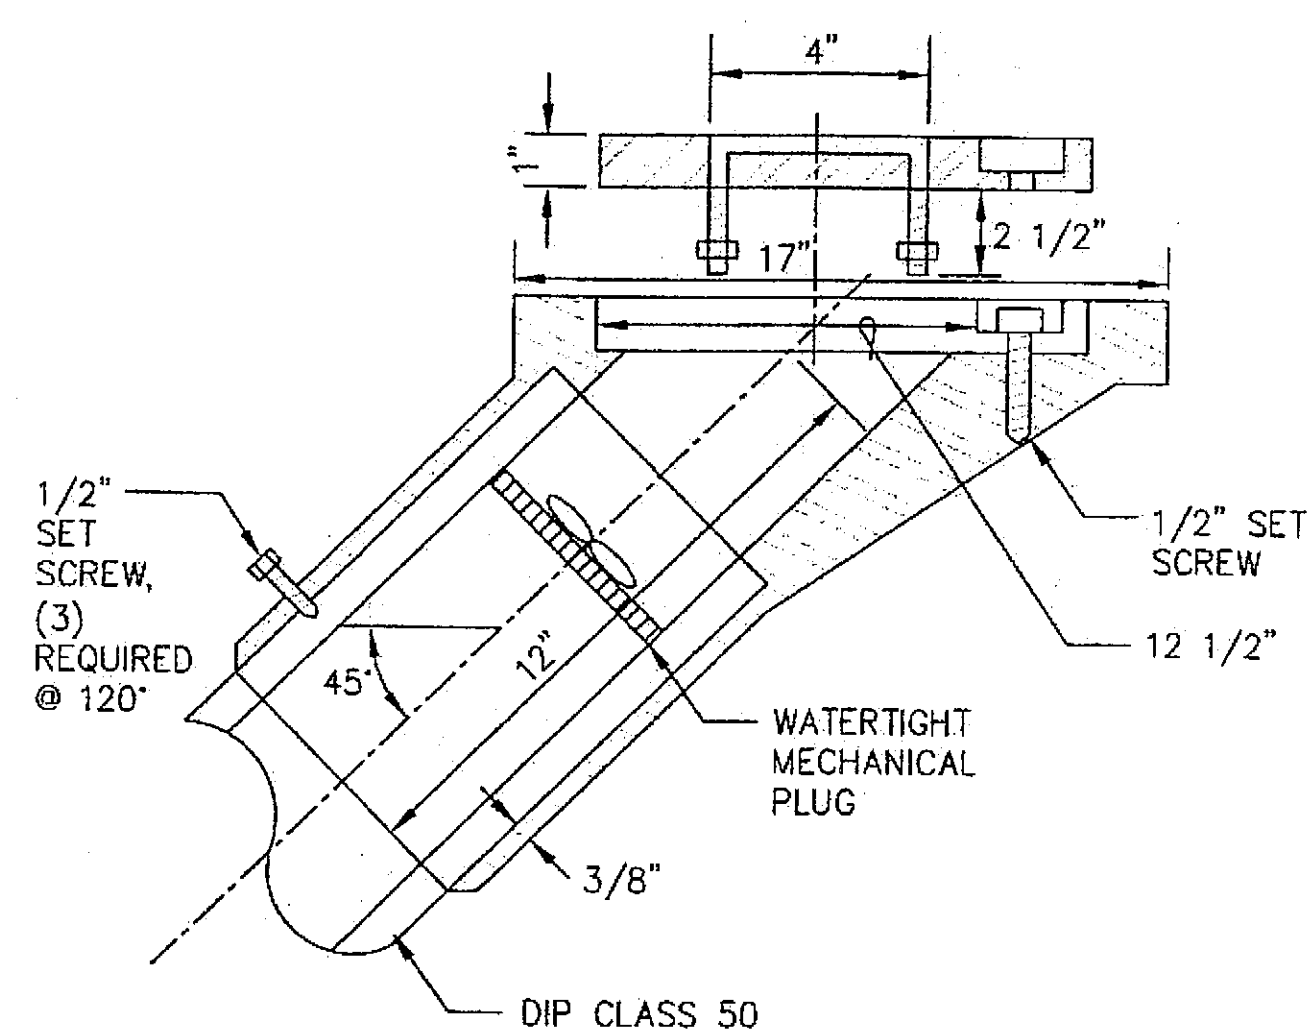

D SANITARY CLEANOUT COVER

- NOTES:**
1. COVER SHALL BE CAST.
 2. CASTING THICKNESS SUBJECT TO
FOUNDRY REQUIREMENTS.
 3. CASTING MUST BE SIZED TO 8" CLASS
50 D.I.P.
 4. COVER SHALL BE 1/4" BELOW TOP OF
PAVEMENT & 6" BELOW GRAVEL.

Project As-Built Drawings have been reviewed by the Project Engineer and represent to the best of my knowledge, the project as constructed.
Proj. Eng. D. Hull Date 7-07


[illegible]

ADDENDUM NUMBER


ATTACHMENT NUMBER

RECORD OF REVISIONS


No.	DATE	DESCRIPTION

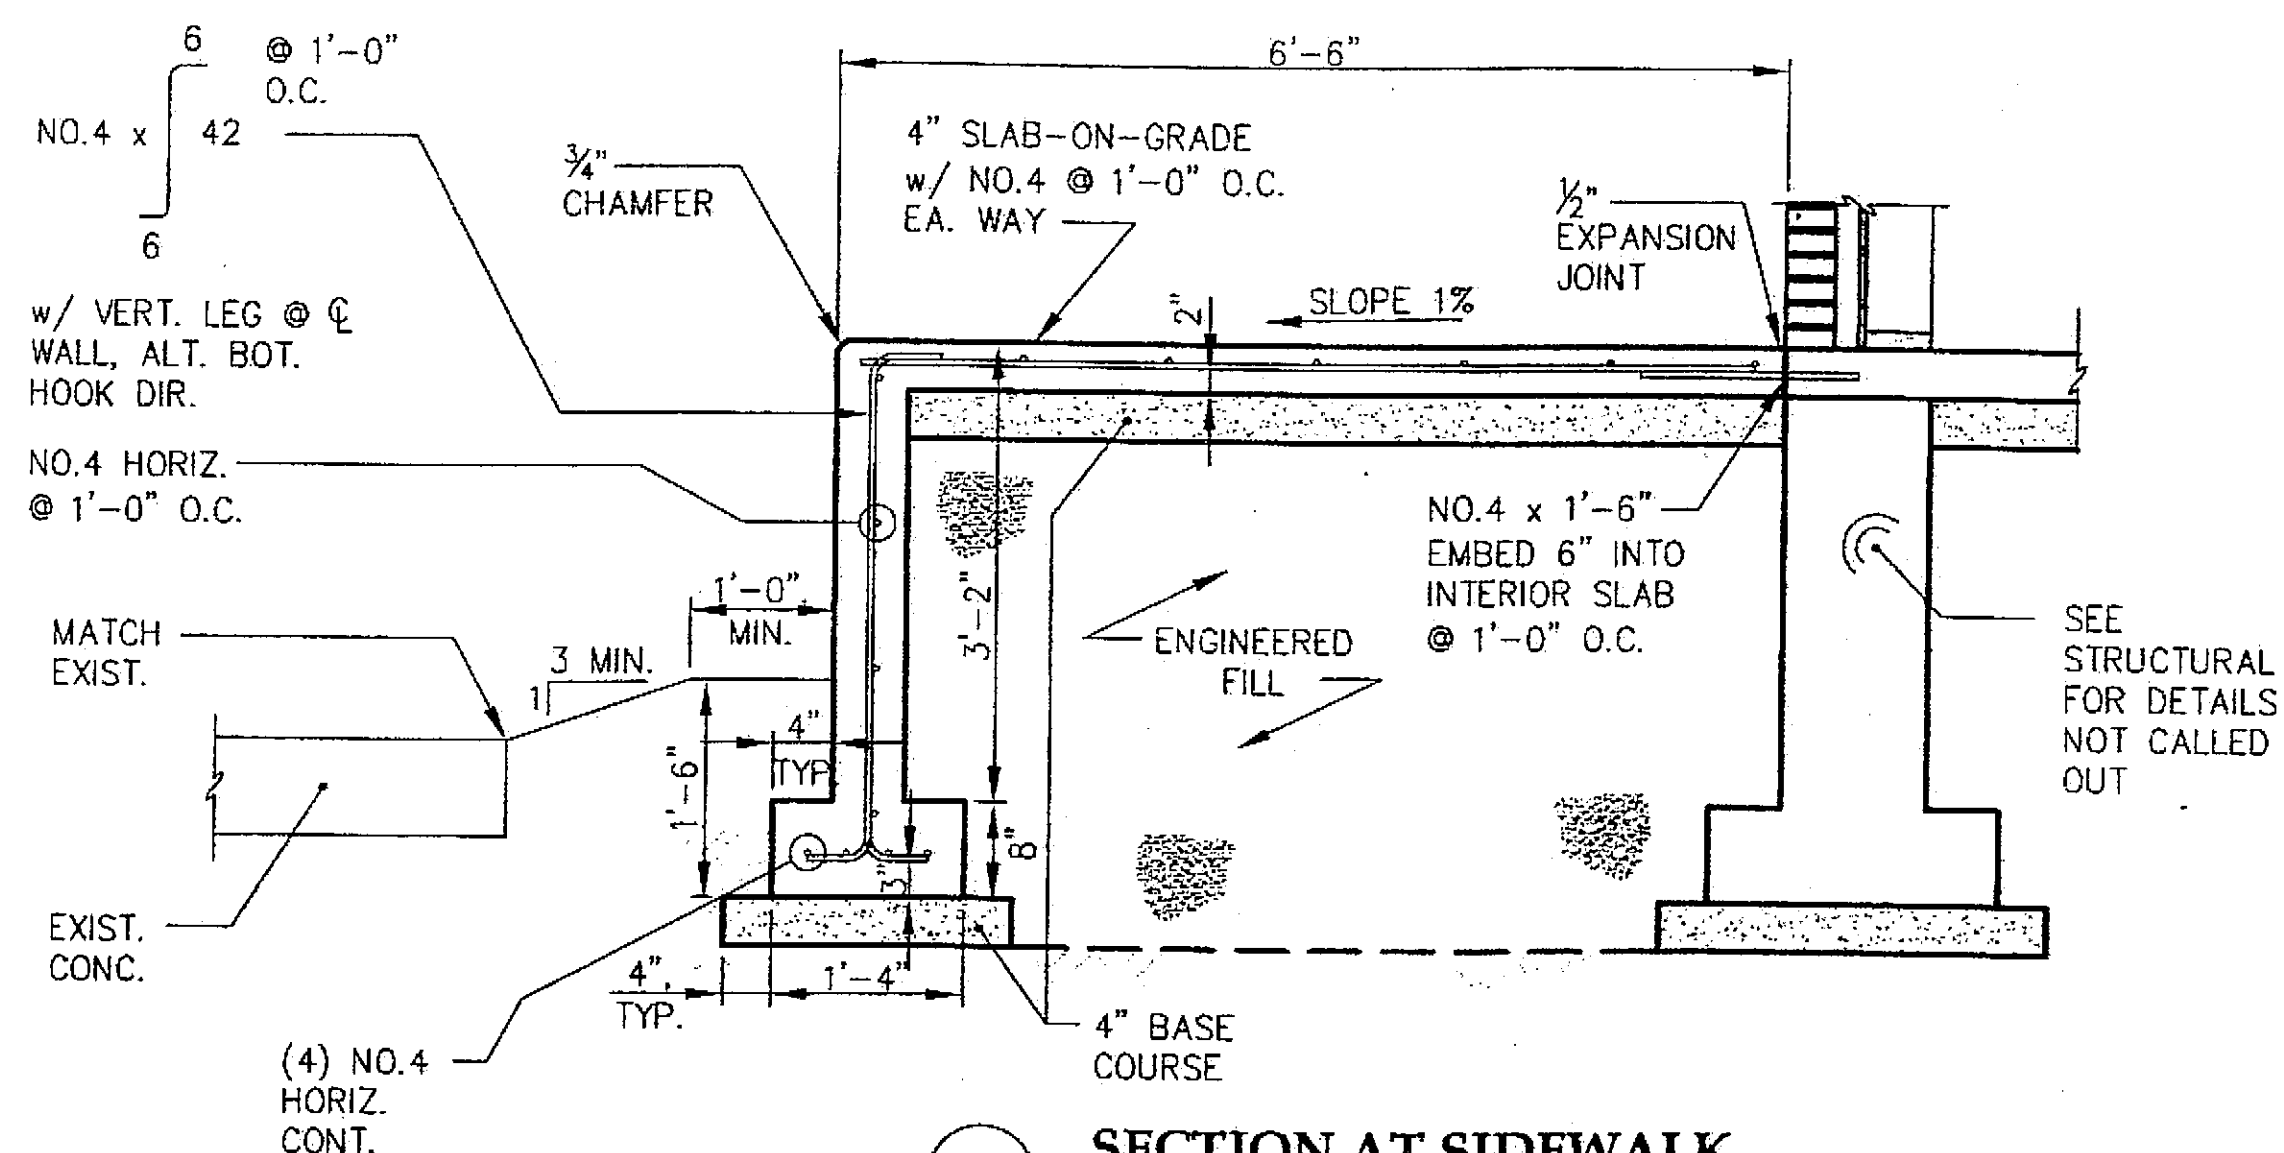


A SECTION AT SIDEWALK

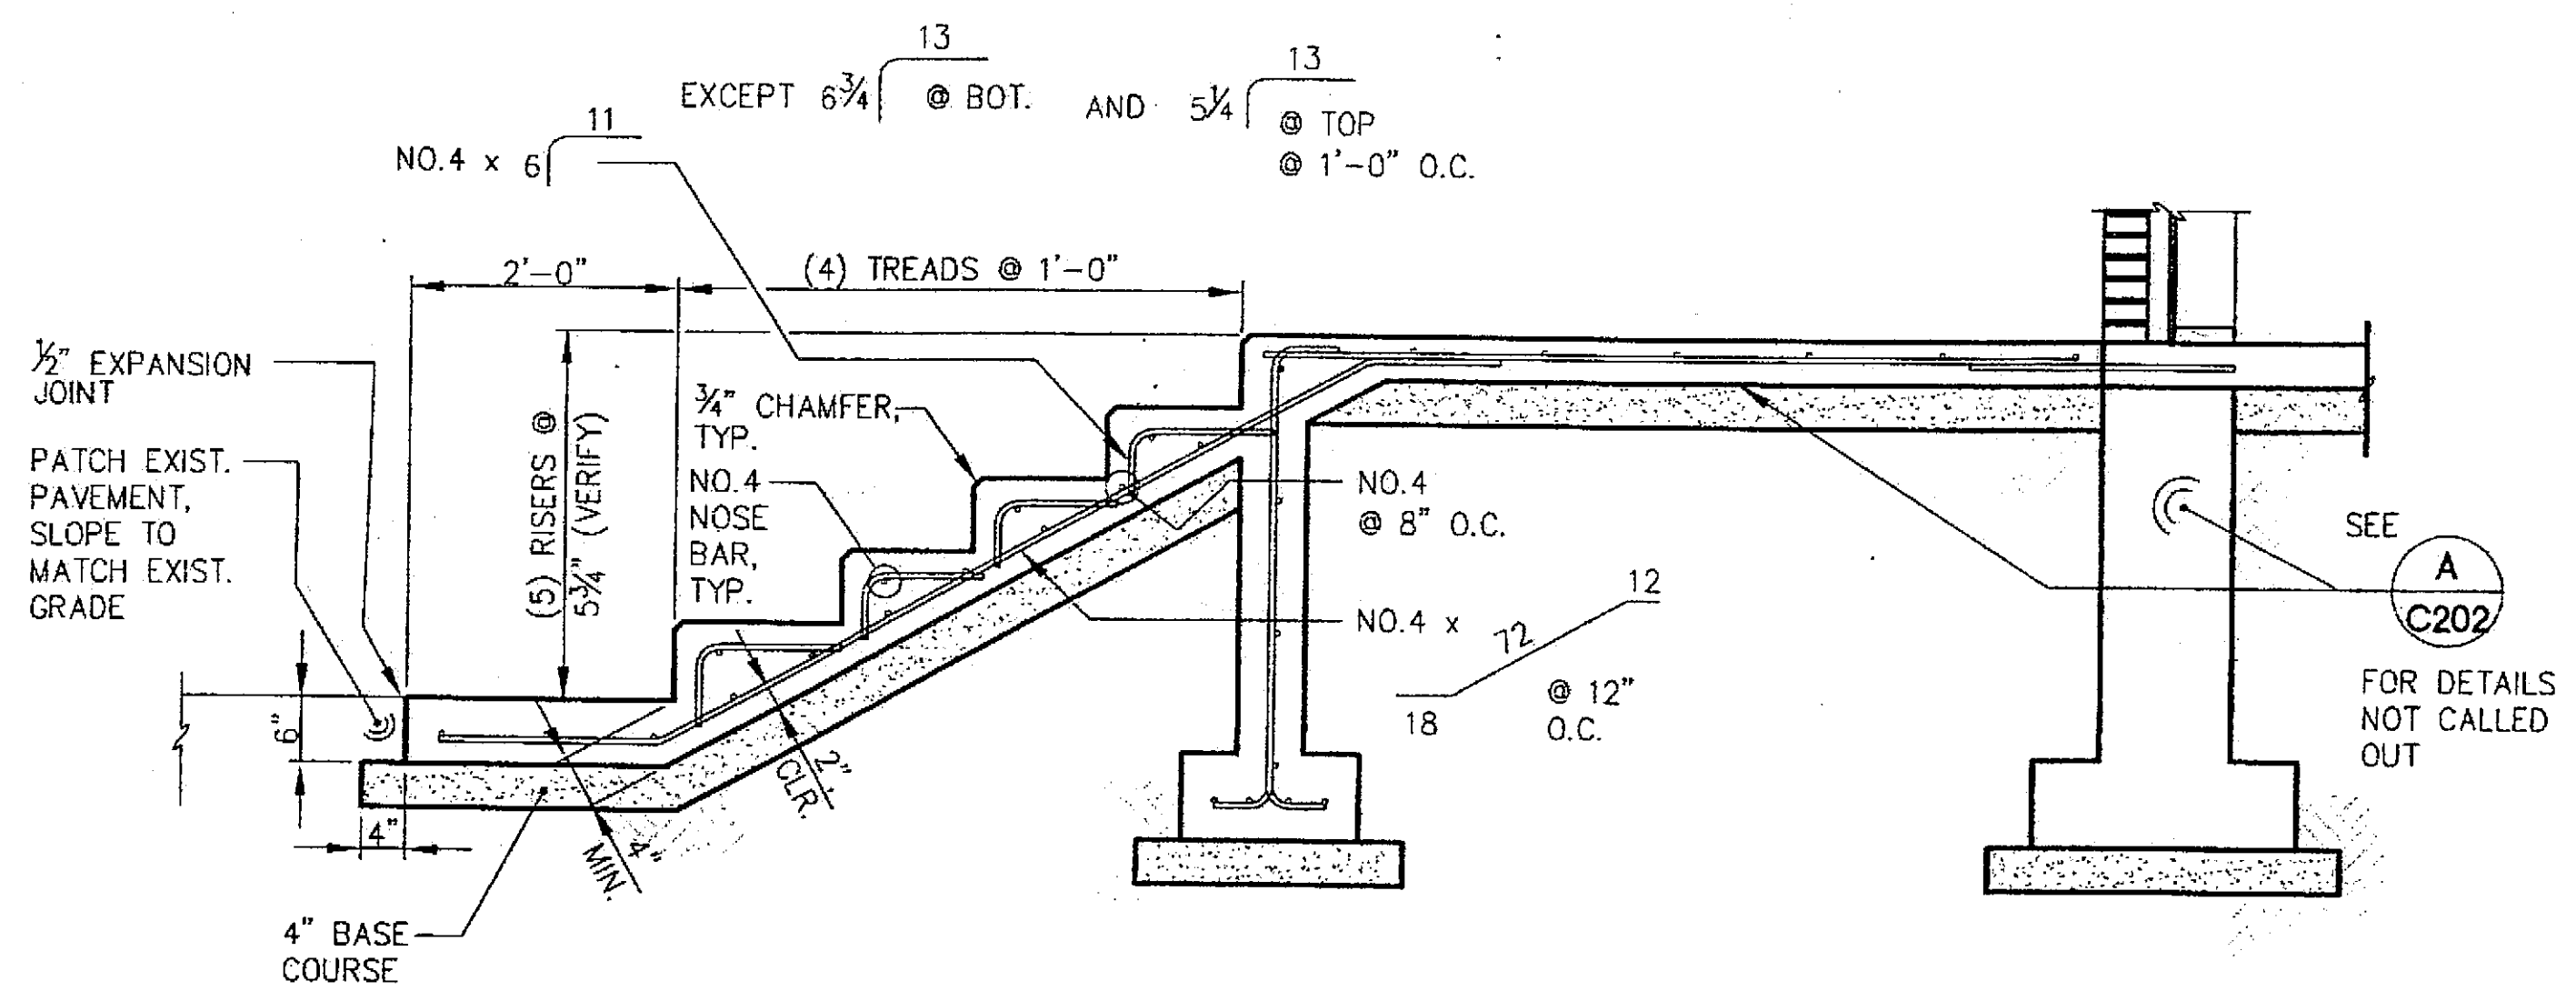


B TYPICAL SECTION AT STAIRS

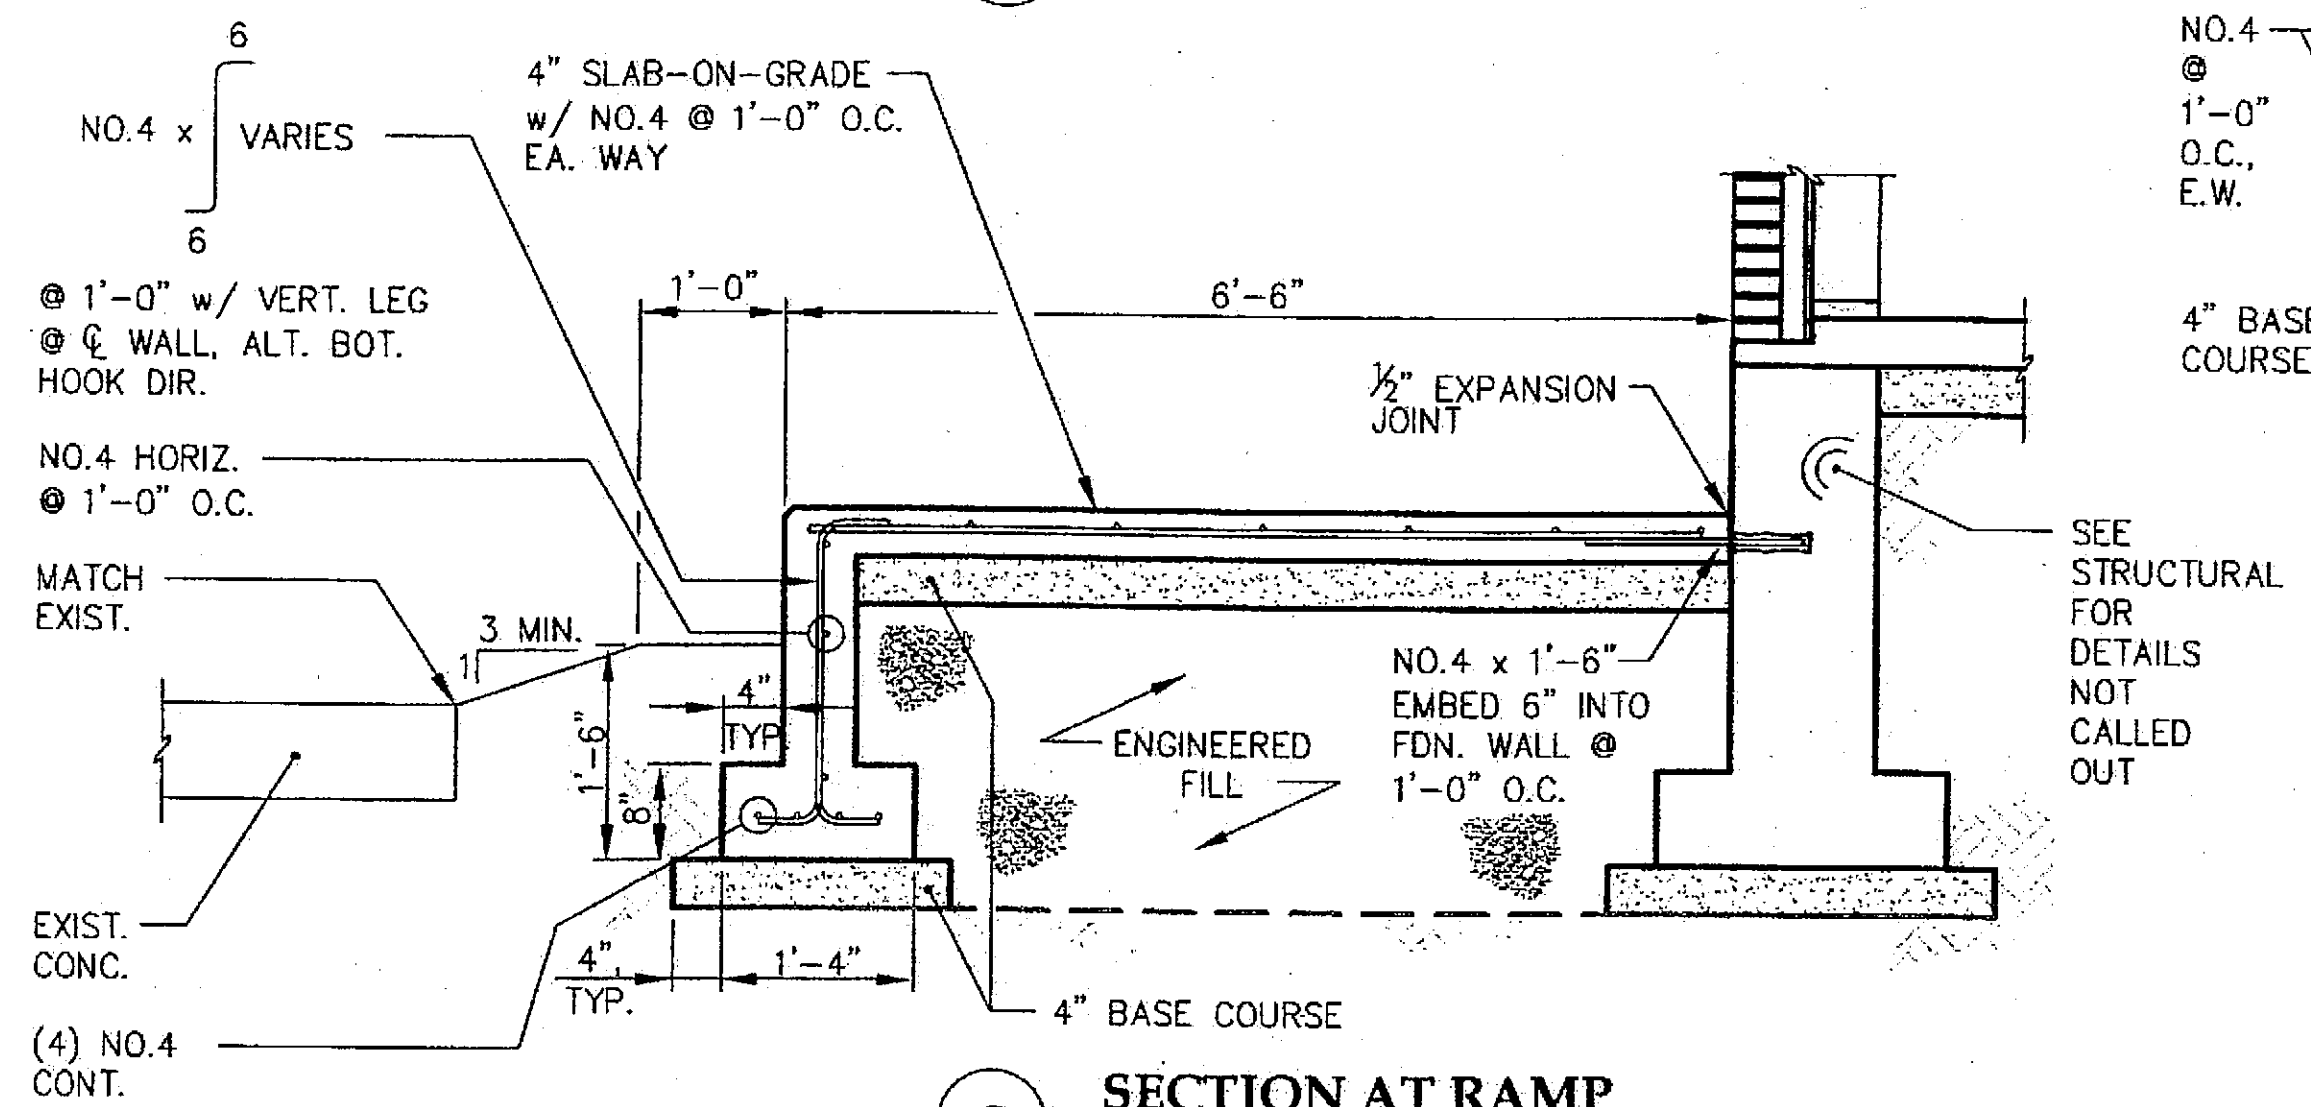


C SECTION AT RAMP

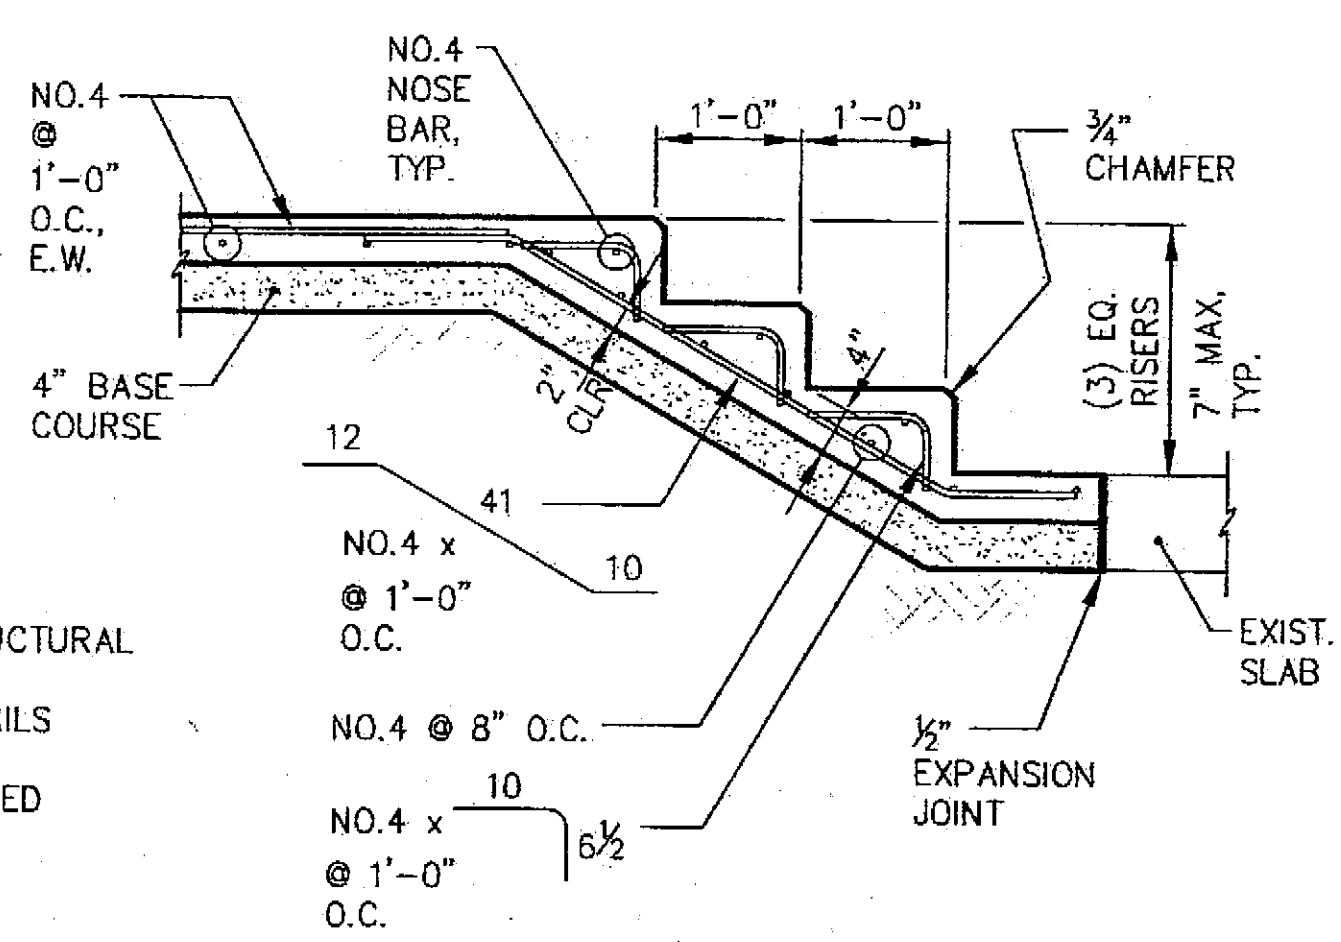


D SECTION AT STAIRS

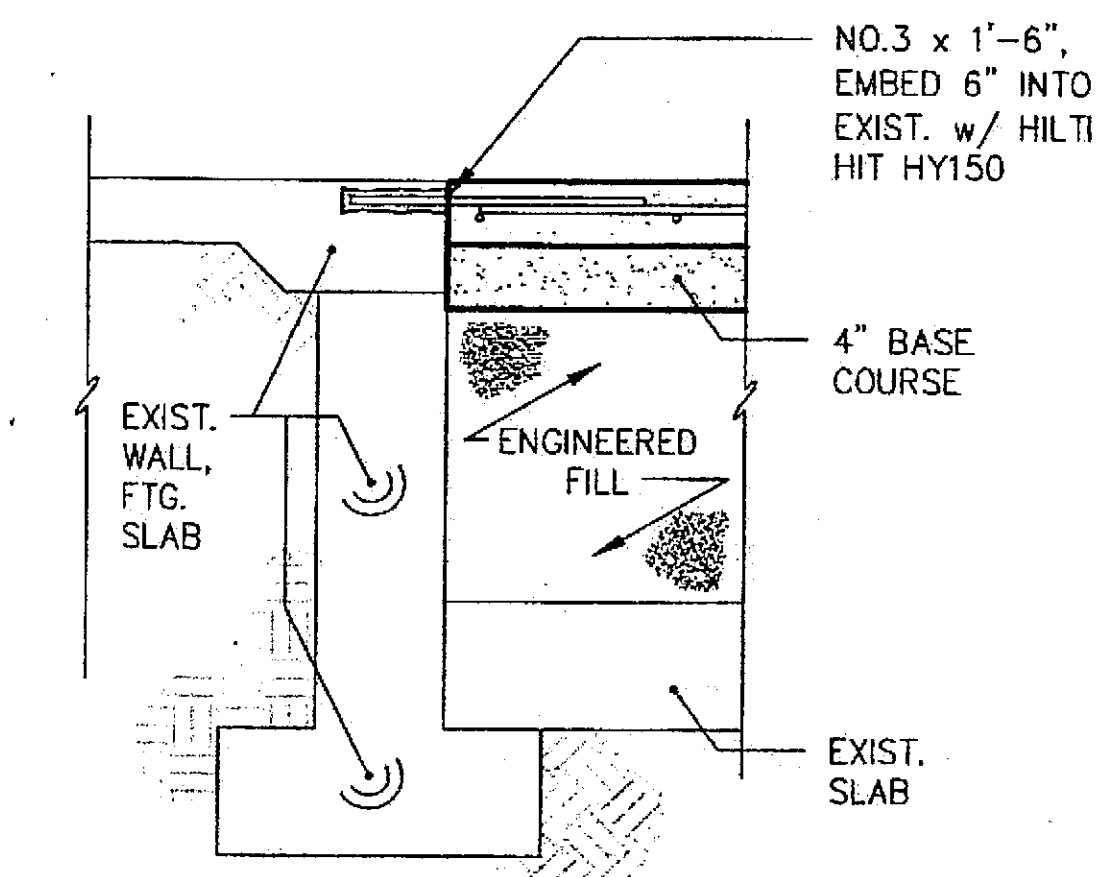


G SECTION AT EXISTING WALL

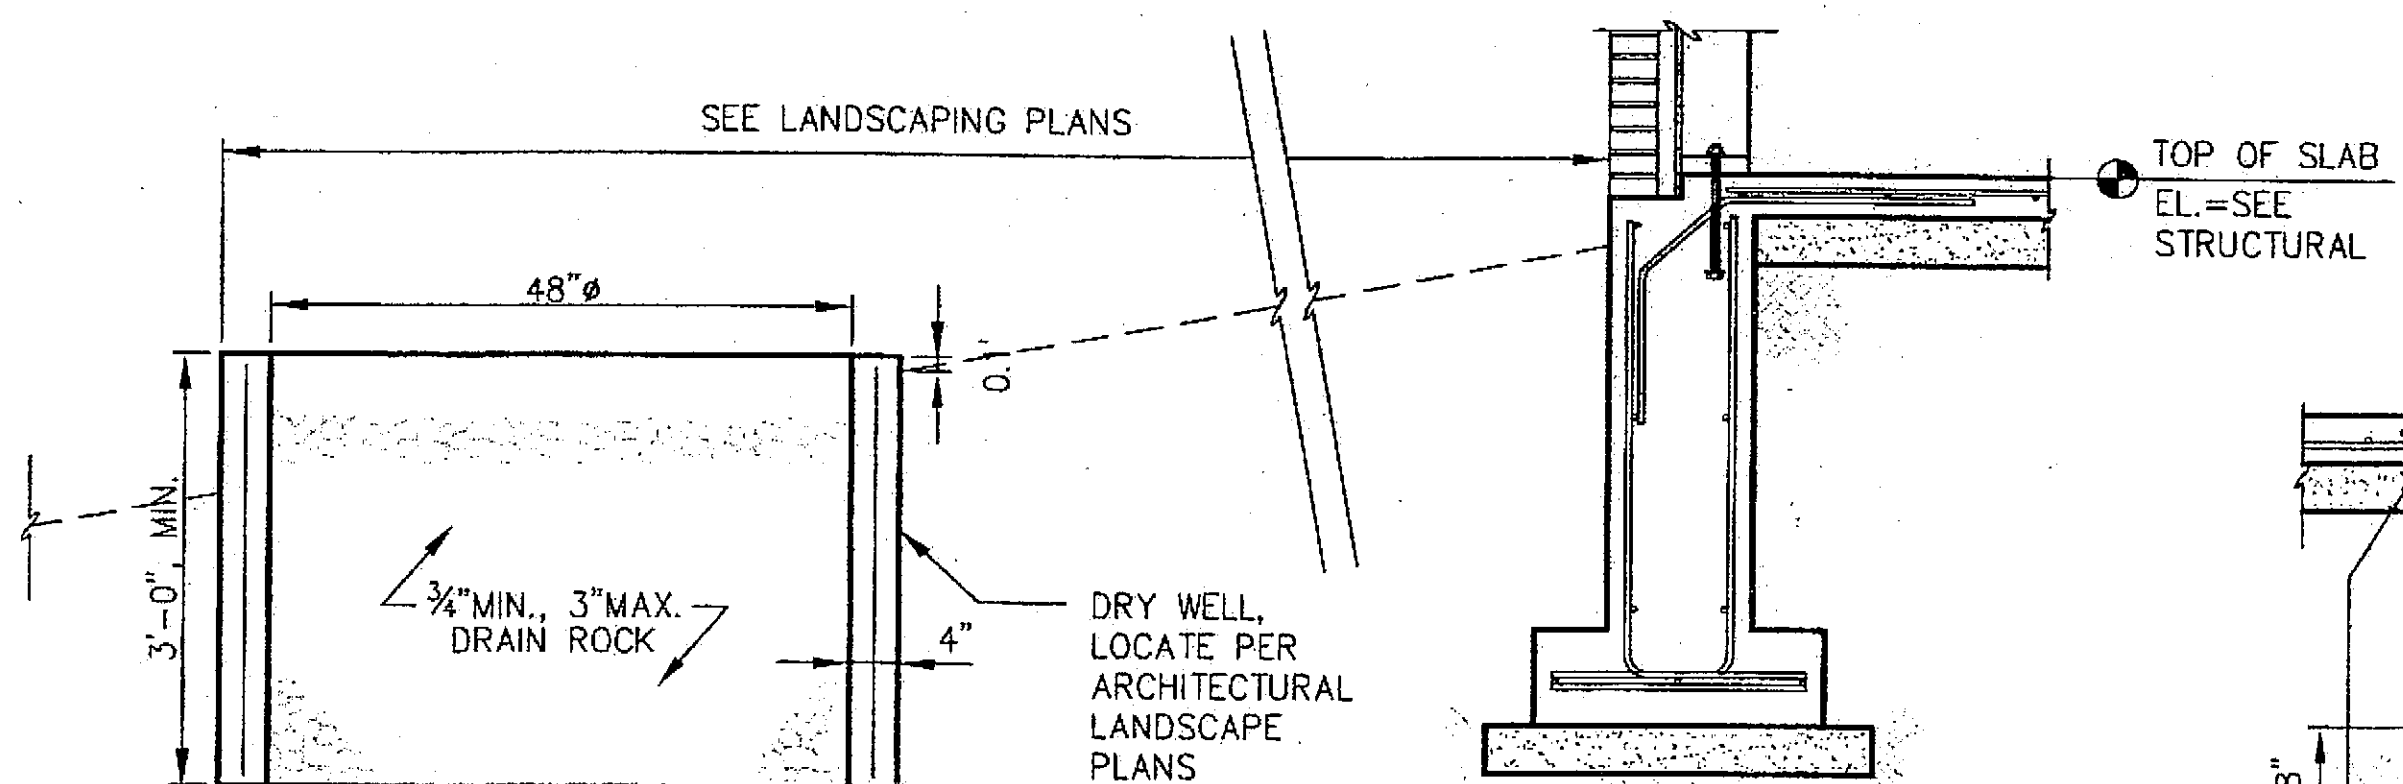

E DRY WELL DETAIL

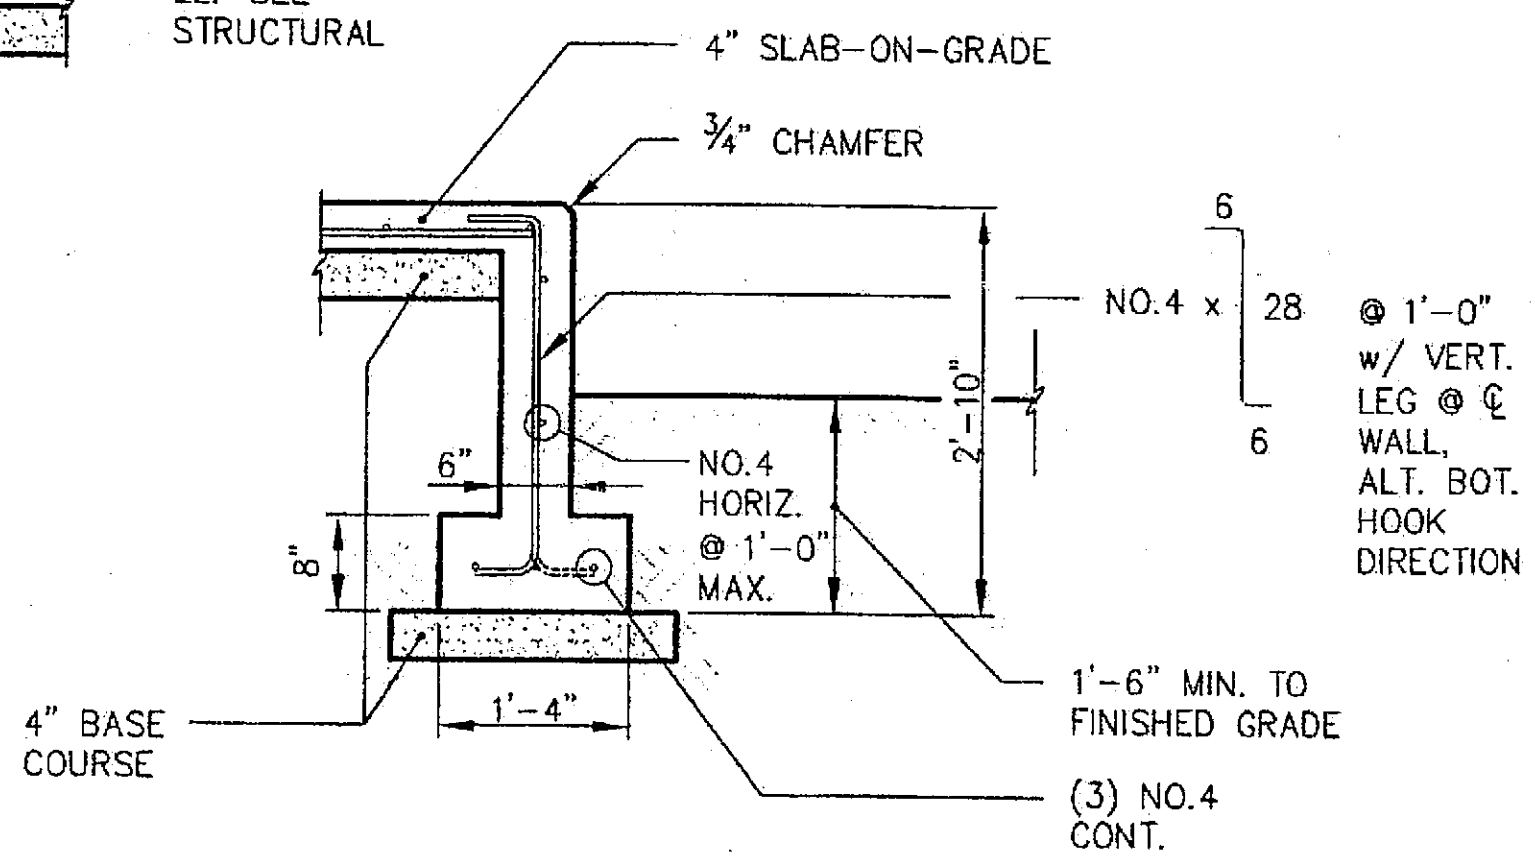


F SECTION

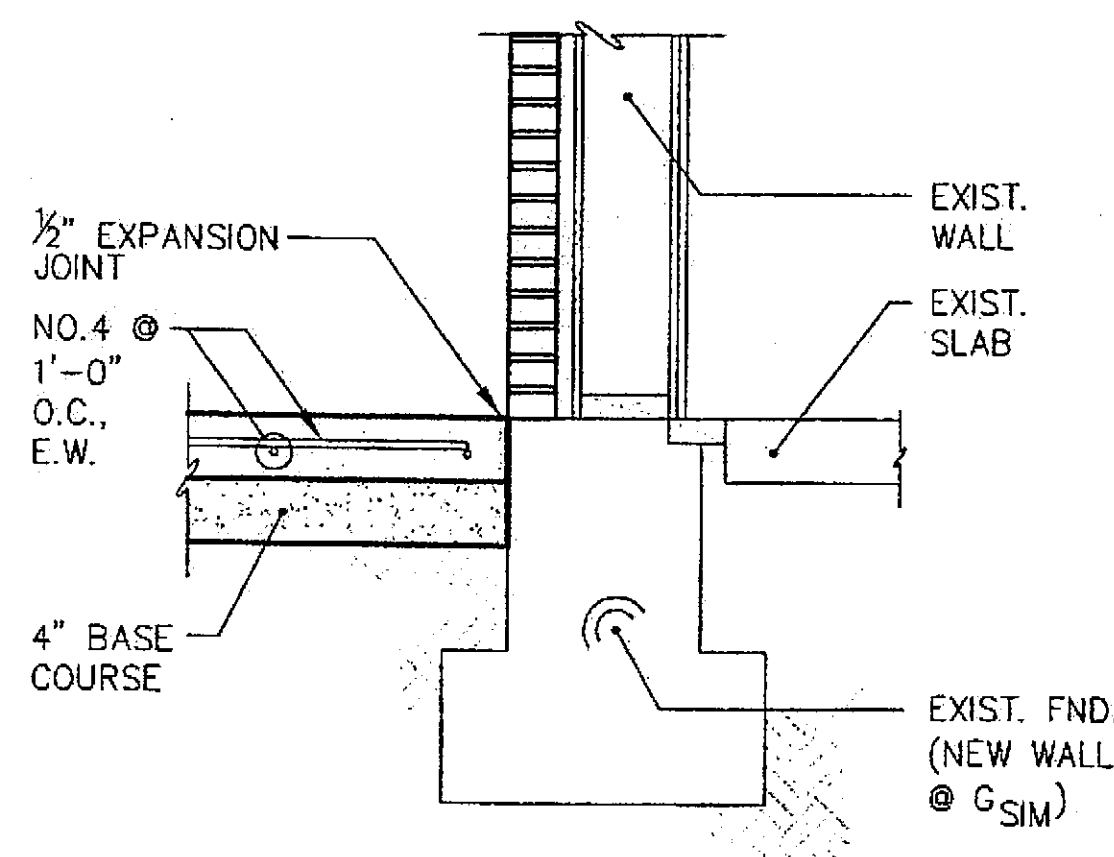

H SECTION AT EXISTING WALK/BUILDING

CHECKED BY:

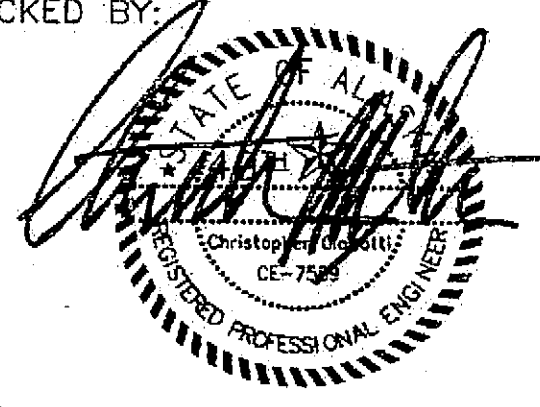

DESIGNED BY: CMG

DRAWN BY: PJD

STATE OF ALASKA
DEPARTMENT OF TRANSPORTATION
& PUBLIC FACILITIES
STATEWIDE DESIGN & ENGINEERING
SERVICES DIVISION

MT EDGECUMBE
HIGH SCHOOL
BUILDING 1330
ACADEMIC
EXPANSION

SHEET C202

PROJECT DESIGNATION NUMBER

67751

STATE	YEAR
ALASKA	2004
SHEET NUMBER	TOTAL SHEETS
40	79

Project As-Built Drawings have been reviewed by the Project Engineer and represent to the best of my knowledge, the project as constructed.
Proj. Eng. *M. M. M.* Date 7-07

STRUCTURAL GENERAL NOTES

CODE:

CONSTRUCTION SHALL BE IN CONFORMANCE WITH THE INTERNATIONAL BUILDING CODE (IBC), 2000 EDITION, AS AMENDED BY STATE OF ALASKA

LOAD CRITERIA:

FUTURE STORAGE 125 psf
SECOND FLOOR LIVE LOAD: 100 psf OR EQUIPMENT WEIGHT
ROOF SNOW LOAD: 40 psf MINIMUM BALANCED SNOW LOAD + DRIFT
GROUND SNOW LOAD: 50 psf, $C_e=1.0$, $C_t=1.0$, $I_s=1.1$
WIND: $V=120$ mph (3-SECOND GUST), EXPOSURE D, $I_w=1.15$
SEISMIC: $S_s=0.97g$, $S_1=0.50g$, $S_{ds}=0.71g$, $S_{d1}=0.50g$, $I_e=1.25$, $R=6$
SITE CLASS D, USE GROUP III, DESIGN CATEGORY D

FOUNDATION:

FOUNDATIONS SHALL BEAR ON COMPACTED BASE COURSE OVER COMPACTED NATIVE MATERIAL OR STRUCTURAL FILL. FOOTINGS HAVE BEEN DESIGNED TO AN ALLOWABLE SOIL PRESSURE OF 2500 psf IN ACCORDANCE WITH ORIGINAL BUILDING PLANS BY KCM DATED 1987.

CONCRETE:

CONCRETE SHALL BE A DENSE WORKABLE MIX WITHOUT EXCESS SURFACE WATER. CONCRETE AND CONCRETE COMPONENTS SHALL BE IN CONFORMANCE WITH THE IBC. USE OF CALCIUM CHLORIDE IS PROHIBITED. SUBMIT MIX DESIGN FOR REVIEW AND APPROVAL PRIOR TO MIXING. CONCRETE FORMWORK, MIXING, PLACING, CONSOLIDATION, AND CURING SHALL BE IN CONFORMANCE WITH THE IBC. MAXIMUM SLUMP AND CEMENT CONTENT SHALL BE AS FOLLOWS FOR VARIOUS CONCRETE STRENGTHS (f'_c) BASED ON THE STANDARD 28 DAY CYLINDER TESTS:

LOCATION	f'_c	MIN. SACKS OF CEMENT PER C.Y. OF CONCRETE	MAX. W/C RATIO	MAX. SLUMP
EXTERIOR SLABS	4000	6.0	0.45	4"
ALL OTHER CONCRETE	3500	5.5	0.50	4"

CONCRETE REINFORCING SHALL CONFORM TO ASTM A615 GRADE 60. FABRICATE AND PLACE STEEL REINFORCEMENT IN ACCORDANCE WITH CRSI'S "MANUAL OF STANDARD PRACTICE". REINFORCING SHALL BE SUPPORTED ON WELL-CURED BLOCKS OR APPROVED METAL ACCESSORIES. WELDING OF REINFORCING IS PROHIBITED. PROVIDE MINIMUM CONCRETE COVER AS SHOWN ON THE PLANS.

STRUCTURAL STEEL:

STEEL SHALL CONFORM TO THE FOLLOWING:

HSS SECTIONS = ASTM A500 GRADE B
PLATES = ASTM A572, GRADE 50
BOLTS = ASTM A307, HEADED BOLTS

ALL STRUCTURAL STEEL SHALL BE FABRICATED AND ERECTED IN ACCORDANCE WITH THE AISC CODE OF STANDARD PRACTICE, LATEST EDITION. SUBMIT FABRICATION SHOP DRAWINGS FOR REVIEW AND APPROVAL PRIOR TO COMMENCING FABRICATION. CLEAN AND PREPARE ALL FABRICATED STEEL IN ACCORDANCE WITH SSPC SP6, COMMERCIAL BLAST, AND SHOP PRIME WITH RED OXIDE PRIMER.

ALL WELDING SHALL BE PERFORMED IN ACCORDANCE WITH AWS D1.1, STRUCTURAL WELDING CODE, BY WELDERS QUALIFIED IN ACCORDANCE WITH AWS D1.1, IN THE POSITION AND PROCESS USED ON THIS PROJECT. SUBMIT WELDER QUALIFICATIONS AND WELDING PROCEDURES IN ACCORDANCE WITH AWS D1.1.

ALL BASE PLATE GROUT SHALL BE NON-SHRINK, NON-METALLIC GROUT WITH MINIMUM COMPRESSIVE STRENGTH OF 7,000psi AT 28 DAYS. PREPARE SURFACES FOR GROUTING, MIX AND APPLY GROUT IN ACCORDANCE WITH MANUFACTURER'S INSTRUCTIONS.

PLYWOOD:

ALL PLYWOOD SHALL BE STANDARD SHEATHING AS GRADED BY THE AMERICAN PLYWOOD ASSOCIATION CONFORM TO APA PS1 OR PS2 AND BEAR THAT QUALITY MARK. ALL PLYWOOD SHALL BE MADE WITH EXTERIOR TYPE GLUE. FLAT BLOCKING SHALL BE USED AT ALL PLYWOOD EDGES AS NOTED ON THE TYPICAL DETAILS OR SHOWN IN THE PLANS. ALL PLYWOOD IN CONTACT WITH OR WITHIN 6 INCHES OF SOIL OR DESIGNATED AS (P/T) SHALL BE PRESSURE TREATED IN ACCORDANCE WITH AWPA C-9, WITH ACZA TO A NET RETENTION OF 0.40 PCF.

LUMBER:

ALL WORKMANSHIP AND CONSTRUCTION SHALL CONFORM TO IBC, CHAPTER 23. ALL SAWN LUMBER SHALL BE VISUALLY GRADED IN ACCORDANCE WITH THE W.W.P.A. GRADING RULES. ALL DIMENSIONED LUMBER SMALLER THAN 6x SHOWN ON THE PLANS, SHALL BE SEASONED S4S NO. 2 GRADE HEM FIR OR BETTER. BEAMS, STRINGERS AND POSTS 6x6 AND LARGER SHALL BE SEASONED S4S NO.1 HEM FIR OR BETTER. ORIENTED STRAND LUMBER SHALL BE PARALLAM OR TIMBERSTRAND AS NOTED ON THE PLANS. PARALLAM MEMBERS SHALL BE MANUFACTURED BY TRUSS JOIST CORPORATION W/E=2.0x10⁶ psi, $F_b=2900$ psi, $F_{c1}=2900$ psi, $F_{c2}=750$ psi, AND $F_v=265$ psi. TIMBERSTRAND MEMBERS SHALL BE AS MANUFACTURED BY THE TRUSS JOIST CORPORATION AND HAVE FOLLOWING PROPERTIES: $E=1.5x10^6$ psi, $F_b=2250$ psi, $F_{c2}=750$ psi, $F_{c3}=1950$ psi, $F_v=285$ psi. ANY SUBSTITUTION SHALL EITHER HAVE THE SAME PROPERTIES OR BE SIZED TO PROVIDE THE SAME PERFORMANCE. SUBMITTAL FOR SUBSTITUTION SHALL BE ACCOMPANIED WITH ICBO EVALUATION REPORT.

TREATED LUMBER:

ALL TIMBER IN CONTACT WITH CONCRETE OR AS INDICATED AS (P/T) ON THE PLANS SHALL BE PRESSURE TREATED WITH ACZA TO A NET RETENTION OF 0.40 PCF IN ACCORDANCE WITH AWPA C2. FIELD TREAT CUTS, HOLES OR DAMAGE TO TREATMENT WITH CUPRINOL IN ACCORDANCE WITH AWPA M4.

WOOD CONNECTIONS AND FRAMING:

ALL FRAMING NAILING SHALL CONFORM TO TABLE 2304.9.1 OF THE IBC UNLESS OTHERWISE SHOWN. STANDARD WASHERS SHALL BE UNDER ALL BOLT HEADS AND NUTS CONTACTING WOOD. PROVIDE STEEL STRAPS AT PIPES IN STUD WALLS AS REQUIRED BY IBC. BOLTS SHALL BE STANDARD ASTM A307, GALVANIZED. ALL NAILS SHALL BE GALVANIZED COMMON WIRE NAILS. ALL METAL HANGERS AND CONNECTORS SHOWN ON DRAWINGS ARE MANUFACTURED BY THE SIMPSON COMPANY. METAL HANGERS OR CONNECTORS BY OTHER MANUFACTURER'S MAY BE CONSIDERED WHERE LOAD CAPACITY AND DIMENSIONS ARE EQUAL OR BETTER. ALL SUBSTITUTIONS SHALL BE SUBMITTED TO THE ENGINEER FOR REVIEW AND APPROVAL. SUBMITTALS MUST INCLUDE AN ICBO EVALUATION REPORT. INSTALL CONNECTORS WITH FULL NAILING AND BOLTING UNLESS OTHERWISE NOTED.

MANUFACTURED WOOD ROOF AND FLOOR TRUSSES AND JOISTS:

ALL WOOD TRUSSES AND MANUFACTURED JOISTS SHALL BE FACTORY MANUFACTURED WITH MACHINE STRESS RATED MATERIALS DESIGNED TO SUPPORT THE LOADING SHOWN ON THE DRAWINGS. BASIS FOR DESIGN OF JOISTS SHOWN ON THE DRAWINGS ARE IN ACCORDANCE WITH PUBLISHED LOAD CHARTS AND MEMBER DESIGNATION OF THE "TRUSS JOIST CORP". TRUSSES BY OTHER MANUFACTURER'S MAY BE SUBSTITUTED UPON APPROVAL BY THE ENGINEER. WHERE DIMENSIONS AND DETAILS CHANGE DUE TO SUCH A SUBSTITUTION, CONTRACTOR SHALL BE RESPONSIBLE FOR ANY REQUIRED MODIFICATION TO THE CONTRACT DRAWINGS. SUBMIT DETAILED SHOP DRAWINGS AND DESIGN CALCULATIONS OF ALL TRUSSES AND MANUFACTURED JOISTS TO THE ENGINEER FOR REVIEW AND APPROVAL PRIOR TO FABRICATION.

SHOP DRAWINGS:

THE CONTRACTOR SHALL REVIEW, STAMP WITH HIS APPROVAL, DATE AND SIGN ALL SHOP DRAWINGS REQUIRED BY THE CONTRACT DOCUMENTS PRIOR TO SUBMITTAL TO THE ENGINEER. AT THE TIME OF SUBMISSION, THE CONTRACTOR SHALL INFORM THE ENGINEER IN WRITING OF ANY DEVIATION IN THE SHOP DRAWINGS FROM THE REQUIREMENTS OF THE CONTRACT DRAWINGS.

MISCELLANEOUS:

REFER TO ARCHITECTURAL PLANS FOR WALL OPENINGS, ARCHITECTURAL TREATMENT AND DIMENSIONS NOT SHOWN, CONSULT MECHANICAL PLANS FOR SIZE AND LOCATION OF ALL OPENINGS FOR DUCTS, PIPING, ETC. NOT SHOWN. COORDINATE WITH ARCHITECTURAL FOR DETAILED INFORMATION. PROVIDE AND INSTALL BLOCKING BETWEEN STUDS AT MECHANICAL EQUIPMENT AND SEISMIC RESTRAINT PER MECHANICAL. PROVIDE BLOCKING FOR ARCHITECTURAL ELEMENTS.

ABBREVIATIONS

AITC	AMERICAN INSTITUTE FOR TIMBER CONSTRUCTION	EW	EACH WAY
AISC	AMERICAN INSTITUTE OF STEEL CONSTRUCTION	GALV	GALVANIZED
ARCH	ARCHITECT	GLB	GLU LAM BEAM
ASTM	AMERICAN SOCIETY FOR TESTING AND MATERIALS	MAX.	MAXIMUM
AWPA	AMERICAN WOOD PRESERVER'S ASSOCIATION	ML	MALLEABLE IRON
BLDG	BUILDING	MIN.	MINIMUM
BLKG	BLOCKING	NO.	NUMBER
BM	BEAM	O.C.	ON CENTER
BN	BOUNDARY NAILING	OSB	ORIENTED STRAND BOARD
BTWN	BETWEEN	P	PLATE
C	CENTERLINE	P/T	PRESSURE TREATED
CJ	CONTROL JOINT	PHD	SIMPSON HOLD DOWN
CLR	CLEAR	PSI	POUNDS PER SQUARE INCH
CONC	CONCRETE	PVC	POLYVINYL CHLORIDE
CP	COMPLETE PENETRATION	REINF	REINFORCING
CRSI	CONCRETE REINFORCING STEEL INSTITUTE	REQ'D	REQUIRED
CY	CUBIC YARD	SEL	SELECT
DBL	DOUBLE	SHED	SCHEDULE
DFT	DRY FILM THICKNESS	SIM	SIMILAR
EA	EACH	SIP	STRUCTURAL INSULATED PANEL
EMBED	EMBEDMENT	STD	STANDARD
EN	EDGE NAILING	STR	STRUCTURAL
ELEV.	ELEVATION	T&G	TONGUE AND GROOVE
EQ	EQUIVALENT	T.O.S.	TOP OF SLAB
		TYP.	TYPICAL
		W/C	WATER/CEMENT
		W.P.	WORK POINT
		U.N.O.	UNLESS NOTED OTHERWISE

Tue, 14/Dec/04 12:00PM


ADDENDUM NUMBER

ATTACHMENT NUMBER

RECORD OF REVISIONS

No.	DATE	DESCRIPTION

CHECKED BY:

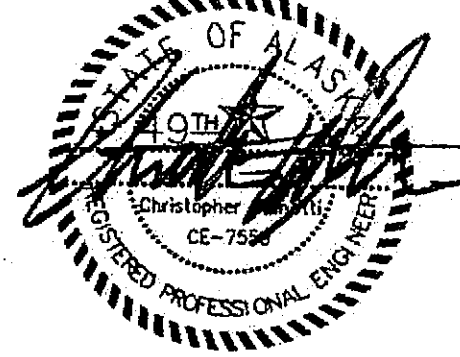

DESIGNED BY: BCN

DRAWN BY: PJD

STATE OF ALASKA
DEPARTMENT OF TRANSPORTATION
& PUBLIC FACILITIES
STATEWIDE DESIGN & ENGINEERING
SERVICES DIVISION

MT EDGE CUMBE
HIGH SCHOOL
BUILDING 1330
ACADEMIC
EXPANSION


SHEET S100

PROJECT DESIGNATION NUMBER

67751C

STATE	YEAR
ALASKA	2004
SHEET NUMBER	TOTAL SHEETS
41	79


Project As-Built Drawings have been
reviewed by the Project Engineer and
represent to the best of my knowledge, the
project as constructed.
Proj. Eng. *Smith* Date *7-7*

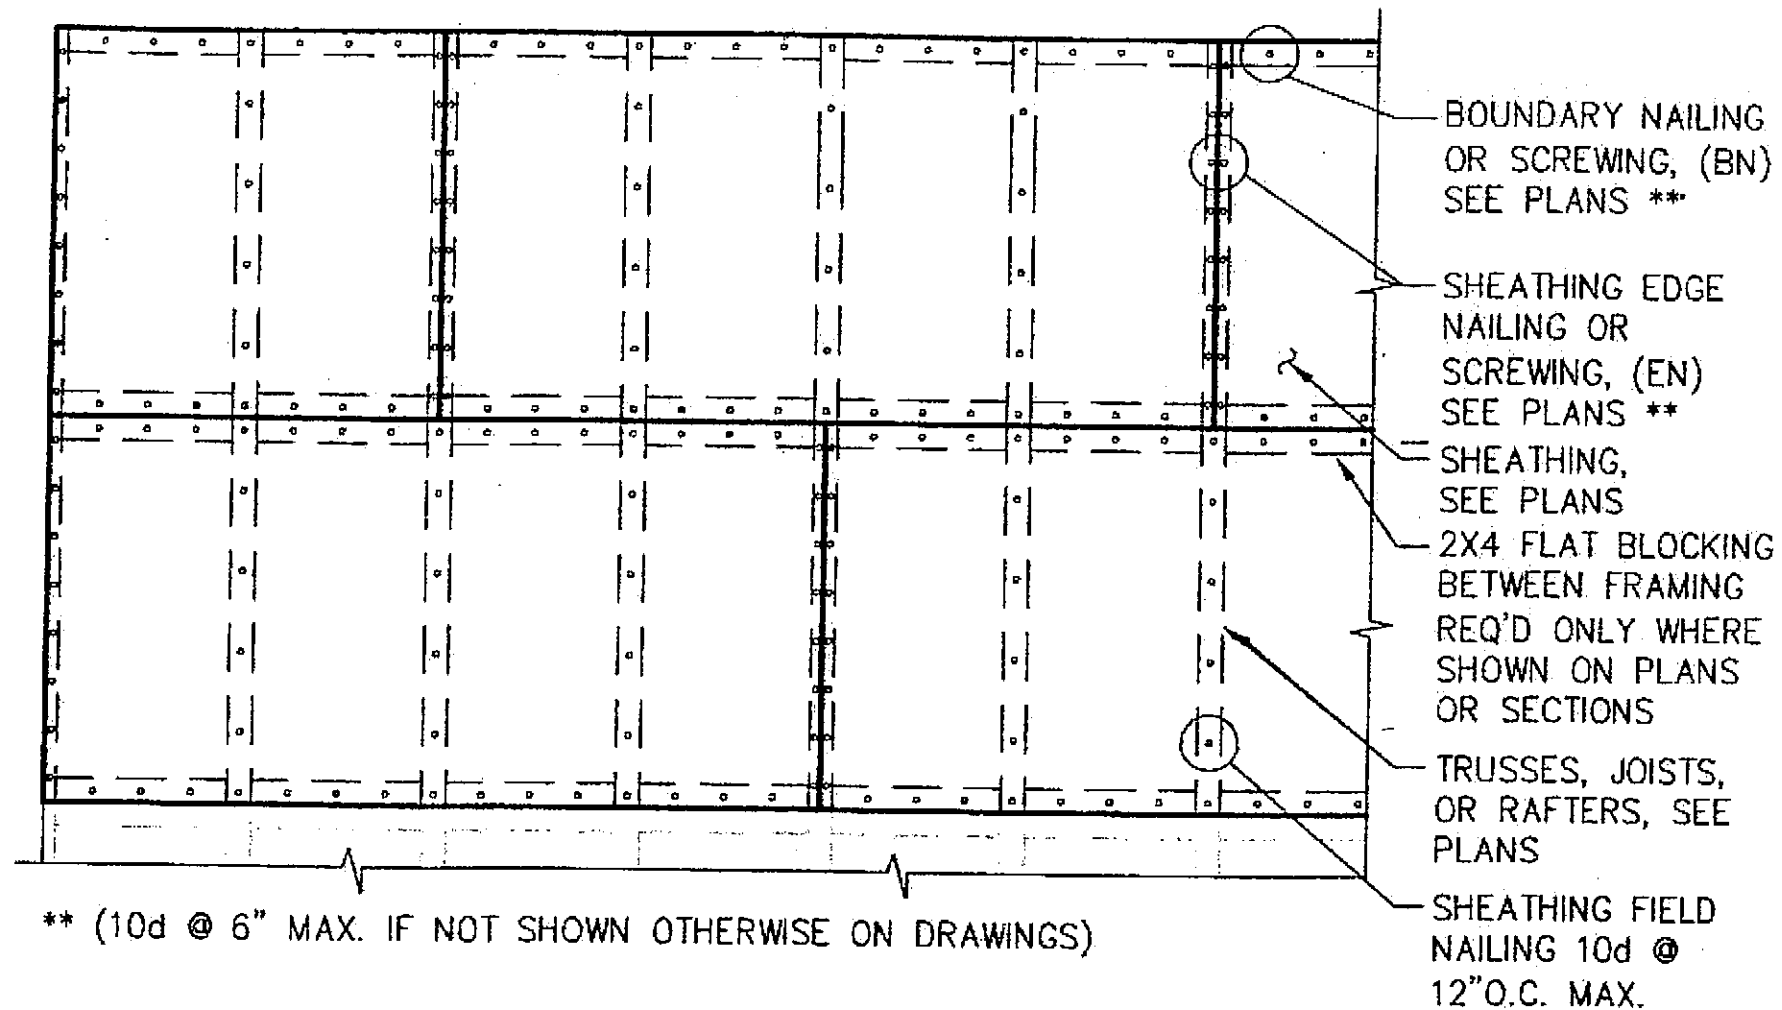

PLAN

NOTES:

1. STAGGER SHEATHING JOINTS A MINIMUM OF TWO JOIST SPACES
2. NAILS AT ABUTTING SHEATHING EDGES MUST PENETRATE THE SAME PIECE OF FRAMING OR BLOCKING.

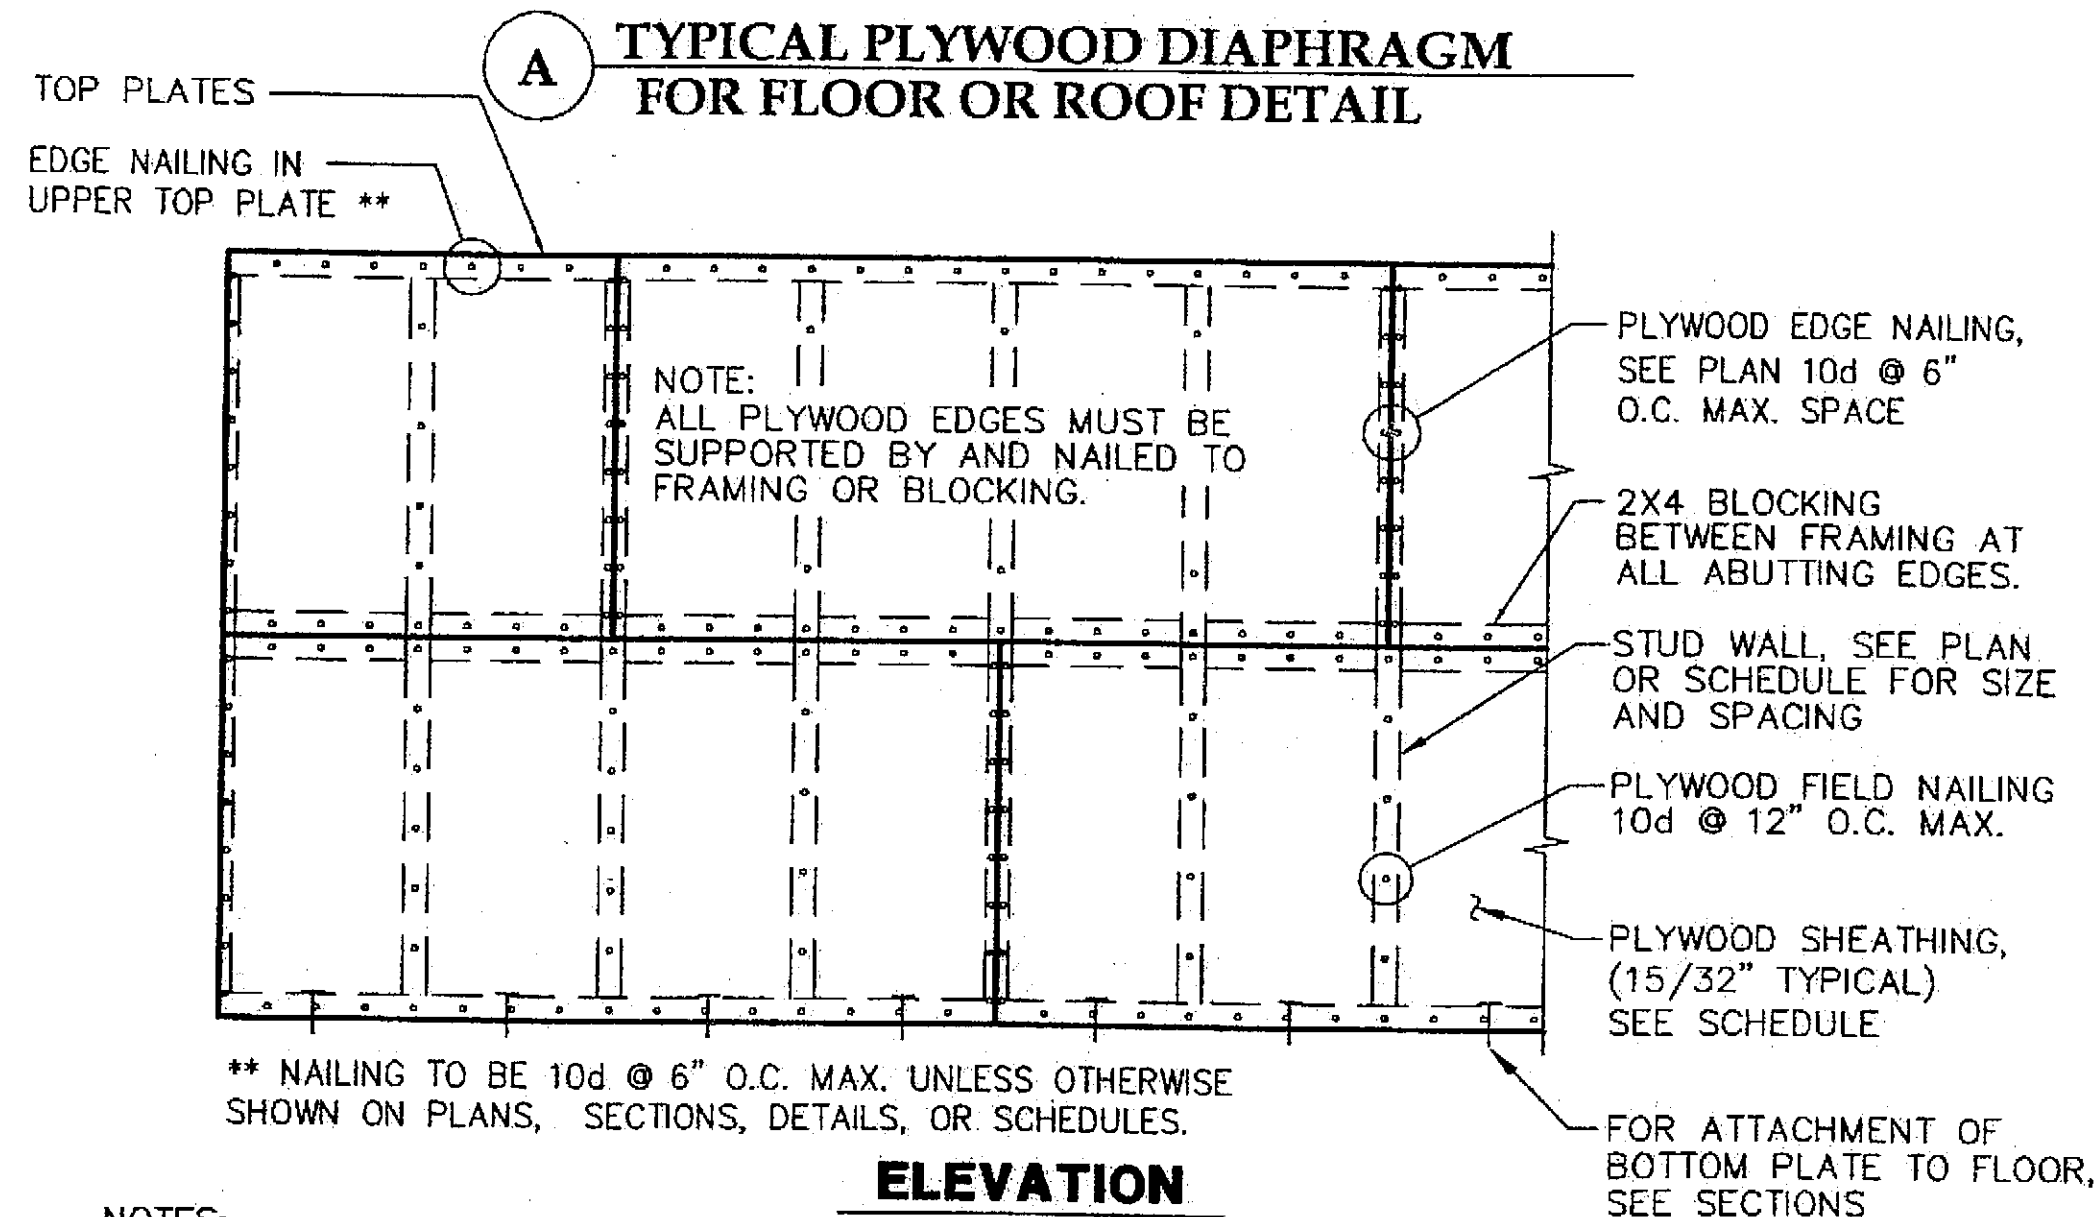


ELEVATION


NOTES:

1. PLYWOOD IS SHOWN HORIZONTAL, IT MAY ALSO BE POSITIONED VERTICAL.
2. STAGGER PLYWOOD JOINTS A MINIMUM OF TWO STUD SPACES.
3. NAILS AT ABUTTING PLYWOOD EDGES MUST PENETRATE THE SAME PIECE OF FRAMING OR BLOCKING.
4. SEE TYPICAL WALL ELEVATIONS AND PLANS FOR HOLD DOWNS, STRAPS AND ADDITIONAL BLOCKING.

B TYPICAL SHEAR WALL DETAIL

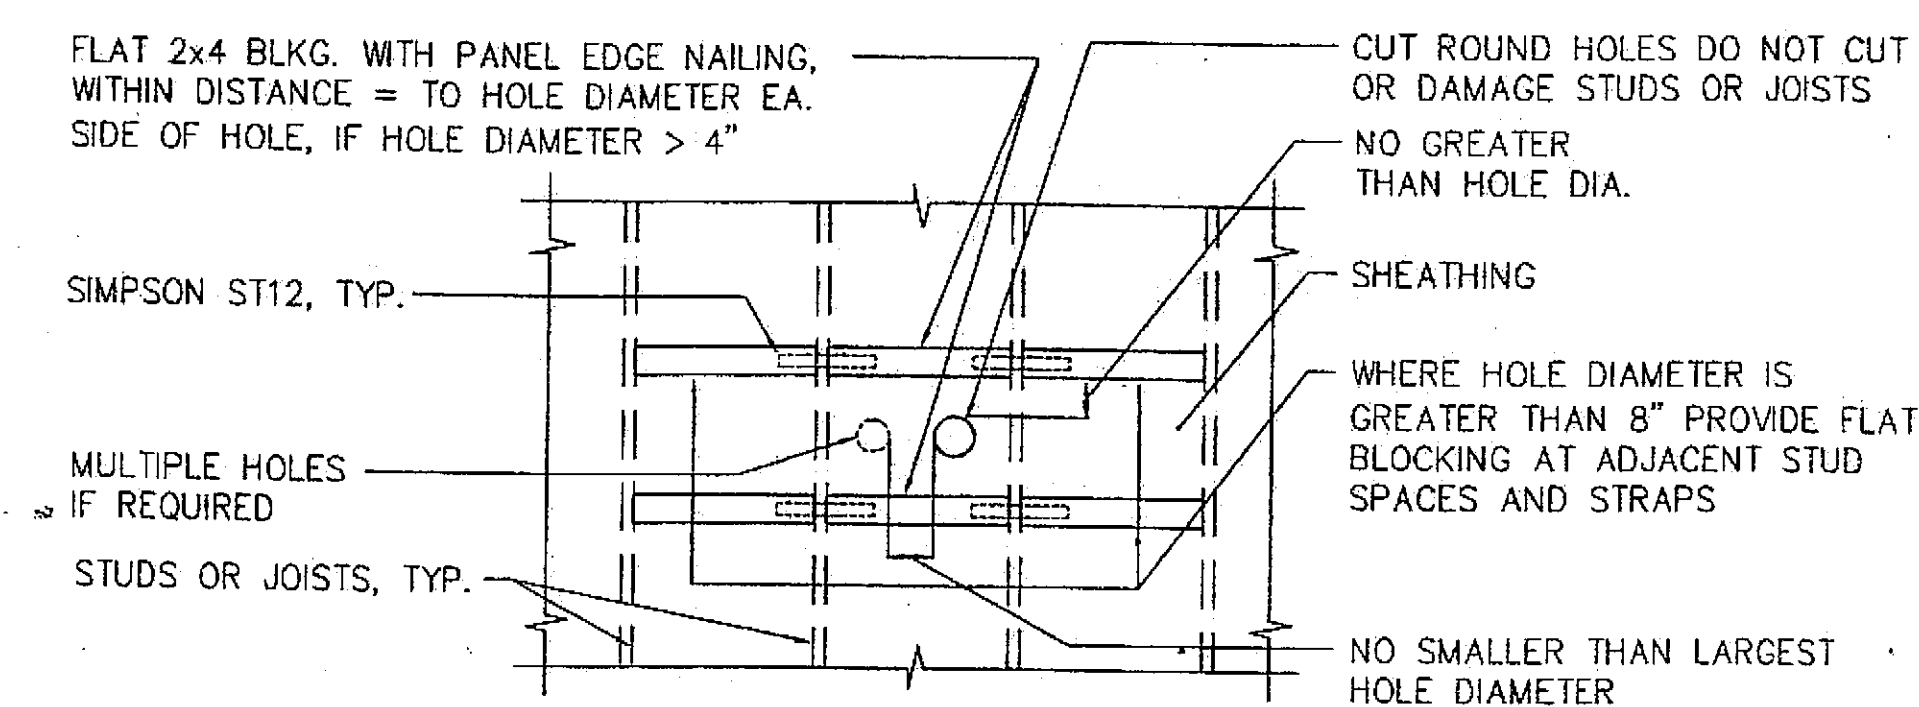

C TYPICAL SHEAR WALL AND DIAPHRAGM PENETRATION DETAIL

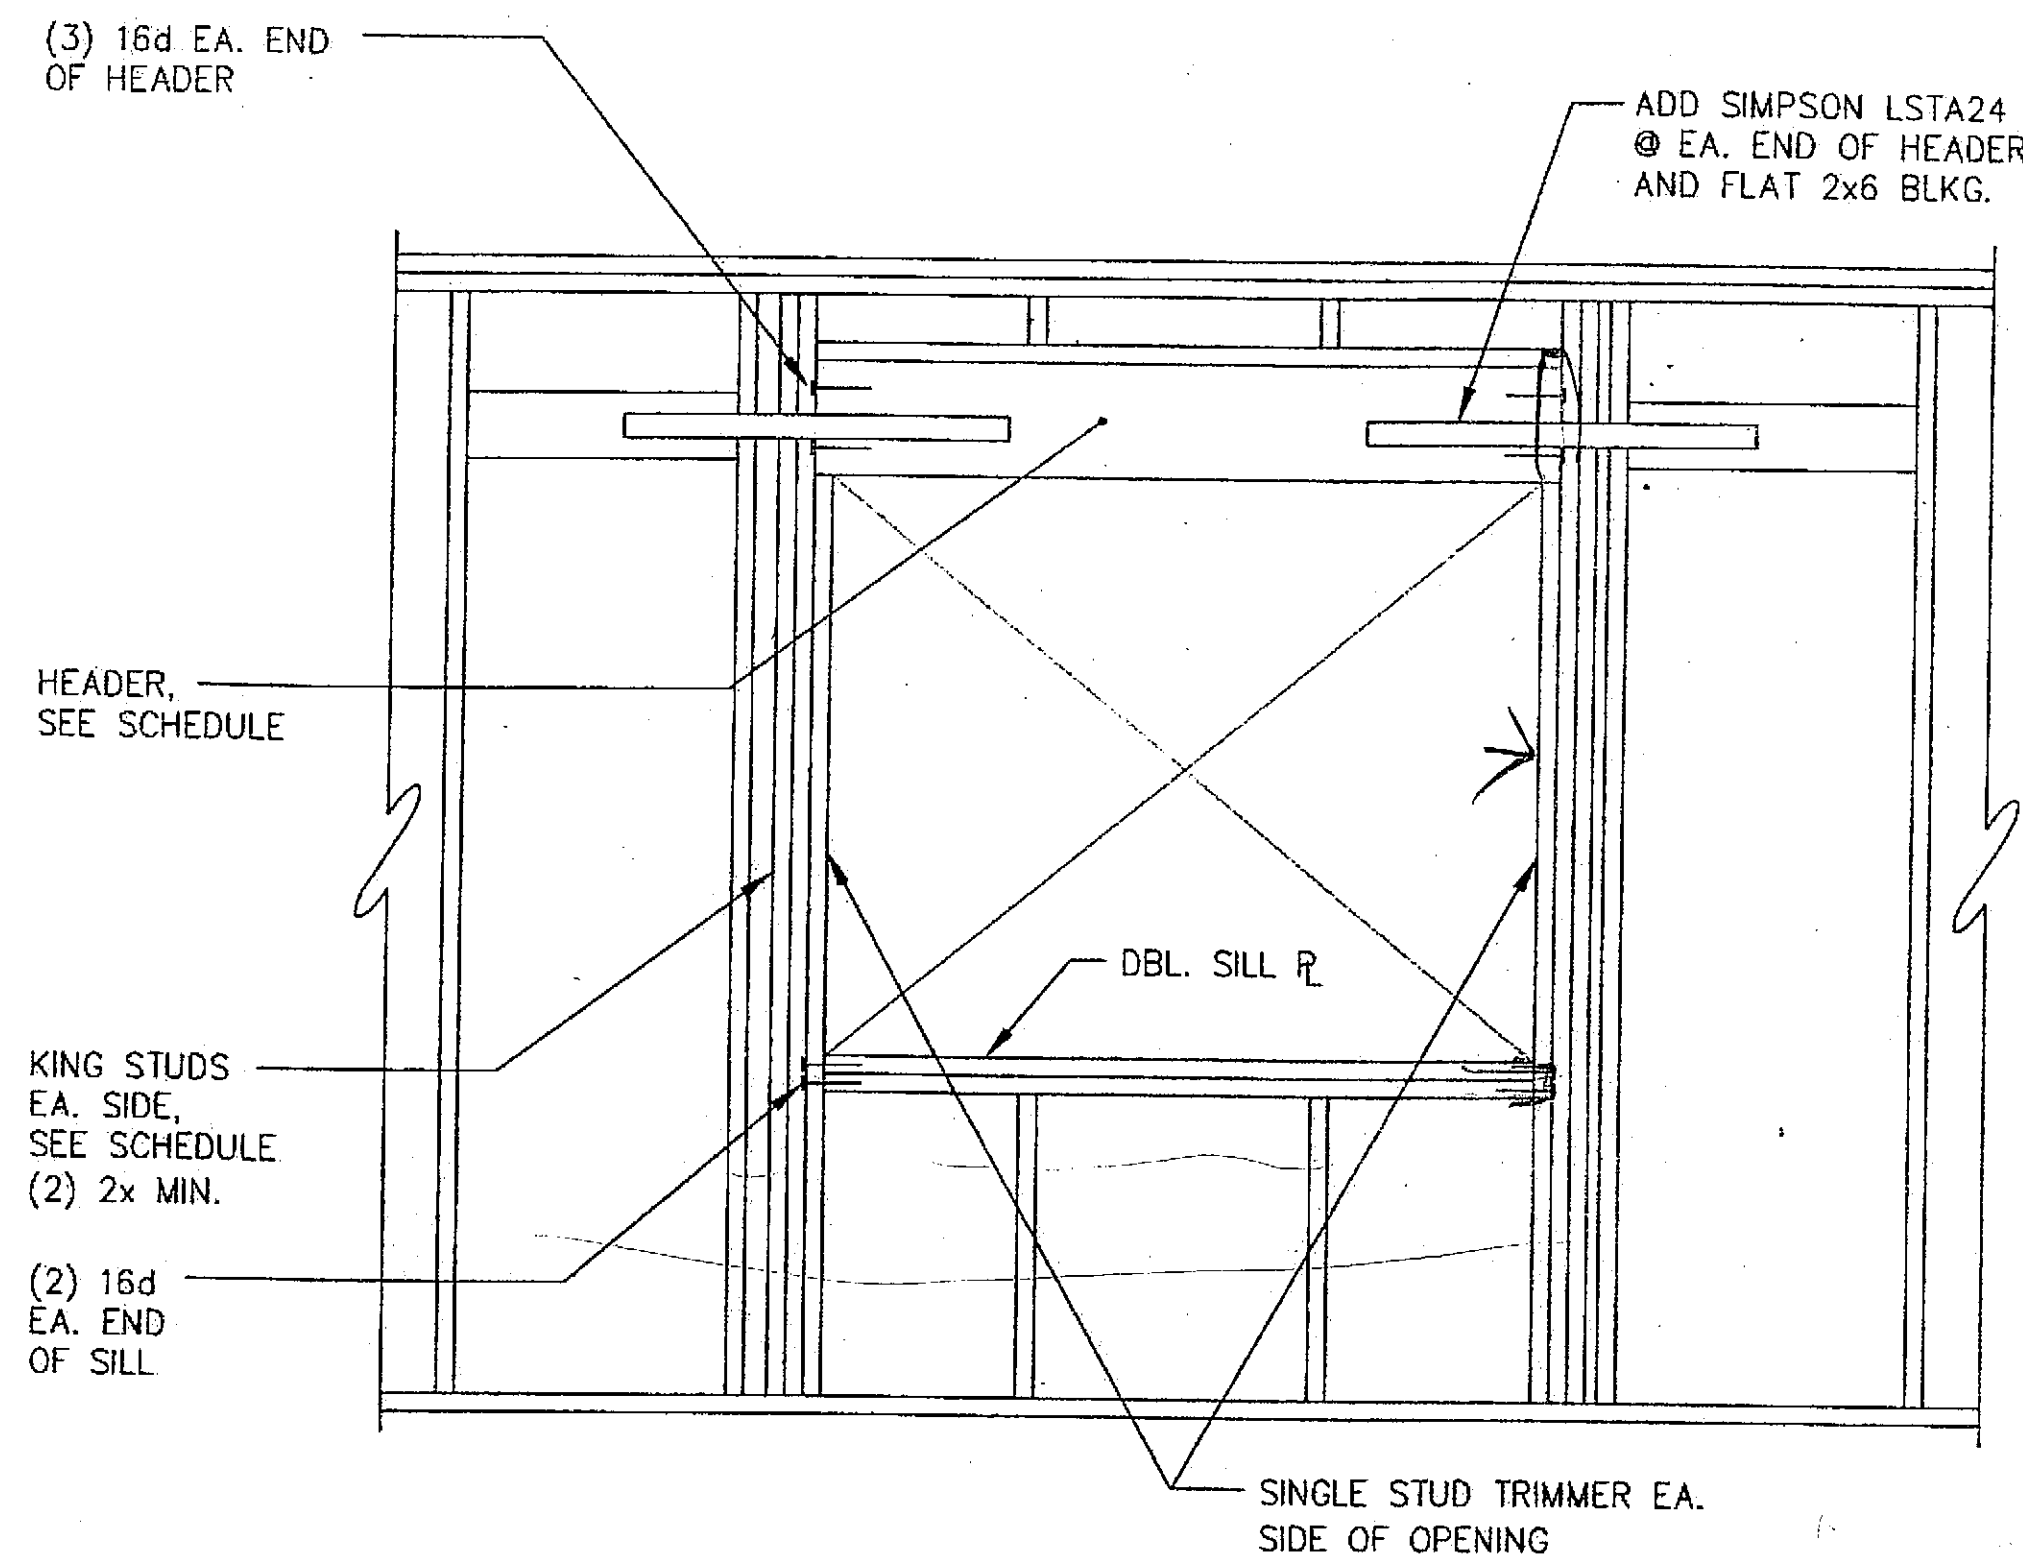


D TYPICAL HEADER DETAIL

HEADER SCHEDULE			
MARK	OPENING	HEADER SIZE	KING STUDS
(X)	TYPICAL HEADER WHERE INDICATED	(3) 2x12	DBL. STUD
(Y)	TYPICAL HEADER WHERE INDICATED	5 1/4"x16" P-LAM	DBL. STUD


BASE PLATE SCHEDULE						
TYPE	t (IN)	b (IN)	l (IN)	ANCHOR BOLTS		
				NO.	DIA (IN)	EMBED (IN)
1	1/2	11	11	4	3/4	9
2	3/8	10	10	4	3/4	9
3	3/8	5 1/2	10	4	3/4	9

NOTES:


1. 1 INDICATES BASE PLATE TYPE AND ANCHOR BOLTS. SEE SCHEDULE THIS SHEET.

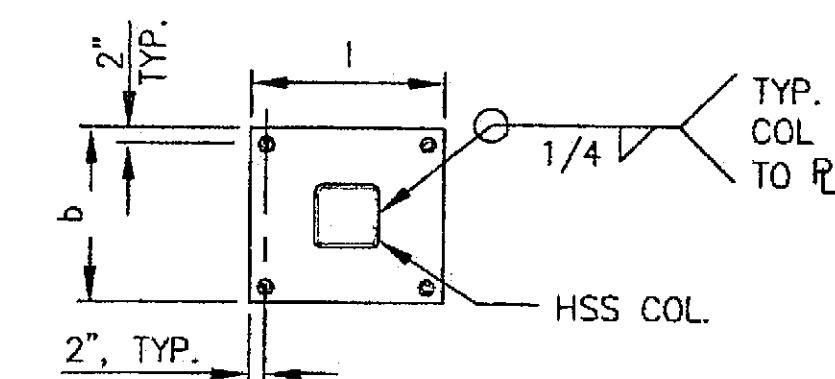

B TYPICAL BASE PLATE DETAIL

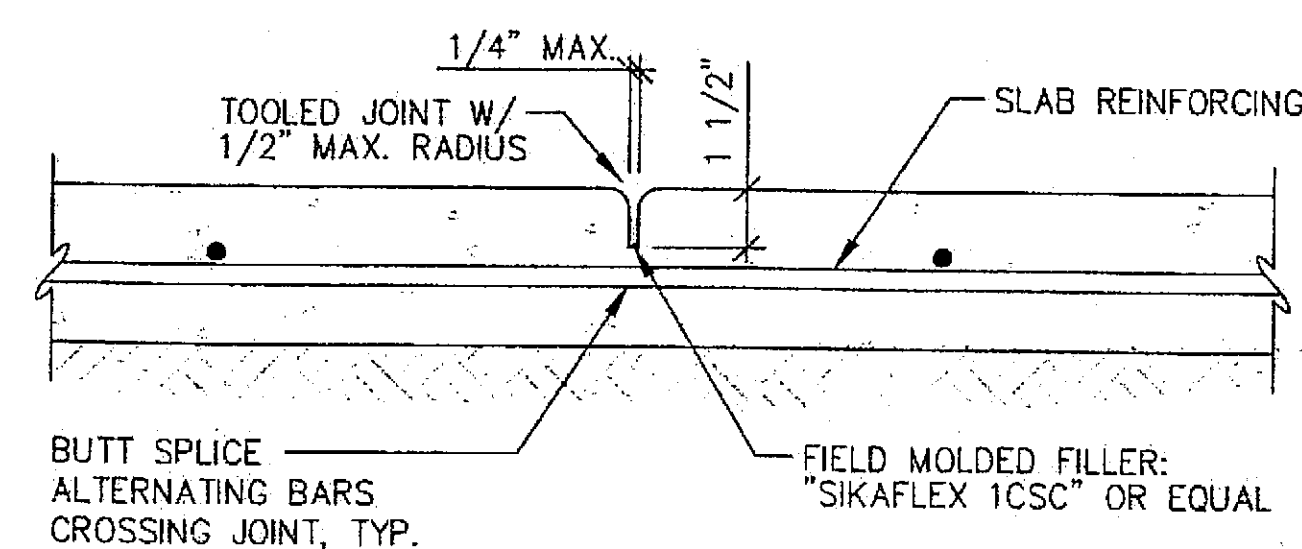

E TYPICAL CRACK CONTROL JOINT (CJ)

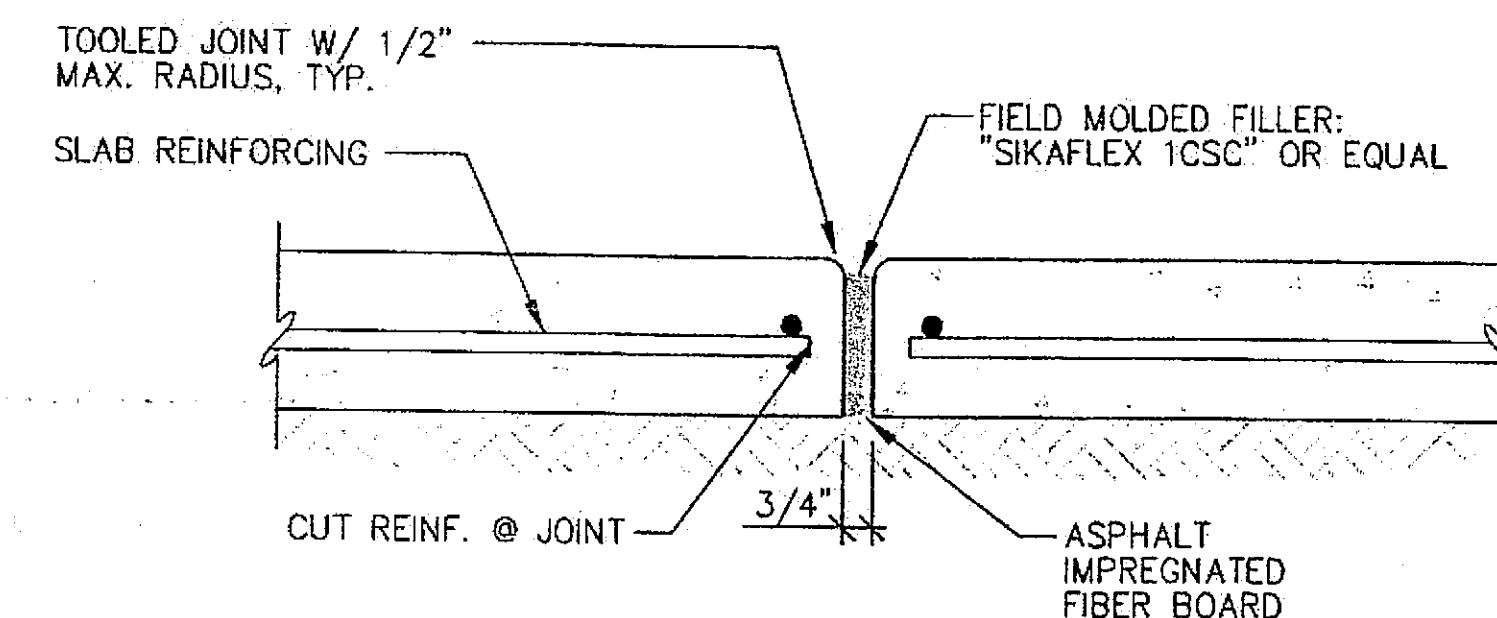

F TYPICAL ISOLATION OR EXPANSION JOINT SECTION

Tue, 14/Dec/04 12:00PM


ADDENDUM NUMBER

ATTACHMENT NUMBER

RECORD OF REVISIONS

No.	DATE	DESCRIPTION

CHECKED BY:

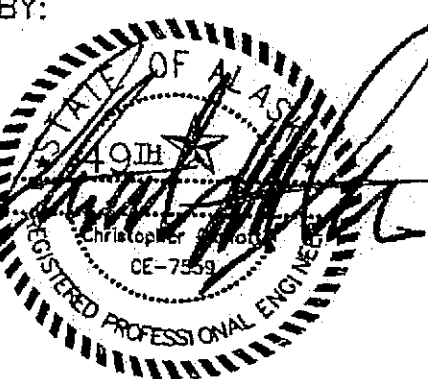

DESIGNED BY: BCN

DRAWN BY: PJD

STATE OF ALASKA
DEPARTMENT OF TRANSPORTATION
& PUBLIC FACILITIES
STATEWIDE DESIGN & ENGINEERING
SERVICES DIVISION

MT EDGECOMBE
HIGH SCHOOL
BUILDING 1330
ACADEMIC
EXPANSION

SHEET S101

PROJECT DESIGNATION NUMBER

67751C

STATE YEAR

ALASKA 2004

SHEET NUMBER TOTAL SHEETS

42 79

Project As-Built Drawings have been
reviewed by the Project Engineer and
presented to the best of my knowledge,
project as constructed.
Proj. Eng. *[Signature]* Date 7-27

ADDENDUM NUMBER


ATTACHMENT NUMBER

RECORD OF REVISIONS

No.	DATE	DESCRIPTION

NOTE: SEE BASE BID
PLAN FOR CALLOUTS
NOT SHOWN.

39000
20000
\$ 20000

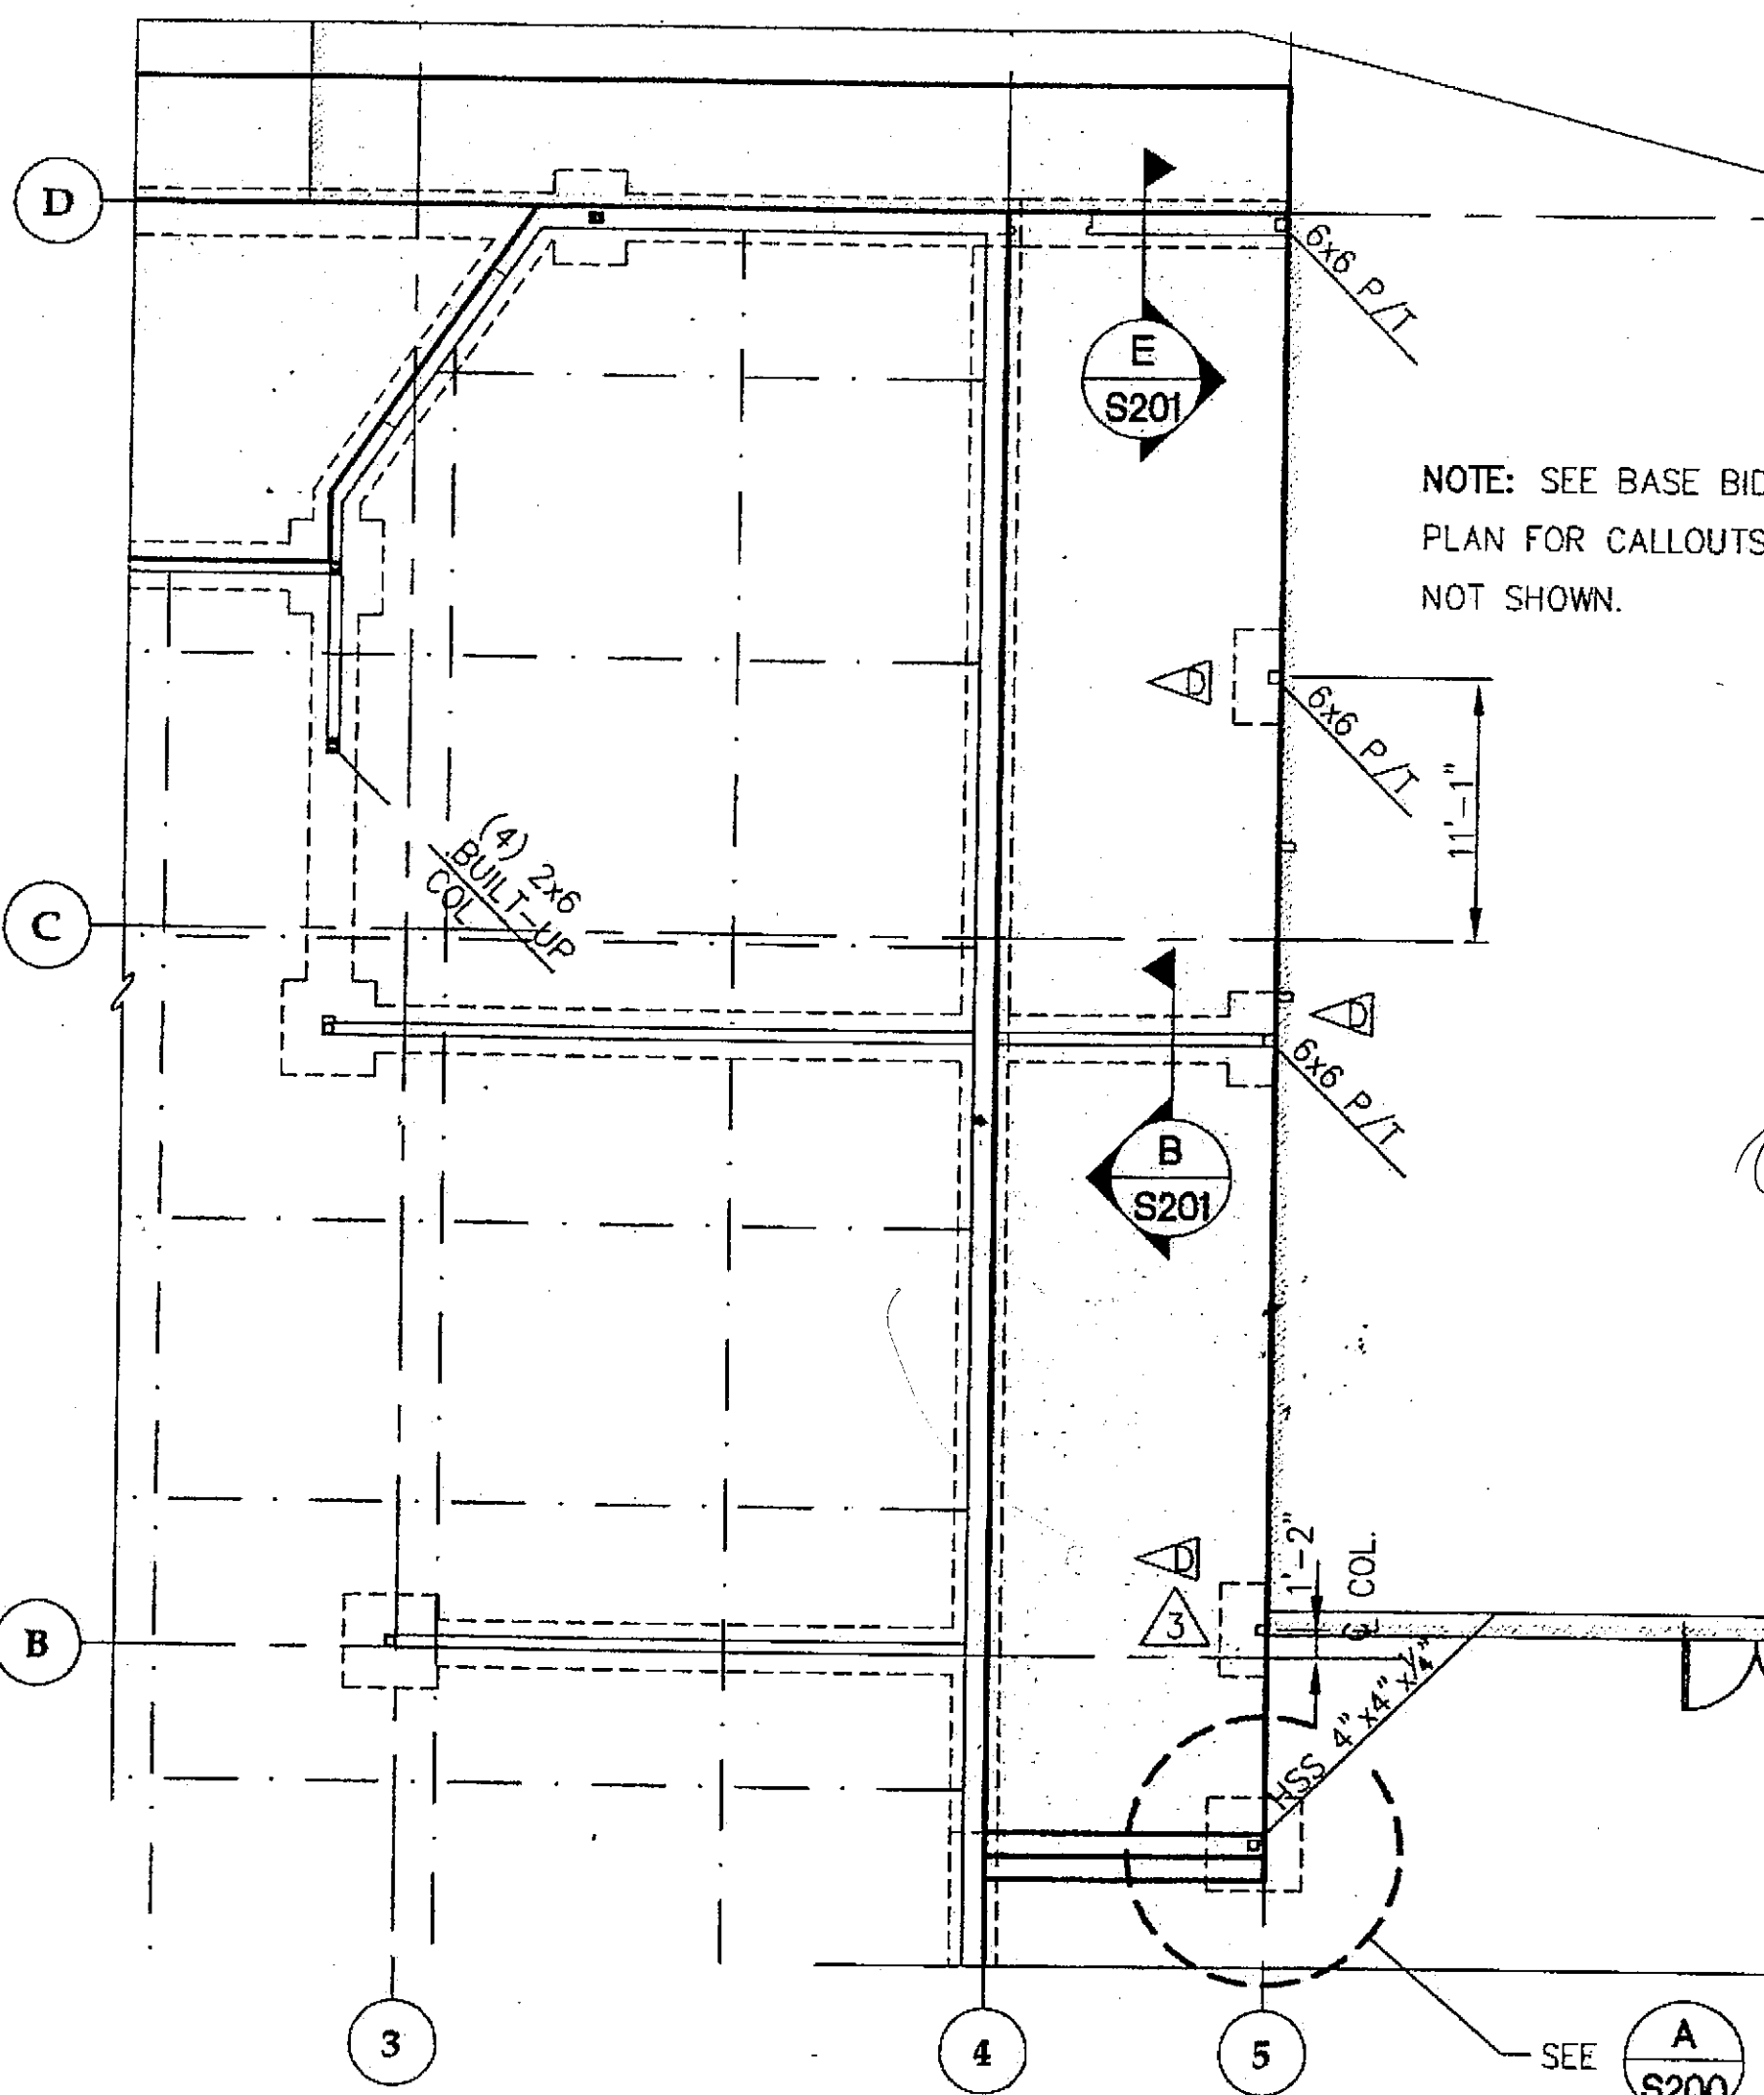


FOUNDATION & FIRST
FLOOR FRAMING PLAN
ALTERNATE


SHEAR WALL SCHEDULE			
MARK	SHEATHING	PANEL EDGE NAILING	ANCHOR BOLTS
(A)	15/32 CDX ONE SIDE	10d@ 6"	3/4" @ 4'-0"
(B)	15/32 CDX ONE SIDE	10d@ 4"	3/4" @ 2'-0"
(C)	15/32 CDX BOTH SIDES	10d@ 4"	3/4" @ 1'-0"
(D)	15/32 CDX BOTH SIDES	10d@ 6"	3/4" @ 1'-0"

STUDWALL SCHEDULE			
NO.	MATERIAL	STUD SIZE	STUD SPACING
①	HEM-FIR	2"x6"	1'-0"
②	HEM-FIR	2"x6"	2'-0"
③	HEM-FIR	(2) 2"x6"	2'-0"

FOOTING SCHEDULE		
MARK	LENGTH	DEPTH
▲▲▲	3'-0" x 4'-0"	8"
▲▲	4'-0" x 4'-0"	1'-0"
▲	6'-0" x 6'-0"	1'-6"
▲	5'-0" x 3'-6"	1'-0"
▲	6'-0" x 2'-0"	1'-0"

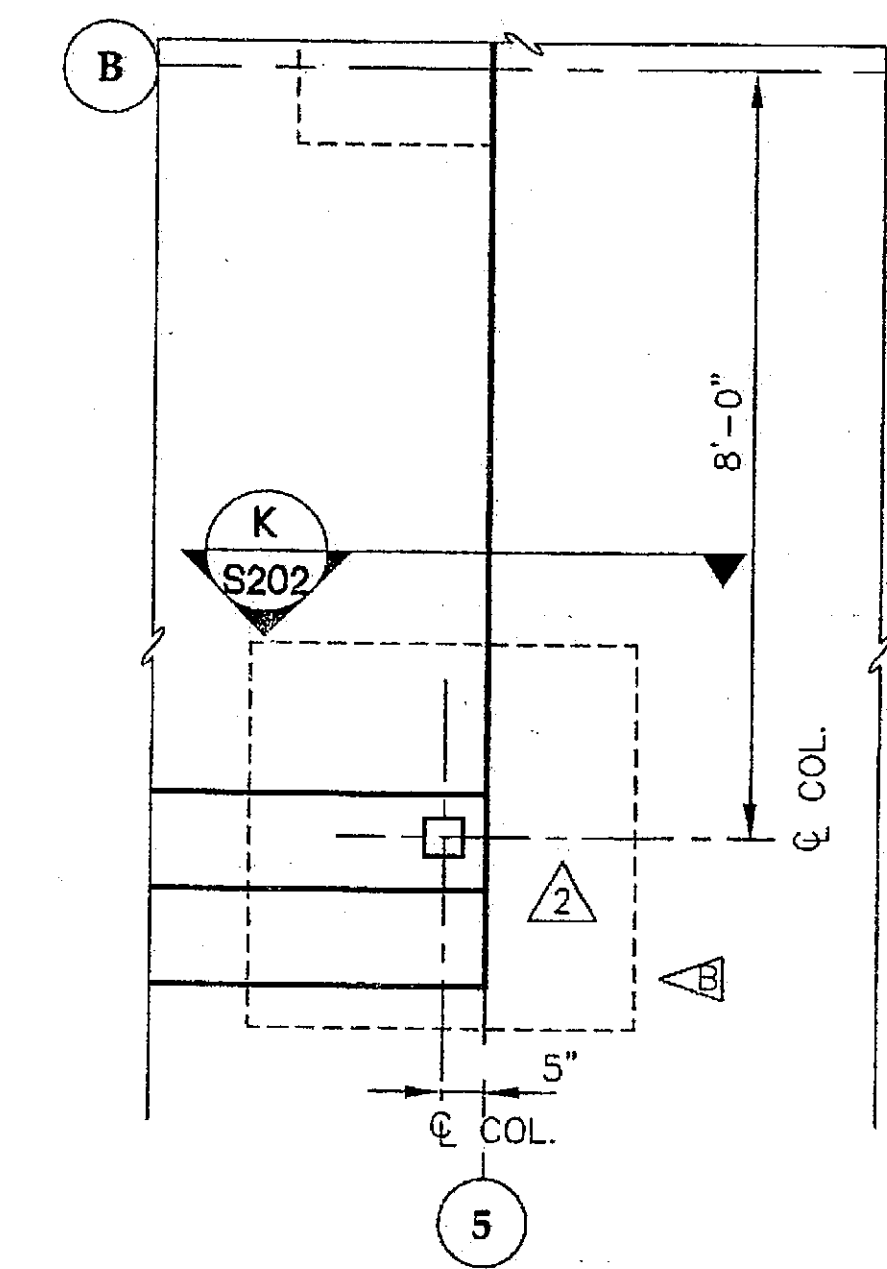


FOOTING DETAIL

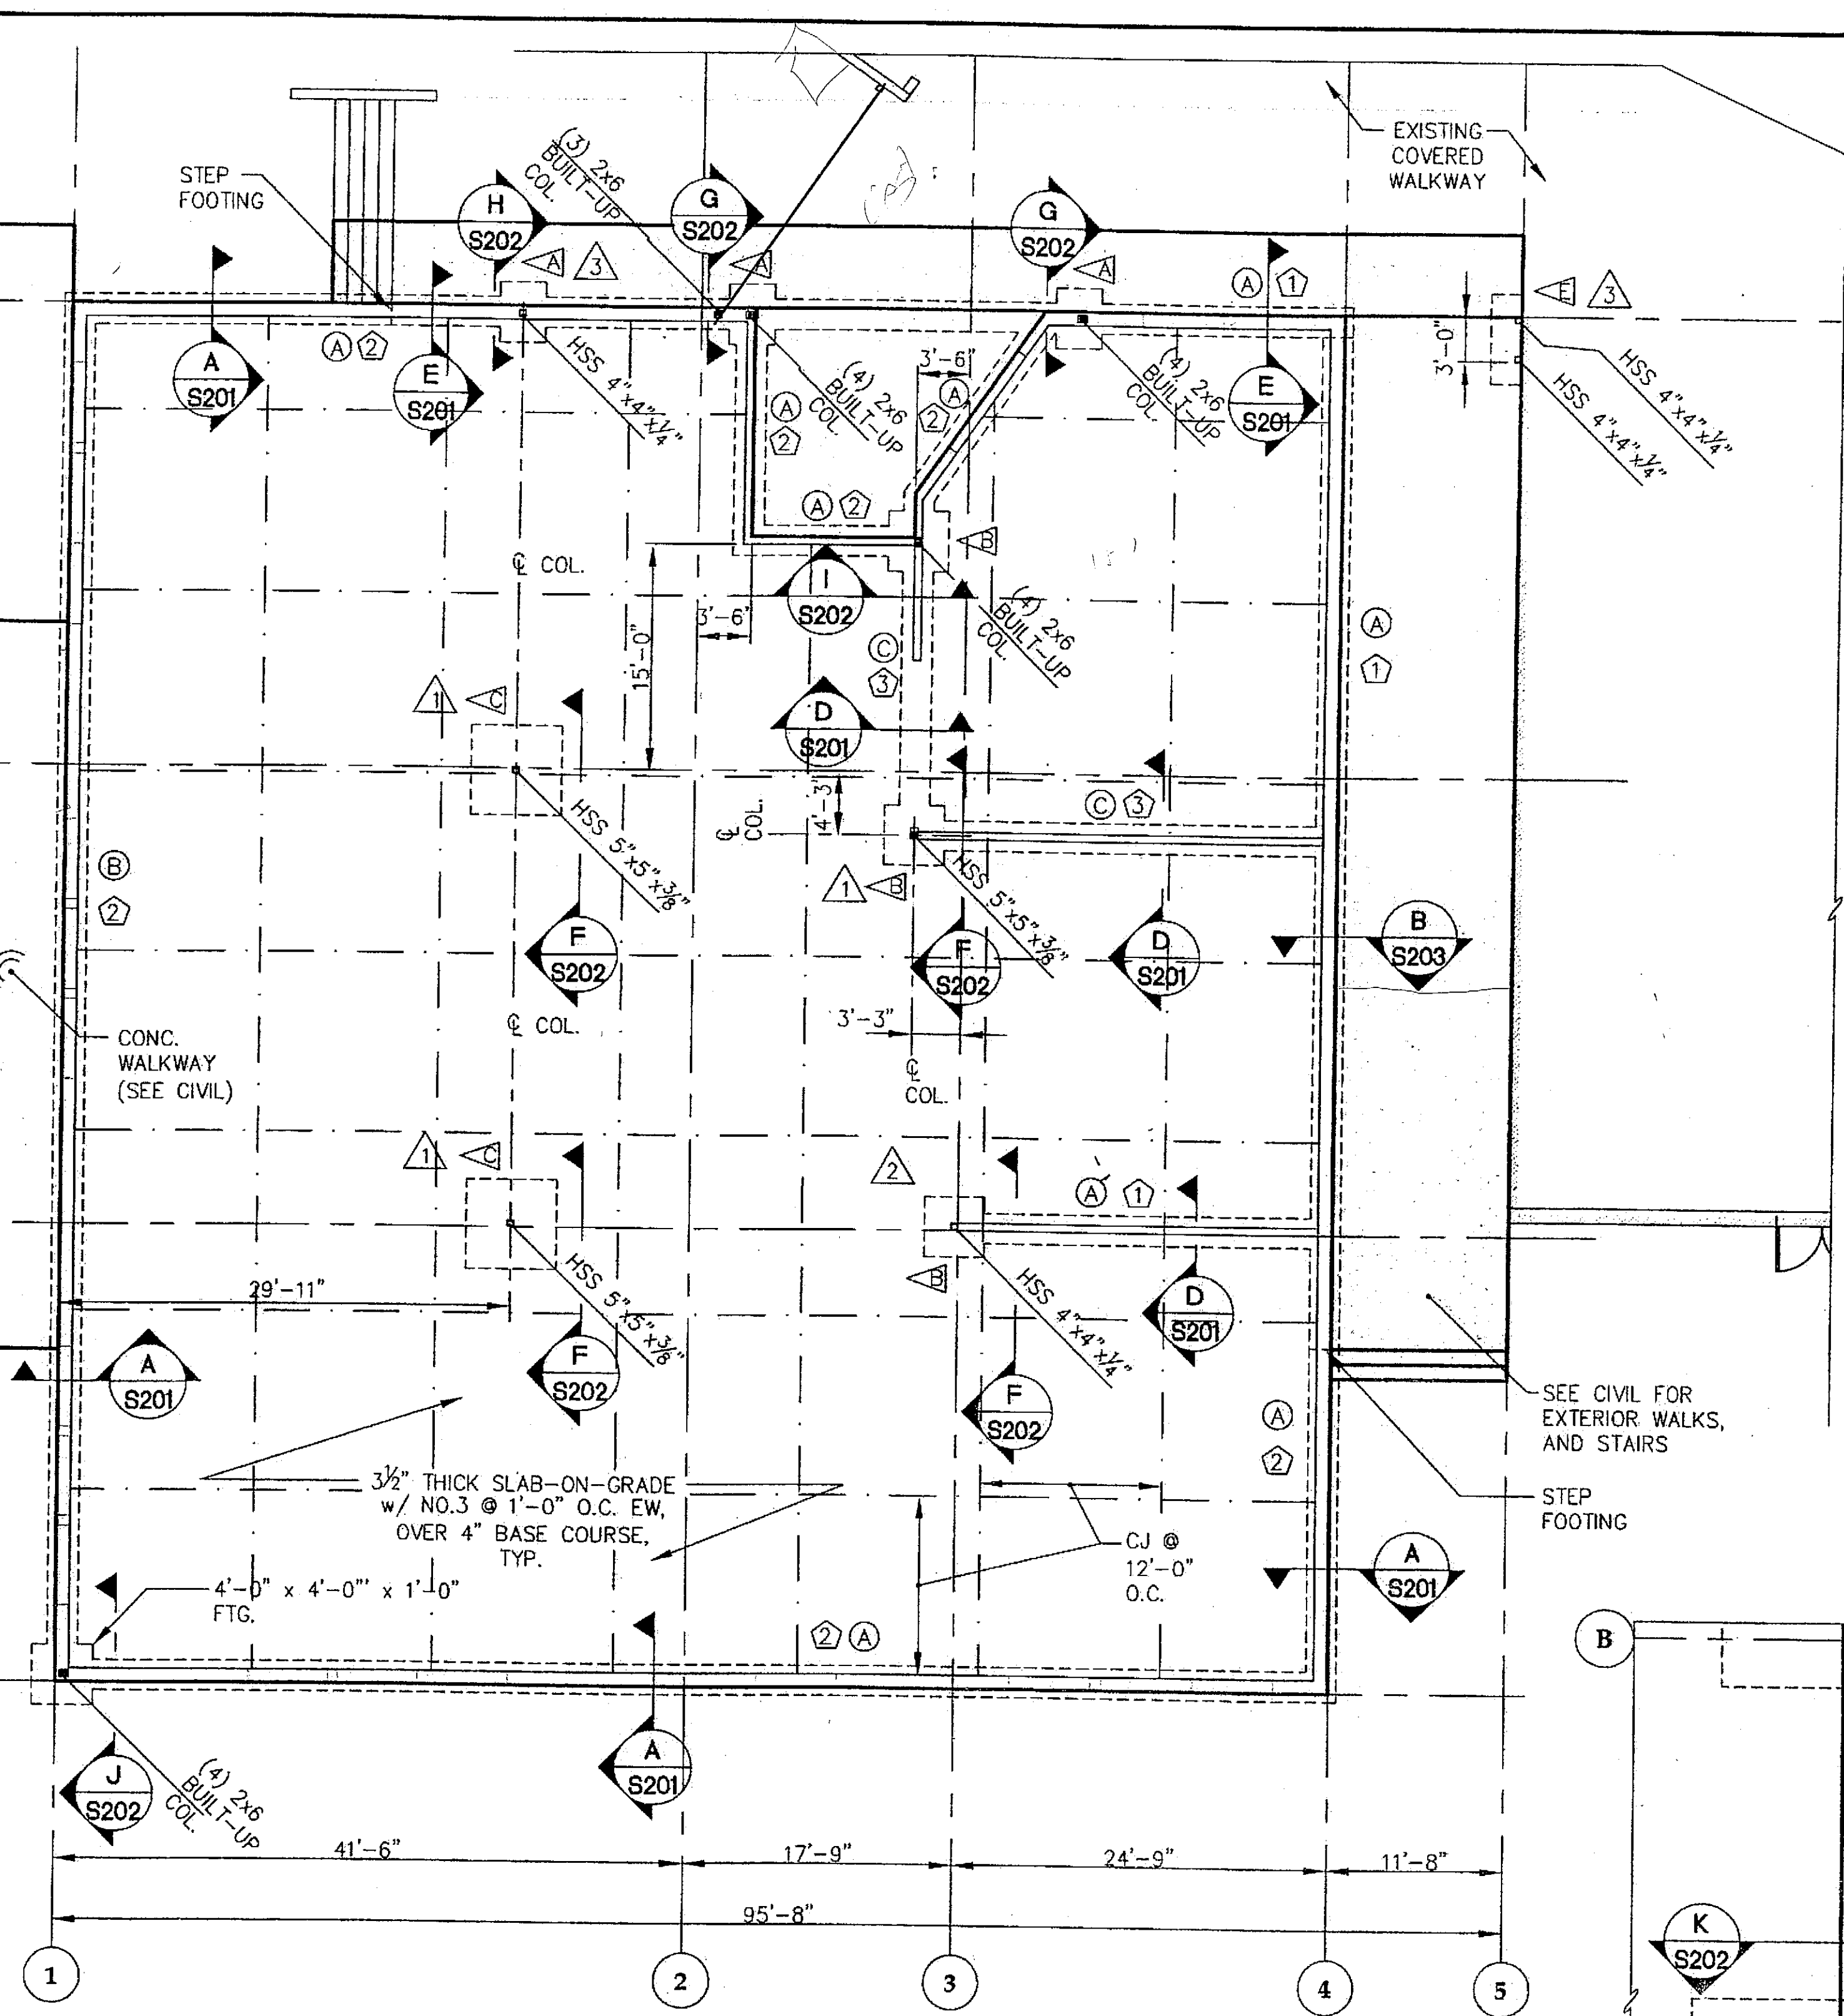

FOUNDATION & FIRST FLOOR FRAMING PLAN
BASE BID

- NOTES:
- ① INDICATES STUDWALL TYPE, SEE SCHEDULE.
 - ▲ INDICATES SHEAR WALL TYPE, SEE SCHEDULE.
 - ▲ INDICATES FOOTING TYPE, SEE SCHEDULE.
 - DIMENSIONS TO FACE OF STUD, UNLESS NOTED OTHERWISE.

CHECKED BY:

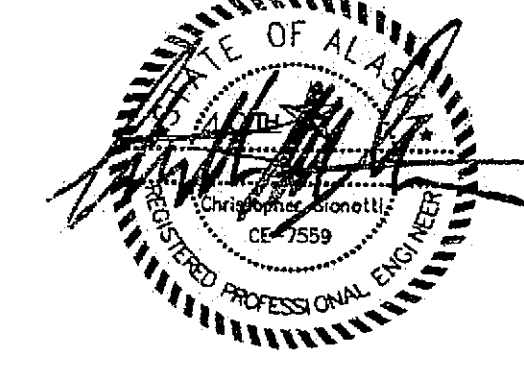

DESIGNED BY: BCN

DRAWN BY: PJD

STATE OF ALASKA
DEPARTMENT OF TRANSPORTATION
& PUBLIC FACILITIES
STATEWIDE DESIGN & ENGINEERING
SERVICES DIVISION

MT EDGE CUMBE
HIGH SCHOOL
BUILDING 1330
ACADEMIC
EXPANSION

SHEET S200

PROJECT DESIGNATION NUMBER

67751C

STATE	YEAR
ALASKA	2004
SHEET NUMBER	TOTAL SHEETS
43	79

Project As-Built Drawings have been
reviewed by the Project Engineer and
represent to the best of my knowledge, the
project as constructed.
Proj. Eng. *[Signature]* Date 7/01


Tue, 14/Dec/04 12:00PM

ADDENDUM NUMBER


ATTACHMENT NUMBER

RECORD OF REVISIONS


No.	DATE	DESCRIPTION

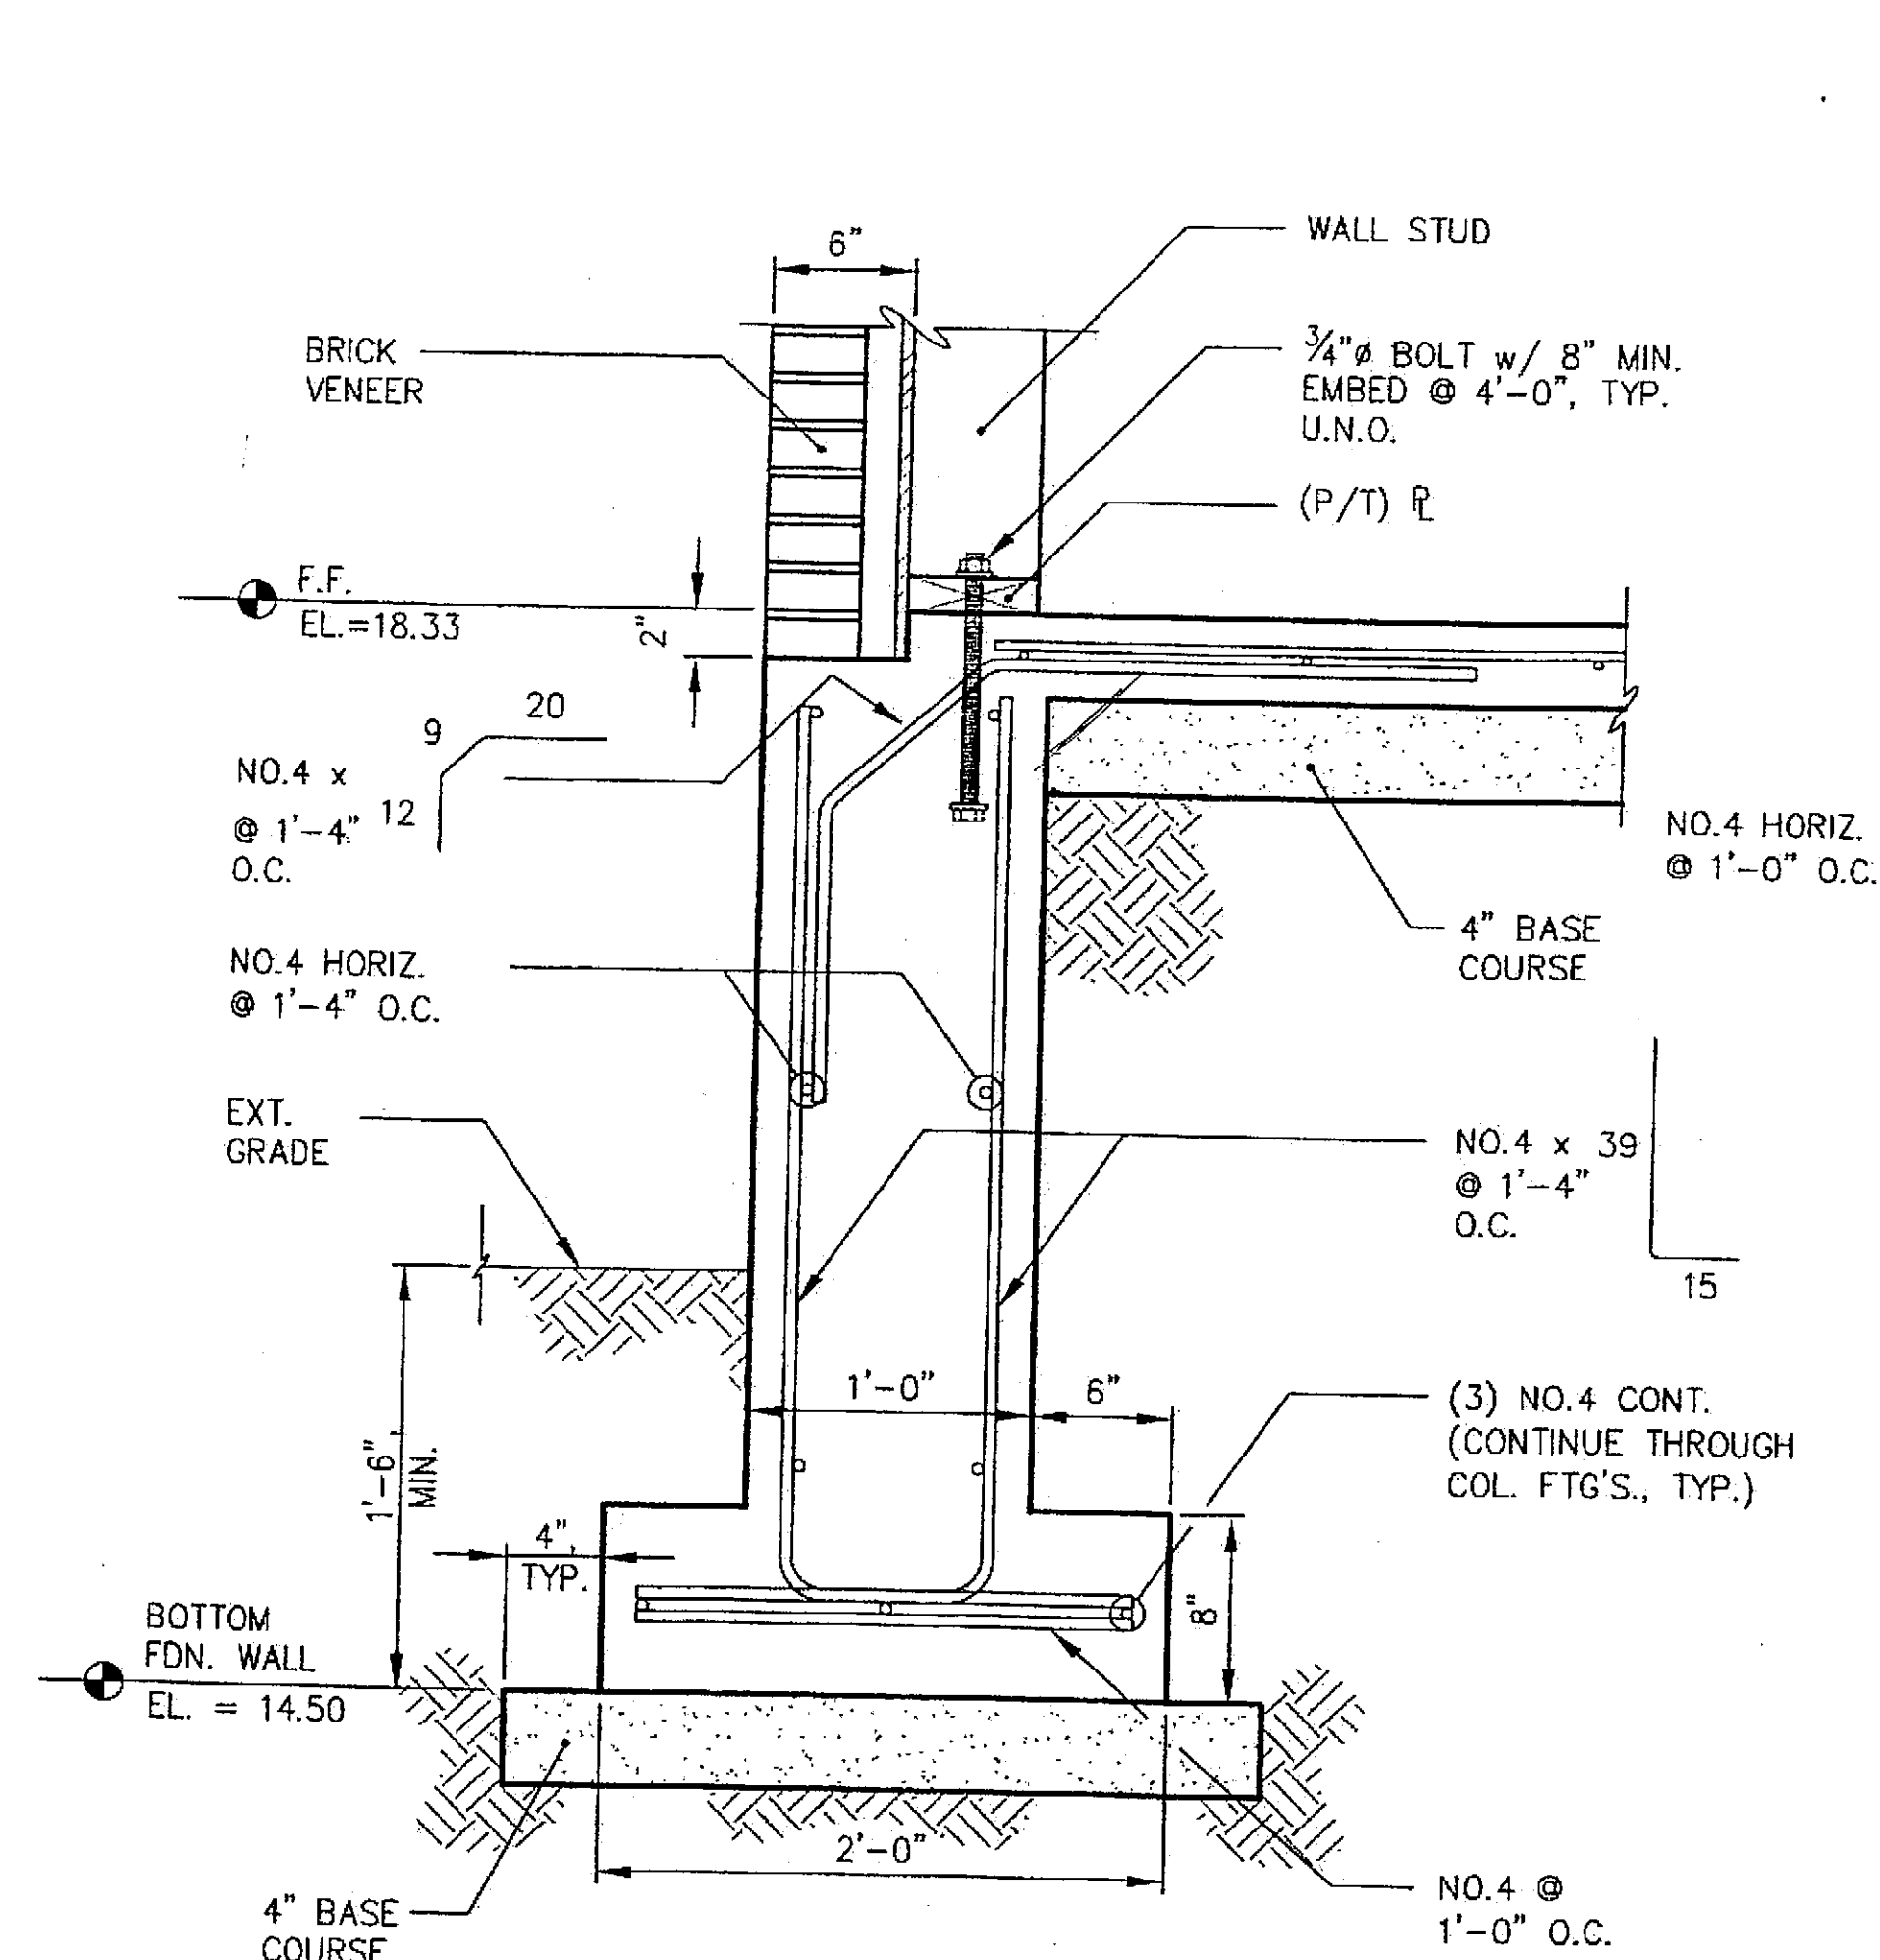


A TYPICAL EXTERIOR FOUNDATION WALL

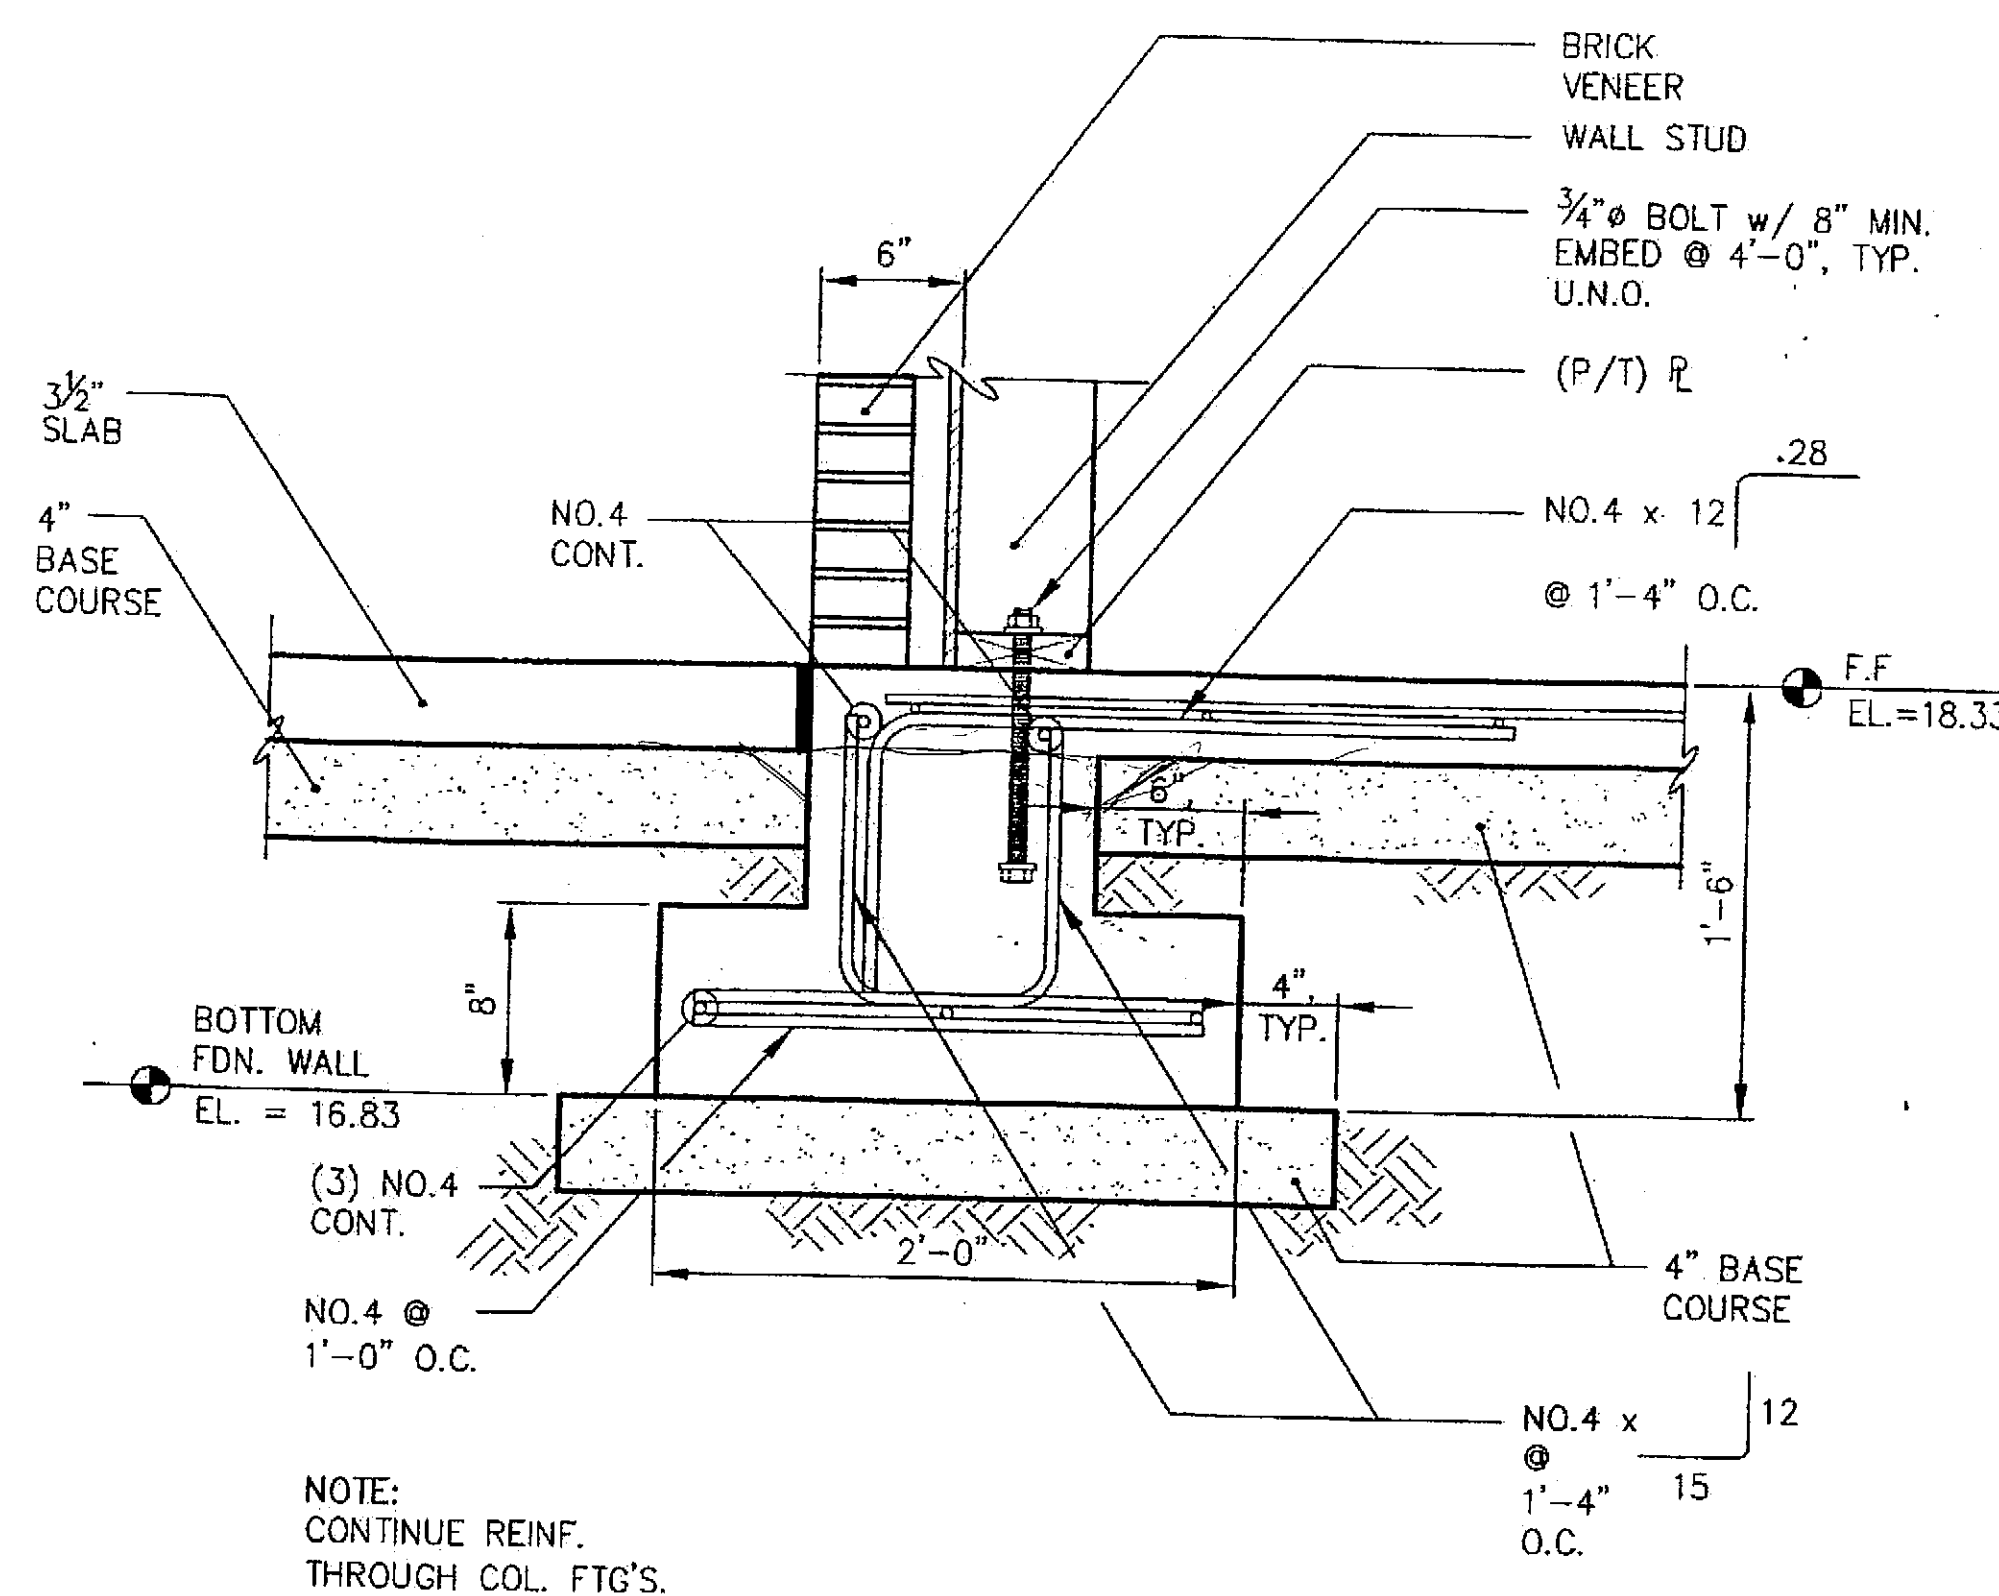


B EXTERIOR FOUNDATION WALL AT ALTERNATE NO. 1

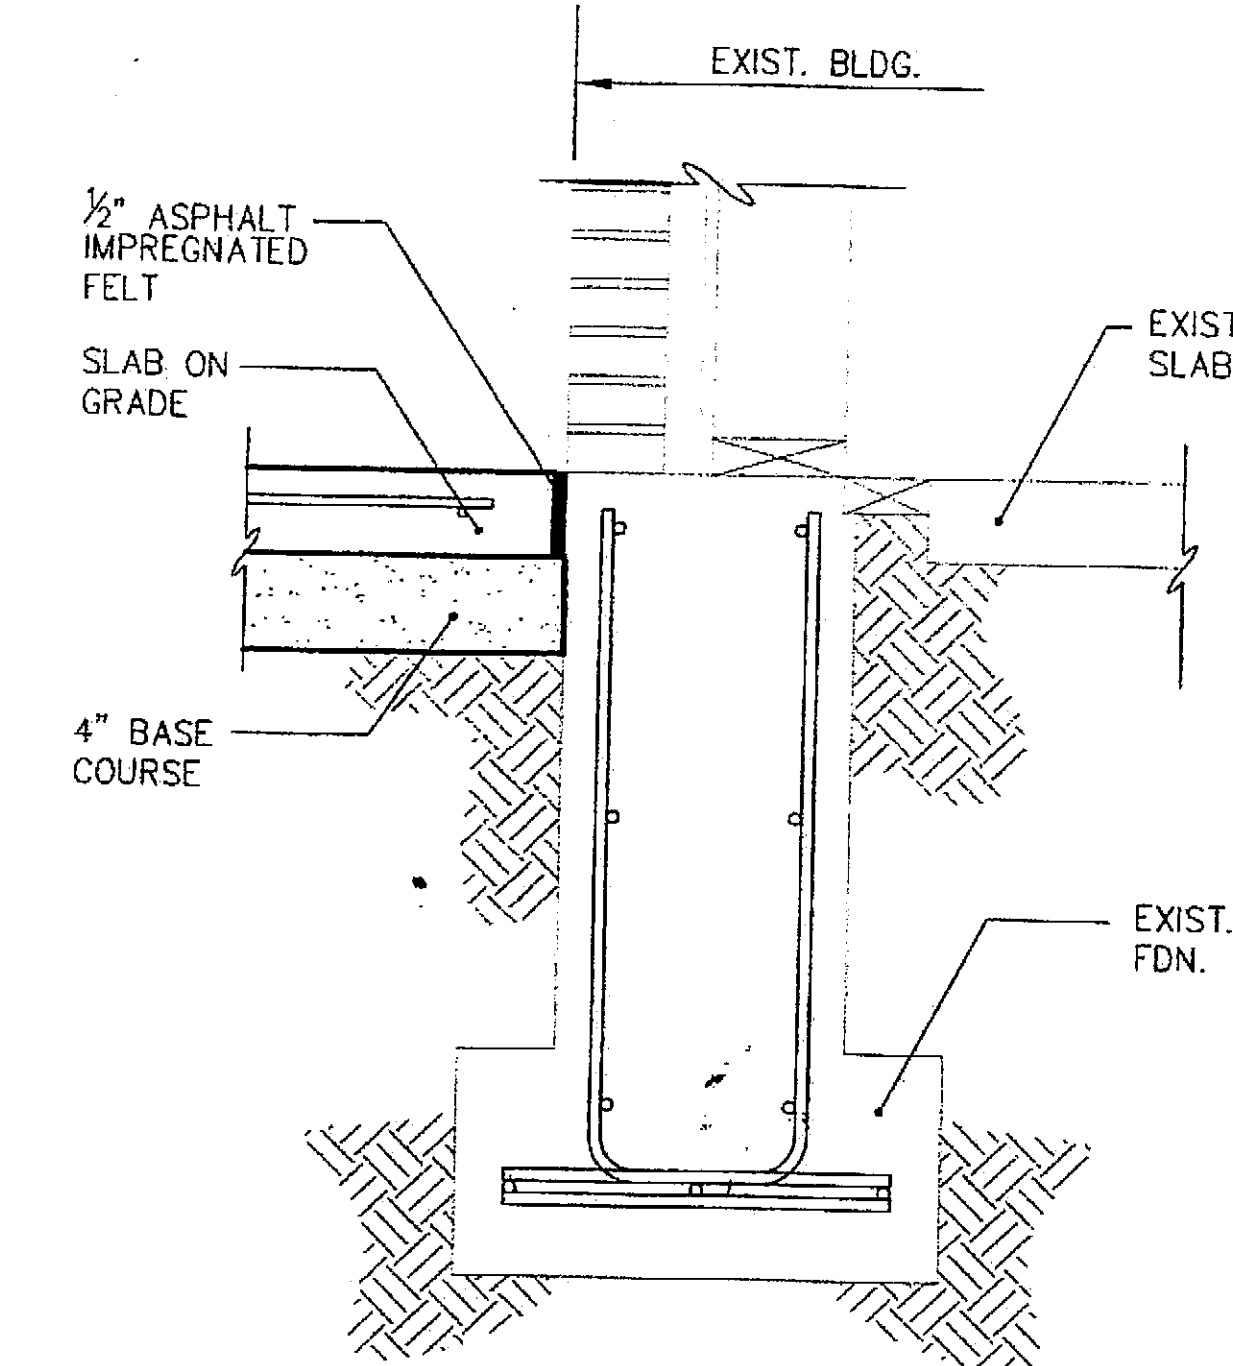

C SLAB AT EXISTING BUILDING

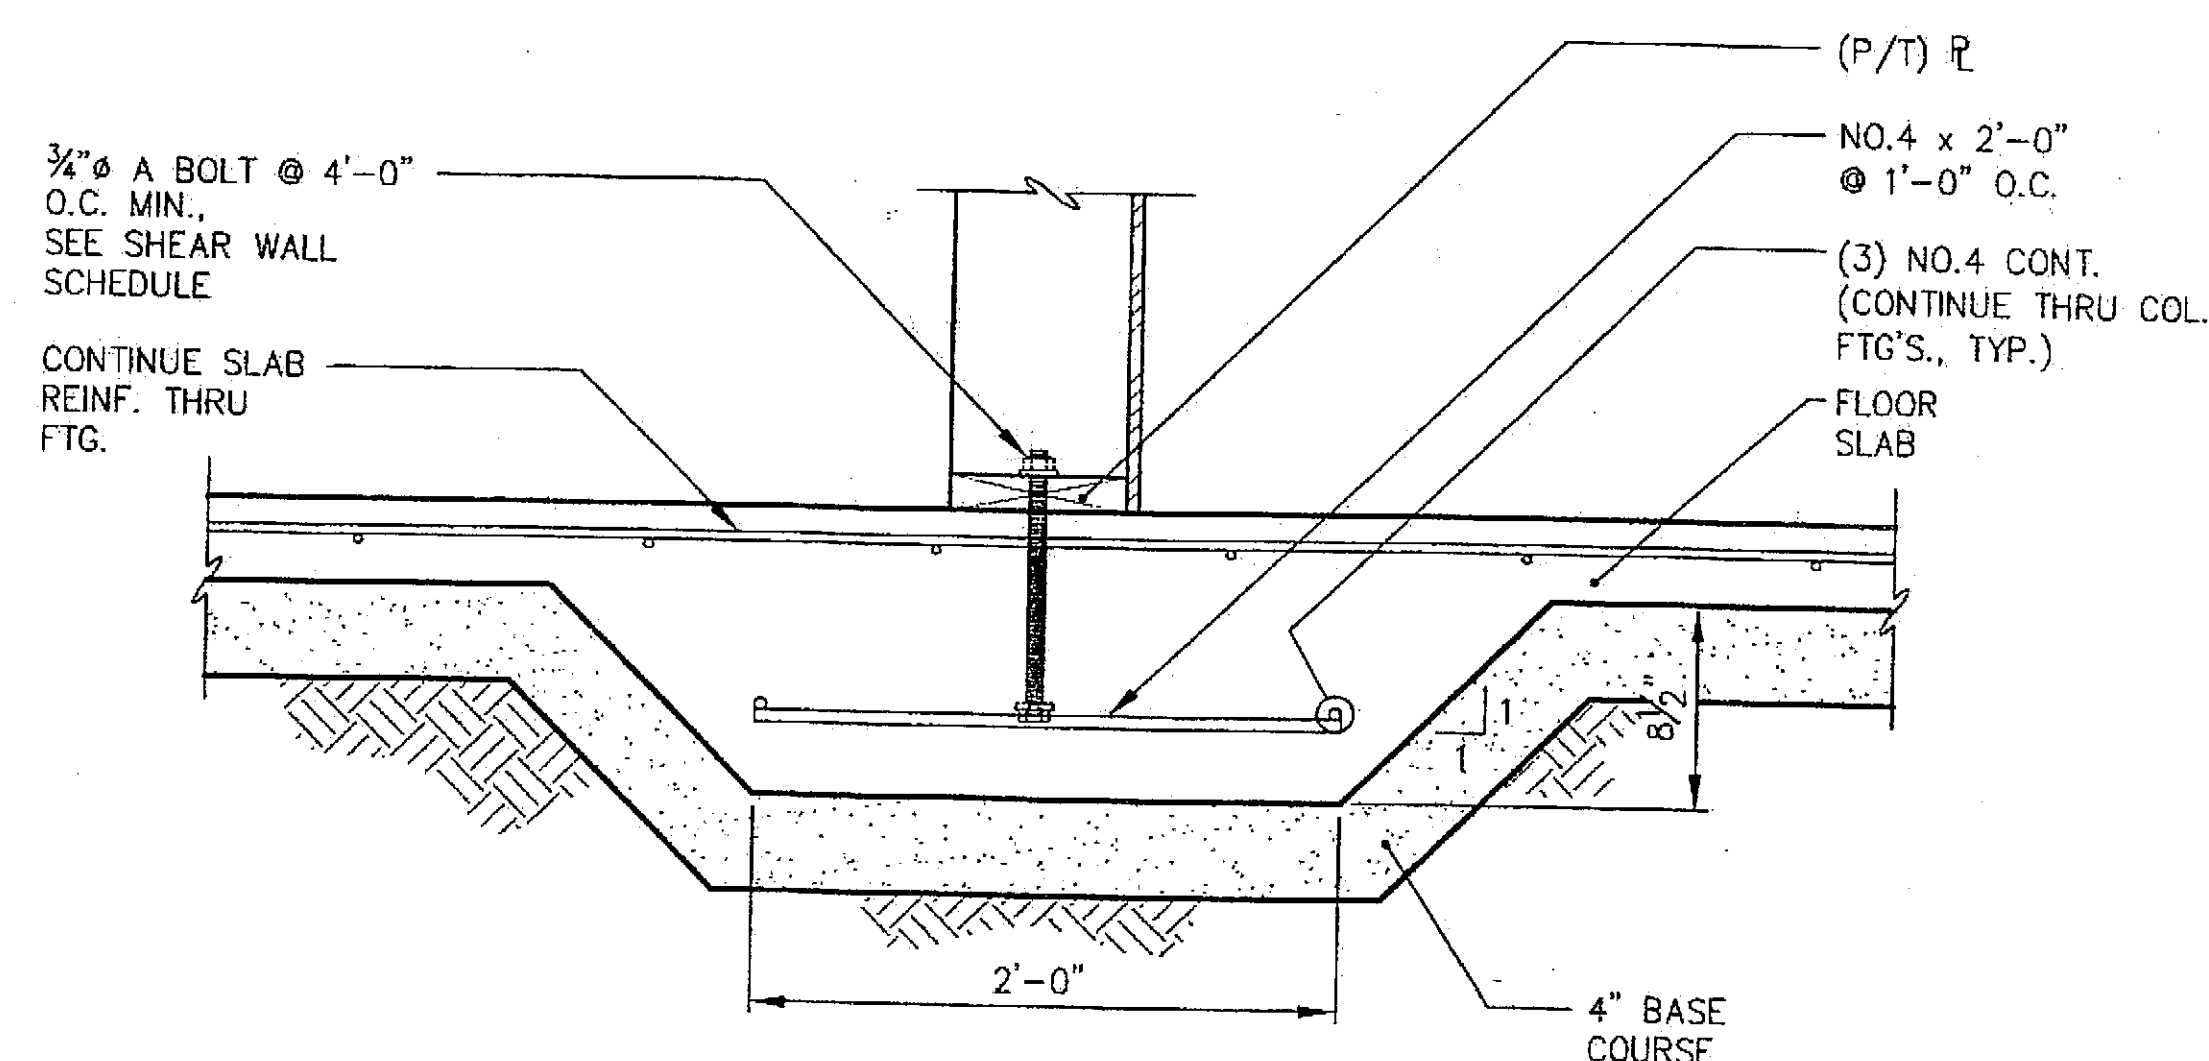


D TYPICAL INTERIOR FOOTING

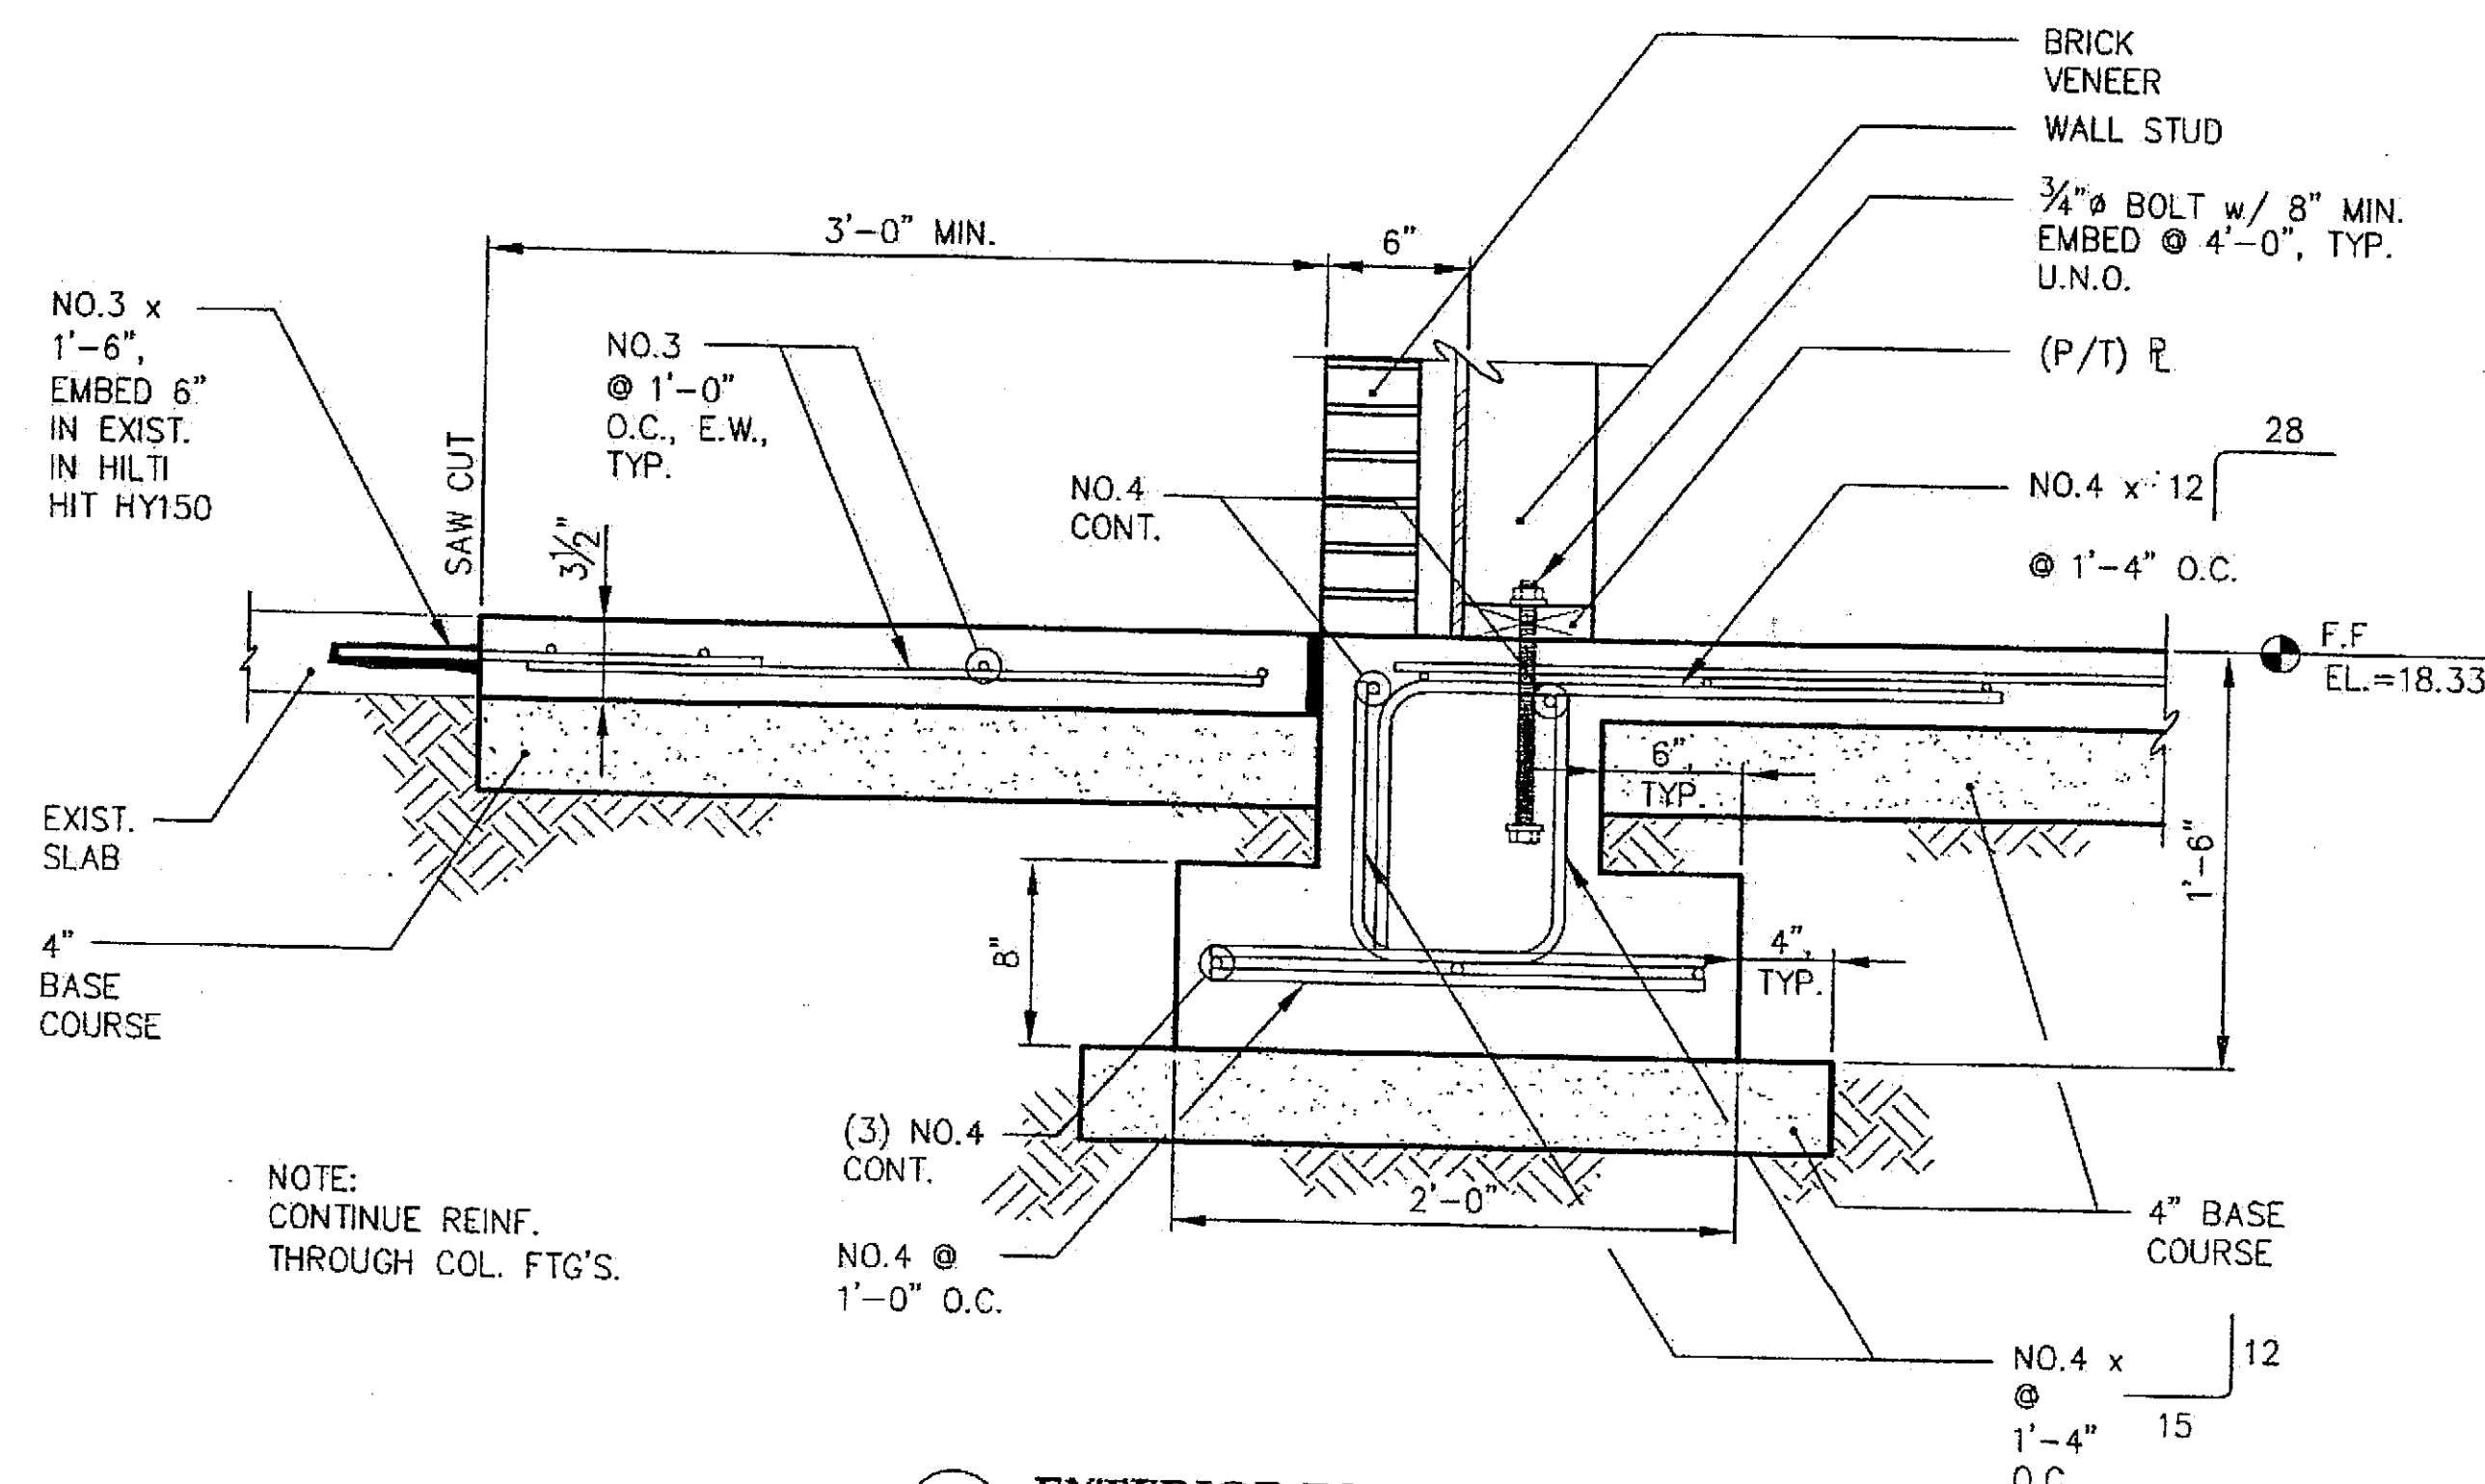

E EXTERIOR FOUNDATION WALL AT EXISTING SIDEWALK

CHECKED BY:

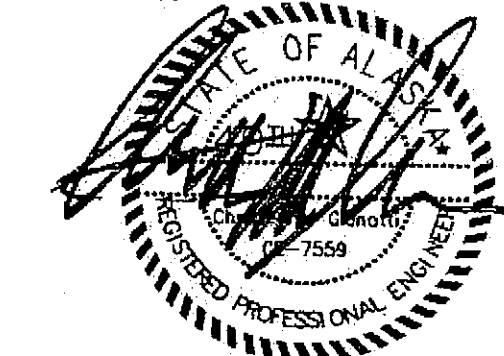

DESIGNED BY: BCN

DRAWN BY: PJD

STATE OF ALASKA
DEPARTMENT OF TRANSPORTATION
& PUBLIC FACILITIES
STATEWIDE DESIGN & ENGINEERING
SERVICES DIVISION

MT EDGE CUMBE
HIGH SCHOOL
BUILDING 1330
ACADEMIC
EXPANSION






SHEET S201

PROJECT DESIGNATION NUMBER

67751C

STATE	YEAR
ALASKA	2004
SHEET NUMBER	TOTAL SHEETS
44	79

Project As-Built Drawings have been reviewed by the Project Engineer and represent to the best of my knowledge, the project as constructed.
Proj. Eng. *[Signature]* Date 7-07

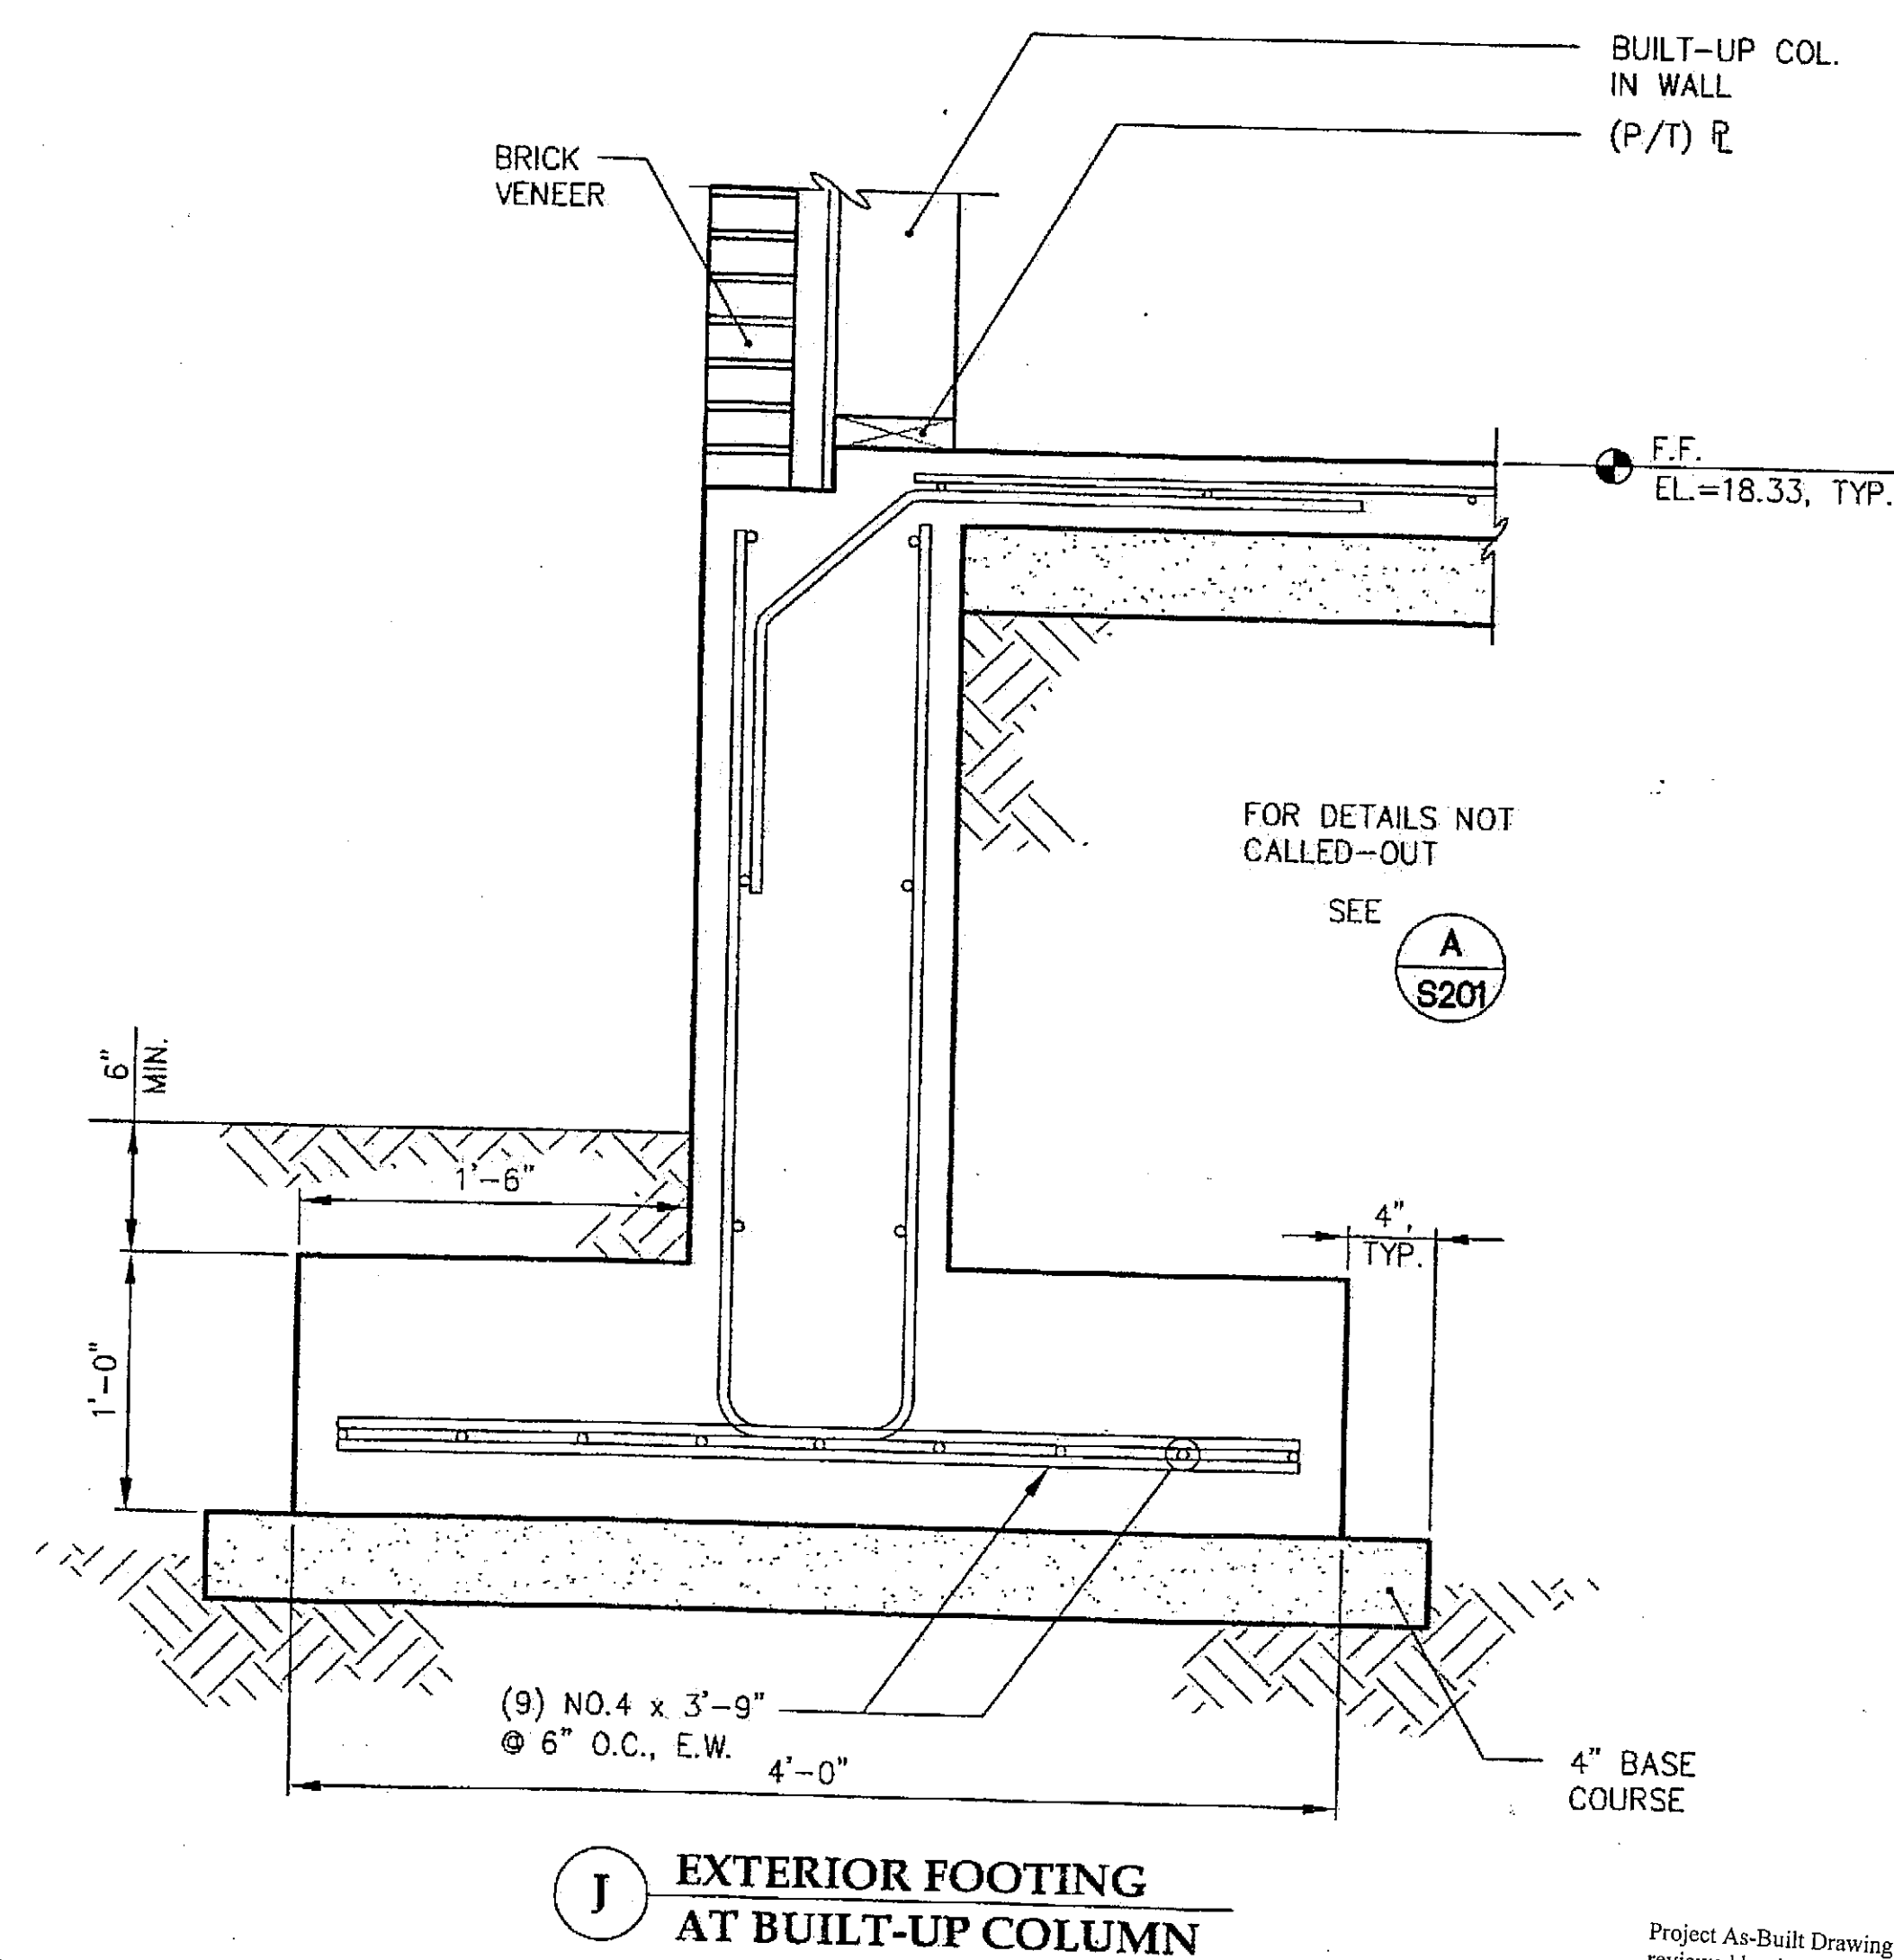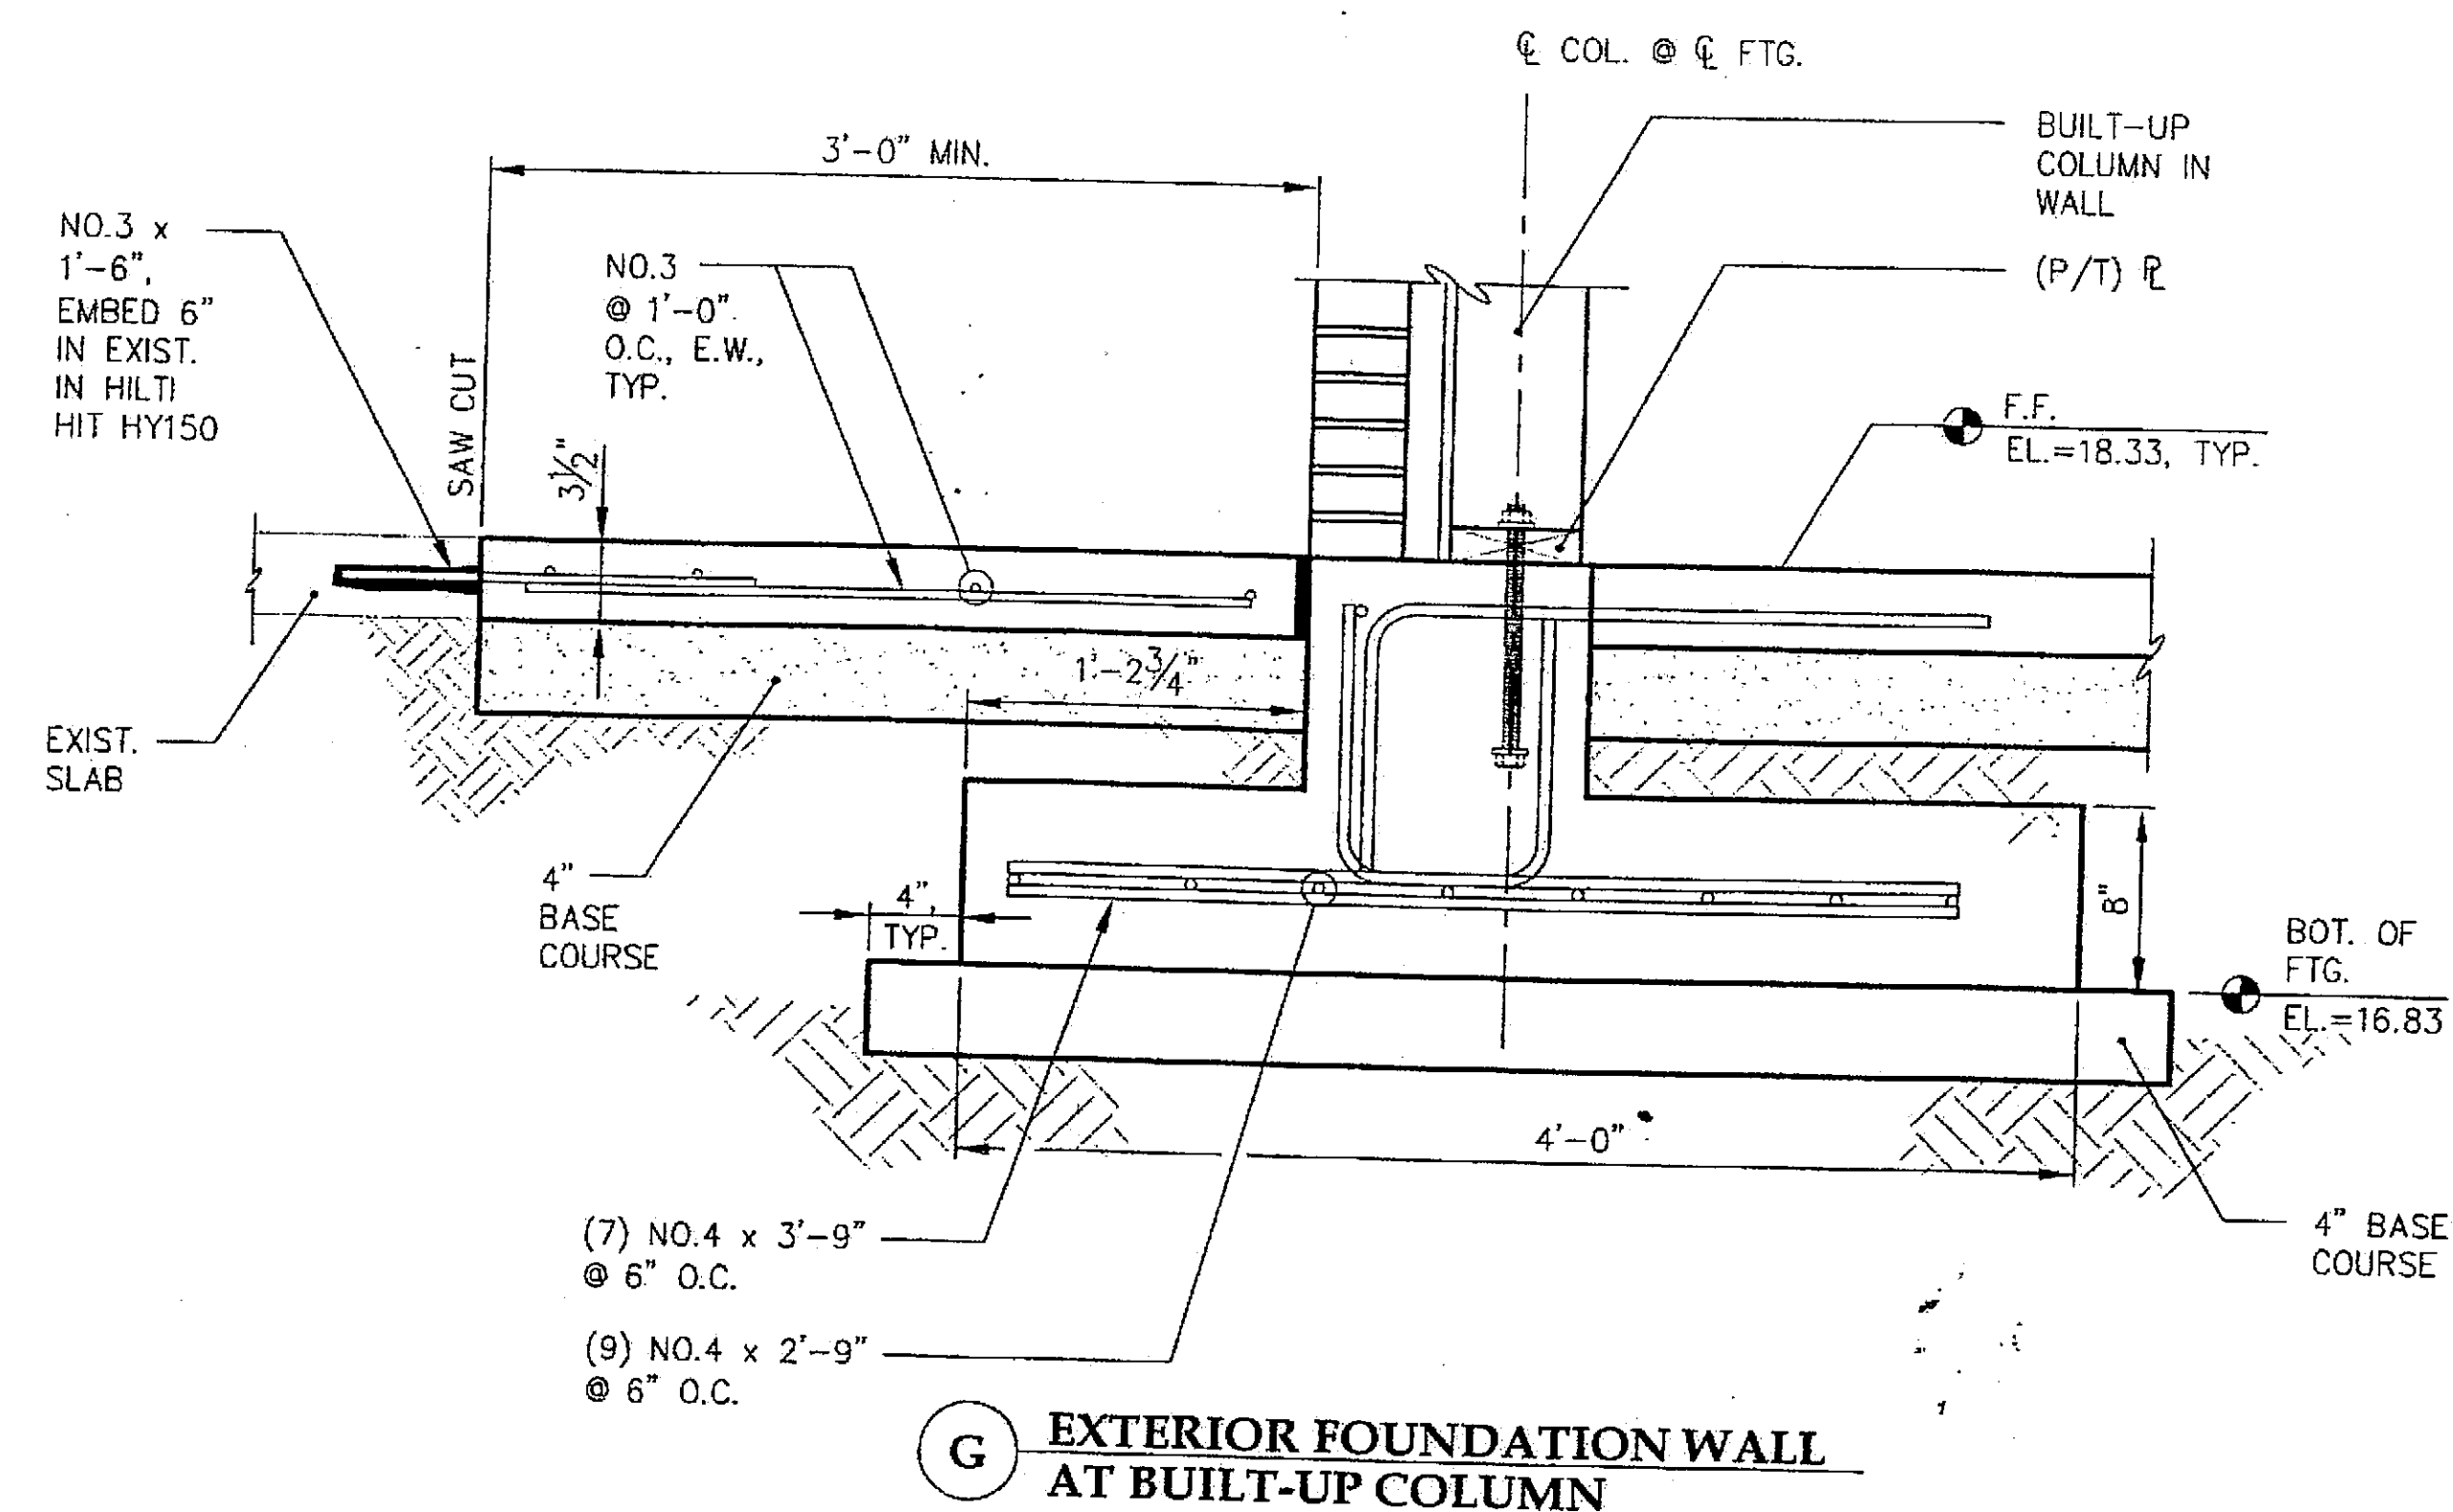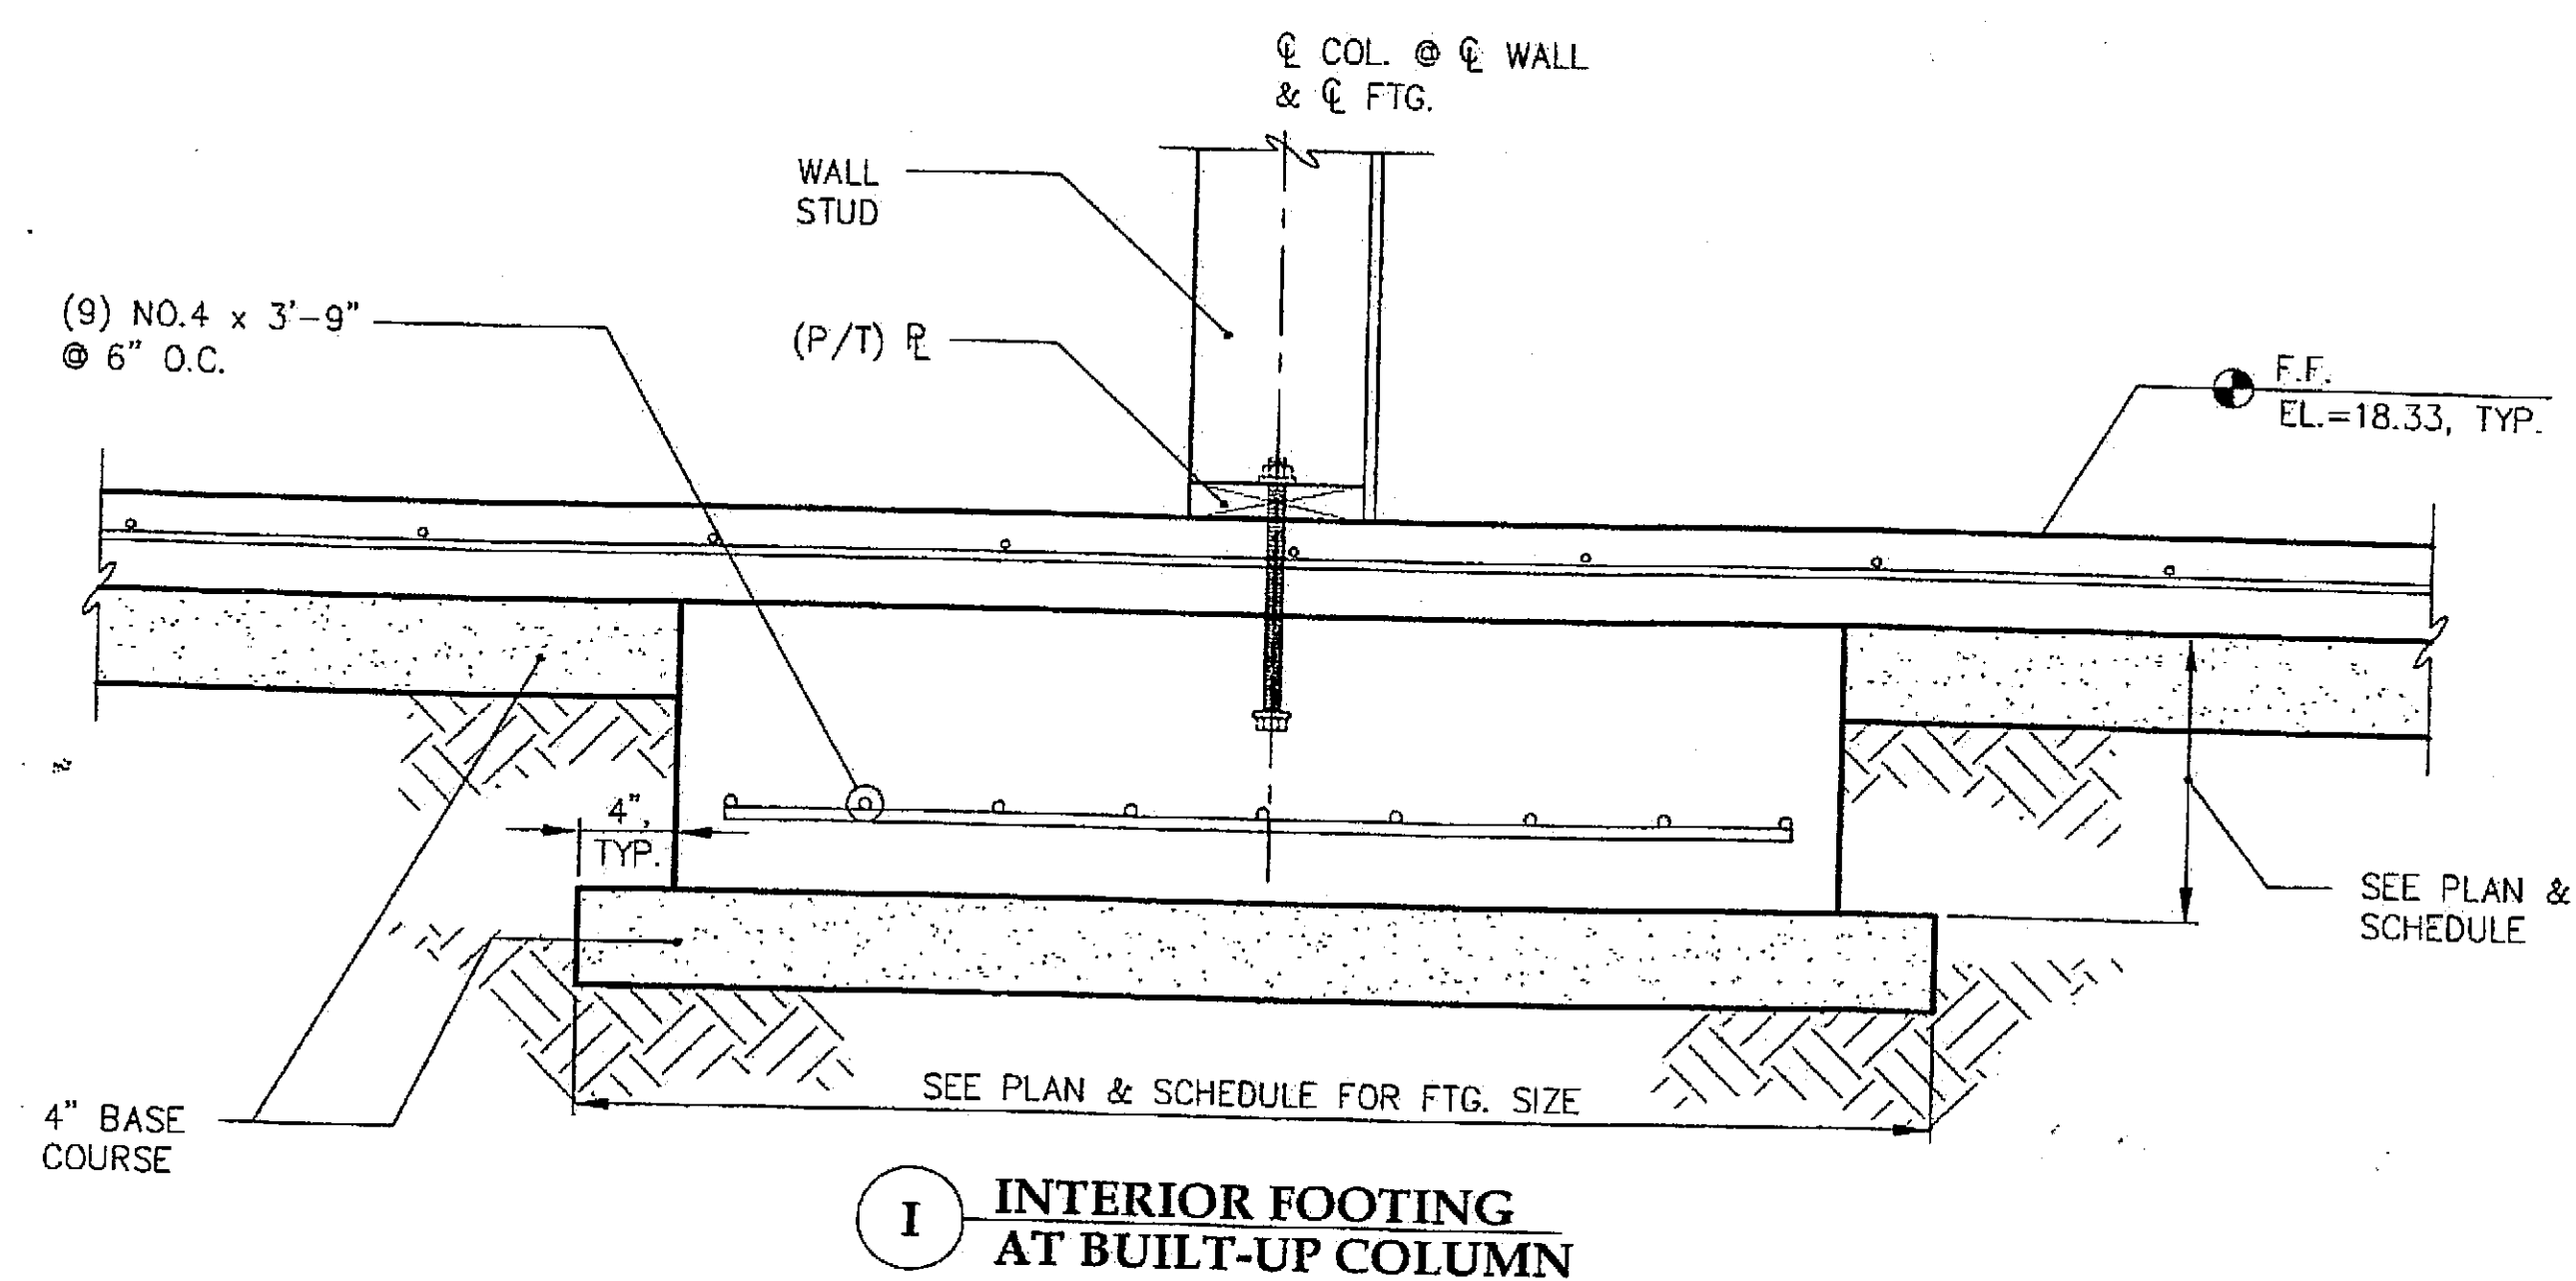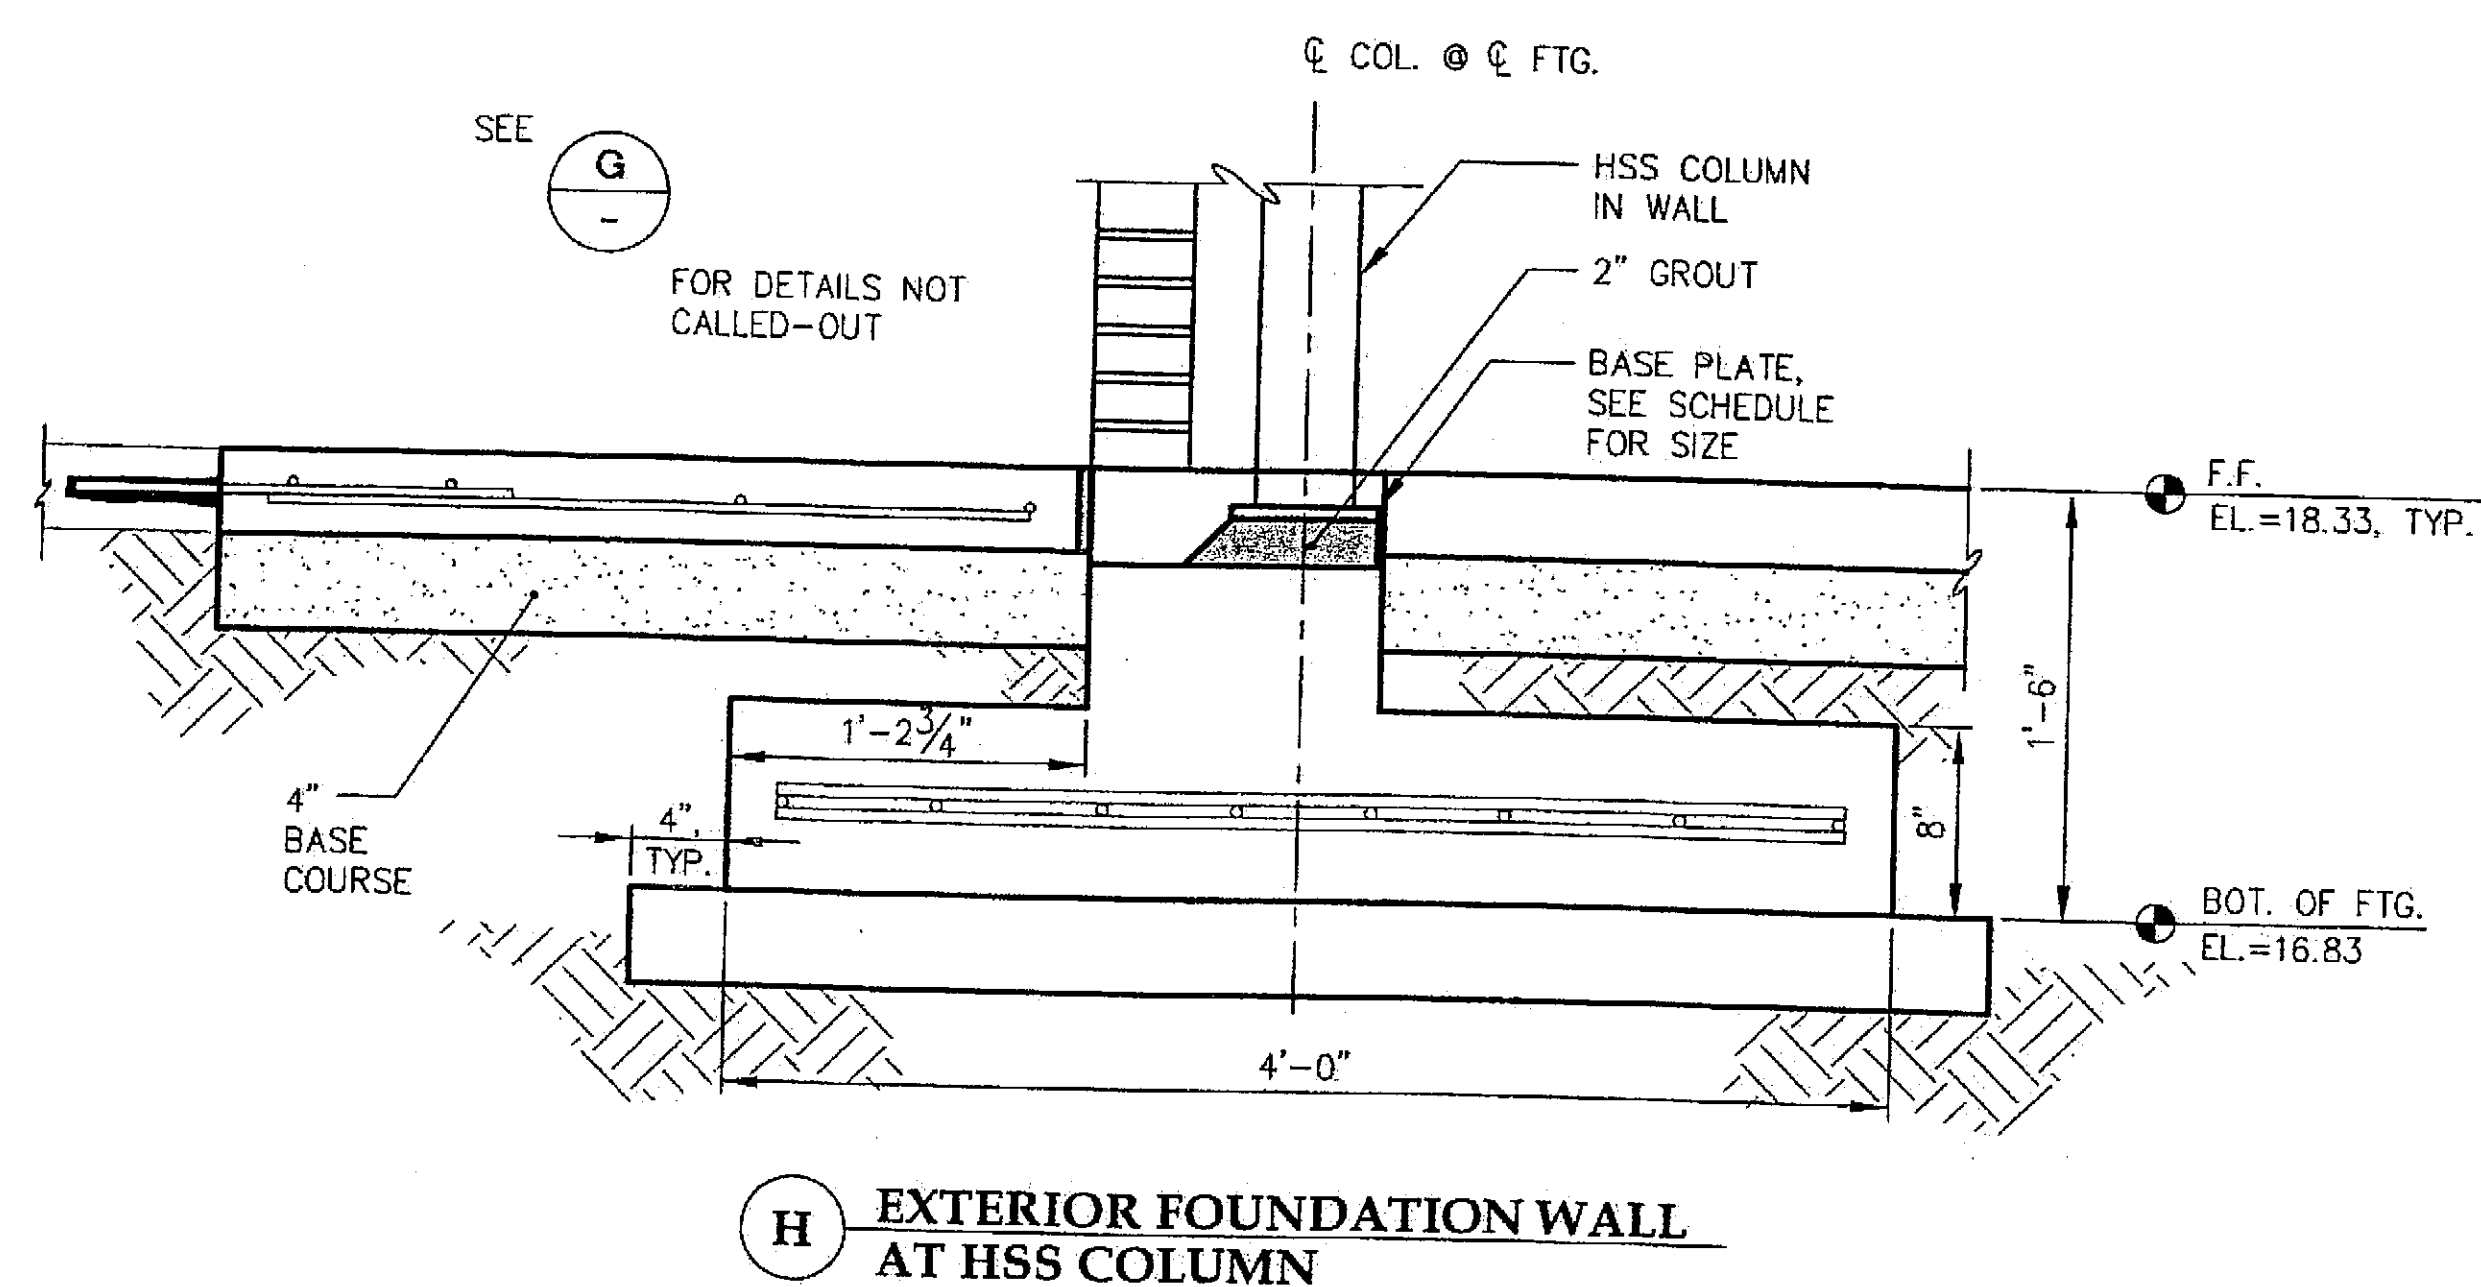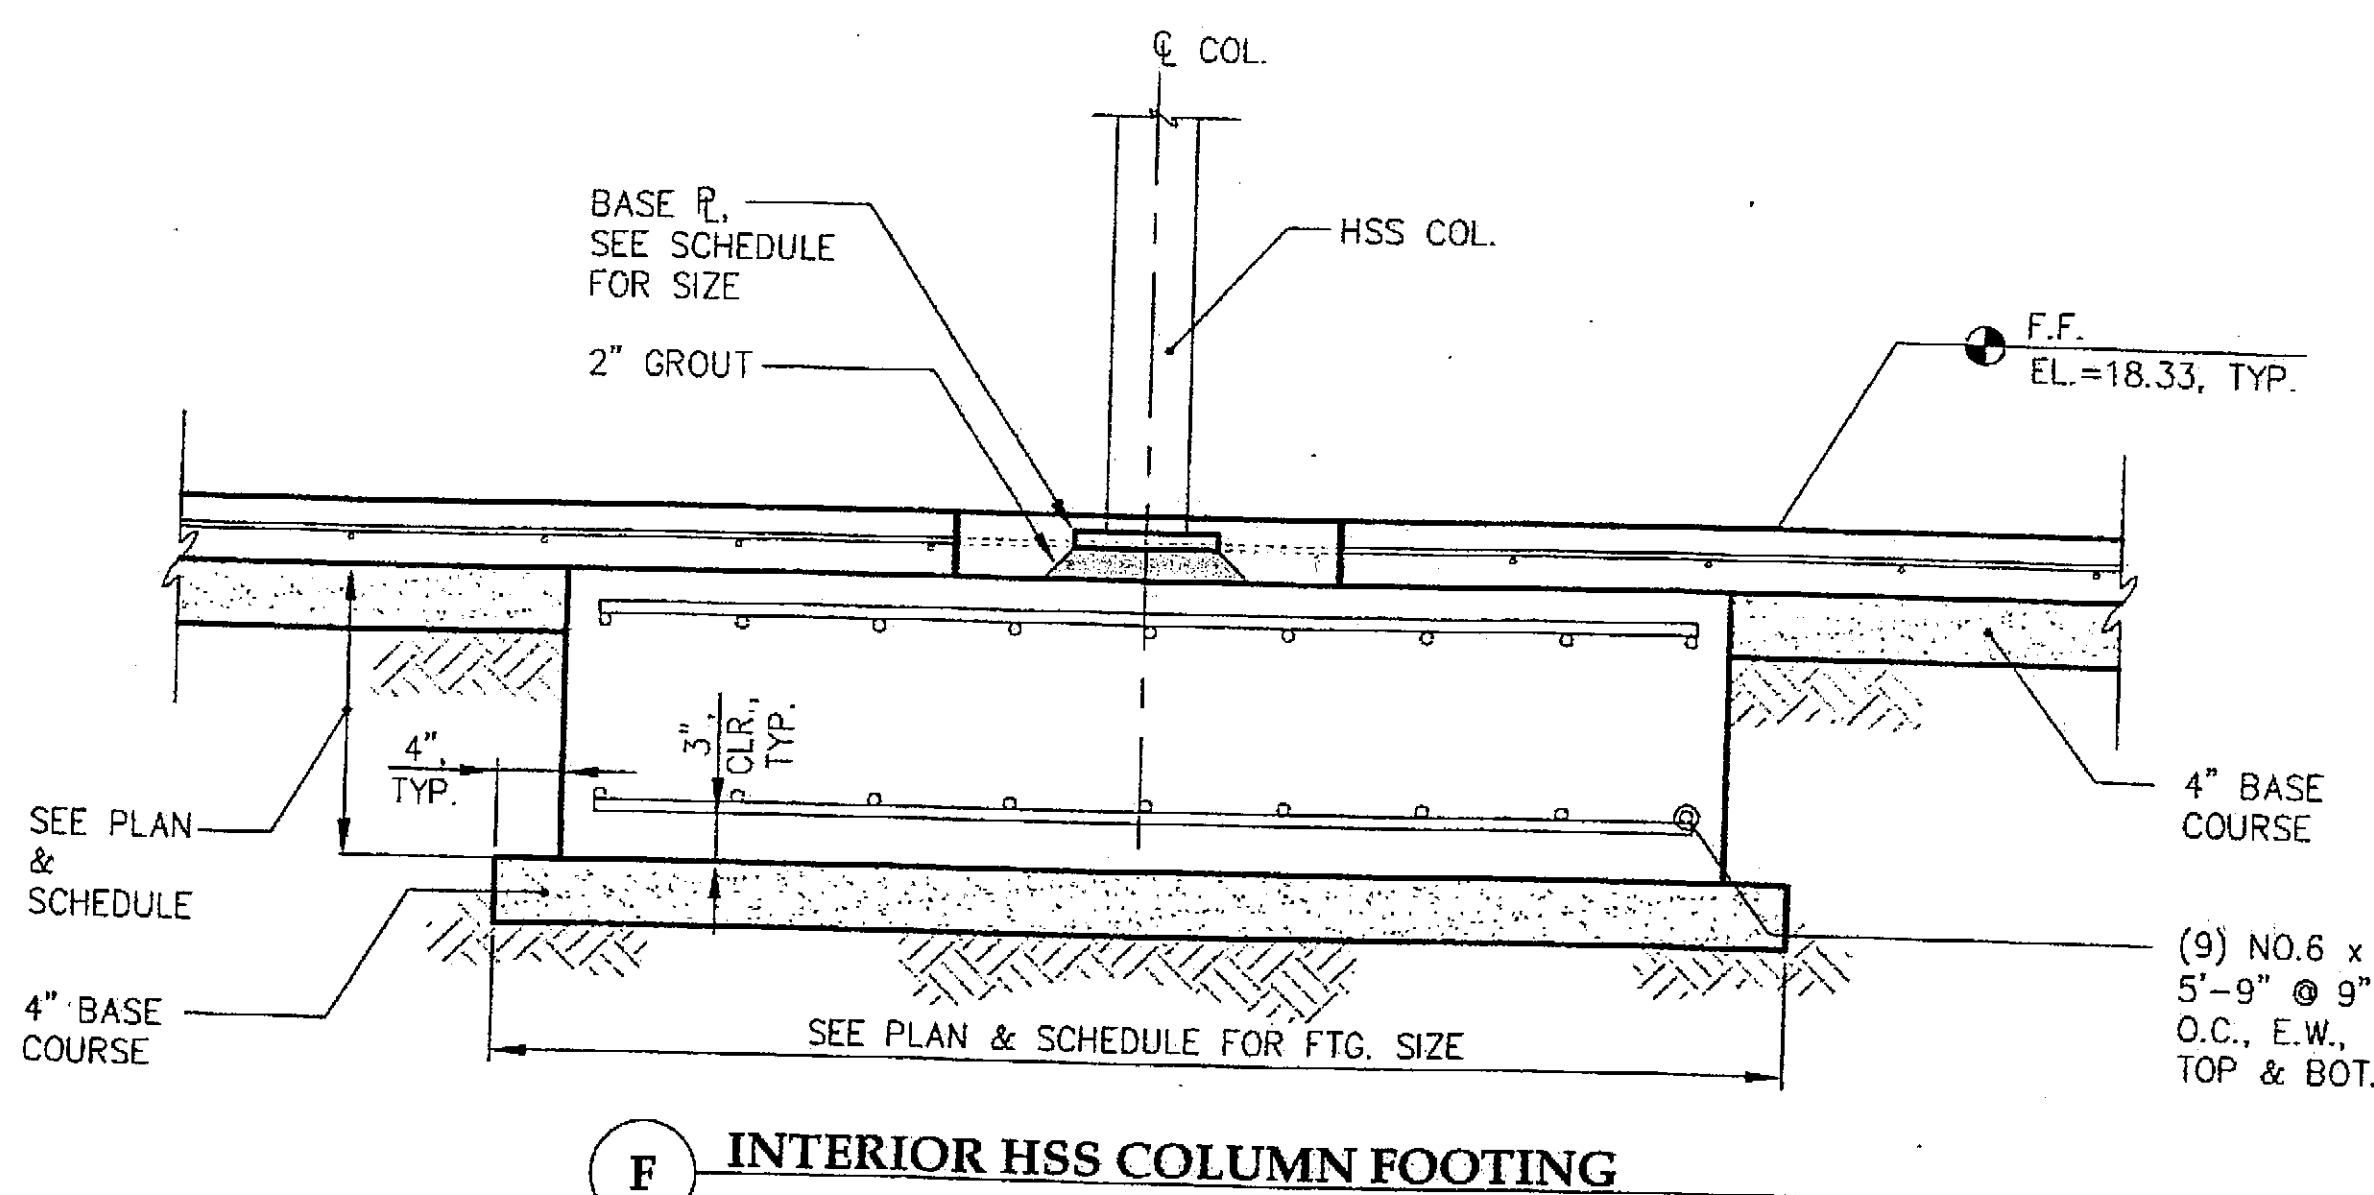

Project As-Built Drawings have been reviewed by the Project Engineer and represent to the best of my knowledge, the project as constructed.

Proj. Eng. *Dr. H. H. H.* Date *7/07*

Tue, 14/Dec/04 12:00PM


ADDENDUM NUMBER

ATTACHMENT NUMBER

RECORD OF REVISIONS

No.	DATE	DESCRIPTION

CHECKED BY:

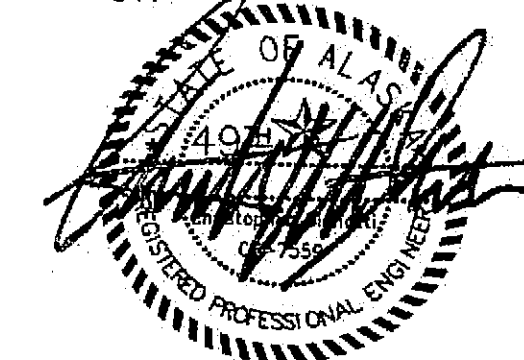

DESIGNED BY: BCN

DRAWN BY: PJD

STATE OF ALASKA
DEPARTMENT OF TRANSPORTATION
& PUBLIC FACILITIES
STATEWIDE DESIGN & ENGINEERING
SERVICES DIVISION


MT EDGECUMBE
HIGH SCHOOL
BUILDING 1330
ACADEMIC
EXPANSION

SHEET S202


PROJECT DESIGNATION NUMBER

67751C


STATE	YEAR
ALASKA	2004
SHEET NUMBER	TOTAL SHEETS
45	79

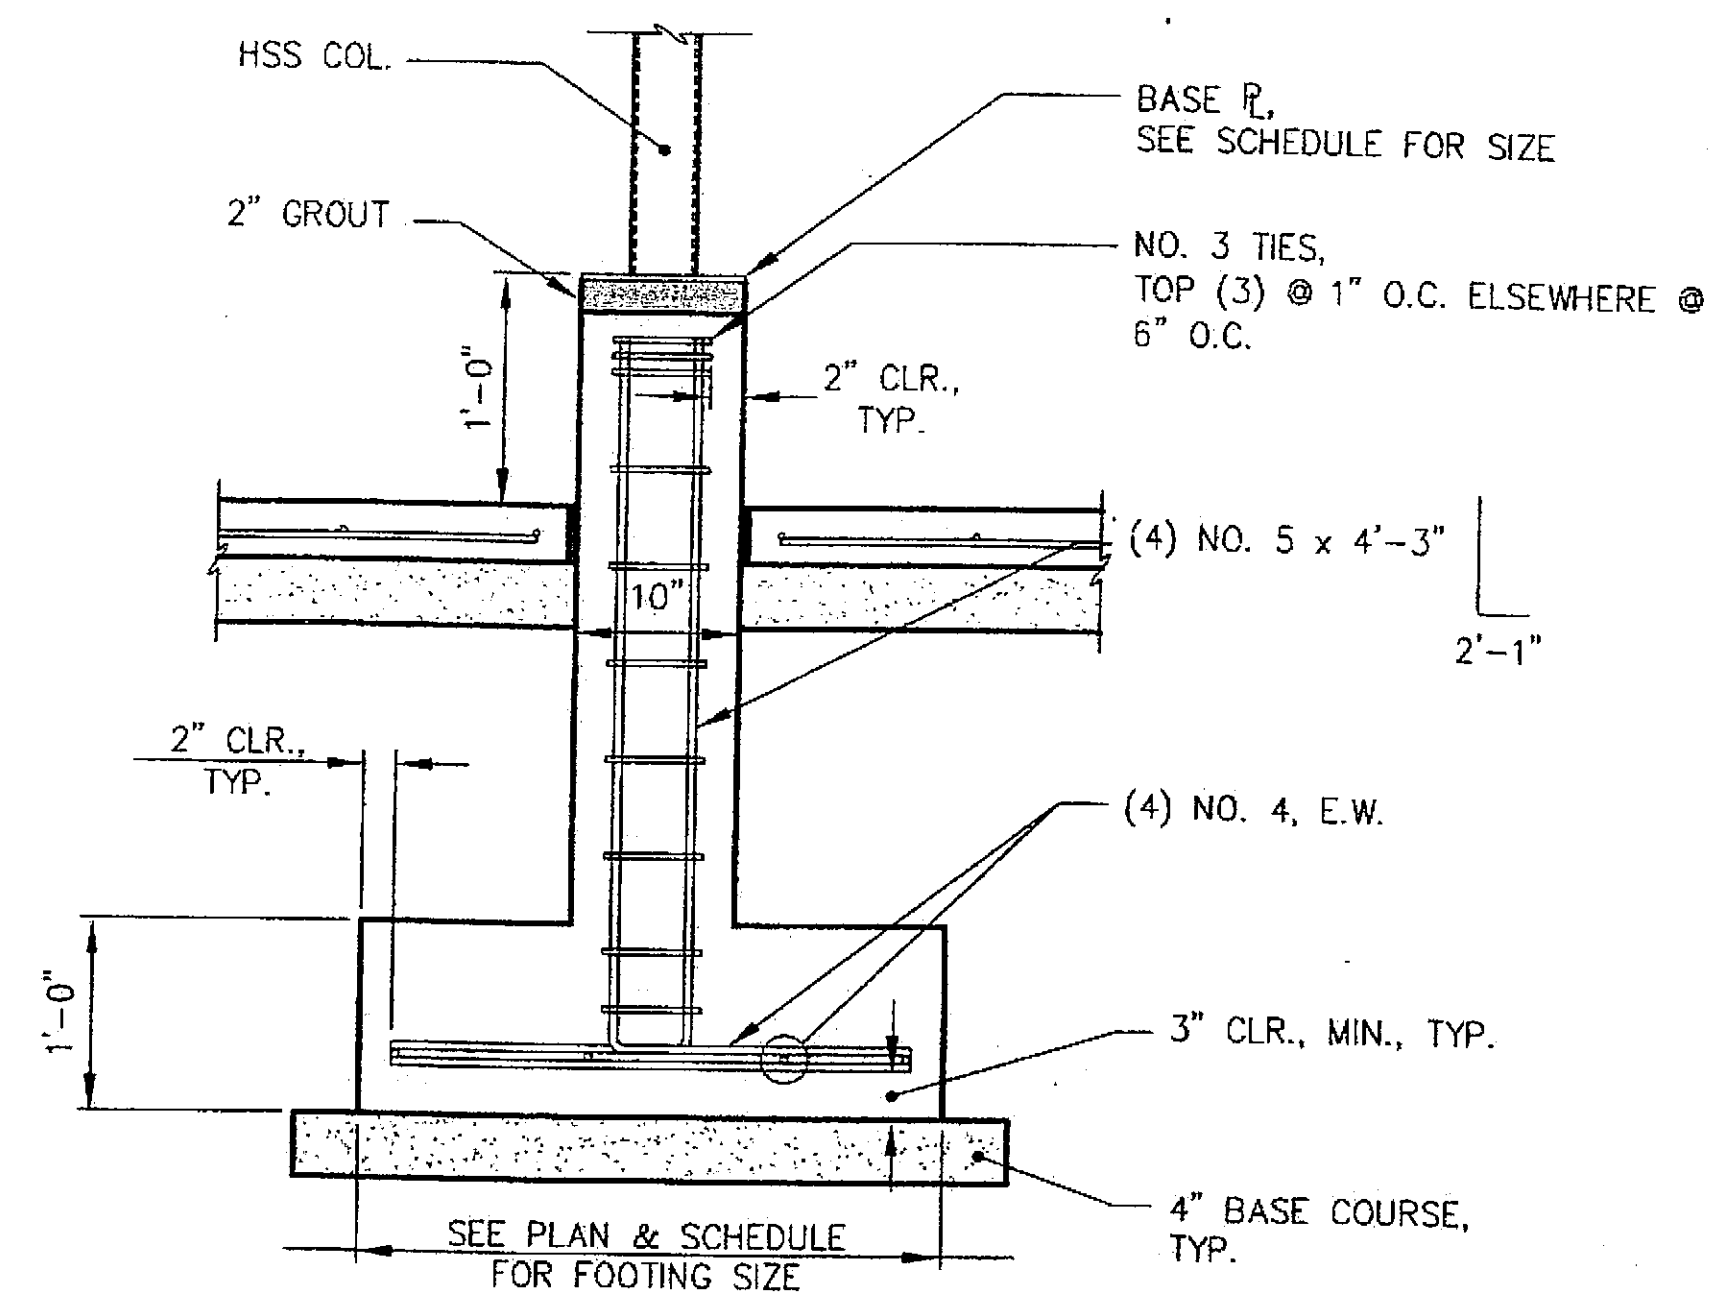

A PILASTER DETAIL

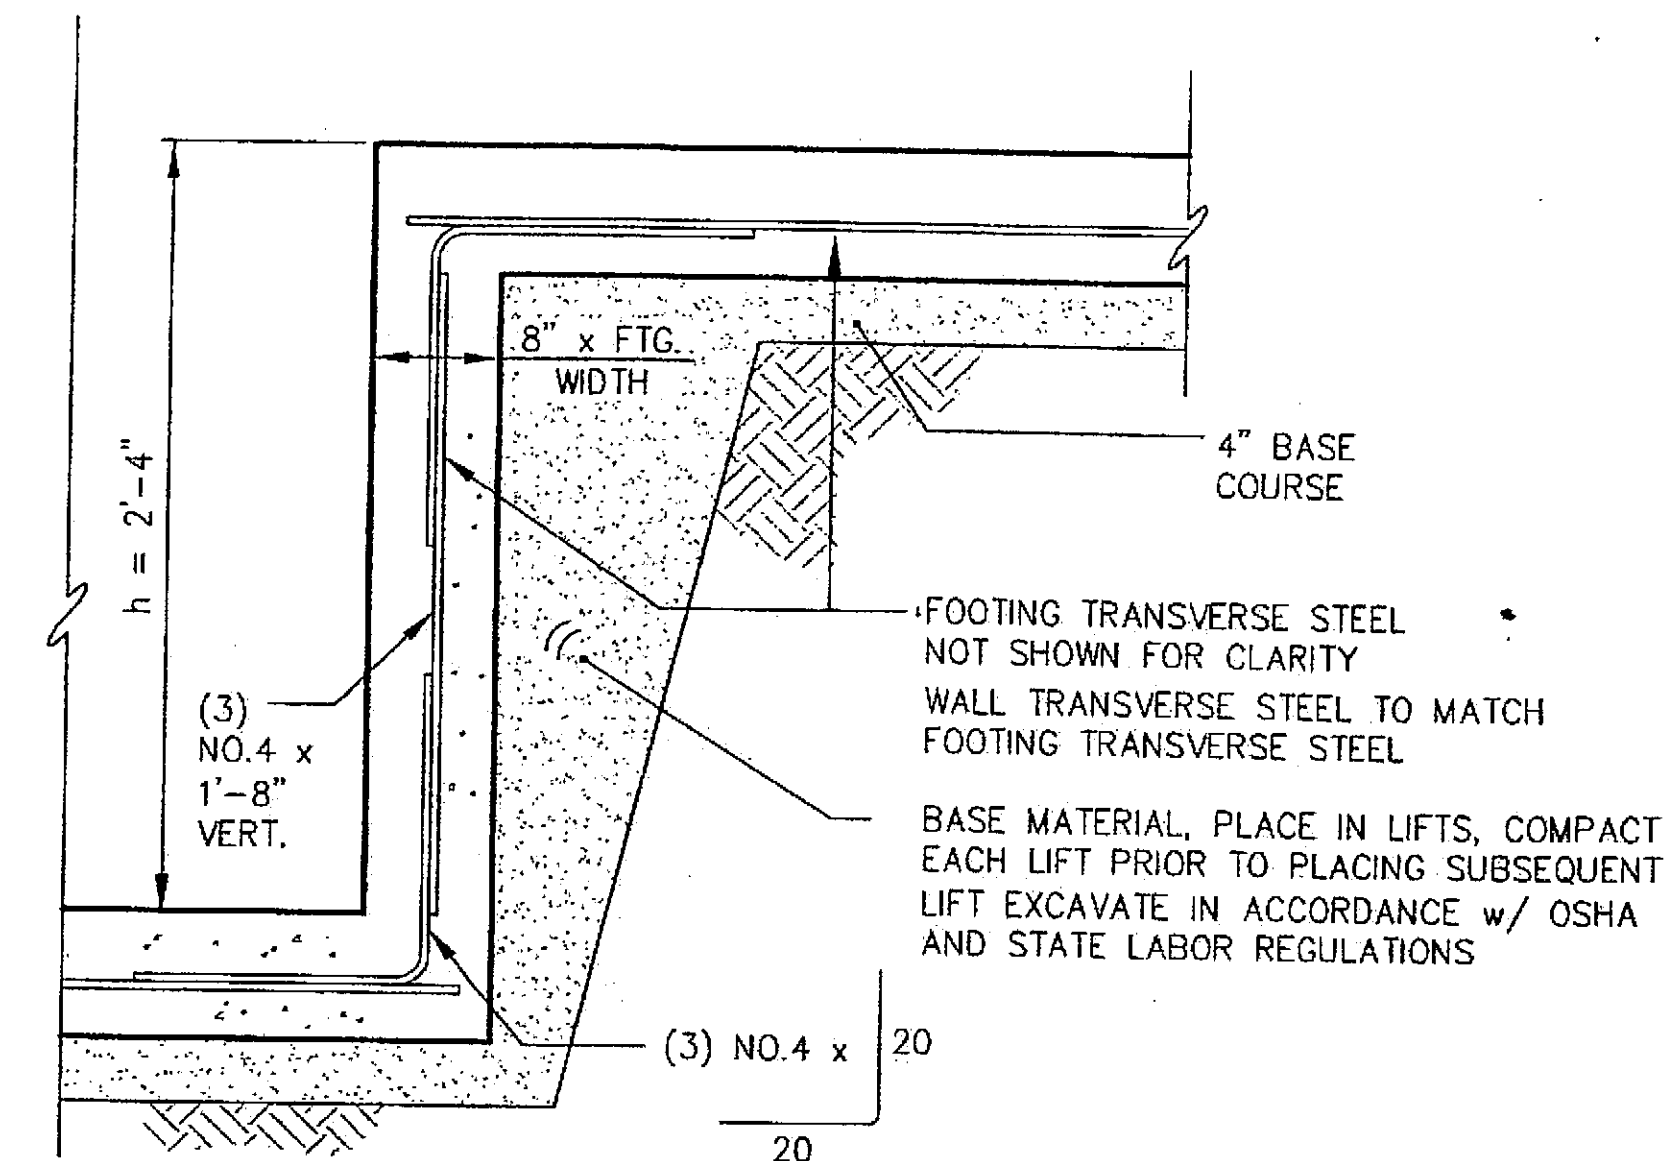

B STEP FOOTING SECTION

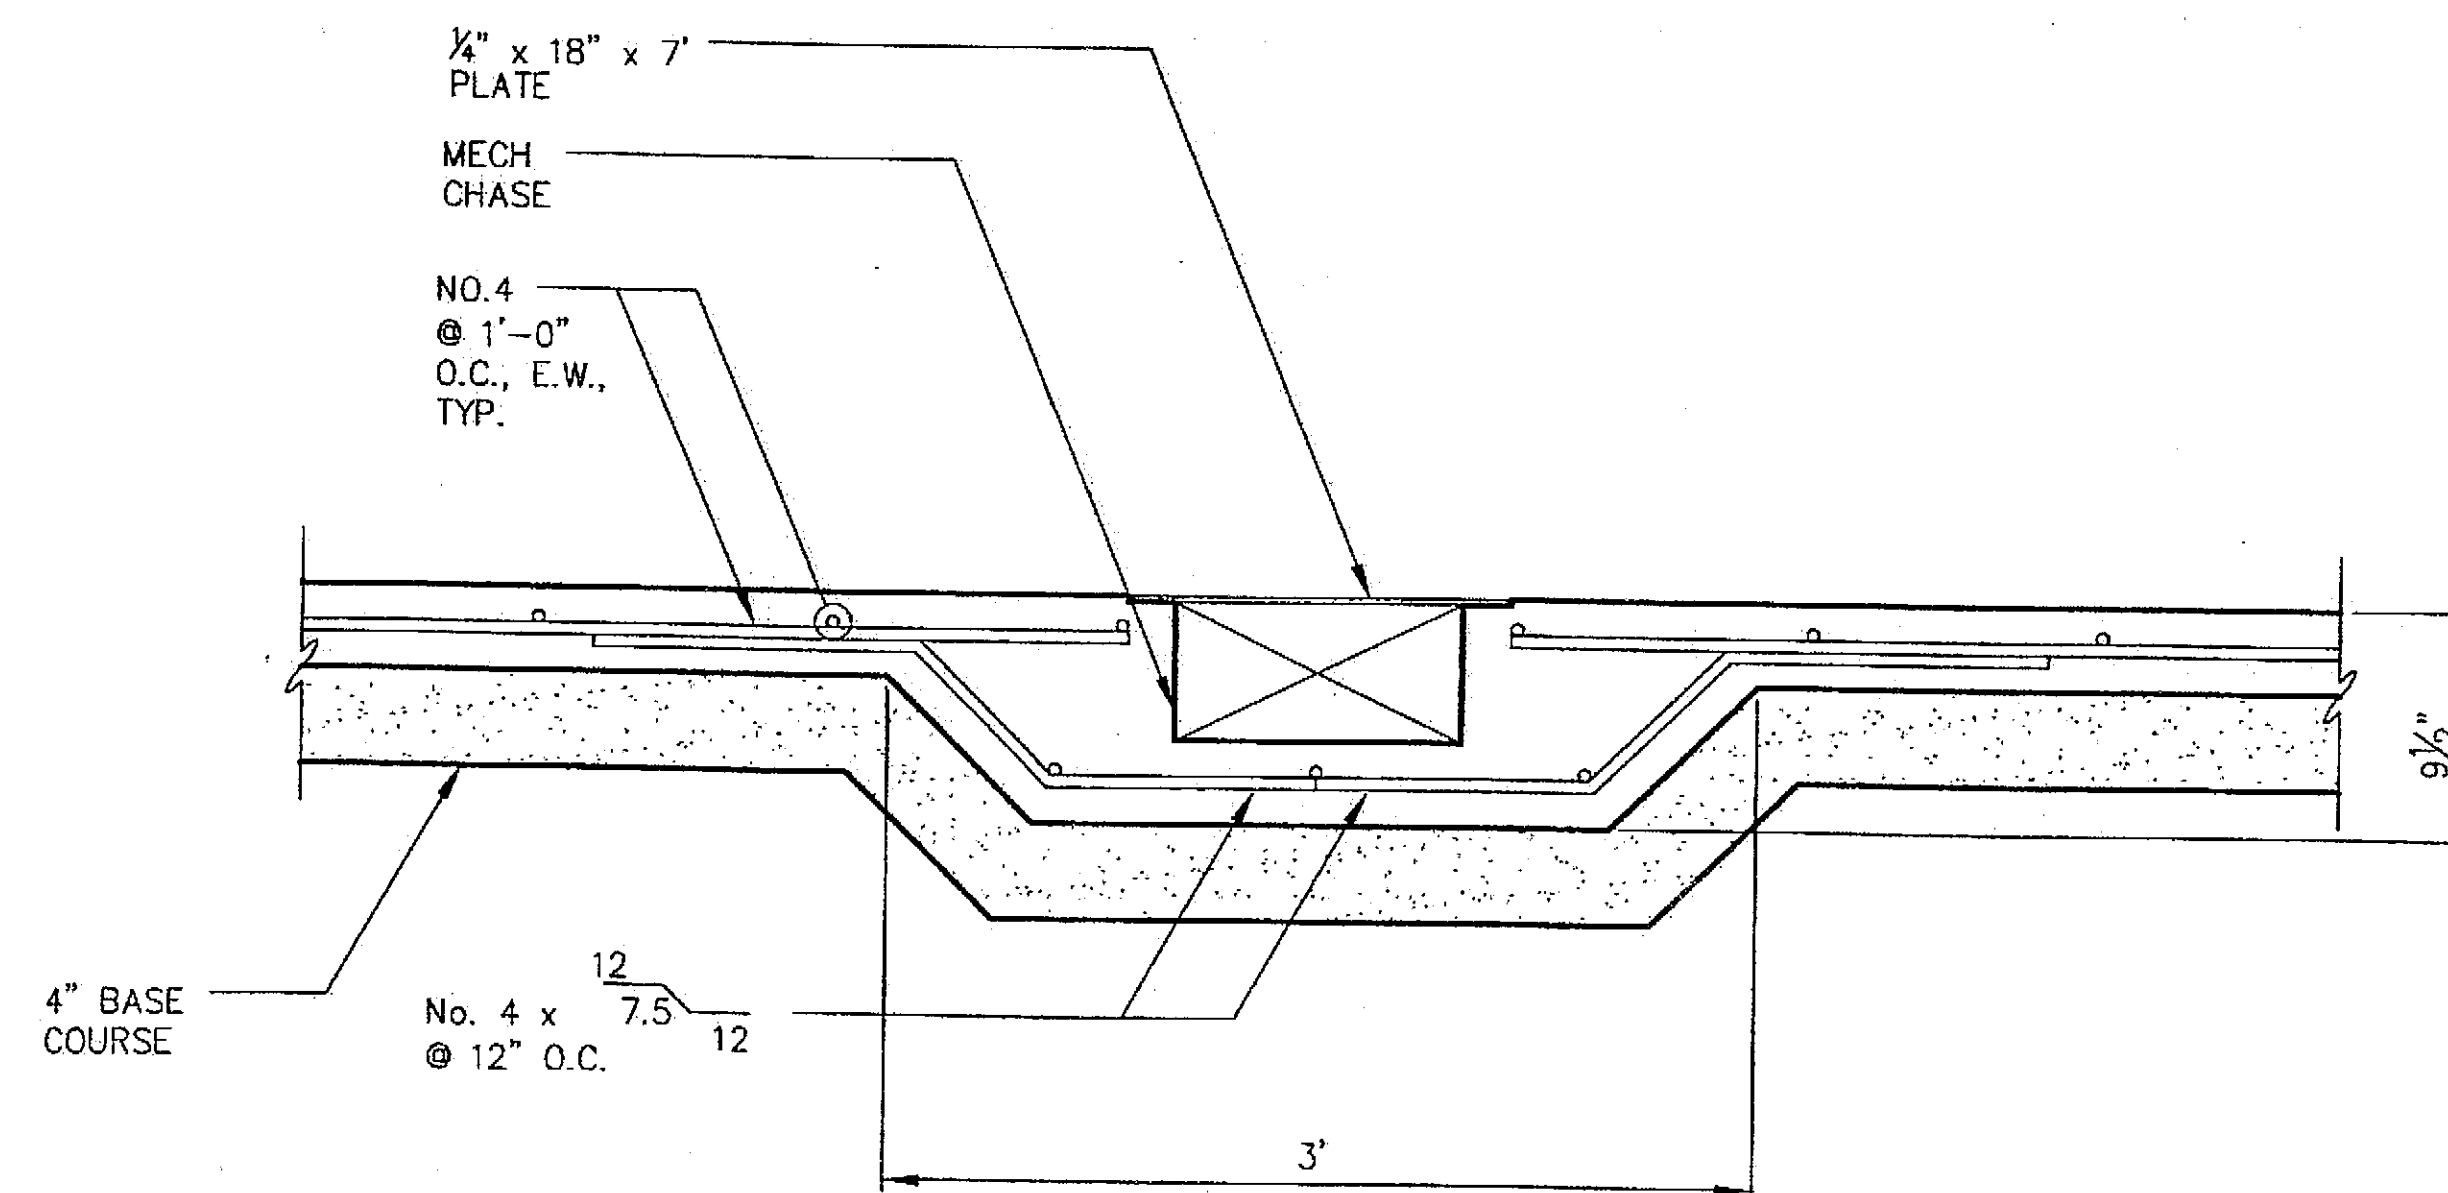

C SLAB AT MECHANICAL CHASE

Tue, 14/Dec/04 12:00PM


ADDENDUM NUMBER

ATTACHMENT NUMBER

RECORD OF REVISIONS

No.	DATE	DESCRIPTION

CHECKED BY:

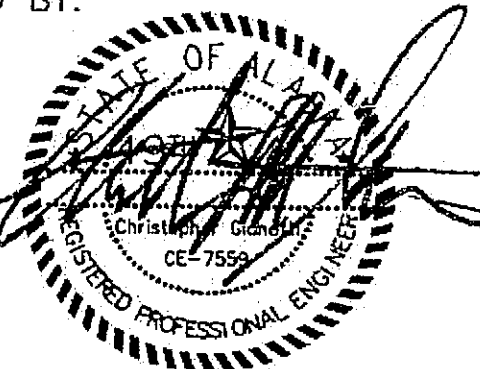

DESIGNED BY: BCN

DRAWN BY: PJD

STATE OF ALASKA
DEPARTMENT OF TRANSPORTATION
& PUBLIC FACILITIES
STATEWIDE DESIGN & ENGINEERING
SERVICES DIVISION

MT EDGE CUMBE
HIGH SCHOOL
BUILDING 1330
ACADEMIC
EXPANSION

SHEET S203

PROJECT DESIGNATION NUMBER

67751C

STATE	YEAR
ALASKA	2004
SHEET NUMBER	TOTAL SHEETS
46	79

Project As-Built Drawings have been reviewed by the Project Engineer and represent to the best of my knowledge, the project as constructed.
Proj. Eng. *[Signature]* Date *7-07*

ADDENDUM NUMBER

ATTACHMENT NUMBER

RECORD OF REVISIONS

No.	DATE	DESCRIPTION

CHECKED BY:



DESIGNED BY: BCN

DRAWN BY: PJD

STATE OF ALASKA
DEPARTMENT OF TRANSPORTATION
& PUBLIC FACILITIES
STATEWIDE DESIGN & ENGINEERING
SERVICES DIVISION


MT EDGECOMBE
HIGH SCHOOL
BUILDING 1330
ACADEMIC
EXPANSION

SHEET S300

PROJECT DESIGNATION NUMBER

67751C


STATE	YEAR
ALASKA	2004
SHEET NUMBER	TOTAL SHEETS
47	79

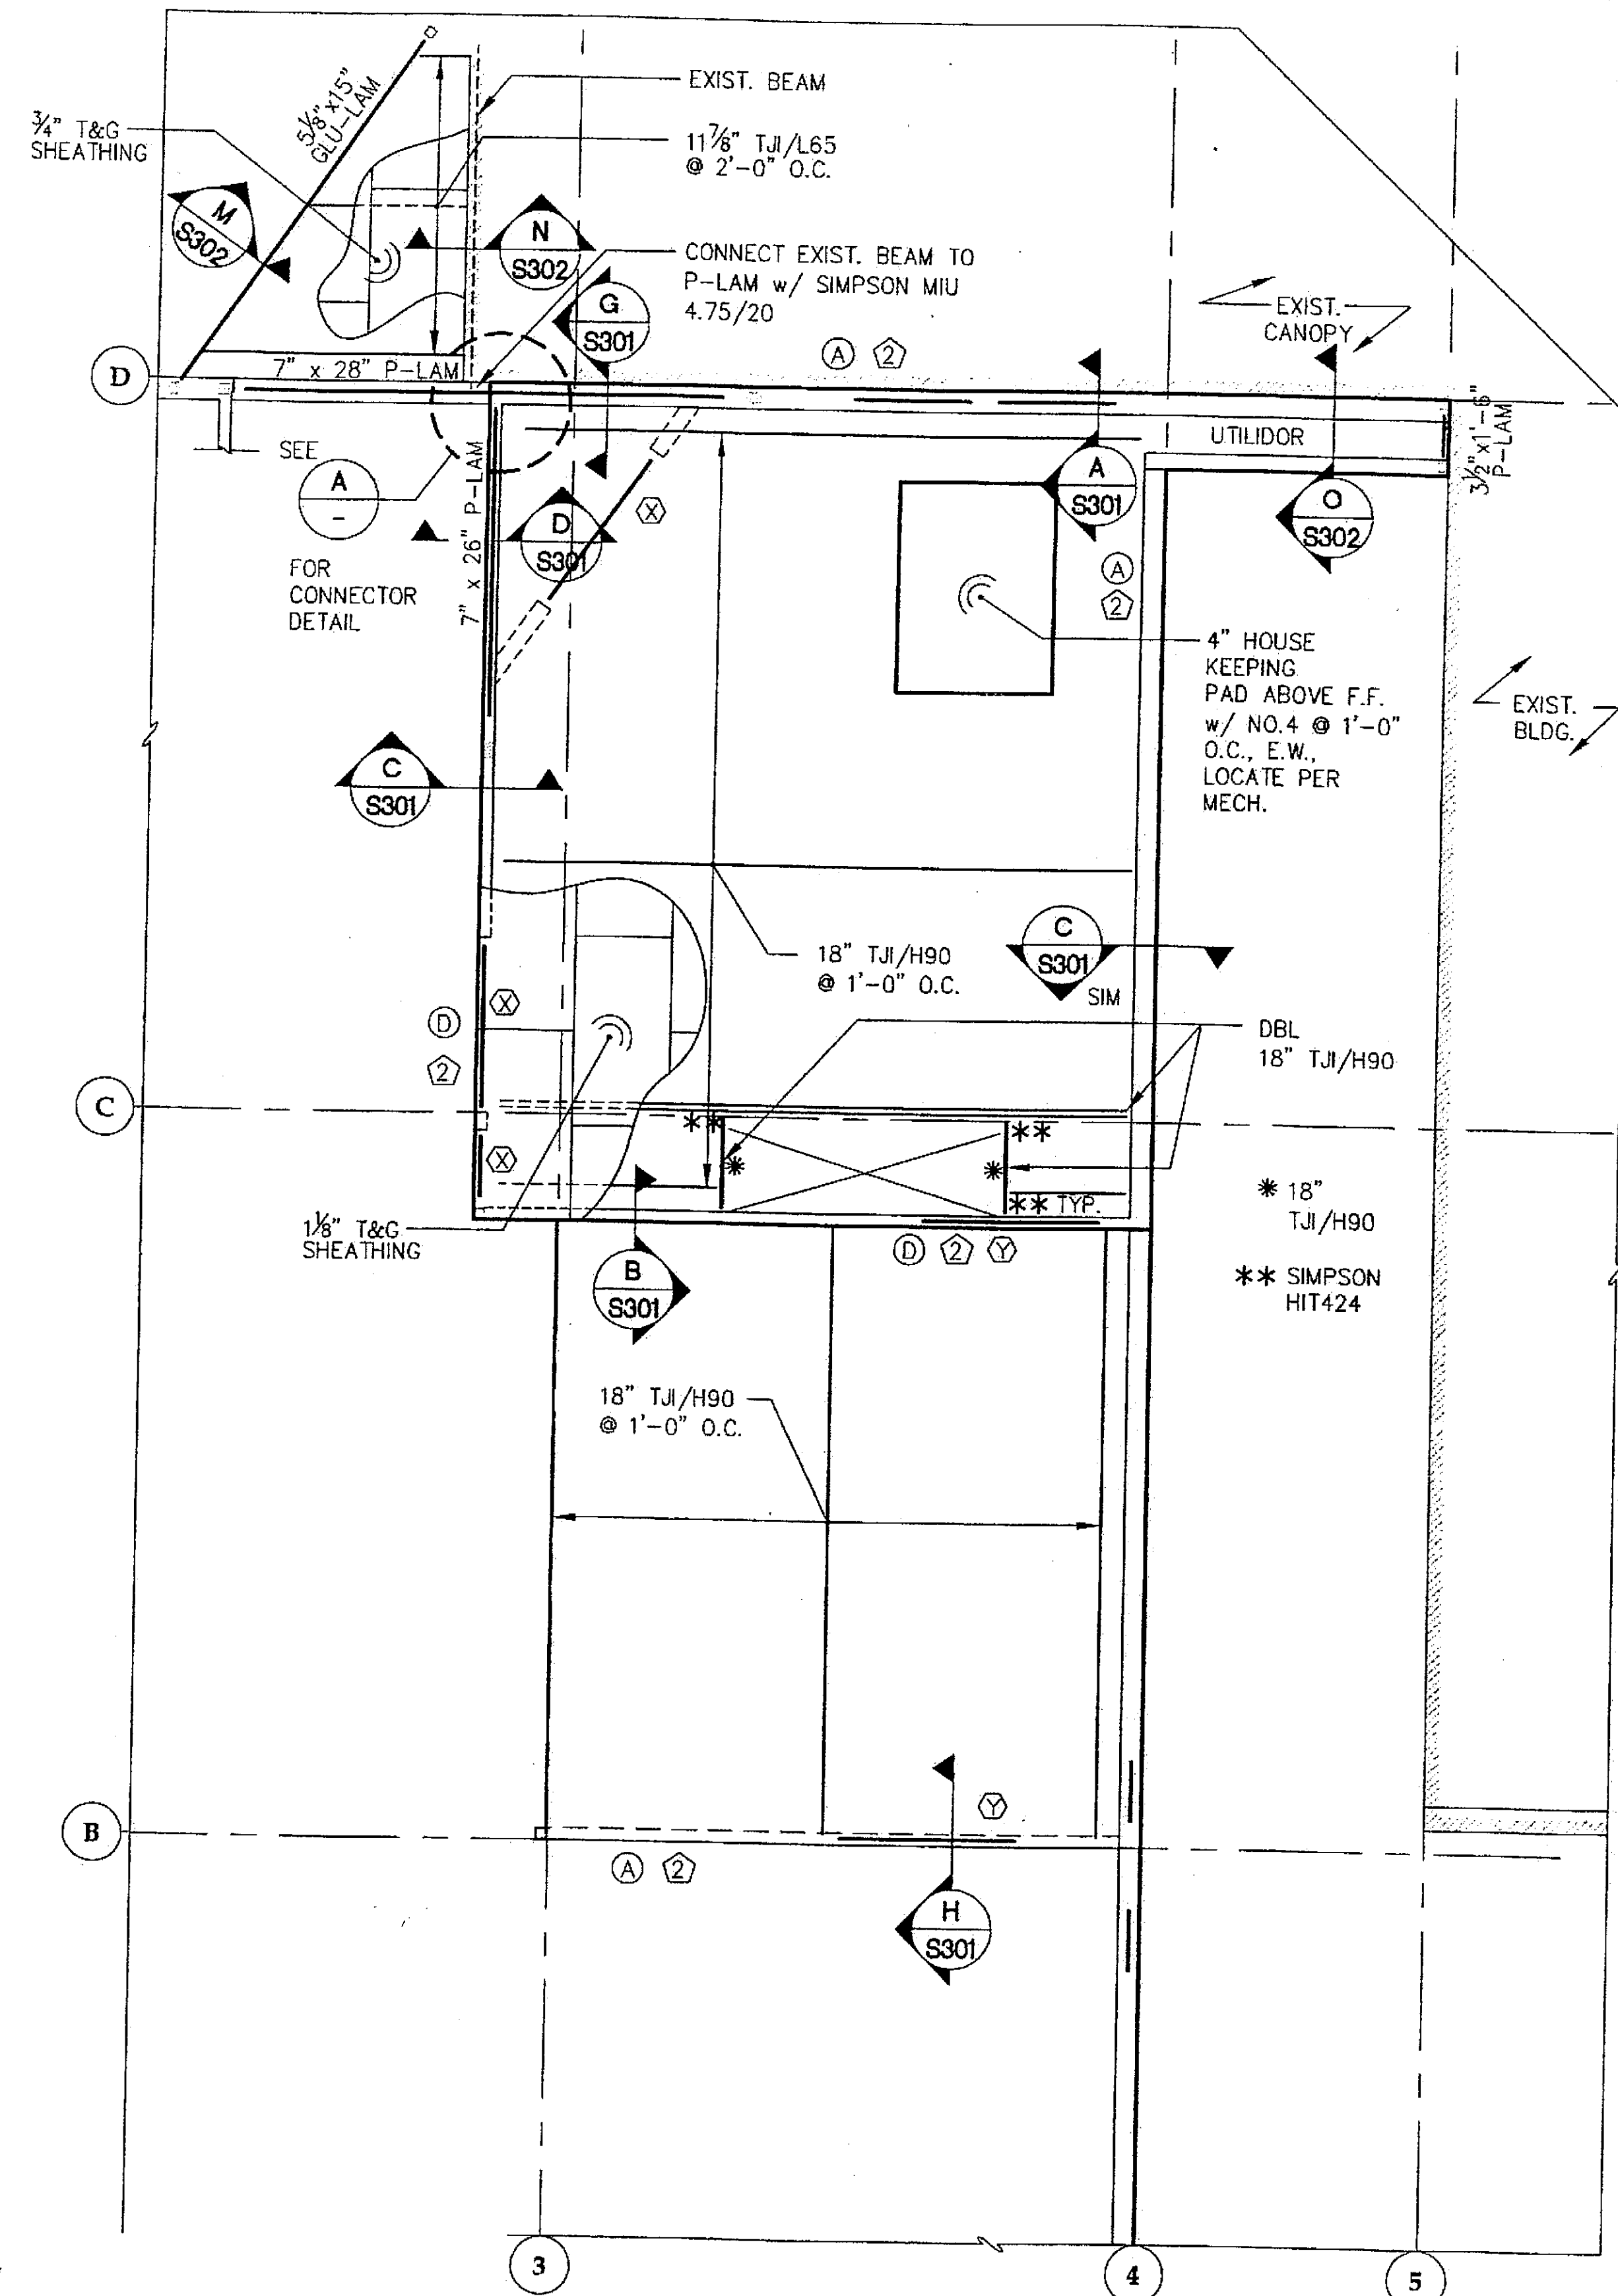


1 SECOND FLOOR FRAMING PLAN
BASE BID

NOTES:

- 1 INDICATES STUDWALL TYPE, SEE SCHEDULE.
- 2 A INDICATES SHEAR WALL TYPE, SEE SCHEDULE.

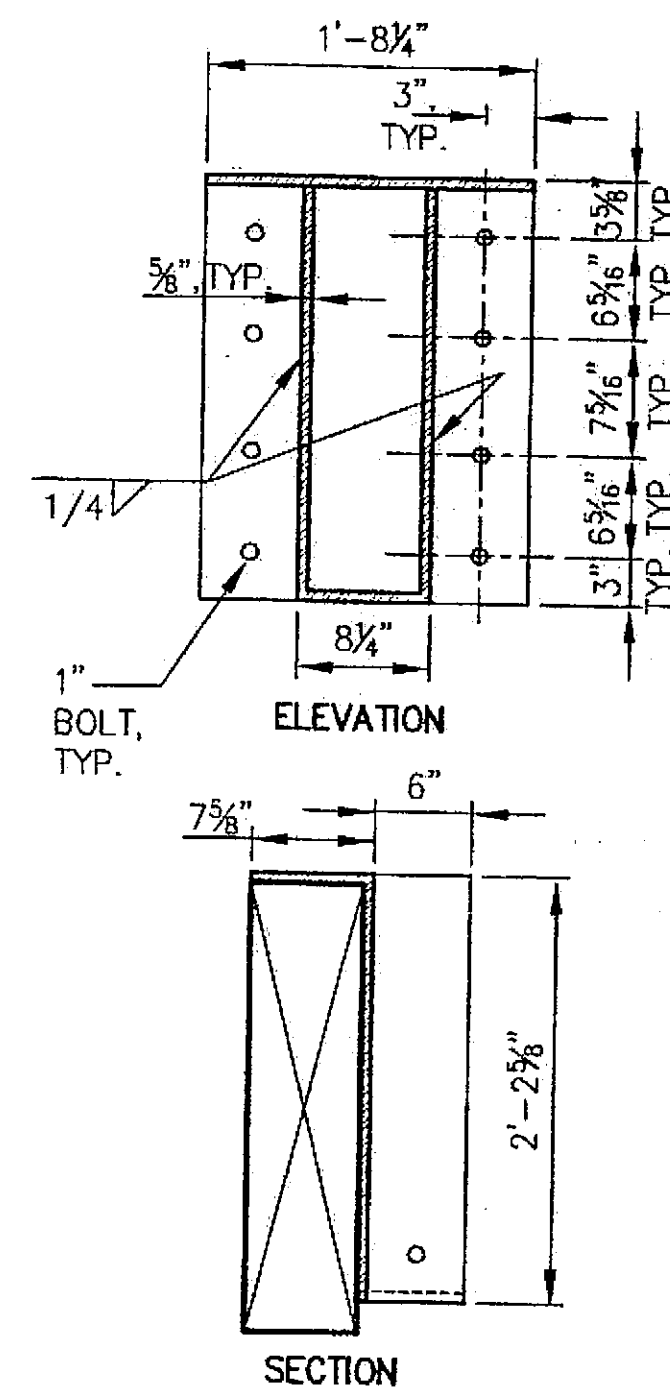

A CONNECTION
DETAIL

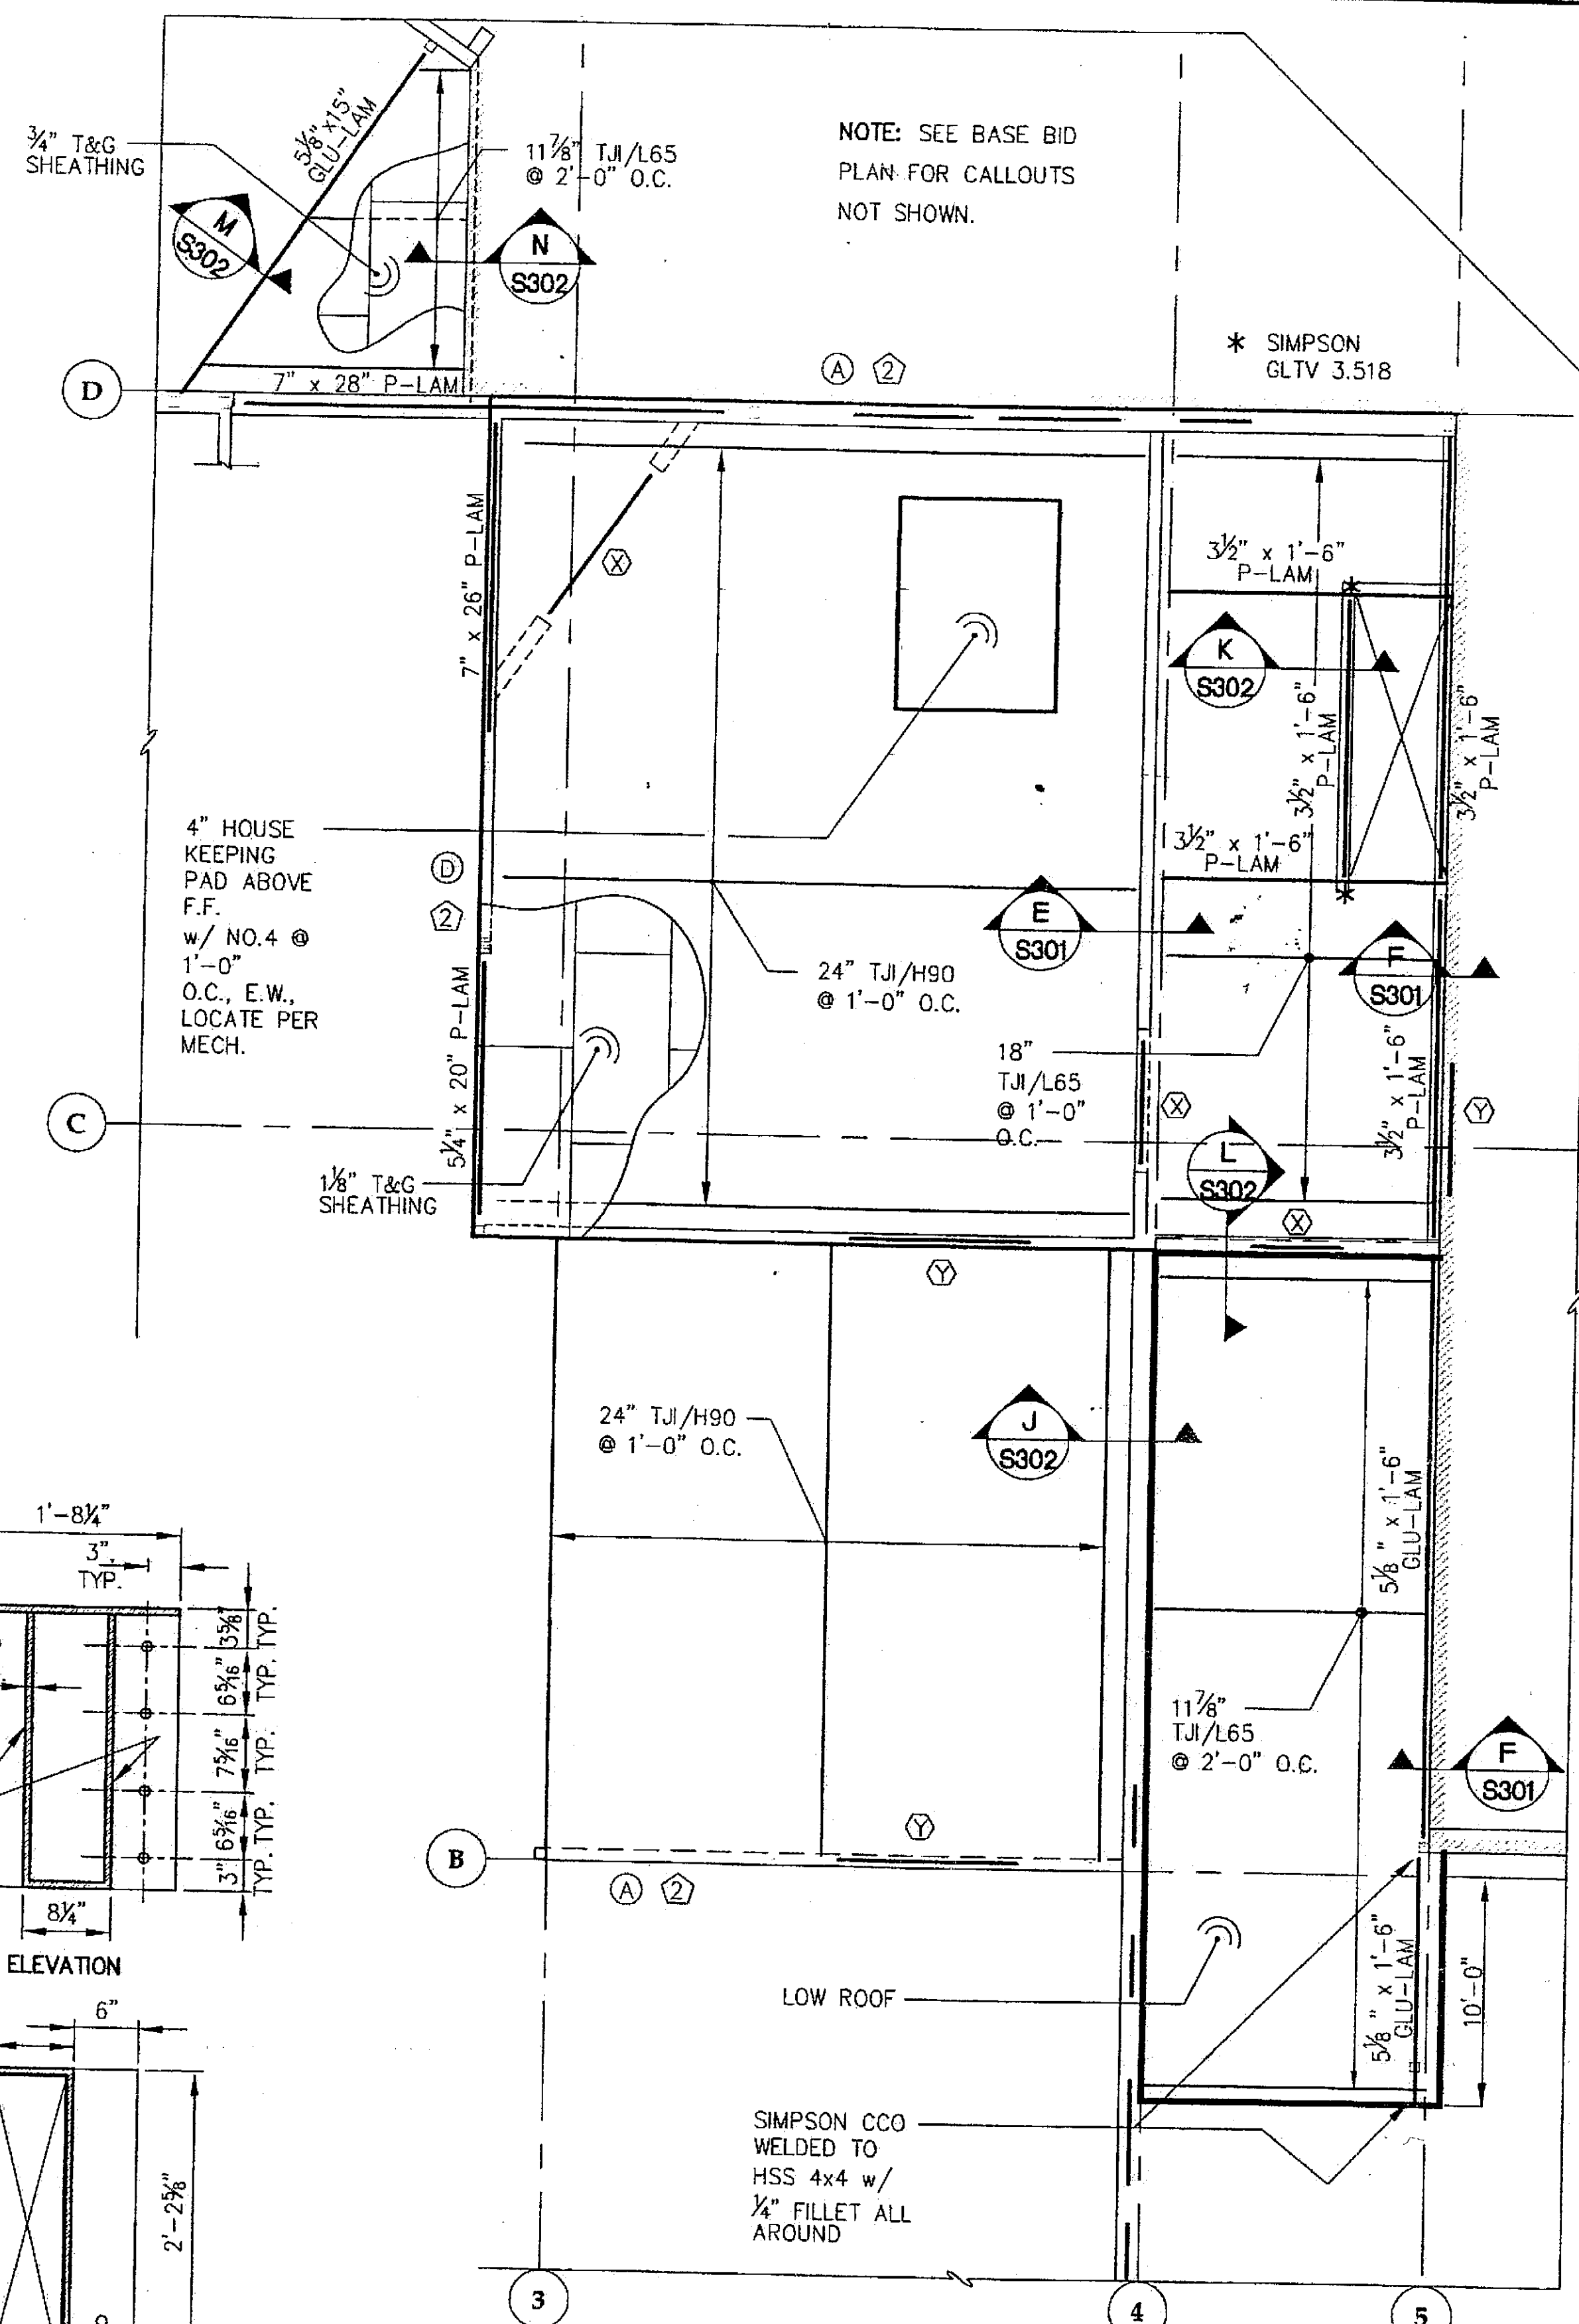

2 SECOND FLOOR FRAMING PLAN
ALTERNATE

Project As-Built Drawings have been
reviewed by the Project Engineer and
represent to the best of my knowledge, the
project as constructed.
Proj. Eng. *[Signature]* Date 7-97


Tue, 14/Dec/04 12:00PM

ADDENDUM NUMBER

ATTACHMENT NUMBER

RECORD OF REVISIONS

No.	DATE	DESCRIPTION

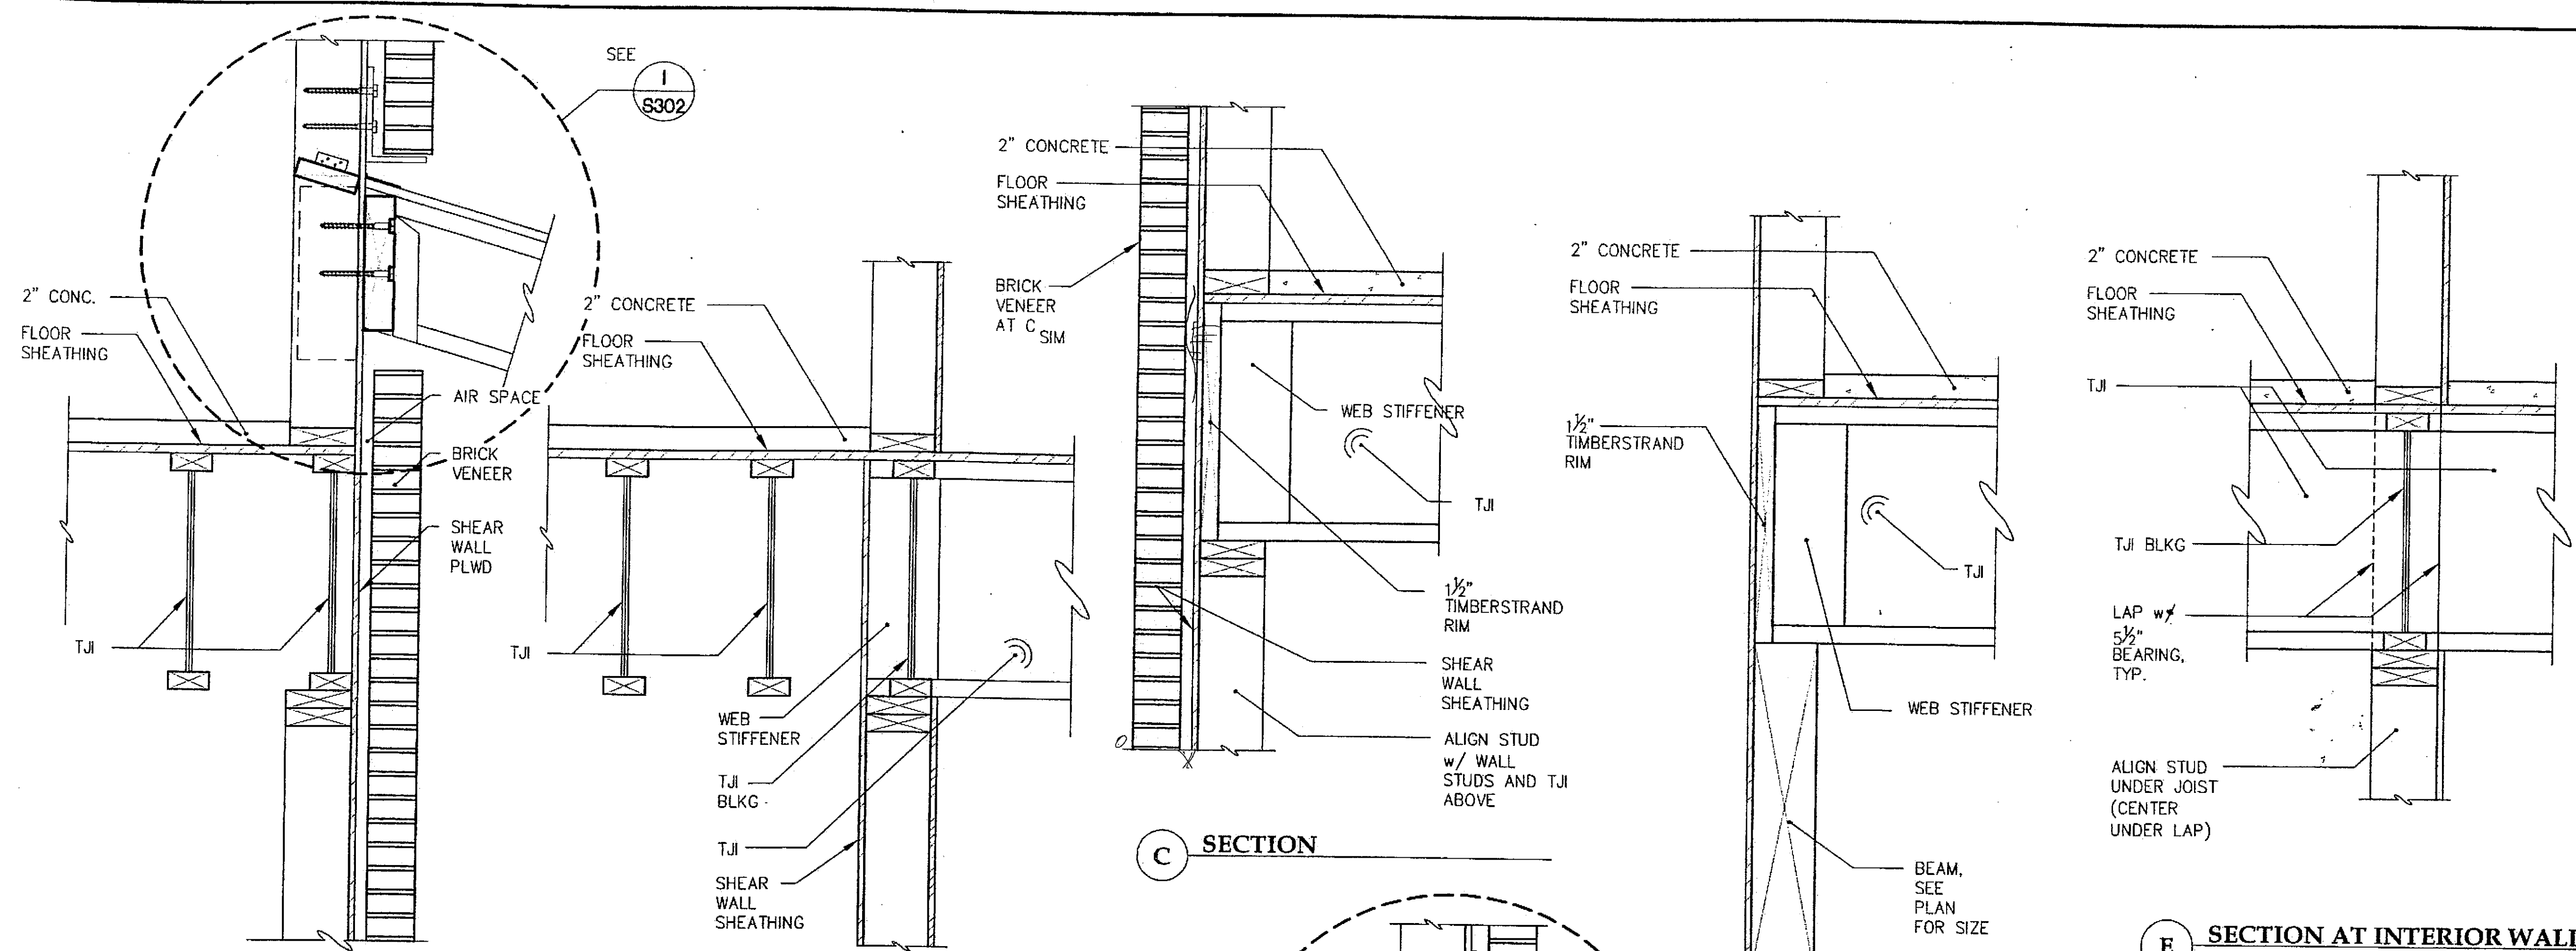


A TYPICAL SECTION

B SECTION


C SECTION

D SECTION AT BEAM

E SECTION AT INTERIOR WALL

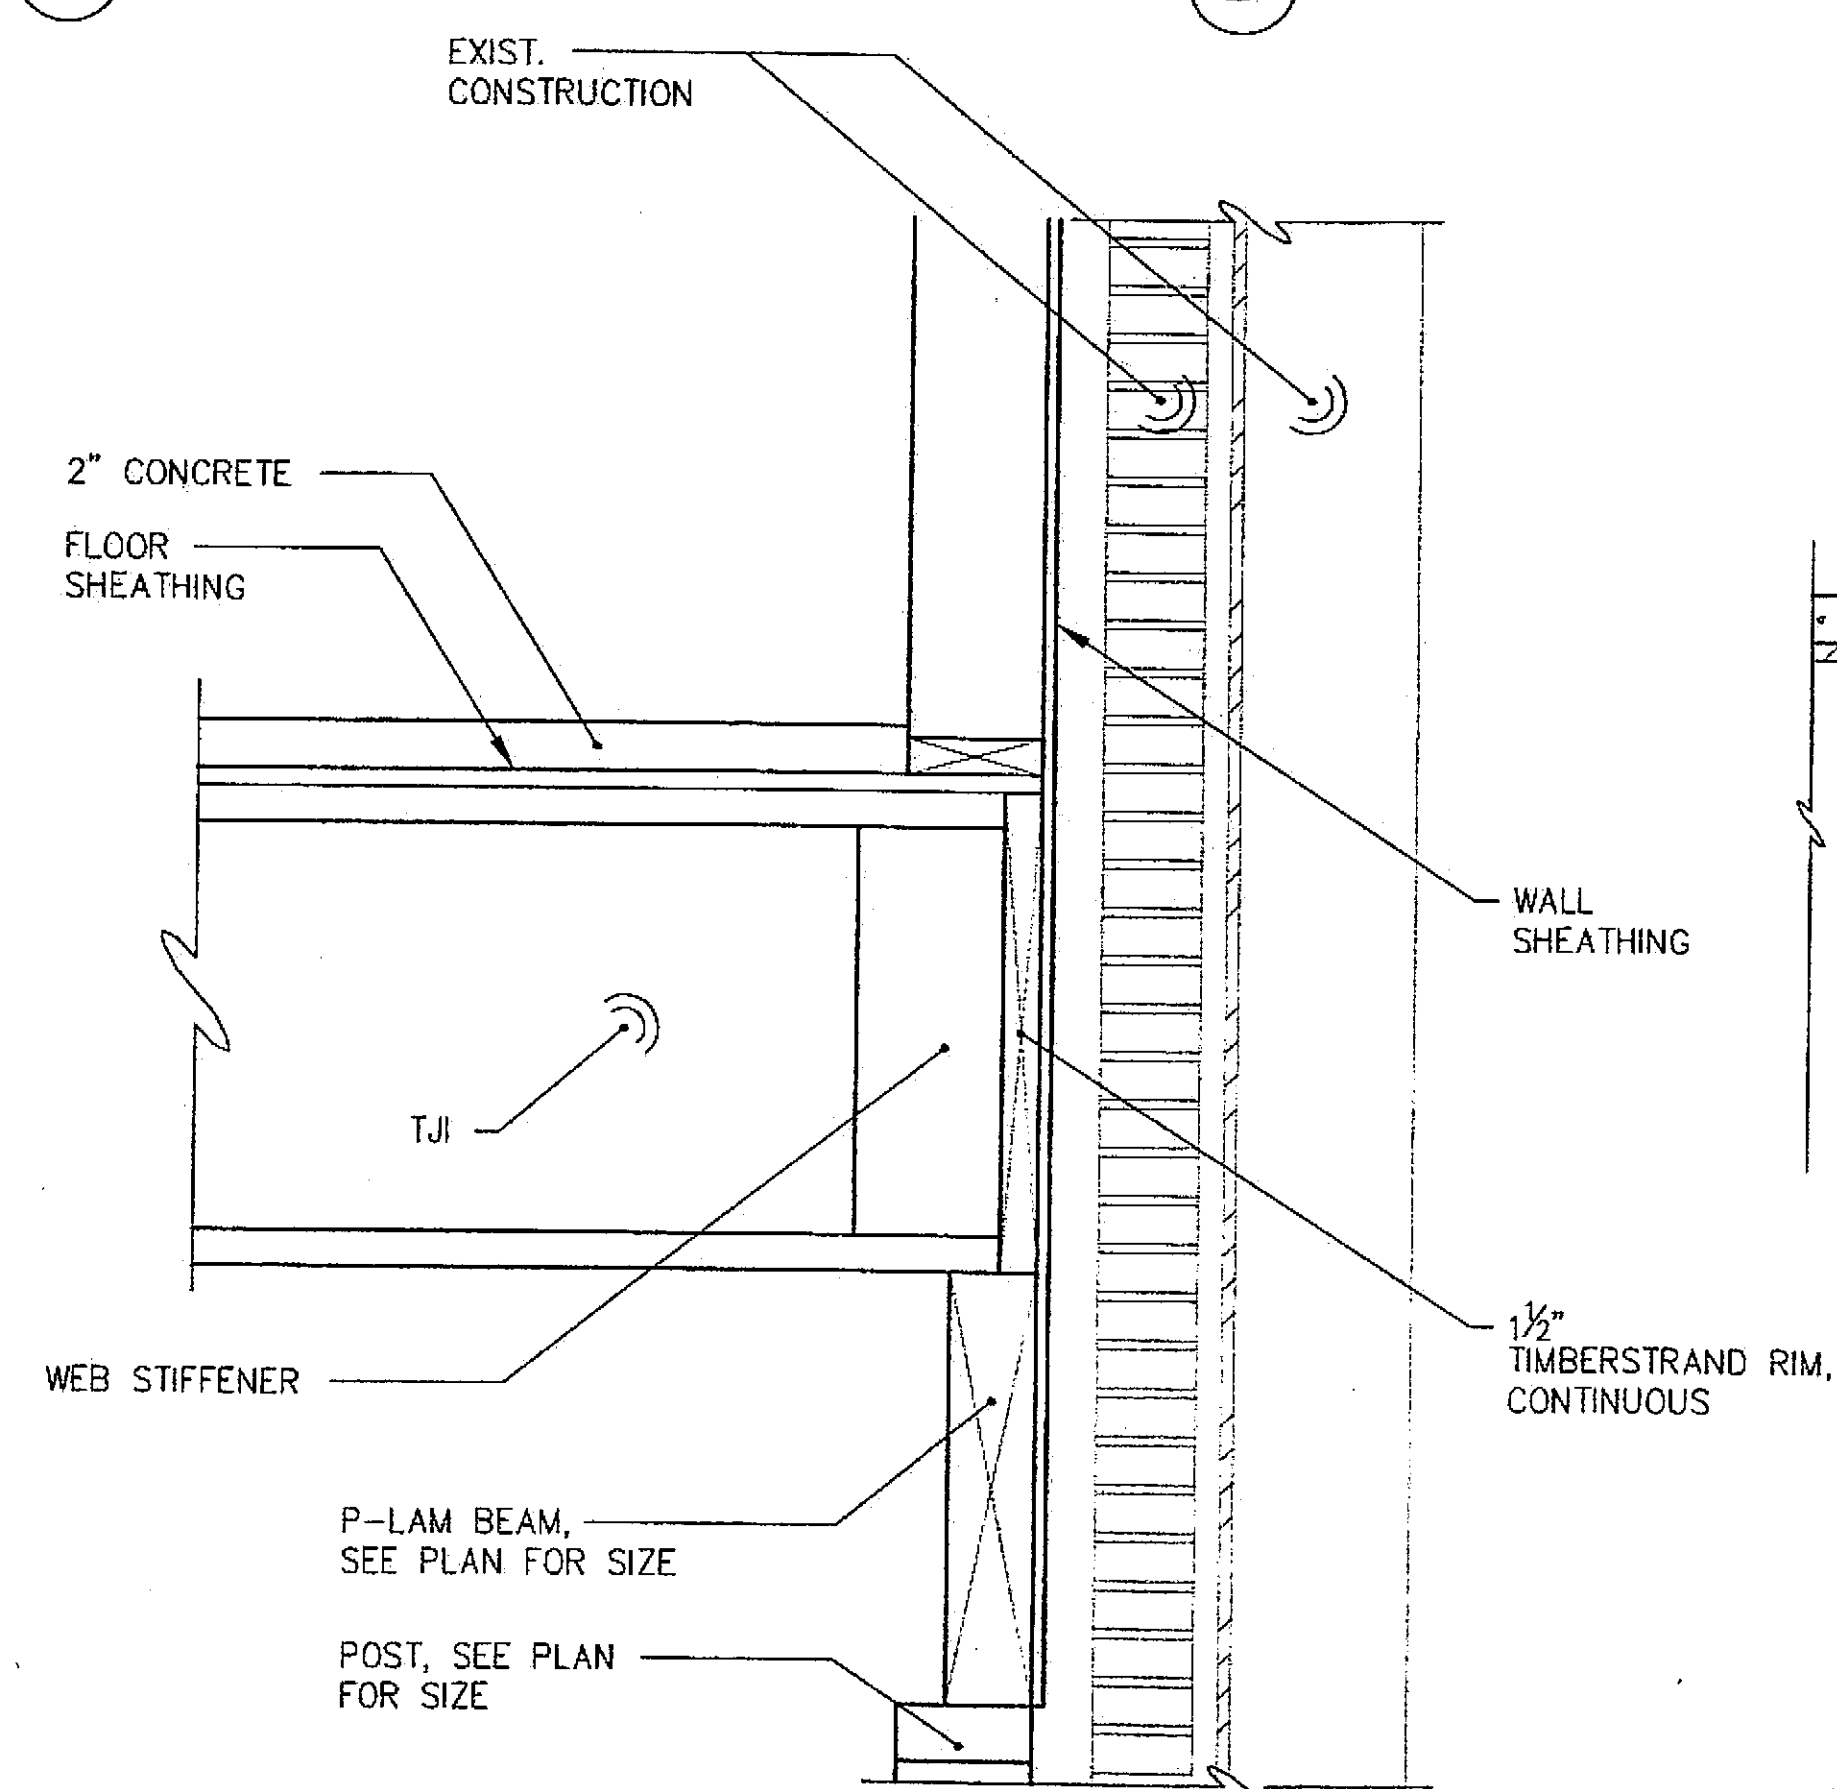


F SECTION AT EXISTING WALL

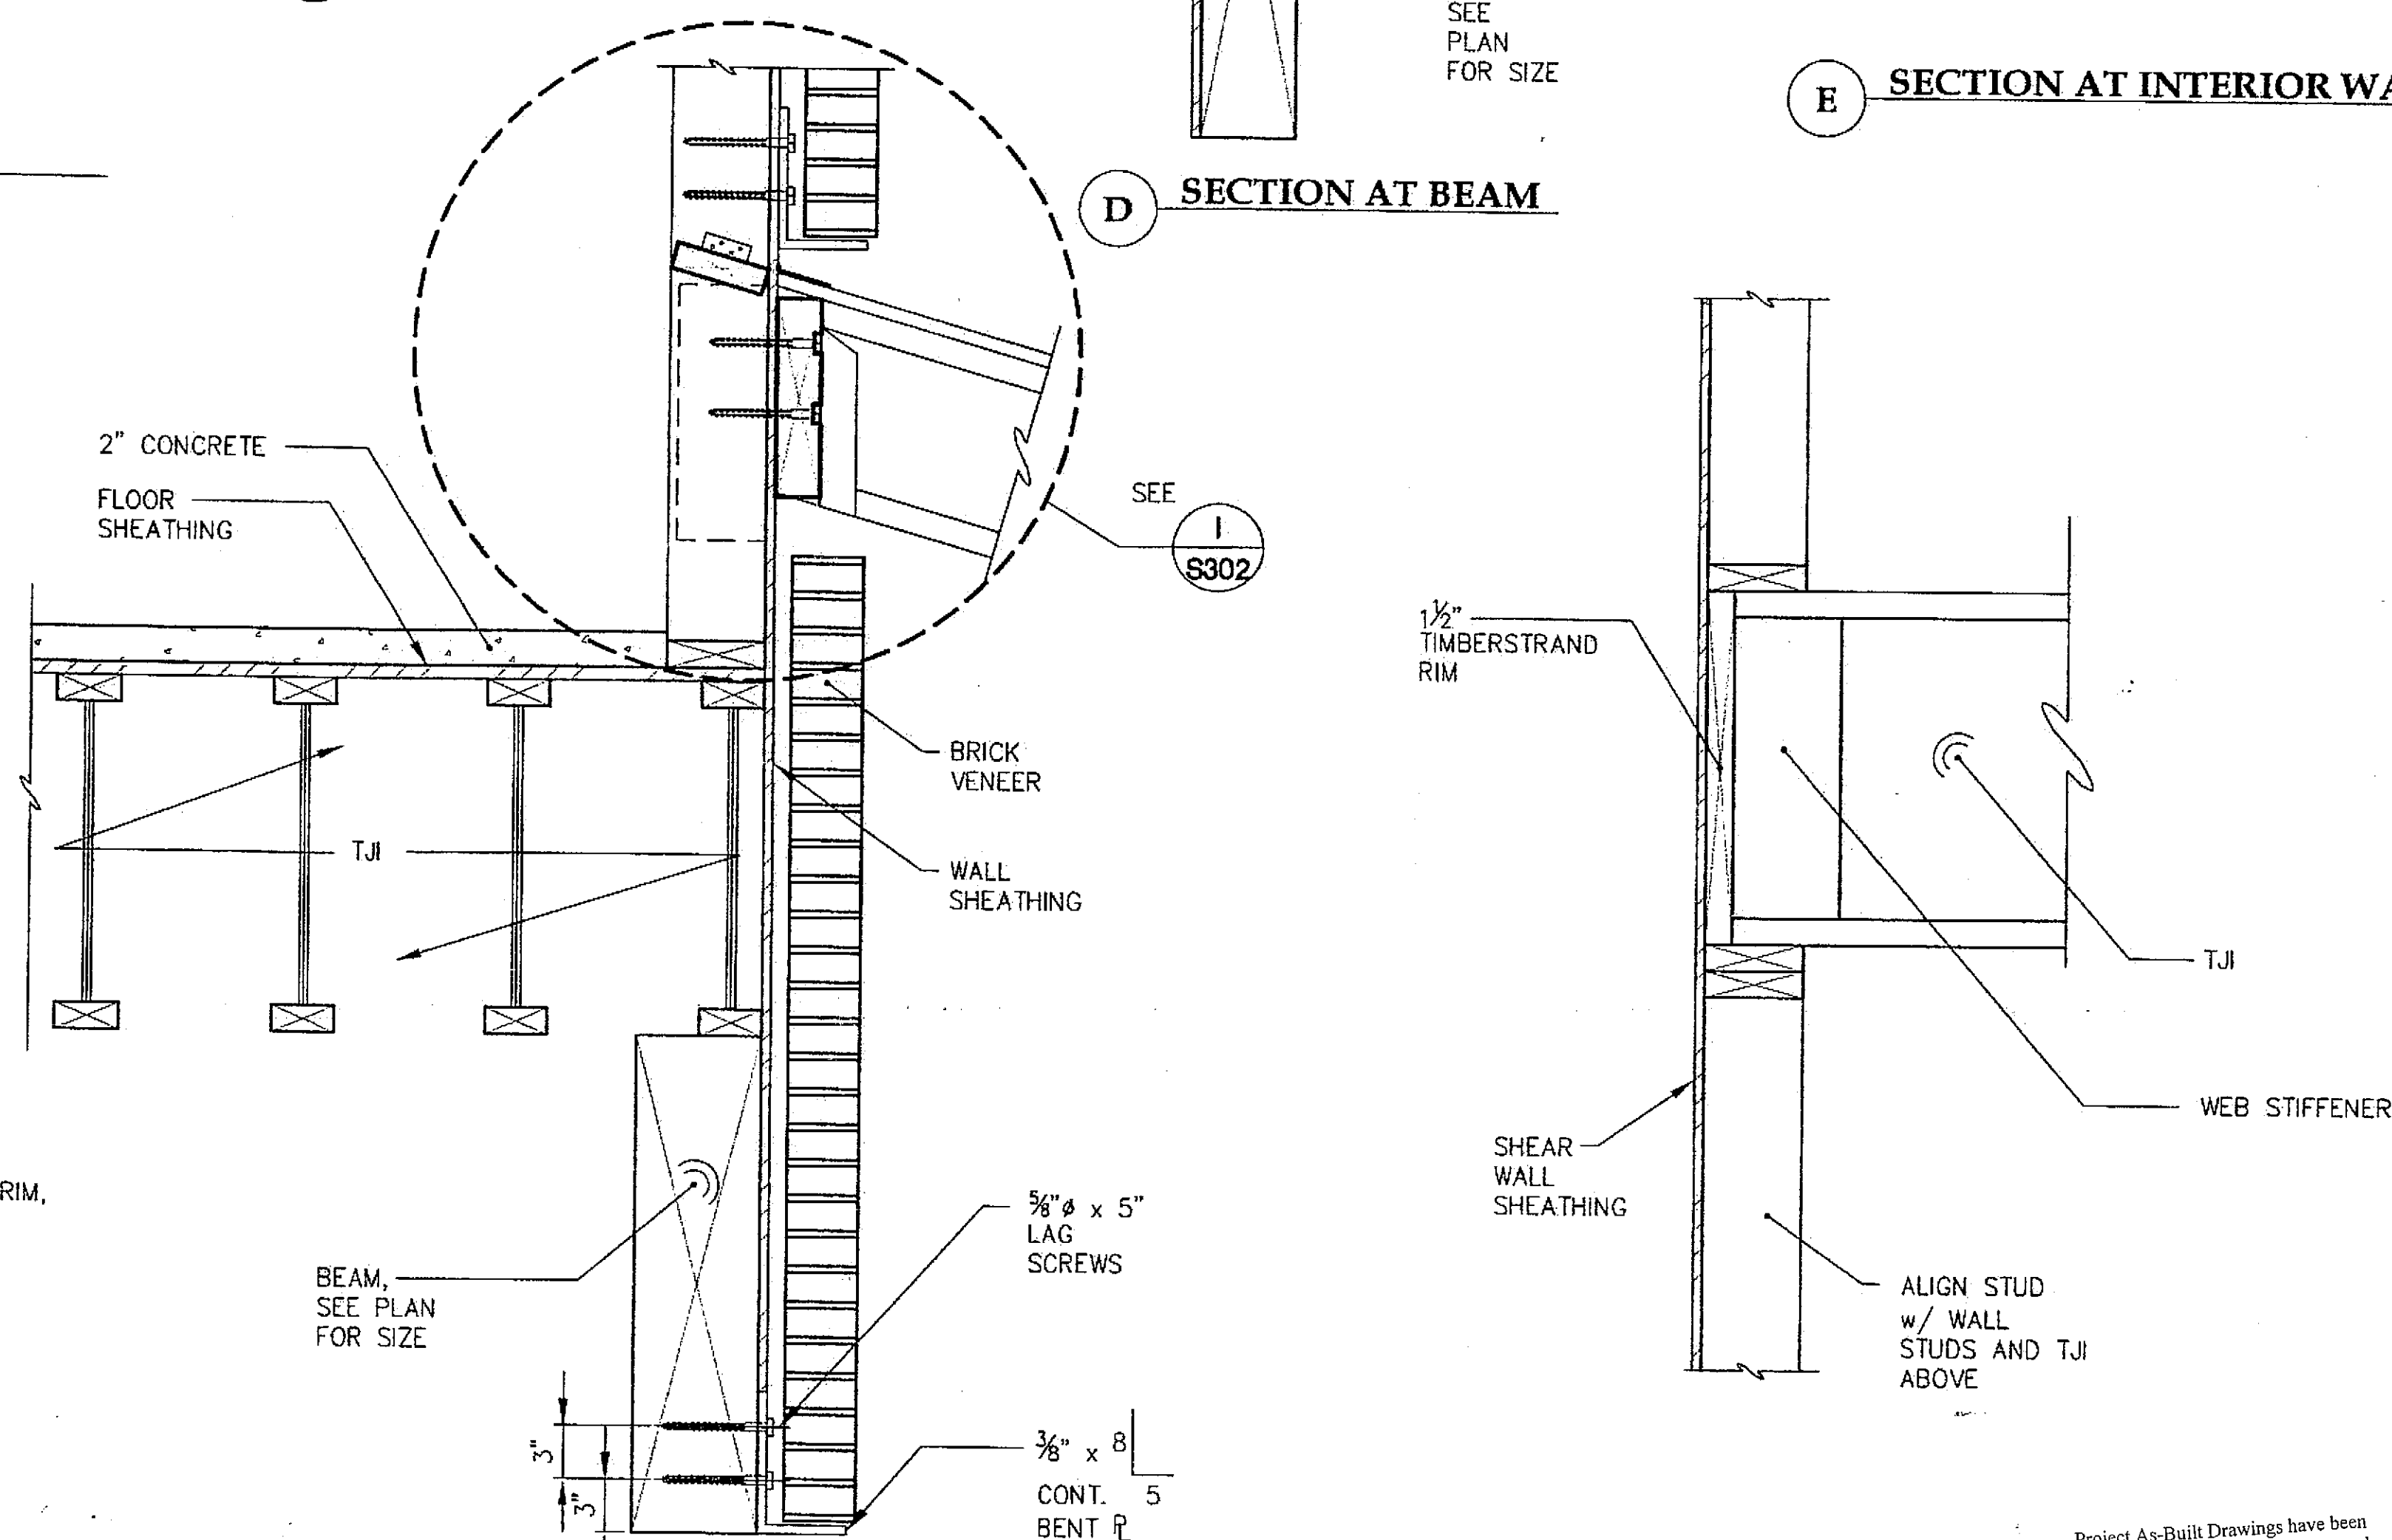

G SECTION AT ENTRY

H SECTION

CHECKED BY:

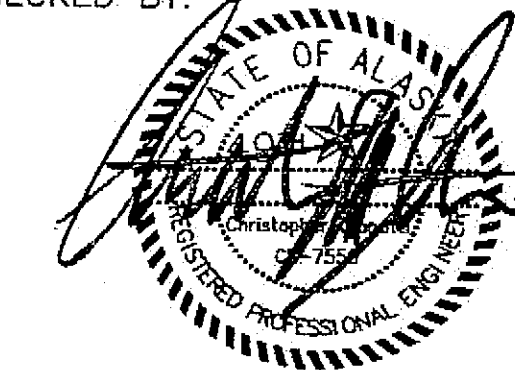

DESIGNED BY: BCN

DRAWN BY: PJD

STATE OF ALASKA
 DEPARTMENT OF TRANSPORTATION
 & PUBLIC FACILITIES
 STATEWIDE DESIGN & ENGINEERING
 SERVICES DIVISION

MT EDGE CUMBE
 HIGH SCHOOL
 BUILDING 1330
 ACADEMIC
 EXPANSION

SHEET S301

PROJECT DESIGNATION NUMBER

67751C


STATE YEAR

ALASKA 2004


SHEET NUMBER TOTAL SHEETS

48 79


Project As-Built Drawings have been
 reviewed by the Project Engineer and
 represent to the best of my knowledge, the
 project as constructed.
 Proj. Eng. *[Signature]* Date 7-07

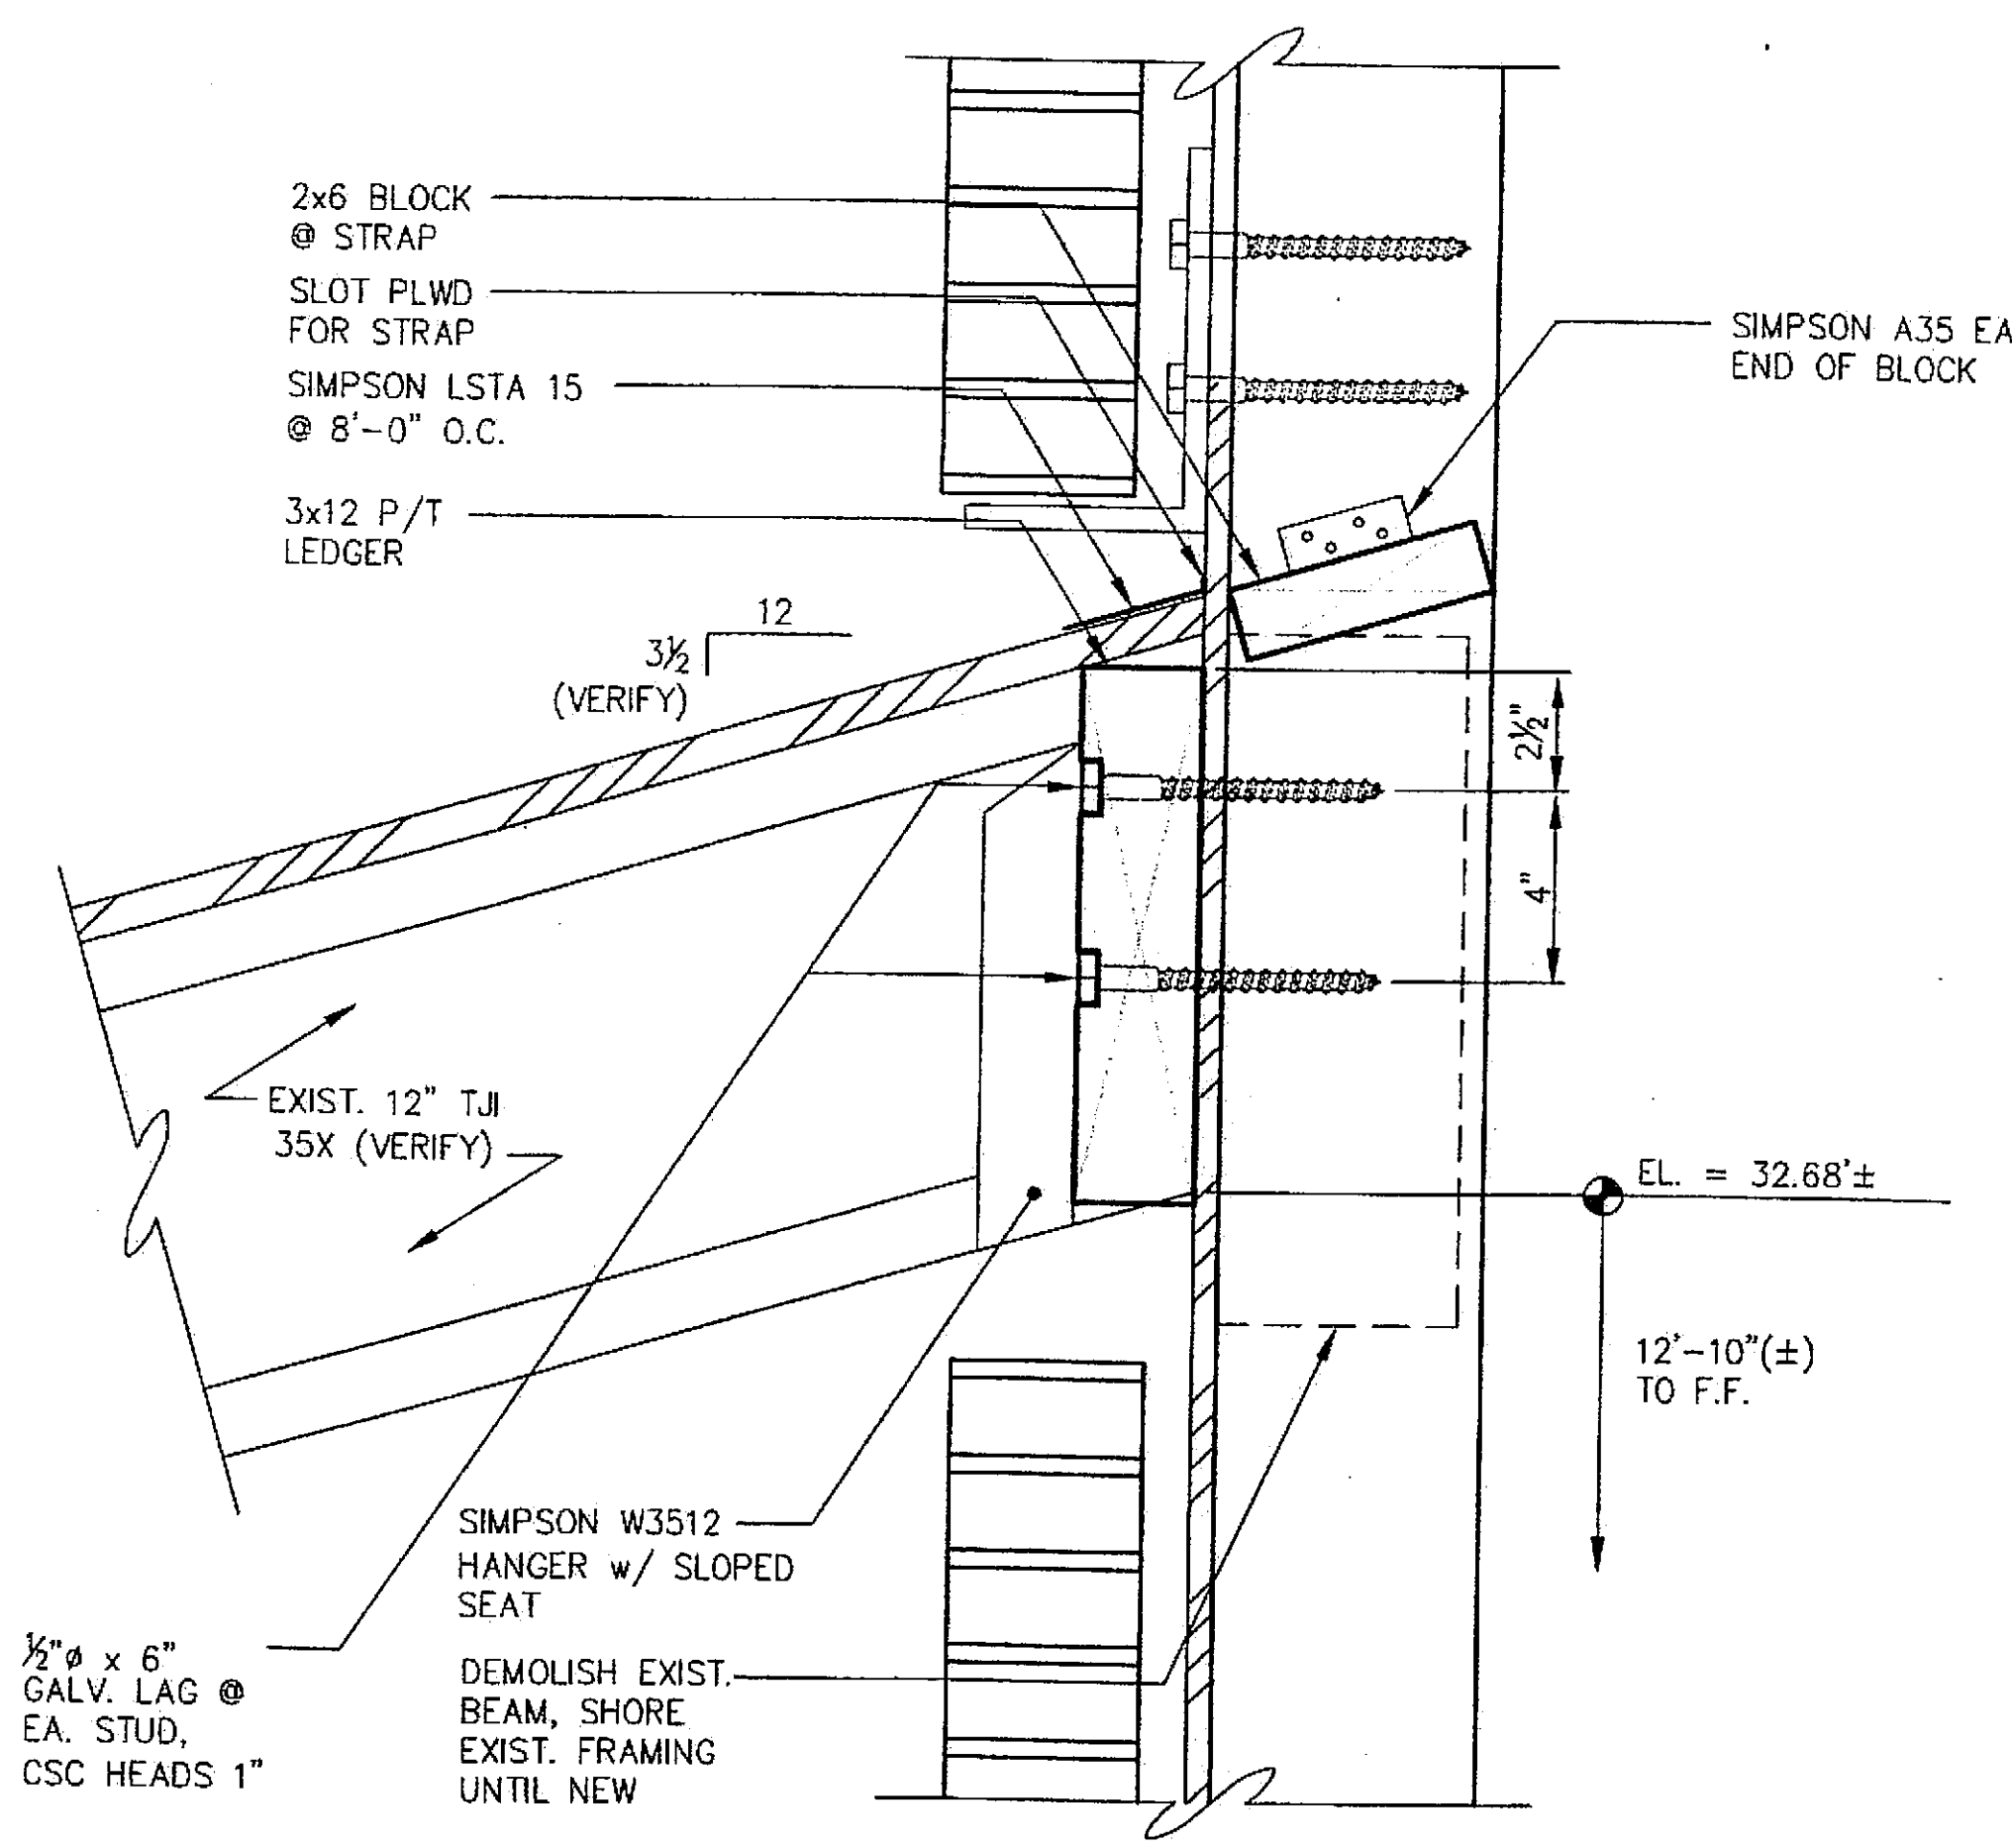


I EXISTING CANOPY TO STUDS

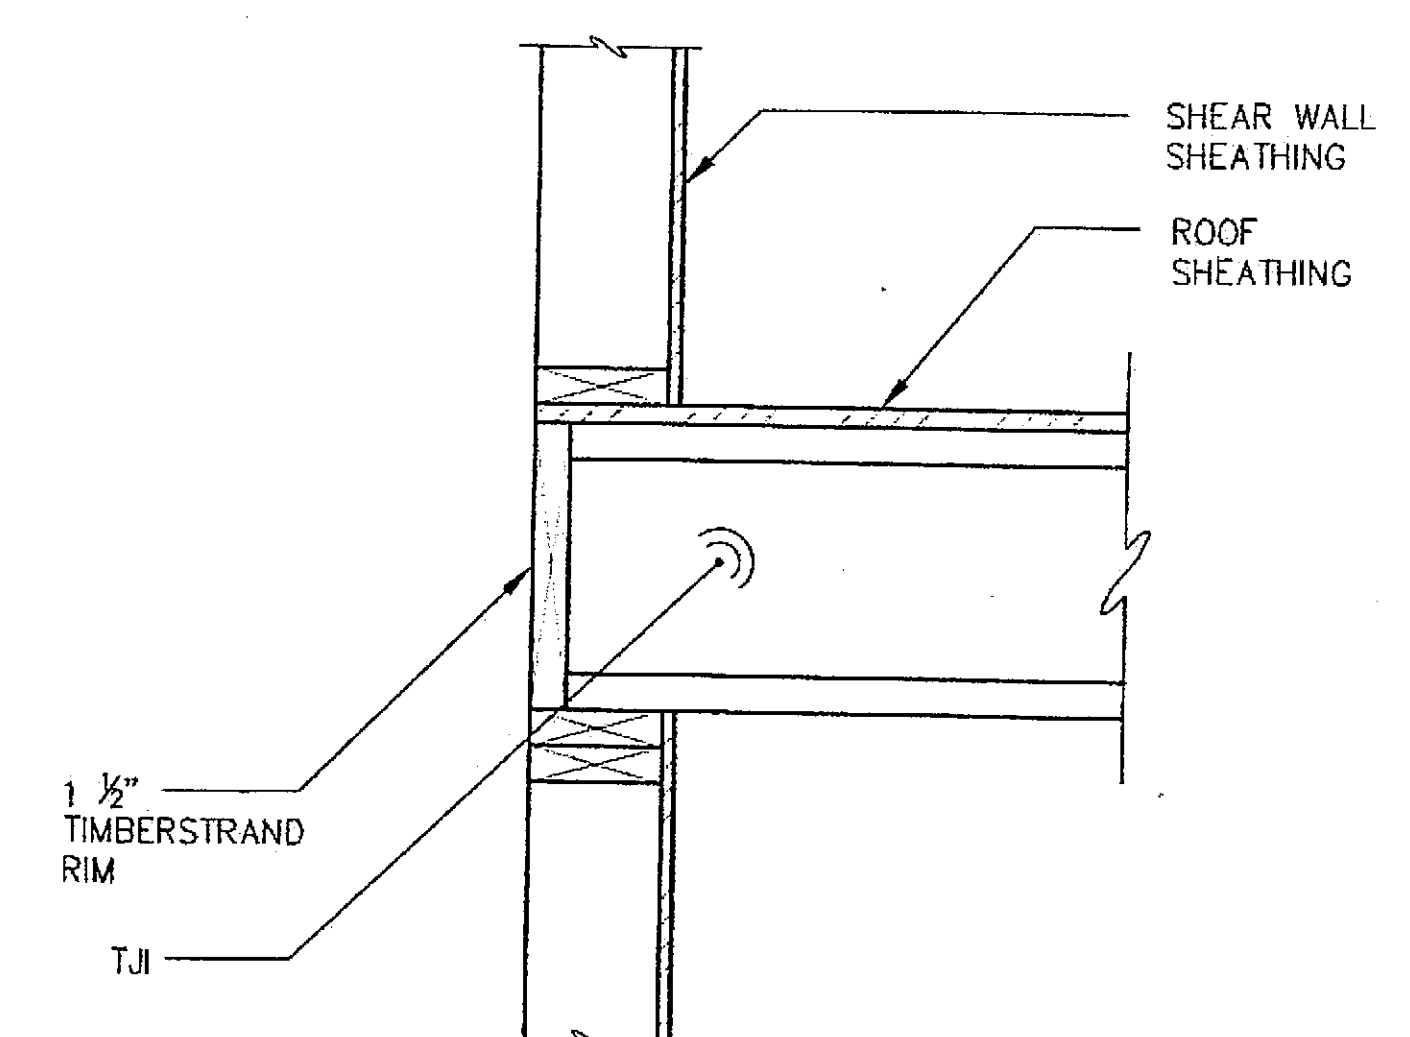


J SECTION

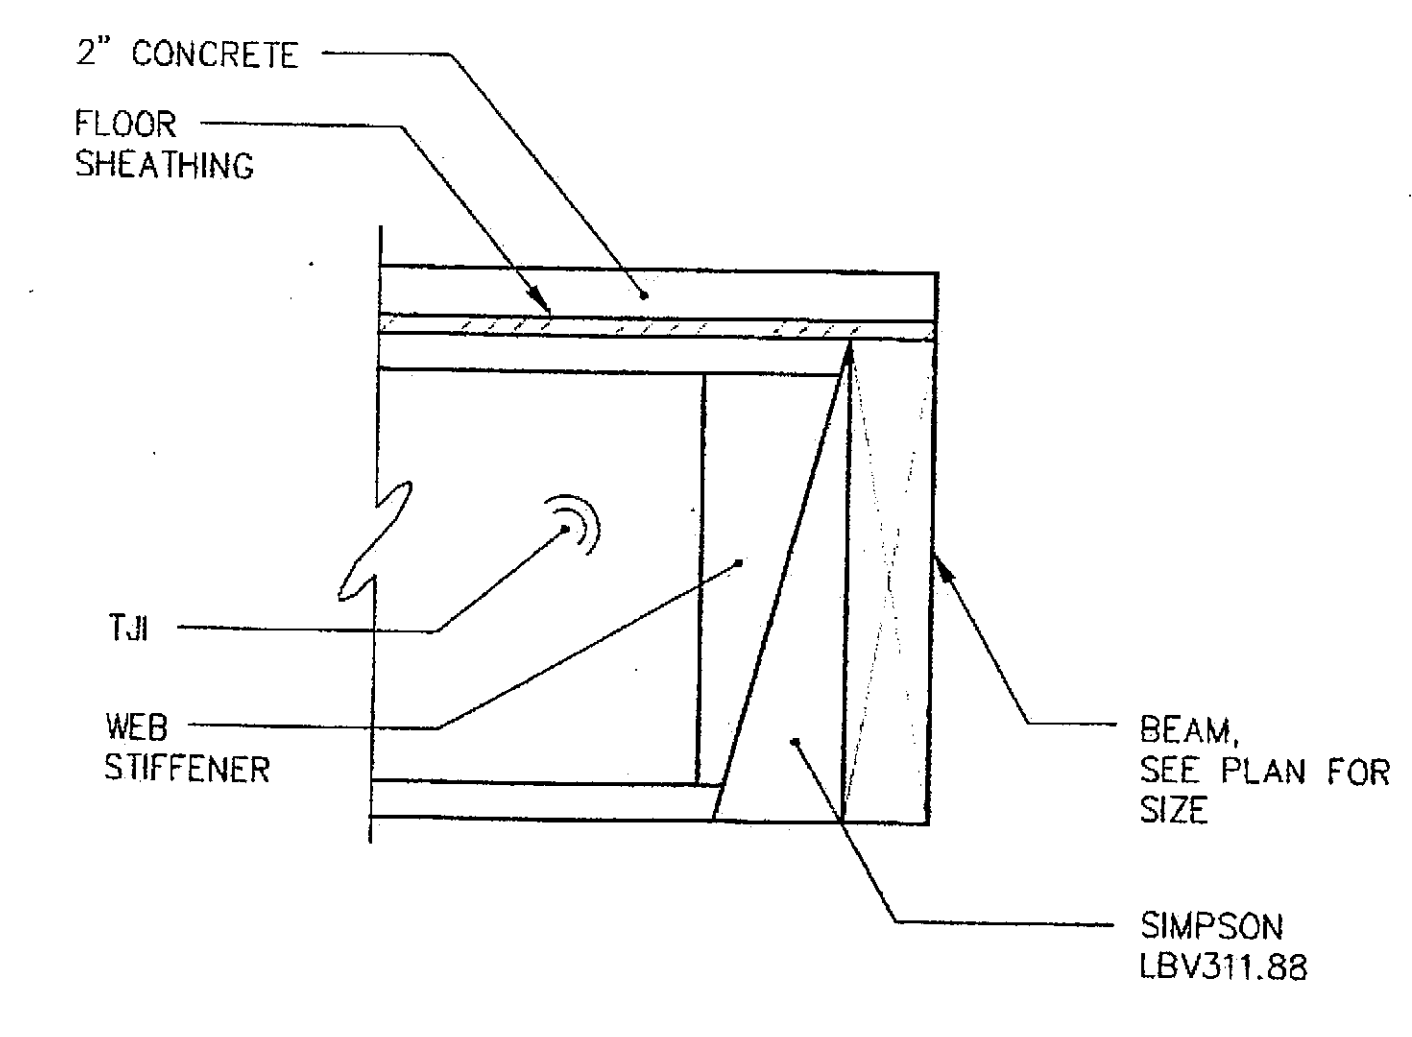


K SECTION

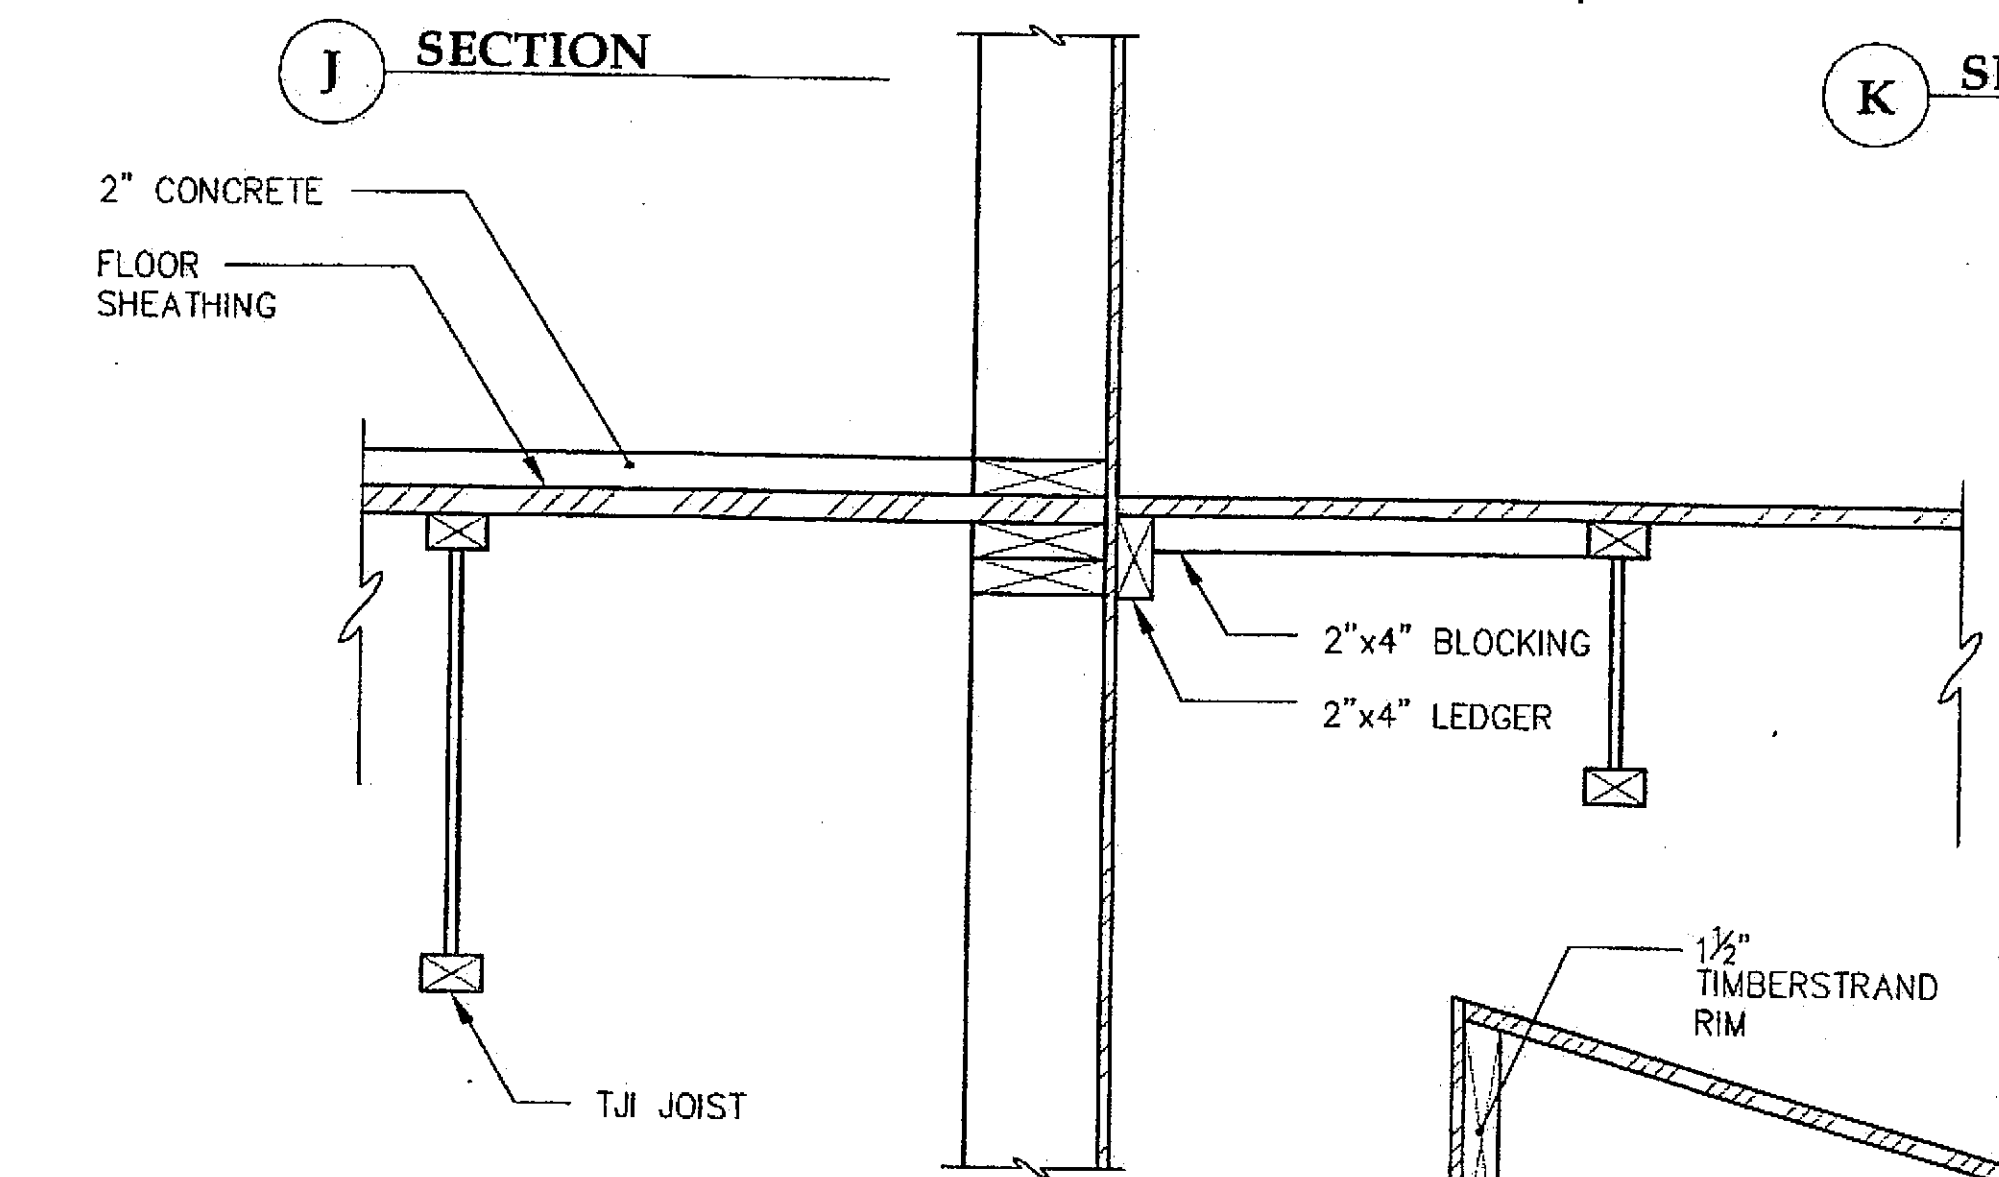


L SECTION

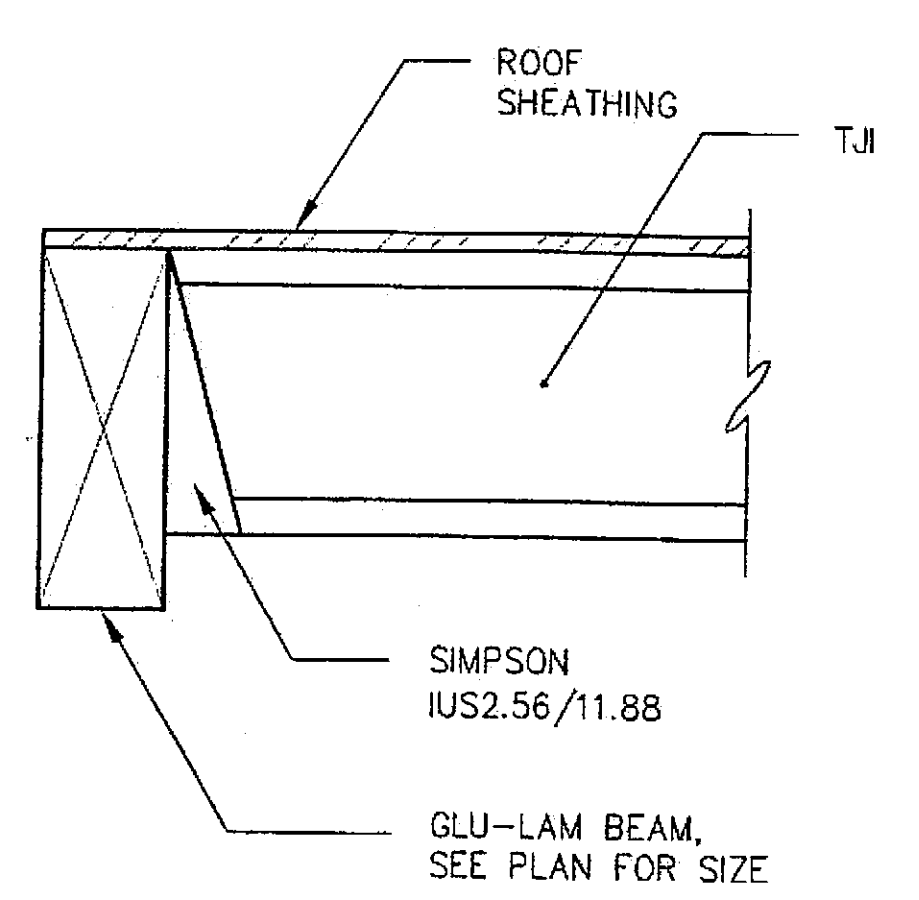

M SECTION AT CANOPY

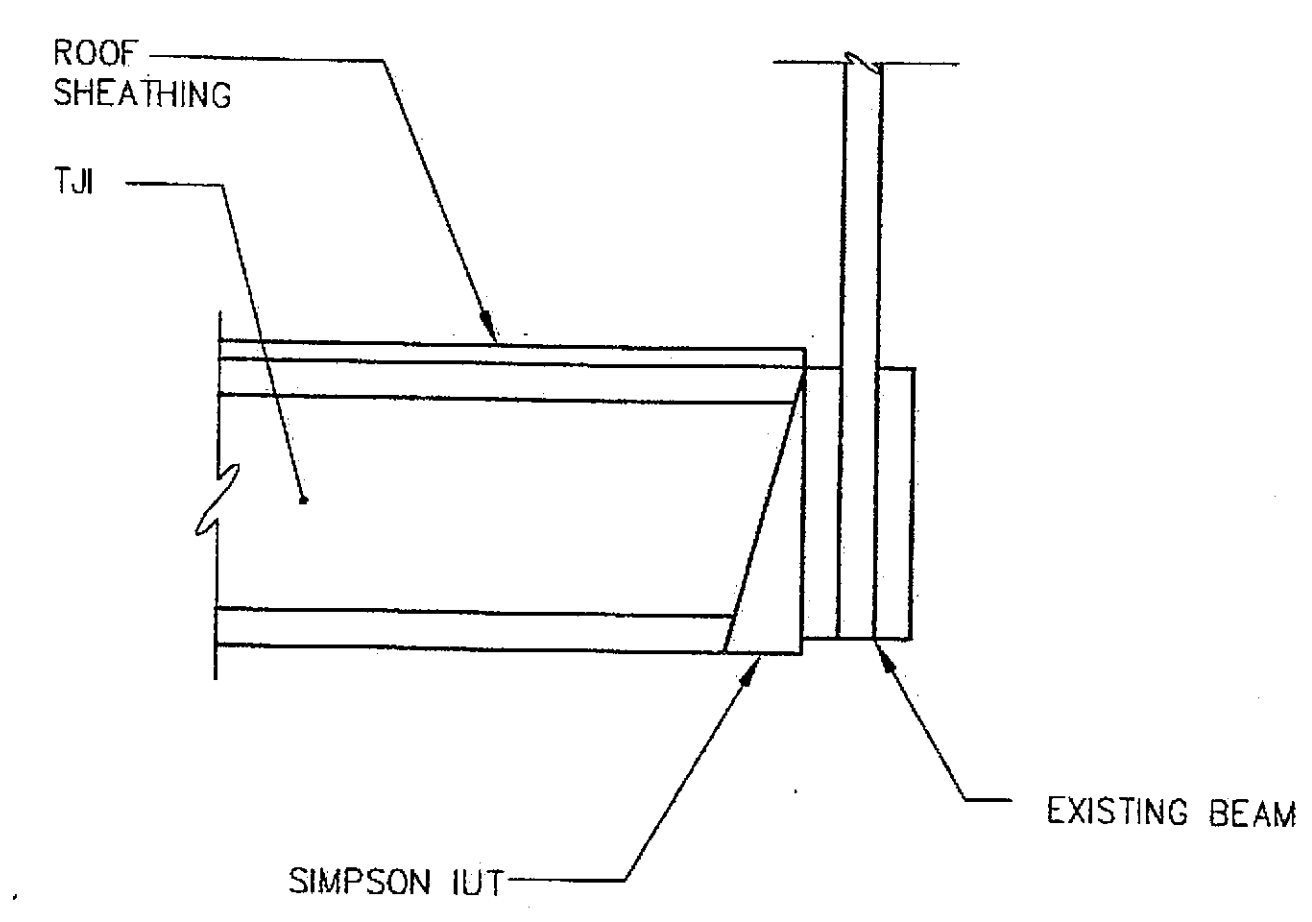

N SECTION AT CANOPY

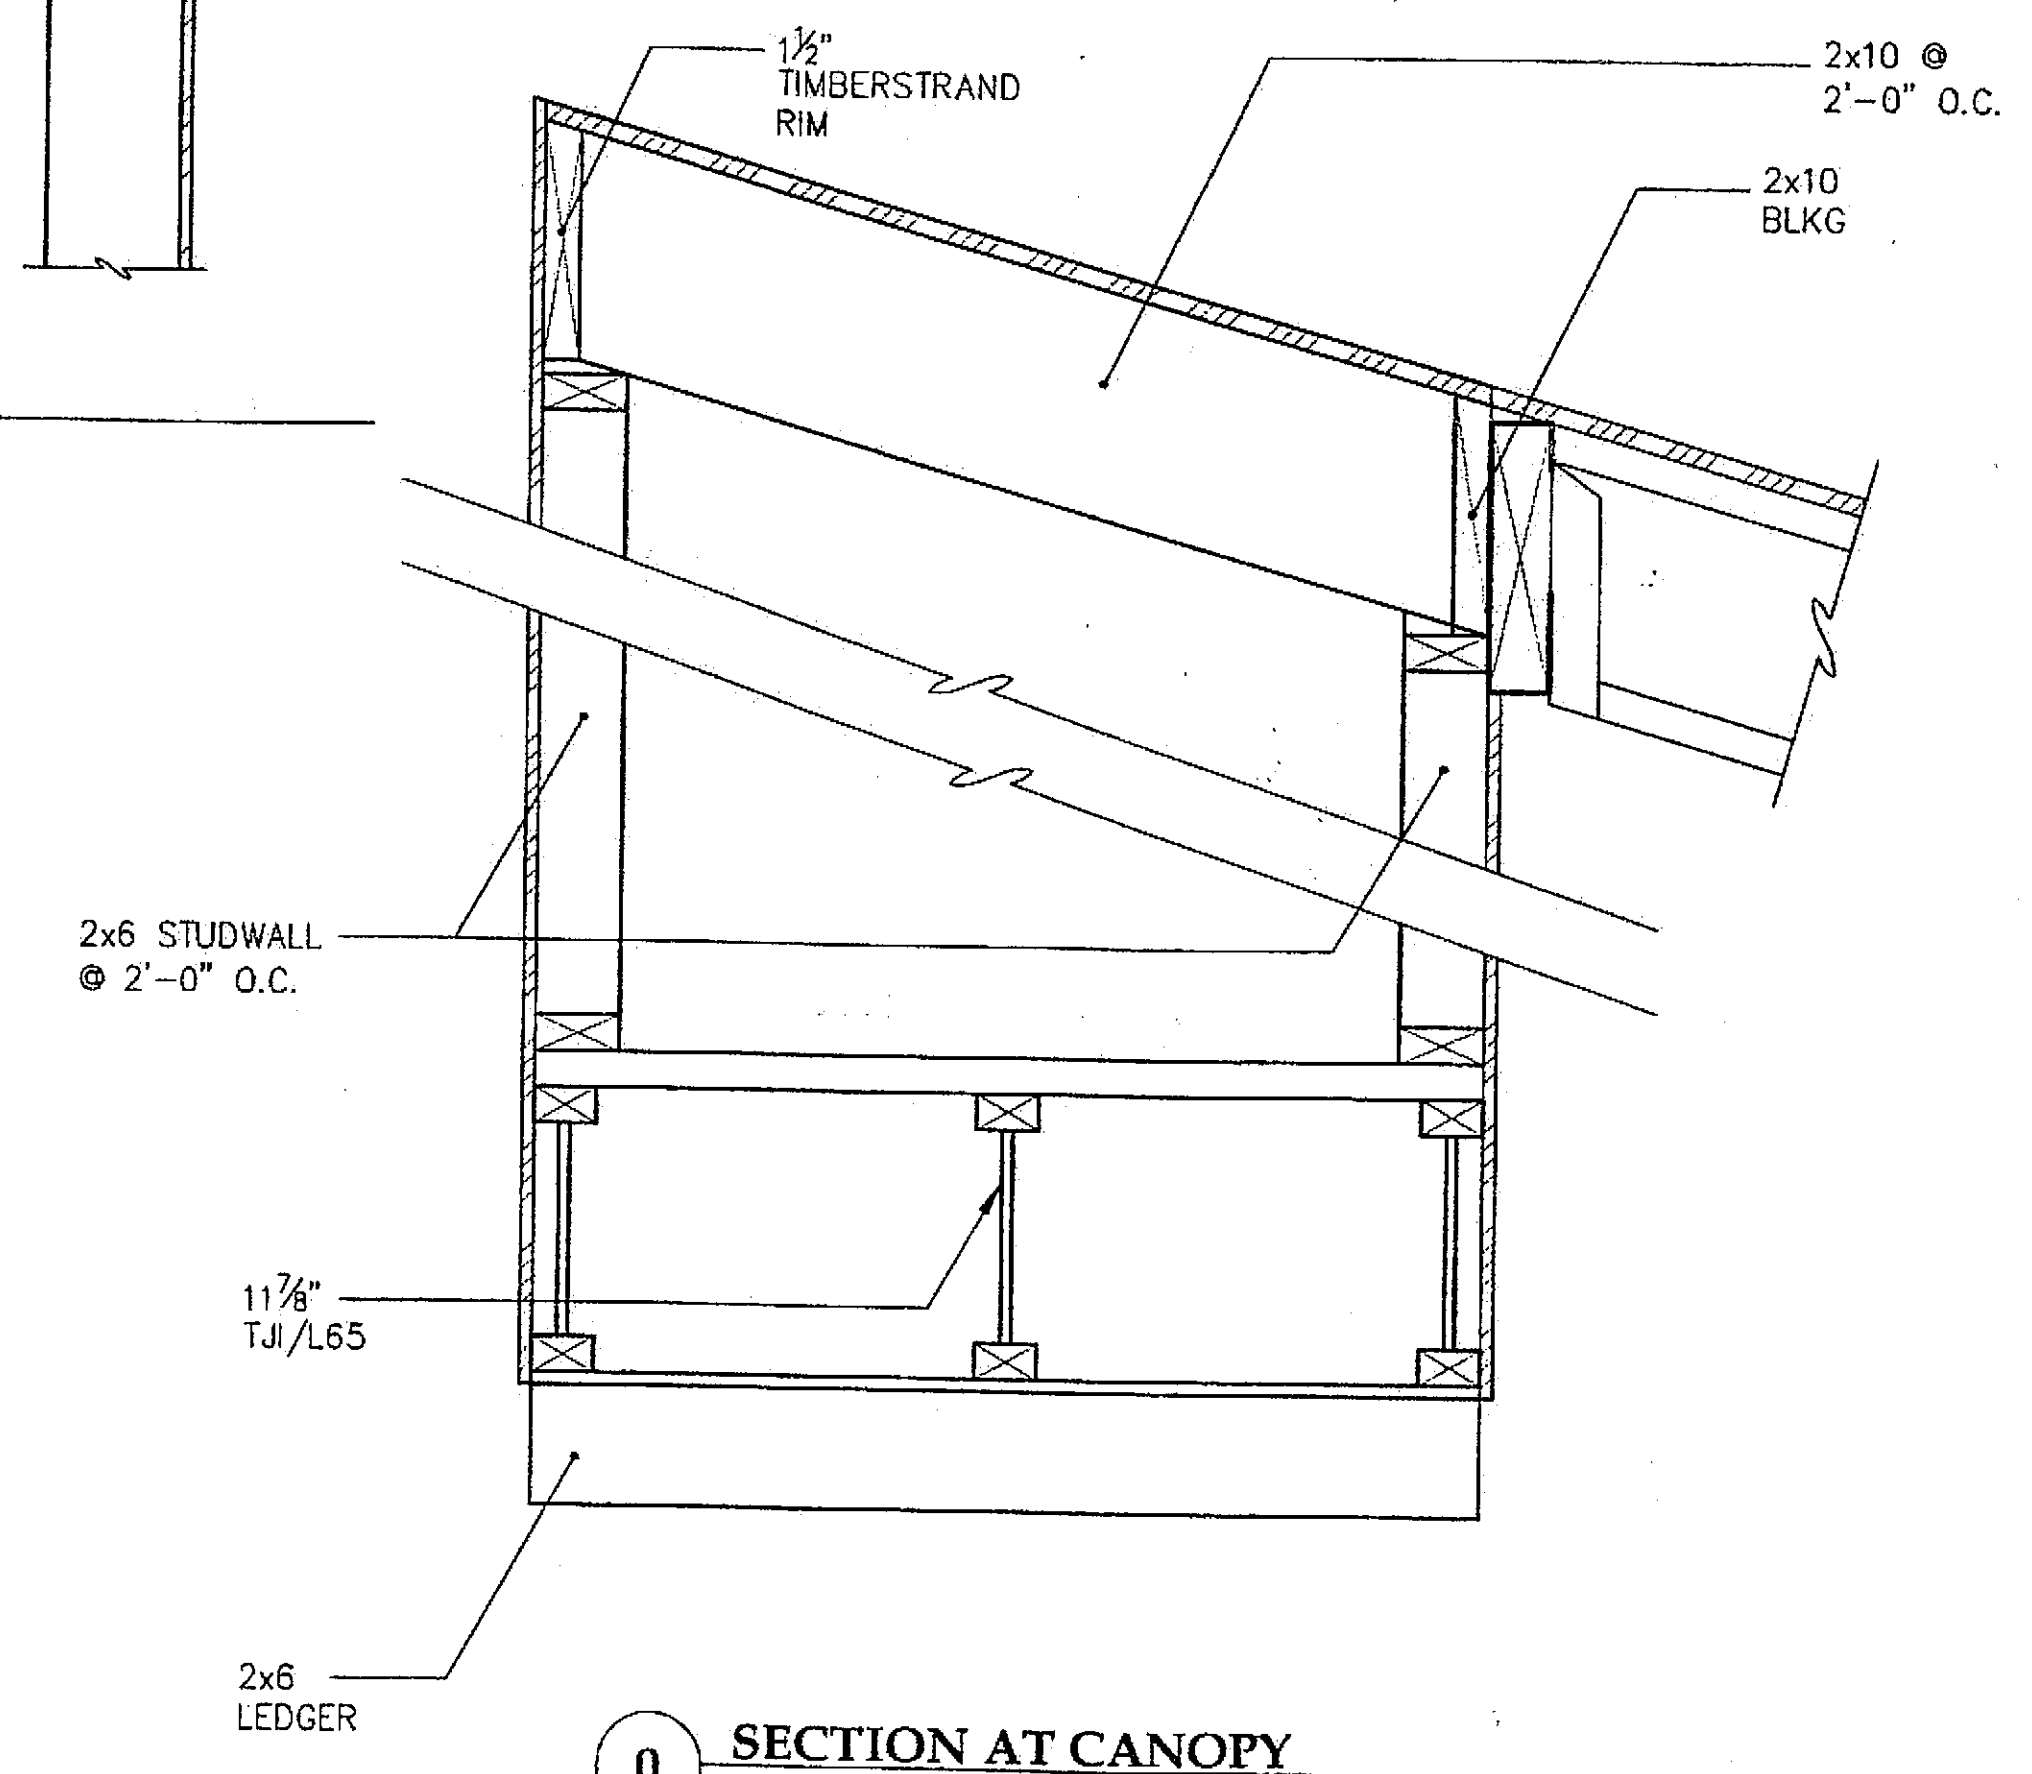

O SECTION AT CANOPY

Project As-Built Drawings have been reviewed by the Project Engineer and represent to the best of my knowledge, the project as constructed.
 Proj. Eng. *[Signature]* Date 7-07

Tue, 14/Dec/04 12:00PM		
ADDENDUM NUMBER		
ATTACHMENT NUMBER		
RECORD OF REVISIONS		
No.	DATE	DESCRIPTION


ADDENDUM NUMBER

ATTACHMENT NUMBER

RECORD OF REVISIONS

No.	DATE	DESCRIPTION

NOTE: SEE BASE
BID PLAN FOR
CALLOUTS NOT
SHOWN.


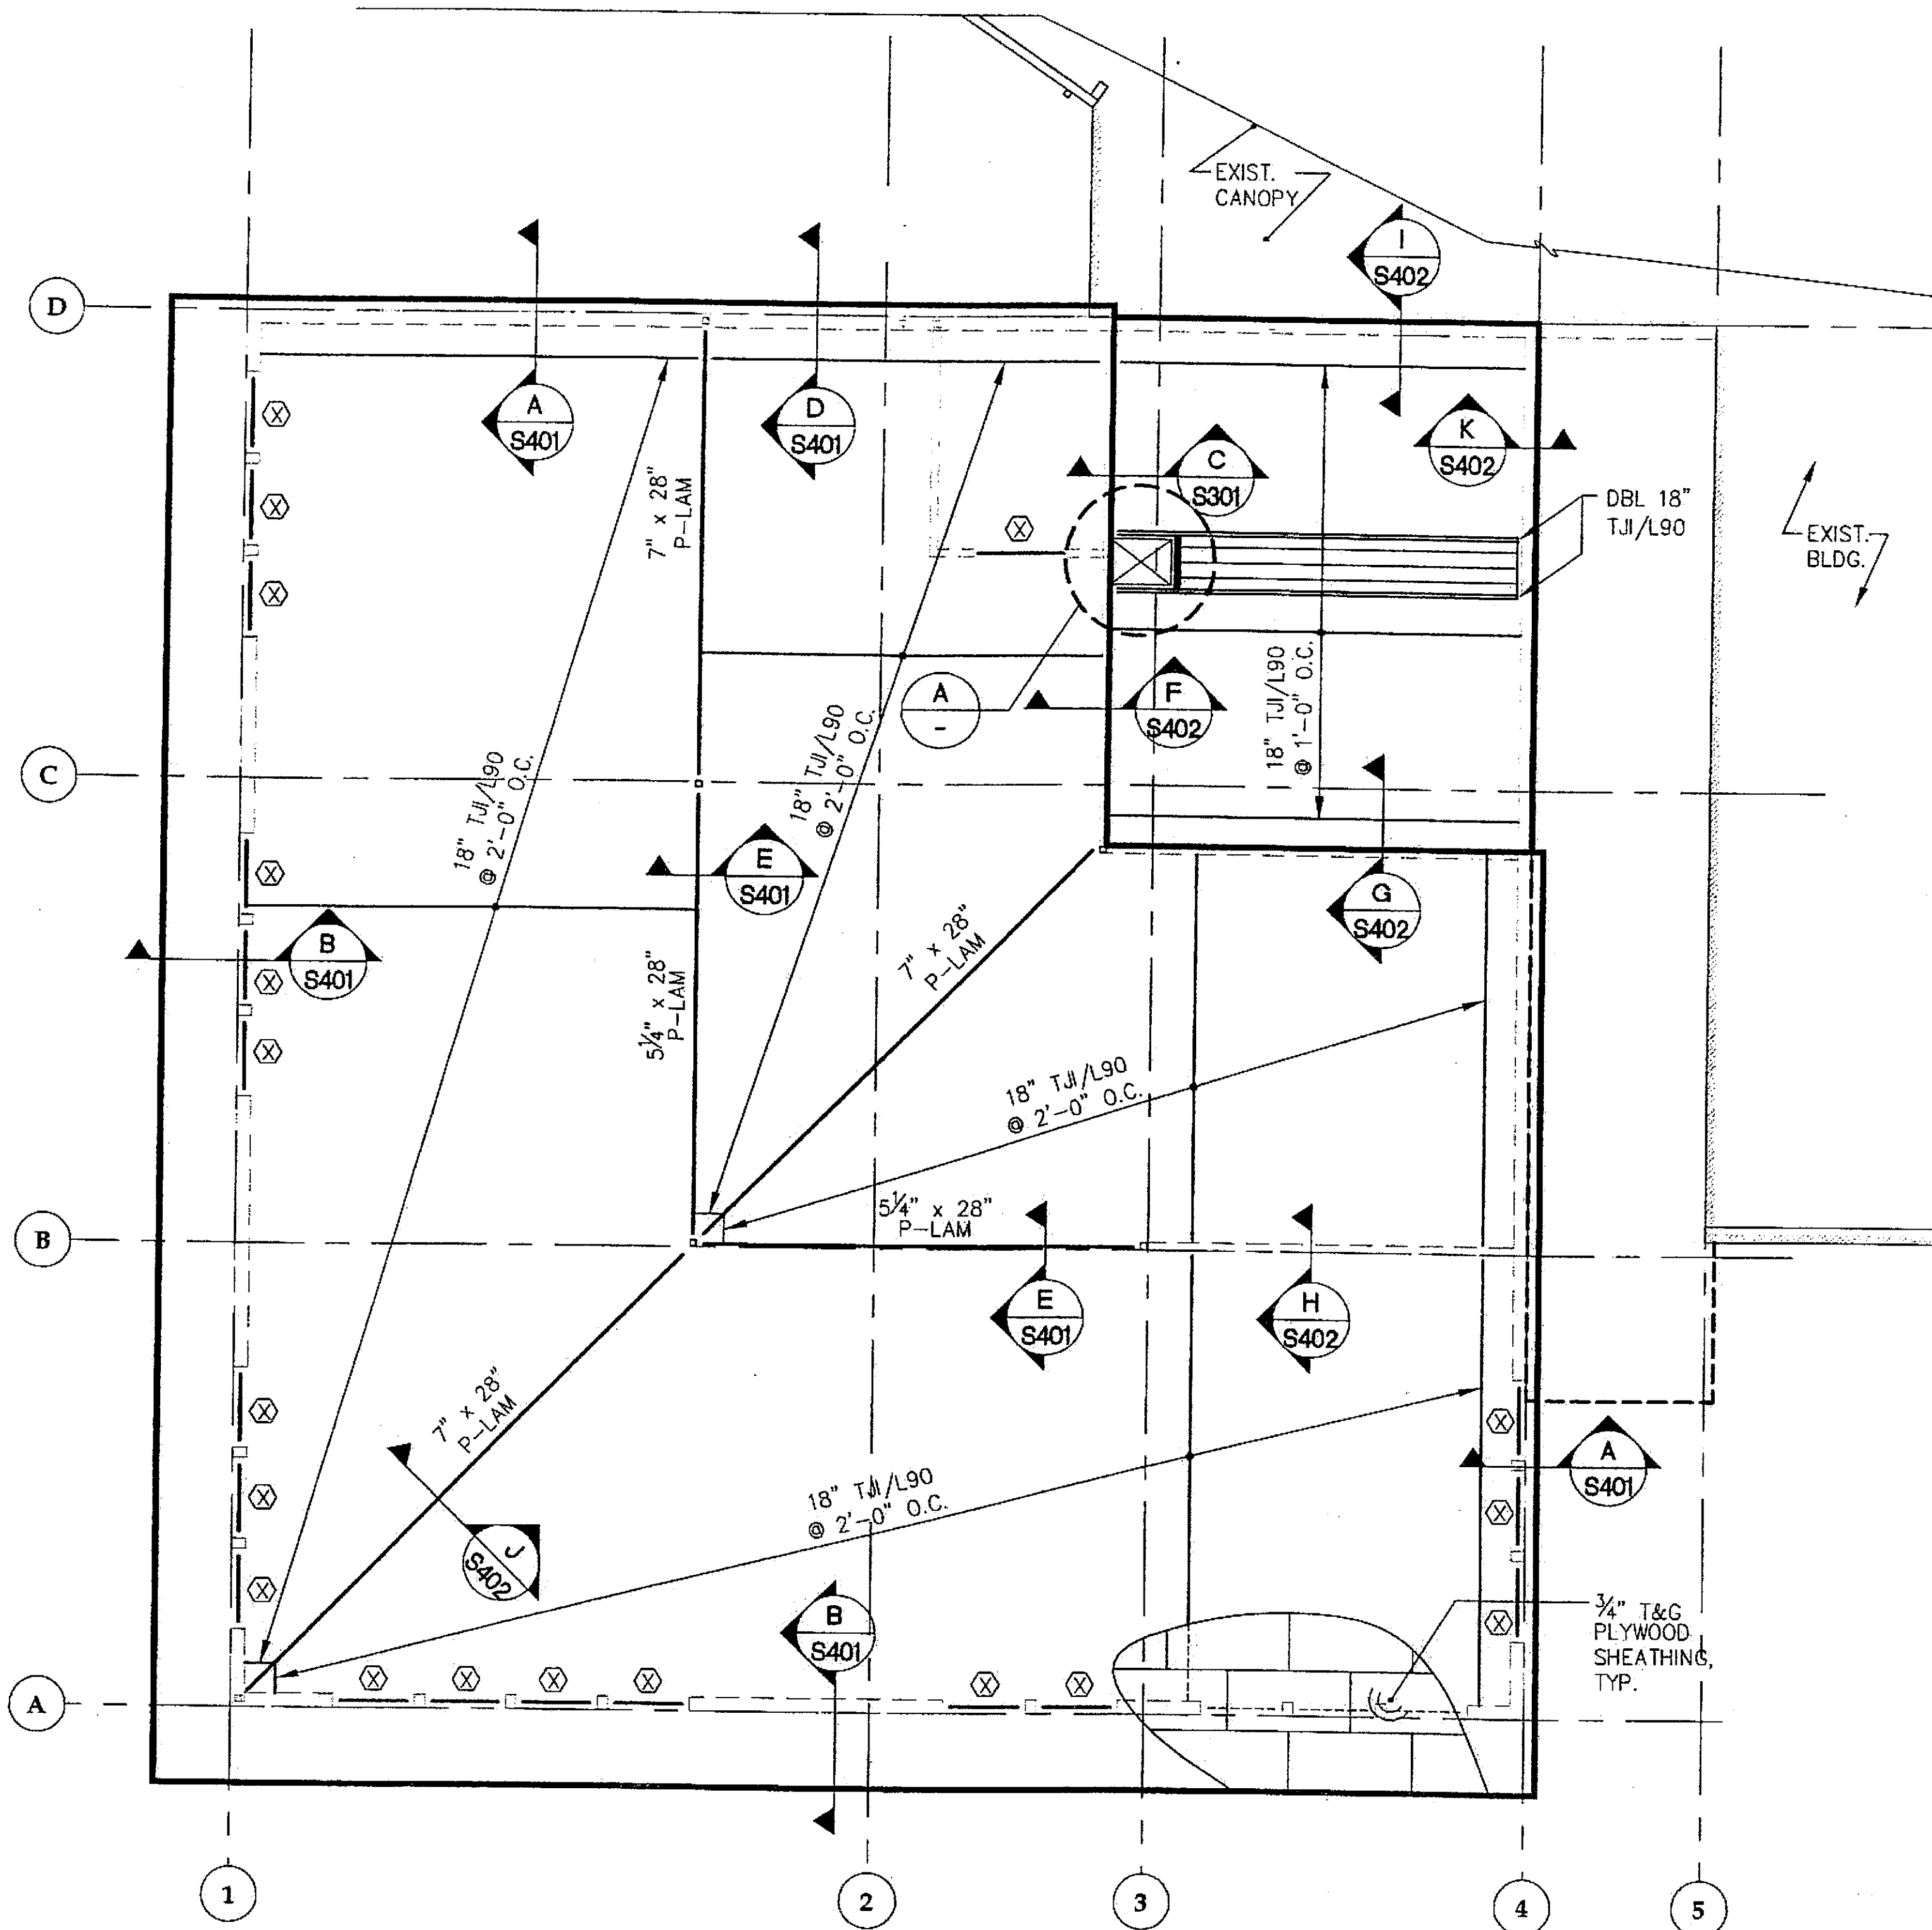


**1 ROOF FRAMING PLAN
BASE BID**

NOTES:



1. (1) INDICATES STUDWALL TYPE, SEE SCHEDULE.
2. (A) INDICATES SHEAR WALL TYPE, SEE SCHEDULE.

SCALE: 0 4' 8' 16'

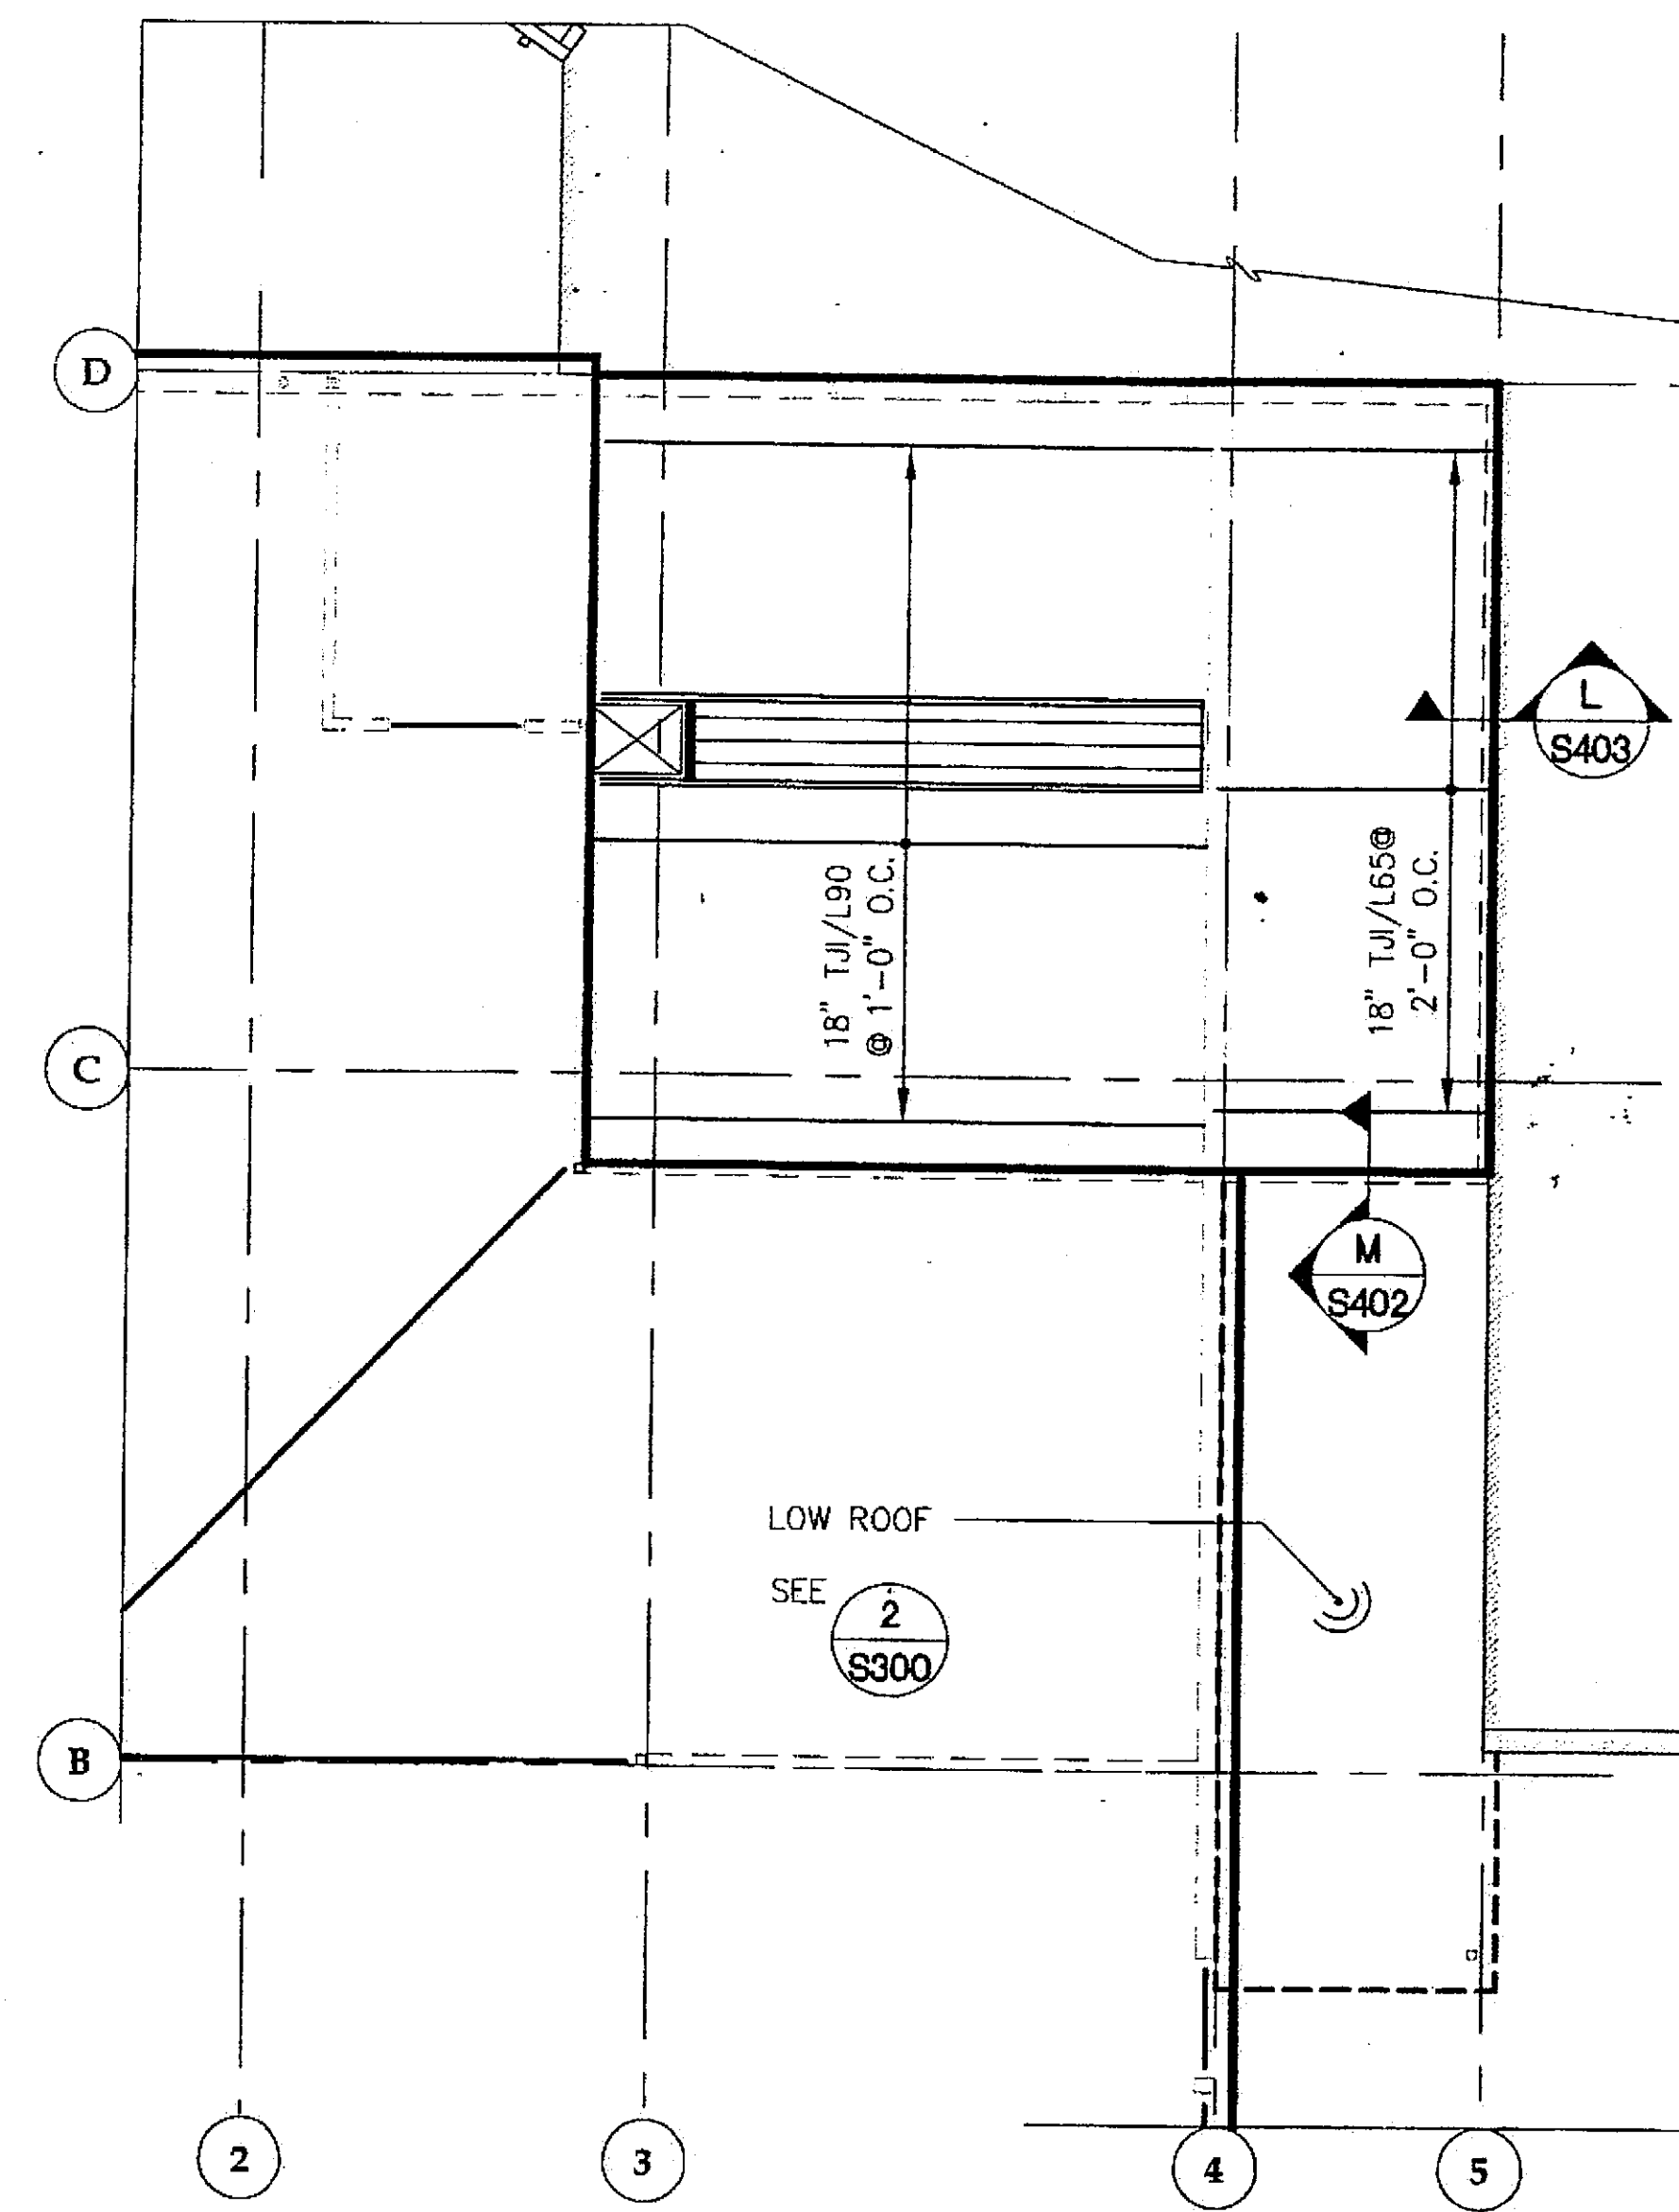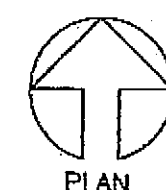

**2 ROOF FRAMING PLAN
ALTERNATE**

SCALE: 0 4' 8' 16'

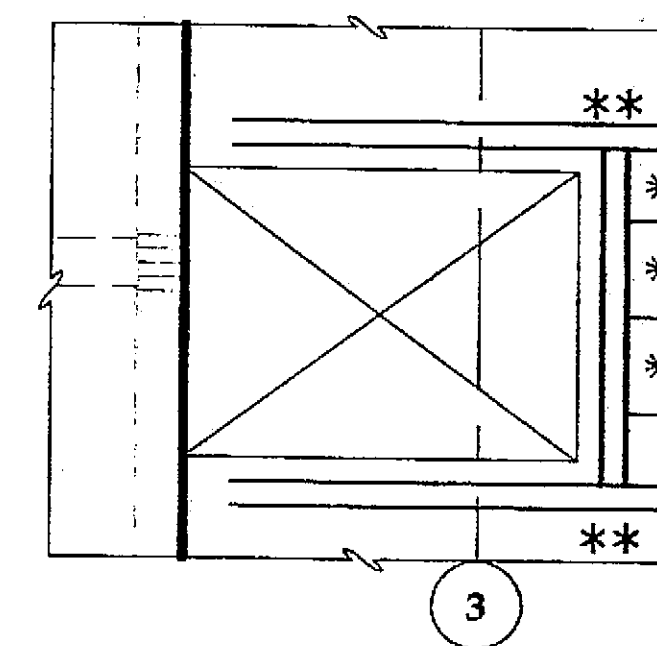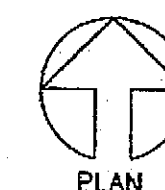


A CONNECTION DETAIL

* SIMPSON
MIT418

** SIMPSON
WPI418-2

Project As-Built Drawings have been
reviewed by the Project Engineer and
represent to the best of my knowledge, the
project as constructed.
Proj. Eng. *[Signature]* Date *7-01*

CHECKED BY:

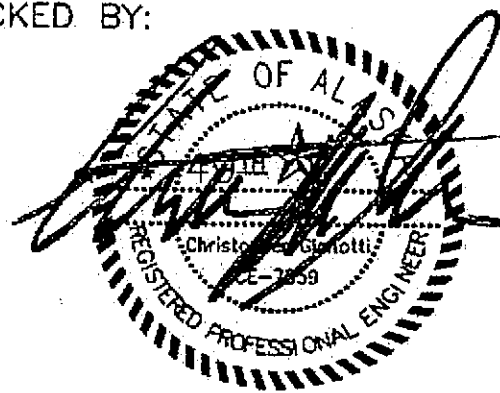

DESIGNED BY: BCN

DRAWN BY: PJD

STATE OF ALASKA
DEPARTMENT OF TRANSPORTATION
& PUBLIC FACILITIES
STATEWIDE DESIGN & ENGINEERING
SERVICES DIVISION

MT EDGECUMBE
HIGH SCHOOL
BUILDING 1330
ACADEMIC
EXPANSION

SHEET S400

PROJECT DESIGNATION NUMBER

67751C

STATE	YEAR
ALASKA	2004
SHEET NUMBER	TOTAL SHEETS
50	79


Tue, 14/Dec/04 12:00PM

ADDENDUM NUMBER

ATTACHMENT NUMBER


RECORD OF REVISIONS

No.	DATE	DESCRIPTION

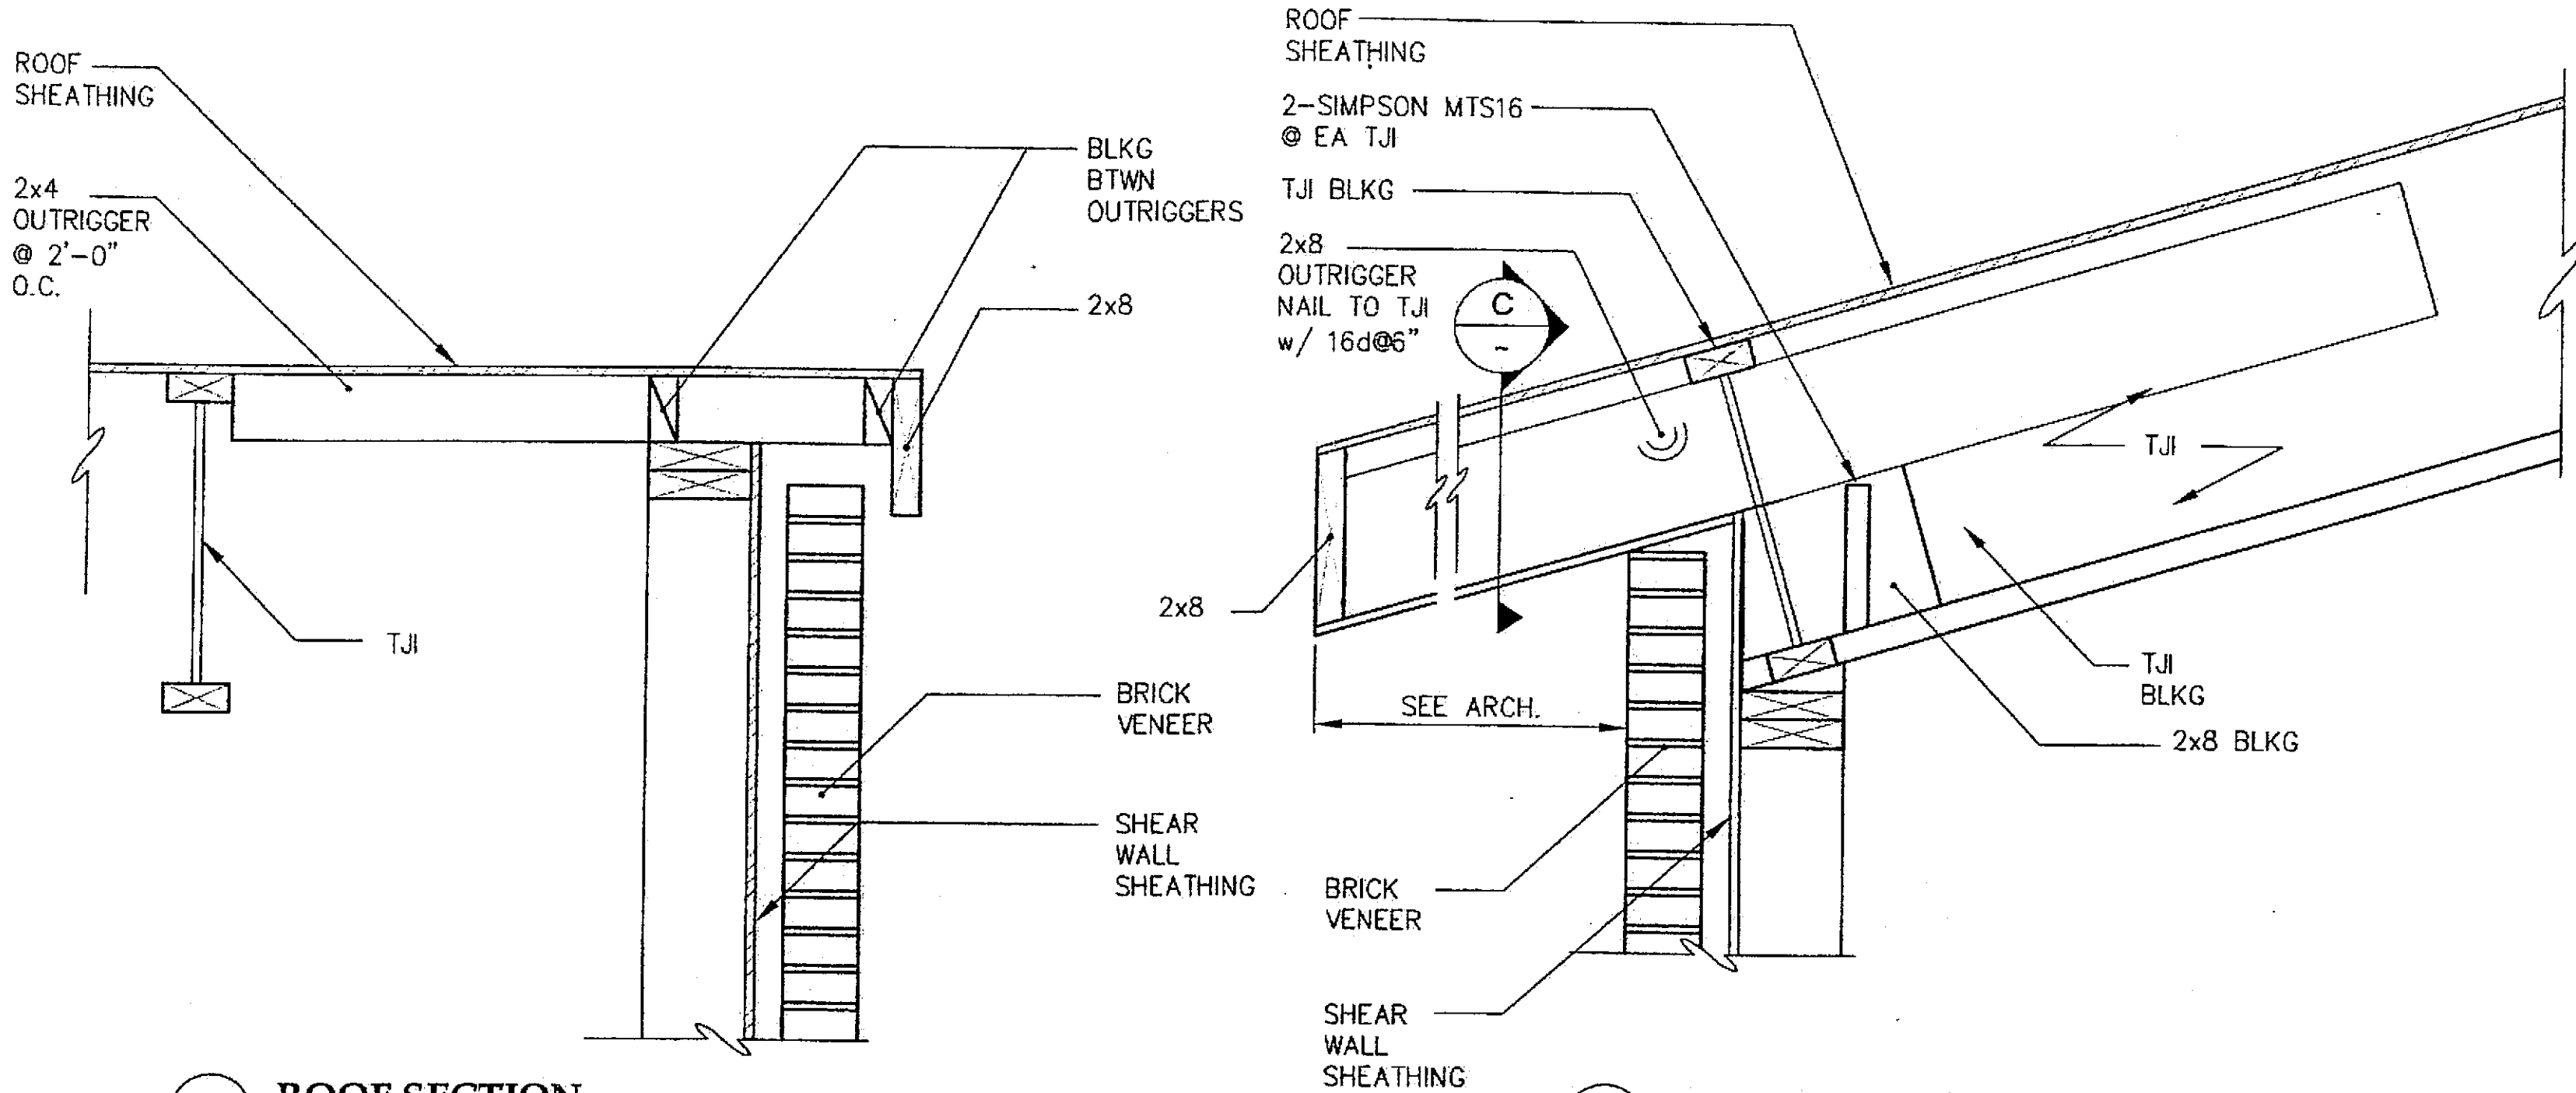


A ROOF SECTION AT EXTERIOR WALL


B ROOF SECTION AT EXTERIOR WALL

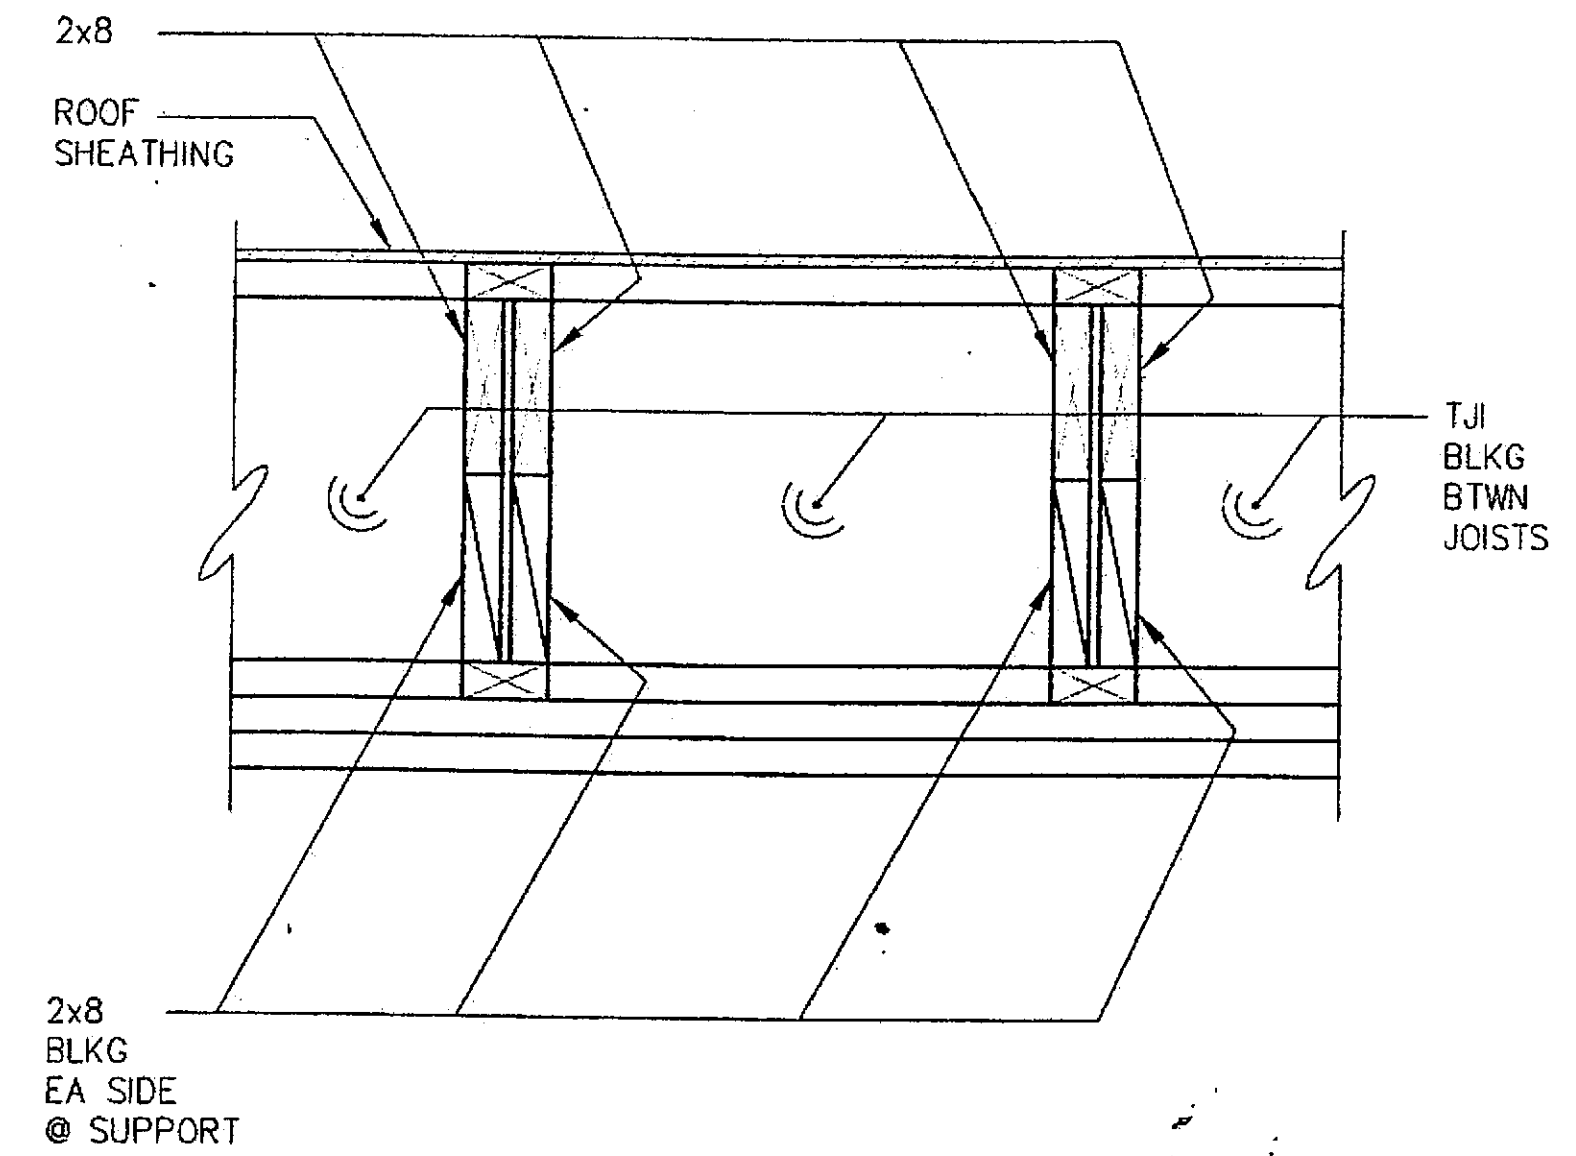

C ROOF SECTION AT EXTERIOR WALL

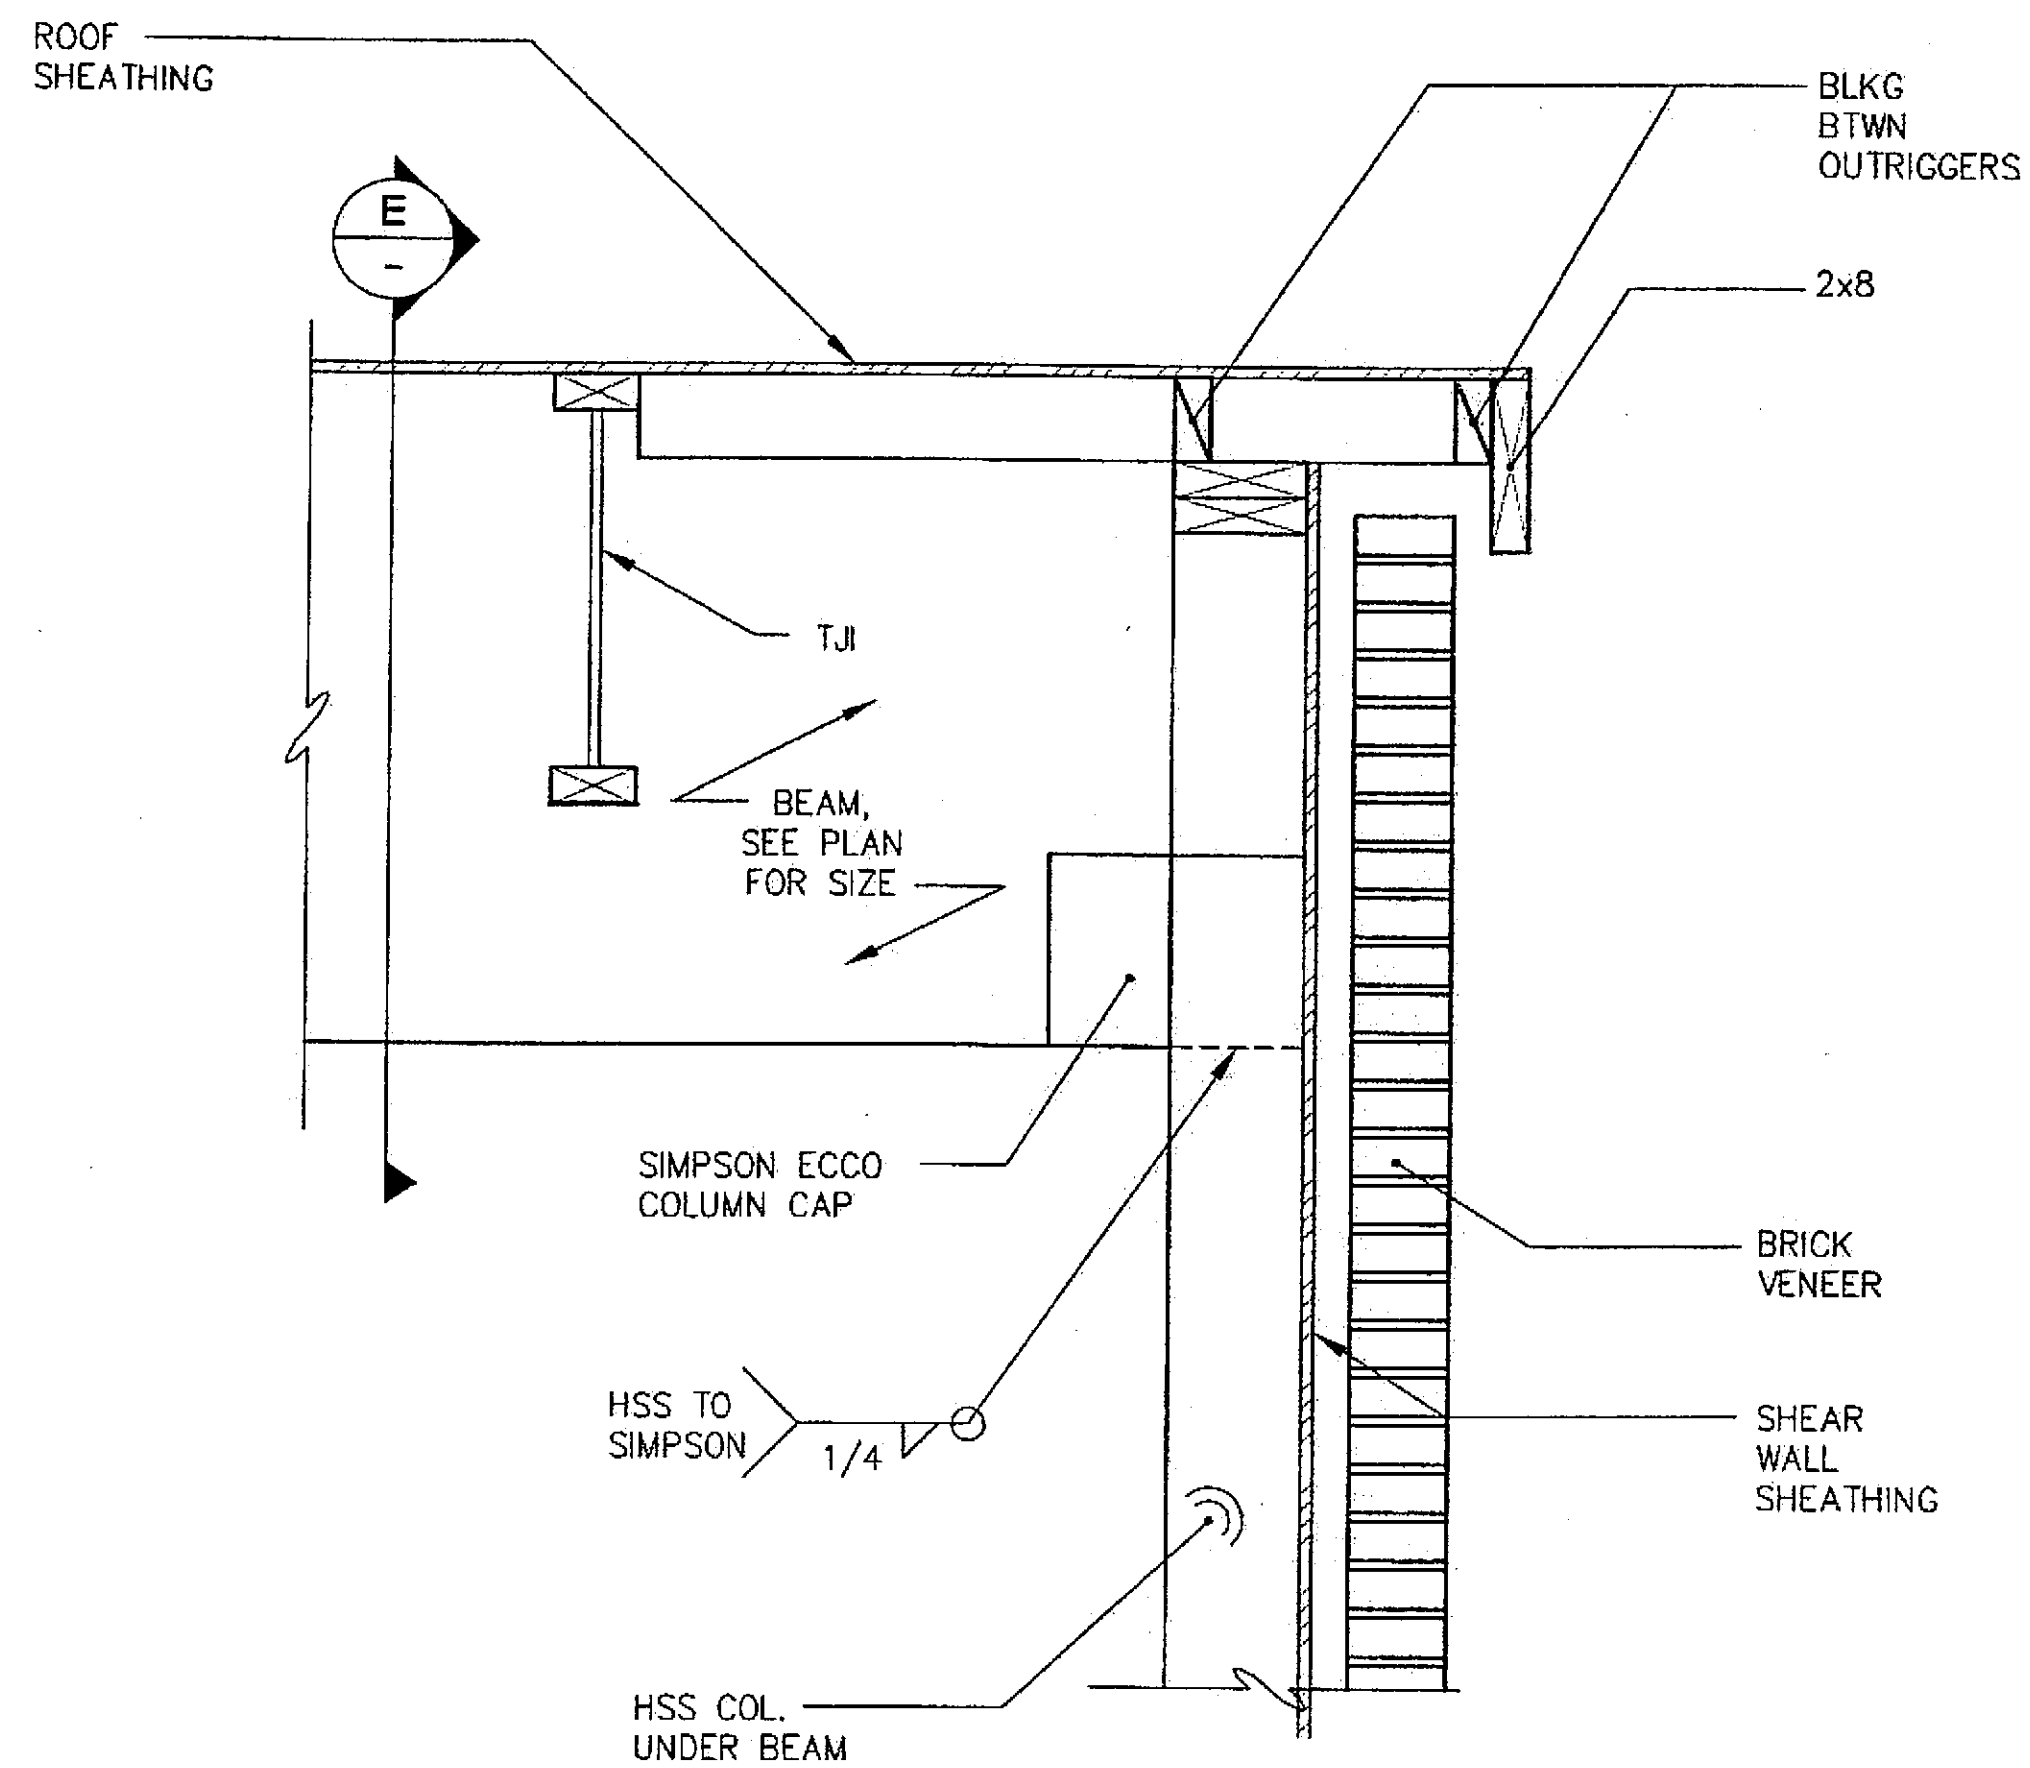

D ROOF SECTION AT BEAM

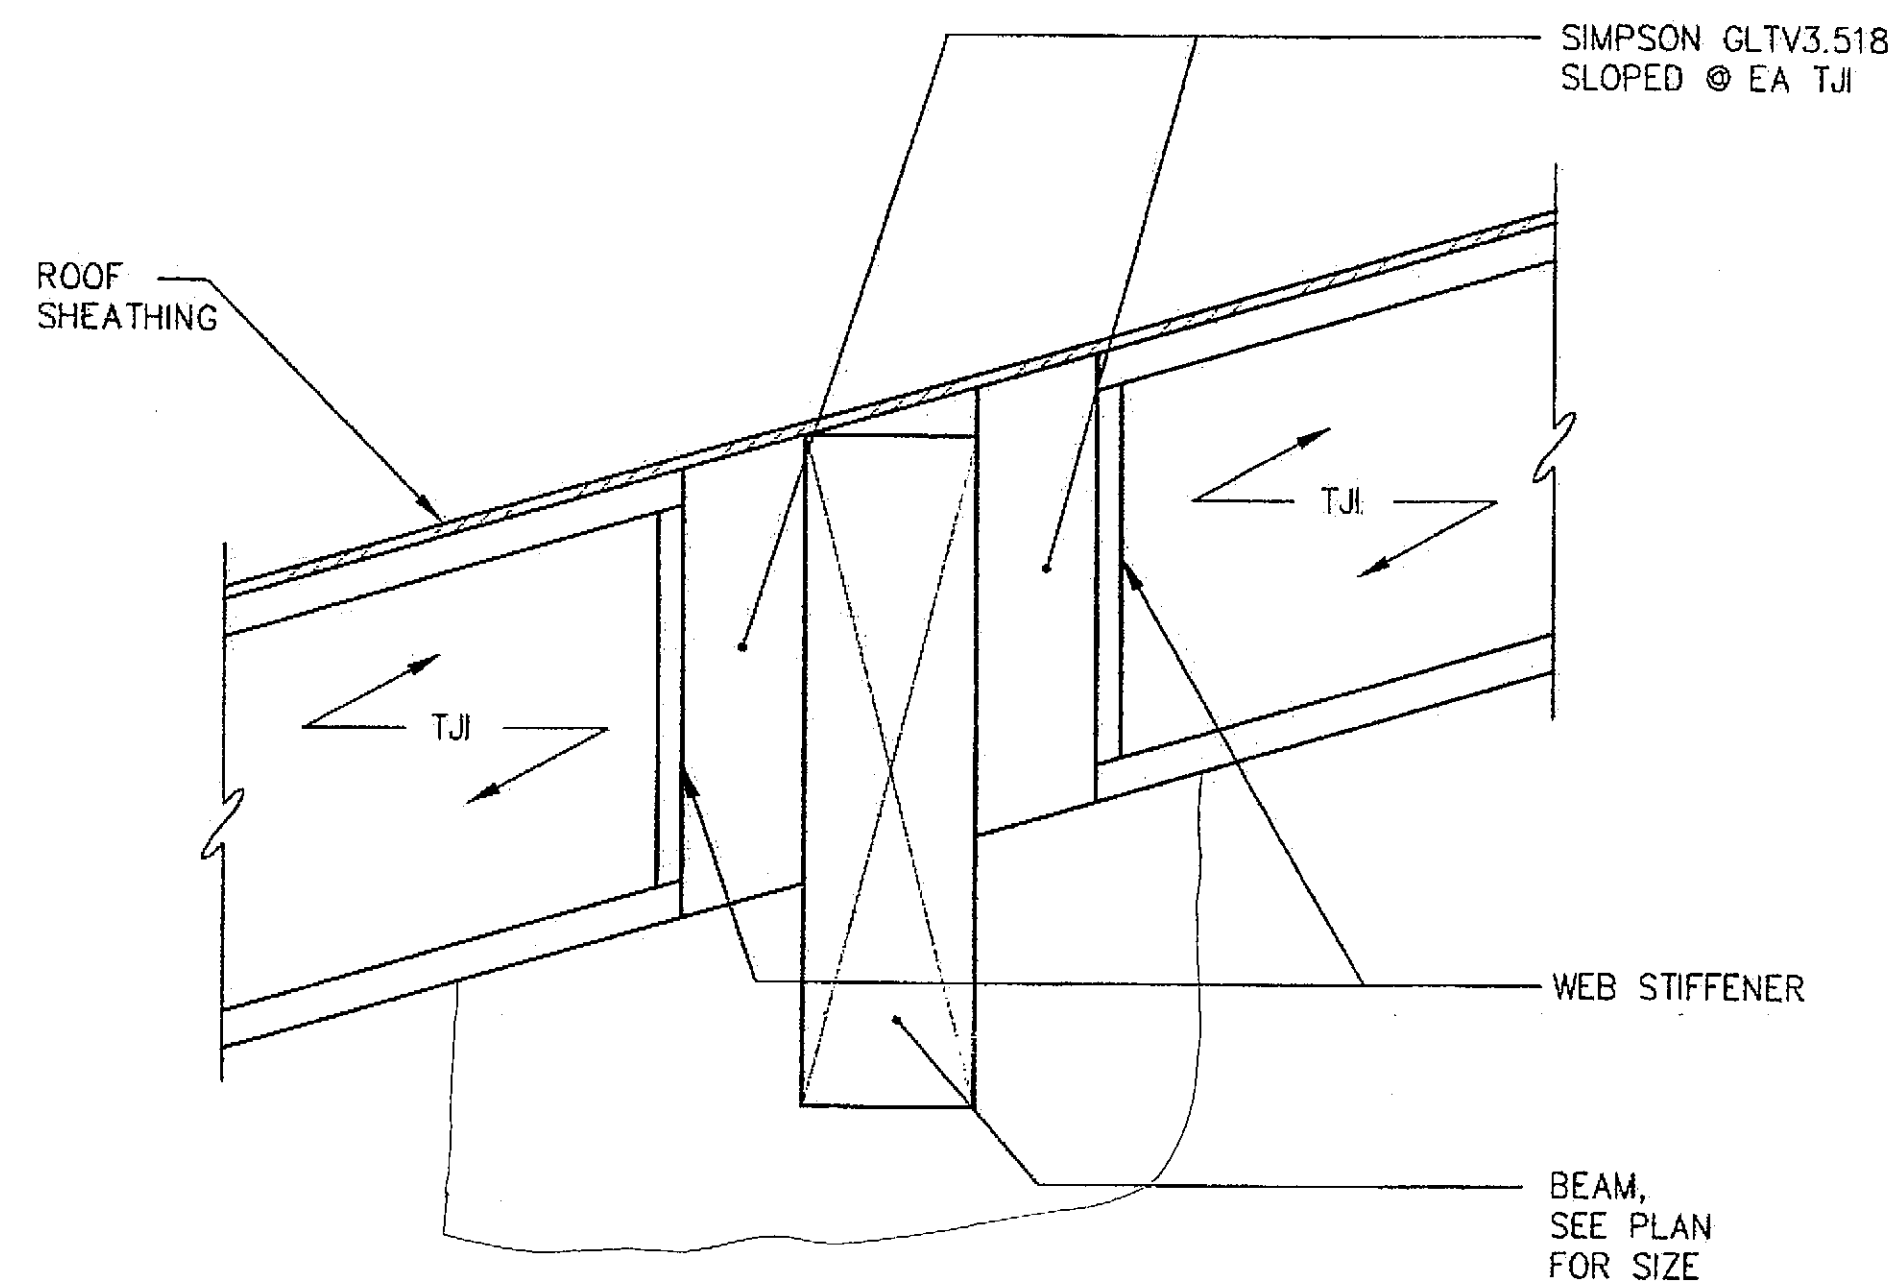

E ROOF SECTION AT BEAM

CHECKED BY:



DESIGNED BY: BCN

DRAWN BY: PJD

STATE OF ALASKA
DEPARTMENT OF TRANSPORTATION
& PUBLIC FACILITIES
STATEWIDE DESIGN & ENGINEERING
SERVICES DIVISION
MT EDGECUMBE
HIGH SCHOOL
BUILDING 1330
ACADEMIC
EXPANSION

SHEET S401

PROJECT DESIGNATION NUMBER

67751C


STATE YEAR

ALASKA 2004


SHEET NUMBER TOTAL SHEETS

51 79


Project As-Built Drawings have been reviewed by the Project Engineer and represent to the best of my knowledge, the project as constructed.
Proj. Eng. *[Signature]* Date *2/07*

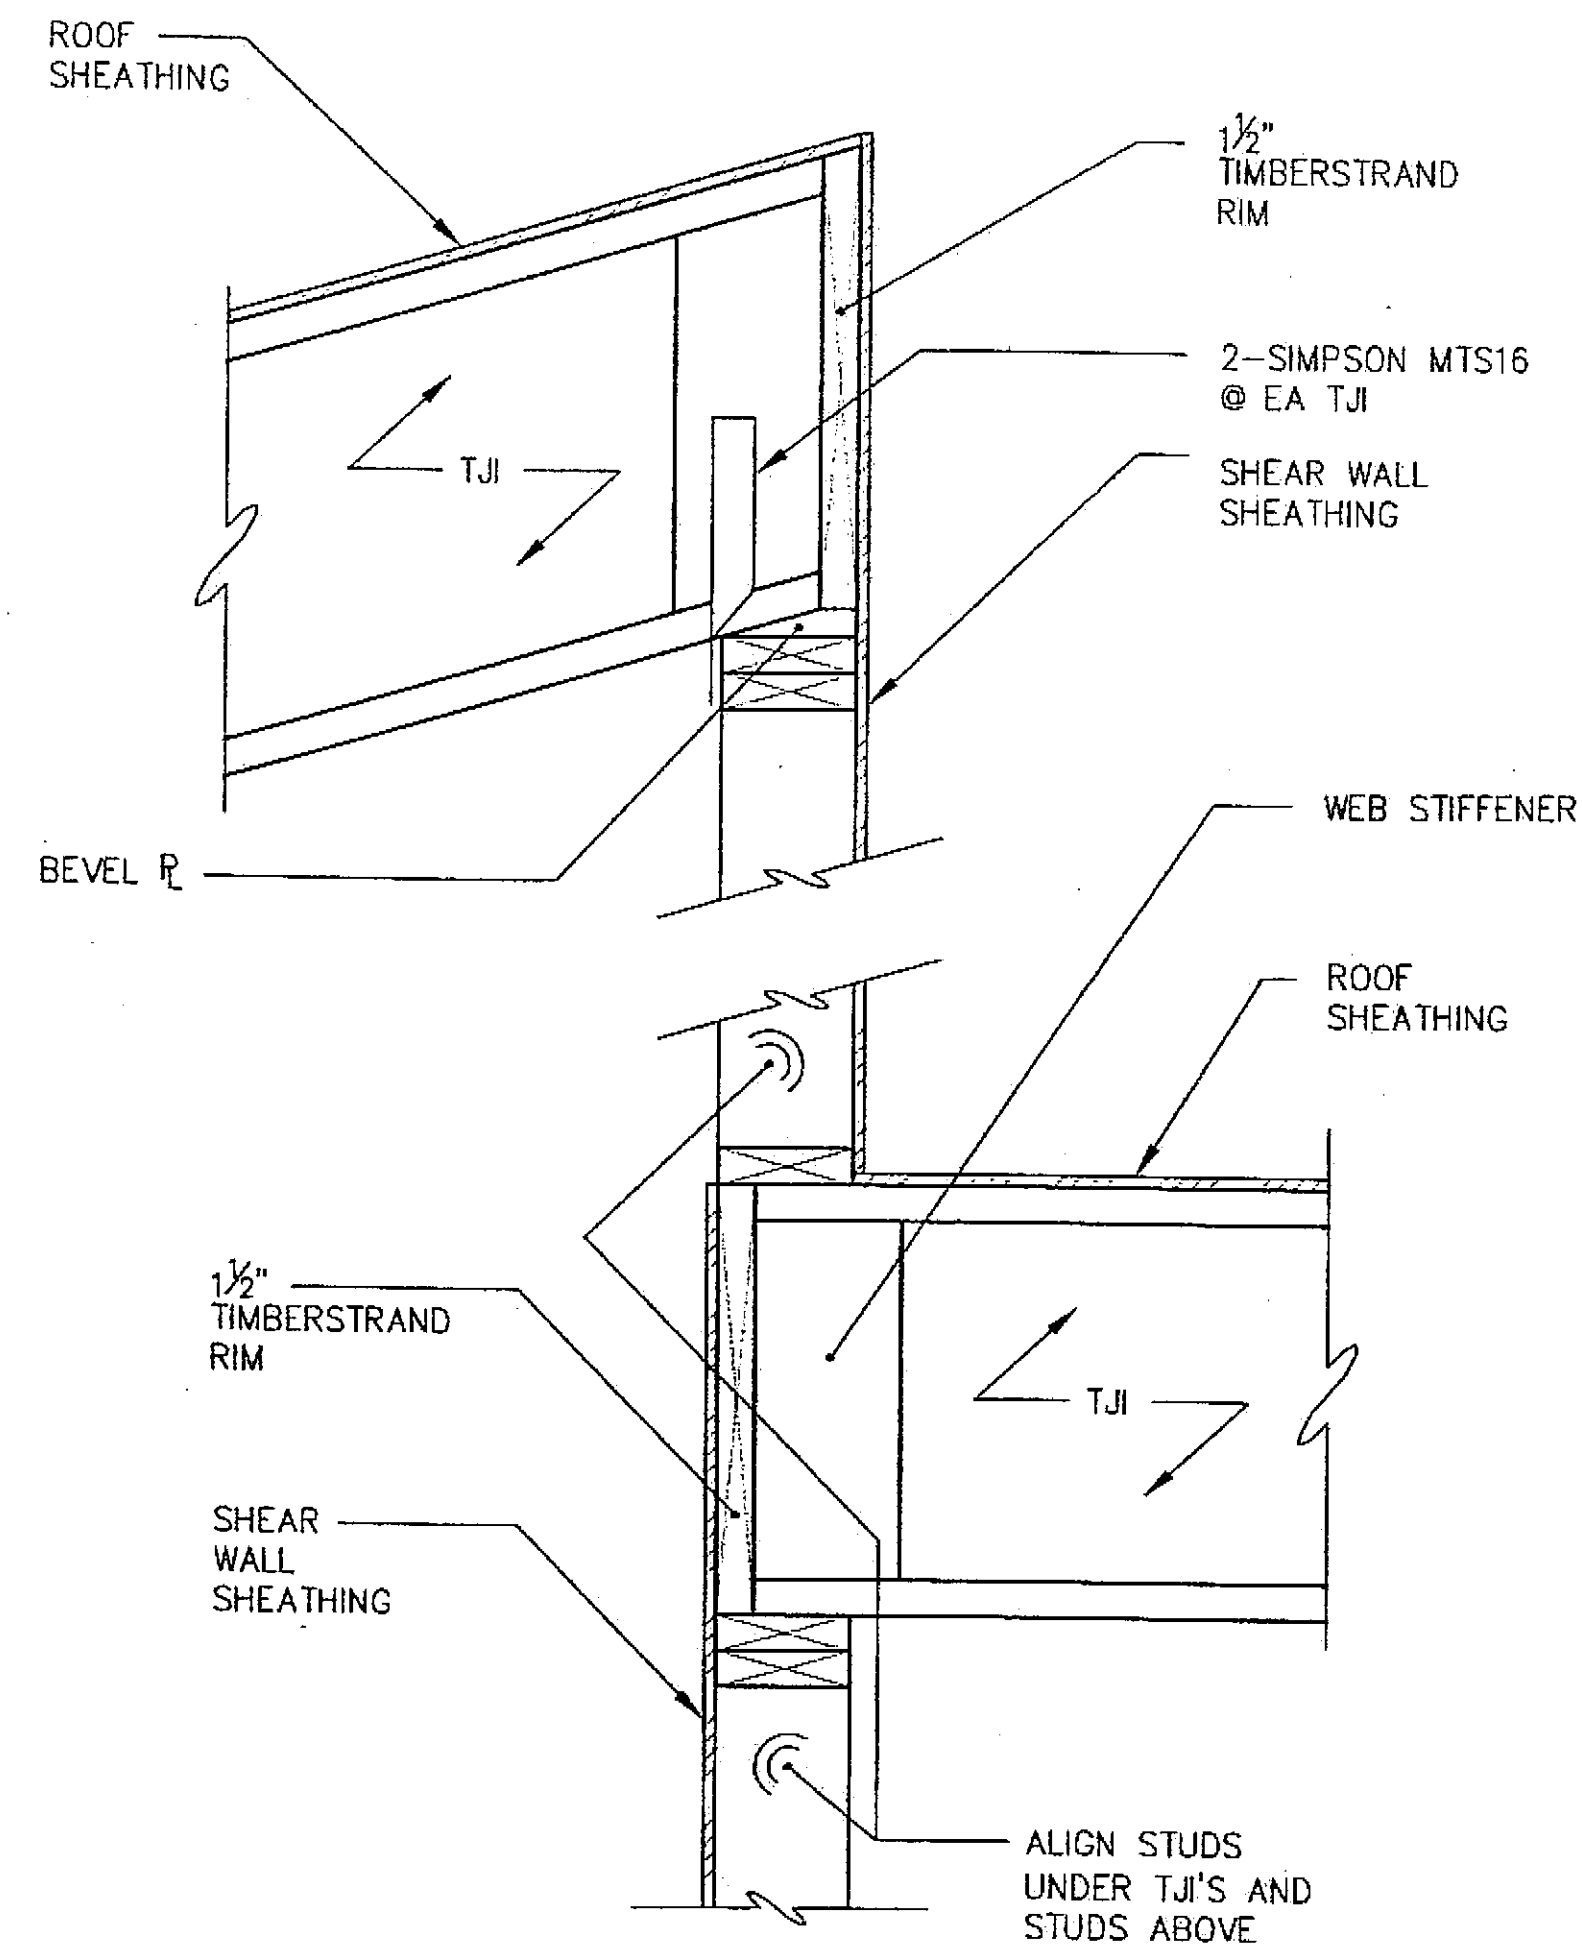


F ROOF SECTION
AT INTERIOR WALL

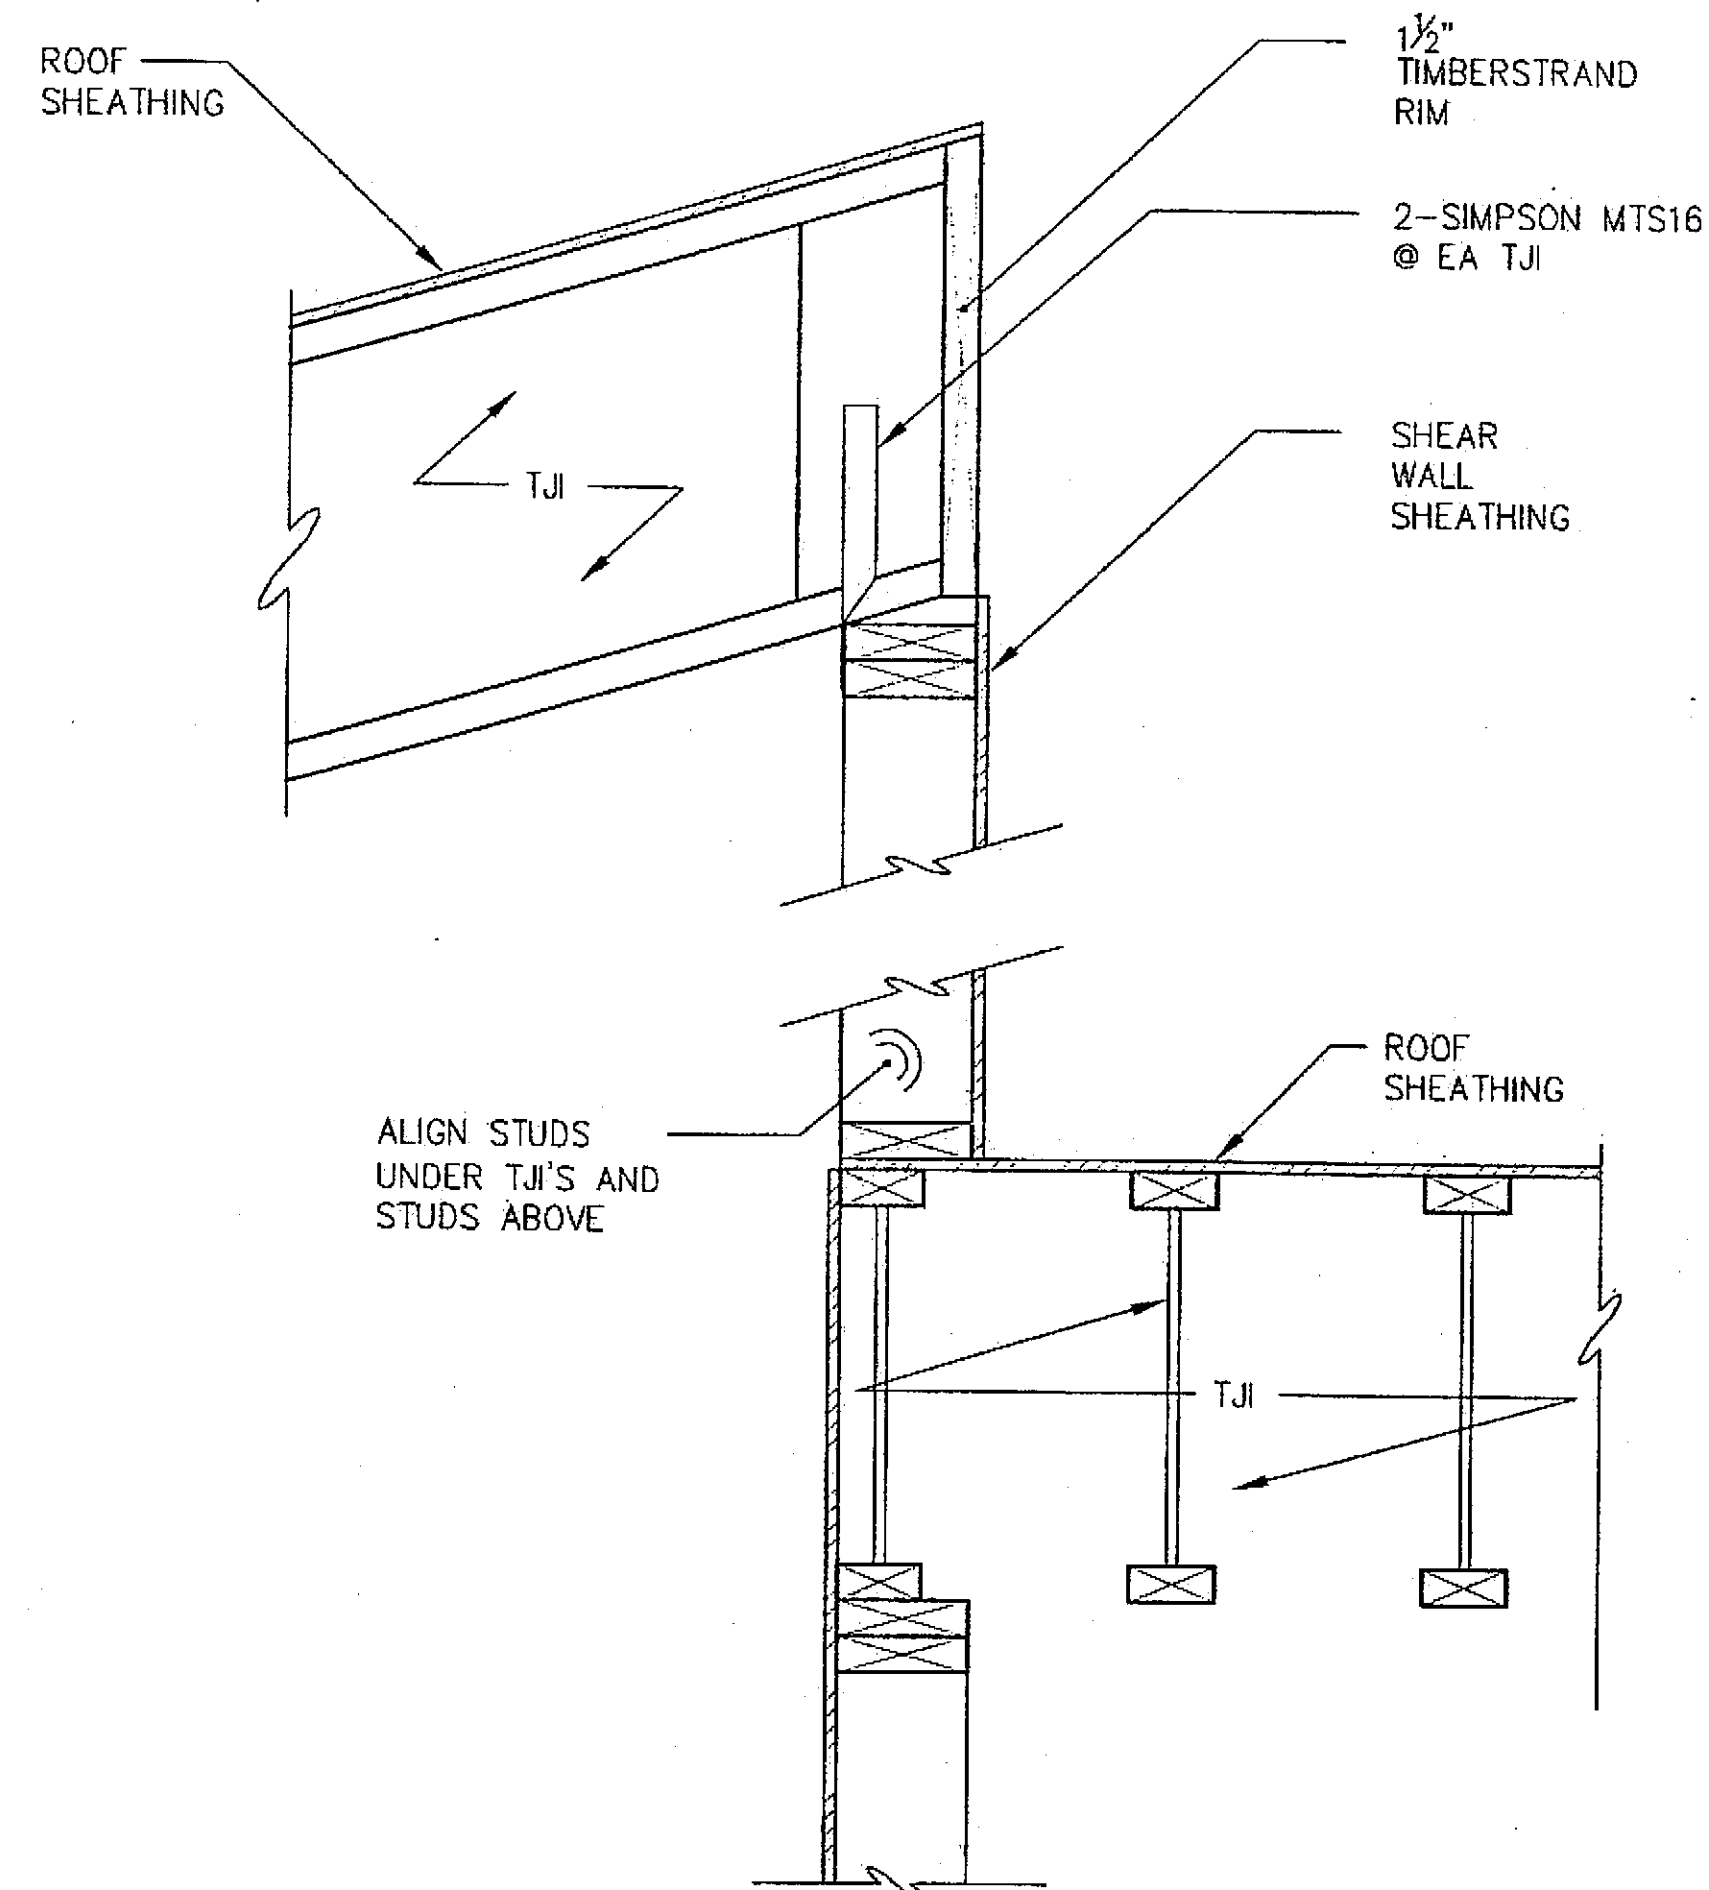


G ROOF SECTION
AT INTERIOR WALL

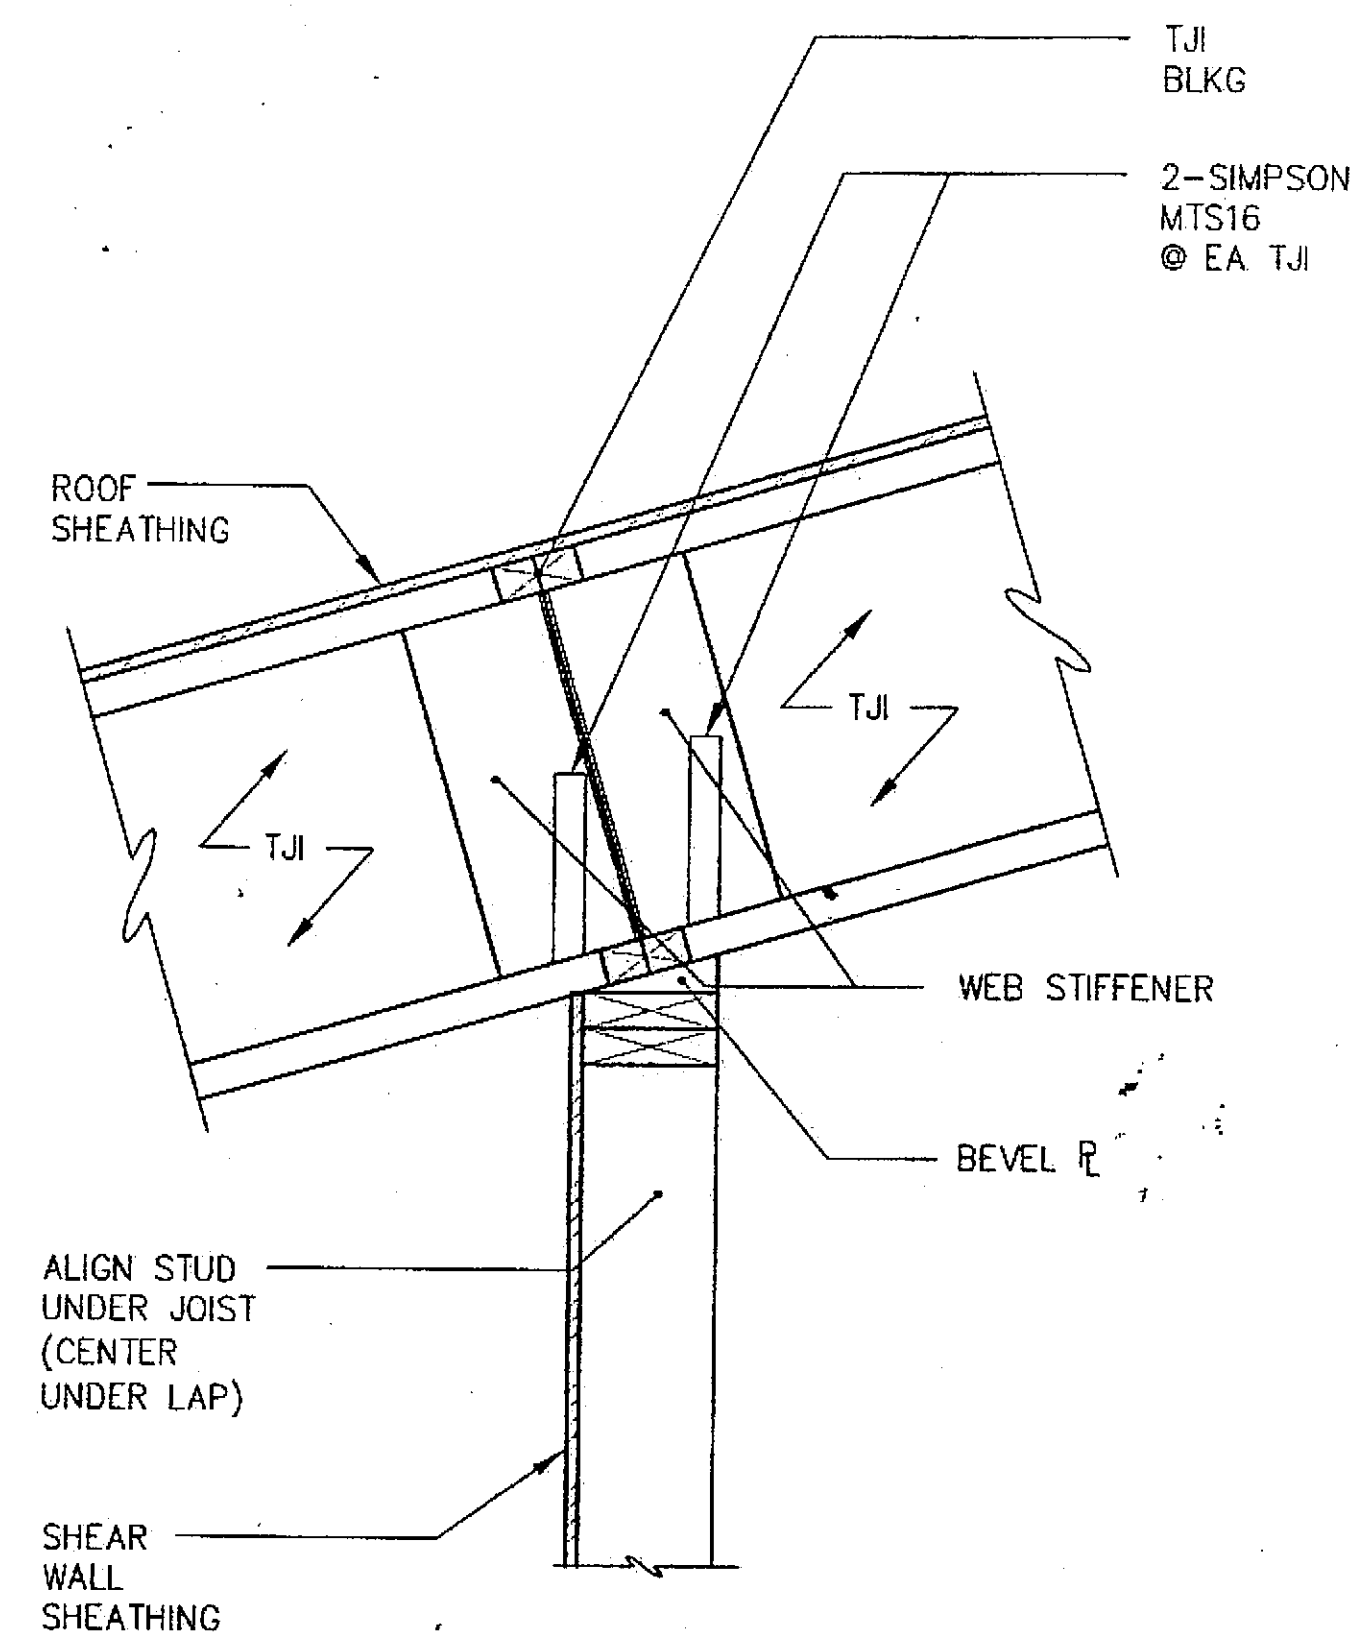


H ROOF SECTION
AT BEARING WALL

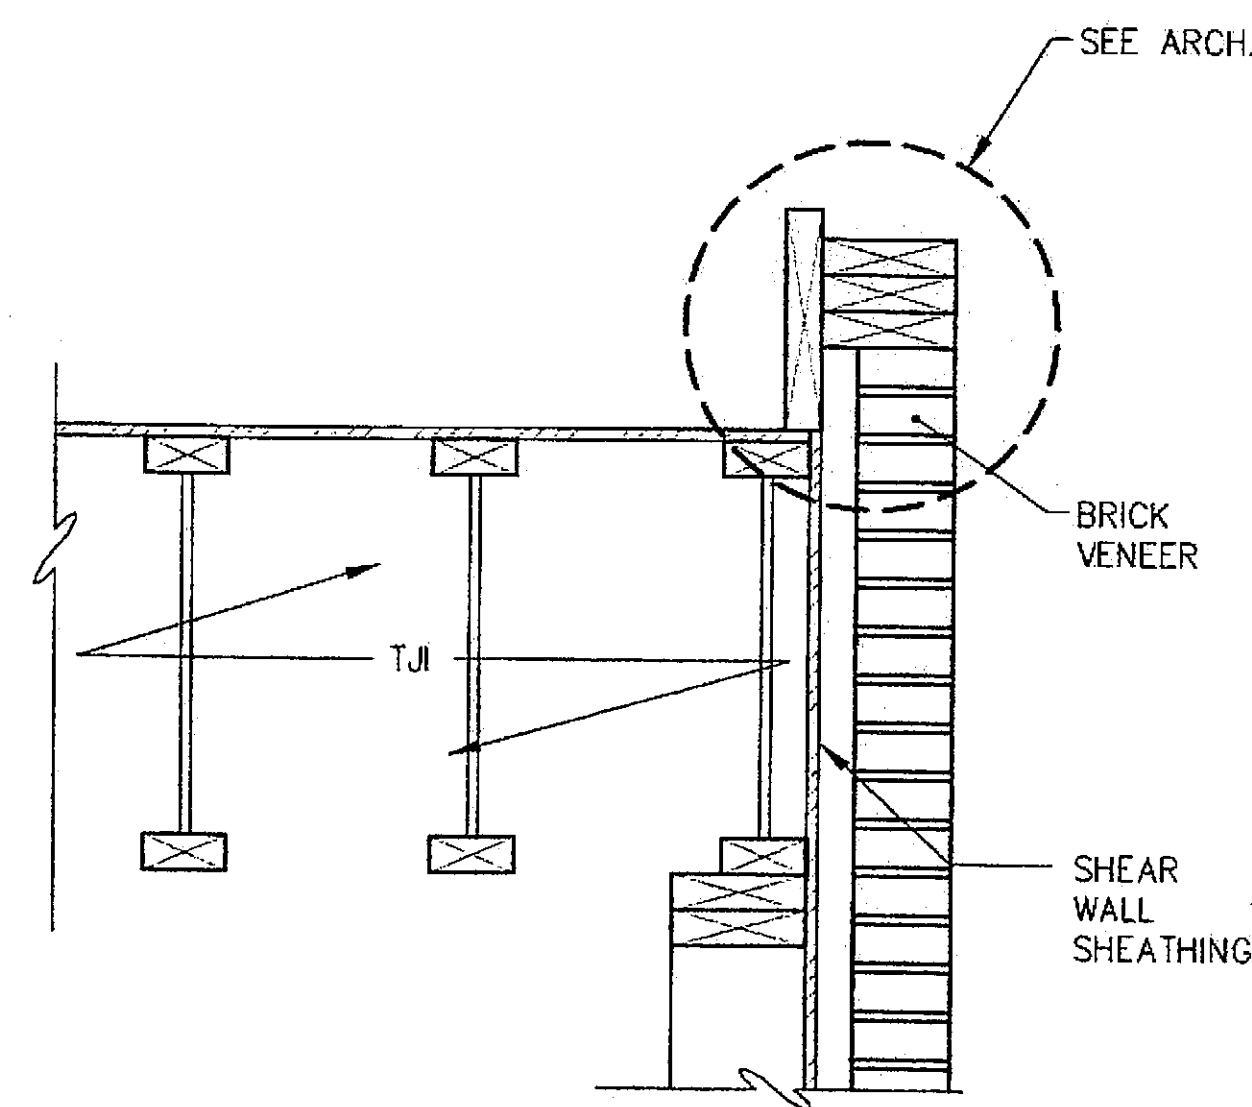

I ROOF SECTION

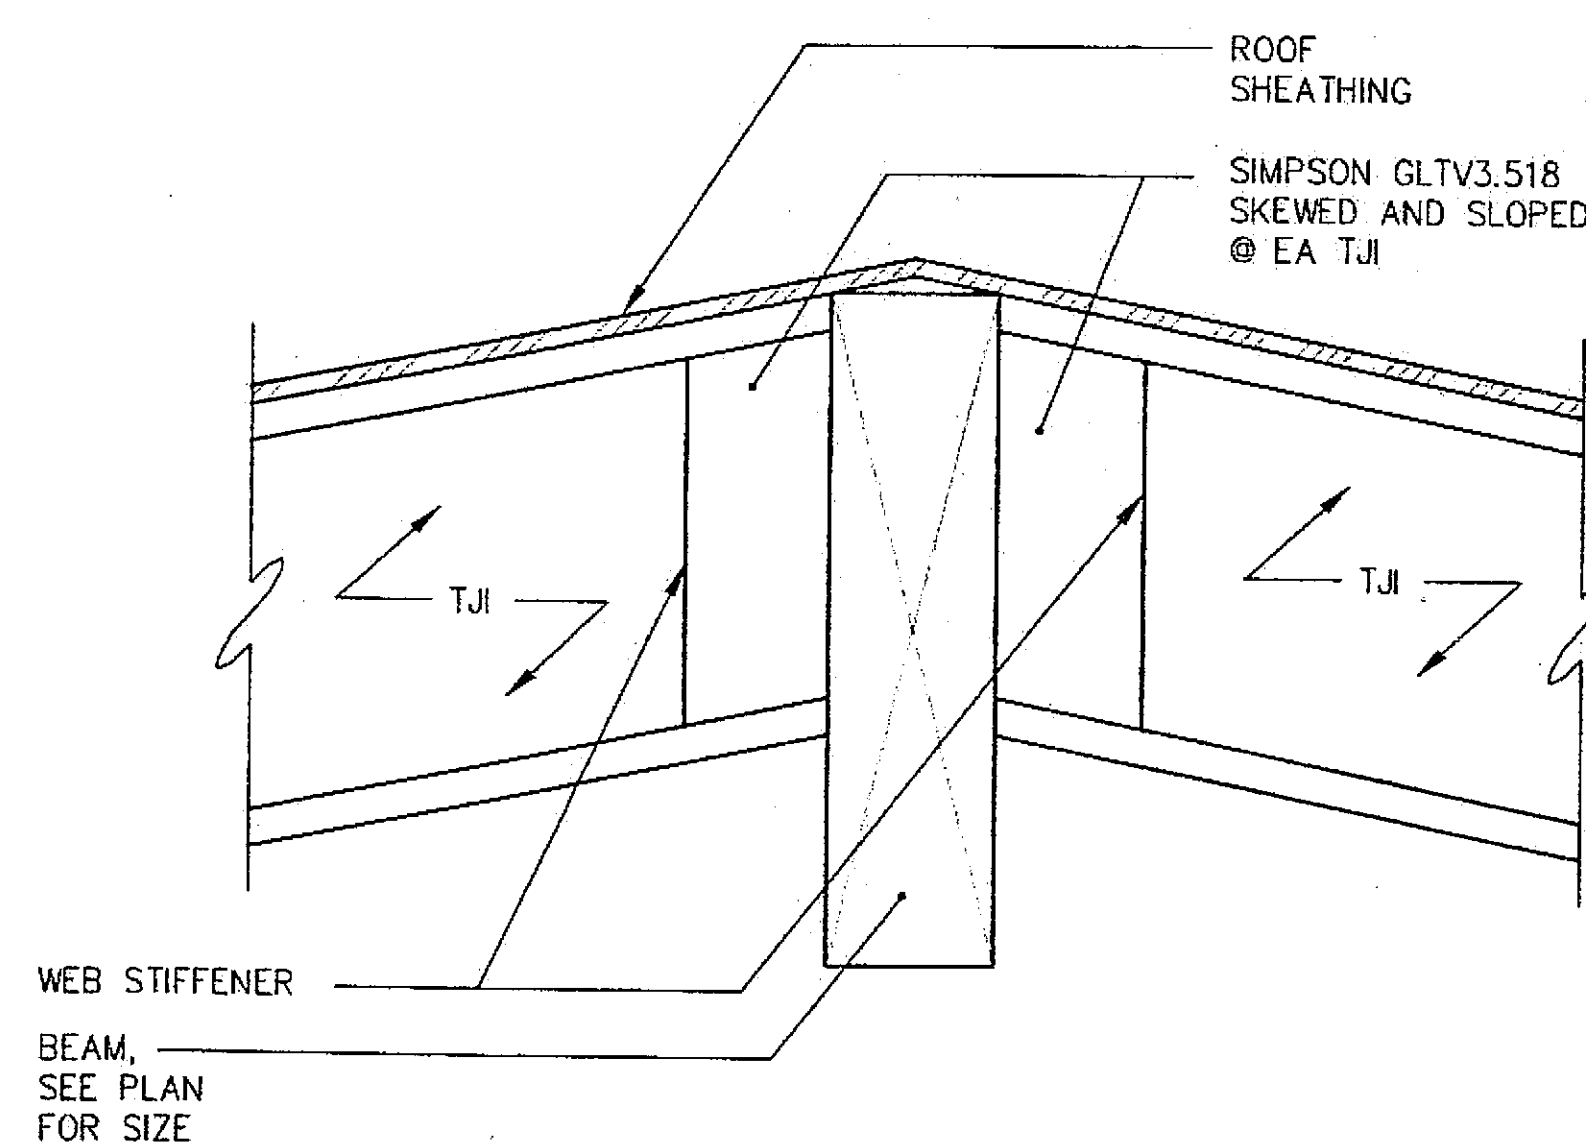

J ROOF SECTION
AT BEAM

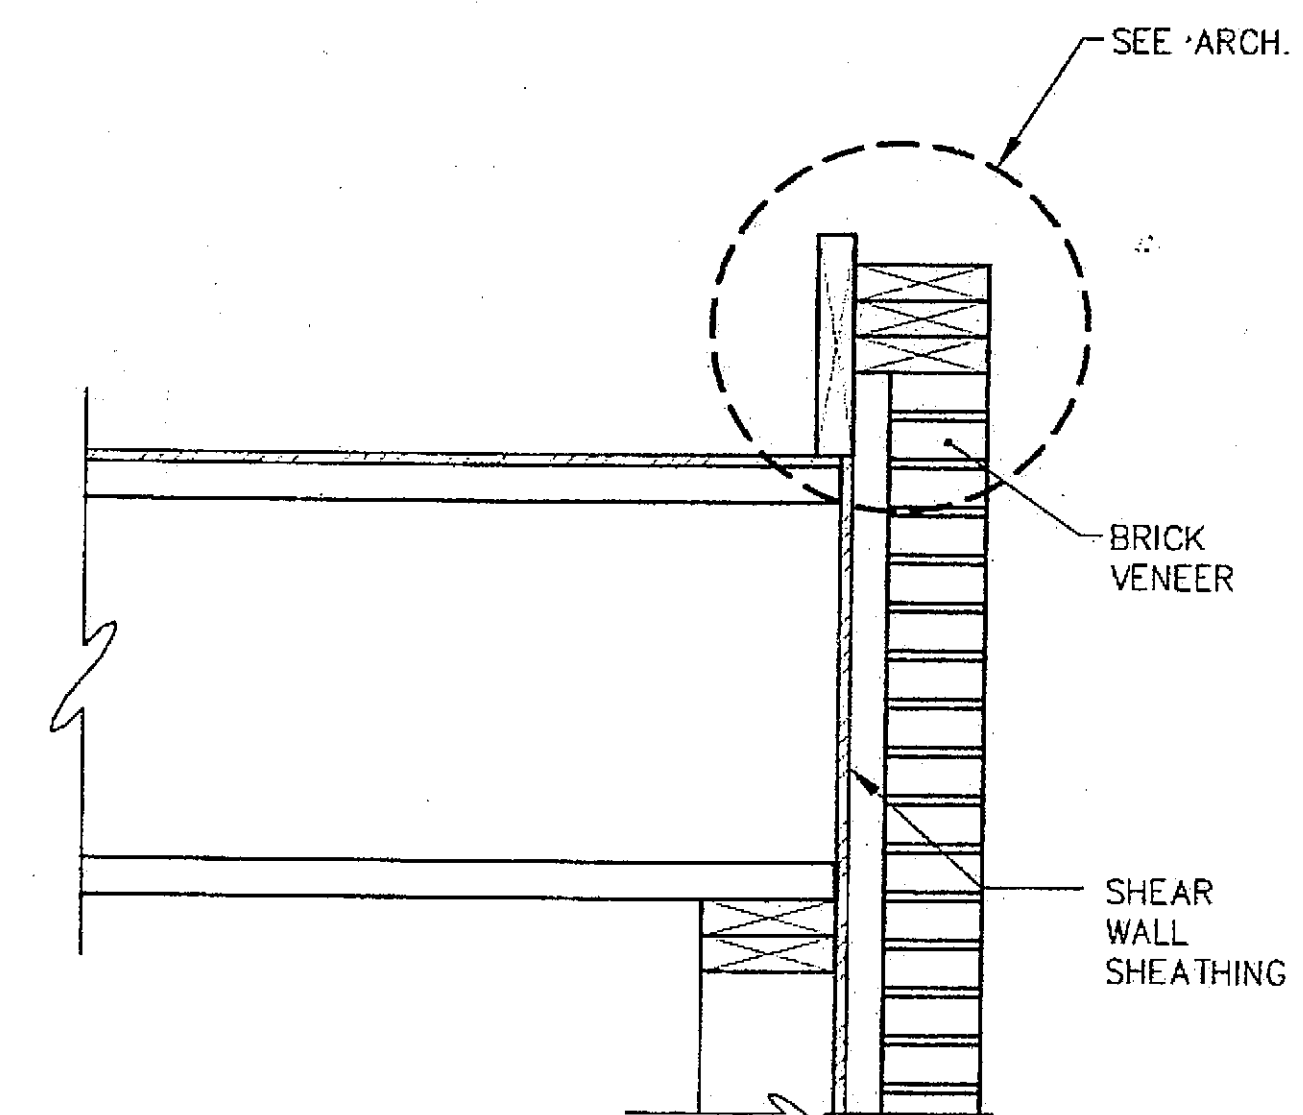

K ROOF SECTION
AT EXTERIOR WALL

Tue, 14/Dec/04 12:00PM


ADDENDUM NUMBER

ATTACHMENT NUMBER

RECORD OF REVISIONS

No.	DATE	DESCRIPTION

CHECKED BY:

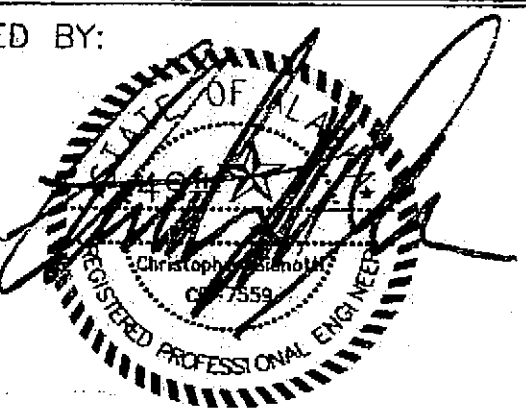

DESIGNED BY: BCN

DRAWN BY: PJD

STATE OF ALASKA
DEPARTMENT OF TRANSPORTATION
& PUBLIC FACILITIES
STATEWIDE DESIGN & ENGINEERING
SERVICES DIVISION

MT EDGECUMBE
HIGH SCHOOL
BUILDING 1330
ACADEMIC
EXPANSION

SHEET S402

PROJECT DESIGNATION NUMBER

67751C

STATE	YEAR
ALASKA	2004
SHEET NUMBER	TOTAL SHEETS
52	79

Project As-Built Drawings have been
viewed by the Project Engineer and
present to the best of my knowledge, the
object as constructed.
roj. Eng. *[Signature]* Date 7/07


Tue, 14/Dec/04 12:00PM

ADDENDUM NUMBER


ATTACHMENT NUMBER

RECORD OF REVISIONS

No.	DATE	DESCRIPTION

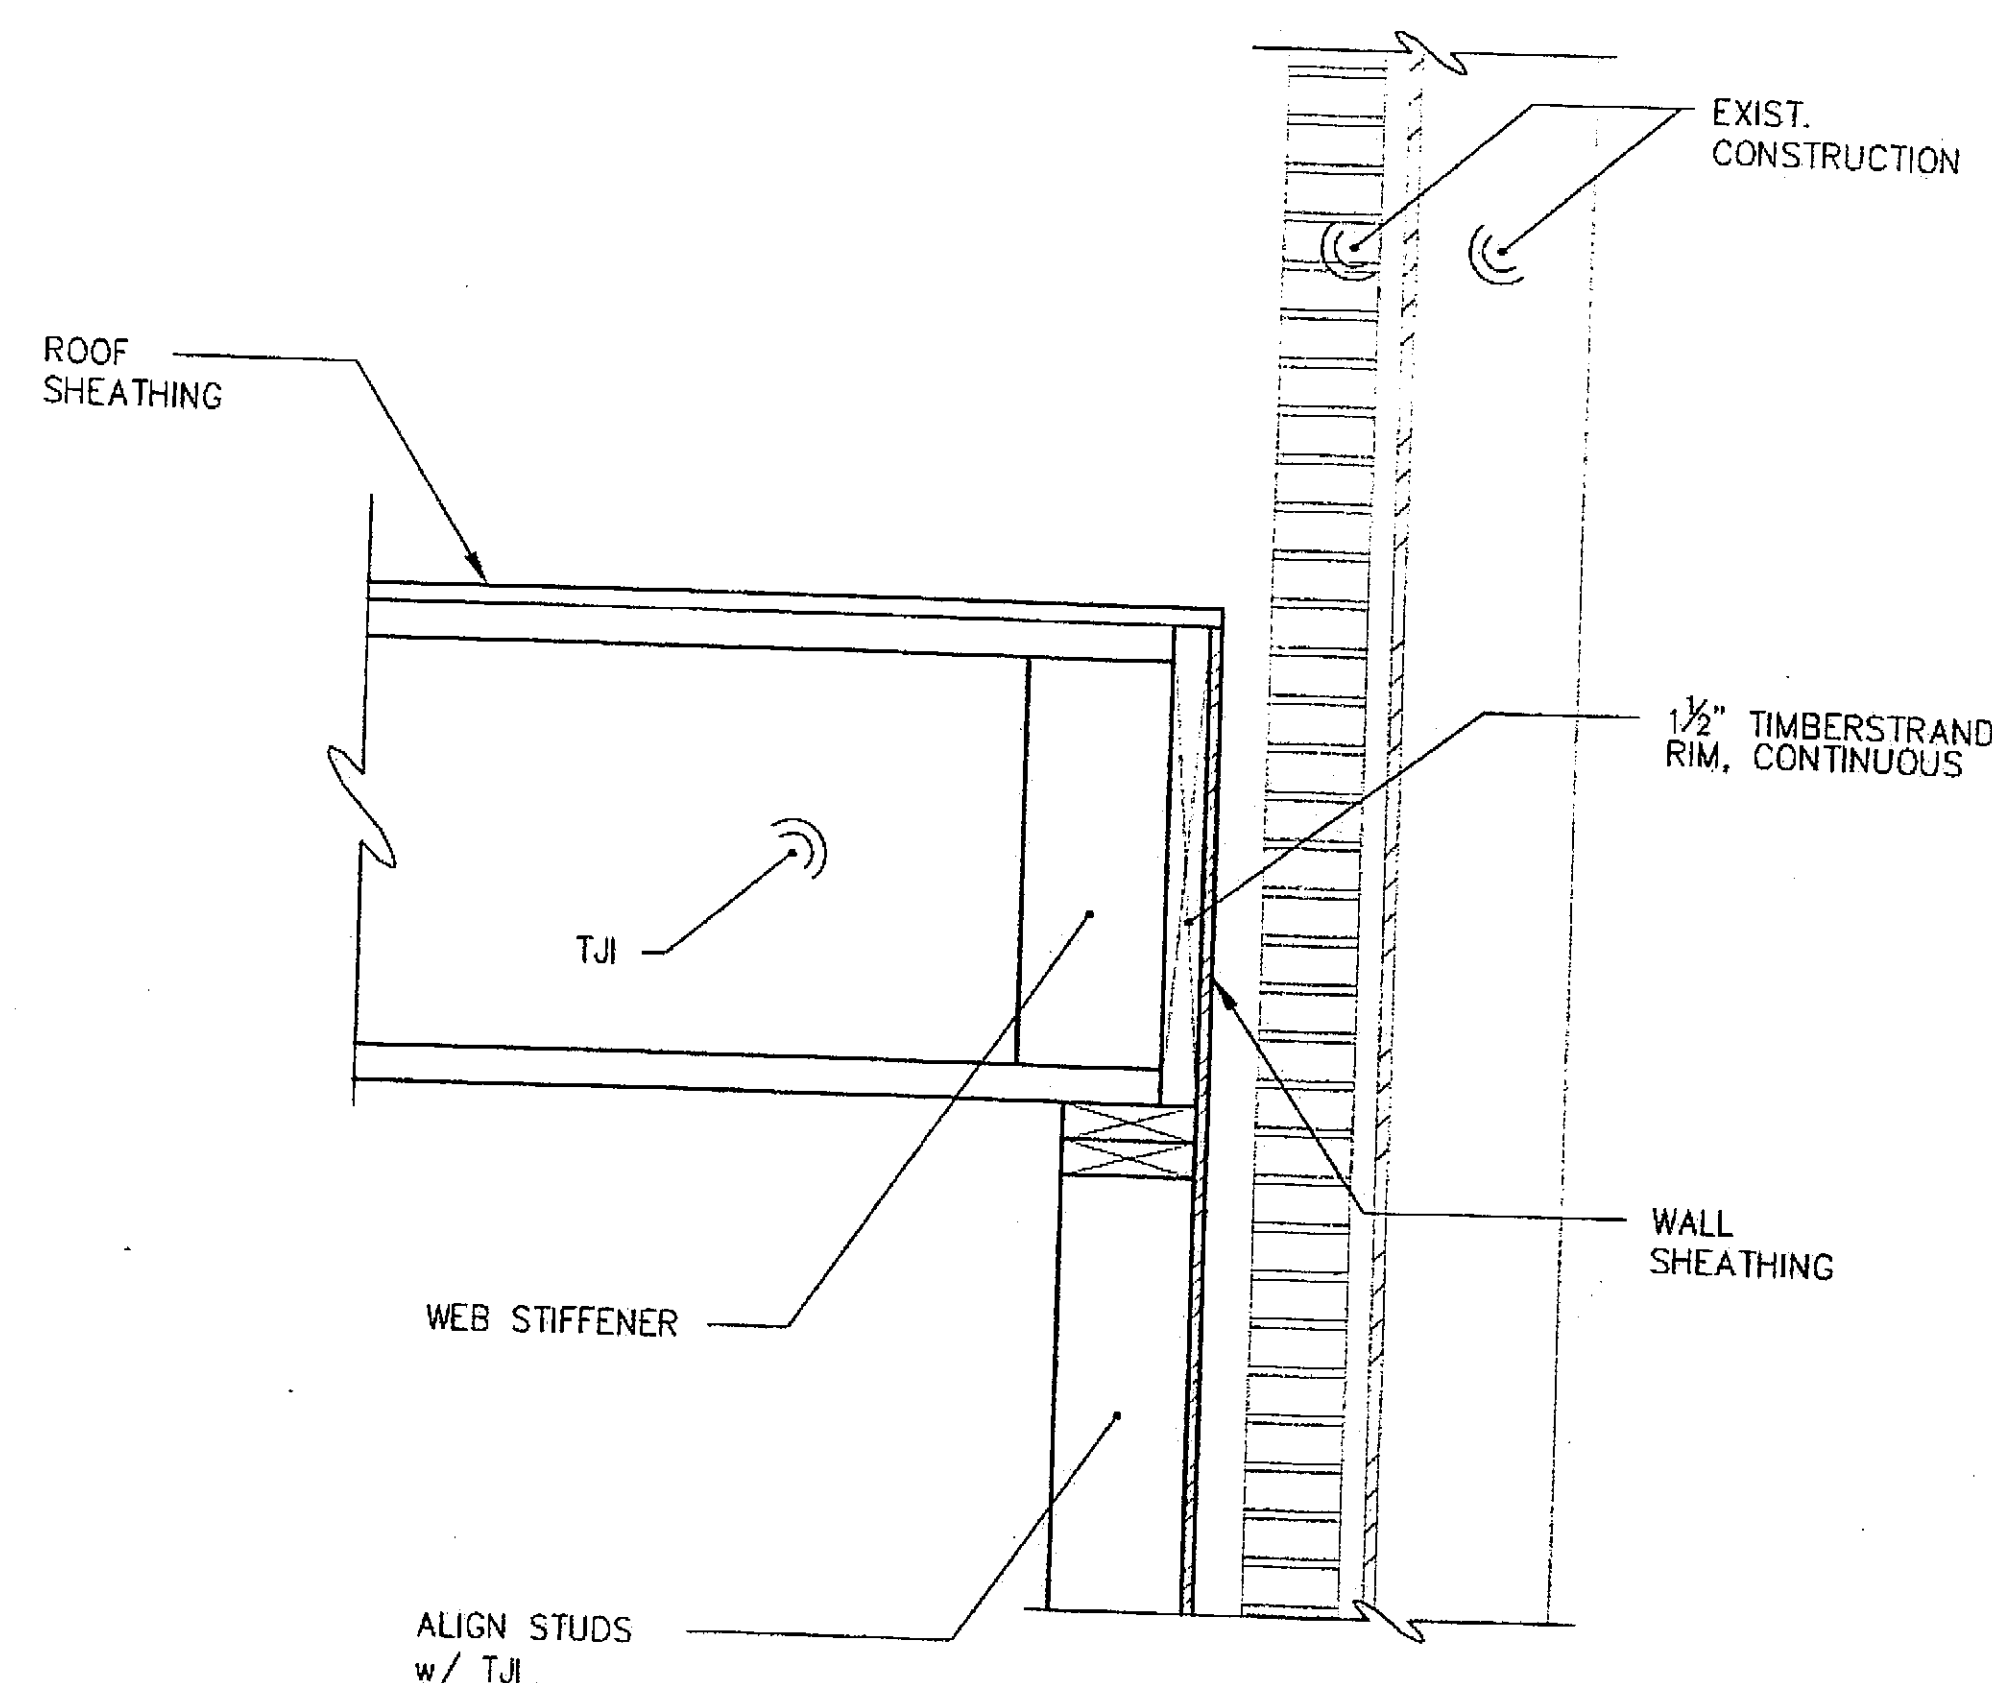


L ROOF SECTION

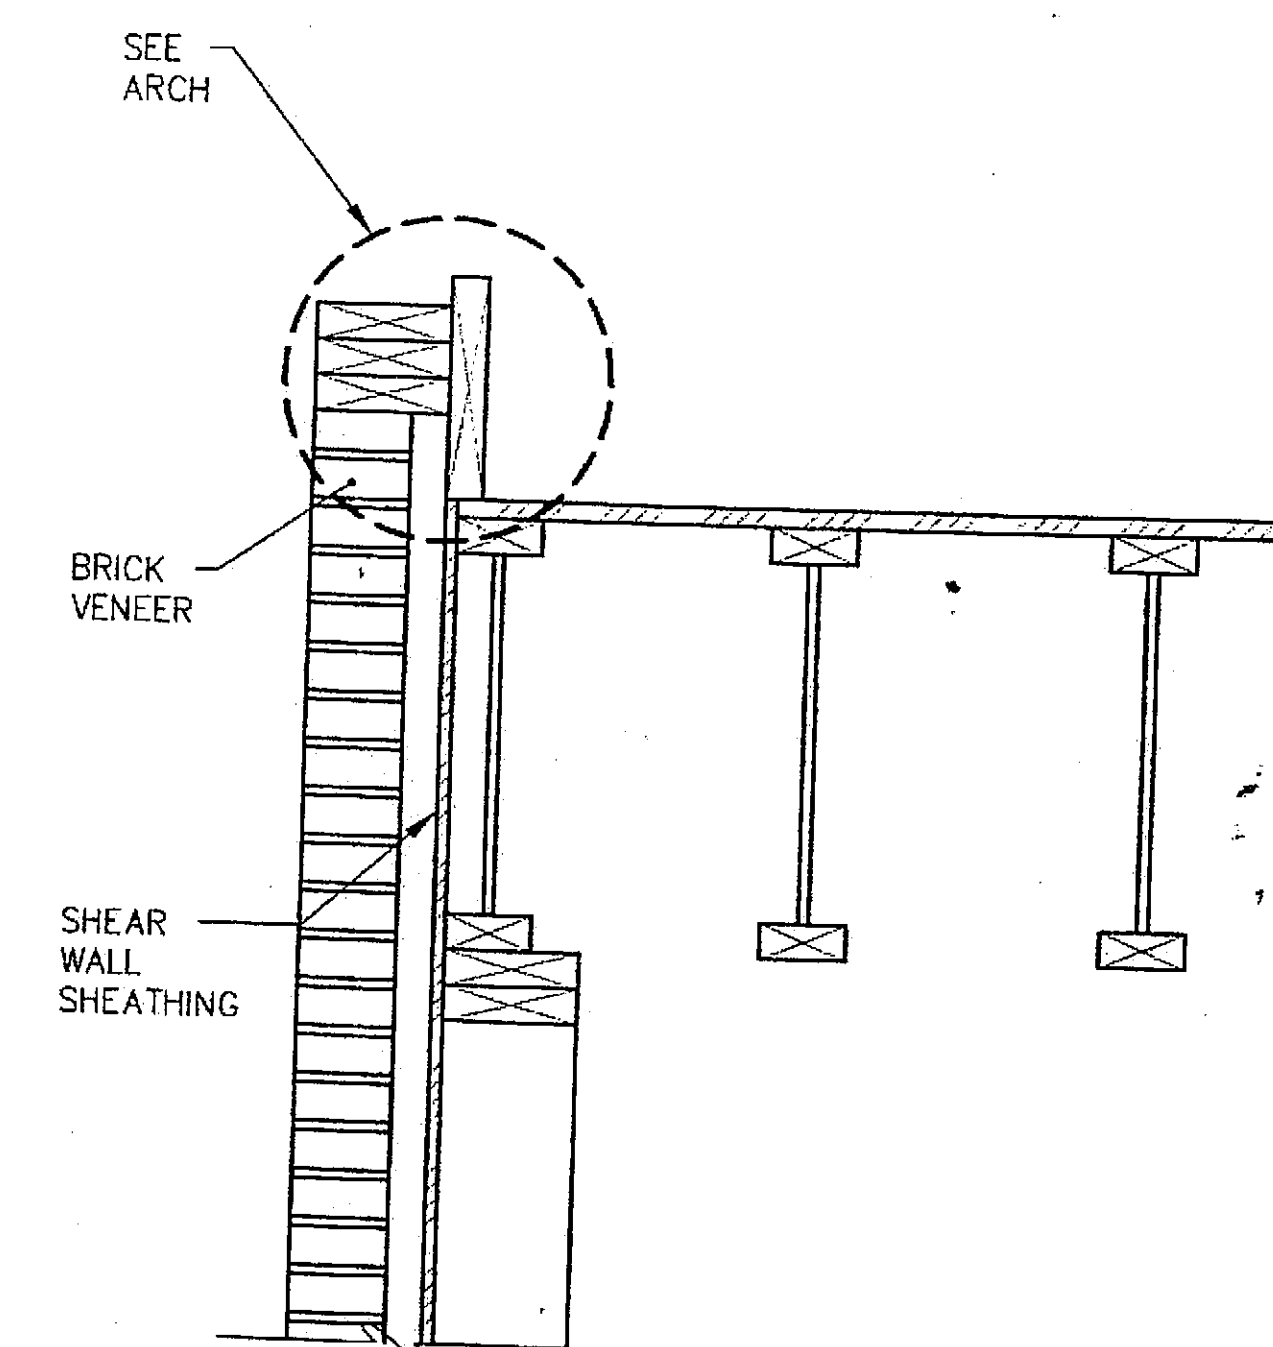

M ROOF SECTION

CHECKED BY:

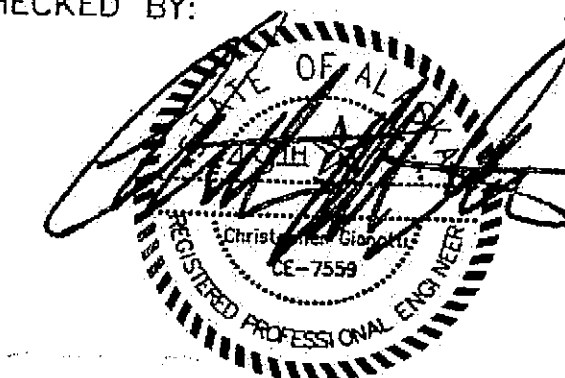

DESIGNED BY: BCN

DRAWN BY: PJD

STATE OF ALASKA
DEPARTMENT OF TRANSPORTATION
& PUBLIC FACILITIES
STATEWIDE DESIGN & ENGINEERING
SERVICES DIVISION

MT EDGE CUMBE
HIGH SCHOOL
BUILDING 1330
ACADEMIC
EXPANSION

SHEET S403

PROJECT DESIGNATION NUMBER



67751C

STATE	YEAR
ALASKA	2004
SHEET NUMBER	TOTAL SHEETS

53

79

Project As-Built Drawings have been
reviewed by the Project Engineer and
present to the best of my knowledge, the
project as constructed.
Proj. Eng. *[Signature]* Date *7/07*

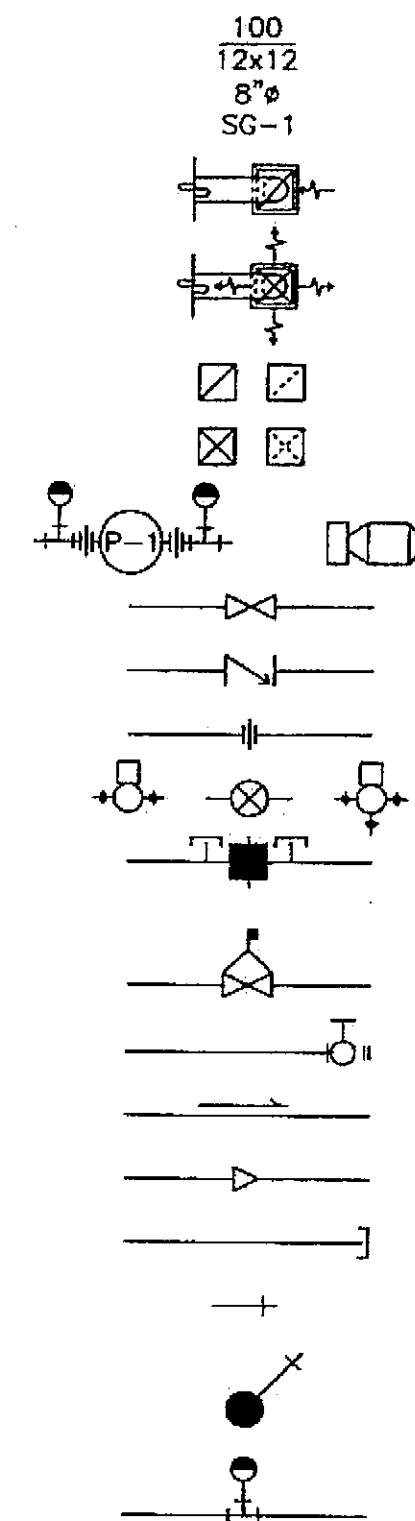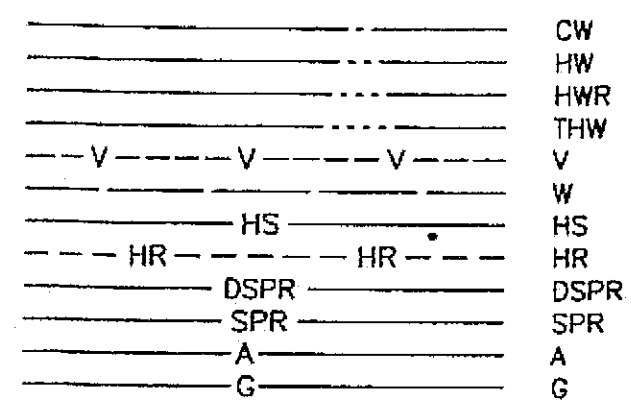

CW COLD WATER
HW HOT WATER
HWR HOT WATER RECIRCULATING
THW TEMPERED HOT WATER
V VENT
W WASTE
HS HEATING SUPPLY
HR HEATING RETURN
DSPR DRY SPRINKLER
SPR SPRINKLER
A COMPRESSED AIR
G GAS

AIR VOLUME
DIFFUSER/GRILLE SIZE
DUCT CONNECTION SIZE
GRILLE TYPE

RG/EG CEILING RETURN AIR GRILLE/EXHAUST AIR GRILLE
SG CEILING SUPPLY DIFFUSER

RETURN/EXHAUST DUCT UP, DOWN
SUPPLY DUCT UP, DOWN

PU-1 PUMP
GATE VALVE
CHECK VALVE
UNION
AV AUTOMATIC VALVE
FLOW SETTER W/NO.
RISING STEM GATE VALVE WITH VALVE SWITCH
DV DRAIN VALVE
PITCHED DOWN
REDUCER
CAPPED OR PLUGGED
CO CLEANOUT
FCO FLOOR CLEANOUT
TEST PORT/PLUG

SYMBOLS

⊖ THERMOSTAT - IMMERSION, ROOM
⊖ THERMOMETER
⊖ PRESSURE GAGE
⊖ PRESSURE SWITCH
⊖ EXISTING
⊖ TO BE RELOCATED
⊖ POINT OF CONNECTION OR REMOVAL
⊖ ACCESS DOOR
⊖ DIAMETER
AAV AUTOMATIC AIR VENT
AHU AIR HANDLING UNIT
BC-1 BOOSTER COIL
BTU BRITISH THERMAL UNIT
CFM CUBIC FEET PER MINUTE
DF-1 DRINKING FOUNTAIN
DW DISHWASHER
EA EXHAUST AIR
EAC EXHAUST AIR CAP
EAT ENTERING AIR TEMPERATURE
EF EXHAUST FAN
ESP EXTERNAL STATIC PRESSURE
EW-1 EMERGENCY EYEWASH/SHOWER
EWT ENTERING WATER TEMPERATURE
FD-1 FLOOR DRAIN
FPM FINNED PIPE
FPM FEET PER MINUTE
FS-1 FLOOR SINK
FT FEET
GPM GALLONS PER MINUTE
HC HEATING COIL
HP HORSE POWER

HWM HOT WATER MAKER
HWRP HOT WATER RECIRCULATING PUMP
IPS IRON PIPE SIZE
HWRP HOT WATER RECIRCULATING PUMP
L-1 LAVATORY
LAT LEAVING AIR TEMPERATURE
LWT LEAVING WATER TEMPERATURE
MAV MANUAL AIR VENT
OSA OUTSIDE AIR
PRV PRESSURE REDUCING VALVE
RA RETURN AIR
RF RETURN FAN
S-1 SINK
SA SUPPLY AIR TEMPERATURE
SS-1 SERVICE SINK
T&P TEMPERATURE AND PRESSURE
TEF TOILET EXHAUST FAN
TMB TERMINAL MIXING BOX
TV TEMPERING VALVE
UH-1 UNIT HEATER
VAV VARIABLE AIR VOLUME
VTR VENT THROUGH ROOF
WC-1 WATER CLOSET
WH-1 WALL HYDRANT

SHEET NOTES:

- SEE SPECIFICATIONS FOR ADDITIONAL DATA ON ALL EQUIPMENT. DATA REQUIRED SHOWING CONFORMANCE OF DESIGN INTENT FOR EACH PIECE OF EQUIPMENT AND APPURTENANCES LISTED IN THE SCHEDULES.

CODE NOTES:

- ALL MECHANICAL WORK IS TO BE DESIGNED AND CONSTRUCTED IN ACCORDANCE WITH 2003 INTERNATIONAL BUILDING CODES, 2003 UNIFORM PLUMBING CODE, AND NFPA.

EQUIPMENT SCHEDULE

EQUIPMENT	FUNCTION	LOCATION	SIZE/CAPACITY	DESIGN MANUFACTURE AND MODEL	FEATURES AND ACCESSORIES
EXPANSION TANK (ET) DOMESTIC	AIR EXPANSION	MECH./ELEC. 201	10 GALLON TOTAL 2 GALLON ACCEPTANCE	AMTROL ST SERIES	ASME. PIPE MOUNTED.

FLOWSETTER AND AUTOMATIC VALVE SCHEDULE

NUMBER	UNIT SERVED	LOCATION	DESIGN GPM	SETTER SIZE (INCHES)	VALVE TYPE	VALVE OPERATION	NORMAL POSITION
1	TMB-1	ROOM 141	3.5	1"	2-WAY	MODULATING	OPEN
2	TMB-2	ROOM 142	3.0	1"	2-WAY	MODULATING	OPEN
3	TMB-3	ROOM 143	3.5	1"	2-WAY	MODULATING	OPEN
4	TMB-4	ROOM 144	1.6	3/4"	2-WAY	MODULATING	OPEN
5	TMB-5	ROOM 145	2.4	3/4"	2-WAY	MODULATING	OPEN
6	TMB-6	ROOM 146	1.3	1/2"	2-WAY	MODULATING	OPEN
7	TMB-7	ROOM 147	1.2	1/2"	2-WAY	MODULATING	OPEN
8	HWM	ROOM 201	9.0	1-1/4"	2-WAY	POSITIVE	CLOSED
9	AHU-3 HC	ROOM 201	10.0	1-1/4"	3-WAY	MODULATING	OPEN
10	CV	CENTER HALL 140	1.0	1/2"	2-WAY	POSITIVE	OPEN
11	UH-1	FAN ROOM	0.5	1/2"	2-WAY	POSITIVE	OPEN
12*	UH-1	JAN 150	0.8	1/2"	2-WAY	POSITIVE	OPEN

* IN ALTERNATE WORK.

PLUMBING FIXTURE SCHEDULE

FIXTURE	HOT WATER	COLD WATER	WASTE	VENT
WATER CLOSET, WC-1	-	1-1/4"	3 OR 4"	3"
LAVATORY, L-1	1/2"	1/2"	1-1/2"	1-1/2"
SINK, S-1	1/2"	1/2"	2"	1-1/2"
SINK, S-2	-	1/2"	1-1/2"	1-1/2"
SINK, S-3	1/2"	1/2"	2"	1-1/2"
SERVICE SINK, SS-1	1/2"	1/2"	3"	2"
FLOOR SINK, FS-1	-	-	3"	2"
FLOOR DRAIN, FD-1	-	-	2"	1-1/2"
EMERGENCY EYEWASH, EW-1	-	-	-	-
DRINKING FOUNTAIN, DF-1	-	1/2"	2"	1-1/2"
WALL HYDRANT, WH-1	-	3/4"	-	-

PLUMBING EQUIPMENT SCHEDULE

EQUIPMENT	DESIGN MANUFACTURER	OPTIONS/TRIM
WATER CLOSET, WC-1	AMERICAN STANDARD, KOHLER CRANE	FLOOR MOUNTED FLUSH VALVE, TOP SPUD, ELONGATED BOWL WITH OPEN FRONT SEAT AND CHECK HINGES. 1-1/2-INCH, BATTERY POWERED, SENSOR OPERATED FLUSH VALVE. 1-1/4-INCH IPS WHEEL HANDLE ISOLATING VALVE AND FLEXIBLE RISER.
LAVATORY, L-1	AMERICAN STANDARD, KOHLER	VITREOUS CHINA, WALL MOUNTED, 20"x18". 4" FAUCET CENTERS. BATTERY POWERED, SENSOR OPERATED SUPPLY, WITH MIXING VALVE. COMBINATION SUPPLY WITH GRID DRAIN. ADA COMPLIANT.
SINK 1, S-1	JUST, ELKAY	SINGLE-COMPARTMENT SINK SUPPLIED WITH SCIENCE CASEWORK. TRIM: GOOSENECK FAUCET WITH VACUUM BREAKER, SERRATED NOZZLE. HOT AND COLD WATER INDEXED WRIST BLADE HANDLES. COORDINATE WITH SCIENCE CASEWORK.
SINK 2, S-2	JUST, ELKAY	SINGLE-COMPARTMENT, SELF-RIMMING, LEDGEBACK FULLY UNDERCOATED, PRE-PUNCHED 18-GAGE STAINLESS STEEL. 21"x19"x6-1/2" DEEP. TRIM: GOOSENECK FAUCET WITH VACUUM BREAKER, SERRATED NOZZLE. HOT AND COLD WATER INDEXED WRIST BLADE HANDLES. COORDINATE WITH CASEWORK.
SINK 3, S-3	JUST, ELKAY	SINGLE-COMPARTMENT CUP SINK PROVIDED WITH FUME HOOD. TRIM ALSO PROVIDED WITH HOOD. PROVIDE COLD WATER, WASTE, AND VENT CONNECTION.
SERVICE SINK, SS-1	AMERICAN STANDARD, KOHLER	28"x28" VITREOUS CHINA, WITH MIXING FAUCET. INTEGRAL VACUUM BREAKER, RIM GUARD AND TRIM. 3" OUTLET.
FLOOR SINK, FS-1	ZURN JOSAM	4"x8" PORCELAIN ENAMEL INTERIOR WITH SECONDARY STRAINER. 3" OUTLET. 4" SUMP DEPTH.
FLOOR DRAIN, FD-1	ZURN JOSAM	7" DIAMETER TOP WITH INTEGRAL FUNNEL DRAIN SOLID NICKEL BRONZE. 2" OUTLET.
EMERGENCY EYEWASH, EW-1	HAWS ELKAY	COMBINATION EMERGENCY EYEWASH AND SHOWER, ADA COMPLIANT.
DRINKING FOUNTAIN, DF-1	ELKAY	STAINLESS STEEL DOUBLE UNIT, ADA COMPLIANT.
WALL HYDRANT, WH-1	JOSAM, ZURN	3/4" NON-FREEZE TYPE IN RECESSED BOX. WITH INTERNAL VACUUM BREAKER.

TMB BOX AND REHEAT COIL SCHEDULE

NUMBER	CFM	COIL CAPACITY * (MBH)	INLET DIAMETER	OUTLET DIAMETER	OUTLET NUMBER	UNIT MODEL **
TMB-1	1,190	35.0	10"	8"	5	DESV 10
TMB-2	1,190	30.0	10"	8"	5	DESV 10
TMB-3	1,460	35.0	12"	10"	5	DESV 12
TMB-4	760	16.0	8"	8"	4	DESV 8
TMB-5	670	24.4	8"	8"	5	DESV 8
TMB-6	650	12.6	8"	10"	2	DESV 8
TMB-7	810	12.2	8"	8"	4	DESV 8

* 190°F EWT, 160°F LWT, 55°F EAT
** DESIGN BASED ON TITUS MODEL DESV

PUMP SCHEDULE

EQUIPMENT	FUNCTION	GPM	HEAD, FT	DESIGN MANUFACTURER AND MODEL	MINIMUM HORSEPOWER ELECTRICAL CHARACTERISTICS	FEATURES
HWRP	DOMESTIC HOT WATER RECIRC.	2	7	TACO - 006	1/40HP, 120V, SINGLE-PHASE	BRONZE, UNITIZED.
PU-5, PU-6	HEATING	40	18	TACO - 1635	1/2HP, 208-230/460V, THREE-PHASE	PIPE MOUNTED. CENTRIFUGAL PUMP. TRIMMED CUSTOM IMPELLER 4.6".

FAN SCHEDULE

EQUIPMENT	AREA SERVED	CFM	ESP, INCHES OF WATER	DESIGN MANUFACTURER AND MODEL	MIN. HP	VOLTS / PHASE	FEATURES AND ACCESSORIES
AHU-3	BUILDING SUPPLY	6,440	1.0	SCOTT SPRINGFIELD BAF-DW 27	5.0	208V/3φ	CUSTOM AIR FOIL OR BACKWARD INCLINED CABINET FAN.
RF-3	BUILDING RETURN	5,760	0.75	SCOTT SPRINGFIELD BAF-DW 22	3.0	208V/3φ	CUSTOM AIR FOIL OR BACKWARD INCLINED CABINET FAN.
EF-13, EF-14	FUME HOOD EXHAUST	735	1.25	GREENHECK, 12-BISW-21	1/4	120V/1φ	BACKWARD INCLINED UTILITY FAN.
EF-12	GENERAL EXHAUST	800	1.0	GREENHECK SWB-12-4	1/4	120V/1φ	FORWARD CURVED UTILITY FAN.

HEATING COIL SCHEDULE

COIL	UNIT SERVED	CAPACITY (MBH)	WATER TEMPERATURES ENTERING LEAVING	AIR TEMPERATURES ENTERING LEAVING	FEATURES AND ACCESSORIES
HC	AHU	150	180°F 160°F	45°F 65°F	MAXIMUM 8 FPI, NONFERROUS MATERIAL. MAXIMUM AIR FRICTION DROP 0.25 INCHES OF WATER. MAXIMUM WATER FRICTION DROP, 3.0 FEET OF WATER. MAXIMUM COIL FACE VELOCITY, 500 FPM.

HEATING UNIT SCHEDULE

EQUIPMENT	DESIGN MANUFACTURER	MODEL	FEATURES AND ACCESSORIES
CONVECTOR, CV	VULCAN	SF-A24	8,200 BTU/HR WATER RATING AT AVERAGE 180°F WATER TEMPERATURE, AND 65°F ENTERING AIR. FLOOR MOUNTED SURFACE MOUNTED, CONVECTOR. ACCESS DOOR FOR ACCESS TO AUTOMATIC VALVE. 48"Lx24"Hx6" DEEP. COLOR SELECTED BY ARCHITECT.
UNIT HEATER, UH-1	VULCAN	HV-24	HORIZONTAL UNIT HEATER. 20,000 BTU/HR AT AVERAGE 180°F WATER TEMPERATURE, 20°F DROP. 120V/1φ.

Tue, 14/Dec/04 12:10PM


ADDENDUM NUMBER

ATTACHMENT NUMBER

RECORD OF REVISIONS

No.	DATE	DESCRIPTION

CHECKED BY: DM

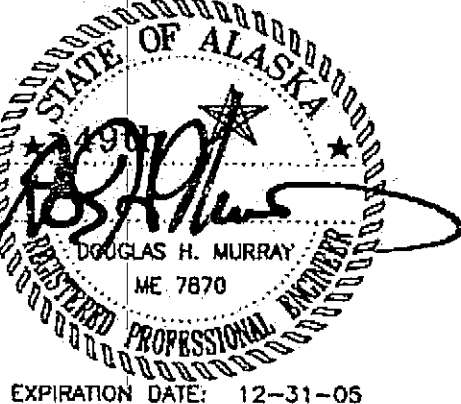

EXPIRATION DATE: 12-31-05

DESIGNED BY: DM/LH

DRAWN BY: WN

STATE OF ALASKA
DEPARTMENT OF TRANSPORTATION
& PUBLIC FACILITIES
STATEWIDE DESIGN & ENGINEERING
SERVICES DIVISION

MT EDGE CUMBE
HIGH SCHOOL
BUILDING 1330
ACADEMIC
EXPANSION

SHEET M001

PROJECT DESIGNATION NUMBER

67751C

STATE YEAR


ALASKA 2004

SHEET NUMBER TOTAL SHEETS

54


79

Project As-Built Drawings have been
reviewed by the Project Engineer and
represented to the best of my knowledge, the
project as constructed.
Proj. Eng. *[Signature]* Date *2/9*

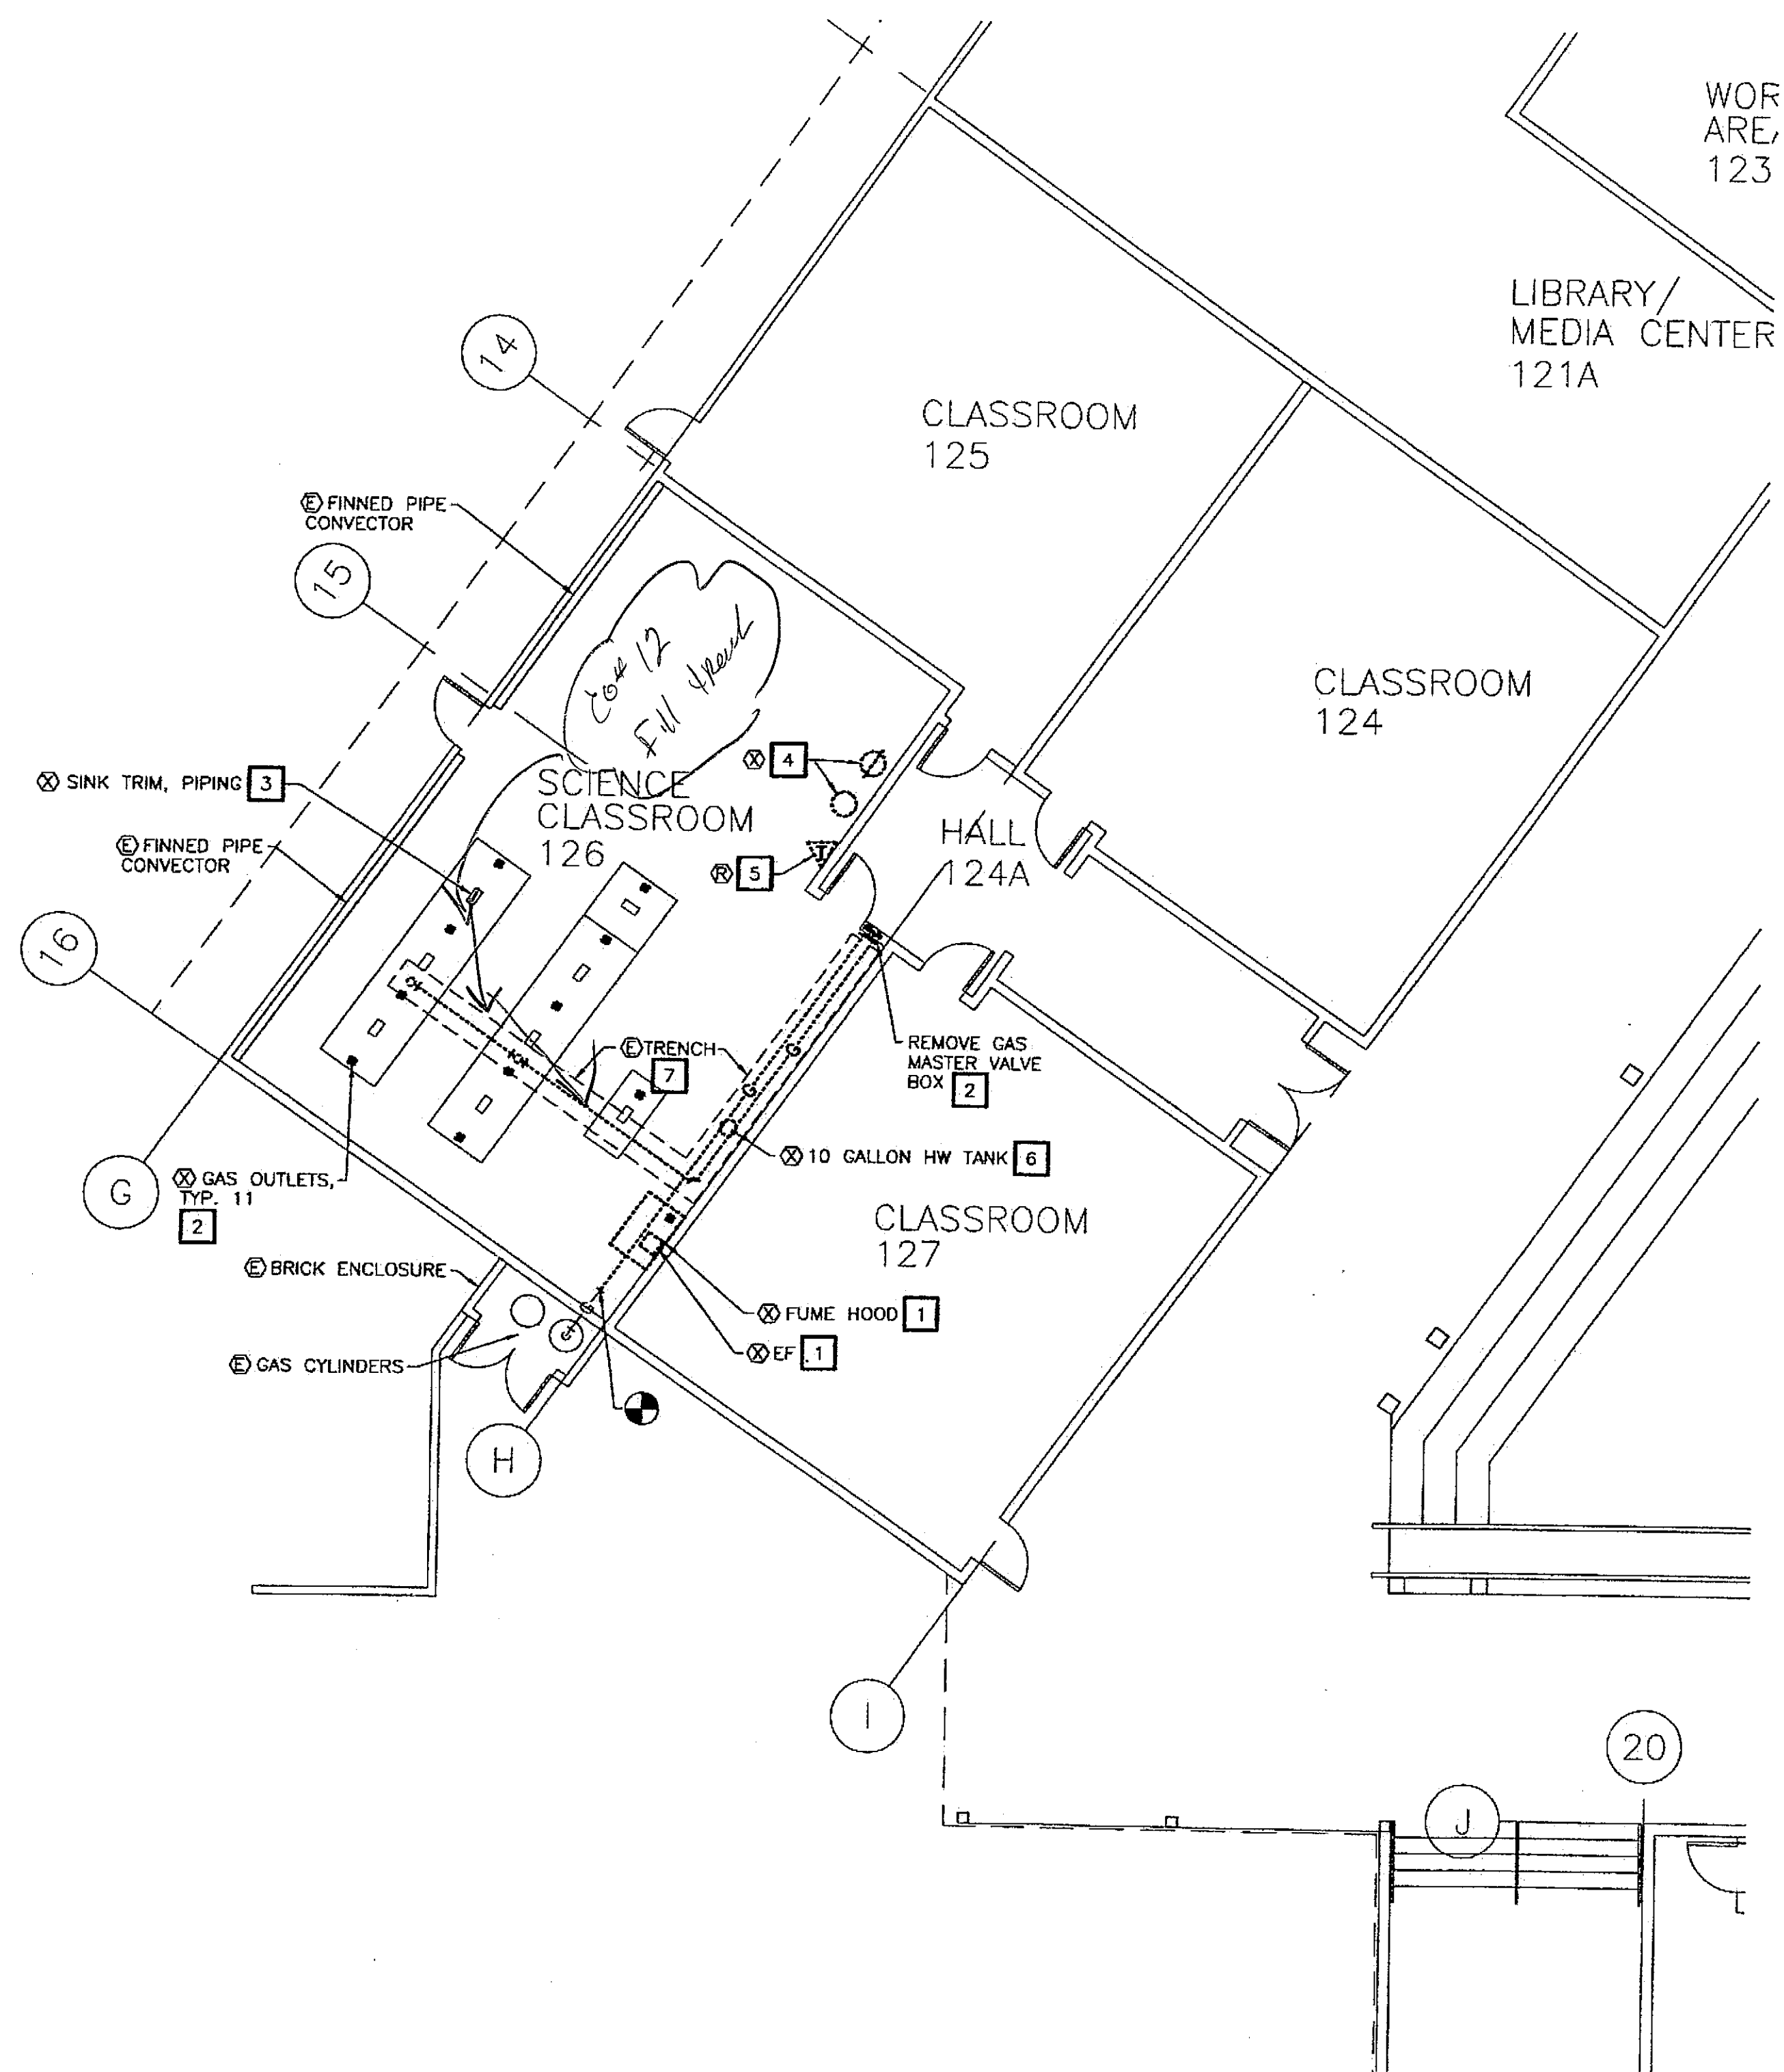

1 DEMOLITION FLOOR PLAN

SCALE: 0 4' 8' 16'

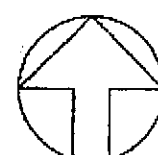

DEMOLITION NOTES:

- 1 REMOVE FUME HOOD, EXHAUST FAN AND SUPPORTS ABOVE, AND DUCT THROUGH ROOF. PATCH ROOF. REMOVE ALL PLUMBING AND GAS CONNECTIONS.
- 2 REMOVE ALL GAS PIPING, VALVES, AND OUTLETS.
- 3 REMOVE DOMESTIC CW, HW, W, AND V FROM LAB SINKS. CAP DOMESTIC WATER MAINS AT EAST WALL OF CLASSROOM. CAP WASTE PIPING AT FLOOR AND VENT PIPING. TYPICAL OF 8 SINKS TOTAL.
- 4 REMOVE EMERGENCY SHOWER AND EMERGENCY EYEWASH FIXTURES. CAP PIPING IN ADJACENT WALL. FILL FLOOR DRAIN WITH CONCRETE AND FINISH SMOOTH.
- 5 RELOCATE PNEUMATIC THERMOSTAT.
- 6 REMOVE HW TANK, PIPING, TRIM AND ELECTRICAL.
- 7 REMOVE ALL GAS, CW, HW, W, AND V PIPING FROM TRENCH. CAP AT MAINS.

Tue, 14/Dec/04 08:35AM


ADDENDUM NUMBER

ATTACHMENT NUMBER

RECORD OF REVISIONS

No.	DATE	DESCRIPTION

CHECKED BY: DM

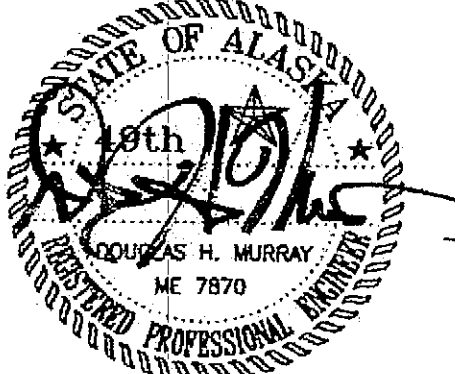

EXPIRATION DATE: 12-31-05

DESIGNED BY: DM/LH

DRAWN BY: WN

STATE OF ALASKA
DEPARTMENT OF TRANSPORTATION
& PUBLIC FACILITIES
STATEWIDE DESIGN & ENGINEERING
SERVICES DIVISION

MT EDGECUMBE
HIGH SCHOOL
BUILDING 1330
ACADEMIC
EXPANSION

SHEET M101

PROJECT DESIGNATION NUMBER

67751C

STATE	YEAR
ALASKA	2004
SHEET NUMBER	TOTAL SHEETS
55	79


Project As-Built Drawings have been
reviewed by the Project Engineer and
represent to the best of my knowledge, the
project as constructed.
Proj. Eng. *[Signature]* Date *12/17/04*

ADDENDUM NUMBER

ATTACHMENT NUMBER


RECORD OF REVISIONS

No.	DATE	DESCRIPTION

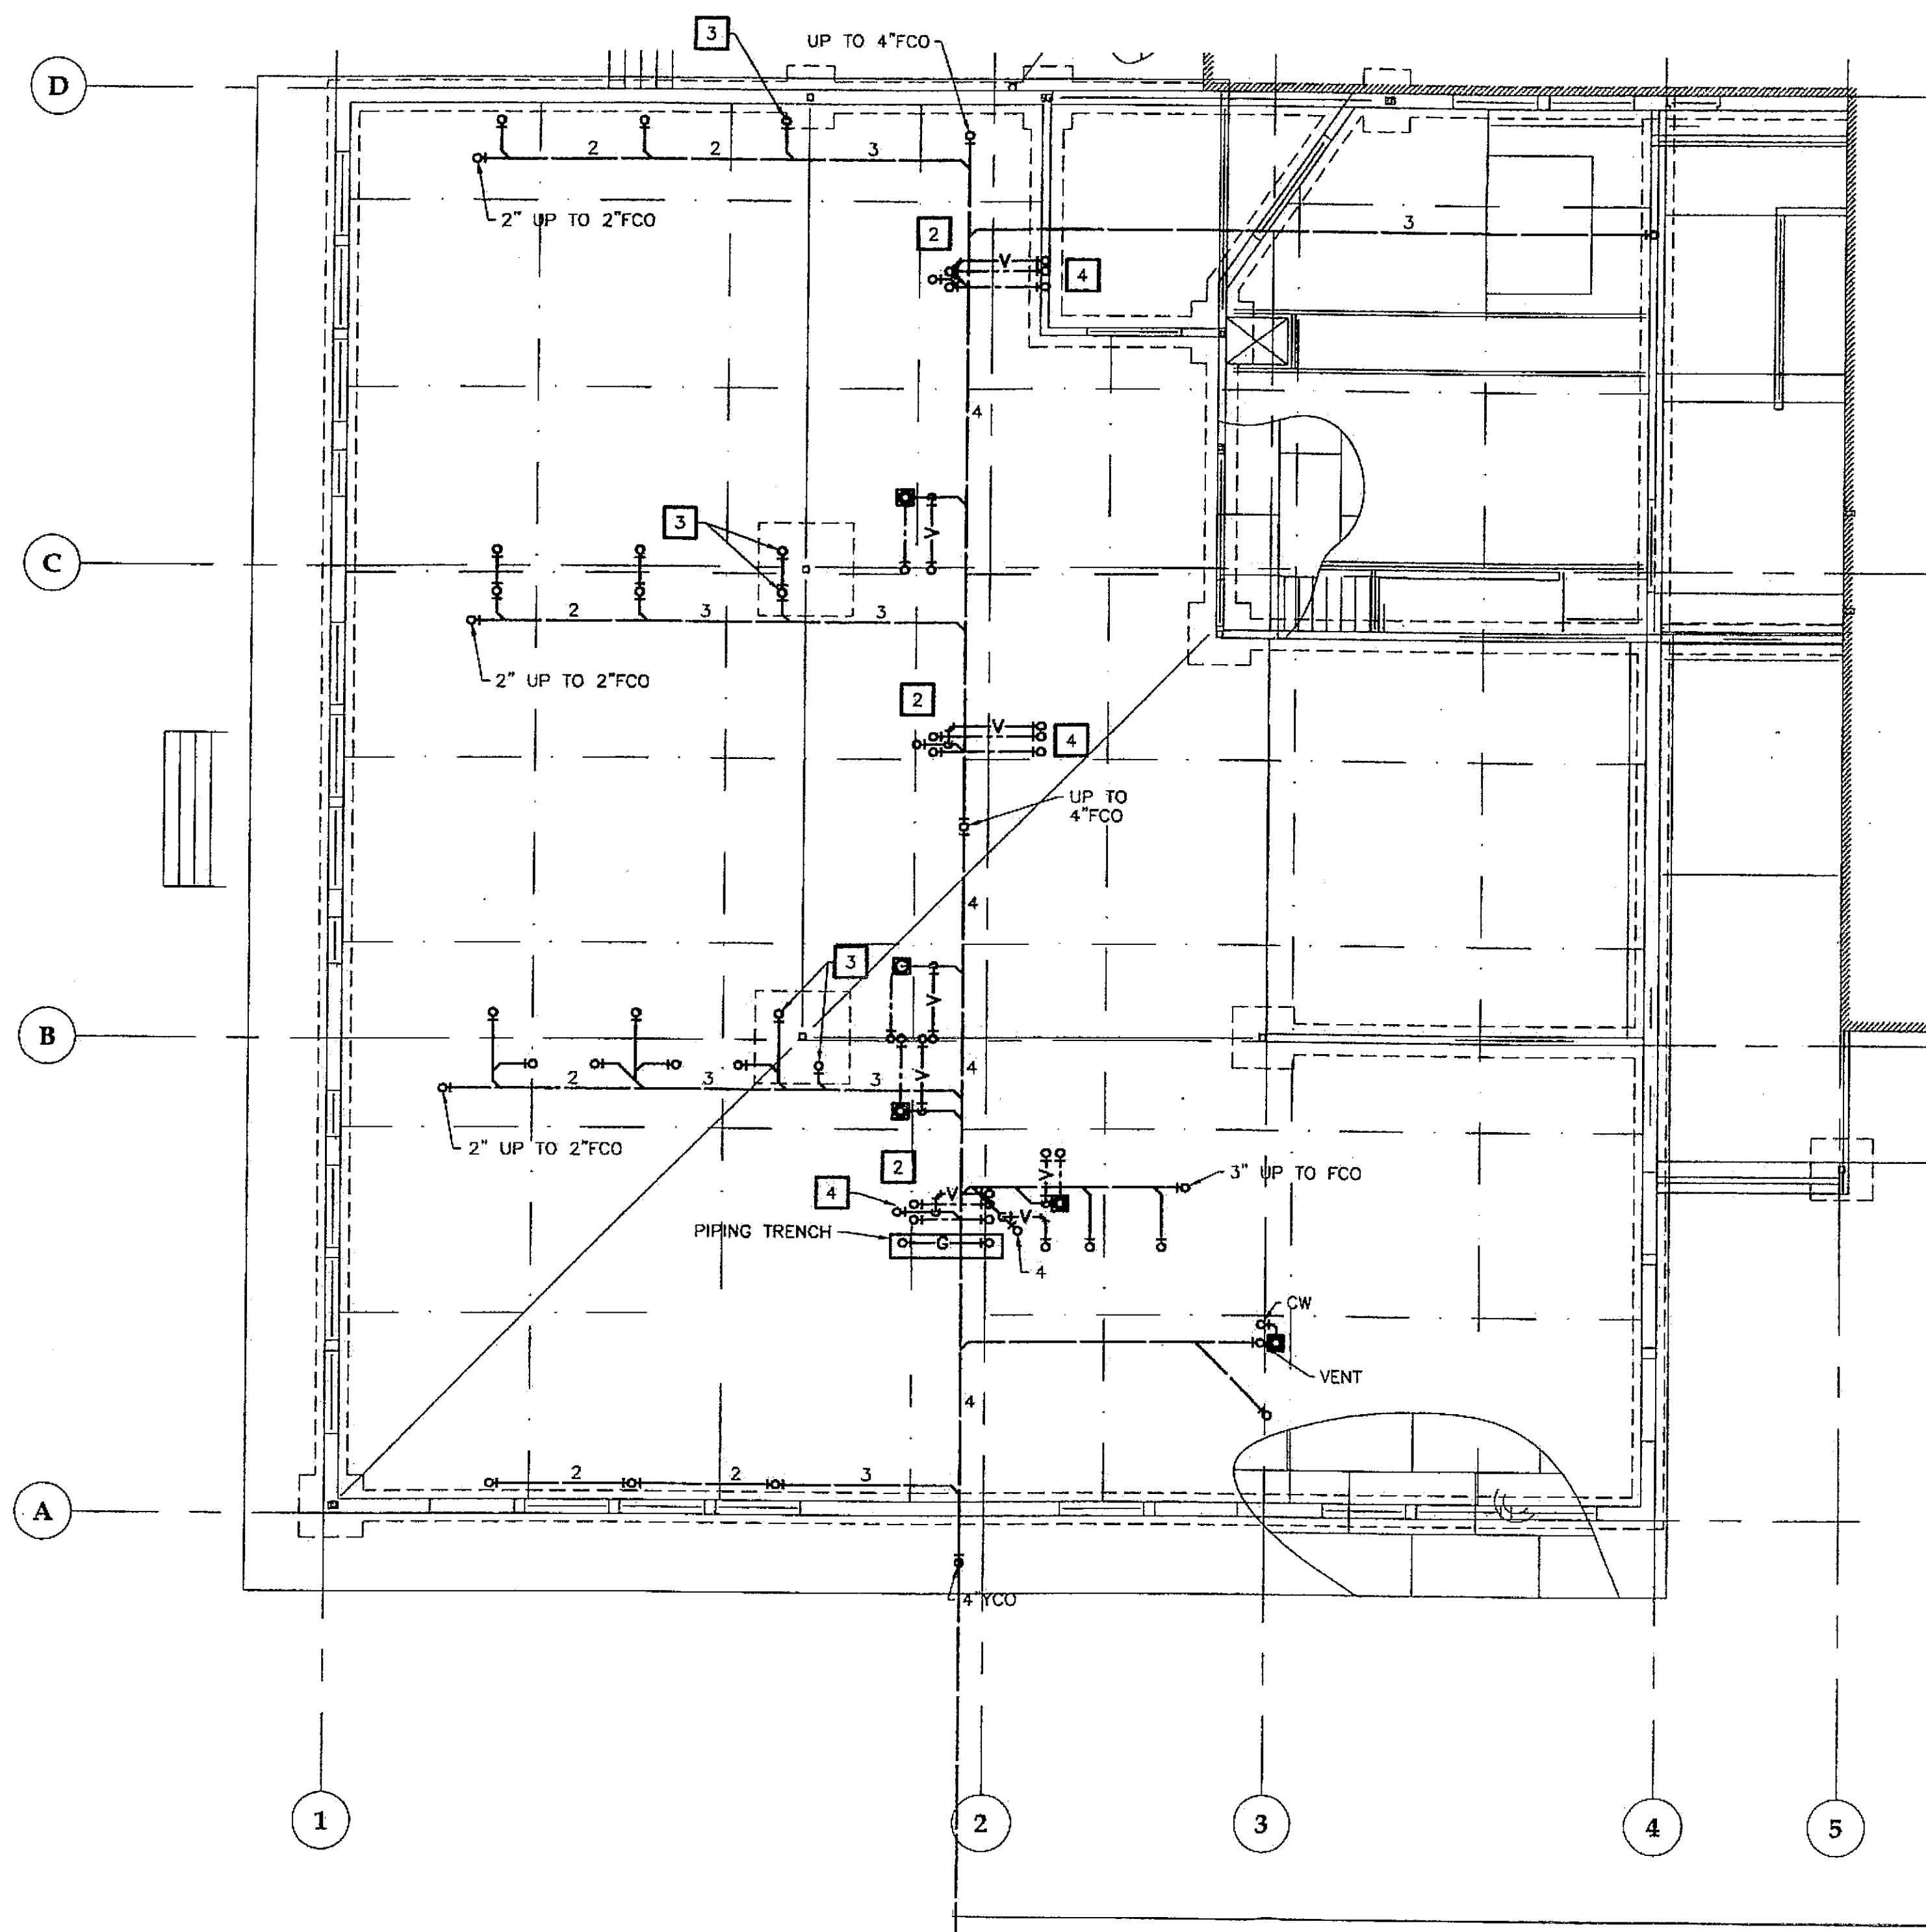

1 FOUNDATION PLAN - BUILDING C

SCALE: 0 4' 8' 16'

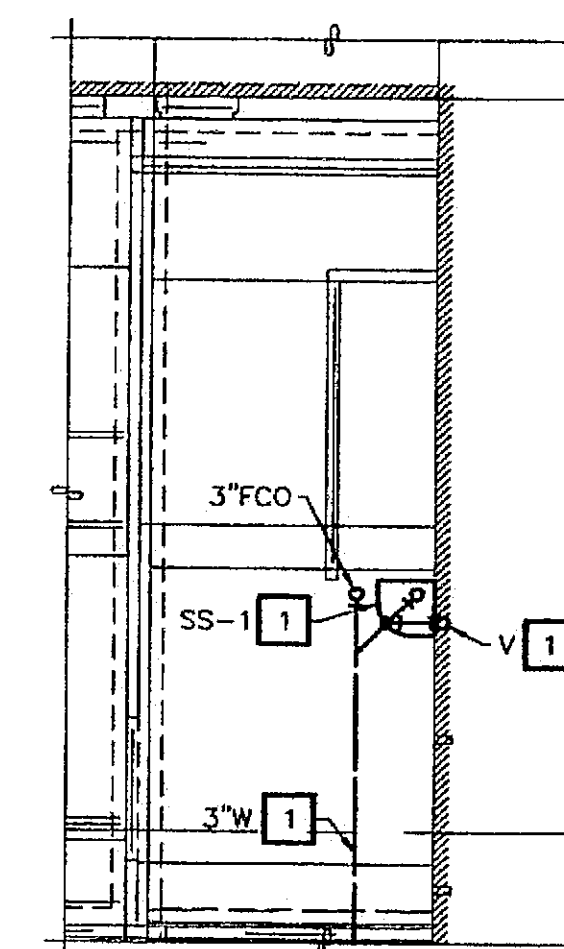

2 PART FOUNDATION PLAN-ALTERNATE

SCALE: 0 4' 8' 16'


CONSTRUCTION NOTES:

- 1 SERVICE SINK, SS-1, WASTE, AND VENT PIPING TO BE INSTALLED IN ALTERNATE WORK. SEE ARCHITECTURAL DRAWINGS FOR EXTENT OF ALTERNATE WORK. VENT PIPING ROUTED UP TO FAN ROOM.
- 2 ISLAND WASTE AND VENTING PIPING AT THESE LOCATIONS. SEE PLUMBING PIPING DIAGRAM ON SHEET M502 FOR CONFIGURATION.
- 3 SLEEVE PIPING BEFORE POURING FOOTING. COORDINATE WITH STRUCTURAL.
- 4 ROUTE POLYETHYLENE WATER, WASTE, AND VENT PIPING IN CONCRETE FLOOR TO ISLAND SINK.
- 5 ROUTE GAS PIPING IN TRENCH.

Fuel Lines
Cott 10
Remove Fuel Lines.

Service Line

CHECKED BY: DM

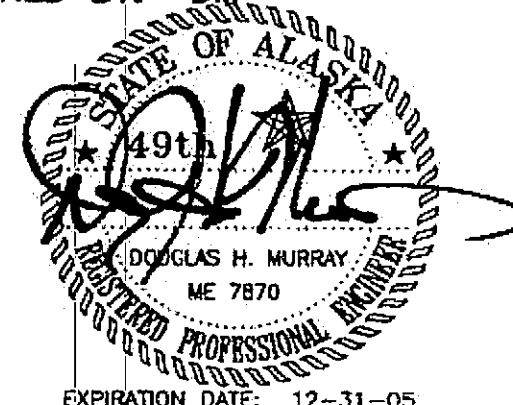

DESIGNED BY: DM/LH

DRAWN BY: WN

STATE OF ALASKA
DEPARTMENT OF TRANSPORTATION
& PUBLIC FACILITIES
STATEWIDE DESIGN & ENGINEERING
SERVICES DIVISION

MT EDGECUMBE
HIGH SCHOOL
BUILDING 1330
ACADEMIC
EXPANSION

SHEET M201

PROJECT DESIGNATION NUMBER

67751C

STATE	YEAR
ALASKA	2004
SHEET NUMBER	TOTAL SHEETS
56	79

Project As-Built Drawings have been reviewed by the Project Engineer and represent to the best of my knowledge, the project as constructed.
Proj. Eng. *[Signature]* Date *12/17/04*

Lot 2 LAB Equipment. No sinks were provided in contract. Plumbing was provided.
 But not the actual sinks. This also contained gas faucets for RM 143.

Lot 2
 Lab by Eq.
 Add sinks S-1
 Housed and

B.O.


Tue, 14/Dec/04 10:13AM

ADDENDUM NUMBER

ATTACHMENT NUMBER


RECORD OF REVISIONS

No.	DATE	DESCRIPTION

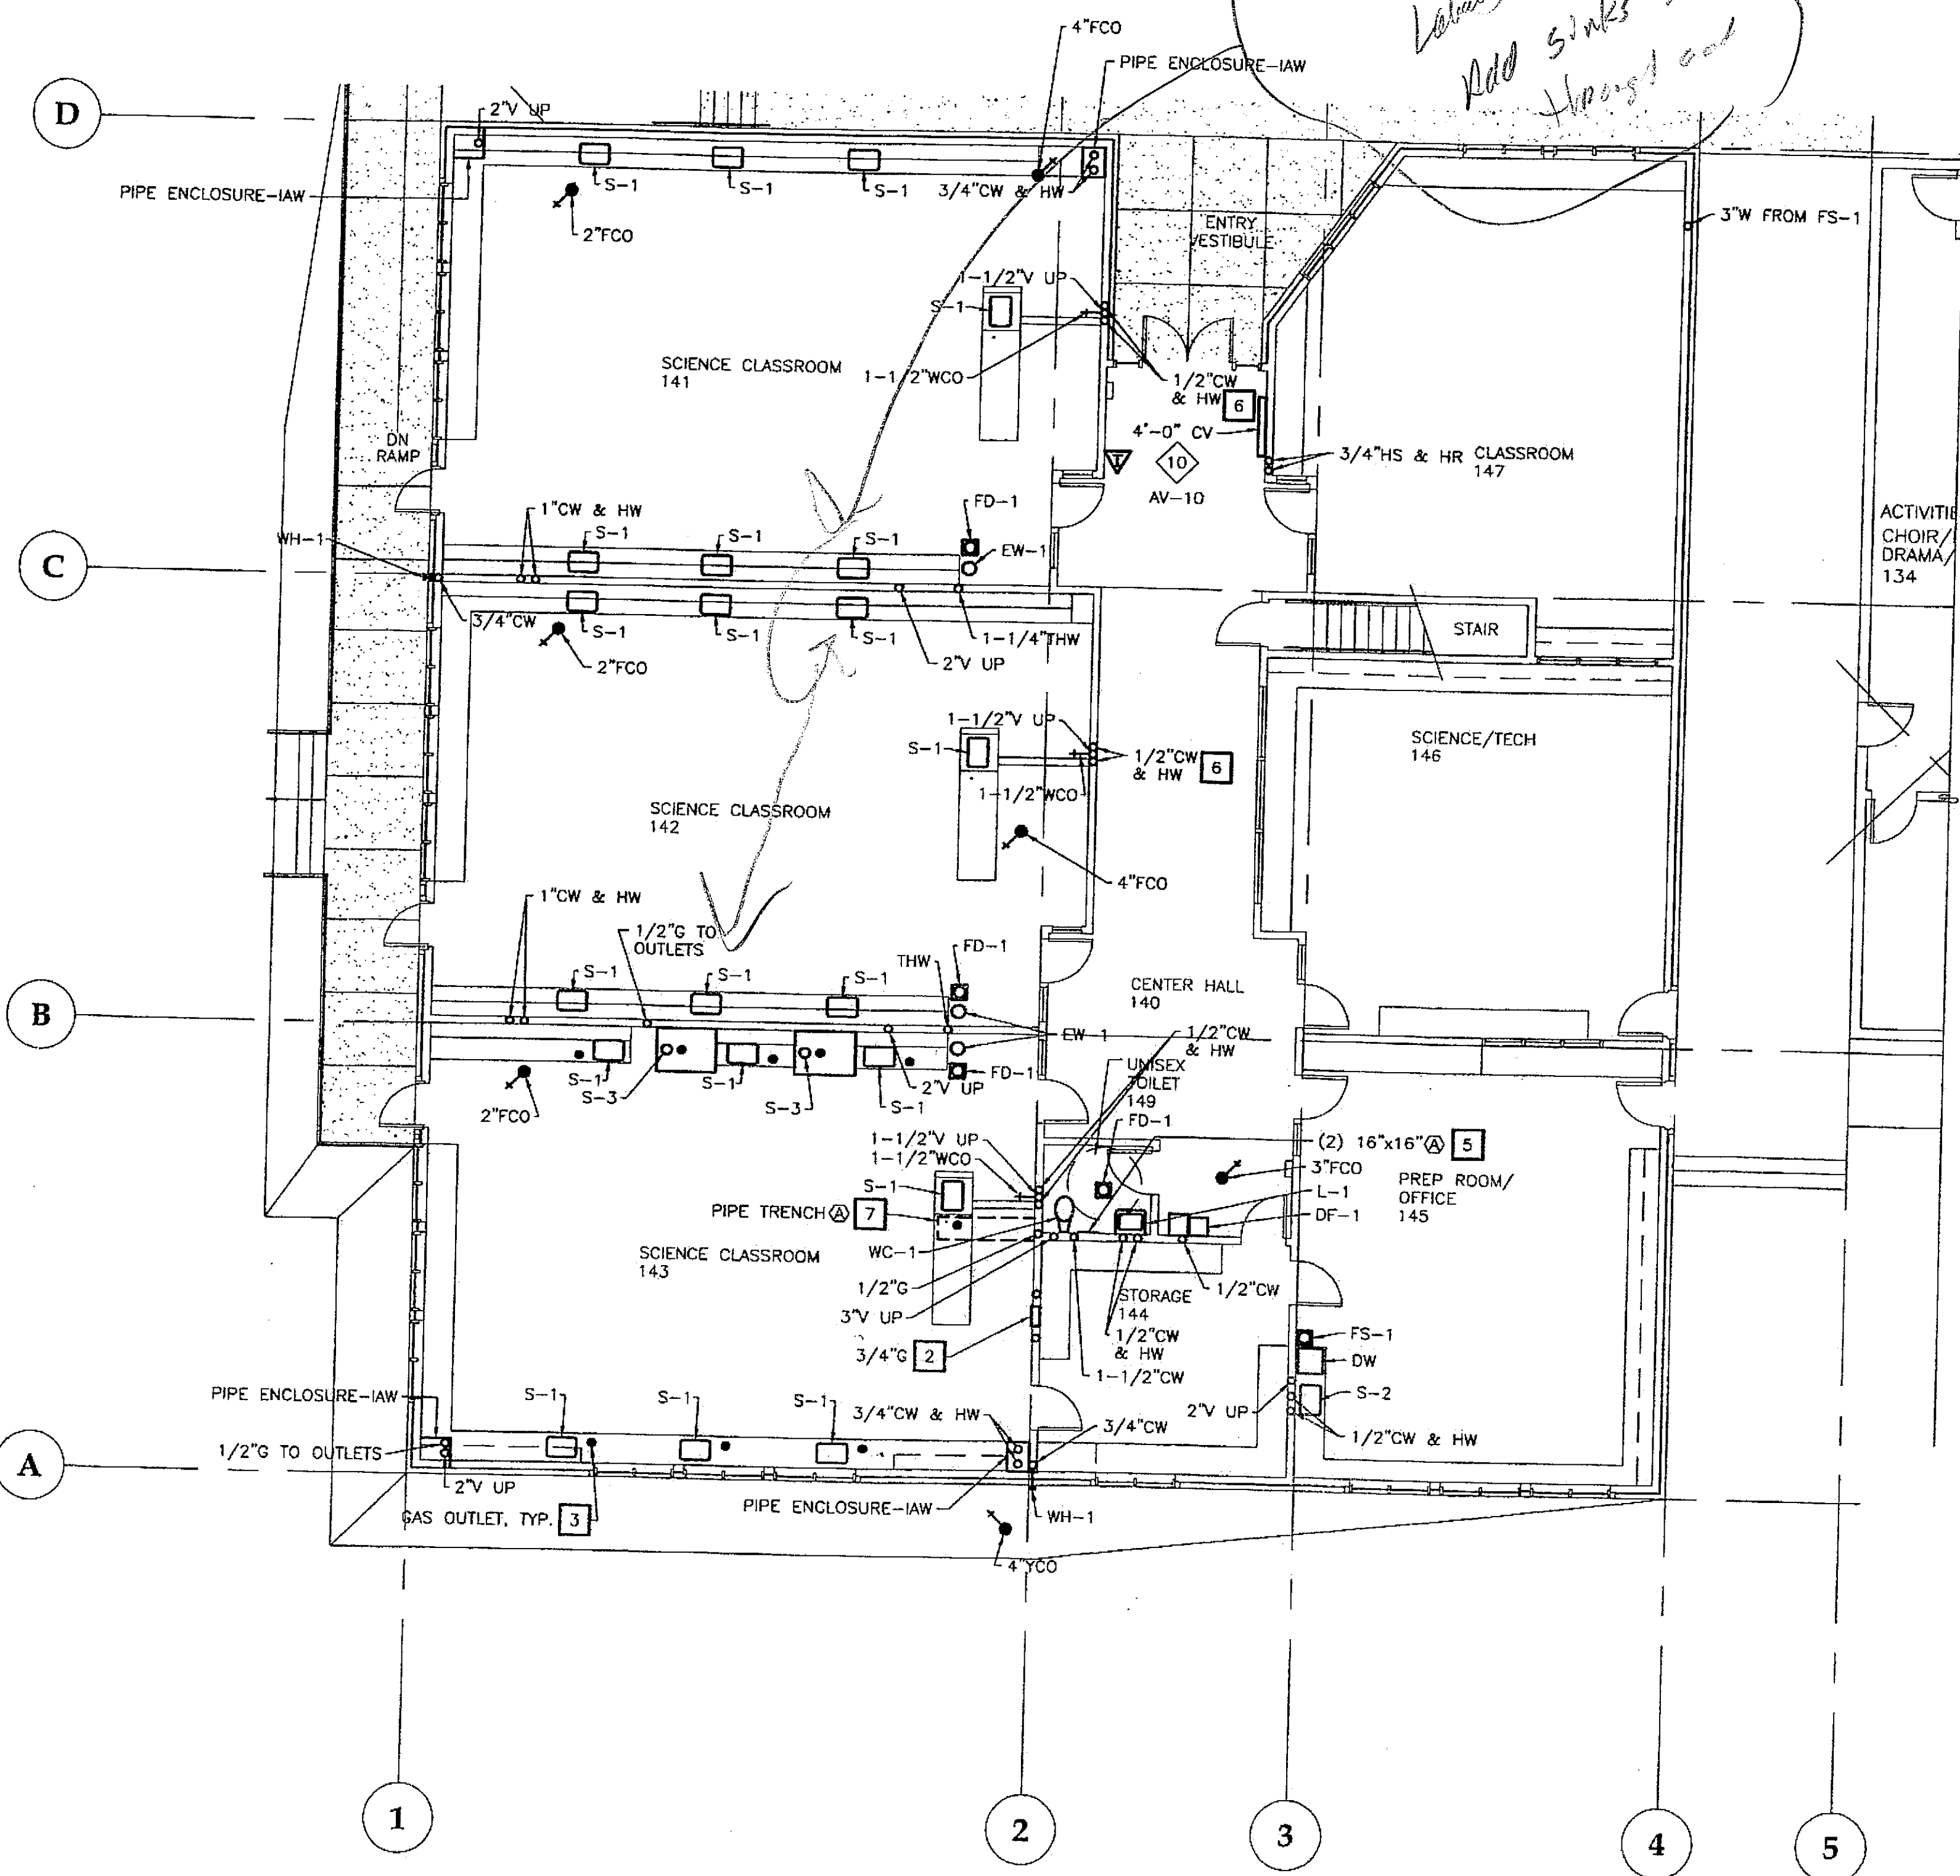

1 FLOOR PLAN - PIPING

SCALE: 0 4' 8' 16'

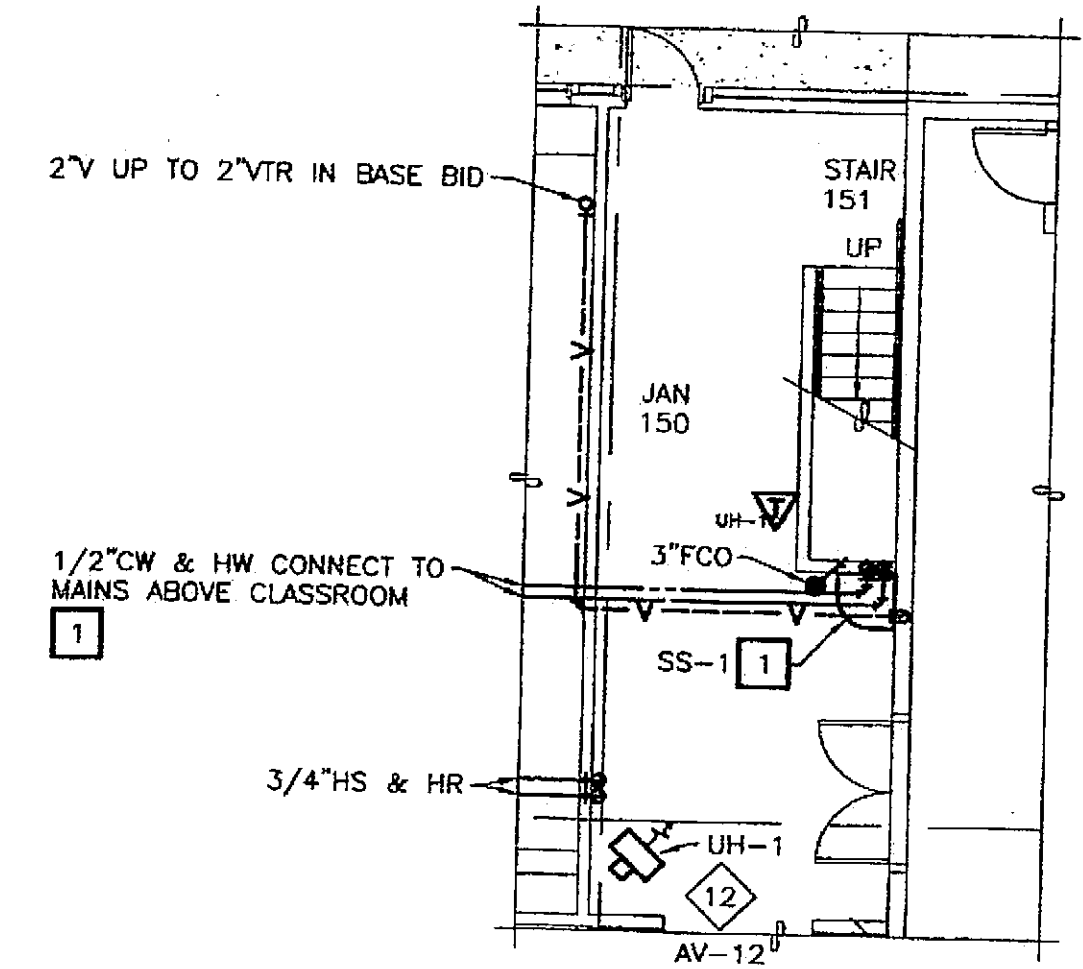

2 PART FLOOR PLAN-ALTERNATE

SCALE: 0 4' 8' 16'


CONSTRUCTION NOTES:

- 1 IN ALTERNATE WORK.
- 2 1/2" G DOWN TO MASTER SHUT OFF VALVE.
- 3 1/2" G DOWN TO GAS OUTLETS, 9 TOTAL.
- 4 ROUTE CW, HW, V PIPING IN SPACE BEHIND COUNTER.
- 5 LOCATE WATER HAMMER ARRESTOR WHA-1 AND WHA-2 BEHIND ACCESS DOOR-HIGH. LOCATE TRAP PRIMER FOR FD & FS BEHIND ACCESS DOOR-LOW.
- 6 ROUTE POLYETHYLENE WATER, WASTE, AND VENT PIPING IN CONCRETE FLOOR TO ISLAND SINK.
- 7 ROUTE GAS PIPING IN TRENCH.

SHEET NOTES:

1. VENT PIPING FROM INDIVIDUAL SINKS IS TO BE ROUTED BEHIND CABINETRY SEPARATELY AND MANIFOLDED TOGETHER MINIMUM 12 INCHES ABOVE RIM OF FIXTURES SERVED.

CHECKED BY: DM

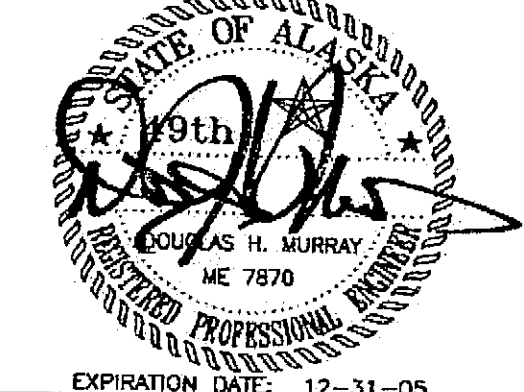

EXPIRATION DATE: 12-31-05

DESIGNED BY: DM/LH

DRAWN BY: WN

STATE OF ALASKA
DEPARTMENT OF TRANSPORTATION
& PUBLIC FACILITIES
STATEWIDE DESIGN & ENGINEERING
SERVICES DIVISION

MT EDGE CUMBE
HIGH SCHOOL
BUILDING 1330
ACADEMIC
EXPANSION

SHEET M202

PROJECT DESIGNATION NUMBER

67751C

STATE YEAR

ALASKA 2004

SHEET NUMBER TOTAL SHEETS

57

79

Project As-Built Drawings have been
 reviewed by the Project Engineer and
 represent to the best of my knowledge, the
 project as constructed.
 Proj. Eng. *[Signature]* Date *2/14/05*

M-67761-D


Tue, 14/Dec/04 02:53PM

ADDENDUM NUMBER

ATTACHMENT NUMBER

RECORD OF REVISIONS

No.	DATE	DESCRIPTION

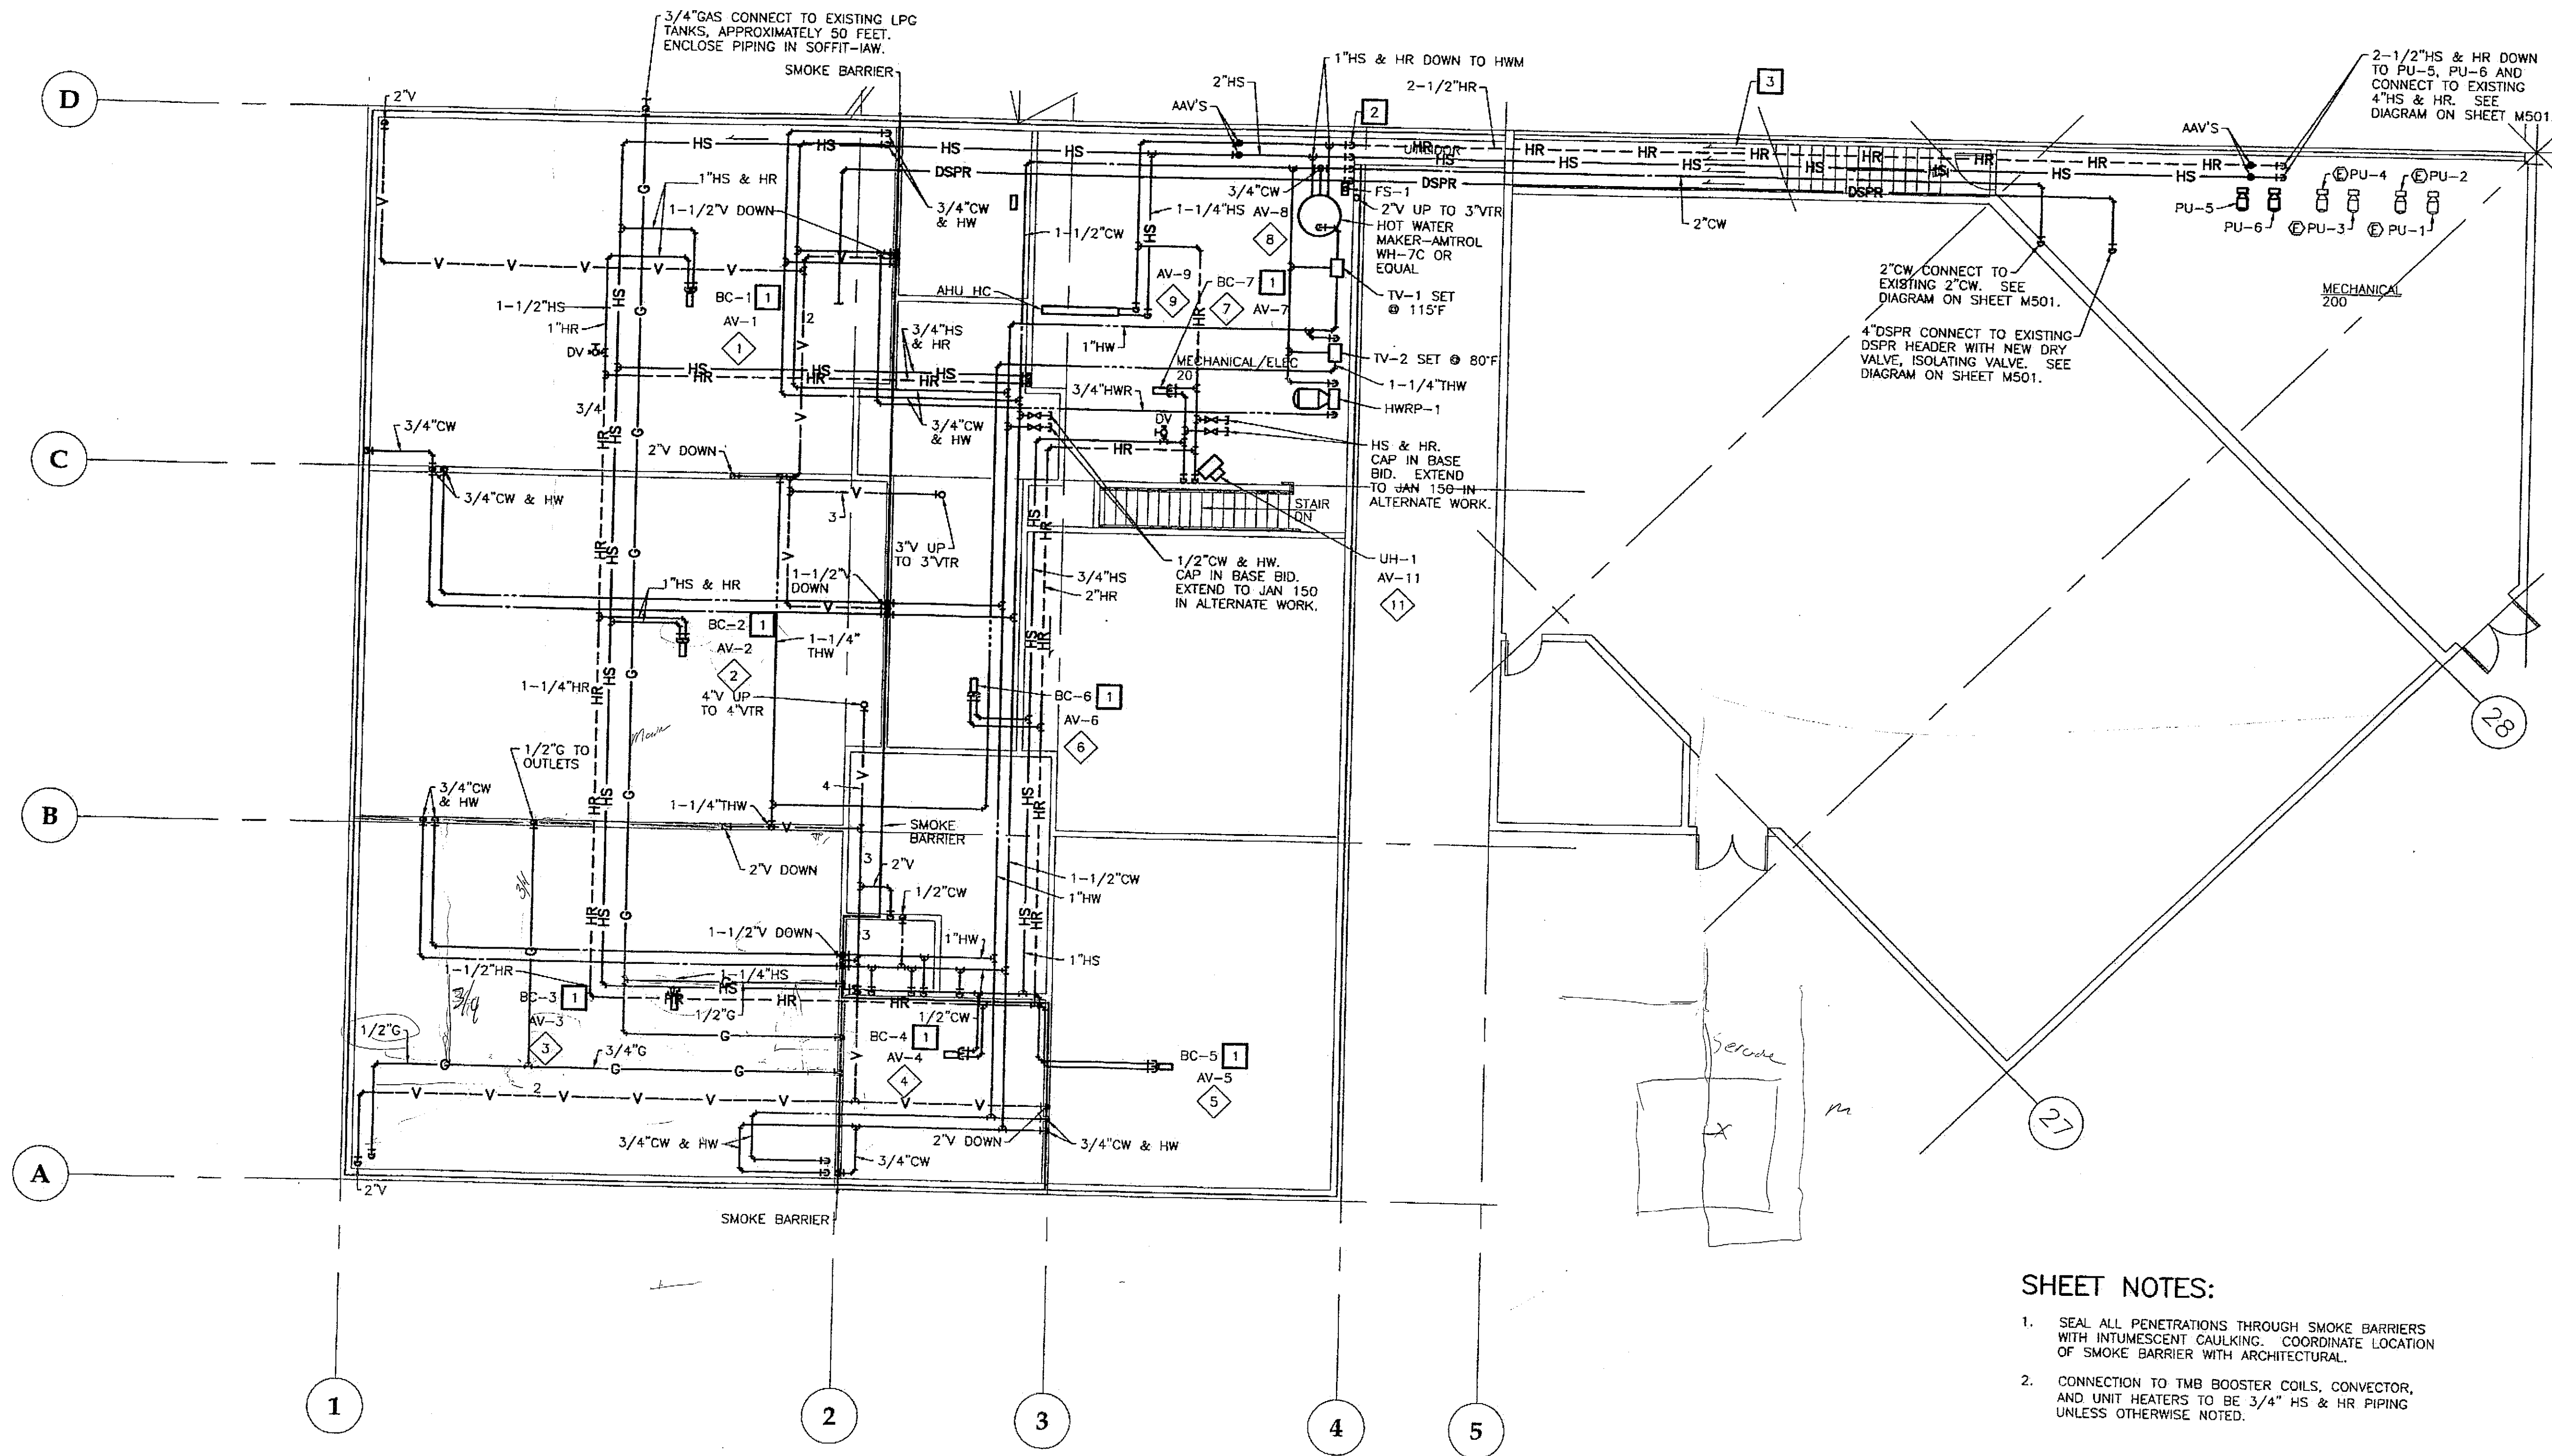

1 ATTIC FLOOR PLAN - PIPING

SCALE: 0 4' 8' 16'

SHEET NOTES:

1. SEAL ALL PENETRATIONS THROUGH SMOKE BARRIERS WITH INTUMESCENT CAULKING. COORDINATE LOCATION OF SMOKE BARRIER WITH ARCHITECTURAL.
2. CONNECTION TO TMB BOOSTER COILS, CONVECTOR, AND UNIT HEATERS TO BE 3/4" HS & HR PIPING UNLESS OTHERWISE NOTED.

CONSTRUCTION NOTES:

1. SEE DETAIL ON SHEET M701.
2. ELBOW PIPING DOWN TO ROUTE PIPING THROUGH CANOPY AREA. COORDINATE WITH HEIGHT OF CANOPY. INSTALL AUXILIARY DRAIN AT LOW POINT OF DRY SPRINKLER PIPE. COORDINATE DRAIN LOCATION.
3. ROUTE PIPING AS HIGH AS POSSIBLE. PITCH PIPING DOWN FOLLOWING PITCH OF STAIRWELL. PROJECT AS-BUILT DRAWINGS HAVE BEEN REVIEWED BY THE PROJECT ENGINEER AND REPRESENTS TO THE BEST OF MY KNOWLEDGE, THE PROJECT AS CONSTRUCTED.
Proj. Eng. *[Signature]* Date *12/14/04*

48-30-
3840
A04
55
Corson

CHECKED BY: DM
[Signature]
STATE OF ALASKA
19th
DANIEL H. MURRAY
ME 7870
REGISTERED PROFESSIONAL ENGINEER
EXPIRATION DATE: 12-31-05

DESIGNED BY: DM/LH
DRAWN BY: WN

STATE OF ALASKA
DEPARTMENT OF TRANSPORTATION
& PUBLIC FACILITIES
STATEWIDE DESIGN & ENGINEERING
SERVICES DIVISION
MT EDGE CUMBE
HIGH SCHOOL
BUILDING 1330
ACADEMIC
EXPANSION

SHEET M203	
PROJECT DESIGNATION NUMBER	
67751C	
STATE	YEAR
ALASKA	2004
SHEET NUMBER	TOTAL SHEETS
58	79

ADDENDUM NUMBER


ATTACHMENT NUMBER

RECORD OF REVISIONS

No.	DATE	DESCRIPTION


CONSTRUCTION NOTES:

1. INSTALL 3/4" GAS PIPING ABOVE CEILINGS OR ENCLOSED IN SOFFIT UNDER EXISTING CANOPY. CONNECT TO 1/2" AT WALL WHERE SHOWN.
2. RELOCATE THERMOSTAT TO WHERE SHOWN, MOUNT AT 4'-0" AFF. PROVIDE NEW PNEUMATIC TUBING AS REQUIRED. TEST HEATING CONTROL AND REPORT ANY DEFICIENCIES TO OWNER.

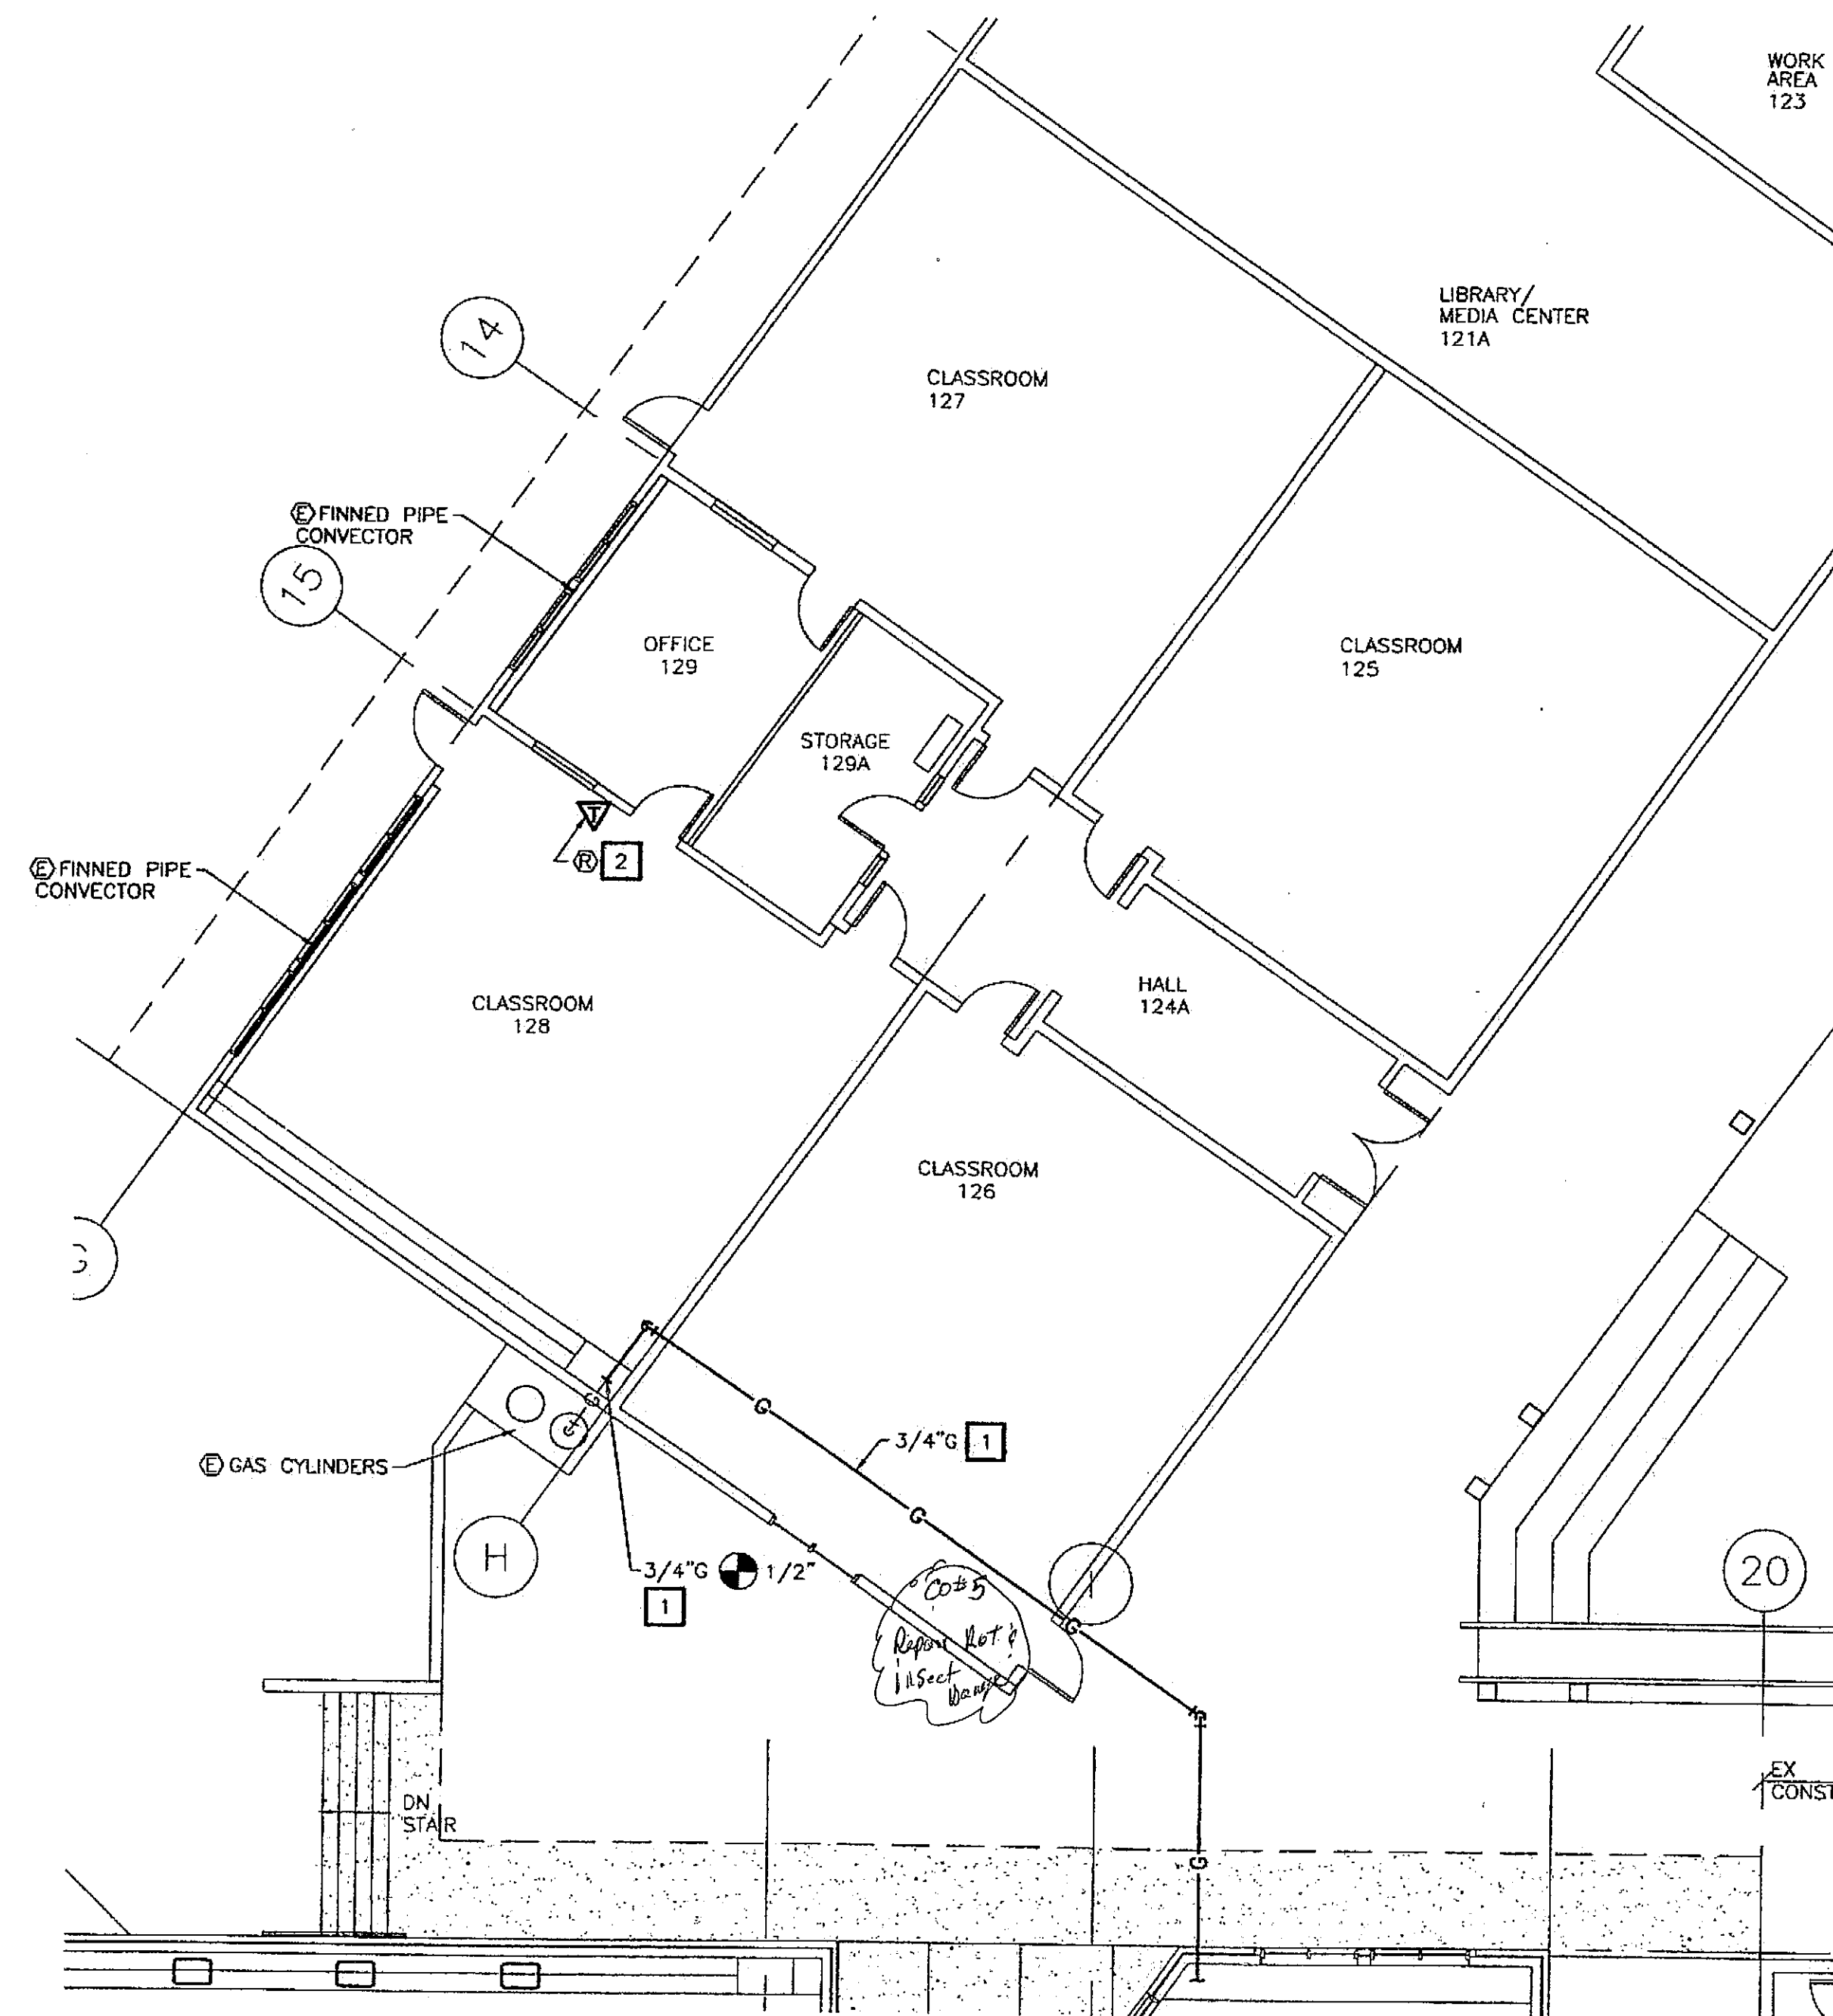


1 FLOOR PLAN - BUILDING A CLASSROOMS

SCALE: 0 4' 8' 16'

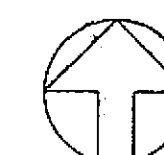

Project As-Built Drawings have been reviewed by the Project Engineer and represent to the best of my knowledge, the project as constructed.
 Proj. Eng. *Thuy* Day 2007

CHECKED BY: DM

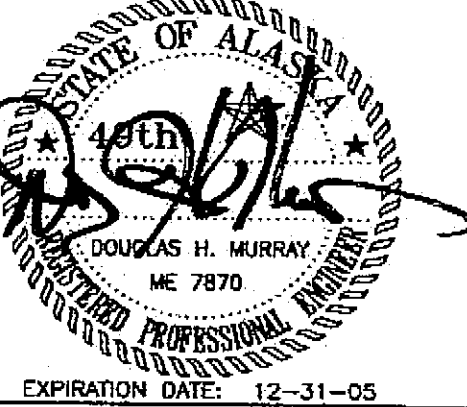

EXPIRATION DATE: 12-31-05

DESIGNED BY: DM/LH

DRAWN BY: WN

STATE OF ALASKA
 DEPARTMENT OF TRANSPORTATION
 & PUBLIC FACILITIES
 STATEWIDE DESIGN & ENGINEERING
 SERVICES DIVISION

MT EDGE CUMBE
 HIGH SCHOOL
 BUILDING 1330
 ACADEMIC
 EXPANSION

SHEET M204

PROJECT DESIGNATION NUMBER

67751C


STATE	YEAR
ALASKA	2004
SHEET NUMBER	TOTAL SHEETS
59	79

CONSTRUCTION NOTES:

1 IN ALTERNATE WORK.

SHEET NOTES:


1. ALL SUPPLY DIFFUSERS TO BE 12"x12" WITH 12"ø COLLAR IN 24"x24" LAY-IN PANEL. ALL RETURN/EXHAUST GRILLES TO BE 18"x18" SIZE.

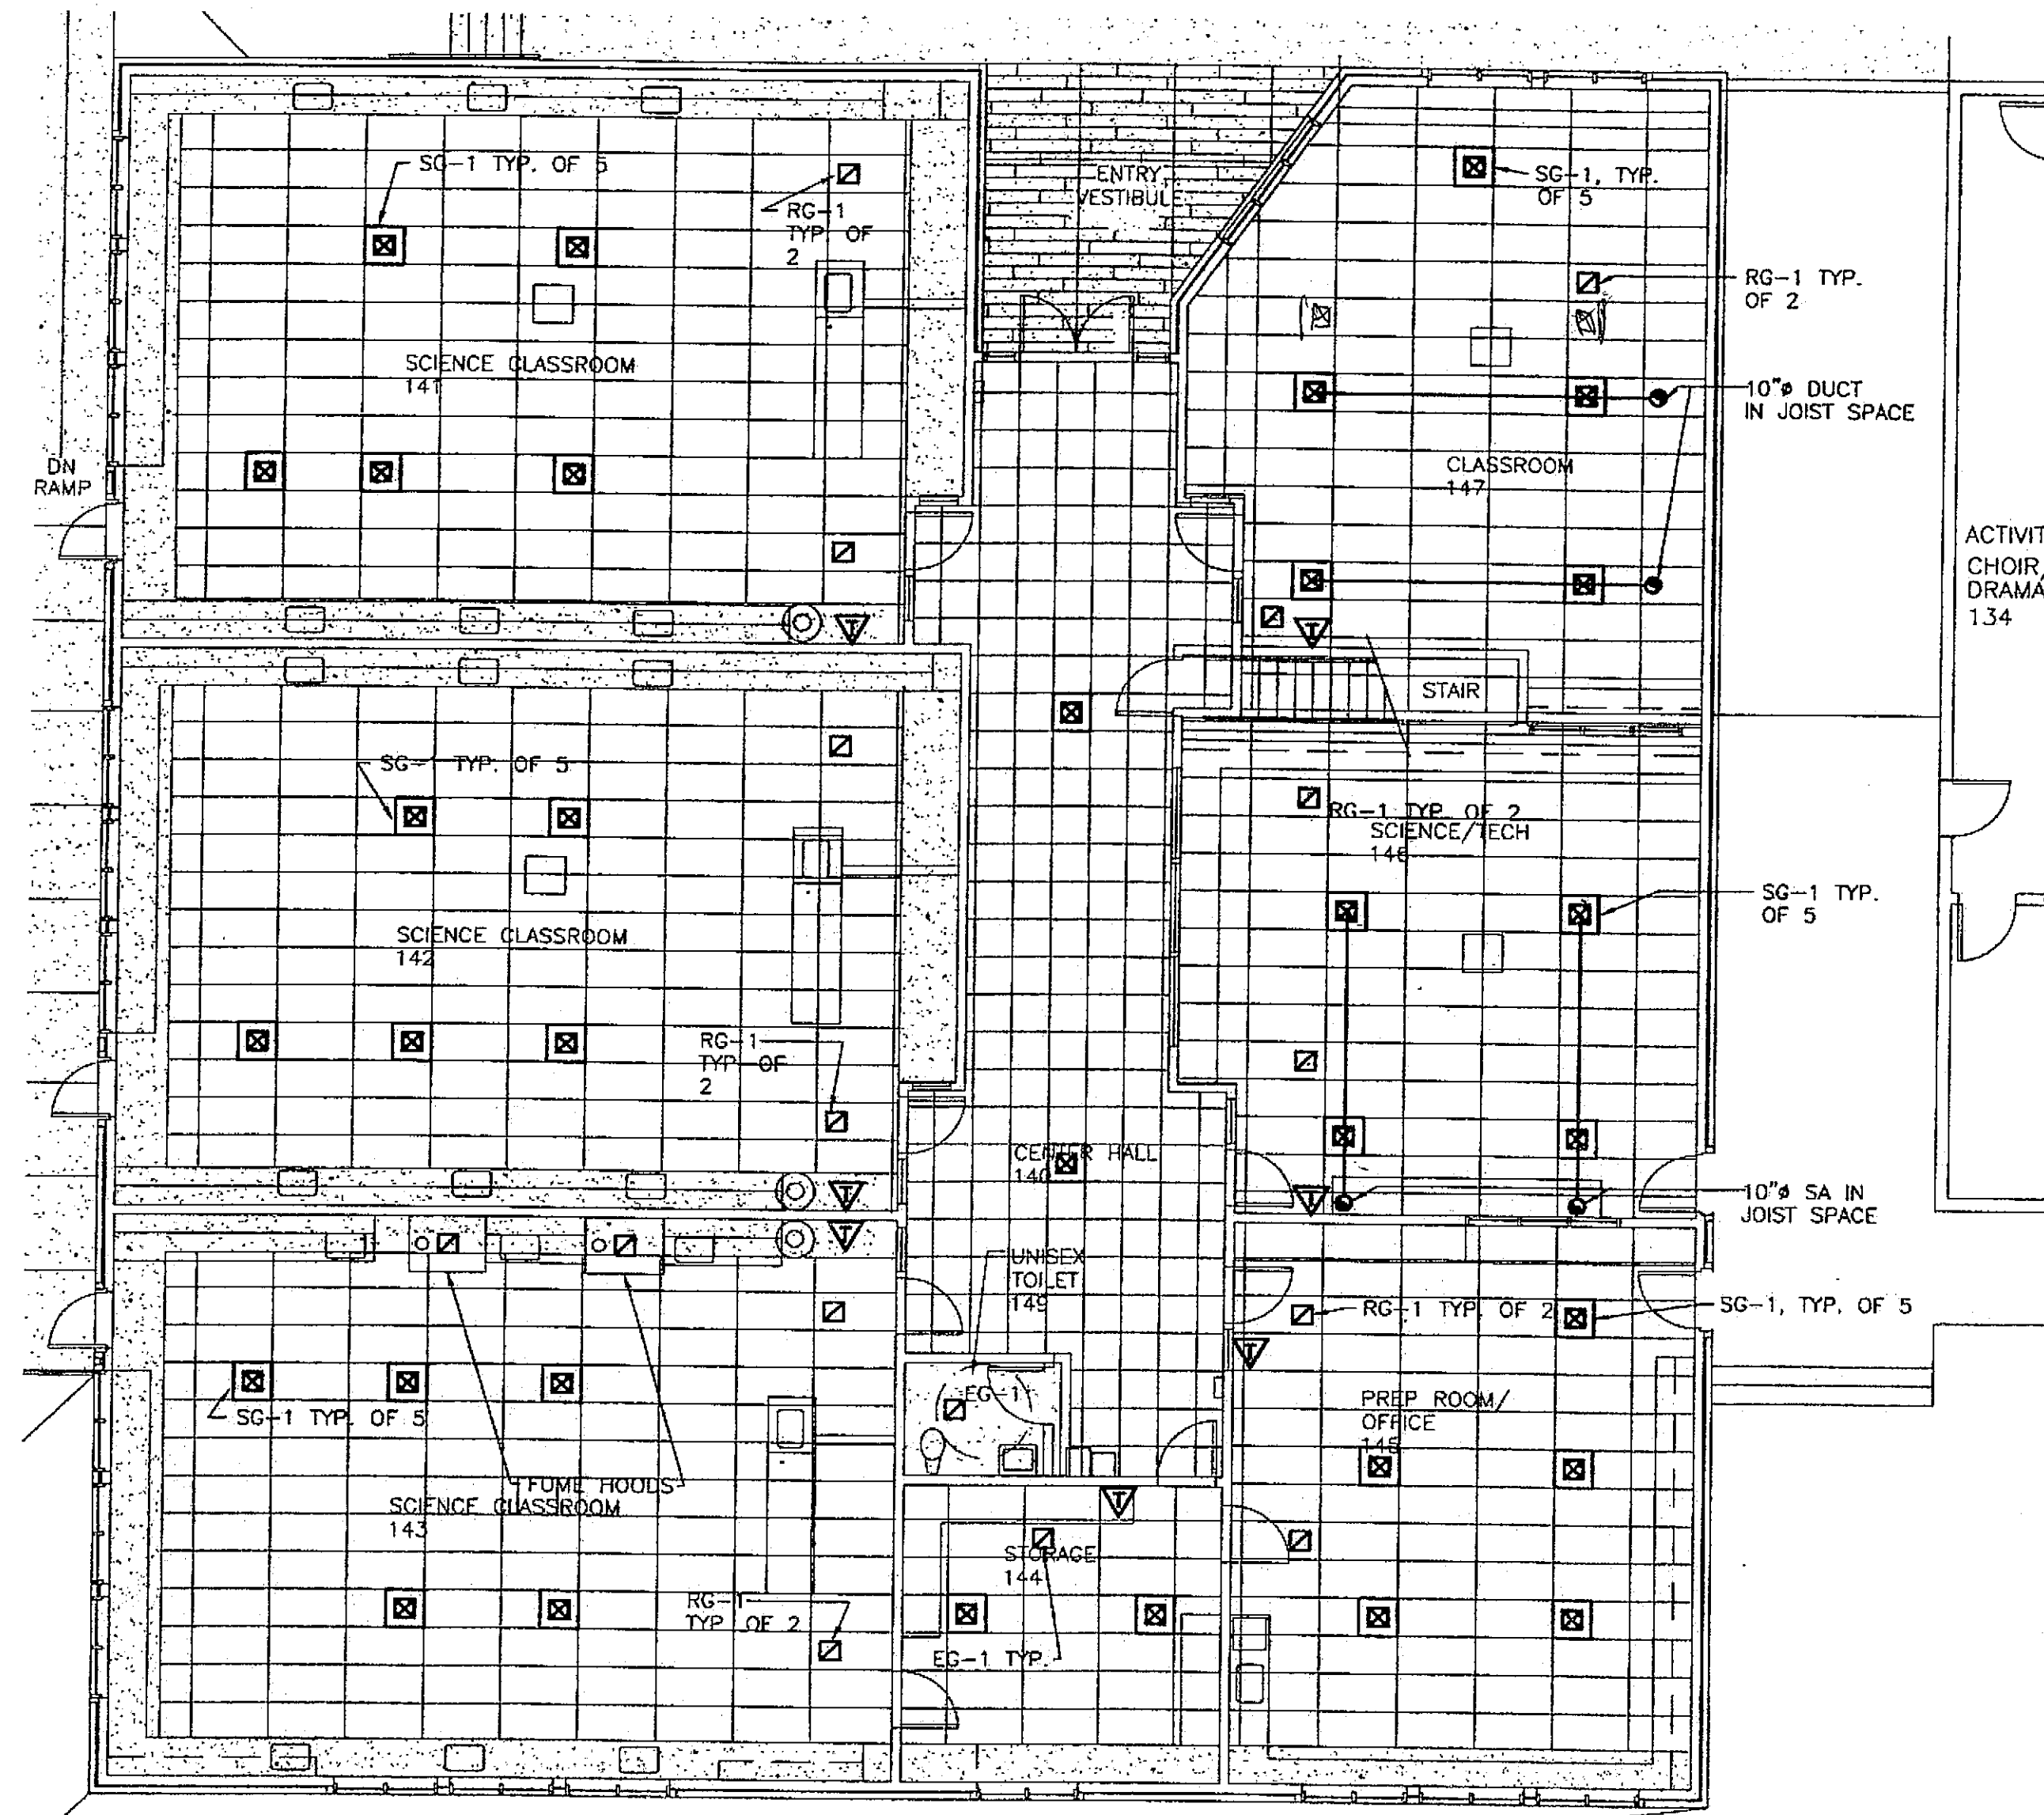


1

FLOOR PLAN - VENTILATION

SCALE: 0 4' 8' 16'

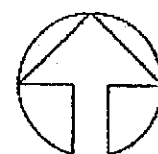


NOTE: *ALTERNATE WORK

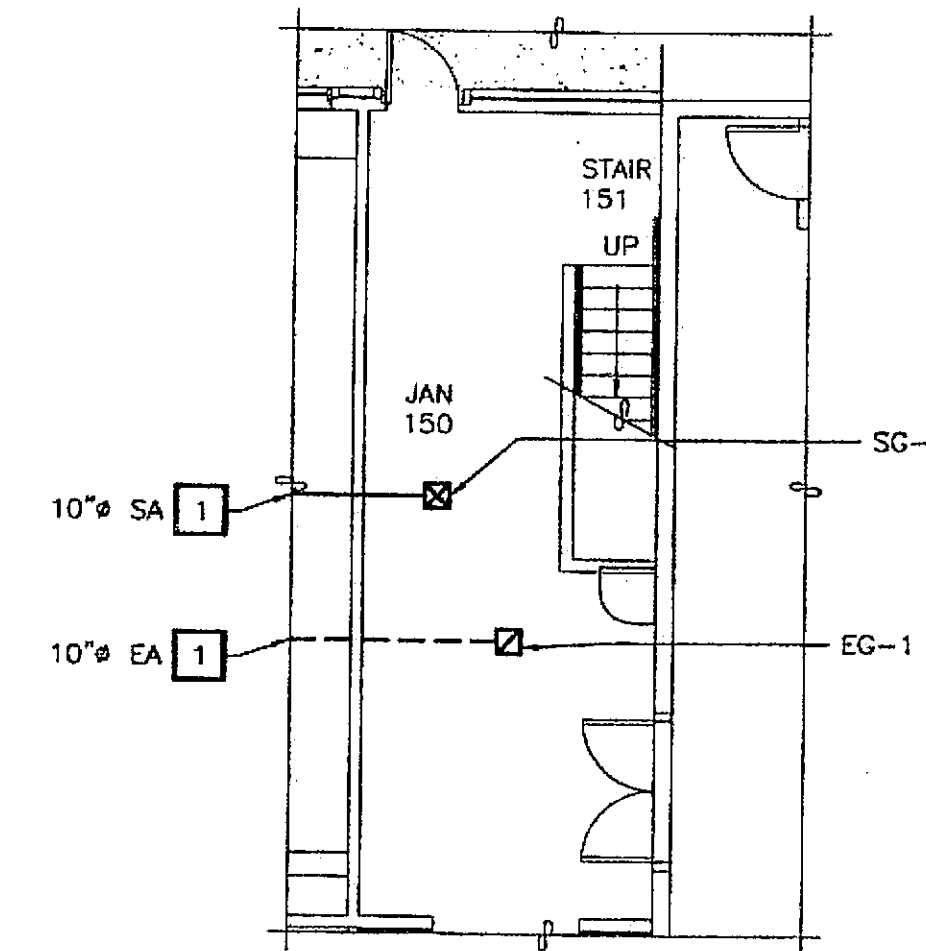

2

PART FLOOR PLAN-ALTERNATE

SCALE: 0 4' 8' 16'

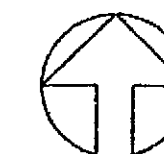

DIFFUSER AND GRILLE SCHEDULE

NOTE: SEE FLOOR PLANS FOR DIFFUSER BLOW PATTERNS

SUPPLY CEILING DIFFUSER OR WALL GRILLE						RETURN OR EXHAUST GRILLE					
ROOM	MARK	NUMBER	SUPPLY CFM	FACE SIZE	NECK SIZE	MARK	NUMBER	RETURN CFM	EXHAUST CFM	FACE SIZE	NECK SIZE
140	SG-1	2	240	12 X 12	8"ø	-	-	-	-	-	-
141	SG-1	5	238	12 X 12	10"ø	RG-1	2	570	-	24 X 22	24 X 22
142	SG-1	5	238	12 X 12	10"ø	RG-1	2	570	-	24 X 22	24 X 22
143	SG-1	5	292	12 X 12	12"ø	RG-1	2	695	-	24 X 24	24 X 24
144	SG-1	2	125	9 X 9	8"ø	EG-1	1	-	280	20 X 20	20 X 20
145	SG-1	5	135	9 X 9	8"ø	RG-1	2	320	-	20 X 20	20 X 20
146	SG-1	4	162	12 X 12	8"ø	RG-1	2	310	-	20 X 20	20 X 20
147	SG-1	5	162	12 X 12	8"ø	RG-1	2	385	-	20 X 20	20 X 20
149	-	-	-	-	-	EG-1	1	-	90	10 X 10	10 X 10
*150	SG-1	1	350	12 X 12	12"ø	EG-1	1	-	390	20 X 20	20 X 20

Project As-Built Drawings have been reviewed by the Project Engineer and represent to the best of my knowledge, the project as constructed.
 Proj. Eng. *M. M. M.* Date 7-07

Tue, 14/Dec/04 02:54PM
 TAB: 11x17


ADDENDUM NUMBER

ATTACHMENT NUMBER

RECORD OF REVISIONS

No.	DATE	DESCRIPTION

CHECKED BY: DM

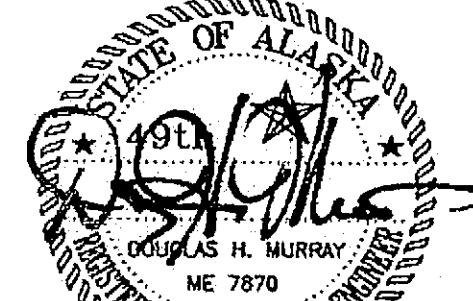

EXPIRATION DATE: 12-31-05

DESIGNED BY: DM/LH

DRAWN BY: WN

STATE OF ALASKA
 DEPARTMENT OF TRANSPORTATION
 & PUBLIC FACILITIES
 STATEWIDE DESIGN & ENGINEERING
 SERVICES DIVISION

MT EDGE CUMBE
 HIGH SCHOOL
 BUILDING 1330
 ACADEMIC
 EXPANSION

SHEET M302

PROJECT DESIGNATION NUMBER

67751C


STATE	YEAR
ALASKA	2004
SHEET NUMBER	TOTAL SHEETS
60	80

SHEET NOTES:

1. INLET DIAMETER TO TMB'S IS 8" UNLESS SHOWN OTHERWISE. OUTLET DIAMETER OF TMB'S TO DIFFUSERS IS 8" UNLESS SHOWN OTHERWISE.
2. INDIVIDUAL RETURN DUCTS TO GRILLES ARE 10"Ø UNLESS SHOWN OTHERWISE.
3. SEAL ALL PENETRATIONS THROUGH SMOKE BARRIERS WITH INTUMESCENT CAULKING.


CONSTRUCTION NOTES:

- 1 IN ALTERNATE WORK. DUCTWORK TO JANITOR. CAP 10" DIAMETER DUCT IN BASE BID.

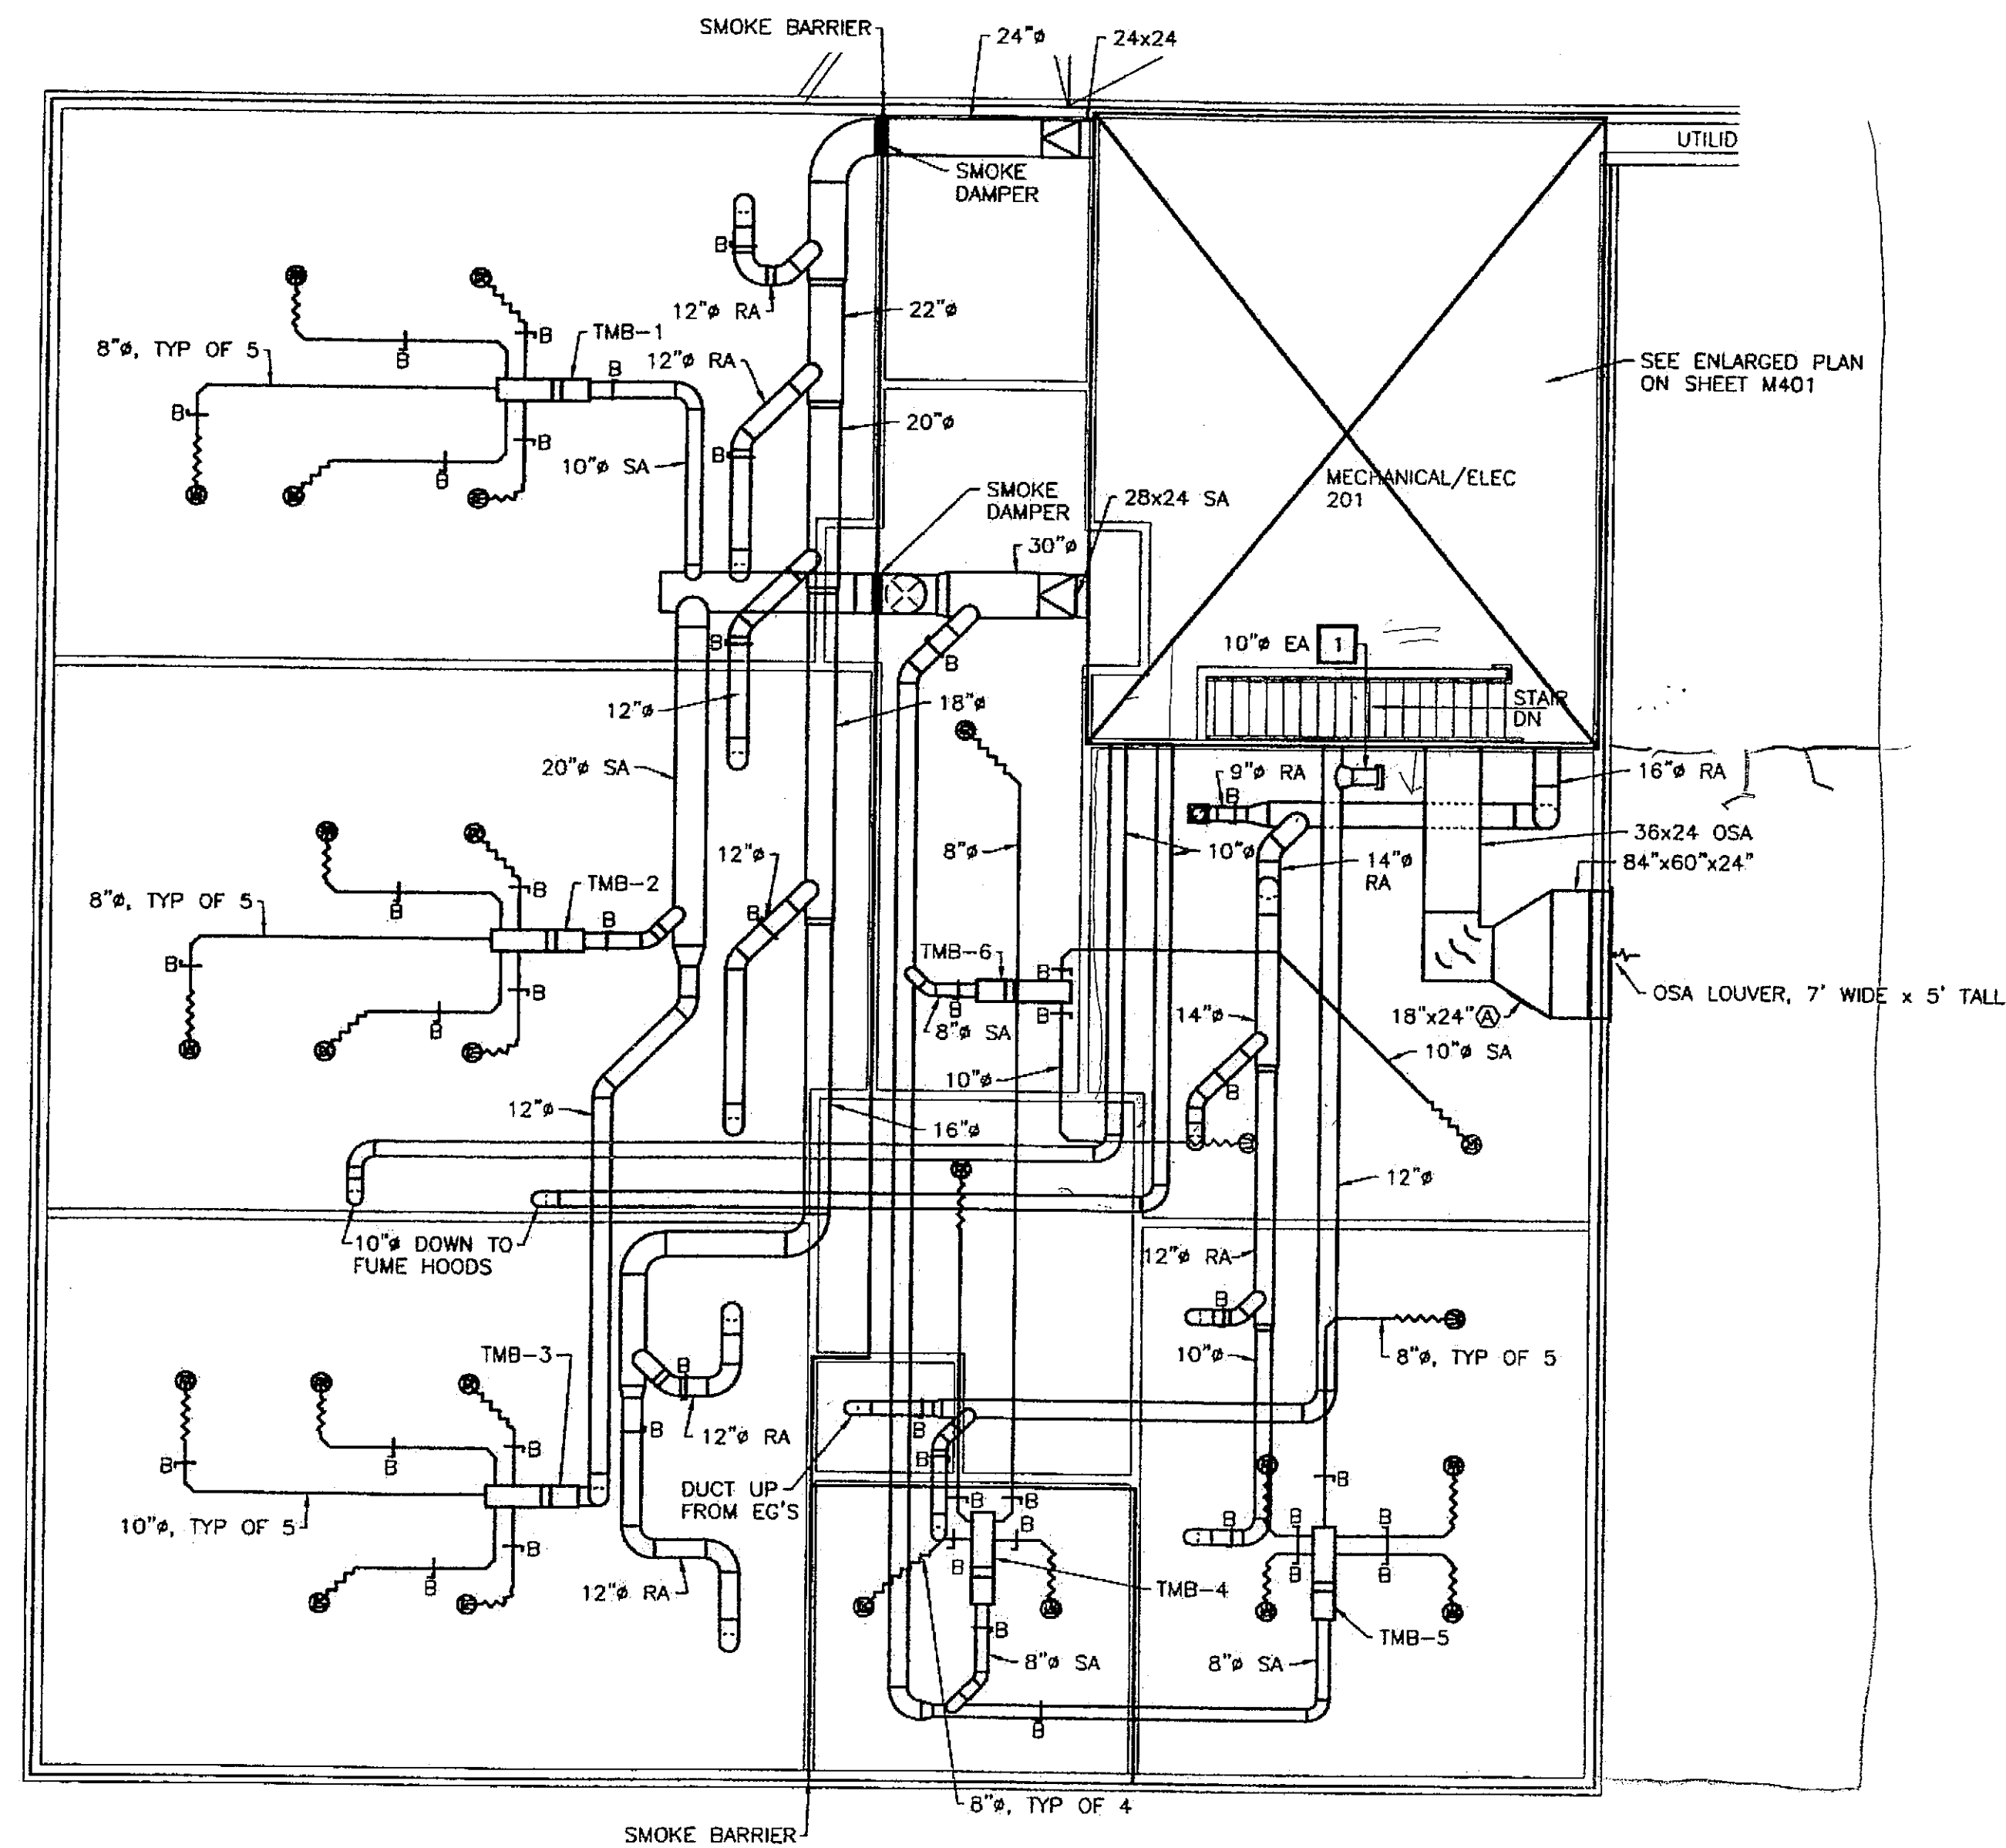


1 MEZZANINE FLOOR PLAN - DUCTWORK

SCALE: 0 4' 8' 1

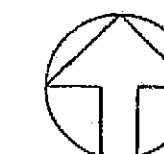

Project As-Built Drawings have been reviewed by the Project Engineer and represent to the best of my knowledge, the project as constructed.
Proj. Eng. [Signature] Date 7-07

CHECKED BY: DM

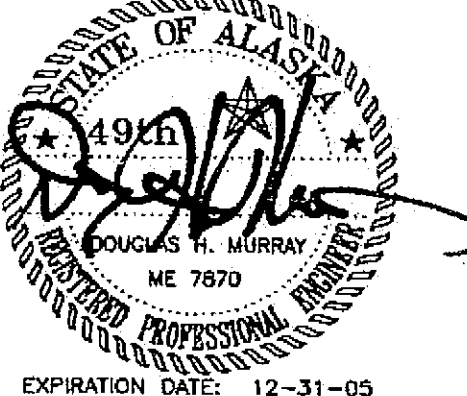

EXPIRATION DATE: 12-31-05

DESIGNED BY: DM/LH

DRAWN BY: WN

STATE OF ALASKA
DEPARTMENT OF TRANSPORTATION
& PUBLIC FACILITIES
STATEWIDE DESIGN & ENGINEERING
SERVICES DIVISION

MT EDGE CUMBE
HIGH SCHOOL
BUILDING 1330
ACADEMIC
EXPANSION

SHEET M303

PROJECT DESIGNATION NUMBER

67751C


STATE	YEAR
-------	------

ALASKA	2004
--------	------

SHEET NUMBER	TOTAL SHEETS
--------------	--------------

NET NUMBER	TOTAL STILETS
61	70

61	79
----	----

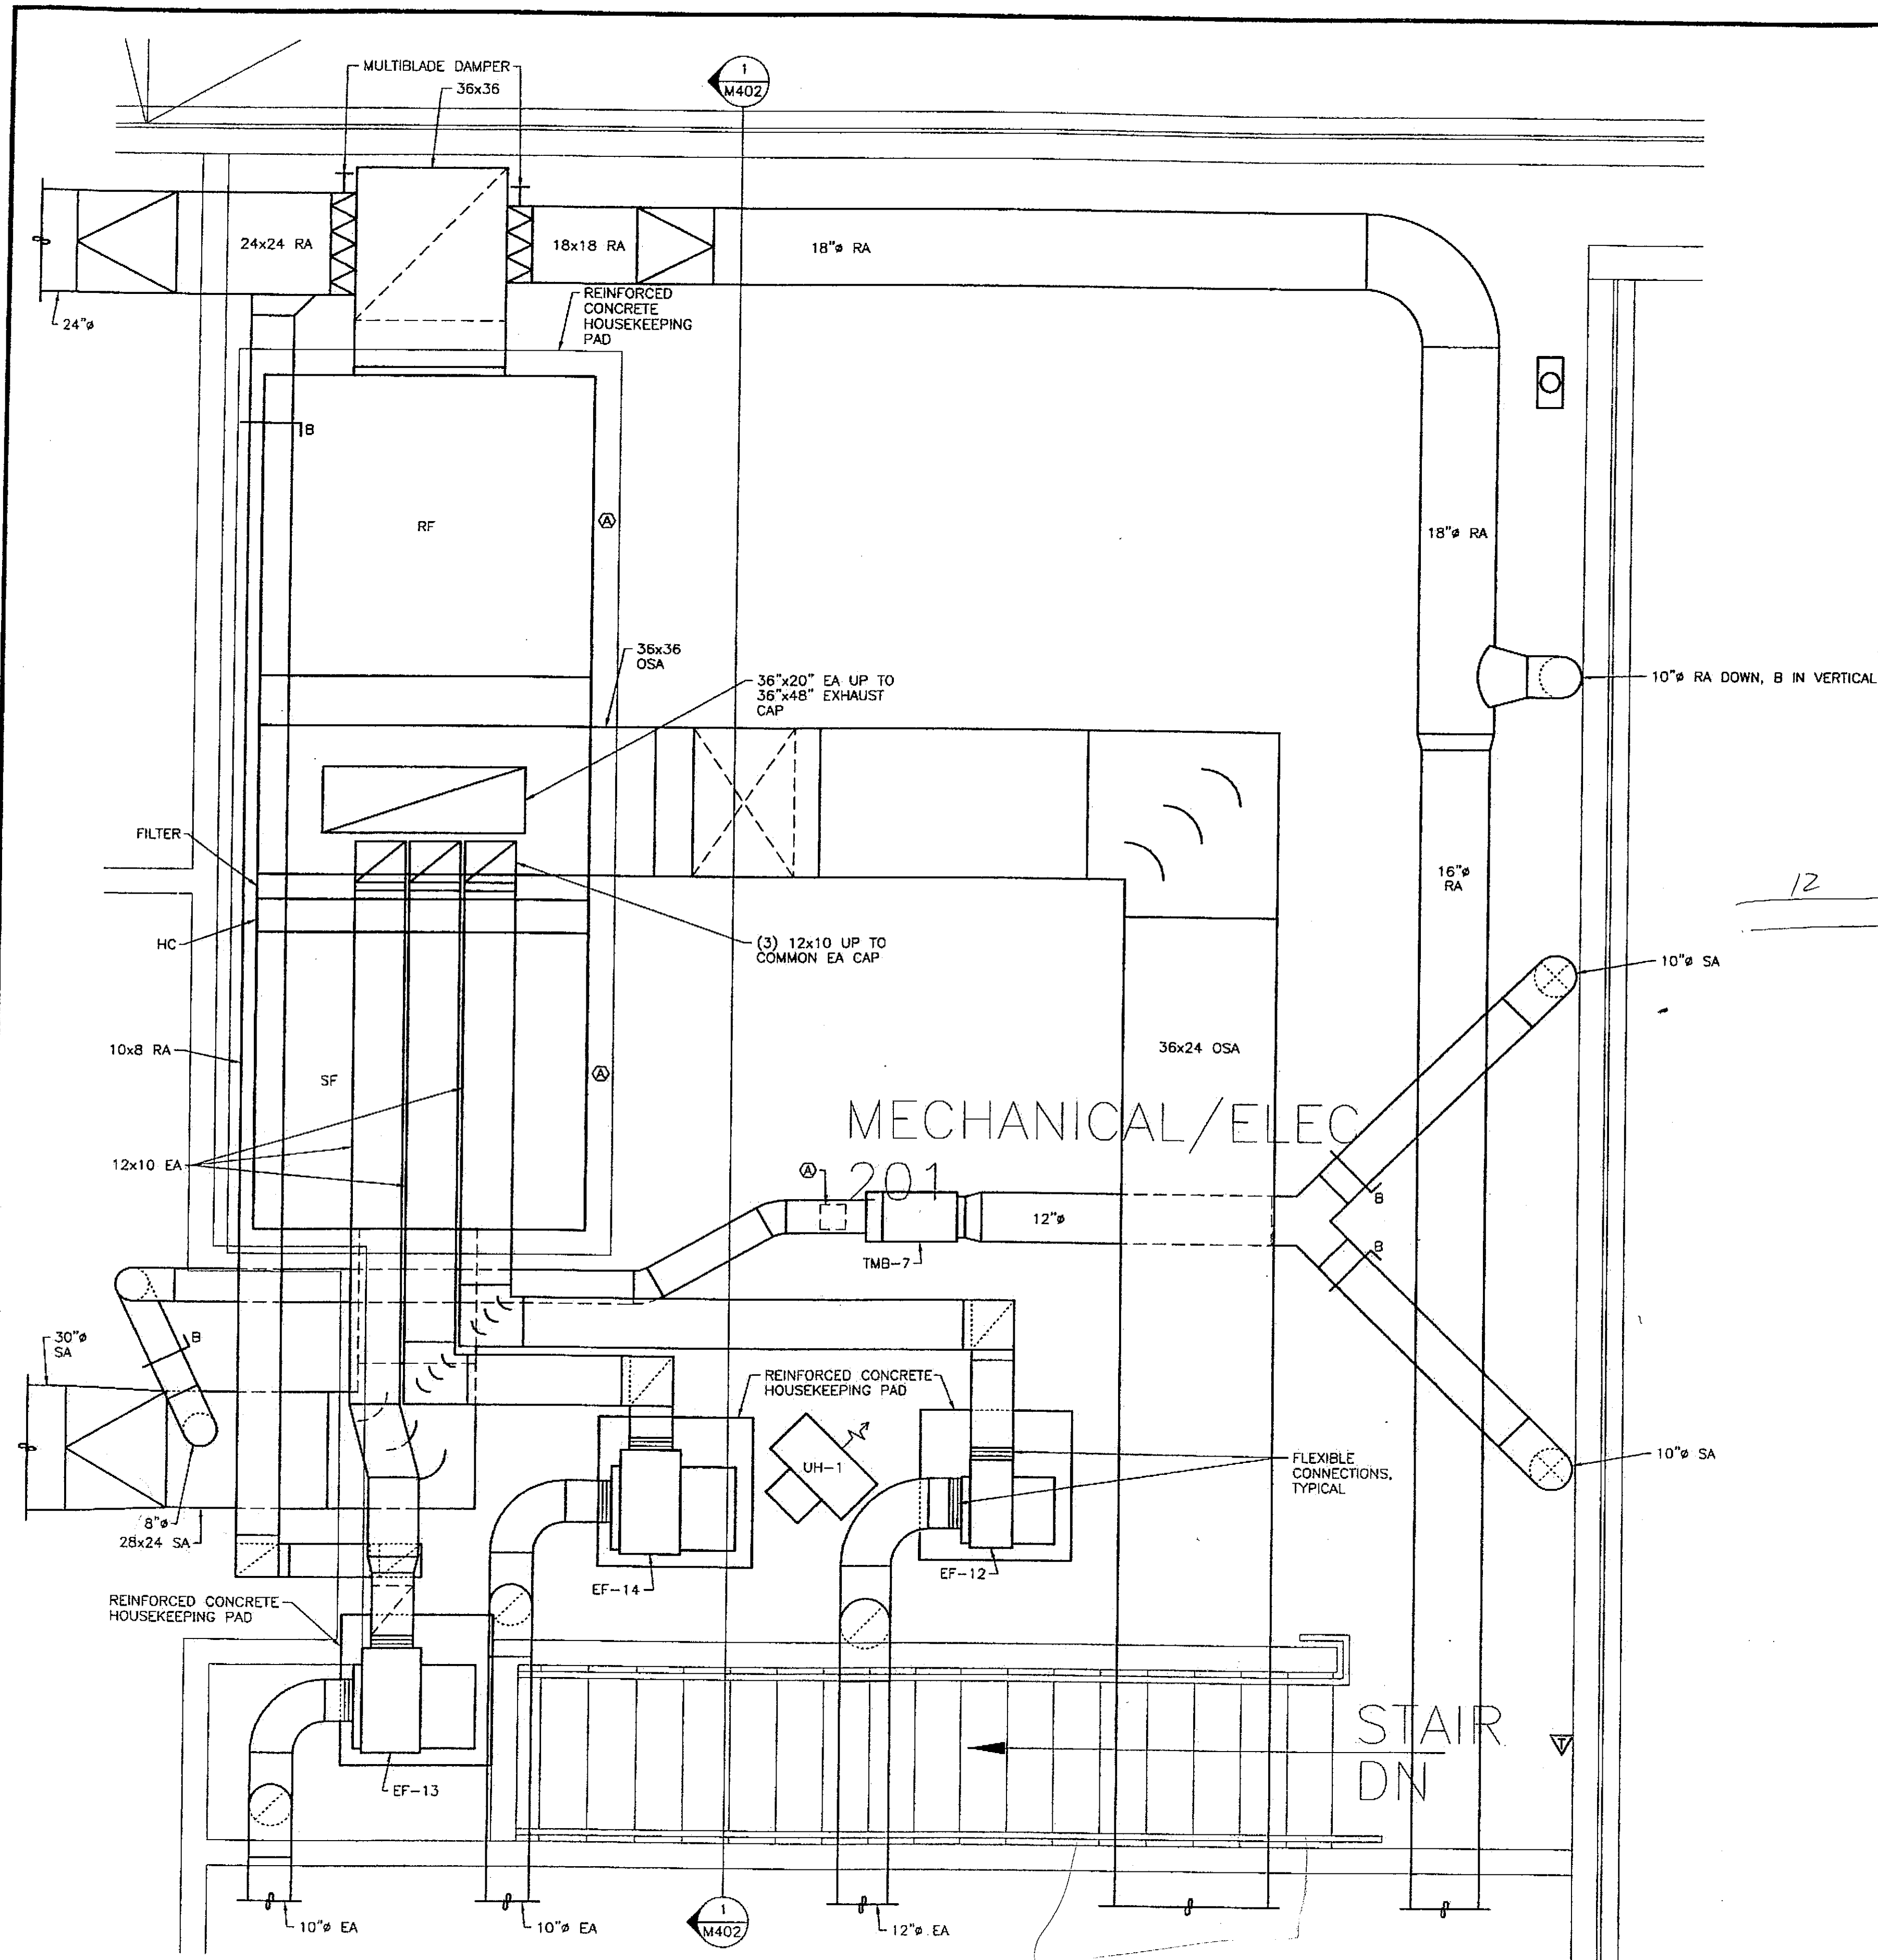

SHEET NOTES:

1. PIPING IS NOT SHOWN THIS PLAN. SEE SHEET M203 AND PIPING DIAGRAMS FOR MORE INFORMATION ON PIPING.
2. SEE SHEET M601 FOR LOCATION OF CONTROL DEVICES.

Tue, 14/Dec/04 03:58PM


ADDENDUM NUMBER

ATTACHMENT NUMBER

RECORD OF REVISIONS

No.	DATE	DESCRIPTION

CHECKED BY: DM

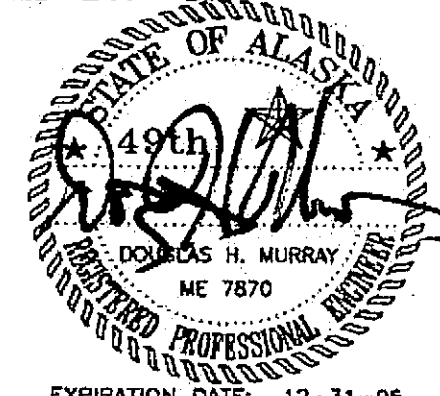

EXPIRATION DATE: 12-31-05

DESIGNED BY: DM/LH

DRAWN BY: WN

STATE OF ALASKA
DEPARTMENT OF TRANSPORTATION
& PUBLIC FACILITIES
STATEWIDE DESIGN & ENGINEERING
SERVICES DIVISION

MT EDGE CUMBE
HIGH SCHOOL
BUILDING 1330
ACADEMIC
EXPANSION

SHEET M401


PROJECT DESIGNATION NUMBER

67751C

STATE	YEAR
ALASKA	2004
SHEET NUMBER	TOTAL SHEETS
62	79

1 ENLARGED FAN ROOM PLAN BUILDING C

SCALE: 0 1' 2' 4'

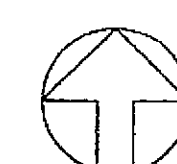

Project As-Built Drawings have been
reviewed by the Project Engineer and
represented to the best of my knowledge, the
project as constructed.
Proj. Eng. *[Signature]* Date 7-07


Tue, 14/Dec/04 10:20AM

SHEET NOTES:

1. INSULATE OUTSIDE AIR AND EXHAUST AIR DUCTS AS SPECIFIED.

CONSTRUCTION NOTES:

1. INSTALL BACKDRAFT DAMPERS IN THREE EA DUCTS FOR EF-12, EF-13, AND EF-14.

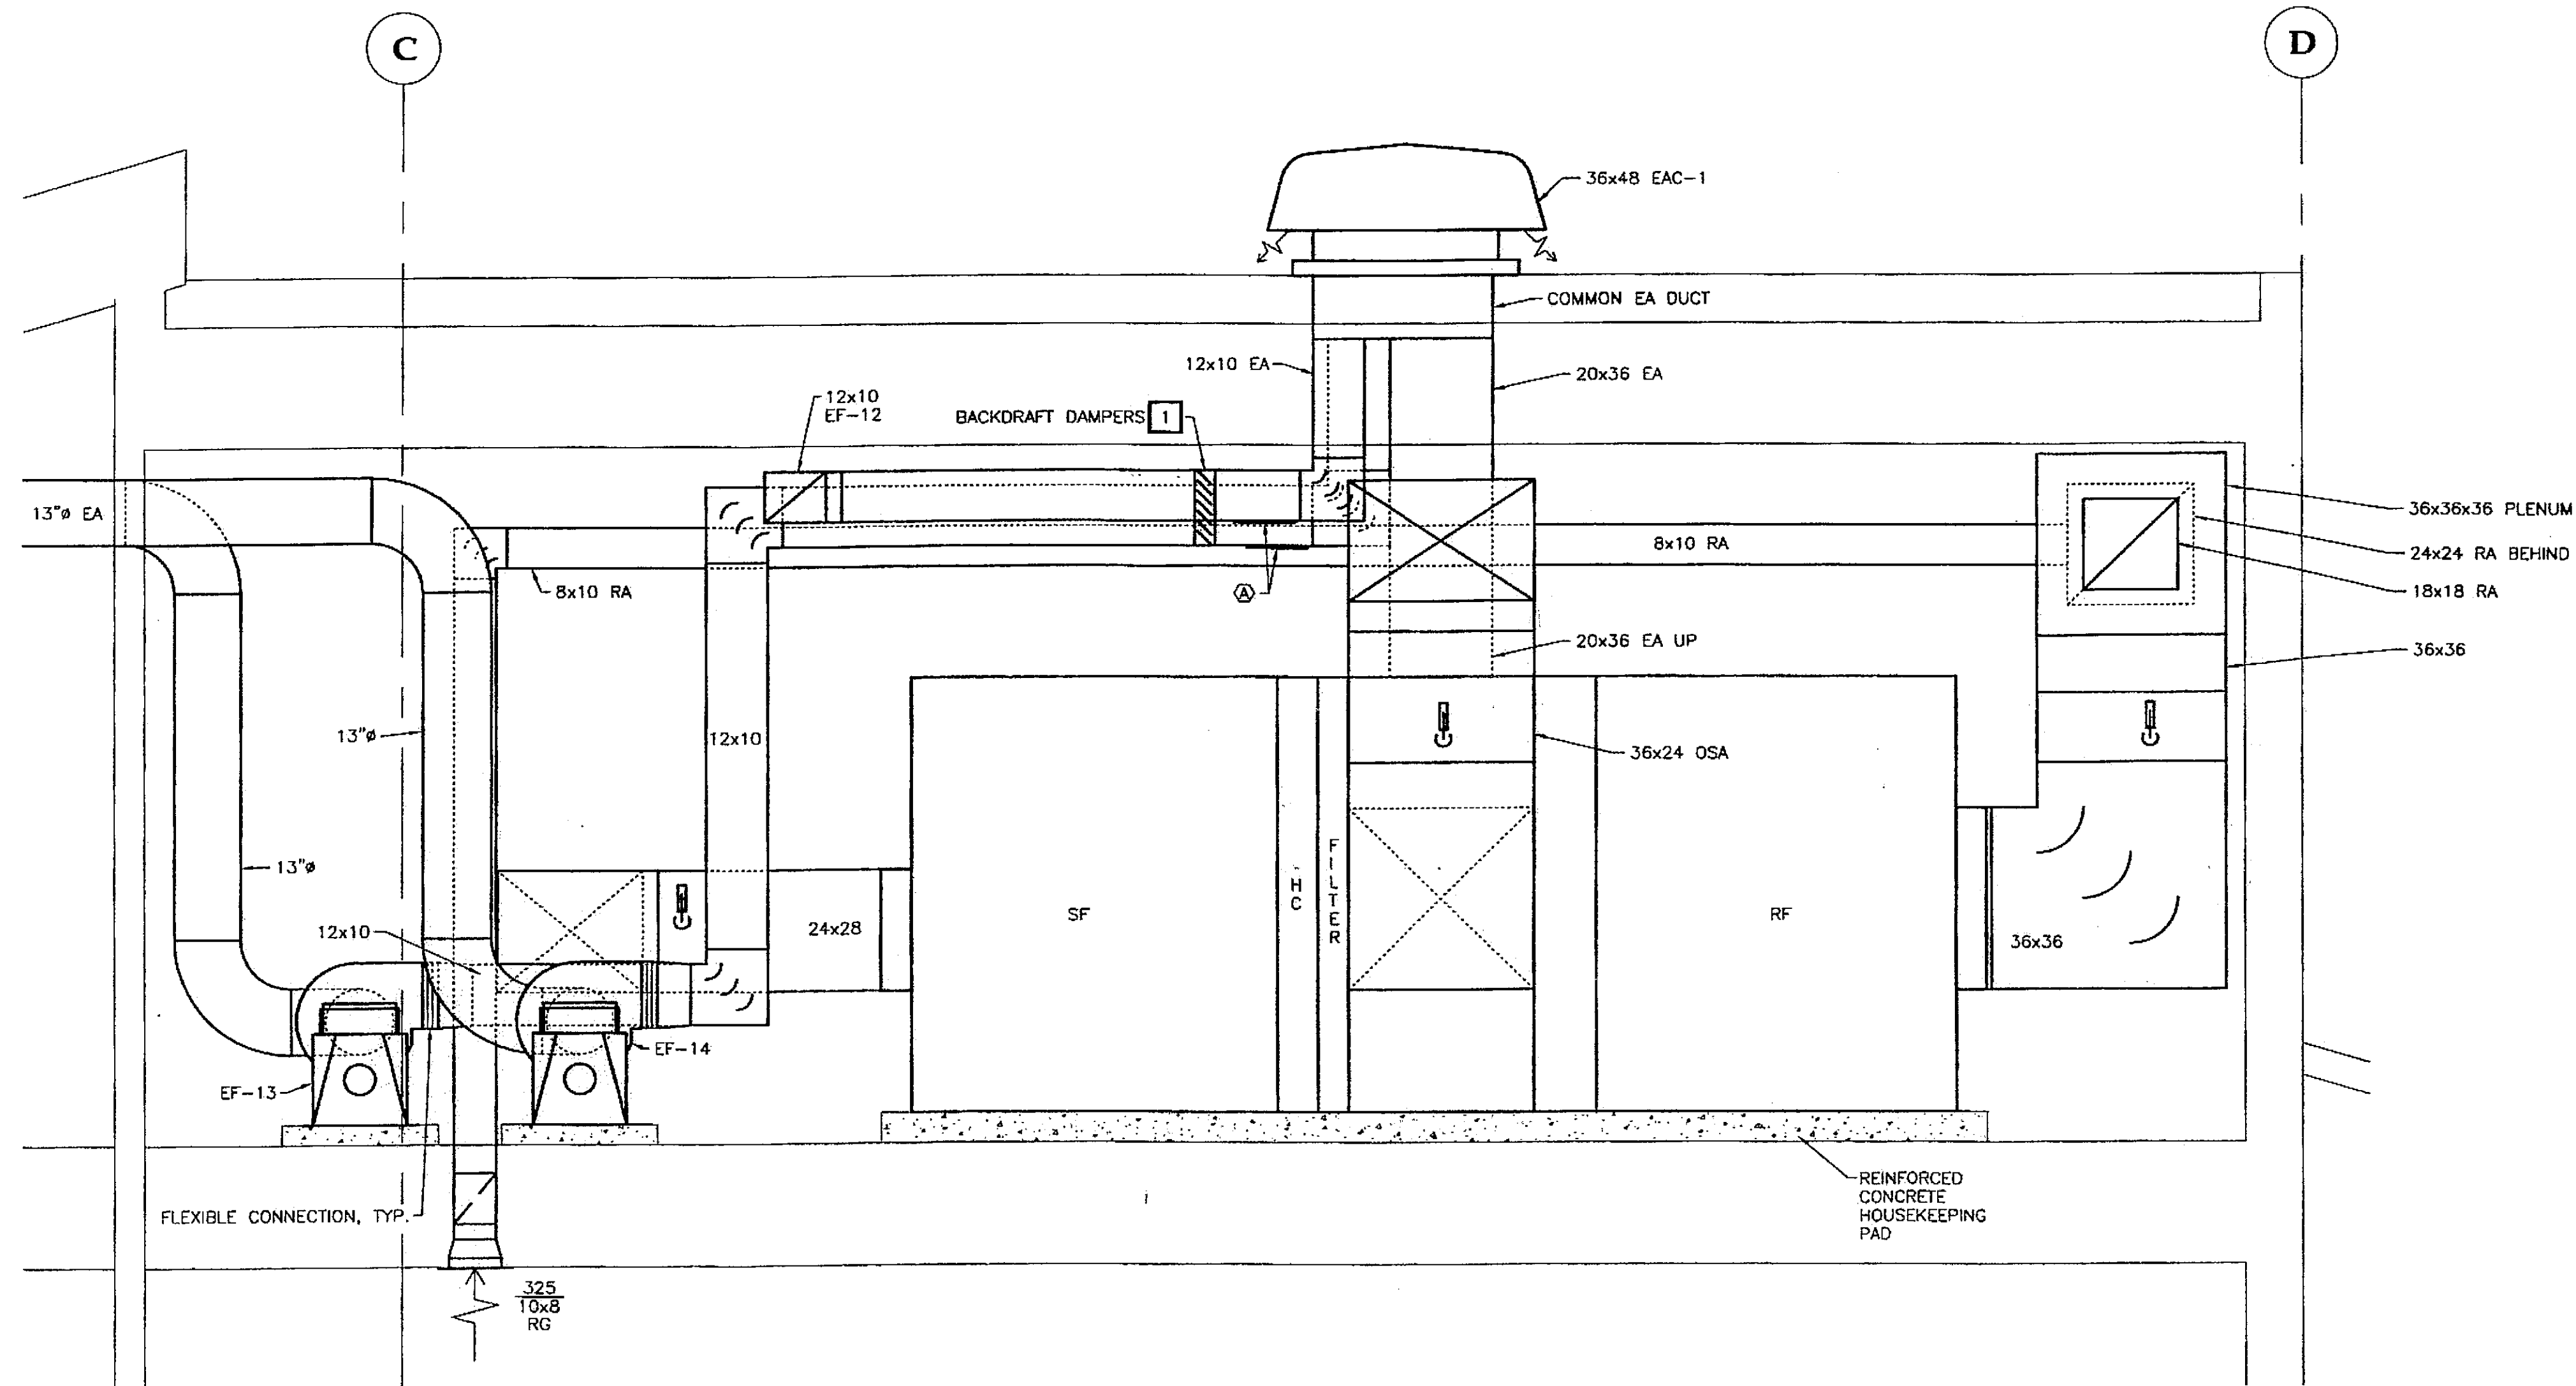

1 ENLARGED FAN ROOM SECTION BUILDING C

SCALE: 0 1' 2' 4'

Project As-Built Drawings have been reviewed by the Project Engineer and represent to the best of my knowledge, the project as constructed.
Proj. Eng. *[Signature]* Date *7/07*


ADDENDUM NUMBER

ATTACHMENT NUMBER

RECORD OF REVISIONS

No.	DATE	DESCRIPTION

CHECKED BY: DM

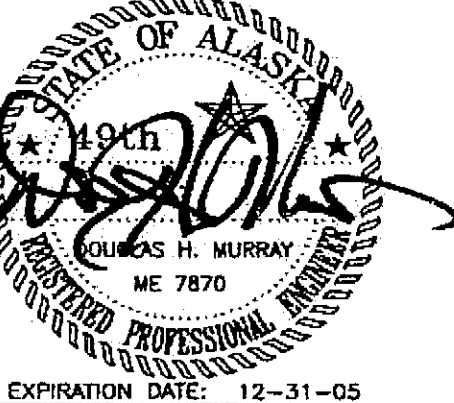

EXPIRATION DATE: 12-31-05

DESIGNED BY: DM/LH

DRAWN BY: WN

STATE OF ALASKA
DEPARTMENT OF TRANSPORTATION
& PUBLIC FACILITIES
STATEWIDE DESIGN & ENGINEERING
SERVICES DIVISION

MT EDGE CUMBE
HIGH SCHOOL
BUILDING 1330
ACADEMIC
EXPANSION

SHEET M402

PROJECT DESIGNATION NUMBER




67751C

STATE YEAR

ALASKA 2004

SHEET NUMBER TOTAL SHEETS

63 79

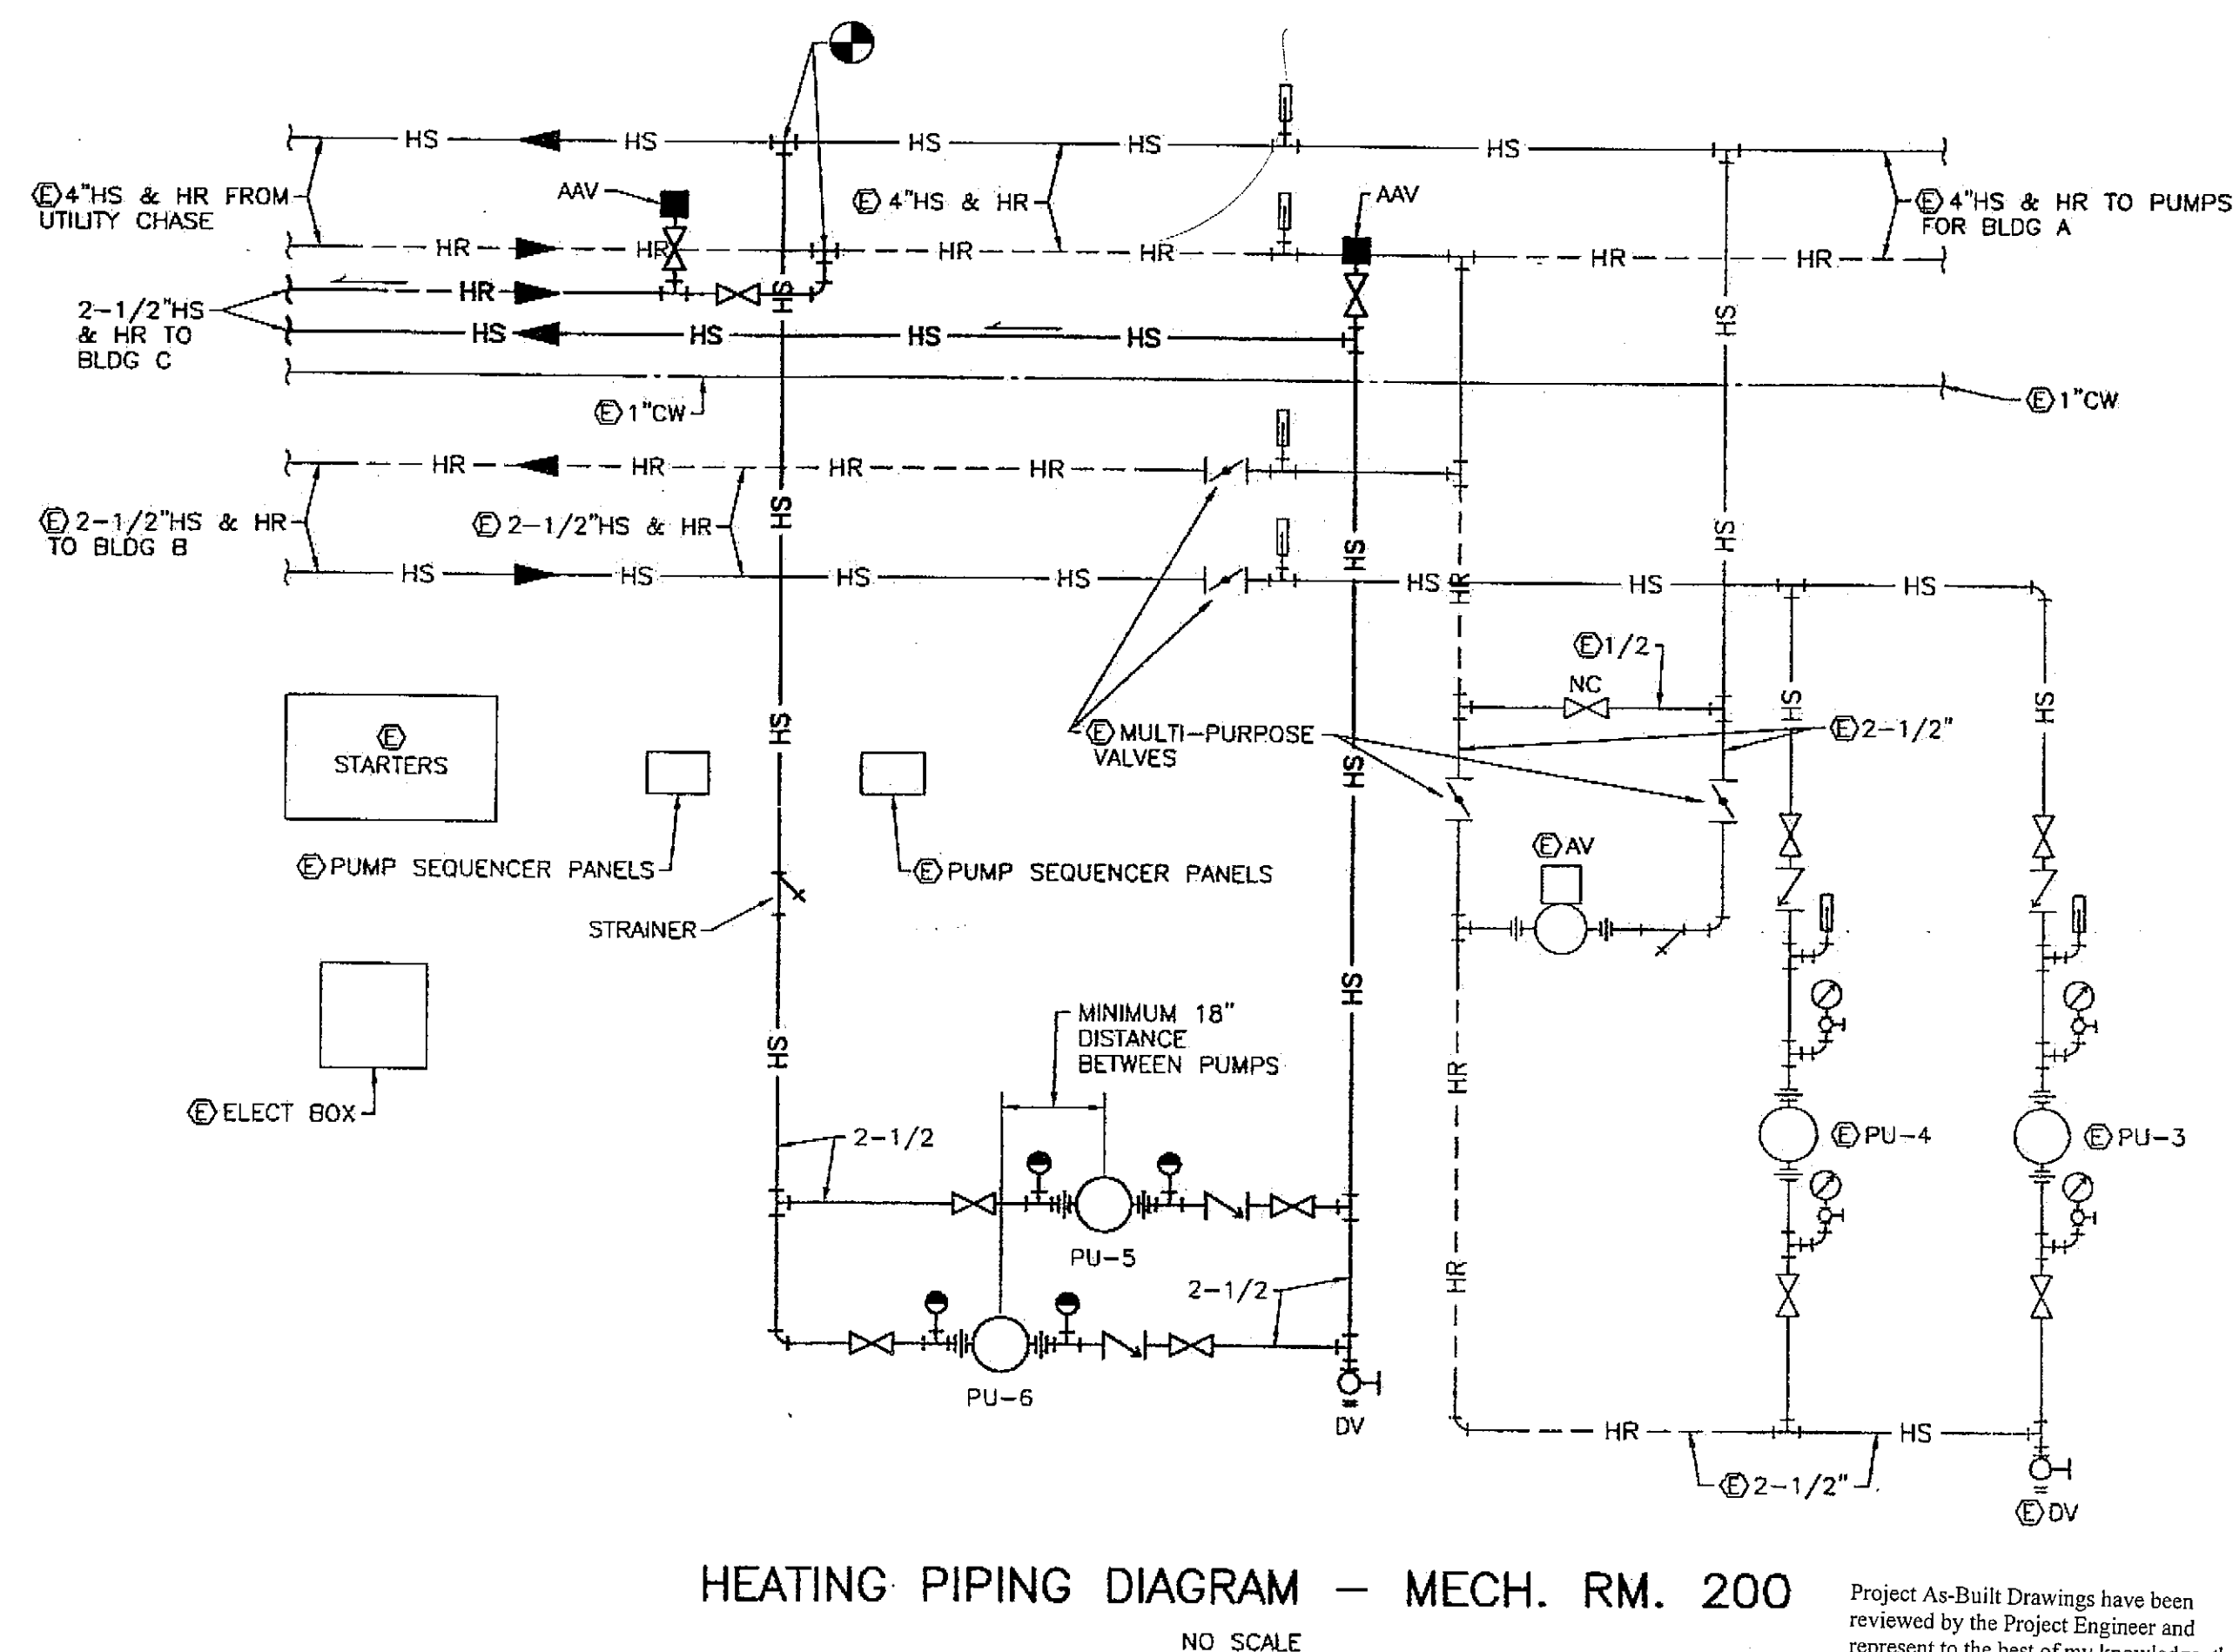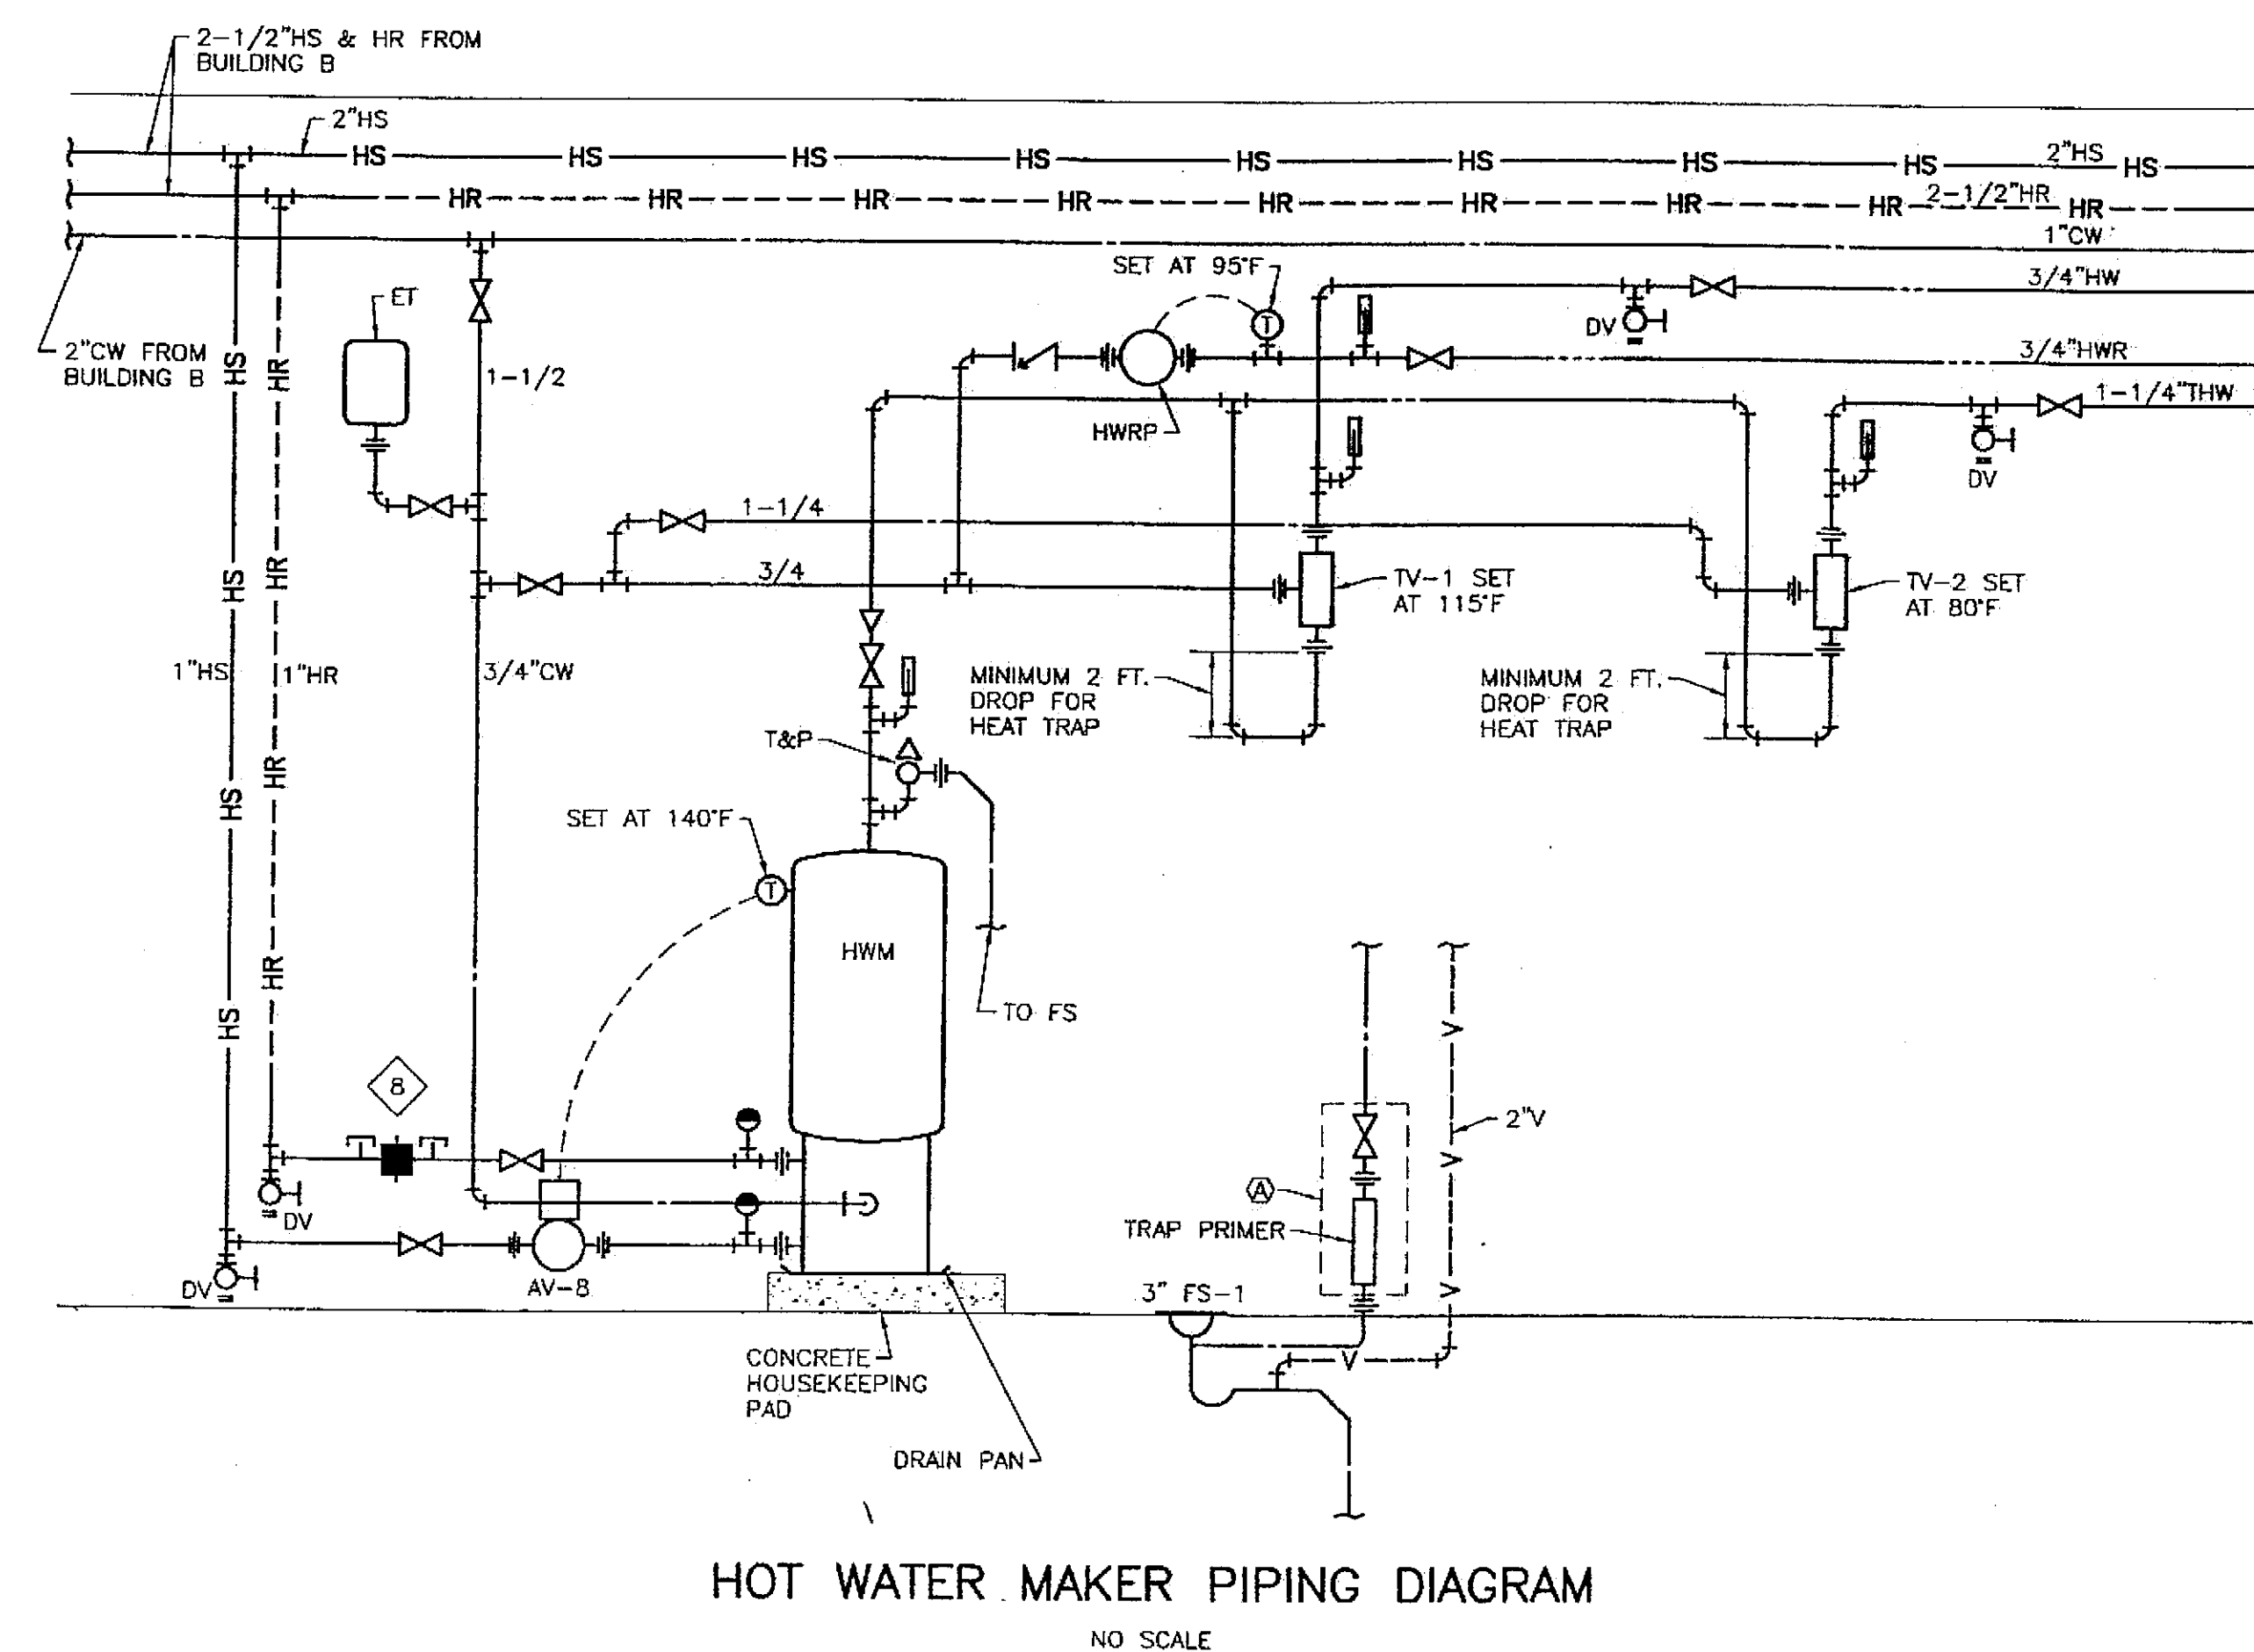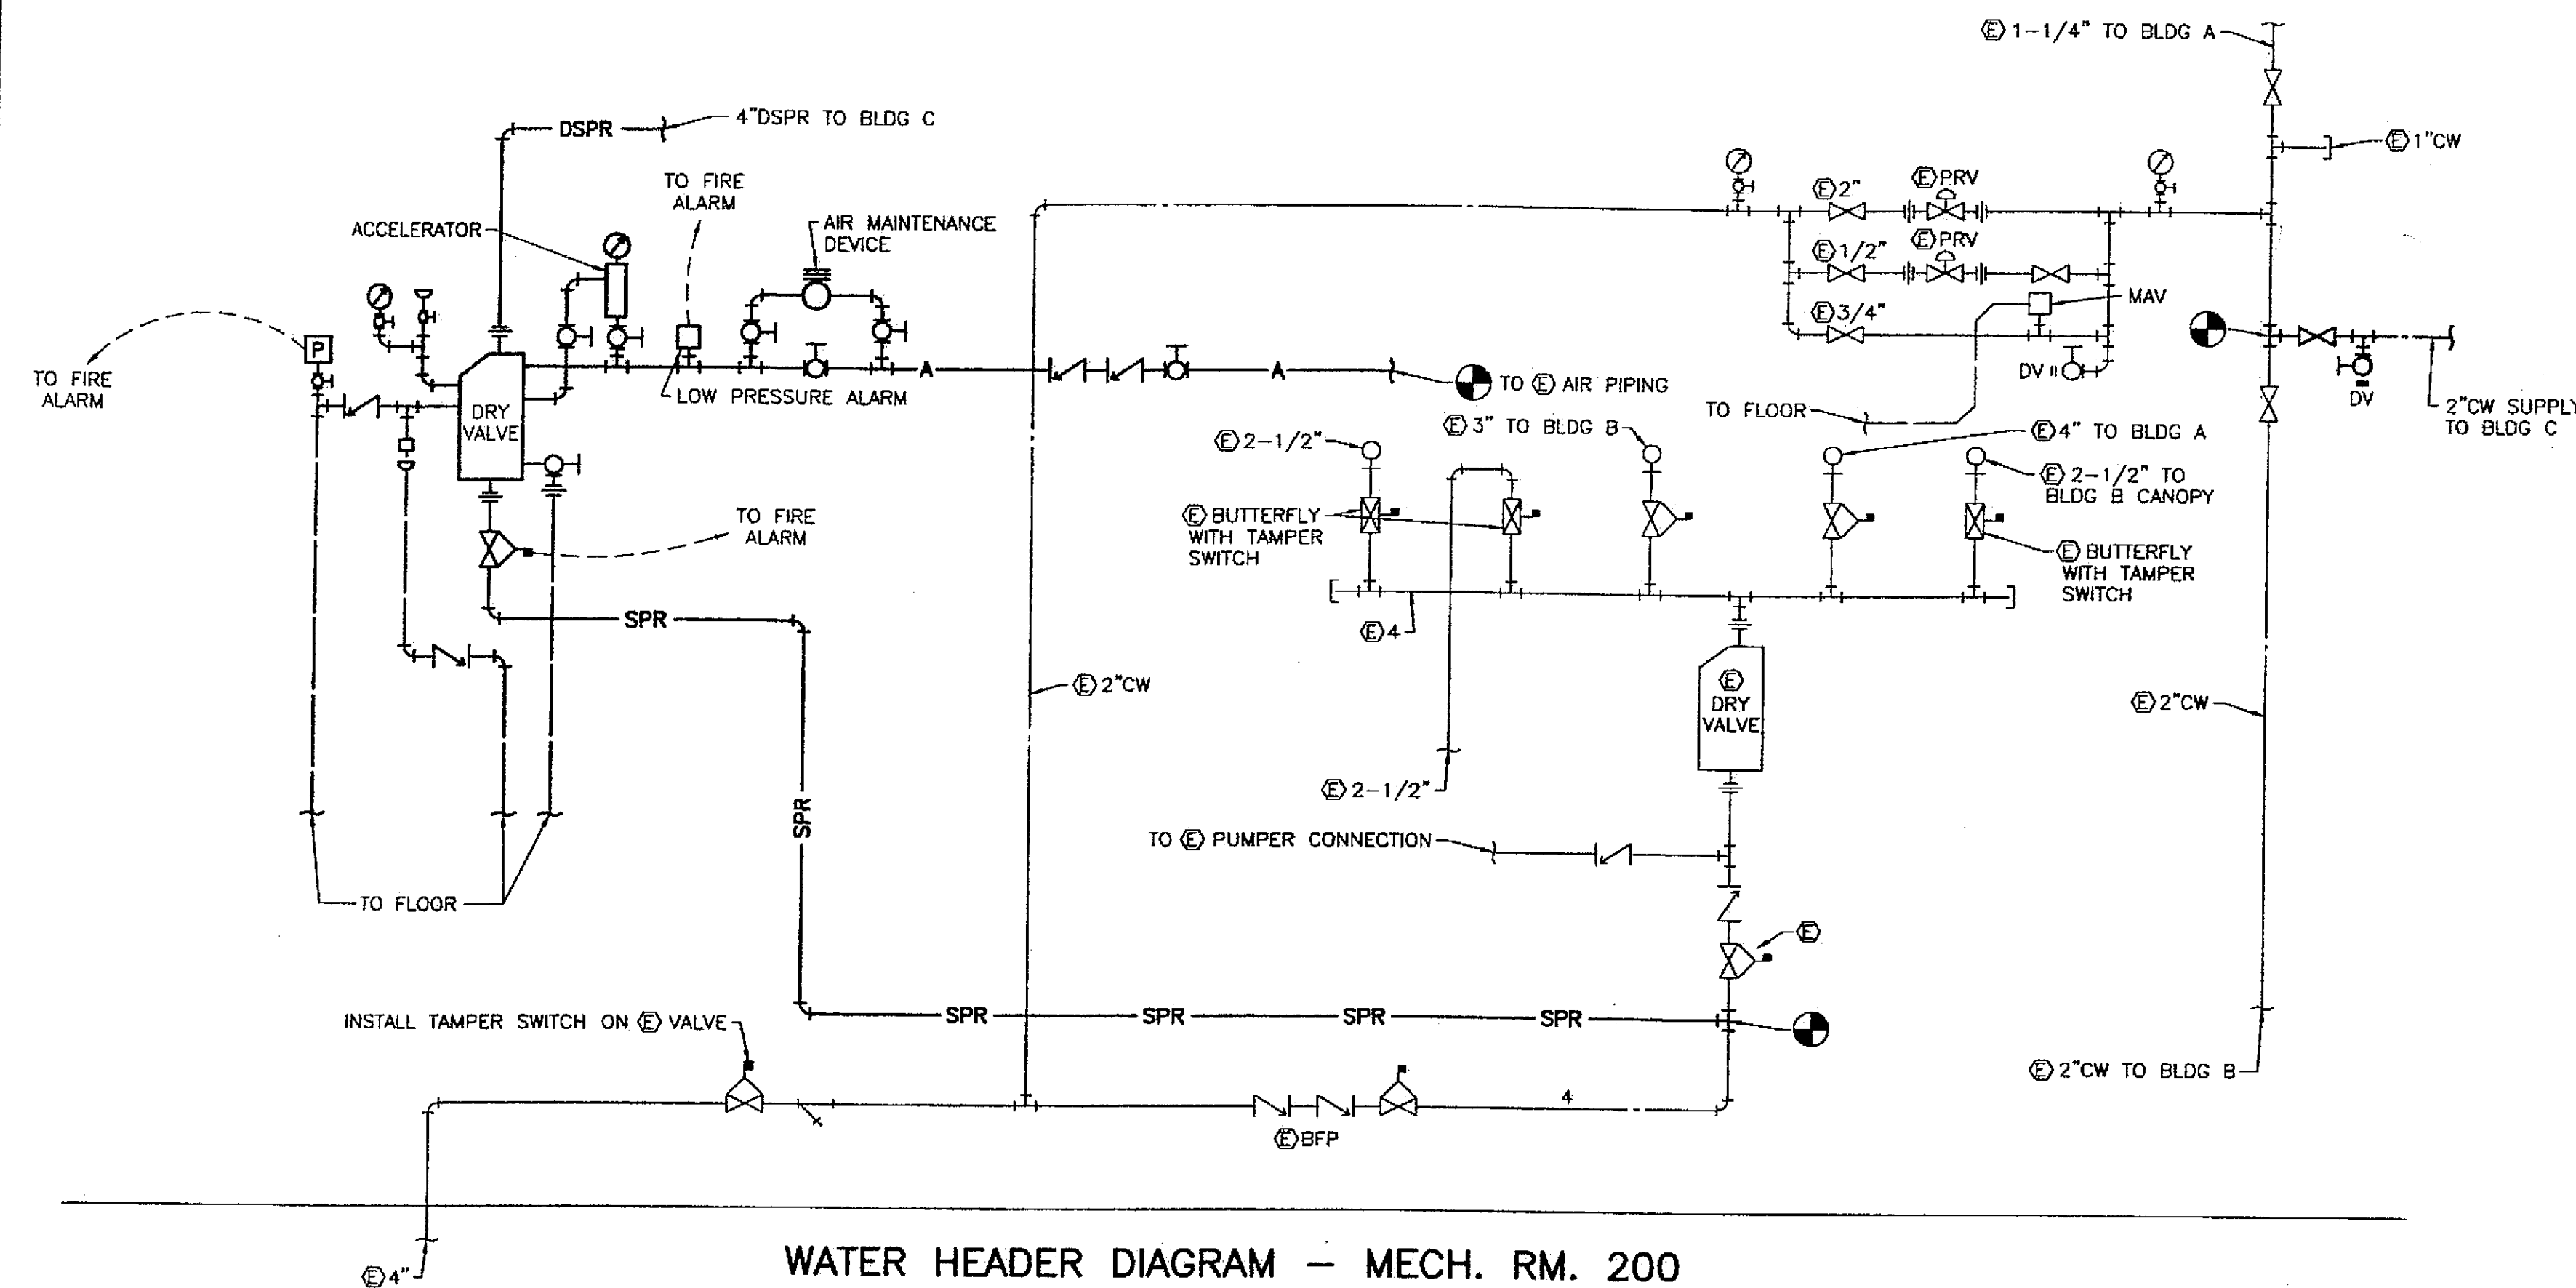

Tue, 14/Dec/04 09:34AM


ADDENDUM NUMBER

ATTACHMENT NUMBER

RECORD OF REVISIONS

No.	DATE	DESCRIPTION

CHECKED BY: DM

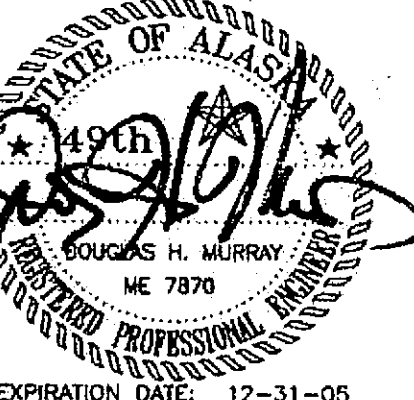

EXPIRATION DATE: 12-31-05

DESIGNED BY: DM/LH

DRAWN BY: WN

STATE OF ALASKA
DEPARTMENT OF TRANSPORTATION
& PUBLIC FACILITIES
STATEWIDE DESIGN & ENGINEERING
SERVICES DIVISION

MT EDGECLUMBE
HIGH SCHOOL
BUILDING 1330
ACADEMIC
EXPANSION

SHEET M501

PROJECT DESIGNATION NUMBER

67751C

STATE	YEAR
ALASKA	2004
SHEET NUMBER	TOTAL SHEETS
64	79

Project As-Built Drawings have been
reviewed by the Project Engineer and
represent to the best of my knowledge, the
project as constructed.
Proj. Eng. *[Signature]* Date 7-01


Tue, 14/Dec/04 02:55PM

ADDENDUM NUMBER


ATTACHMENT NUMBER

RECORD OF REVISIONS


No.	DATE	DESCRIPTION

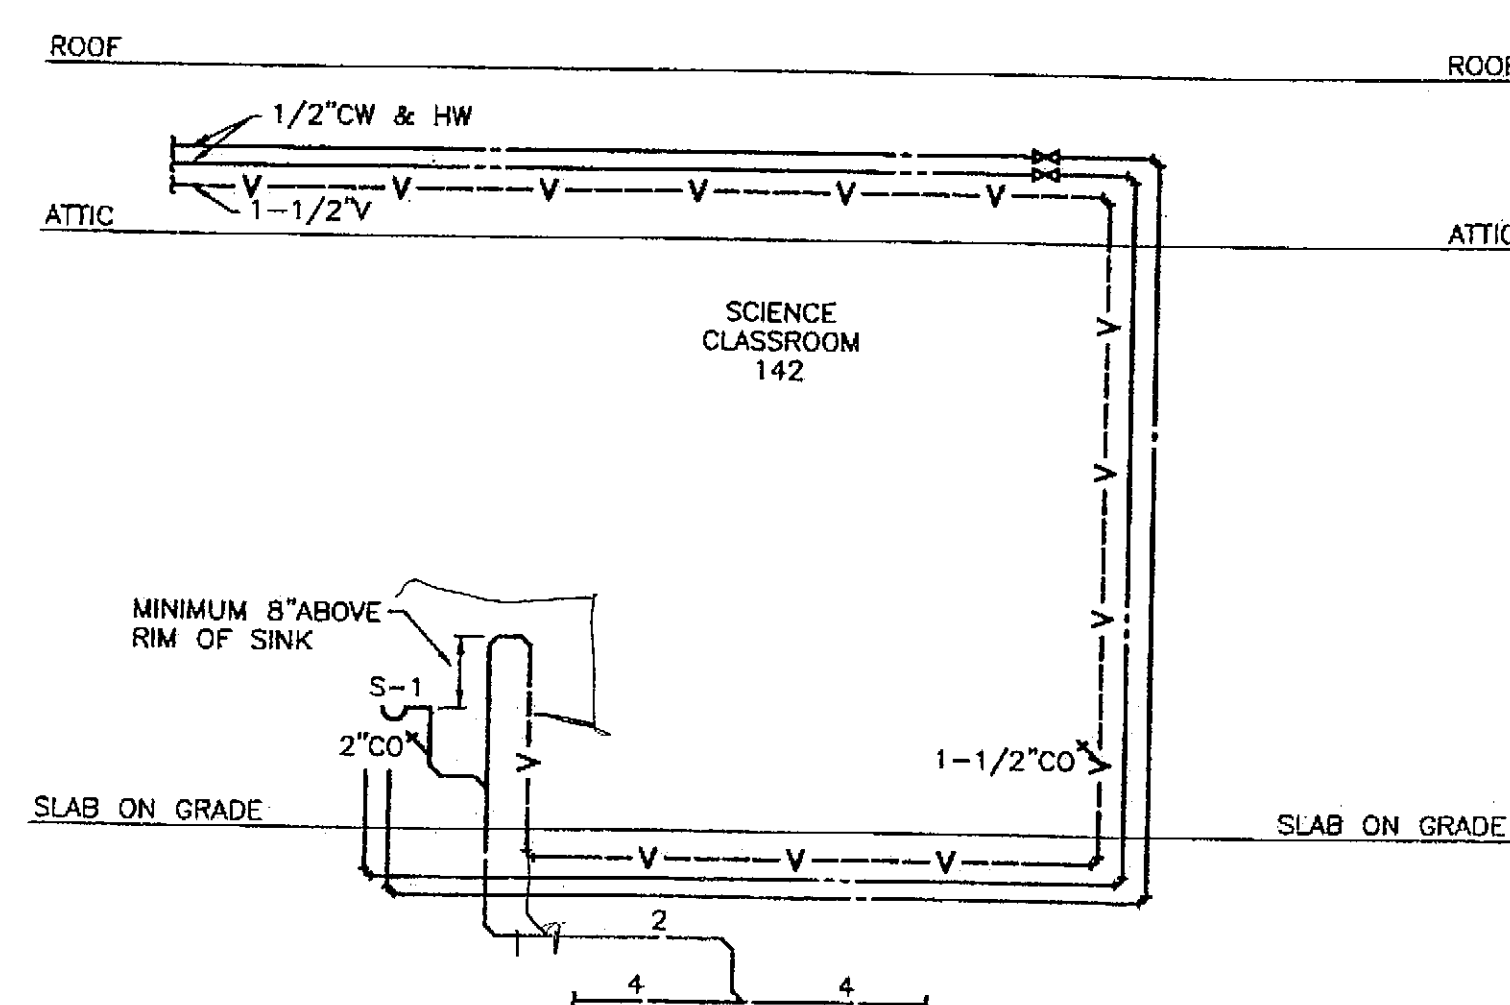


PLUMBING DIAGRAM
TYPICAL ISLAND WASTE AND VENT
NO SCALE

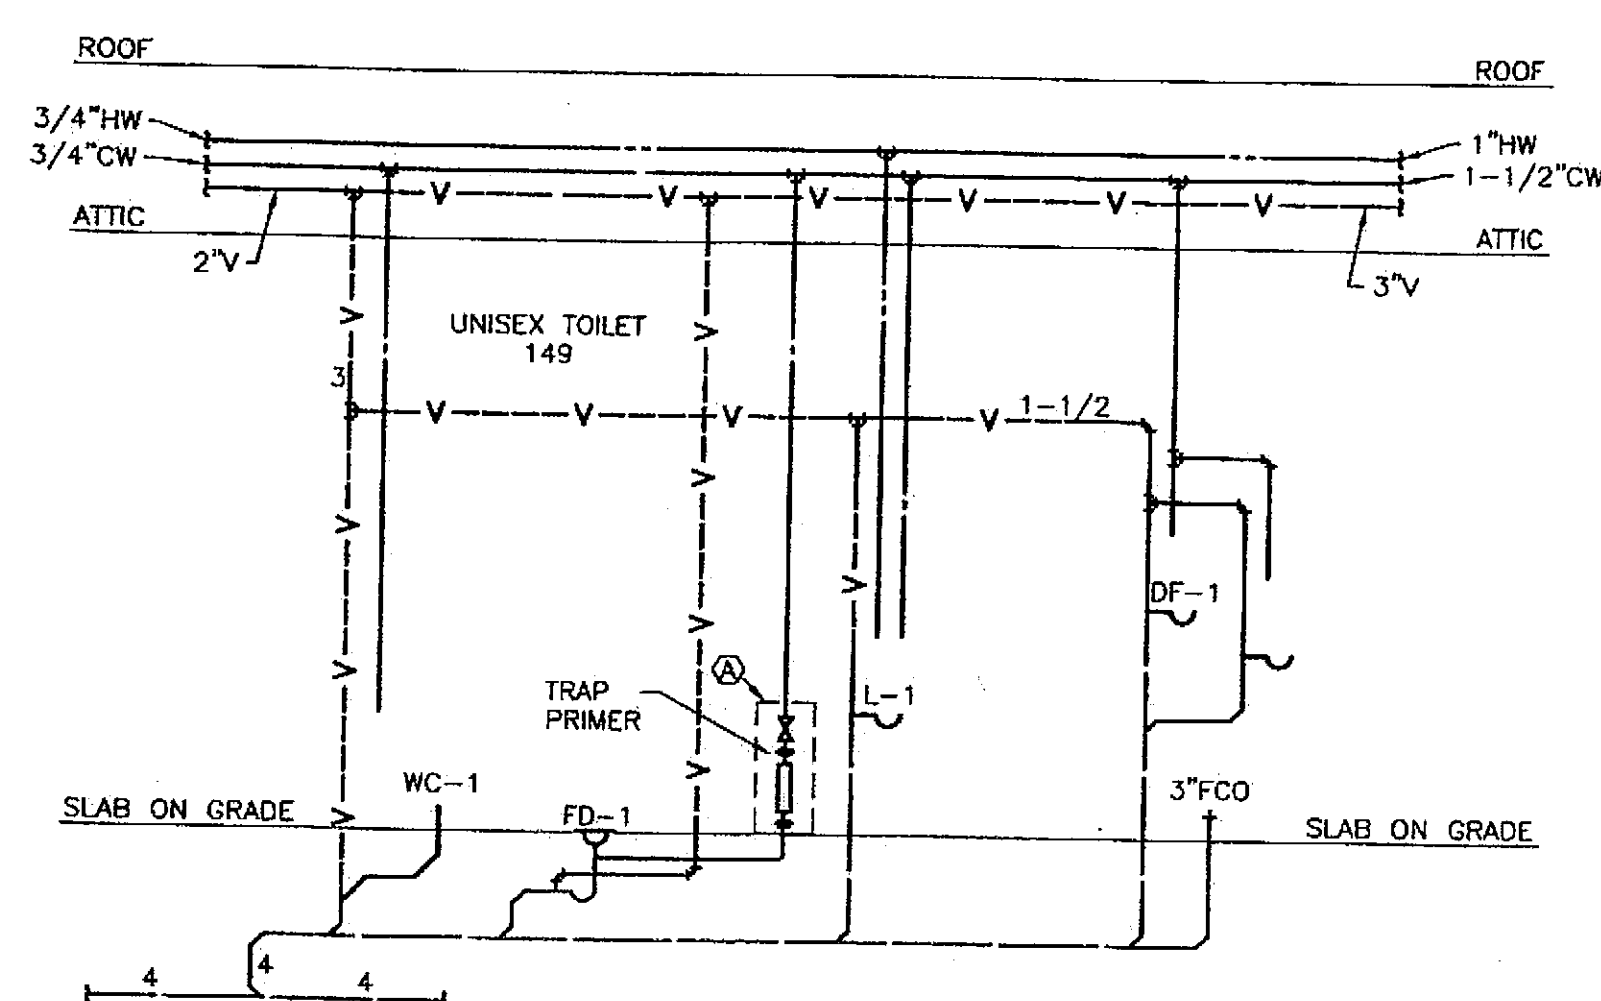


PLUMBING DIAGRAM
UNISEX TOILET 149
NO SCALE

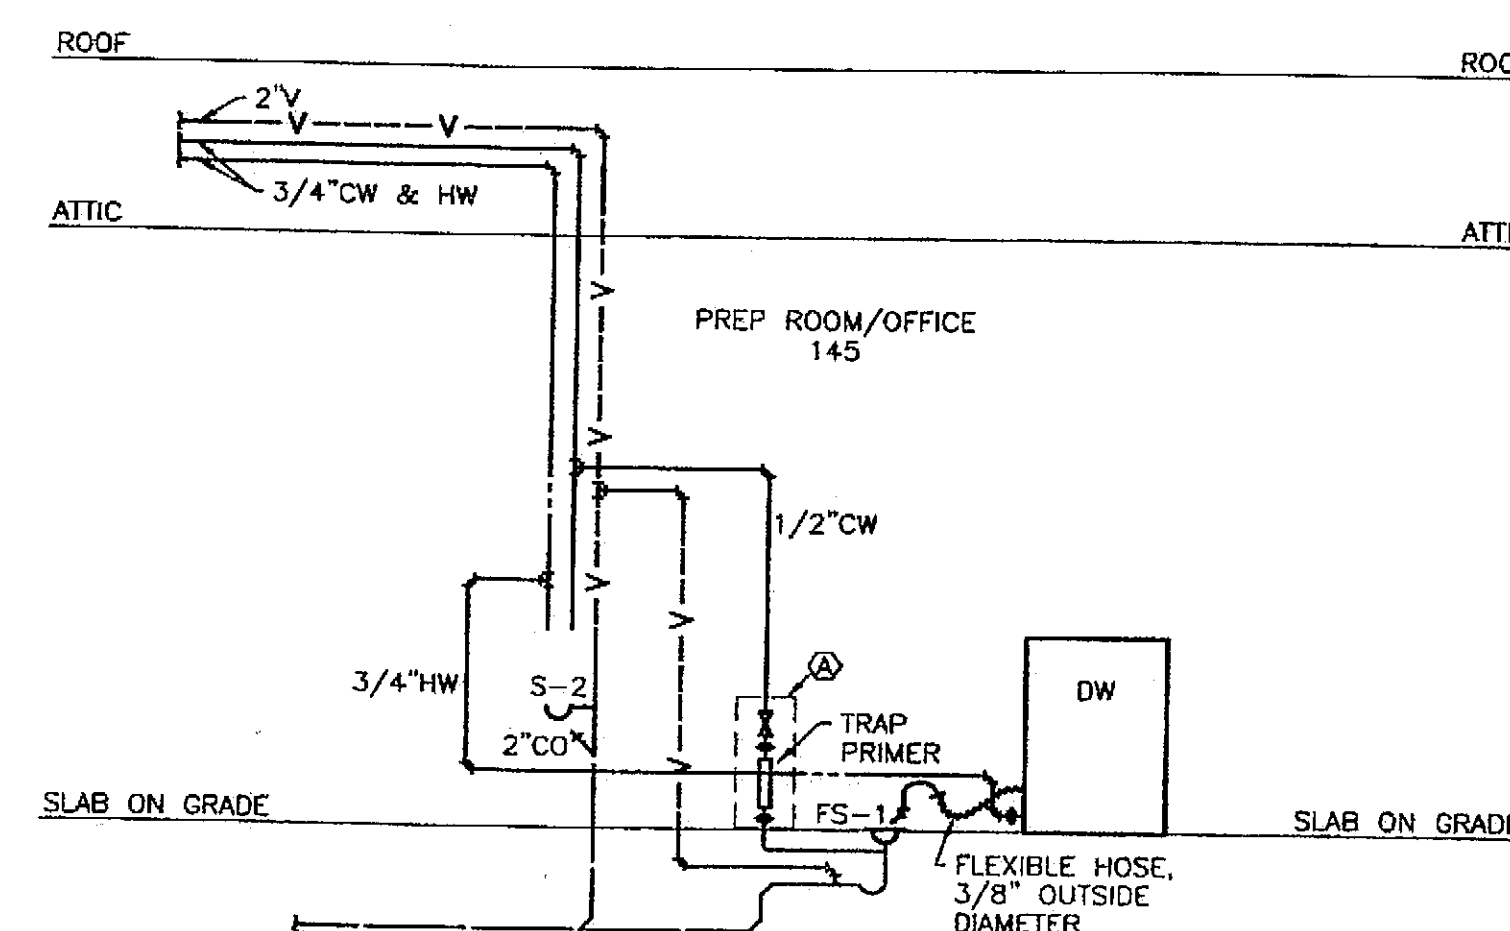

PLUMBING DIAGRAM
PREP ROOM/OFFICE 145
NO SCALE

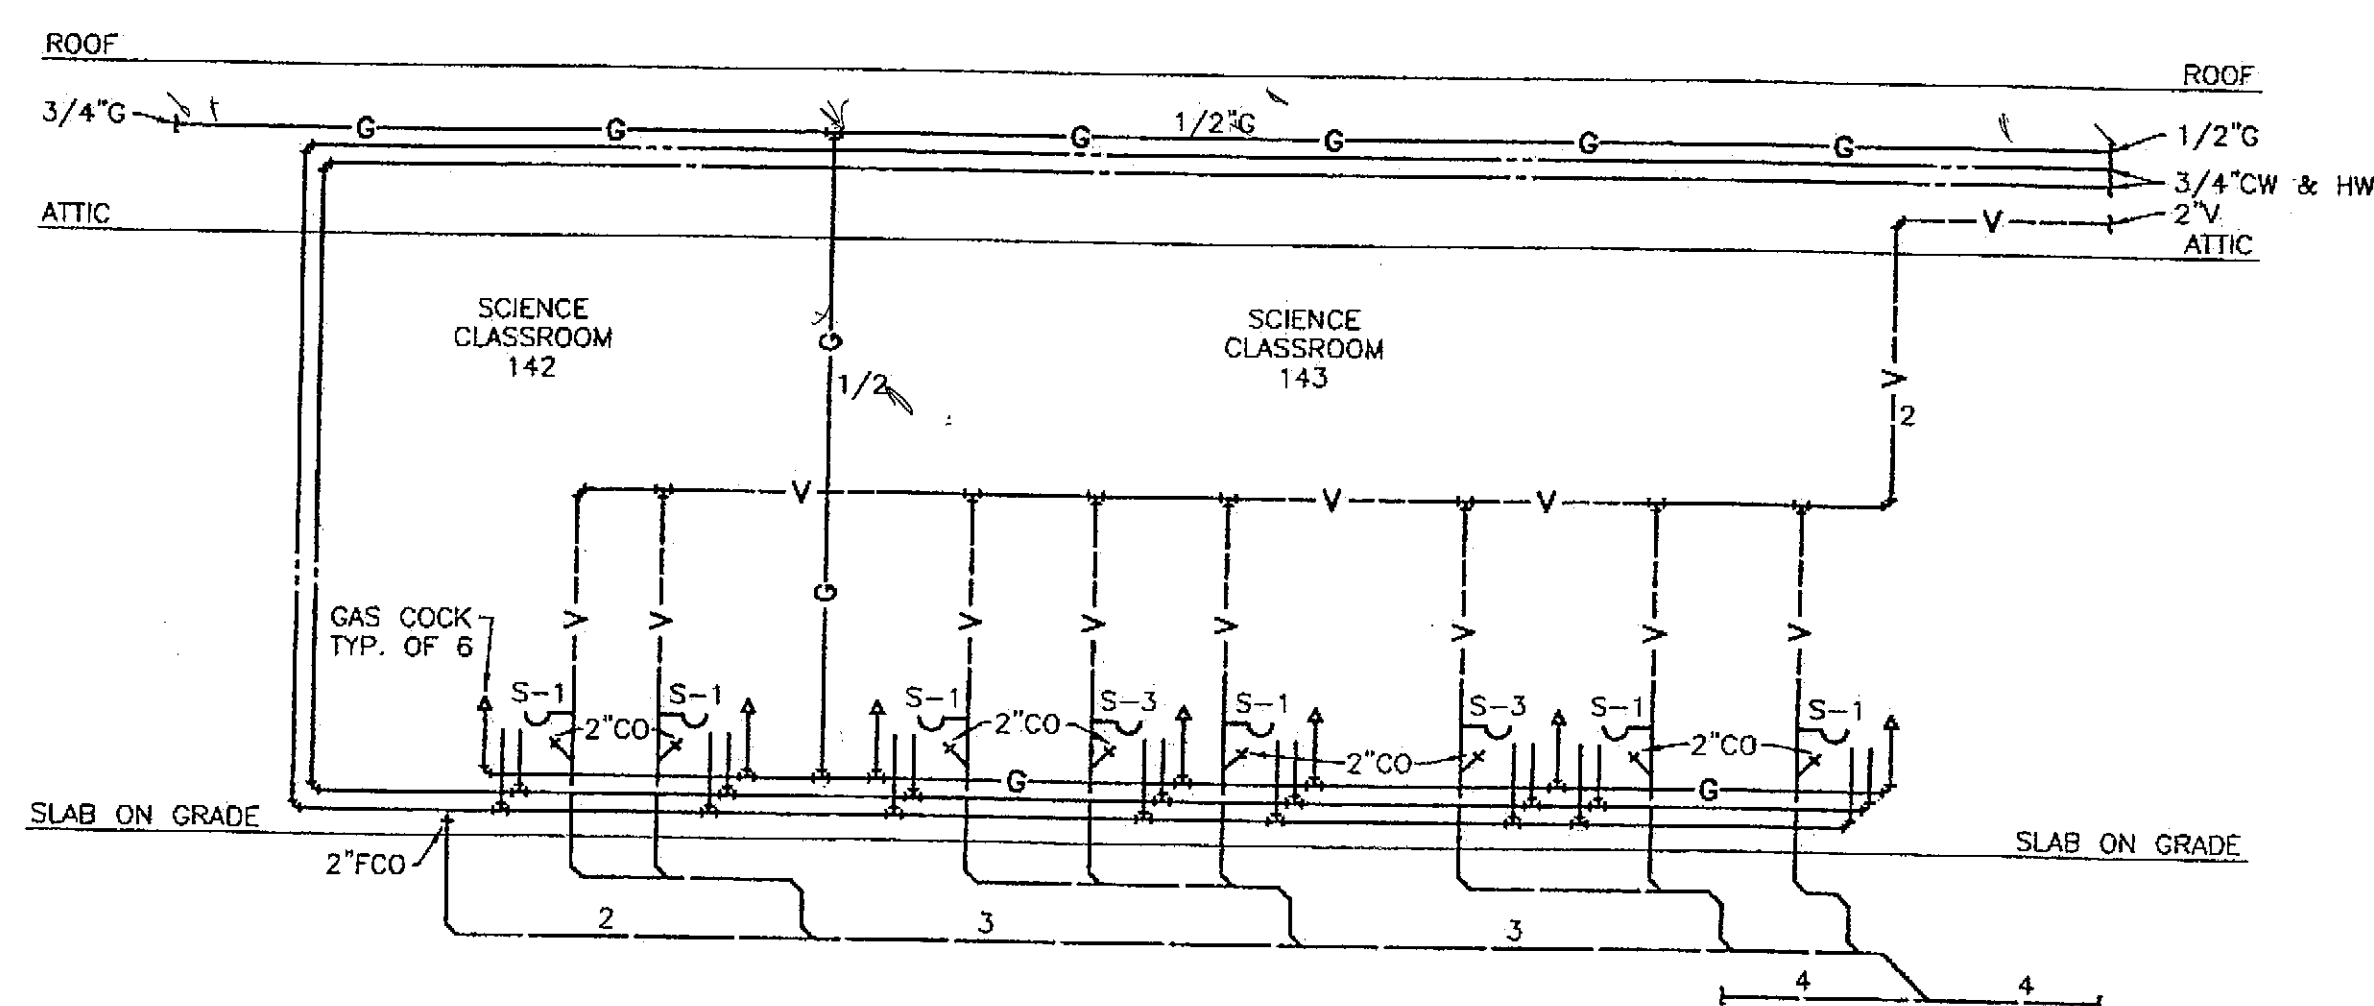


PLUMBING DIAGRAM
SCI 142 & 143 FUME HOOD WALL
NO SCALE

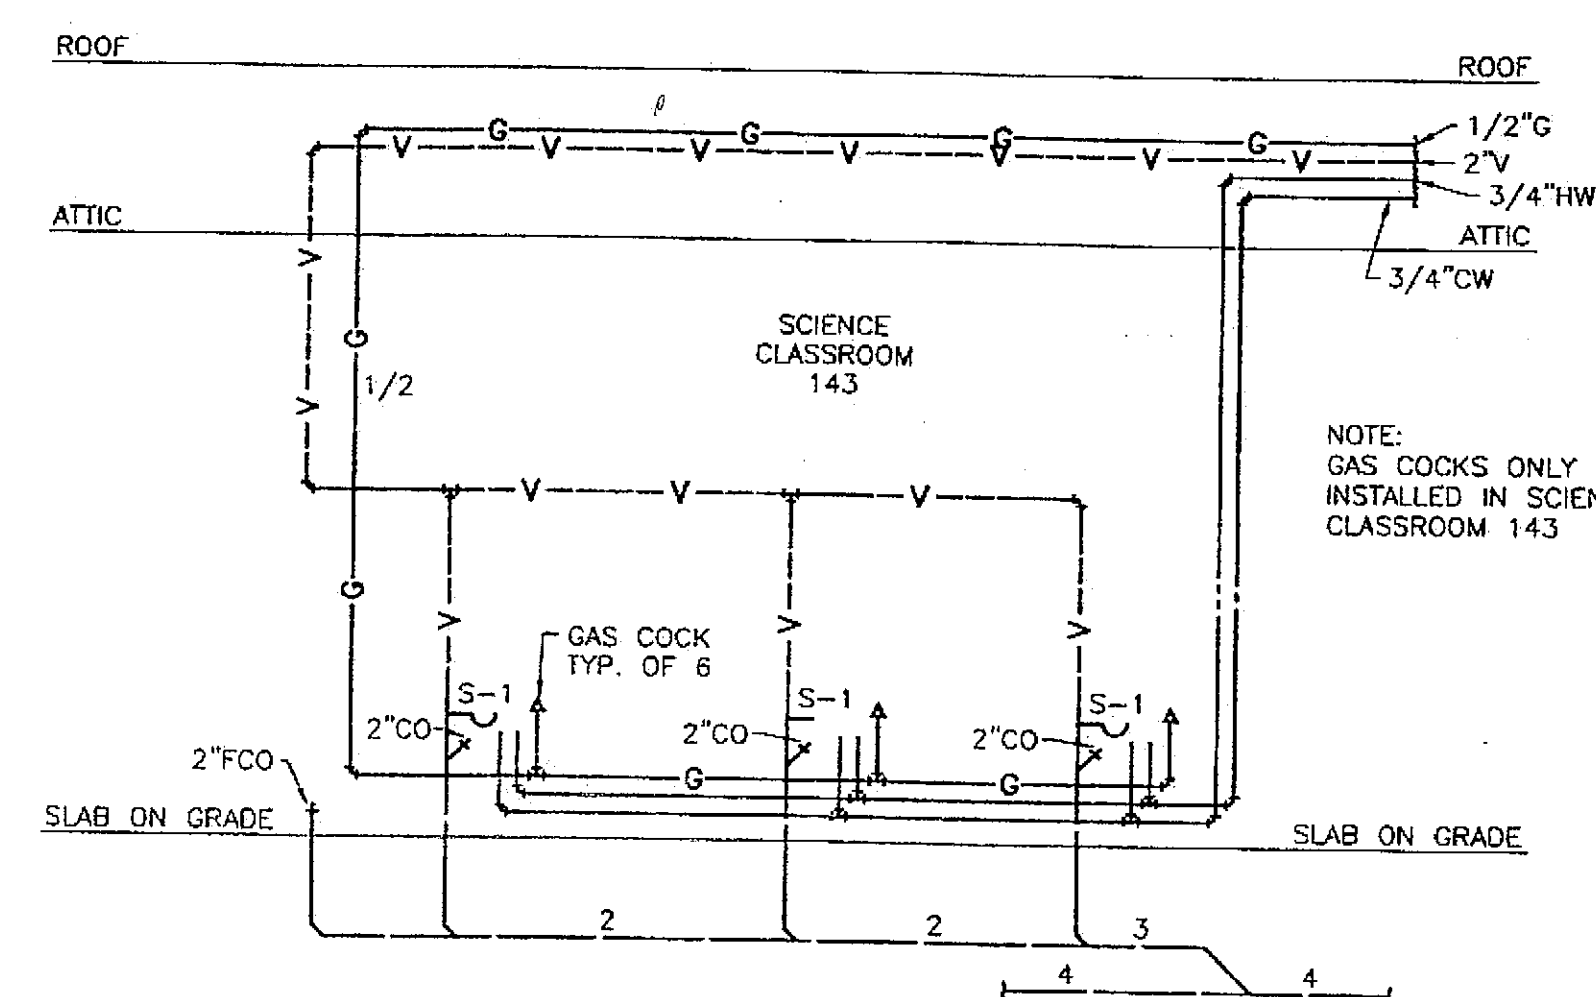

PLUMBING DIAGRAM
TYP. OF SCI 141 & 143
NO SCALE

Project As-Built Drawings have been reviewed by the Project Engineer and represent to the best of my knowledge, the project as constructed.
Proj. Eng. *[Signature]* Date 7-07

CHECKED BY: DM

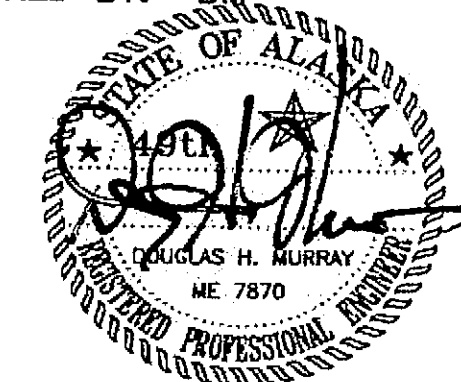

EXPIRATION DATE: 12-31-05

DESIGNED BY: DM/LH

DRAWN BY: WN

STATE OF ALASKA
DEPARTMENT OF TRANSPORTATION
& PUBLIC FACILITIES
STATEWIDE DESIGN & ENGINEERING
SERVICES DIVISION
MT EDGE CUMBE
HIGH SCHOOL
BUILDING 1330
ACADEMIC
EXPANSION

SHEET M502

PROJECT DESIGNATION NUMBER

67751C

STATE	YEAR
ALASKA	2004
SHEET NUMBER	TOTAL SHEETS
65	79

ADDENDUM NUMBER

ATTACHMENT NUMBER

RECORD OF REVISIONS

No.	DATE	DESCRIPTION

CONTROLS LEGEND

C	CONTROLLER
S	SMOKE SENSOR
T	IMMERSION THERMOSTAT OR THERMOSTATIC SENSOR
VA	VALVE ACTUATOR
DA	DAMPER ACTUATOR
CS	CURRENT SENSOR
▽	ROOM THERMOSTAT
→	AIR DIRECTION
⊕	THERMOMETER
⊙	MOTOR
DP	DIFFERENTIAL PRESSURE SWITCH

AHU	AIR HANDLING UNIT	LCM	LOCAL CONTROL MODULE
AI	ANALOG INPUT	LL	LOW LIMIT CONTROL
AO	ANALOG OUTPUT	MA	MIXED AIR
COM	COMMON	NO	NORMALLY OPEN
DDC	DIRECT DIGITAL CONTROL	NC	NORMALLY CLOSED
DI	DIGITAL INPUT	OSA	OUTSIDE AIR
DO	DIGITAL OUTPUT	RA	RETURN AIR
EF	EXHAUST FAN	RF	RETURN FAN
GCM	GLOBAL CONTROL MODULE	RHP	RADIANT HEAT PANEL
HC	HEATING COIL	SA	SUPPLY AIR
IEW	IN ELECTRICAL WORK		


GENERAL NOTES:

- THE DIAGRAMS AND POINTS SHOWN HERE ARE SCHEMATIC ONLY. REFER TO SEQUENCE OF OPERATIONS OF THE SPECIFICATIONS FOR COMPLETE CONFIGURATION OF THE SYSTEMS. COORDINATE WITH ALL OTHER DISCIPLINES TO ACHIEVE RESULTS AS SHOWN AND INTENDED HEREUNDER IN THE DOCUMENTS.
- SEE FLOOR PLANS AND PIPING DIAGRAMS FOR RESPECTIVE ROOM THERMOSTAT, IMMERSION THERMOSTAT, AND PRESSURE SWITCH LOCATIONS. SEE PLANS FOR OTHER CONTROL EQUIPMENT LOCATIONS. COORDINATE WITH DIVISION 15 AND 16 FOR EQUIPMENT INTERFACE REQUIREMENTS, INCLUDING PIPING TEES AND WELLS, SENSOR LOCATIONS, AND INTERCONNECTIONS.
- ALL SYSTEMS ABBREVIATIONS, FUNCTIONS, AND EQUIPMENT NAMES SHALL BE LISTED IN ALL SUBMITTAL DATA, O&M DATA, AND AS-BUILTS, AS SHOWN HEREUNDER.
- ALL THERMOSTATS LOCATED IN ALL ROOMS SHALL HAVE THERMOMETER ONLY ON COVER, AND SHALL BE DDC. ALL THERMOSTATS IN OCCUPIED AREAS SHALL HAVE TEMPERATURE ADJUSTMENT ON COVER INSIDE LOCKABLE ENCLOSURE.

SEQUENCE OF OPERATIONS

- AIR HANDLING UNIT AHU-3:
 - SWITCHES: MAGNETIC STARTERS WITH HAND-OFF-AUTO SWITCH AND AUXILIARY CONTACT, LOCATED ON THE MOUNTING BOARD IN THE FAN ROOM. IN THE AUTO POSITION, AHU OPERATES AT THE COMMAND OF THE BAS SYSTEM. IN THE HAND POSITION, THE FAN OPERATES. IN BOTH POSITIONS AHU OPERATES AT THE COMMAND OF THE SAFETY FUNCTIONS; LOW LIMIT CONTROL AND FIRE ALARM. DIFFERENTIAL AIR PRESSURE SWITCH SHALL SIGNAL BAS STATUS OF FAN.
 - AHU-3 MIXED AIR DAMPER CONTROL: AVERAGING BULB MIXED AIR THERMOSTAT COVERING THE CROSS SECTIONAL AREA OF FAN MODULATES THE OUTSIDE AND RETURN AIR DAMPERS TO MAINTAIN THE MIXED AIR TEMPERATURE (MAT) SETPOINT. THE MAT SETPOINT IS TO BE RESET AS FOLLOWS: OUTSIDE AIR TEMPERATURE OF 40F AND LESS THE MIXED AIR TEMPERATURE IS TO BE 65F AND MODULATE TO 55F AT AN OUTSIDE AIR TEMPERATURE OF 55F AND ABOVE. OUTSIDE AIR DAMPER MINIMUM POSITION IS TO BE POSITIONED DURING BALANCING TO DELIVER 2,800 CFM AT ALL OCCUPIED TIMES. NORMAL POSITION OF OUTSIDE DAMPER AND EXHAUST AIR DAMPER IS CLOSED AND NORMAL POSITION OF RETURN AIR DAMPER IS OPEN.
 - AHU-3 SUPPLY AIR TEMPERATURE: AVERAGING BULB DUCT THERMOSTAT IN THE SUPPLY AIR DISCHARGE TO MODULATE THE THREE WAY AUTOMATIC VALVE AV-12 ON THE HEATING COIL TO MAINTAIN SUPPLY AIR TEMPERATURE SETPOINT RESET BY OUTSIDE AIR THERMOSTAT. ADJUSTABLE RESET SCHEDULE SET AS FOLLOWS: OUTSIDE AIR TEMPERATURE OF 40F AND LESS THE SUPPLY AIR TEMPERATURE IS TO BE 70F AND MODULATE TO 55F AT AN OUTSIDE AIR TEMPERATURE OF 55F AND ABOVE. OUTSIDE AIR DAMPER MINIMUM POSITION IS TO BE 20% OPEN AT ALL OCCUPIED TIMES. EXHAUST AIR DAMPER IS TO LAG OUTSIDE AIR DAMPER BY 20% TO ALLOW FOR A SLIGHT PRESSURIZATION OF SPACE.
 - RETURN FANS (RF-3): MAGNETIC STARTER WITH HAND-OFF-AUTO SWITCH ON THE COVER. LOCATED ON THE MOUNTING BOARD IN THE MECHANICAL ROOM. IN THE HAND POSITION, RETURN FAN RF OPERATES WHENEVER RESPECTIVE AHU OPERATES. IN THE AUTO POSITION THE RETURN FAN OPERATES. IN BOTH POSITIONS RETURN FAN OPERATES AT THE COMMAND OF THE SAFETY FUNCTIONS, FIRE ALARM, AND SMOKE SENSOR.
 - AHU-3 LOW LIMIT CONTROL: AVERAGING BULB THERMOSTAT, LOCATED AT THE DISCHARGE OF THE HEATING COIL TO STOP THE FAN BELOW 35F AFTER AN ADJUSTABLE TIME DELAY OF 45 SECONDS. BAS SHALL RECORD ALARM. DURING A LOW LIMIT CONDITION RESPECTIVE AUTOMATIC VALVE IS TO OPEN TO FULL.
 - SMOKE SENSORS: UPON ACTIVATION OF SENSOR, THE SMOKE SENSOR SHALL STOP THE AHU, RF, AND EF. SMOKE SENSOR AND FAN SHUT DOWN CONTROL PROVIDED UNDER ELECTRICAL DIVISION. COORDINATE PROVISION AND CONNECTION TO BAS FOR ALARM.
- EXHAUST FAN EF-12: MAGNETIC STARTER WITH HAND-OFF-AUTO SWITCH, LOCATED ON THE WALL IN THE JANITOR'S ROOM TO CONTROL FAN. IN THE AUTO POSITION, FAN OPERATES WHEN AHU-3 OPERATES. IN THE HAND POSITION, FAN OPERATES. COORDINATE WORK WITH ELECTRICAL WORK.
- UNIT HEATER CONTROL: LOCAL CONTROL. ROOM THERMOSTAT OPENS RESPECTIVE AUTOMATIC VALVE AND OPERATES FAN BELOW SETPOINT. LOCAL LINE VOLTAGE CONTROL IN ELECTRICAL WORK.
- CONVECTOR HEATING CONTROL: ROOM THERMOSTAT OPENS RESPECTIVE AUTOMATIC VALVE WHEN BELOW SETPOINT.
- ROOM TEMPERATURE CONTROLS:
 - TMB BOX WITH HEATING COIL CONTROLS: ROOM TEMPERATURE SHALL BE MAINTAINED ACCORDING TO AN OCCUPIED/UNOCCUPIED SCHEDULE FOR EACH ZONE. ROOM THERMOSTAT WITH ADJUSTABLE OCCUPIED HEATING SETPOINT, AND OCCUPIED SCHEDULE OVERRIDE PUSHBUTTON. SET THE COOLING SETPOINTS AT 5F ABOVE THE HEATING SETPOINTS. THE OVERRIDE BUTTON SHALL PROVIDE VISUAL INDICATION THAT THE THERMOSTAT IS IN OVERRIDE STATUS. ACTIVATION OF THE OVERRIDE BUTTON SHALL CHANGE SYSTEM TO OCCUPIED MODE FOR AN ADJUSTABLE 3 HOURS. AFTER THE ADJUSTABLE 3 HOURS, THE SCHEDULE SHALL RETURN TO NORMAL. UNOCCUPIED HEATING AND COOLING SETPOINTS AND OCCUPIED SETPOINT LIMIT ADJUSTABLE FROM THE BAS. GRAPHICS: ALL ROOMS, ZONES, ROOM NAMES AND NUMBERS, ROOM TEMPERATURE SETPOINTS, AND ACTUAL ROOM TEMPERATURES SHALL BE DISPLAYED IN PLAN VIEW. ROOMS IN COOLING MODE SHALL BE SHOWN AS RED, ROOMS IN HEATING MODE SHALL BE SHOWN AS BLUE, AND ROOMS IN THROTTLING RANGE SHALL BE SHOWN AS WHITE. EACH ZONE'S TMB VAV DAMPER POSITIONS, AUTOMATIC VALVE POSITIONS, AND SUPPLY AIR TEMPERATURE SETPOINTS AND ACTUAL TEMPERATURES SHOULD BE ACCESSIBLE ON THE GRAPHICS PROGRAM BY "CLICKING" ON THE ZONE.
 - OCCUPIED MODE: HEATING: THE TMB DAMPER AND HEATING AUTOMATIC VALVE SHALL MODULATE TO MAINTAIN ROOM TEMPERATURE WITHIN 1 DEGREE OF HEATING SETPOINT UTILIZING A PID CONTROL SEQUENCE. THE TMB DAMPER SHALL POSITION TO MAINTAIN THE MINIMUM AIR VOLUME AT 3 DEGREES BELOW SETPOINT. COOLING: MODULATE VAV DAMPER BETWEEN MINIMUM POSITION AND MAXIMUM POSITION, WITH FEEDBACK FROM A FLOW SENSOR IN THE BOX INLET TO MAINTAIN ROOM TEMPERATURE. HEATING VALVE SHALL REMAIN SHUT WHEN IN COOLING MODE.
 - IN THE UNOCCUPIED MODE, THE TMB DAMPER SHALL POSITION TO THE MINIMUM POSITION AND THE AUTOMATIC VALVE SHALL BE FULLY OPEN (ADJUSTABLE) WHEN TEMPERATURE IS 2F BELOW SETPOINT. THE AUTOMATIC VALVE SHALL CLOSE WHEN ROOM TEMPERATURE IS 2F ABOVE THE SETPOINT.

CHECKED BY: DM

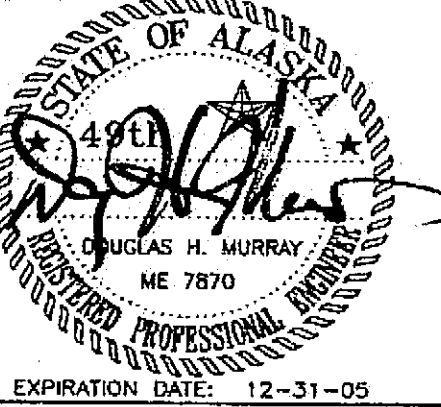

EXPIRATION DATE: 12-31-05

DESIGNED BY: DM/LH

DRAWN BY: WN

STATE OF ALASKA
DEPARTMENT OF TRANSPORTATION
& PUBLIC FACILITIES
STATEWIDE DESIGN & ENGINEERING
SERVICES DIVISION

MT EDGE CUMBE
HIGH SCHOOL
BUILDING 1330
ACADEMIC
EXPANSION


SHEET M601

PROJECT DESIGNATION NUMBER

67751C


STATE	YEAR
ALASKA	2004
SHEET NUMBER	TOTAL SHEETS
66	79

Project As-Built Drawings have been
reviewed by the Project Engineer and
represent to the best of my knowledge, the
project as constructed.
Proj. Eng. *D. Murray* Date *7-07*

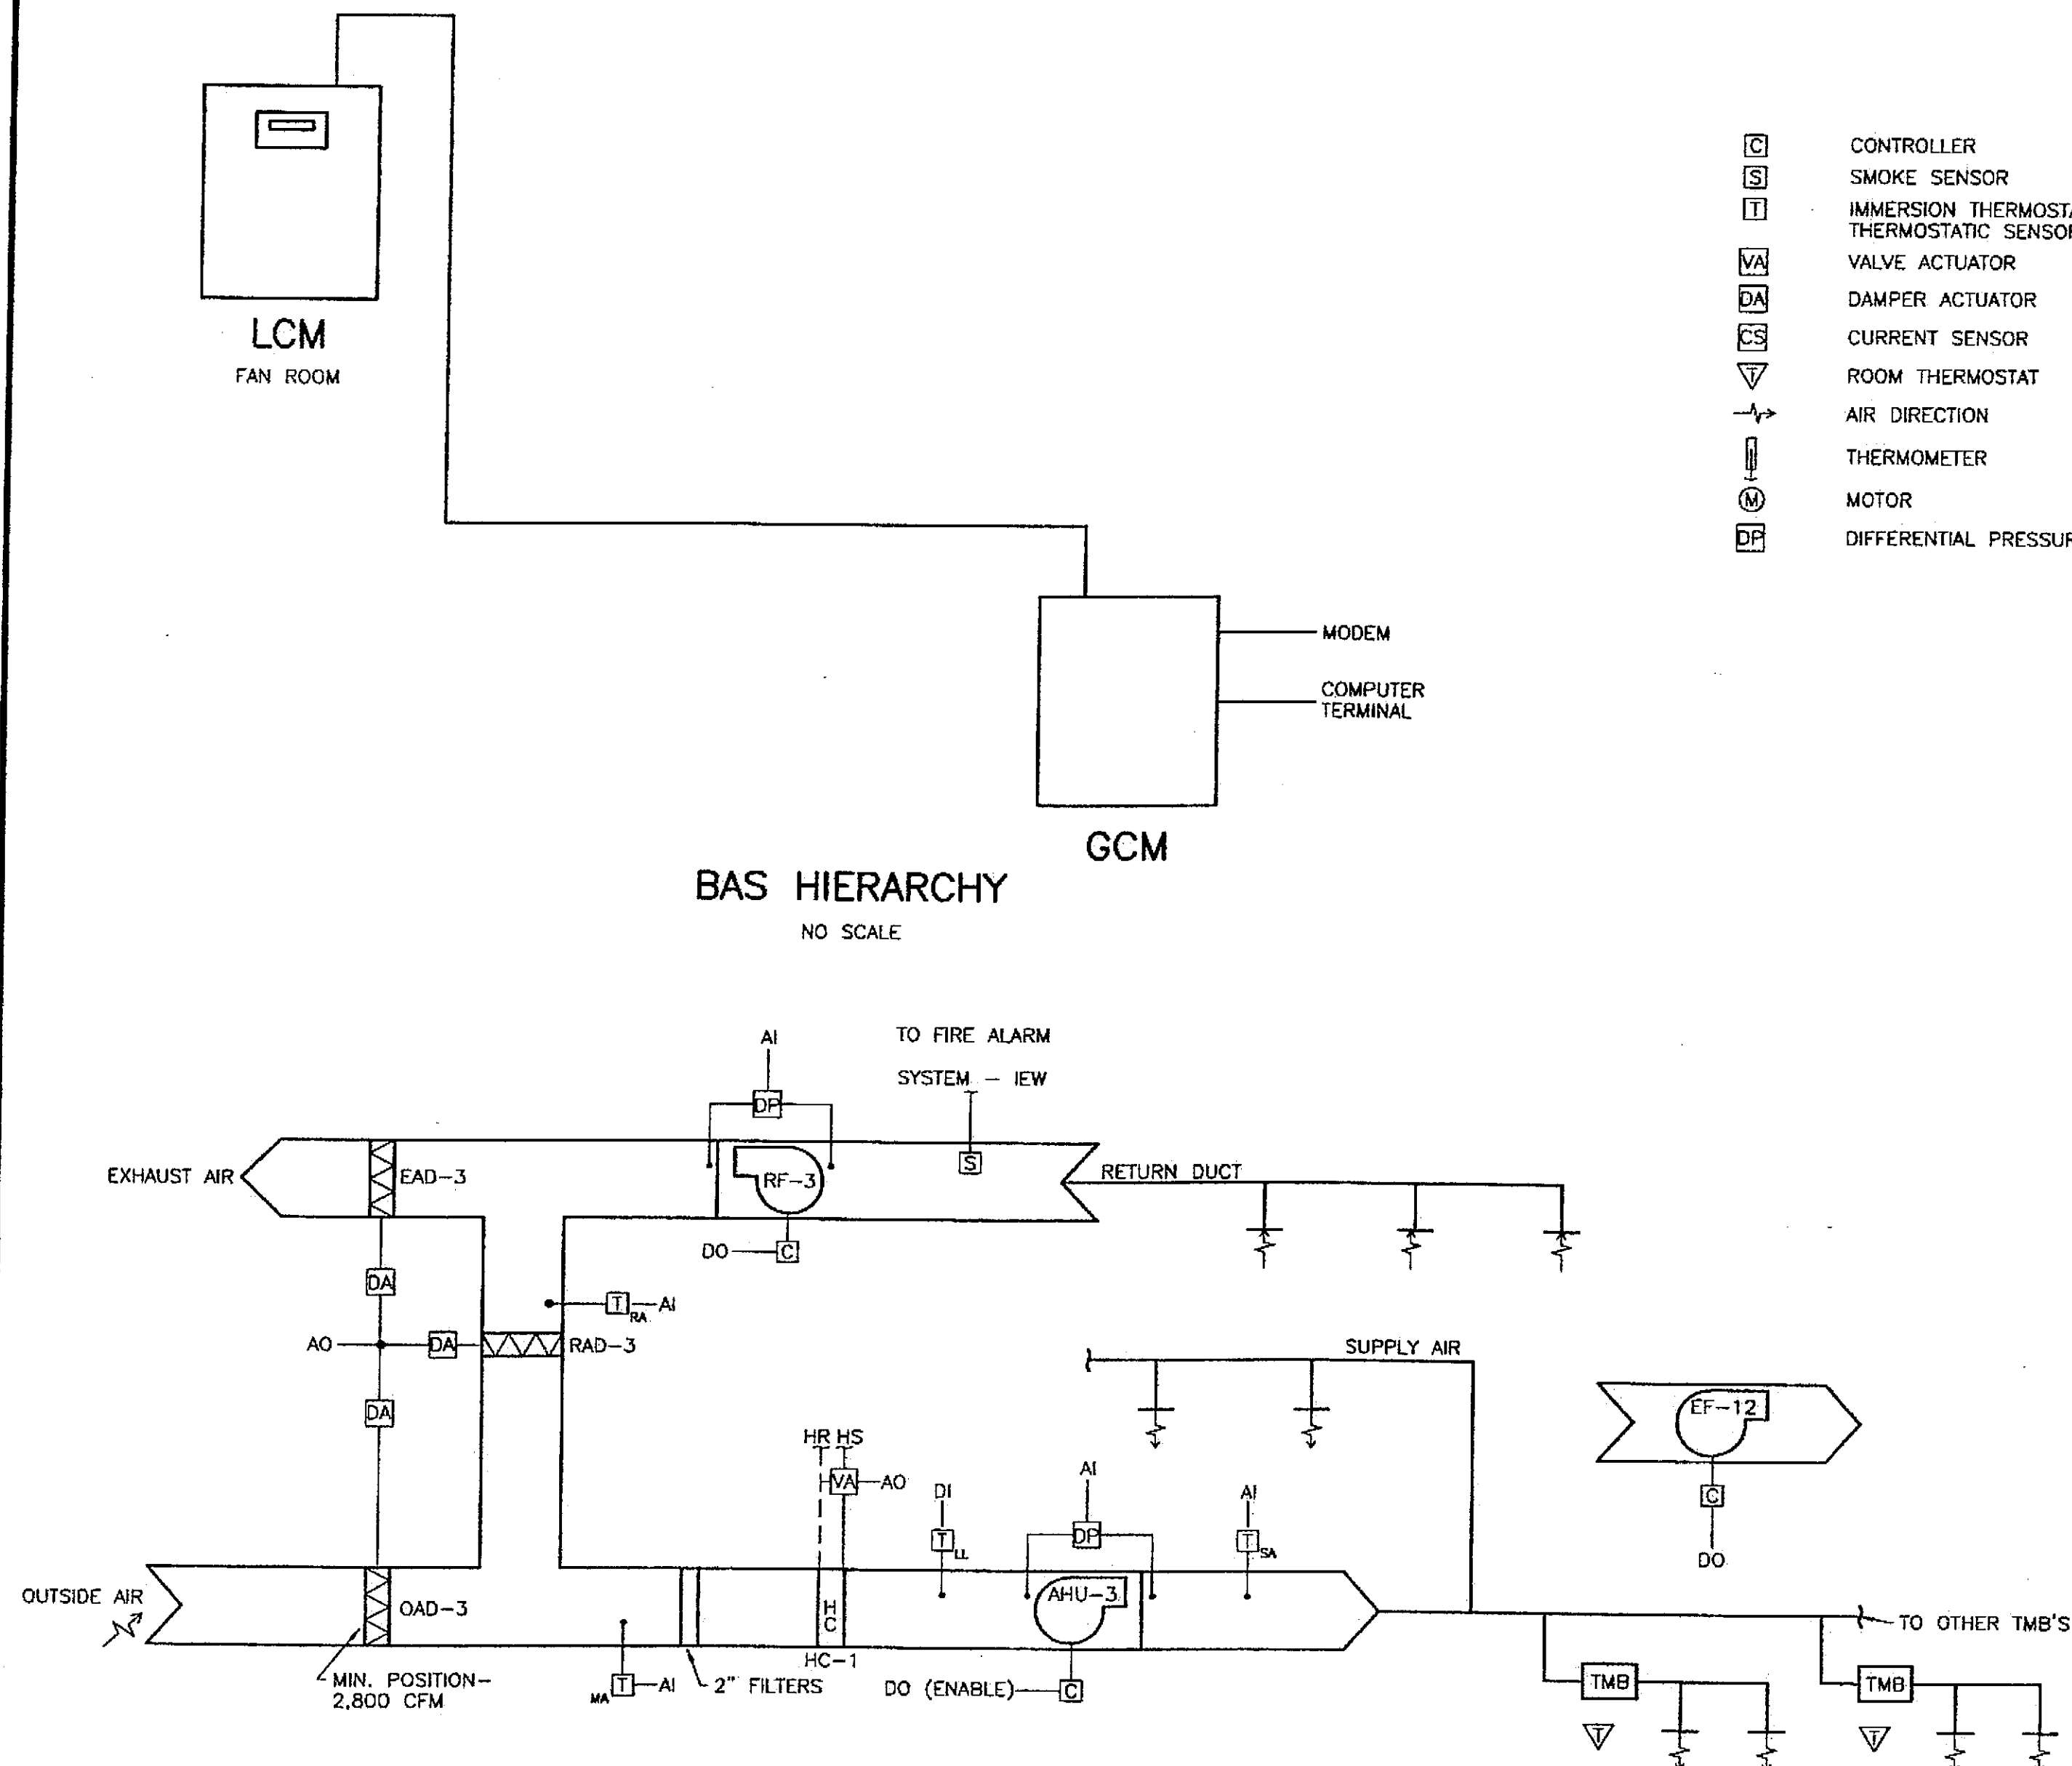


CONTROL SCHEMATIC - AHU-3

NO SCALE

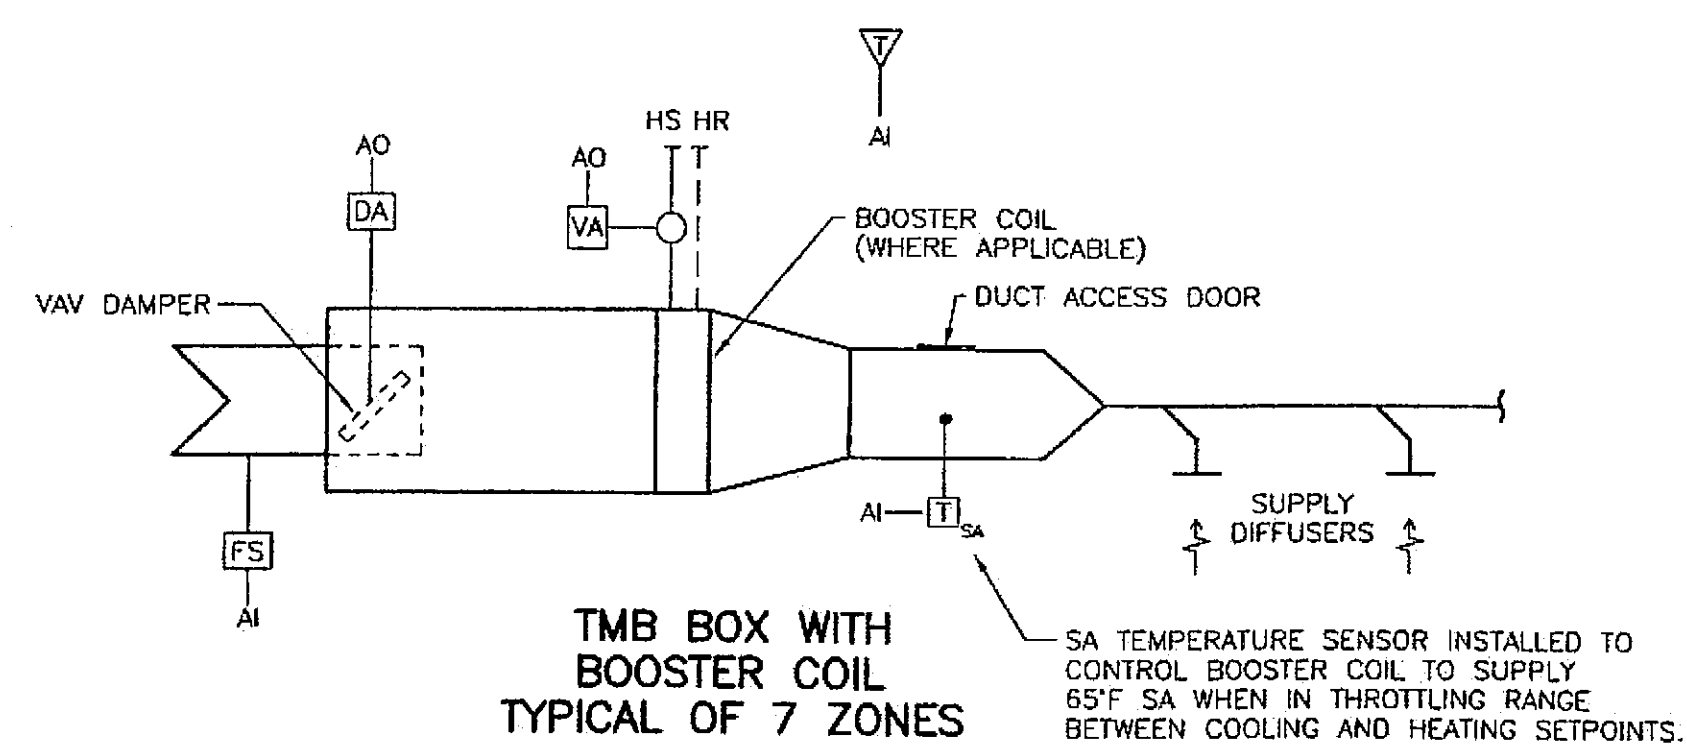


ROOM TEMPERATURE CONTROL DIAGRAM

NO SCALE

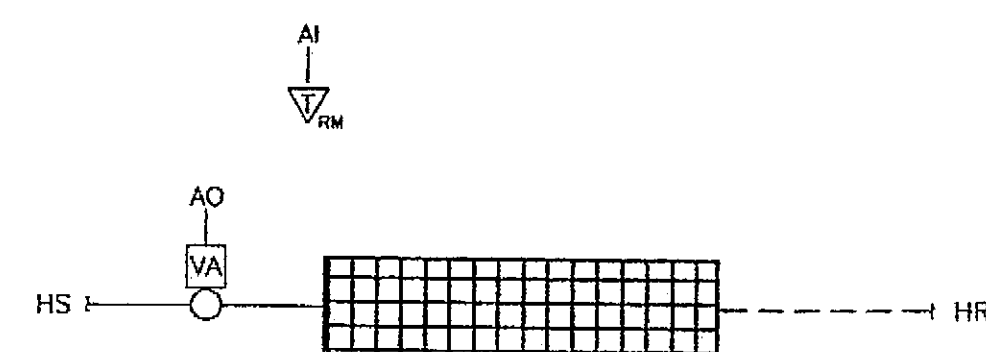


CV CONTROL DIAGRAM

NO SCALE

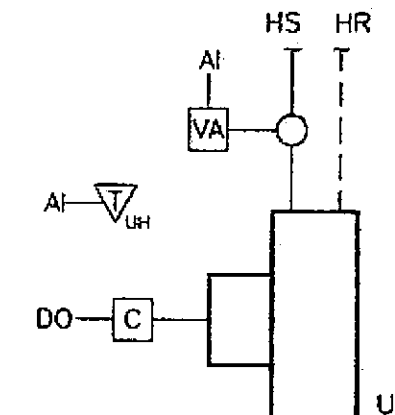


UH CONTROL DIAGRAM


NO SCALE

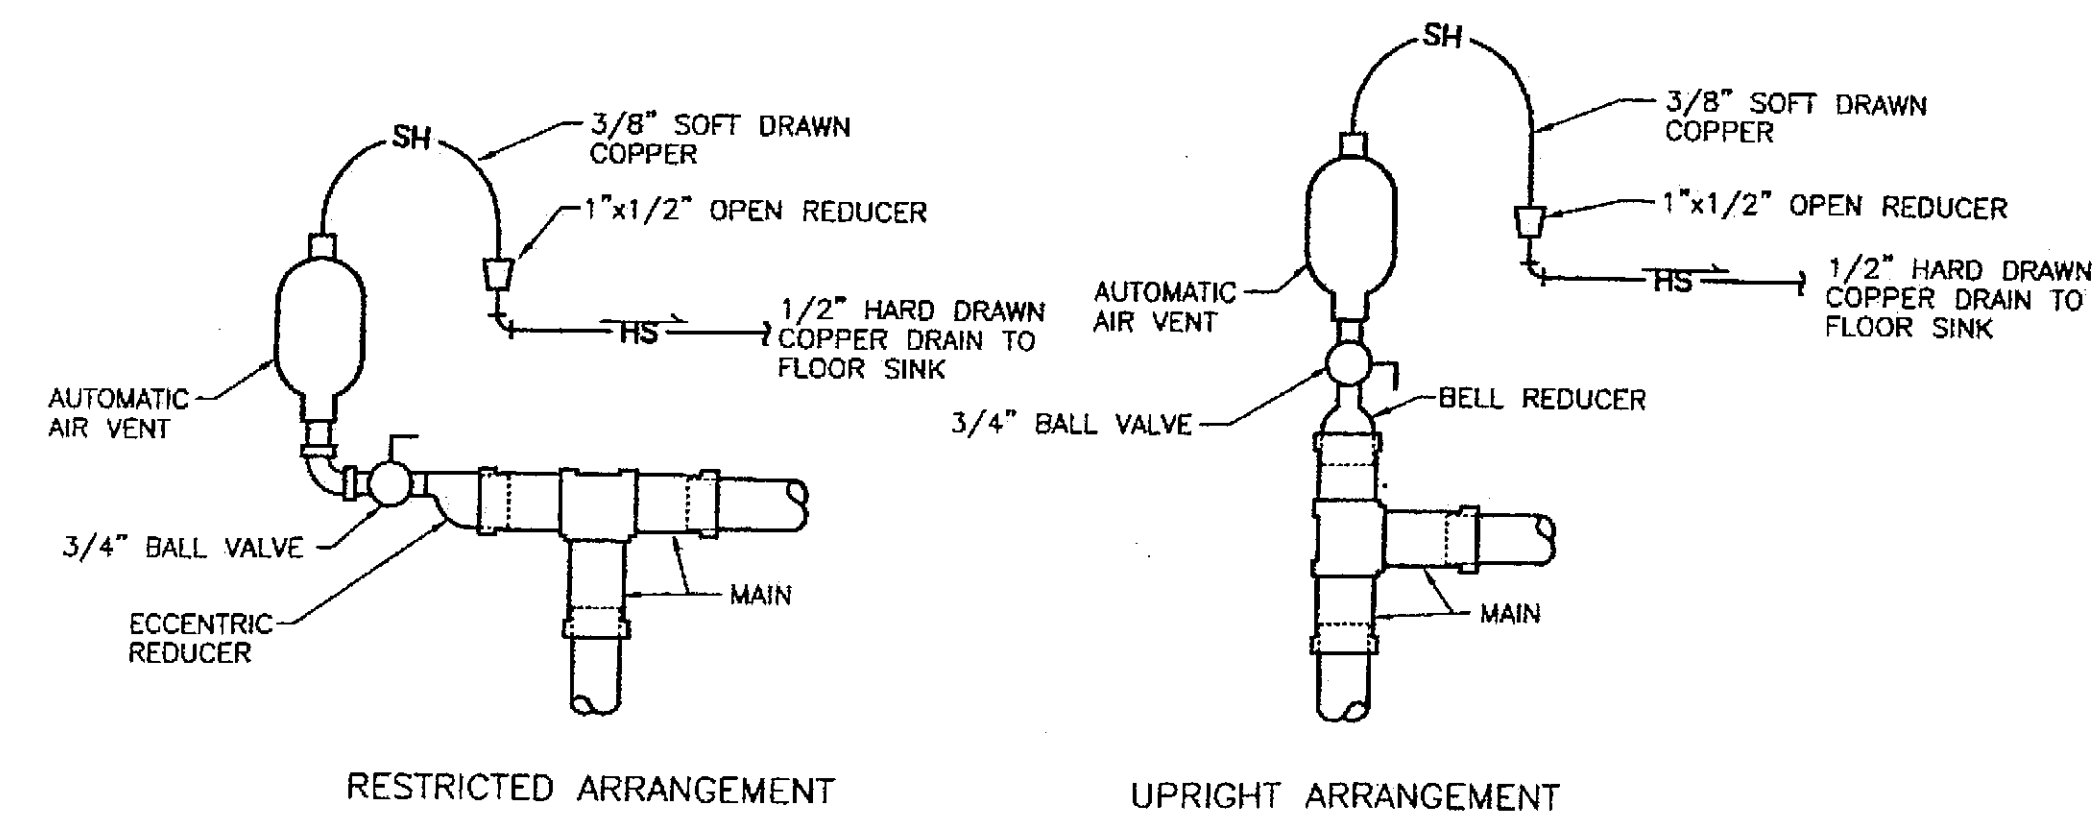


AUTOMATIC AIR VENT DETAIL
NO SCALE

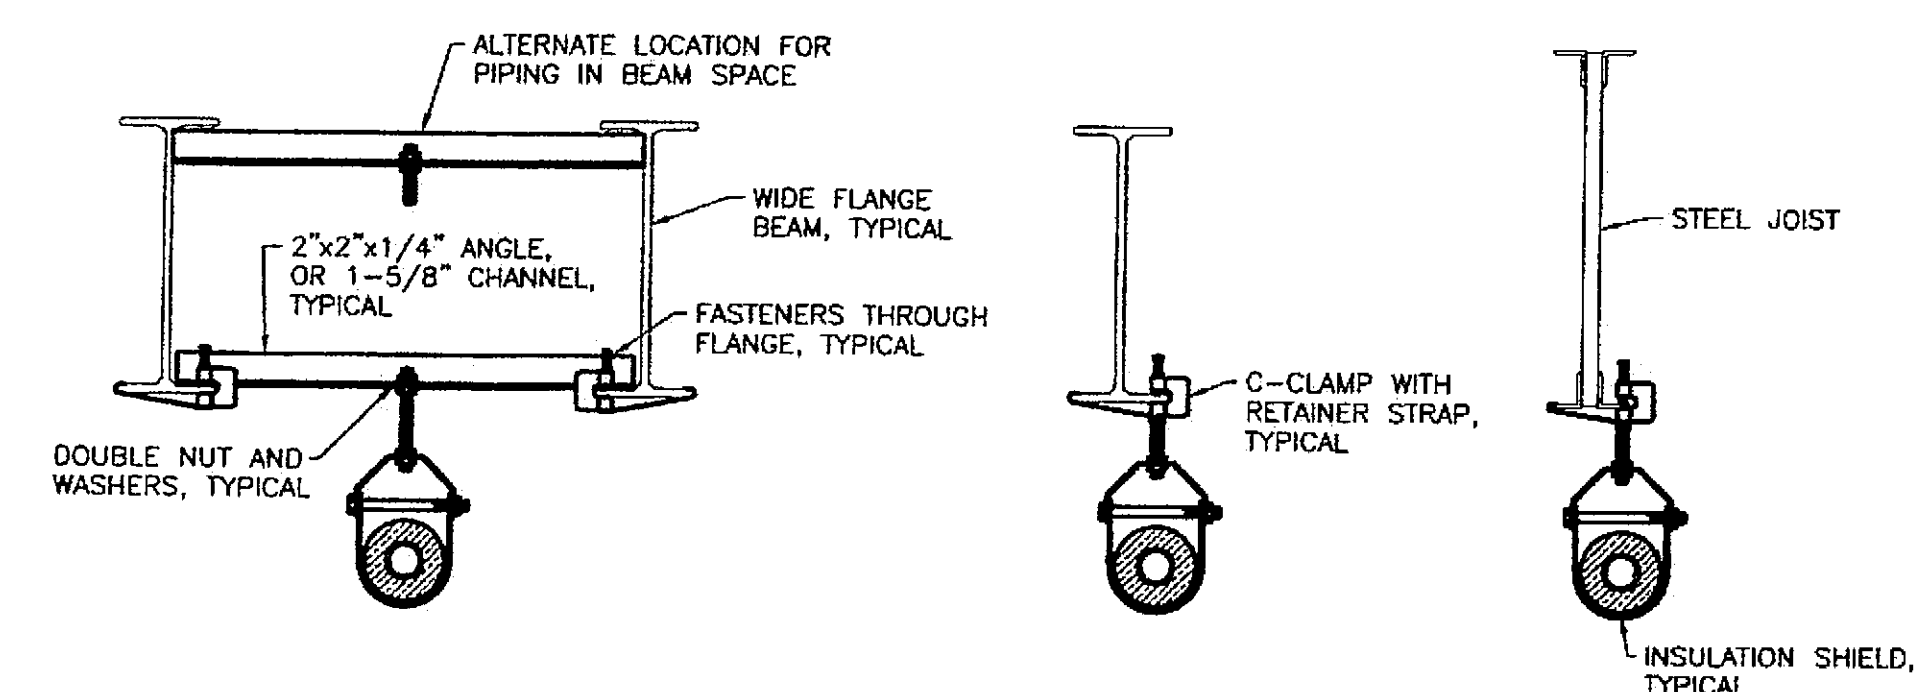


PIPE SUPPORT DETAILS—JOISTS
NO SCALE

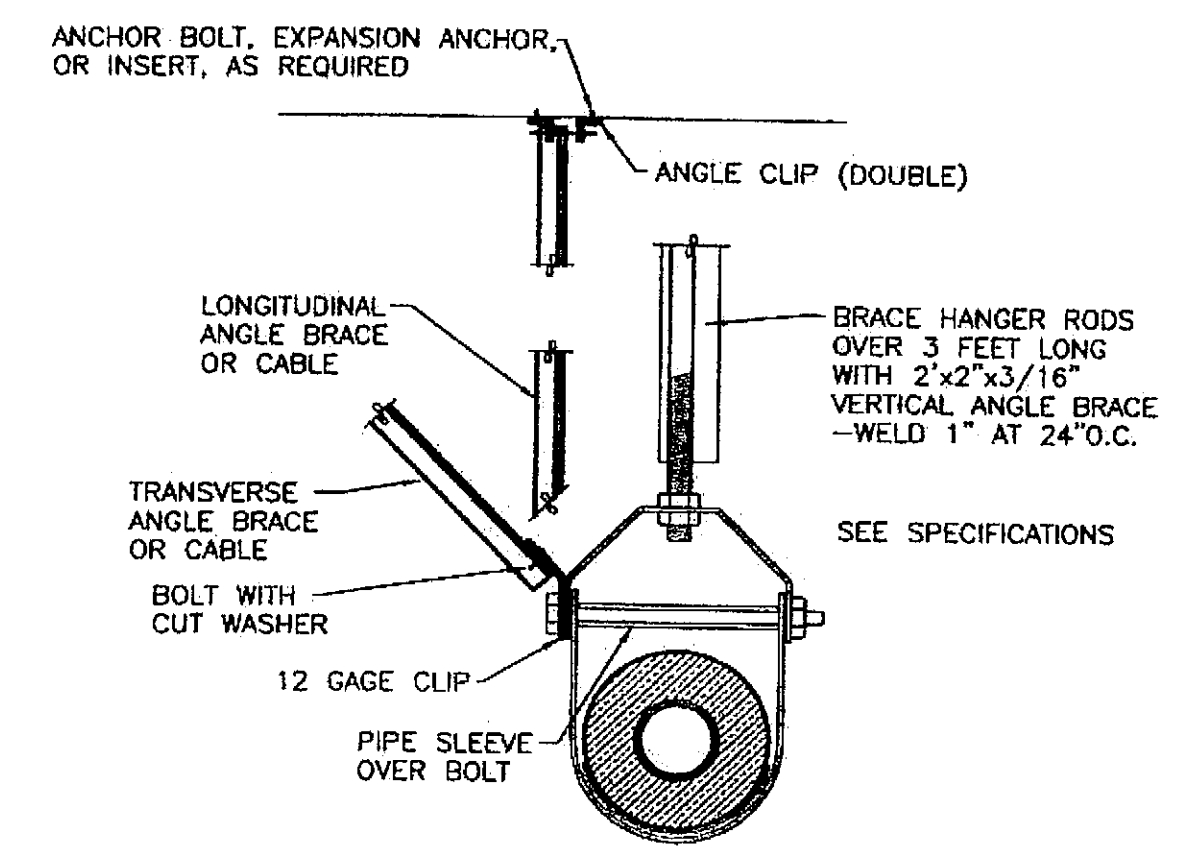


SEISMIC PIPE BRACING DETAIL
NO SCALE

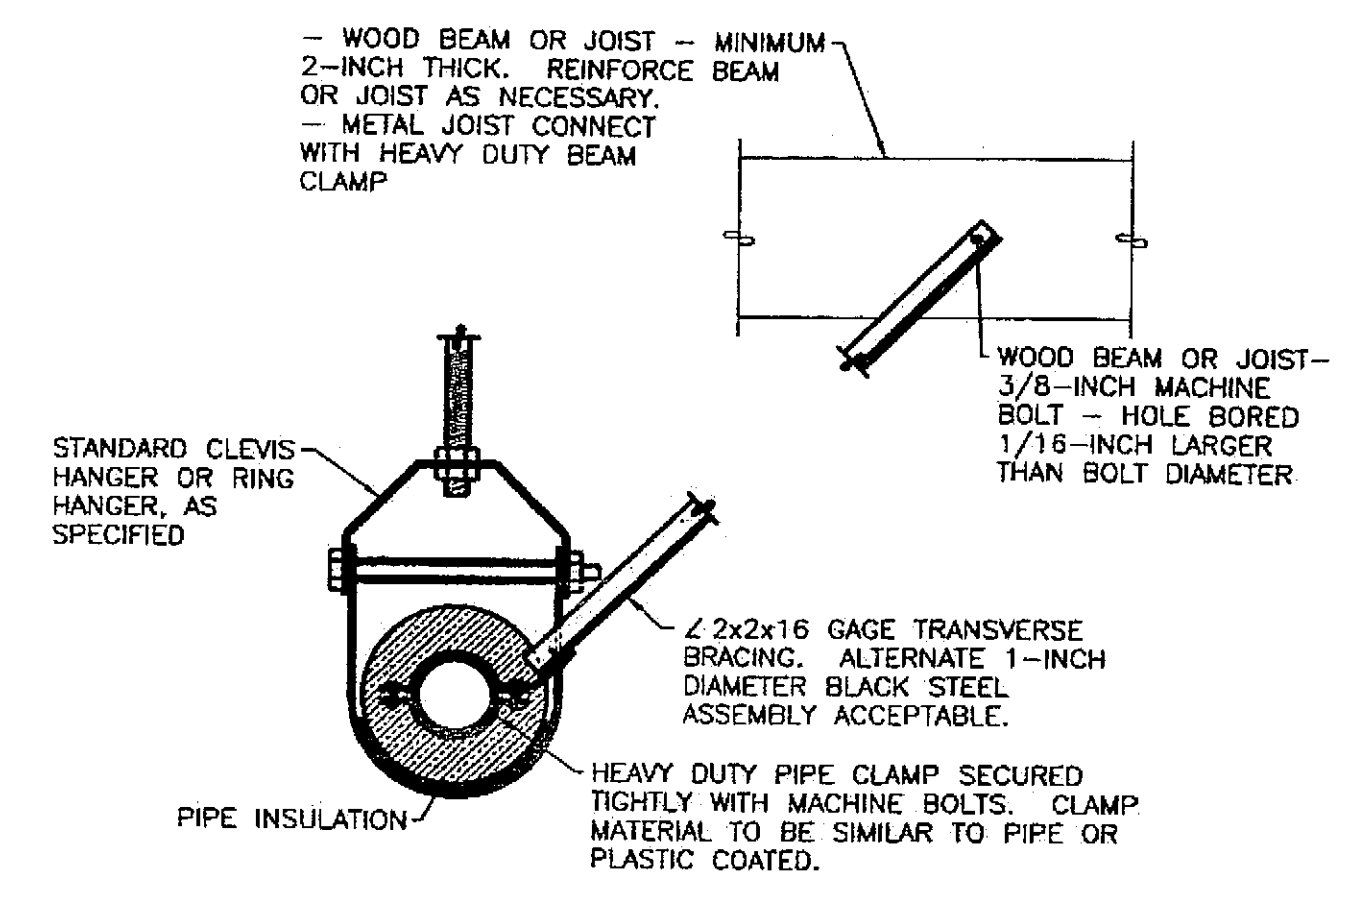


PIPE ANCHOR DETAIL
NO SCALE

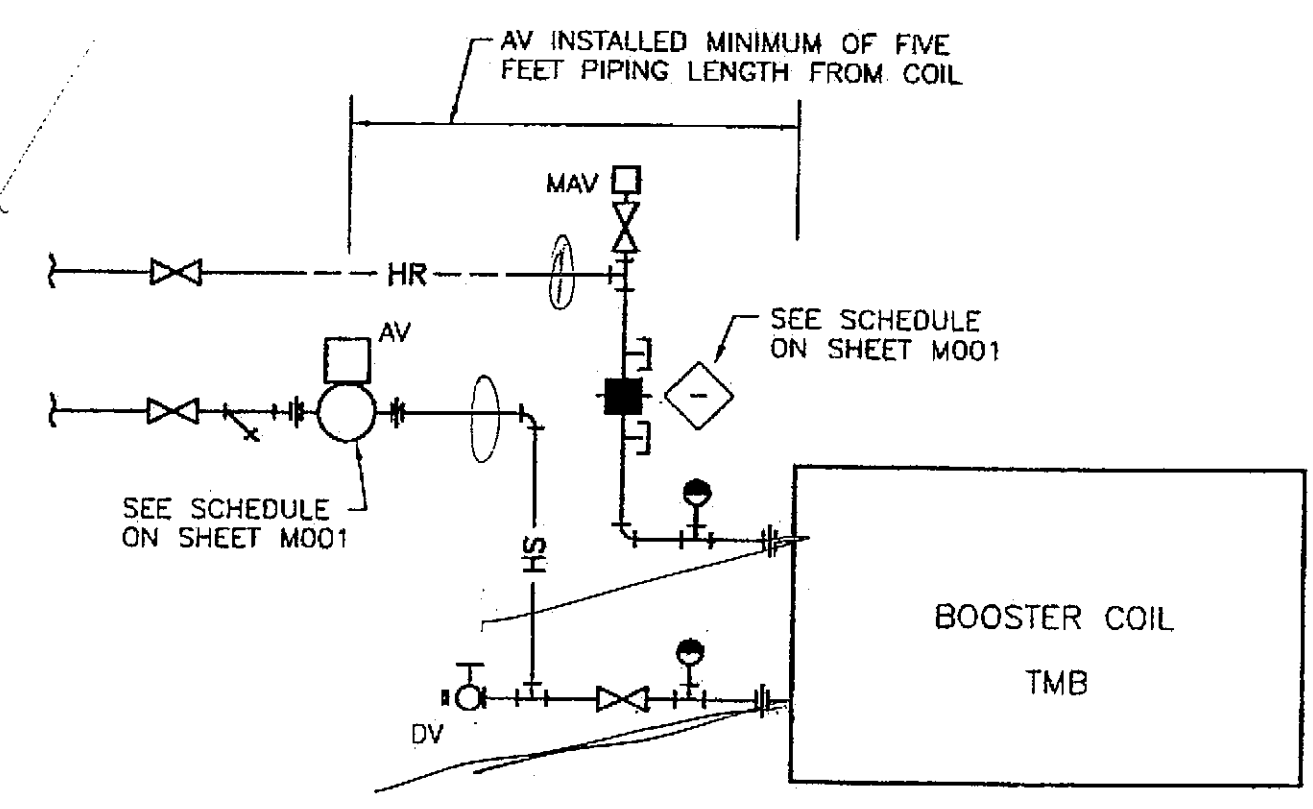

TMB BOOSTER COIL DETAIL
NO SCALE

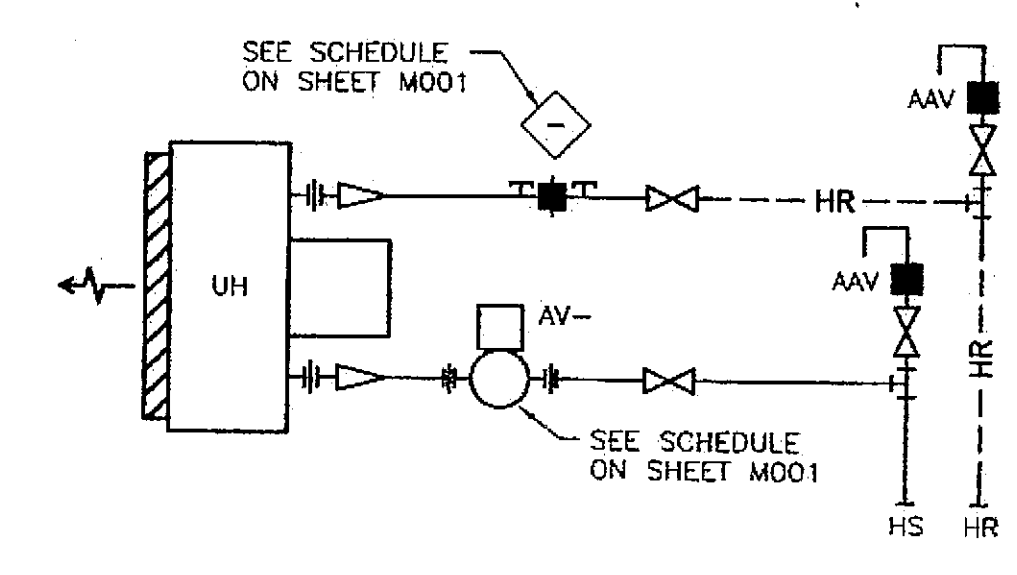

UNIT HEATER DETAIL
NO SCALE

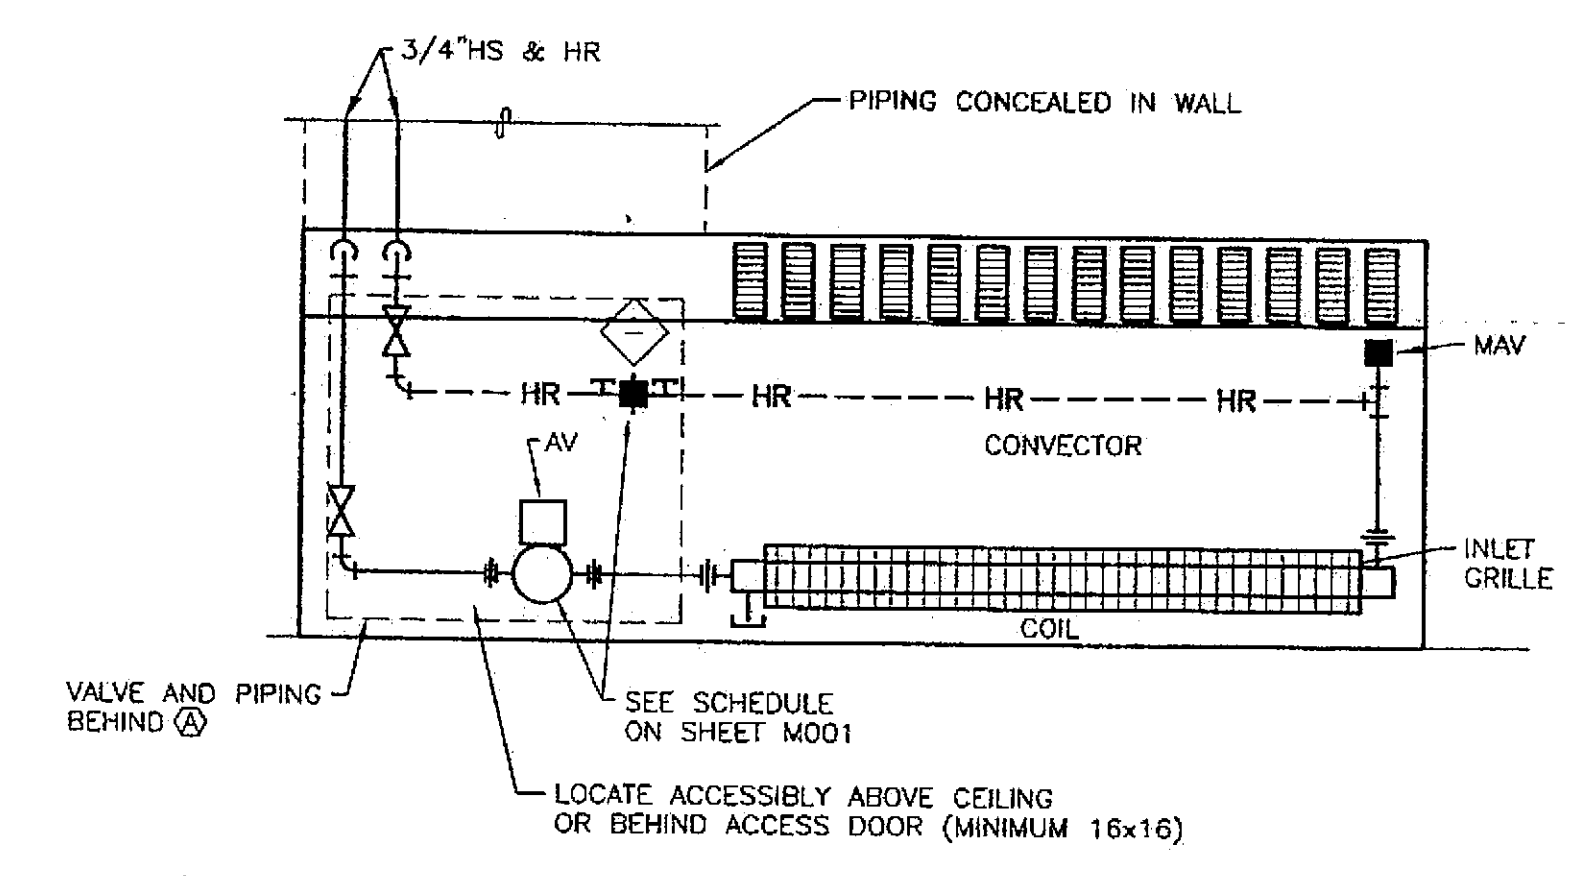

CONVECTOR DETAIL
NO SCALE

Tue, 14/Dec/04 09:00AM

RECORD OF REVISIONS		
No.	DATE	DESCRIPTION

CHECKED BY: DM

 EXPIRATION DATE: 12-31-05

DESIGNED BY: DM/LH
 DRAWN BY: WN

STATE OF ALASKA
 DEPARTMENT OF TRANSPORTATION & PUBLIC FACILITIES
 STATEWIDE DESIGN & ENGINEERING SERVICES DIVISION
 MT EDGECUMBE HIGH SCHOOL BUILDING 1330 ACADEMIC EXPANSION

SHEET M701
 PROJECT DESIGNATION NUMBER

67751C	
STATE	YEAR
ALASKA	2004
SHEET NUMBER	TOTAL SHEETS
67	79


Project As-Built Drawings have been reviewed by the Project Engineer and represent to the best of my knowledge, the project as constructed.
 Proj. Eng. *[Signature]* Date 7-07

ADDENDUM NUMBER


ATTACHMENT NUMBER

RECORD OF REVISIONS


No.	DATE	DESCRIPTION

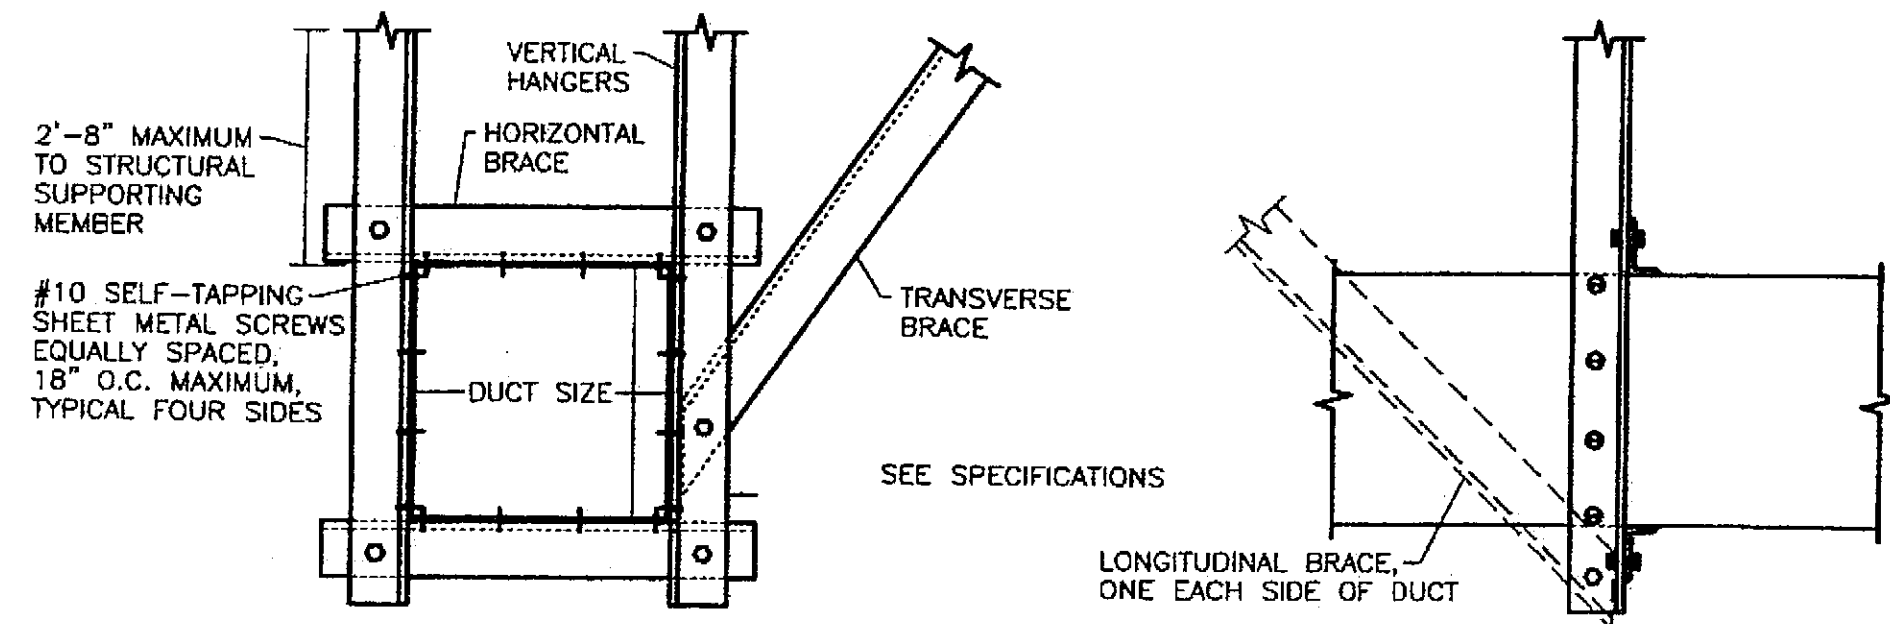


DUCT SEISMIC BRACING DETAIL
NO SCALE

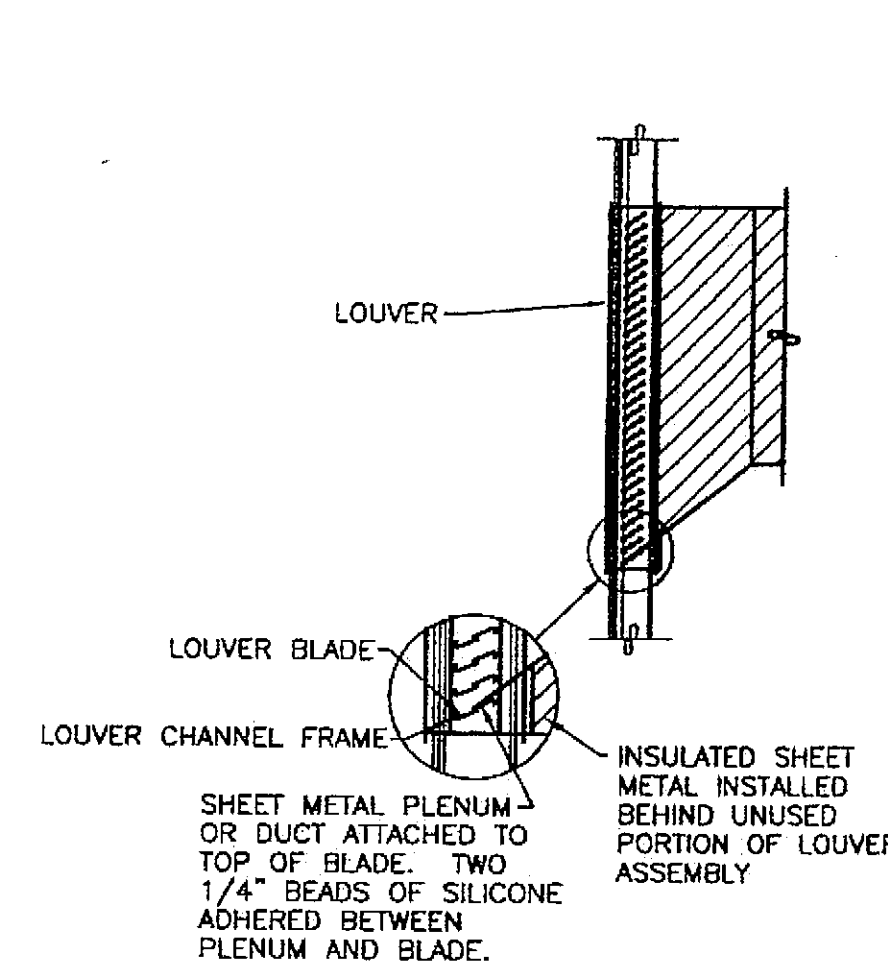


LOUVER CONNECTION DETAIL
NO SCALE

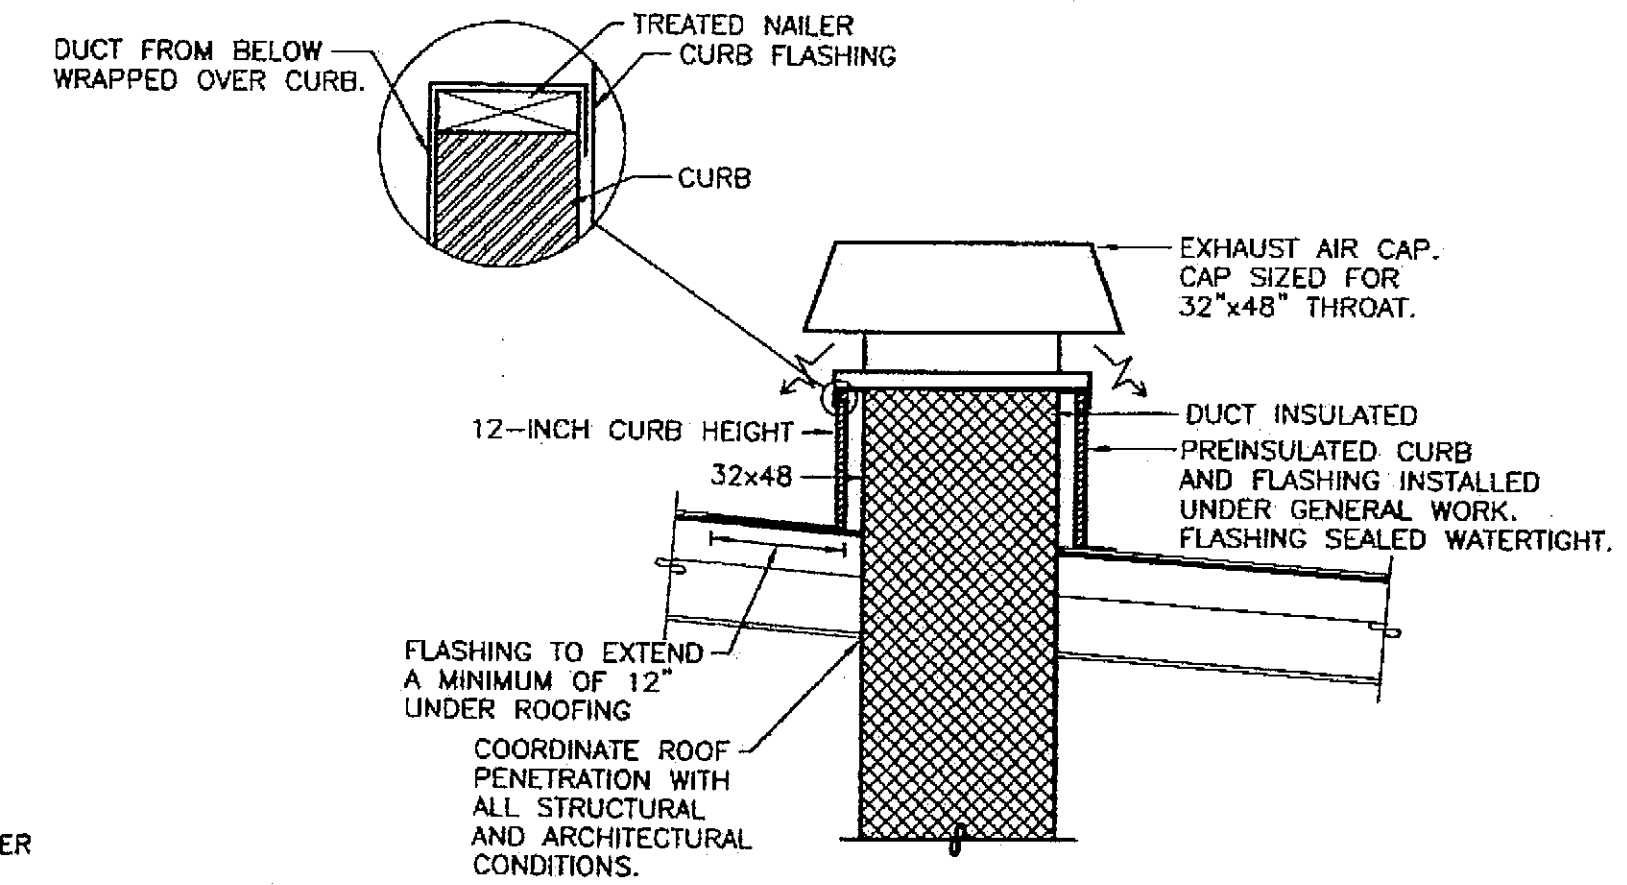

EXHAUST CAP DETAIL
NO SCALE

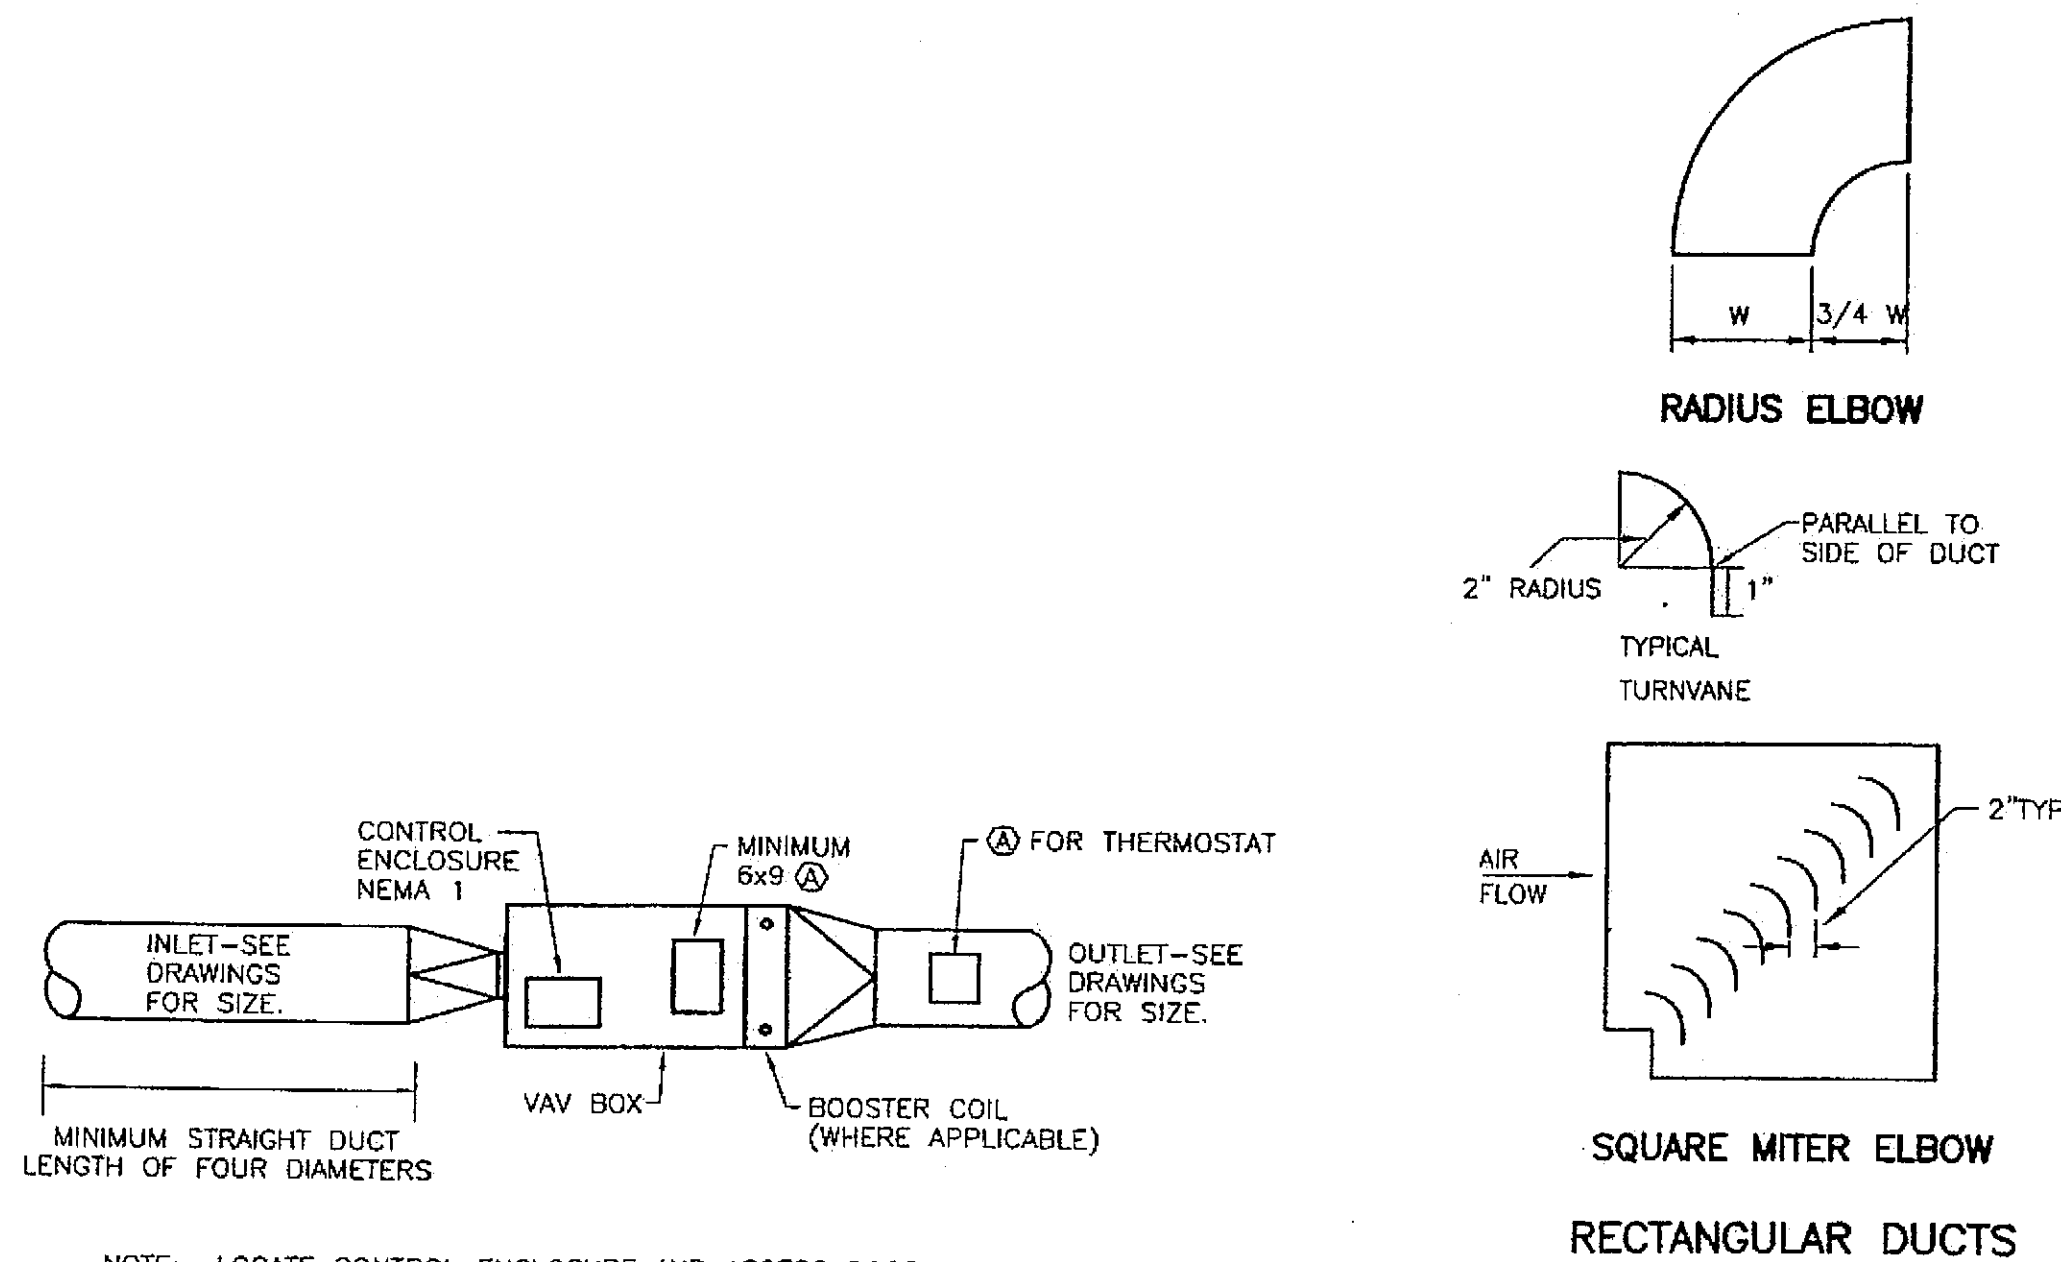


TMB BOX DETAIL
NO SCALE

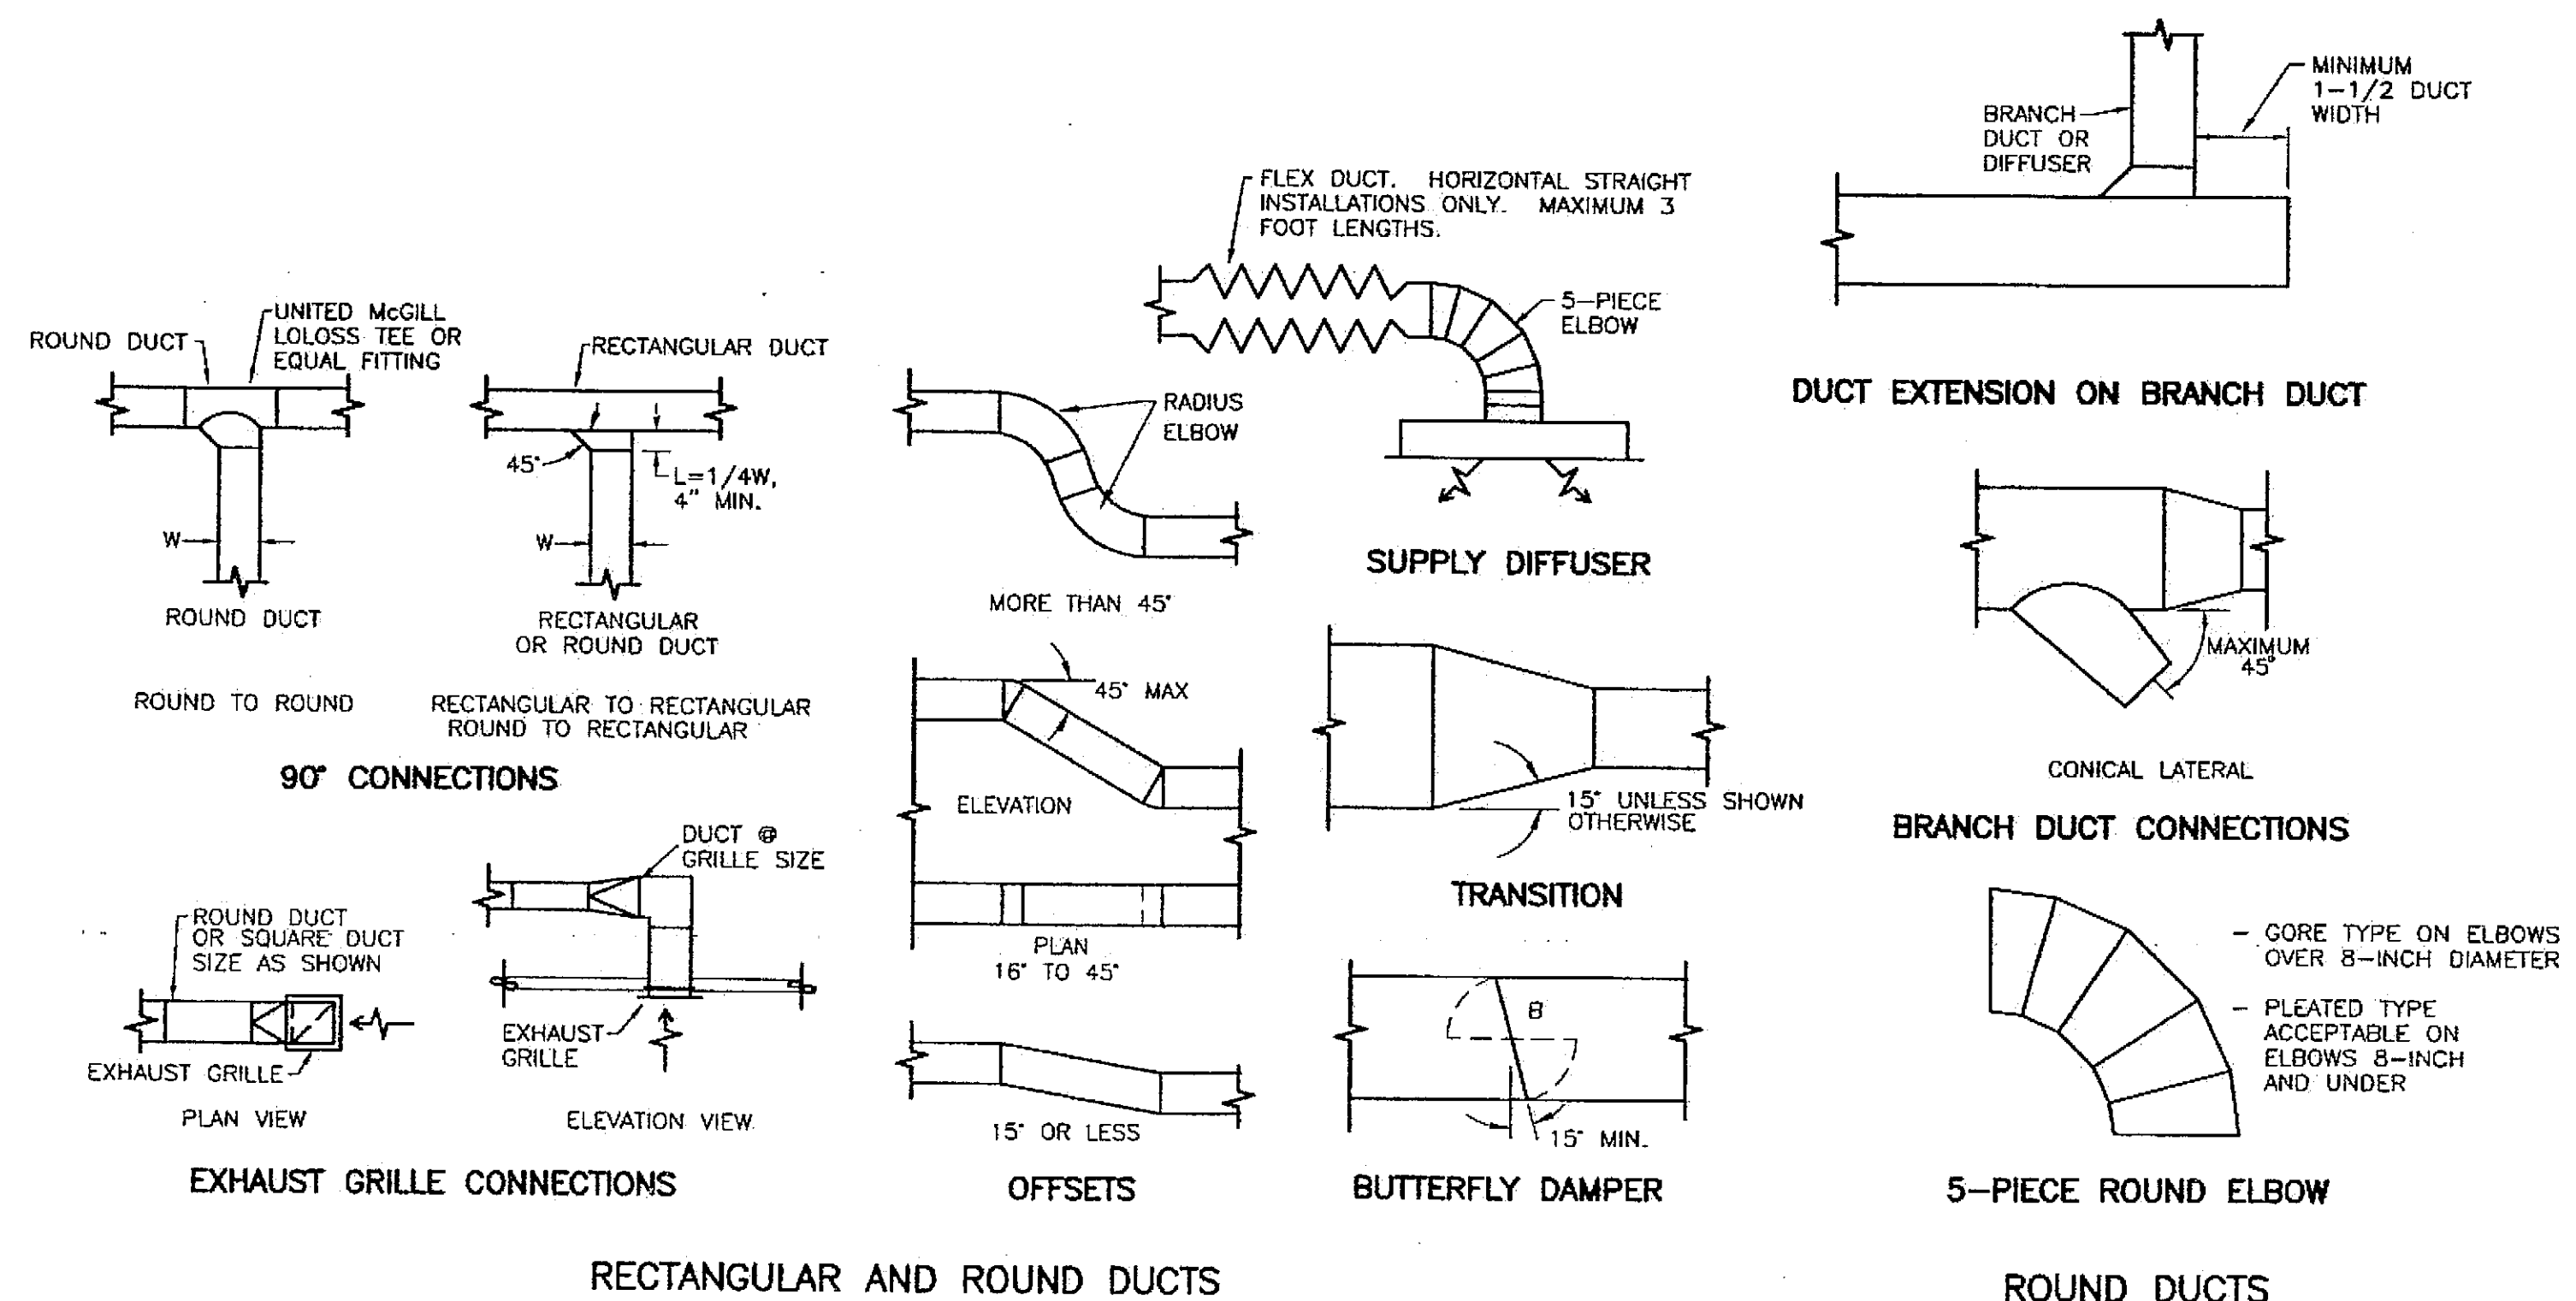

NOTE: ALL DUCTWORK SHALL BE CONSTRUCTED IN ACCORDANCE WITH THESE DETAILS AND THE SPECIFICATIONS.

DUCT CONSTRUCTION DETAILS
NO SCALE

CHECKED BY: DM

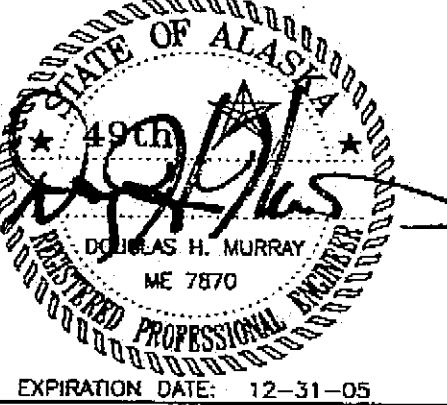

EXPIRATION DATE: 12-31-05

DESIGNED BY: DM/LH

DRAWN BY: WN

STATE OF ALASKA
DEPARTMENT OF TRANSPORTATION
& PUBLIC FACILITIES
STATEWIDE DESIGN & ENGINEERING
SERVICES DIVISION

MT EDGECUMBE
HIGH SCHOOL
BUILDING 1330
ACADEMIC
EXPANSION

SHEET M702

PROJECT DESIGNATION NUMBER


67751C

STATE YEAR

ALASKA 2004


SHEET NUMBER TOTAL SHEETS

68 79

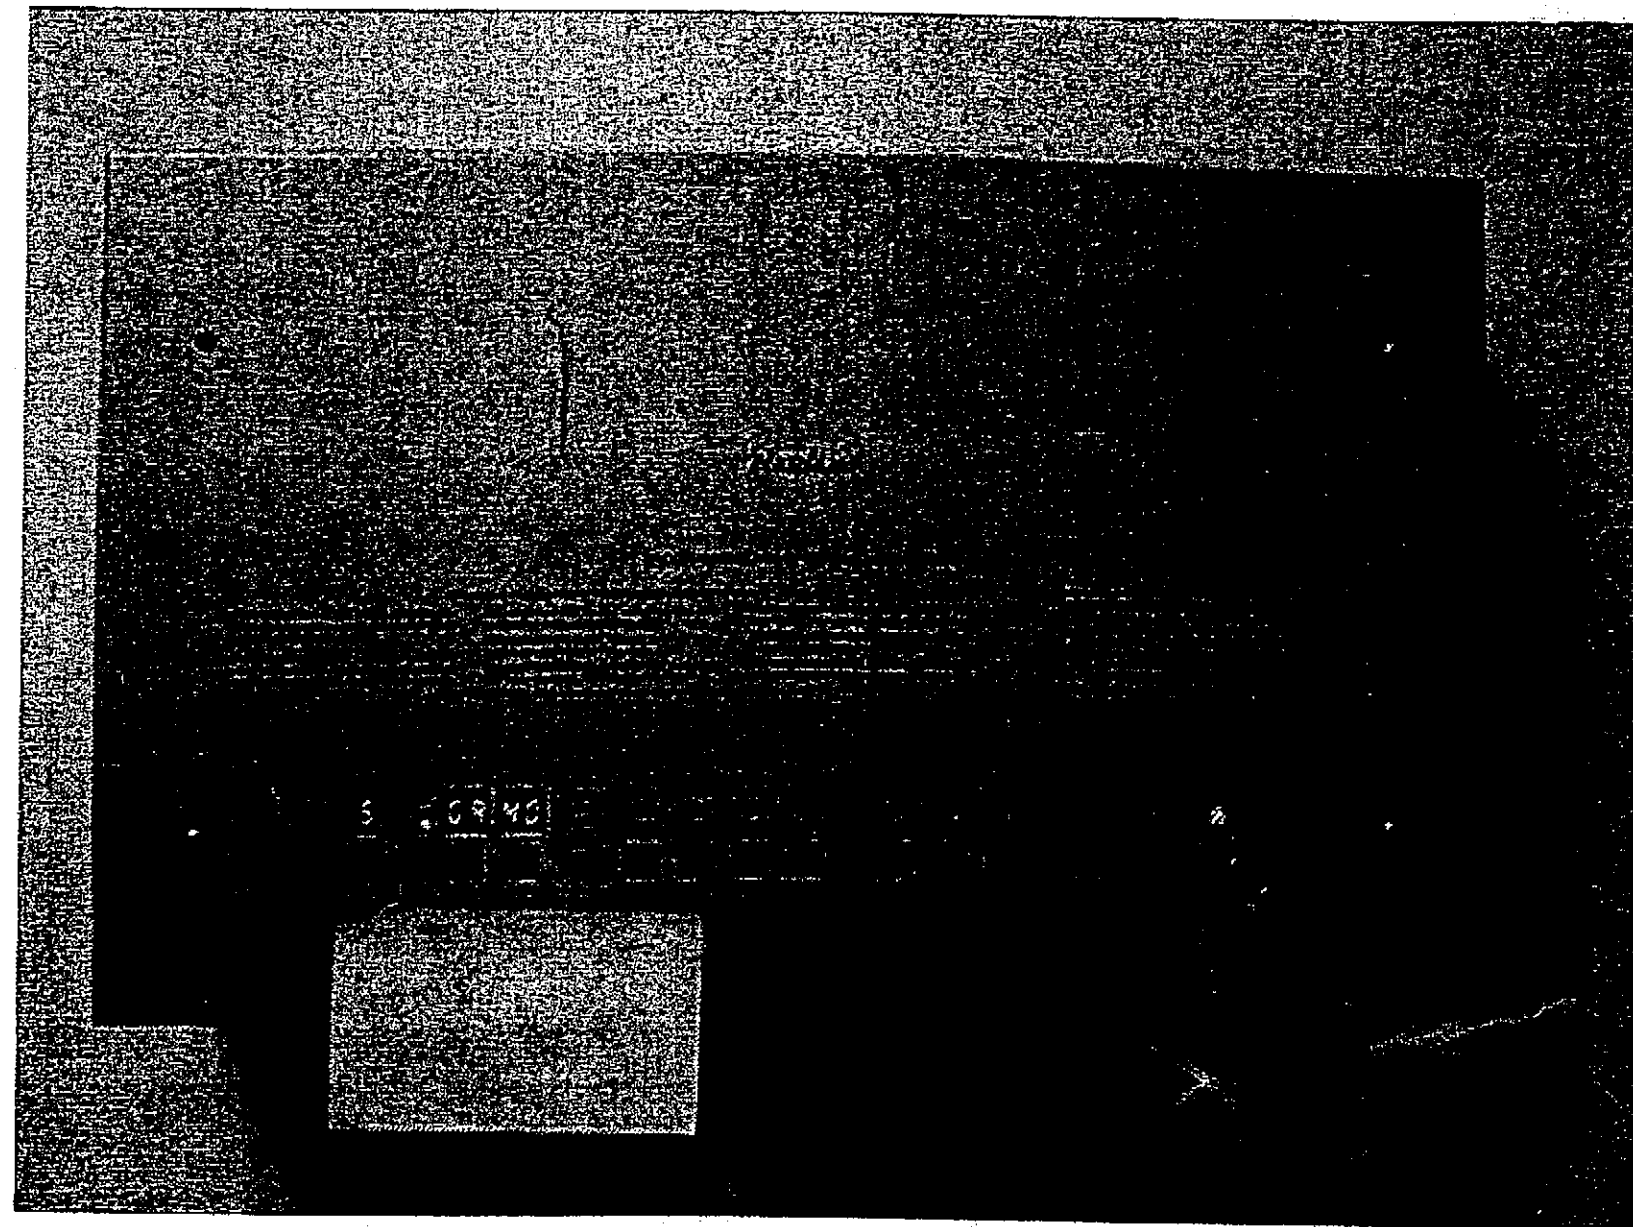

NOTE: CONNECT NEW CLOCKS TO EXISTING MASTER CLOCK UNIT.

MASTER CLOCK BUILDING A

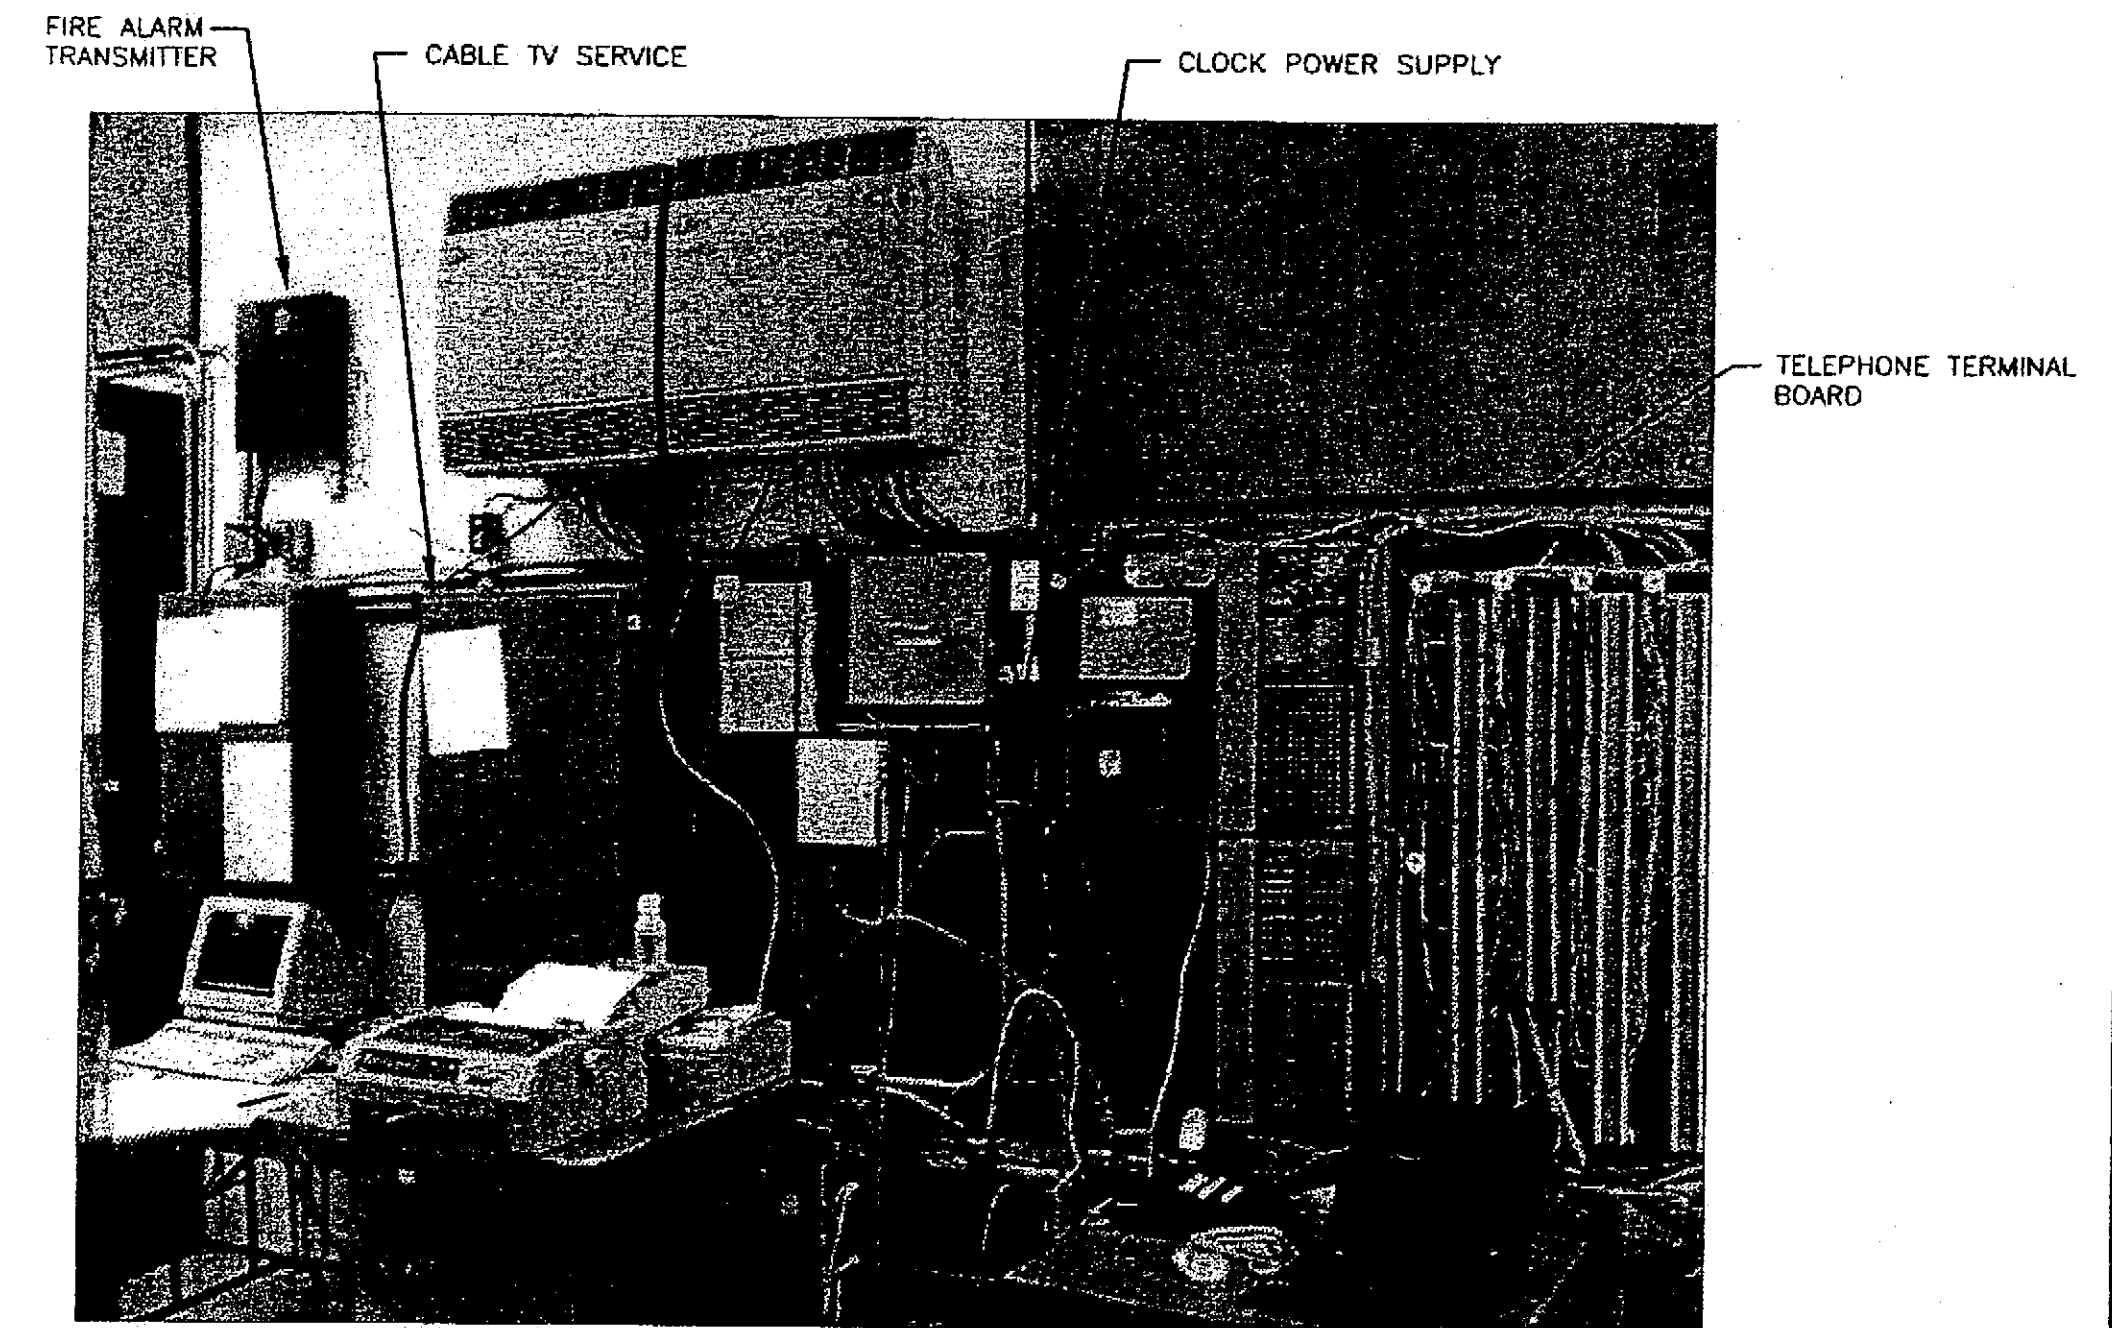


NOTE: REPLACE EXISTING FIRE ALARM TRANSMITTER. UTILIZE EXISTING CONDUIT TO FACP, RE-TERMINATE EXISTING TELEPHONE LINES.

ROUTE NEW TELEVISION CABLING TO EXISTING SERVICE ENTRANCE. COORDINATE WITH LOCAL SERVICE PROVIDER TO INTERIE NEW OUTLETS TO EXISTING SYSTEM. EXISTING SYSTEM CONFIGURATION IS NOT DOCUMENTED.

TERMINATE NEW TELEPHONE OUTLETS AT EXISTING TELEPHONE TERMINAL BOARD. COORDINATE WITH LOCAL SERVICE PROVIDER.


TERMINATE NEW CLOCK CORRECTION CIRCUIT AT EXISTING CLOCK POWER SUPPLY. MAINTAIN CIRCUIT CONTINUITY TO EXISTING CLOCKS.

MECHANICAL 200 - EAST WALL BUILDING B

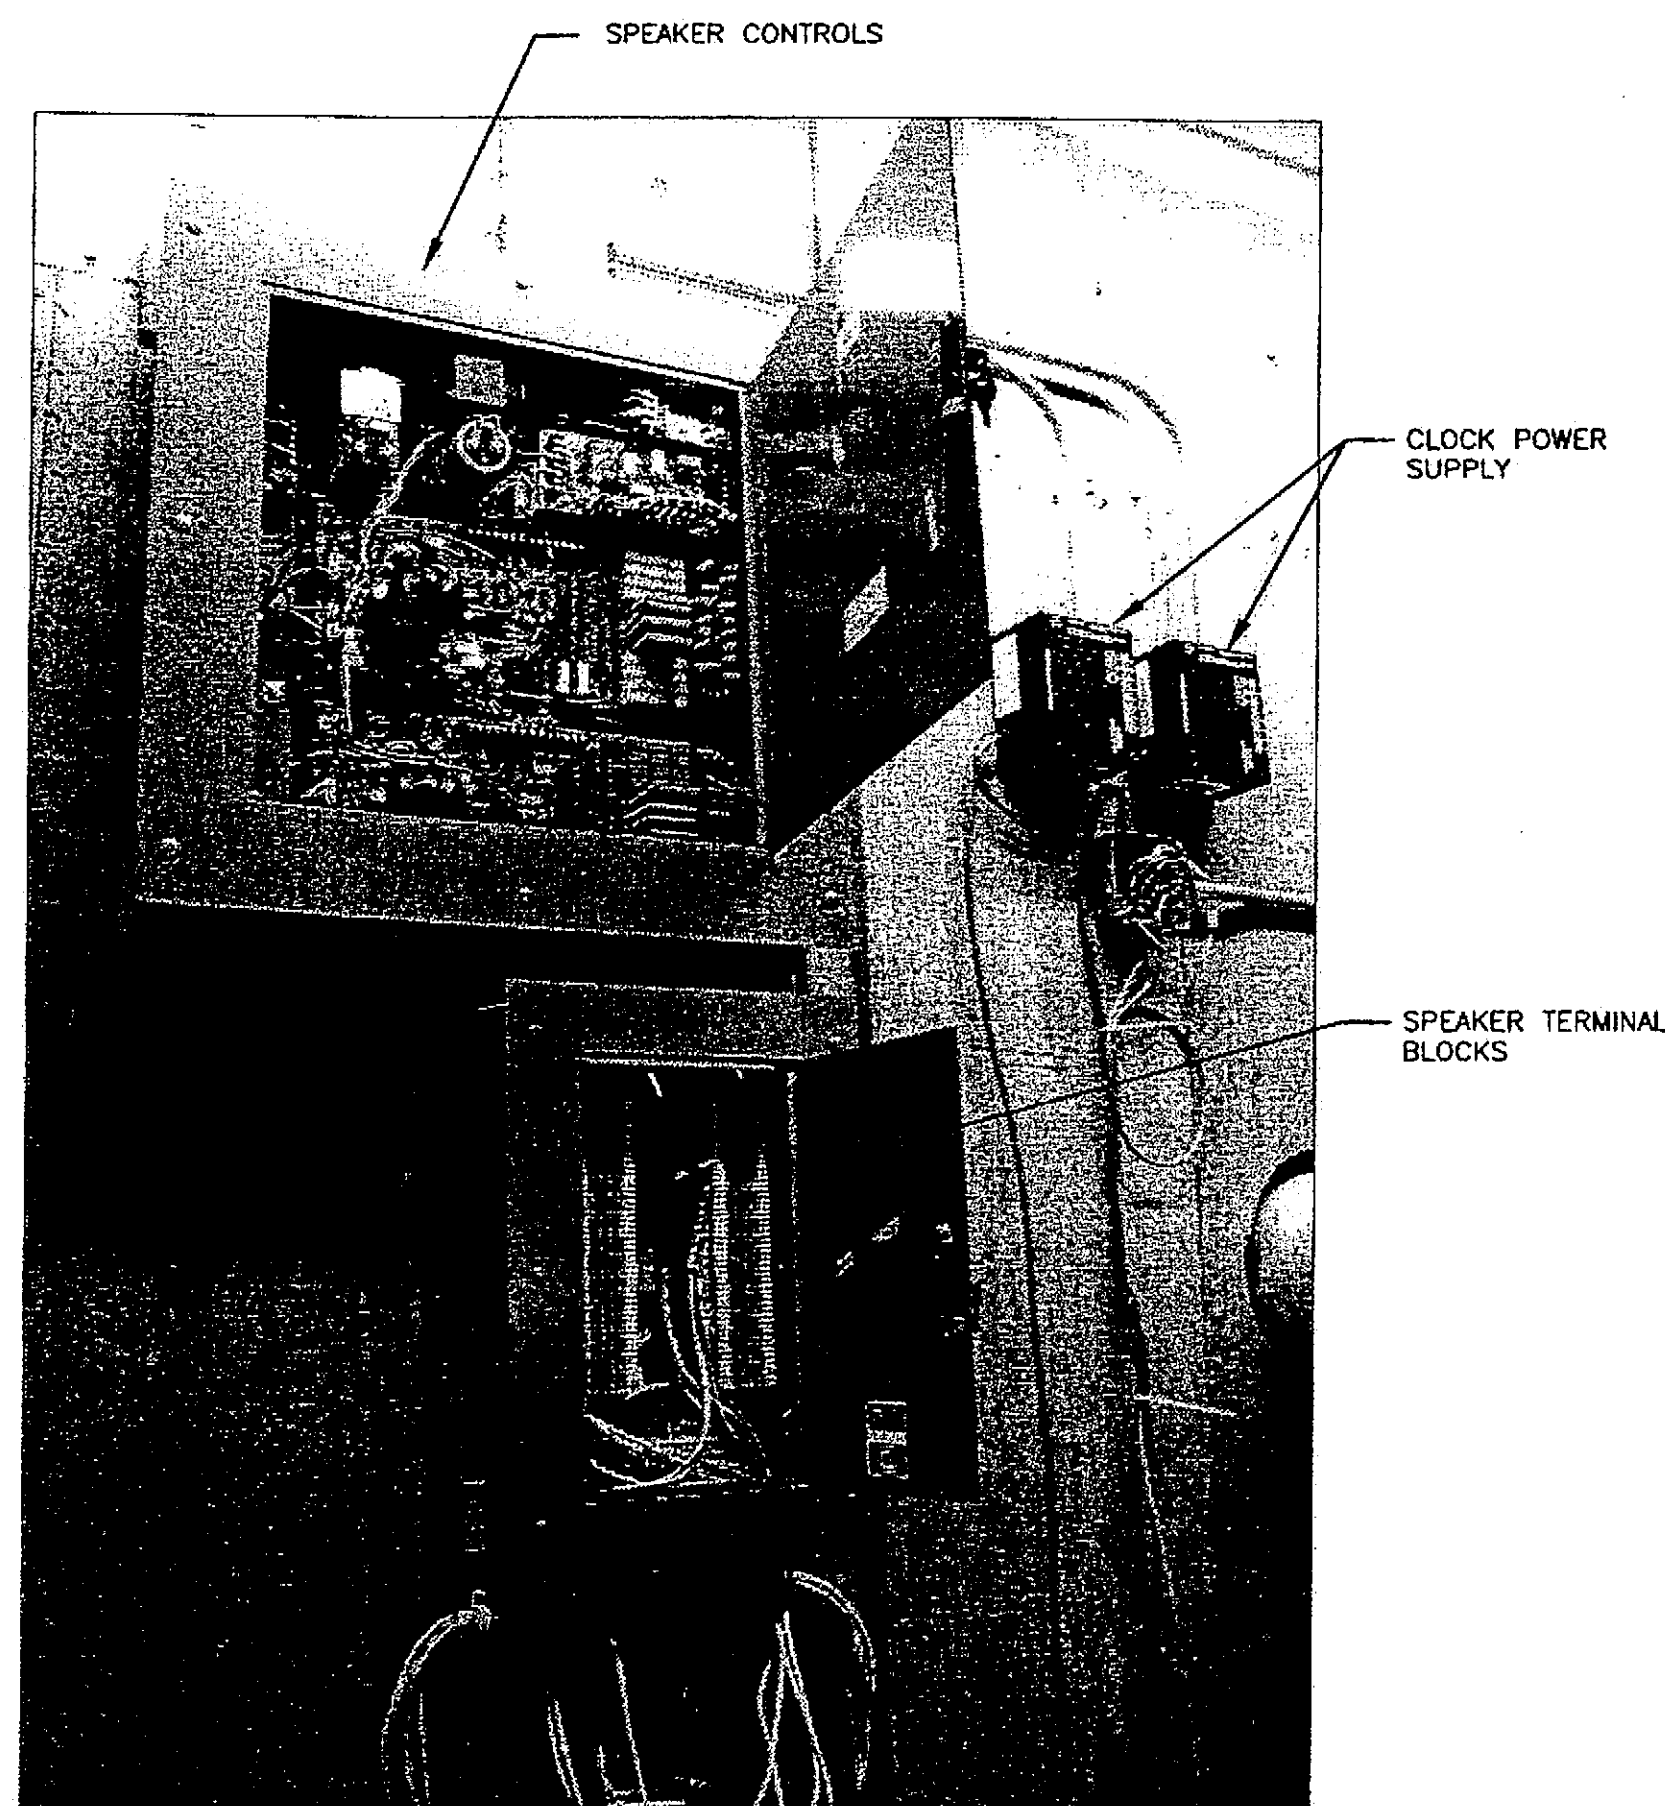


NOTE: TERMINATE NEW INTERCOM SPEAKERS AT EXISTING SPEAKER TERMINAL BLOCK. INTEGRATE NEW INTERCOM SPEAKERS WITH EXISTING CONTROLS.

INTERCOM/CLOCK EQUIPMENT BUILDING A

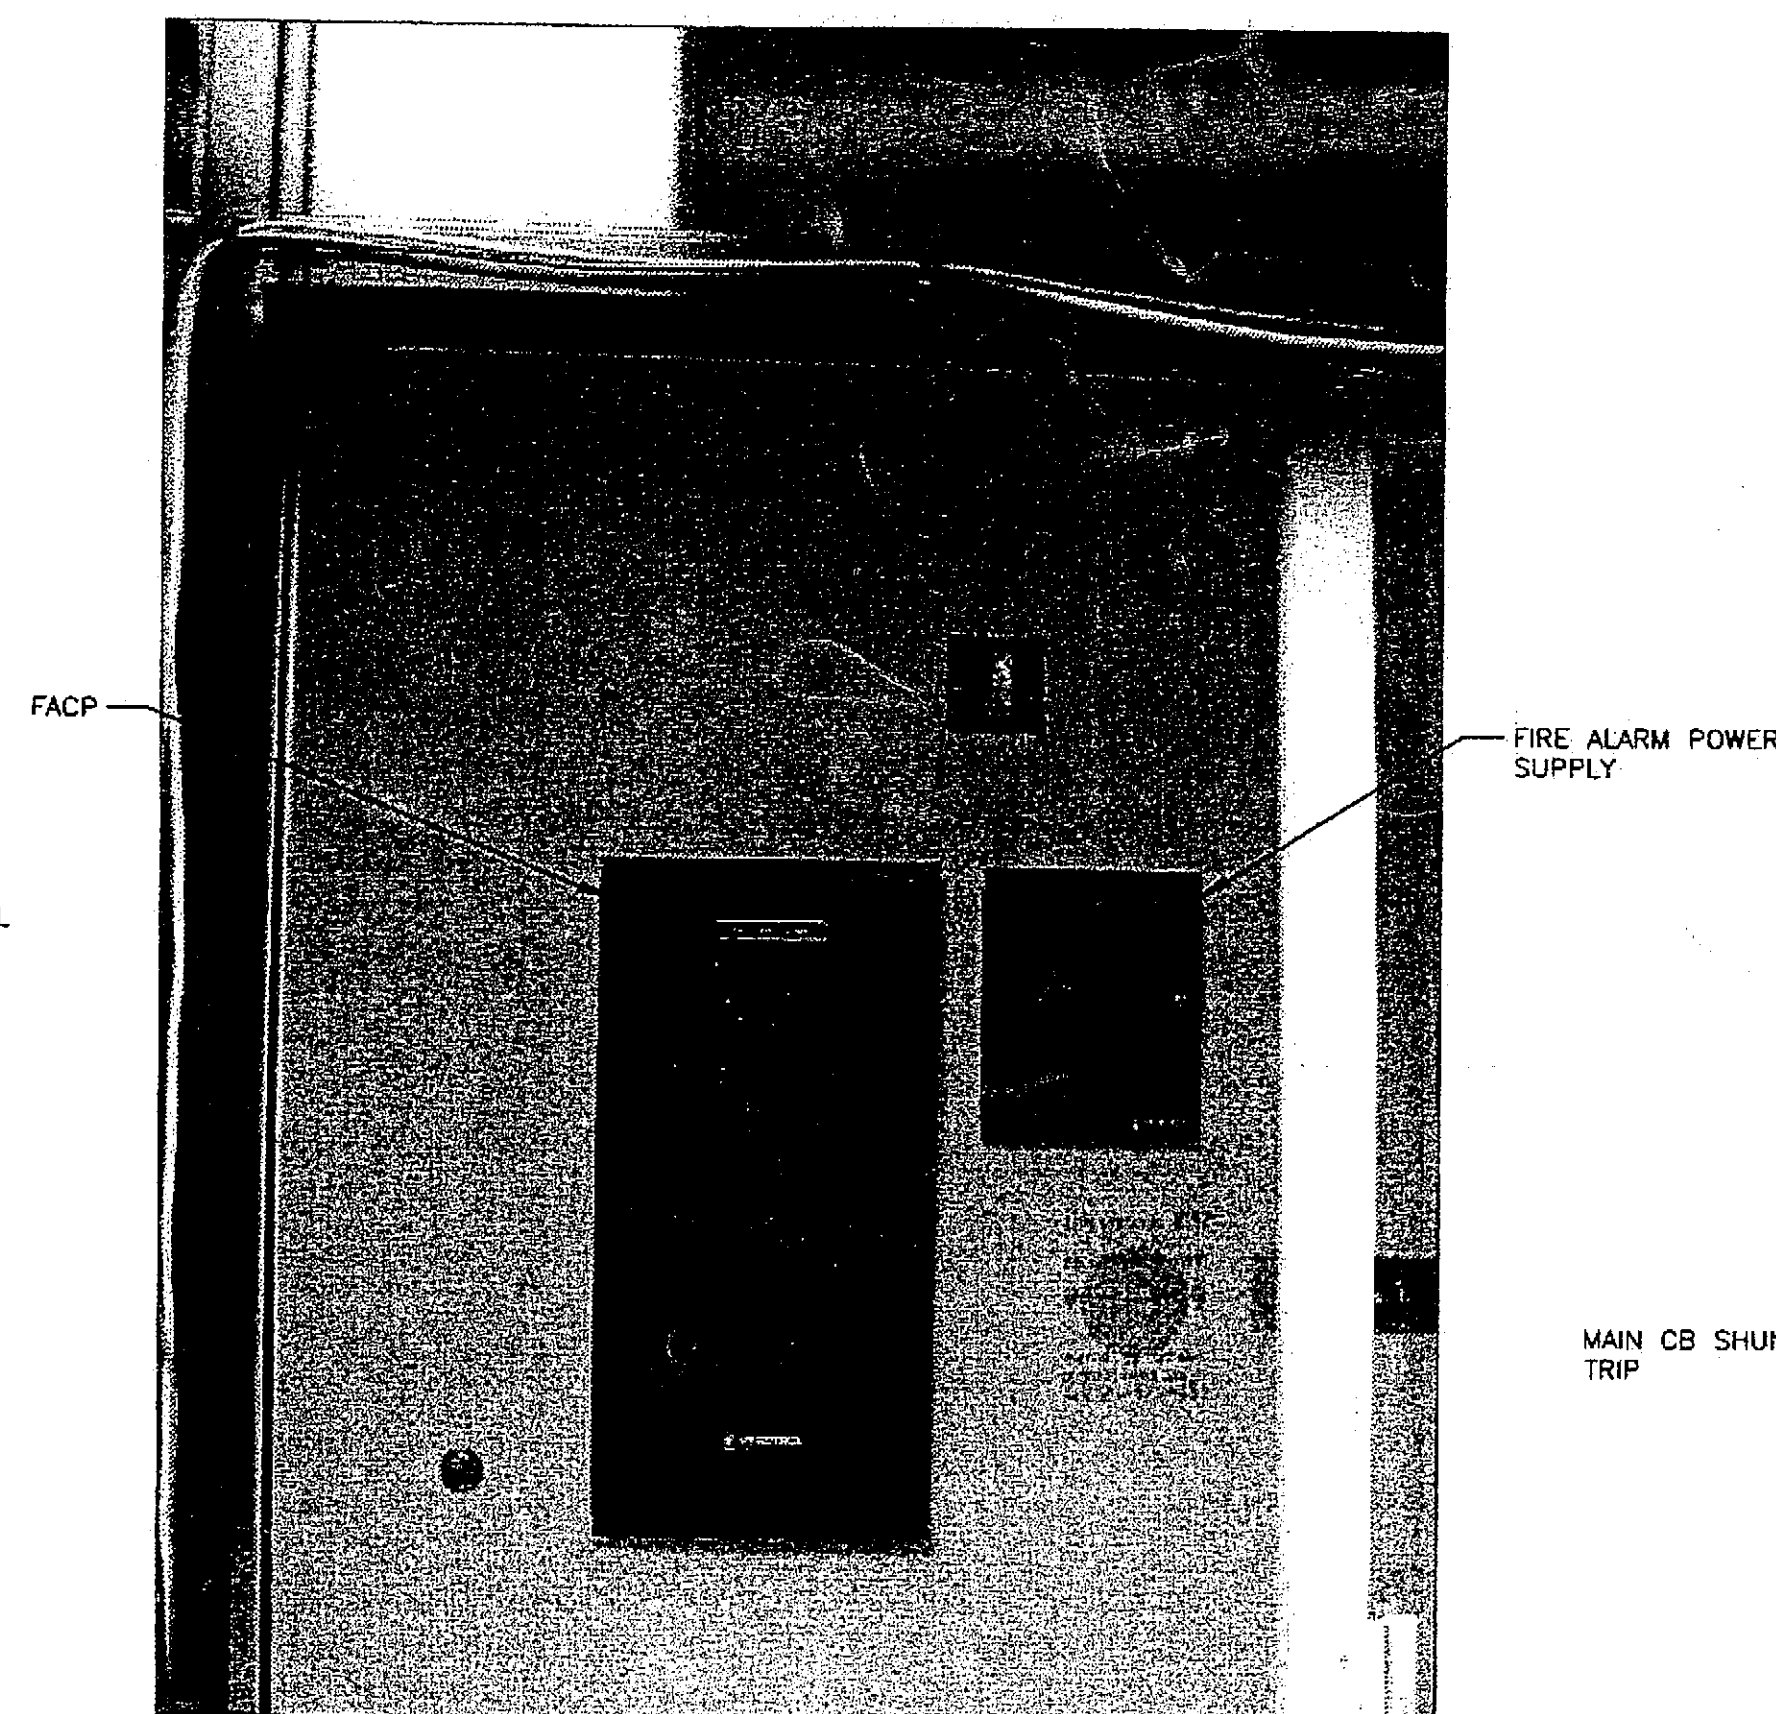

NOTE: REPLACE EXISTING FIRE ALARM CONTROL PANEL AND POWER SUPPLY.

FIRE ALARM EQUIPMENT BUILDING A

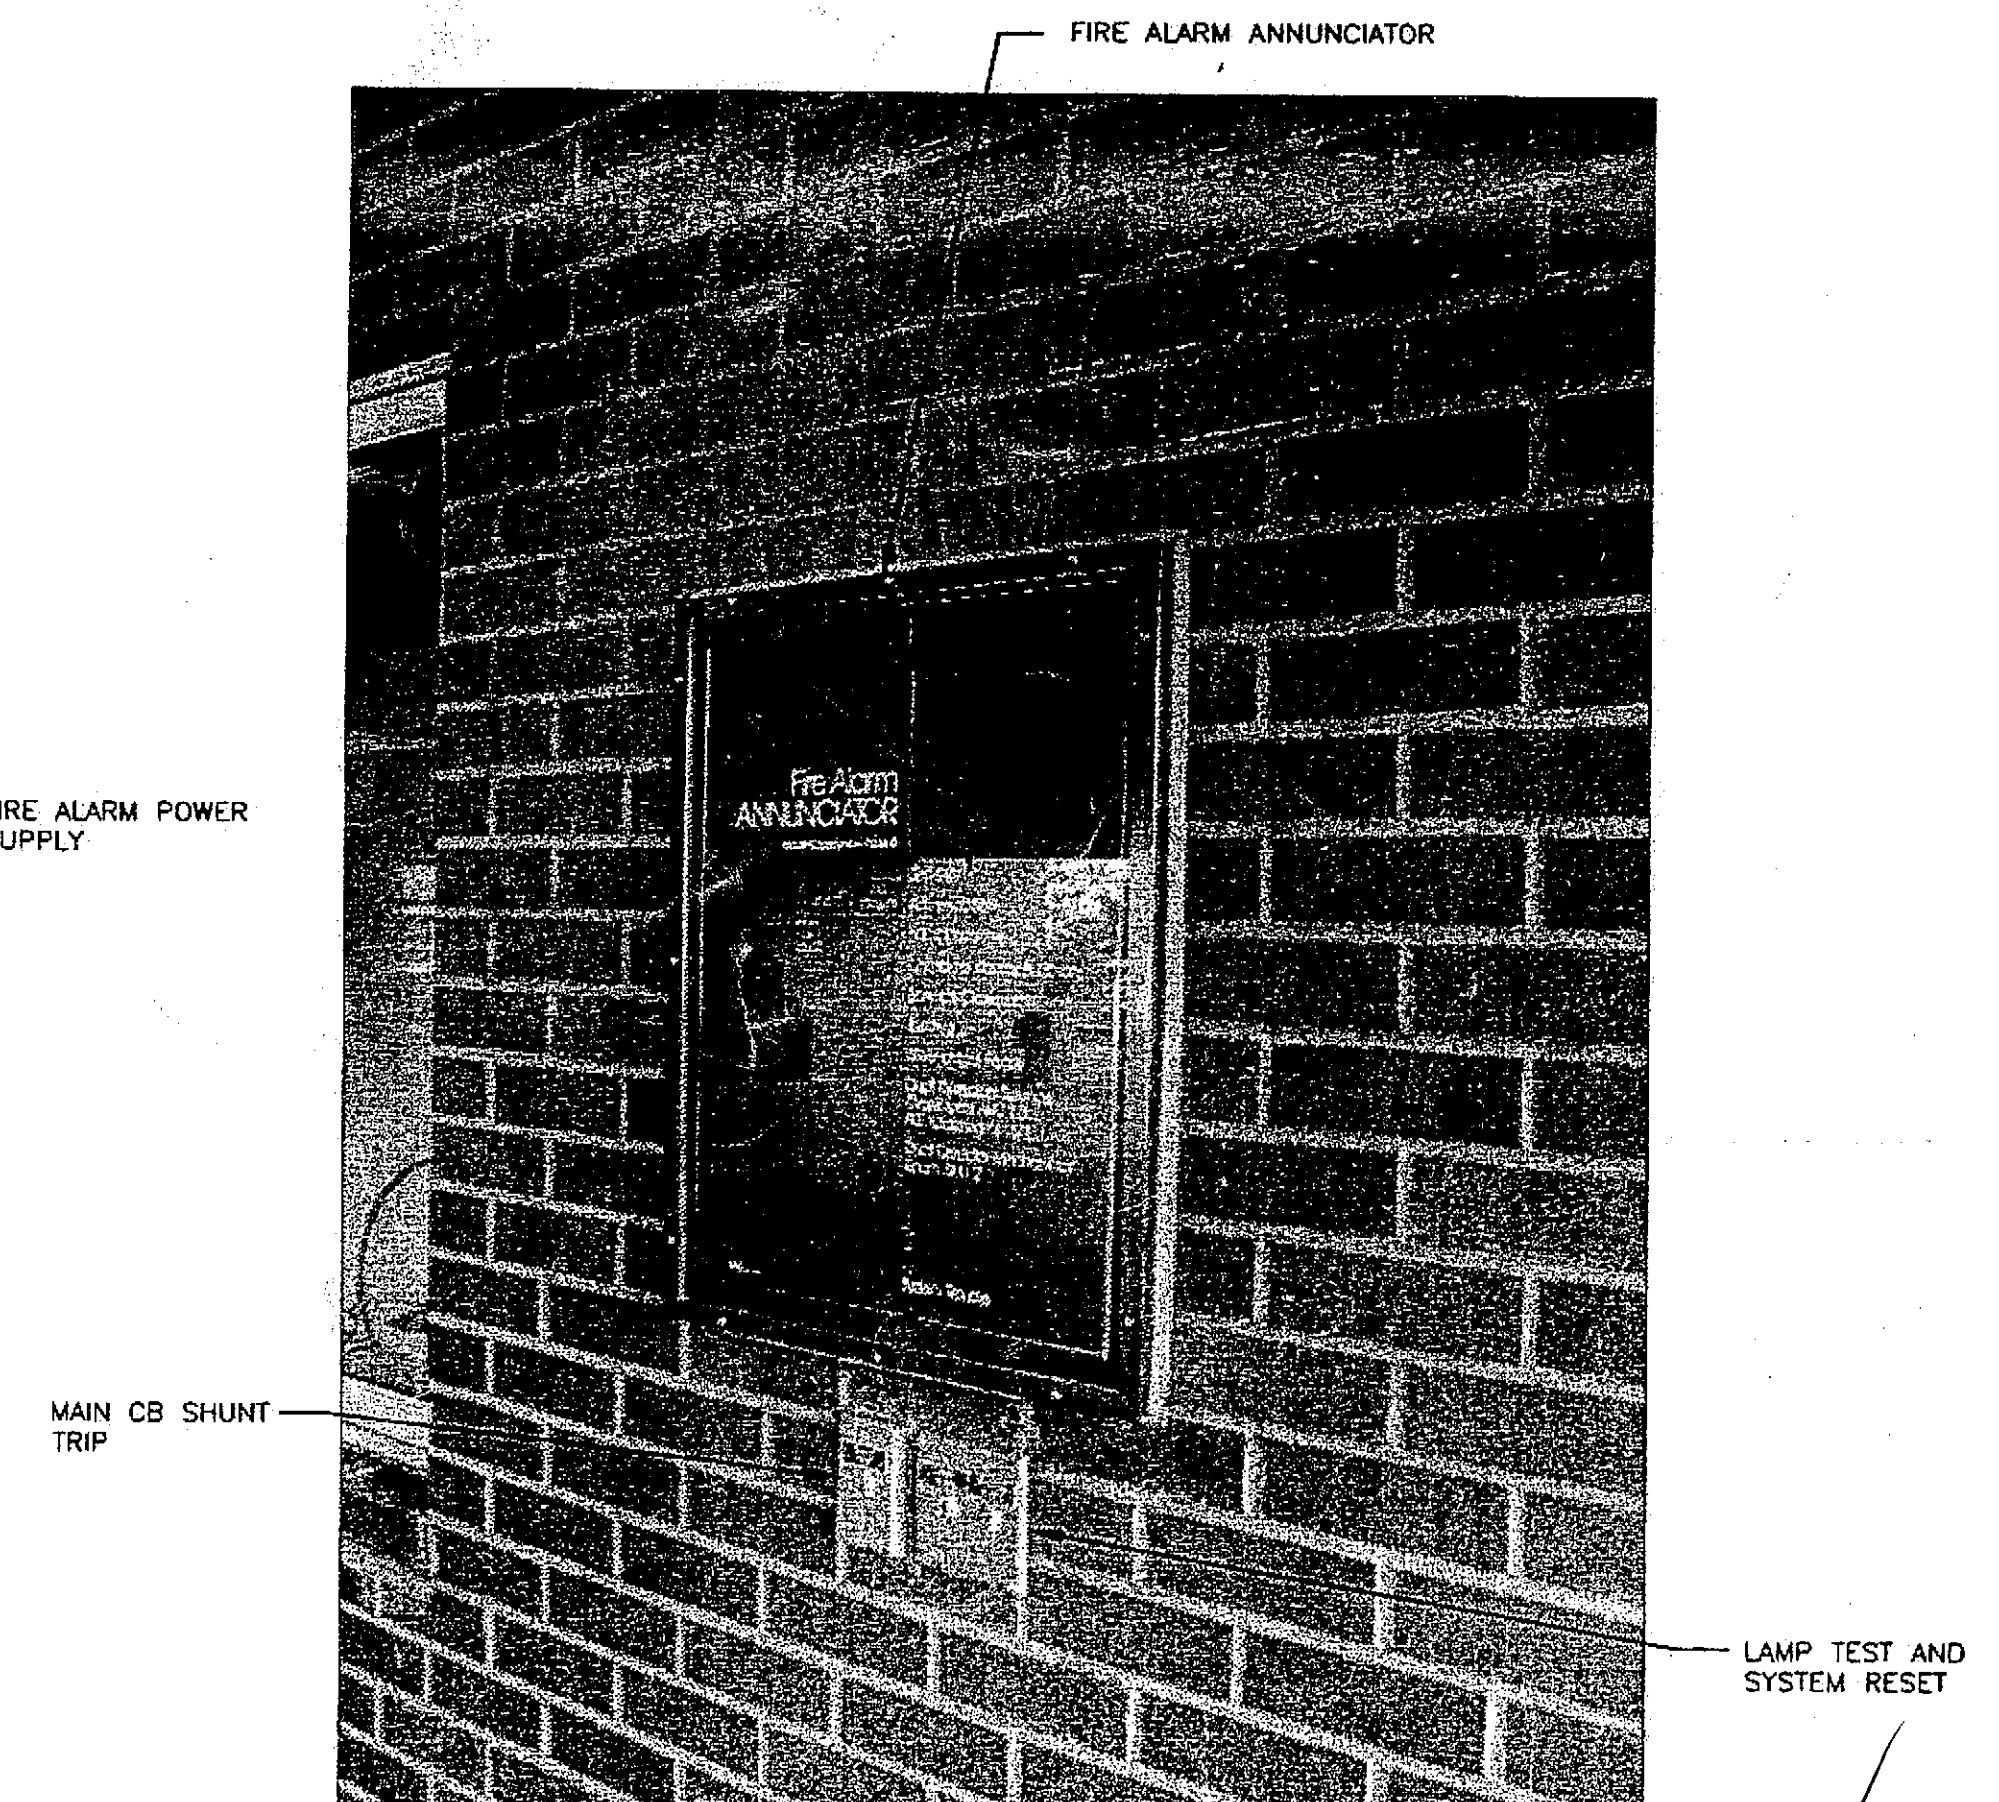

NOTE: REPLACE EXISTING FIRE ALARM ANNUNCIATOR AND MAIN CIRCUIT BREAKER SHUNT TRIP SWITCH. DEMOUSH LAMP TEST AND SYSTEM RESET SWITCHES.

FIRE ALARM ANNUNCIATOR BUILDING A

DATE: DECEMBER 13, 2004

ADDENDUM NUMBER

ATTACHMENT NUMBER

RECORD OF REVISIONS

No.	DATE	DESCRIPTION



13 DEC 2004

DESIGNED BY: BJB

DRAWN BY: PEL, RJB

STATE OF ALASKA
DEPARTMENT OF TRANSPORTATION
& PUBLIC FACILITIES
STATEWIDE DESIGN & ENGINEERING
SERVICES DIVISION

MT EDGECUMBE
HIGH SCHOOL
BUILDING 1330
ACADEMIC
EXPANSION

SHEET E100

PROJECT DESIGNATION NUMBER

67751C

STATE	YEAR
ALASKA	2004
SHEET NUMBER	TOTAL SHEETS
69	79

LEGEND

ABBREVIATIONS:

- AFF ABOVE FINISHED FLOOR
- AFG ABOVE FINISHED GRADE
- FAA FIRE ALARM ANNUNCIATOR
- FACP FIRE ALARM CONTROL PANEL
- GFI GROUND FAULT INTERRUPTED
- PE PHOTOELECTRIC
- TTB TELEPHONE TERMINAL BOARD
- UON UNLESS OTHERWISE NOTED
- WP WEATHERPROOF
- XFMR TRANSFORMER
- (E) EXISTING
- (N) NEW
- (R) REPLACE
- (X) RELOCATE
- (Y) REMOVE

SWITCHING:

- S SINGLE POLE SWITCH, 48" AFF
- S₀ SUBSCRIPT DENOTES LUMINAIRE SWITCHED, 48" AFF
- S₃ THREE WAY SWITCH, 48" AFF
- S_M MANUAL STARTER
- SW SWITCH, THERMAL TRIP, w/ O.L. HTR TO SUIT MOTOR PROTECTED
- NS NON SWITCHED
- PE PHOTOELECTRIC CELL

LIGHTING:

- FLUORESCENT LUMINAIRE, EQUIP w/ SINGLE EMERGENCY BALLAST WHERE SHOWN, BODINE B50 F-48 OR APPROVED EQUAL
- FLUORESCENT LUMINAIRE
- RECESSED DOWNLIGHT LUMINAIRE
- WALL MOUNTED EXIT LUMINAIRE
- EXTERIOR SOFFIT MOUNTED LUMINAIRE
- EXTERIOR WALL MOUNTED LUMINAIRE

POWER:


- DUPLEX RECEPTACLE, 18" AFF UON.
- DOUBLE DUPLEX RECEPTACLE, 18" AFF
- RECEPTACLE RACEWAY
- SPECIAL RECEPTACLE, 18" AFF UON.
- 220V SINGLE PHASE RECEPTACLE, 18" AFF
- FLOOR RECEPTACLE

- JUNCTION BOX
- PANELBOARD
- SIGNAL CABINET
- MOTOR CONNECTION
- MOTOR STARTER
- COMBINATION STARTER/DISCONNECT
- DISCONNECT
- SIGNAL:
- SMOKE DETECTOR
- HEAT DETECTOR
- DUCT DETECTOR
- MANUAL PULL STATION, 48" AFF
- FIRE ALARM HORN/STROBE, 80" AFF TO BASE
- FIRE ALARM STROBE ONLY, 80" AFF TO BASE
- END-OF-LINE DEVICE
- FIRE ALARM BELL, 90" AFF
- SPRINKLER TAMPER SWITCH
- SPRINKLER PRESSURE SWITCH
- SPRINKLER FLOW SWITCH
- PROGRAM BELL, 90" AFF
- TELEPHONE, 18" AFF UON.
- DATA, 18" AFF UON.
- DATA/TELEPHONE, 18" AFF UON.
- TELEVISION, 18" AFF UON.
- INTERCOM CALL STATION, 48" AFF
- CLOCK RECEPTACLE, 90" AFF
- WALL SPEAKER, 90" AFF
- CEILING SPEAKER
- MAGNETIC DOOR HOLDER

GENERAL:


- HOME RUN
- CONDUIT: 1/2" UON.
- UNGROUND CONDUCTORS
- NEUTRAL: #10 WITH DOT #12 OTHERWISE
- GROUND CONDUCTOR
- CONDUCTORS NOT SHOWN WHERE ONLY #12 NEUTRAL AND UNGROUND CONDUCTOR ARE REQUIRED
- CONDUIT IN FLOOR
- FLEXIBLE CONDUIT

NOTE: ALL DEVICE HEIGHTS TO CENTER, UON.

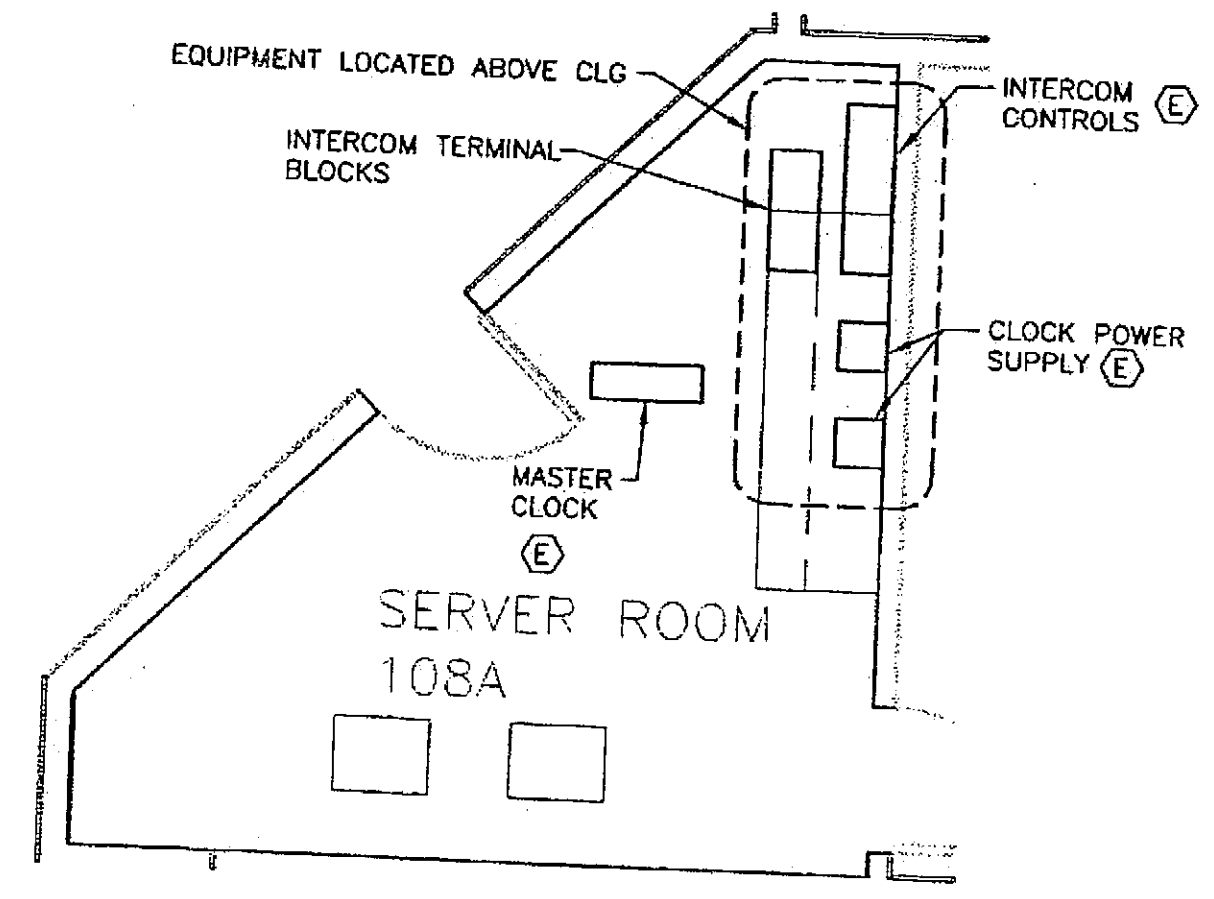

2 RM 108A ENLARGED PLAN

SCALE: 0 4' 8' 16'

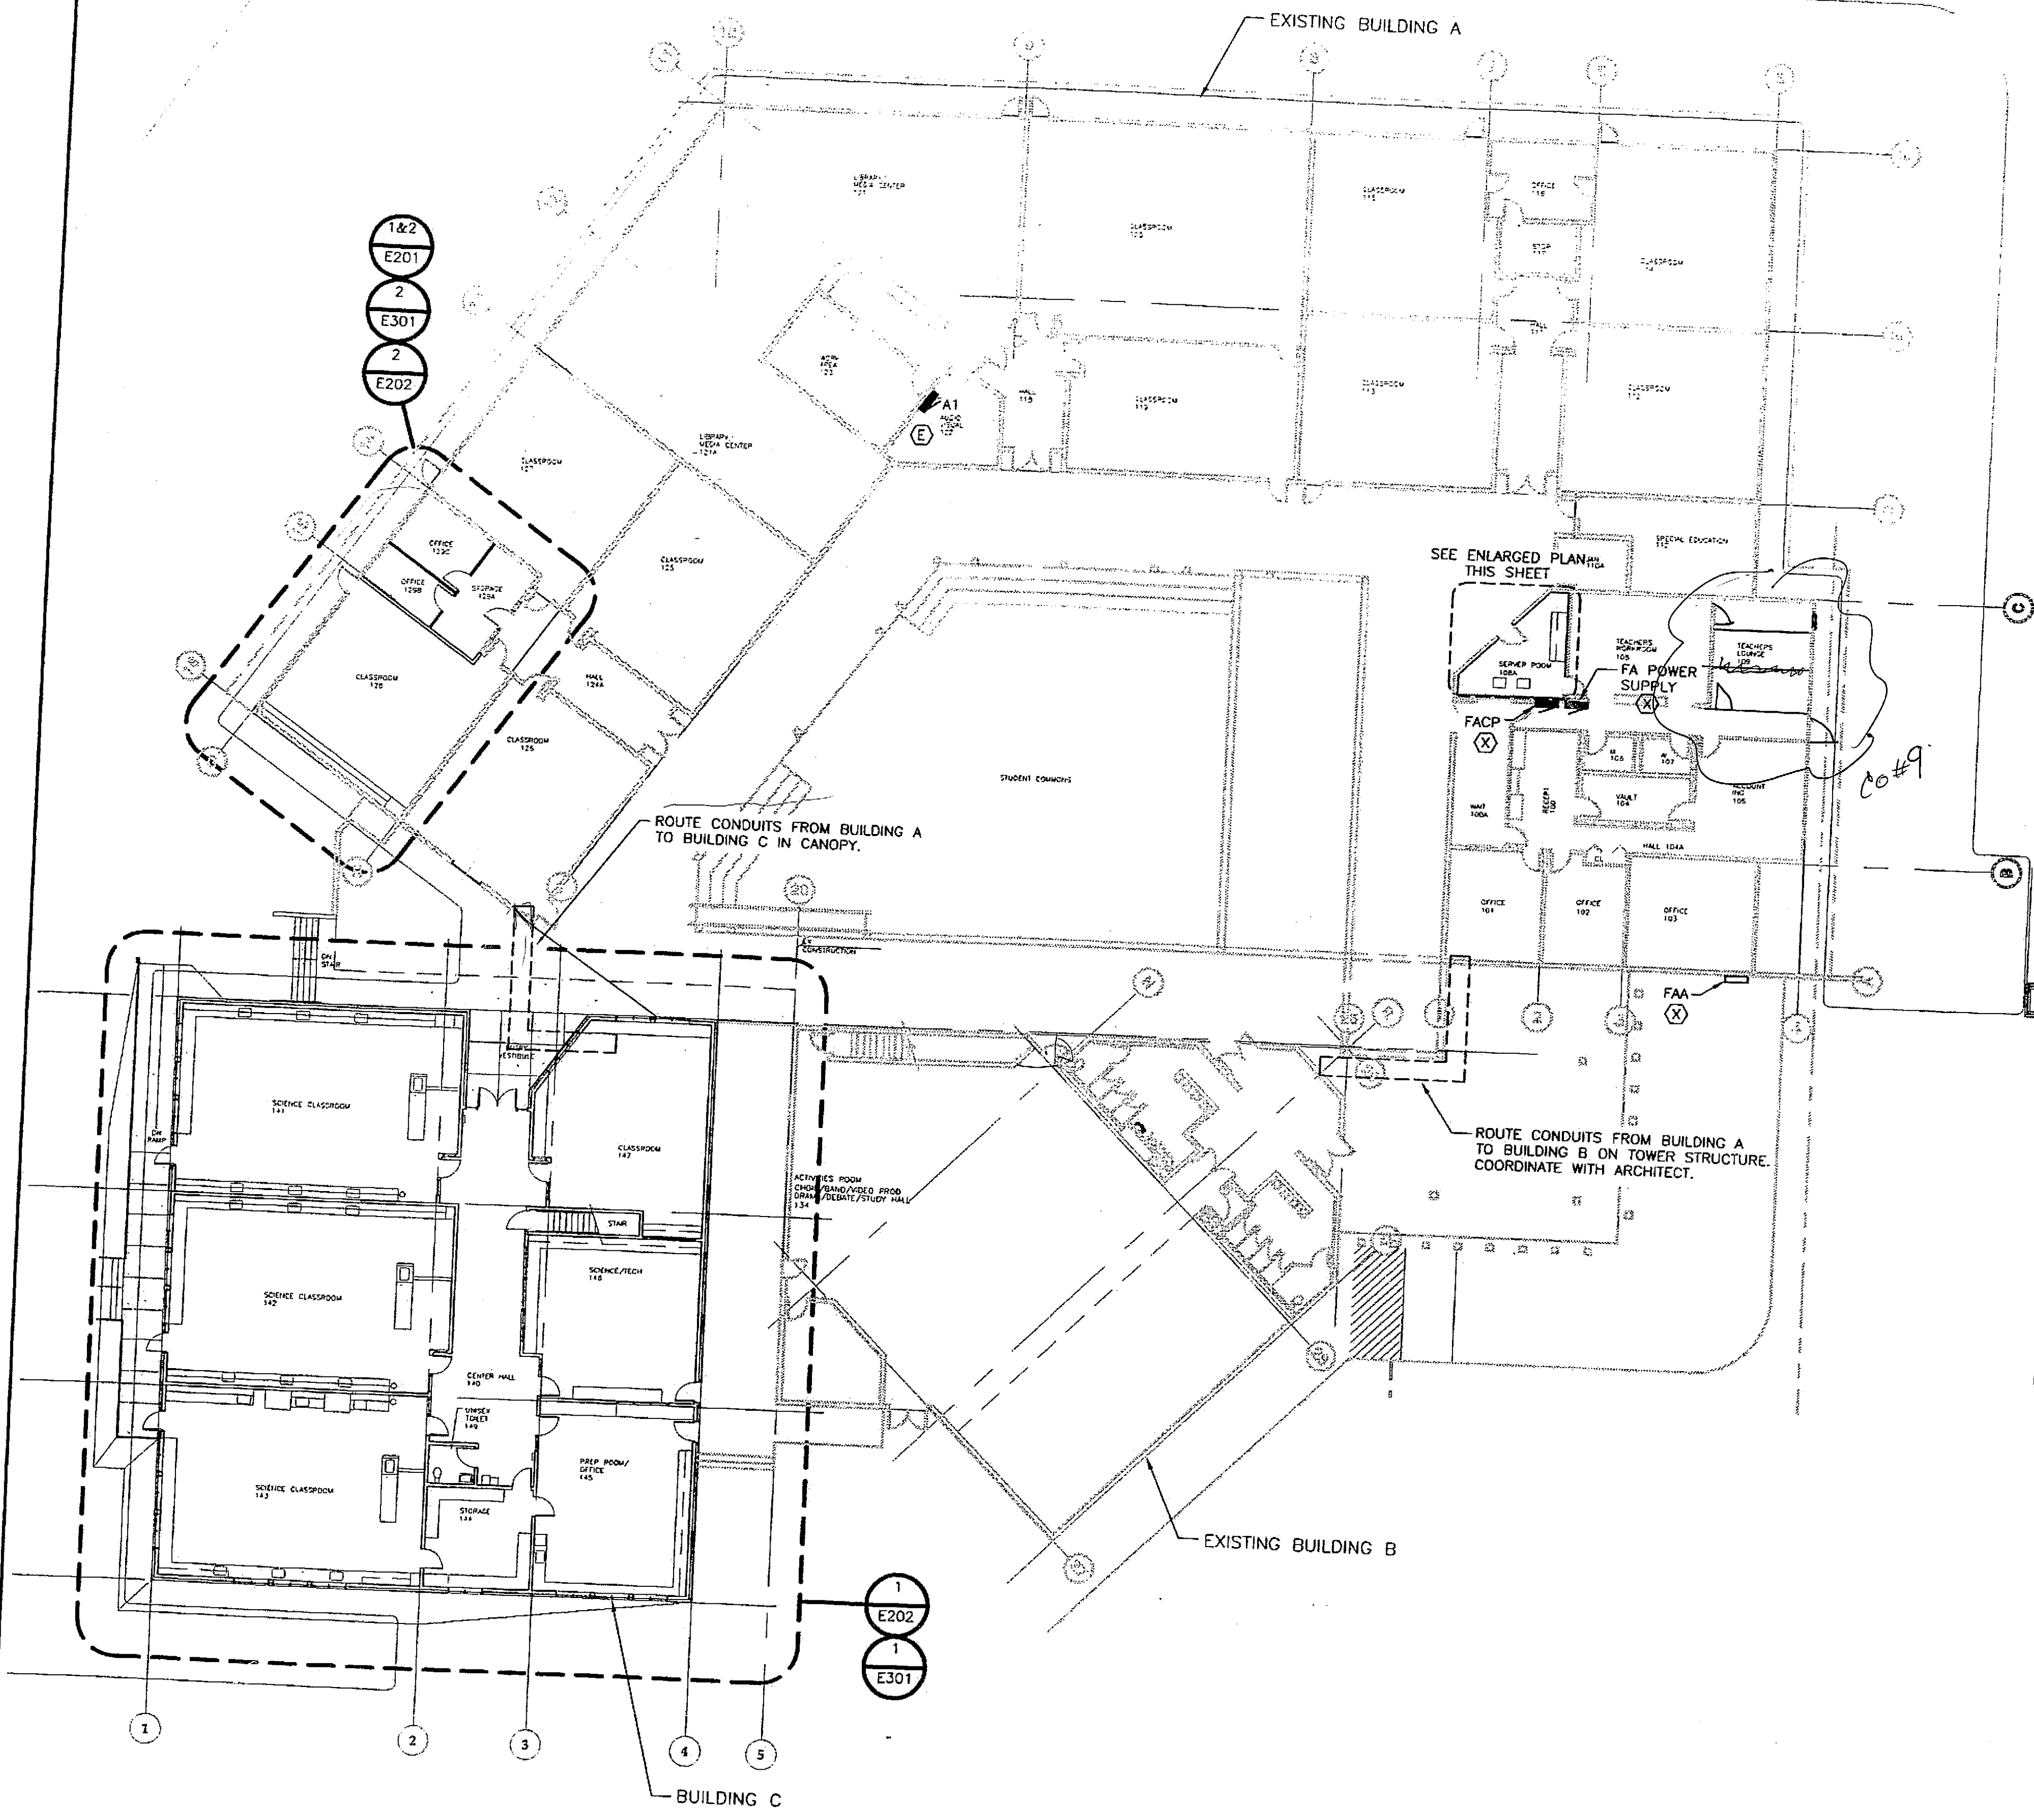

1 FLOOR PLAN

SCALE: 0 8' 16' 32'


DATE: DECEMBER 13, 2004

ADDENDUM NUMBER

ATTACHMENT NUMBER

RECORD OF REVISIONS

No.	DATE	DESCRIPTION

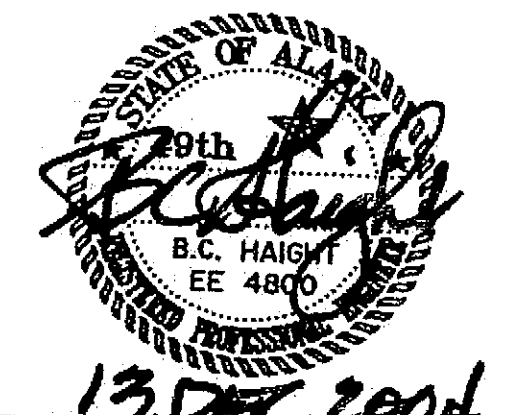

DESIGNED BY: BJB

DRAWN BY: PEL, RJB

STATE OF ALASKA
DEPARTMENT OF TRANSPORTATION & PUBLIC FACILITIES
STATEWIDE DESIGN & ENGINEERING SERVICES DIVISION

MT EDGE CUMBE
HIGH SCHOOL
BUILDING 1330
ACADEMIC EXPANSION

SHEET E200

PROJECT DESIGNATION NUMBER

67751C

STATE YEAR

ALASKA 2004

SHEET NUMBER TOTAL SHEETS

70

79


DATE: DECEMBER 13, 2004

ADDENDUM NUMBER

ATTACHMENT NUMBER


RECORD OF REVISIONS

No.	DATE	DESCRIPTION

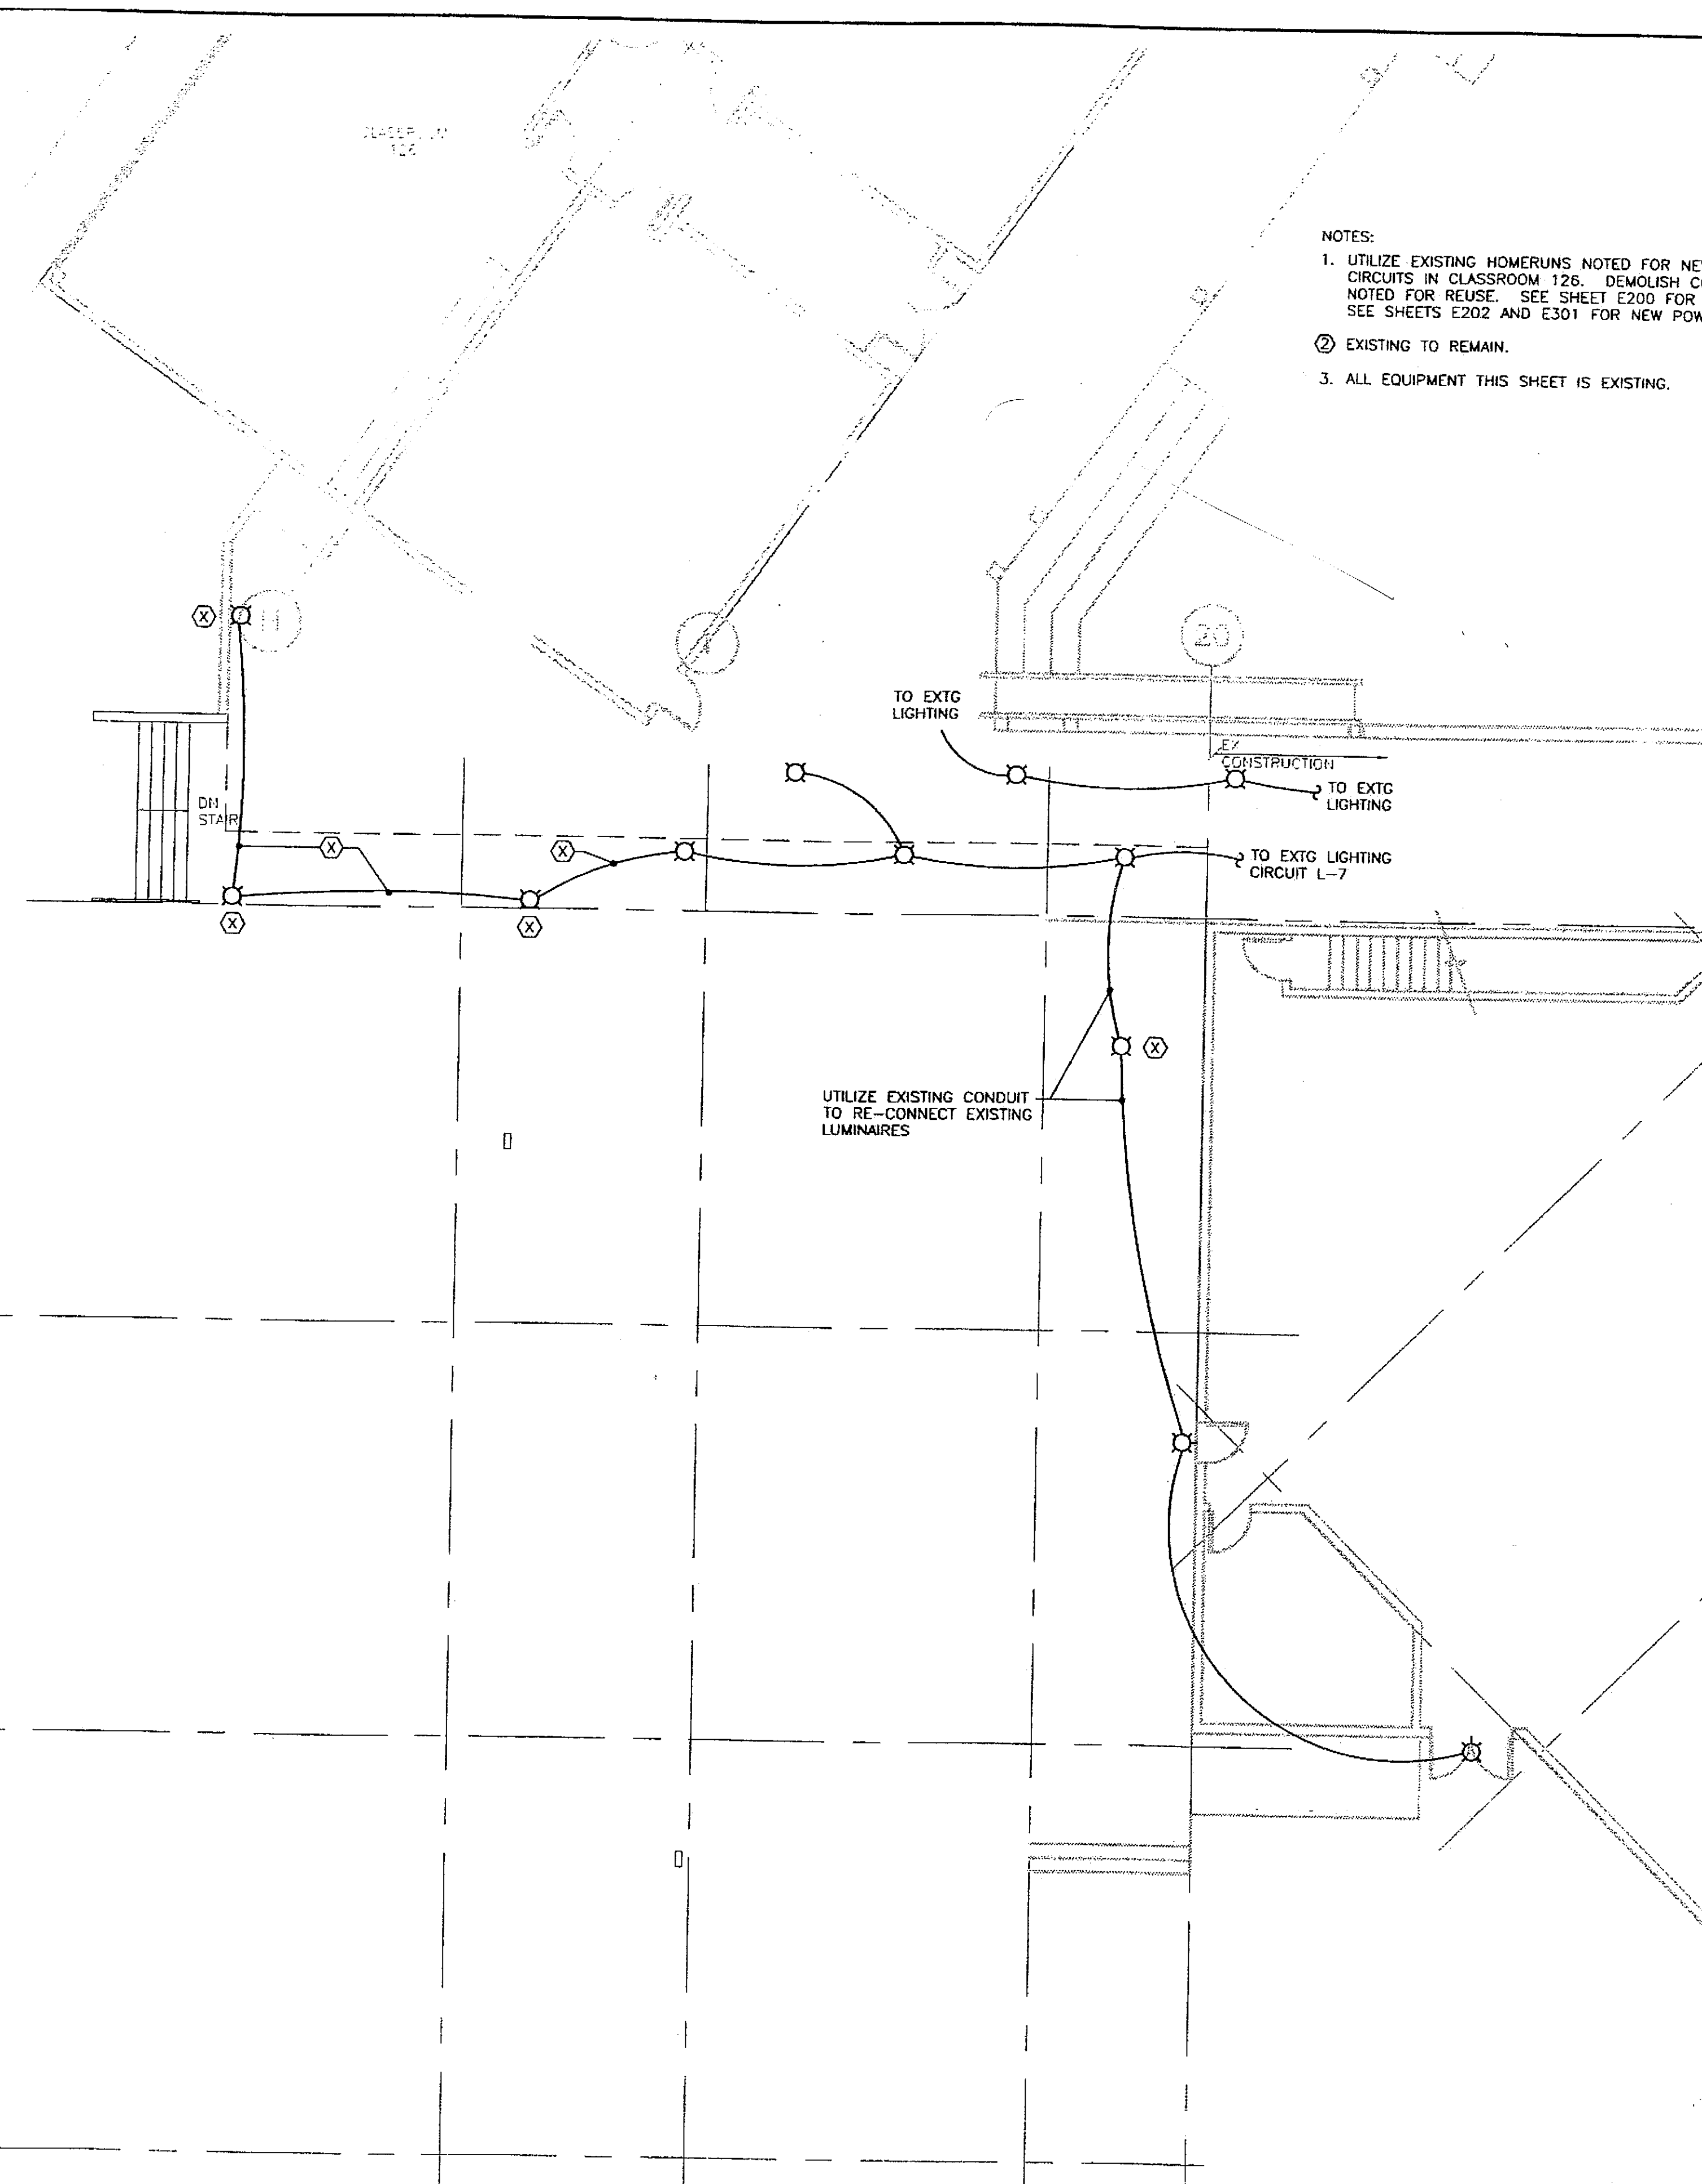


3 EXTERIOR LIGHTING DEMOLITION PLAN
BUILDINGS A & B

SCALE: 0 4' 8' 16'


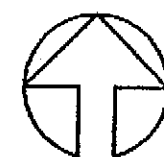


- NOTES:
1. UTILIZE EXISTING HOMERUNS NOTED FOR NEW POWER AND LIGHTING CIRCUITS IN CLASSROOM 126. DEMOLISH CONDUIT AND WIRING NOT NOTED FOR REUSE. SEE SHEET E200 FOR PANELBOARD LOCATIONS. SEE SHEETS E202 AND E301 FOR NEW POWER AND LIGHTING PLANS.
 2. EXISTING TO REMAIN.
 3. ALL EQUIPMENT THIS SHEET IS EXISTING.

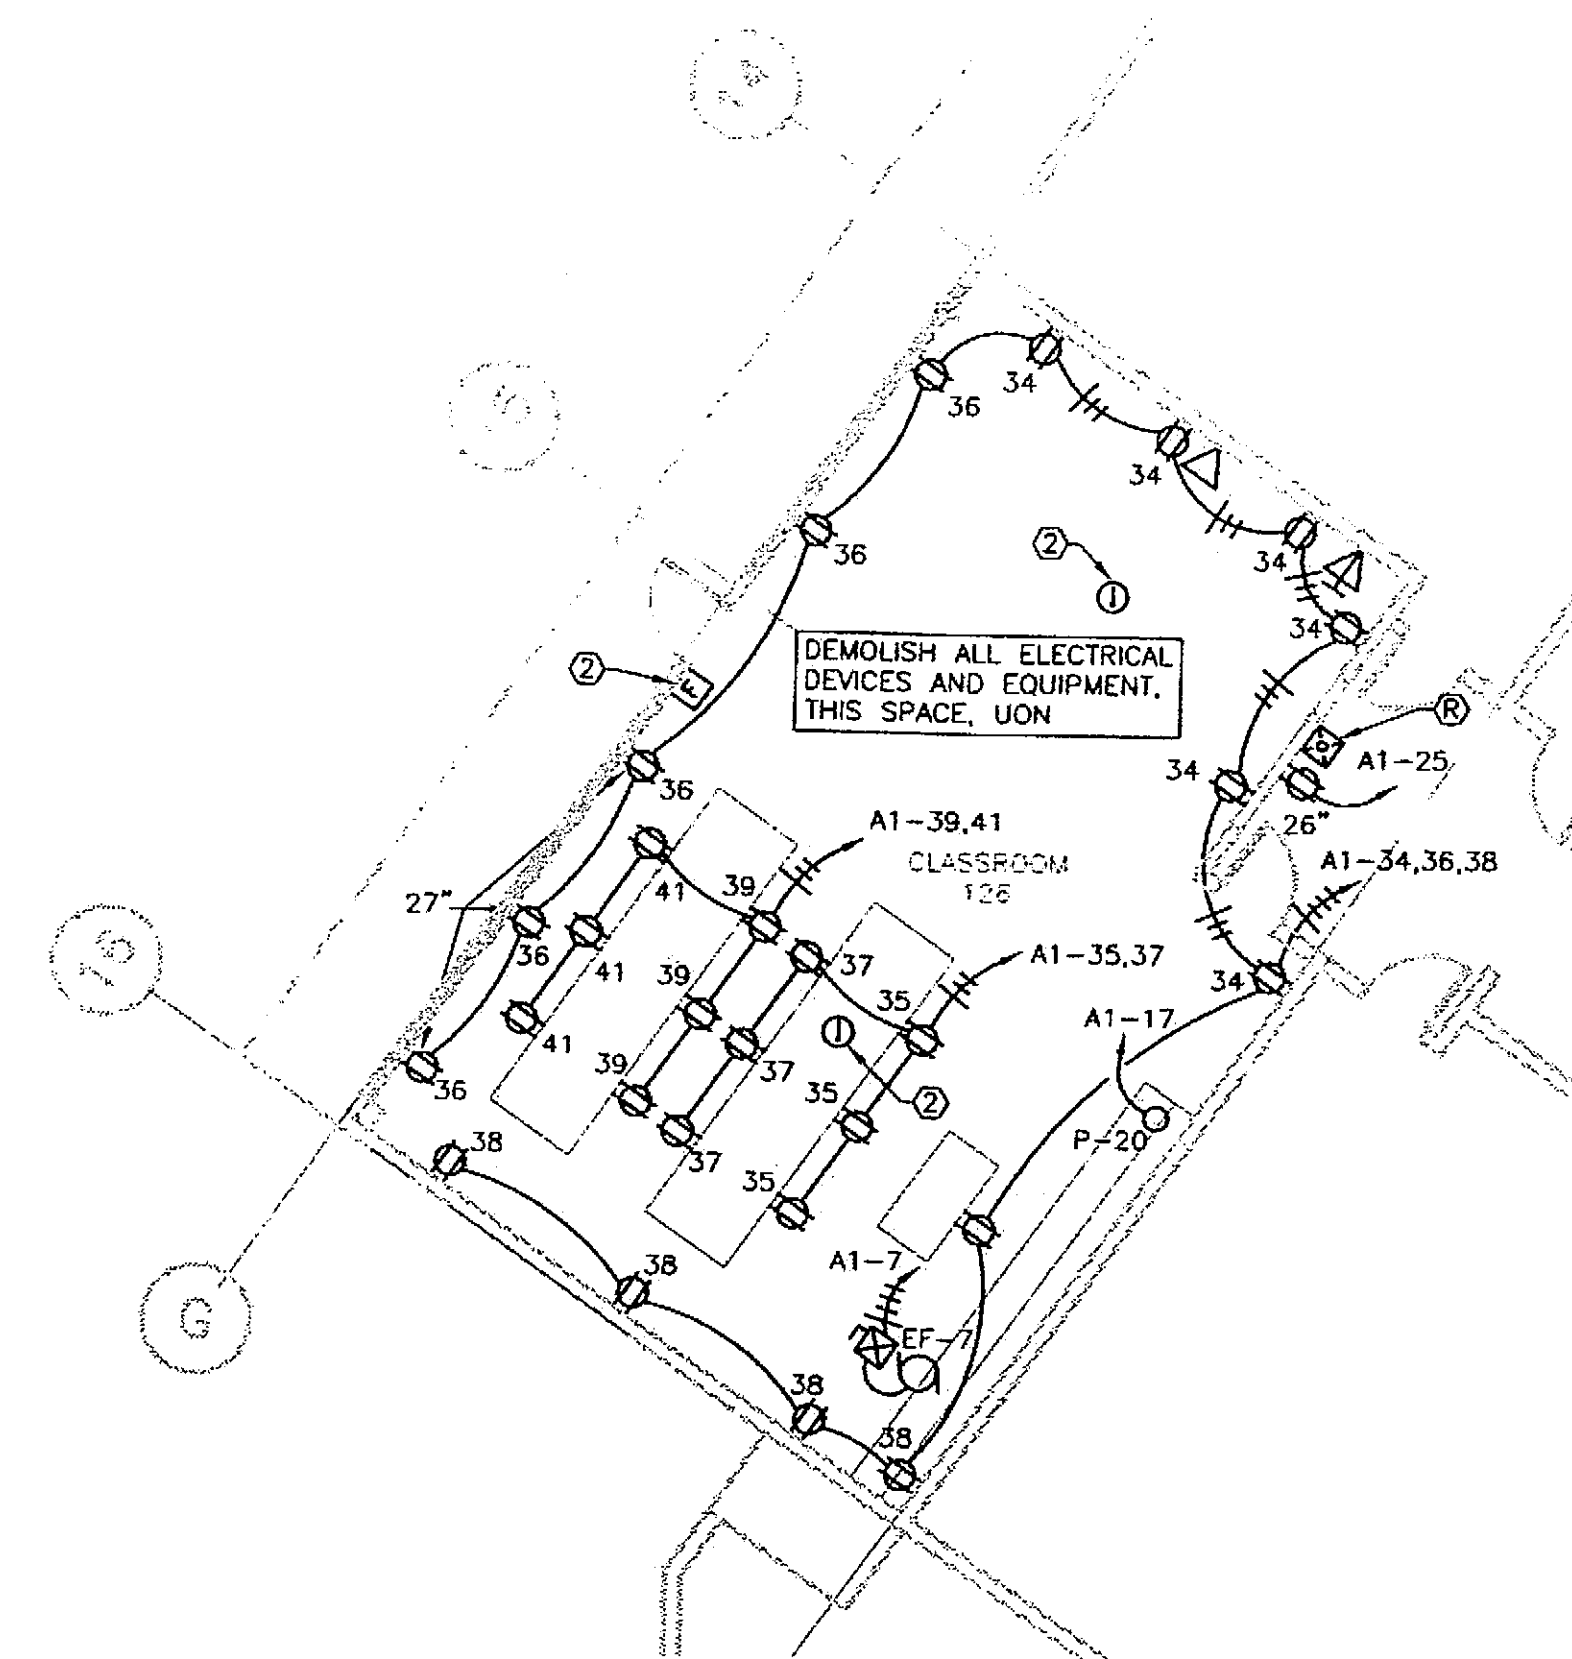


1 PARTIAL POWER/SIGNAL DEMOLITION PLAN
BUILDING A

SCALE: 0 4' 8' 16'

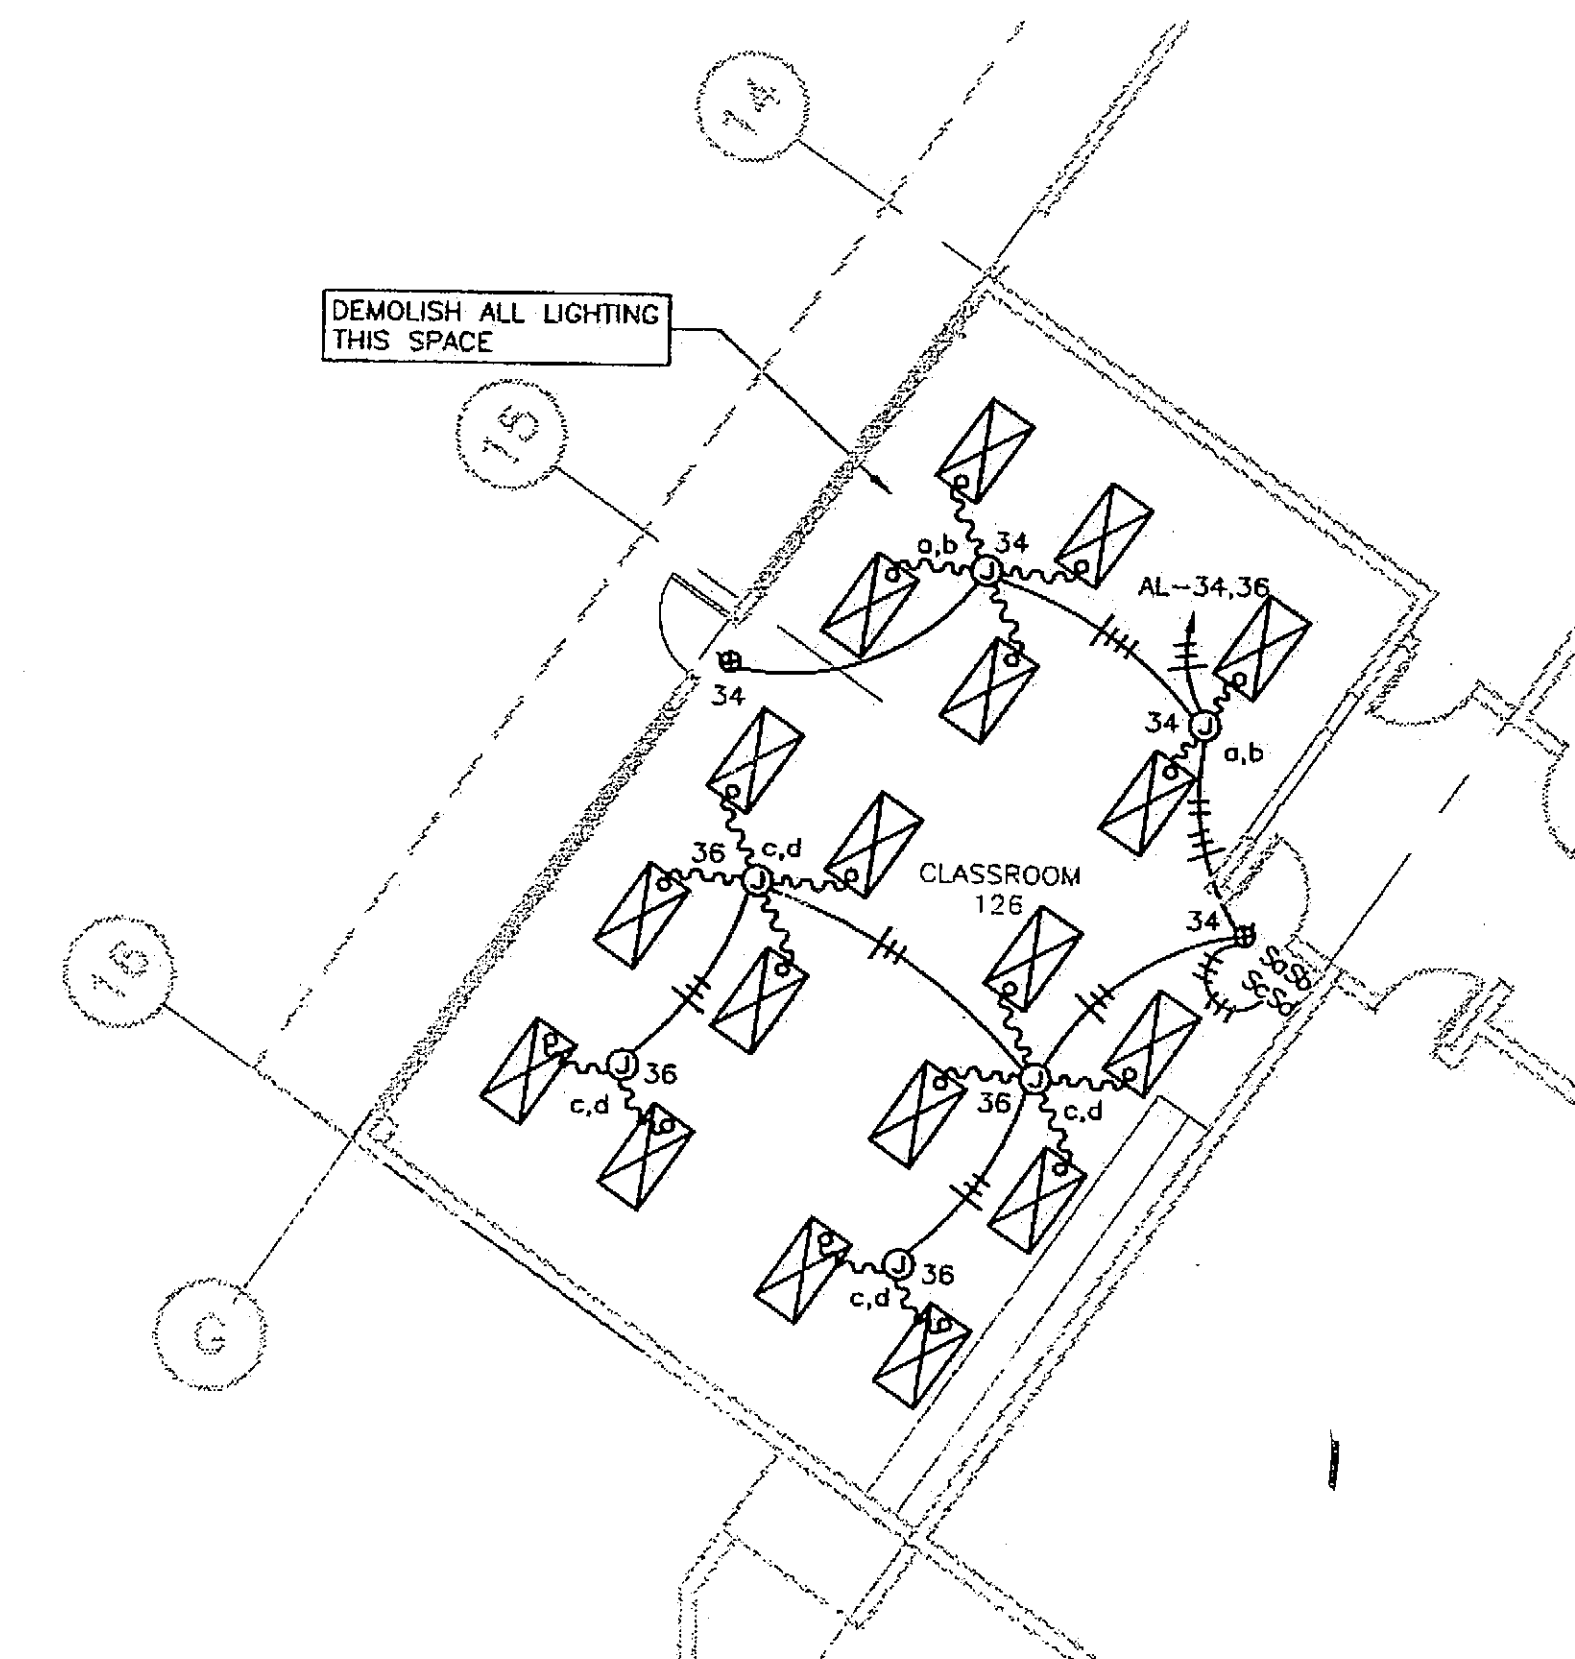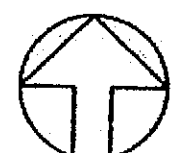


2 PARTIAL LIGHTING DEMOLITION PLAN
BUILDING A

SCALE: 0 4' 8' 16'

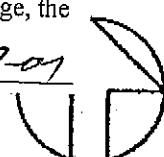

Project As-Built Drawings have been reviewed by the Project Engineer and represent to the best of my knowledge, the project as constructed.
Proj. Eng. *Whit* Date *7-01*

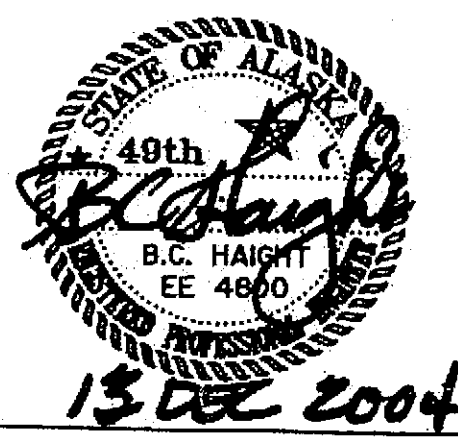

DESIGNED BY: BJB

DRAWN BY: PEL, RJB

STATE OF ALASKA
DEPARTMENT OF TRANSPORTATION
& PUBLIC FACILITIES
STATEWIDE DESIGN & ENGINEERING
SERVICES DIVISION

MT EDGE CUMBE
HIGH SCHOOL
BUILDING 1330
ACADEMIC
EXPANSION

SHEET E201

PROJECT DESIGNATION NUMBER

67751C

STATE	YEAR
ALASKA	2004
SHEET NUMBER	TOTAL SHEETS
71	79


DATE: DECEMBER 13, 2004

ADDENDUM NUMBER

ATTACHMENT NUMBER


RECORD OF REVISIONS

No.	DATE	DESCRIPTION

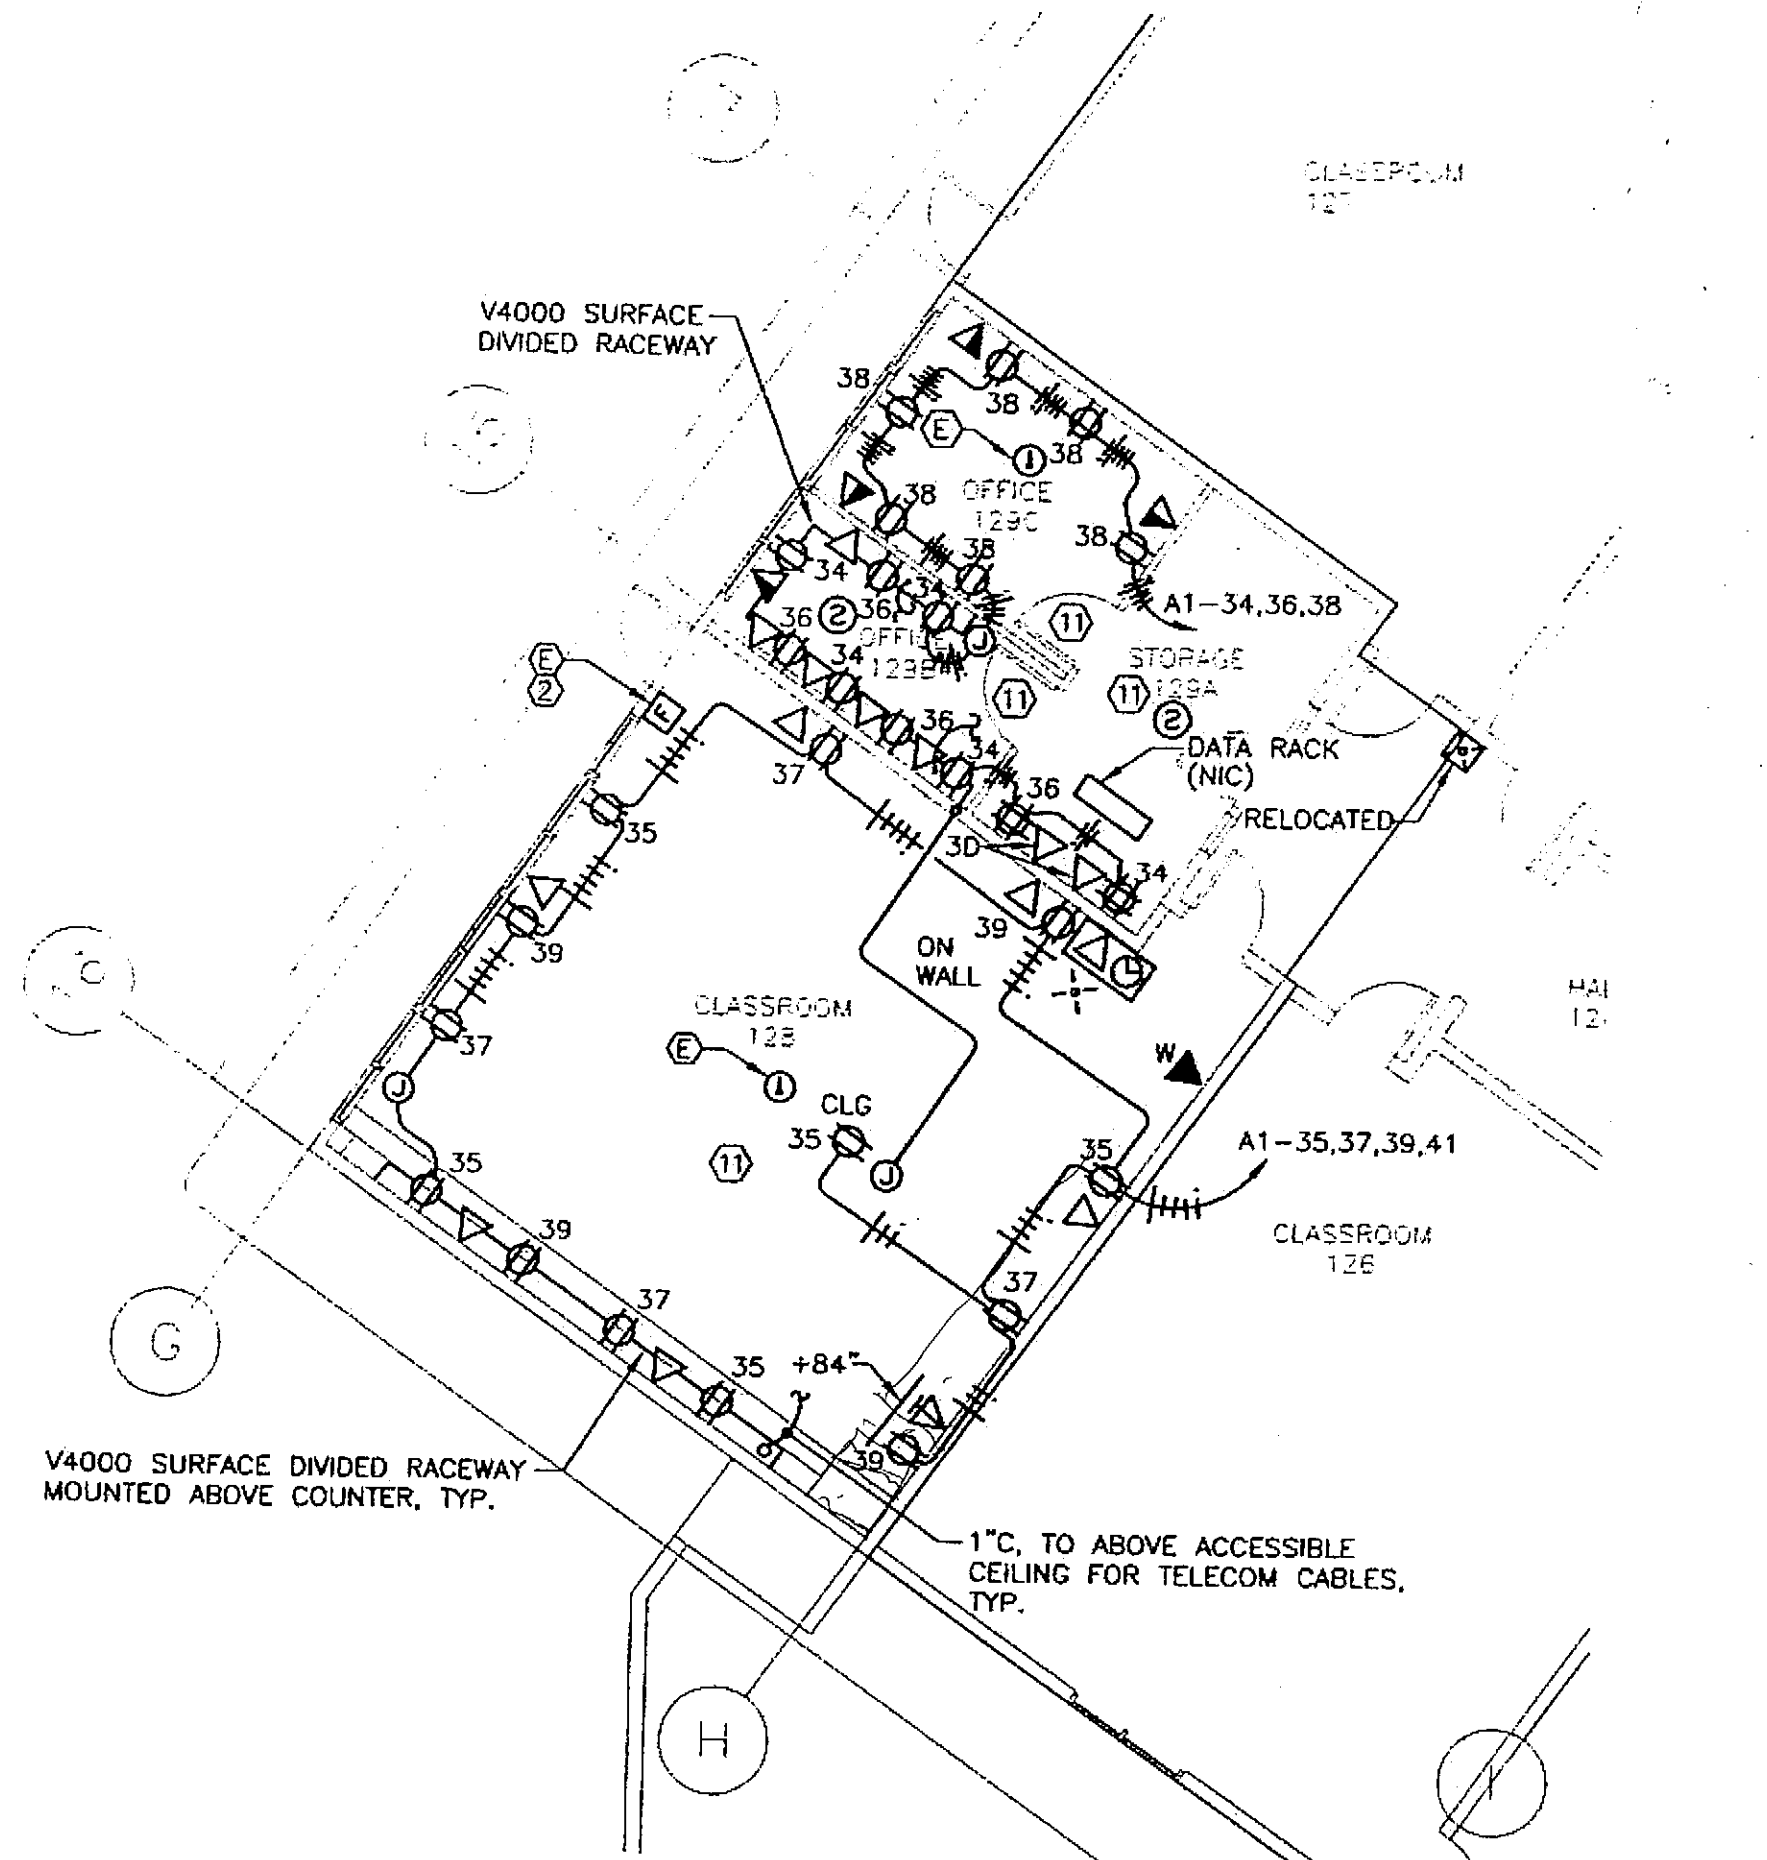

2 FIRST FLOOR PARTIAL PLAN - POWER
BUILDING A

SCALE: 0 4' 8' 16'

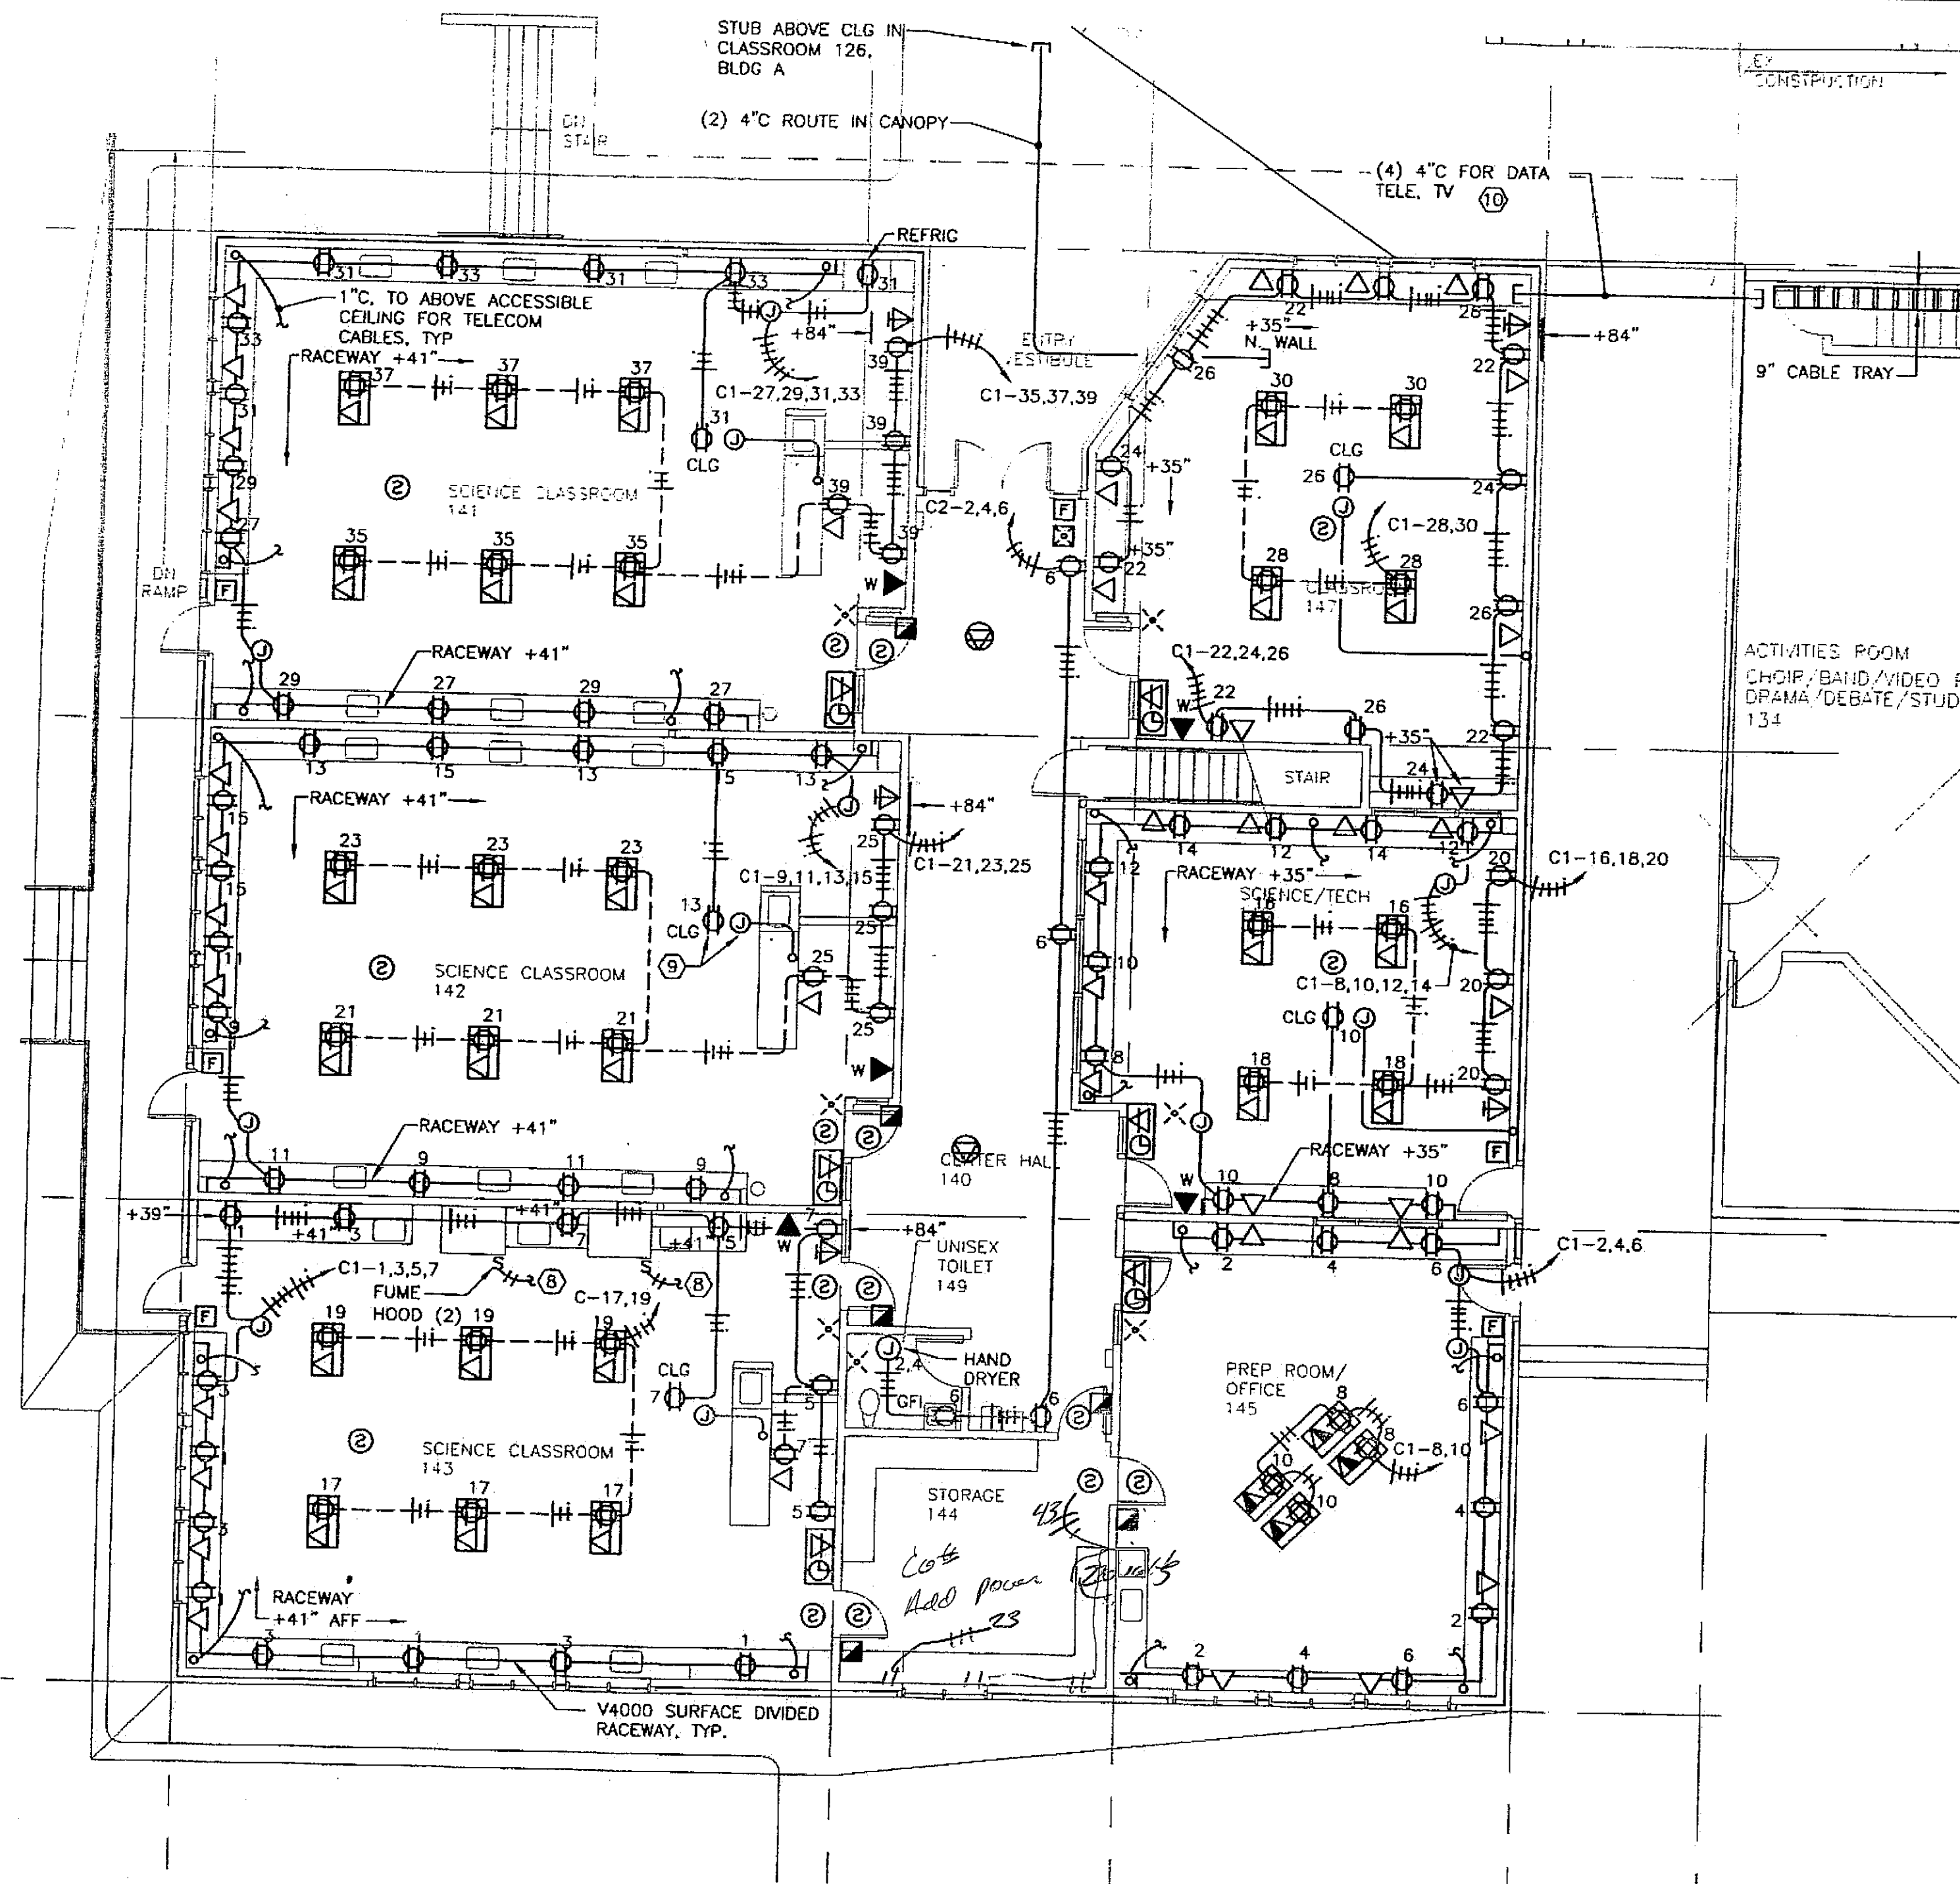

1 FIRST FLOOR PARTIAL PLAN - POWER
BUILDING C

SCALE: 0 4' 8' 16'

NOTES:

- COORDINATE EXACT LOCATION OF FLOOR BOXES WITH OWNER.
- RELOCATE PULLSTATION TO HEIGHT NOTED ON LEGEND. MAINTAIN WIRING TO EXISTING ZONE.
- ALL POWER OUTLETS MOUNTED ABOVE COUNTER IN 141, 142, AND 143 SHALL BE GFI.
- ROUTE DATA CABLES TO TELECOM RACK IN MECH 200. ROUTE TELE CABLES IN ADDITION TO EXISTING TELEPHONE TERMINAL BOARD IN MECH 200. ROUTE TELEVISION CABLES IN ADDITION TO EXISTING TV TERMINAL BOARD IN MECH 200. SEE E203 FOR EQUIPMENT LOCATIONS.
- ROUTE FIRE ALARM INITIATING LOOP TO EXISTING FACP NEAR SERVER ROOM 108A. ROUTE FIRE ALARM INDICATING LOOP TO EXISTING POWER SUPPLY NEAR SERVER ROOM 108A. SEE E200 FOR PANEL LOCATIONS.
- PROVIDE 2 DATA JACKS PER DATA OUTLET, UON. PROVIDE 1 TELEPHONE AND 1 DATA OUTLET PER COMBINATION DATA/TELE OUTLET, UON.
- DEVICE HEIGHTS ARE REFERENCED TO CENTER OF BOX, OR RACEWAY. VERIFY HEIGHTS WITH CASEWORK SHOP DRAWINGS.
- ROUTE SWITCH WIRING TO EF IN MECH 201.
- MOUNT RECEPTACLE FLUSH IN CEILING FOR PROJECTOR. MOUNT JUNCTION BOX ABOVE CEILING WITH 1\"/>

10 WALL MOUNT 11 FEET AFF, MINIMUM.

11 ROUTE DATA CABLE TO EXISTING PATCH PANEL IN CLASSROOM 120, EAST WALL, BUILDING A. ROUTE TELEPHONE CABLE TO EXISTING TELEPHONE TERMINAL BOARD, IN MECHANICAL 200, BUILDING B.

12. PROVIDE RG59 COAX CABLE FROM EACH TELEVISION OUTLET TO THE EXISTING TV TERMINAL BOARD IN MECH 200. COORDINATE WITH LOCAL SERVICE PROVIDER FOR INTERCONNECTION TO EXISTING SYSTEM. EXISTING SYSTEM CONFIGURATION IS NOT DOCUMENTED.

Project As-Built Drawings have been reviewed by the Project Engineer and represent to the best of my knowledge, the project as constructed.
Proj. Eng. *[Signature]* Date 7-07



13 DEC 2004

DESIGNED BY: BJB

DRAWN BY: PEL, RJB

STATE OF ALASKA
DEPARTMENT OF TRANSPORTATION
& PUBLIC FACILITIES
STATEWIDE DESIGN & ENGINEERING
SERVICES DIVISION

MT EDGECLUMBE
HIGH SCHOOL
BUILDING 1330
ACADEMIC
EXPANSION

SHEET E202

PROJECT DESIGNATION NUMBER

67751C

STATE	YEAR
ALASKA	2004
SHEET NUMBER	TOTAL SHEETS
72	79


DATE: DECEMBER 13, 2004

ADDENDUM NUMBER

ATTACHMENT NUMBER

RECORD OF REVISIONS

No.	DATE	DESCRIPTION

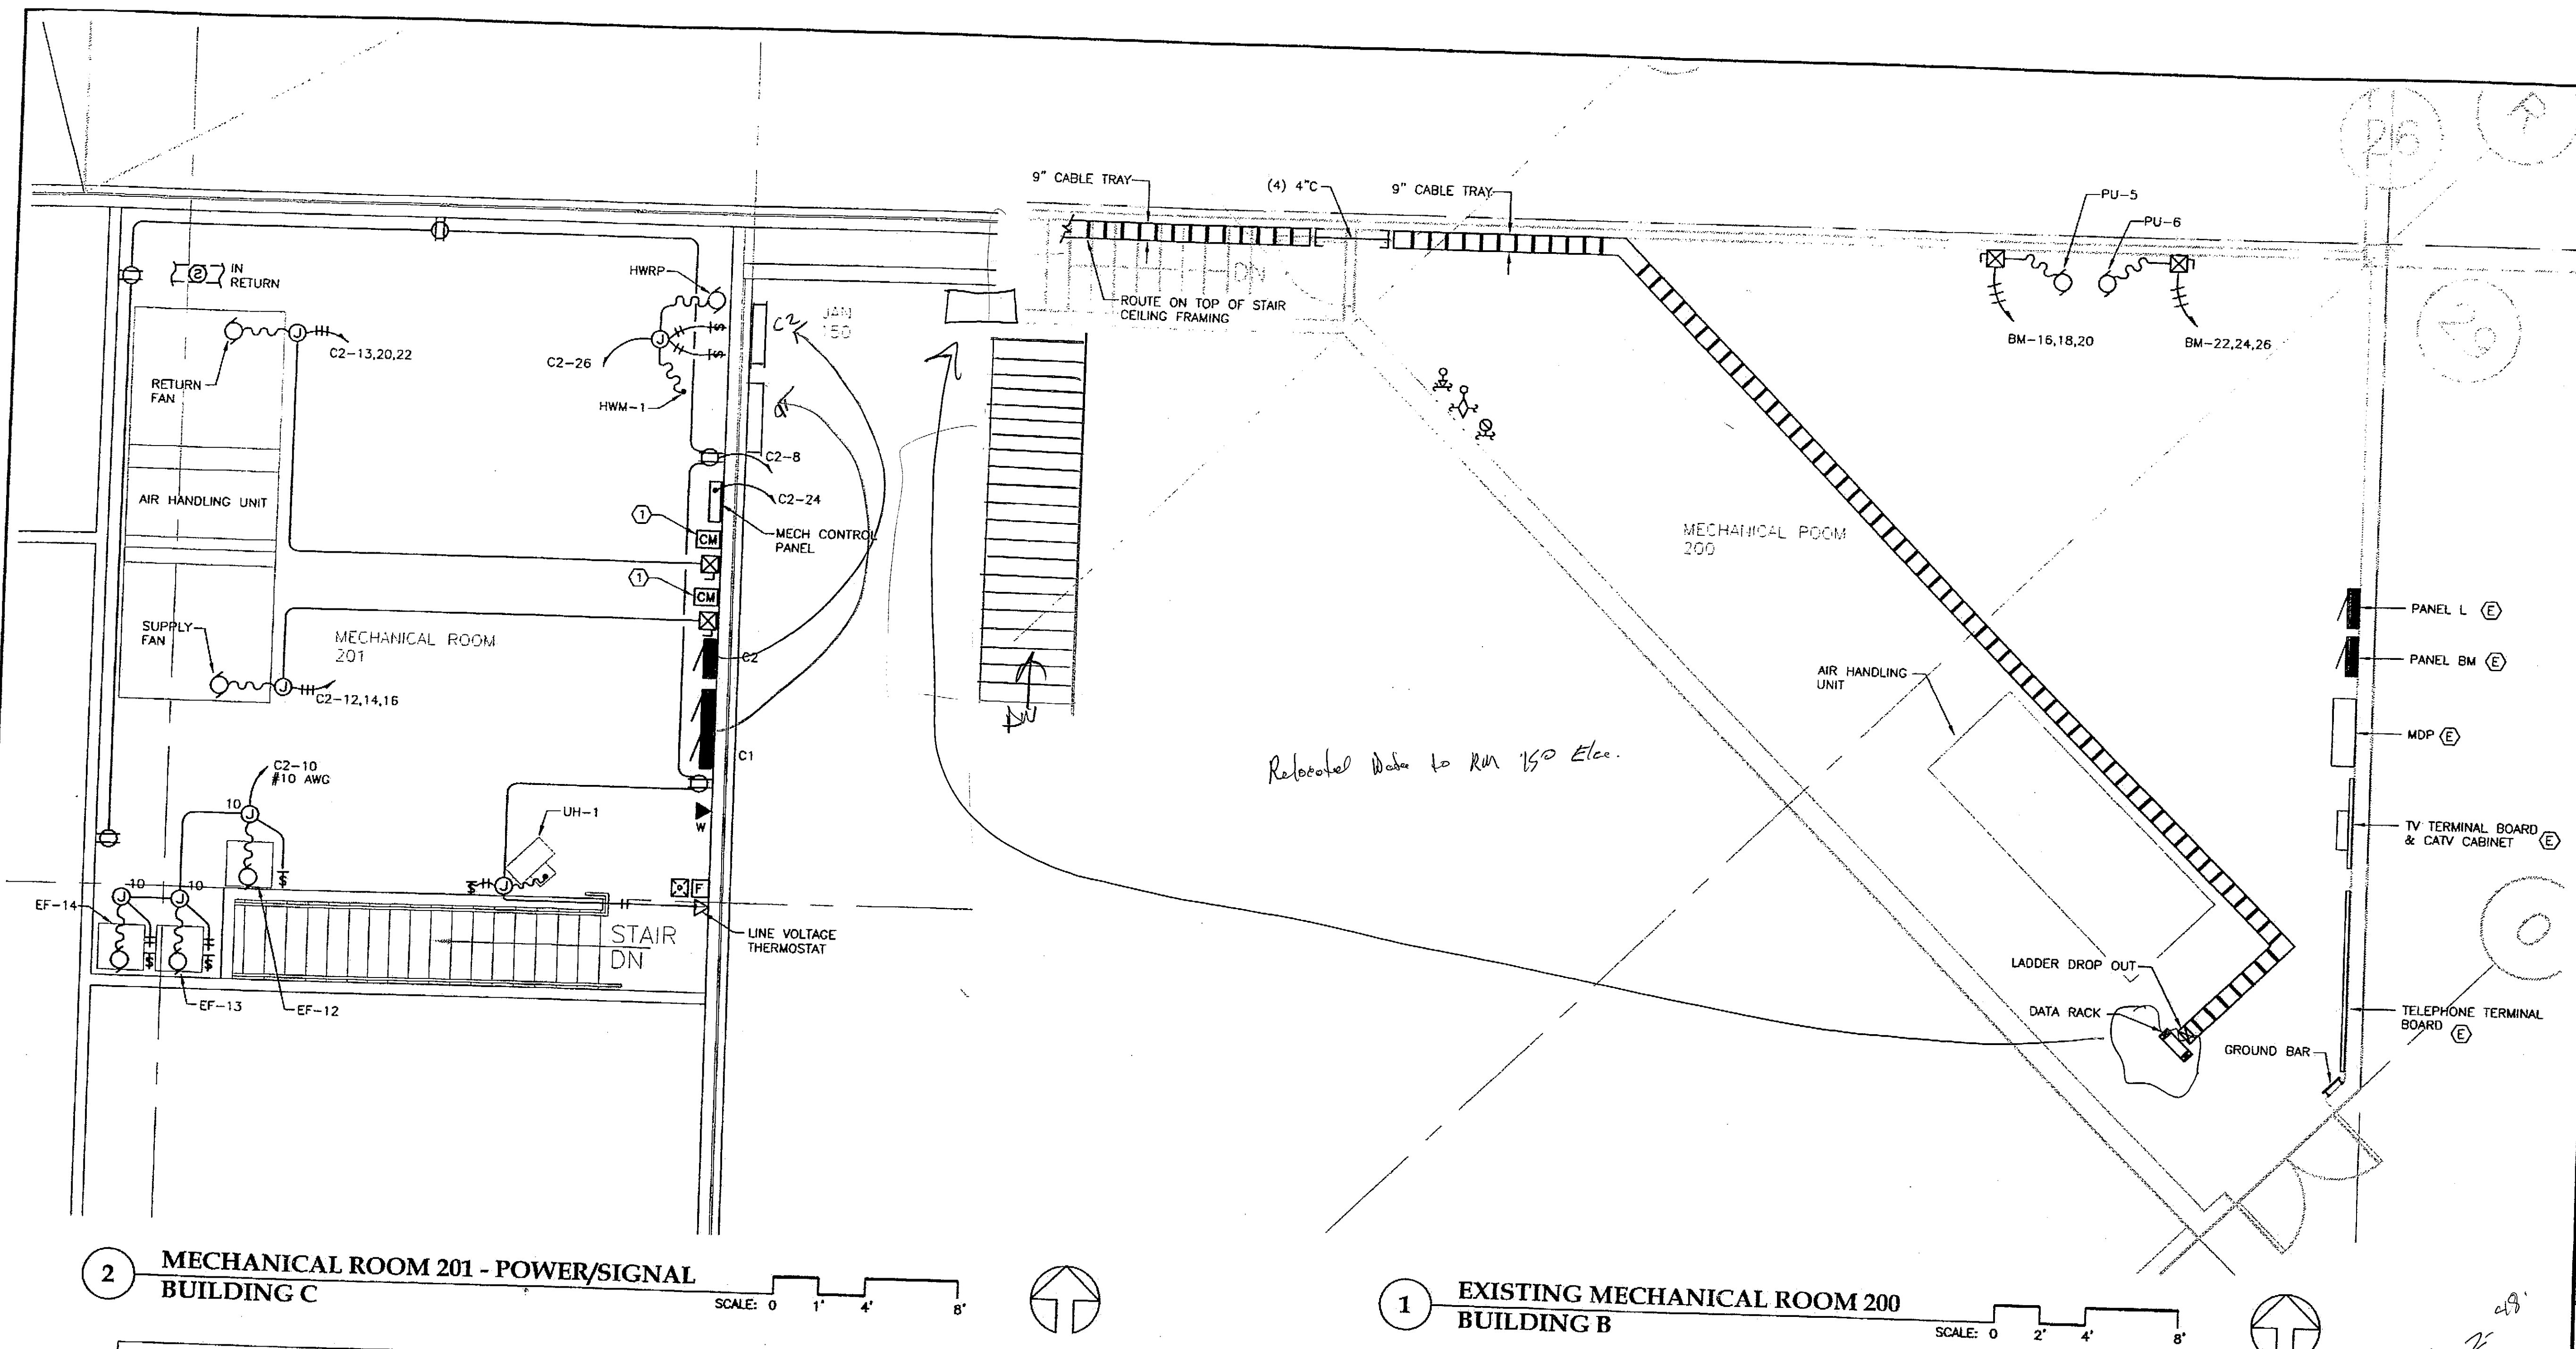

2 MECHANICAL ROOM 201 - POWER/SIGNAL BUILDING C

SCALE: 0 1' 4' 8'

1 EXISTING MECHANICAL ROOM 200 BUILDING B


SCALE: 0 2' 4' 8'

EQUIPMENT SCHEDULE

EQUIPMENT SCHEDULE													
DESIGNATION			LOAD					CIRCUITING			CONTROL		
ITEM	DESCRIPTION	LOCATION	HP	KW	AMPS	VOLTS	PHASE	CONDUCTORS	DISCONNECT		STARTER SIZE	CONTROL	REMARKS
									SWITCH	FUSE			
AHU	AIR HANDLING UNIT												
	SUPPLY FAN	MECHANICAL 201	5			208	3 PH	3/4"C, 3 NO. 10, 1 NO. 10 GND	30/3	.	1	H-O-A	.
	RETURN FAN	MECHANICAL 201	1			208	3 PH	1/2"C, 3 NO. 12, 1 NO. 12 GND	30/3	8	0	H-O-A	.
EF-12	EXHAUST FAN	MECHANICAL 201	1/4			120	1 PH	1/2"C, 2 NO. 12, 1 NO. 12 GND	\$	.	0	H-O-A	.
EF-13	FUME HOODS	MECHANICAL 201	1/4			120	1 PH	1/2"C, 2 NO. 12, 1 NO. 12 GND	\$	.	.	H-O-A	.
EF-14	FUME HOODS	MECHANICAL 201	1/4			120	1 PH	1/2"C, 2 NO. 12, 1 NO. 12 GND	\$	.	.	ON-OFF	.
UH-1	UNIT HEATER	MECHANICAL 201	1/20			120	1 PH	1/2"C, 2 NO. 12, 1 NO. 12 GND	\$	.	.	ON-OFF	.
PU-5/6	MAIN HEATING PUMPS	MECHANICAL/FAN ROOM	3/4			120	1 PH	1/2"C, 2 NO. 12, 1 NO. 12 GND	\$	.	.	ON-OFF	.
HWRP	CIRC PUMP	MECHANICAL/FAN ROOM BLDG B	1/8			208	3 PH	1/2"C, 3 NO. 12, 1 NO. 12 GND	30/3	6.25	0	H-O-A	DISC BY DIV. 15
HWM-1	HOT WATER MAKER	MECHANICAL/FAN ROOM BLDG B	1/40			120	1 PH	1/2"C, 2 NO. 12, 1 NO. 12 GND	\$	.	.	ON-OFF	.
-	CONTROLS	MECHANICAL 201				120	1 PH	1/2"C, 2 NO. 12, 1 NO. 12 GND	\$	.	.	.	.

NOTES:

- INTERFACE CONTROL MODULE WITH SUPPLY AND RETURN FAN CONTROLS. SEE WIRING DIAGRAM, E206.
- PROVIDE DATA LINE TO MECHANICAL CONTROL PANEL IN MECHANICAL ROOM 201.
- PROVIDE 19\" x 7\" DATA RACK, CHATSWORTH 46353503 WITH DOUBLE SIDED WIDE VERTICAL CABLING SECTION AND 70\" VERTICAL POWER STRIP. PROVIDE (2) 96 PORT PATCH PANELS WITH HORIZONTAL CABLE MANAGEMENT. OWNER SHALL PROVIDE NETWORK SWITCH. INTERCONNECT NETWORK SWITCH TO FIBER DISTRIBUTION UNIT MOUNTED ON EAST WALL. PROVIDE 2-STRAND FIBER OPTIC CABLE FOR INTERCONNECTION.
- PROVIDE NO. 6 AWG FROM GROUND BAR TO MDP GROUND BUS. BOND TO CABLE TRAY, CONDUIT, AND RACK WITH NO. 6 INSULATED GROUND CONDUCTOR.
- SUSPEND CABLE TRAY AT APPROXIMATELY 8' AFF. BELOW PIPING AND DUCTWORK.
- VERIFY QUANTITY AND CONFIGURATION OF SPRINKLER MONITORING DEVICES WITH DIVISION 15 DRAWINGS.
- VERIFY MOTOR HORSEPOWER RATINGS WITH DIVISION 15 DRAWINGS.

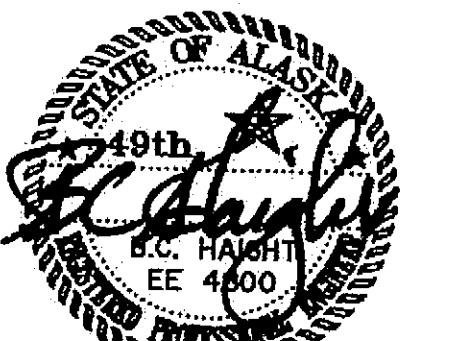

13 DEC 2004

DESIGNED BY: BJB

DRAWN BY: PEL, RJB

STATE OF ALASKA
DEPARTMENT OF TRANSPORTATION
& PUBLIC FACILITIES
STATEWIDE DESIGN & ENGINEERING
SERVICES DIVISION
MT EDGE CUMBE
HIGH SCHOOL
BUILDING 1330
ACADEMIC
EXPANSION


SHEET E203

PROJECT DESIGNATION NUMBER

67751C


STATE	YEAR
ALASKA	2004
SHEET NUMBER	TOTAL SHEETS
73	79

Project As-Built Drawings have been reviewed by the Project Engineer and represent to the best of my knowledge, the project as constructed.
Proj. Eng. *[Signature]* Date *[Date]*

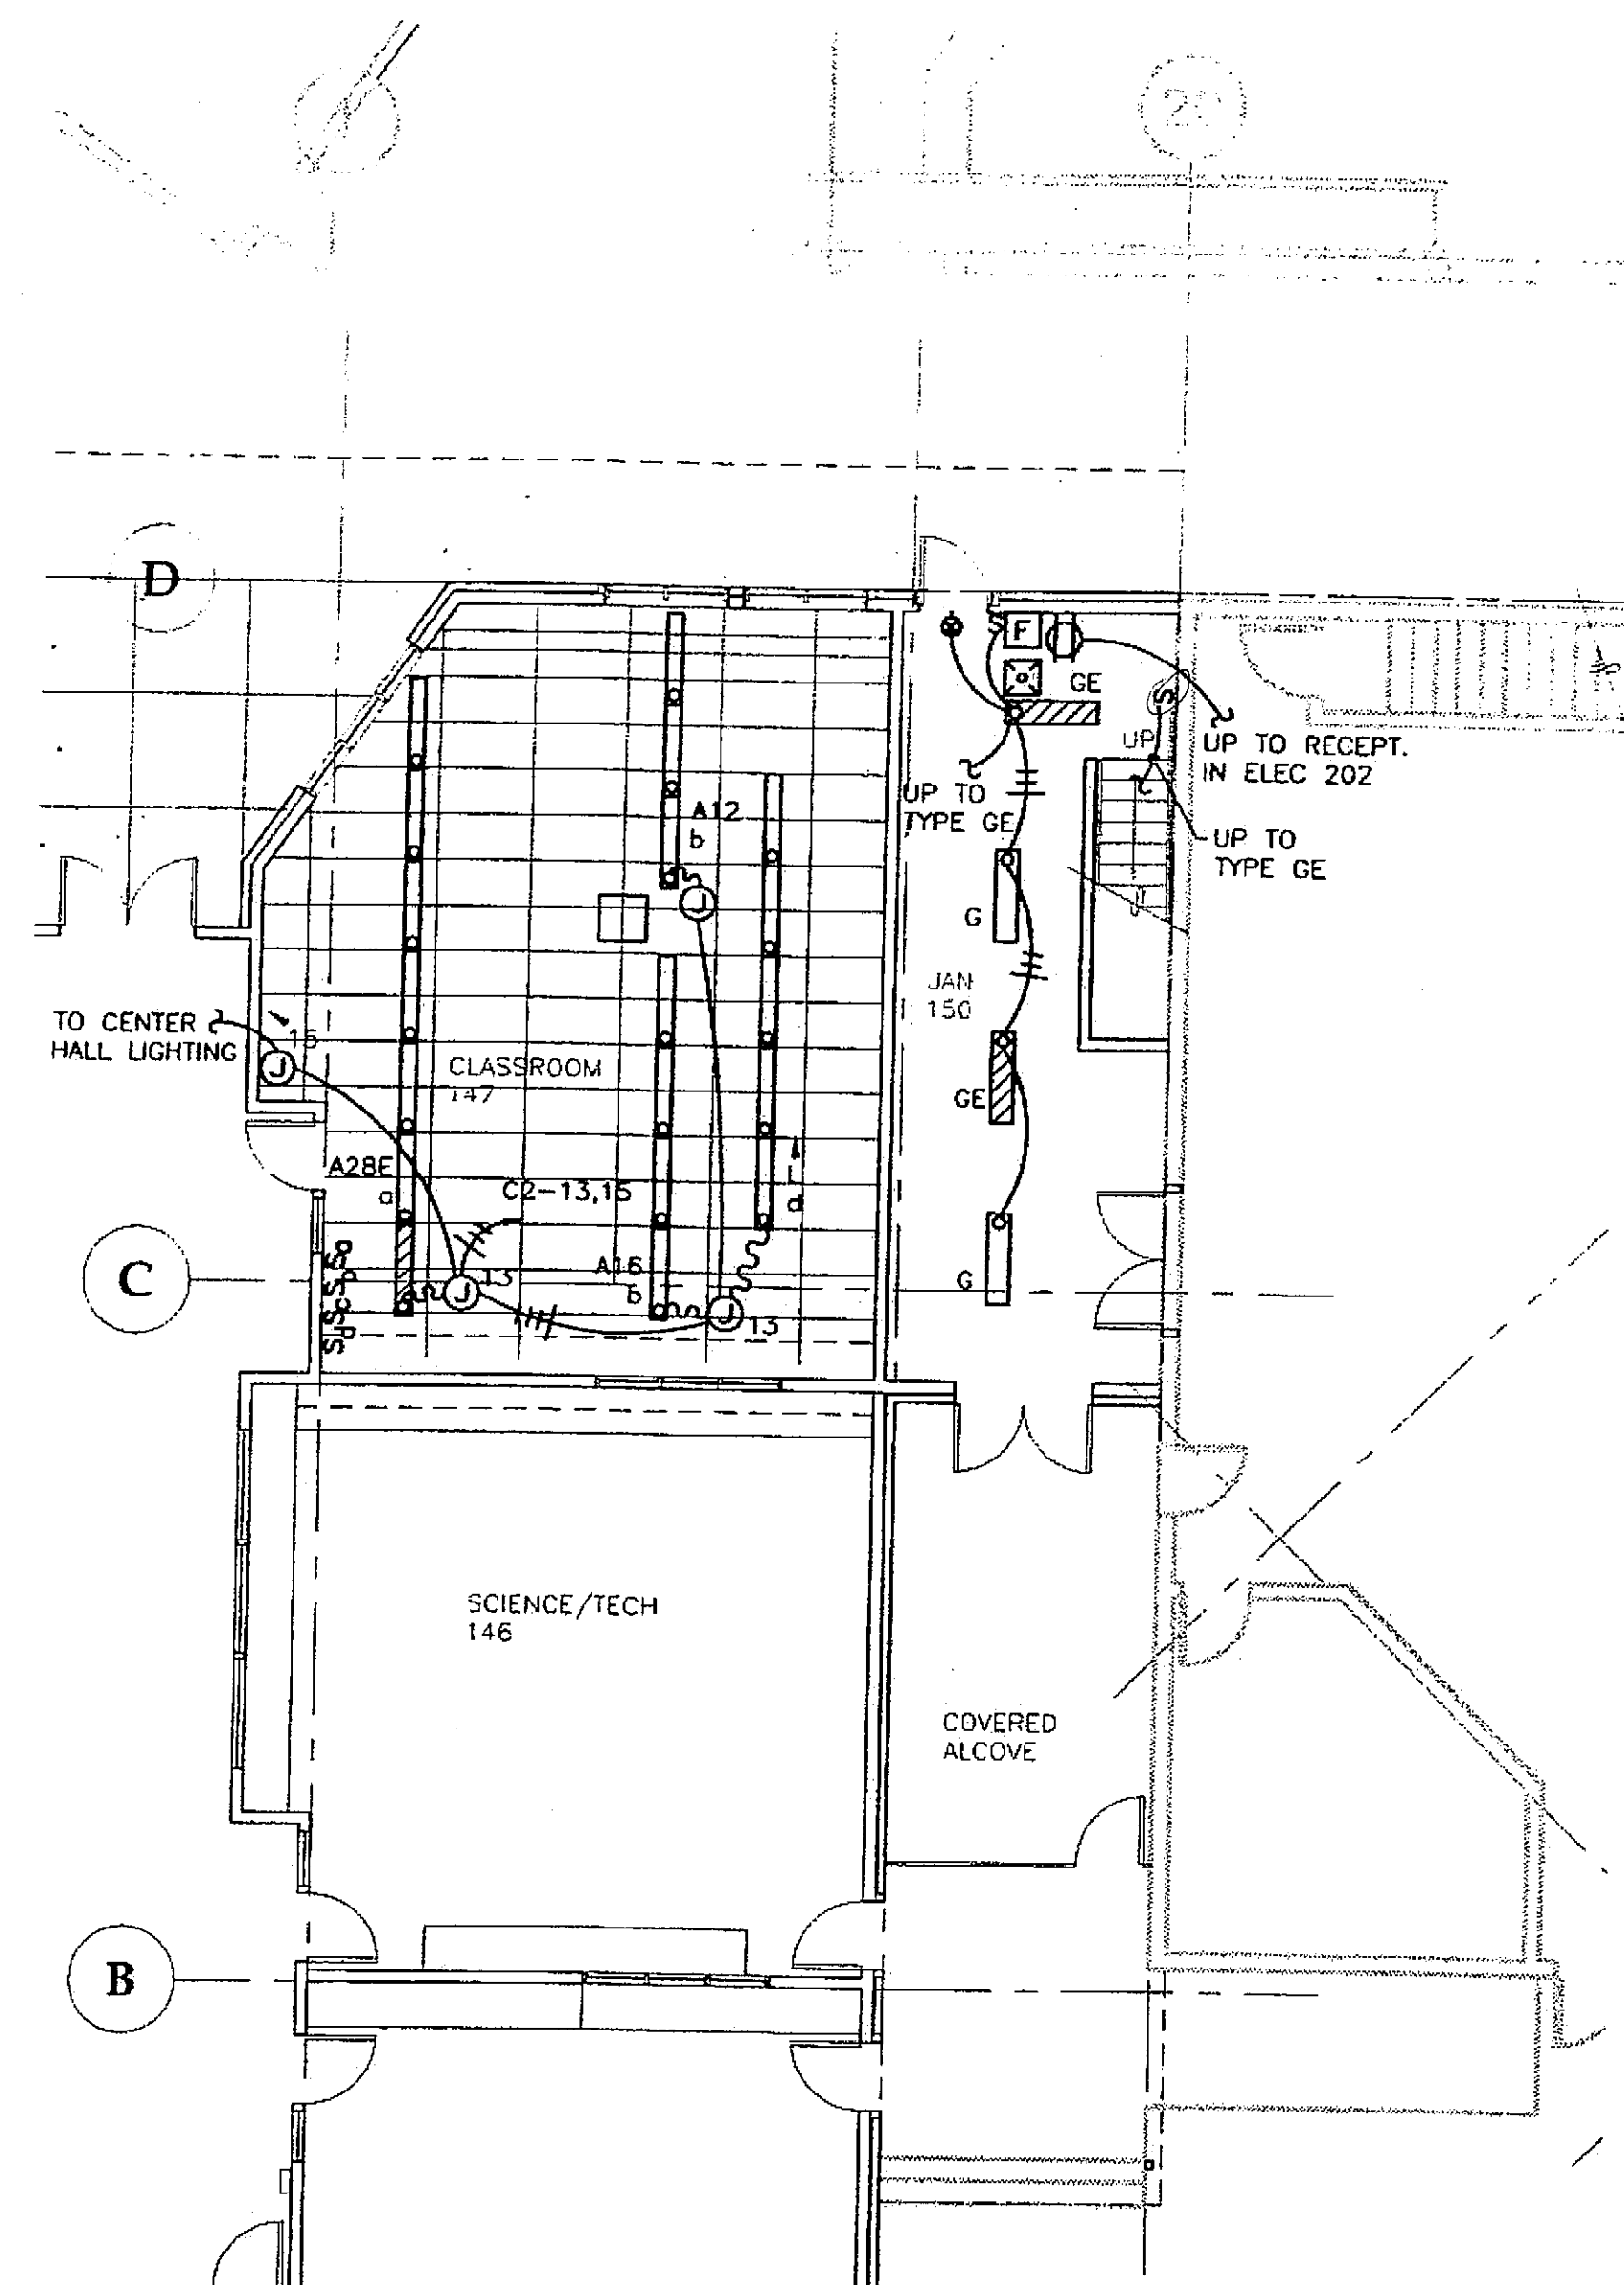

1 FIRST FLOOR PARTIAL PLAN - ALTERNATE POWER/SIGNAL
BUILDING C

SCALE: 0 4' 8' 16'

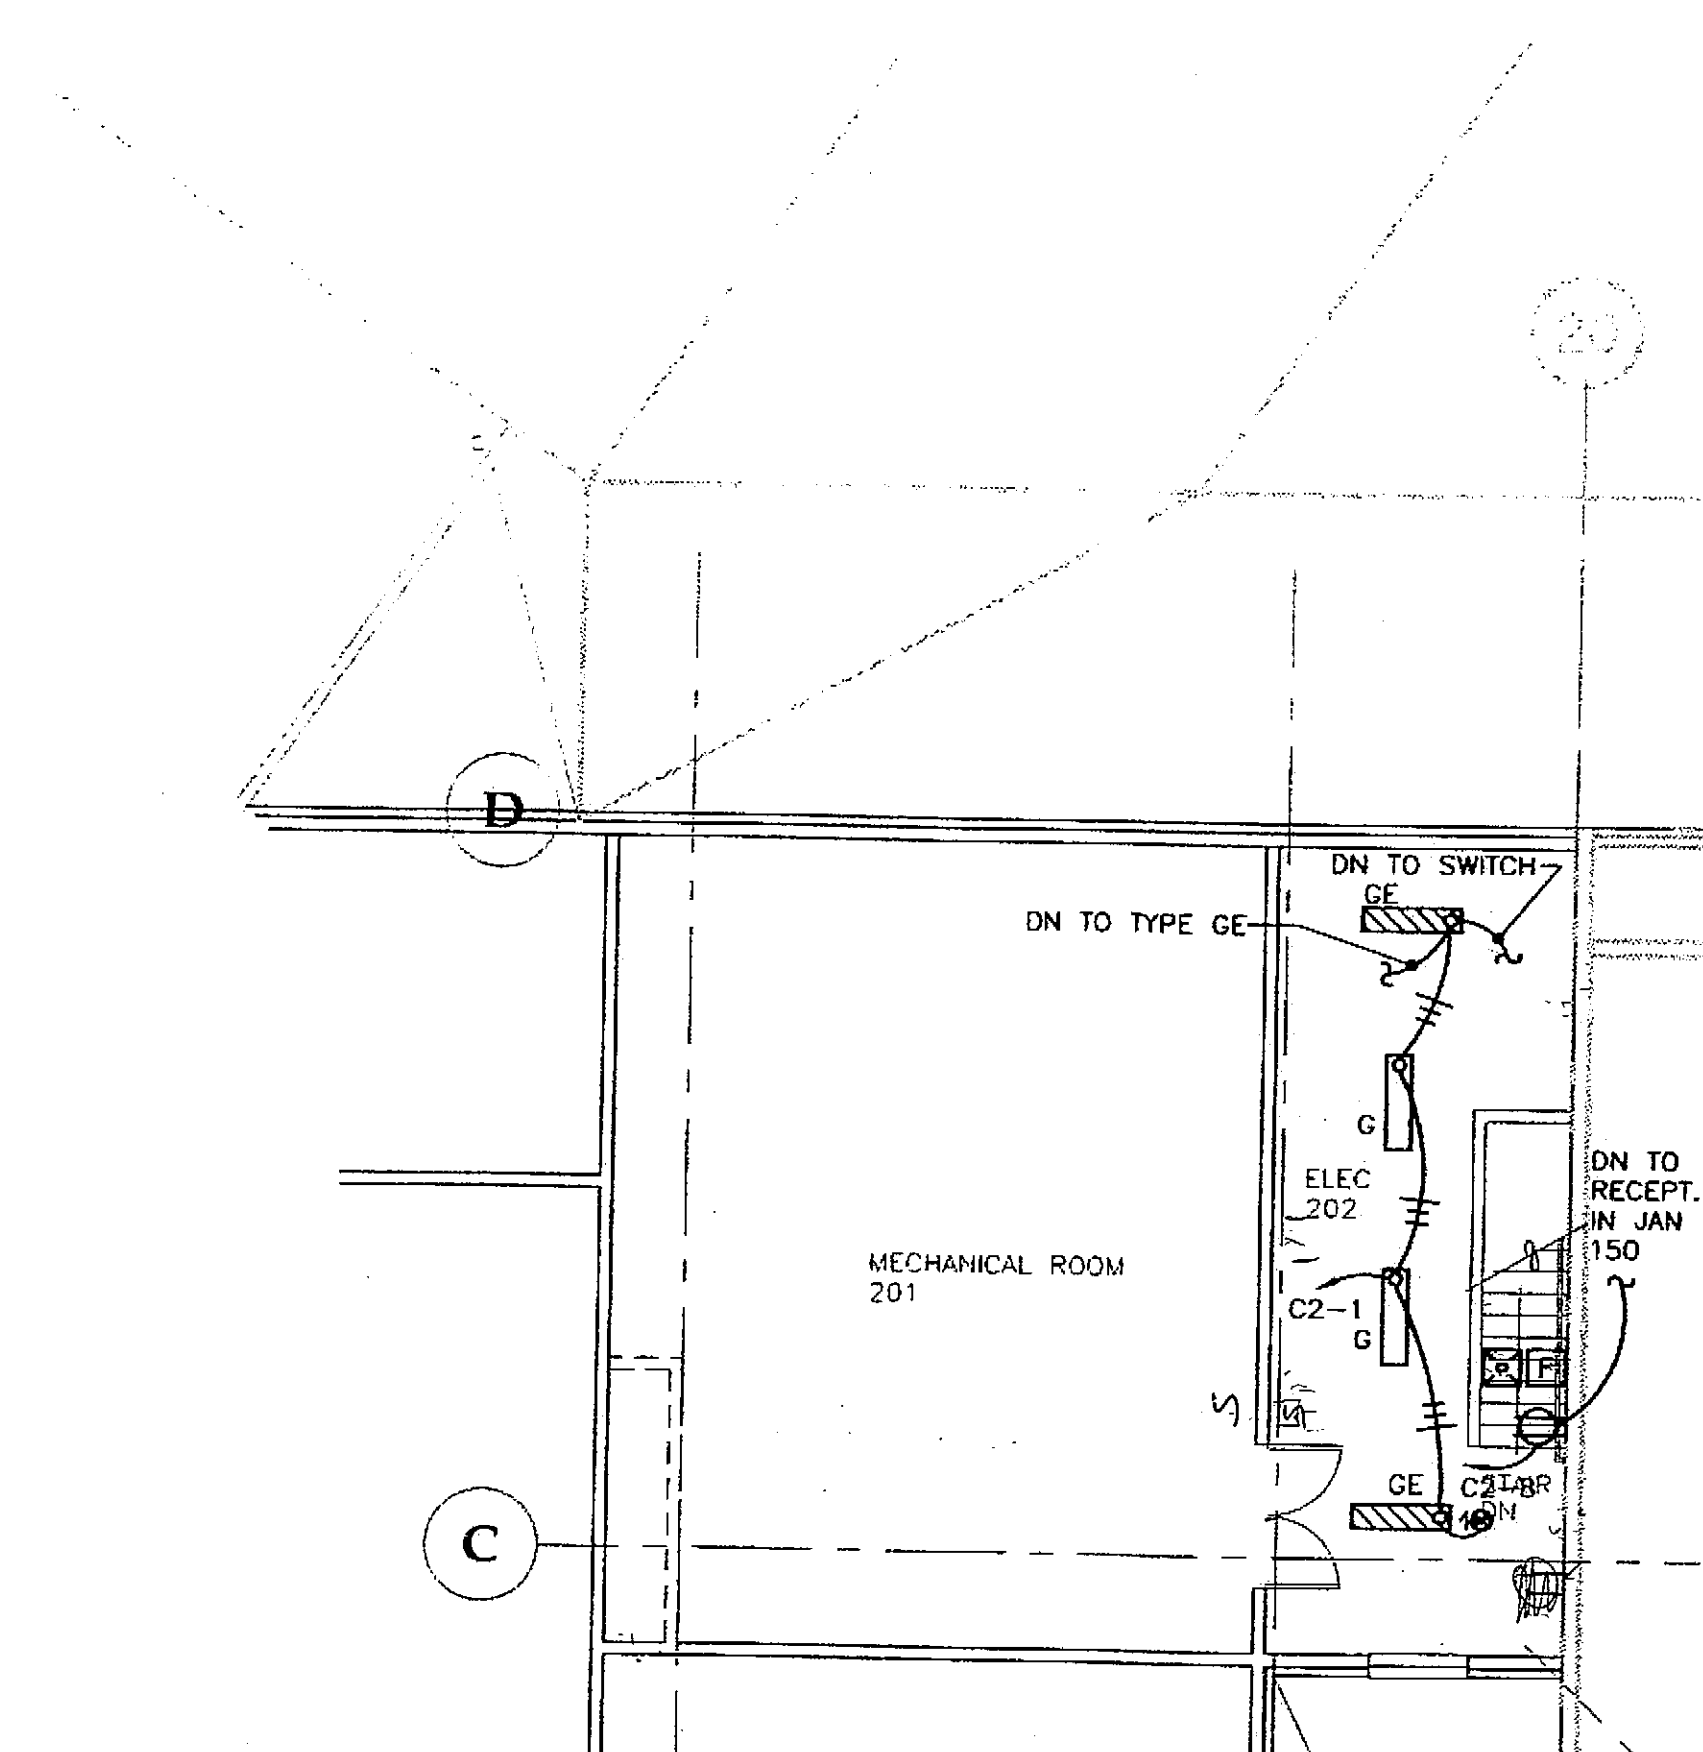

2 MECHANICAL ROOM 201 - ALTERNATE POWER/SIGNAL
BUILDING C

SCALE: 0 1' 4' 8'

Project As-Built Drawings have been reviewed by the Project Engineer and represent to the best of my knowledge, the project as constructed.
Proj. Eng. *[Signature]* Date 2-07

DATE: DECEMBER 13, 2004		
ADDENDUM NUMBER		
ATTACHMENT NUMBER		
RECORD OF REVISIONS		
No.	DATE	DESCRIPTION
13 DEC 2004		
DESIGNED BY: BJB		
DRAWN BY: PEL, RJB		
STATE OF ALASKA DEPARTMENT OF TRANSPORTATION & PUBLIC FACILITIES STATEWIDE DESIGN & ENGINEERING SERVICES DIVISION MT EDGE CUMBE HIGH SCHOOL BUILDING 1330 ACADEMIC EXPANSION		
SHEET E204		
PROJECT DESIGNATION NUMBER		
67751C		
STATE	YEAR	
ALASKA	2004	
SHEET NUMBER	TOTAL SHEETS	
74	79	

PANEL C1		(SECTION 1)	SIZE	VOLTS/PHASE				MAIN	LOCATION		MOUNT
			225 AMPS	120/208V, 3Ø, 4W				LUGS ONLY	MECHANICAL 201		SURFACE
C K T NO	DESCRIPTION	BREAKER AMP/ POLE	KVA						BREAKER AMP/ POLE	DESCRIPTION	C K T NO
			CKT	AØ	BØ	CØ	CKT				
1	CLASSROOM 143	20/1	0.9	1.4				0.5	20/1	PREP ROOM 145	2
3	CLASSROOM 143	20/1	0.9		1.4			0.5	20/1	PREP ROOM 145	4
5	CLASSROOM 143	20/1	0.5				1.0	0.5	20/1	PREP ROOM 145	6
7	CLASSROOM 143	20/1	0.5	1.0				0.5	20/1	SCIENCE/TECH 146	8
9	CLASSROOM 142	20/1	0.5		1.0			0.5	20/1	SCIENCE/TECH 146	10
11	CLASSROOM 142	20/1	0.5			1.0		0.5	20/1	SCIENCE/TECH 146	12
13	CLASSROOM 142	20/1	0.7	1.2				0.5	20/1	SCIENCE/TECH 146	14
15	CLASSROOM 142	20/1	0.5		1.2			0.7	20/1	SCIENCE/TECH 146	16
17	CLASSROOM 143	20/1	1.1				1.8	0.7	20/1	SCIENCE/TECH 146	18
19	CLASSROOM 143	20/1	1.1	1.6				0.5	20/1	SCIENCE/TECH 146	20
21	CLASSROOM 142	20/1	1.1		2.0			0.9	20/1	CLASSROOM 147	22
23	CLASSROOM 142	20/1	1.1				1.8	0.7	20/1	CLASSROOM 147	24
25	CLASSROOM 142	20/1	0.7	1.2				0.5	20/1	CLASSROOM 147	26
27	CLASSROOM 141	20/1	0.5		1.2			0.7	20/1	CLASSROOM 147	28
29	CLASSROOM 141	20/1	0.5			1.2		0.7	20/1	CLASSROOM 147	30
31	CLASSROOM 141	20/1	0.7	.7				0.0	20/1	SPARE	32
33	CLASSROOM 141	20/1	0.5		.5			0.0	20/1	SPARE	34
35	CLASSROOM 141	20/1	1.1			1.1		0.0	20/1	SPARE	36
37	CLASSROOM 141	20/1	1.1	1.1				0.0	20/1	SPARE	38
39	CLASSROOM 141	20/1	0.7		.7			0.0	20/1	SPARE	40
41	SPARE	20/1	0.0				0.0	0.0	20/1	SPARE	42
BALANCED CONNECTED LOAD = 24 KVA / 67 AMPS				8.2	8.0	7.9			BALANCED DEMAND LOAD = 0.0 KVA / 00 AMPS		
MAXIMUM CONNECTED LOAD = 24 KVA / 68 AMPS									MAXIMUM DEMAND LOAD = 0.0 KVA / 00 AMPS		

PANEL C1			SIZE		VOLTS/PHASE			MAIN		LOCATION		MOUNT	
(SECTION 2)			225 AMPS		120/208V, 3 PH			LUGS ONLY		MECHANICAL 201		SURFACE	
C K 1	NO	DESCRIPTION	BREAKER AMP/ POLE	KVA						BREAKER AMP/ POLE	DESCRIPTION	C K	
				CKT	AØ	BØ	CØ	CKT					
43	SPACE	--	0.0	0.0				0.0	70/3	TVSS UNIT	44		
45	SPACE	--	0.0		0.0			0.0	----	----	46		
47	SPACE	--	0.0				0.0	0.0	----	----	48		
49	SPACE	--	0.0	0.0				0.0	----	----	50		
51	SPACE	--	0.0		0.0			0.0	20/1	SPARE	52		
53	SPACE	--	0.0				0.0	0.0	20/1	SPARE	54		
55	SPACE	--	0.0	0.0				0.0	20/1	SPARE	56		
57	SPACE	--	0.0		0.0			0.0	20/1	SPARE	58		
59	SPACE	--	0.0			0.0		0.0	20/1	SPARE	60		
61	SPACE	--	0.0			0.0		0.0	20/1	SPARE	62		
63	SPACE	--	0.0	0.0				0.0	20/1	SPARE	64		
65	SPACE	--	0.0		0.0			0.0	--	SPACE	66		
67	SPACE	--	0.0				0.0	0.0	--	SPACE	68		
69	SPACE	--	0.0	0.0				0.0	--	SPACE	70		
71	SPACE	--	0.0		0.0			0.0	--	SPACE	72		
73	SPACE	--	0.0				0.0	0.0	--	SPACE	74		
75	SPACE	--	0.0	0.0				0.0	--	SPACE	76		
77	SPACE	--	0.0		0.0			0.0	--	SPACE	78		
79	SPACE	--	0.0			0.0		0.0	--	SPACE	80		
81	SPACE	--	0.0	0.0				0.0	--	SPACE	82		
83	SPACE	--	0.0		0.0			0.0	--	SPACE	84		
BALANCED CONNECTED LOAD = 0.0 KVA / 00 AMPS				0.0	0.0	0.0	BALANCED DEMAND LOAD = 0.0 KVA / 00 AMPS						
MAXIMUM CONNECTED LOAD = 0.0 KVA / 00 AMPS				MAXIMUM DEMAND LOAD = 0.0 KVA / 00 AMPS									

PANEL C2			SIZE	VOLTS/PHASE				MAIN	LOCATION		MOUNT
			100 AMPS	120/208V, 3 PH				LUGS ONLY	MECHANICAL 201		SURFACE
C K T N O	DESCRIPTION	BREAKER AMP/ POLE	KVA						BREAKER AMP/ POLE	DESCRIPTION	C K T N O
			CKT	AØ	BØ	CØ	CKT				
1	MECHANICAL 201, JANITOR (ALTERNATE)	LTG	20/1	1.0	2.5			1.5	20/2	HAND DRYER	2
3	SCIENCE CLASSROOM 141		20/1	1.4		2.9		1.5	----		4
5	SCIENCE CLASSROOM 142		20/1	1.4			2.1	0.7	20/1	CENTER HALL 140	6
7	SCIENCE CLASSROOM 143		20/1	1.4	2.8			1.4	20/1	MECHANICAL 201, JANITOR (ALTERNATE)	8
9	STORAGE 144, PREP/OFFICE 145		20/1	1.3		3.4		2.1	20/1	EF-12,13,14	10
11	SCIENCE/TECH CLASSROOM 146		20/1	1.1			3.2	2.1	25/3	SUPPLY FAN	12
13	CLASSROOM 147		20/1	0.9	3.0			2.1	----		14
15	CENTER HALL 140		20/1	1.3		3.4		2.1	----		16
17	EXTERIOR		20/1	0.0				0.6	15/3	RETURN FAN	18
19	SMOKE DAMPERS		20/1	0.0	0.6			0.6	----		20
21	SPACE <i>Rm 143 Storage</i>		----	0.0		0.6		0.6	----		22
23	SPACE <i>Rm 143 Storage</i>		----	0.0			0.6	0.6	20/1	MECH CONTROL PANEL	24
25	SPACE <i>Rm 143 Storage</i>		----	0.0	0.6			0.6	20/1	HWRP, HWM	26
27	SPACE		----	0.0		0.0		0.0	20/1	SPARE	28
29	SPACE		----	0.0			0.0	0.0	20/1	SPARE	30
31	SPACE		----	0.0	0.0			0.0	20/1	SPARE	32
33	SPACE		----	0.0		0.0		0.0	20/1	SPARE	34
35	SPACE		----	0.0			0.0	0.0	20/1	SPARE	36
37	SPACE		----	0.0	0.0			0.0	20/1	SPARE	38
39	SPACE		----	0.0		0.0		0.0	20/1	SPARE	40
41	SPACE		----	0.0			0.0	0.0	20/1	SPARE	42
BALANCED CONNECTED LOAD = 26.3 KVA / 73 AMPS											
MAXIMUM CONNECTED LOAD = 26.3 KVA / 86 AMPS				9.5	10.3	6.5				BALANCED DEMAND LOAD = 0.0 KVA	

DATE: DECEMBER 13, 2004

ADDENDUM NUMBER

ATTACHMENT NUMBER

RECORD OF REVISIONS

No.	DATE	DESCRIPTION



13 DEC. 2004

DESIGNED BY: BJB

DRAWN BY: PEL, RJB

STATE OF ALASKA
DEPARTMENT OF TRANSPORTATION
& PUBLIC FACILITIES
STATEWIDE DESIGN & ENGINEERING
SERVICES DIVISION
MT EDGE CUMBE
HIGH SCHOOL
BUILDING 1330
ACADEMIC
EXPANSION

SHEET E205

PROJECT DESIGNATION NUMBER

67751C

STATE	YEAR
ALASKA	2004
SHEET NUMBER	TOTAL SHEETS
75	79

Project As-Built Drawings have been reviewed by the Project Engineer and represent the best of my knowledge, the project as constructed.
Proj. Eng. *Dr. [Signature]* Date *2-07*

DATE: DECEMBER 13, 2004

ADDENDUM NUMBER

ATTACHMENT NUMBER



RECORD OF REVISIONS

No.	DATE	DESCRIPTION


NOTES:

1. VERIFY FIRE ALARM DEVICE QUANTITIES.
2. PROVIDE FIRE ALARM CONTROL MODULE AND 120V BRANCH CIRCUIT TO EACH SMOKE DAMPER. REFER TO MECHANICAL DRAWINGS FOR LOCATIONS. MAXIMUM OF (6) DAMPERS PER 20 AMP CIRCUIT.
3. RELEASE ALL MAGNETIC DOOR HOLDERS UPON SMOKE ALARM.


EXISTING DEVICES
MAINTAIN OUTPUTS
AND CONTROL
FUNCTIONS

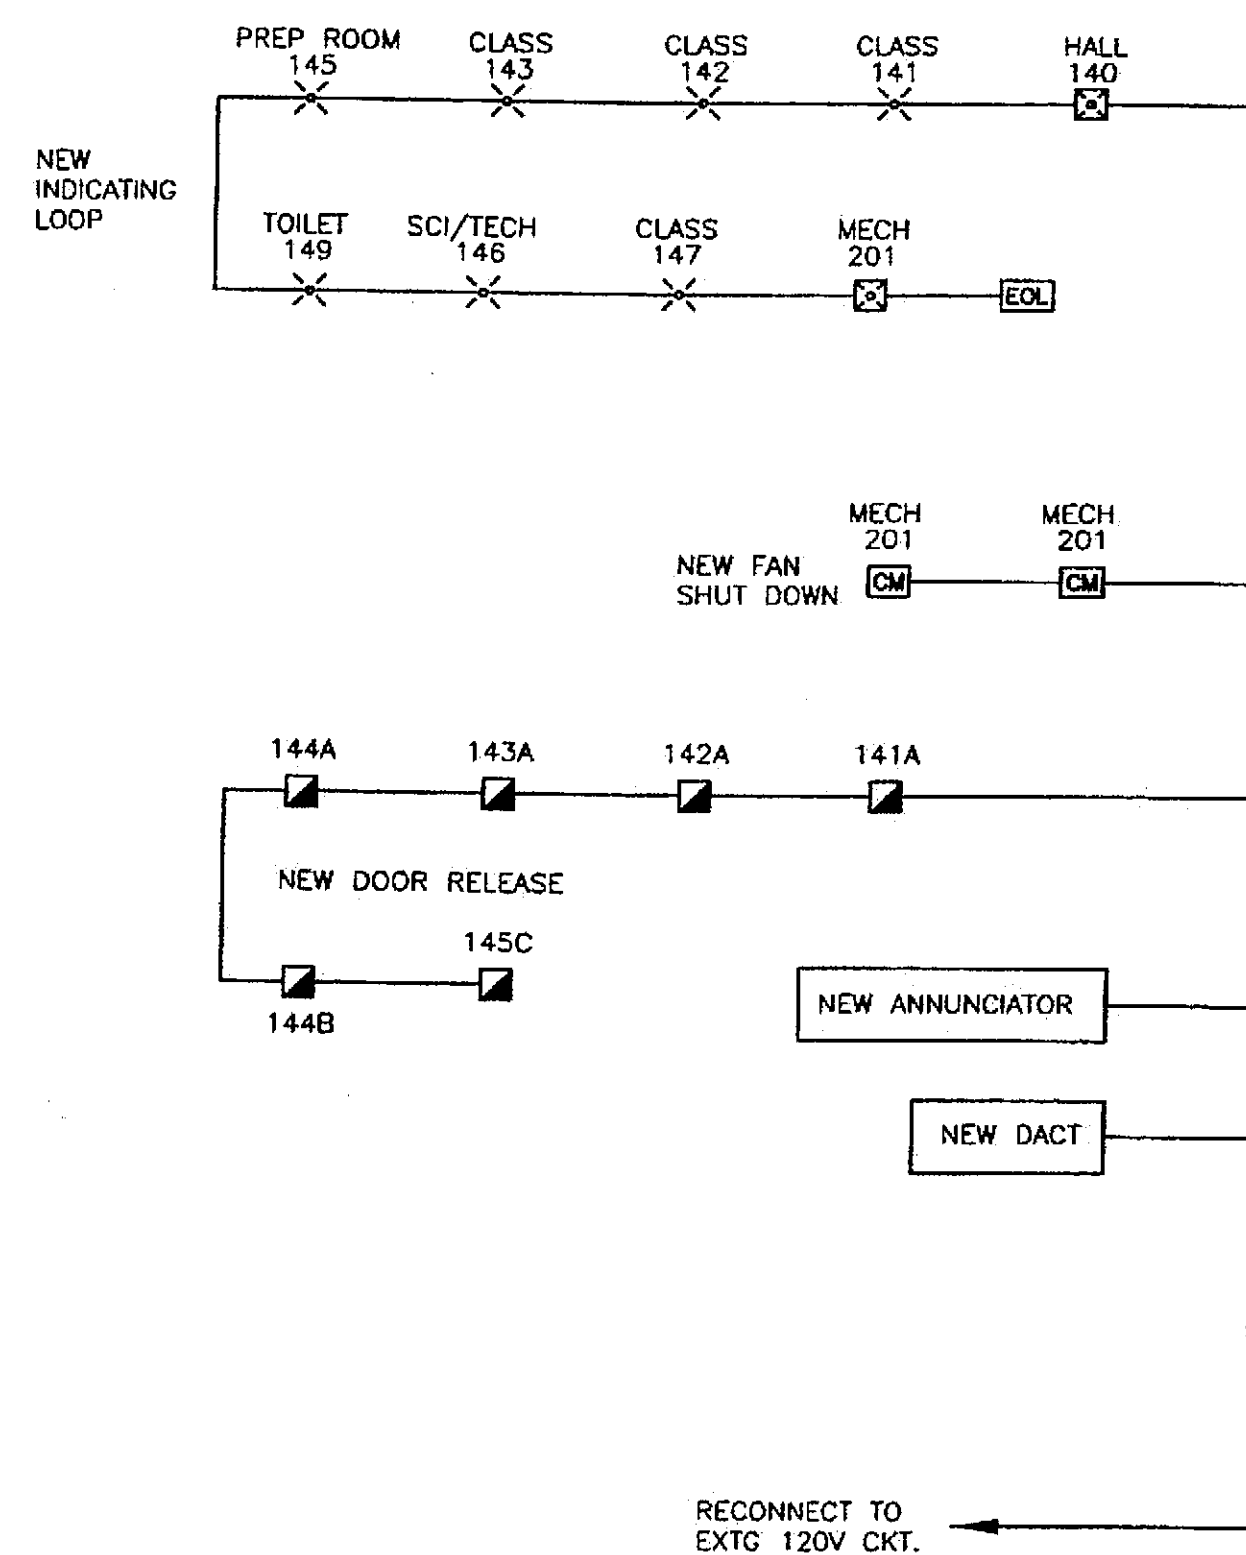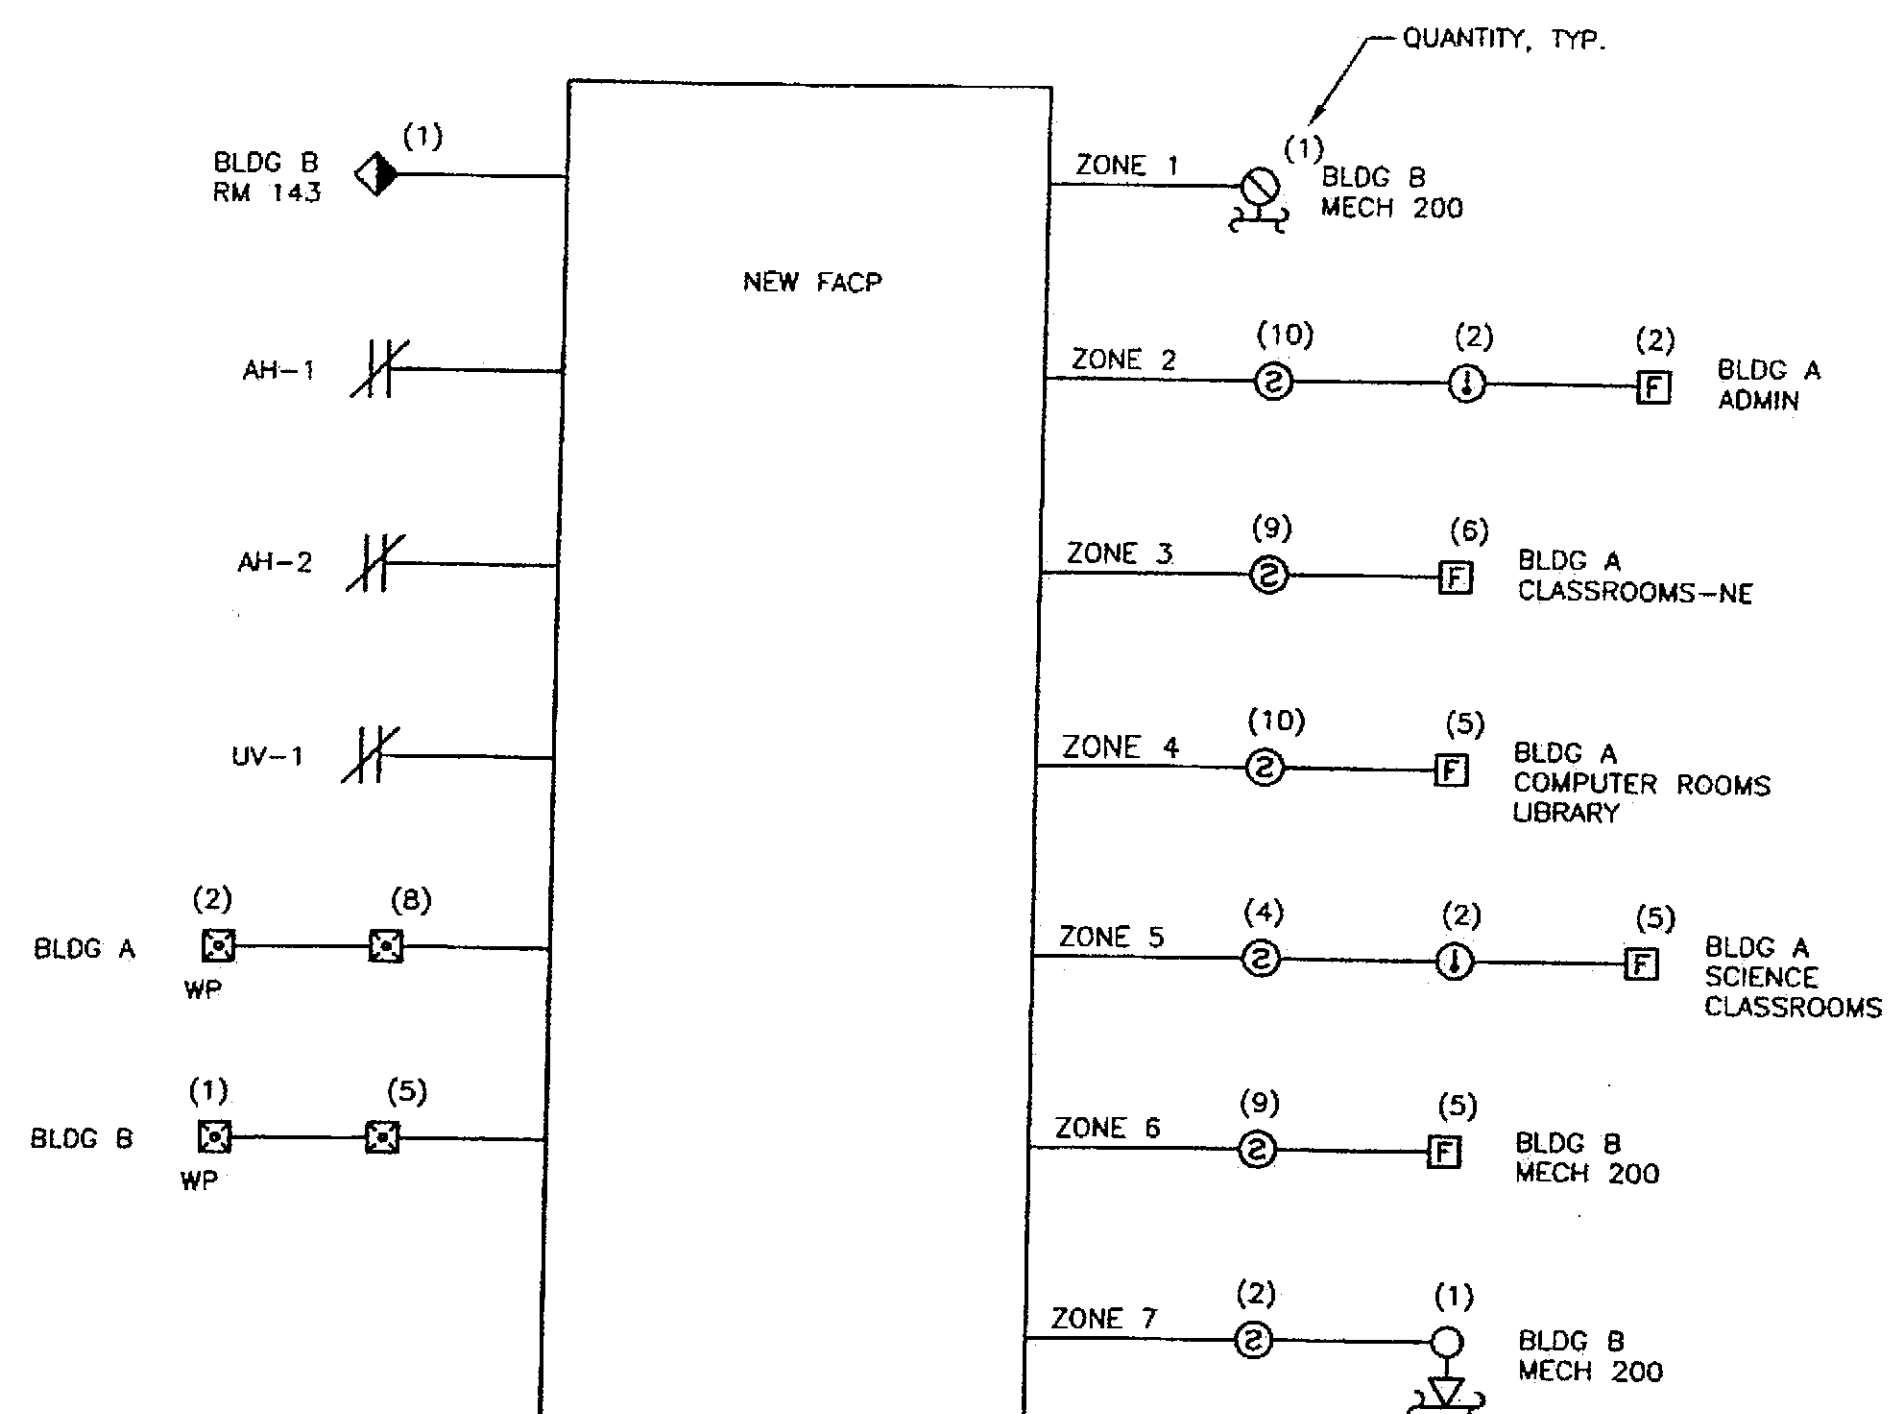

FIRE ALARM RISER DIAGRAM
NO SCALE

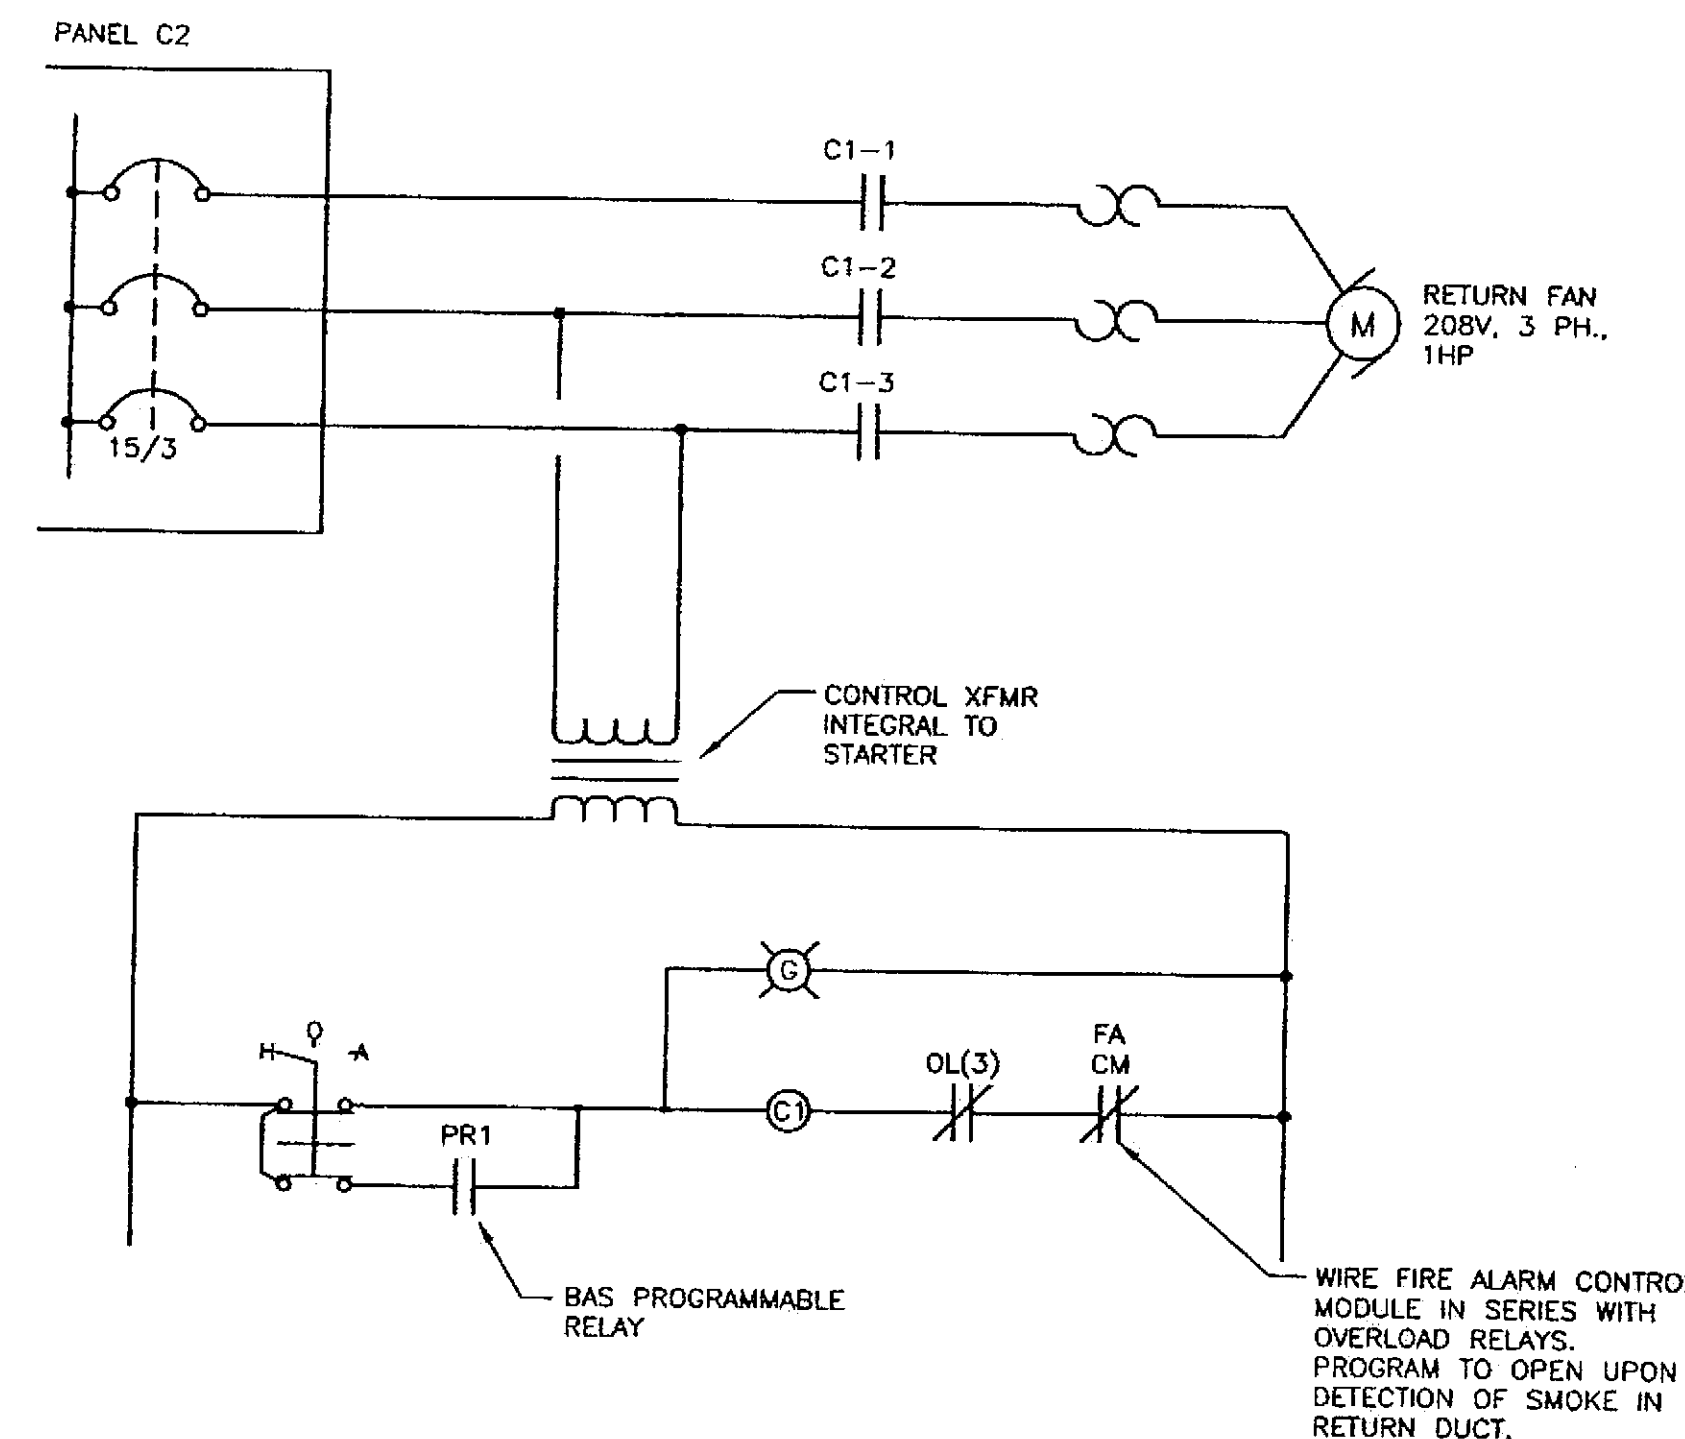

SUPPLY AND RETURN FAN WIRING DIAGRAM
NO SCALE

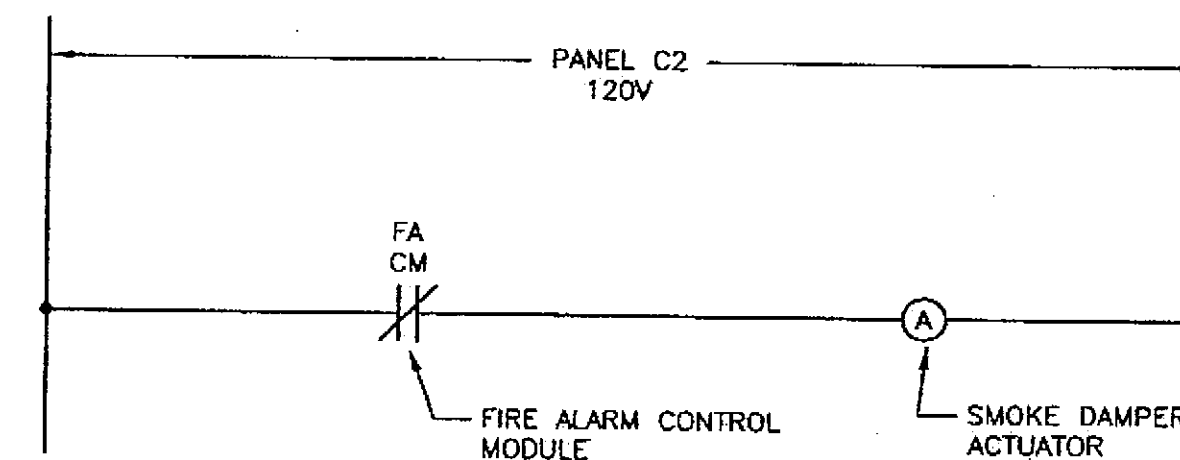

SMOKE DAMPER WIRING DIAGRAM
NO SCALE



DESIGNED BY: BJB

DRAWN BY: PEL, RJB

STATE OF ALASKA
DEPARTMENT OF TRANSPORTATION
& PUBLIC FACILITIES
STATEWIDE DESIGN & ENGINEERING
SERVICES DIVISION
MT EDGE CUMBE
HIGH SCHOOL
BUILDING 1330
ACADEMIC
EXPANSION

SHEET E206


PROJECT DESIGNATION NUMBER

67751C


STATE	YEAR
ALASKA	2004

SHEET NUMBER	TOTAL SHEETS
76	79


Project As-Built Drawings have been reviewed by the Project Engineer and represent to the best of my knowledge, the project as constructed.
Proj. Eng. *[Signature]* Date 7-07

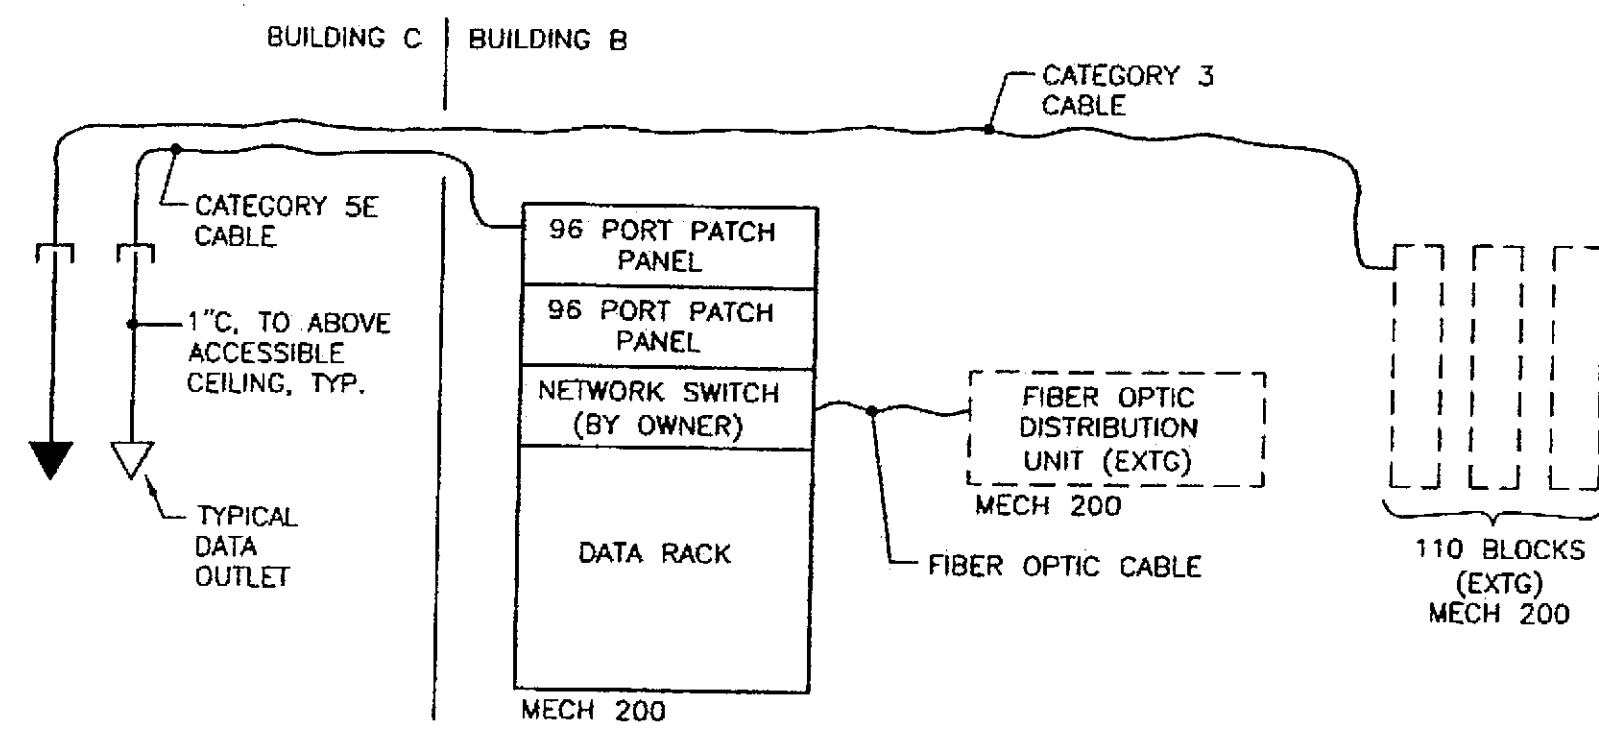

TELECOM SINGLE LINE DIAGRAM
NO SCALE

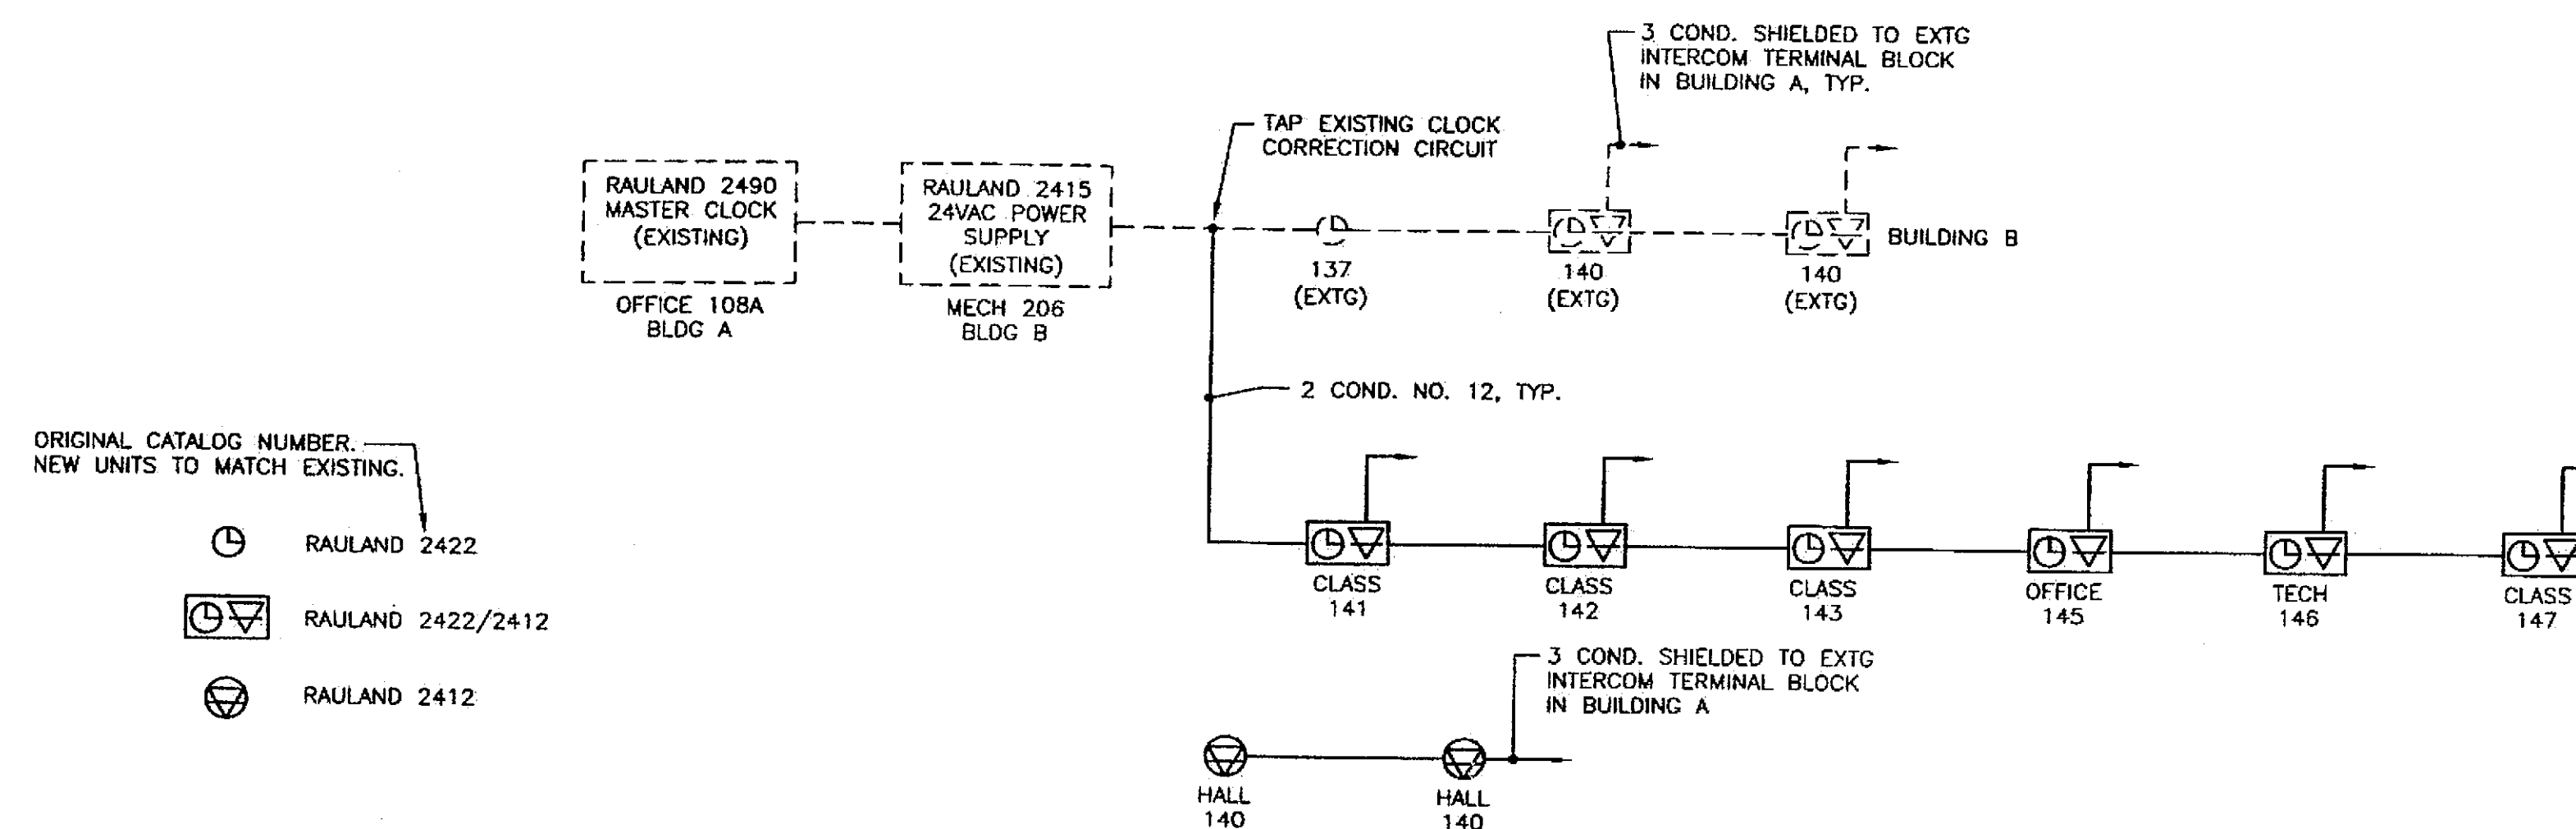

CLOCK AND INTERCOM SPEAKER SINGLE LINE DIAGRAM
NO SCALE

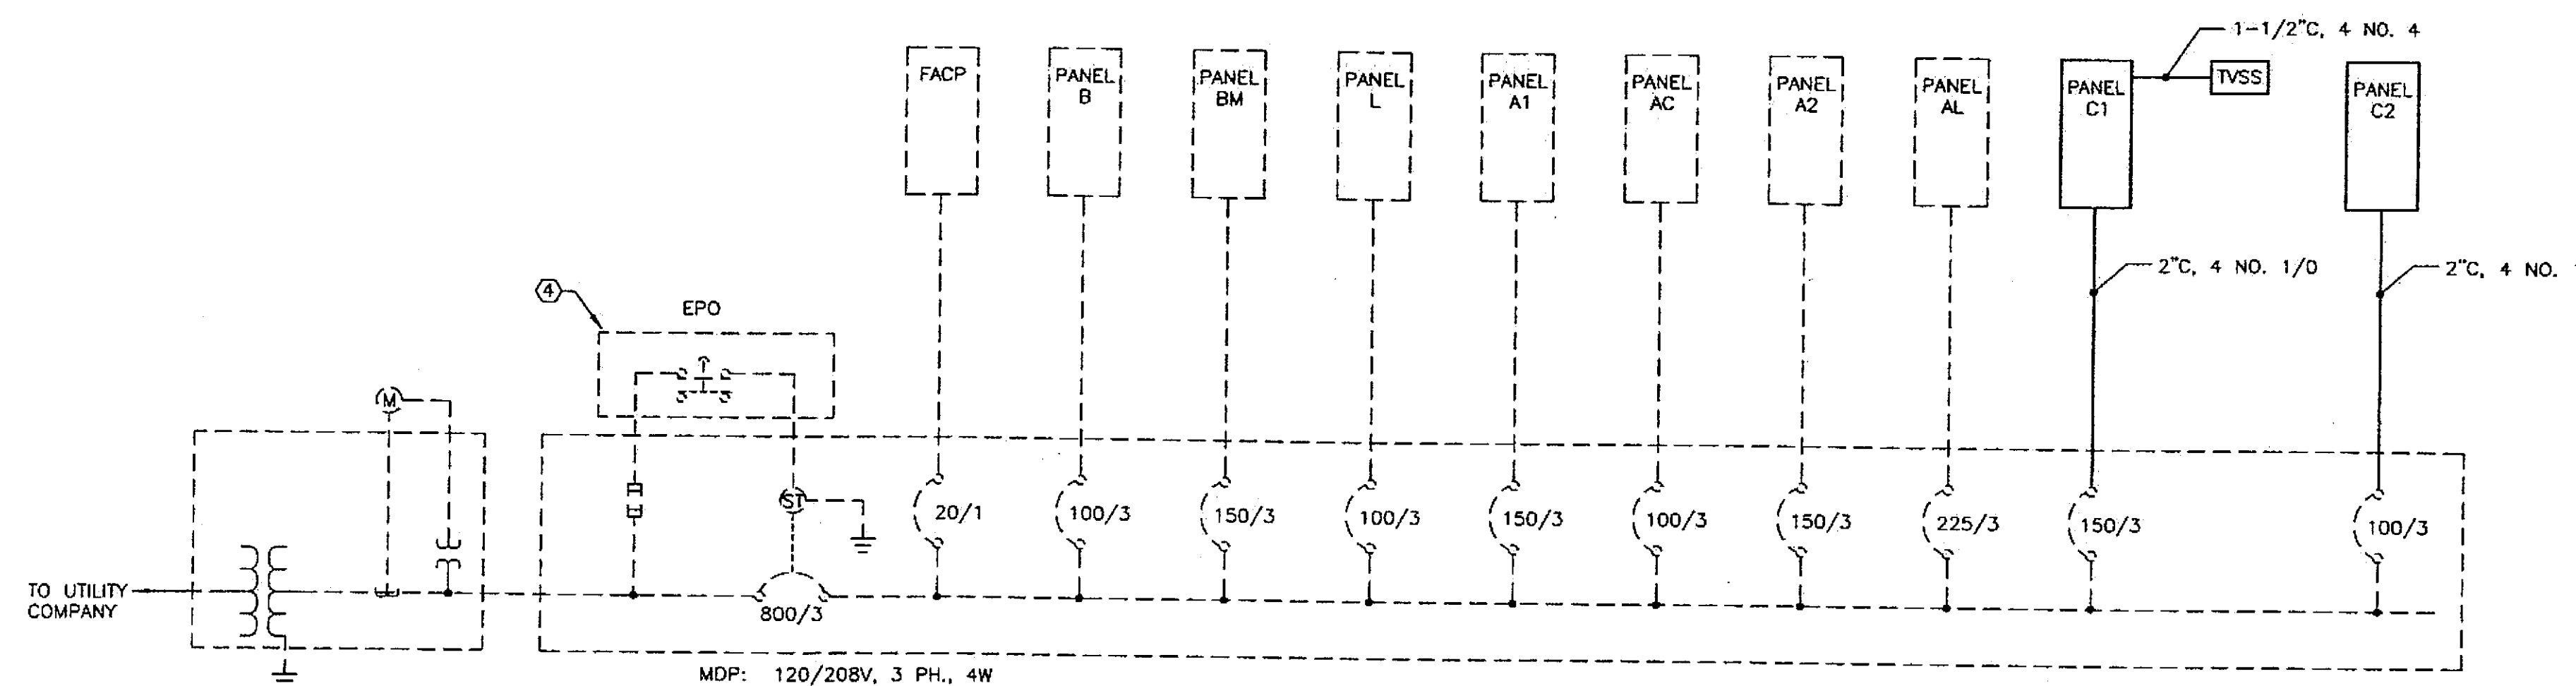

SINGLE LINE DIAGRAM
NO SCALE

- NOTES:
1. TVSS UNIT: TRANSECTOR APEX II X5120WR, OR APPROVED EQUAL.
 2. VERIFY SIZE OF TVSS CIRCUIT BREAKER WITH SUPPLIER.
 3. EXISTING EQUIPMENT SHOWN DASHED.
 - ④ REPLACE SHUNT TRIP EPD SWITCH MOUNTED IN EXISTING FIRE ALARM ANNUNCIATOR PANEL.

DATE: DECEMBER 13, 2004

ADDENDUM NUMBER

ATTACHMENT NUMBER

RECORD OF REVISIONS

No.	DATE	DESCRIPTION



13 DEC 2004

DESIGNED BY: BJB

DRAWN BY: PEL, RJB

STATE OF ALASKA
DEPARTMENT OF TRANSPORTATION
& PUBLIC FACILITIES
STATEWIDE DESIGN & ENGINEERING
SERVICES DIVISION

MT EDGE CUMBE
HIGH SCHOOL
BUILDING 1330
ACADEMIC
EXPANSION

SHEET E207


PROJECT DESIGNATION NUMBER

67751C

STATE	YEAR
ALASKA	2004
SHEET NUMBER	TOTAL SHEETS
77	79



Project As-Built Drawings have been reviewed by the Project Engineer and represent to the best of my knowledge, the project as constructed.
Proj. Eng. *[Signature]* Date 7-07

MOUNT TYPE A12, A20, & A20E
THESE ROOMS @ 7'-9" AFF
TO TOP OF LUMINAIRE

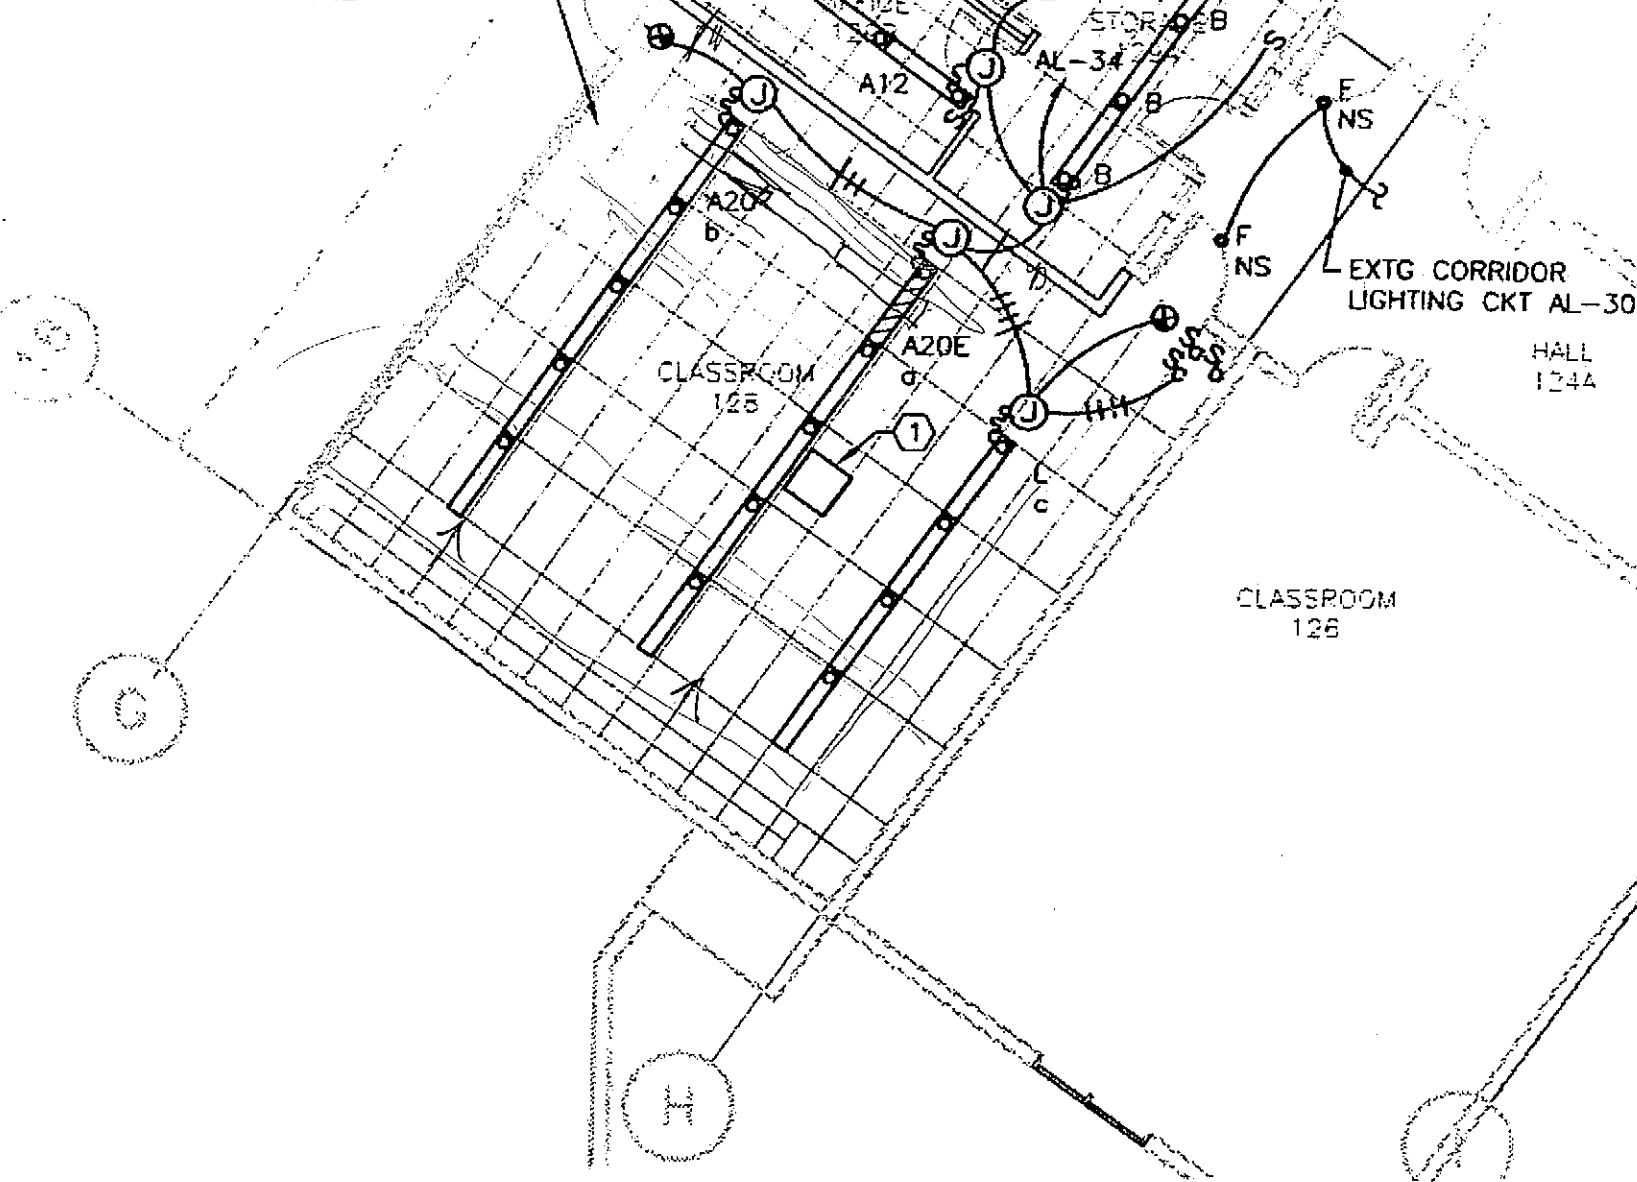



2 FIRST FLOOR PARTIAL PLAN - LIGHTING
BUILDING A

SCALE: 0 4' 8' 16'

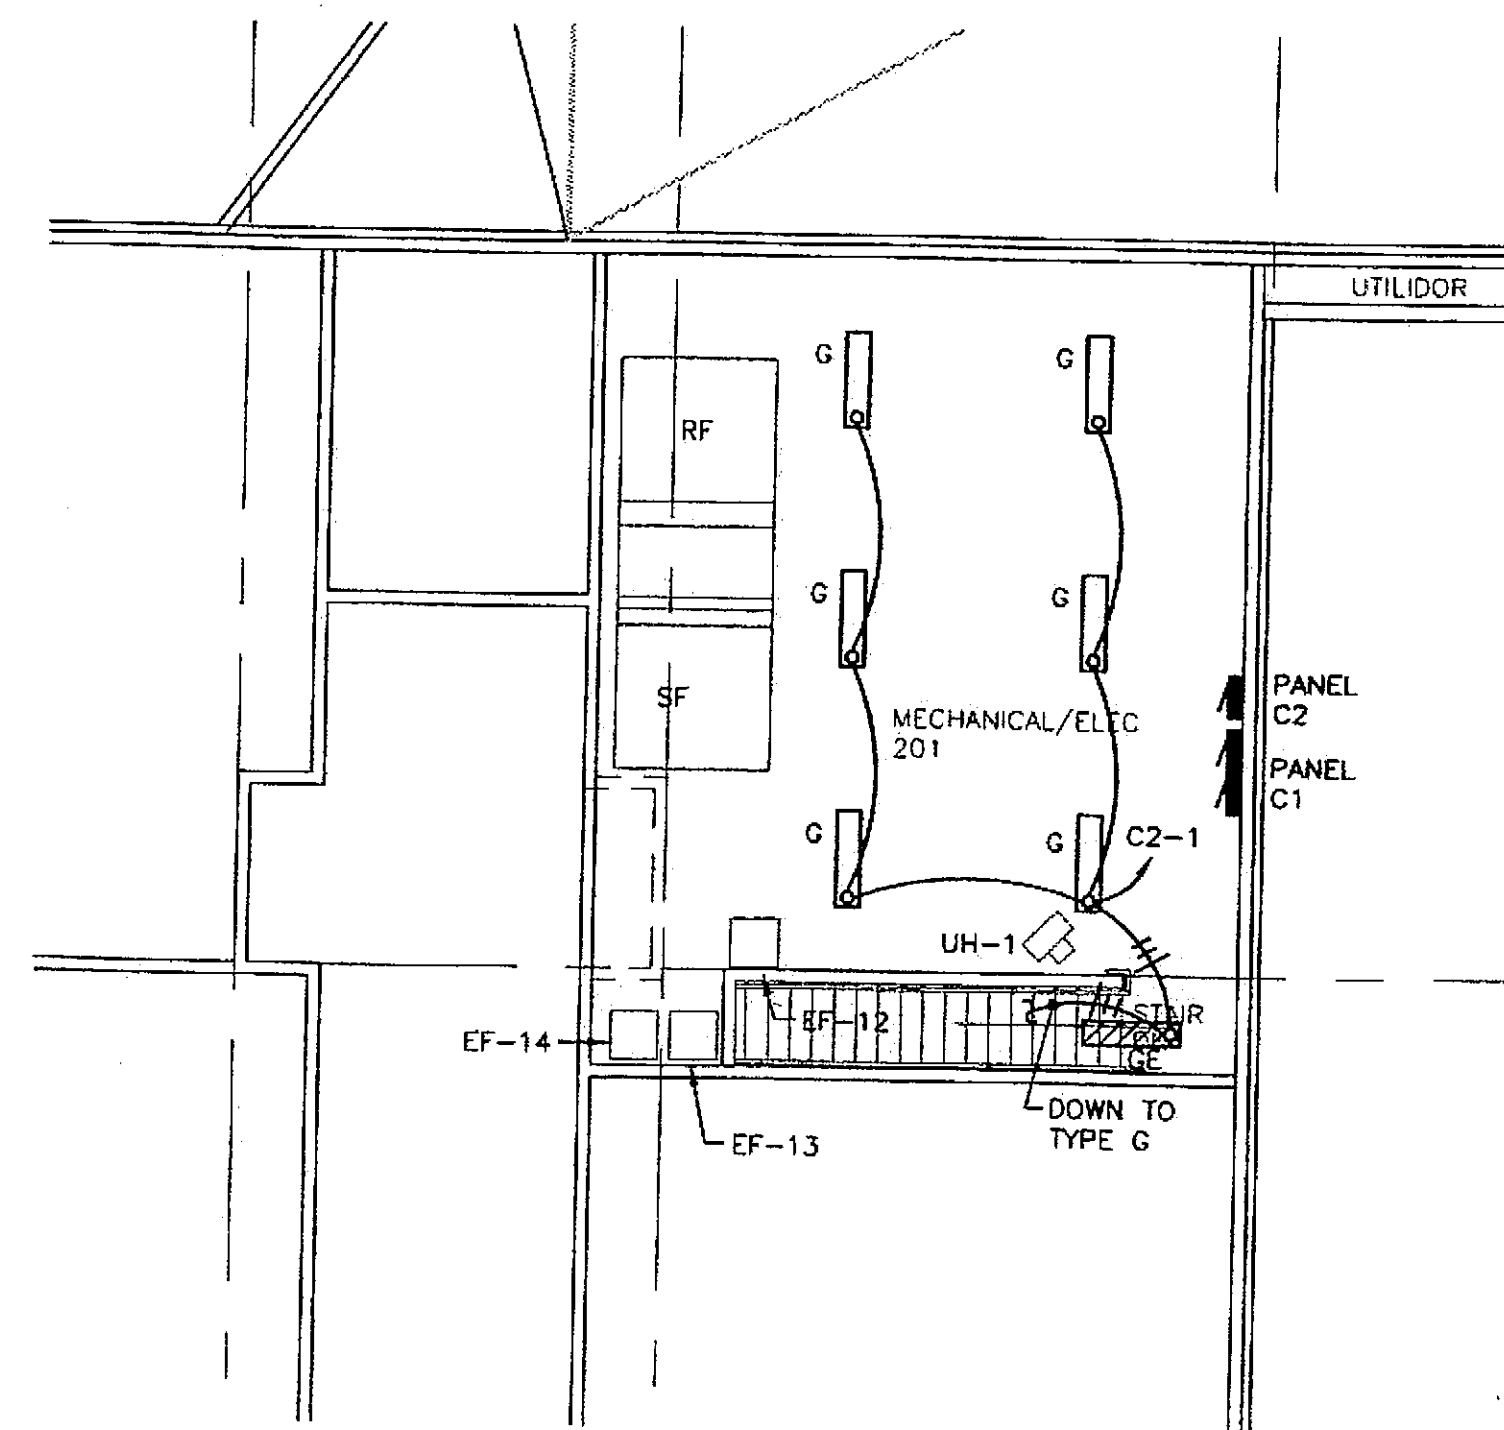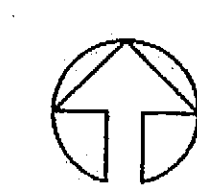

3 SECOND FLOOR PARTIAL PLAN - LIGHTING
BUILDING C

SCALE: 0 4' 8' 16'

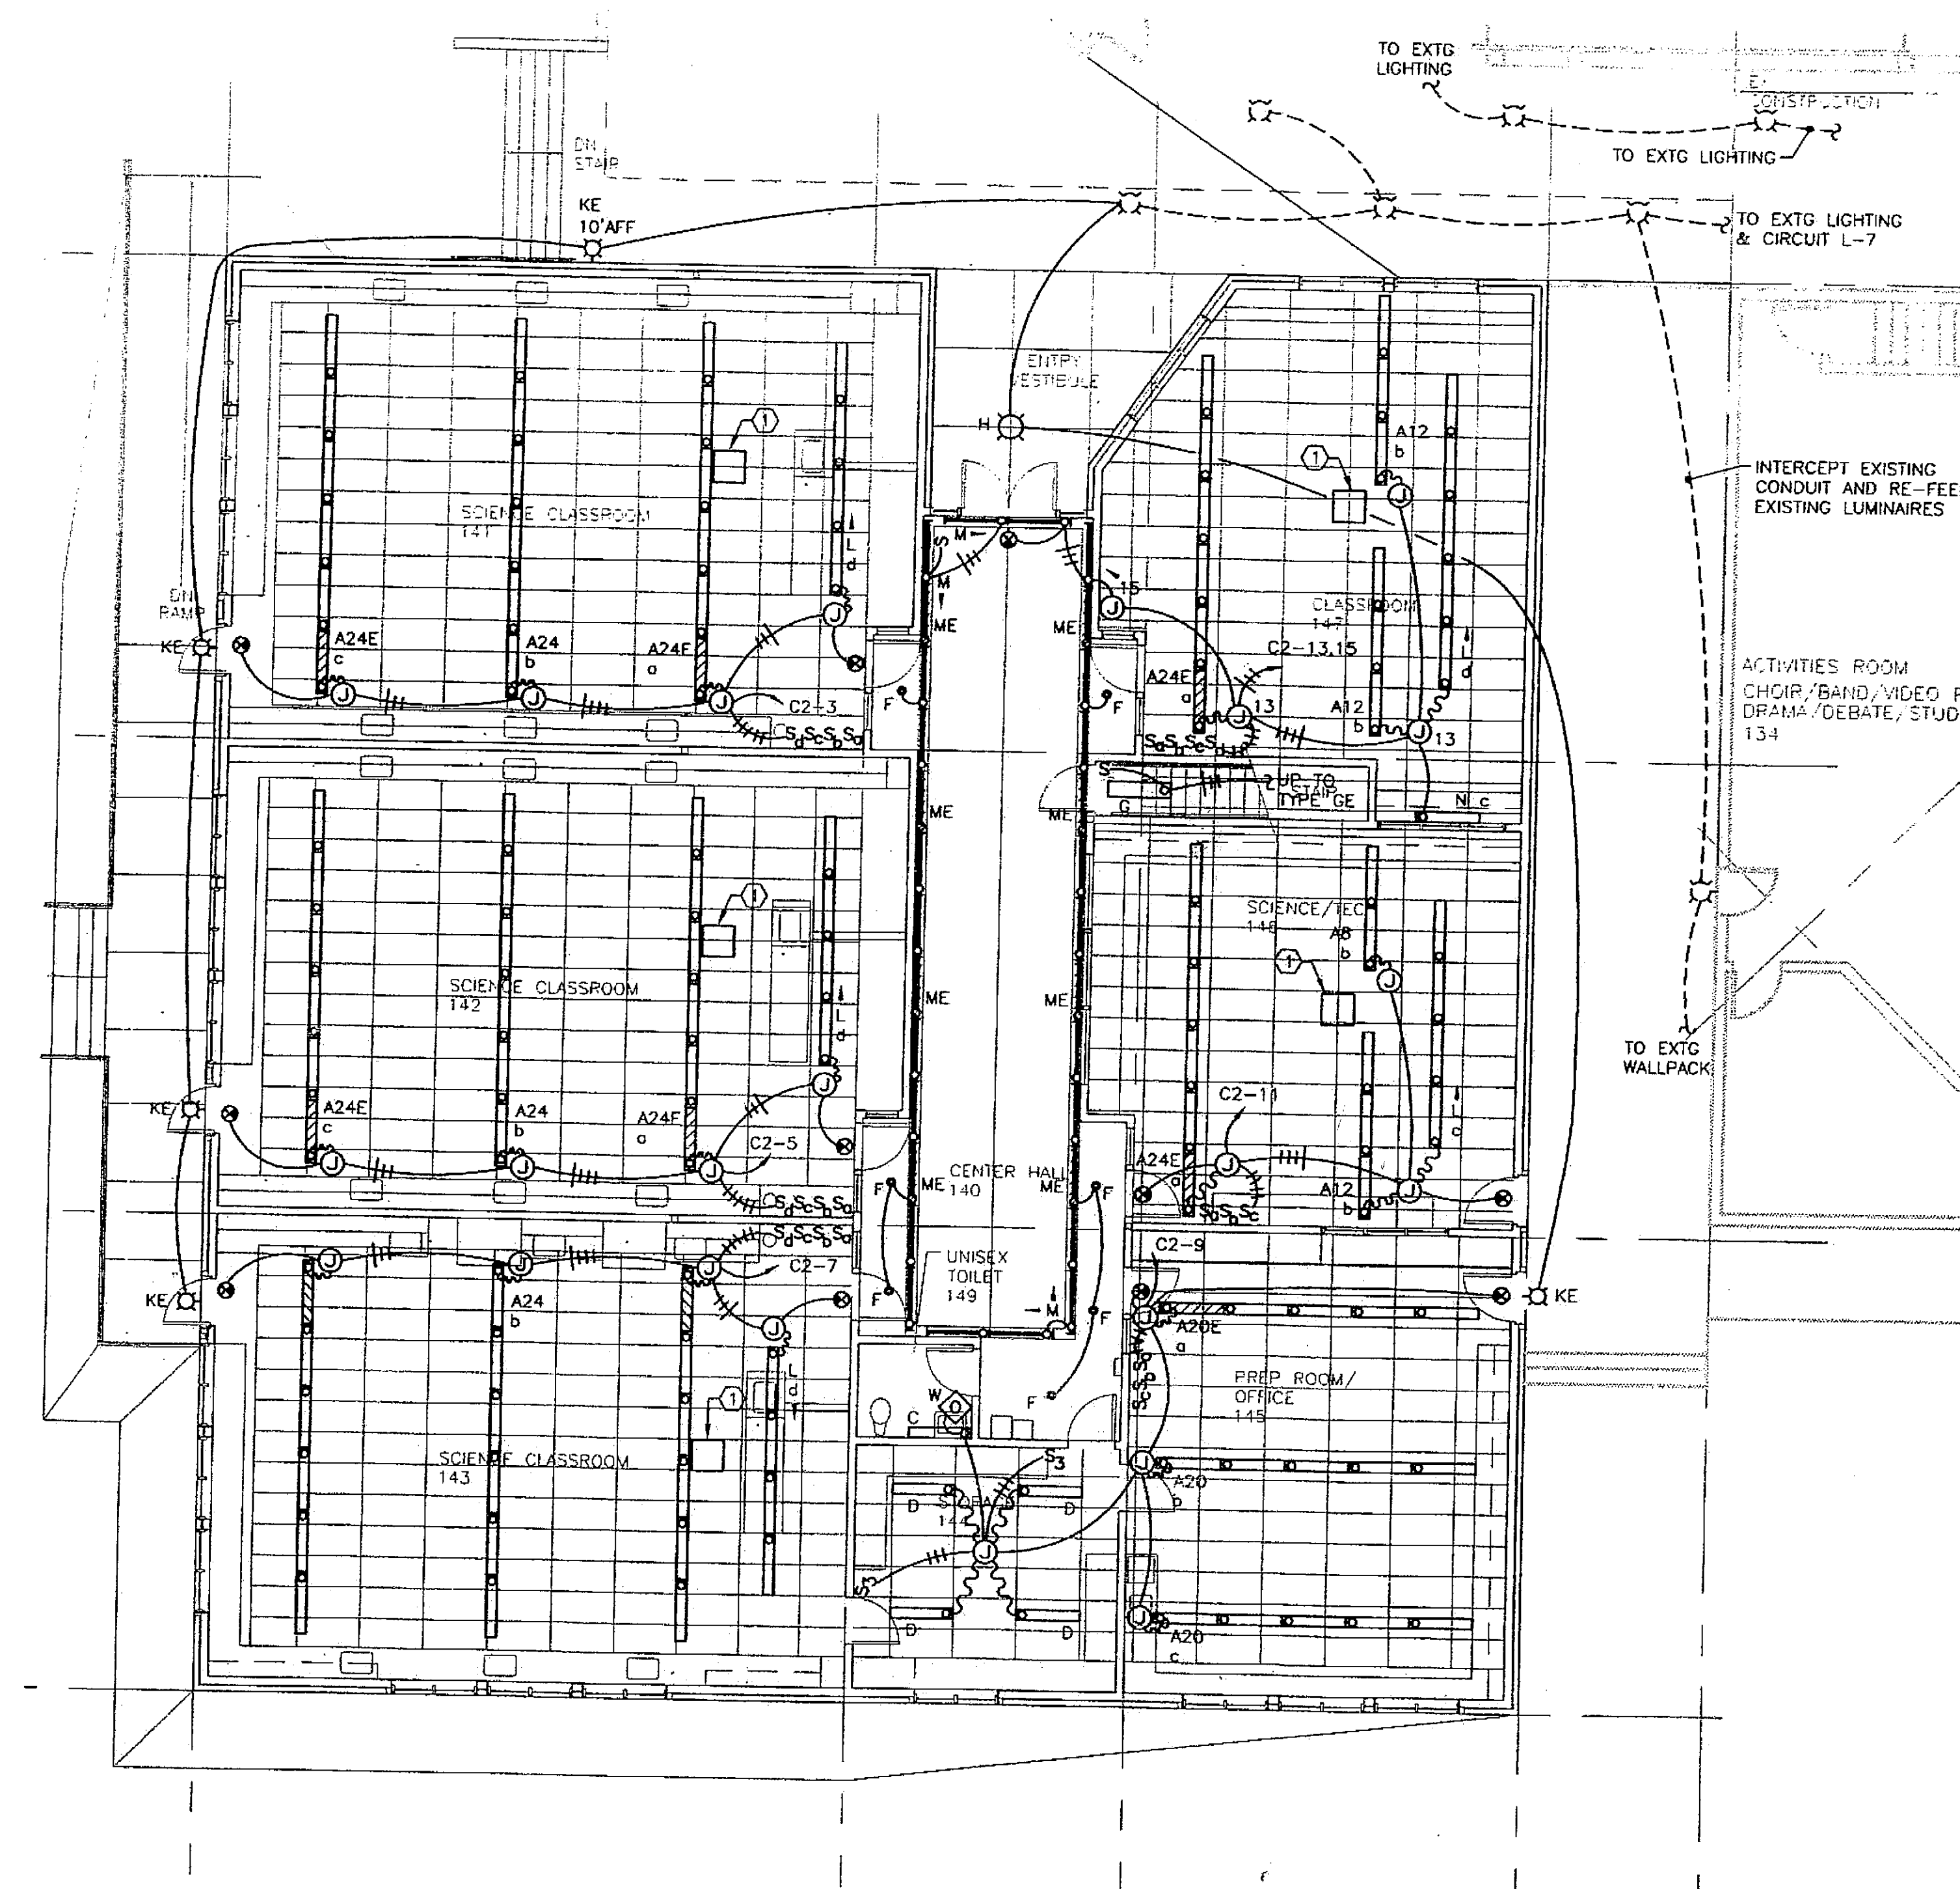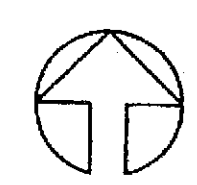

1 FIRST FLOOR PARTIAL PLAN - LIGHTING
BUILDING C

SCALE: 0 4' 8' 16'



NOTES:
① PROJECTOR: COORDINATE LUMINAIRE LOCATIONS WITH PROJECTOR MOUNTING BRACKET TO AVOID CONFLICTS WITH PROJECTION.

Project As-Built Drawings have been reviewed by the Project Engineer and represent to the best of my knowledge, the project as constructed.
Proj. Eng. *[Signature]* Date 7-07

DATE: DECEMBER 13, 2004

ADDENDUM NUMBER

ATTACHMENT NUMBER

RECORD OF REVISIONS

No.	DATE	DESCRIPTION



13 DEC 2004

DESIGNED BY: BJB

DRAWN BY: PEL, RJB

STATE OF ALASKA
DEPARTMENT OF TRANSPORTATION
& PUBLIC FACILITIES
STATEWIDE DESIGN & ENGINEERING
SERVICES DIVISION

MT EDGE CUMBE
HIGH SCHOOL
BUILDING 1330
ACADEMIC
EXPANSION

SHEET E301

PROJECT DESIGNATION NUMBER

67751C

STATE	YEAR
ALASKA	2004
SHEET NUMBER	TOTAL SHEETS
78	79

LUMINAIRE SCHEDULE

TYPE	DESCRIPTION	MANUFACTURER	LAMPS	REMARKS
A8	8 FT PENDANT MOUNT INDIRECT LINEAR FLUORESCENT w/ SPECULAR REFLECTOR, SQUARE PERF/ACRYLIC OVERLAY SHIELDING, DUST COVER, 2 LAMP	PEERLESS LIGHTING 10CRM2 232 SPR 8FT R8 120 GEB10IS SCT LP835 F1/21 ACG CMG DU	(2) 32W T8 3500K, CRI 85	MOUNT @ 8'-0" AFF TO BOTTOM OF LUMINAIRE, UON.
A12	12 FT PENDANT MOUNT INDIRECT LINEAR FLUORESCENT w/ SPECULAR REFLECTOR, SQUARE PERF/ACRYLIC OVERLAY SHIELDING, DUST COVER, 2 LAMP	PEERLESS LIGHTING 10CRM2 232 SPR 12FT R8 120 GEB10IS SCT LP835 F1/21 ACG CMG DU	(2) 32W T8 3500K, CRI 85	MOUNT @ 8'-0" AFF TO BOTTOM OF LUMINAIRE, UON.
A16	16 FT PENDANT MOUNT INDIRECT LINEAR FLUORESCENT w/ SPECULAR REFLECTOR, SQUARE PERF/ACRYLIC OVERLAY SHIELDING, DUST COVER, 2 LAMP	PEERLESS LIGHTING 10CRM2 232 SPR 16FT R8 120 GEB10IS SCT LP835 F1/21 ACG CMG DU	(2) 32W T8 3500K, CRI 85	MOUNT @ 8'-0" AFF TO BOTTOM OF LUMINAIRE, UON.
A20	20 FT PENDANT MOUNT INDIRECT LINEAR FLUORESCENT w/ SPECULAR REFLECTOR, SQUARE PERF/ACRYLIC OVERLAY SHIELDING, DUST COVER, 2 LAMP	PEERLESS LIGHTING 10CRM2 232 SPR 20FT R8 120 GEB10IS SCT LP835 F1/21 ACG CMG DU	(2) 32W T8 3500K, CRI 85	MOUNT @ 8'-0" AFF TO BOTTOM OF LUMINAIRE, UON.
A20E	SAME AS TYPE A20, w/ 1 SECTION EMERGENCY BATTERY PACK, AND THROUGH WIRE w/ SEPARATE FEED	PEERLESS LIGHTING 10CRM2 232 SPR 20FT R8 120 GEB10IS 1SE EL SCT LP835 F1/21 ACG CMG DU ELH	(2) 32W T8 3500K, CRI 85	MOUNT @ 8'-0" AFF TO BOTTOM OF LUMINAIRE, UON.
A24	24 FT PENDANT MOUNT INDIRECT LINEAR FLUORESCENT w/ SPECULAR REFLECTOR, SQUARE PERF/ACRYLIC OVERLAY SHIELDING, DUST COVER, 2 LAMP	PEERLESS LIGHTING 10CRM2 232 SPR 24FT R8 120 GEB10IS SCT LP835 F1/21 ACG CMG DU	(2) 32W T8 3500K, CRI 85	MOUNT @ 8'-0" AFF TO BOTTOM OF LUMINAIRE, UON.
A24E	SAME AS TYPE A24, w/ 1 SECTION EMERGENCY BATTERY PACK, AND THROUGH WIRE w/ SEPARATE FEED	PEERLESS LIGHTING 10CRM2 232 SPR 24FT R8 120 GEB10IS 1SE EL SCT LP835 F1/21 ACG CMG DU ELH	(2) 32W T8 3500K, CRI 85	MOUNT @ 8'-0" AFF TO BOTTOM OF LUMINAIRE, UON.
A28E	28 FT PENDANT MOUNT INDIRECT LINEAR FLUORESCENT w/ SPECULAR REFLECTOR, SQUARE PERF/ACRYLIC OVERLAY SHIELDING, DUST COVER, 1 SECTION EMERGENCY BATTERY PACK, AND THROUGH WIRE w/ SEPARATE FEED, 2 LAMP	PEERLESS LIGHTING 10CRM2 232 SPR 28FT R8 120 GEB10IS 1SE EL SCT LP835 F1/21 ACG CMG DU ELH	(2) 32W T8 3500K, CRI 85	MOUNT @ 8'-0" AFF TO BOTTOM OF LUMINAIRE, UON.
B	4' SURFACE MOUNT SPEC GRADE FLUORESCENT WRAPAROUND w/ ACRYLIC DIFFUSER, 2 LAMP	DAY-BRITE SWN232-120-1/2-EB	(2) 32W T8 3500K, CRI 85	
C	4' WALL MOUNTED DIRECT/INDIRECT FLUORESCENT WRAPAROUND w/ ACRYLIC DIFFUSER, 2 LAMP	DAY-BRITE CB232W-120-1/2EB	(2) 32W T8 3500K, CRI 85	MOUNT ABOVE MIRROR
D	4' SURFACE FLUORESCENT ENCLOSED GASKETED INDUSTRIAL w/ FIBERGLASS HOUSING, HIGH-IMPACT ACRYLIC DIFFUSER, 2 LAMP OPTION	DAY-BRITE V2AT232-120-1/2EB METALUX VT2-232DR-120V-EB8	(2) 32W T8 3500K, CRI 85 (2) 32W T8 3500K, CRI 85	
F	6" DIA RECESSED LENSED DOWNLIGHT w/ HORIZONTAL LAMP, CLEAR SPECULAR LOW IRIDESCENT REFLECTOR, BLACK BAFFLE, FRESNEL LENS, 2 LAMP	OMEGA LIGHTING OM62H26QPL-BBSPLFL-120	(2) 26W QUAD 3500K, CRI 85	
G	4' SURFACE FLUORESCENT INDUSTRIAL w/20% UPLIGHT, END CAPS, 2 LAMP OPTION	DAY-BRIGHT 2F232-PP-120-1/2EB METALUX EVM-232-120-EB8 / CEP	(2) 32W T8 3500K, CRI 85 (2) 32W T8 3500K, CRI 85	
GE	SAME AS TYPE G, w/ EMERGENCY BATTERY PACK OPTION	DAY-BRIGHT 2F232-PP-120-1/2EB DEB-5 METALUX EVM-232-120-EB8-EL-B50 CEP	(2) 32W T8 3500K, CRI 85 (2) 32W T8 3500K, CRI 85	
H	10" SQUARE RECESSED LENSED HID DOWNLIGHT, WITH STEPPED TRIM AND FRESNEL LENS, MATCH EXISTING	PRESCOLITE LFHSQL-H10-50HPS-50HPSFE- 9SRFR	(1) 50W HPS 1900K, CRI 22	
KE	EXTERIOR COMPACT FLUORESCENT WALLPACK, WITH EMERGENCY BATTERY PACK, MATCH APPEARANCE OF EXISTING WALLPACKS.	NITEBRITES WLS26CF120-LP	(1) 26W QUAD 3500K, CRI 85	MOUNT @ 8'-0" AFF TO BOTTOM OF LUMINAIRE, UON.
L	4' SEMI-RECESSED LINEAR FLUORESCENT WALLWASH, WITH SPECULAR ALUMINUM REFLECTOR, 1 LAMP	ELLIPTIPAR F210-T155-L-02-1-00-0	(1) 54W T5HO 3500K, CRI 80	
M	4' COVE MOUNTED FLUORESCENT STRIP w/ ASYMMETRIC REFLECTOR, 1 LAMP OPTION	DAY-BRITE N132-120-1/1-EB-NAR-4 METALUX STN-132-120-EB8	(1) 32W T8 3500K, CRI 85 (1) 32W T8 3500K, CRI 85	SEE ARCHITECTURAL PLANS FOR MOUNTING DETAIL. PROVIDE LUMINAIRE LENGTHS REQUIRED FOR CONTINUOUS ROW AS SHOWN ON PLANS.
ME	SAME AS TYPE M, w/ EMERGENCY BATTERY PACK OPTION	DAY-BRITE N132-120-1/2-EB-NAR-4 DEB-5 METALUX STN-132-120-EB8-EL-B50	(1) 32W T8 3500K, CRI 85 (1) 32W T8 3500K, CRI 85	SEE ARCHITECTURAL PLANS FOR MOUNTING DETAIL. PROVIDE LUMINAIRE LENGTHS REQUIRED FOR CONTINUOUS ROW AS SHOWN ON PLANS.
N	4' SURFACE MOUNTED FLUORESCENT UNDERCABINET w/ ACRYLIC DIFFUSER, 1 LAMP	DAY-BRITE 8UC132-W-120-1/1-EB	(1) 32W T8 3500K, CRI 85	
⊗	EMERGENCY EXIT LIGHT w/ SELF DIAGNOSTICS	McPHILBEN ER55LD-1-12/27-G	LED	CEILING MOUNT IN CENTER HALL AND CLASSROOMS 141,142,143,145. WALL MOUNT @ 8'-0" AFF IN CLASS 128.
◇	WALL MOUNTED OCCUPANCY SENSOR WITH HARD LENS	THE WATT STOPPER WA-100	---	MOUNT @ 48" AFF TO CENTER.


DATE: DECEMBER 13, 2004

ADDENDUM NUMBER

ATTACHMENT NUMBER

RECORD OF REVISIONS

No.	DATE	DESCRIPTION

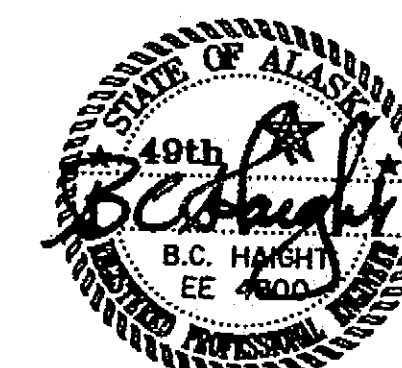

DESIGNED BY: BJB

DRAWN BY: PEL, RJB

STATE OF ALASKA
DEPARTMENT OF TRANSPORTATION
& PUBLIC FACILITIES
STATEWIDE DESIGN & ENGINEERING
SERVICES DIVISION

MT EDGE CUMBE
HIGH SCHOOL
BUILDING 1330
ACADEMIC
EXPANSION

SHEET E302

PROJECT DESIGNATION NUMBER

67751C

STATE YEAR

ALASKA 2004

SHEET NUMBER TOTAL SHEETS

79

79

Project As-Built Drawings have been
reviewed by the Project Engineer and
represent to the best of my knowledge, the
Project as constructed.
Proj. Eng. *D. Haight* Date *7-07*